


09.08/25

4/1/2026  
R:\Utilities\RDy\_Ut\Proj\BP1-R018\_util\_tsh.dgn  
VHB/gotkins

TIP PROJECT: BP1-R018


CONTRACT:

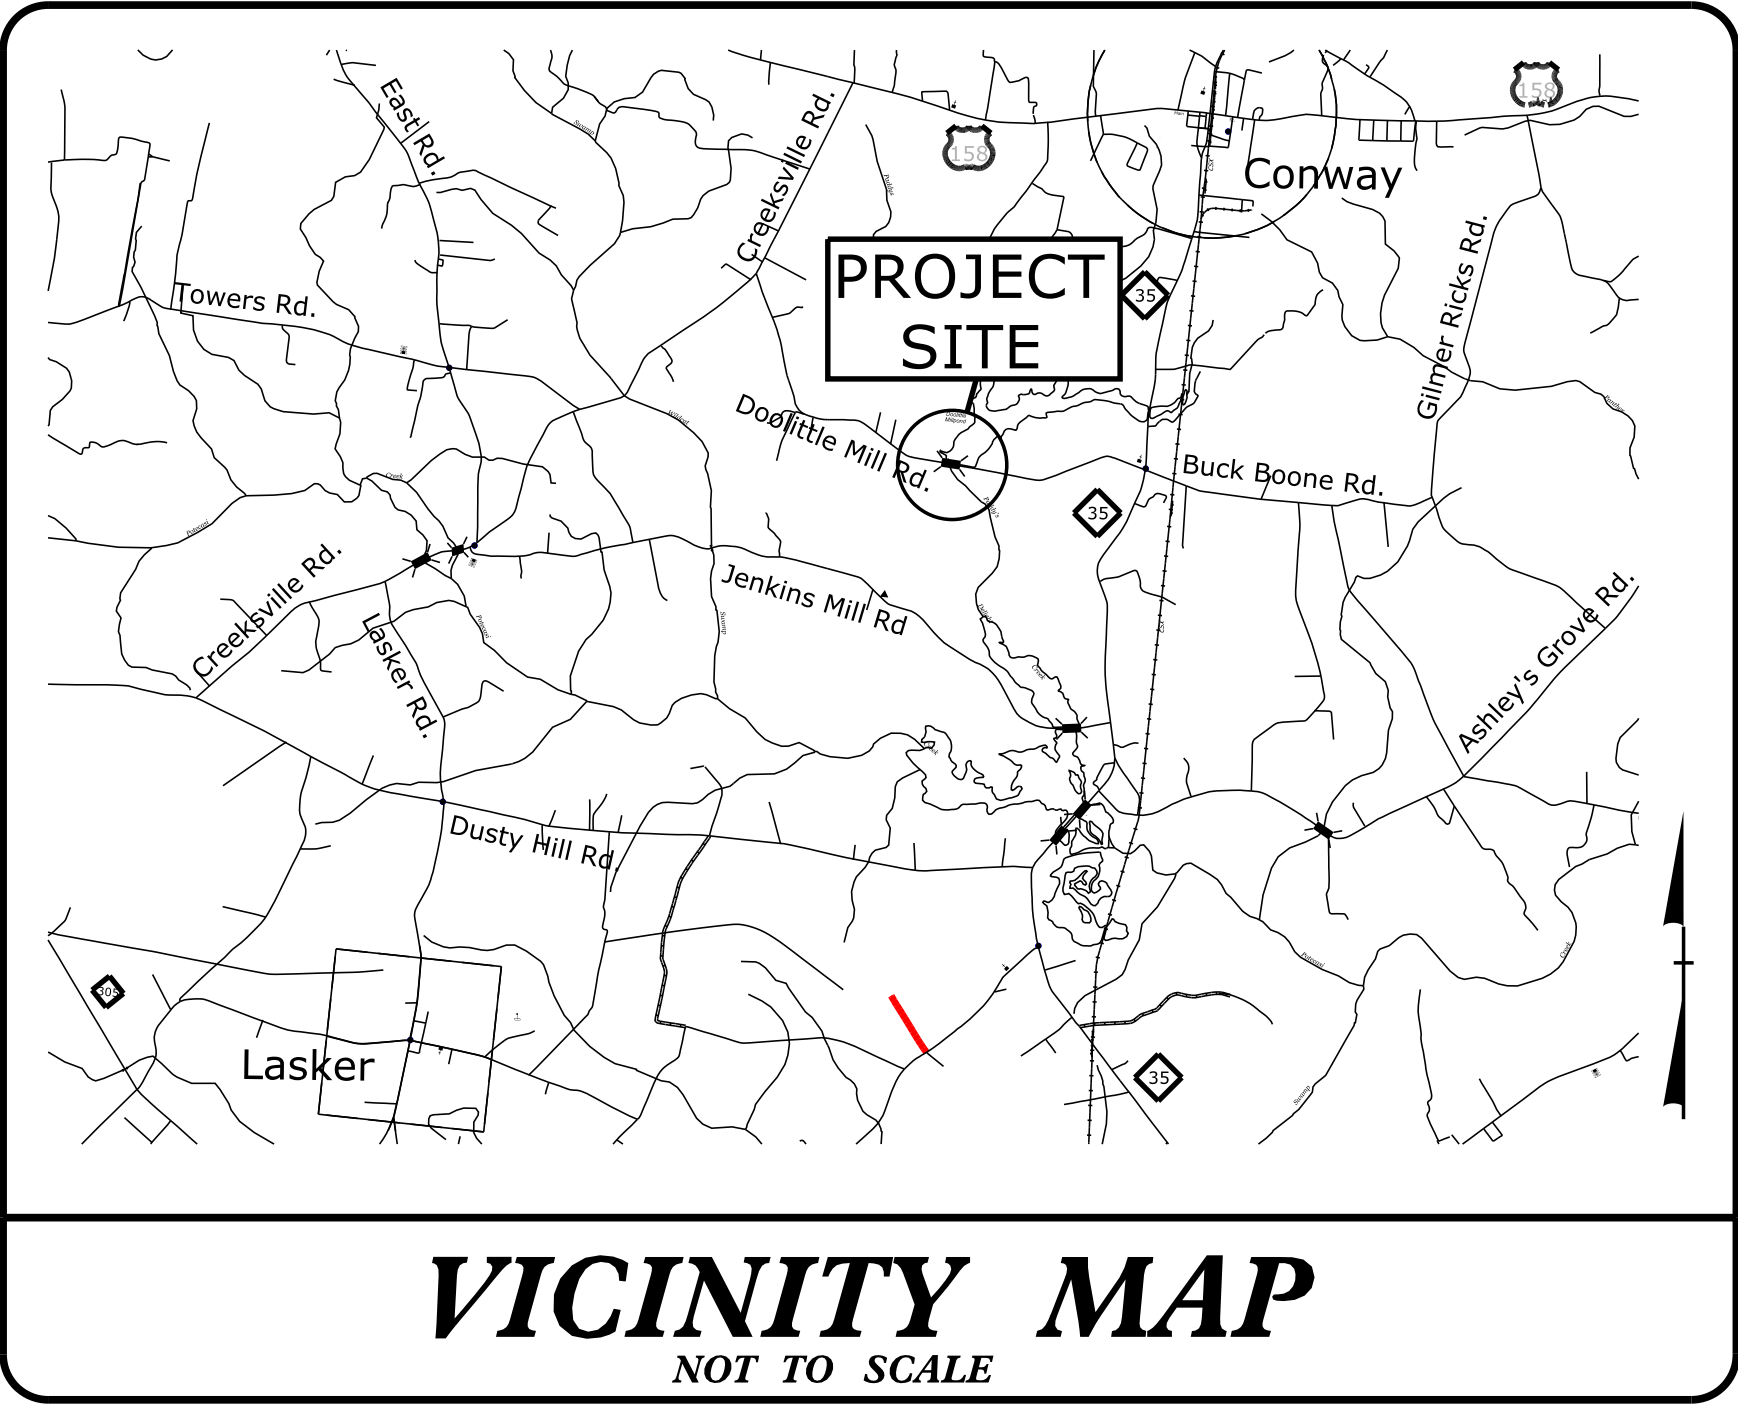


STATE OF NORTH CAROLINA  
DIVISION OF HIGHWAYS  
**NORTHAMPTON COUNTY**

LOCATION: BRIDGE NO. 650017 OVER PADDYS DELIGHT CREEK  
ON JENKINS MILL ROAD (SR 1508)  
TYPE OF WORK: WATER MAIN RELOCATION

STATE	STATE PROJECT REFERENCE NO.	SHEET NO.	TOTAL SHEETS
N.C.	BP1-R018	UC-1	
STATE PROJ. NO.	F.A. PROJ. NO.	DESCRIPTION	
BP1-R018.1	STATE FUNDED	PE	
BP1-R018.2	STATE FUNDED	RW&UTIL.	
BP1-R018.3	STATE FUNDED	CONSTRUCTION	

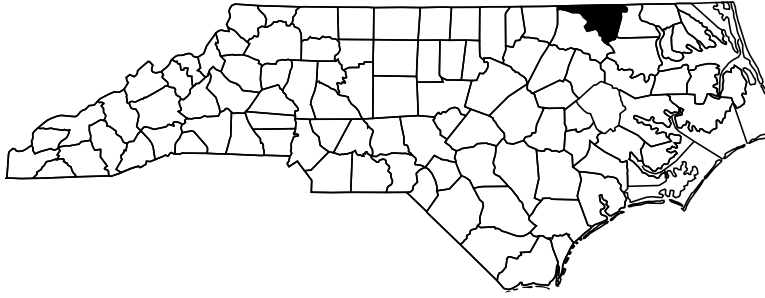

INDEX OF SHEETS	
SHEET NO.	DESCRIPTION
UC-1	TITLE SHEET
UC-2	UTILITY CONSTRUCTION PLAN AND PROFILE
UC-3	CONSTRUCTION DETAILS AND NOTES

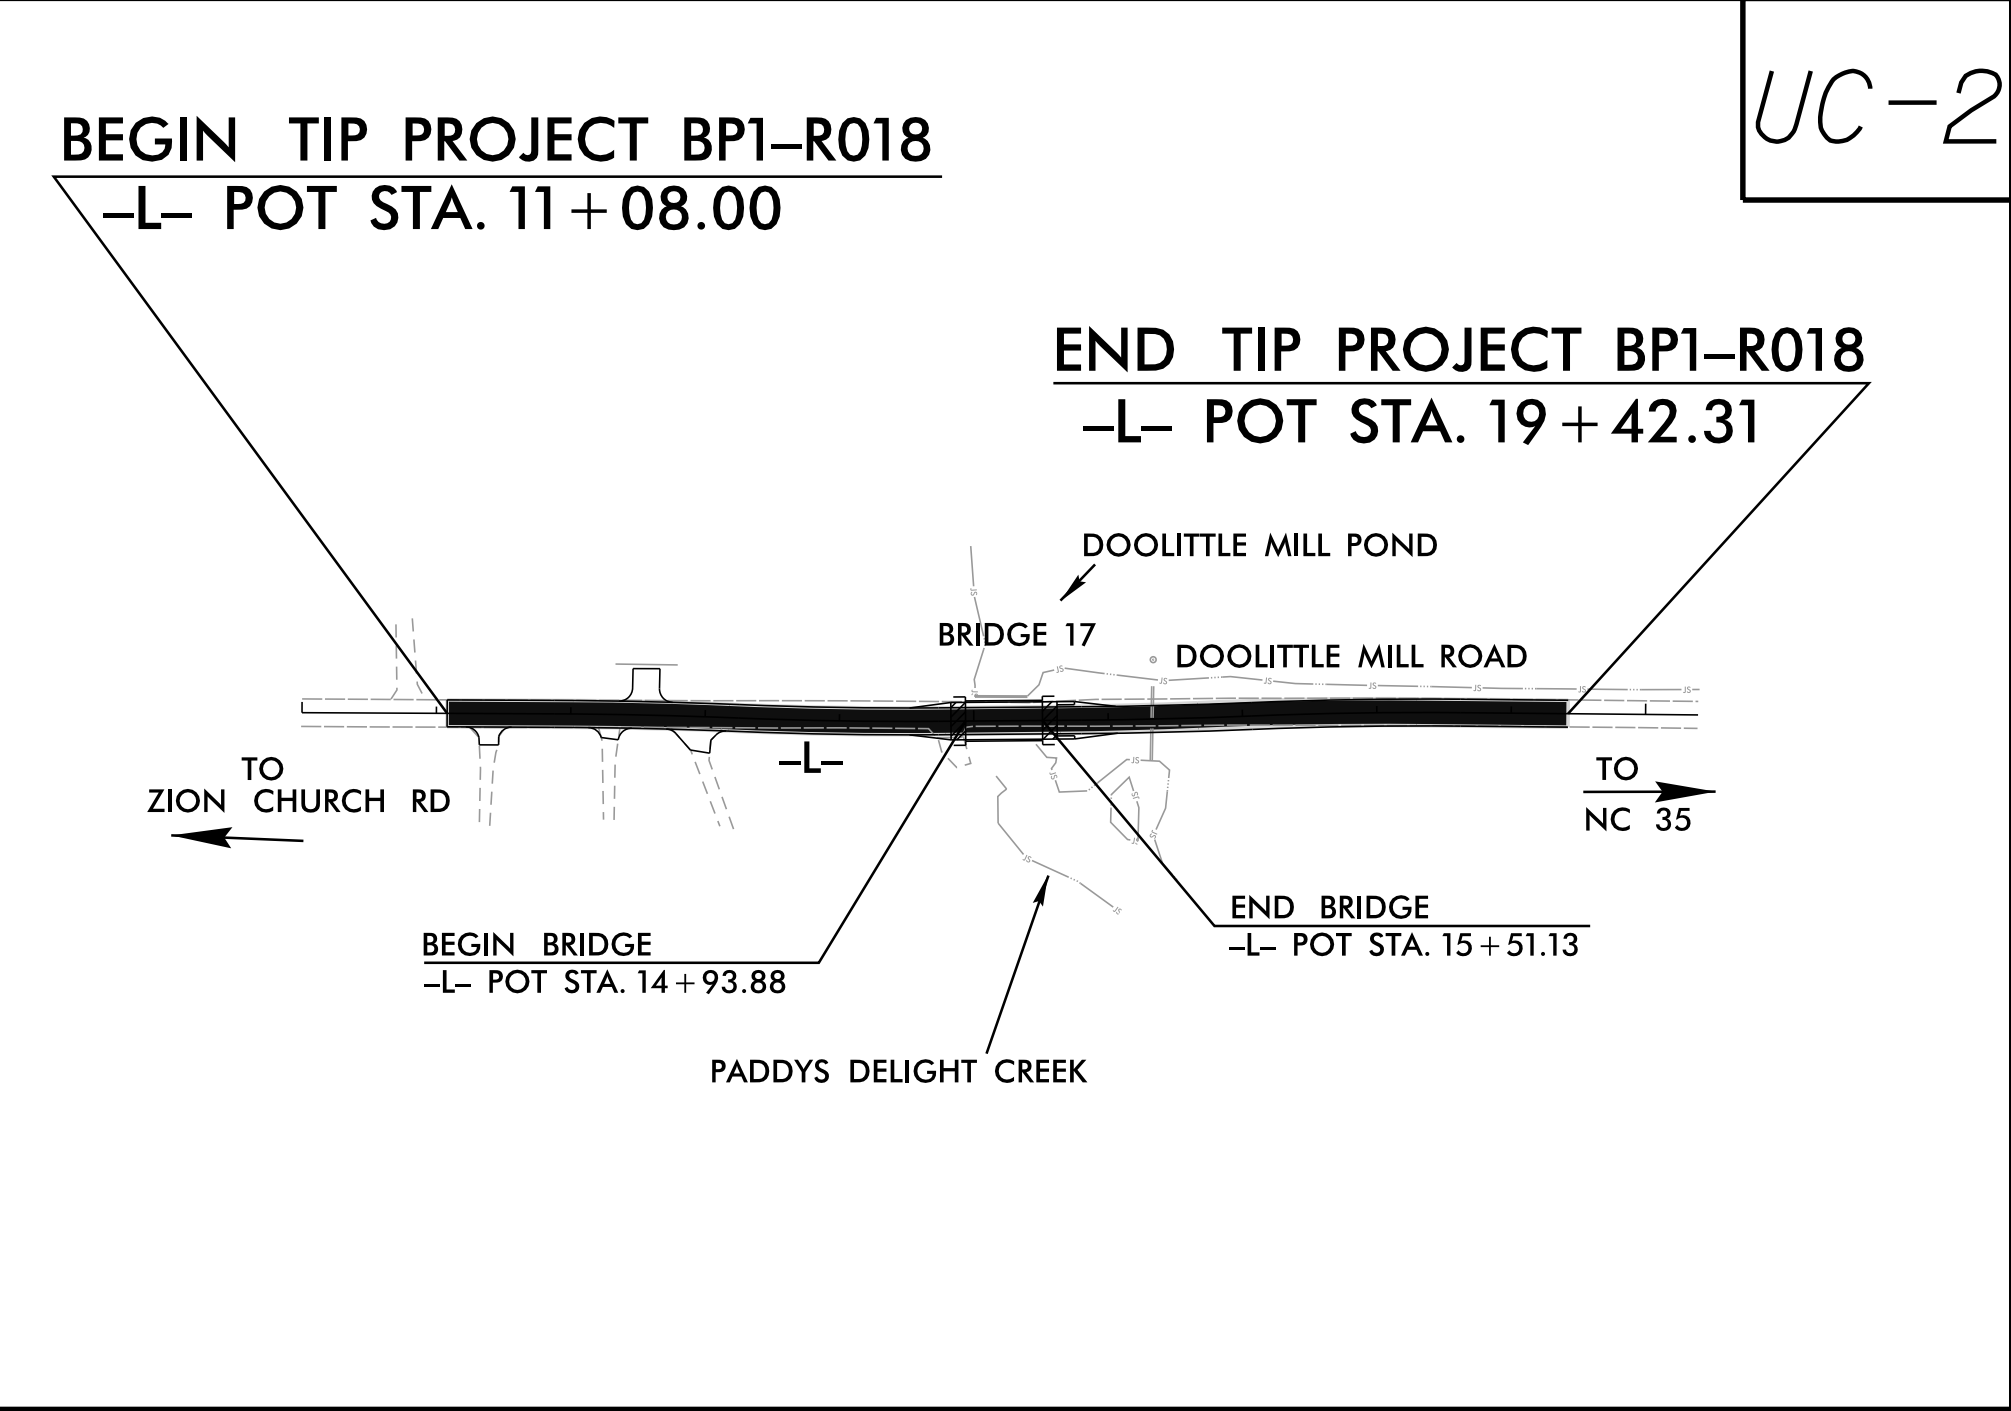

ALL WORK ASSOCIATED WITH THE INSTALLATION OF WATER MAINS  
SHALL BE IN ACCORDANCE WITH THE NCDOT STANDARD  
SPECIFICATIONS FOR ROADS AND BRIDGES, LATEST EDITION.

DOCUMENT NOT CONSIDERED FINAL  
UNLESS ALL SIGNATURES COMPLETED

<p><b>GRAPHIC SCALES</b></p> <p>50 25 0 50 100 PLANS</p> <p>50 25 0 50 100 PROFILE (HORIZONTAL)</p> <p>10 5 0 10 20 PROFILE (VERTICAL)</p>	<p><b>DESIGN DATA</b></p> <p>AADT 2022 = 500 ADT 2022 = N/A K = N/A % D = N/A % T = N/A % * V = 50 MPH FUNC CLASS = LOCAL</p> <p>SUBREGIONAL TIER DESIGN GUIDELINES</p>	<p><b>WATER AND SEWER OWNERS ON PROJECT</b></p> <p>NORTHAMPTON COUNTY PUBLIC WORKS DEPARTMENT</p> <p><b>LENGTH OF WATER MAINS ON PROJECT</b></p> <p>10" WATER MAIN – 100 LF</p>	<p>Prepared for the North Carolina Department of Transportation In the Office of:</p> <p><b>vhb</b> 940 Main Campus Drive, Suite 500 Raleigh, NC 27606 NC License No. C-3705</p> <p>2024 STANDARD SPECIFICATIONS</p> <p><b>RIGHT OF WAY DATE:</b> August 28, 2025</p> <p><b>LETTING DATE:</b> May 20, 2026</p> <p><b>NCDOT CONTACT</b></p>	<p><b>UTILITIES DESIGN ENGINEER</b></p> <p>4/1/2026</p> <p><b>GREGORY K. ATKINS, PE</b> UTILITIES PROJECT ENGINEER</p> <p><b>JOHN M. KAMPRATH, PE</b> UTILITIES PROJECT DESIGN ENGINEER</p> <p><b>RYAN L. SHOOK</b> PROJECT ENGINEER-ROADWAY DESIGN</p>	<p><b>UTILITIES DESIGN ENGINEER</b></p> <p>4/1/2026</p> <p><b>GREGORY K. ATKINS</b> P.E.</p>	<p><b>DIVISION OF HIGHWAYS DIVISION 1</b></p> <p>113 AIRPORT DRIVE SUITE 100 EDENTON, NC 27932</p> <p><b>STEPHEN G. SEALY –</b> DIVISION UTILITIES ENGINEER</p> <p><b>DANIEL MERRITT –</b> DIVISION UTILITIES COORDINATOR</p>
--	---	---	--	---	--	---