


CONTRACT: DA-00701

TIP PROJECT: FF-0001A

NCDOT HATTERAS FERRY DOCK REPLACEMENT

LOCATION:Hatteras Island, NC

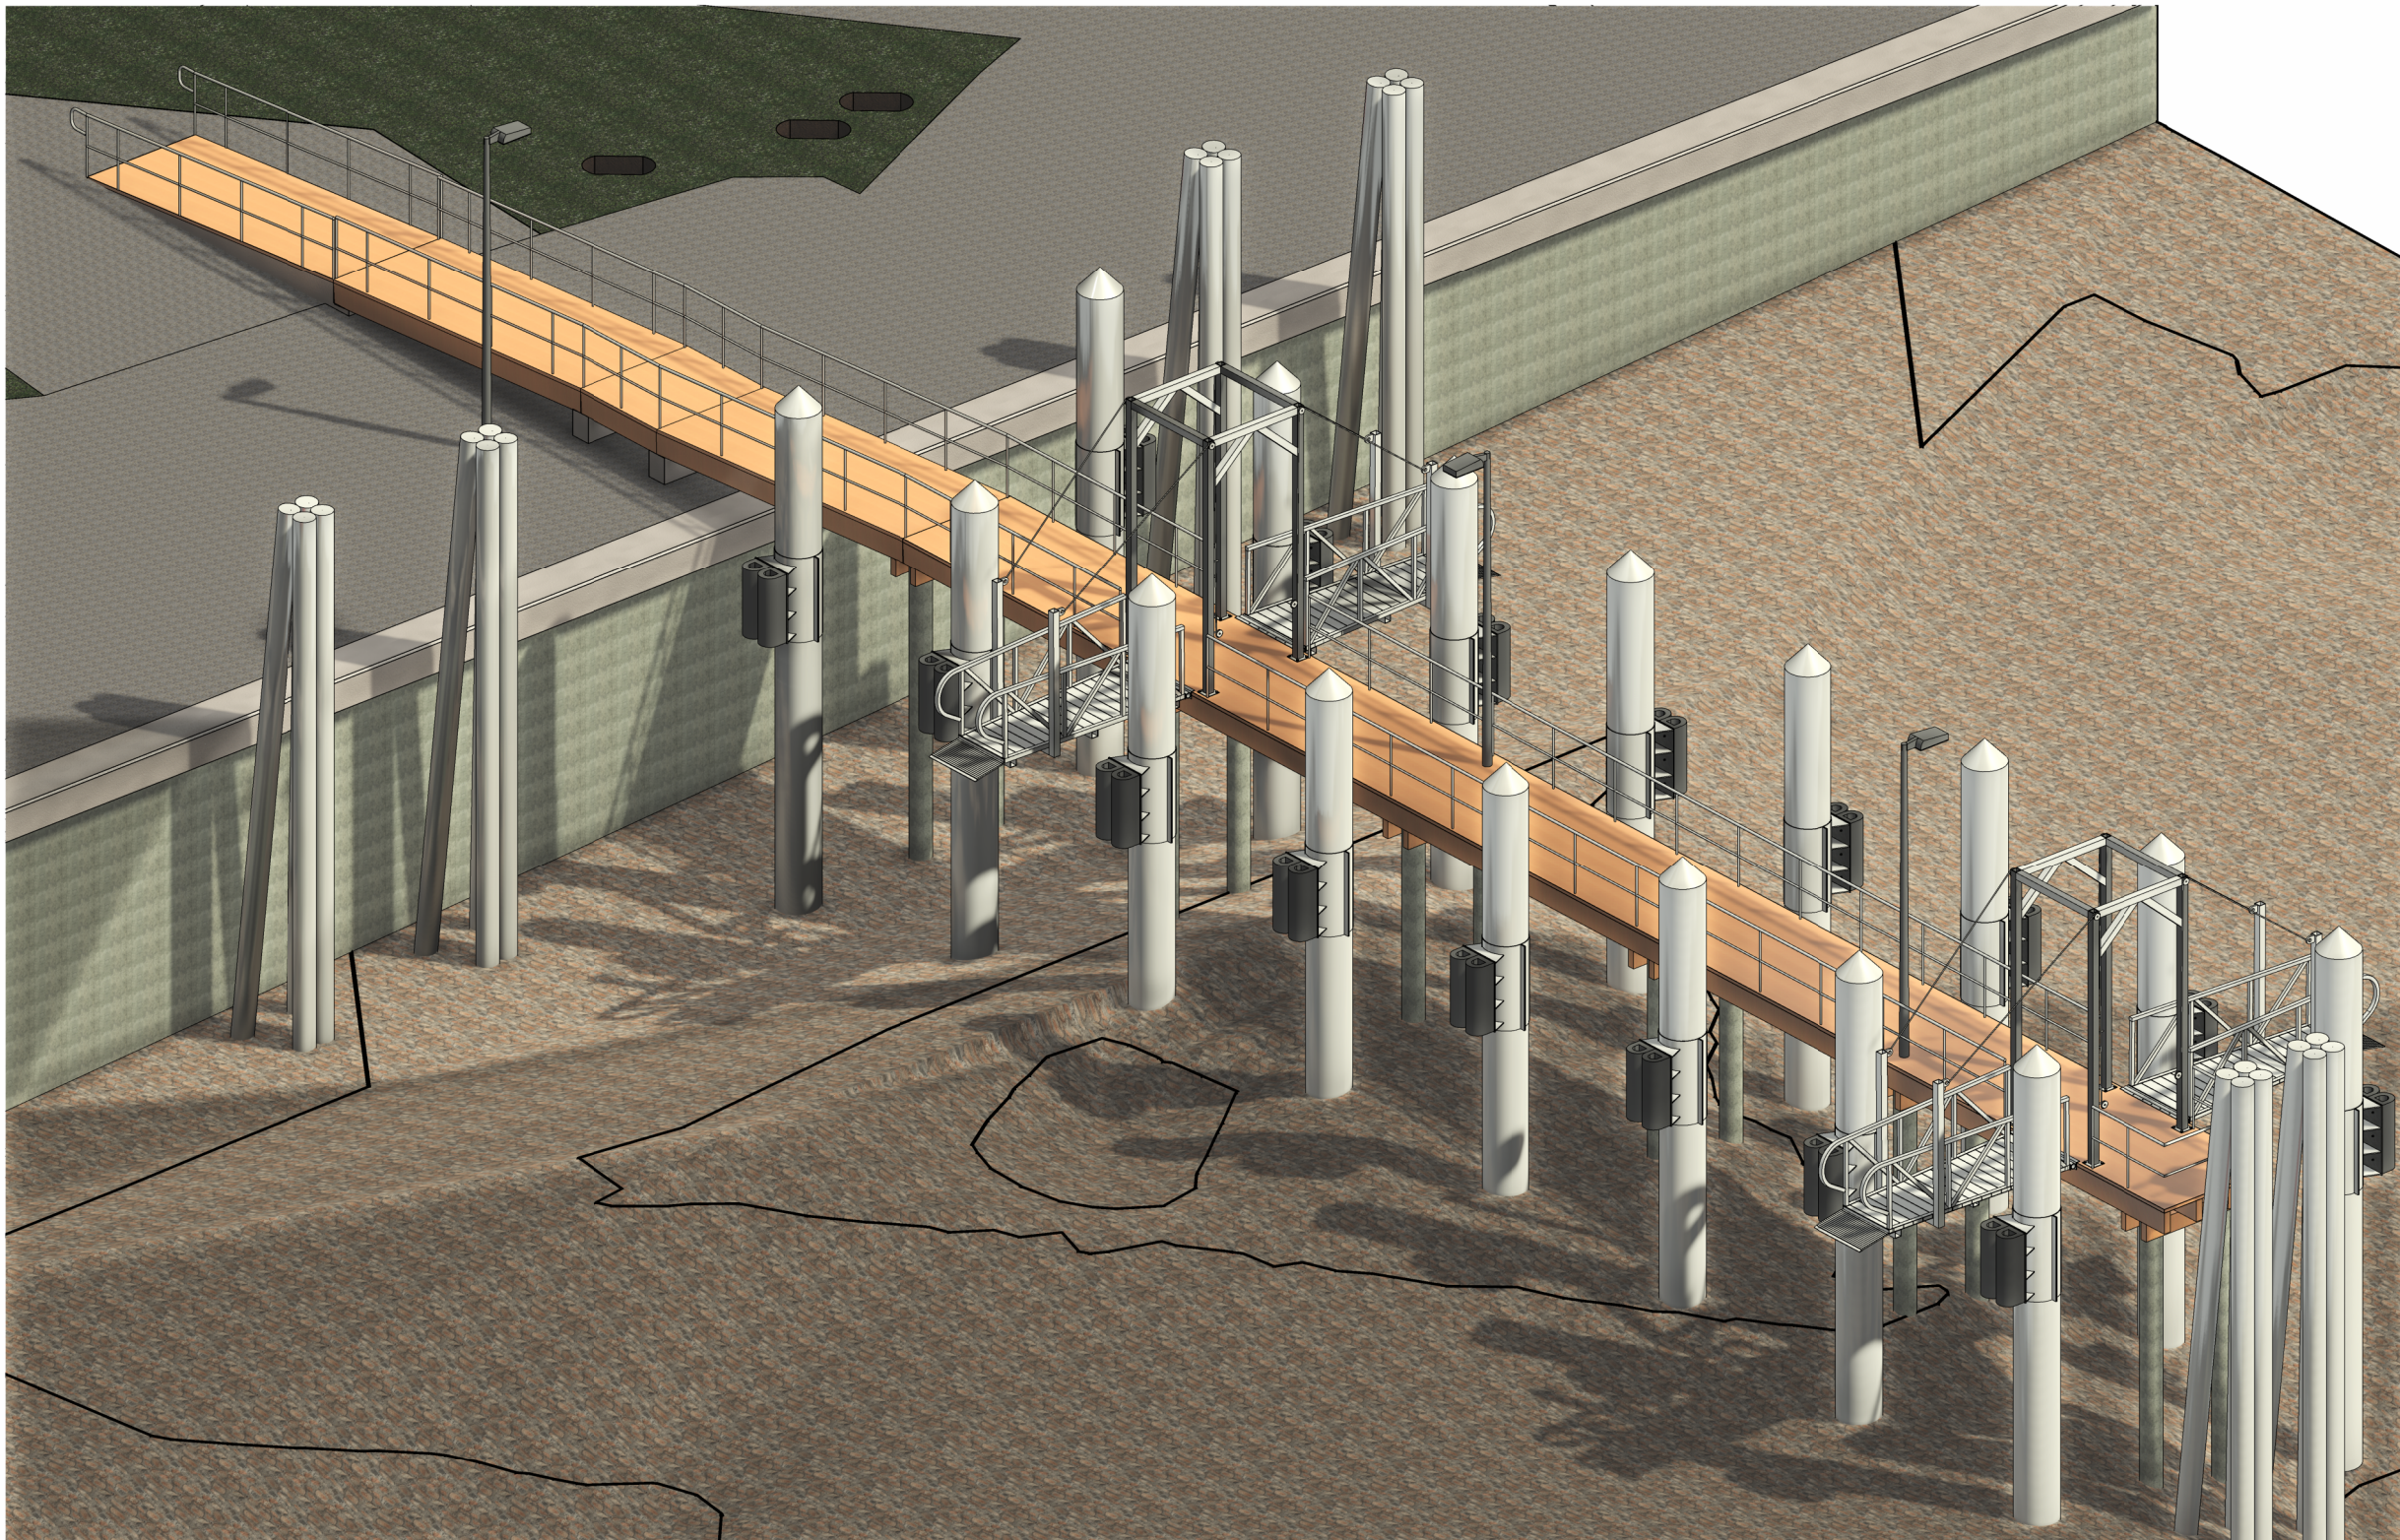

3D VIEW

MARINE DISCIPLINE		
1	G-001	COVER SHEET
2	G-002	MARINE GENERAL NOTES (1 OF 2)
3	G-003	MARINE GENERAL NOTES (2 OF 2)
4	D-101	EXISTING CONDITIONS AND DEMOLITION PLAN
5	D-102	NOT USED
6	D-103	NOT USED
7	M-101	MARINE OVERALL SITE PLAN
8	M-102	FOUNDATION AND PILE LAYOUT PLAN
9	M-103	PIER FRAMING PLAN
10	M-301	LONGITUDINAL SECTION & ELEVATION
11	M-302	TRANSVERSE SECTION
12	M-401	HOIST FRAME DETAILS
13	M-501	MISCELLANEOUS DETAILS (1 OF 5)
14	M-502	MISCELLANEOUS DETAILS (2 OF 5)
15	M-503	MISCELLANEOUS DETAILS (3 OF 5)
16	M-504	MISCELLANEOUS DETAILS (4 OF 5)
17	M-505	MISCELLANEOUS DETAILS (5 OF 5)

CIVIL DISCIPLINE		
18	C-101	WATER SERVICE PLAN
19	C-102	WATER SERVICE DETAILS
20	C-103	EROSION CONTROL DETAILS

ELECTRICAL DISCIPLINE		
21	E-001	ELECTRICAL LEGEND AND NOTES 1
22	E-002	ELECTRICAL LEGEND AND NOTES 2
23	E-003	ELECTRICAL DIAGRAMS
24	E-004	ELECTRICAL SCHEDULES
25	E-100	ELECTRICAL SITE PLAN
26	E-900	ELECTRICAL LIGHTING DETAILS

M

M

MOTT
MACDONALD

930 Main Campus Drive,
Suite 200
Raleigh, NC 27606
License No. F-0669
T +1 (919) 552 2253
F +1 (919) 552 2254
www.mottmacamericas.com

GRAPHIC SCALE

PROJECT ENGINEER

DESIGNED BY

JAVIER QUIROS

COUNTY

DARE COUNTY

ENTERED BY

VICTOR PADILLA

DIVISION

FERRY DIVISION

PROJECT ENGINEER

KRISTOPHER PAGAN

PLAN DATE

1-14-26

PROJECT MANAGER

ALLISON THORBURN

Rev.

Date

Drawn

Description

Ch'kd

App'd

SEAL

044825

ENGINEER


PHERNANDO PAGAN-CRUIZ

NCDOT HATTERAS FERRY DOCK REPLACEMENT

G-001 COVER SHEET

STATE	STATE PROJECT REFERENCE NO.	SHEET NO.	TOTAL SHEETS
		1	26
STATE PROJ. NO.		F. A. PROJ. NO.	DESCRIPTION
50801.1.2		5080111	PE
50801.3.2		5080111	CON

NCDOT HATTERAS FERRY DOCK REPLACEMENT PROJECT

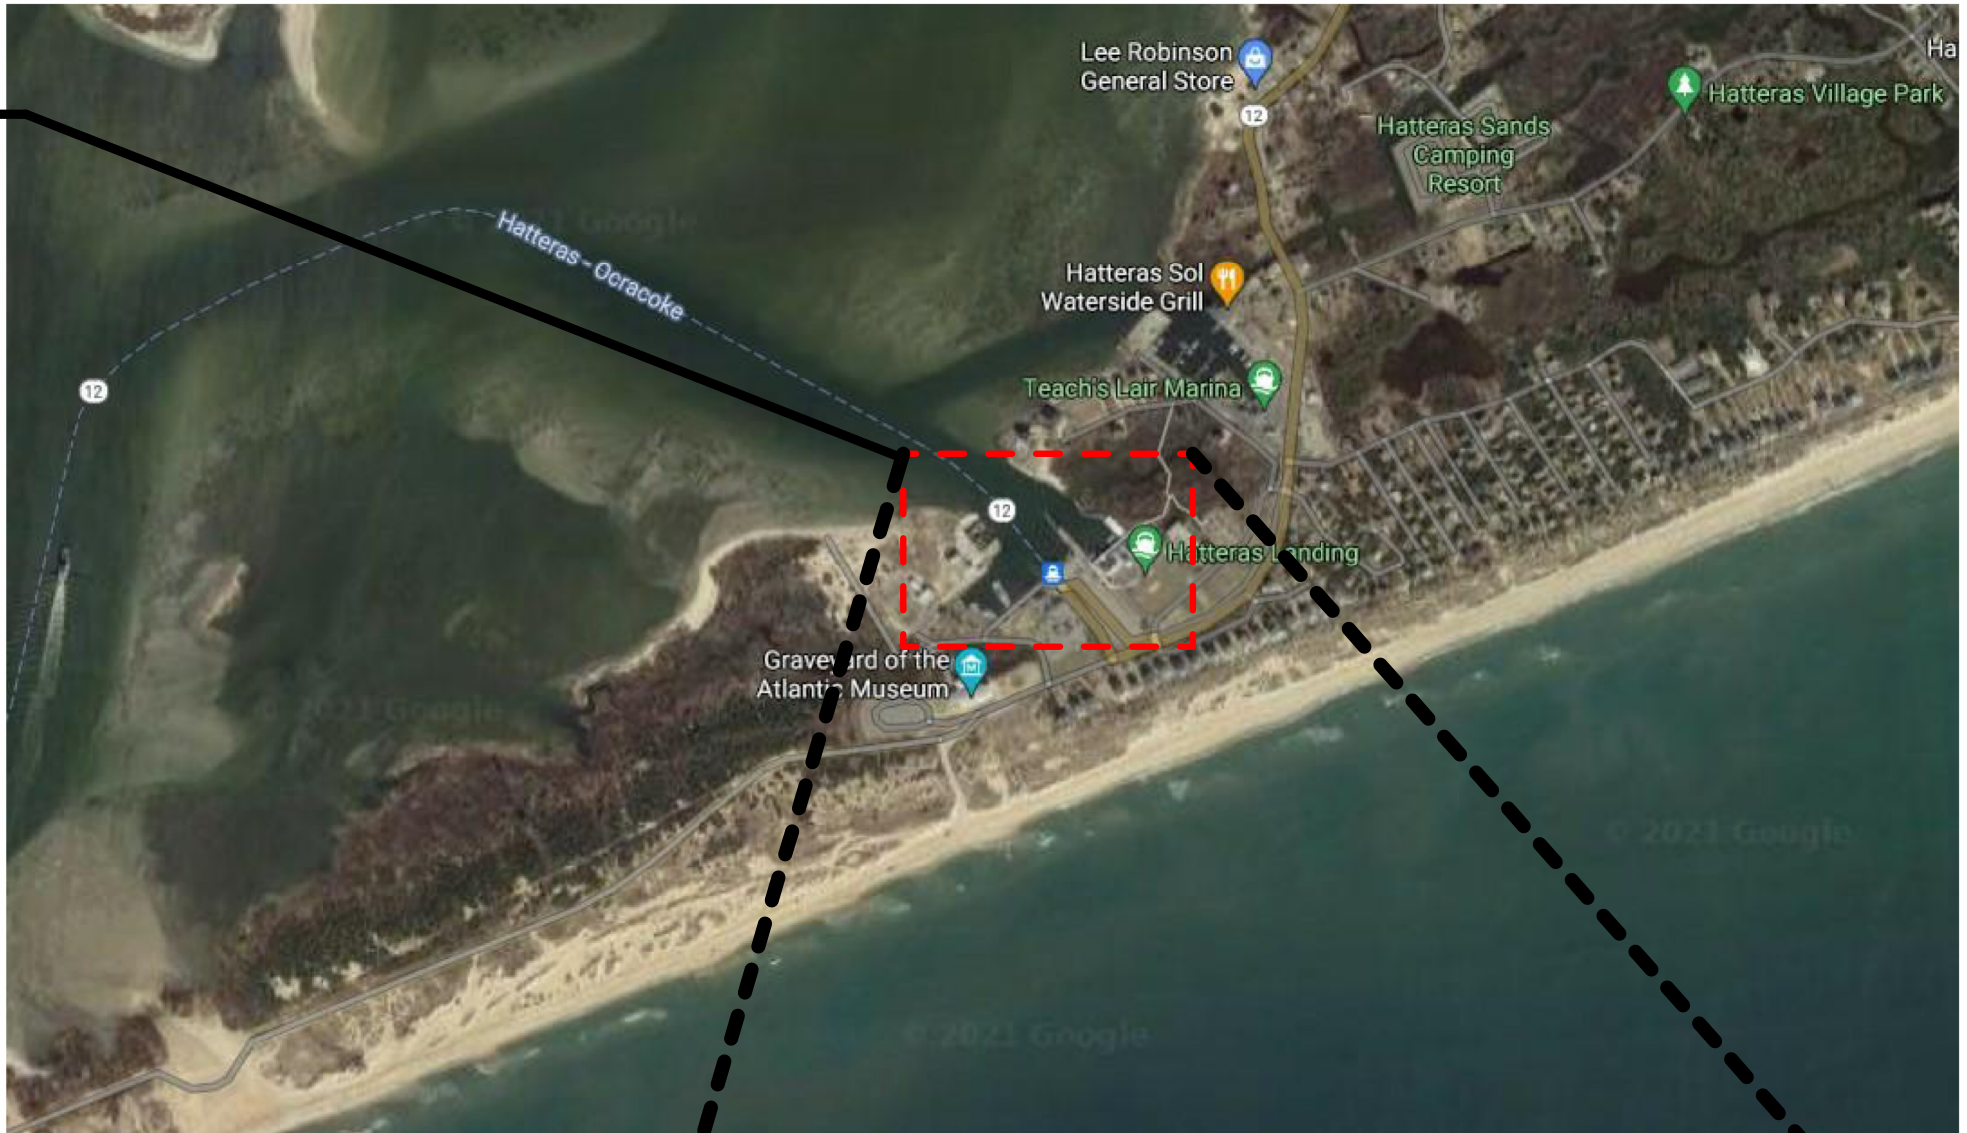

LOCATION MAP

NCDOT HATTERAS FERRY DOCK REPLACEMENT PROJECT



VICINITY MAP