
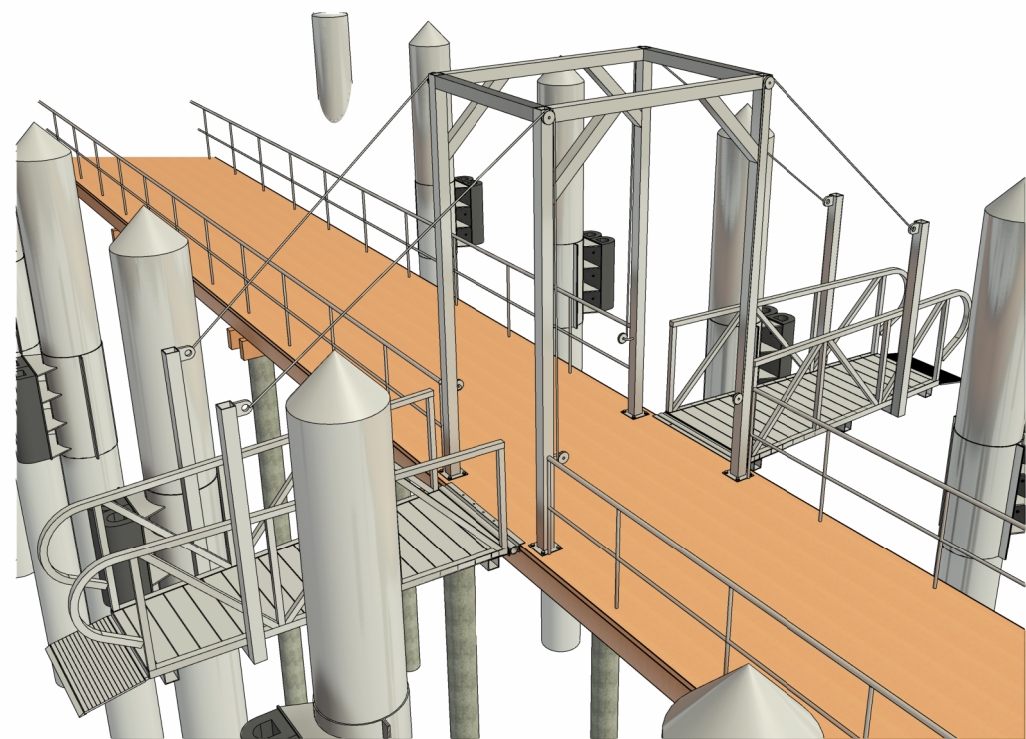
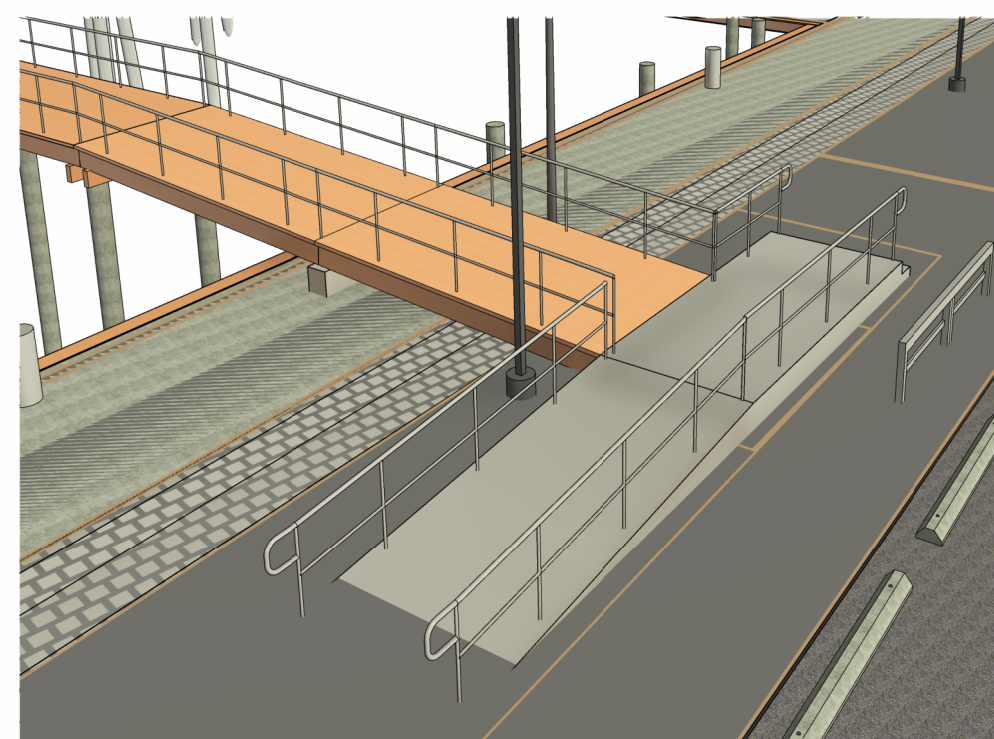


CONTRACT: DA-00701

TIP PROJECT: FF-0001A

# NCDOT PASSENGER FERRY DOCK REPLACEMENT - OCRACOKE ISLAND

LOCATION:Ocracoke Island, North Carolina

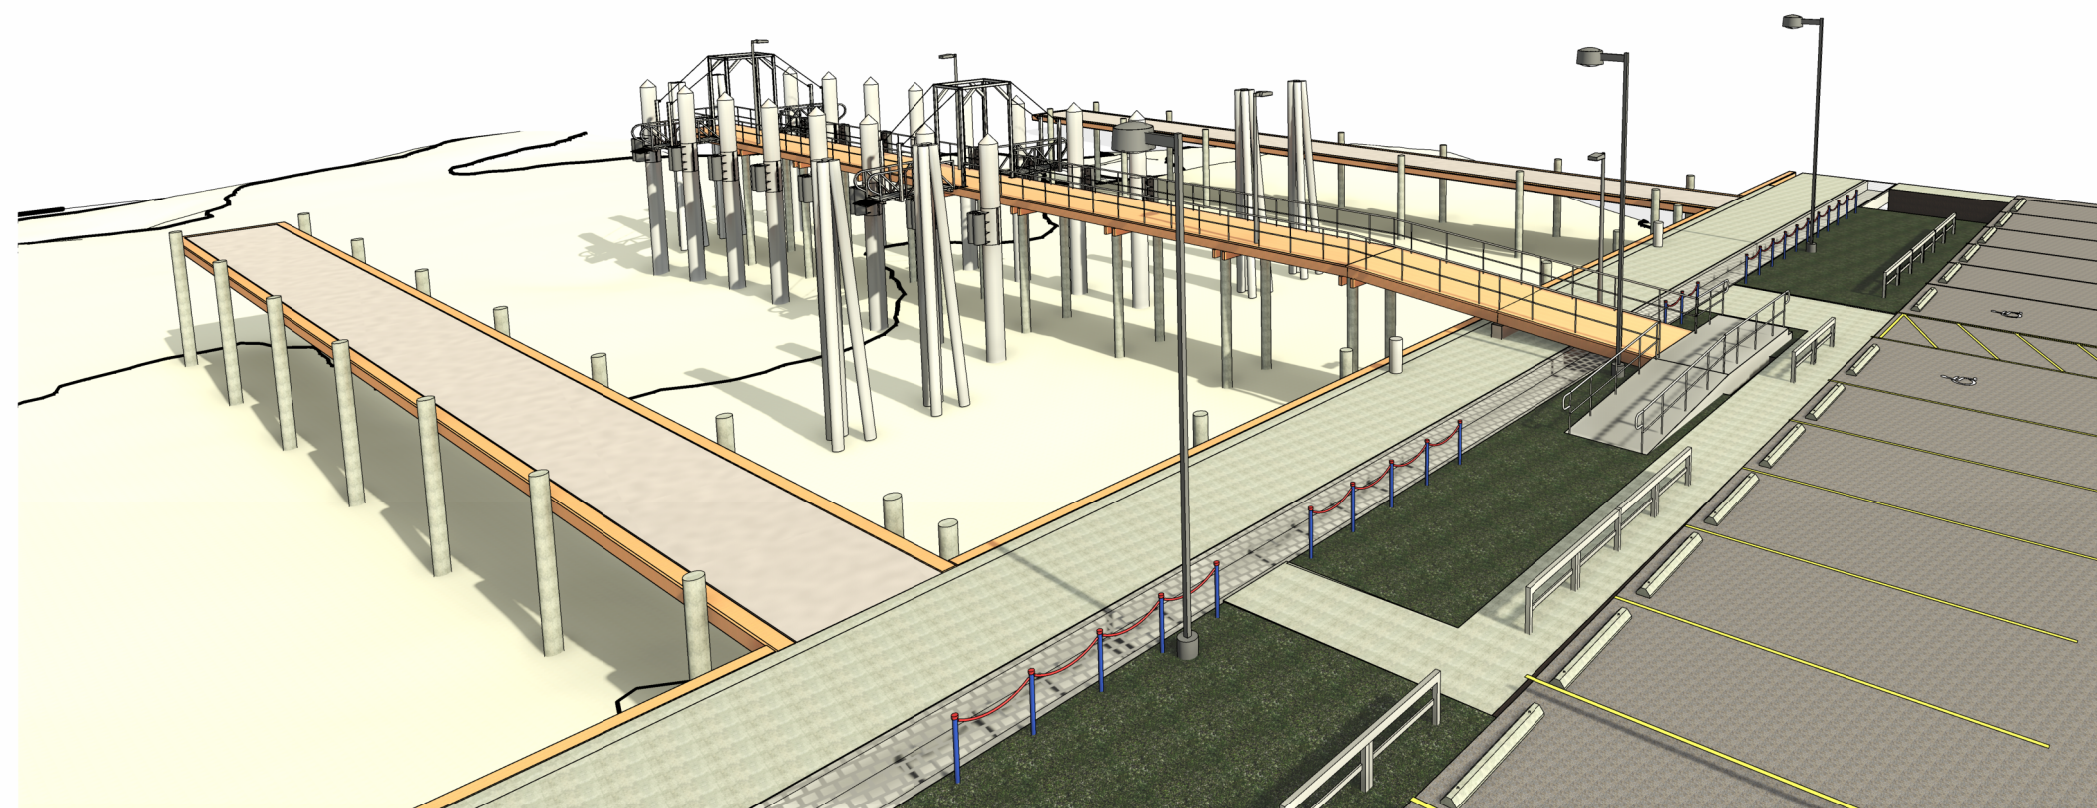

3D VIEWS

| MARINE DISCIPLINE |       |   |
|-------------------|-------|---|
| 1                 | G-001 | COVER SHEET                             |
| 2                 | G-002 | MARINE GENERAL NOTES (1 OF 2)           |
| 3                 | G-003 | MARINE GENERAL NOTES (2 OF 2)           |
| 4                 | D-101 | EXISTING CONDITIONS AND DEMOLITION PLAN |
| 5                 | M-101 | MARINE OVERALL SITE PLAN                |
| 6                 | M-102 | FOUNDATION AND PILE LAYOUT PLAN         |
| 7                 | M-103 | PIER FRAMING PLAN                       |
| 8                 | M-301 | LONGITUDINAL SECTION & ELEVATION        |
| 9                 | M-302 | TRANSVERSE SECTION                      |
| 10                | M-401 | HOIST FRAME DETAILS                     |
| 11                | M-501 | MISCELLANEOUS DETAILS (1 OF 5)          |
| 12                | M-502 | MISCELLANEOUS DETAILS (2 OF 5)          |
| 13                | M-503 | MISCELLANEOUS DETAILS (3 OF 5)          |
| 14                | M-504 | MISCELLANEOUS DETAILS (4 OF 5)          |
| 15                | M-505 | MISCELLANEOUS DETAILS (5 OF 5)          |

| CIVIL DISCIPLINE |       |                         |
|------------------|-------|-------------------------|
| 16               | C-101 | EROSION CONTROL DETAILS |

| ELECTRICAL DISCIPLINE |       |                                   |
|-----------------------|-------|-----------------------------------|
| 17                    | E-001 | ELECTRICAL LEGEND AND NOTES 1     |
| 18                    | E-002 | ELECTRICAL LEGEND AND NOTES 2     |
| 19                    | E-003 | ELECTRICAL DIAGRAMS AND SCHEDULES |
| 20                    | E-100 | ELECTRICAL SITE PLAN              |
| 21                    | E-101 | ENLARGED ELECTRICAL SITE PLAN     |
| 22                    | E-900 | ELECTRICAL LIGHTING DETAILS       |

M

M

MOTT  
MACDONALD

930 Main Campus Drive,  
Suite 200  
Raleigh, NC 27606  
License No. F-0669  
T +1 (919) 552 2253  
F +1 (919) 552 2254  
www.mottmacamericas.com

GRAPHIC SCALE


| PROJECT ENGINEER |                  |           |                |
|------------------|------------------|-----------|----------------|
| Designed By      | JAVIER QUIROS    | County    | HYDE COUNTY    |
| Entered By       | VICTOR PADILLA   | Division  | FERRY DIVISION |
| Project Engineer | KRISTOPHER PAGAN | Plan Date | 1-14-26        |
| Project Manager  | ALLISON THORBURN |           |                |
|                  |                  |           |                |
|                  |                  |           |                |
|                  |                  |           |                |
| Rev.             | Date             | Drawn     | Description    |
|                  |                  |           | Ch'k'd App'd   |

NCDOT PASSENGER FERRY  
DOCK REPLACEMENT -  
OCRACOKE ISLAND

G-001 COVER SHEET

| STATE           | STATE PROJECT REFERENCE NO. | SHEET NO.       | TOTAL SHEETS |
|-----------------|-----------------------------|-----------------|--------------|
|                 |                             | 1               | 22           |
| STATE PROJ. NO. |                             | F. A. PROJ. NO. | DESCRIPTION  |
| 50801.1.2       |                             | 5080111         | PE           |
| 50801.3.2       |                             | 5080111         | CON          |
|                 |                             |                 |              |
|                 |                             |                 |              |

Ocracoke Ferry  
Terminal Project

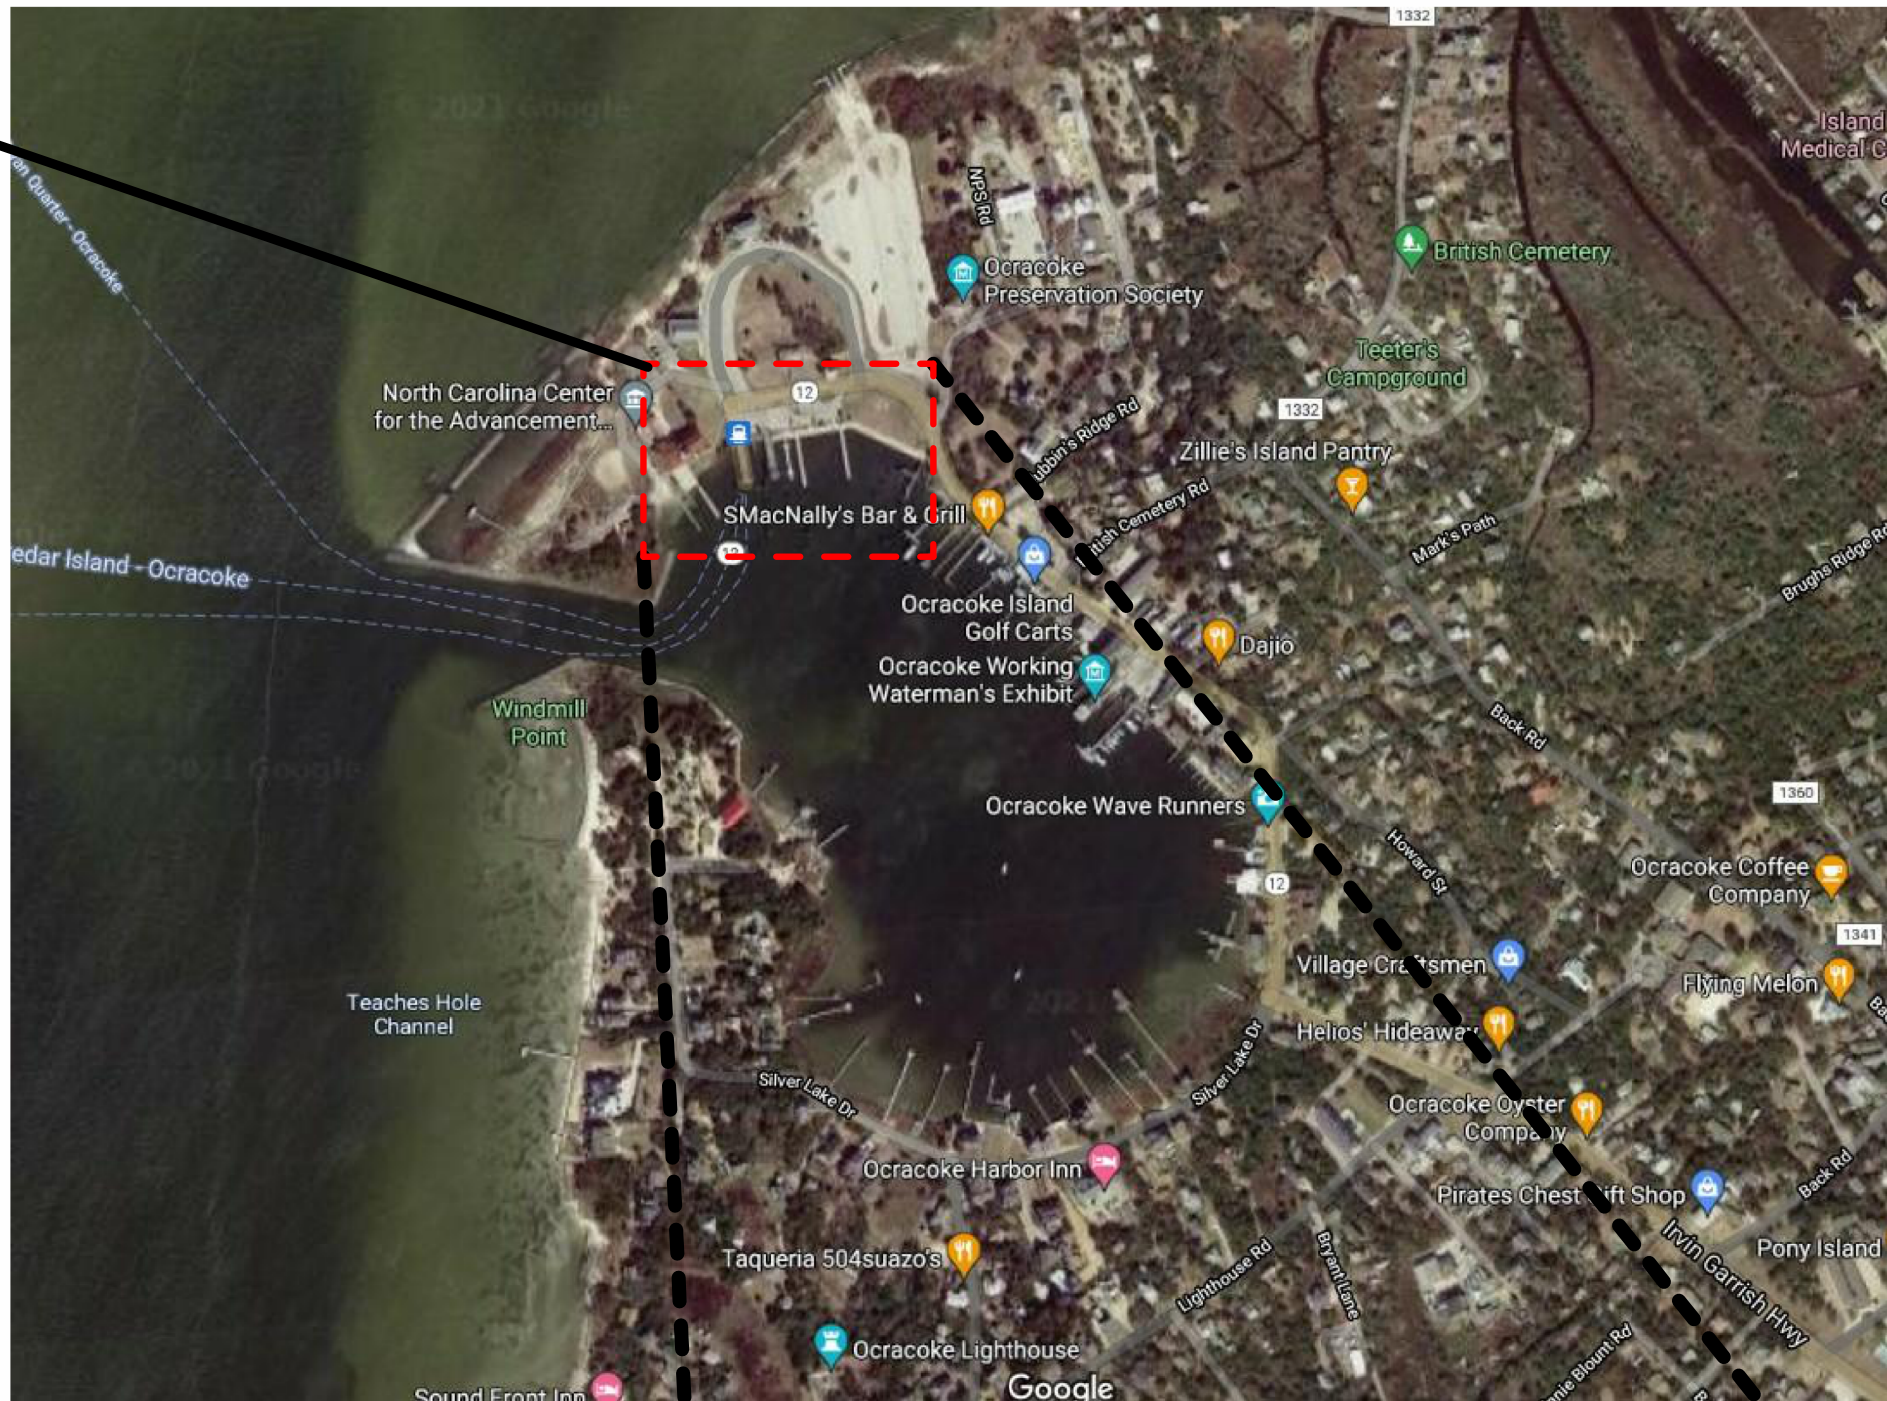

LOCATION MAP

Ocracoke Ferry  
Terminal Project



VICINITY MAP