
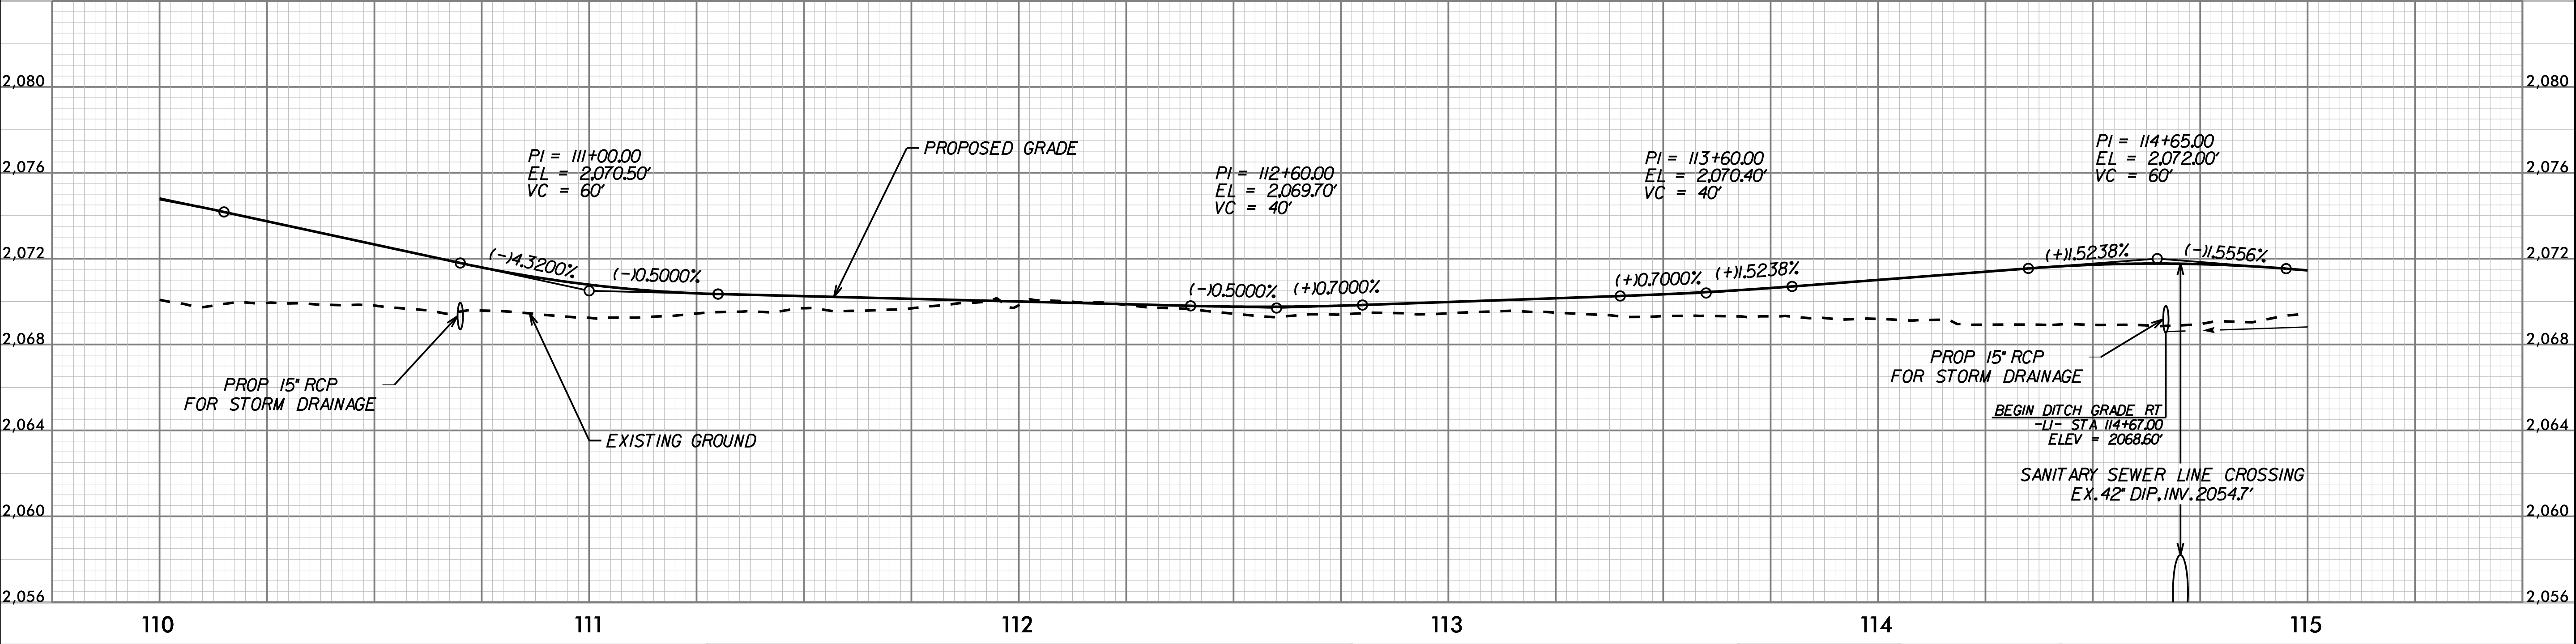


K:\RAL_Roadway\015574013 - BL-0008 Clear Creek Greenway\Proj\Plan Streets\BL-0008_rdy_psh_L0.dgn 11/26/2025

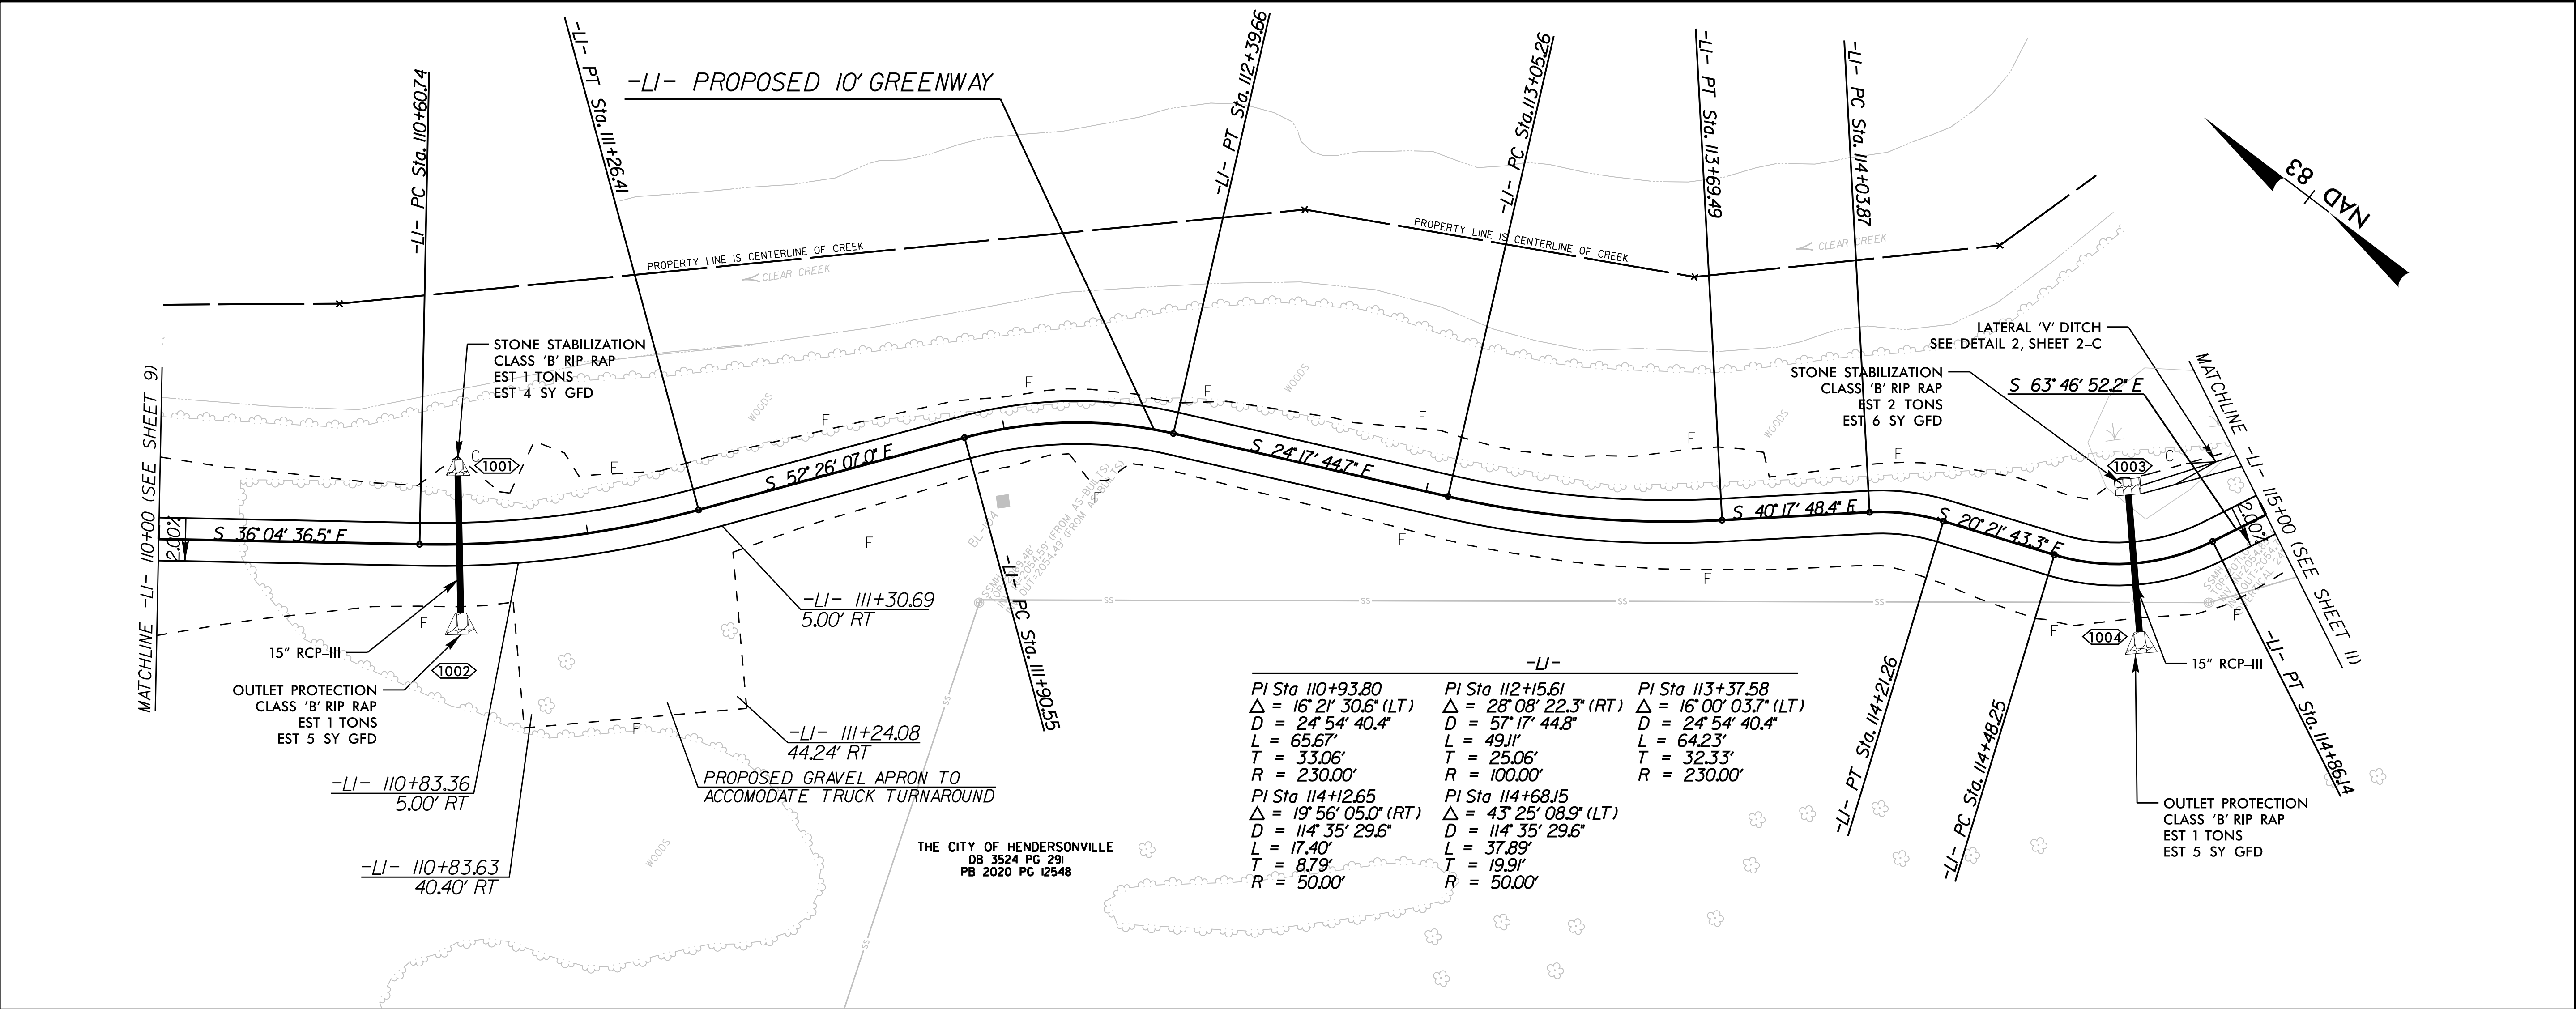

REV. No.	REVISION	DATE	DRAWN BY	CHECKED BY
1				

PREPARED IN THE OFFICE OF:

Kimley»Horn

NC LICENSE #F-0102
200 S TRYON ST, SUITE 200
CHARLOTTE, NORTH CAROLINA 28202
PHONE: (704) 333-5131
© 2025

-L1- PLAN AND PROFILE

PROFESSIONAL ENGINEER
G. GOLDSCHMIDT
052844

10' 0' 20'

PROJECT:

CLEAR CREEK GREENWAY

JOB NUMBER: 015574013 SHEET NUMBER: 10