
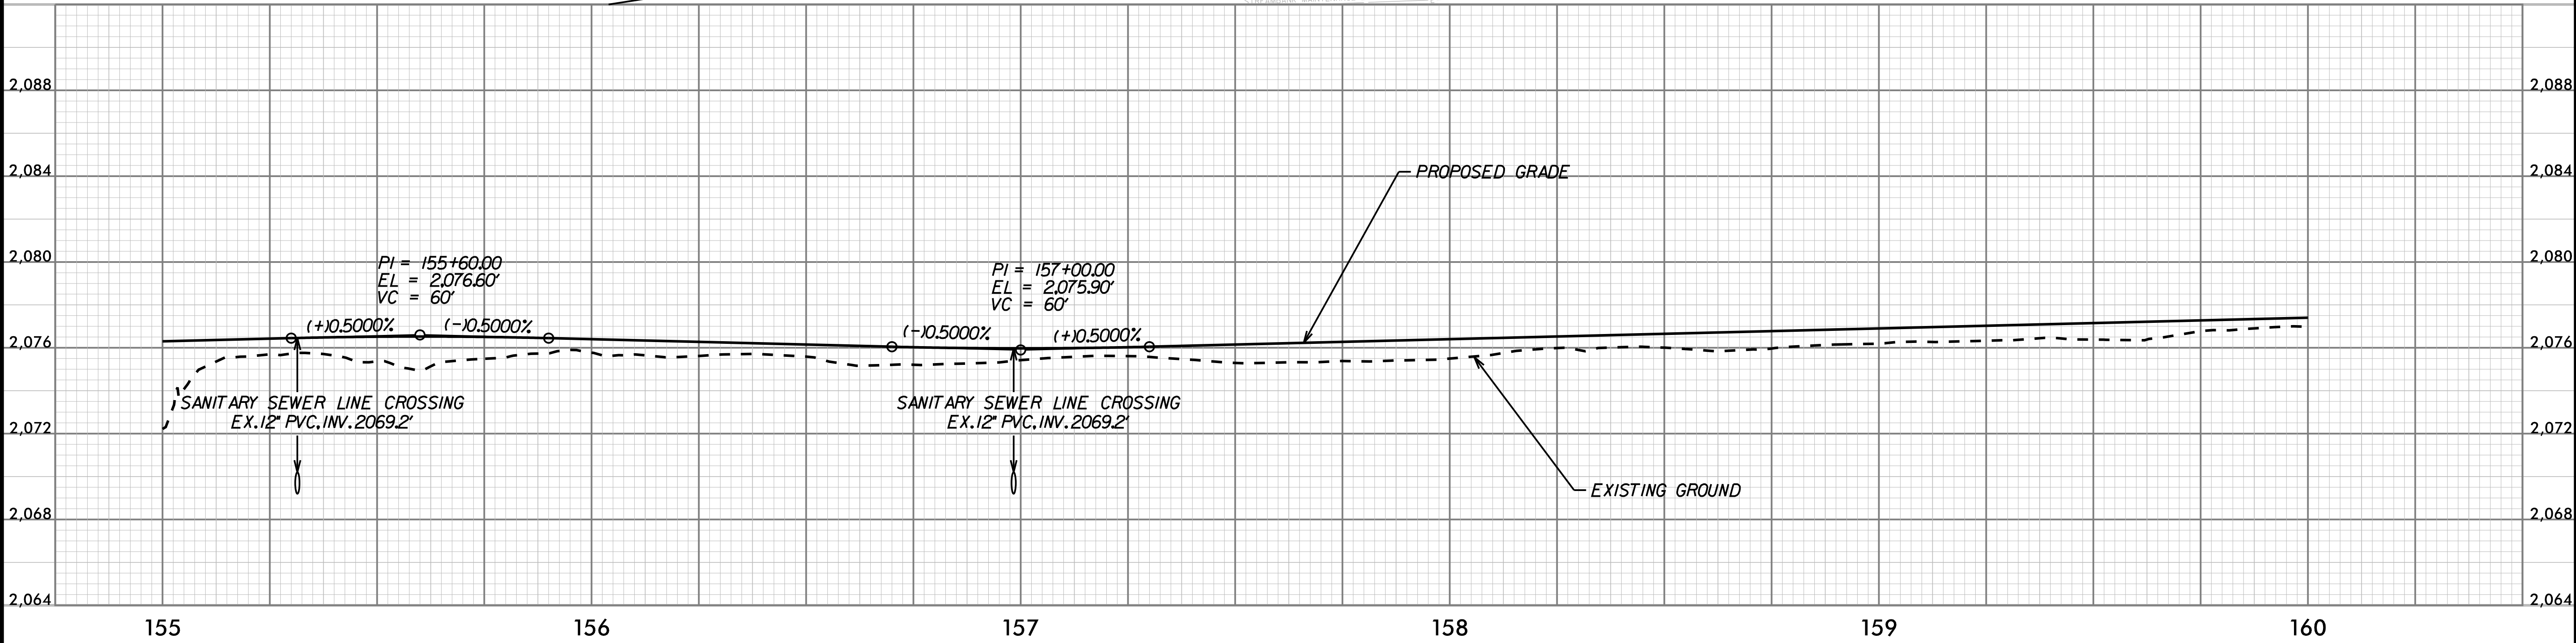


K:\RAL\_Roadway\015574013 - BL-0008 Clear Creek Greenway\Roadway\Proj\Plan Streets\BL-0008\_rdy\_psh\_L19.dgn

11/26/2025

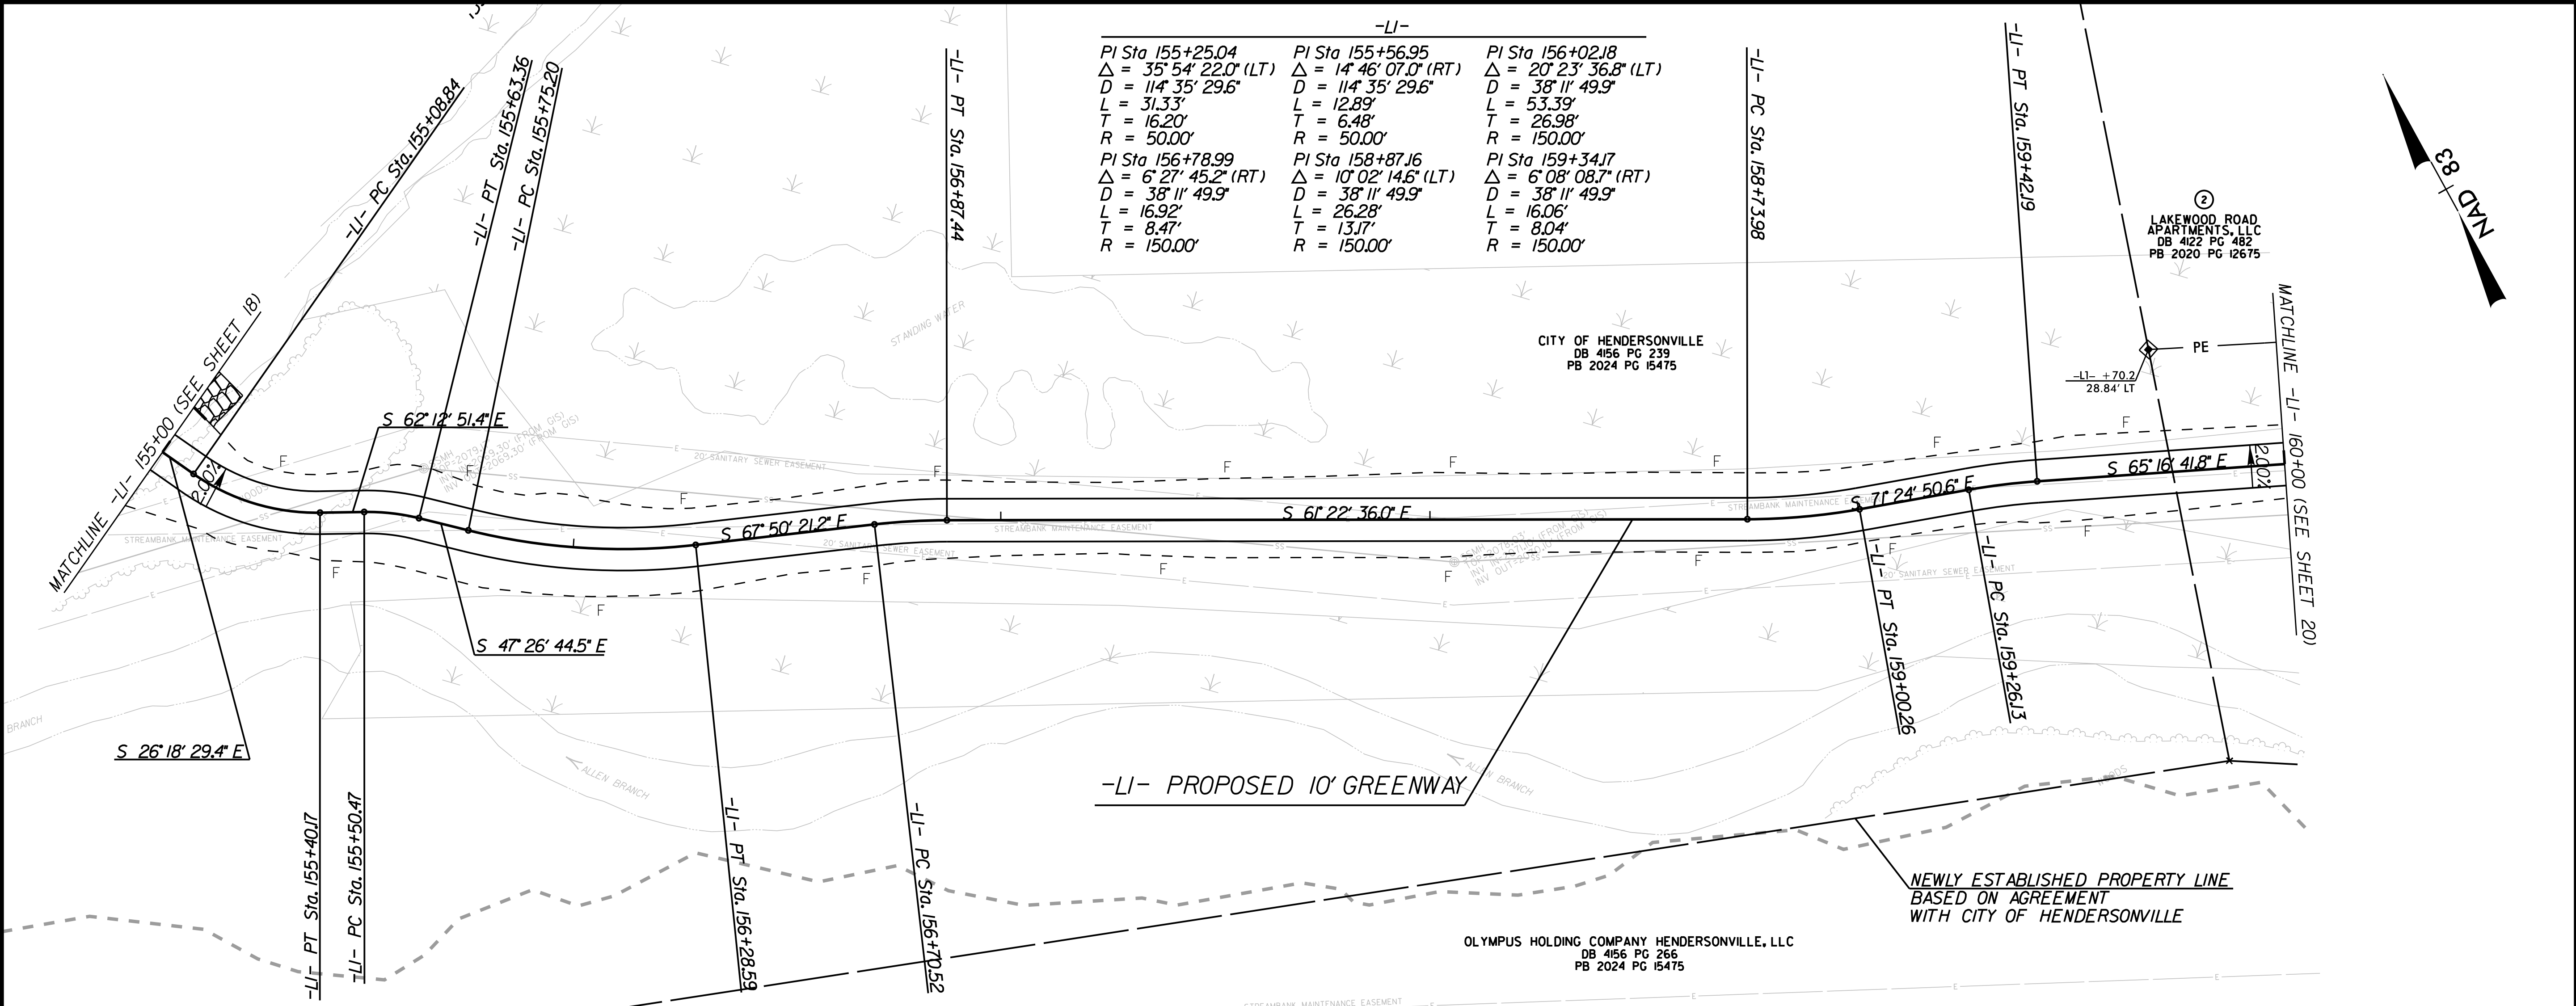

REV. NO.	REVISION	DATE	DRAWN BY	CHECKED BY

PREPARED IN THE OFFICE OF:

**Kimley»Horn**

NC LICENSE #F-0102  
200 S TRYON ST, SUITE 200  
CHARLOTTE, NORTH CAROLINA 28202  
PHONE: (704) 333-5131

© 2025

-L1- PLAN AND PROFILE

Professional Engineer Seal for G. G. G. (G. G. G. is a placeholder for the actual name).

Scale: 1" = 0' = 20'

PROJECT:	CLEAR CREEK GREENWAY
JOB NUMBER:	015574013
SHEET NUMBER:	19