
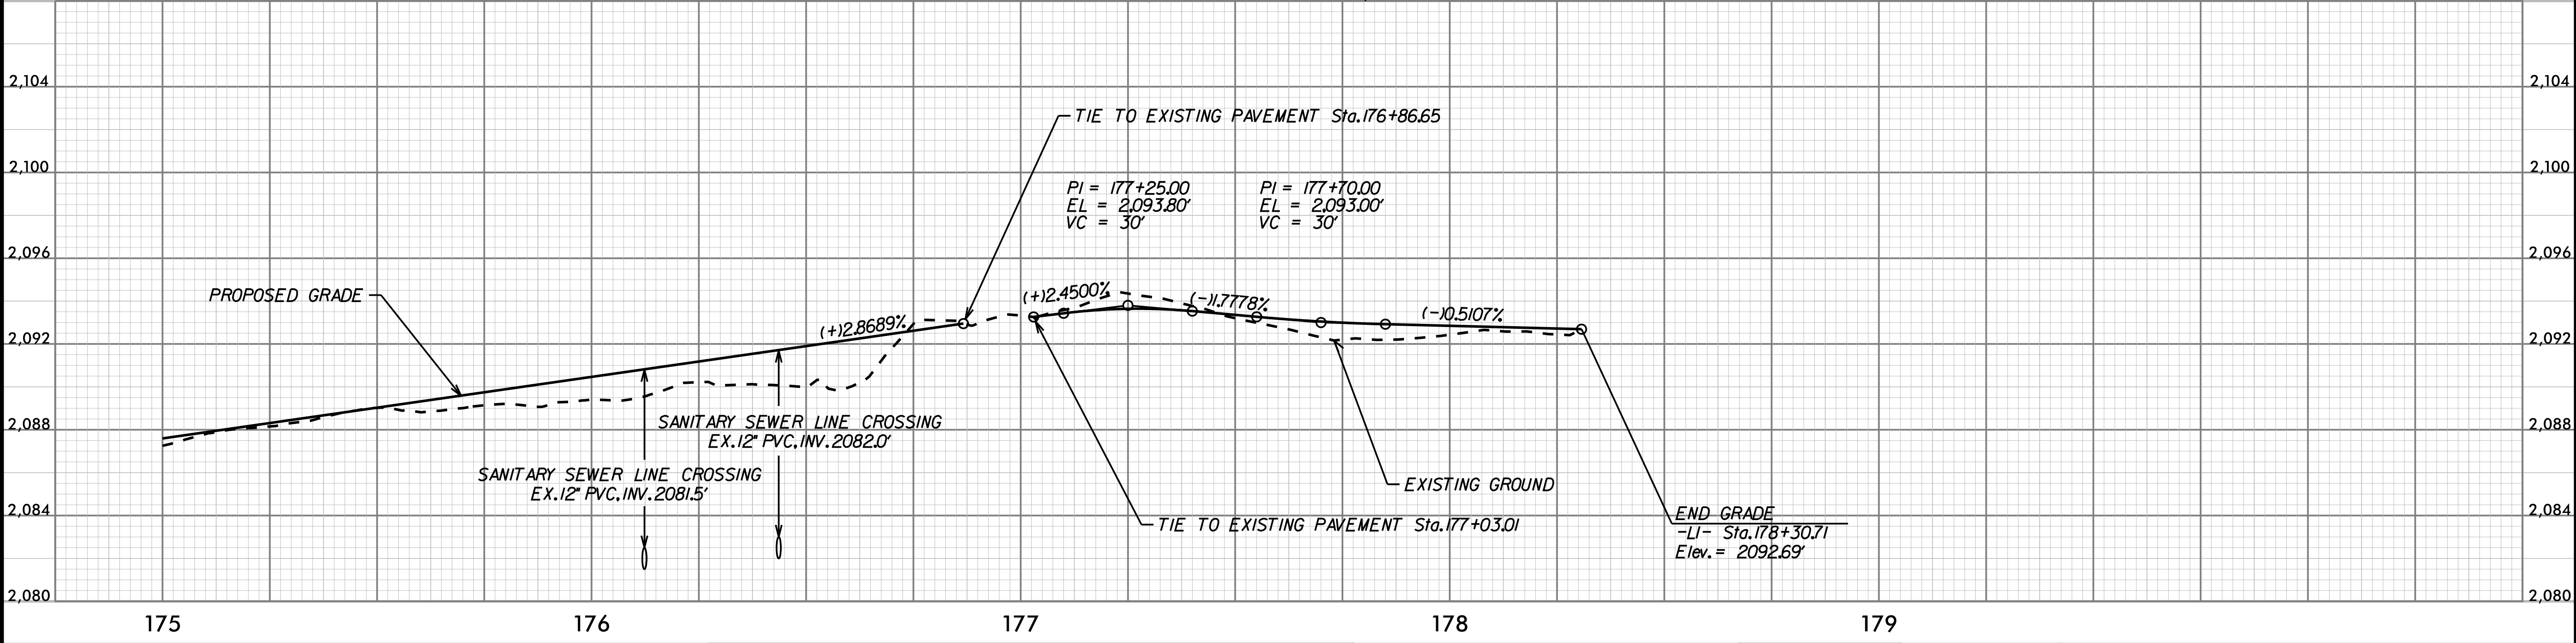


K:\RAL_Roadway\015574013 - BL-0008 Clear Creek Greenway\Roadway\Proj\Plan Streets\BL-0008_rdy_psh_23.dgn
11/26/2025

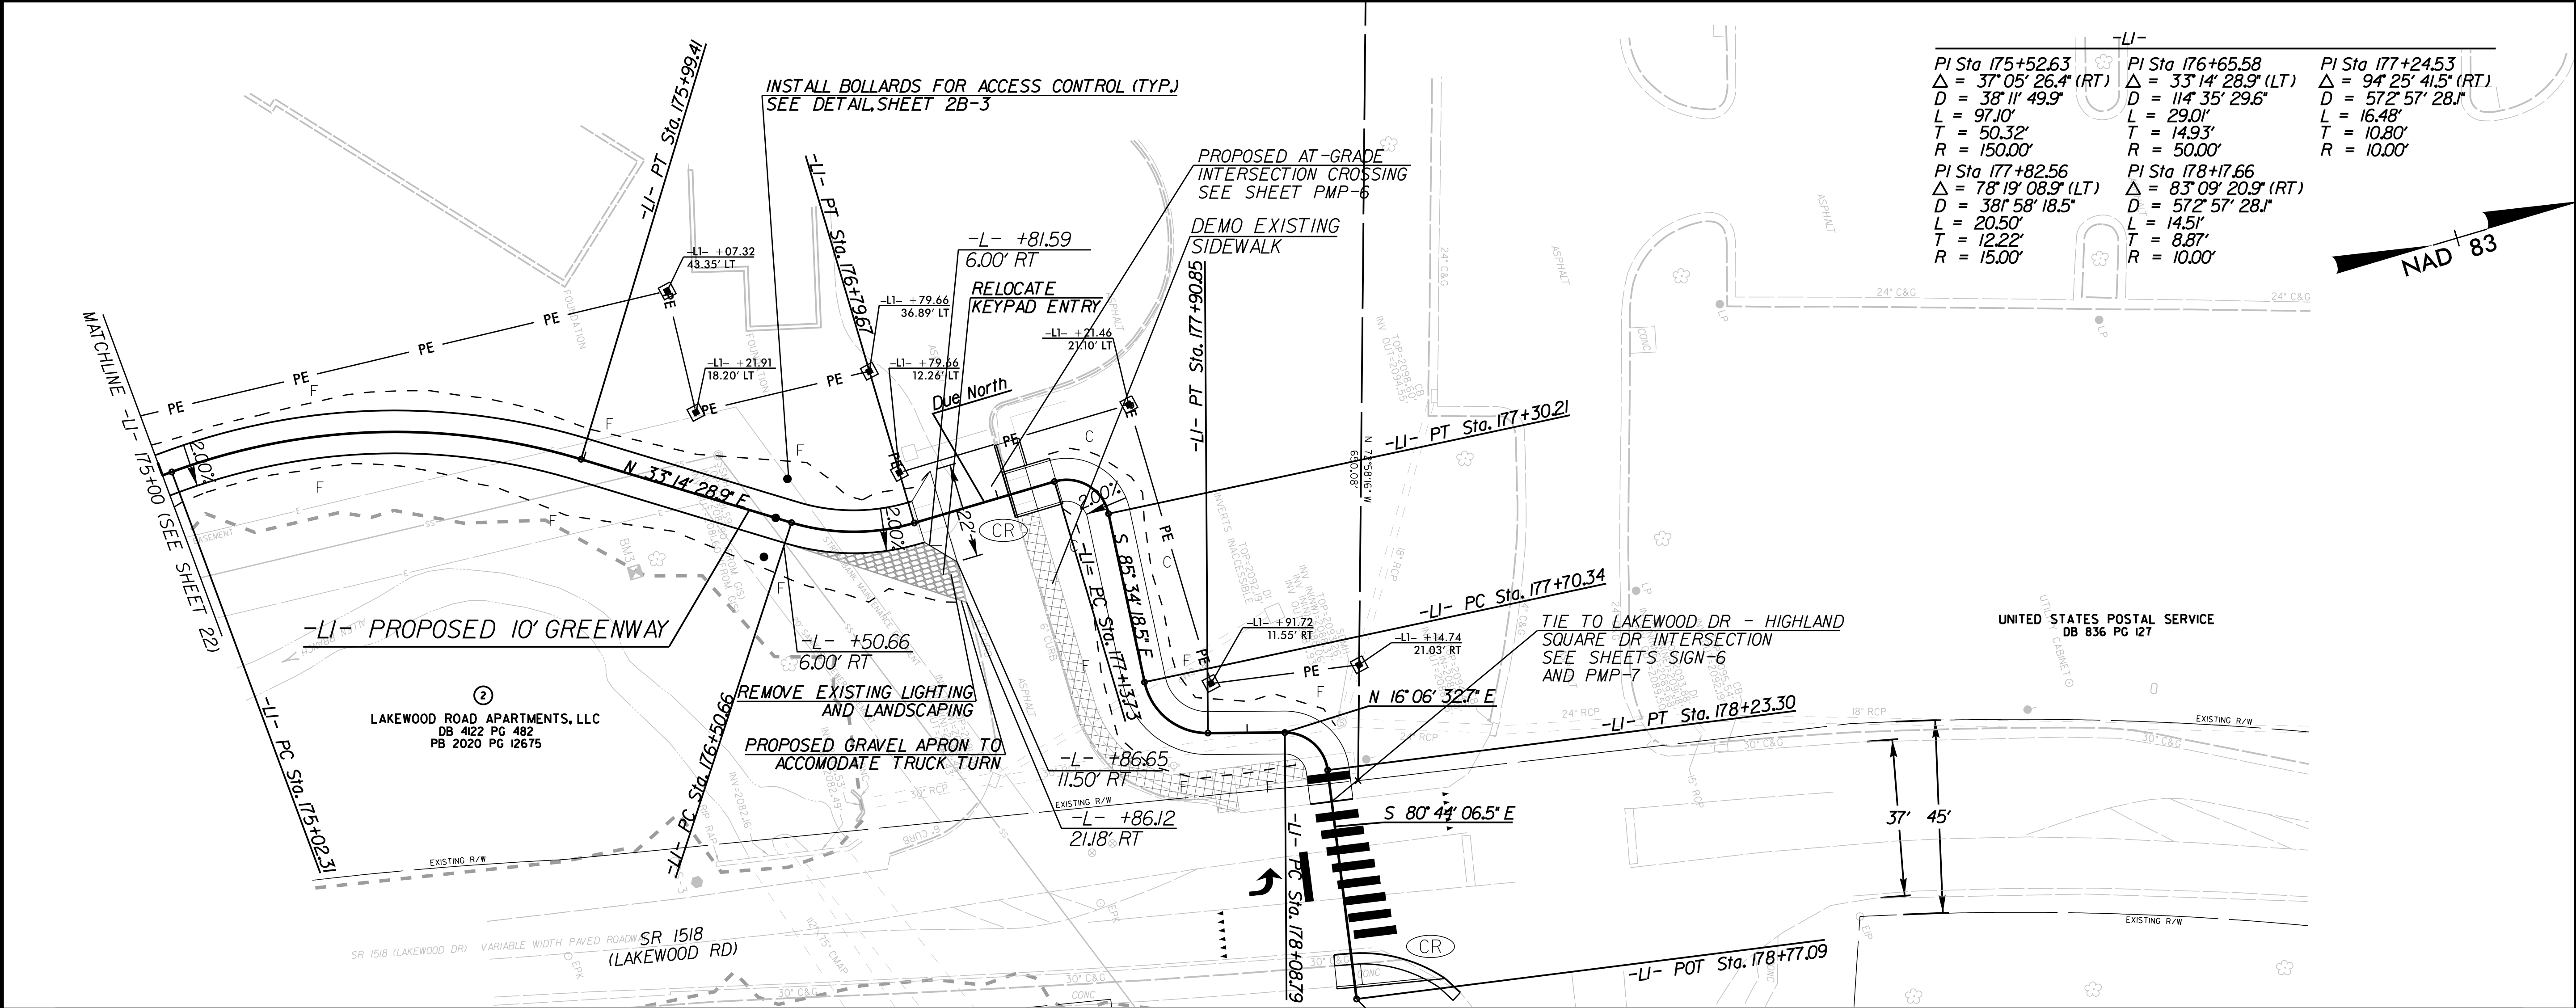



REV.	NO.	REVISION	DATE	DRAWN BY	CHECKED BY

PREPARED IN THE OFFICE OF:

Kimley»Horn

NC LICENSE #F-0102
200 S TRYON ST., SUITE 200
CHARLOTTE, NORTH CAROLINA 28202
PHONE: (704) 333-5131
© 2025

-L1- PLAN AND PROFILE

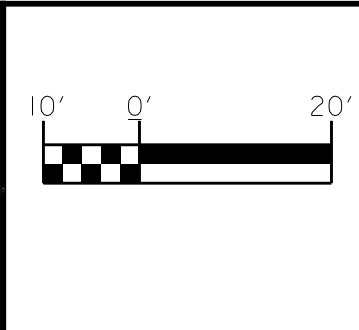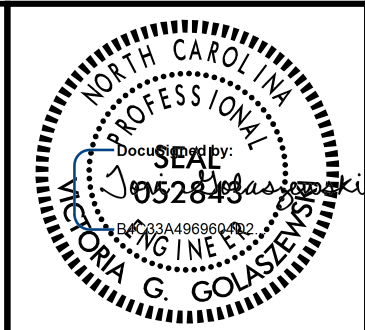

PROJECT:	CLEAR CREEK GREENWAY
JOB NUMBER:	015574013
SHEET NUMBER:	23