


09/08/24

STATE PROJECT: DF18314.2044195

CONTRACT:

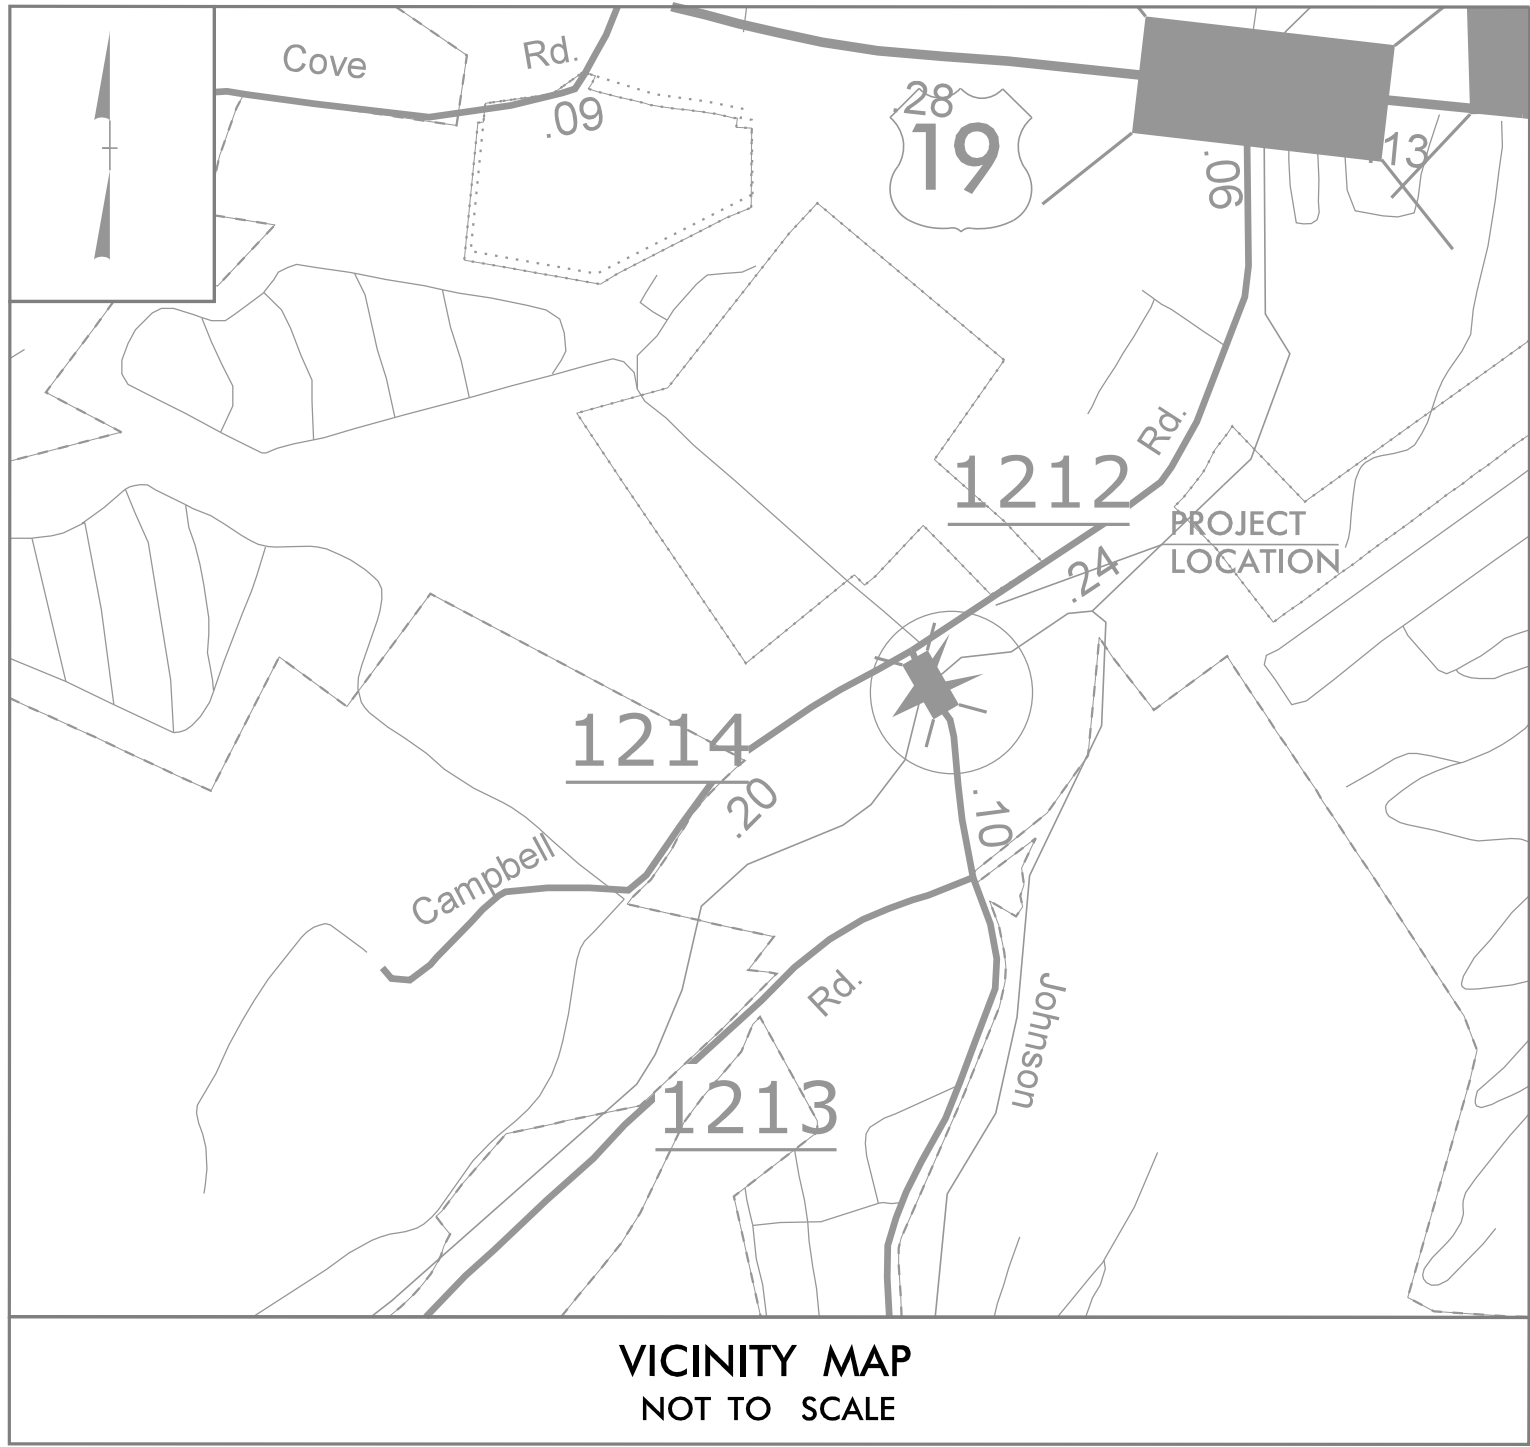


VICINITY MAP
NOT TO SCALE

STATE OF NORTH CAROLINA
DIVISION OF HIGHWAYS

HAYWOOD COUNTY

LOCATION: SR 1212 (JOHNSON BRANCH RD) OVER CAMPBELL CREEK



TYPE OF WORK: WATER AND SEWER LINE RELOCATION

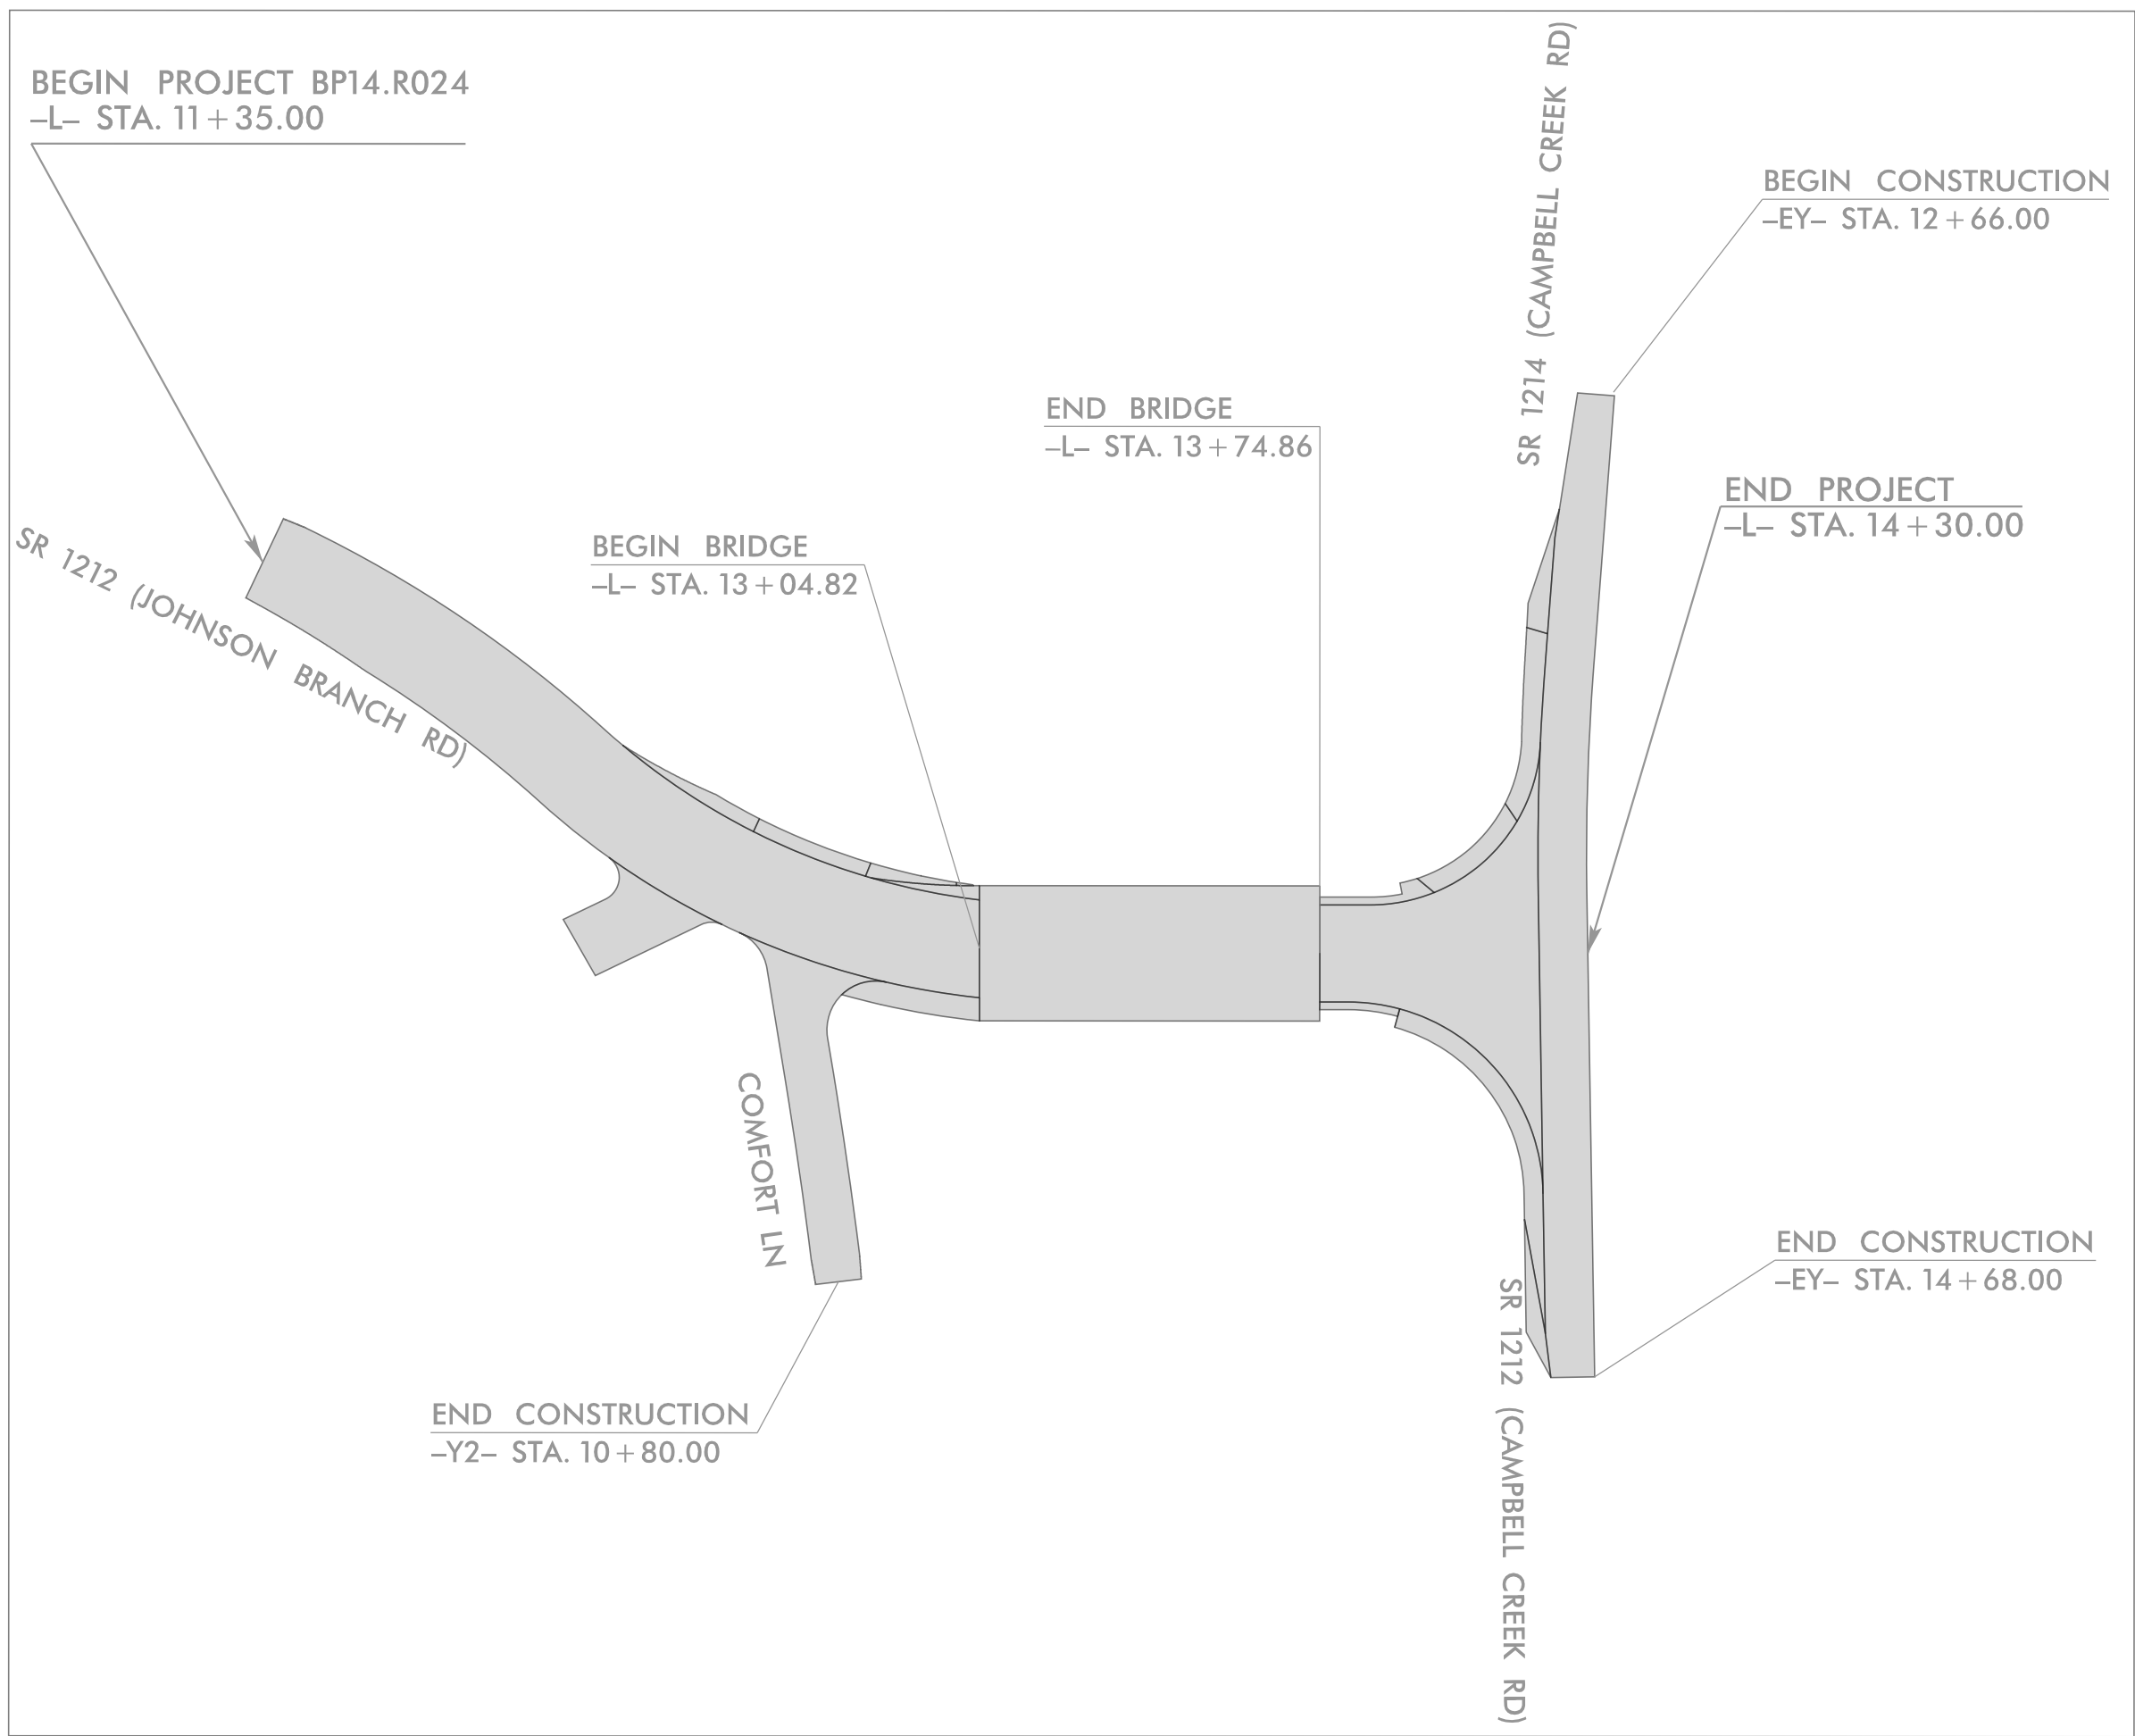


LOCATION SKETCH
NOT TO SCALE

THIS PROJECT IS WITHIN THE MAGGIE VALLEY MUNICIPAL BOUNDARIES.
CLEARING ON THIS PROJECT SHALL BE PERFORMED TO THE LIMITS ESTABLISHED BY MODIFIED METHOD III.

STATE	STATE PROJECT REFERENCE NO.	SHEET NO.	TOTAL SHEETS
N.C.	DF18314.2044195	1	
STATE PROJ. NO.	F.A. PROJ. NO.	DESCRIPTION	

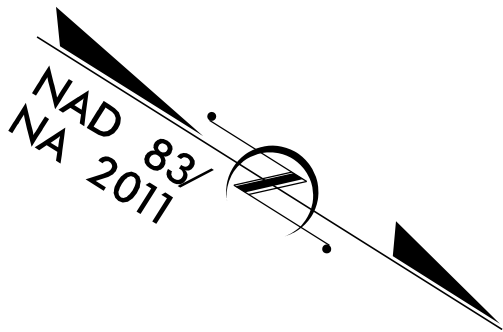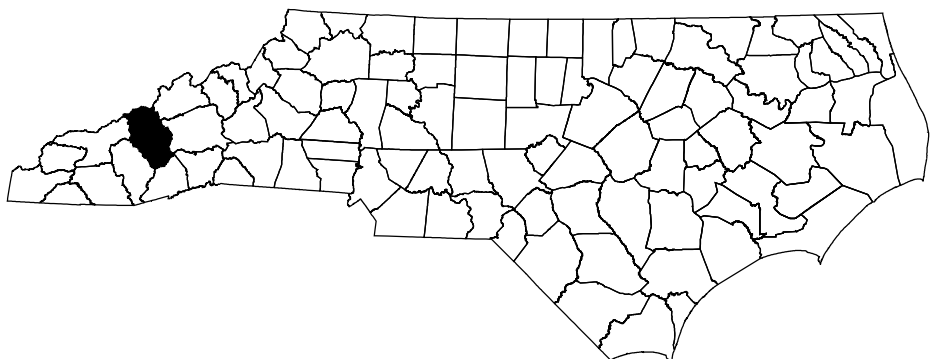


DOCUMENT NOT CONSIDERED FINAL
UNLESS ALL SIGNATURES COMPLETED

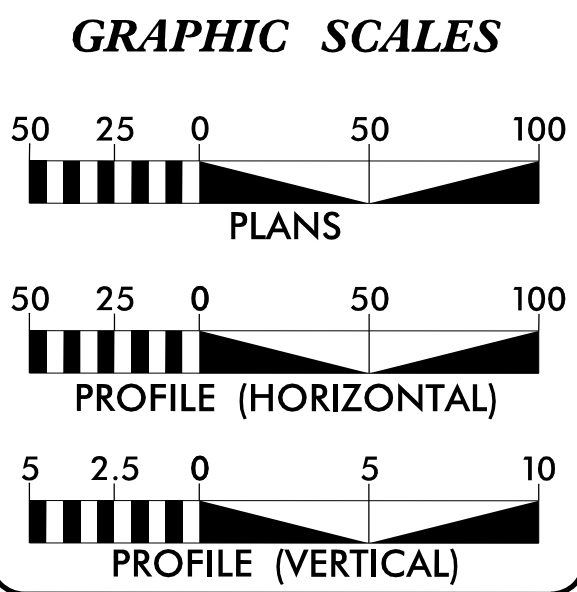


INDEX OF SHEETS	
SHEET NO.:	DESCRIPTION:
UC-1	TITLE SHEET
UC-2	UTILITY SYMBOLOGY
UC-3	NOTES
UC-3A THRU UC-3C	DETAILS
UC-4 THRU UC-4B	UTILITY PLAN /PROFILE SHEETS

WATER AND SEWER OWNERS ON PROJECT	
(A) WATER - MAGGIE VALLEY	
(B) SEWER - MAGGIE VALLEY	

PREPARED IN THE OFFICE OF	
 40 COLONIAL SQUARE SYLVA, NC 28779 (828) 477-4993	
Jamie Noe, PE	PROJECT UTILITY ENGINEER
Emily Morris, EIT	UTILITY DESIGN ENGINEER
Shane Waidner	UTILITY DESIGN ENGINEER

SEAL

12/20/2025 5:20:01 PM EST

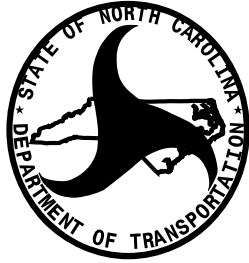	DIVISION OF HIGHWAYS UTILITIES DIVISION 14 253 WEBSTER ROAD SYLVA, NC 28779 PHONE (828) 331-5200 FAX (828) 331-5201
Wesley T. Grindstaff	DIVISION UTILITY ENGINEER
Bob Golding	SENIOR DIVISION 14 UTILITY COORDINATOR