

**This electronic collection of documents is provided
for the convenience of the user
and is Not a Certified Document –**

**The documents contained herein were originally issued
and sealed by the individuals whose names and license
numbers appear on each page, on the dates appearing
with their signature on that page.**


**This file or an individual page
shall not be considered a certified document.**

09/08/2019

7/12/2018
R:\Environmental\Design\U5105_hyd\EC_tsh.dgn
default

TIP PROJECT: U-5105

CONTRACT: DN00650

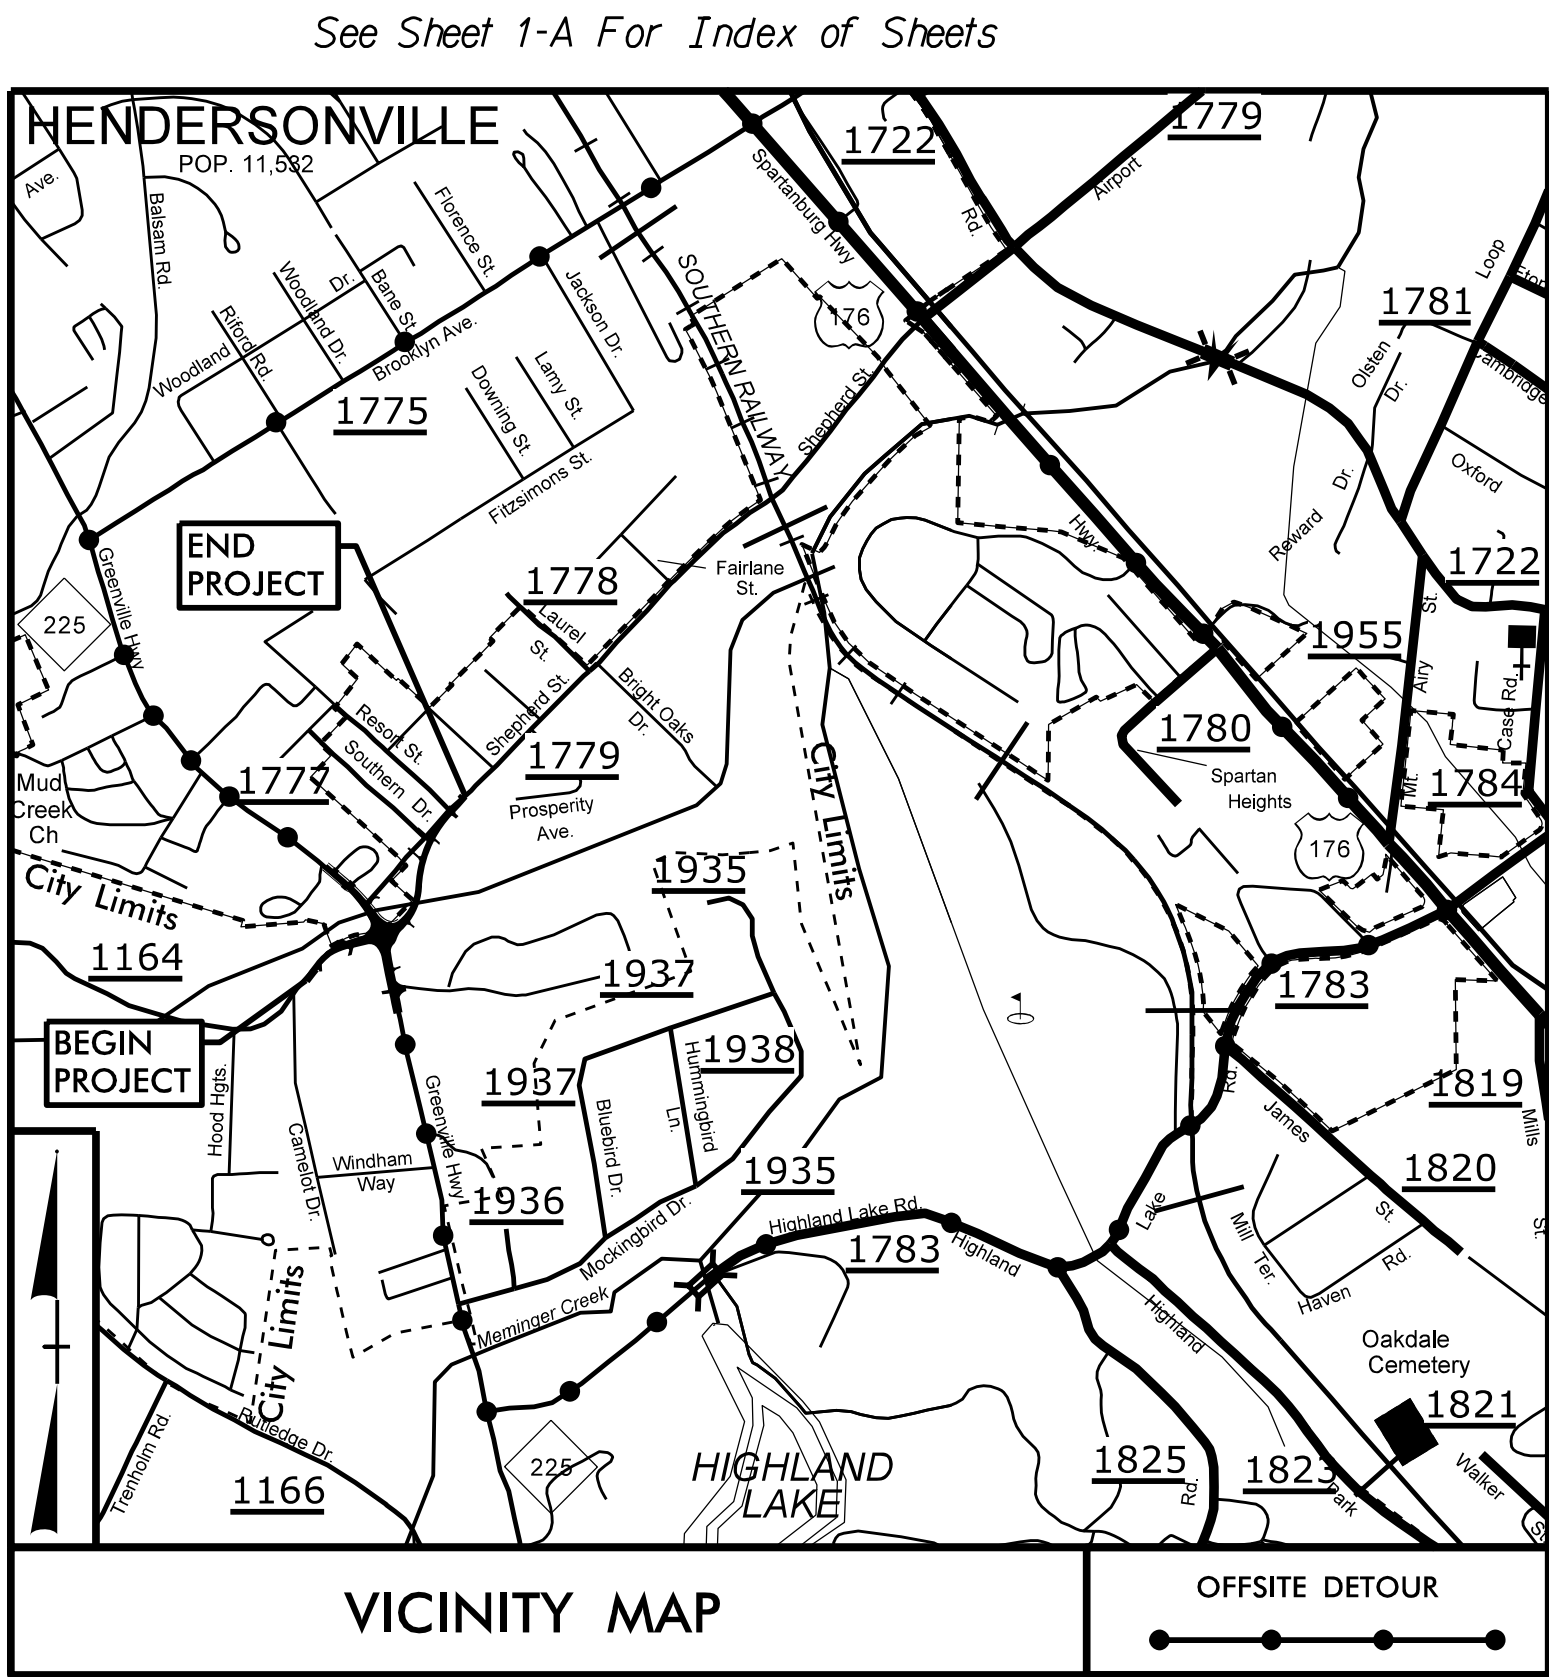


STATE OF NORTH CAROLINA
DIVISION OF HIGHWAYS


THIS PROJECT CONTAINS
EROSION CONTROL PLANS
FOR CLEARING AND
GRUBBING PHASE OF
CONSTRUCTION.

HENDERSON COUNTY

LOCATION: HENDERSONVILLE - NC 225/SR 1164 (ERKWOOD DRIVE) /SR 1779
(SHEPHERD STREET) - INTERSECTION IMPROVEMENTS
TYPE OF WORK: GRADING, PAVING, DRAINAGE, CULVERT, & LIGHTING

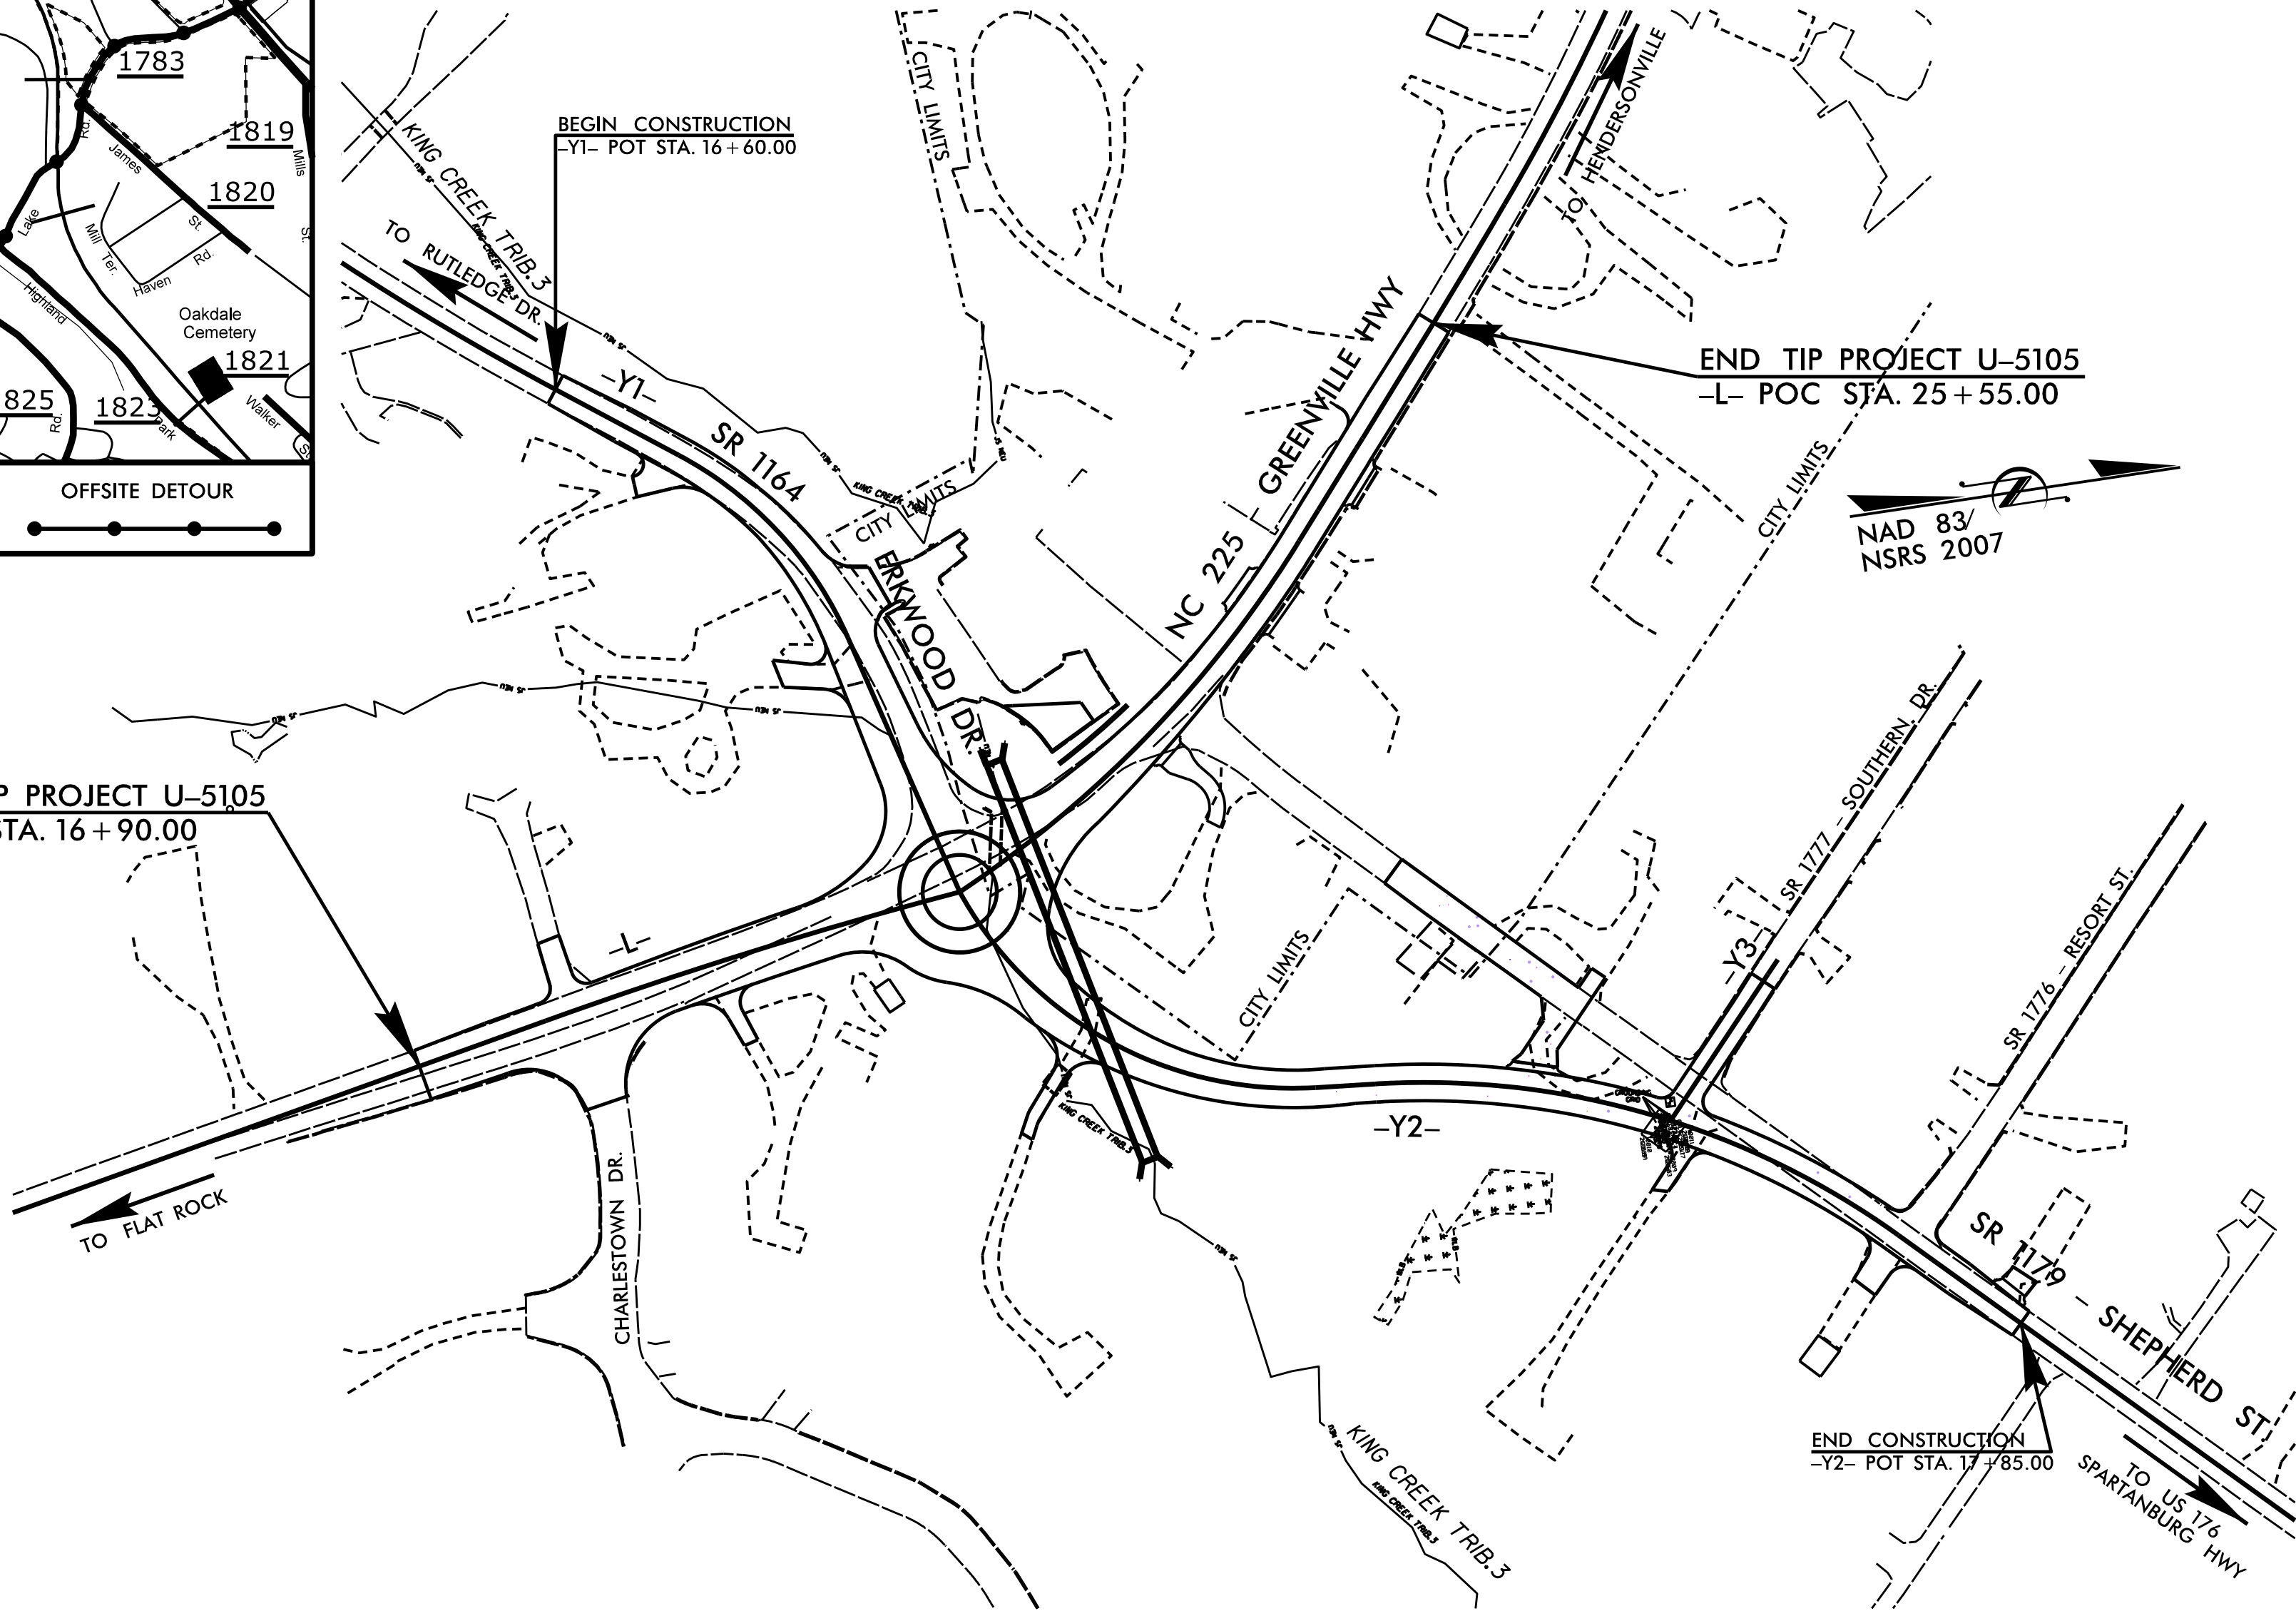

THERE IS NO CONTROL OF ACCESS ON
THIS PROJECT.

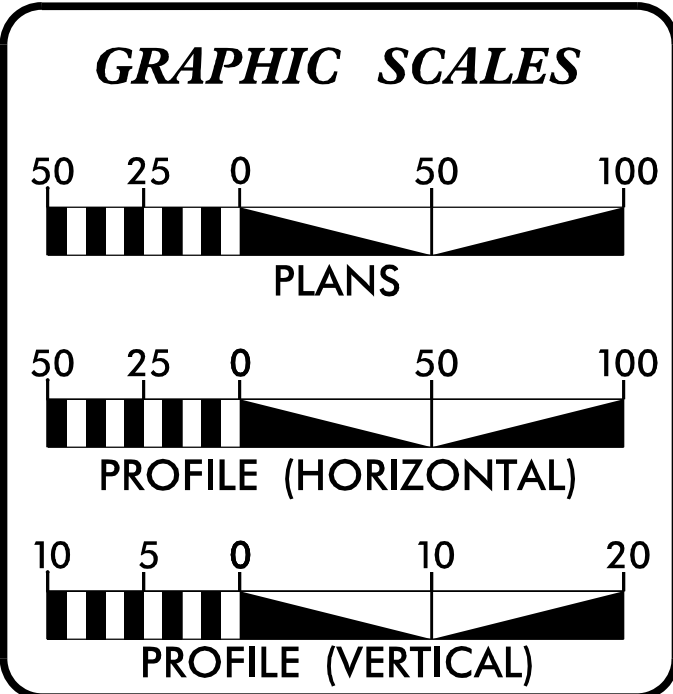

ROADSIDE ENVIRONMENTAL UNIT
DIVISION OF HIGHWAYS
STATE OF NORTH CAROLINA

THESE EROSION AND SEDIMENT
CONTROL PLANS COMPLY WITH
THE REGULATIONS SET FORTH
BY THE NCG-010000 GENERAL
CONSTRUCTION PERMIT EFFECTIVE
AUGUST 3, 2011 ISSUED BY
THE NORTH CAROLINA DEPARTMENT
OF ENVIRONMENT AND NATURAL
RESOURCES DIVISION OF WATER
QUALITY.

CALYX
ENGINEERS + CONSULTANTS
Formerly Mulkey Engineers & Consultants

7500 EAST INDEPENDENCE
BOULEVARD, SUITE 100
CHARLOTTE, NC 28227
phone: 704.537.7300
CALYXengineers.com
NC License # F-1333


Prepared in the Office of:
ROADSIDE ENVIRONMENTAL UNIT
1 South Wilmington St.
Raleigh, NC 27611
2018 STANDARD SPECIFICATIONS

Designed by:
JAMES R. HOPSON JR. 3736
NAME LEVEL III CERTIFICATION NO.

Roadway Standard Drawings

The following roadway english standards as appear in "Roadway Standard Drawings"- Roadway Design Unit - N. C. Department of Transportation - Raleigh, N. C., dated January 2012 and the latest revision thereto are applicable to this project and by reference hereby are considered a part of these plans.

1604.01 Railroad Erosion Control Detail	1632.01 Rock Inlet Sediment Trap Type A
1605.01 Temporary Silt Fence	1632.02 Rock Inlet Sediment Trap Type B
1606.01 Special Sediment Control Fence	1632.03 Rock Inlet Sediment Trap Type C
1607.01 Gravel Construction Entrance	1633.01 Temporary Rock Silt Check Type A
1622.01 Temporary Berms and Slope Drains	1633.02 Temporary Rock Silt Check Type B
1630.01 Riser Basin	1634.01 Temporary Rock Sediment Dam Type A
1630.02 Silt Basin Type B	1634.02 Temporary Rock Sediment Dam Type B
1630.03 Temporary Silt Ditch	1635.01 Rock Pipe Inlet Sediment Trap Type A
1630.04 Stilling Basin	1635.02 Rock Pipe Inlet Sediment Trap Type B
1630.05 Temporary Diversion	1640.01 Coir Fiber Baffle
1630.06 Special Stilling Basin	1645.01 Temporary Stream Crossing
1631.01 Matting Installation	

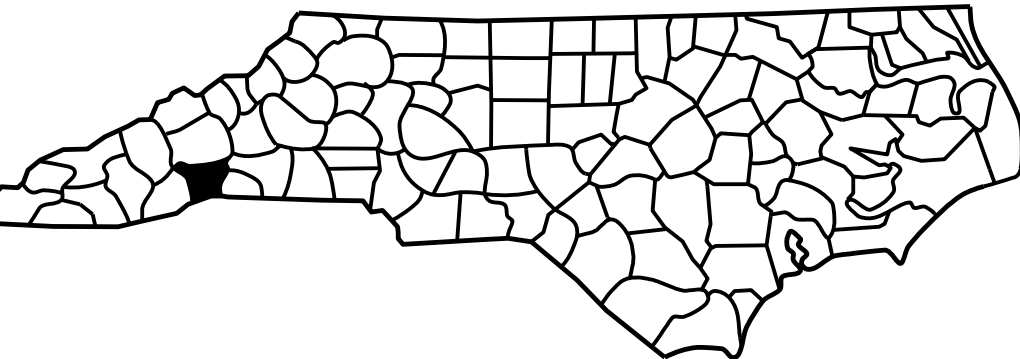


EROSION AND SEDIMENT CONTROL MEASURES

Std. #	Description	Symbol
1605.01	Temporary Silt Fence	
1606.01	Special Sediment Control Fence	
1622.01	Temporary Berms and Slope Drains	
1630.02	Silt Basin Type B	
1630.03	Temporary Silt Ditch	
1630.05	Temporary Diversion	
1630.06	Special Stilling Basin	
1632.03	Rock Inlet Sediment Trap Type C	
1633.01	Temporary Rock Silt Check Type-A	
	Temporary Rock Silt Check Type-A with Matting and Polyacrylamide (PAM)	
1633.02	Temporary Rock Silt Check Type-B	
	Wattle	
	Wattle with Polyacrylamide (PAM)	
1634.01	Temporary Rock Sediment Dam Type-A	
1634.02	Temporary Rock Sediment Dam Type-B	
1635.01	Rock Pipe Inlet Sediment Trap Type-A	
1635.02	Rock Pipe Inlet Sediment Trap Type-B	
1630.04	Stilling Basin	
1630.06	Special Stilling Basin	
	Rock Inlet Sediment Trap:	
1632.01	Type A	
1632.02	Type B	
1632.03	Type C	
	Skimmer Basin	
	Tiered Skimmer Basin	
	Infiltration Basin	

PROJECT REFERENCE NO.	SHEET NO.
U-5105	EC-2
RW SHEET NO.	


SKIMMER BASIN WITH BAFFLES DETAIL

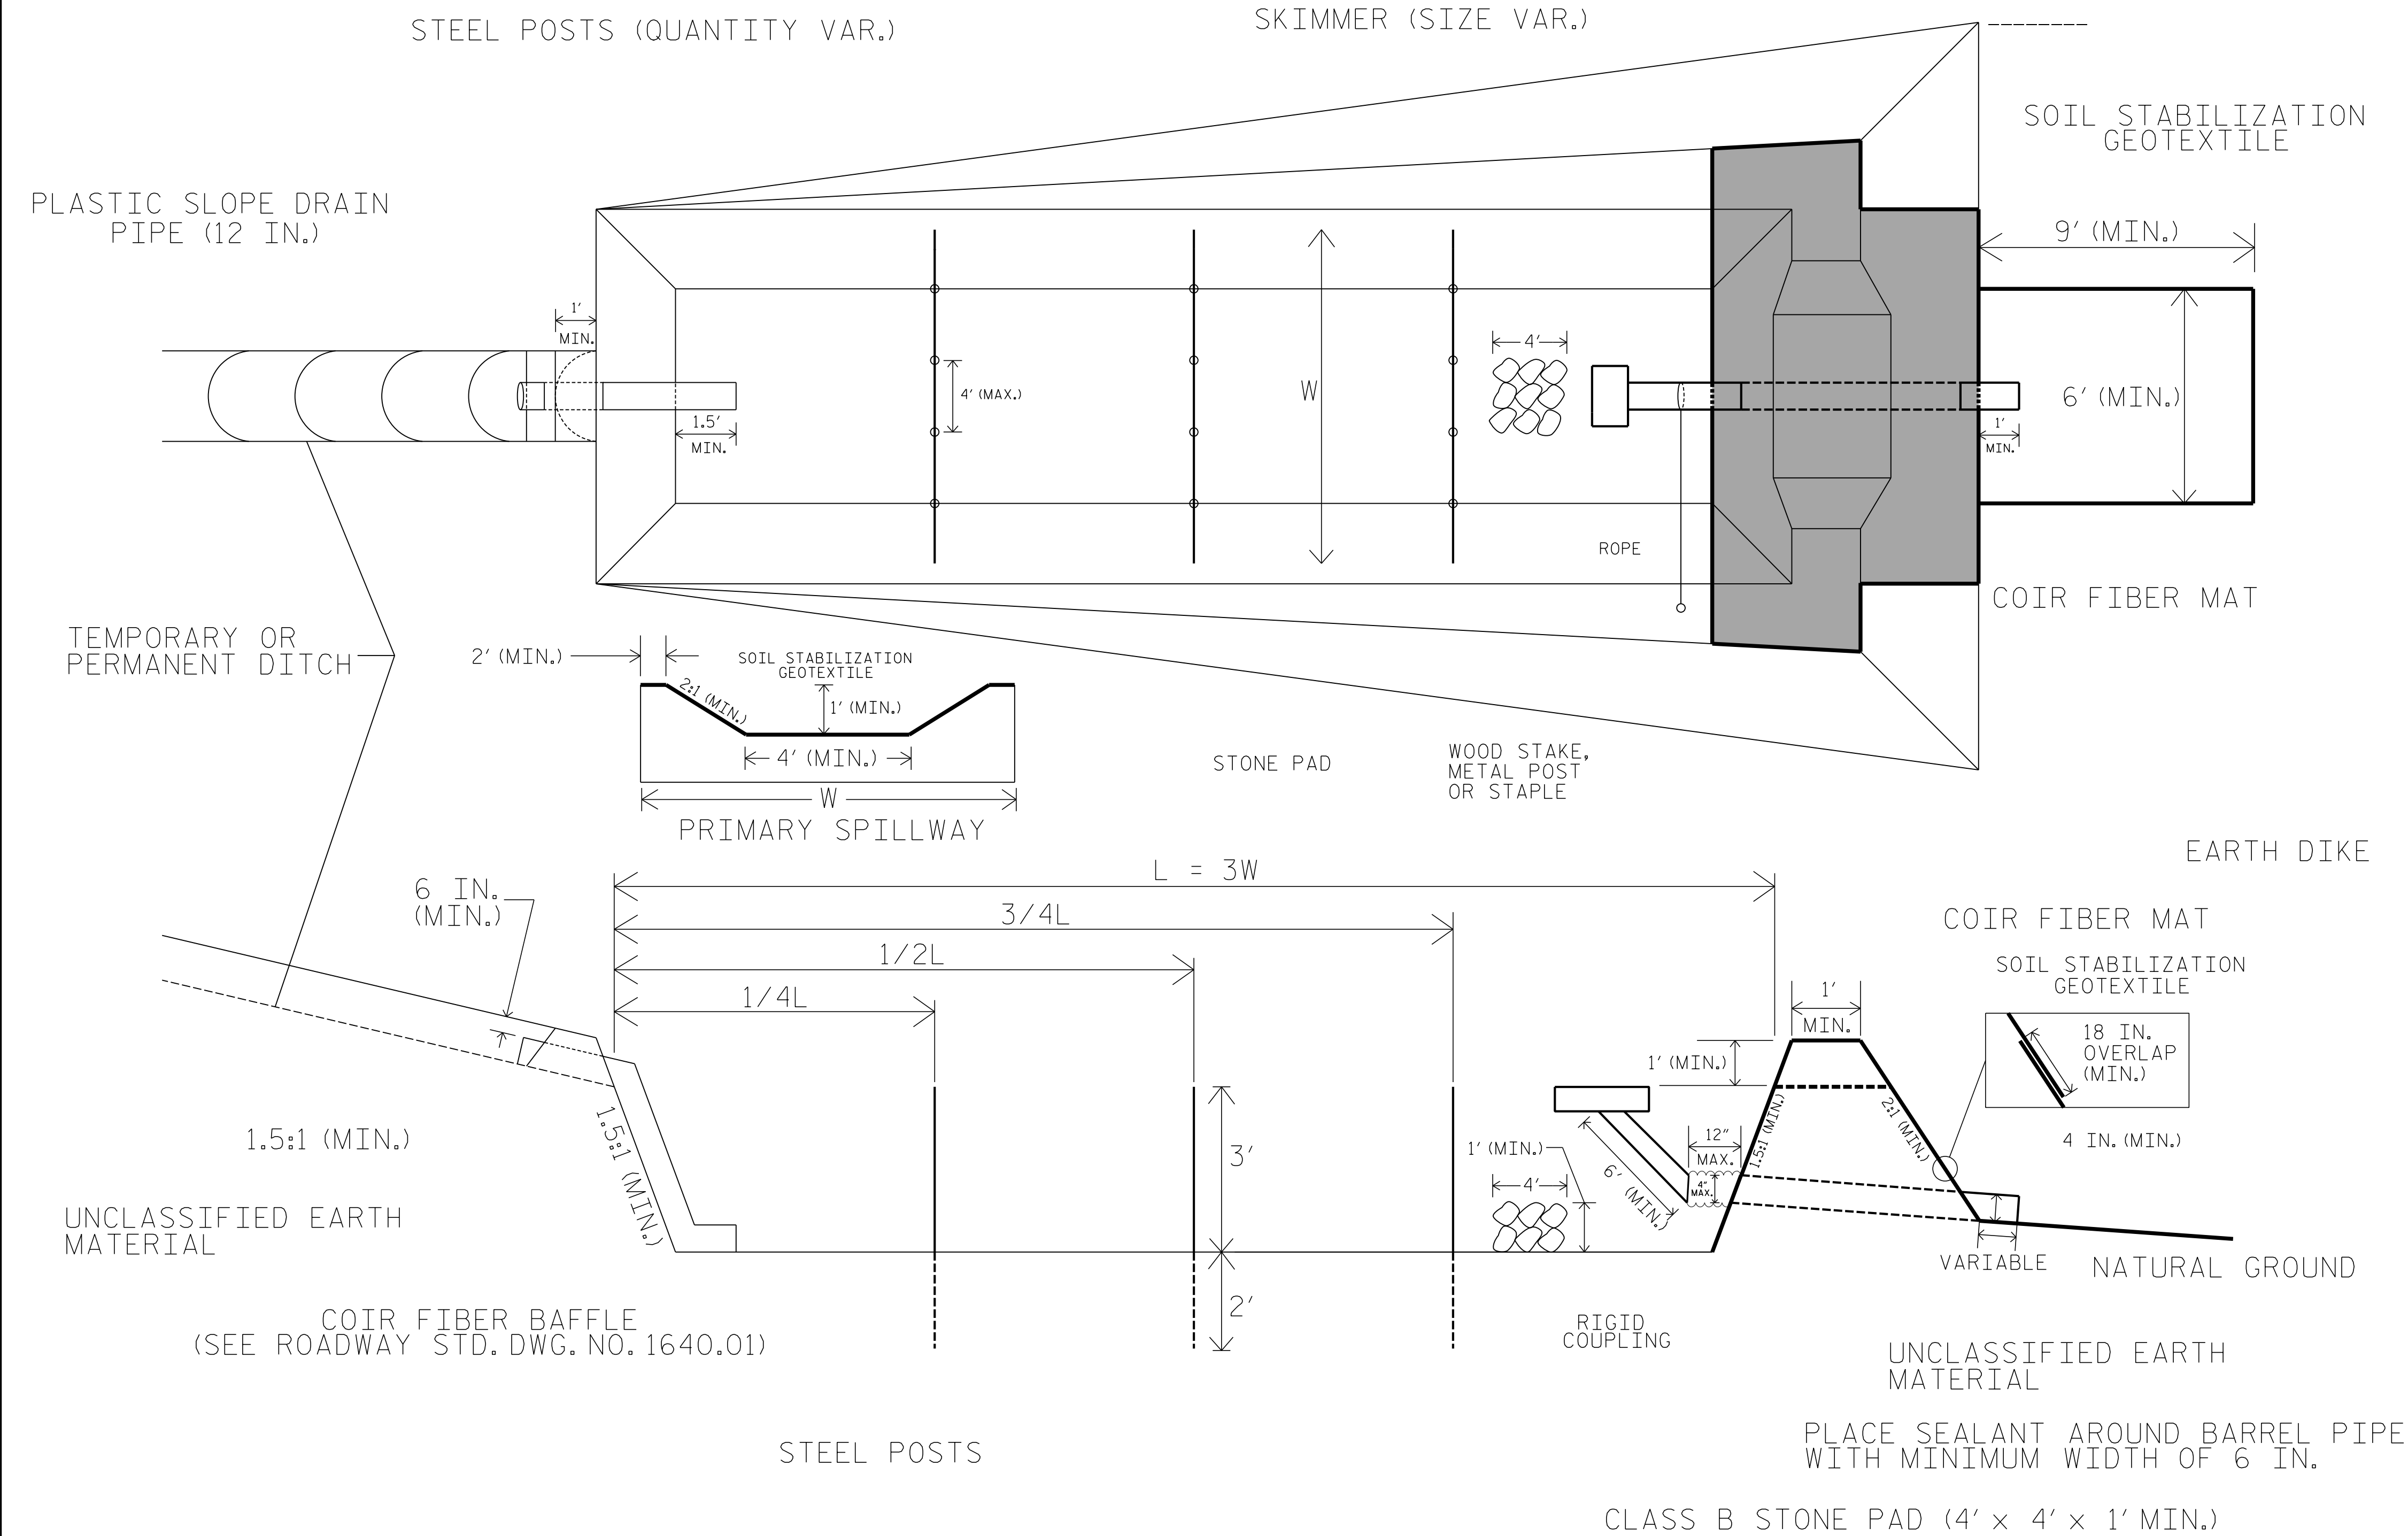

NOTES

- 1. SEED AND PLACE MATTING FOR EROSION CONTROL ON INTERIOR AND EXTERIOR SIDESLOPES.
- 2. LIMIT EARTH DIKE HEIGHT TO 5 FT.
- 3. FOR BASIN DEPTH OF 3 FT., THE MINIMUM BASIN WIDTH SHALL BE 9 FT.
- 4. DETERMINE PRIMARY SPILLWAY WEIR LENGTH (FT.) USING $Q/0.8$, WHERE Q IS FLOW RATE (CFS) INTO BASIN.
- 5. PLASTIC SLOPE DRAIN PIPE AT INLET OF BASIN MAY BE REPLACED BY FILTRATION GEOTEXTILE OR TARP AS DIRECTED.
- 6. SOIL STABILIZATION GEOTEXTILE FOR PRIMARY SPILLWAY SHALL BE ONE CONTINUOUS PIECE OF MATERIAL OR OVERLAPPED 18 IN. (MIN.).

NOT TO SCALE

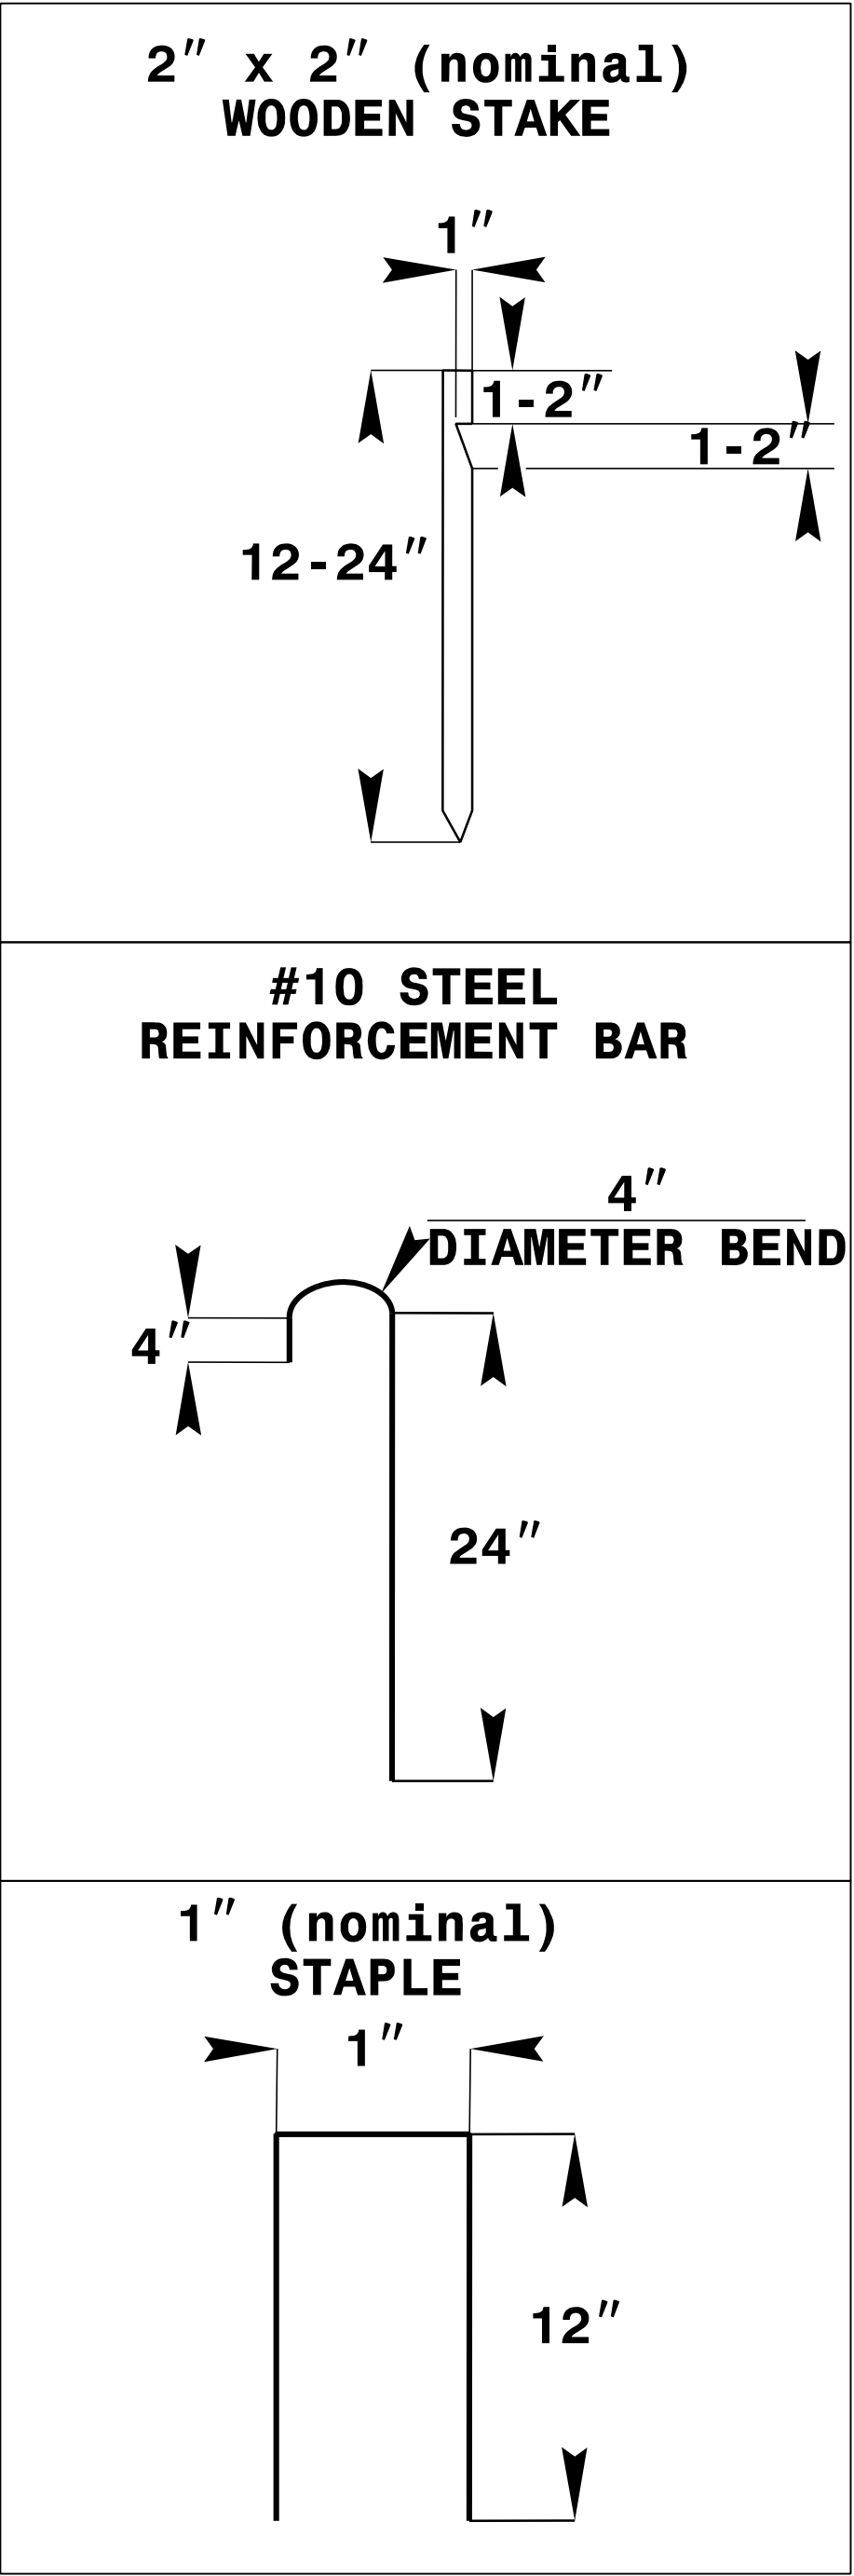

COIR FIBER MAT ANCHOR OPTIONS

PROJECT REFERENCE NO.	SHEET NO.
U-5105	EC-2A
RW SHEET NO.	

COIR FIBER WATTLE WITH POLYACRYLAMIDE (PAM) DETAIL

NOTES:

USE MINIMUM 12 IN. DIAMETER COIR FIBER (COCONUT FIBER) WATTLE.

USE 2 FT. WOODEN STAKES WITH A 2 IN. BY 2 IN. NOMINAL CROSS SECTION.

ONLY INSTALL WATTLE(S) TO A HEIGHT IN DITCH SO FLOW WILL NOT WASH AROUND WATTLE AND SCOUR DITCH SLOPES AND AS DIRECTED.

INSTALL A MINIMUM OF 2 UPSLOPE STAKES AND 4 DOWNSLOPE STAKES AT AN ANGLE TO WEDGE WATTLE TO BOTTOM OF DITCH.






PROVIDE STAPLES MADE OF 0.125 IN. DIAMETER STEEL WIRE FORMED INTO A U SHAPE NOT LESS THAN 12" IN LENGTH.

INSTALL STAPLES APPROXIMATELY EVERY 1 LINEAR FOOT ON BOTH SIDES OF WATTLE AND AT EACH END TO SECURE IT TO THE SOIL.

INSTALL MATTING IN ACCORDANCE WITH SECTION 1631 OF THE STANDARD SPECIFICATIONS.

PRIOR TO POLYACRYLAMIDE (PAM) APPLICATION, OBTAIN A SOIL SAMPLE FROM PROJECT LOCATION, AND FROM OFFSITE MATERIAL, AND ANALYZE FOR APPROPRIATE PAM FLOCCULANT TO BE APPLIED TO EACH WATTLE.

INITIALLY APPLY 2 OUNCES OF ANIONIC OR NEUTRALLY CHARGED PAM OVER WATTLE WHERE WATER WILL FLOW AND 1 OUNCE OF PAM ON MATTING ON EACH SIDE OF WATTLE. REAPPLY PAM AFTER EVERY RAINFALL EVENT THAT IS EQUAL TO OR EXCEEDS 0.50 IN.

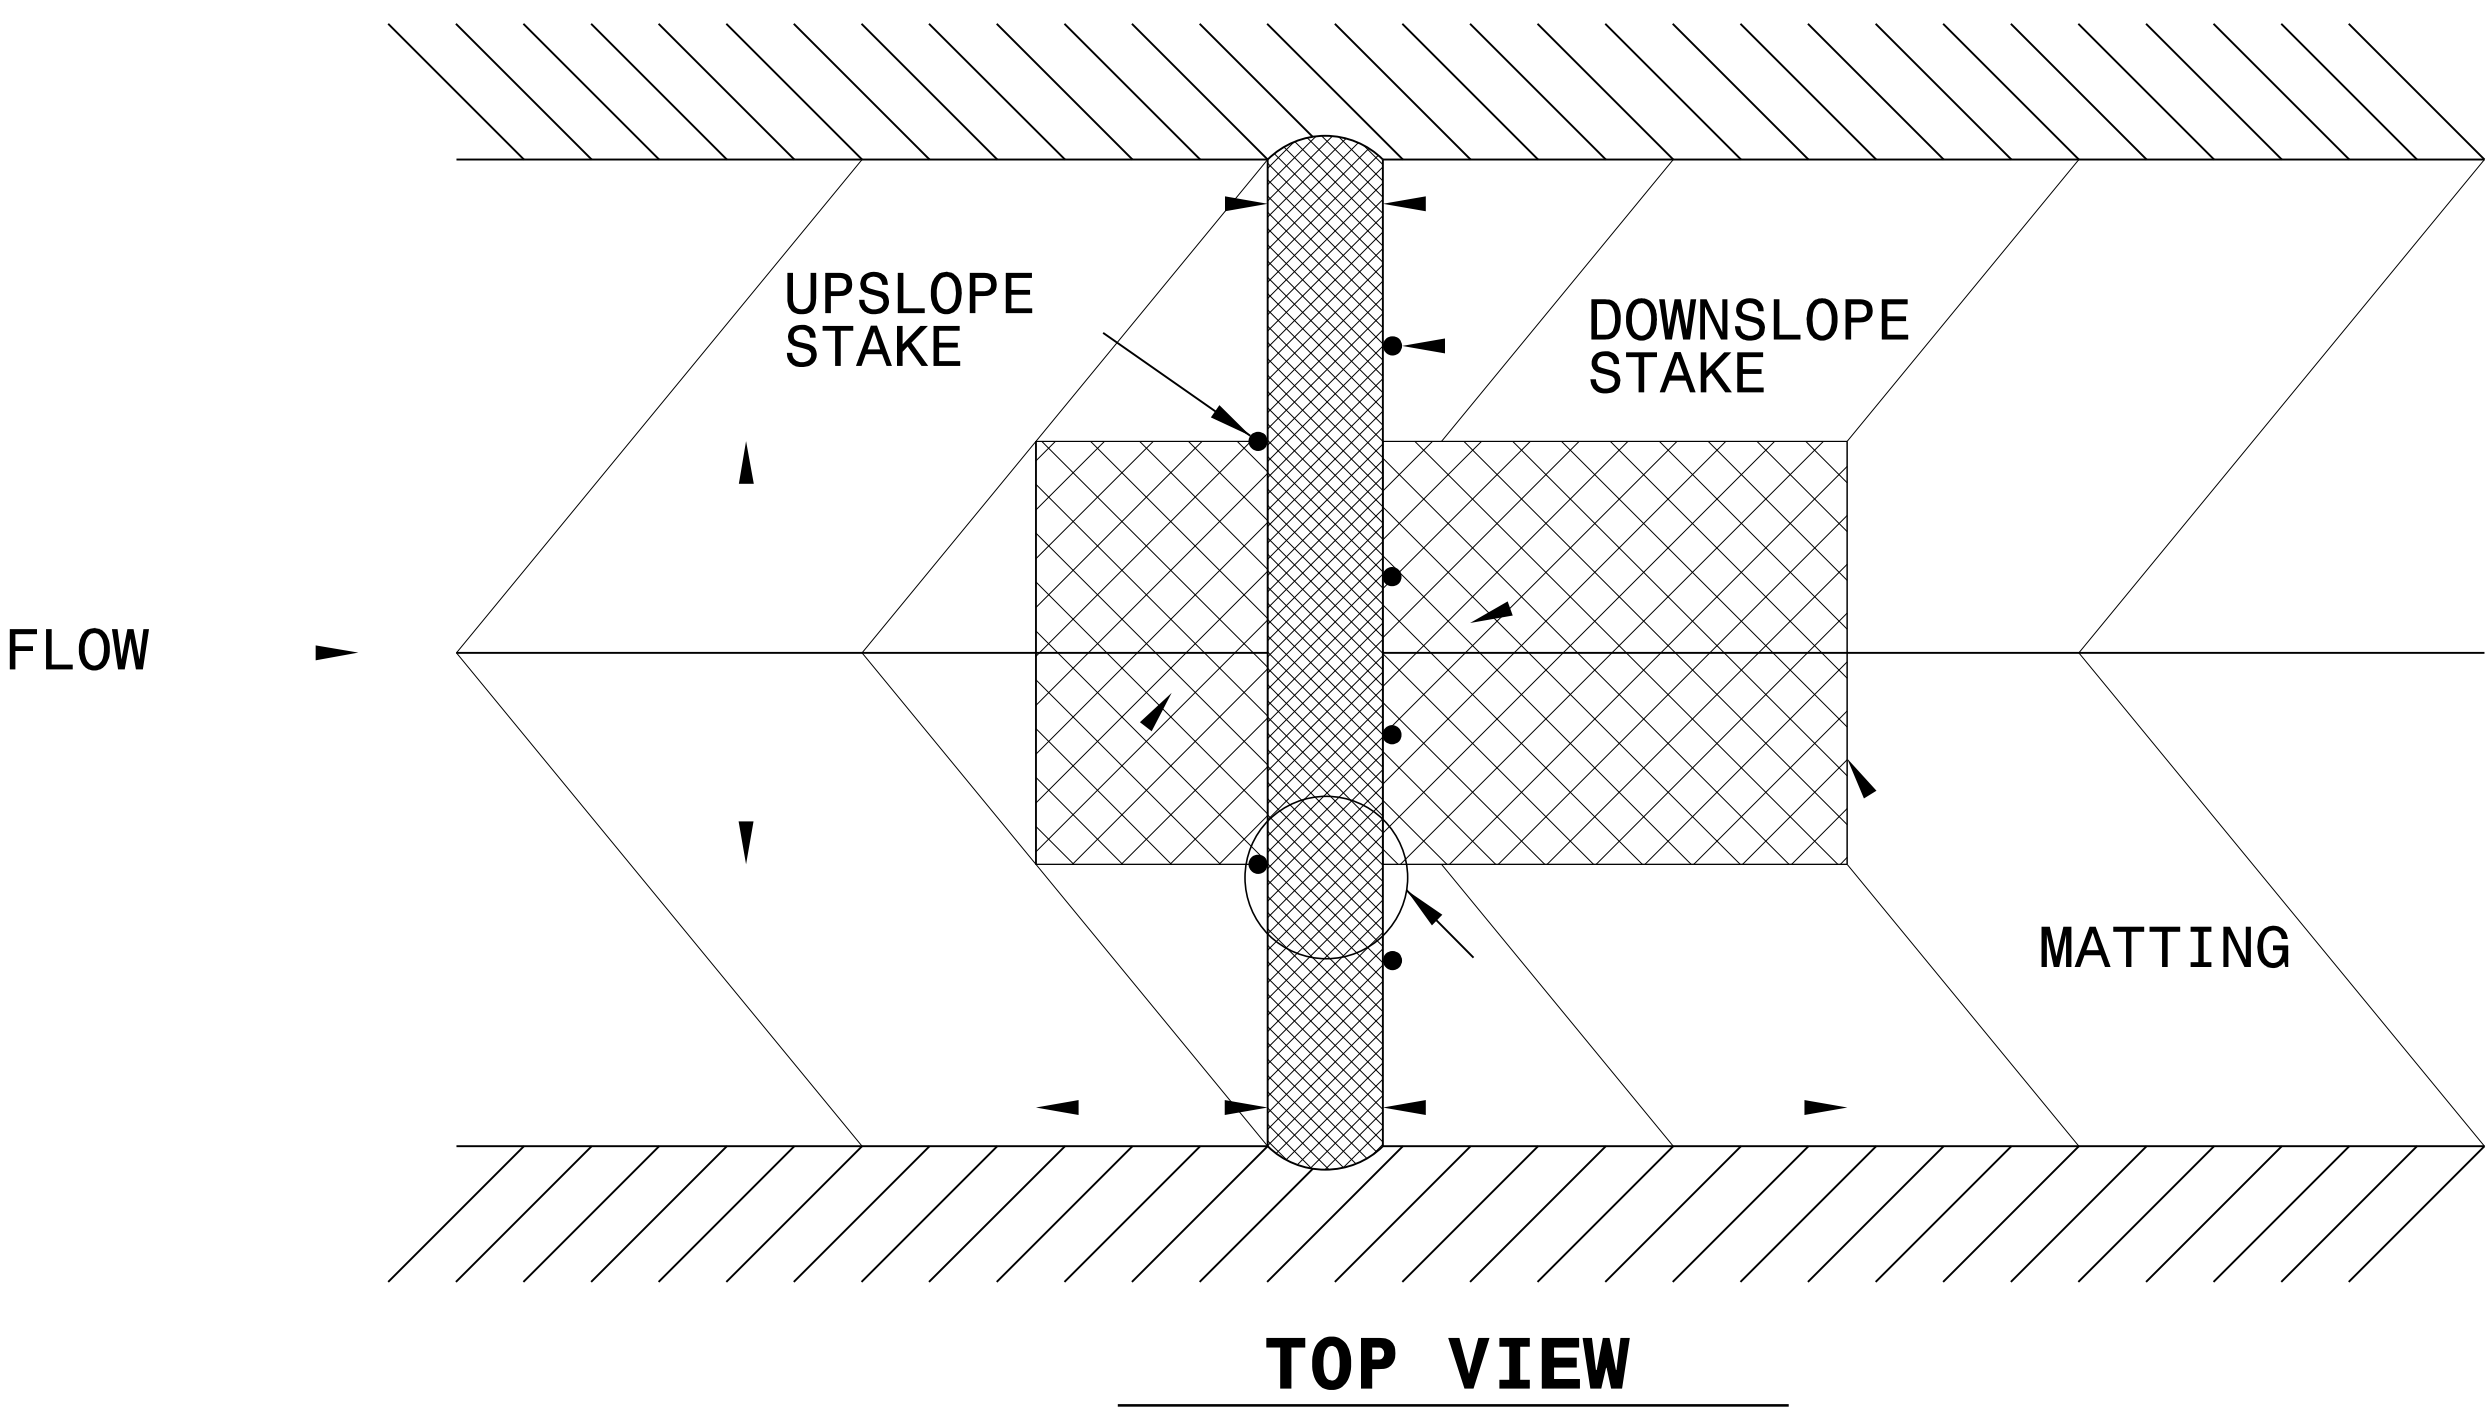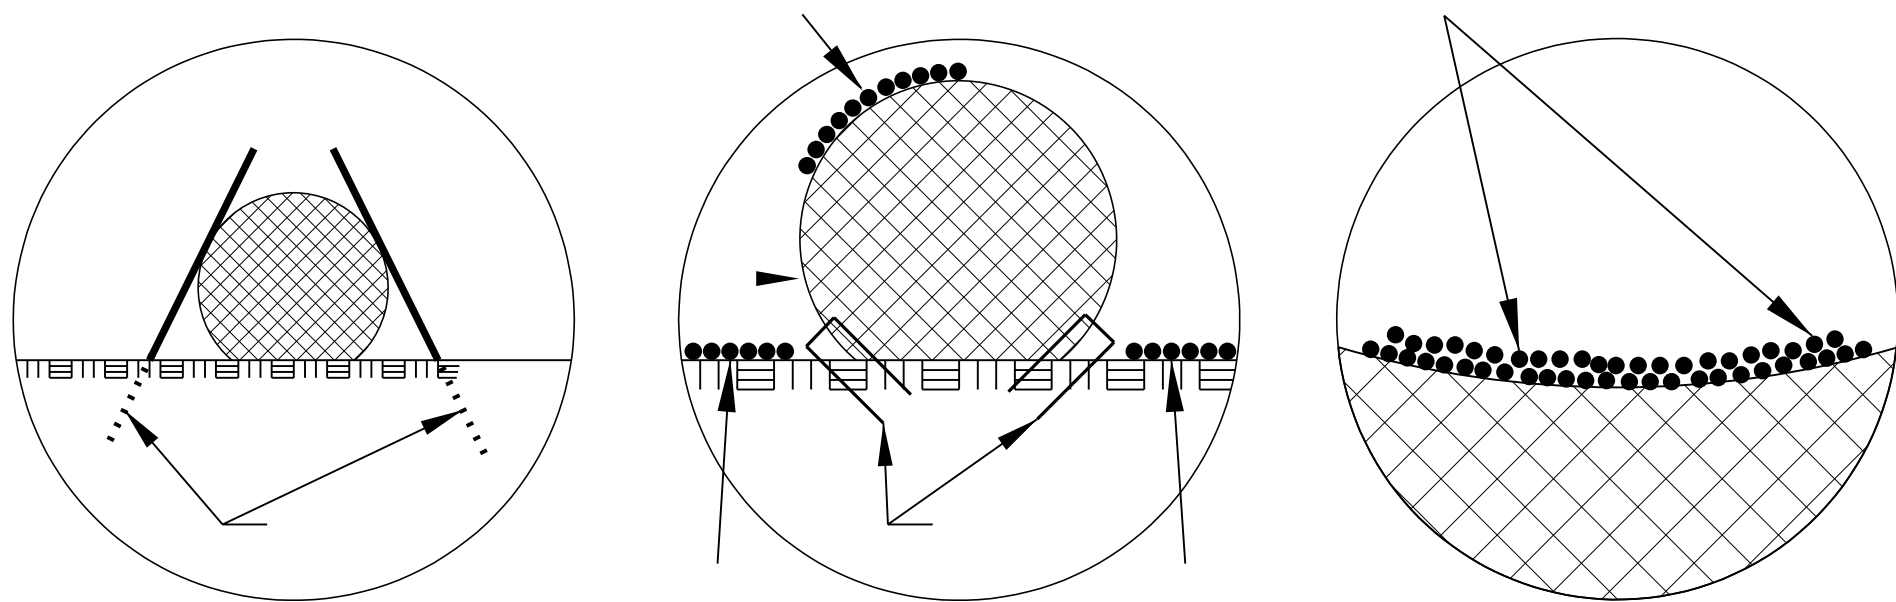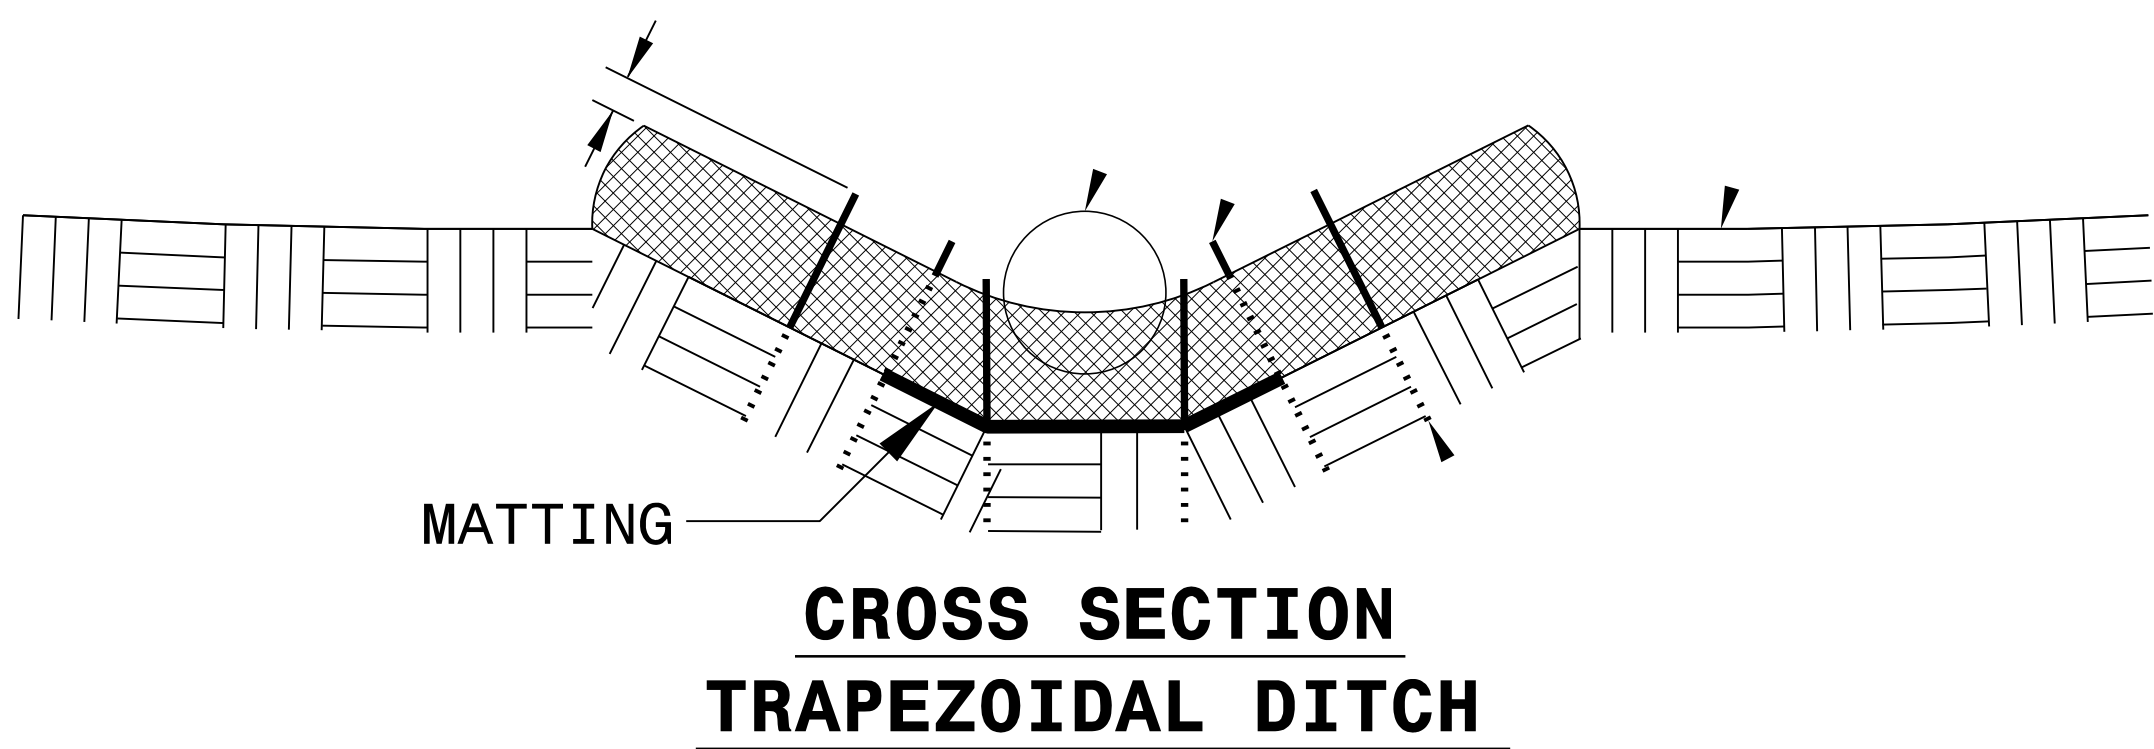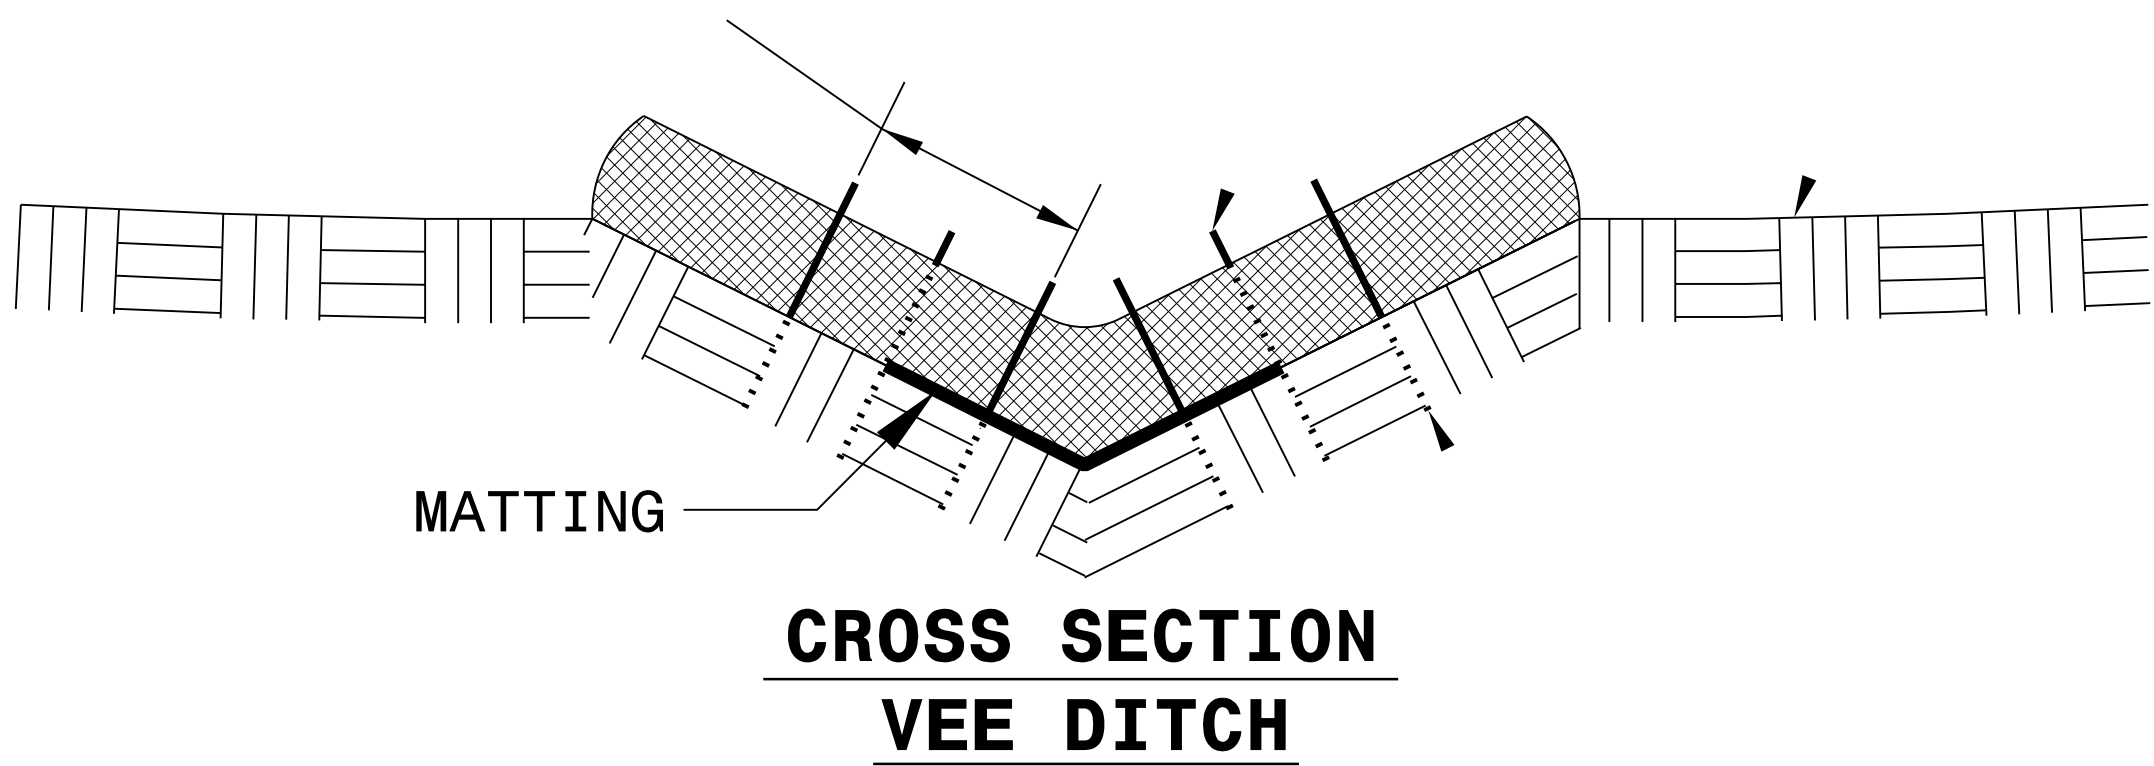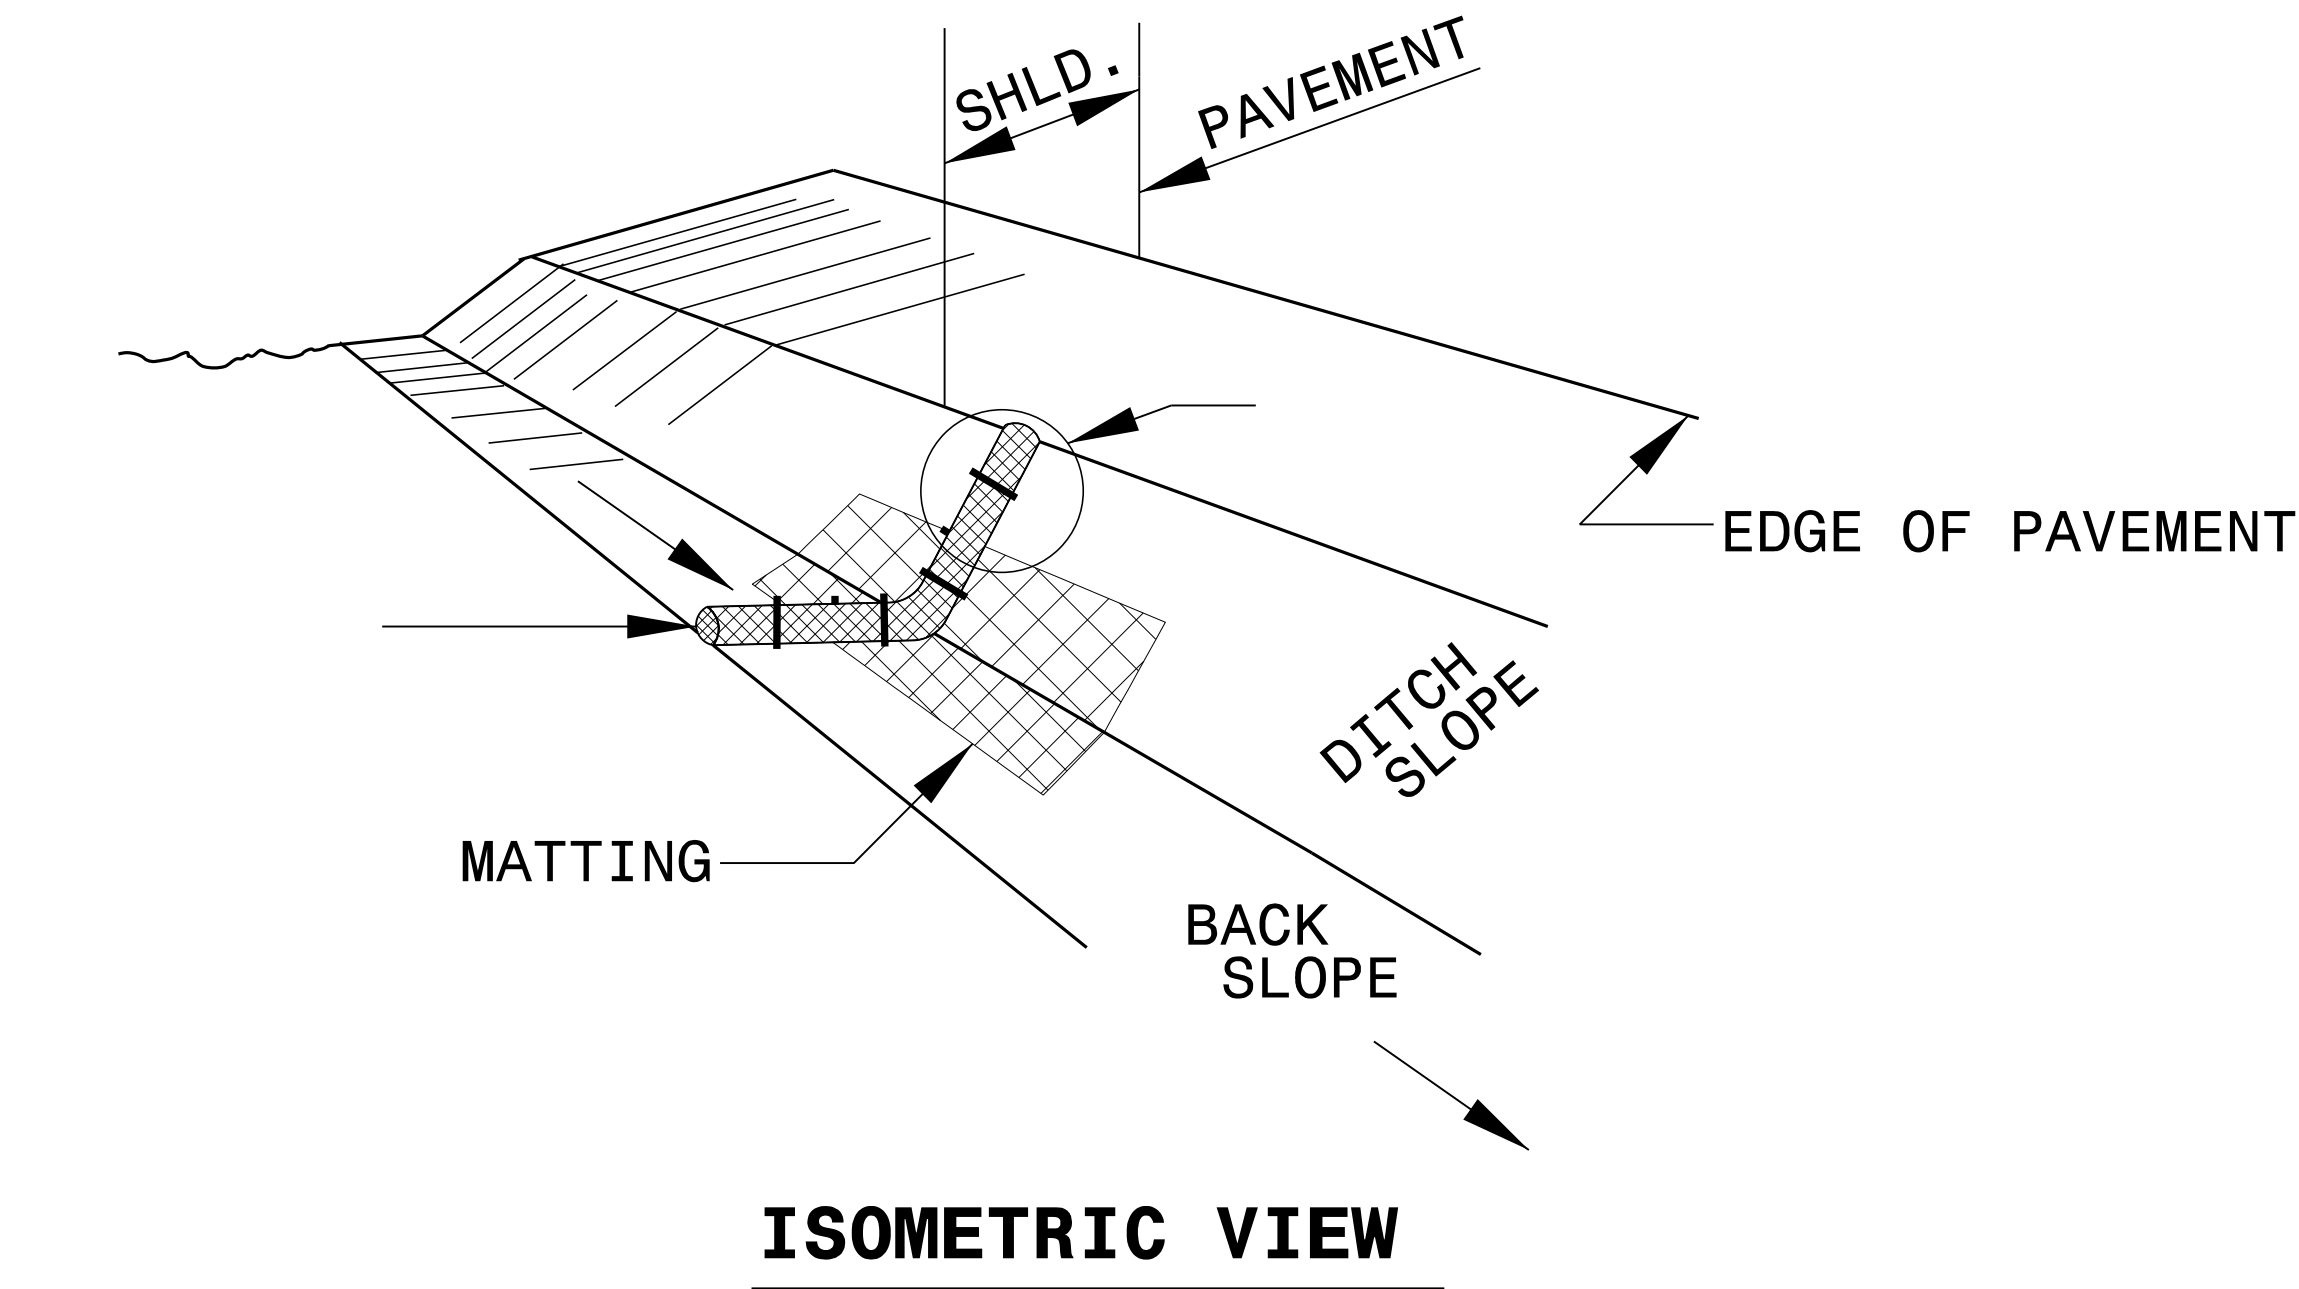

DIVISION OF HIGHWAYS STATE OF NORTH CAROLINA

SOIL STABILIZATION SUMMARY SHEET

MATTING FOR EROSION CONTROL

[illegible]


PERMANENT SOIL REINFORCEMENT MAT

[illegible]

DIVISION OF HIGHWAYS
STATE OF NORTH CAROLINA

SOIL STABILIZATION TIMEFRAMES

SITE DESCRIPTION	STABILIZATION TIME	TIMEFRAME EXCEPTIONS
PERIMETER DIKES, SWALES, DITCHES AND SLOPES	7 DAYS	NONE
HIGH QUALITY WATER (HQW) ZONES	7 DAYS	NONE
SLOPES STEEPER THAN 3:1	7 DAYS	IF SLOPES ARE 10’ OR LESS IN LENGTH AND ARE NOT STEEPER THAN 2:1, 14 DAYS ARE ALLOWED.
SLOPES 3:1 OR FLATTER	14 DAYS	7 DAYS FOR SLOPES GREATER THAN 50’ IN LENGTH.
ALL OTHER AREAS WITH SLOPES FLATTER THAN 4:1	14 DAYS	NONE, EXCEPT FOR PERIMETERS AND HQW ZONES.

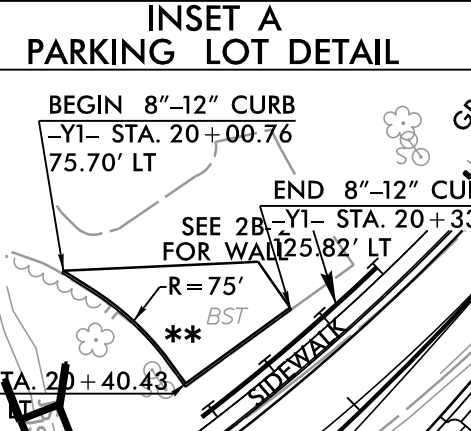

The diagram is a square divided into four quadrants by a horizontal and vertical axis. The quadrants are labeled as follows:

- Top-Left Quadrant:** Labeled $-Y1-$ SR 1164 (ERKWOOD DR). It contains the values 4,400 and 6,000 stacked vertically.
- Top-Right Quadrant:** Labeled $-L-$ NC 225. It contains the values 7,500 and 9,600 stacked vertically. A north arrow points towards the top-right corner.
- Bottom-Left Quadrant:** Labeled $-L-$ NC 225. It contains the values 2,200 and 11,600 stacked vertically.
- Bottom-Right Quadrant:** Labeled $-Y2-$ SR 1779 (SHEPHERD ST). It contains the values 2,900 and 4,600 stacked vertically. Below this, it also lists 2018 ADT and 2035 ADT.

Arrows indicate the flow of traffic or relationships between the quadrants:

- An arrow points from the Top-Left quadrant to the Top-Right quadrant, labeled with 2,400 and 3,200.
- An arrow points from the Top-Right quadrant to the Top-Left quadrant, labeled with 2,000 and 100.
- An arrow points from the Top-Left quadrant to the Bottom-Left quadrant, labeled with 2,100 and 400.
- An arrow points from the Bottom-Left quadrant to the Top-Left quadrant, labeled with 2,400 and 3,200.
- An arrow points from the Bottom-Left quadrant to the Bottom-Right quadrant, labeled with 800 and 1,500.
- An arrow points from the Bottom-Right quadrant to the Bottom-Left quadrant, labeled with 800 and 1,500.

DETAIL F - INLET TYPICAL

(LEFT TO RIGHT CARRY DOWNSTREAM)

NATURAL GROUND

CLASS 17 RIPRAP
W/ GEOTEXTILE

7:8

15'

15'

15'

EST TONS CLASS 17 = 56 TONS
EST GEOTEXTILE = 75 SY
DOE = 46 CY

DETAIL C - OUTLET TYPICAL

(LEFT TO RIGHT LOOKING DOWNSTREAM)

NATURAL GROUND

7'-8"

CLASS 1 RIPRAP W/ GEOTEXTILE

1.5'

BASE VARIES 8" TO 10"

EST TONS CLASS 1' = 67 TONS
EST GEOTEXTILE = 102.5 Y

2-


Pl Sta 15+10.78
Δ = 39°13'33.7" (RT)
D = 10°44'58.8"
L = 364.90'
T = 189.93'
R = 533.00'
Vd = 40MPH
SUPER = 0.04
RO = 84'

Pl Sta 27+23.08
 $\Delta = 5^{\circ} 53' 02.0''$ (LT)
 $D = 3^{\circ} 49' 11.0''$
 $L = 154.04'$
 $T = 77.09'$
 $R = 1,500.00'$


114 x 57 x 3
2.5 inch Skimmer
with 2.25 inch
Orifice Diameter
24 ft. weir
ID 4.1

NOTES:
SEE SHEET 5 FOR -L-, -Y1- AND -Y2- PROFILE
SEE SHEET 6 FOR -Y3- PROFILE
SEE SHEET 2B-1 FOR INTERSECTION DETAIL
SEE SHEET 2B-2 FOR WALL DETAIL
SEE SHEET C-1 THRU C-7 FOR CULVERT PLANS

* DO NOT DISTURB CURB
* REPLACE CURB AND EXISTING ASPHALT AS
NEEDED. SEE INSET A-2, PARKING LOT DETAIL

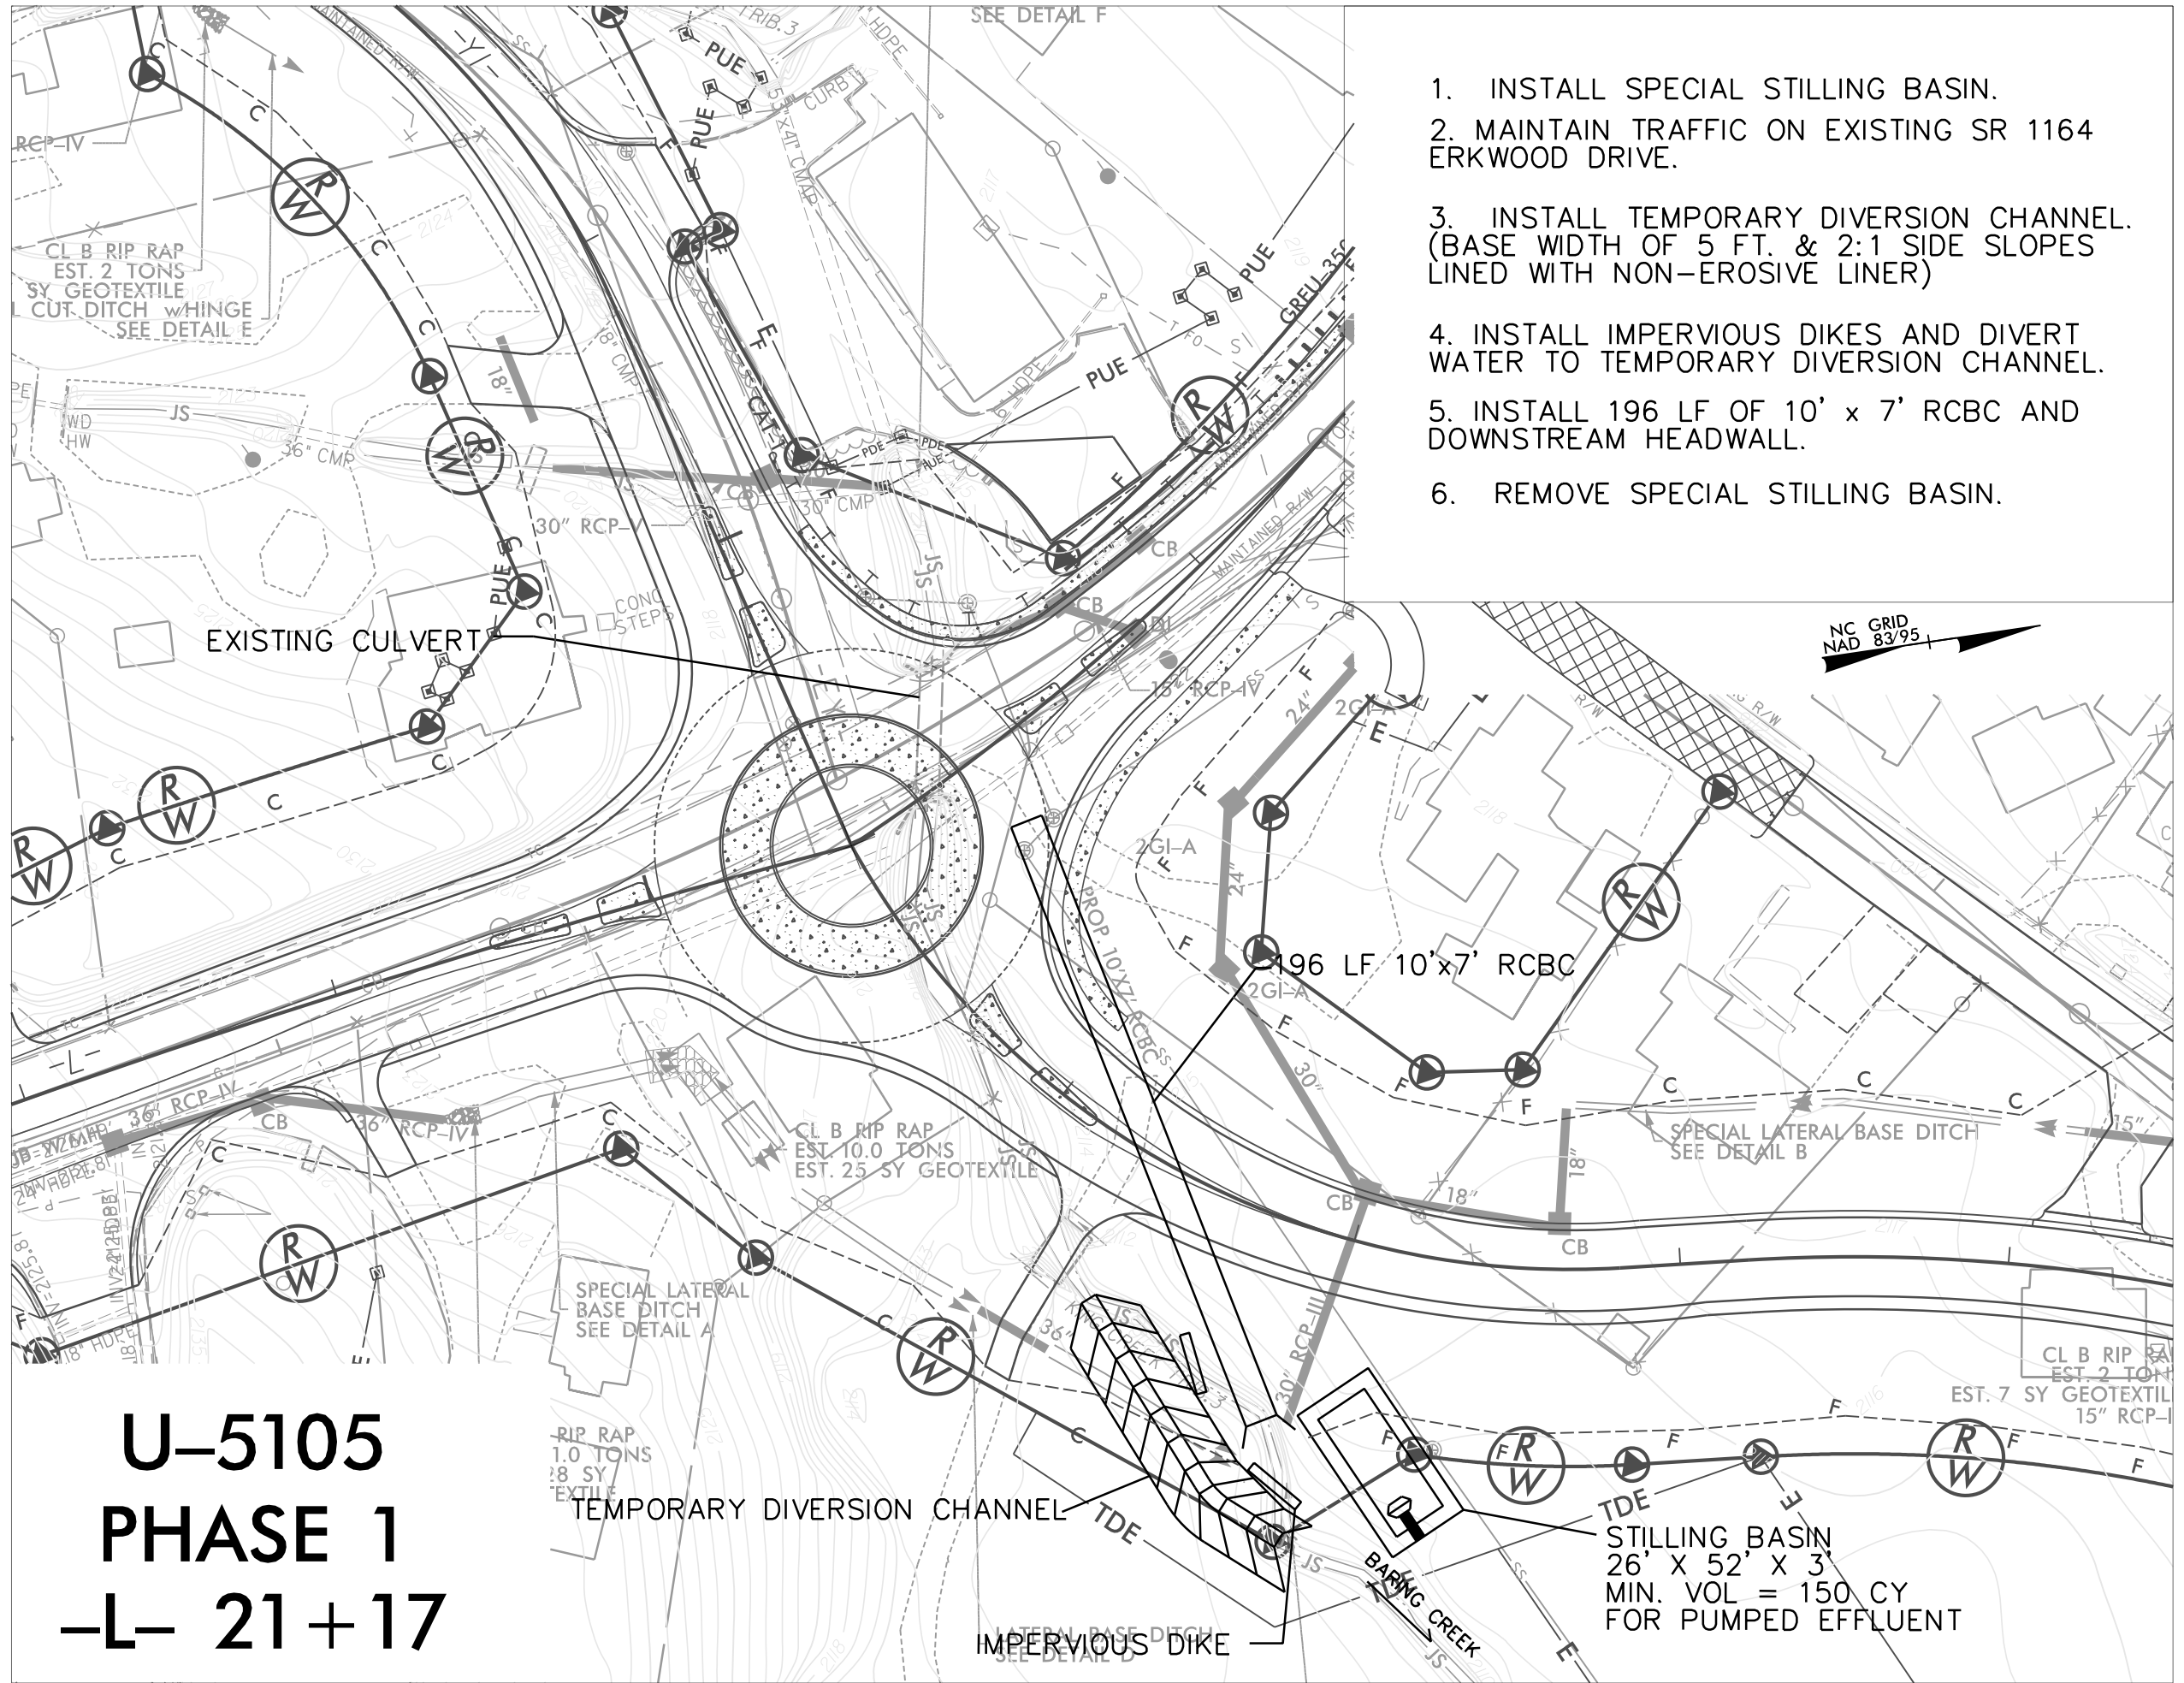

PROJECT REFERENCE NO.	SHEET NO.
U-5105	EC-7
RW SHEET NO.	

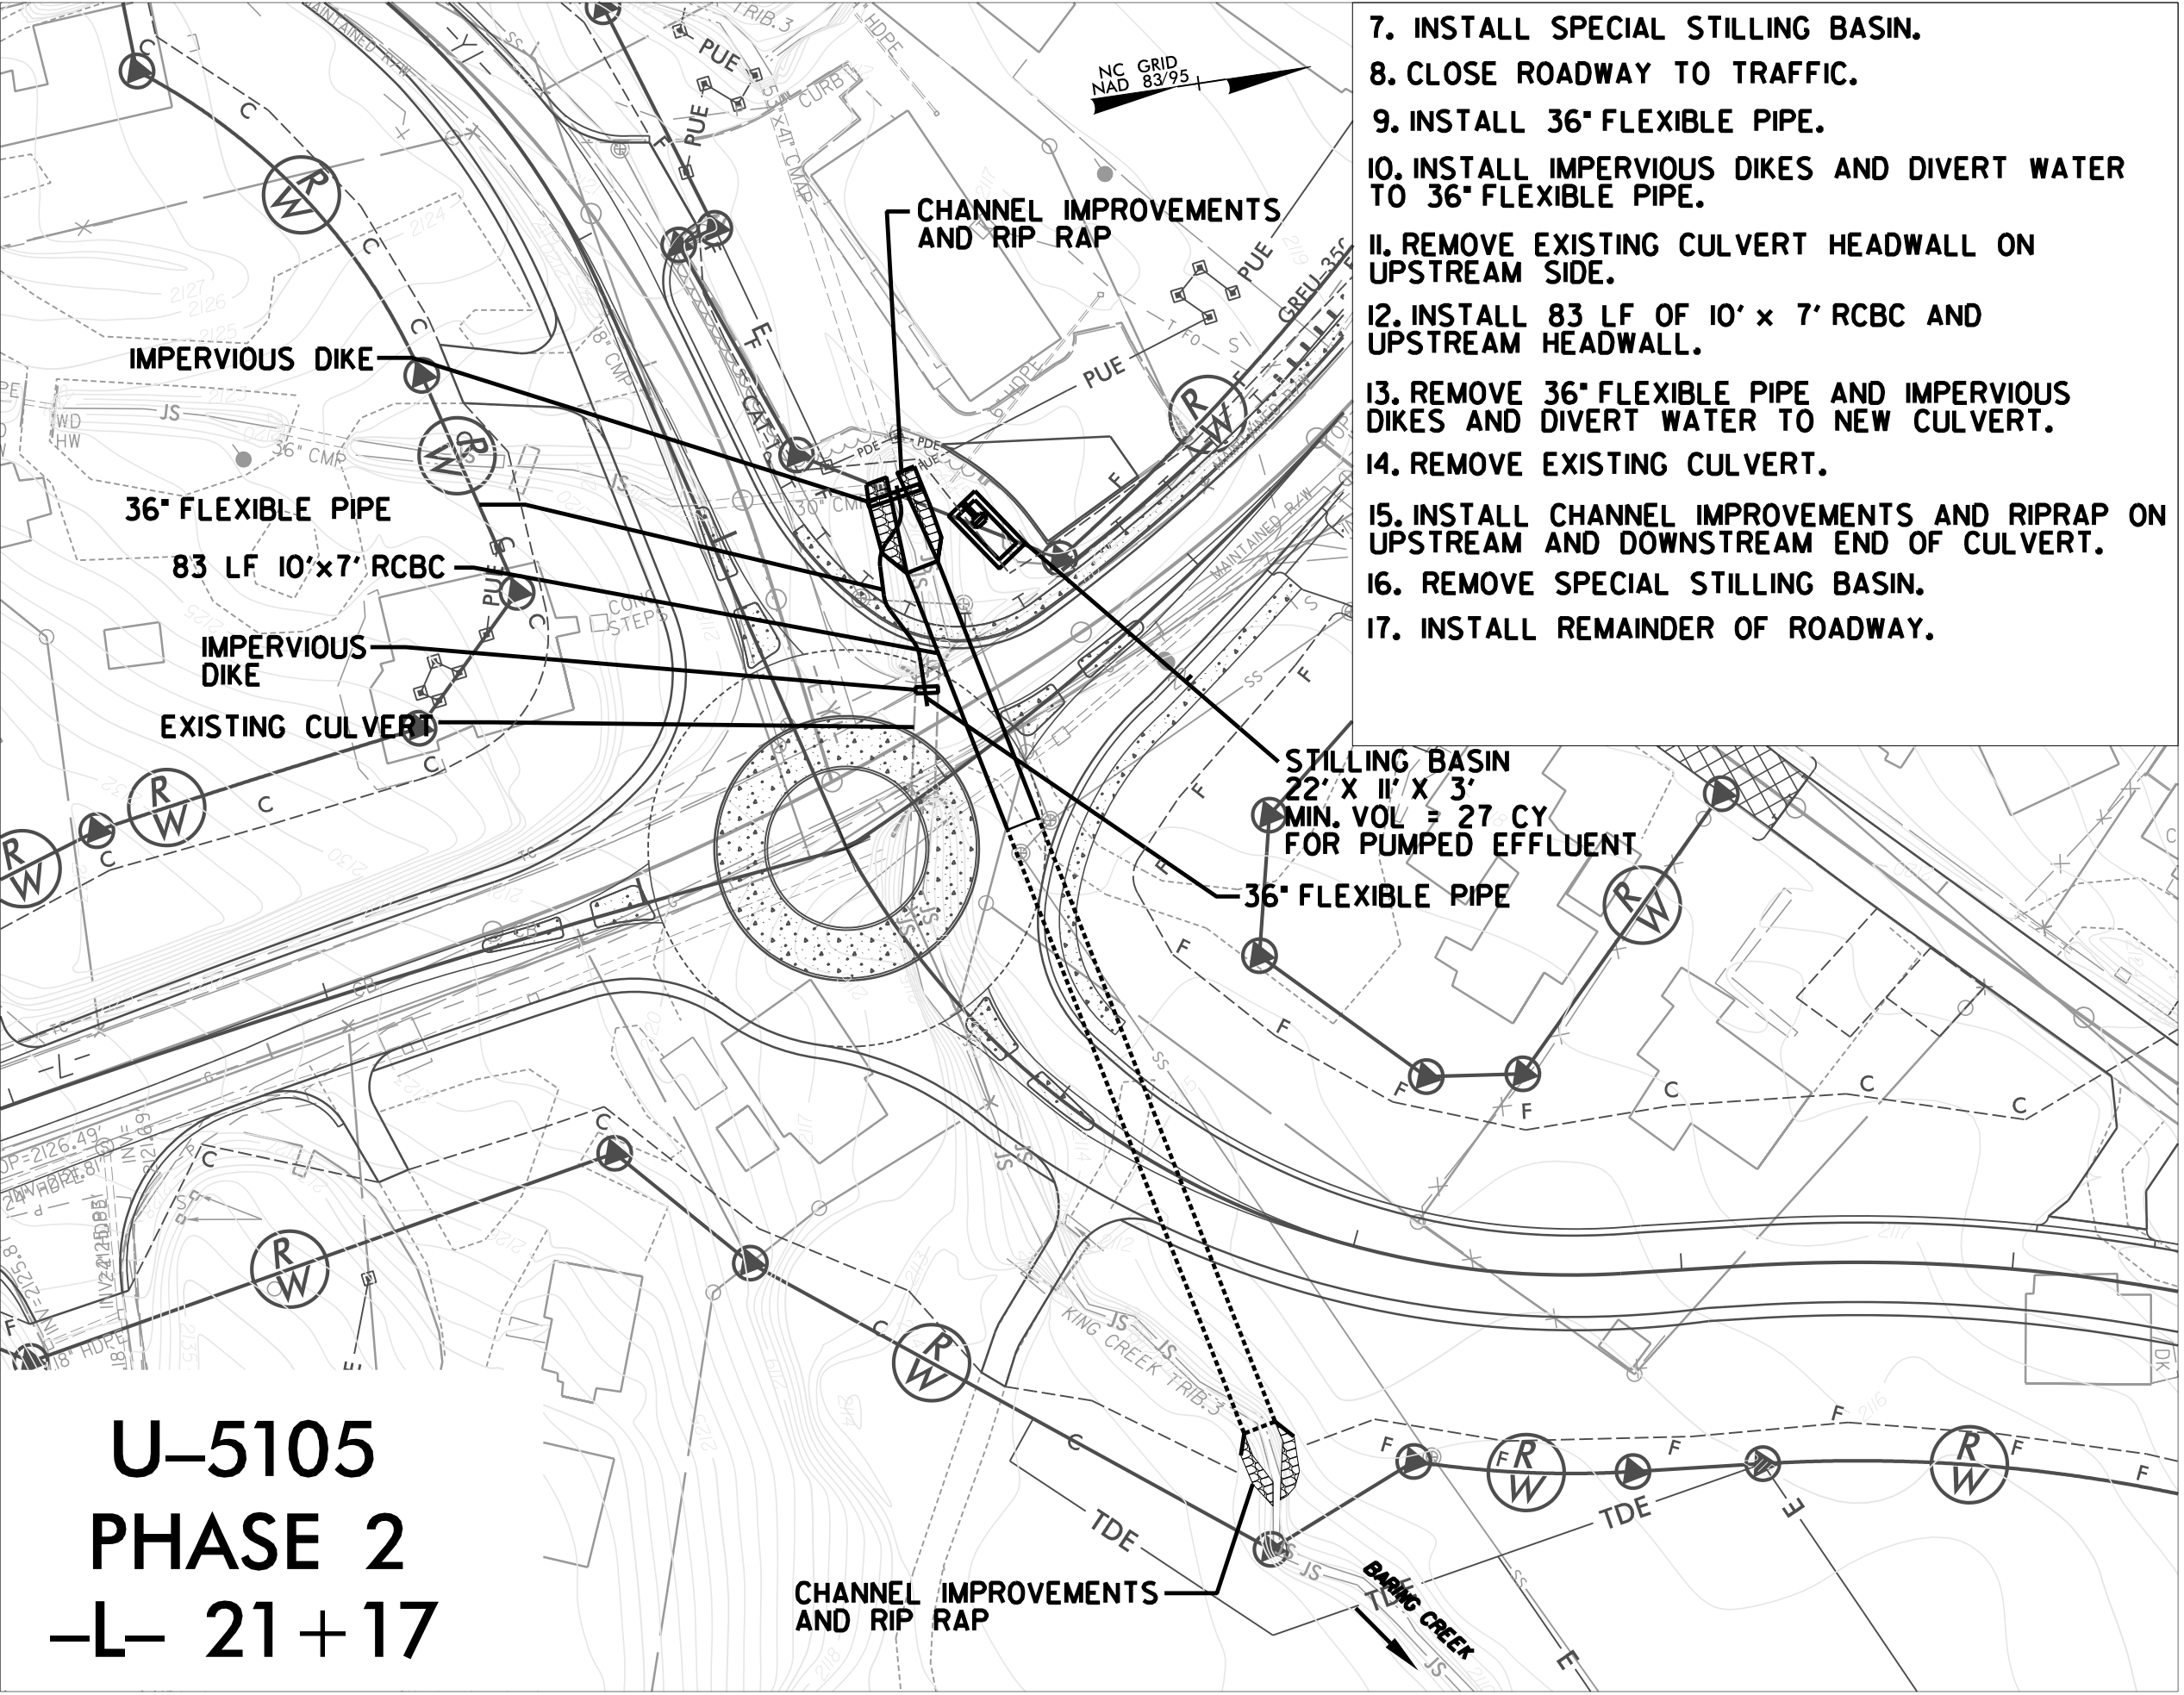



U-5105

CONTRACT:

STATE OF NORTH CAROLINA
DEPARTMENT OF TRANSPORTATION

SIGNING PLAN
HENDERSON COUNTY

 LOCATION: NC 225 (GREENVILLE HIGHWAY) AT SR 1164 (ERKWOOD DR.) AND SR 1779 (SHEPHERD ST)

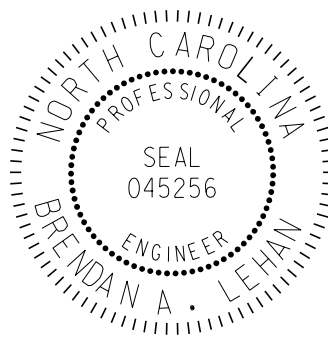TIP NO.	SHEET NO.
U-5105	SIGN-1
APPROVED:  DocuSigned by: Brendan A. Lehan 8B17082F7B54C0...	
DATE: 2/26/2018	
SEAL 	
DOCUMENT NOT CONSIDERED FINAL UNLESS ALL SIGNATURES COMPLETED	

SUMMARY OF QUANTITIES

ITEM NO.		ITEM DESCRIPTION	QUANTITY	UNIT
DESC. NO.	SECT. NO.			
4072000000	903	SUPPORTS, 3LB STEEL U-CHANNEL	400	L.F.
4102000000	904	SIGN ERECTION, TYPE E	22	EA.
4129000000	906	RELOCATE SIGN, TYPE E	4	EA.
4155000000	907	DISPOSAL OF SIGN SYSTEM, U-CHANNEL	5	EA.
4192000000	907	DISPOSAL OF SUPPORT, U-CHANNEL	4	EA.

GENERAL NOTES

- 1 WHEN NOT STATIONED OR DIMENSIONED ON PLANS, ALL 'E' AND 'F' SIGNS SHALL BE FIELD LOCATED BY THE ENGINEER
- 2 ALL EXISTING SIGNS ON "U" CHANNEL POST WITHIN THE PROJECT LIMITS SHALL BE REMOVED AND DISPOSED OF UNLESS OTHERWISE NOTED ON PLANS.
- 3 ALL TYPE 'D' SIGNS SHALL BE MOUNTED ON TWO U-CHANNEL POSTS UNLESS OTHERWISE INDICATED ON THE PLANS.
- 4 WHEN EXISTING SIGNS ARE REMOVED AND INSTALLED ON NEW SUPPORTS, THE RE-ERECTION SHALL IMMEDIATELY FOLLOW THE REMOVAL
- 5 IF REMOVAL OR RELOCATION OF SIGNS ON PRIVATE STREET (NON-STATE MAINTAINED) IS REQUIRED DUE TO CONSTRUCTION, THE CONTRACTOR SHALL INFORM THE ENGINEER. THE WORK WILL BE COMPLETED BY OTHERS.
- 6 THE BACKGROUND FOR TYPE E & F SIGNS SHALL BE TYPE C REFLECTIVE SHEETING

ROADWAY STANDARD DRAWING

THE FOLLOWING ROADWAY STANDARDS AS APPEAR IN "ROADWAY STANDARD DRAWINGS" - PROJECT SERVICES UNIT - N.C. DEPARTMENT OF TRANSPORTATION - RALEIGH, N.C., DATED JANUARY 2018 ARE APPLICABLE TO THIS PROJECT AND BY REFERENCE HEREBY ARE CONSIDERED A PART OF THESE PLANS:

STD. NO.	TITLE
904.10	ORIENTATION OF GROUND MOUNTED SIGNS
904.50	MOUNTING OF TYPE 'D', 'E', AND 'F' SIGNS ON 'U' CHANNEL POSTS
910.40	SINGLE LANE ROUNDABOUT SIGNING, WITH PEDESTRIANS


PAY ITEM NOTES

1. DISPOSAL OF SIGN SYSTEM, U-CHANNEL
2. RELOCATE SIGN, TYPE E
3. DISPOSAL OF SUPPORT, U-CHANNEL
4. CONTACT NCDOT TRAFFIC SERVICES FOR REMOVAL AND REPLACEMENT

INDEX

SHEET NO.	DESCRIPTION
SIGN-1	TITLE SHEET
SIGN-2	SIGN QUANTITIES
SIGN-3	SIGN (EXISTING) DETAIL
SIGN-4	SIGN (PROPOSED) DETAIL

Prepared In the Offices of: M M MOTT MACDONALD PO Box 700 Fayetteville, NC 27526 www.mtmtd.com License No. F-00693	SIGNING DESIGN ENGINEER DocuSigned by: <i>Brendan Lehan</i> e01708e2f7b54cd. 
	DOCUMENT NOT CONSIDERED FINAL UNLESS ALL SIGNATURES COMPLETED

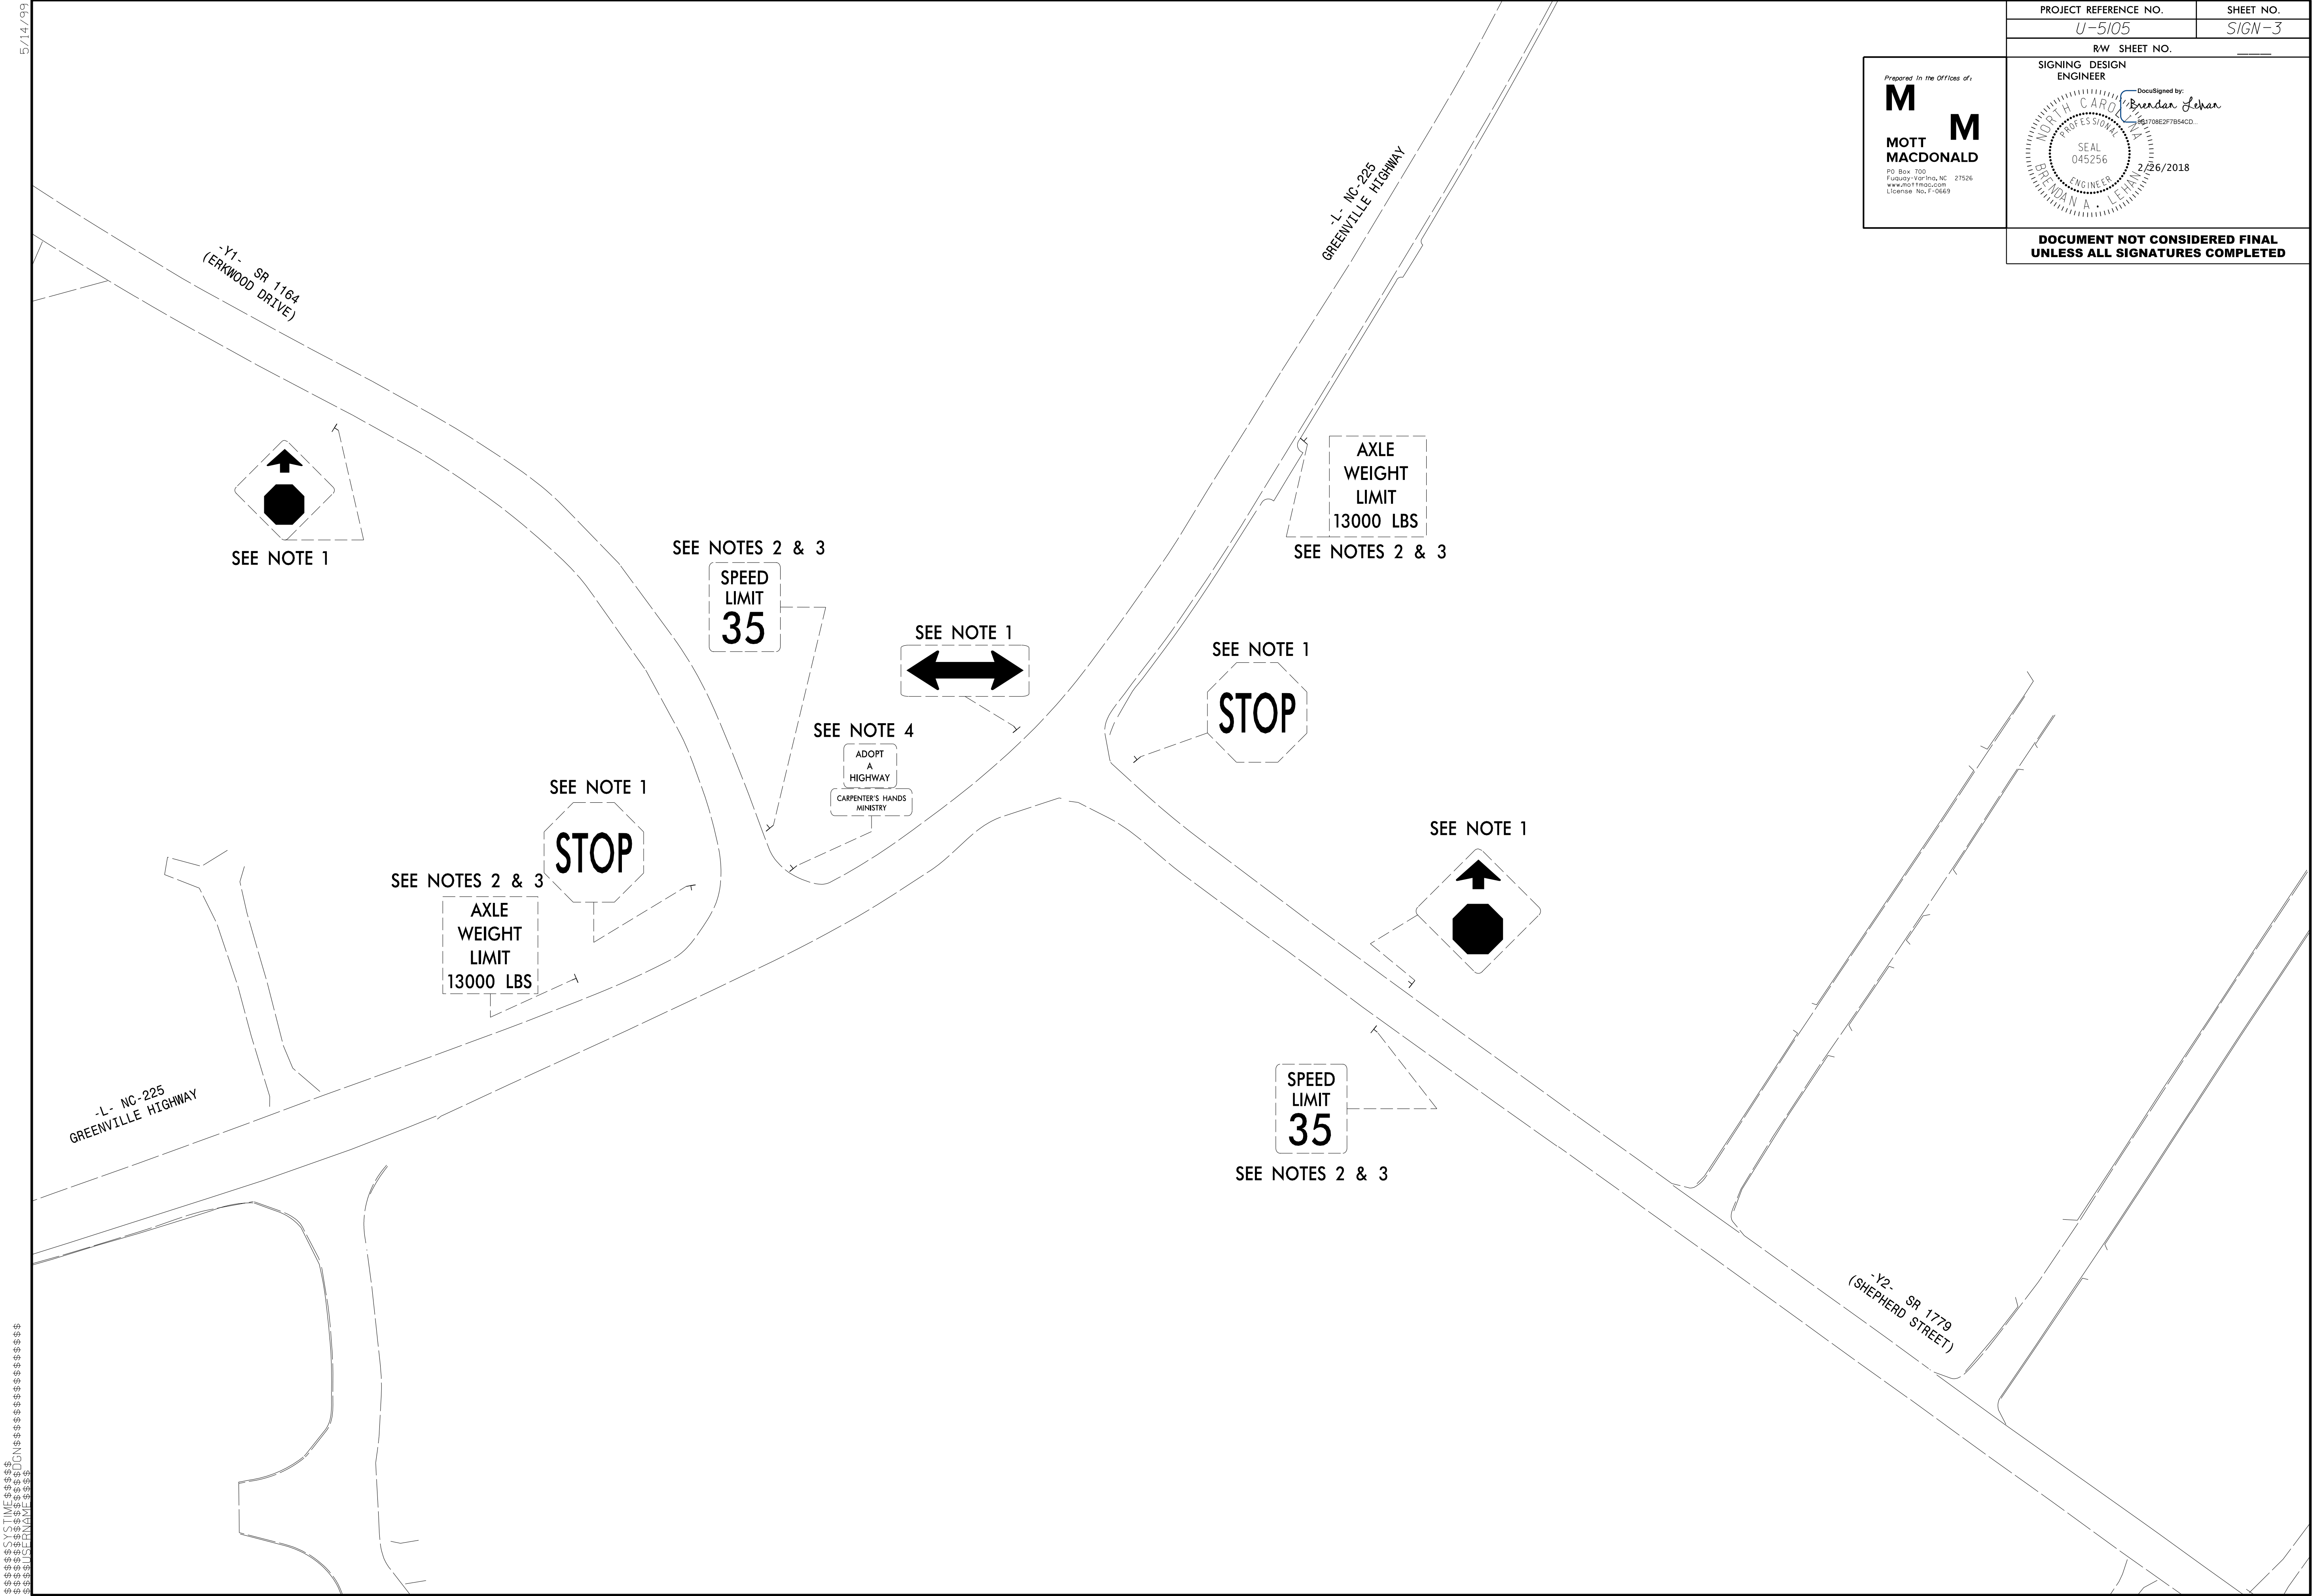

Prepared In the Offices of:

M

M

**MOTT
MACDONALD**

PO Box 700
Fuquay-Varina, NC 27526
www.mmt1llp.com
License No. F-0669

SIGNING DESIGN
ENGINEER


DocuSigned by:
Brendan Lehar
045256
2/26/2018


PROJECT REFERENCE NO.
U-5105

SHEET NO.
SIGN-3


RW SHEET NO.

**DOCUMENT NOT CONSIDERED FINAL
UNLESS ALL SIGNATURES COMPLETED**

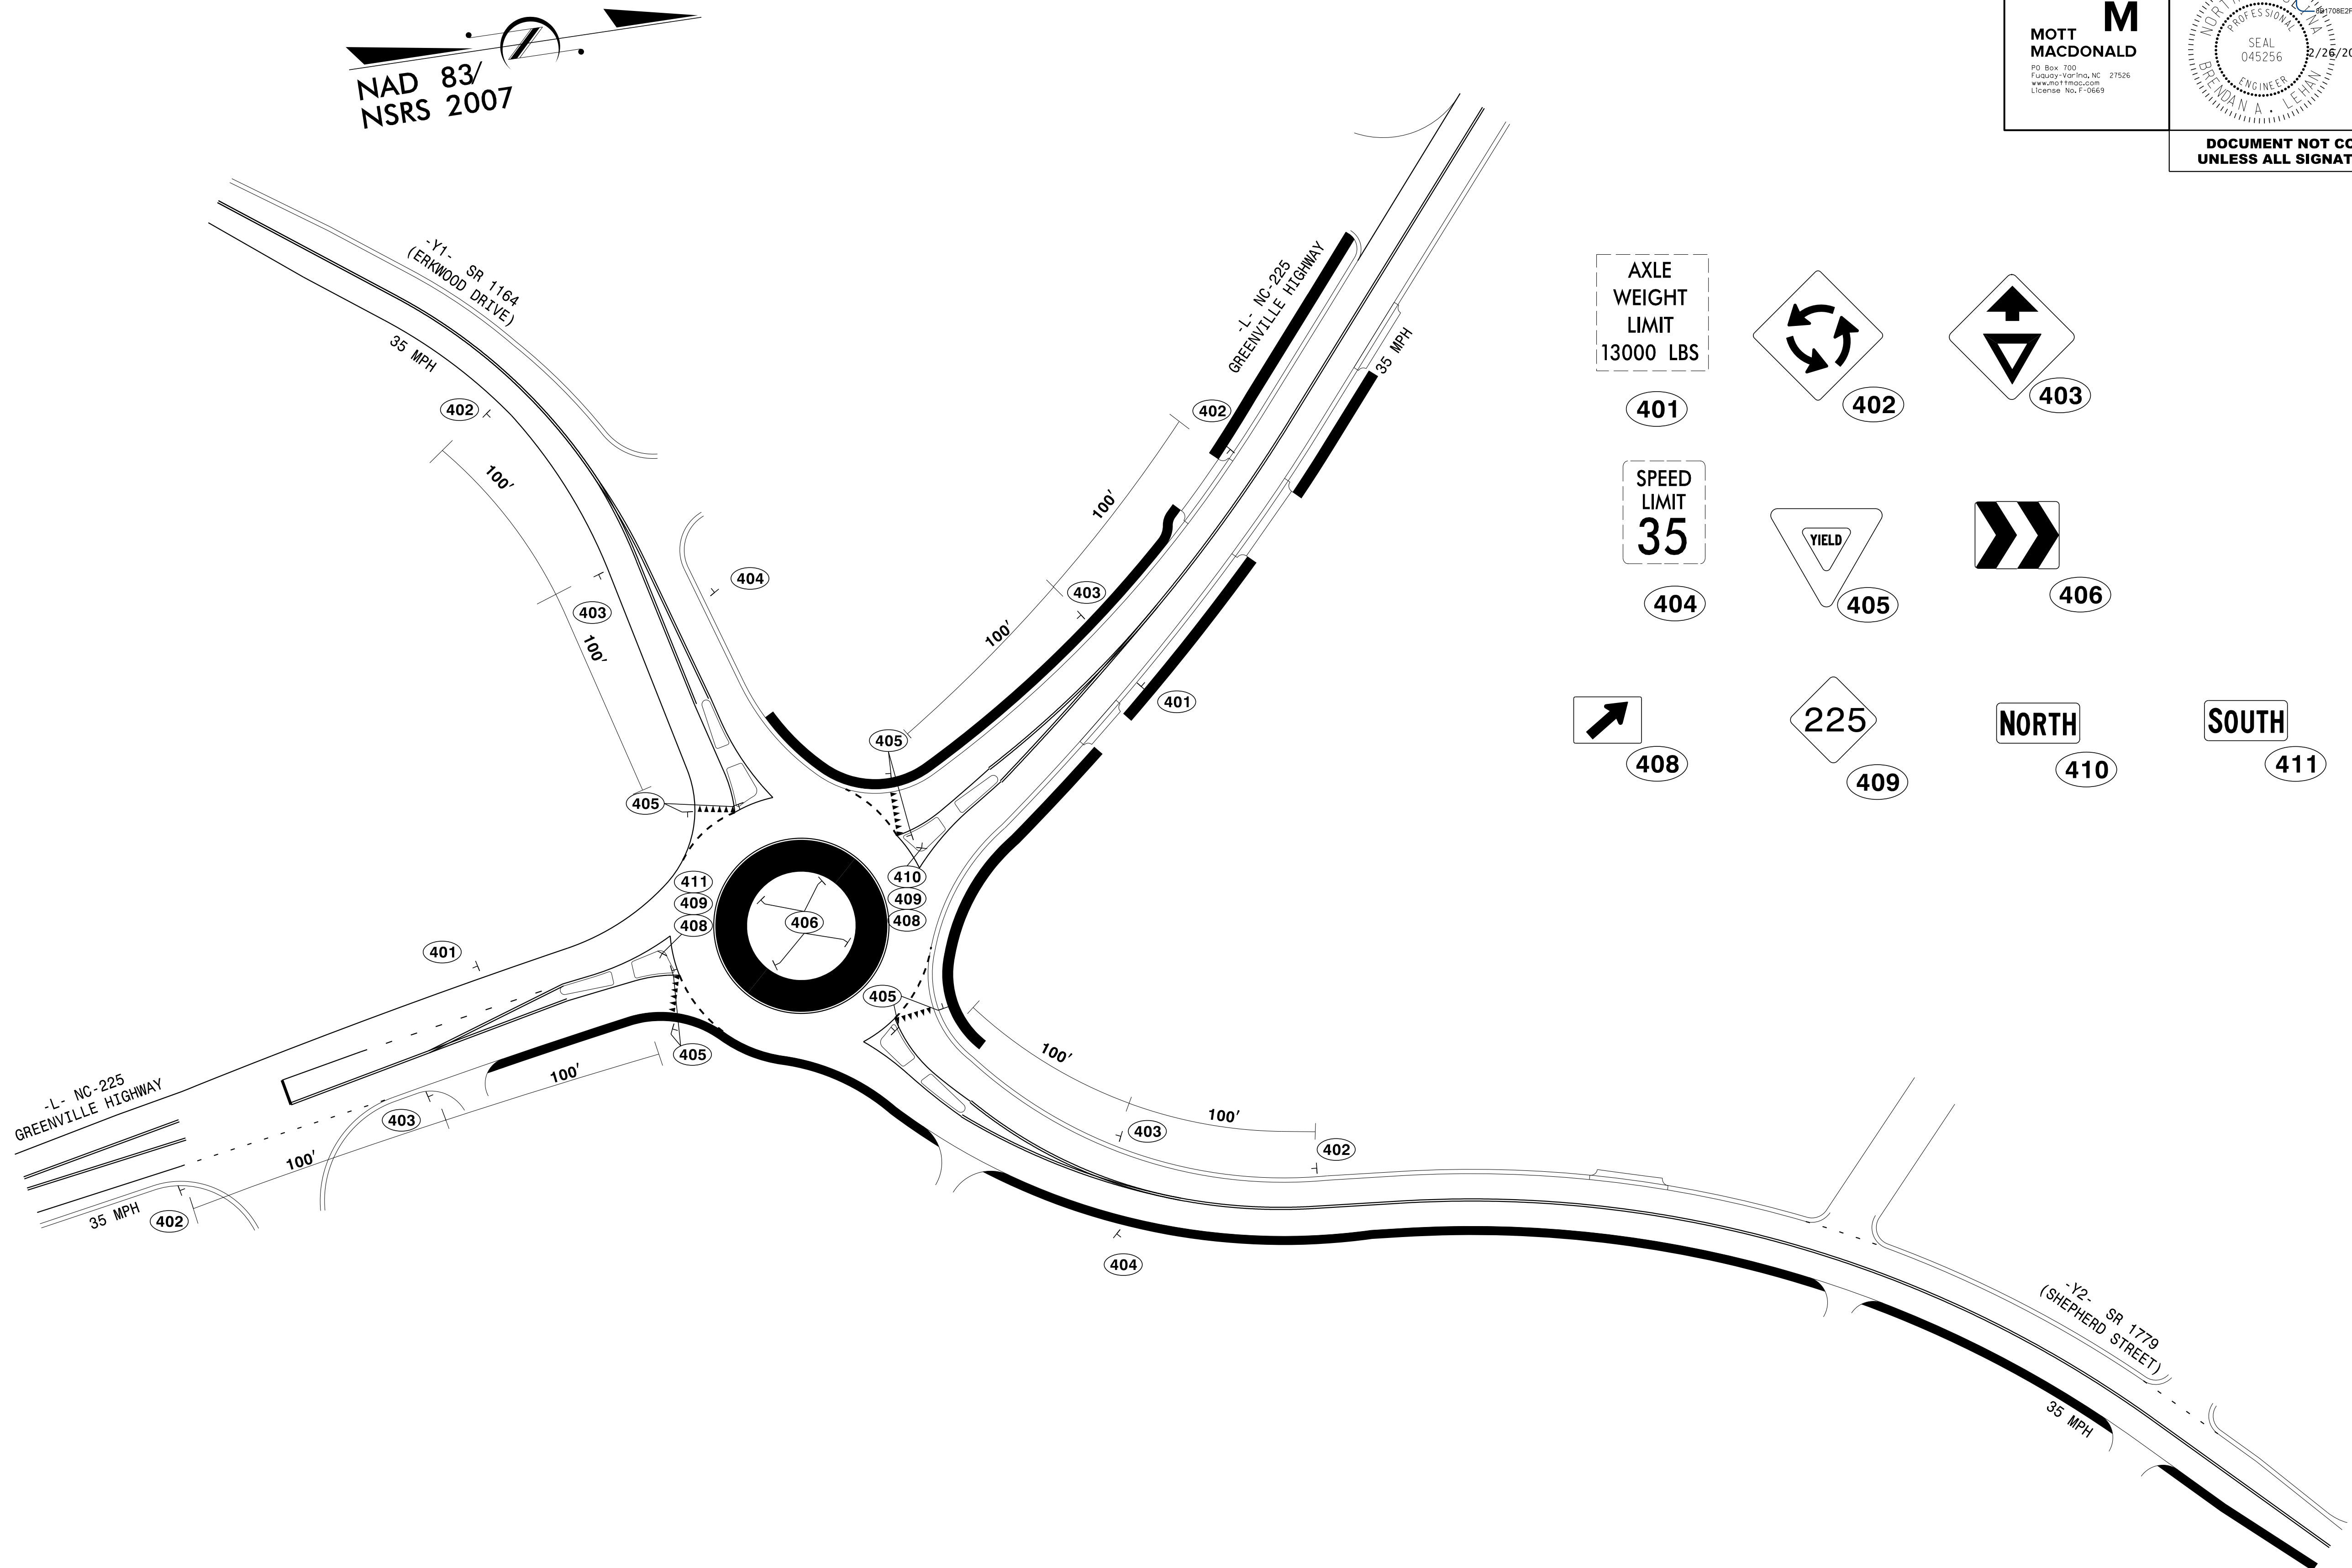

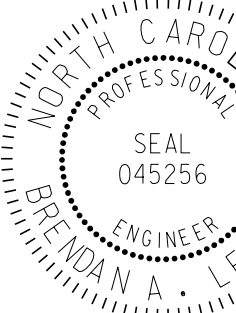PROJECT REFERENCE NO. <i>U-5105</i>	SHEET NO. <i>SIGN-4</i>
RW SHEET NO. _____	
SIGNING DESIGN ENGINEER	
 DocuSigned by: <i>Brenda Lehan</i> 0617082F7B54CD...	
DOCUMENT NOT CONSIDERED FINAL UNLESS ALL SIGNATURES COMPLETED	



TIP PROJECT: U-5105

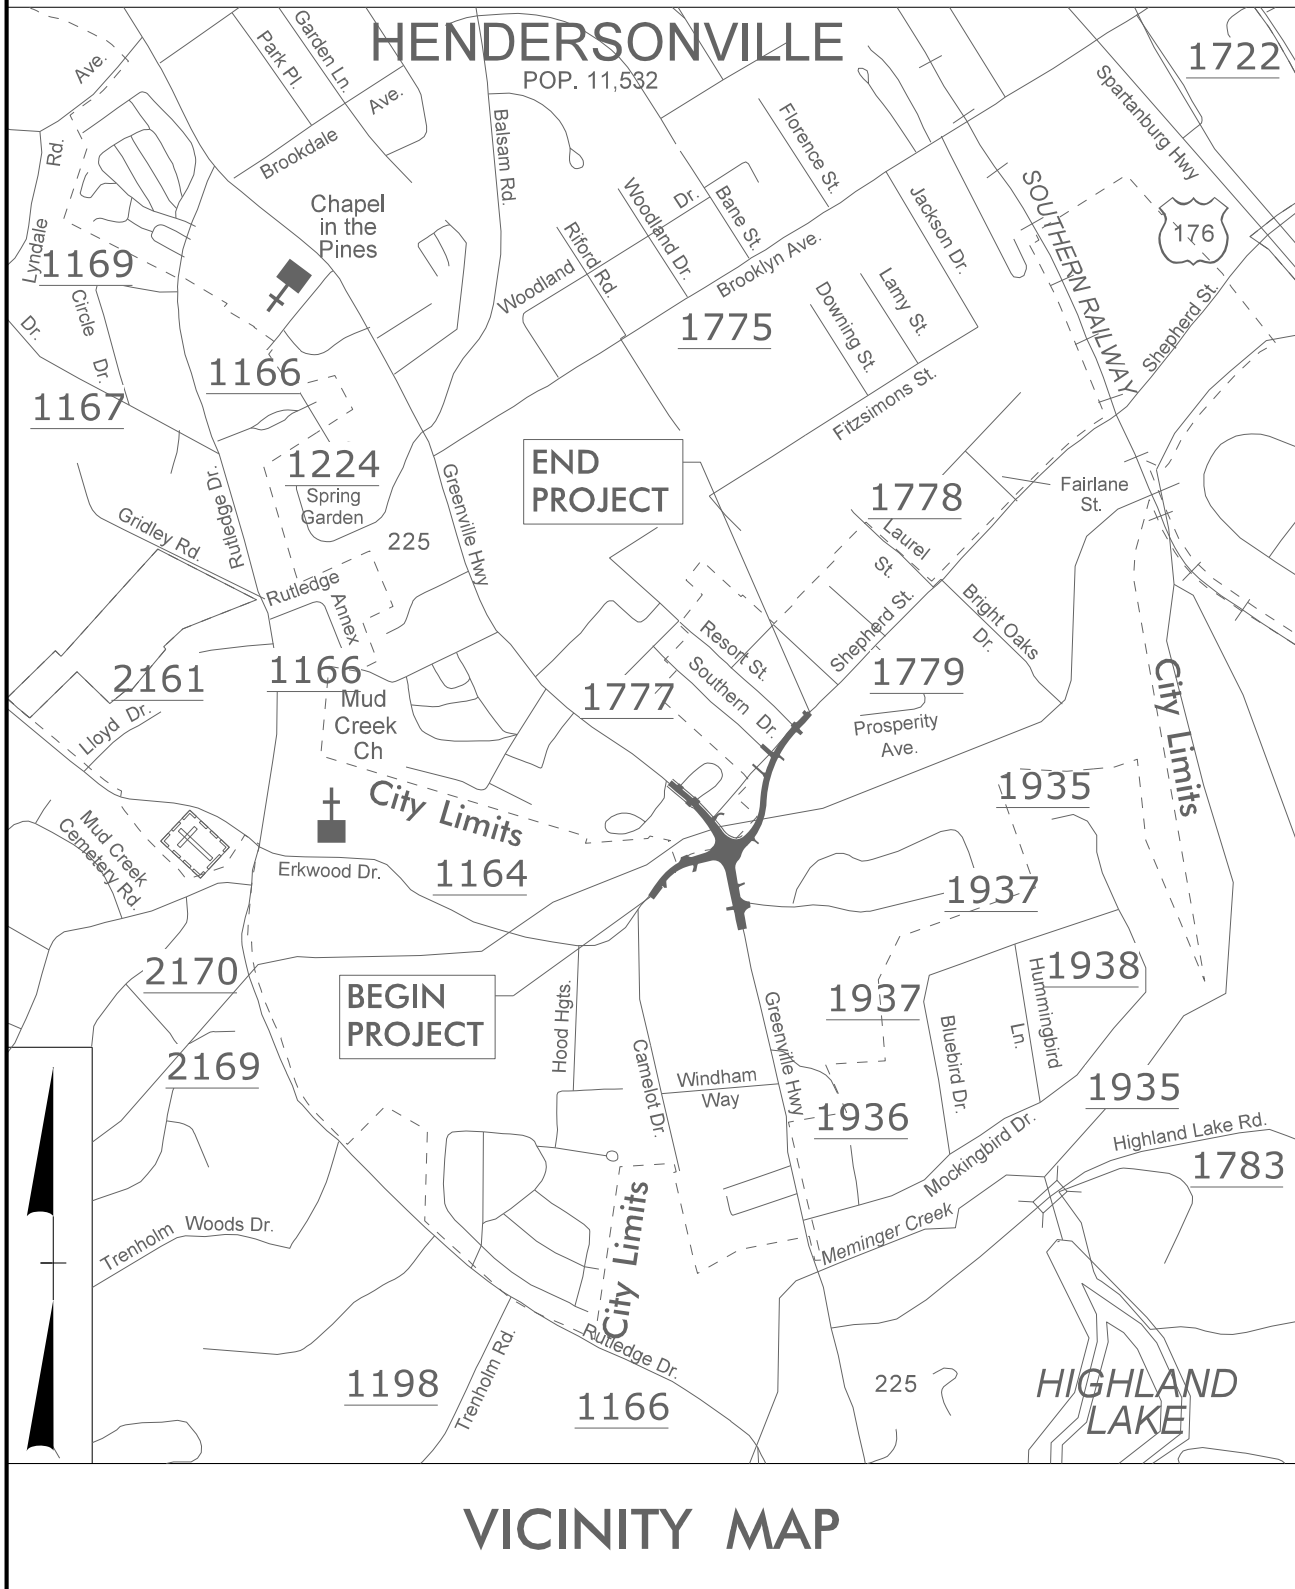

STATE OF NORTH CAROLINA
DIVISION OF HIGHWAYS


UTILITY CONSTRUCTION PLANS HENDERSON COUNTY

LOCATION: NC 225 (GREENVILLE HWY) INTERSECTION IMPROVEMENTS
FROM SR 1164 (ERKWOOD DR) TO SR 1779 (SHEPHERD ST)
TYPE OF WORK: UTILITIES

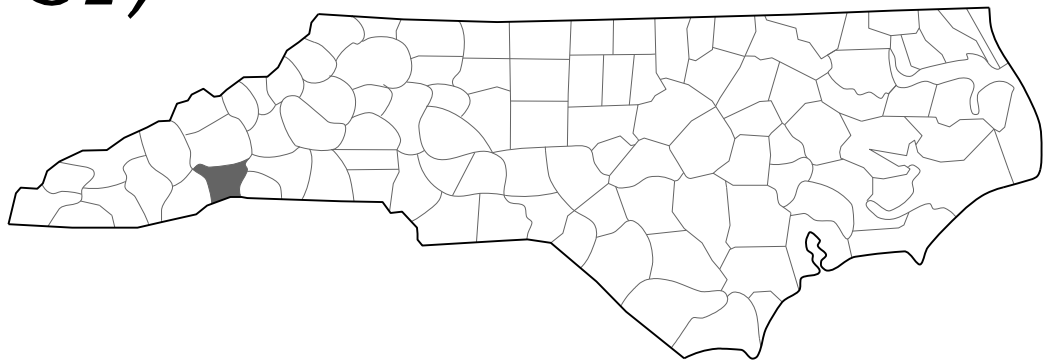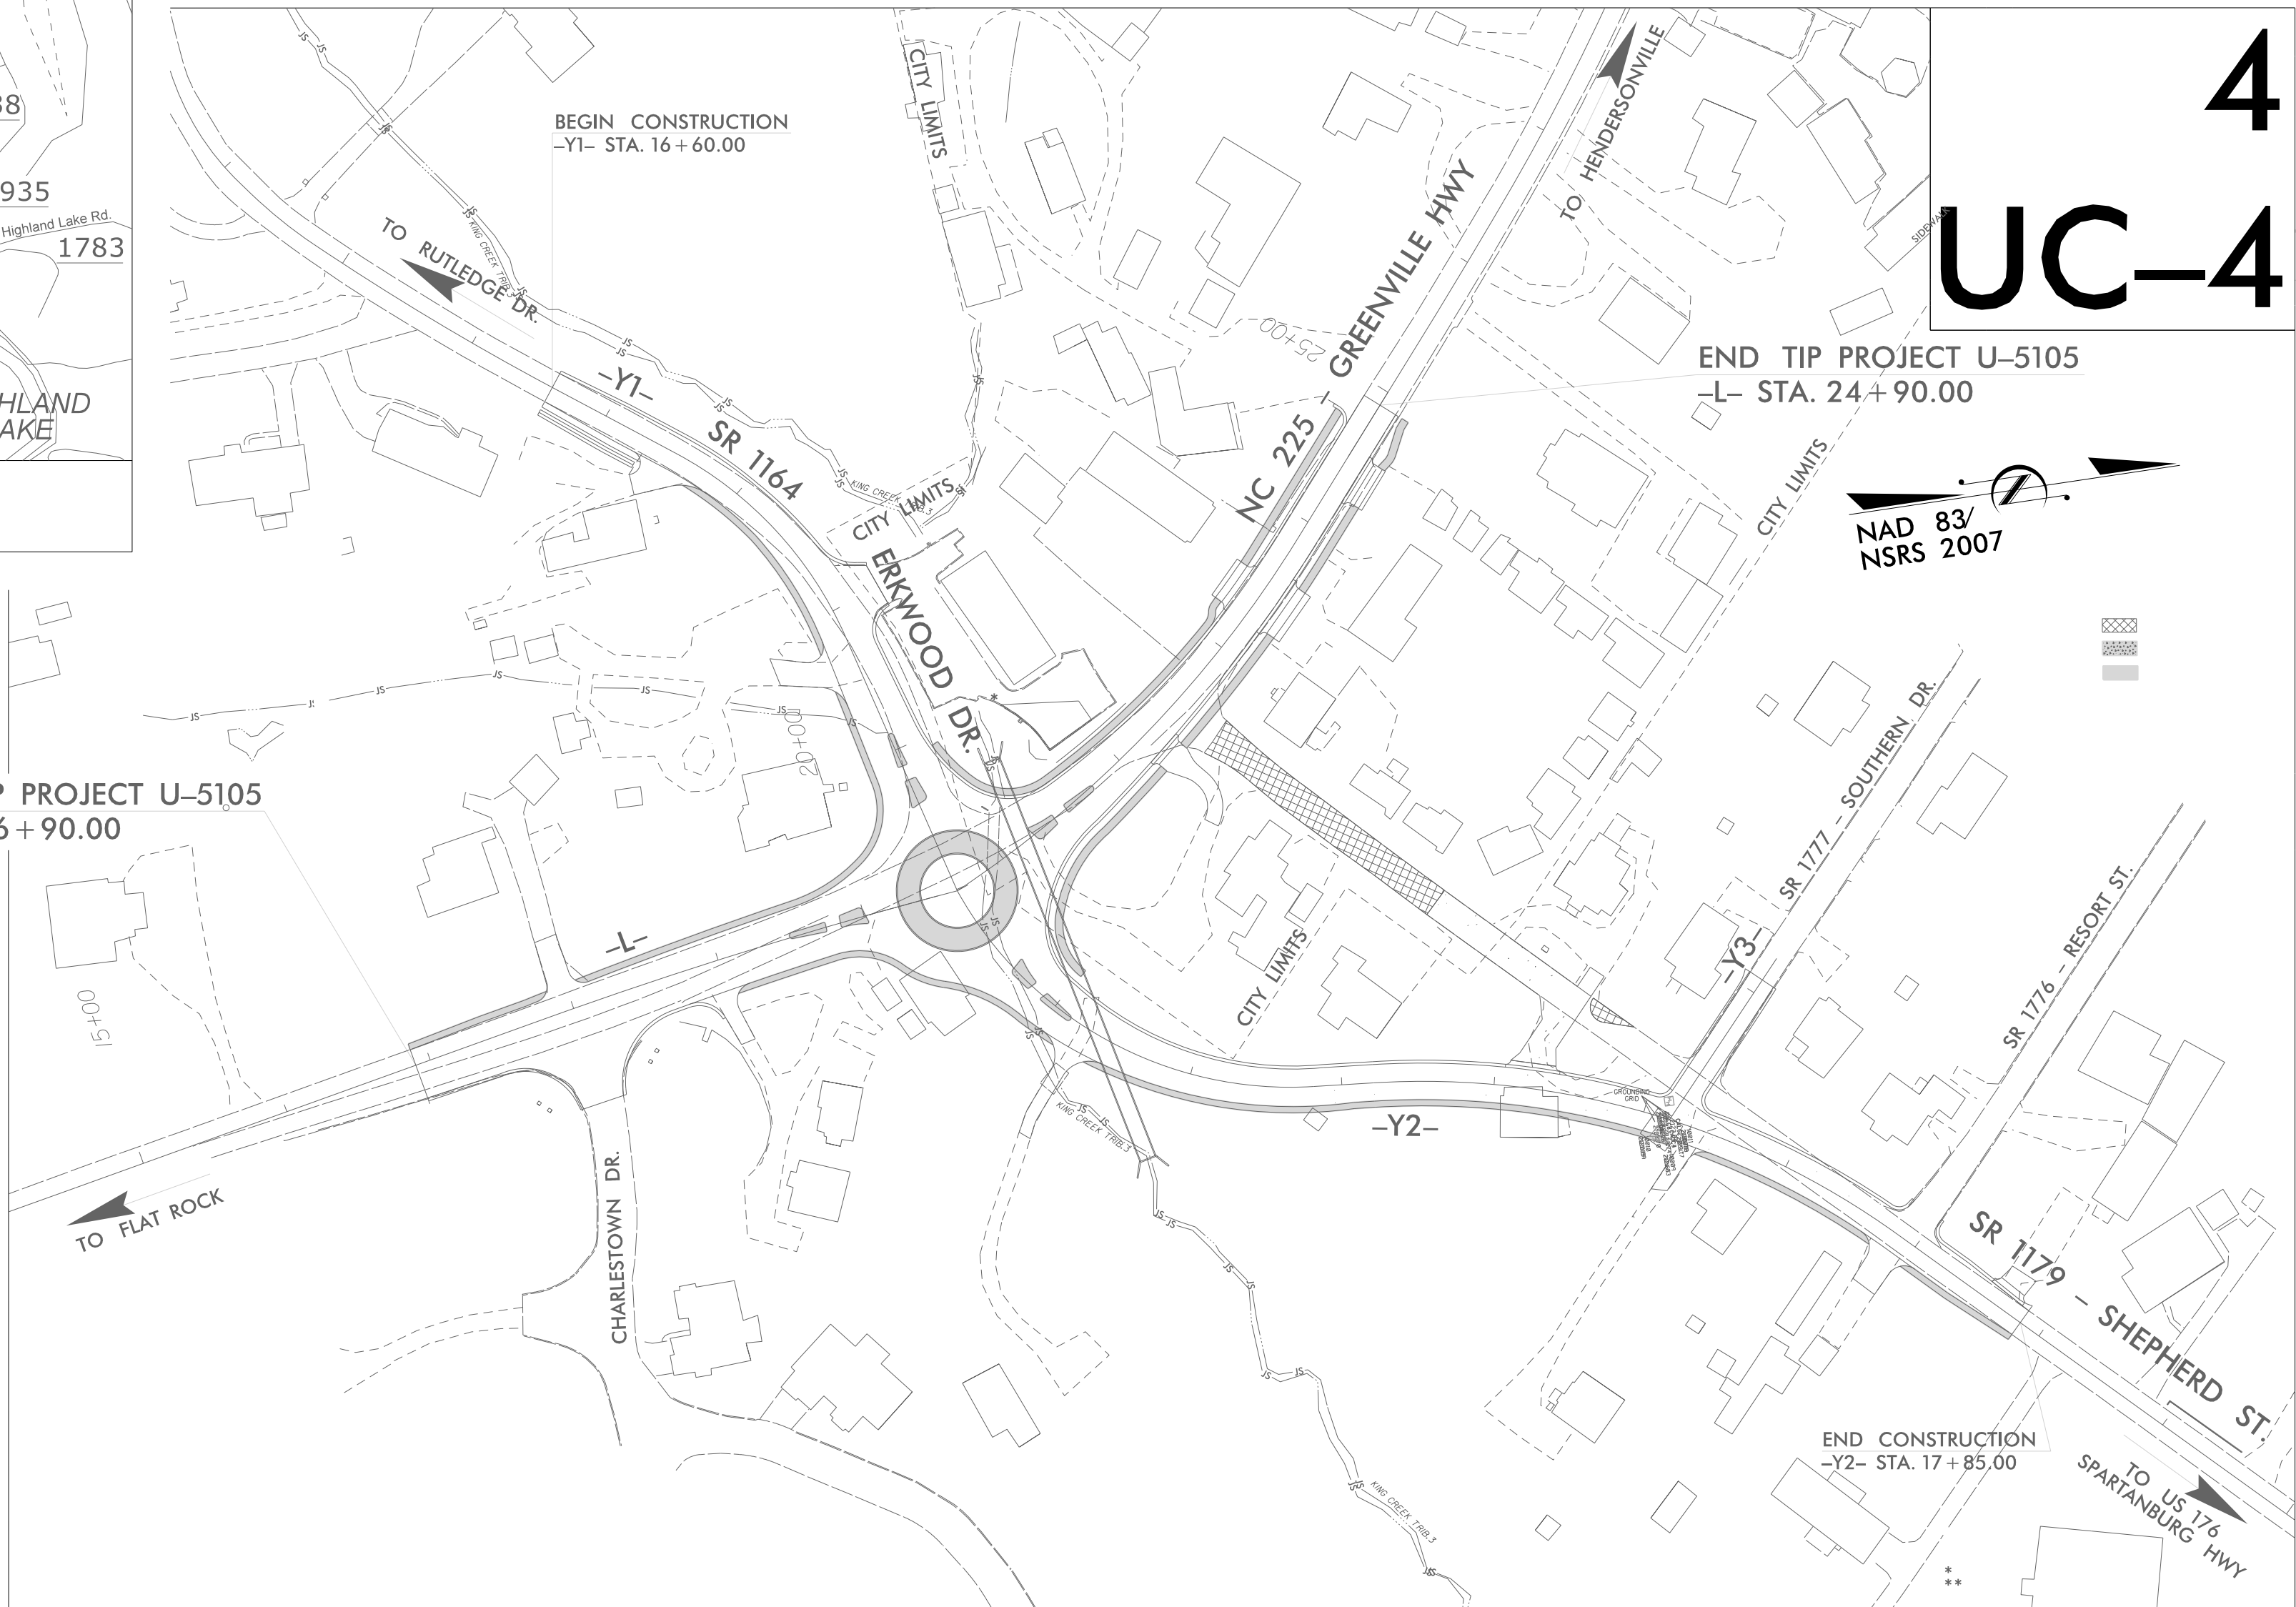

A PORTION OF THIS PROJECT IS WITHIN THE MUNICIPAL BOUNDARIES OF HENDERSONVILLE.

CLEARING ON THIS PROJECT SHALL BE PERFORMED TO THE LIMITS ESTABLISHED BY METHOD II.

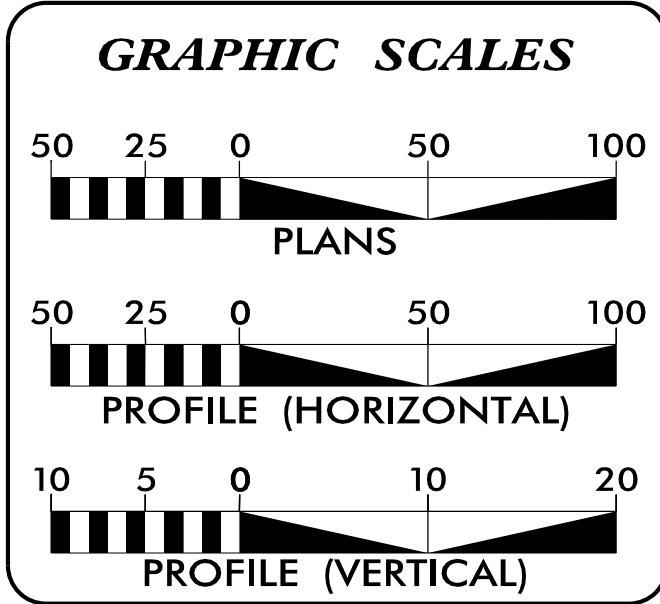

INDEX OF SHEETS	
SHEET NO.	DESCRIPTION
UC-1	TITLE SHEET
UC-2	UTILITY SYMBOLOGY
UC-3	NOTES
UC-3A THRU UC-3D	DETAILS
UC-4	UTILITY CONSTRUCTION SHEET
UC-5 THRU UC-7	PROFILE SHEETS

WATER AND SEWER OWNERS ON PROJECT

TOWN OF HENDERSONVILLE - WATER AND SEWER

PREPARED IN THE OFFICE OF:

HINDE ENGINEERING

License No. C-2639
7520 E. Independence Blvd., Suite 230 Charlotte, NC 28227
Ph. (704) 814-4407

Ronald B. Wilkins, P.E. UTILITIES PROJECT MANAGER
Clint L. Stevens, P.E. UTILITIES PROJECT ENGINEER
Ronald B. Wilkins, P.E. UTILITIES PROJECT DESIGNER

SEAL

5/21/2018 7:13:09 AM EDT


DIVISION OF HIGHWAYS UTILITIES UNIT

1555 MAIL SERVICES CENTER
RALEIGH NC 27699-1555
PHONE (919) 707-6690
FAX (919) 250-4151



<u>Ted Adams</u>	DIVISION CONTACT #1
<u>Mitchell Bishop</u>	DIVISION CONTACT #2
<u>Bob Golding</u>	DIVISION CONTACT #3
<u>Steve Cannon, PE</u>	DIVISION CONTACT #4

UTILITIES PLAN SHEET SYMBOLS


 
PROPOSED WATER SYMBOLS

Water Line (Sized as Shown)	
11¼ Degree Bend	
22½ Degree Bend	
45 Degree Bend	
90 Degree Bend	
Plug	
Tee	
Cross	
Reducer	
Gate Valve	
Butterfly Valve	
Tapping Valve	
Line Stop	
Line Stop with Bypass	
Blow Off	
Fire Hydrant	
Relocate Fire Hydrant	
Remove Fire Hydrant	
Water Meter	
Relocate Water Meter	
Remove Water Meter	
Water Pump Station	
RPZ Backflow Preventer	
DCV Backflow Preventer	
Relocate RPZ Backflow Preventer	
Relocate DCV Backflow Preventer	

  PROPOSED SEWER SYMBOLS


Gravity Sewer Line (Sized as Shown)	
Force Main Sewer Line (Sized as Shown)	
Manhole (Sized per Note)	
Sewer Pump Station	



 
 
PROPOSED MISCELLANEOUS UTILITIES SYMBOLS


Power Pole	
Telephone Pole	
Joint Use Pole	
Telephone Pedestal	
Utility Line by Others (Type as Shown)	
Trenchless Installation	
Encasement by Open Cut	
Encasement	

Thrust Block	
Air Release Valve	
Utility Vault	
Concrete Pier	
Steel Pier	
Plan Note	
Pay Item Note	

 EXISTING UTILITIES SYMBOLS

Power Pole	
Telephone Pole	
Joint Use Pole	
Utility Pole	
Utility Pole with Base	
H-Frame Pole	
Power Transmission Line Tower	
Water Manhole	
Power Manhole	
Telephone Manhole	
Sanitary Sewer Manhole	
Hand Hole for Cable	
Power Transformer	
Telephone Pedestal	
CATV Pedestal	
Gas Valve	
Gas Meter	
Located Miscellaneous Utility Object	
Abandoned According to Utility Records	
End of Information	

    *Underground Power Line	
*Underground Telephone Cable	
*Underground Telephone Conduit	
*Underground Fiber Optics Telephone Cable	
*Underground TV Cable	
*Underground Fiber Optics TV Cable	
*Underground Gas Pipeline	
Aboveground Gas Pipeline	
*Underground Water Line	
Aboveground Water Line	
*Underground Gravity Sanitary Sewer Line	
Aboveground Gravity Sanitary Sewer Line	
*Underground SS Forced Main Line	
Underground Unknown Utility Line	
SUE Test Hole	
Water Meter	
Water Valve	
Fire Hydrant	
Sanitary Sewer Cleanout	

 *For Existing Utilities	
Utility Line Drawn from Record (Type as Shown)	
Designated Utility Line (Type as Shown)	

18-JUL-2018 06:19 C:\S:\PROJECTS\2014\A20141102.00 MulKey-U-5105\Design\Utilities\Engineering\UC\Proj\U5105_ut_notes_UC03.psh.dgn

GENERAL NOTES:

1. THE PROPOSED UTILITY CONSTRUCTION SHALL MEET THE APPLICABLE REQUIREMENTS OF THE NC DEPARTMENT OF TRANSPORTATION'S "STANDARD SPECIFICATIONS FOR ROADS AND STRUCTURES" DATED JANUARY 2018.
2. THE EXISTING UTILITIES BELONG TO THE CITY OF HENDERSONVILLE, N.C. THE CONTACT PERSON FOR THE CITY IS MR. BRENT DETWILER, PE AND HE CAN BE REACHED AT (828) 697-3060
3. ALL WATER LINES TO BE INSTALLED WITHIN COMPLIANCE OF THE RULES AND REGULATIONS OF THE NORTH CAROLINA DEPARTMENT OF ENVIRONMENTAL QUALITY, DIVISION OF WATER RESOURCES, PUBLIC WATER SUPPLY SECTION. ALL SEWER LINES TO BE INSTALLED WITHIN COMPLIANCE OF THE RULES AND REGULATIONS OF THE NORTH CAROLINA DEPARTMENT OF ENVIRONMENT QUALITY, DIVISION OF WATER RESOURCES, WATER QUALITY SECTION. PERFORM ALL WORK IN ACCORDANCE WITH THE APPLICABLE PLUMBING CODES.
4. THE UTILITY OWNER OWNS THE EXISTING UTILITY FACILITIES AND WILL OWN THE NEW UTILITY FACILITIES AFTER ACCEPTANCE BY THE DEPARTMENT. THE DEPARTMENT OWNS THE CONSTRUCTION CONTRACT AND HAS ADMINISTRATIVE AUTHORITY. COMMUNICATIONS AND DECISIONS BETWEEN THE CONTRACTOR AND UTILITY OWNER ARE NOT BINDING UPON THE DEPARTMENT OR THIS CONTRACT UNLESS AUTHORIZED BY THE ENGINEER. AGREEMENTS BETWEEN THE UTILITY OWNER AND CONTRACTOR FOR THE WORK THAT IS NOT PART OF THIS CONTRACT OR IS SECONDARY TO THIS CONTRACT ARE ALLOWED, BUT ARE NOT BINDING UPON THE DEPARTMENT.
5. PROVIDE ACCESS FOR THE DEPARTMENT PERSONNEL AND THE OWNER'S REPRESENTATIVES TO ALL PHASES OF CONSTRUCTION. NOTIFY DEPARTMENT PERSONNEL AND THE UTILITY OWNER TWO WEEKS PRIOR TO COMMENCEMENT OF ANY WORK AND ONE WEEK PRIOR TO SERVICE INTERRUPTION. KEEP UTILITY OWNERS' REPRESENTATIVES INFORMED OF WORK PROGRESS AND PROVIDE OPPORTUNITY FOR INSPECTION OF CONSTRUCTION AND TESTING.

UTILITY CONSTRUCTION

6. THE PLANS DEPICT THE BEST AVAILABLE INFORMATION FOR THE LOCATION, SIZE, AND TYPE OF MATERIAL FOR ALL EXISTING UTILITIES. MAKE INVESTIGATIONS FOR DETERMINING THE EXACT LOCATION, SIZE, AND TYPE MATERIAL OF THE EXISTING FACILITIES AS NECESSARY FOR THE CONSTRUCTION OF THE PROPOSED UTILITIES AND FOR AVOIDING DAMAGE TO EXISTING FACILITIES. REPAIR ANY DAMAGE INCURRED TO EXISTING FACILITIES TO THE ORIGINAL OR BETTER CONDITION AT NO ADDITIONAL COST TO THE DEPARTMENT.
7. MAKE FINAL CONNECTIONS OF THE NEW WORK TO THE EXISTING SYSTEM WHERE INDICATED ON THE PLANS, AS REQUIRED TO FIT THE ACTUAL CONDITIONS, OR AS DIRECTED.
8. MAKE CONNECTIONS BETWEEN EXISTING AND PROPOSED UTILITIES AT TIMES MOST CONVENIENT TO THE PUBLIC, WITHOUT ENDANGERING THE UTILITY SERVICE, AND IN ACCORDANCE WITH THE UTILITY OWNER'S REQUIREMENTS. MAKE CONNECTIONS ON WEEKENDS, AT NIGHT, AND ON HOLIDAYS IF NECESSARY.
9. ALL UTILITY MATERIALS SHALL BE APPROVED PRIOR TO DELIVERY TO THE PROJECT. SEE 1500-7, " SUBMITTALS AND RECORDS" IN SECTION 1500 OF THE STANDARD SPECIFICATIONS.

PROJECT SPECIFIC NOTES:


1. WATER LINE AND SEWER LINE CONSTRUCTION SHALL BE IN ACCORDANCE WITH THE CITY OF HENDERSONVILLE STANDARD DETAILS AND THE PROJECT SPECIAL PROVISIONS.
2. PRIOR TO FINAL ACCEPTANCE OF THE WATER AND SEWER LINE WORK THE CONTRACTOR SHALL PROVIDE SURVEYED AS-BUILT RECORD DRAWINGS.
3. ANY PROPOSED CHANGES TO WATER OR SEWER LINE WORK SHALL BE APPROVED IN ADVANCE IN WRITING BY THE ENGINEER.
4. FLUSHING, DISINFECTING AND TESTING OF WATER LINES SHALL BE IN ACCORDANCE WITH THE PROJECT SPECIAL PROVISIONS.
5. TESTING OF SANITARY SEWER PIPING AND MANHOLES SHALL BE IN ACCORDANCE WITH THE PROJECT SPECIAL PROVISIONS.
6. ALL MANHOLES SHALL BE PRECAST WITH PRECAST BASES. NO DOGHOUSE MANHOLES WILL BE ALLOWED ON THIS PROJECT.






HINDE
ENGINEERING

License No. C-2639
7520 E. Independence Blvd., Suite 230 Charlotte, NC 28227


**DOCUMENT NOT CONSIDERED FINAL
UNLESS ALL SIGNATURES COMPLETED**

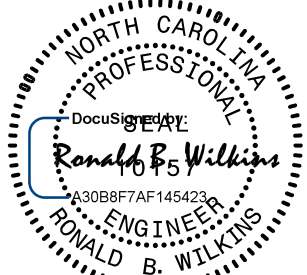PROJECT REFERENCE NO.		SHEET NO.	
U-5105		UC-3	
DESIGNED BY:	RBW		
DRAWN BY:	RBW		
CHECKED BY:	CLS		
APPROVED BY:	RBW		
REVISED:			
NORTH CAROLINA DEPARTMENT OF TRANSPORTATION		7/18/2018 11:58:50 AM EDT	
UTILITIES ENGINEERING SEC. PHONE: (919) 707-6690 FAX: (919) 250-4151		UTILITY CONSTRUCTION PLANS ONLY	

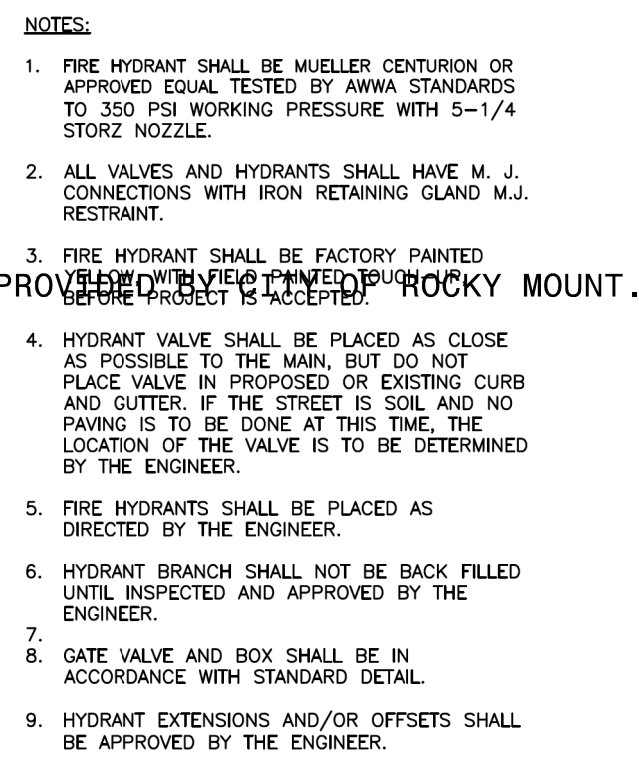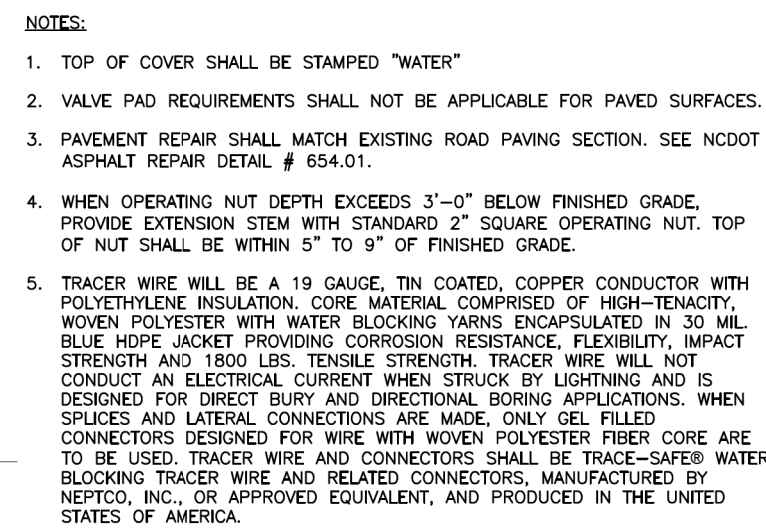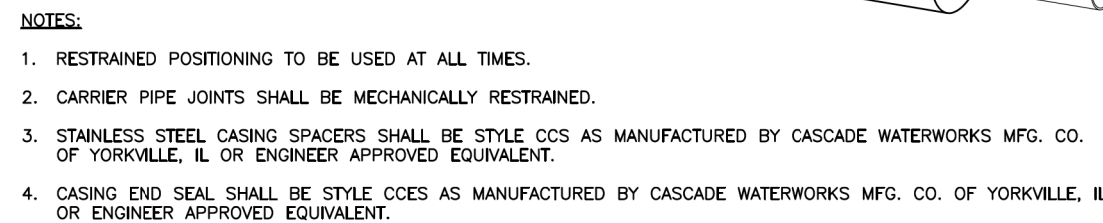
04/04/18 04/04/18 

04/04/18

* REQUIRES REDUCER L84-34G NI

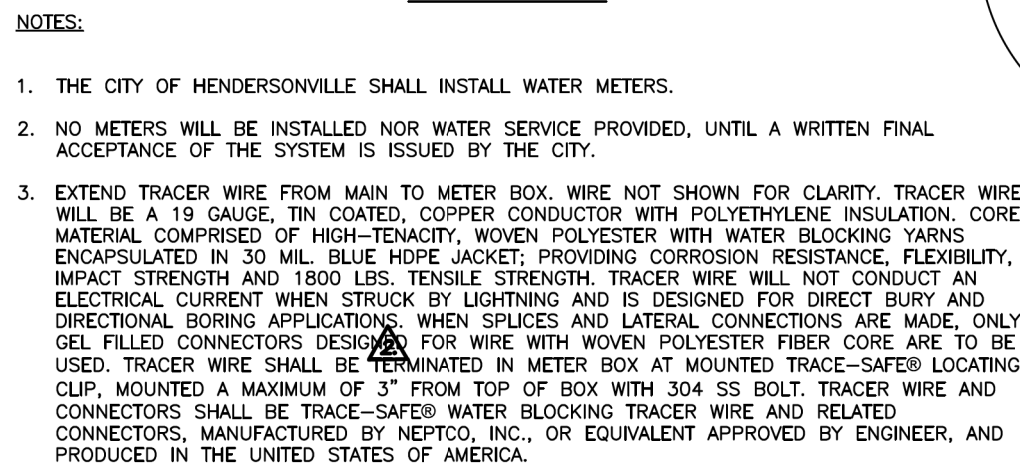02/16/18 ³

26 JUN-2018 11:23 C:\Users\jfernandez\Documents\Projects\2014\A20141102.00_Mulkey-U-5105\Design\Utilities\Engineering\UC\Proj\U5105_Ut_dtl_UC3A_psh.dgn

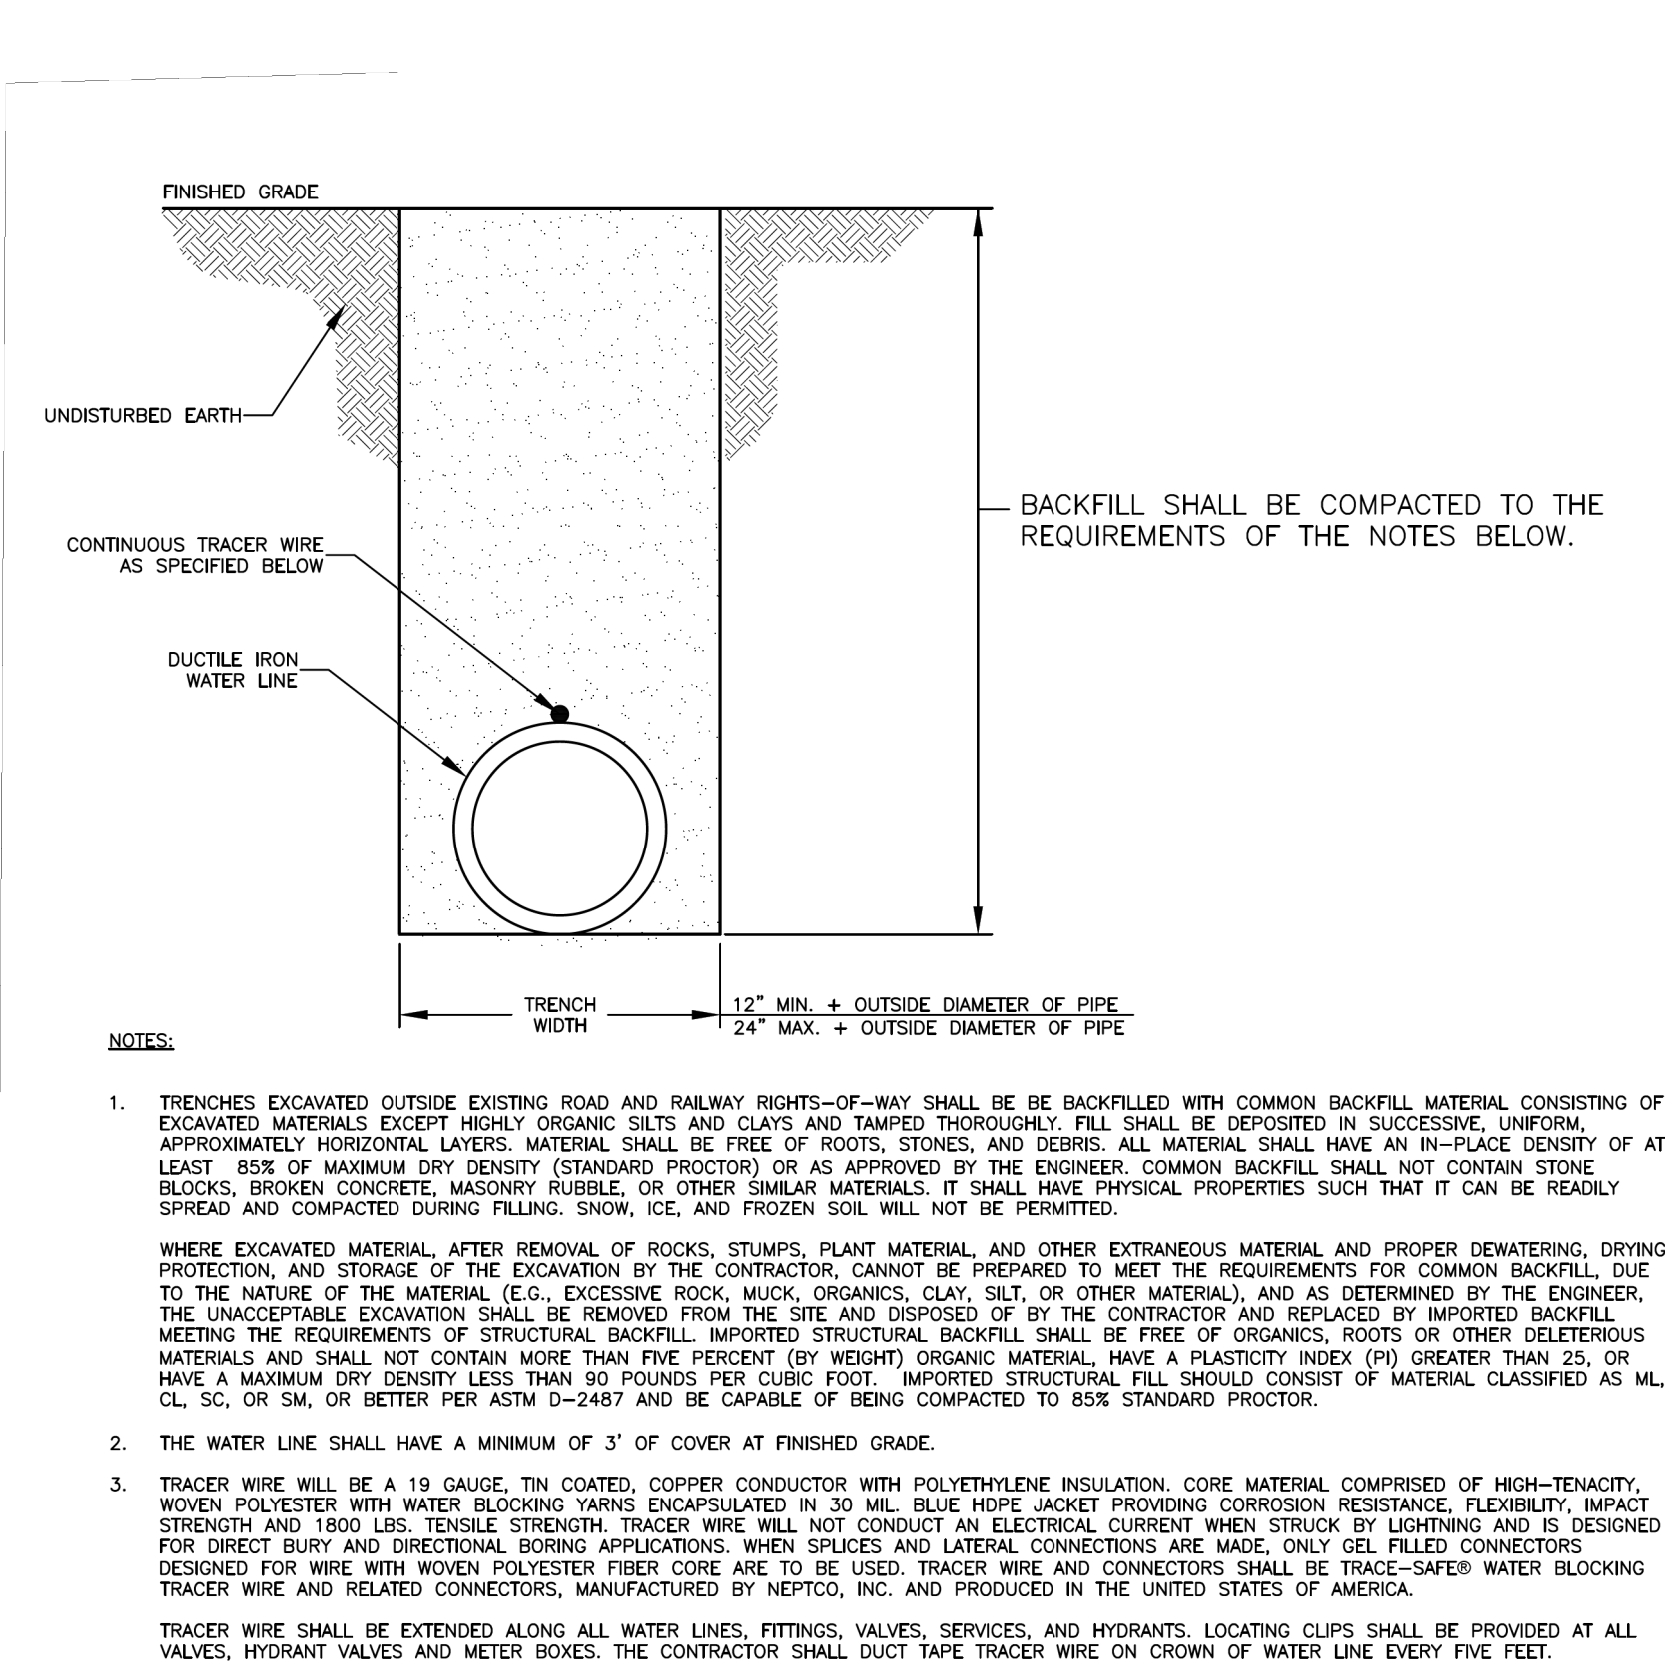

NOTES:


- TRENCHES EXCAVATED OUTSIDE EXISTING ROAD AND RAILWAY RIGHTS-OF-WAY SHALL BE BACKFILLED WITH COMMON BACKFILL MATERIAL CONSISTING OF EXCAVATED MATERIALS EXCEPT HIGHLY ORGANIC SILTS AND CLAYS AND TAMPED THOROUGHLY. FILL SHALL BE DEPOSITED IN SUCCESSIVE, UNIFORM, APPROXIMATELY HORIZONTAL LAYERS. MATERIAL SHALL BE FREE OF ROOTS, STONES, AND DEBRIS. ALL MATERIAL SHALL HAVE AN IN-PLACE DENSITY OF AT LEAST 85% OF MAXIMUM DRY DENSITY (STANDARD PROCTOR) OR AS APPROVED BY THE ENGINEER. COMMON BACKFILL SHALL NOT CONTAIN STONE BLOCKS, BROKEN CONCRETE, MASONRY RUBBLE, OR OTHER SIMILAR MATERIALS. IT SHALL HAVE PHYSICAL PROPERTIES SUCH THAT IT CAN BE READILY SPREAD AND COMPACTED DURING FILLING. SNOW, ICE, AND FROZEN SOIL WILL NOT BE PERMITTED.

WHERE EXCAVATED MATERIAL, AFTER REMOVAL OF ROCKS, STUMPS, PLANT MATERIAL, AND OTHER EXTRANEOUS MATERIAL AND PROPER DEWATERING, DRYING, PROTECTION, AND STORAGE OF THE EXCAVATION BY THE CONTRACTOR, CANNOT BE PREPARED TO MEET THE REQUIREMENTS FOR COMMON BACKFILL, DUE TO THE NATURE OF THE MATERIAL (E.G., EXCESSIVE ROCK, MUCK, ORGANICS, CLAY, SILT, OR OTHER MATERIAL), AND AS DETERMINED BY THE ENGINEER, THE UNACCEPTABLE EXCAVATION SHALL BE REMOVED FROM THE SITE AND DISPOSED OF BY THE CONTRACTOR AND REPLACED BY IMPORTED BACKFILL MEETING THE REQUIREMENTS OF STRUCTURAL BACKFILL. IMPORTED STRUCTURAL BACKFILL SHALL BE FREE OF ORGANICS, ROOTS OR OTHER DELETERIOUS MATERIALS AND SHALL NOT CONTAIN MORE THAN FIVE PERCENT (BY WEIGHT) ORGANIC MATERIAL, HAVE A PLASTICITY INDEX (PI) GREATER THAN 25, OR HAVE A MAXIMUM DRY DENSITY LESS THAN 90 POUNDS PER CUBIC FOOT. IMPORTED STRUCTURAL FILL SHOULD CONSIST OF MATERIAL CLASSIFIED AS ML, CL, SC, OR SM, OR BETTER PER ASTM D-2487 AND BE CAPABLE OF BEING COMPACTED TO 85% STANDARD PROCTOR.
- THE WATER LINE SHALL HAVE A MINIMUM OF 3' OF COVER AT FINISHED GRADE.
- TRACER WIRE WILL BE A 19 GAUGE, TIN COATED, COPPER CONDUCTOR WITH POLYETHYLENE INSULATION, CORE MATERIAL COMPRISED OF HIGH-TENACITY, WOVEN POLYESTER WITH WATER BLOCKING YARNS ENCAPSULATED IN 30 MIL. BLUE HDPE JACKET PROVIDING CORROSION RESISTANCE, FLEXIBILITY, IMPACT STRENGTH AND 1800 LBS. TENSILE STRENGTH. TRACER WIRE WILL NOT CONDUCT AN ELECTRICAL CURRENT WHEN STRUCK BY LIGHTNING AND IS DESIGNED FOR DIRECT BURY AND DIRECTIONAL BORING APPLICATIONS. WHEN SPLICES AND LATERAL CONNECTIONS ARE MADE, ONLY GEL FILLED CONNECTORS DESIGNED FOR WIRE WITH WOVEN POLYESTER FIBER CORE ARE TO BE USED. TRACER WIRE AND CONNECTORS SHALL BE TRACE-SAFE® WATER BLOCKING TRACER WIRE AND RELATED CONNECTORS, MANUFACTURED BY NEPTCO, INC. AND PRODUCED IN THE UNITED STATES OF AMERICA.

TRACER WIRE SHALL BE EXTENDED ALONG ALL WATER LINES, FITTINGS, VALVES, SERVICES, AND HYDRANTS. LOCATING CLIPS SHALL BE PROVIDED AT ALL VALVES, HYDRANT VALVES AND METER BOXES. THE CONTRACTOR SHALL DUCT TAPE TRACER WIRE ON CROWN OF WATER LINE EVERY FIVE FEET.

WATER TRENCH CONSTRUCTION
OUTSIDE PAVEMENT


NOT TO SCALE

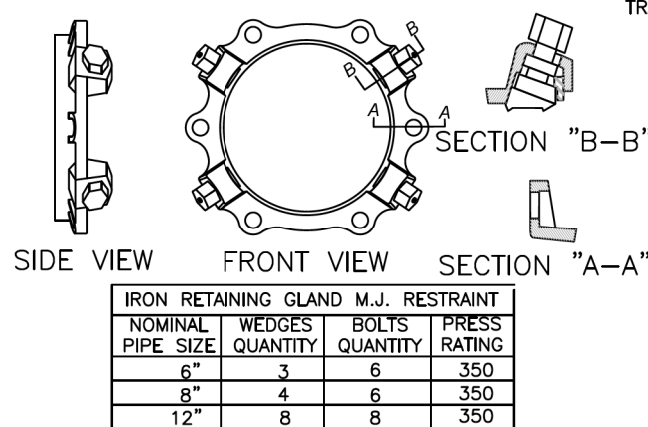

8" SIZE SHOWN 6" & 12" SIMILAR
IRON RETAINING GLAND M.J. RESTRAINT


LR (MIN. LENGTH OF RESTRAINT EACH DIRECTION OF THRUST IN LINEAR FEET).
Based on 200 psig pressure, Safety Factor of 2.0:1, BARE DI PIPE AND ML SOIL, 3.5' COVER
Chart does not apply to pipes wrapped in polyethylene wrap

PIPE SIZE	VALVES DEAD ENDS TEES	90° ELBOWS	45° ELBOW & CROSSES	22-1/2" ELBOWS	REDUCER
6"	55'	31'	13'	7'	8"x2" 67'
8"	72'	40'	17'	8'	8"x6" 30'
12"	102'	57'	24'	12'	12"x8" 54'

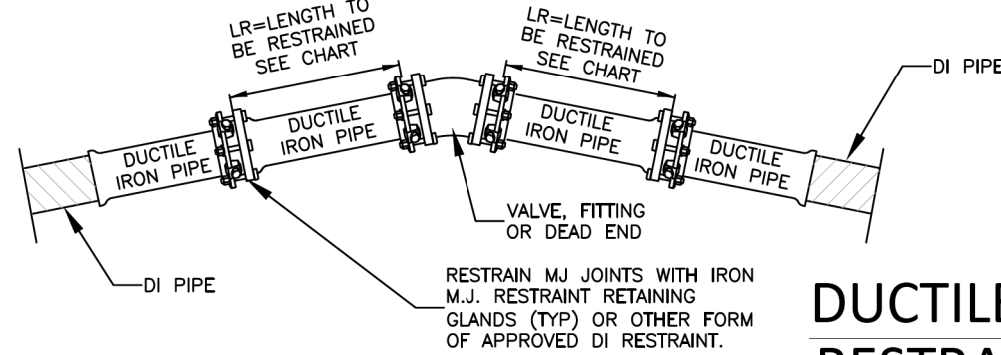

DUCTILE IRON PIPE
RESTRAINT DETAIL

NOT TO SCALE

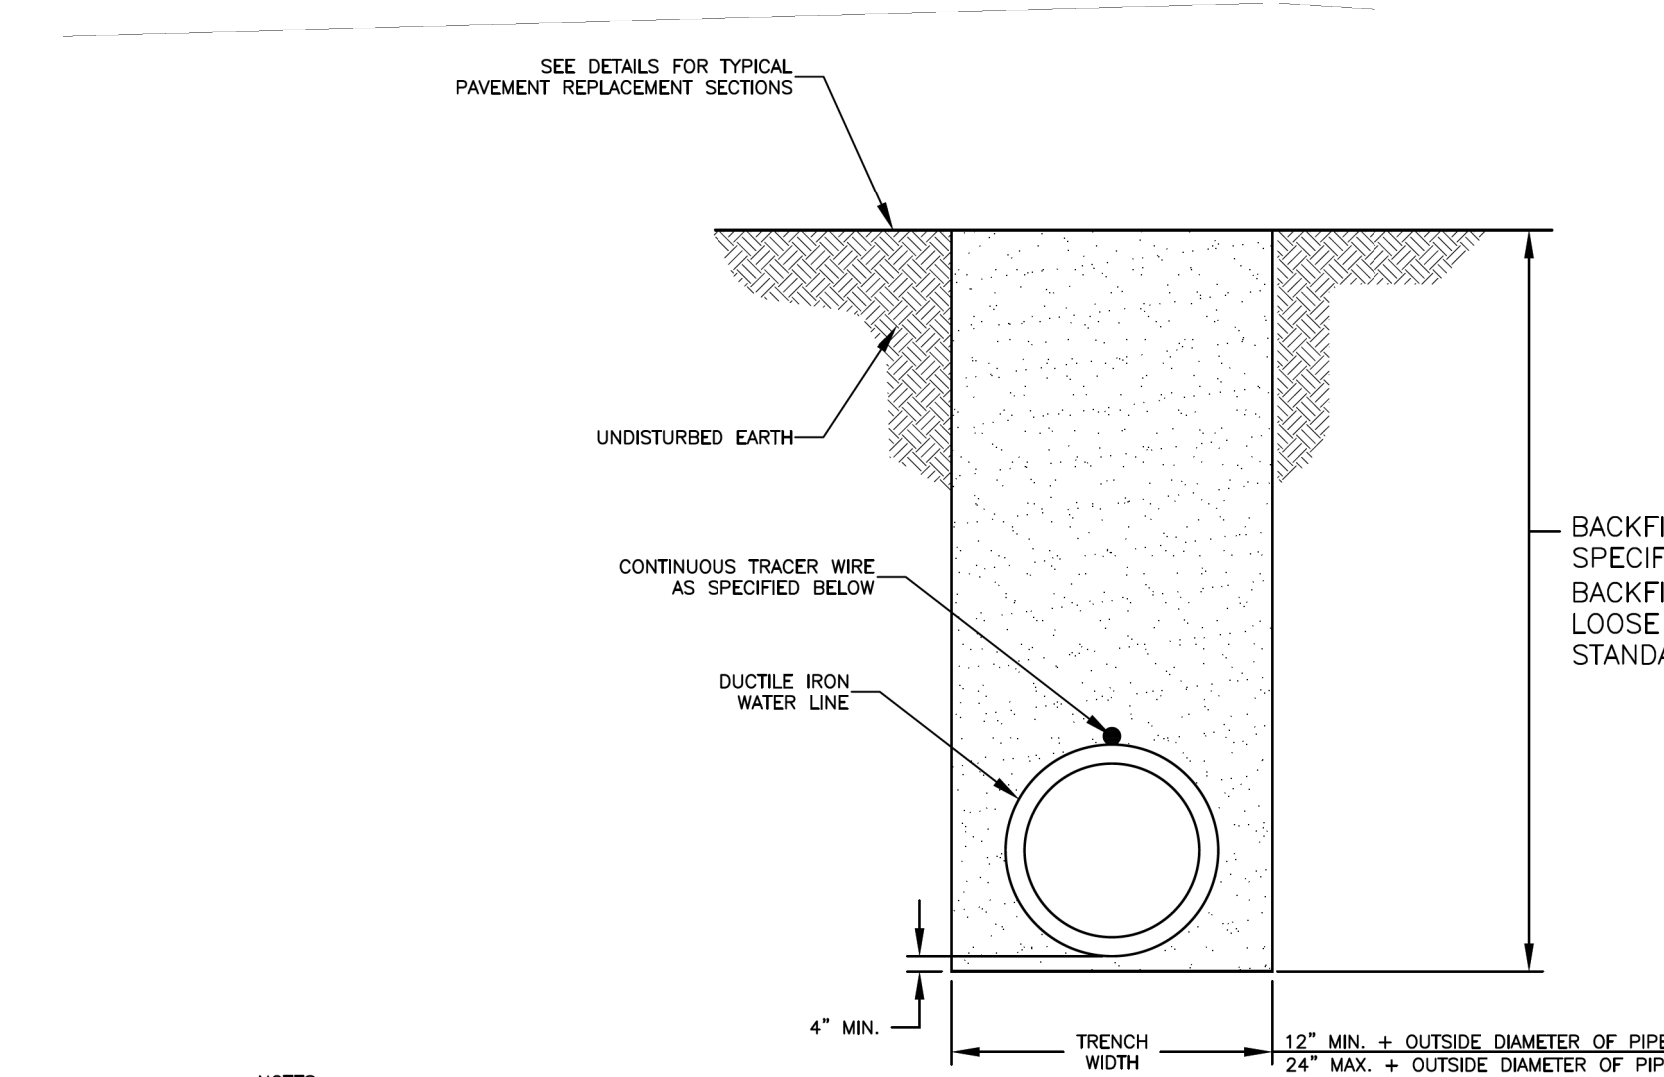

NOTES:

- THIS TRENCH BACKFILL DETAIL APPLIES TO AREAS UNDER PAVEMENT AND AREAS WHERE THE TRENCH IS WITHIN FIVE (5) FEET OF THE EDGE OF PAVEMENT.
- COMPACTION OF THE BACKFILL SHALL BE ACHIEVED THROUGH THE USE OF AN APPROVED VIBRATORY PLATE, TAMPER OR ROLLER.
- COMPACTION TESTING OF THE BACKFILL SHALL BE PROVIDED, DIRECTED AND COORDINATED BY THE OWNER. INTERVALS OF TESTING SHALL BE AT THE TOTAL DISCRETION OF THE OWNER AND MAY BE CHANGED AT ANY TIME.

IF A TEST DOES NOT PASS, THE CONTRACTOR SHALL REMOVE THE DEFECTIVE BACKFILL, REDO THE WORK AND THE AREA WILL BE RETESTED. THE CONTRACTOR SHALL BE AWARE OF THE LEVEL OF COMPACTION REQUIRED.


IF THE WORK IS SUSPECT TO BE DEFECTIVE BY THE OWNER, THE WORK SHALL BE RETESTED.
- THE WATER CONTENT OF THE BACKFILL MATERIAL SHALL ALSO BE TESTED AND RECORDED FOR EACH TEST COMPLETED. THE CONTRACTOR WILL BE ALLOWED TO ADD WATER TO THE BACKFILL MATERIAL IN ORDER TO OBTAIN THE OPTIMUM WATER CONTENT. HOWEVER, THE CONTRACTOR WILL NOT BE ALLOWED TO UTILIZE THE ADDITION OF WATER AS A MEANS OF COMPACTION. FURTHERMORE, SHOULD THE BACKFILL MATERIAL BE FOUND TO HAVE WATER CONTENT RATIOS WHICH IN THE OPINION OF THE ENGINEER OR THE OWNER PREVENTS THE APPROPRIATE COMPACTION OF THE TRENCH, THE CONTRACTOR SHALL REMOVE ALL DEFECTIVE MATERIAL AND UNDERTAKE THE NECESSARY CORRECTIVE WORK.
- THE WATER LINE SHALL HAVE A MINIMUM OF 3' OF COVER AT FINISHED GRADE.

TRACER WIRE WILL BE A 19 GAUGE, TIN COATED, COPPER CONDUCTOR WITH POLYETHYLENE INSULATION, CORE MATERIAL COMPRISED OF HIGH-TENACITY, WOVEN POLYESTER WITH WATER BLOCKING YARNS ENCAPSULATED IN 30 MIL. BLUE HDPE JACKET PROVIDING CORROSION RESISTANCE, FLEXIBILITY, IMPACT STRENGTH AND 1800 LBS. TENSILE STRENGTH. TRACER WIRE WILL NOT CONDUCT AN ELECTRICAL CURRENT WHEN STRUCK BY LIGHTNING AND IS DESIGNED FOR DIRECT BURY AND DIRECTIONAL BORING APPLICATIONS. WHEN SPLICES AND LATERAL CONNECTIONS ARE MADE, ONLY GEL FILLED CONNECTORS DESIGNED FOR WIRE WITH WOVEN POLYESTER FIBER CORE ARE TO BE USED. TRACER WIRE AND CONNECTORS SHALL BE TRACE-SAFE® WATER BLOCKING TRACER WIRE AND RELATED CONNECTORS, MANUFACTURED BY NEPTCO, INC. AND PRODUCED IN THE UNITED STATES OF AMERICA.

TRACER WIRE SHALL BE EXTENDED ALONG ALL WATER LINES, FITTINGS, VALVES, SERVICES, AND HYDRANTS. LOCATING CLIPS SHALL BE PROVIDED AT ALL VALVES, HYDRANT VALVES AND METER BOXES. THE CONTRACTOR SHALL DUCT TAPE TRACER WIRE ON CROWN OF WATER LINE EVERY FIVE FEET.

WATER TRENCH CONSTRUCTION
UNDER PAVEMENT

NOT TO SCALE






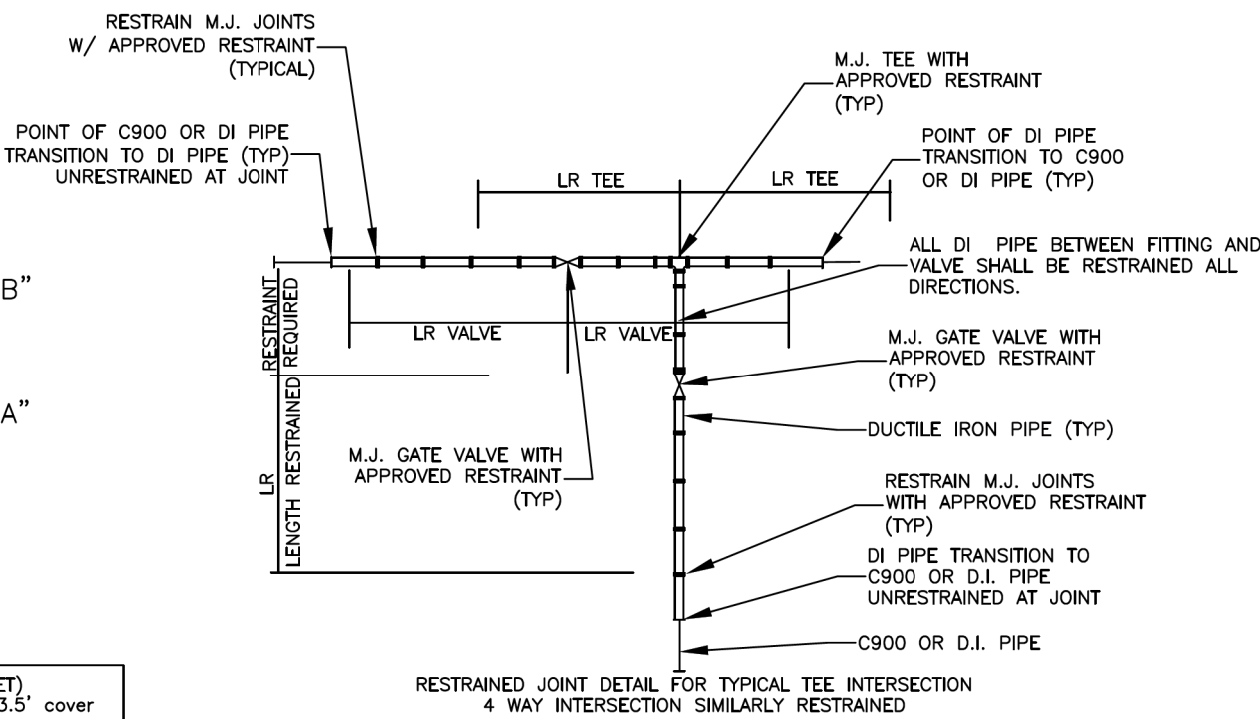


NOTES:

- THRUST RESTRAINT SHALL BE INSTALLED ON DUCTILE IRON WATER DISTRIBUTION LINES 6" THRU 12" DIAMETER IN THE MANNER SHOWN.
- IRON RETAINING GLAND M.J. RESTRAINT OR OTHER FORMS OF IRON RESTRAINT SHALL NOT BE USED ON PVC PIPE.
- PIPE GREATER THAN 12 INCH DIAMETER SHALL REQUIRE RESTRAINED JOINT PIPE FOR THE PROPER LENGTH.
- COMPACT FITTINGS ARE ACCEPTABLE FOR USE WITH IRON RETAINING GLAND M.J. RESTRAINT AND OTHER FORMS OF DI RESTRAINT.
- THE MINIMUM LENGTH OF RESTRAINT INDICATED SHALL REQUIRE ALL JOINTS WITHIN THE LR DISTANCE TO BE RESTRAINED.
- RESTRAINT SYSTEM SHALL BE INSPECTED AND APPROVED PRIOR TO BACKFILLING.
- RESTRAINT SYSTEMS MAY VARY BASED UPON THE ENGINEERS' DESIGN AS SHOWN ON THE PLAN AND PROFILE SHEETS.
- GRIPPER RING AND FIELD LOK GASKETS ARE AN ACCEPTABLE METHOD OF RESTRAINT ON DUCTILE IRON PIPE ONLY.
- TRACER WIRE NOT SHOWN FOR CLARITY. WIRE SHALL BE INSTALLED PER OTHER DETAILS.

26 JUN-2018 11:22 C:\PROJECTS\2014\A20141102.00_Mulkey-U-5105\Design\Utilities\Engineering\UC\Proj\U5105_Ut_dtl_UC3A_psh.dgn
H:\A_ID_DESIGN_2021\12002 - Atkinson Elementary Sewer\bid documents\Standard Details\12 - Shallow Precast Manhole.dwg, Detail, 2/5/2014 12:38:01 AM, bidrevlwr, DWG To PDF.pc3, 1.036

H:\A_ID_DESIGN_2021\12002 - Atkinson Elementary Sewer\bid documents\Standard Details\12 - Shallow Precast Manhole.dwg, Detail, 2/5/2014 12:38:01 AM, bidrevlwr, DWG To PDF.pc3, 1.1

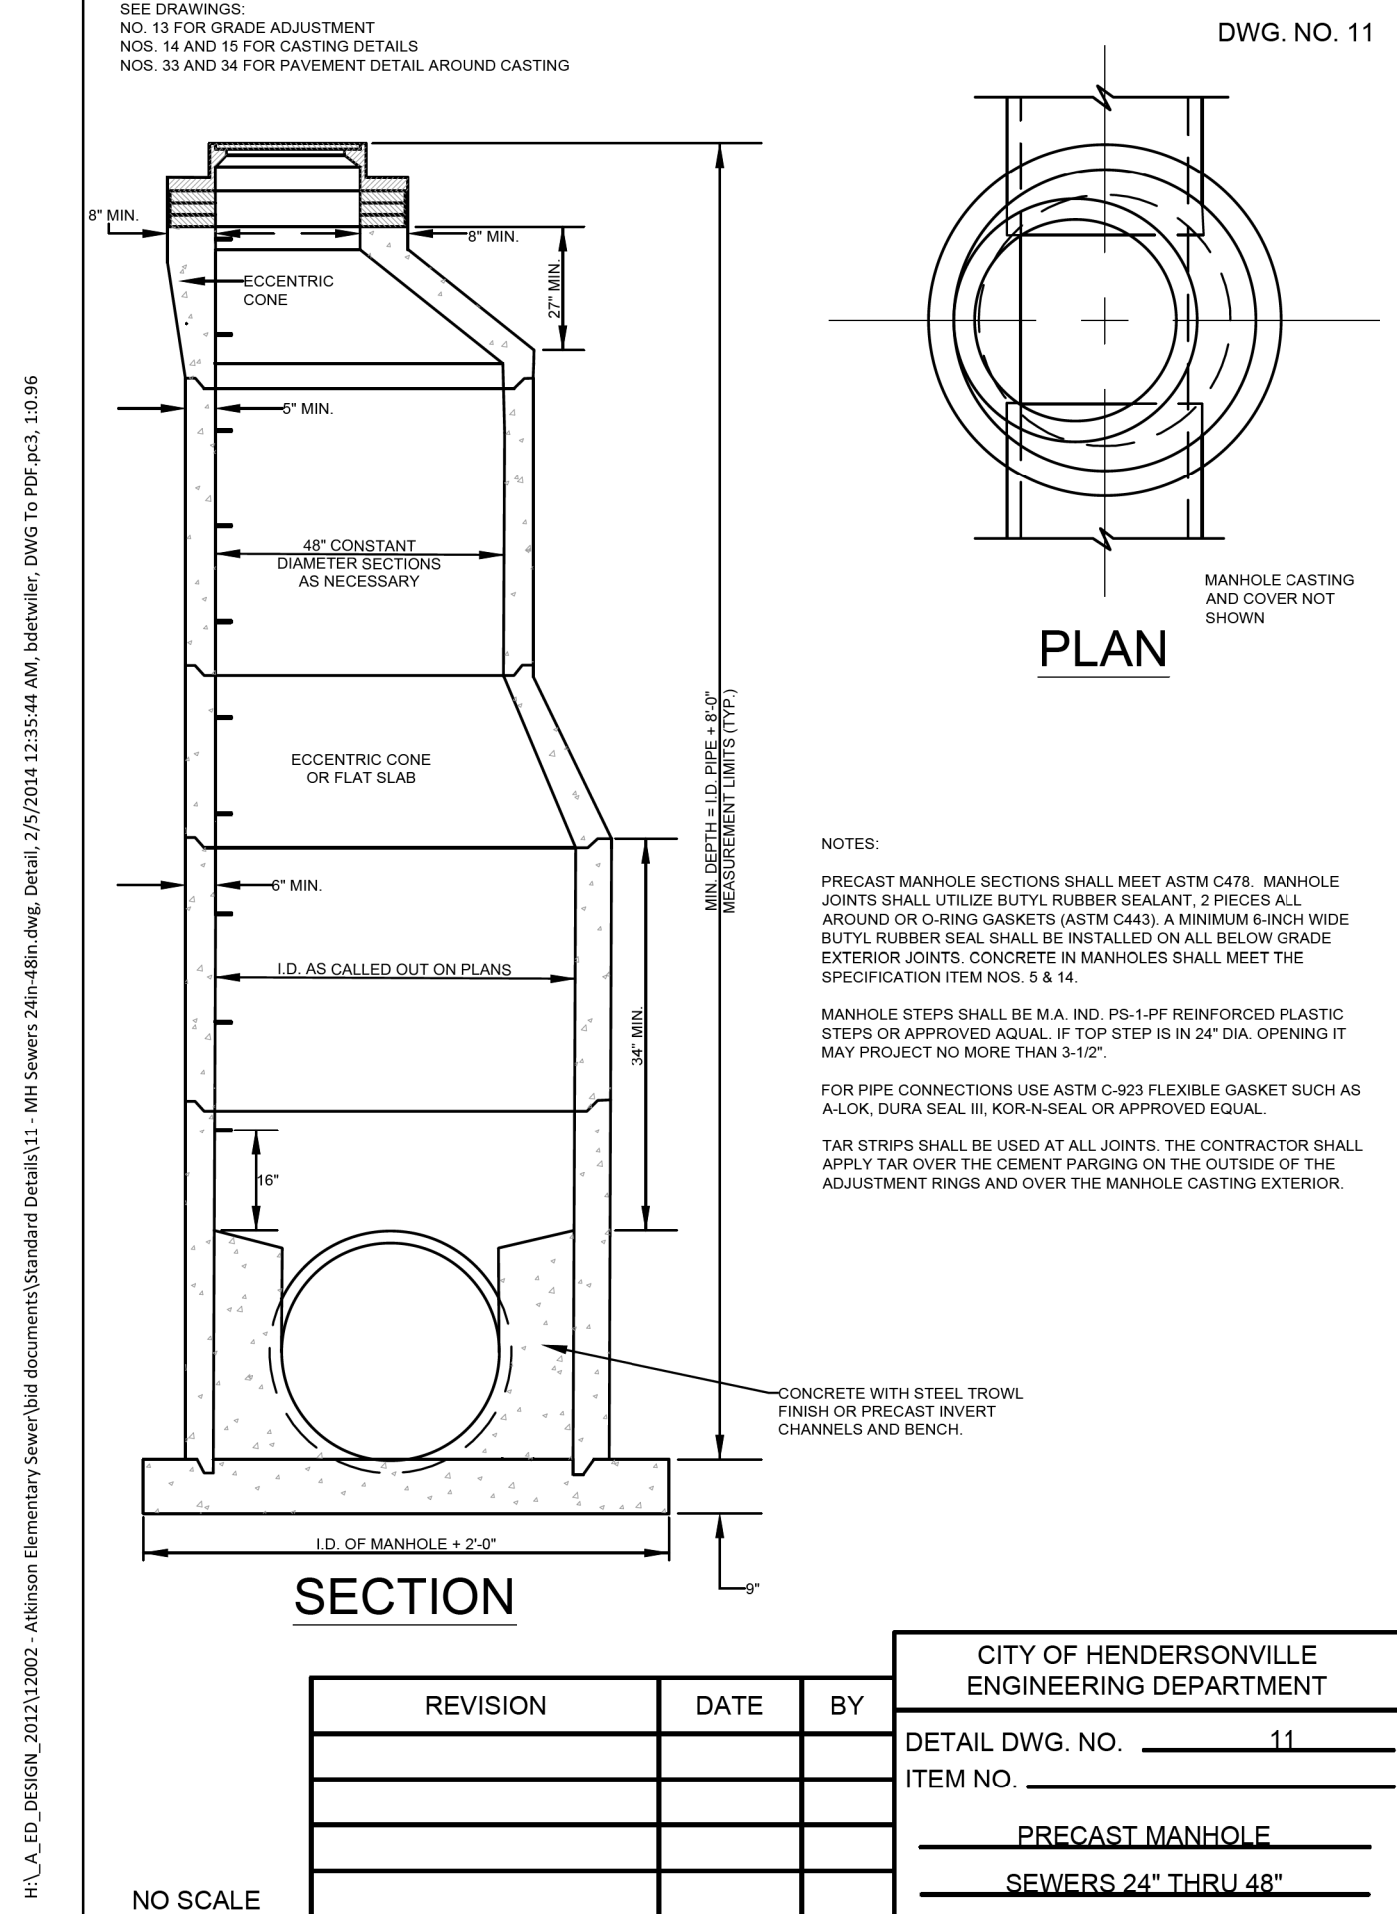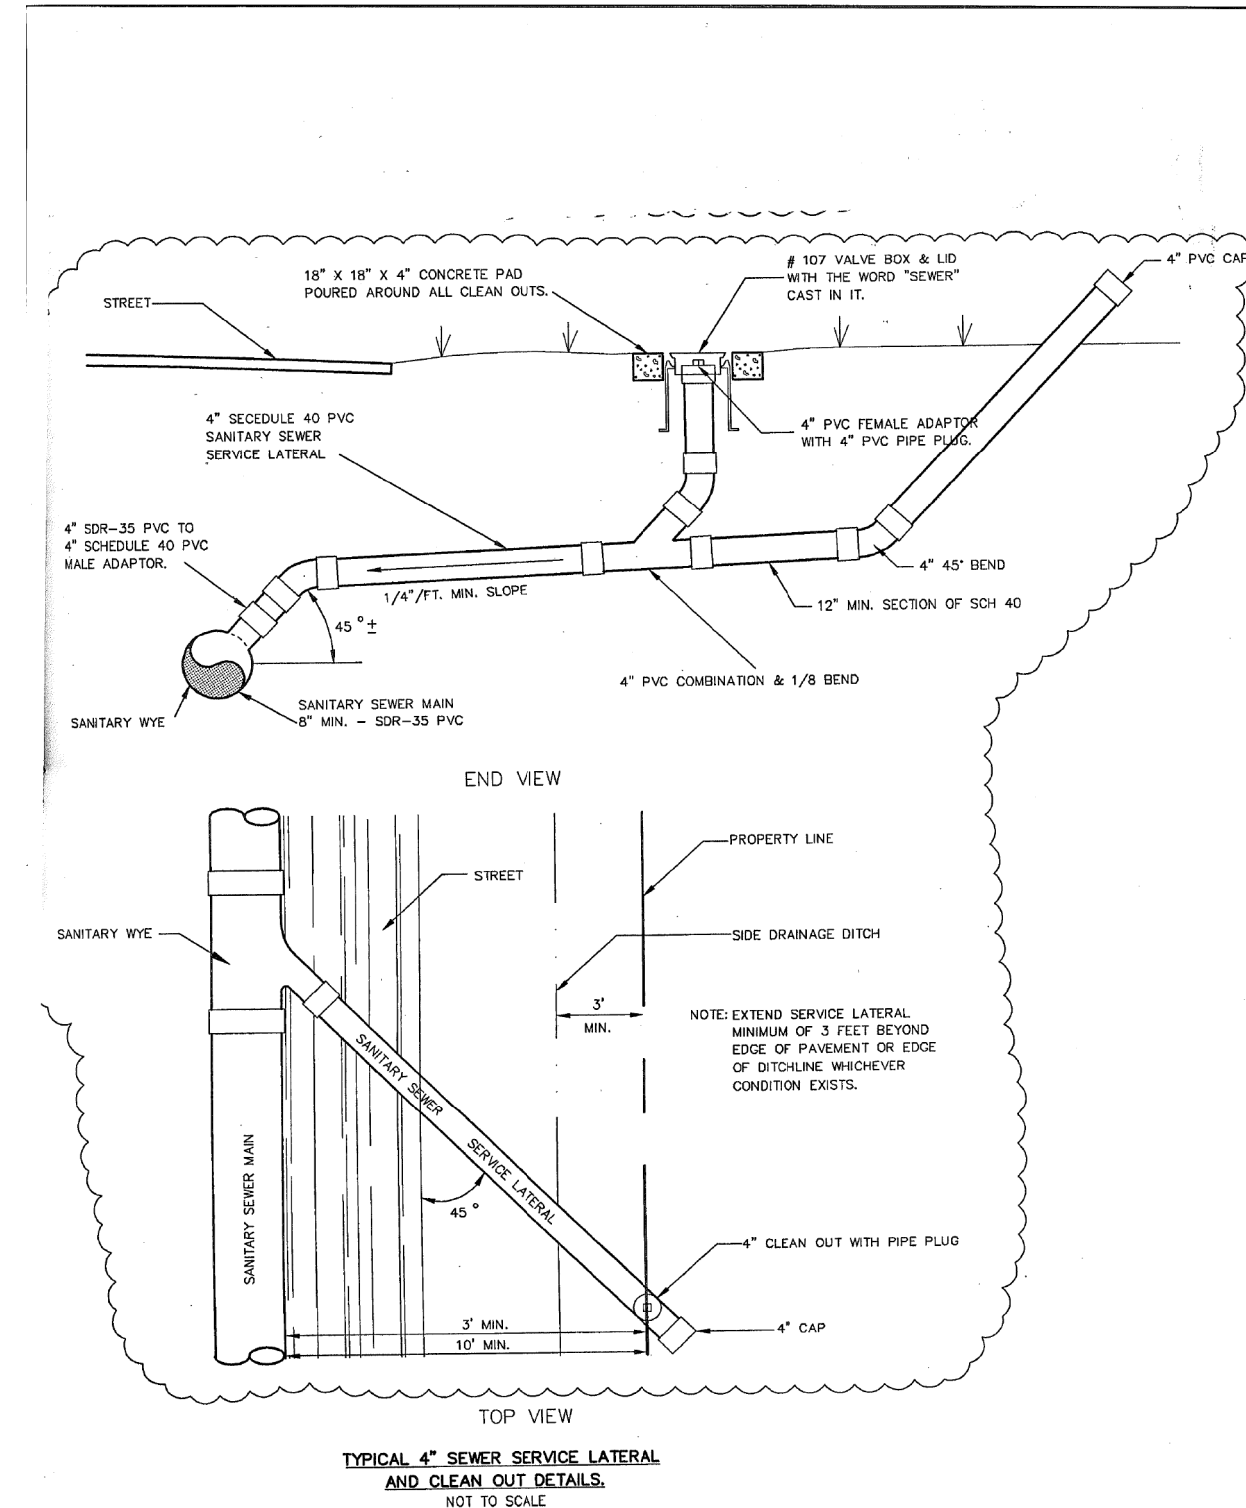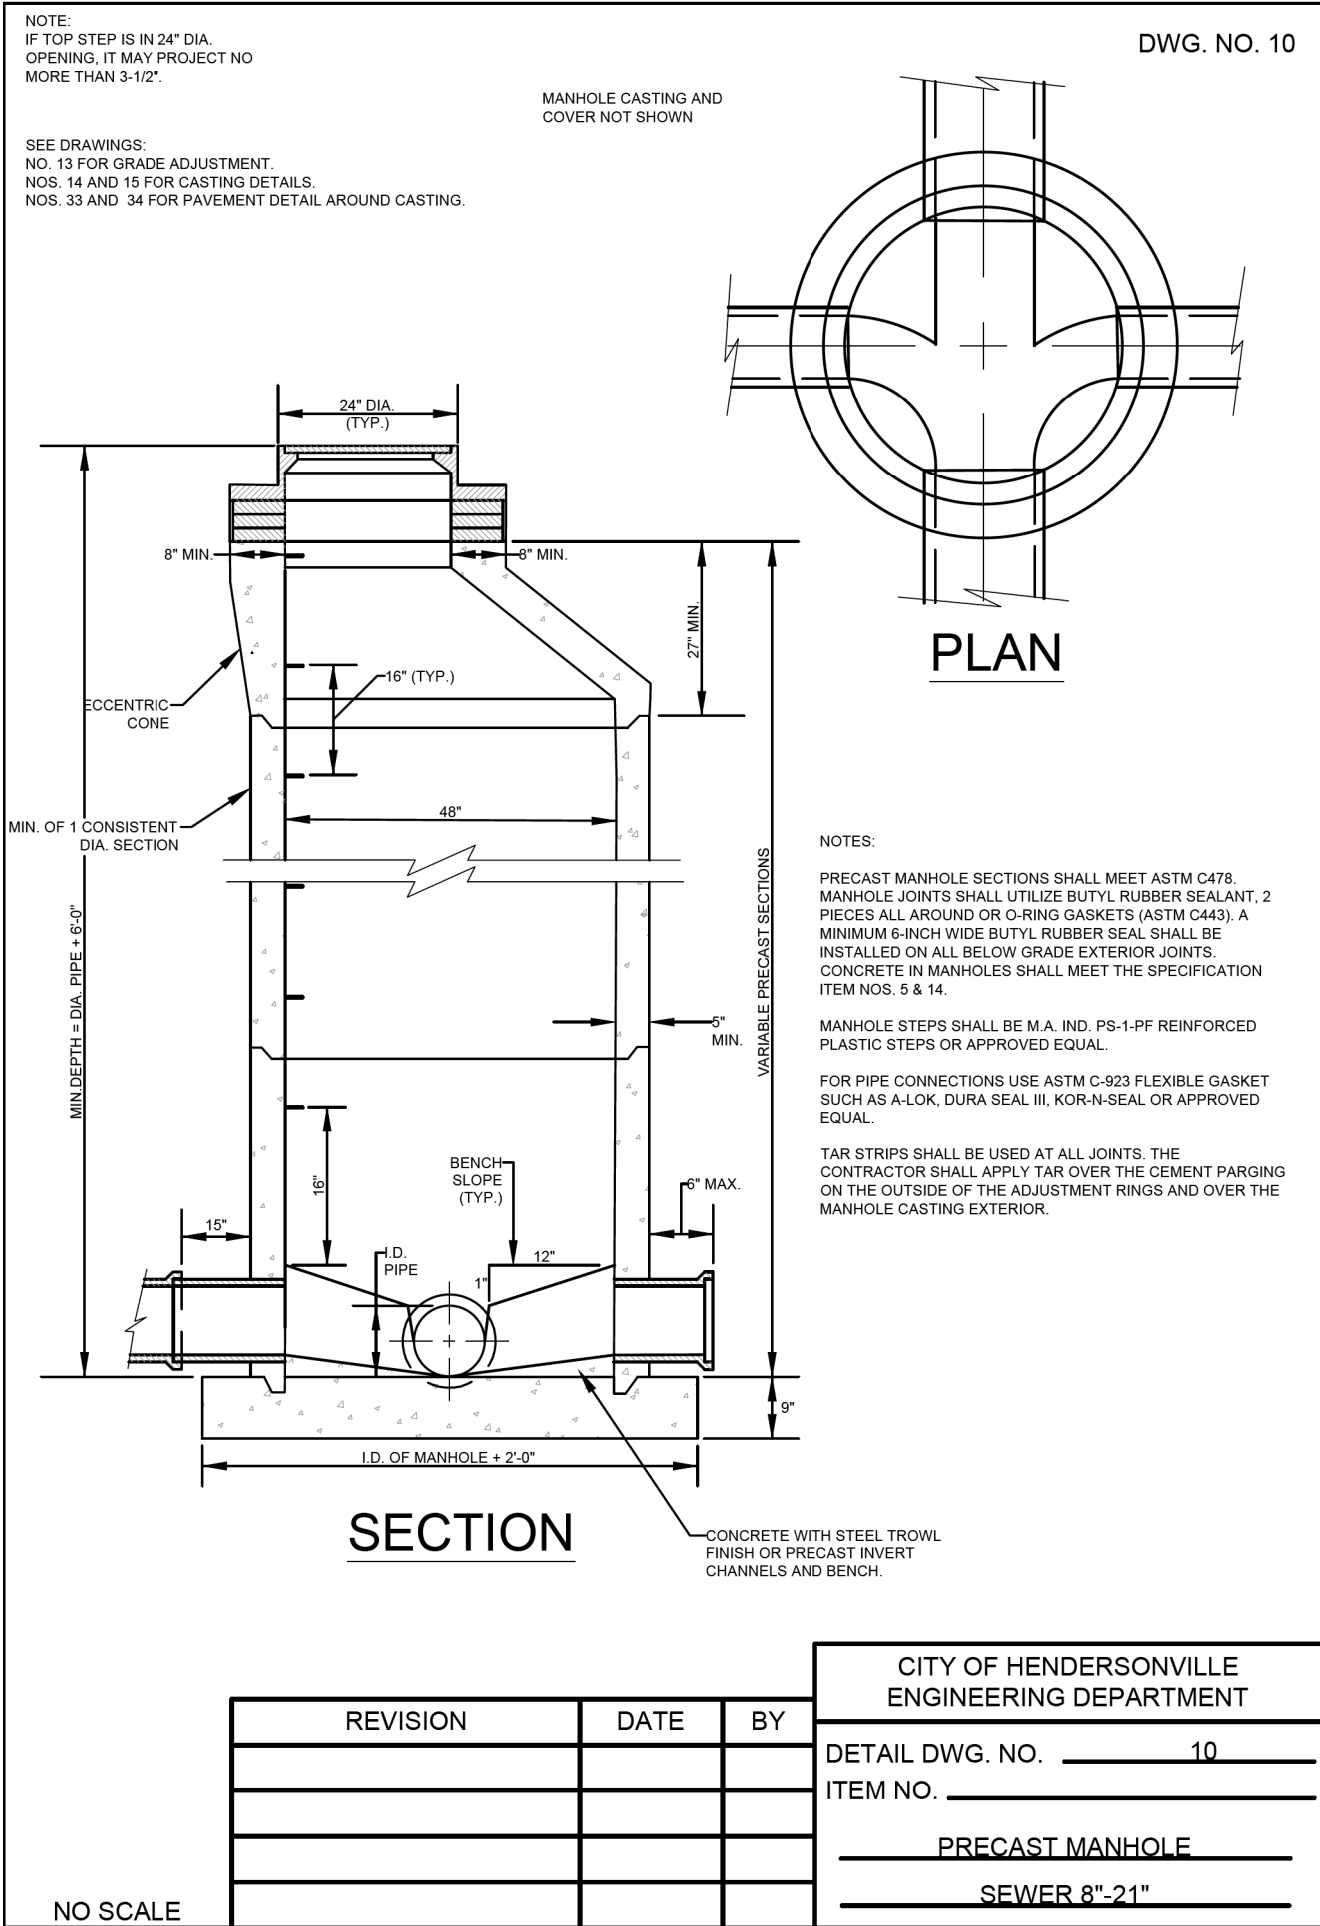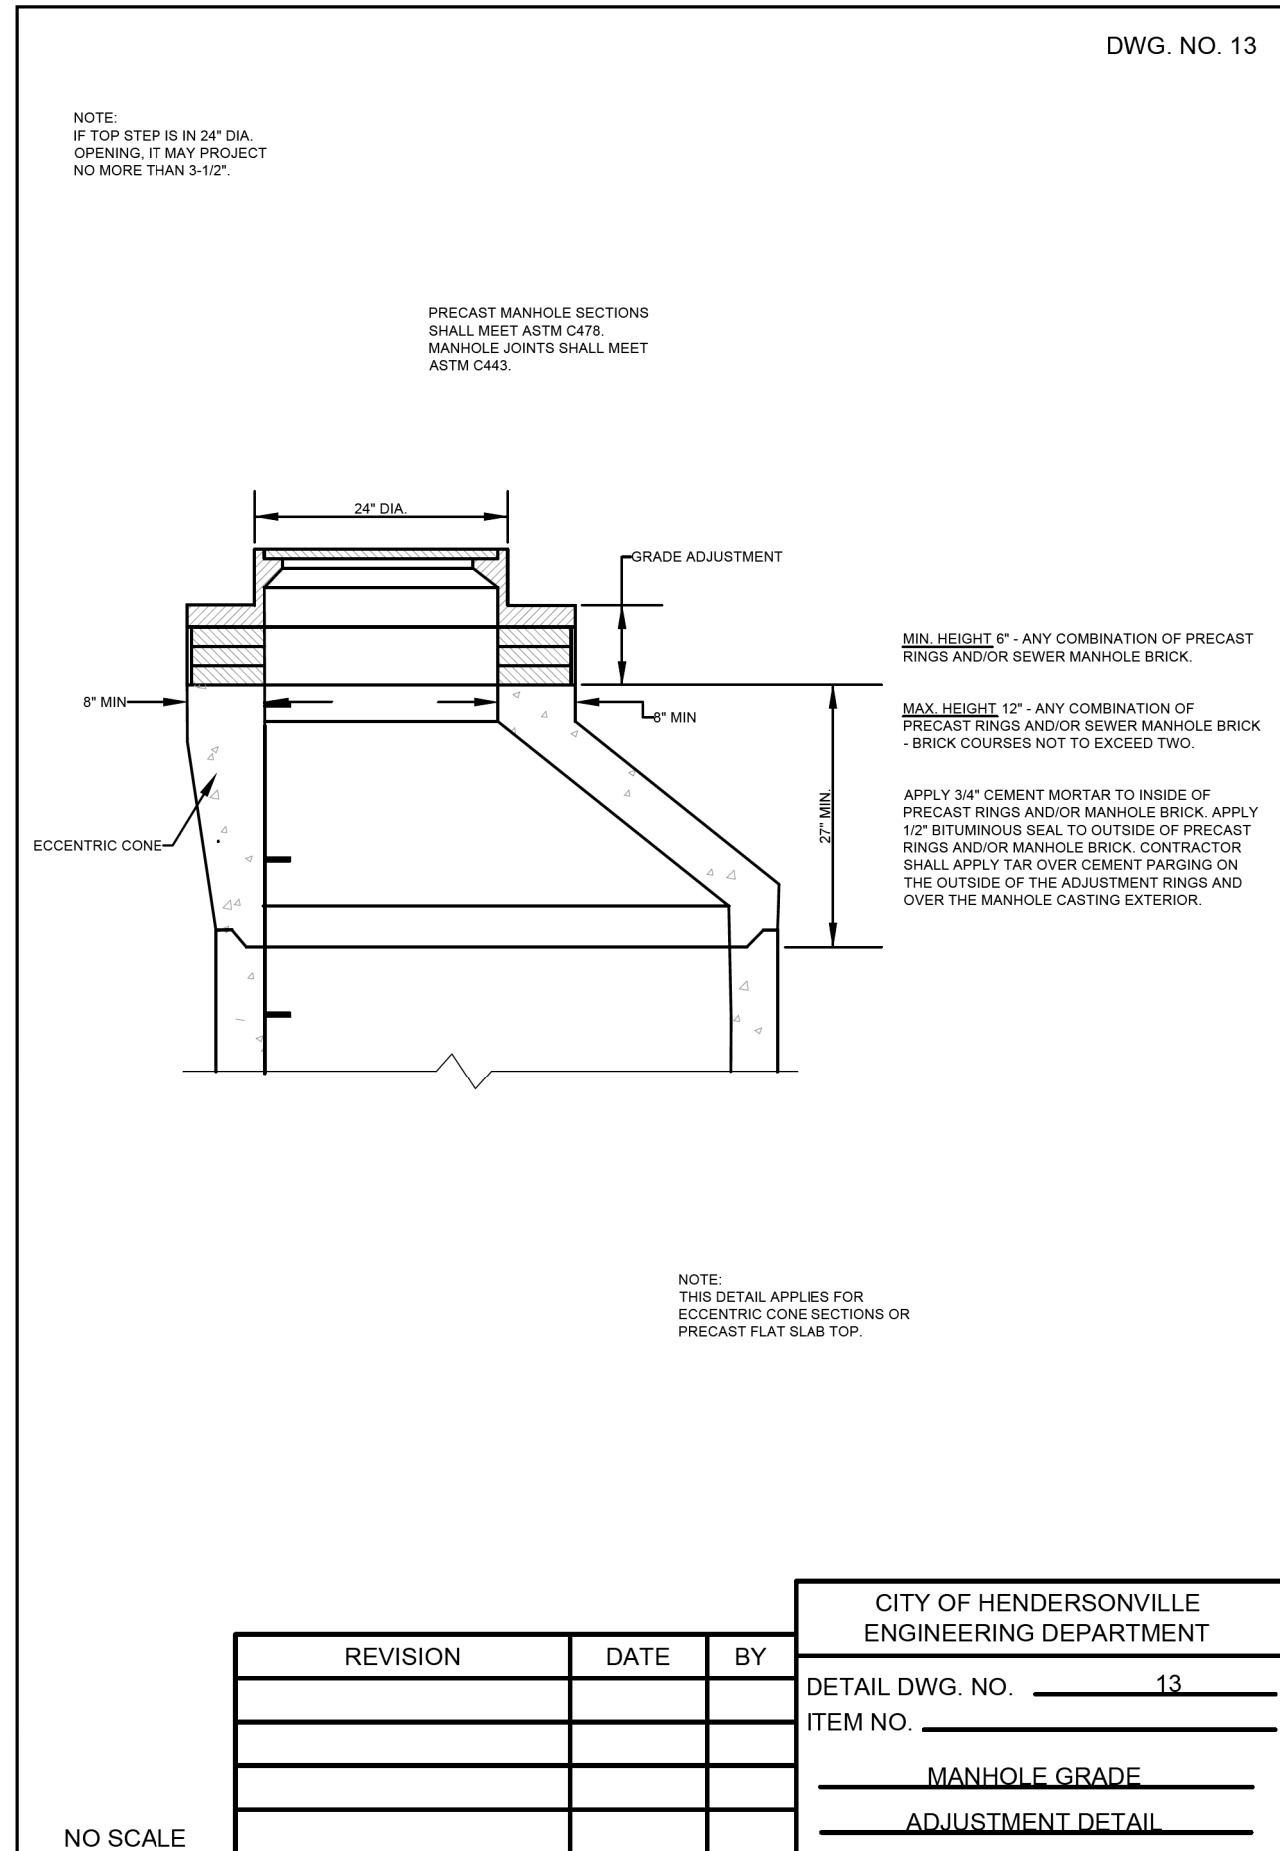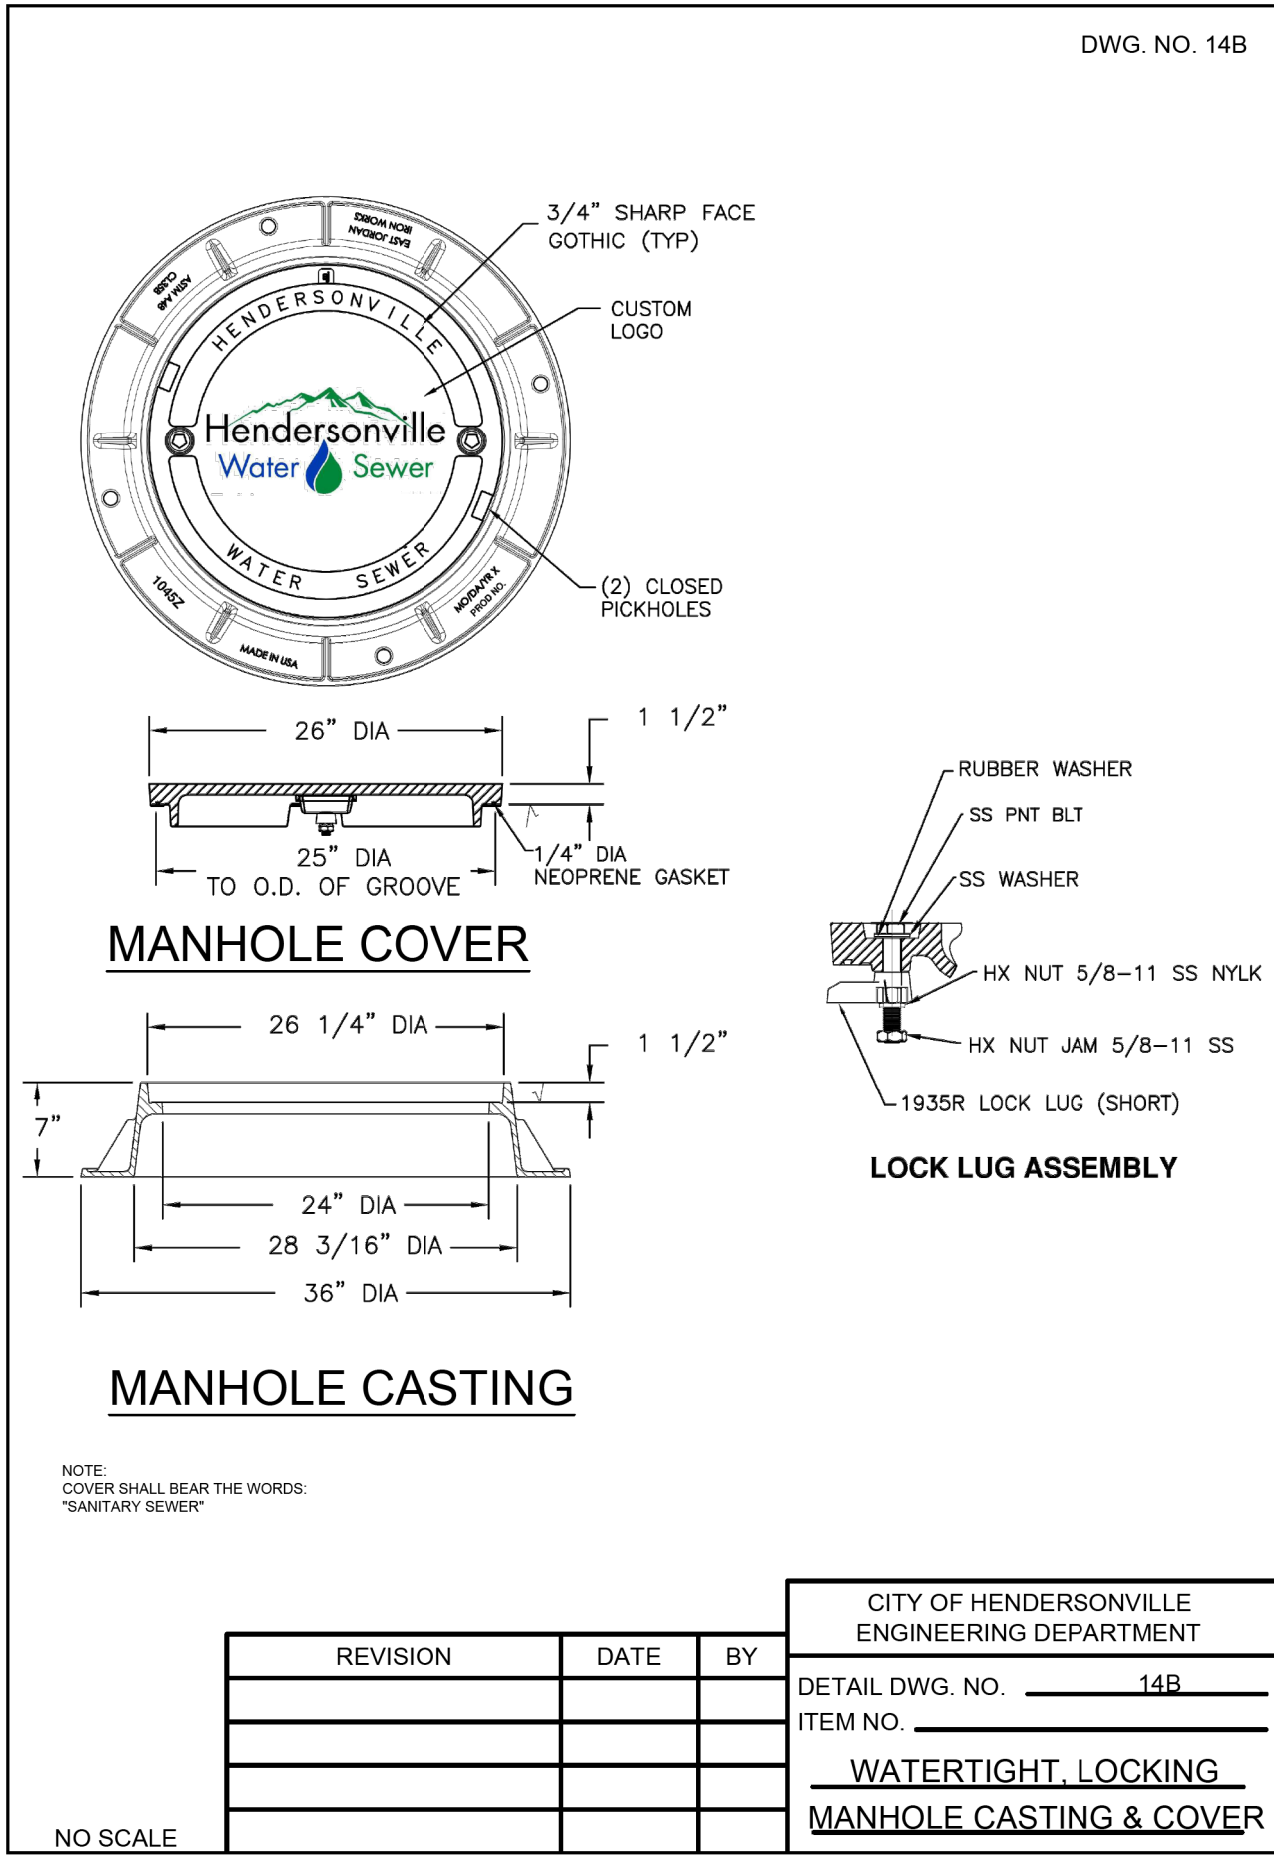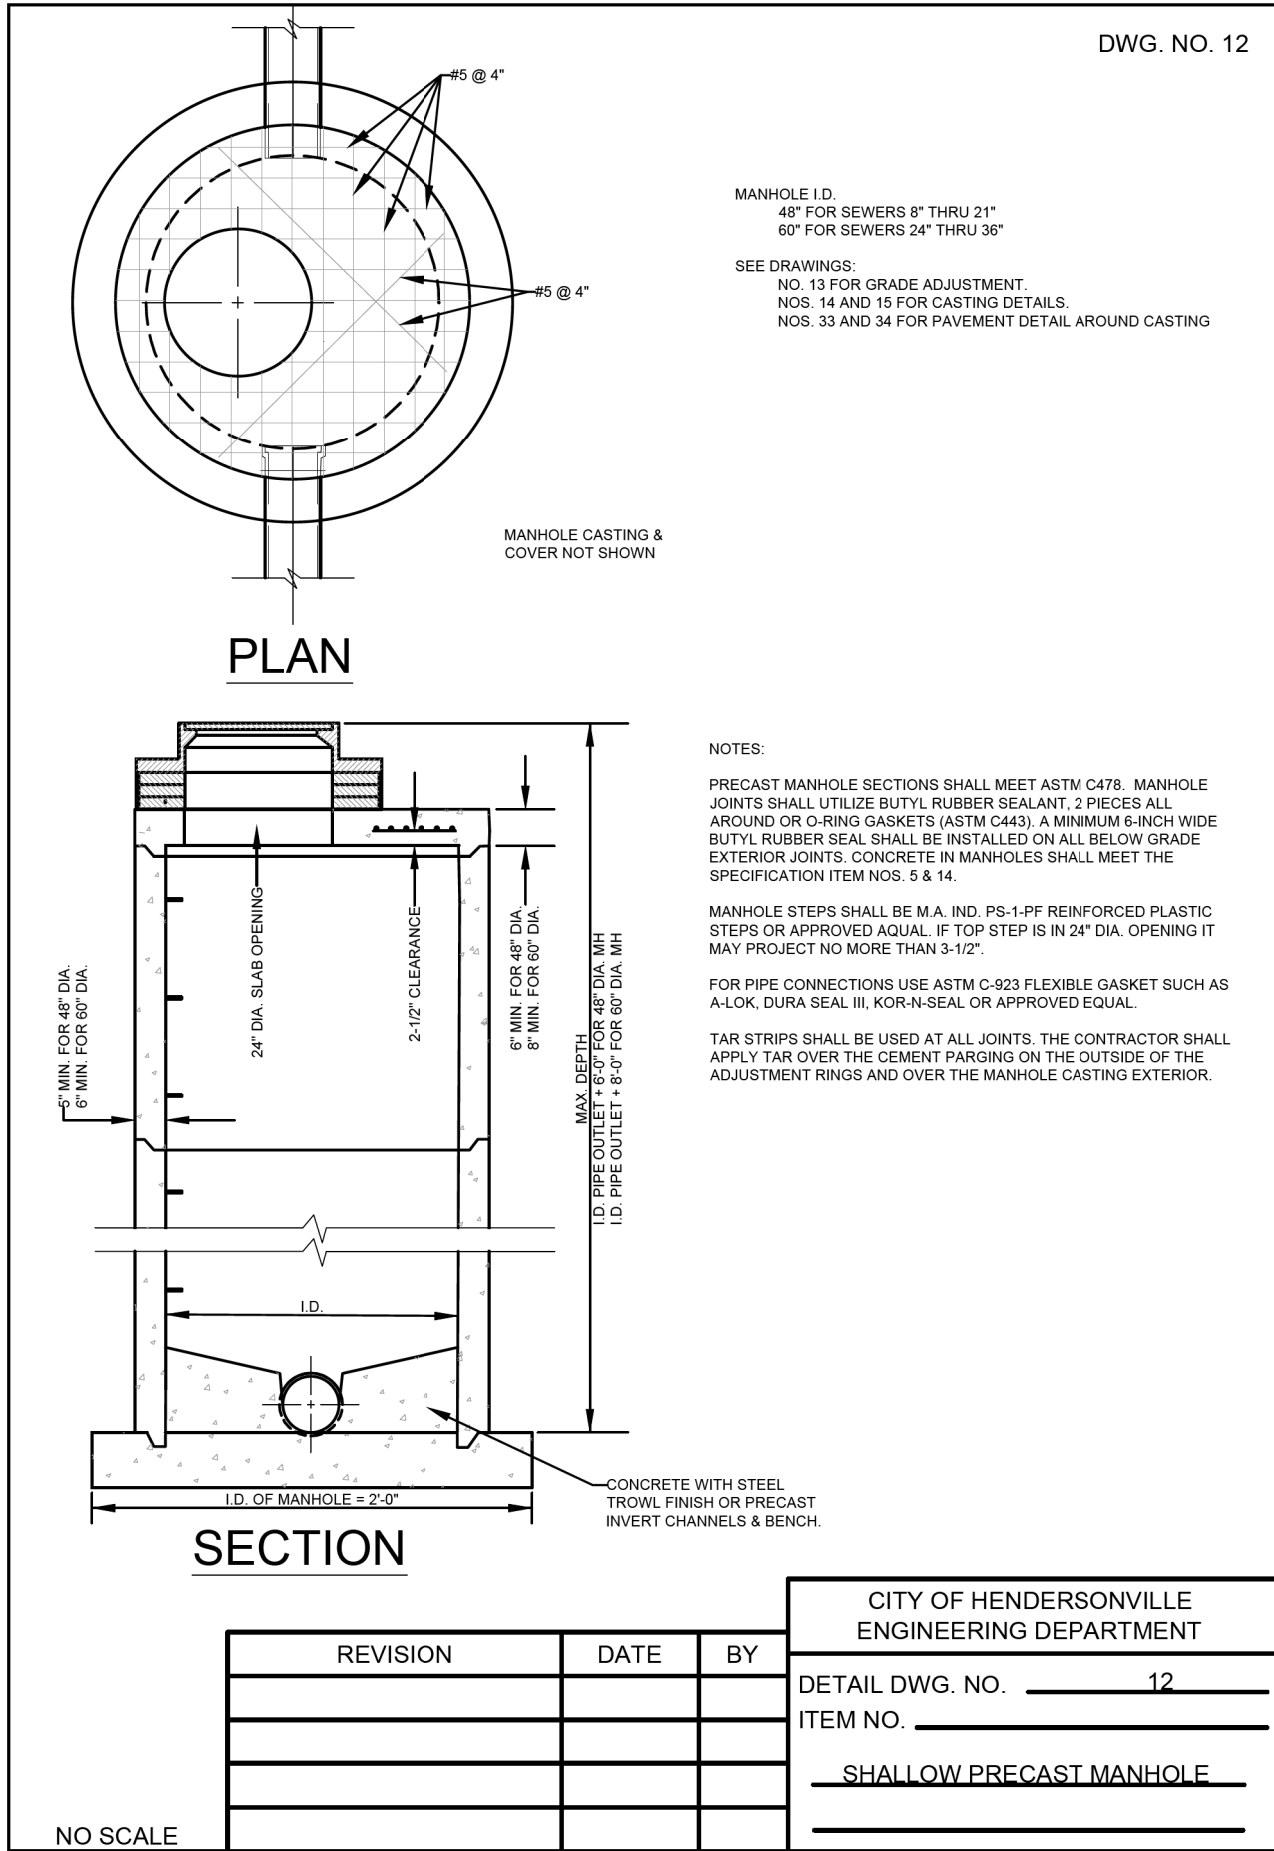


UTILITY CONSTRUCTION

HINDE ENGINEERING


License No. C-2639
401 Harrison Oaks Blvd., Suite 146 Cary, NC 27513

**DOCUMENT NOT CONSIDERED FINAL
UNLESS ALL SIGNATURES COMPLETED**


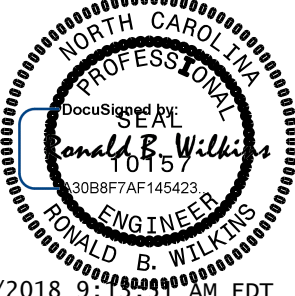
PROJECT REFERENCE NO.		SHEET NO.	
U-5105		UC-3C	
DESIGNED BY: RBW			
DRAWN BY: JNA			
CHECKED BY: CLS			
APPROVED BY: RBW			
REVISED:			
NORTH CAROLINA DEPARTMENT OF TRANSPORTATION		6/7/2018 9:41:00 AM EDT	
UTILITIES ENGINEERING SEC. PHONE: (919) 707-6690 FAX: (919) 250-4151		UTILITY CONSTRUCTION PLANS ONLY	

PROJECT REFERENCE NO.	SHEET NO.
U-5105	UC-3D
DESIGNED BY: RBW	SEAL North Carolina Professional Engineer 2/20/2018 Ronald B. Wilkins ENGINEER
DRAWN BY: JNA	
CHECKED BY: CLS	
APPROVED BY: RBW	
REVISED:	
NORTH CAROLINA DEPARTMENT OF TRANSPORTATION	UTILITY CONSTRUCTION PLANS ONLY
UTILITIES ENGINEERING SEC. PHONE: (919) 707-6690 FAX: (919) 250-4151	

UTILITY CONSTRUCTION

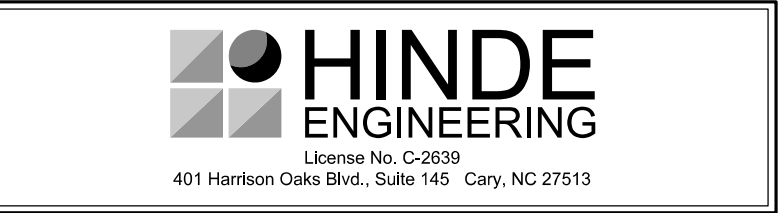

DOCUMENT NOT CONSIDERED FINAL
UNLESS ALL SIGNATURES COMPLETED

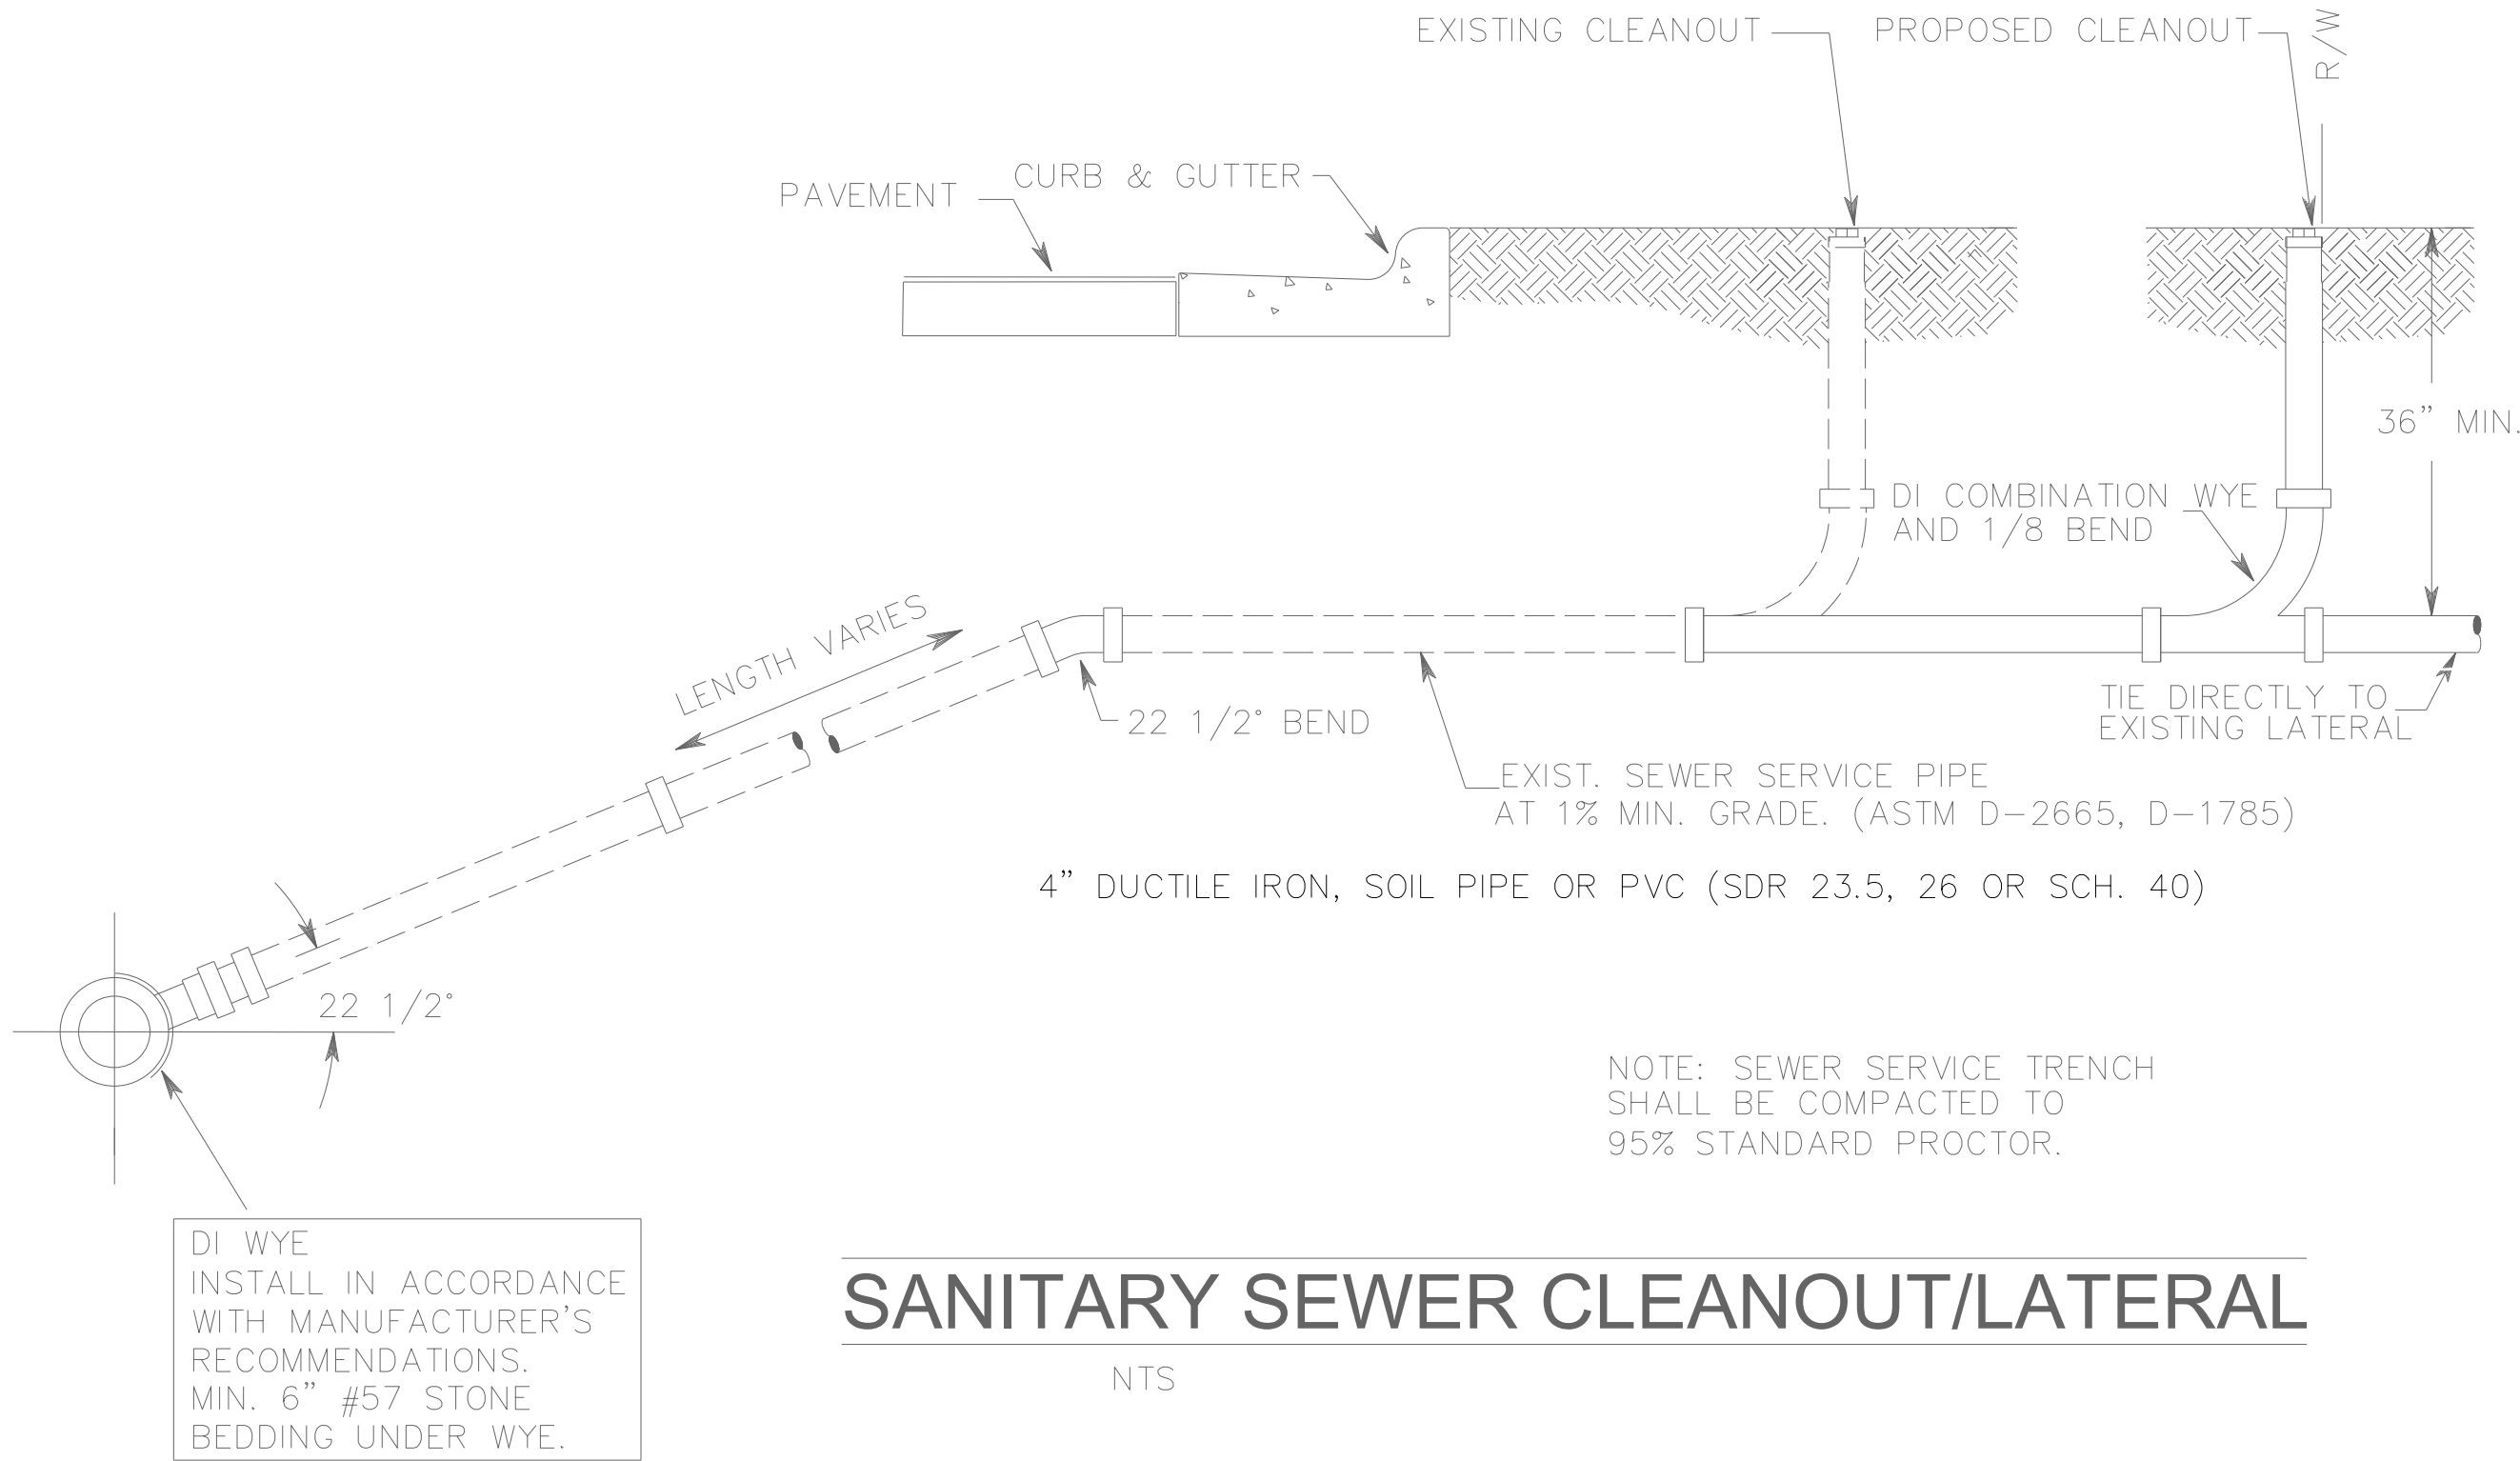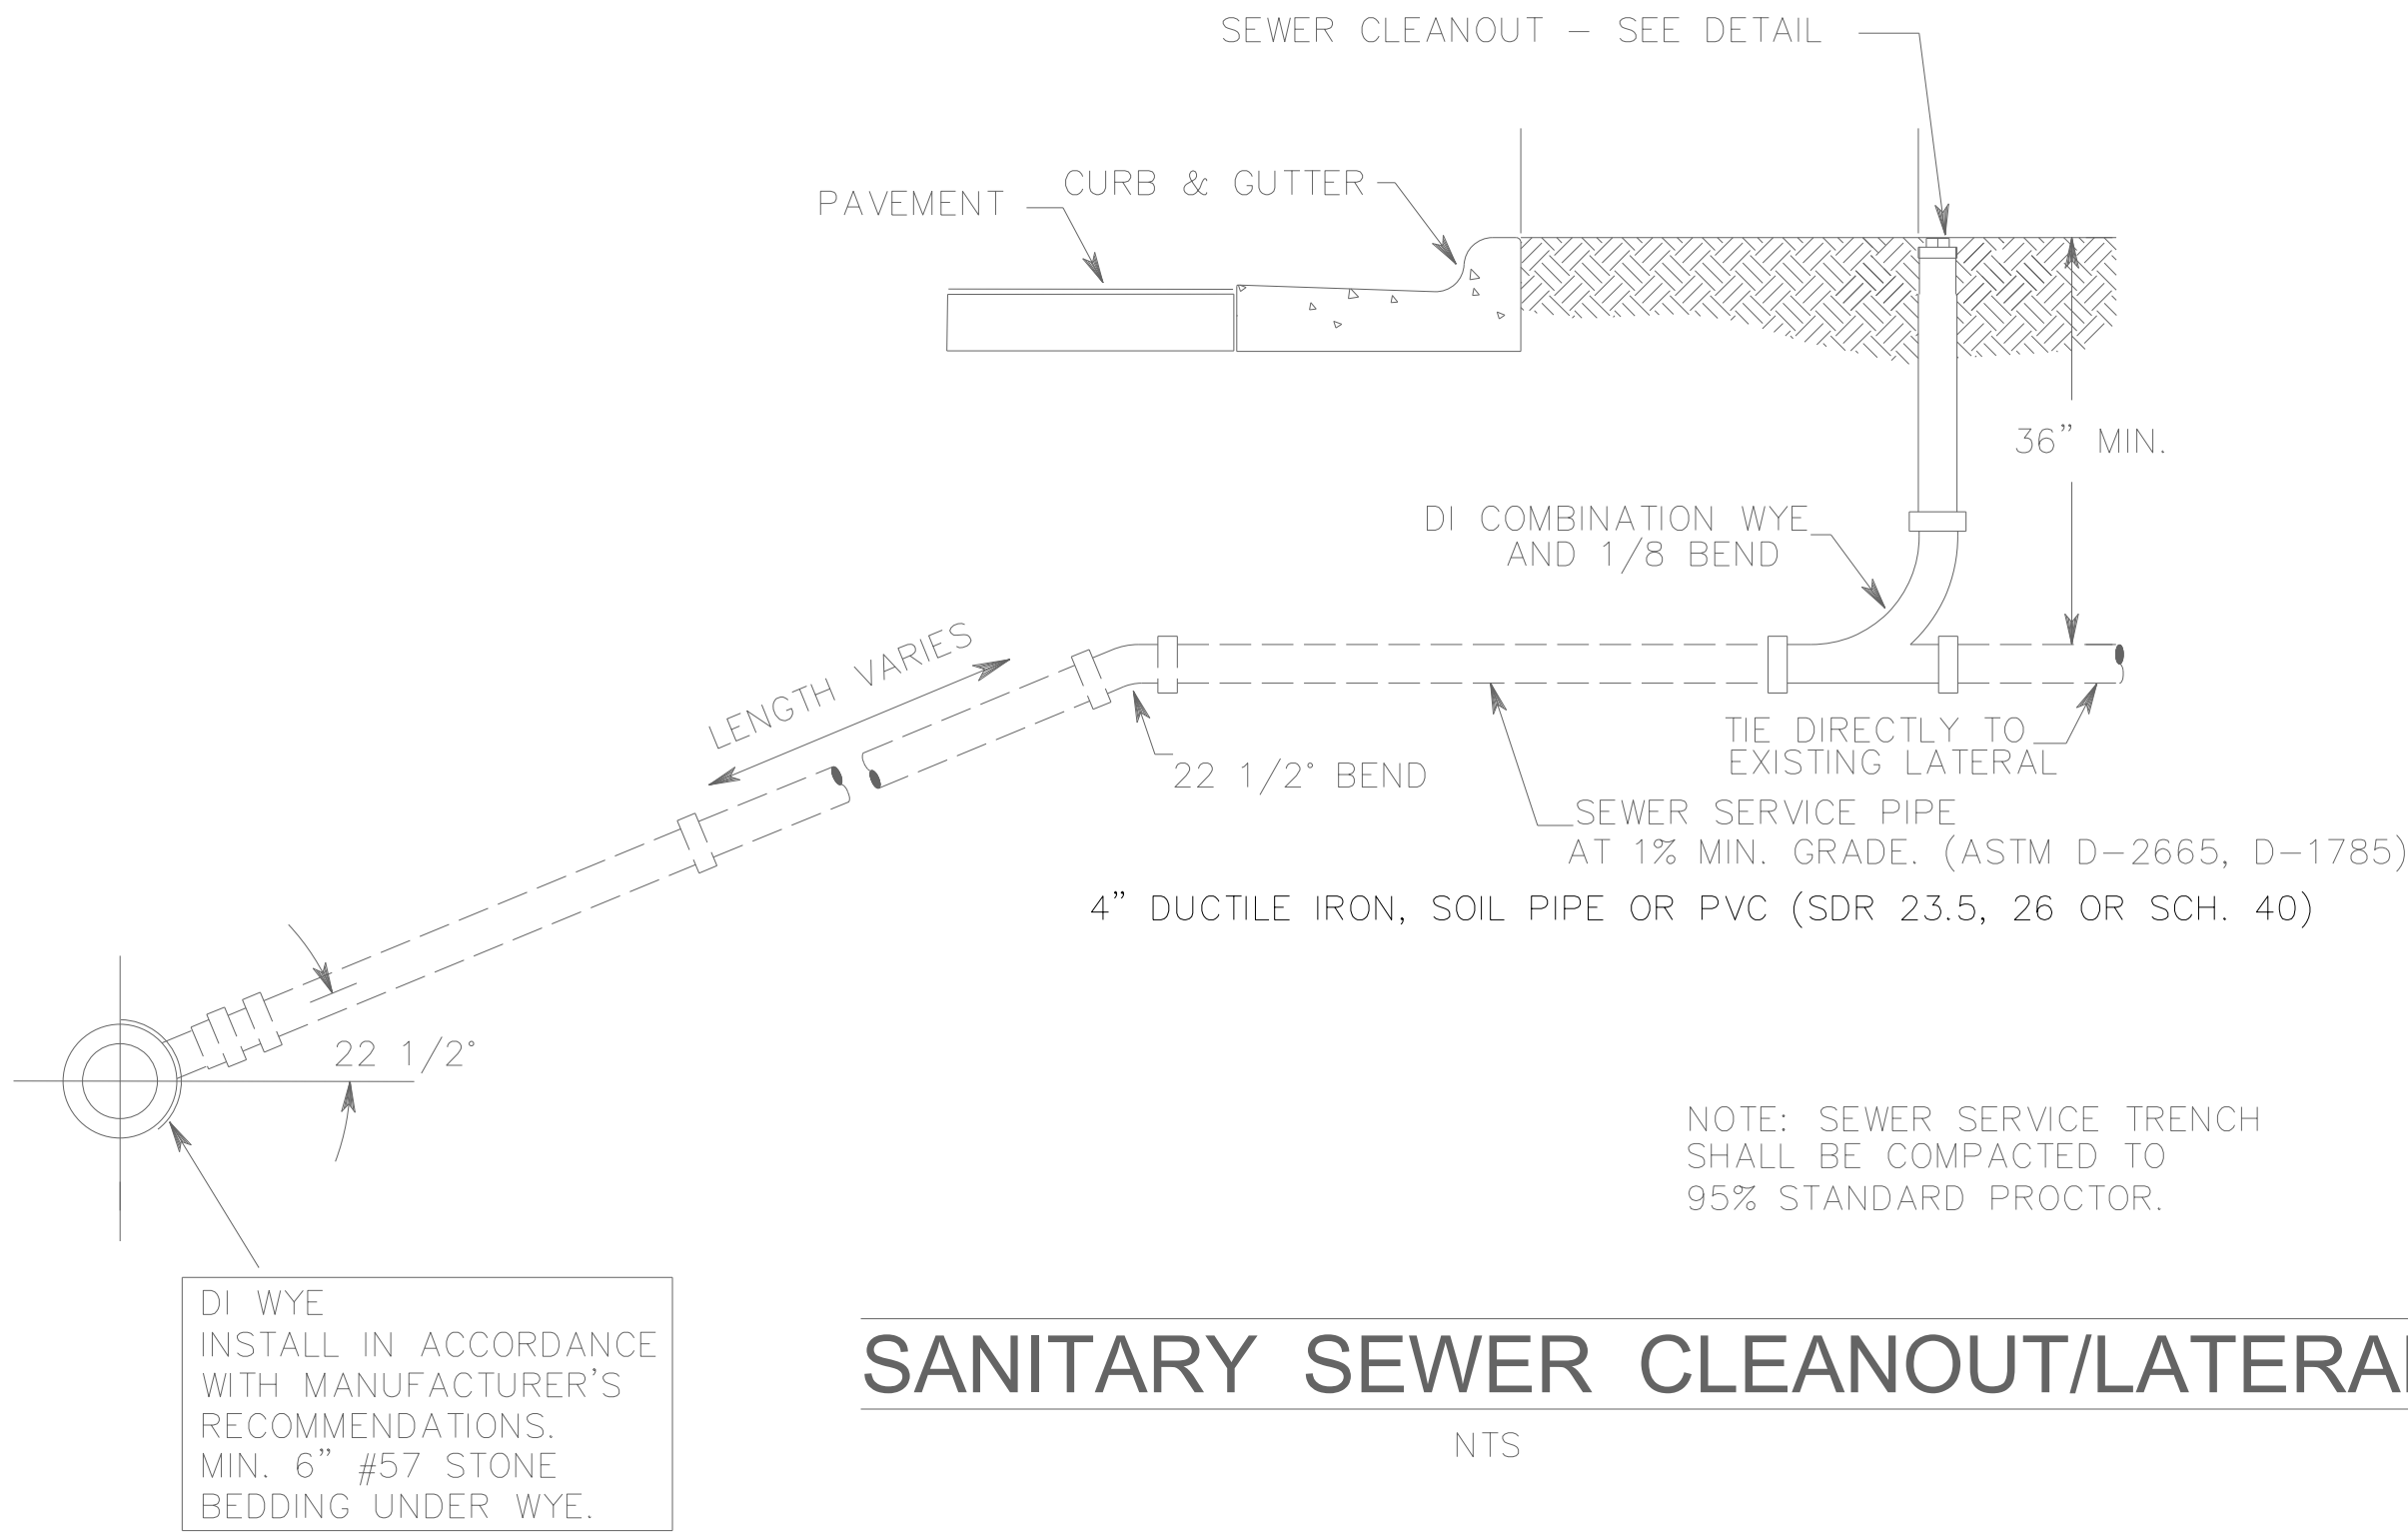

19-FEB-2018 16:53 C:\PROJECTS\2014\A20141102.00 Mulkey-U-5105\Design\Utilities\Engineering\UC\Proj\U5105_Ut_dtl_UC3D_psh.dgn

NOTE:
THE ESTIMATED QUANTITY OF DUCTILE IRON
WATER PIPE FITTINGS ON THIS PLAN SHEET
IS 4805 POUNDS. THE ACTUAL QUANTITY AND
TYPE OF FITTINGS WILL VARY BASED ON
FIELD CONDITIONS. (350# MIN WP)


SEE SHEET UC-5 FOR
PROFILE -WL1-
SEE SHEET UC-6 FOR
PROFILES -WL2-, -SL1-
AND -SL2-
SEE SHEET UC-7 FOR
PROFILE -SL3-

NAD 83
NSRS 2007




License No. C-2639
7520 E. Independence Blvd., Suite 230 Charlotte, NC 28227

**DOCUMENT NOT CONSIDERED FINAL
UNLESS ALL SIGNATURES COMPLETED**

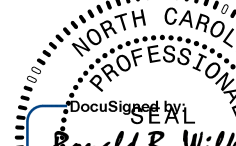PROJECT REFERENCE NO.		SHEET NO.
U-5105		UC-4
DESIGNED BY: CLS		
DRAWN BY: JNA		
CHECKED BY: CLS		
APPROVED BY: CLS		
REVISED:		
NORTH CAROLINA DEPARTMENT OF TRANSPORTATION UTILITIES ENGINEERING SEC. PHONE: (919) 707-6690 FAX: (919) 250-4151  5/17/2018 4:09:28 PM EDT UTILITY CONSTRUCTION PLANS ONLY		

UTILITY CONSTRUCTION

- PAVEMENT REMOVAL
- CONC. ISLANDS & SIDEWALK
- PAVED SHOULDER

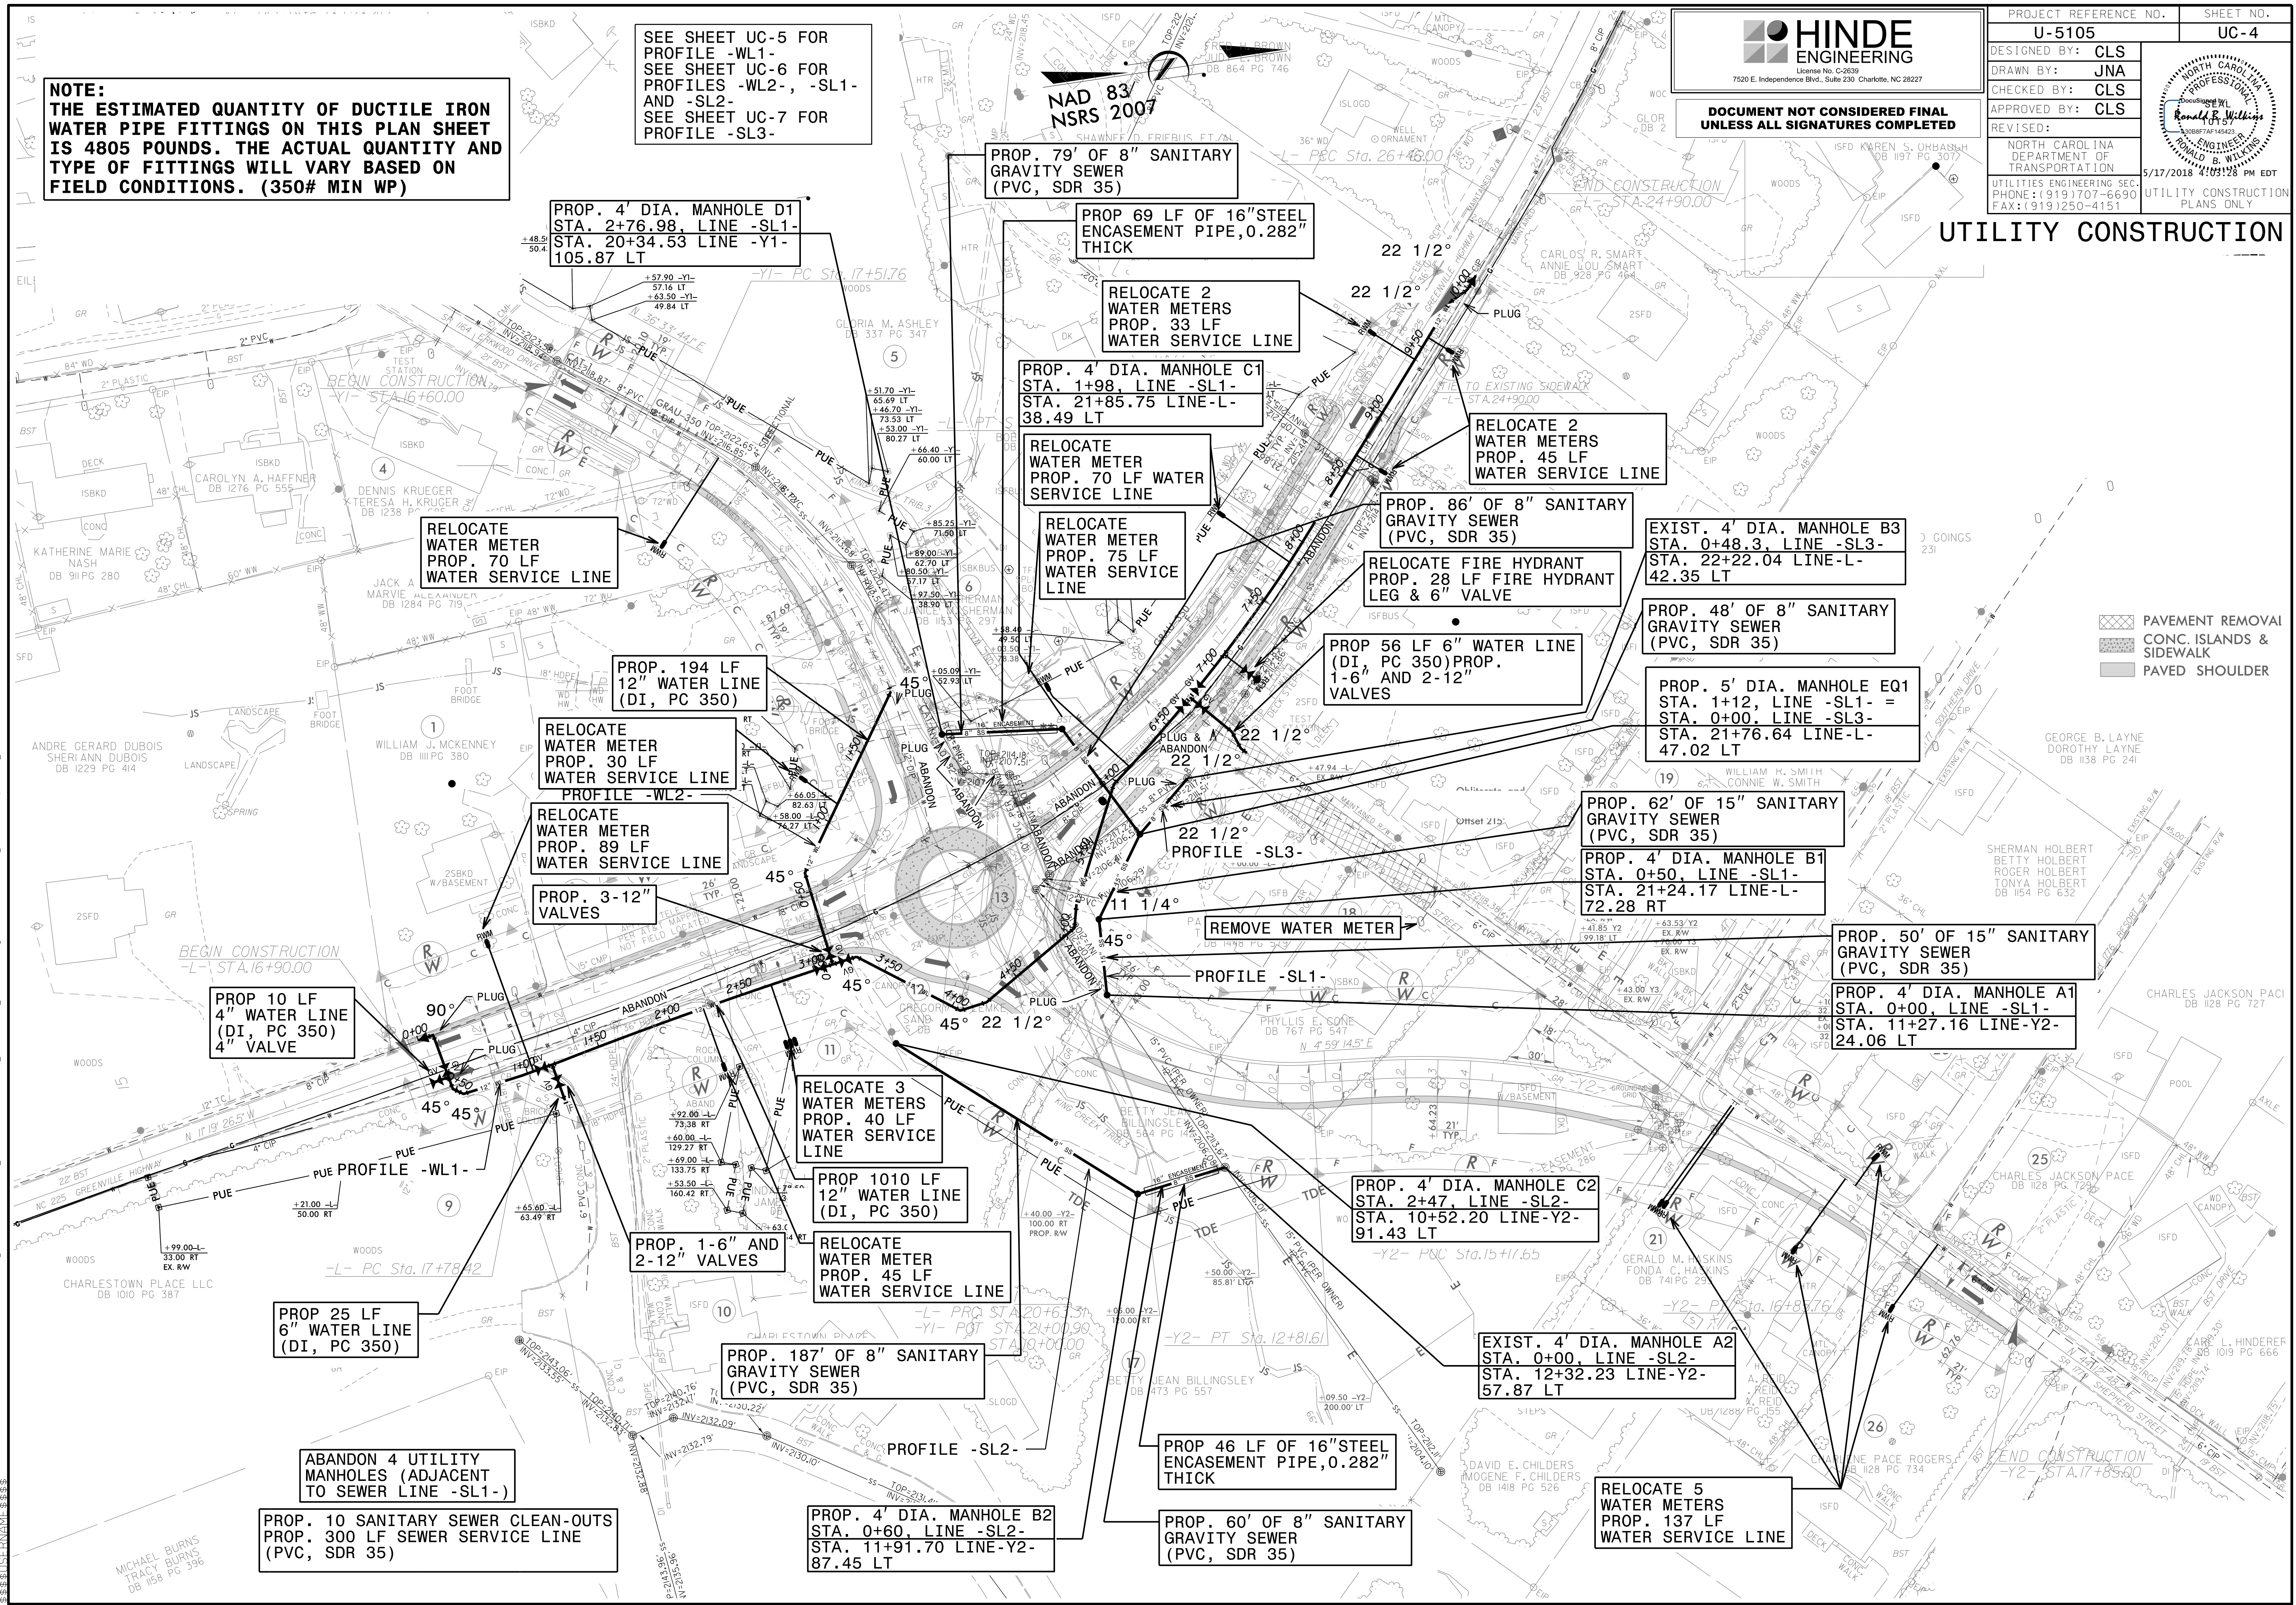

17 MAY 2018 15:05 PROJECTS\2014\A20141102.00 Mulkey-U-5105\Design\Utilities\Engineering\UC\Proj\U5105-ut-rdy4_UC04_psh.dgn

2/2018 4:03:28 PM EDT
LITY CONSTRUCTION
PLANS ONLY



17-MAY-2018 13:16
 C:\Server_Files\PROJECTS\2014\A20141102_00_Mulkey-U-5105\Design\Utilities\Engineering\UC\Proj\U5105_ut_pf1_UC05_psh.dgn
 \$\$\$\$USIFNAME\$\$\$\$

NOTE:
THE ESTIMATED QUANTITY OF DUCTILE IRON
WATER PIPE FITTINGS ON THIS PLAN SHEET
IS 4805 POUNDS. THE ACTUAL QUANTITY AND
TYPE OF FITTINGS WILL VARY BASED ON
FIELD CONDITIONS. (350# MIN WP)

SEE SHEET UC-5 FOR
PROFILE -WL1-
SEE SHEET UC-6 FOR
PROFILES -WL2-, -SL1-
AND -SL2-
SEE SHEET UC-7 FOR
PROFILE -SL3-

PROP. 79' OF 12" SANITARY
GRAVITY SEWER
(DI, PC 350)

PROP. 4' DIA. MANHOLE D1
STA. 2+76.98, LINE -SL1-
STA. 20+34.53 LINE -Y1-
105.87 LT

RELOCATE 2
WATER METERS
PROP. 33 LF
WATER SERVICE LINE

PROP. 4' DIA. MANHOLE C1
STA. 1+98, LINE -SL1-
STA. 21+85.75 LINE -L-
38.49 LT

RELOCATE
WATER METER
PROP. 70 LF
WATER SERVICE LINE

RELOCATE
WATER METER
PROP. 75 LF
WATER SERVICE LINE

RELOCATE 2
WATER METERS
PROP. 45 LF
WATER SERVICE LINE

PROP. 86' OF 12" SANITARY
GRAVITY SEWER
(DI, PC 350)

RELOCATE FIRE HYDRANT
PROP. 28 LF FIRE HYDRANT
LEG & 6" VALVE

EXIST. 4' DIA. MANHOLE B3
STA. 0+48.3, LINE -SL3-
STA. 22+22.04 LINE -L-
42.35 LT

PROP. 48' OF 8" SANITARY
GRAVITY SEWER
(DI, PC 350)

PROP. 5' DIA. MANHOLE EQ1
STA. 1+12, LINE -SL1- =
STA. 0+00, LINE -SL3-
STA. 21+76.64 LINE -L-
47.02 LT

PROP. 62' OF 12" SANITARY
GRAVITY SEWER
(DI, PC 350)

PROP. 4' DIA. MANHOLE B1
STA. 0+50, LINE -SL1-
STA. 21+24.17 LINE -L-
72.28 RT

PROP. 50' OF 12" SANITARY
GRAVITY SEWER
(DI, PC 350)

PROP. 4' DIA. MANHOLE A1
STA. 0+00, LINE -SL1-
STA. 11+27.16 LINE -Y2-
24.06 LT

PROP. 4' DIA. MANHOLE C2
STA. 2+47, LINE -SL2-
STA. 10+52.20 LINE -Y2-
91.43 LT

EXIST. 5' DIA. MANHOLE A2
STA. 0+00, LINE -SL2-
STA. 12+32.23 LINE -Y2-
57.87 LT

RELOCATE 5
WATER METERS
PROP. 137 LF
WATER SERVICE LINE

PROP. 60' OF 8" SANITARY
GRAVITY SEWER
(DI, PC 350)

PROP. 4' DIA. MANHOLE B2
STA. 0+60, LINE -SL2-
STA. 11+91.70 LINE -Y2-
87.45 LT

PROP. 187' OF 8" SANITARY
GRAVITY SEWER
(DI, PC 350)

RELOCATE
WATER METER
PROP. 45 LF
WATER SERVICE LINE

PROP 1010 LF
12" WATER LINE
(DI, PC 350)

RELOCATE 3
WATER METERS
PROP. 40 LF
WATER SERVICE LINE

PROP. 1-6" AND
1-12" VALVES

PROP. 3-12"
VALVES

RELOCATE
WATER METER
PROP. 89 LF
WATER SERVICE LINE

RELOCATE
WATER METER
PROP. 30 LF
WATER SERVICE LINE

PROP. 194 LF
12" WATER LINE
(DI, PC 350)

RELOCATE
WATER METER
PROP. 70 LF
WATER SERVICE LINE

PROP 10 LF
4" WATER LINE
(DI, PC 350)
4" VALVE

PROP 25 LF
6" WATER LINE
(DI, PC 350)

ABANDON 4 UTILITY
MANHOLES (ADJACENT
TO SEWER LINE -SL1-)

10 SANITARY SEWER CLEAN-OUTS

UTILITY CONSTRUCTION

PAVEMENT REMOVAL
CONC. ISLANDS
SIDEWALK
PAVED SHOULDER

GEORGE B. LAYNE
DOROTHY LAYNE
DB 1138 PG 241

SHERMAN HOLBERT
BETTY HOLBERT
ROGER HOLBERT
TONYA HOLBERT
DB 1154 PG 632

CHARLES JACKSON PACI
DB 1128 PG 721

CHARLES JACKSON PACE
DB 1128 PG 722


DAVID E. CHILDERS
MOGENE F. CHILDERS
DB 1418 PG 526

CHARLINE PACE ROGERS
DB 1128 PG 734

DAVID E. CHILDERS
MOGENE F. CHILDERS
DB 1418 PG 526

**HINDE
ENGINEERING**
License No. C-2639
7520 E. Independence Blvd., Suite 230 Charlotte, NC 28227

**DOCUMENT NOT CONSIDERED FINAL
UNLESS ALL SIGNATURES COMPLETED**

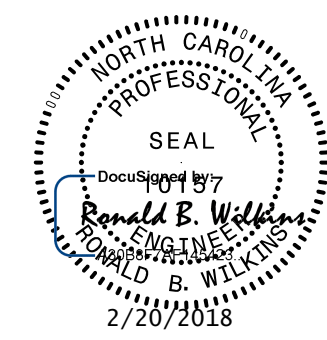PROJECT REFERENCE NO.		SHEET NO.
U-5105		UC-4
DESIGNED BY:	CLS	
DRAWN BY:	JNA	
CHECKED BY:	CLS	
APPROVED BY:	CLS	
REVISED:		
NORTH CAROLINA DEPARTMENT OF TRANSPORTATION		UTILITY CONSTRUCTION PLANS ONLY
UTILITIES ENGINEERING SEC. PHONE: (919) 707-6690 FAX: (919) 250-4151		

Professional Engineer Seal for Ronald B. Wilkins, State of North Carolina, License No. 10157, dated 2/20/2018.



20-FEB-2018 08:22
S:\Server_Files\PROJECTS\2014\20141102.00_Mukey-U-5105\Design\Utilities\Engineering\UC\Proj\U5105.ut_pfl_UC05_psh.dgn

PROP. 46' OF 16
ENCASEMENT
PROFILE SL 2



HINDE

ENGINEERING

License No. C-2639

7520 E. Independence Blvd., Suite 230 Charlotte, NC 28227

DOCUMENT NOT CONSIDERED FINAL

UNLESS ALL SIGNATURES COMPLETED

PROJECT REFERENCE NO.		SHEET NO.
U-5105		UC-6
DESIGNED BY:	RBW	NORTH CAROLINA PROFESSIONAL SEAL DocuSign by: Ronald B. Wilkins C. ENGINEER 2/28/2018
DRAWN BY:	RBW	
CHECKED BY:	CLS	
APPROVED BY:	RBW	
REVISED:		
NORTH CAROLINA DEPARTMENT OF TRANSPORTATION		UTILITY CONSTRUCTION PLANS ONLY
UTILITIES ENGINEERING SEC. PHONE: (919) 707-6690 FAX: (919) 250-4151		

UTILITY CONSTRUCTION

PROP. 8" SEWER MAIN
PARCEL 11 SERVICE
PROFILE -S2-

The profile shows three main sections: Profile -WL2- (Water Line), Profile -SL1- (Sanitary Sewer Line), and Profile -SL2- (Sanitary Sewer Line). The vertical axis represents elevation from 2060 to 2180 feet. The horizontal axis represents stationing from 0+00 to 3+00 feet. Key features include: 1. Profile -WL2-: A water line starting at STA. 0+00 with a 1.12" x 12" DI RJ TEE, passing through a 1.12" x 12" VALVE at STA. 0+07, and ending at STA. 1+94.4 with a 1.12" x 45° RJ DI BEND. It crosses an EXIST. GRADE and an EXIST. WATER LINE. 2. Profile -SL1-: A sanitary sewer line starting at STA. 0+00 with a 5' DIA. MANHOLE A1, passing through a 4' DIA. MANHOLE B1, a 5' DIA. MANHOLE EQ1, a 4' DIA. MANHOLE C1, and a 4' DIA. MANHOLE D1. It crosses an EXIST. GRADE and an EXIST. 12" SEWER LINE. 3. Profile -SL2-: A sanitary sewer line starting at STA. 0+00 with a 4' DIA. MANHOLE A2, passing through a 4' DIA. MANHOLE B2, and ending at STA. 2+47 with a 4' DIA. MANHOLE C2. It crosses an EXIST. GRADE and an EXIST. 8" SEWER LINE. The profile also shows various manholes (A1, B1, EQ1, C1, D1, A2, B2, C2) and their elevations. The water line is labeled 'PROP. 194' OF 12" WATER LINE (DI, PC 350)'. The sanitary sewer lines are labeled 'PROP. 79' OF 12" SANITARY GRAVITY SEWER (DI, PC 350)', 'PROP. 86' OF 12" SANITARY GRAVITY SEWER (DI, PC 350)', 'PROP. 62' OF 12" SANITARY GRAVITY SEWER (DI, PC 350)', 'PROP. 50' OF 12" SANITARY GRAVITY SEWER (DI, PC 350)', and 'PROP. 187' OF 8" SANITARY GRAVITY SEWER (DI, PC 350)'. The profile also shows 'EXIST. GRADE' and 'EXIST. WATER LINE'.


20-FEB-2018 08:06:50 PROJECTS\2014\A20141102.00 Mulkey-U-5105\Design\Utilities\Engineering\UC\Proj\U5105_ut.pfl UC06_psh.dgn

C:\Users\jshelton\Documents\Projects\2014\A20141102.00_Mulkey-U-5105\Design\Utilities\Engineering\UC\Proj\U5105_ut.pfl_UC07.psh.dgn 17 MAY 2016 13:17 3338157616




HINDE
ENGINEERING
License No. C-2639
7520 E. Independence Blvd., Suite 230 Charlotte, NC 28227

**DOCUMENT NOT CONSIDERED FINAL
UNLESS ALL SIGNATURES COMPLETED**

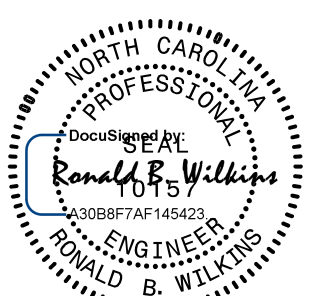PROJECT REFERENCE NO.		SHEET NO.
U-5105		UC-7
DESIGNED BY:	RBW	 5/17/2018 4:03:28 PM EDT UTILITY CONSTRUCTION PLANS ONLY
DRAWN BY:	RBW	
CHECKED BY:	CLS	
APPROVED BY:	RBW	
REVISED:		
NORTH CAROLINA DEPARTMENT OF TRANSPORTATION		
UTILITIES ENGINEERING SEC. PHONE: (919) 707-6690 FAX: (919) 250-4151		

UTILITY CONSTRUCTION

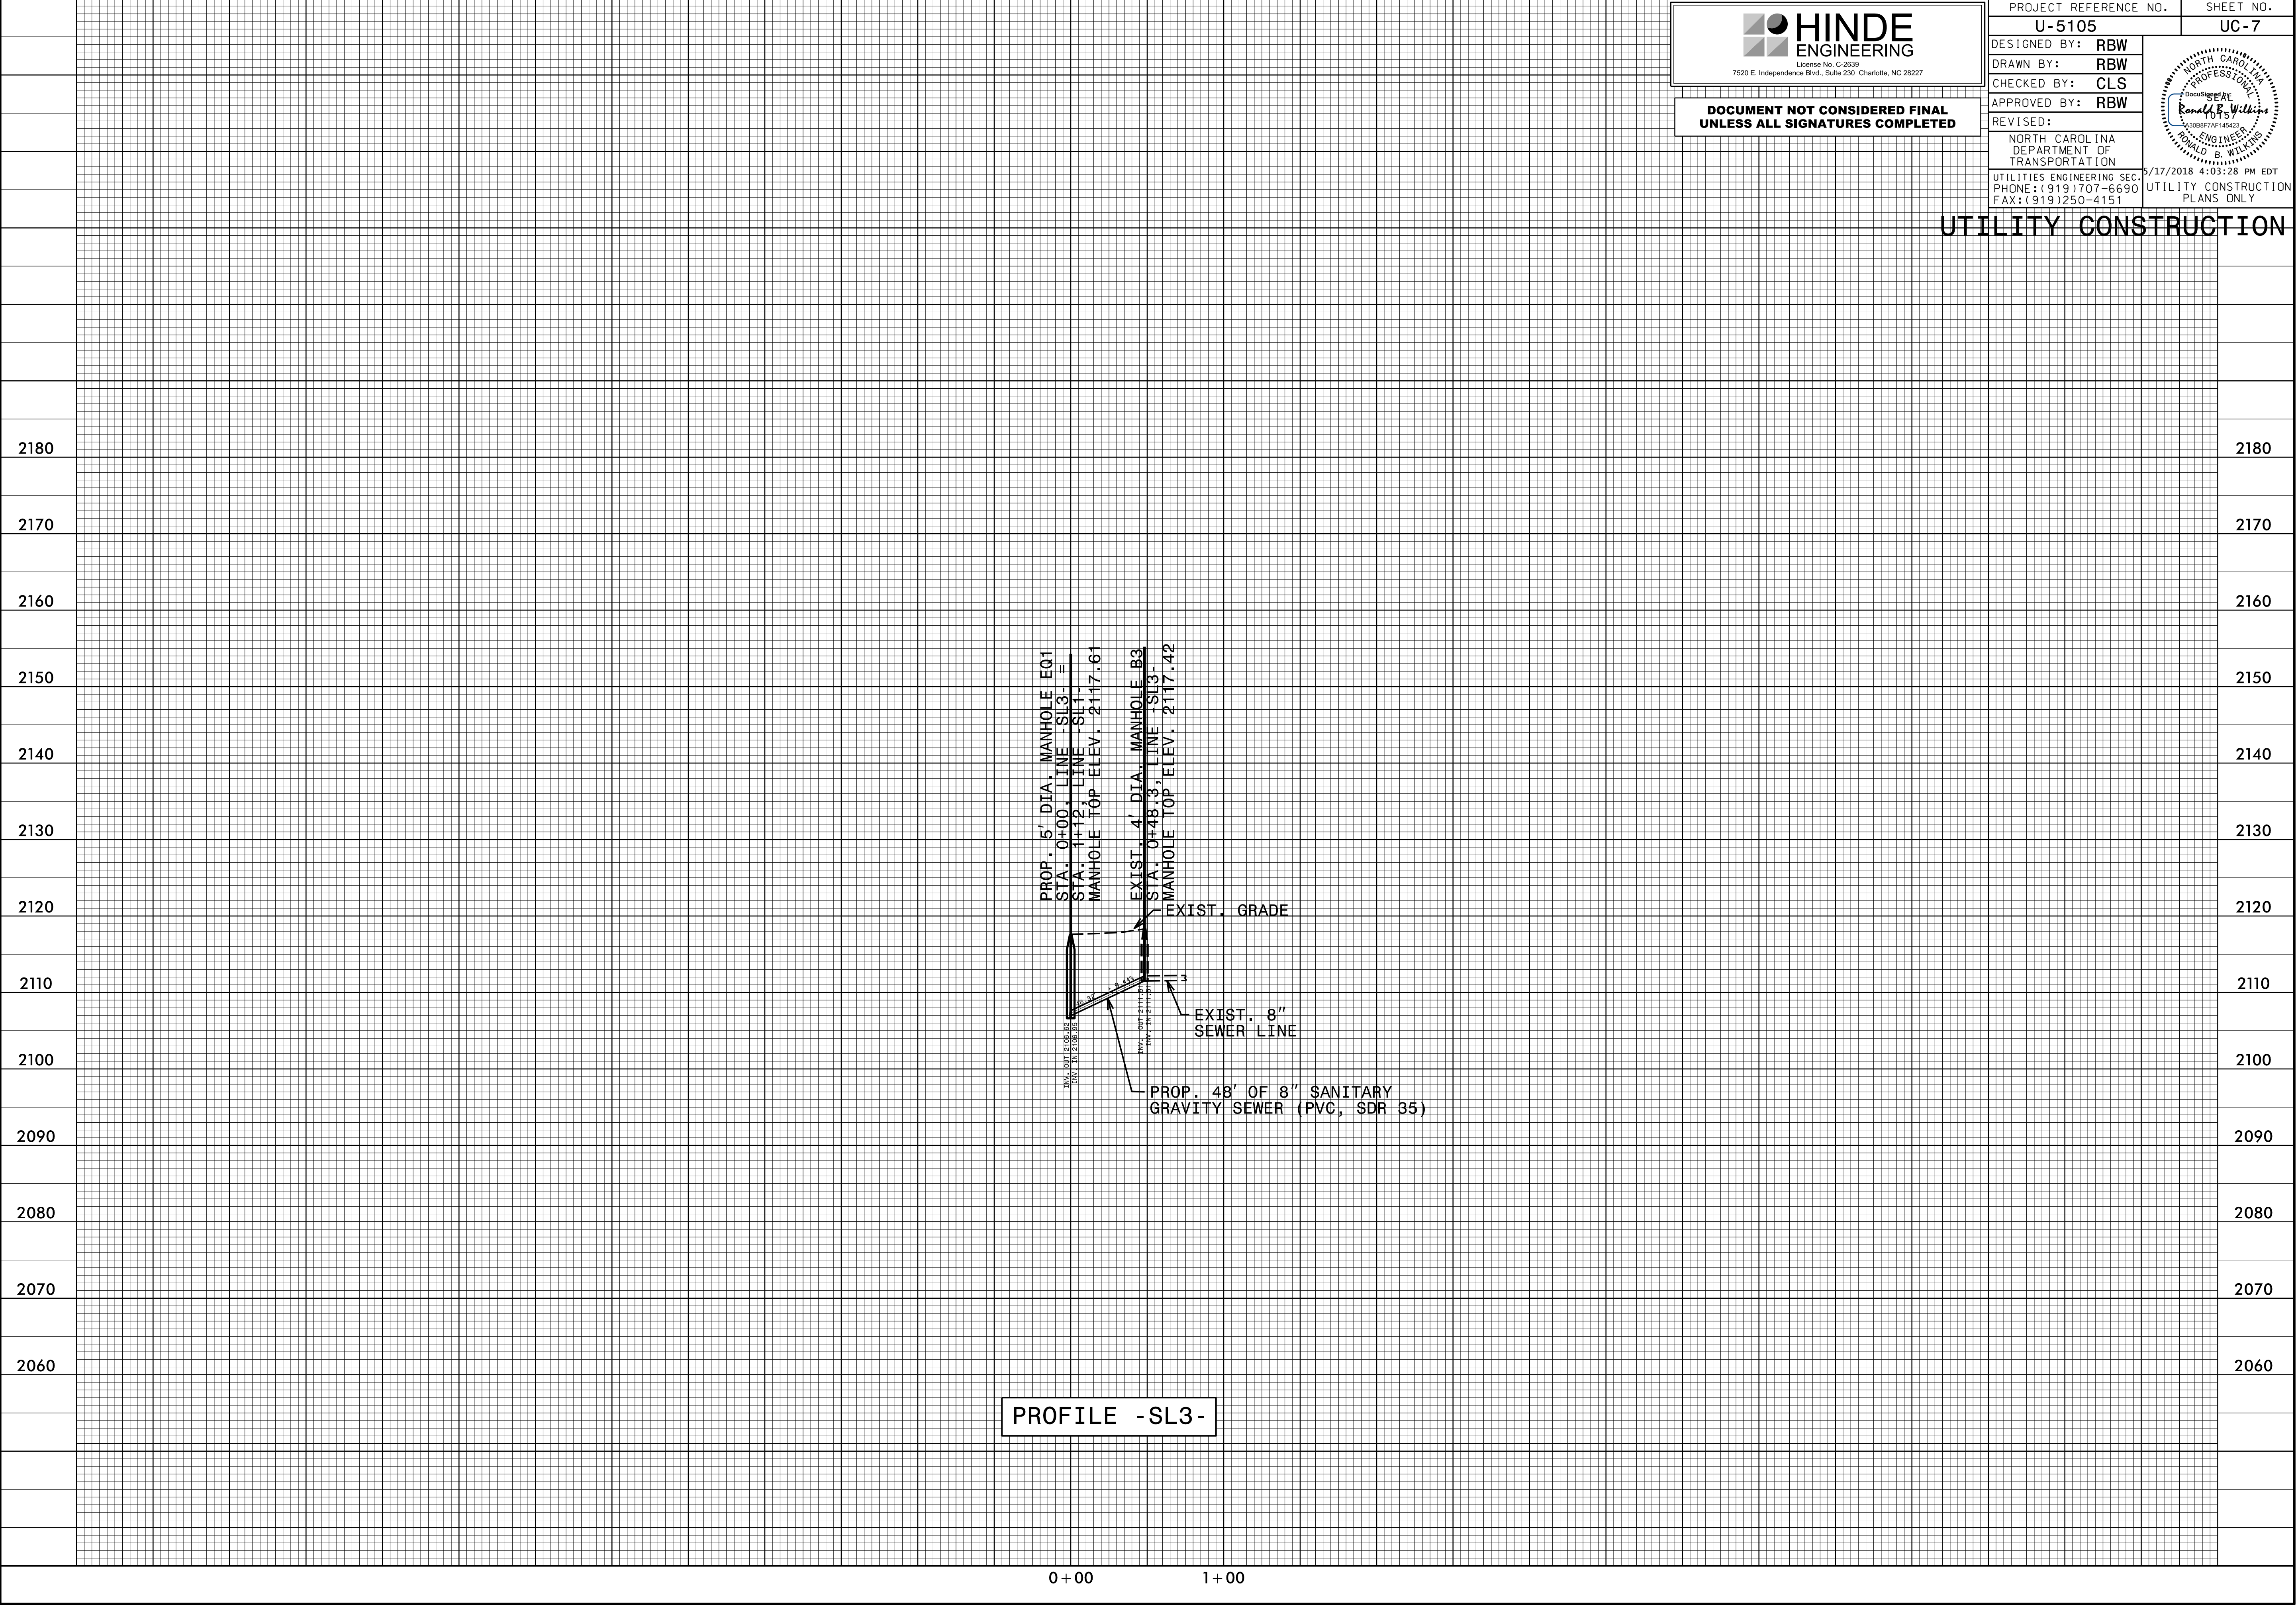

0 + 00 1 + 00

19-FEB-2018 16:09 C:\5\5\PROJECTS\2014\A20141102.00 Mulkey-U-5105\Design\Utilities\Engineering\UC\Proj\U5105_ut.pfl UC07.psh.dgn



HINDE


ENGINEERING

License No. C-2639
7520 E. Independence Blvd., Suite 230 Charlotte, NC 28227

DOCUMENT NOT CONSIDERED FINAL
UNLESS ALL SIGNATURES COMPLETED


PROJECT REFERENCE NO.		SHEET NO.	
U-5105		UC-7	
DESIGNED BY:	RBW	NORTH CAROLINA PROFESSIONAL SEAL <i>Ronald B. Wilkins</i> 2/20/2018 UTILITY CONSTRUCTION PLANS ONLY	
DRAWN BY:	RBW		
CHECKED BY:	CLS		
APPROVED BY:	RBW		
REVISED:			
NORTH CAROLINA DEPARTMENT OF TRANSPORTATION			
UTILITIES ENGINEERING SEC. PHONE: (919) 707-6690 FAX: (919) 250-4151			

UTILITY CONSTRUCTION

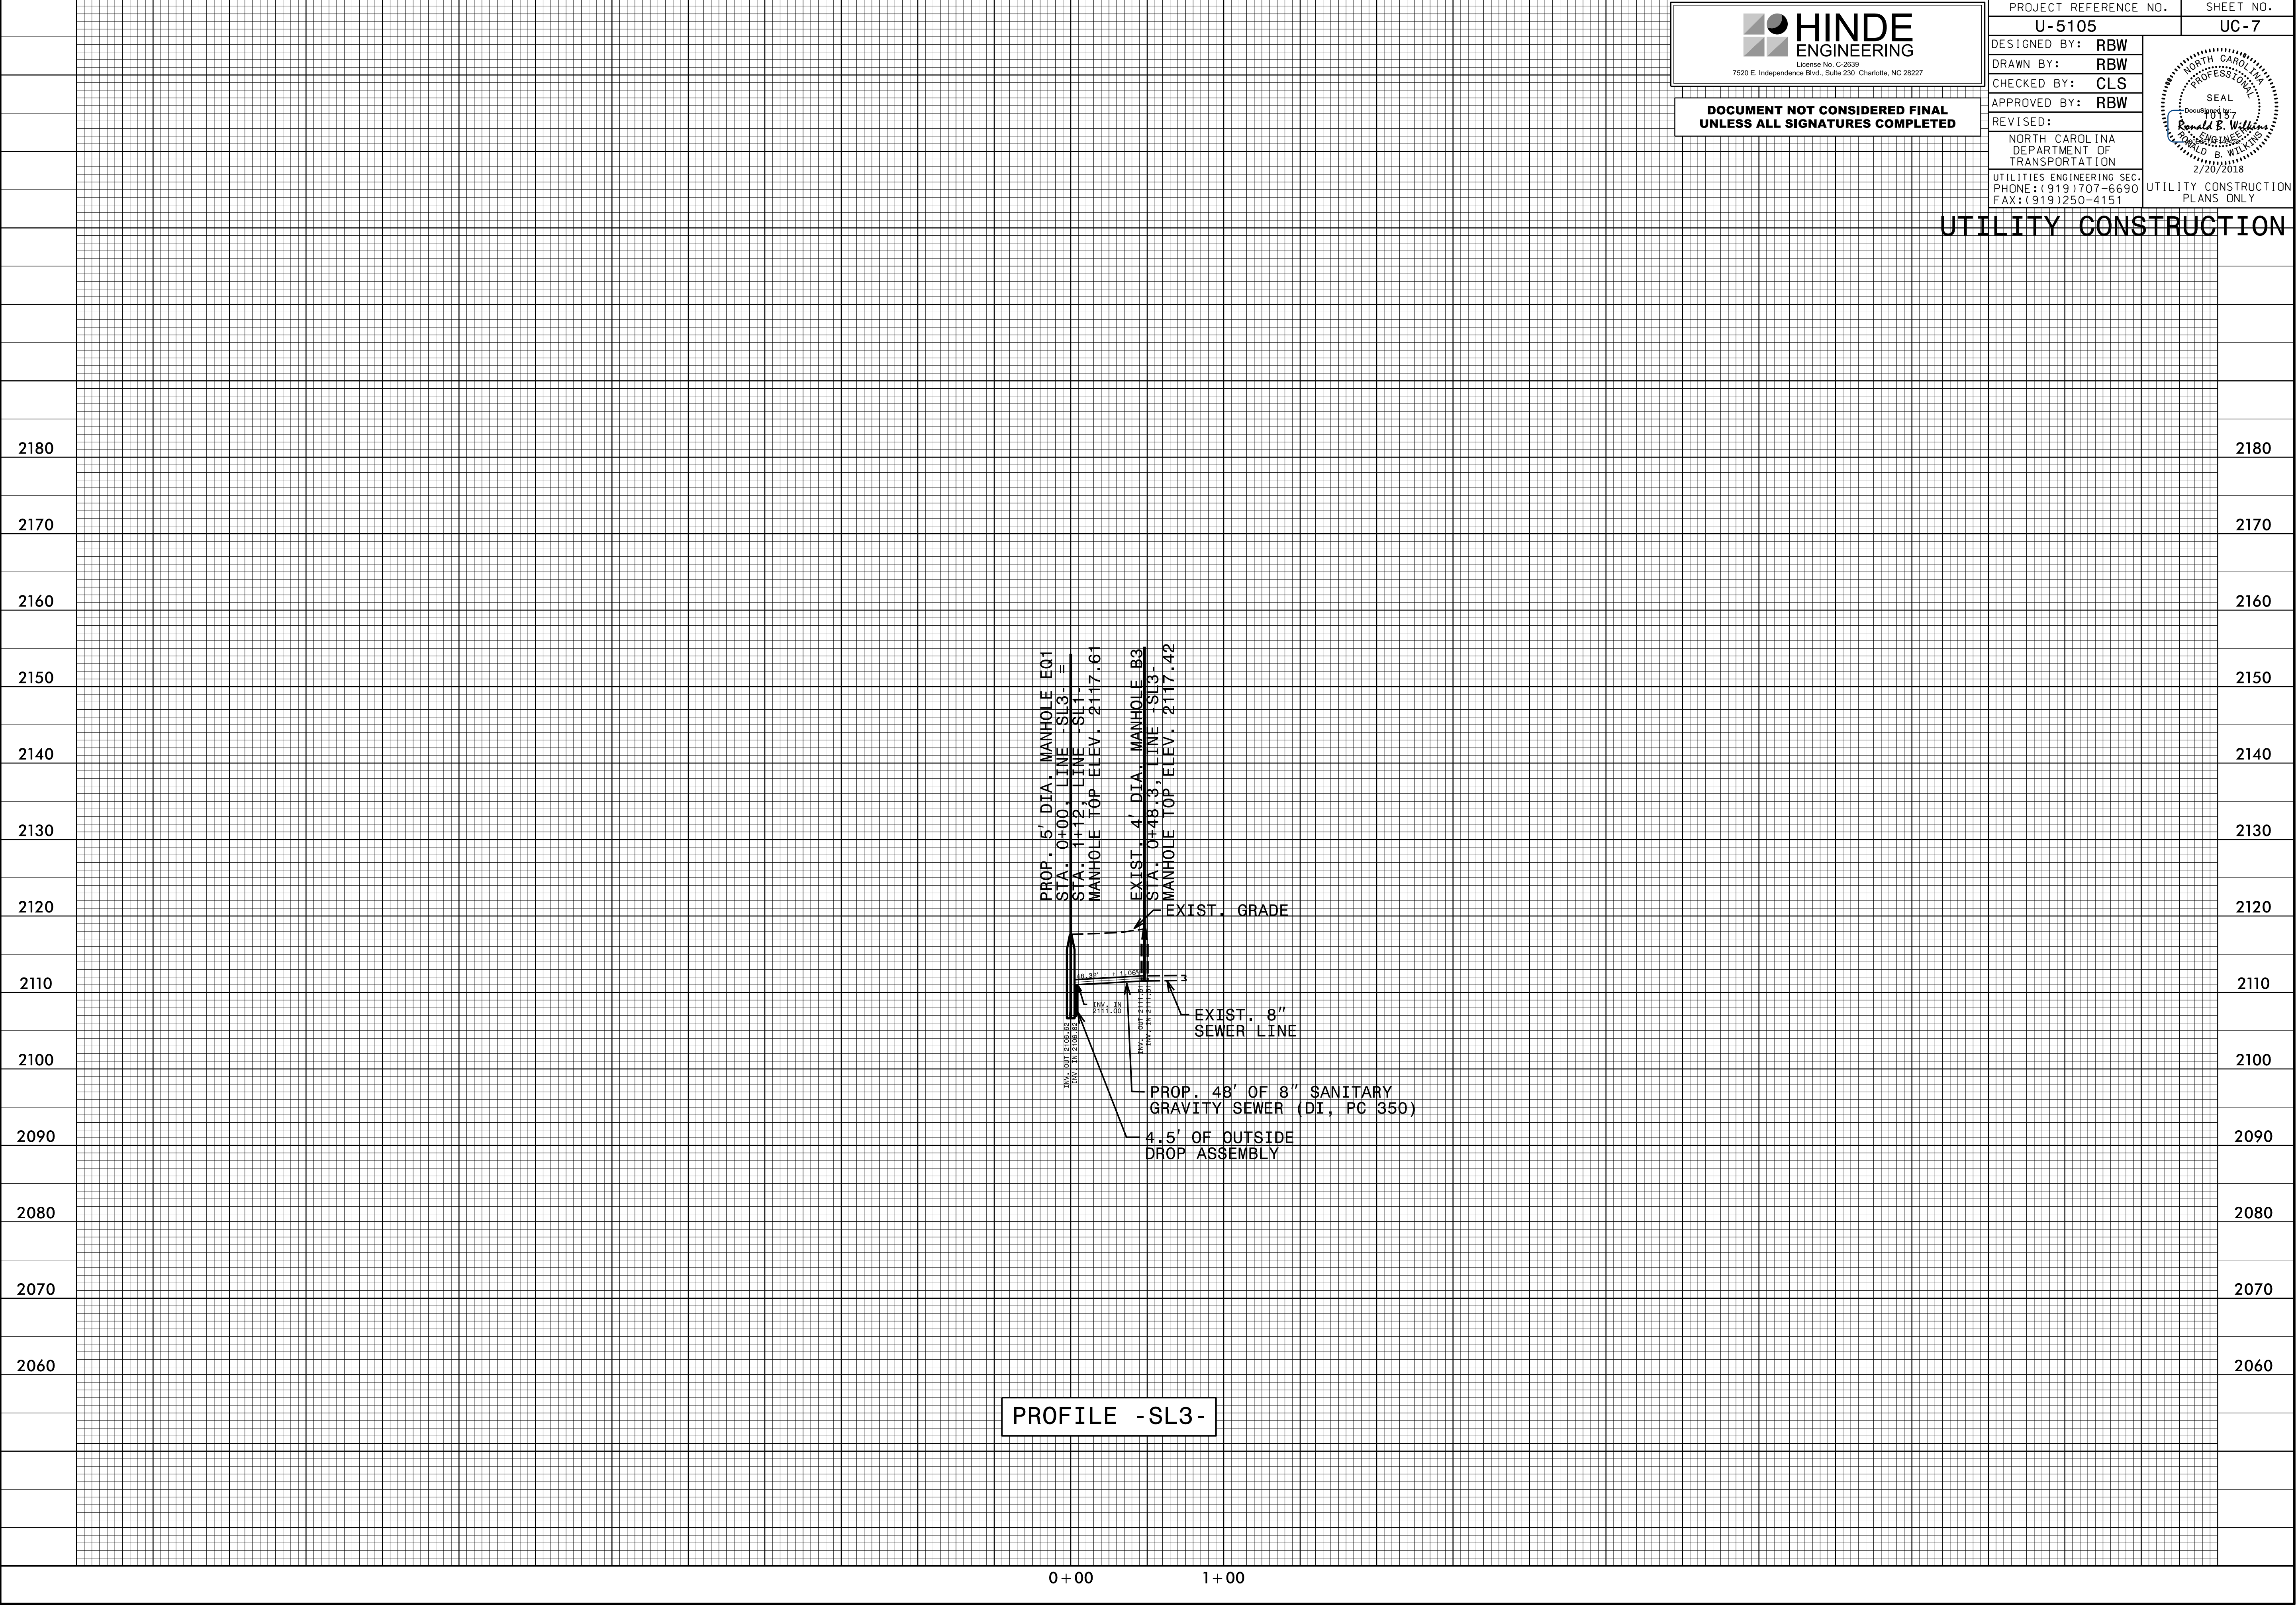

20-NOV-2017 07:34
S:\server_files\PROJECTS\2014\A204102.00 Mukey-U-5105\Design\Utilities\Engineering\UBO\Proj\U5105_ut_tsh_U001.psh.dgn
\$\$\$\$\$USERNAME\$\$\$\$\$

TIP PROJECT: U-5105

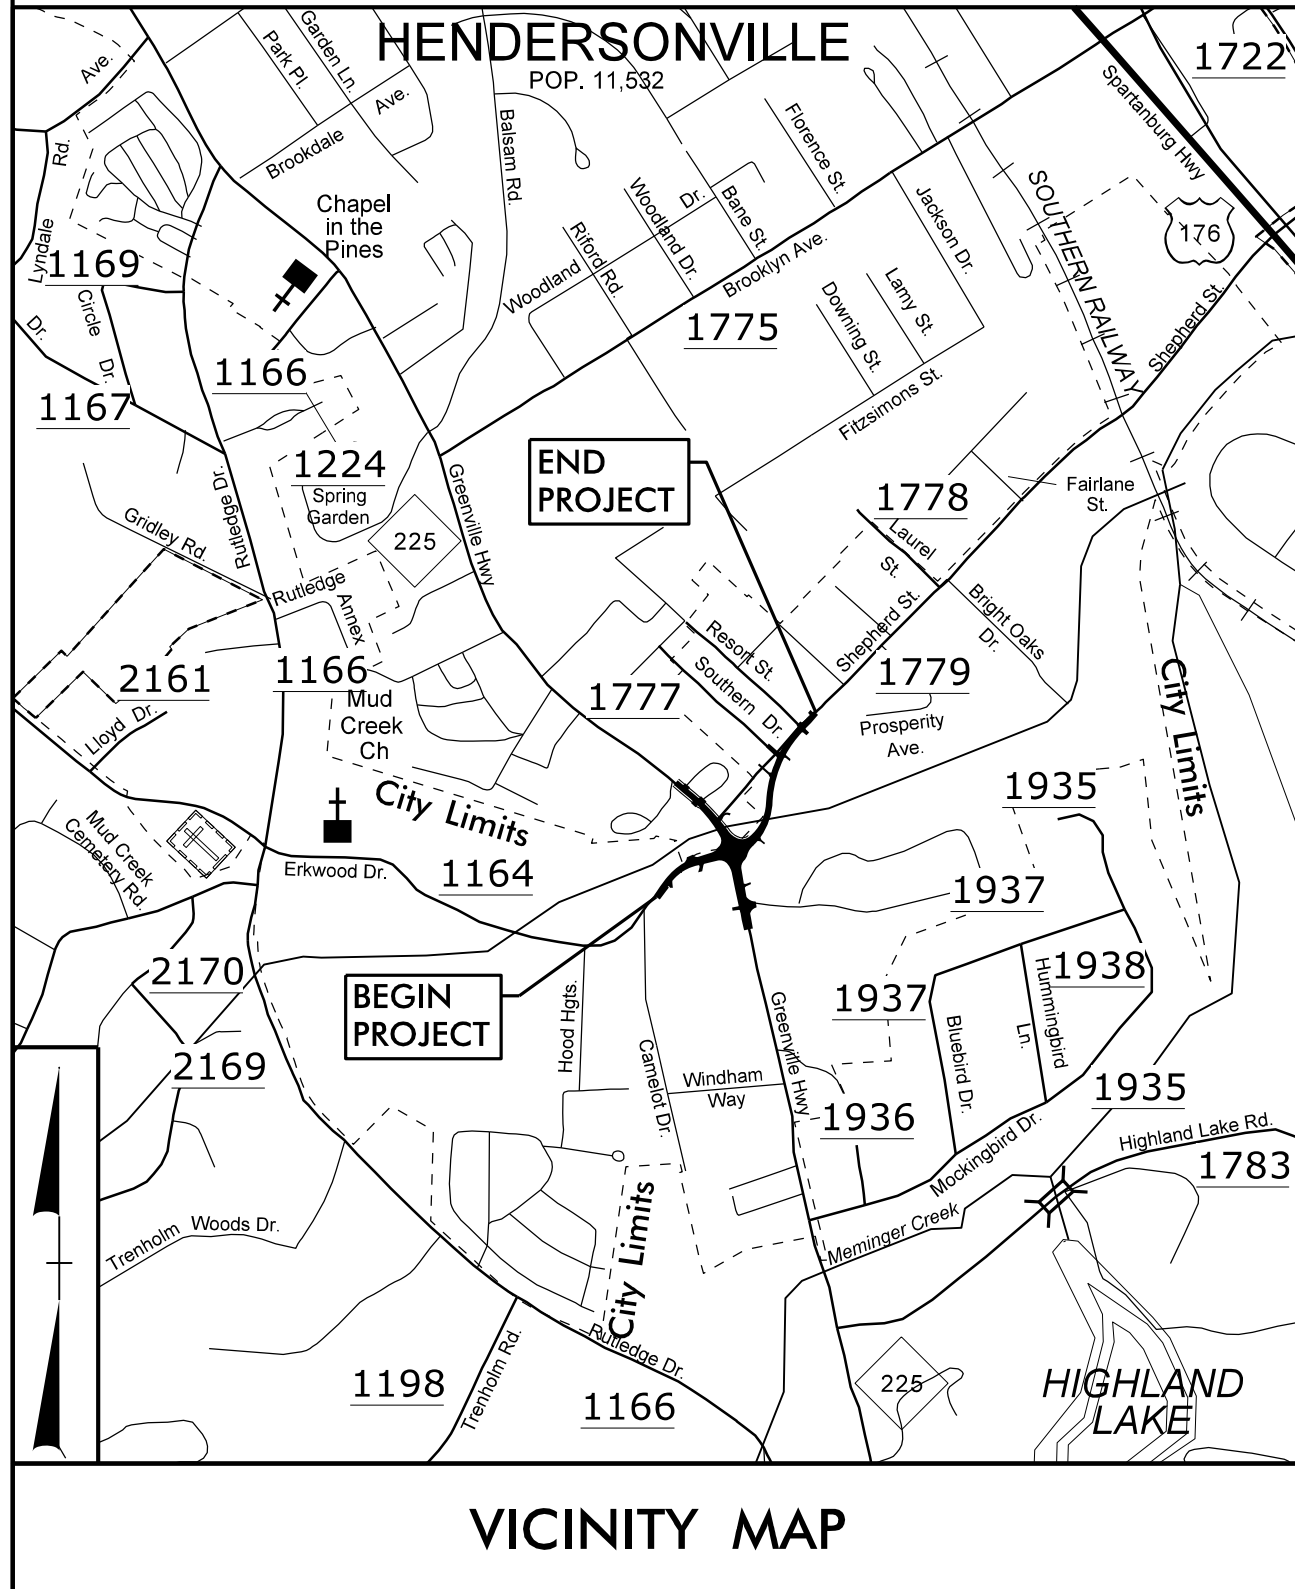


VICINITY MAP

THERE IS NO CONTROL OF ACCESS ON THIS PROJECT.

A PORTION OF THIS PROJECT IS WITHIN THE MUNICIPAL BOUNDARIES OF HENDERSONVILLE.

CLEARING ON THIS PROJECT SHALL BE PERFORMED TO THE LIMITS ESTABLISHED BY METHOD II.

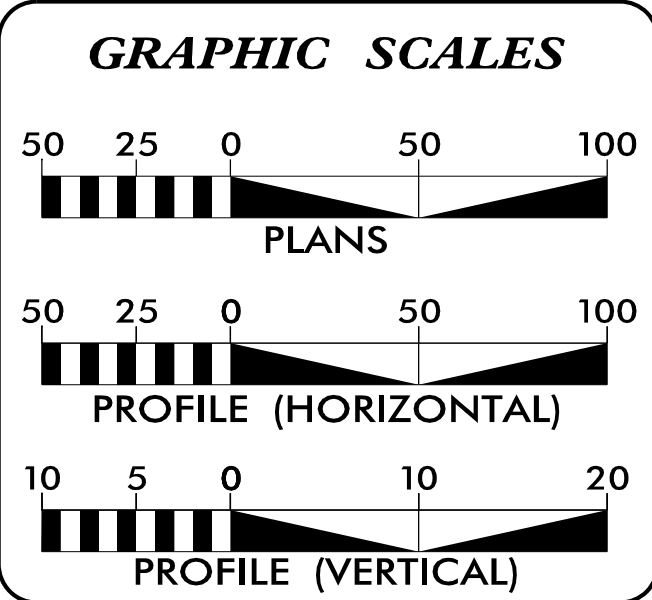

INDEX OF SHEETS

SHEET NO.	DESCRIPTION
UO-1	TITLE SHEET
UO-2	UBO PLAN SHEET


UTILITY OWNERS WITH CONFLICTS

- (A) POWER DISTRIBUTION - DUKE ENERGY
(B) TELECOM - AT&T
(C) TELECOM - MORRIS BROADBAND
(D) GAS - PSNC GAS COMPANY


STATE OF NORTH CAROLINA
DIVISION OF HIGHWAYS

UTILITIES BY OTHERS PLANS
HENDERSON COUNTY

LOCATION: NC 225 (GREENVILLE HWY) INTERSECTION IMPROVEMENTS
FROM SR 1164 (ERKWOOD DR) TO SR 1779 (SHEPHERD ST)
TYPE OF WORK: POWER, TELECOM & GAS RELOCATIONS

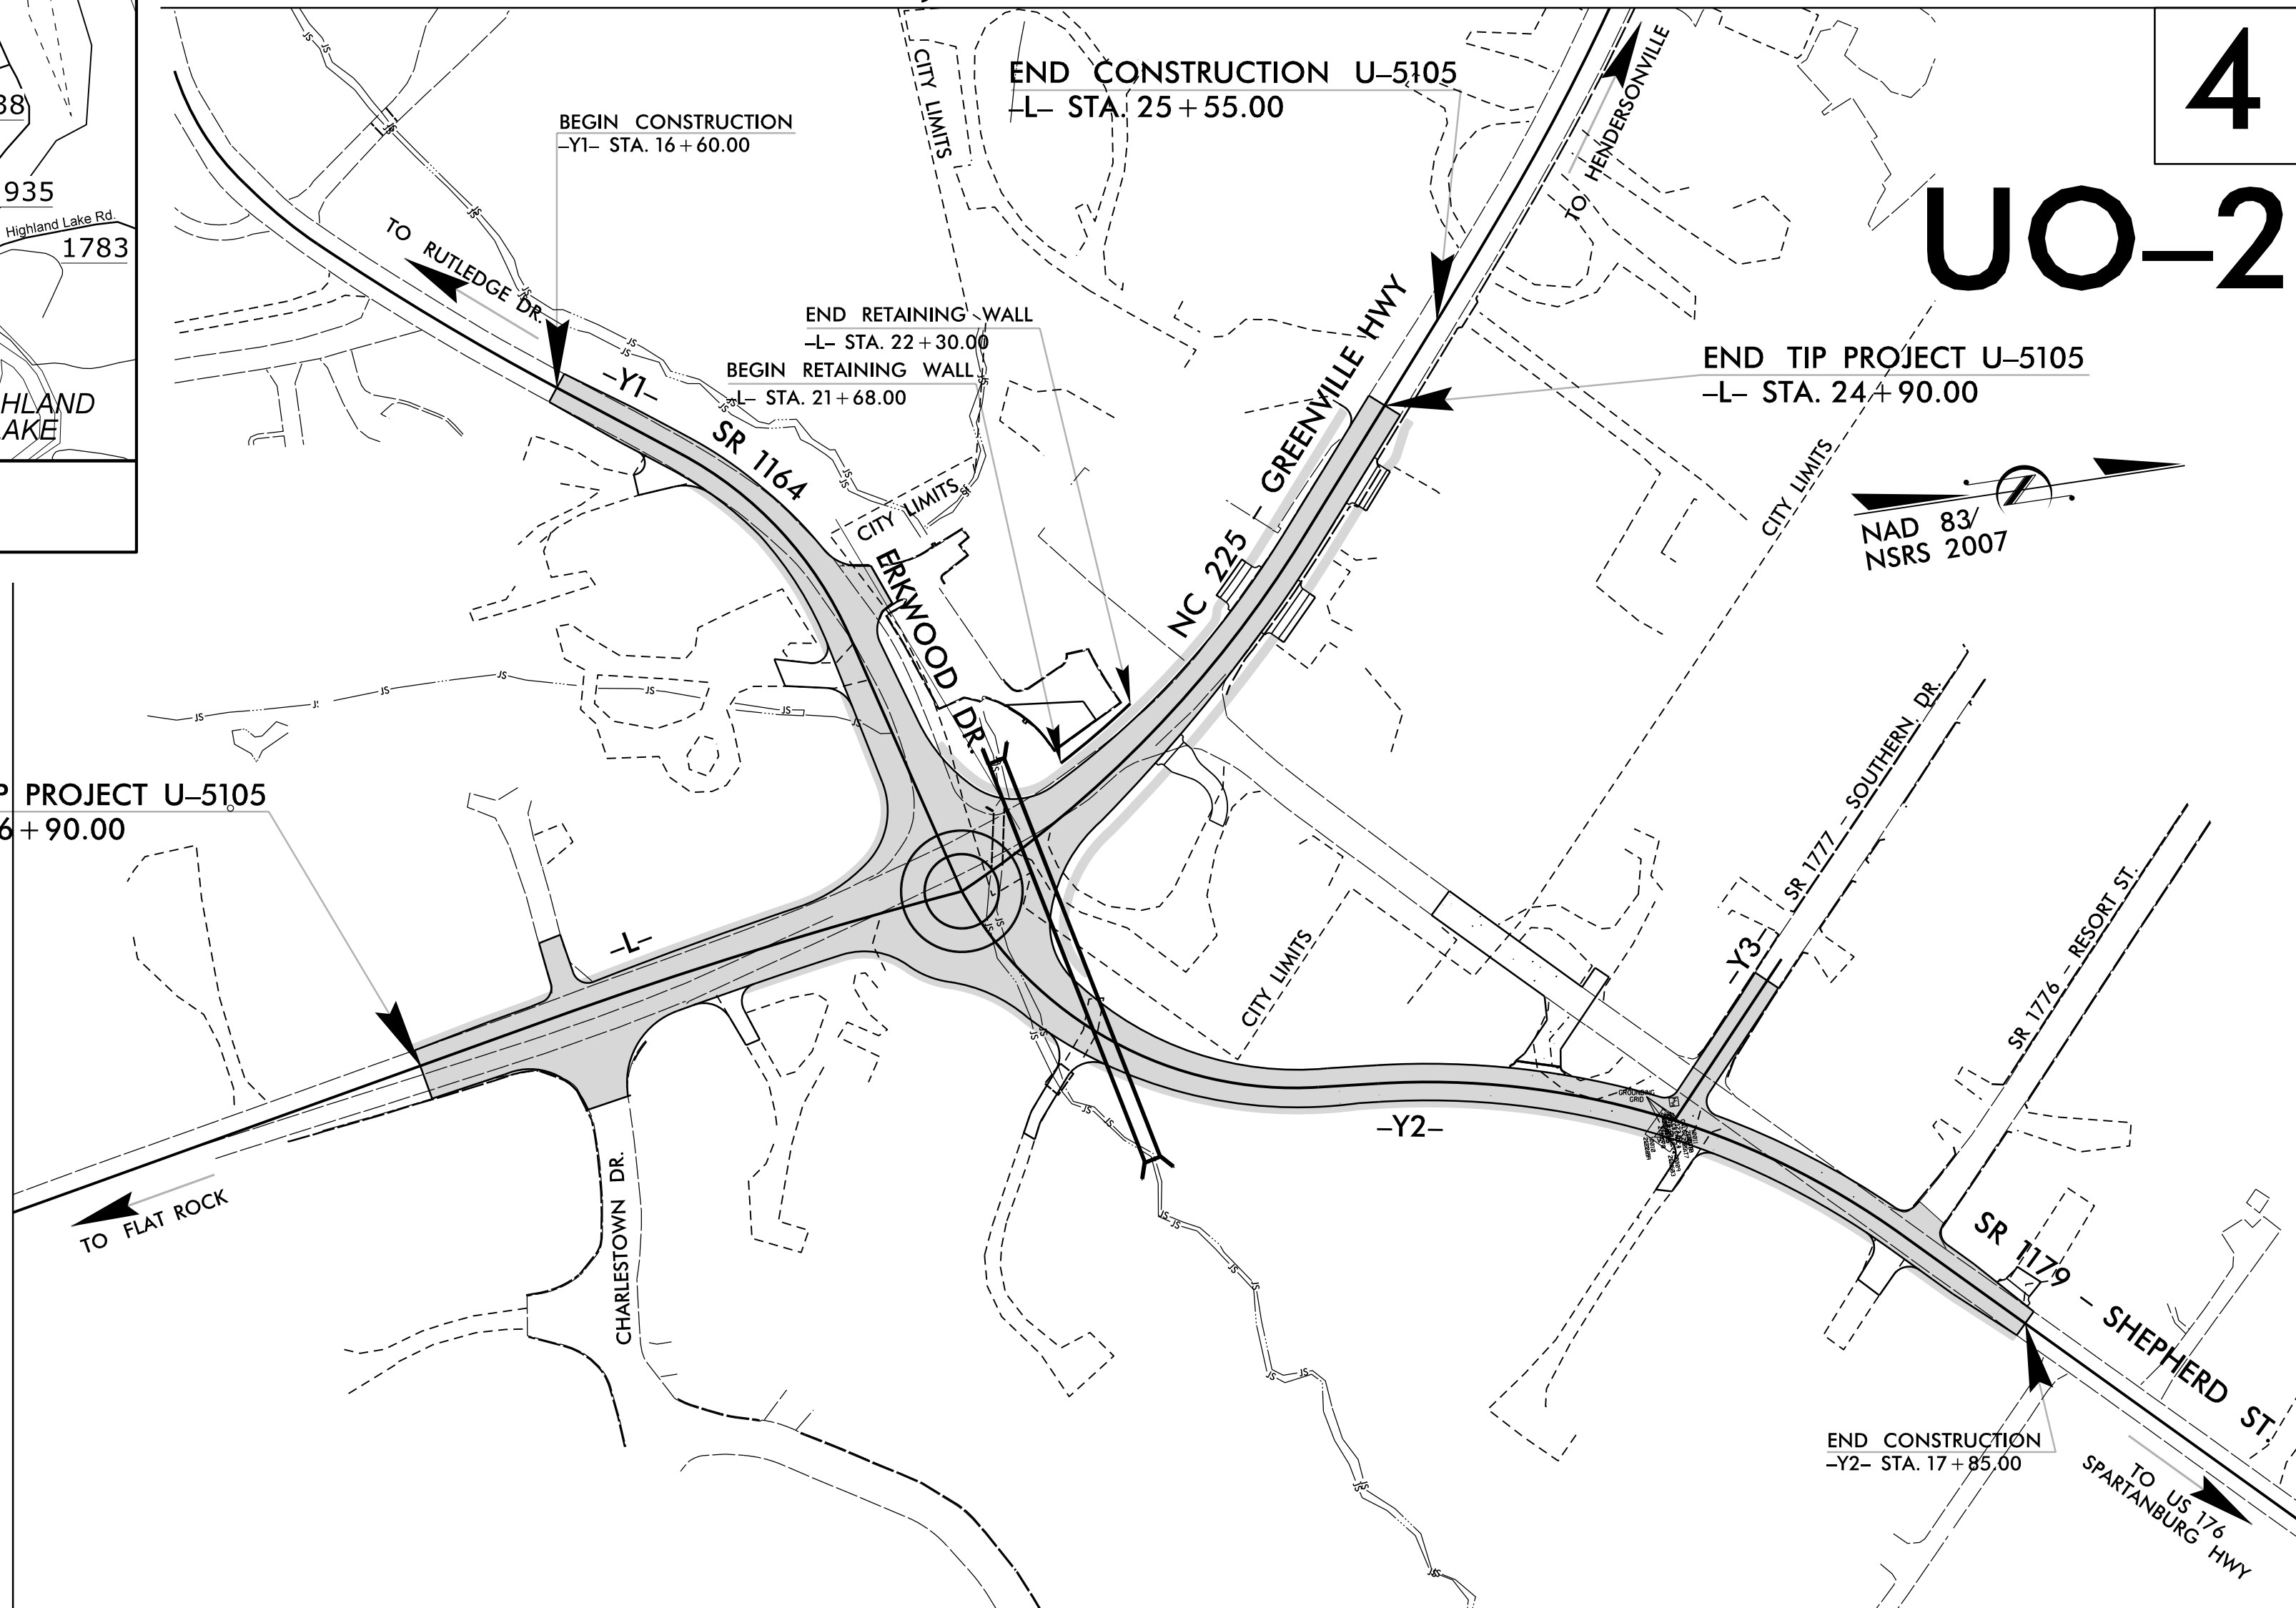

4
UO-2

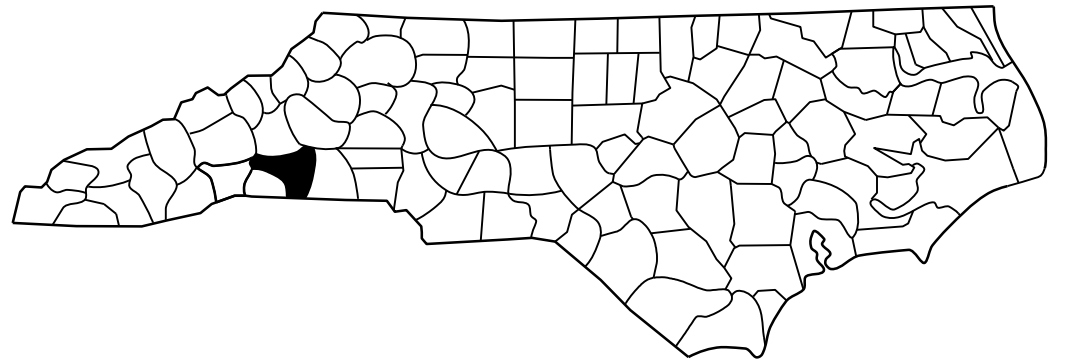

NOTE:
ALL UTILITY WORK SHOWN ON THIS SHEET IS DONE BY OTHERS.
NO PAYMENT WILL BE MADE TO THE CONTRACTOR FOR UTILITY WORK SHOWN ON THIS SHEET.

DOCUMENT NOT CONSIDERED FINAL
UNLESS ALL SIGNATURES COMPLETED

PREPARED IN THE OFFICE OF:



License No. C-2639
7520 E. Independence Blvd., Suite 220 Charlotte, NC 28227
(704) 814-4407

Michael E. Davis UTILITY COORDINATION PROJECT MANAGER
Todd E. Butner PROJECT UTILITY COORDINATOR
James N. Arnold PROJECT UTILITY DESIGNER



DIVISION OF HIGHWAYS
UTILITIES UNIT
1555 MAIL SERVICES CENTER
RALEIGH NC 27699-1555
PHONE (919) 707-6690
FAX (919) 250-4151

Ted Adams DIVISION CONTACT #1
Bob Golding DIVISION CONTACT #2
Mitchell Bishop DIVISION CONTACT #3
Steve Cannon, PE DIVISION CONTACT #4

UTILITIES BY OTHERS

NOTE:
ALL UTILITY WORK SHOWN ON THIS SHEET WILL BE DONE BY OTHERS. NO PAYMENT WILL BE MADE TO THE CONTRACTOR FOR UTILITY WORK SHOWN ON THIS SHEET.

