

9/17/2025
S:\DDC\Dist3\Warren\FUNDED TIP\HS-20050\Roadway\Proj\ORD\HS20050_sgn_SIGNL.dgn
User:vmchavez

09/08/99

CONTRACT: DE00406

TIP PROJECT: HS-20050


STATE OF NORTH CAROLINA
DIVISION OF HIGHWAYS

STATE	STATE PROJECT REFERENCE NO.	SHEET NO.
N.C.	HS-20050	SIGN-1

SIGNING PLANS

WARREN COUNTY

LOCATION: US 1 -158 AT SR 1237 (MANSON DREWRY ROAD)

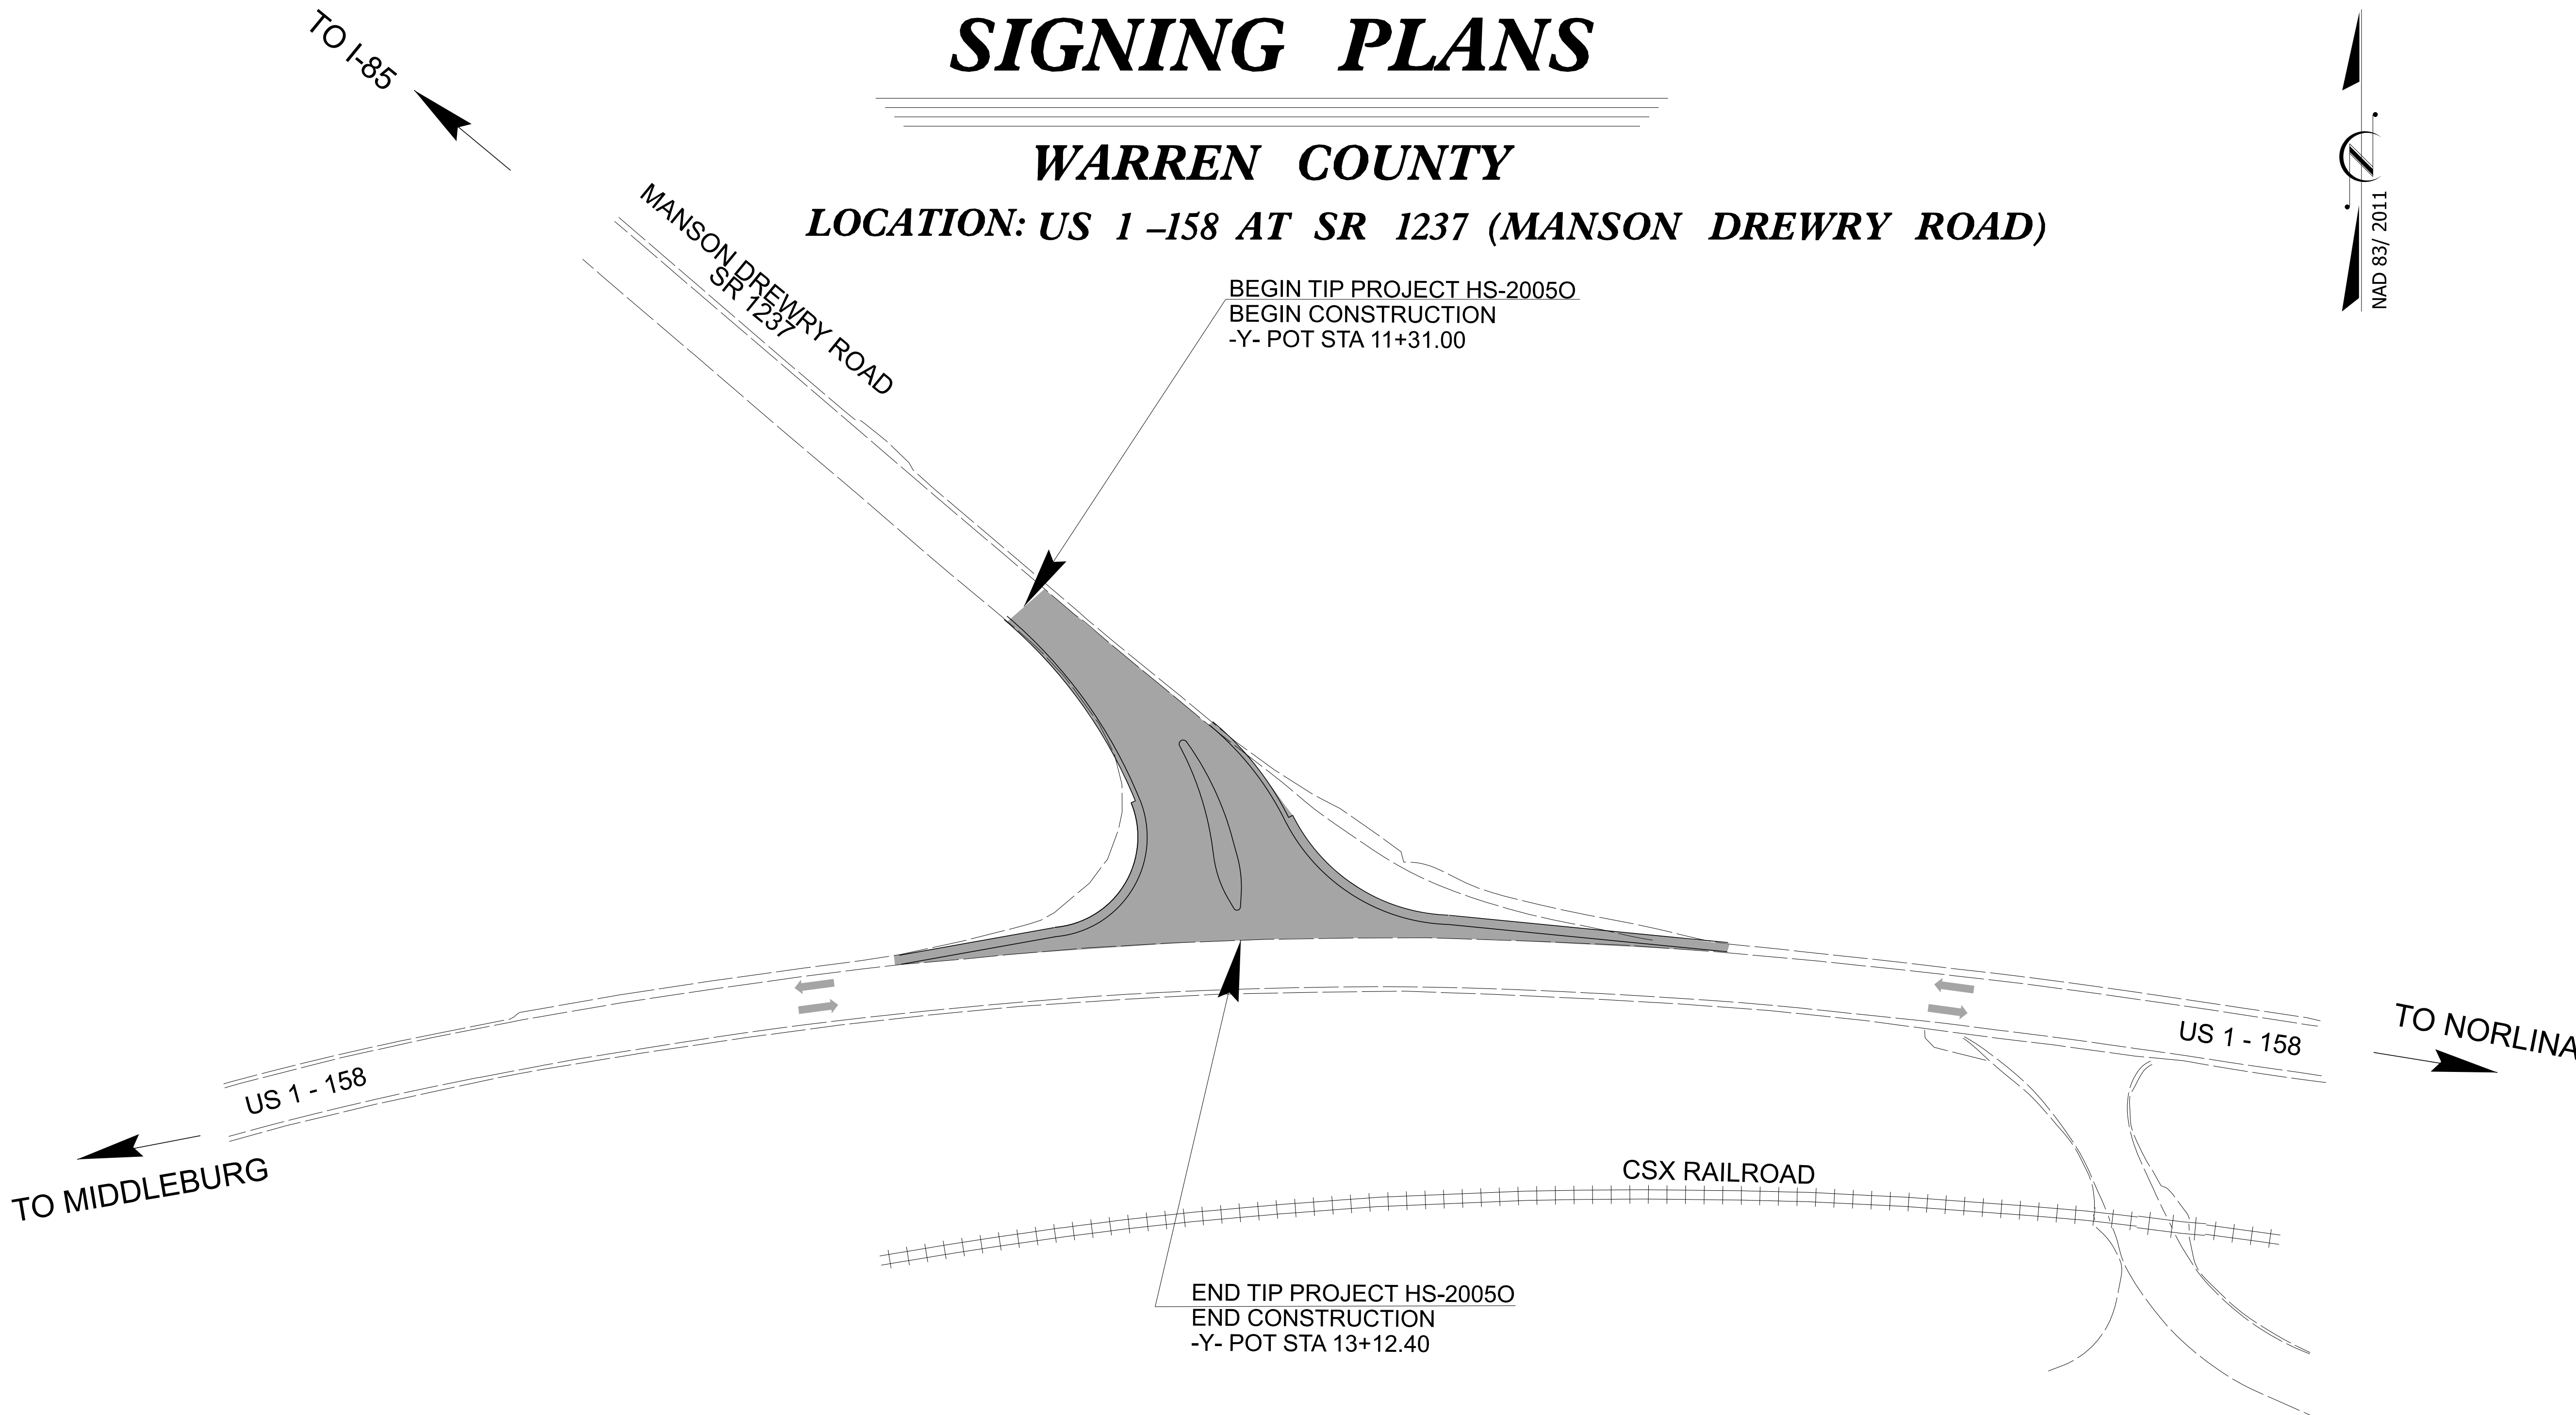

INDEX OF SHEETS

SHEET NO.	DESCRIPTION
1	TITLE SHEET
2	TYPE E AND F SIGN DESIGNS
3	SIGN ROADWAY SHEET

Prepared in the Office of:
DIVISION DESIGN & CONSTRUCTION
815 Stadium Dr., Durham NC, 27704

2024 STANDARD SPECIFICATIONS

VICTOR M. CHAVEZ, PE
PROJECT ENGINEER

VICTOR M. CHAVEZ, PE
PROJECT DESIGN ENGINEER

**DIVISION FIVE DESIGN
& CONSTRUCTION ENGINEER**



**DIVISION OF HIGHWAYS
STATE OF NORTH CAROLINA**
FIFTH DIVISION
B. J. GALLAS, P.E.
DIVISION ENGINEER

