

09/08/99



STATE OF NORTH CAROLINA  
DIVISION OF HIGHWAYS

STATE	STATE PROJECT REFERENCE NO.	SHEET NO.	TOTAL SHEETS
N.C.		1	


**FORSYTH COUNTY**

LOCATION: US 421 NORTH AND SOUTHBOUND FROM M.M. 240  
TO THE YADKIN RIVER

TYPE OF WORK: TREE TRIMMING

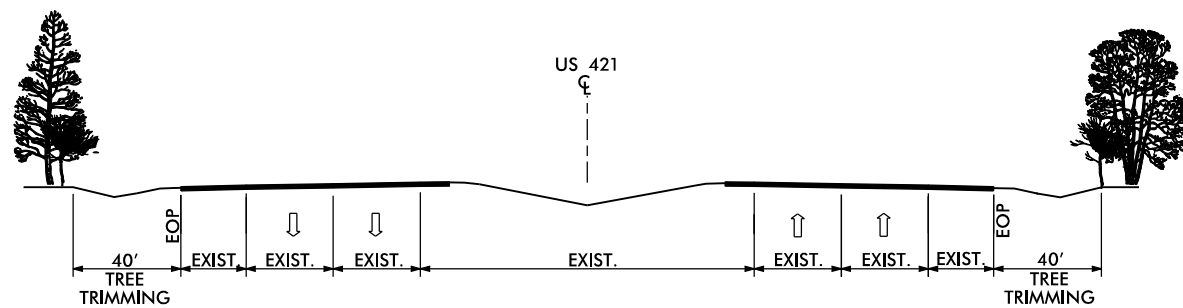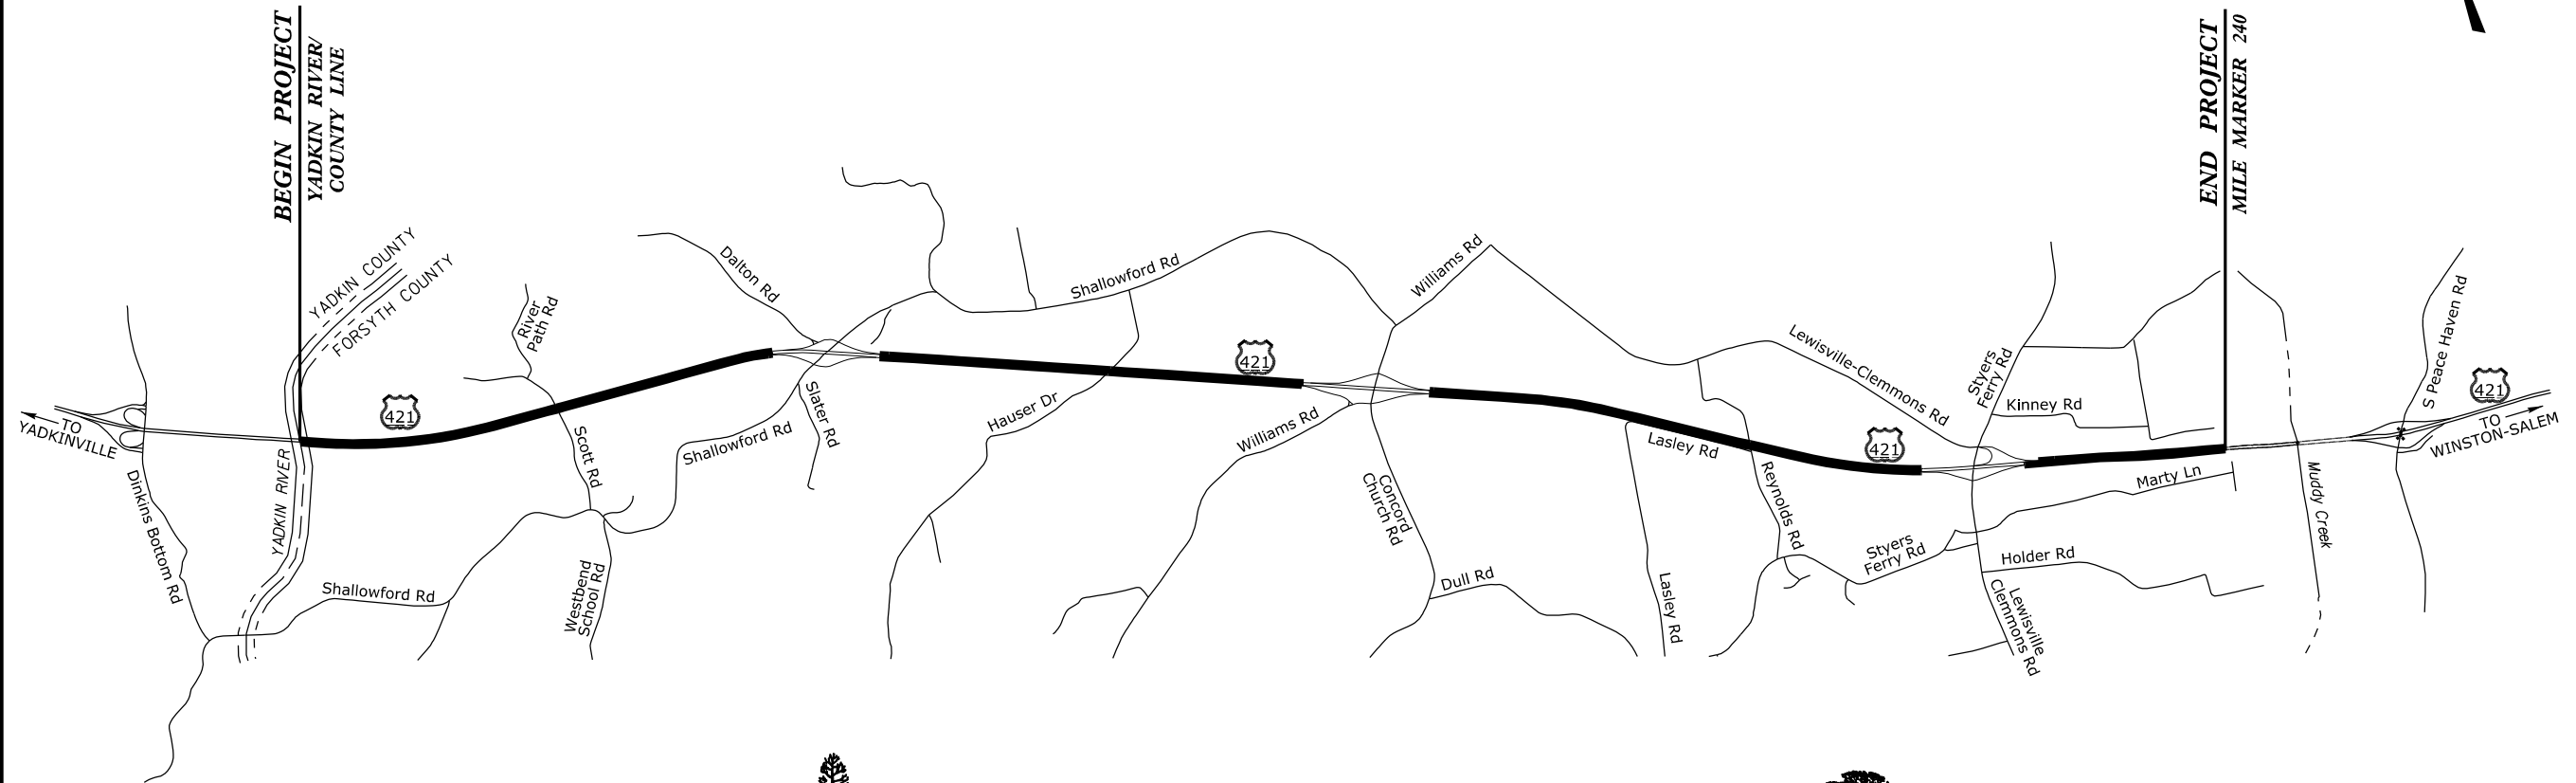

02-NOV-2022 15:55  
S:\DDC\2022\_US421\_TreeTrimming\US421\_TreeTrimming.dgn  
jlkedton AT DIV09-319214

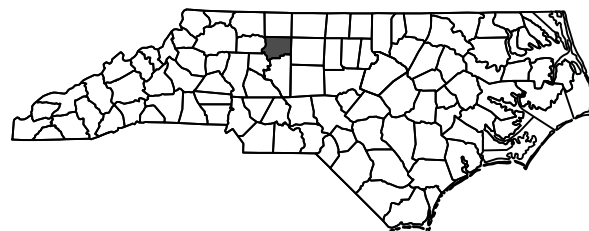

**PROJECT LENGTH**

LENGTH ROADWAY NORTH = 6.78 MILES +/-  
 LENGTH ROADWAY SOUTH = 6.79 MILES +/-  
 TOTAL LENGTH TIP PROJECT = 13.57 MILES +/-

Prepared In the Office of:  
**DIVISION OF HIGHWAYS**  
 375 SILAS CREEK PKWY., WINSTON-SALEM 27127  
 2018 STANDARD SPECIFICATIONS

