

**This electronic collection of documents is provided
for the convenience of the user
and is Not a Certified Document –**

**The documents contained herein were originally issued
and sealed by the individuals whose names and license
numbers appear on each page, on the dates appearing
with their signature on that page.**


**This file or an individual page
shall not be considered a certified document.**

STATE	STATE PROJECT REFERENCE NO.	SHEET NO.	TOTAL SHEETS
N.C.	C-5600K	1	40
STATE PROJ. NO.	F.A. PROJ. NO.	DESCRIPTION	
50061.1.12		PE	

NORTH CAROLINA
DEPARTMENT OF TRANSPORTATION

PLANS FOR PROPOSED
I-85 INTEGRATED CORRIDOR MANAGEMENT SYSTEM

TYPE OF WORK: INTEGRATION OF TRAFFIC MANAGEMENT SOFTWARE FOR FREEWAY
AND ARTERIAL CORRIDORS; INSTALLATION OF CHANGEABLE TRAILBLAZER
SIGNS; EXPANSION OF REGIONAL CCTV MONITORING AND DMS SYSTEMS

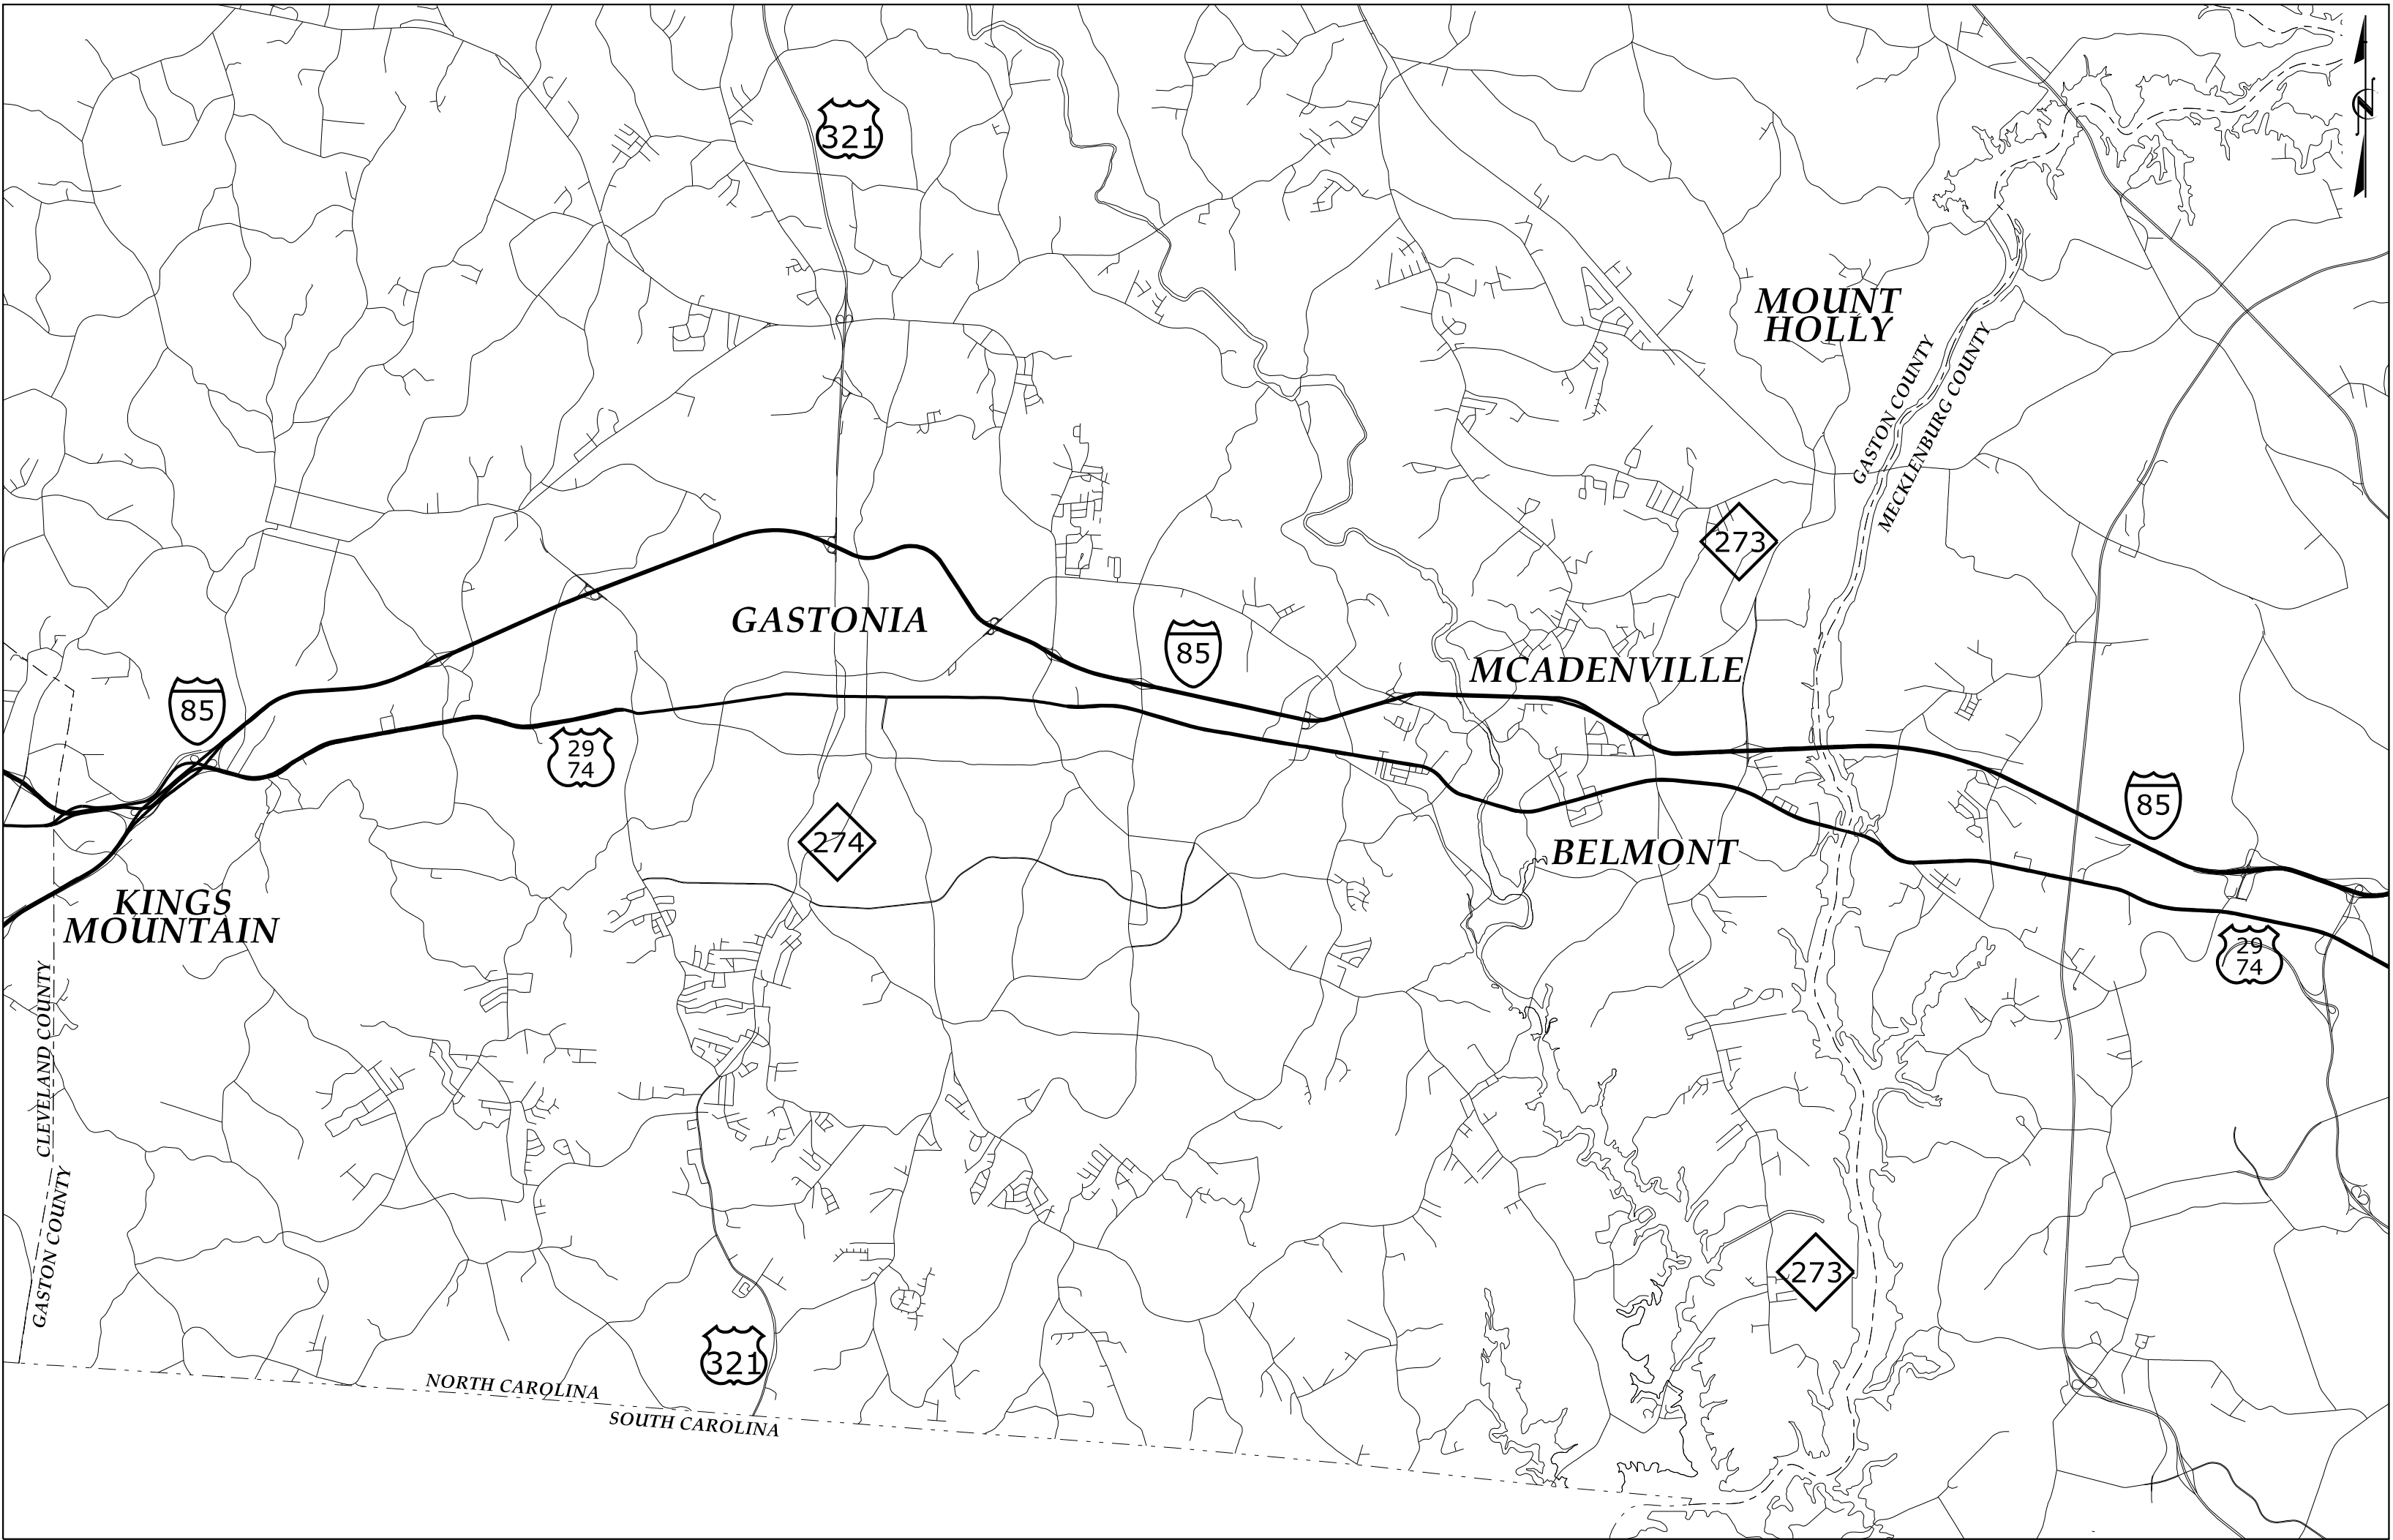


TIP PROJECT: C-5600K

CONTRACT:

2018 STANDARD SPECIFICATIONS

LETTING DATE:

PROJECT LENGTH = 23 MILES

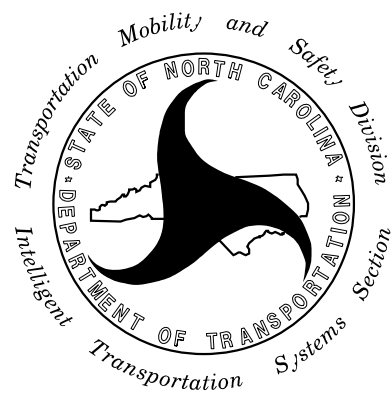


750 Greenfield Pkwy., Garner, NC 27529
NCDOT CONTACTS:
TRANSPORTATION SAFETY AND MOBILITY
INTELLIGENT TRANSPORTATION SYSTEMS SECTION
MEREDITH MCDIARMID, P.E. - STATE ITS AND SIGNALS ENGINEER

PLANS PREPARED BY: **Kimley»Horn**

NC License #F-0102
P.O. Box 33068
Raleigh, NC 27636
Tel: (919) 677-2000
Fax: (919) 677-2050

KIMLEY-HORN CONTACTS: AMANDA GOOD - PROJECT MANAGER
KEVIN W. SMITH, P.E. - PROJECT ENGINEER

SEAL

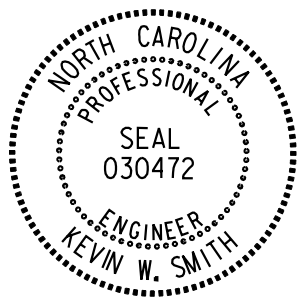

DocuSigned by:
Kevin Smith
0686ED483B0440F

SIGNATURE

3/26/2019

DATE

INDEX OF SHEETS

1.....	TITLE SHEET
2.....	INDEX OF SHEETS, AND ROADWAY STANDARD DRAWINGS
3-4.....	PLAN KEY
5.....	JUNCTION BOX AND EQUIPMENT CABINET DETAILS
6-7.....	DYNAMIC MESSAGE SIGN DETAILS
8-10.....	CCTV CAMERA DETAILS
11.....	CHANGEABLE TRAILBLAZER SIGN DETAIL
12.....	BLOCK DIAGRAM
13-31.....	SIGNING AND DEVICE PLANS
32-40.....	SPLICE DETAILS

ROADWAY STANDARD DRAWINGS

THE FOLLOWING ROADWAY STANDARDS AS APPEAR IN "ROADWAY STANDARD DRAWINGS"- ROADWAY DESIGN UNIT - N.C. DEPARTMENT OF TRANSPORTATION - RALEIGH, N.C., DATED JANUARY 2018 ARE APPLICABLE TO THIS PROJECT AND BY REFERENCE HEREBY ARE CONSIDERED A PART OF THESE PLANS:

STD. NO.	TITLE
848.01	CONCRETE SIDEWALK
1101.02	TEMPORARY LANE CLOSURES
1101.04	TEMPORARY SHOULDER CLOSURES
1700.01	ELECTRICAL SERVICE OPTIONS
1700.02	ELECTRICAL SERVICE GROUNDING
1715.01	UNDERGROUND CONDUIT
1716.01	JUNCTION BOXES
1720.01	WOOD POLES
1730.01	FIBER OPTIC CABLE
1751.01	CONTROLLERS AND CABINETS

LEGEND



— EX1 — EX1 —	EXISTING COMMUNICATIONS CABLE
- - - - -	NEW CONDUIT
— DD — DD —	NEW DIRECTIONAL DRILLED CONDUIT
— — — — —	EXISTING RIGHT OF WAY
- J - - J - - J -	EXISTING GUARDRAIL
□	NEW JUNCTION BOX
■	EXISTING JUNCTION BOX
○	NEW WOOD POLE
●	EXISTING WOOD POLE
(S x C)	EXISTING AERIAL SPLICE ENCLOSURE
⊠	EXISTING BASE-MOUNTED CABINET
⊠	NEW BASE-MOUNTED CABINET
⊠	EXISTING POLE-MOUNTED CABINET
⊠	NEW POLE-MOUNTED CABINET
▶ □	NEW CCTV ASSEMBLY
▶ ■	EXISTING CCTV ASSEMBLY
□	NEW DMS SIGN ASSEMBLY
⊥	EXISTING GROUND-MOUNTED STATIC SIGN
●	EXISTING OVERHEAD STATIC SIGN
XX-XXXX	SIGNAL INVENTORY / DEVICE NUMBER


3/25/2019
K:\RAL\TPTD\ITS\01036443 I-85 ICM\6 Tasks\3 PS&E\Plans\NC-5600.ITS_psh2.dgn



Kimley»Horn


NC License #F-0102
421 Fayetteville St., Suite 600
Raleigh, NC 27636
Tel: (919) 677-2000
Fax: (919) 677-2050

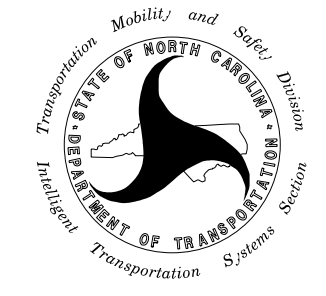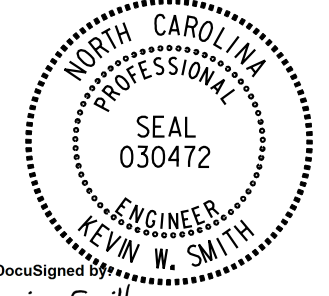Plans Prepared For:  750 N. Greenfield Place, Garner, NC 27529	I-85 INTEGRATED CORRIDOR MANAGEMENT SYSTEM INDEX OF SHEETS AND ROADWAY STANDARD DRAWINGS		SEAL  DocuSigned by Kevin W. Smith 3/26/2019
	DIVISION 10 MECKLENBURG/GASTON COUNTIES		
	PLAN DATE: MAR 2019	REVIEWED BY: A. GOOD	
	PREPARED BY: J. CROSS	REVIEWED BY: K. SMITH	
	REVISIONS		
INIT. DATE			
SIGNATURE DATE			
CADD Filename:			

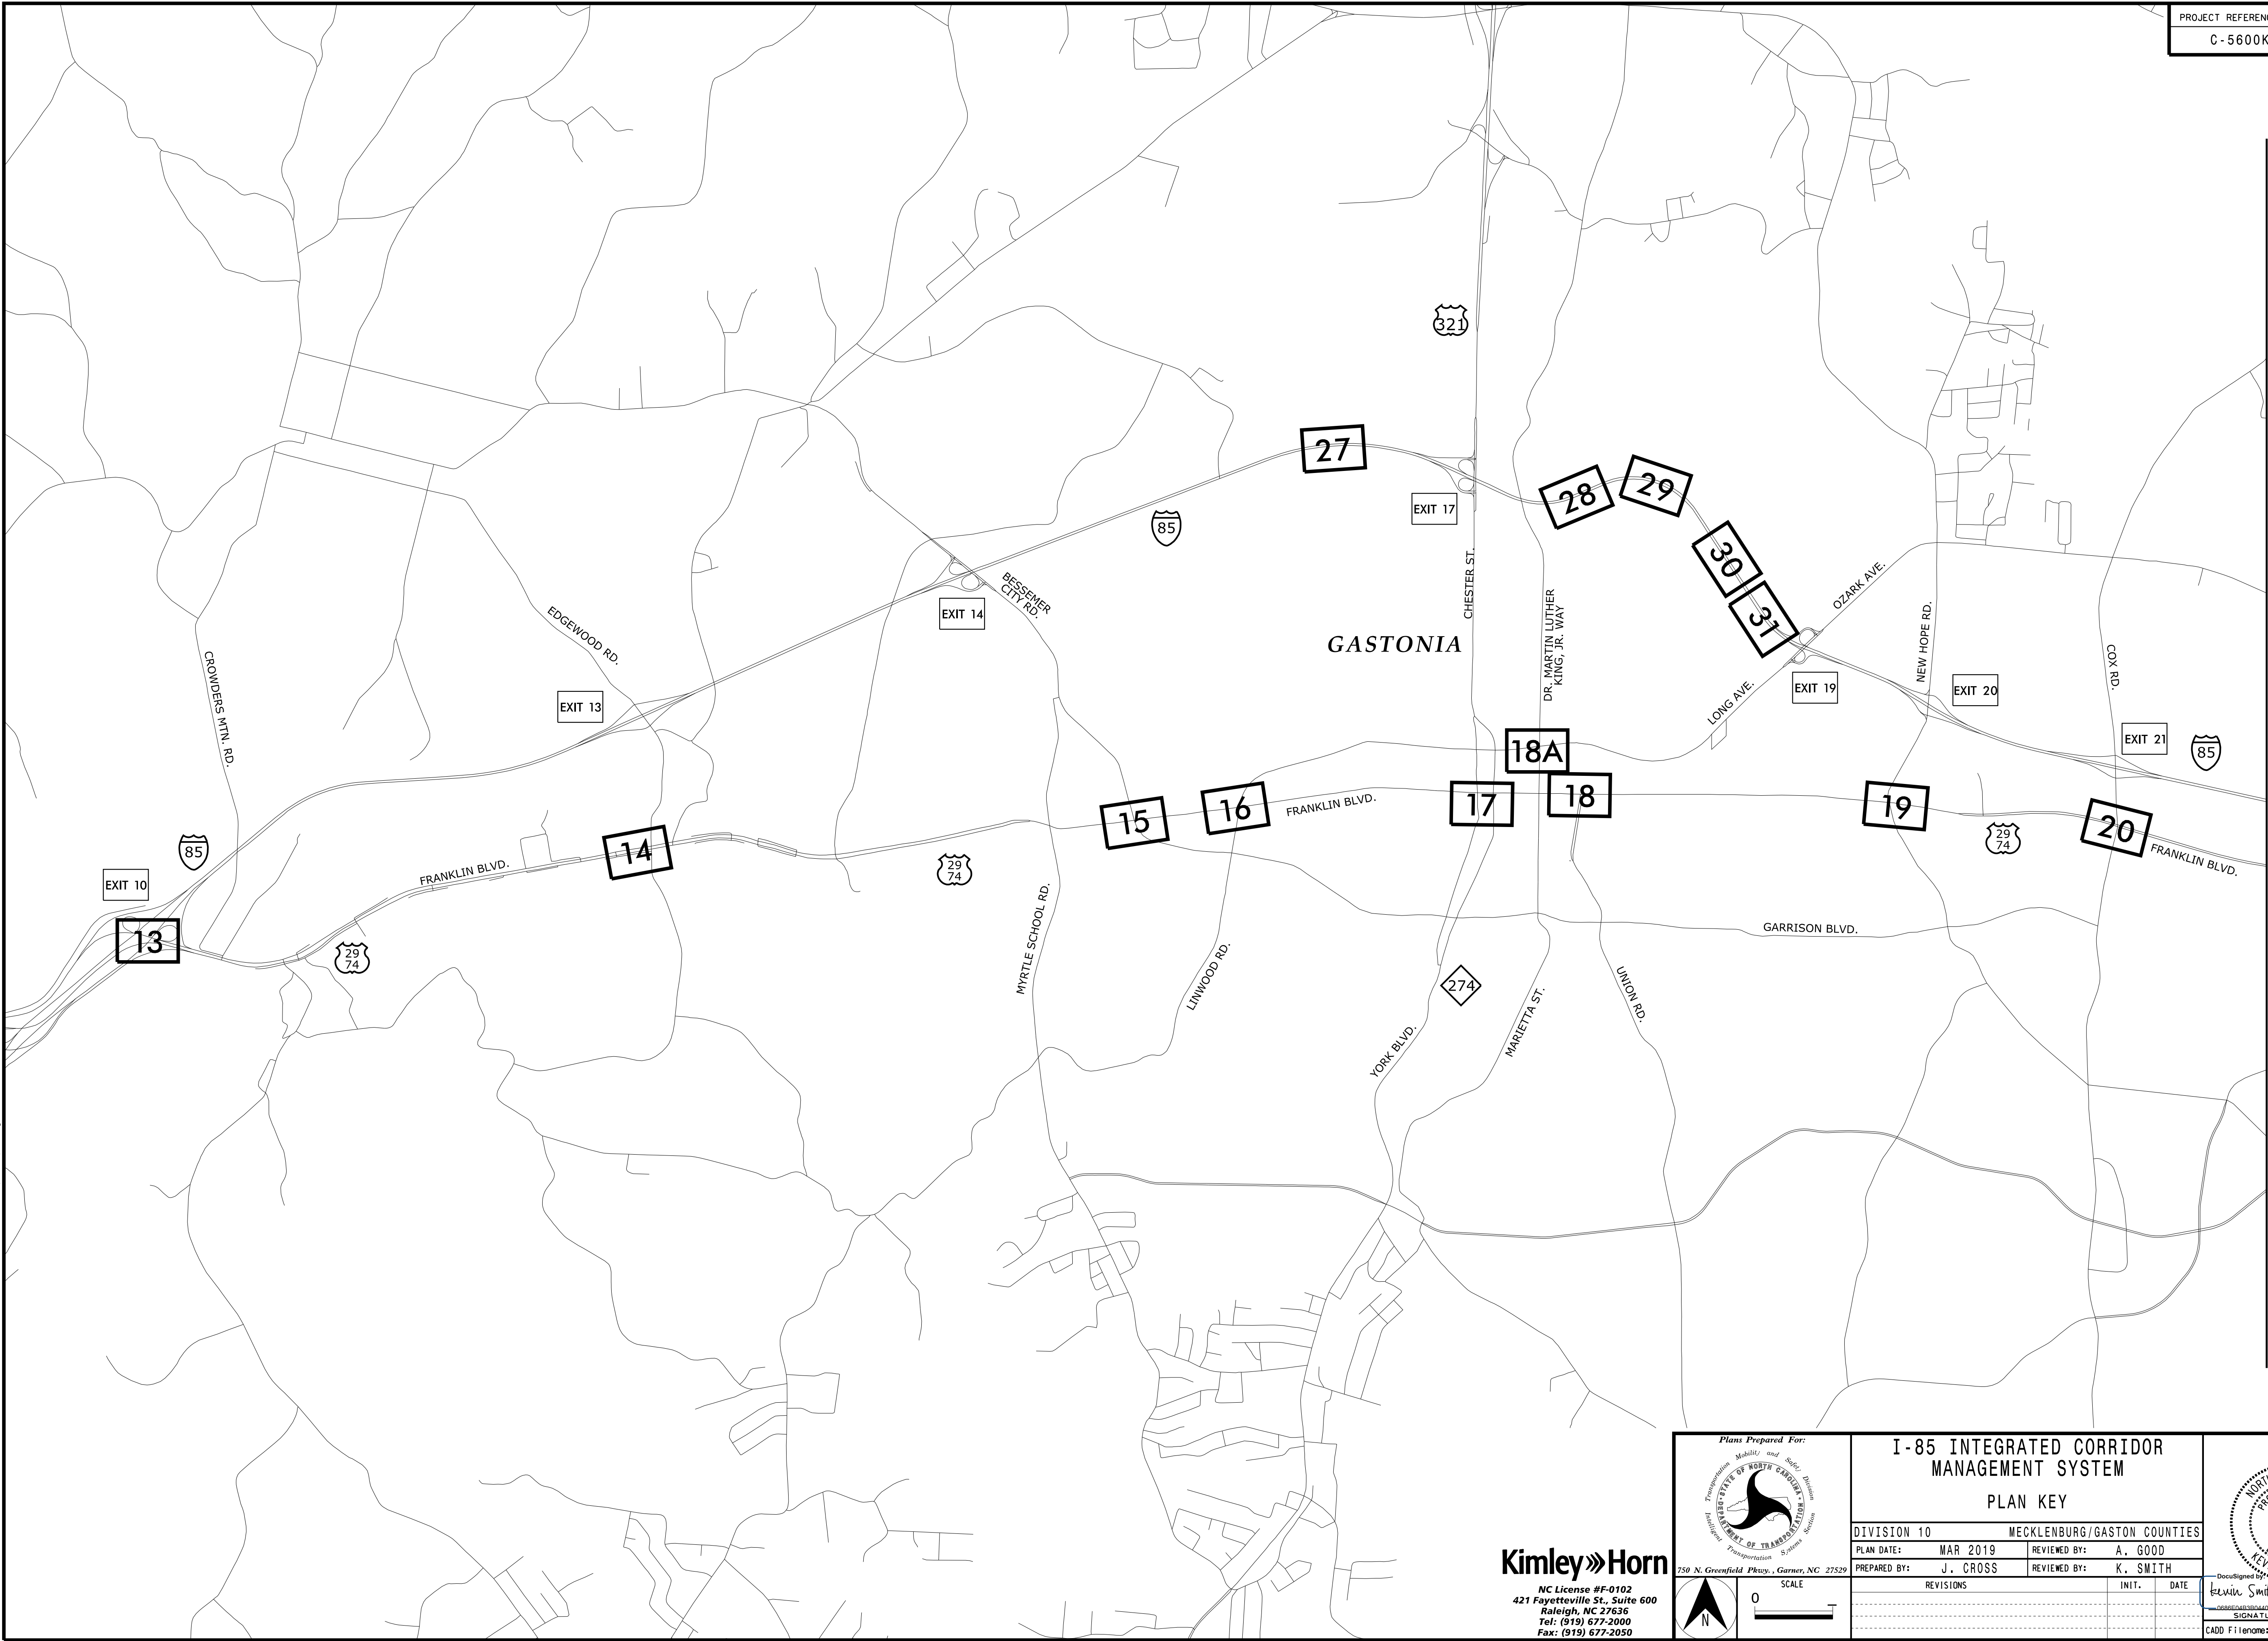

3/25/2019
K:\ARL\TPTD\ITS\01036443 I-85 ICM\6 Tasks\3 PS&E\Plans\NC-5600.ITS.psh3ipk1.dgn

Kimley»Horn
NC License #F-0102
421 Fayetteville St., Suite 600
Raleigh, NC 27636
Tel: (919) 677-2000
Fax: (919) 677-2050

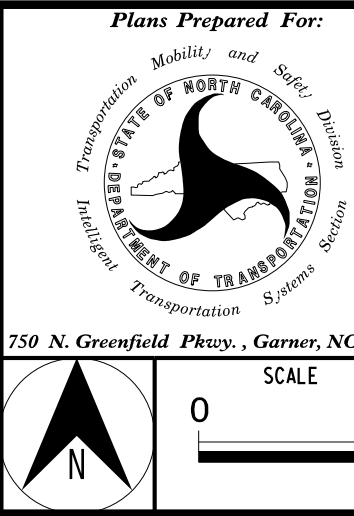


I-85 INTEGRATED CORRIDOR MANAGEMENT SYSTEM			
PLAN KEY			
DIVISION 10		MECKLENBURG/GASTON COUNTIES	
PLAN DATE:	MAR 2019	REVIEWED BY:	A. GOOD
PREPARED BY:	J. CROSS	REVIEWED BY:	K. SMITH
REVISIONS		INIT.	DATE

SEAL

DocuSigned by


3/26/2019
SIGNATURE DATE
CADD Filename:

MATCH LINE, SEE SHEET 3

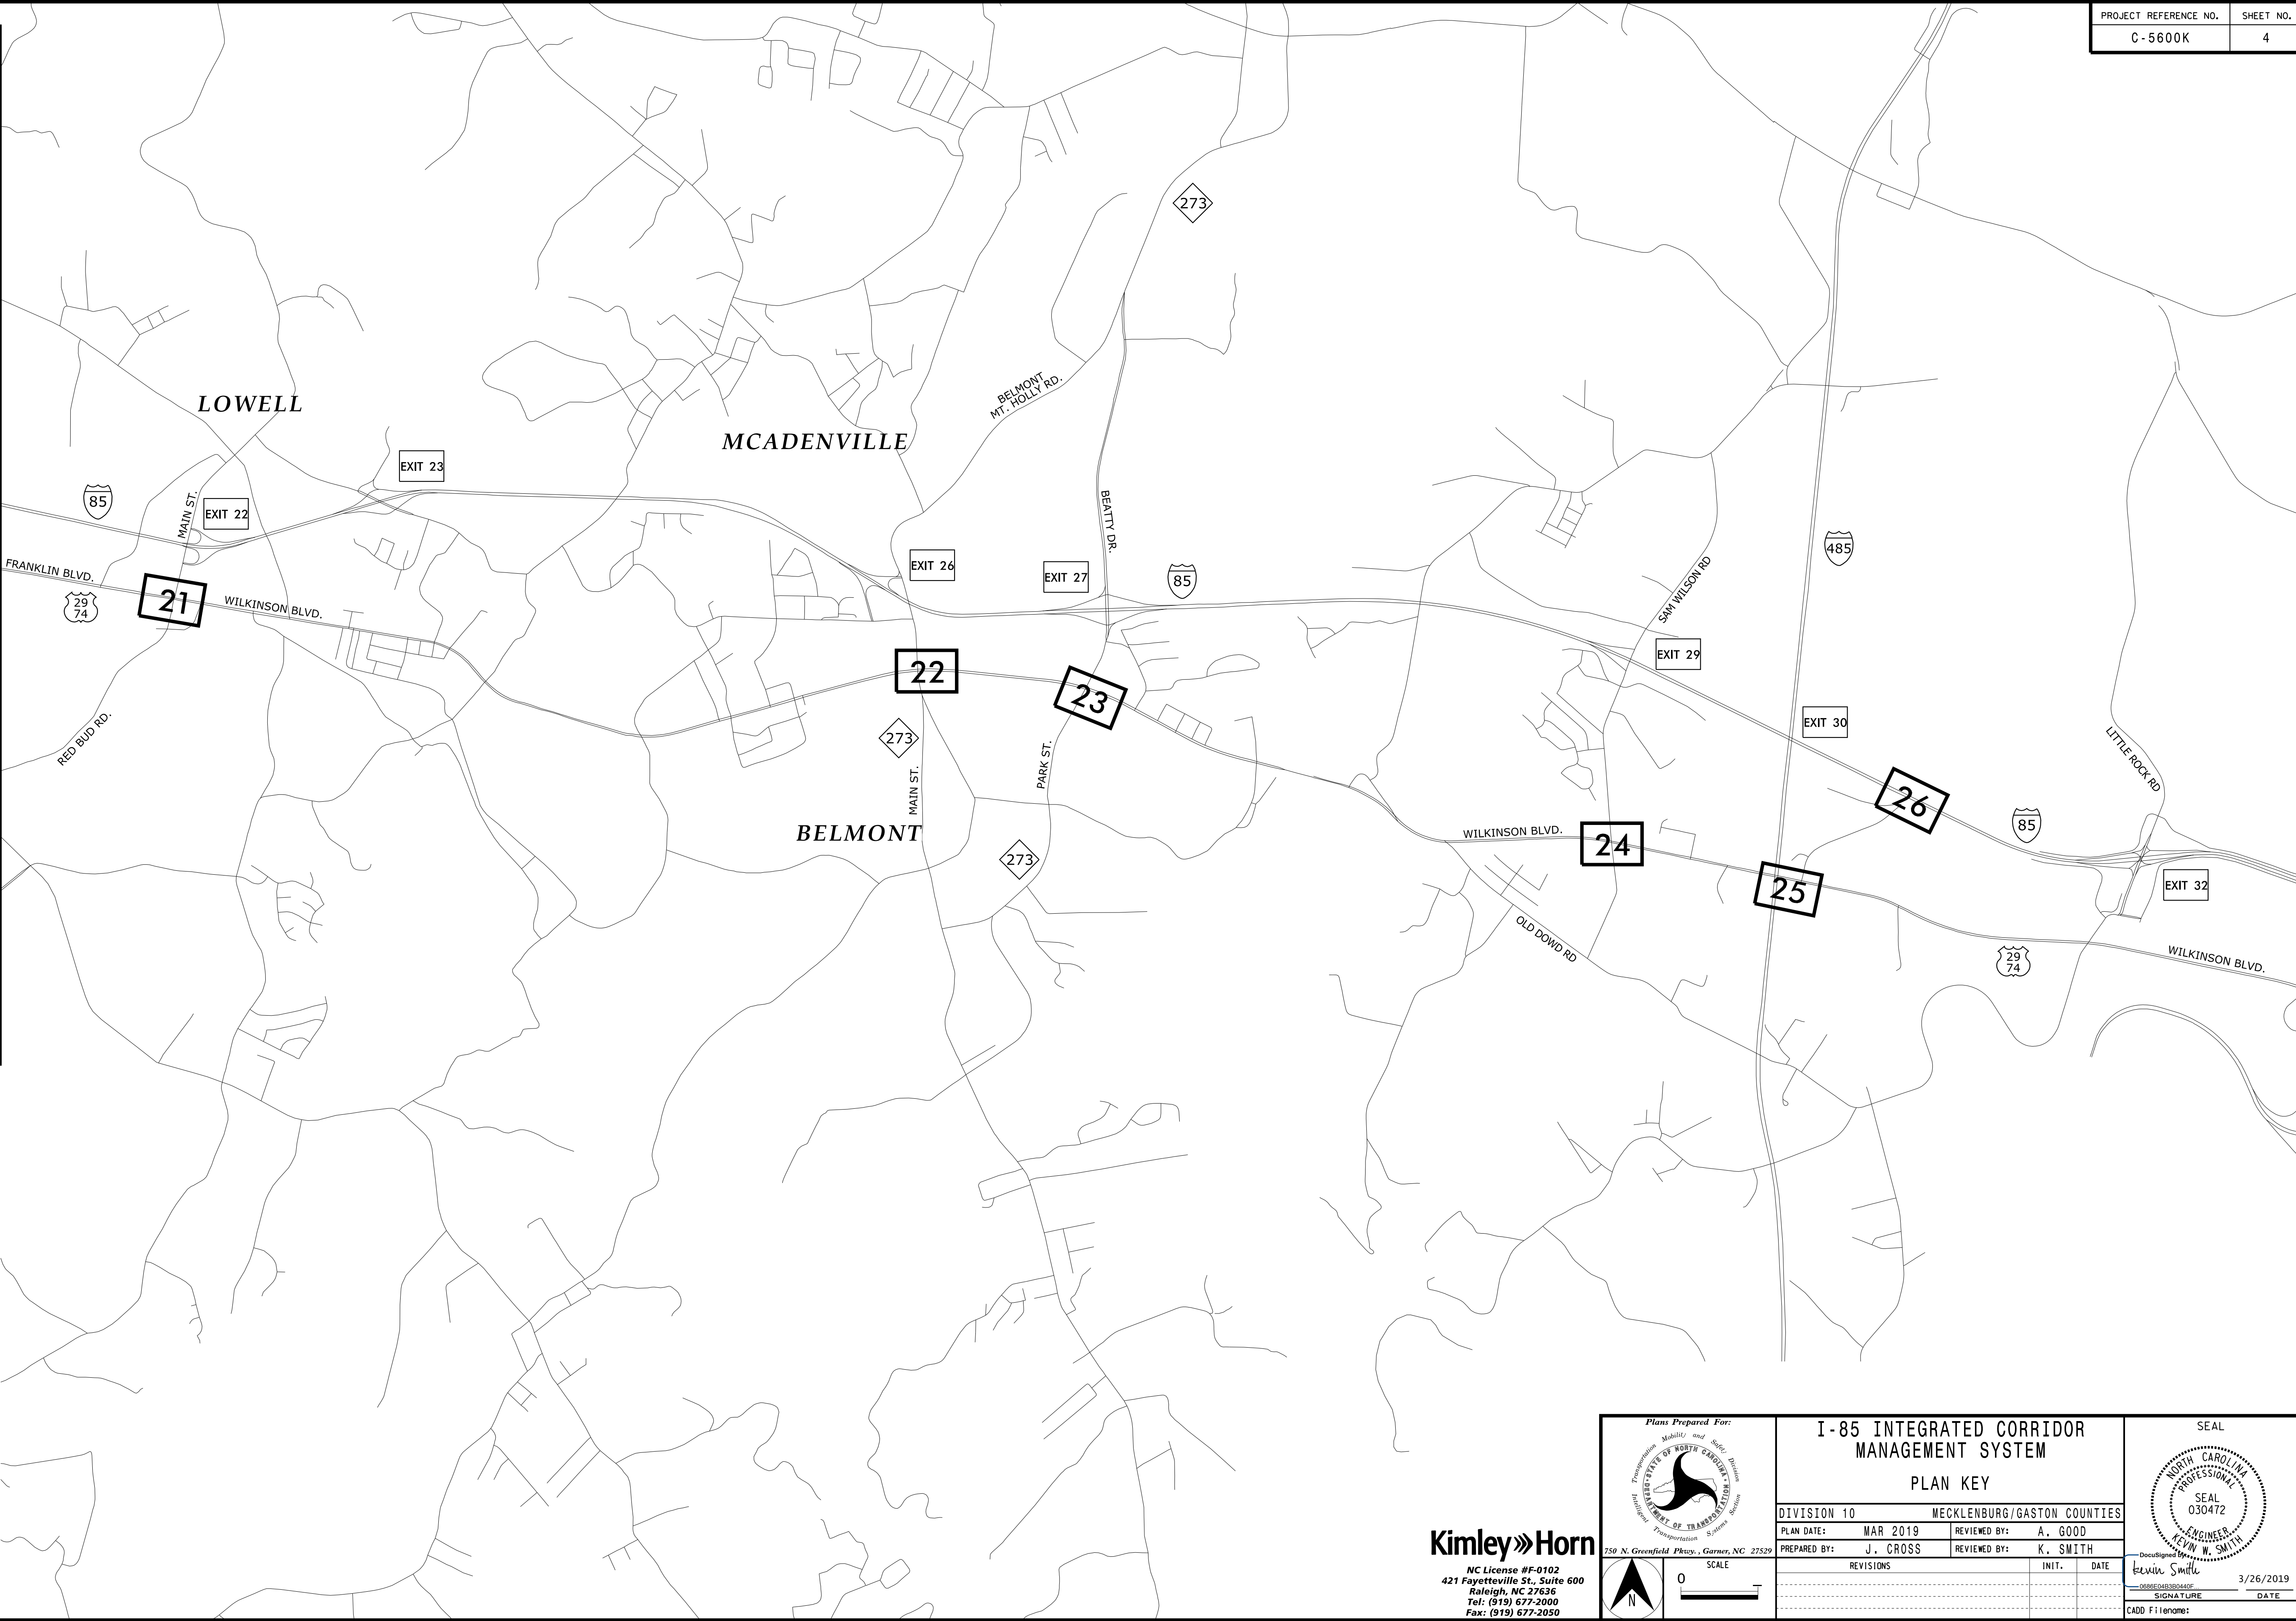

3/25/2019
K:\ARL\TPTD\ITS\01036443 I-85 ICMA6 Tasks\3 PS&E\Plans\NC-5600.ITS.psh\pk1.dgn

Kimley»Horn
NC License #F-0102
421 Fayetteville St., Suite 600
Raleigh, NC 27636
Tel: (919) 677-2000
Fax: (919) 677-2050

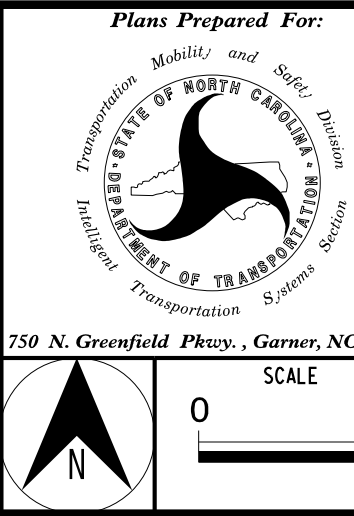

I-85 INTEGRATED CORRIDOR MANAGEMENT SYSTEM			
PLAN KEY			
DIVISION 10		MECKLENBURG/GASTON COUNTIES	
PLAN DATE:	MAR 2019	REVIEWED BY:	A. GOOD
PREPARED BY:	J. CROSS	REVIEWED BY:	K. SMITH
REVISIONS		INIT.	DATE



SEAL

DocuSigned by

3/26/2019

SIGNATURE DATE




CADD Filename:

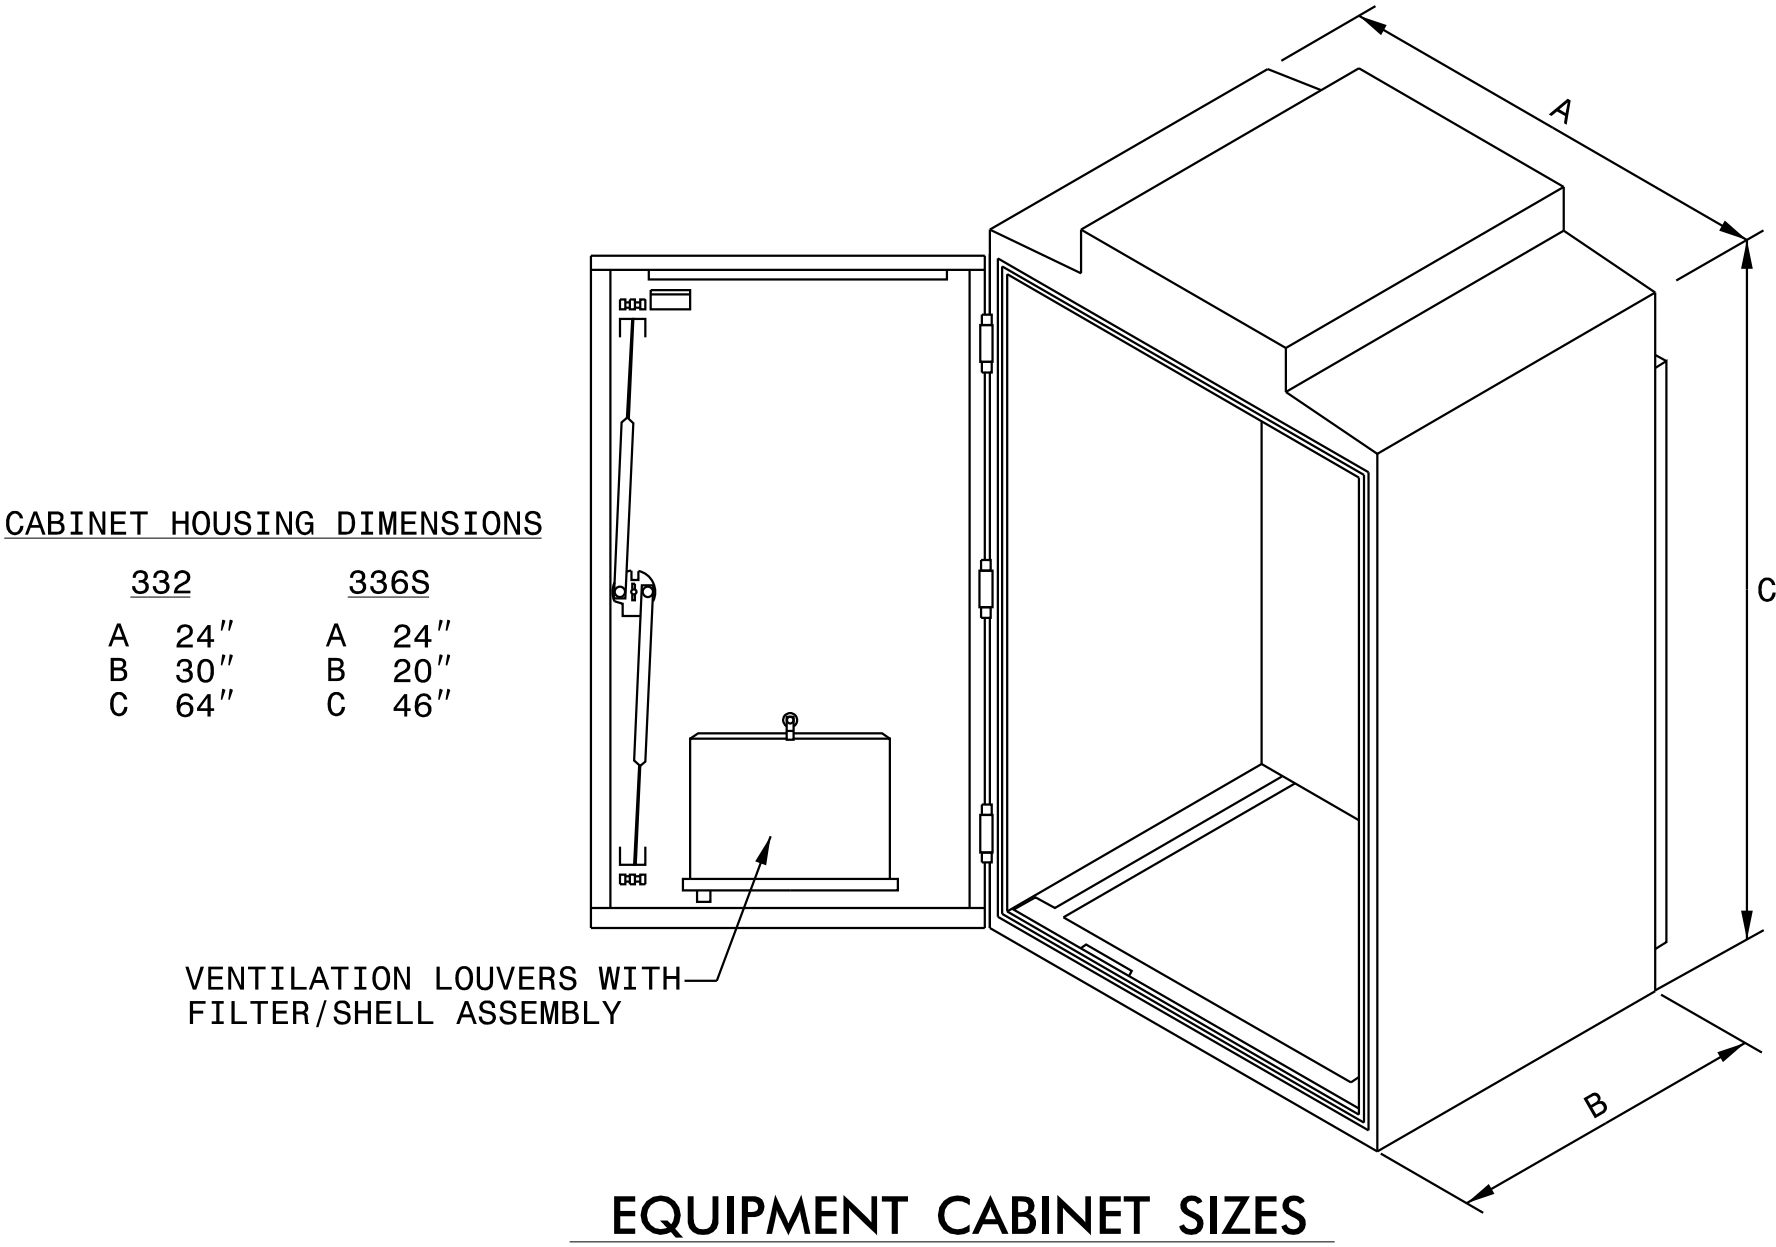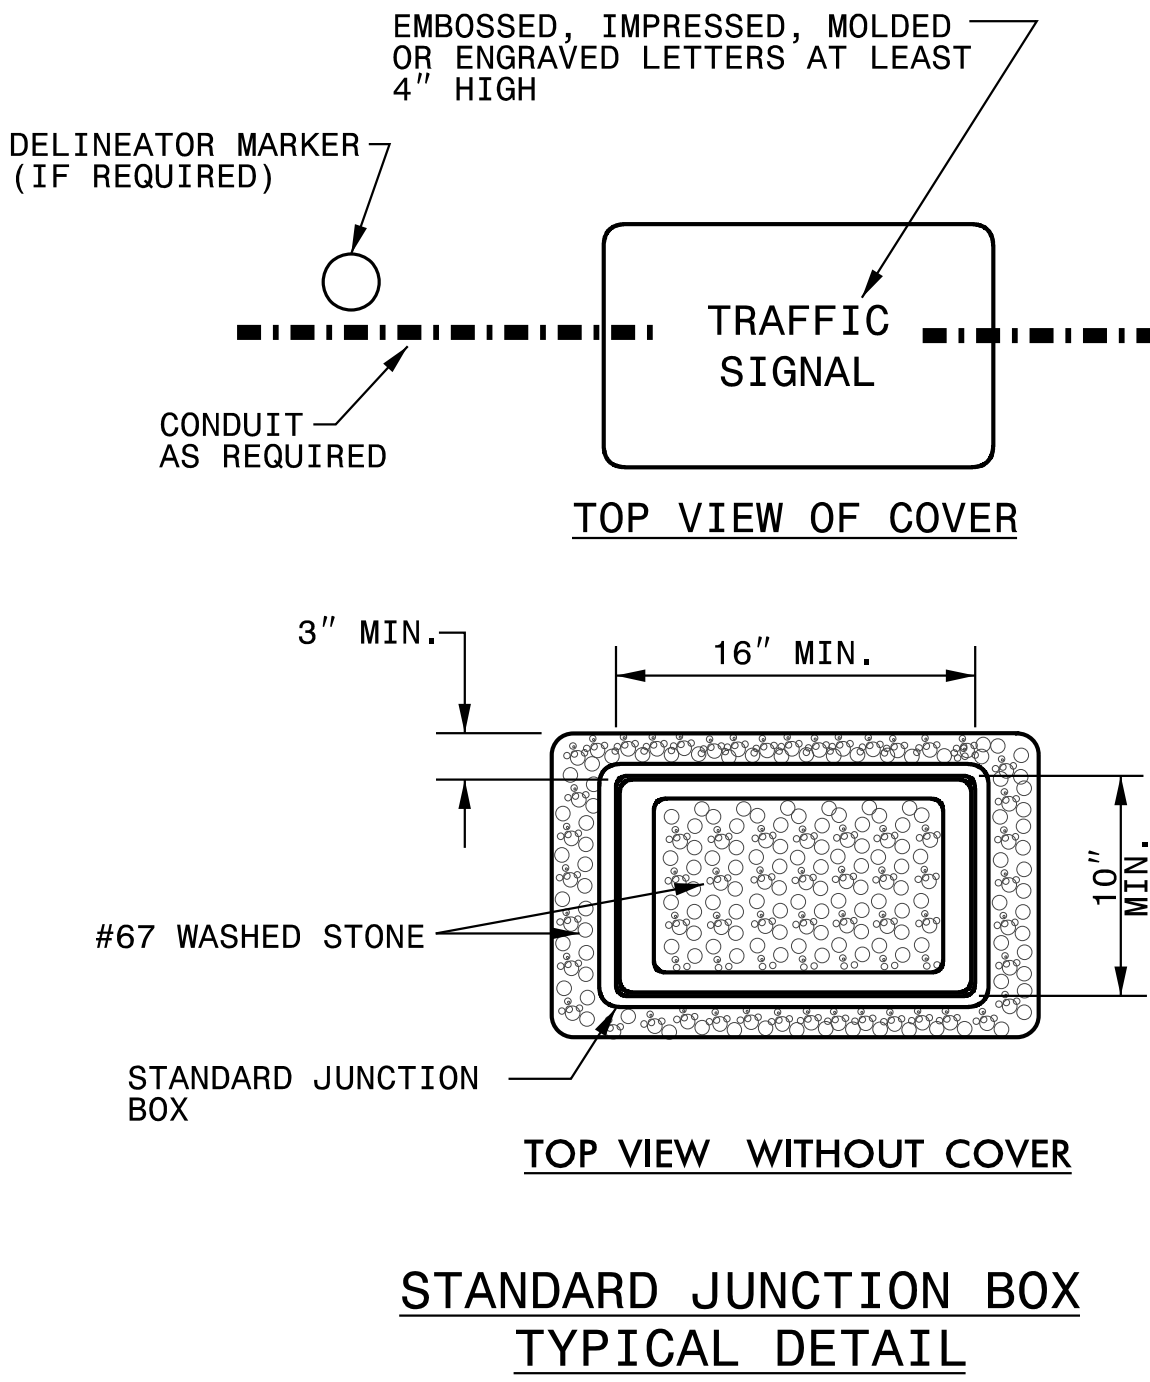


3/25/2019
K:\ARL\TPTD\ITS\01036443 I-85 ICM\6 Tasks\3 PS&E\Plans\C-5600.ITS.psh5.dgn

Kimley»Horn

 
NC License #F-0102
421 Fayetteville St., Suite 600
Raleigh, NC 27636
Tel: (919) 677-2000
Fax: (919) 677-2050

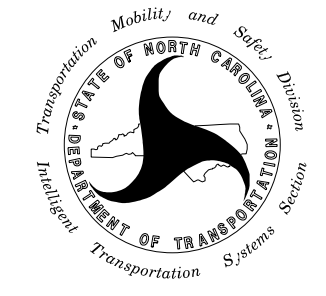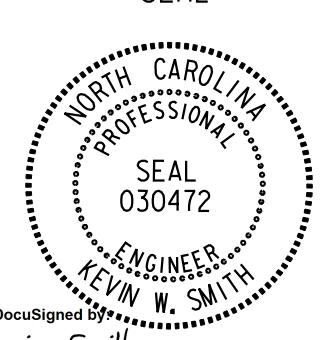Plans Prepared For:  750 N. Greenfield Plaza, Garner, NC 27529	I-85 INTEGRATED CORRIDOR MANAGEMENT SYSTEM JUNCTION BOX AND EQUIPMENT CABINET DETAILS		SEAL 		
	DIVISION 10 MECKLENBURG/GASTON COUNTIES				
	PLAN DATE: MAR 2019	REVIEWED BY: A. GOOD			
	PREPARED BY: J. CROSS	REVIEWED BY: K. SMITH			
	REVISIONS		INIT.	DATE	
				DocuSigned by  SEAL 030472 SIGNATURE DATE CADD Filename:	

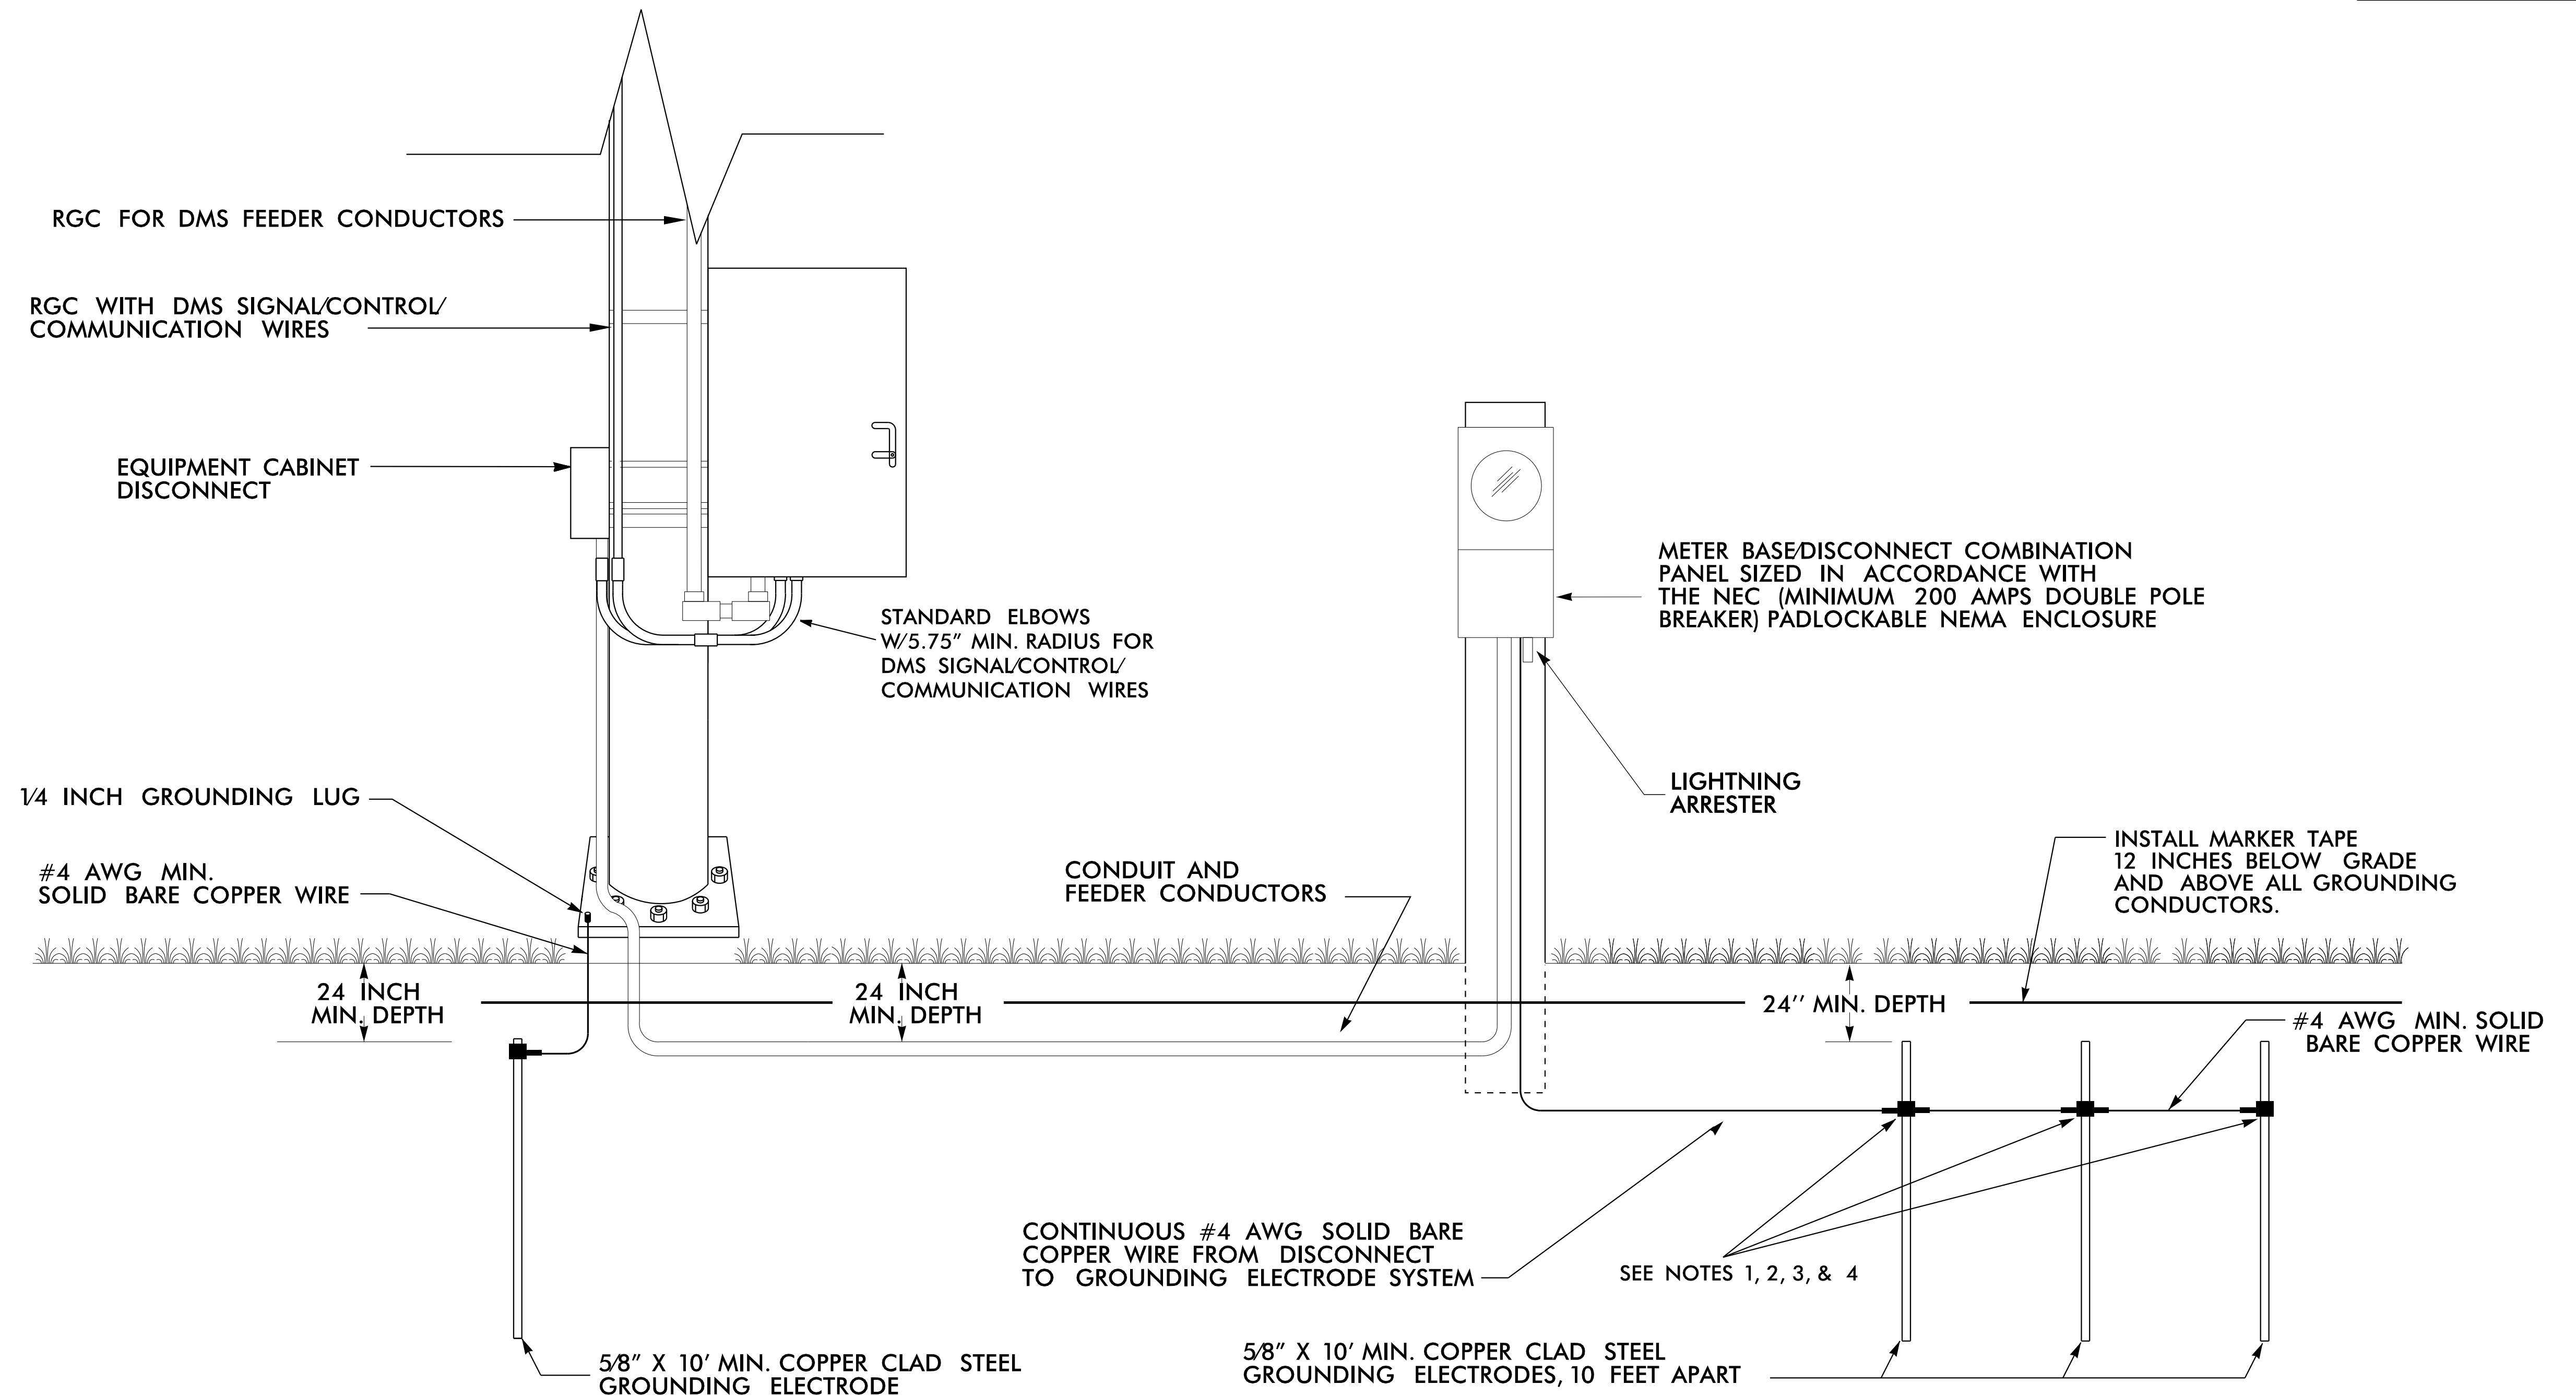





NOTES

 1. INSTALL A MINIMUM OF THREE (3) GROUNDING ELECTRODES SPACED A MINIMUM OF 10 FEET APART. ENSURE THAT EXISTING UNDERGROUND FACILITIES ARE NOT DAMAGED DURING INSTALLATION.
2. TEST GROUNDING SYSTEM USING AN APPROVED METHOD. SYSTEM SHOULD MEASURE TWENTY (20) OHMS OR LESS. ADDITIONAL GROUNDING ELECTRODES SHALL BE INSTALLED AS DIRECTED BY THE ENGINEER TO MEET THIS REQUIREMENT.
3. ALL CONNECTIONS TO GROUND RODS SHOULD BE MADE WITH AN IRREVERIBLE MECHANICAL CRIMP METHOD.
4. INSTALL MARKER TAPE DIRECTLY ABOVE ALL GROUNDING ELECTRODES AND CONDUCTORS AT A DEPTH OF 12 INCHES.
5. REMOVE BONDING JUMPER IN EQUIPMENT CABINET IF INSTALLED BETWEEN AC NEUTRAL AND EQUIPMENT GROUND.
6. BOND ALL RIGID GALVANIZED STEEL CONDUITS ENTERING THE CABINET TO "EQUIPMENT GROUND".
7. INSTALL CONDUIT BETWEEN DISCONNECT AND CABINET.
8. ENSURE EQUIPMENT GROUND IS ELECTRICALLY BONDED TO CABINET.





Plans Prepared For:  750 N. Greenfield Place, Garner, NC 27529	I-85 INTEGRATED CORRIDOR MANAGEMENT SYSTEM DYNAMIC MESSAGE SIGN WITH UNDERGROUND ELECTRICAL SERVICE	SEAL 																						
DIVISION 10 MECKLENBURG/GASTON COUNTIES																								
PLAN DATE: MAR 2019 REVIEWED BY: A. GOOD																								
PREPARED BY: J. CROSS REVIEWED BY: K. SMITH																								
SCALE 0  1"	<table border="1" style="width: 100%; border-collapse: collapse;"> <thead> <tr> <th style="width: 50%;">REVISIONS</th> <th style="width: 50%;">INIT. DATE</th> </tr> </thead> <tbody> <tr><td> </td><td> </td></tr> <tr><td> </td><td> </td></tr> <tr><td> </td><td> </td></tr> <tr><td> </td><td> </td></tr> <tr><td> </td><td> </td></tr> <tr><td> </td><td> </td></tr> <tr><td> </td><td> </td></tr> <tr><td> </td><td> </td></tr> <tr><td> </td><td> </td></tr> <tr><td> </td><td> </td></tr> </tbody> </table>	REVISIONS	INIT. DATE																					Drawn/Designed by: Kevin Smith 3/26/2019 DATE: 3/26/2019 CADD Filename: _____
REVISIONS	INIT. DATE																							



1. INSTALL A MINIMUM OF THREE (3) GROUNDING ELECTRODES SPACED A MINIMUM OF 10 FEET APART. ENSURE THAT EXISTING UNDERGROUND FACILITIES ARE NOT DAMAGED DURING INSTALLATION.
2. TEST GROUNDING SYSTEM USING AN APPROVED METHOD. SYSTEM SHOULD MEASURE TWENTY (20) OHMS OR LESS. ADDITIONAL GROUNDING ELECTRODES SHALL BE INSTALLED AS DIRECTED BY THE ENGINEER TO MEET THIS REQUIREMENT.
3. ALL CONNECTIONS TO GROUND RODS SHOULD BE MADE WITH AN IRREVERIBLE MECHANICAL CRIMP METHOD.
4. INSTALL MARKER TAPE DIRECTLY ABOVE ALL GROUNDING ELECTRODES AND CONDUCTORS AT A DEPTH OF 12 INCHES.
5. REMOVE BONDING JUMPER IN EQUIPMENT CABINET IF INSTALLED BETWEEN AC NEUTRAL AND EQUIPMENT GROUND.
6. BOND ALL RIGID GALVANIZED STEEL CONDUITS ENTERING THE CABINET TO "EQUIPMENT GROUND".
7. INSTALL CONDUIT BETWEEN DISCONNECT AND CABINET.
8. ENSURE EQUIPMENT GROUND IS ELECTRICALLY BONDED TO CABINET.

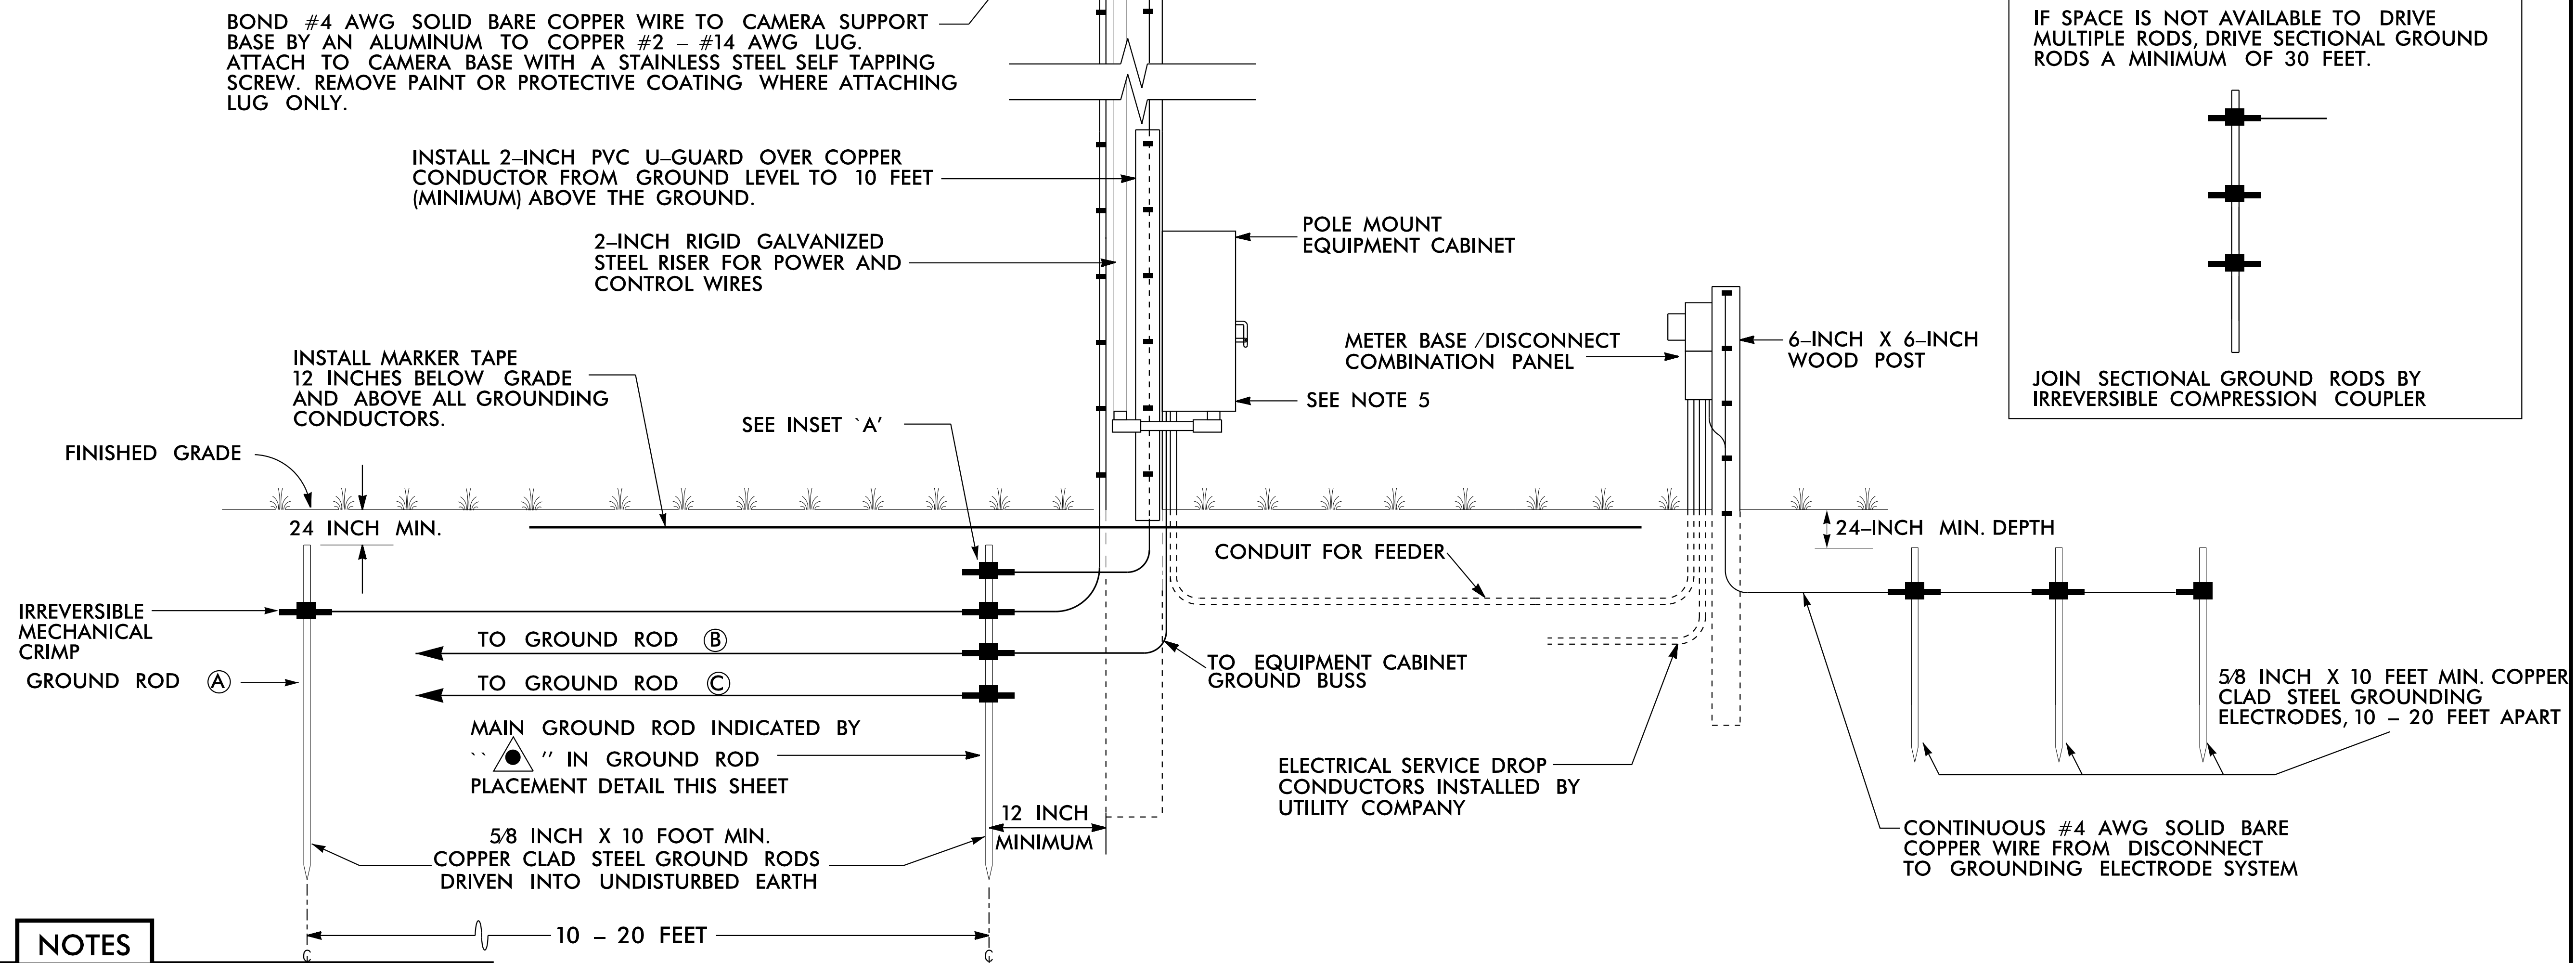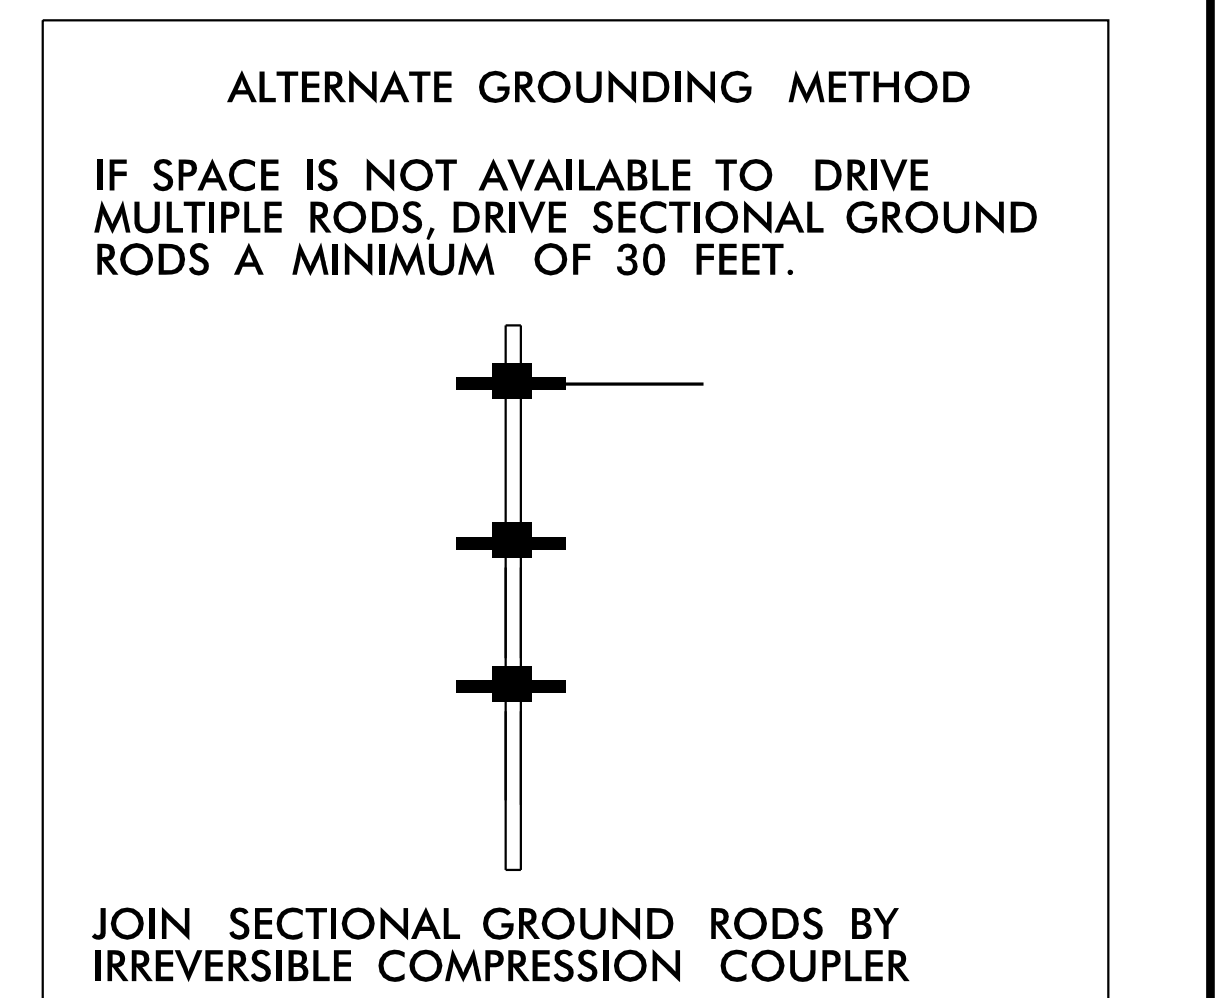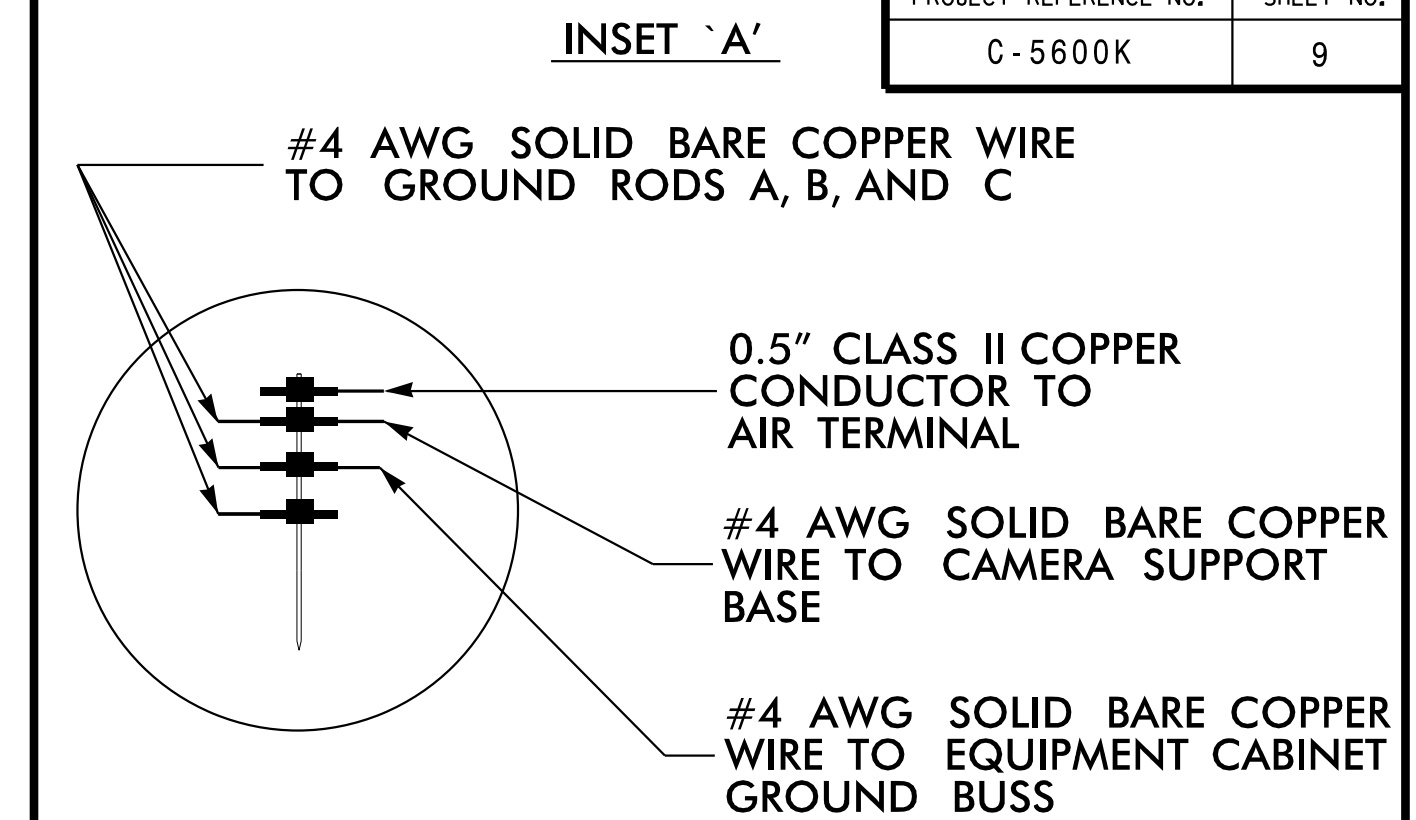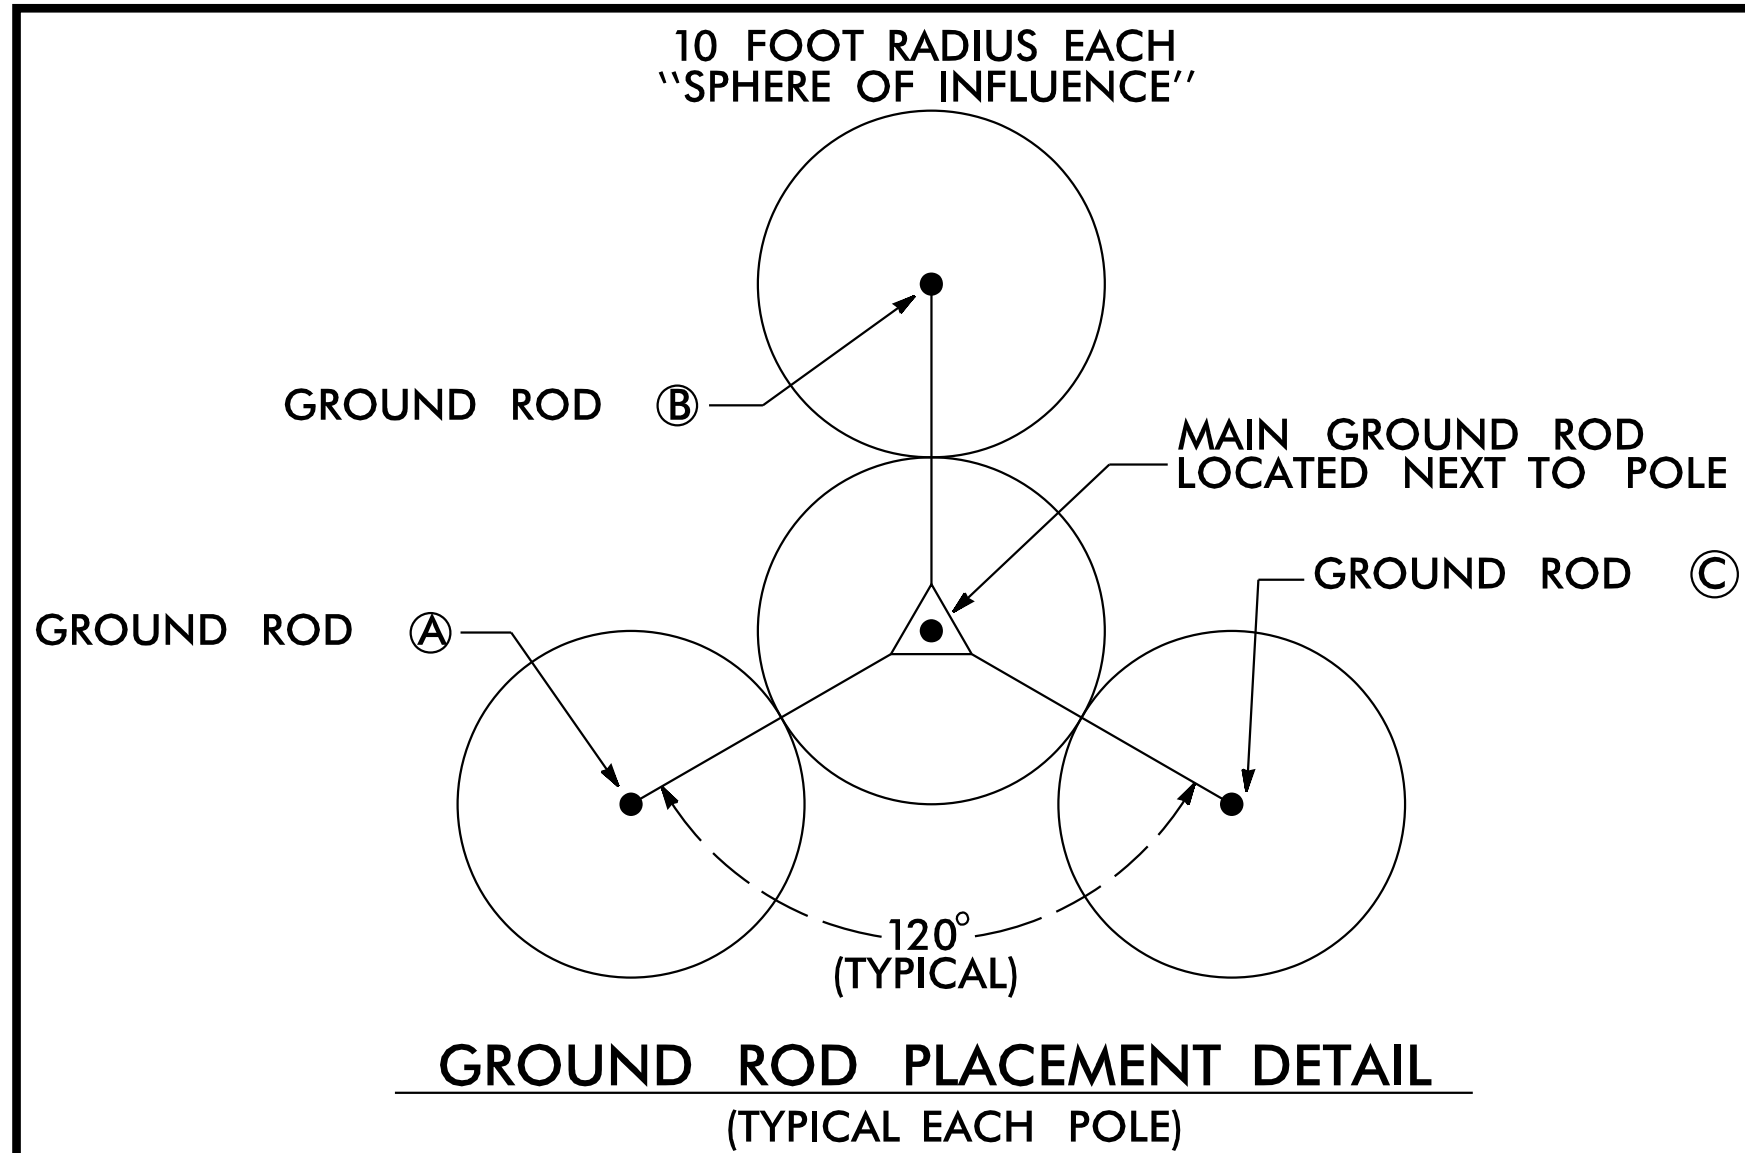


1. BOND CLASS II, 28 STRAND (MINIMUM), 15 AWG (MINIMUM) ROPE-LAY BARE COPPER CONDUCTOR TO THE MAIN GROUND ROD BY AN IRREVERSIBLE MECHANICAL CRIMP METHOD. MAINTAIN MAXIMUM HORIZONTAL SEPARATION BETWEEN COPPER CONDUCTOR AND RISER.
2. ALL CONNECTIONS TO GROUND RODS SHOULD BE MADE WITH AN IRREVERSIBLE MECHANICAL CRIMP METHOD.
3. THE CONTRACTOR MAY, UPON APPROVAL OF THE ENGINEER, INSTALL A 30-FOOT SECTIONAL GROUND ROD FOR INSTANCES WHEN CONDITIONS WILL NOT ALLOW FOR THE INSTALLATION OF THE 3 - RADIAL GROUND RODS.
4. INSTALL MARKER TAPE DIRECTLY ABOVE ALL GROUNDING ELECTRODES AND CONDUCTORS AT A DEPTH OF 12 INCHES.
5. REMOVE BONDING JUMPER BETWEEN EQUIPMENT CABINET GROUND BUSS AND NEUTRAL BUSS.

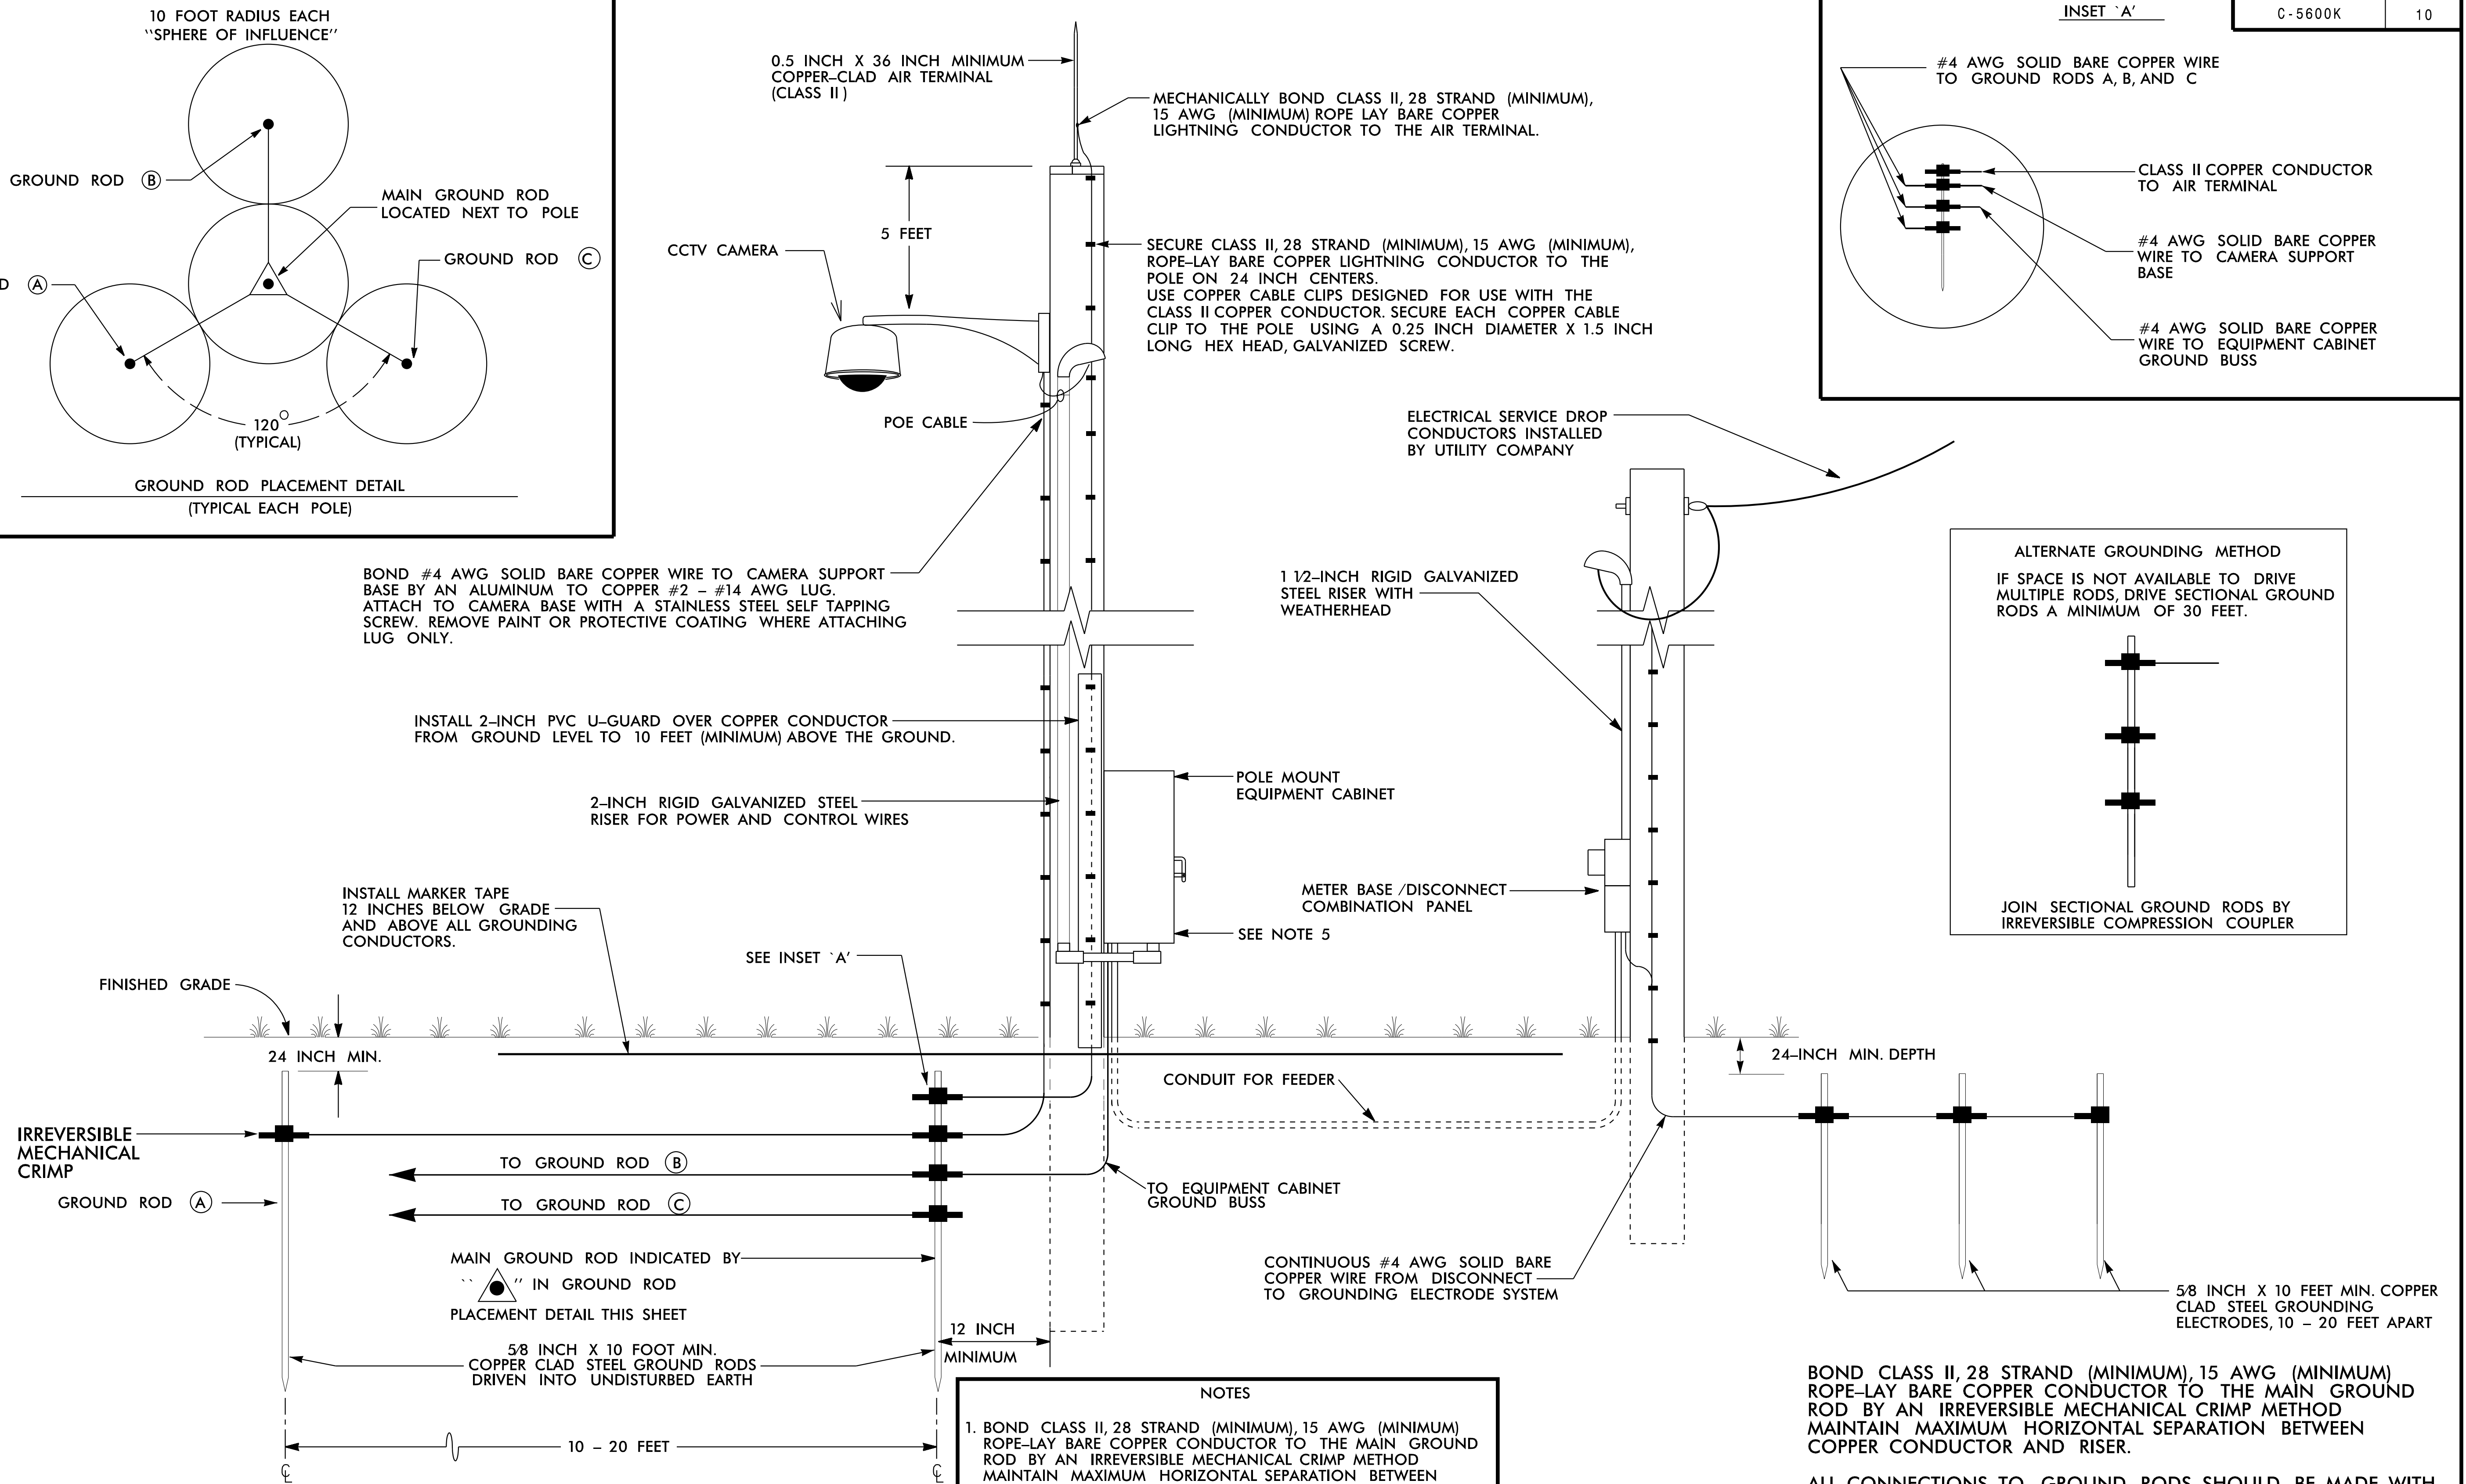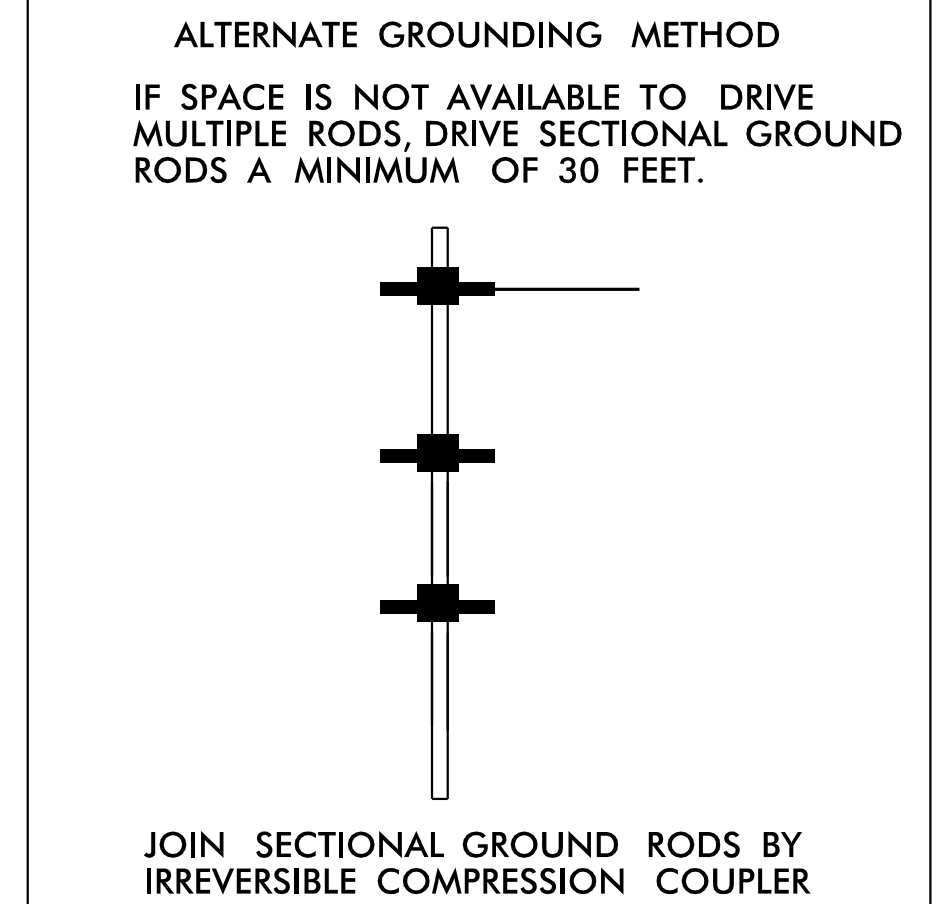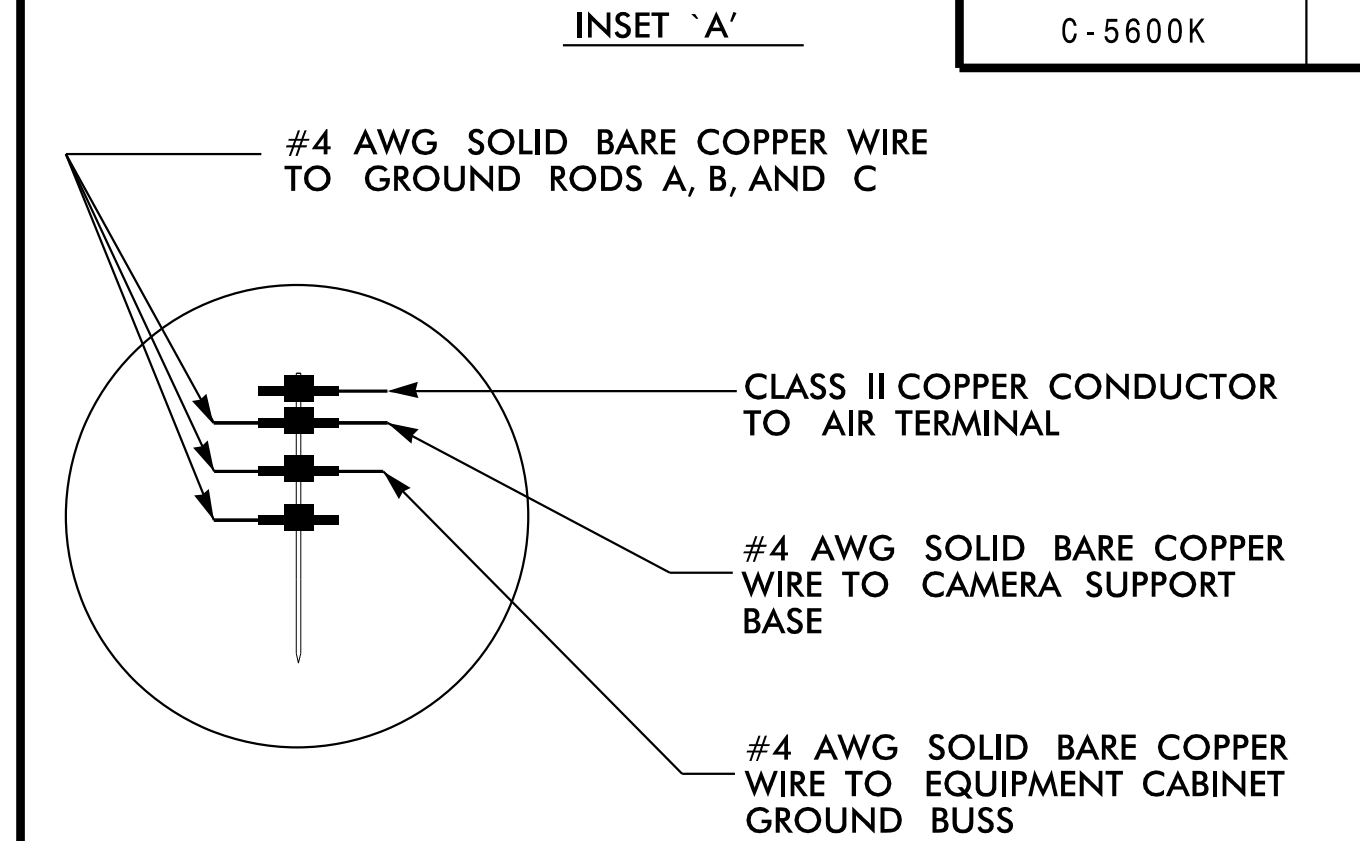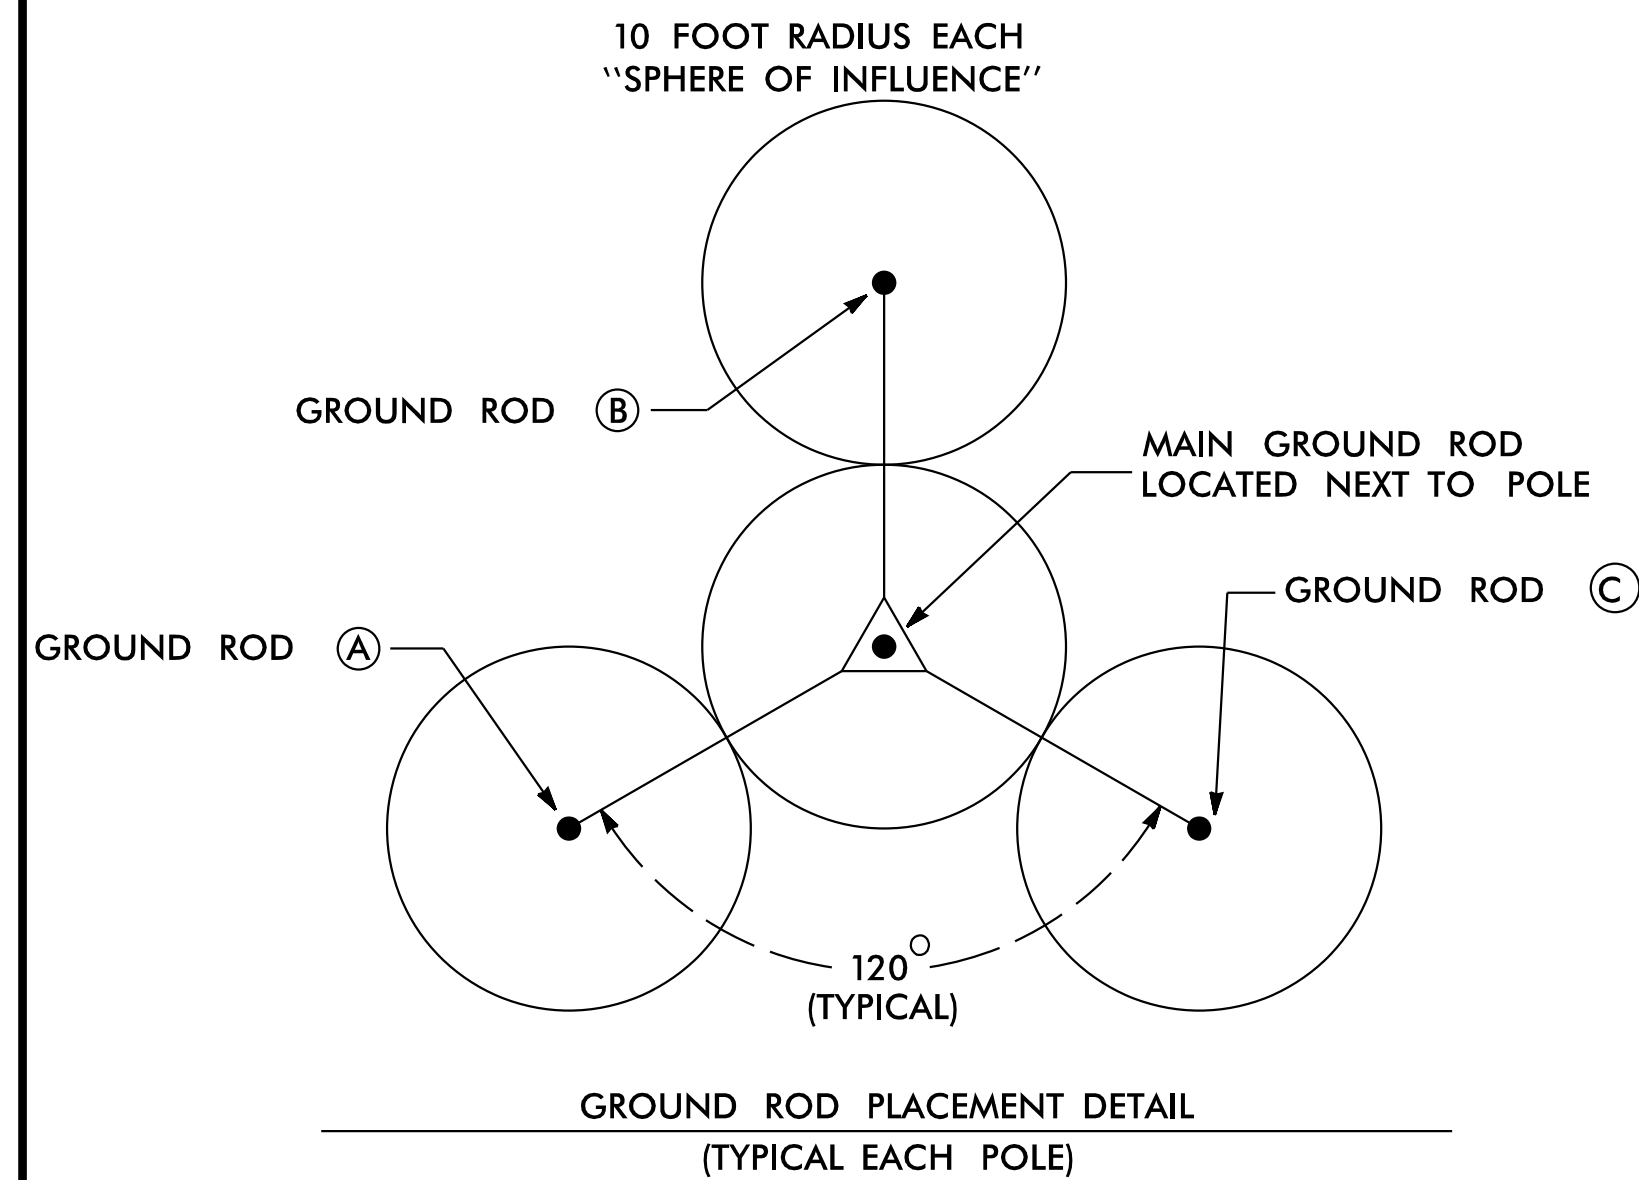


- NOTES**
1. BOND CLASS II, 28 STRAND (MINIMUM), 15 AWG (MINIMUM) ROPE-LAY BARE COPPER CONDUCTOR TO THE MAIN GROUND ROD BY AN IRREVERSIBLE MECHANICAL CRIMP METHOD. MAINTAIN MAXIMUM HORIZONTAL SEPARATION BETWEEN COPPER CONDUCTOR AND RISER.
 2. ALL CONNECTIONS TO GROUND RODS SHOULD BE MADE WITH AN IRREVERSIBLE MECHANICAL CRIMP METHOD.
 3. THE CONTRACTOR MAY, UPON APPROVAL OF THE ENGINEER, INSTALL A 30-FOOT SECTIONAL GROUND ROD FOR INSTANCES WHEN CONDITIONS WILL NOT ALLOW FOR THE INSTALLATION OF THE 3 - RADIAL GROUND RODS.
 4. INSTALL MARKER TAPE DIRECTLY ABOVE ALL GROUNDING ELECTRODES AND CONDUCTORS AT A DEPTH OF 12 INCHES.
 5. REMOVE BONDING JUMPER BETWEEN EQUIPMENT CABINET GROUND BUSS AND NEUTRAL BUSS.

BOND CLASS II, 28 STRAND (MINIMUM), 15 AWG (MINIMUM) ROPE-LAY BARE COPPER CONDUCTOR TO THE MAIN GROUND ROD BY AN IRREVERSIBLE MECHANICAL CRIMP METHOD MAINTAIN MAXIMUM HORIZONTAL SEPARATION BETWEEN COPPER CONDUCTOR AND RISER.

ALL CONNECTIONS TO GROUND RODS SHOULD BE MADE WITH AN IRREVERSIBLE MECHANICAL CRIMP METHOD.

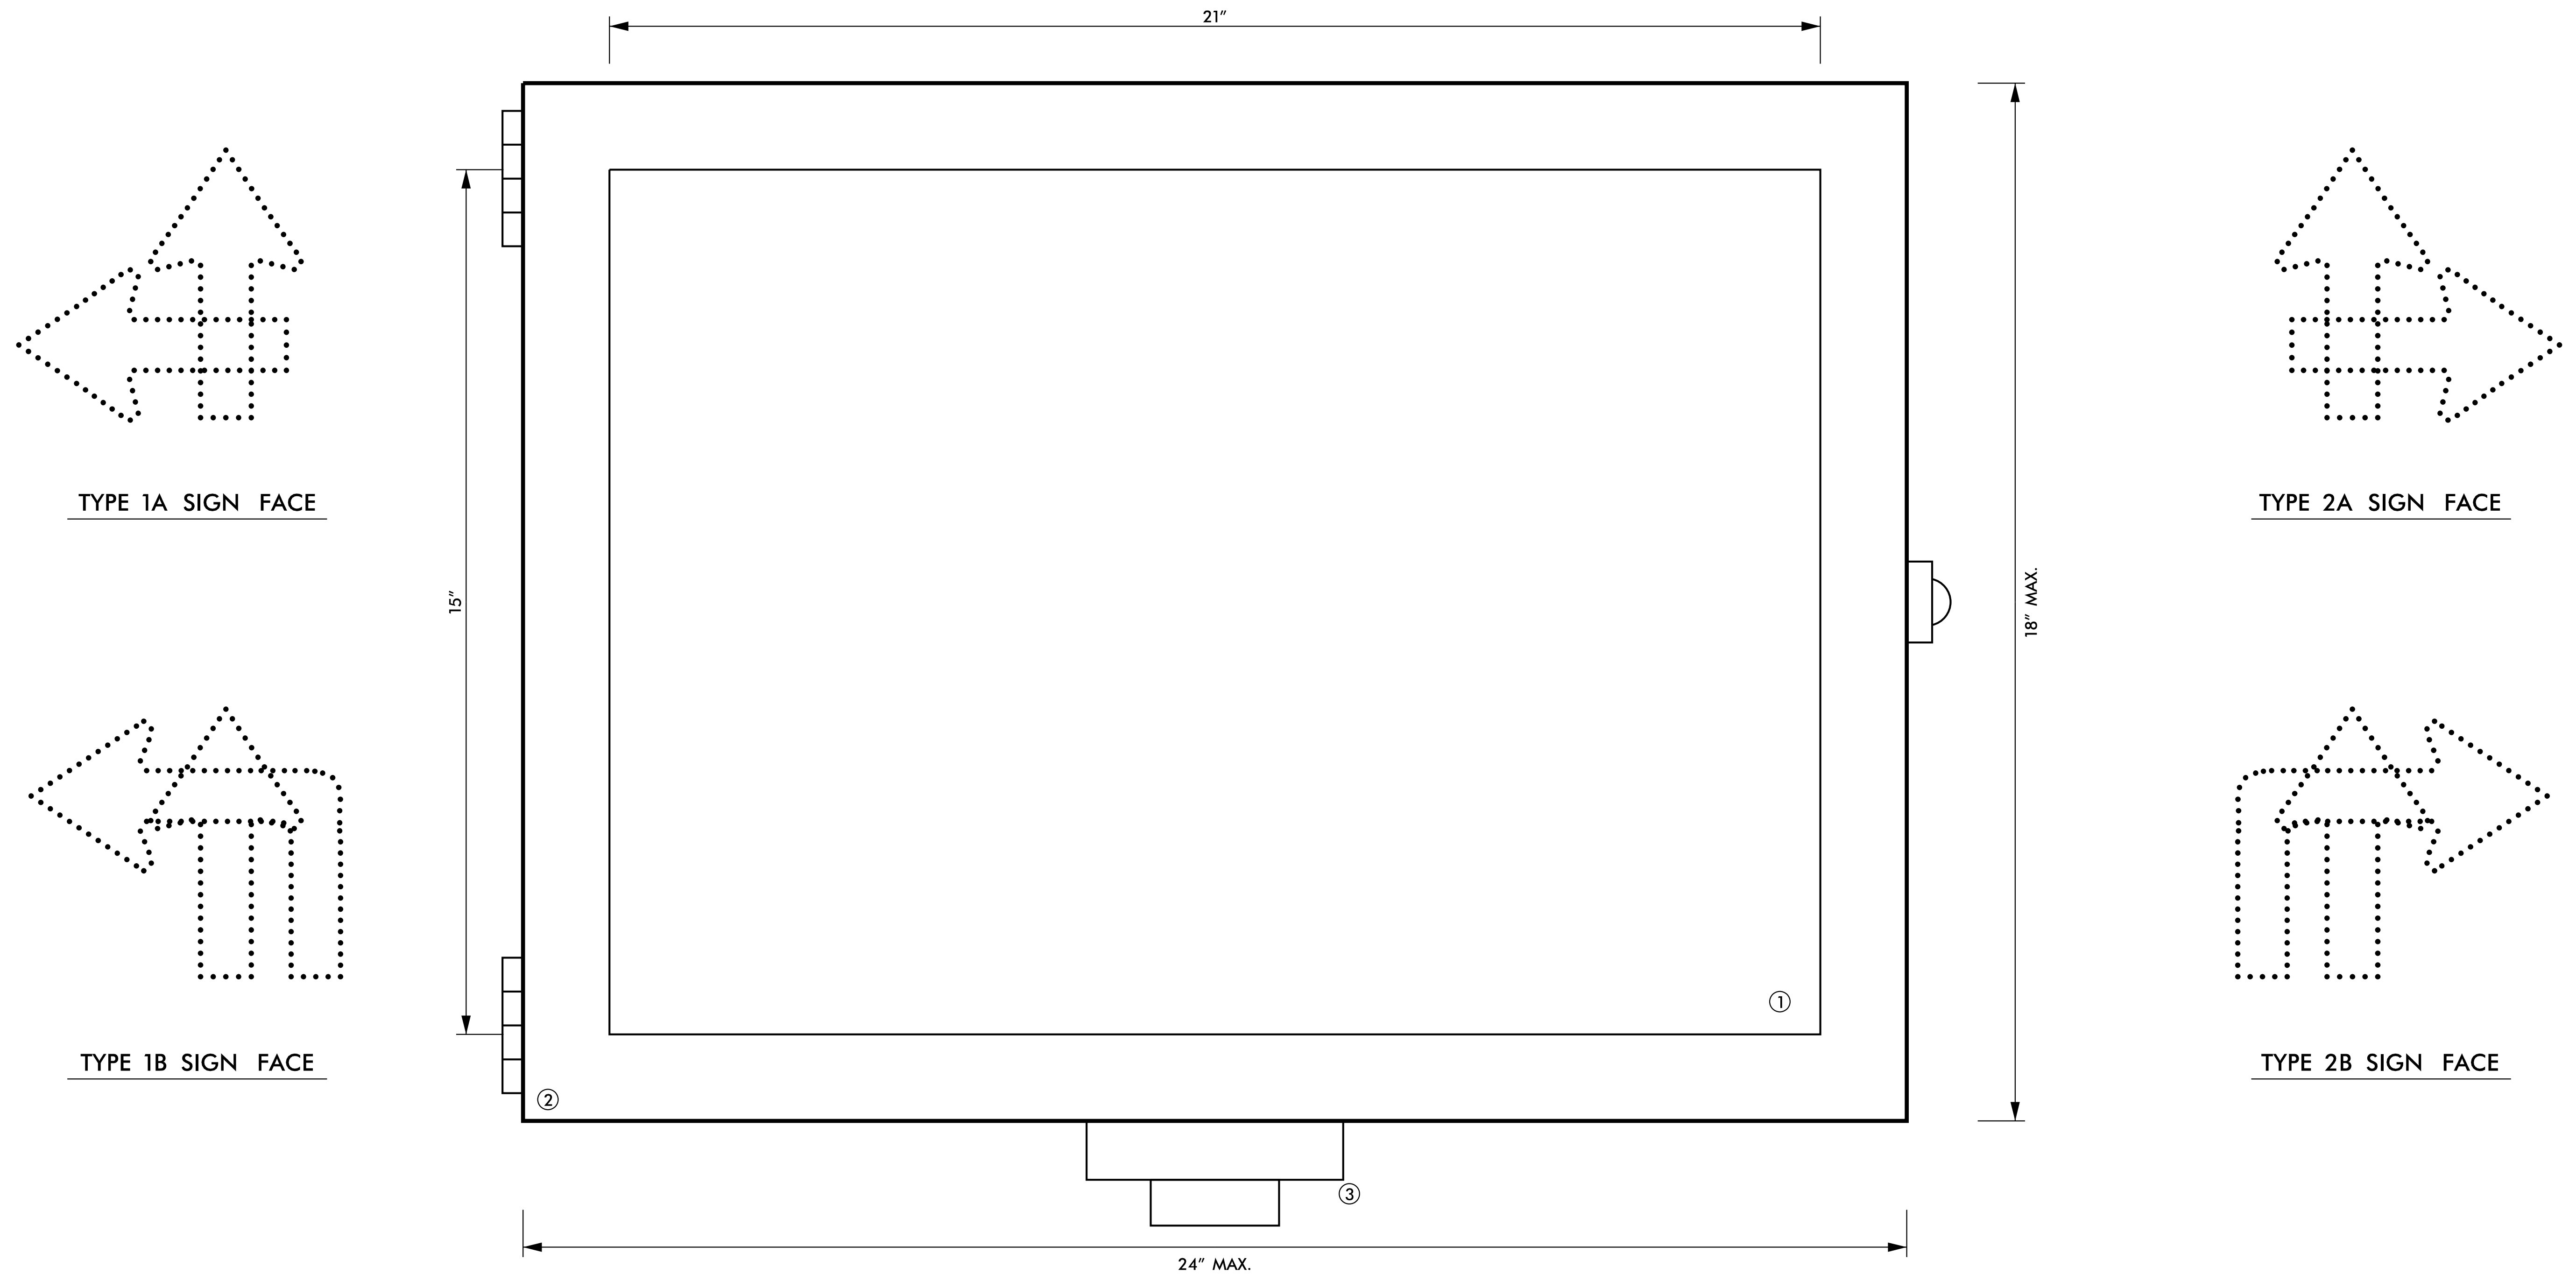

- ① LED SIGN FACE WITH PHOTOCELL SENSOR
- ② SIGN ENCLOSURE WITH LOCKABLE FRONT FACE DRAWER
- ③ OPENING FOR POWER CABLE

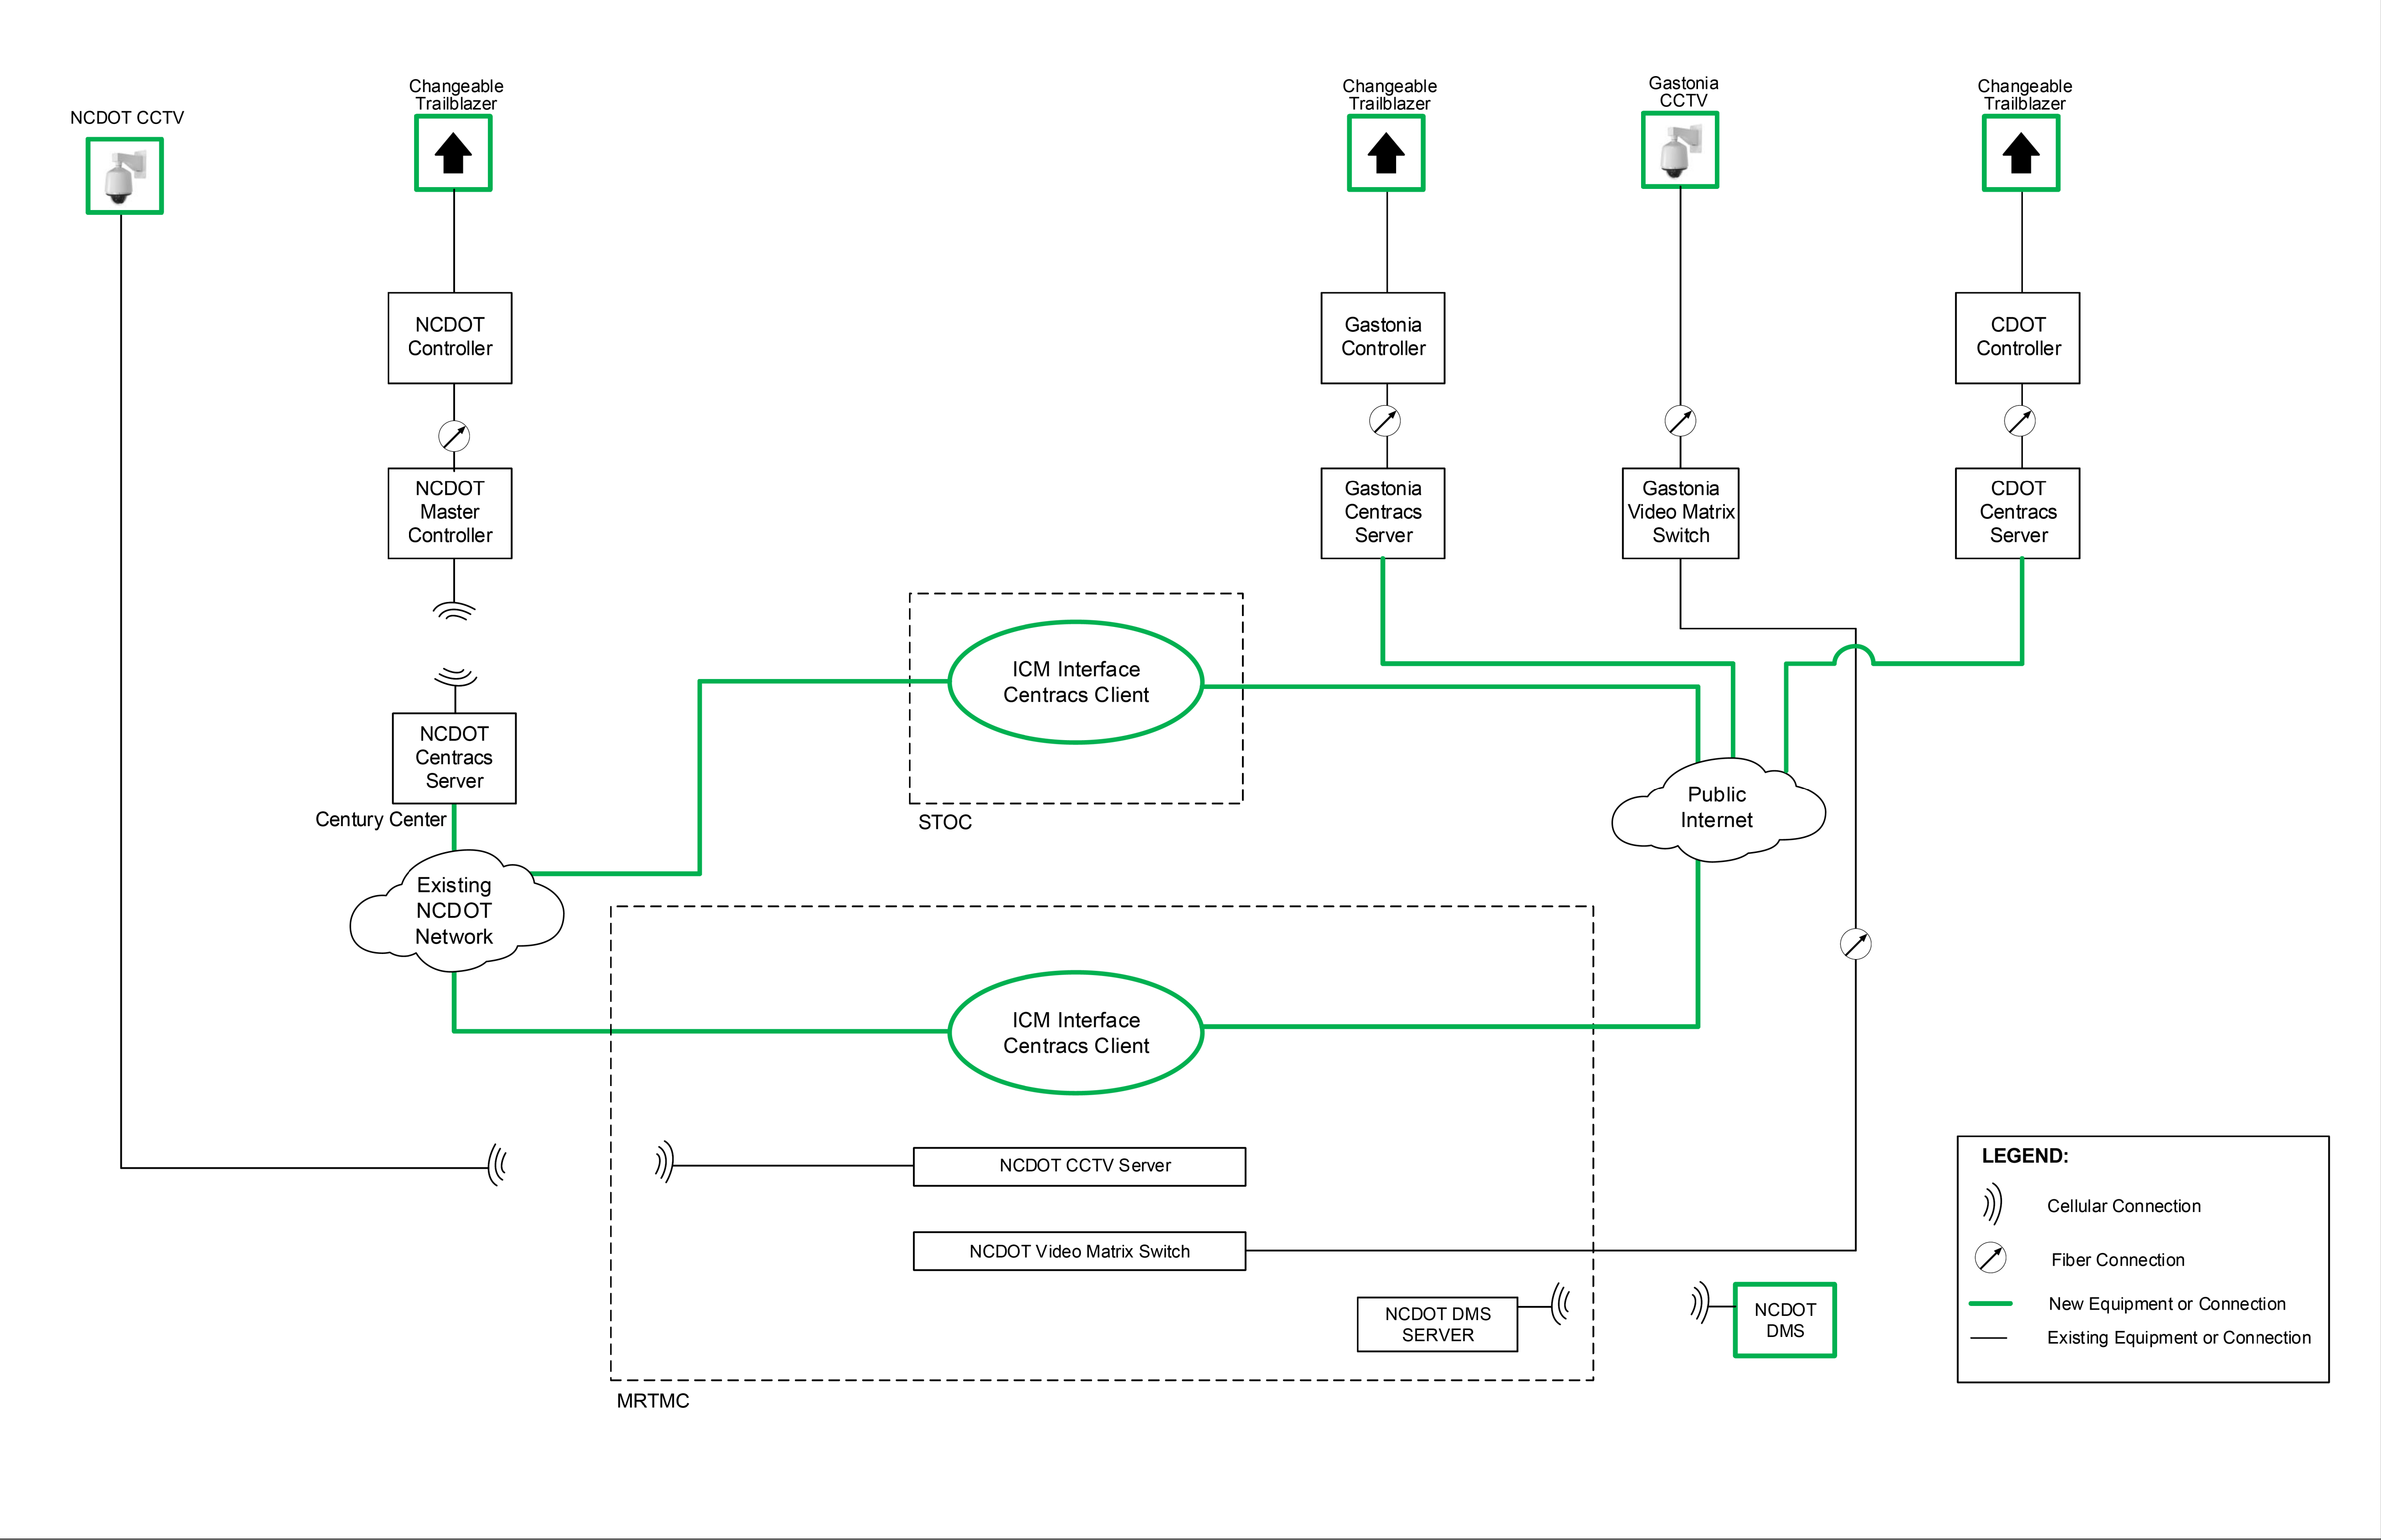

LEGEND:

- Cellular Connection
- Fiber Connection
- New Equipment or Connection
- Existing Equipment or Connection

3/25/2019
K:\ARL\TPTD\ITS\01036443 I-85 ICM\6 Tasks\3 PS&E\Plans\C-5600.ITS_psh12tbl.dgn

Kimley»Horn
NC License #F-0102
421 Fayetteville St., Suite 600
Raleigh, NC 27636
Tel: (919) 677-2000
Fax: (919) 677-2050


Plans Prepared For:
NORTH CAROLINA
DEPARTMENT OF TRANSPORTATION
750 N. Greenfield Plaza, Garner, NC 27529

SCALE
0

I-85 INTEGRATED CORRIDOR MANAGEMENT SYSTEM			
BLOCK DIAGRAM			
DIVISION 10		MECKLENBURG/GASTON COUNTIES	
PLAN DATE:	MAR 2019	REVIEWED BY:	A. GOOD
PREPARED BY:	J. CROSS	REVIEWED BY:	K. SMITH
REVISIONS		INIT.	DATE

SEAL
NORTH CAROLINA
PROFESSIONAL
SEAL
030472
ENGINEER
KEVIN W. SMITH
DocuSign
Kevin W. Smith
0686E04E3B0440F
3/26/2019
SIGNATURE
DATE
CADD Filename:

INSTALL THE FOLLOWING	
QUANTITY	DESCRIPTION
1	DIGITAL CCTV CAMERA ASSEMBLY
1	CCTV WOOD POLE
1	2" RISER WITH WEATHERHEAD
1	SOLAR POWER ASSEMBLY
1	FIELD EQUIPMENT CABINET
1	INSTALL CELLULAR MODEM AND ANTENNA

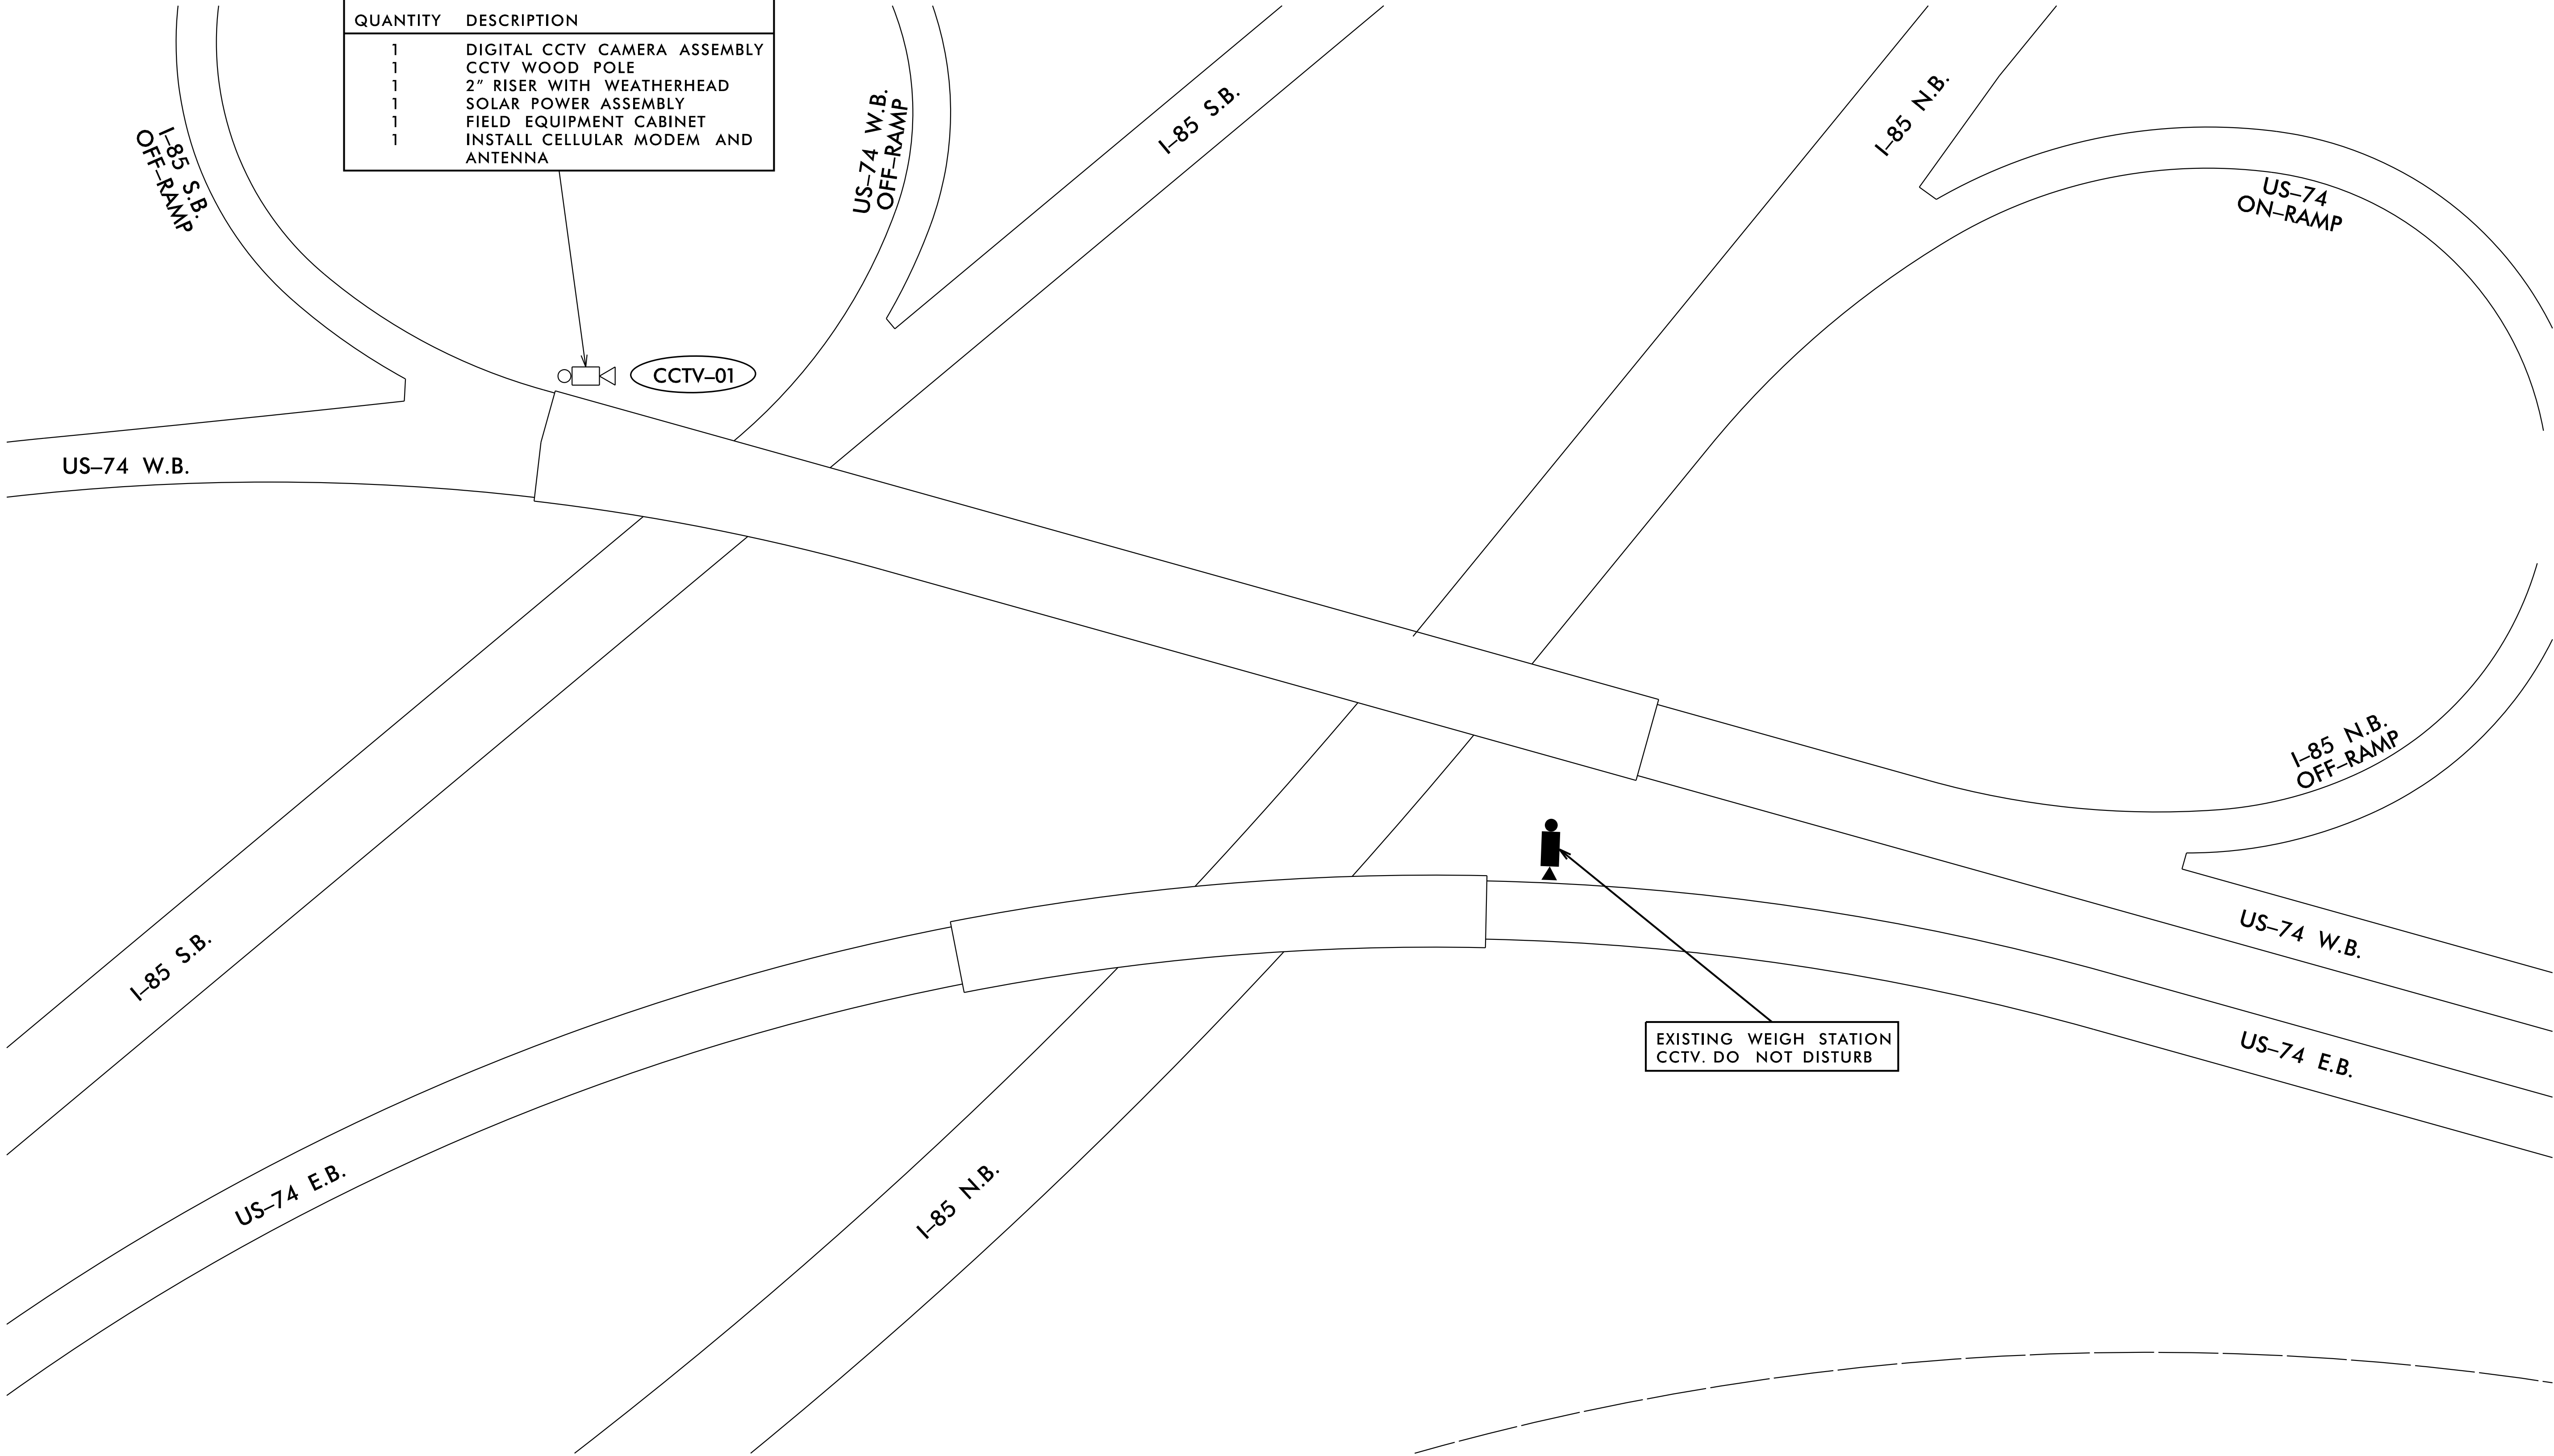

EXISTING WEIGH STATION
CCTV. DO NOT DISTURB

3/25/2019
K:\RAL\TPTD\ITS\01036443 I-85 ICM\6 Tasks\3 PS&E\Plans\C-5600.ITS_psh3.dgn

Kimley»Horn
NC License #F-0102
421 Fayetteville St., Suite 600
Raleigh, NC 27636
Tel: (919) 677-2000
Fax: (919) 677-2050

Plans Prepared For:

750 N. Greenfield Pkwy., Garner, NC 27529

750 N. Greenfield Pkwy., Garner, NC 27529

Division 10

MECKLENBURG/GASTON COUNTIES

PLAN DATE: FEB 2019

REVIEWED BY: A. GOOD

PREPARED BY: J. CROSS

REVIEWED BY: K. SMITH

REVISIONS

INIT. DATE

SEAL


SEAL 030472

KEVIN W. SMITH

3/26/2019

SIGNATURE DATE


CADD Filename:

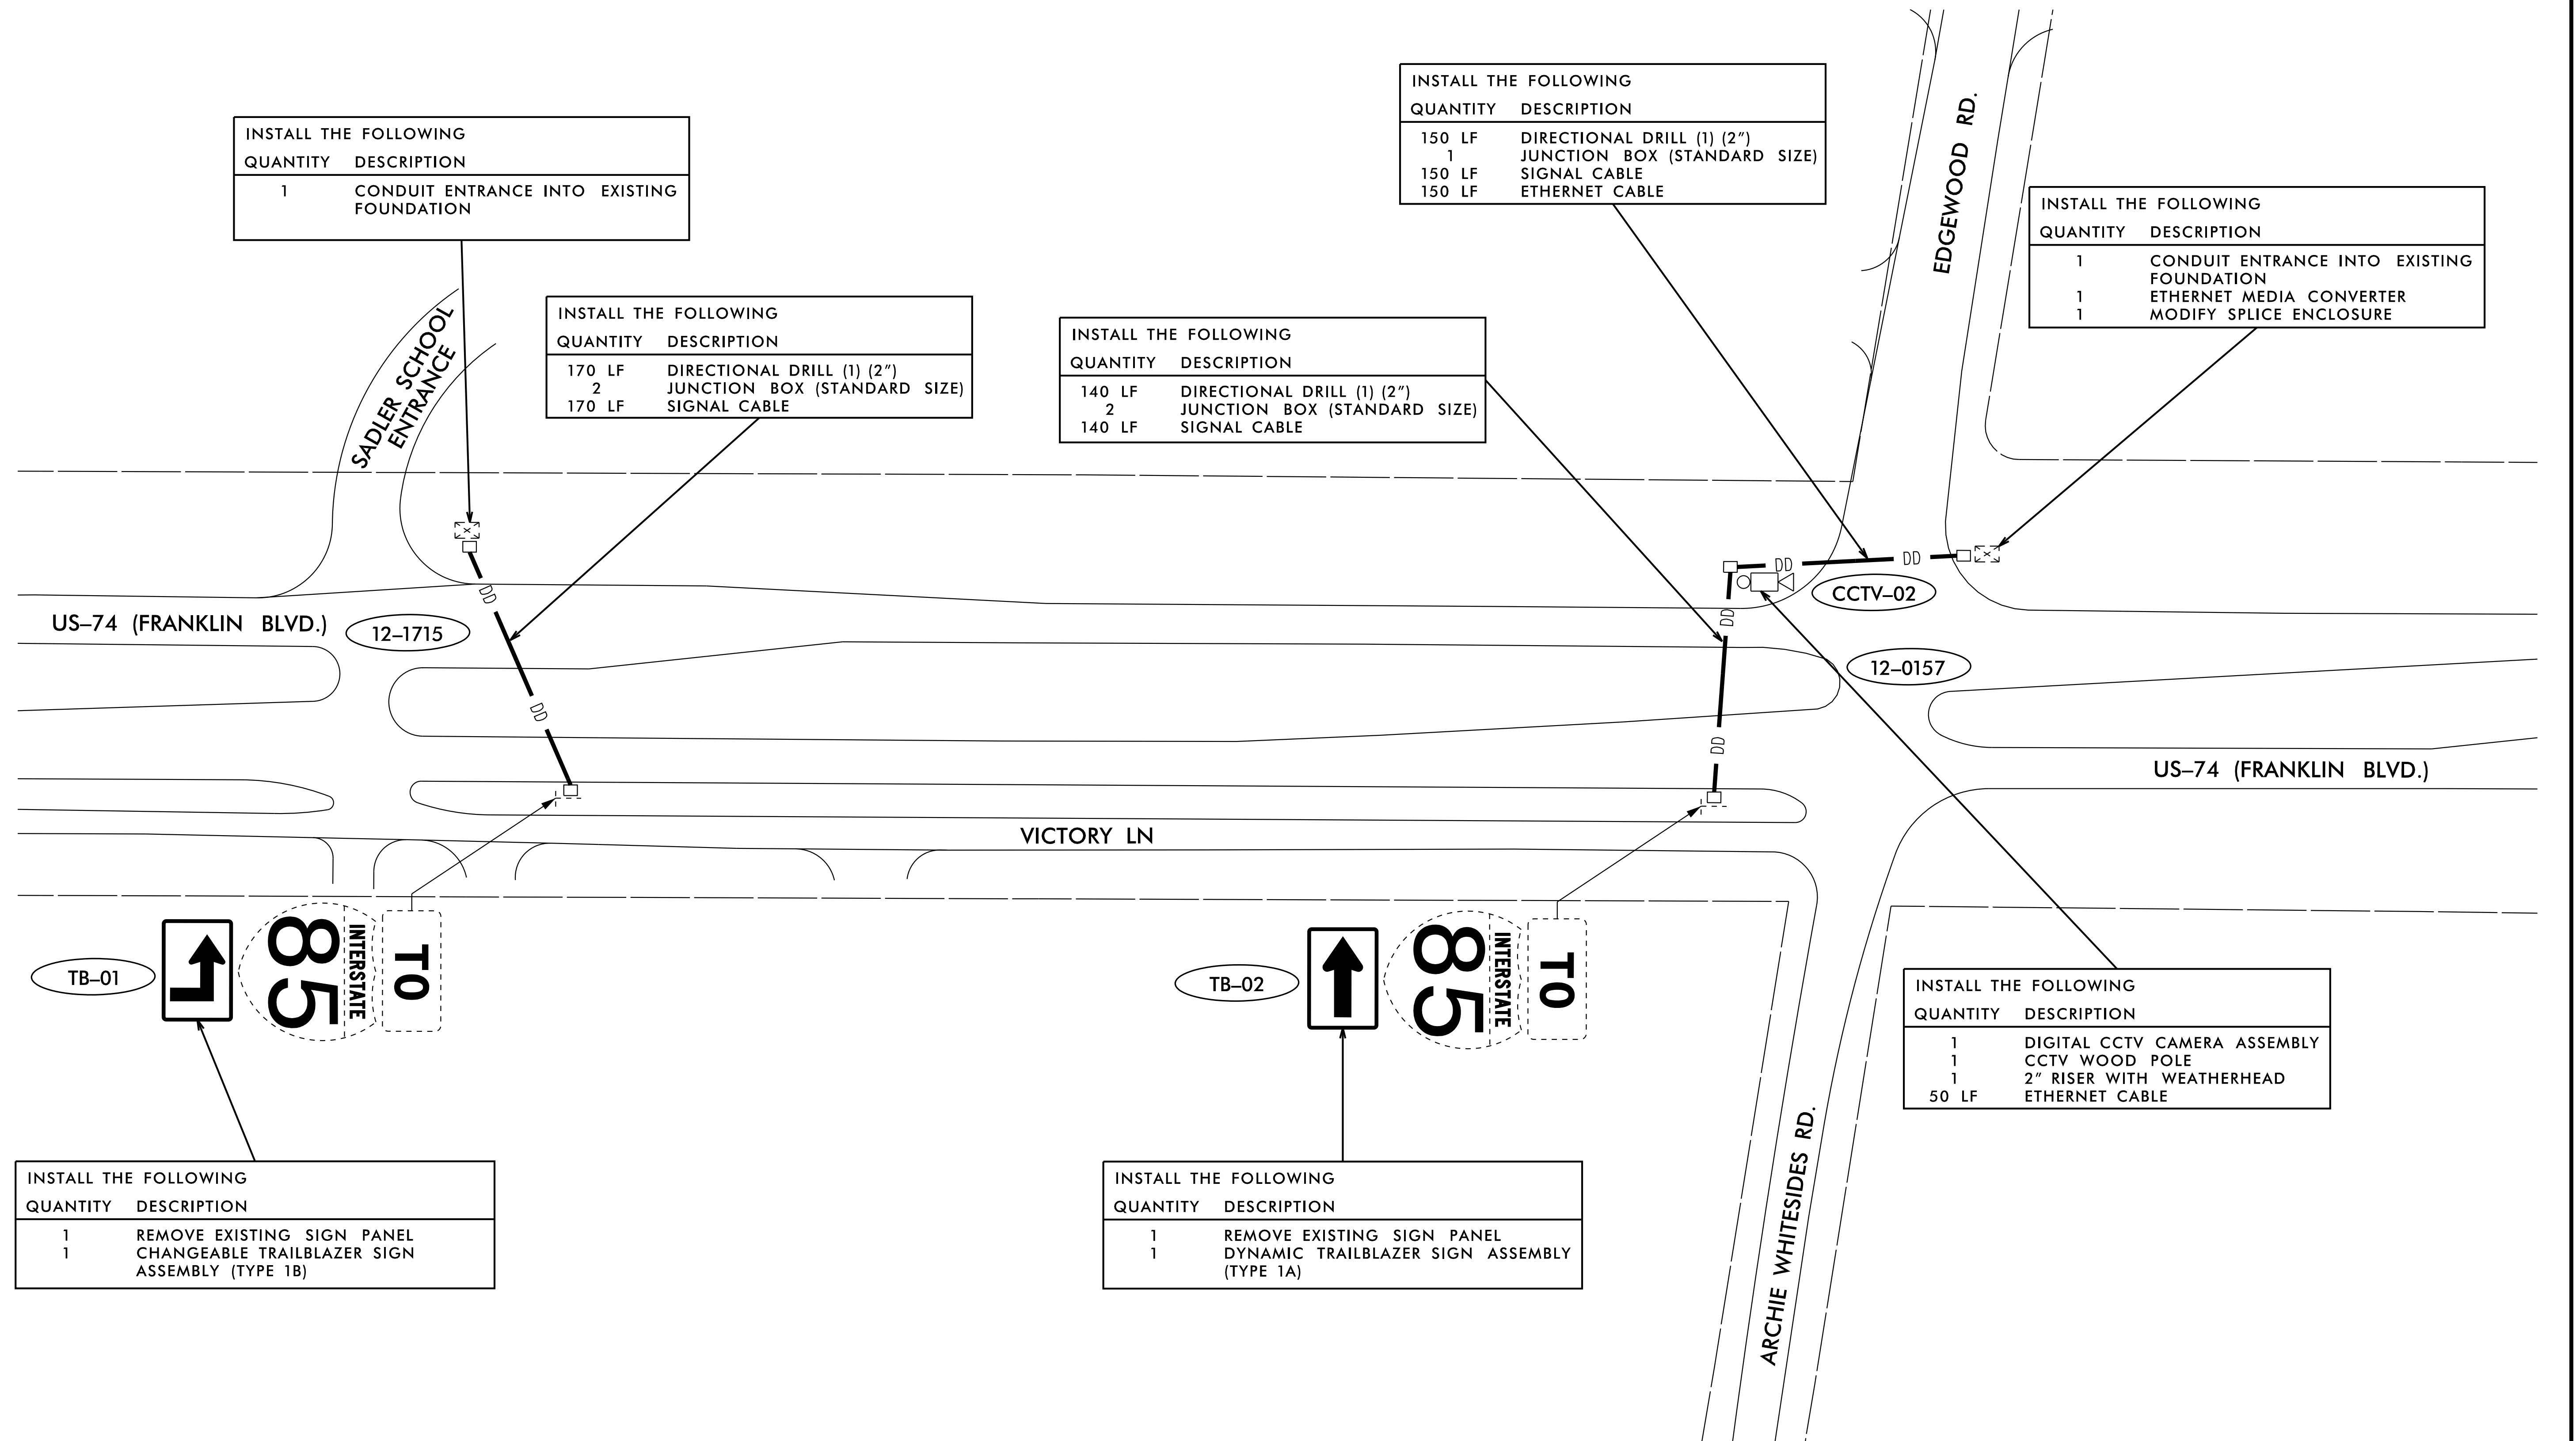

3/25/2019
K:\RAL_TPTO\ITS\OIO36443 I-85 ICM\6 Tasks\3 PS&E\3 PS&E\Plans\C-5600 ITS_psh4.dgn

Kimley»Horn
 NC License #F-0102
 421 Fayetteville St., Suite 600
 Raleigh, NC 27636
 Tel: (919) 677-2000
 Fax: (919) 677-2050

Plans Prepared For:  750 N. Greenfield Pkwy., Garner, NC 27529	I-85 INTEGRATED CORRIDOR MANAGEMENT SYSTEM SIGNING AND DEVICE PLAN	SEAL 																														
<table border="1" style="width: 100%; border-collapse: collapse;"> <tr> <td style="width: 50%;">DIVISION 10</td> <td style="width: 50%;">MECKLENBURG/GASTON COUNTIES</td> </tr> <tr> <td>PLAN DATE: FEB 2019</td> <td>REVIEWED BY: A. GOOD</td> </tr> <tr> <td>PREPARED BY: J. CROSS</td> <td>REVIEWED BY: K. SMITH</td> </tr> </table>			DIVISION 10	MECKLENBURG/GASTON COUNTIES	PLAN DATE: FEB 2019	REVIEWED BY: A. GOOD	PREPARED BY: J. CROSS	REVIEWED BY: K. SMITH																								
DIVISION 10	MECKLENBURG/GASTON COUNTIES																															
PLAN DATE: FEB 2019	REVIEWED BY: A. GOOD																															
PREPARED BY: J. CROSS	REVIEWED BY: K. SMITH																															
 SCALE 0 50	<table border="1" style="width: 100%; border-collapse: collapse;"> <tr> <th style="width: 60%;">REVISIONS</th> <th style="width: 20%;">INIT.</th> <th style="width: 20%;">DATE</th> </tr> <tr><td> </td><td> </td><td> </td></tr> <tr><td> </td><td> </td><td> </td></tr> <tr><td> </td><td> </td><td> </td></tr> <tr><td> </td><td> </td><td> </td></tr> <tr><td> </td><td> </td><td> </td></tr> <tr><td> </td><td> </td><td> </td></tr> <tr><td> </td><td> </td><td> </td></tr> <tr><td> </td><td> </td><td> </td></tr> <tr><td> </td><td> </td><td> </td></tr> </table>	REVISIONS	INIT.	DATE																												Dec. Signed By: <u>Kevin Smith</u> 3/26/2019 _____ SIGNATURE DATE CADD Filename: _____
REVISIONS	INIT.	DATE																														

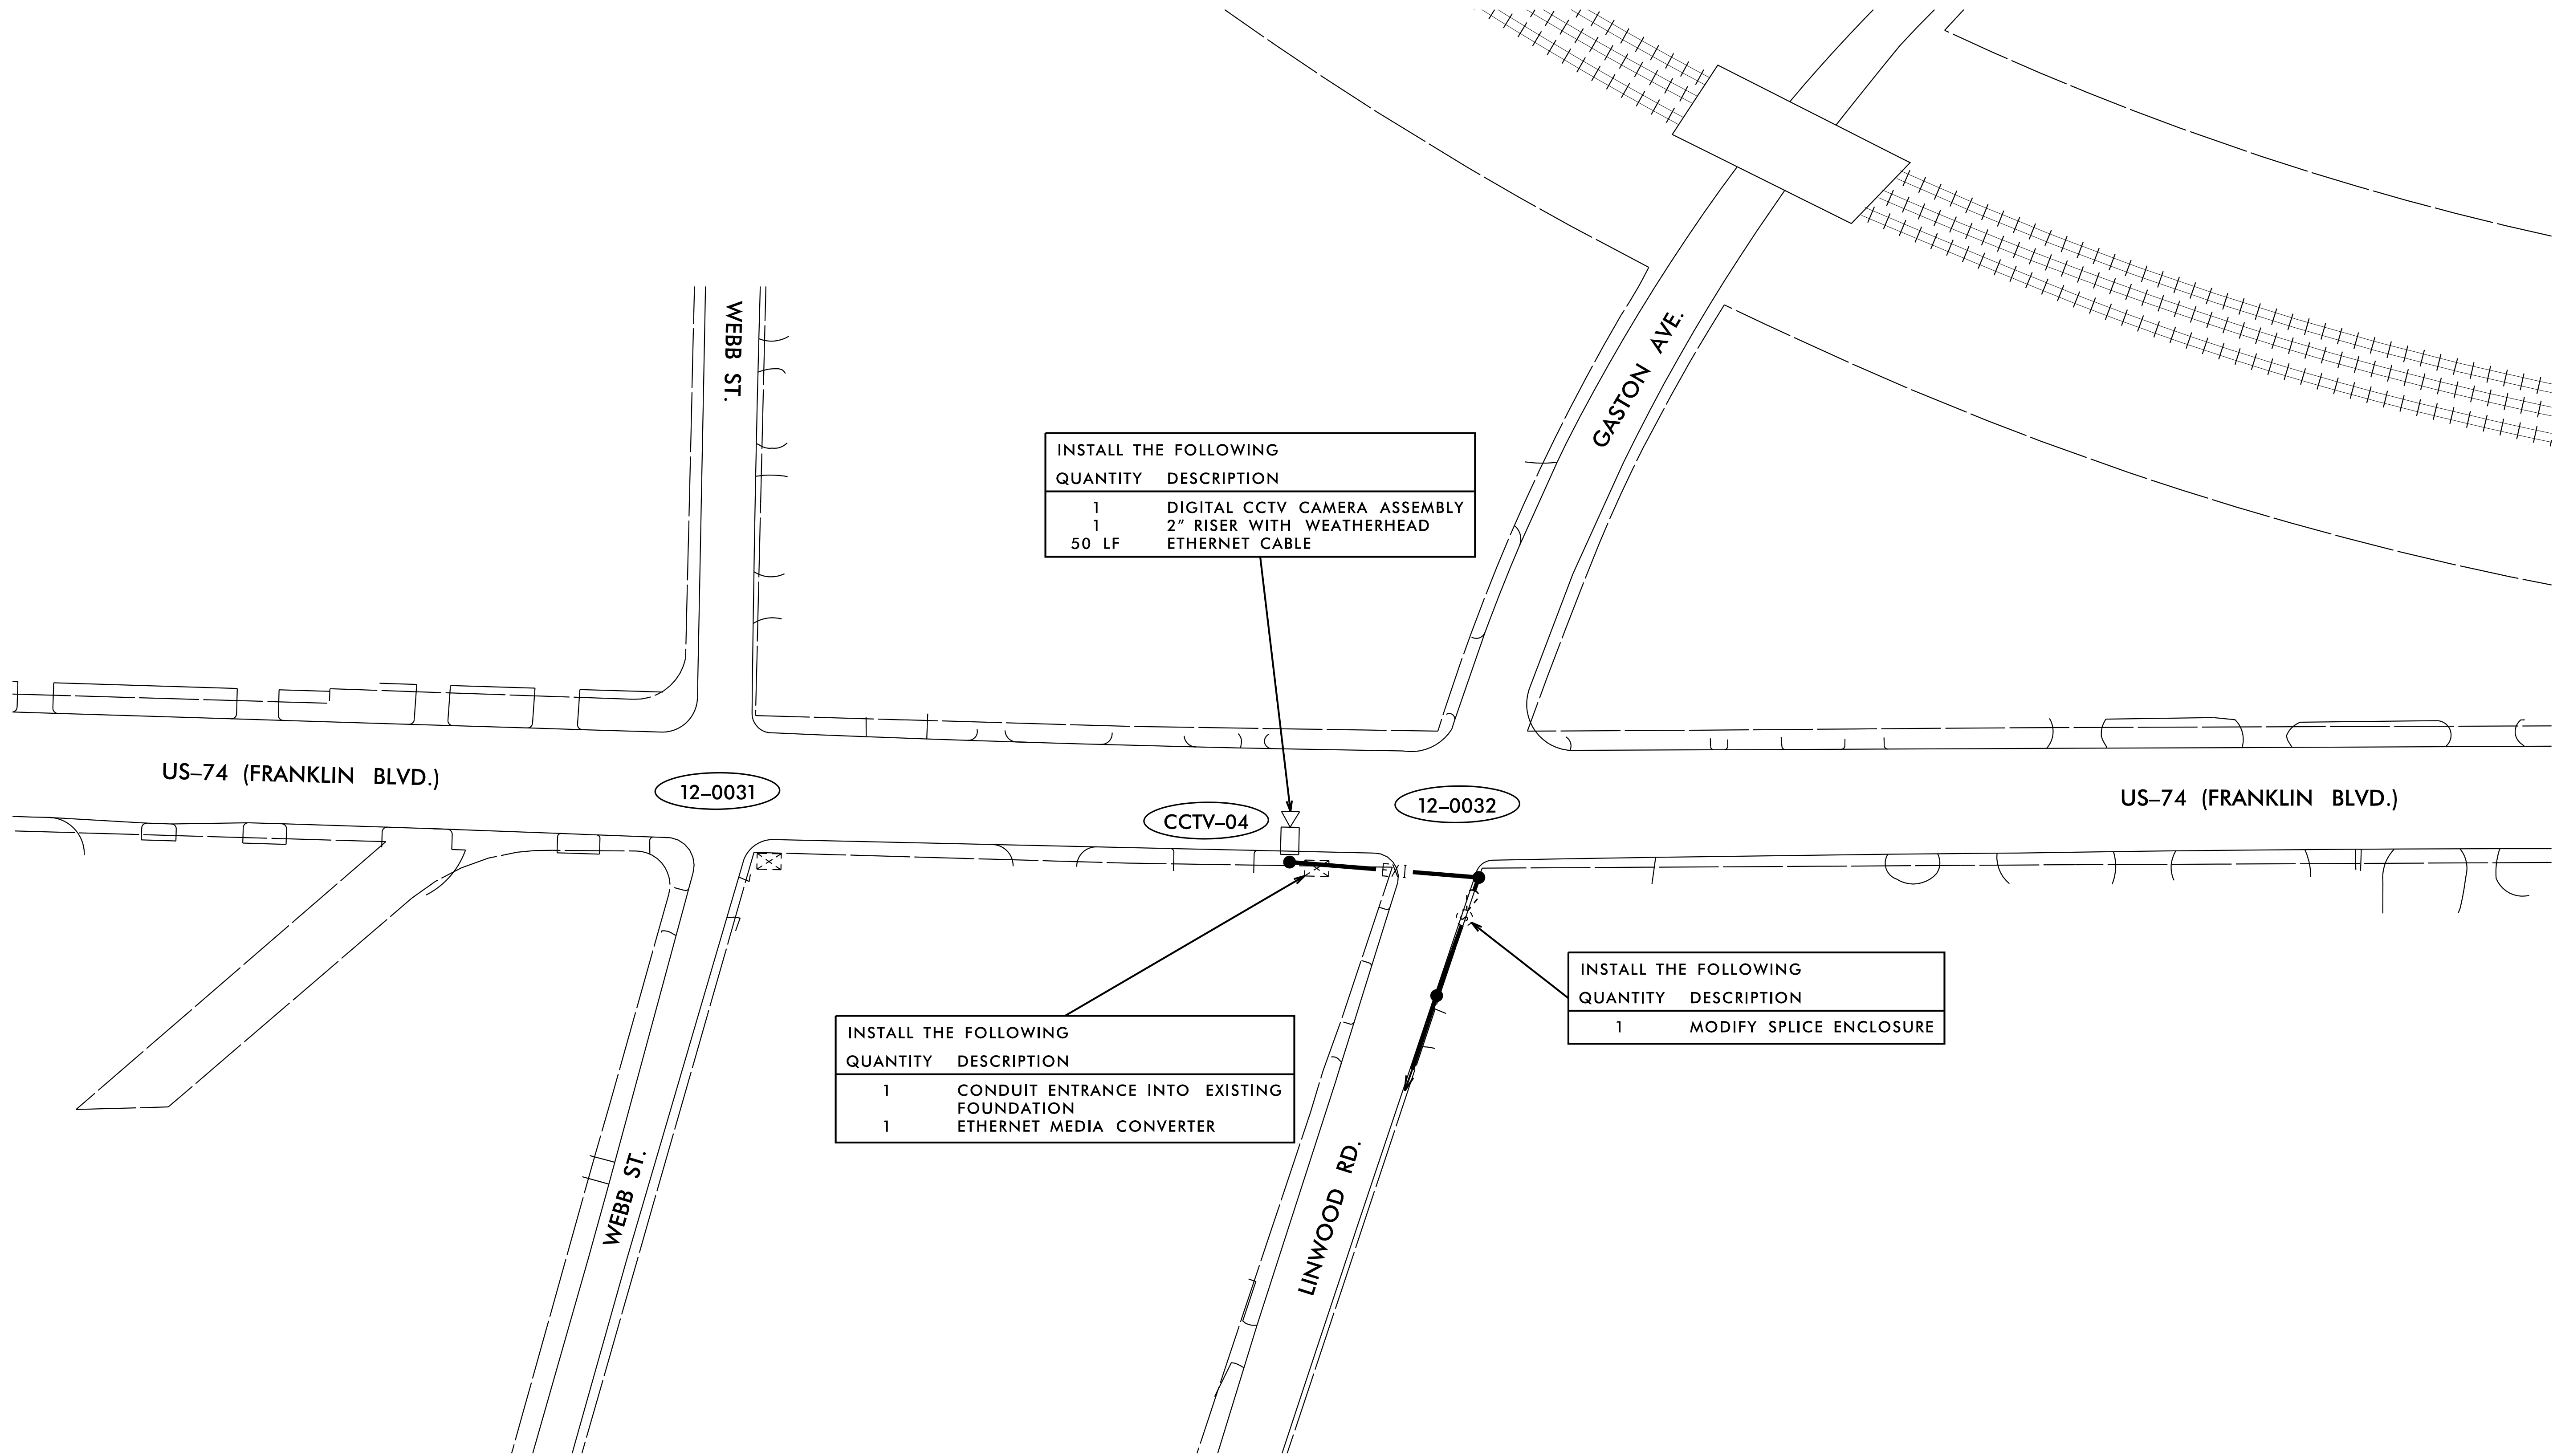


INSTALL THE FOLLOWING	
QUANTITY	DESCRIPTION
1	DIGITAL CCTV CAMERA ASSEMBLY
1	2" RISER WITH WEATHERHEAD
50 LF	ETHERNET CABLE

INSTALL THE FOLLOWING	
QUANTITY	DESCRIPTION
1	CONDUIT ENTRANCE INTO EXISTING FOUNDATION
1	ETHERNET MEDIA CONVERTER


INSTALL THE FOLLOWING	
QUANTITY	DESCRIPTION
1	MODIFY SPLICE ENCLOSURE


3/25/2019
K:\ARL\TPTD\ITS\01036443 I-85 CMA6 Tasks\3 PS&E\Plans\C-5600.ITS_psh6.dgn

Kimley»Horn
NC License #F-0102
421 Fayetteville St., Suite 600
Raleigh, NC 27636
Tel: (919) 677-2000
Fax: (919) 677-2050

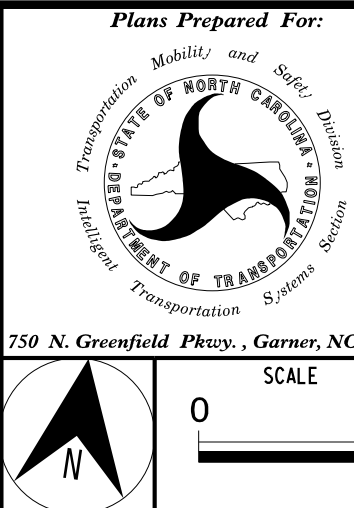


I-85 INTEGRATED CORRIDOR MANAGEMENT SYSTEM			
SIGNING AND DEVICE PLAN			
DIVISION 10		MECKLENBURG/GASTON COUNTIES	
PLAN DATE:	FEB 2019	REVIEWED BY:	A. GOOD
PREPARED BY:	J. CROSS	REVIEWED BY:	K. SMITH
REVISIONS		INIT.	DATE

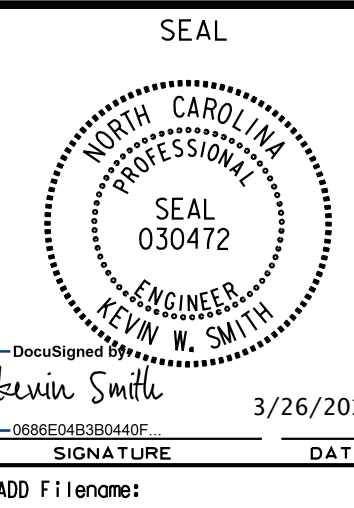

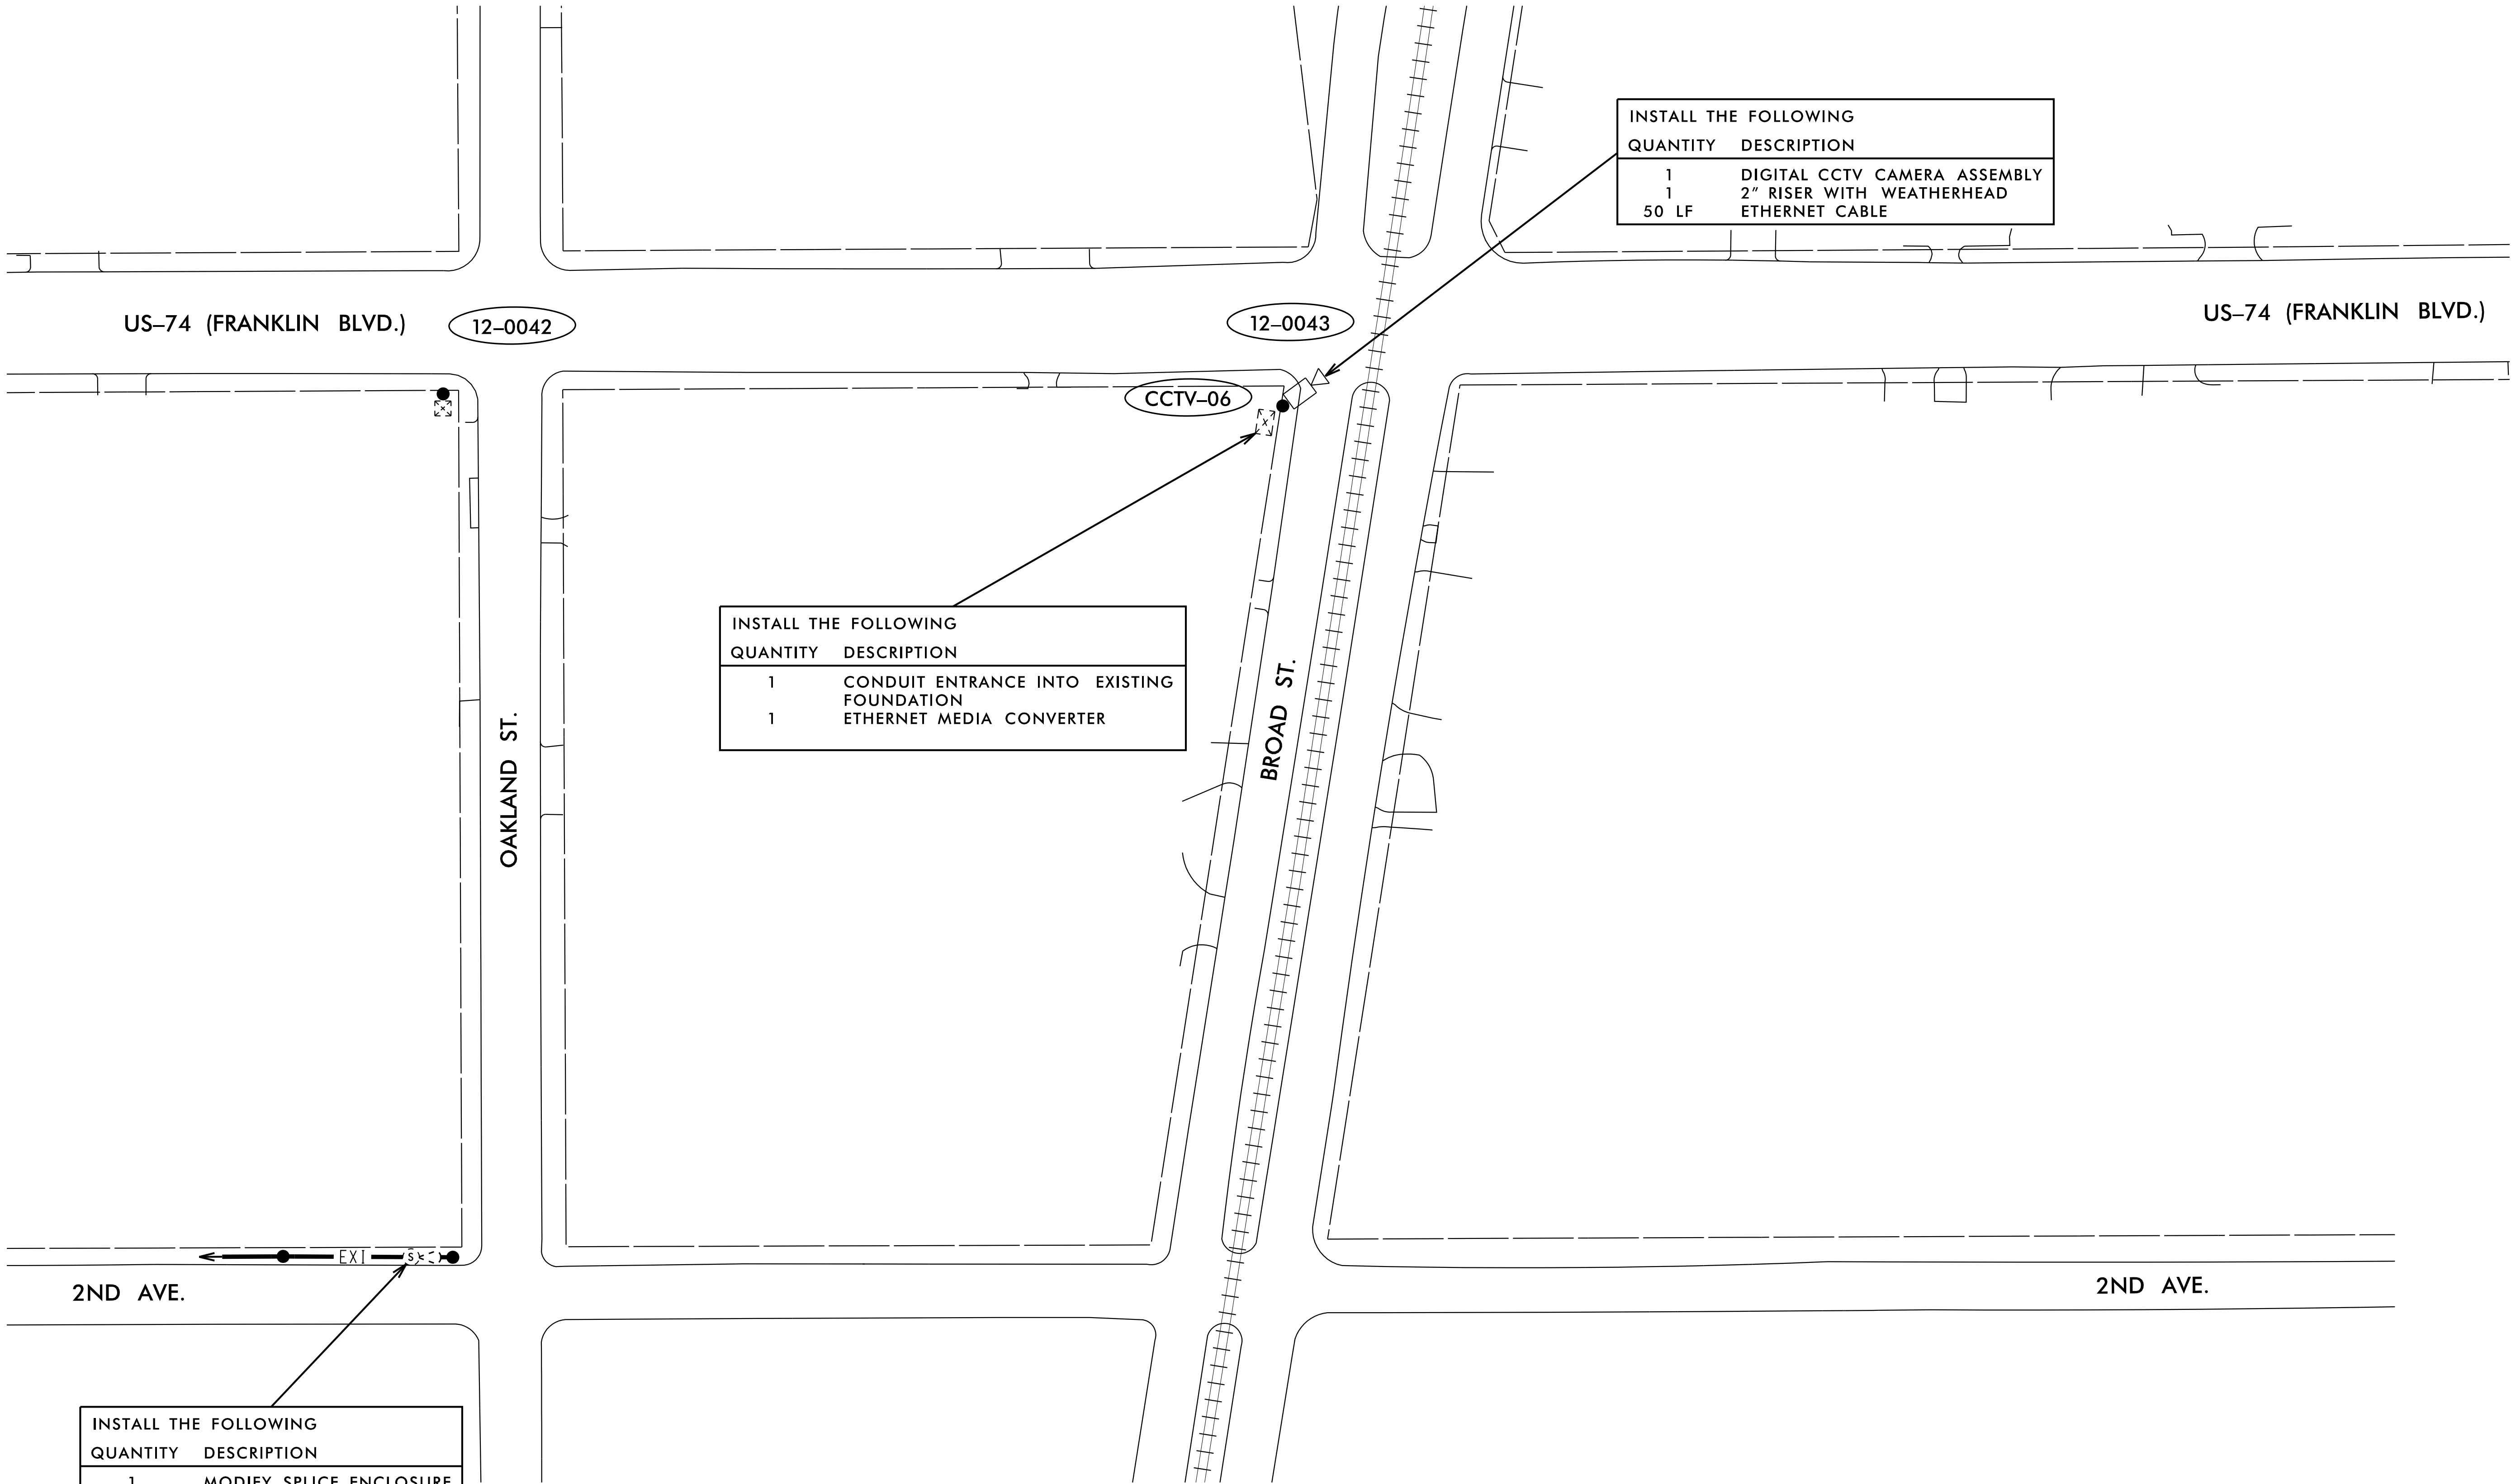



3/25/2019
K:\ARL\TPTD\ITS\01036443 I-85 ICM\6 Tasks\3 PS&E\Plans\C-5600.ITS_psh8.dgn

Kimley»Horn
NC License #F-0102
421 Fayetteville St., Suite 600
Raleigh, NC 27636
Tel: (919) 677-2000
Fax: (919) 677-2050

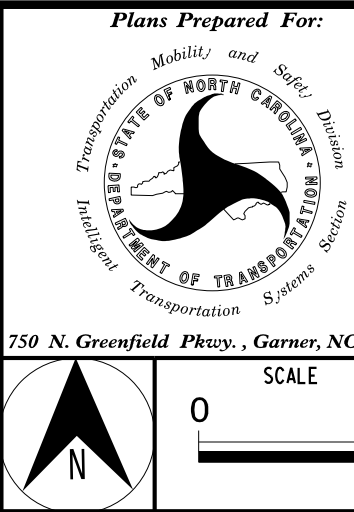


I-85 INTEGRATED CORRIDOR MANAGEMENT SYSTEM			
SIGNING AND DEVICE PLAN			
DIVISION 10		MECKLENBURG/GASTON COUNTIES	
PLAN DATE:	FEB 2019	REVIEWED BY:	A. GOOD
PREPARED BY:	J. CROSS	REVIEWED BY:	K. SMITH
REVISIONS	INIT.	DATE	

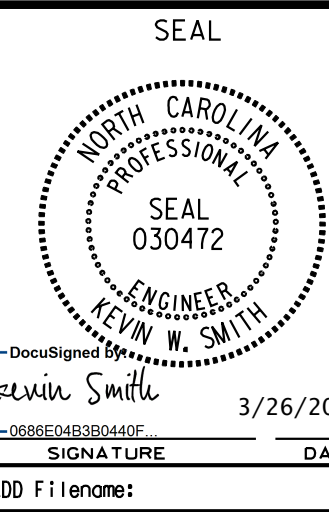

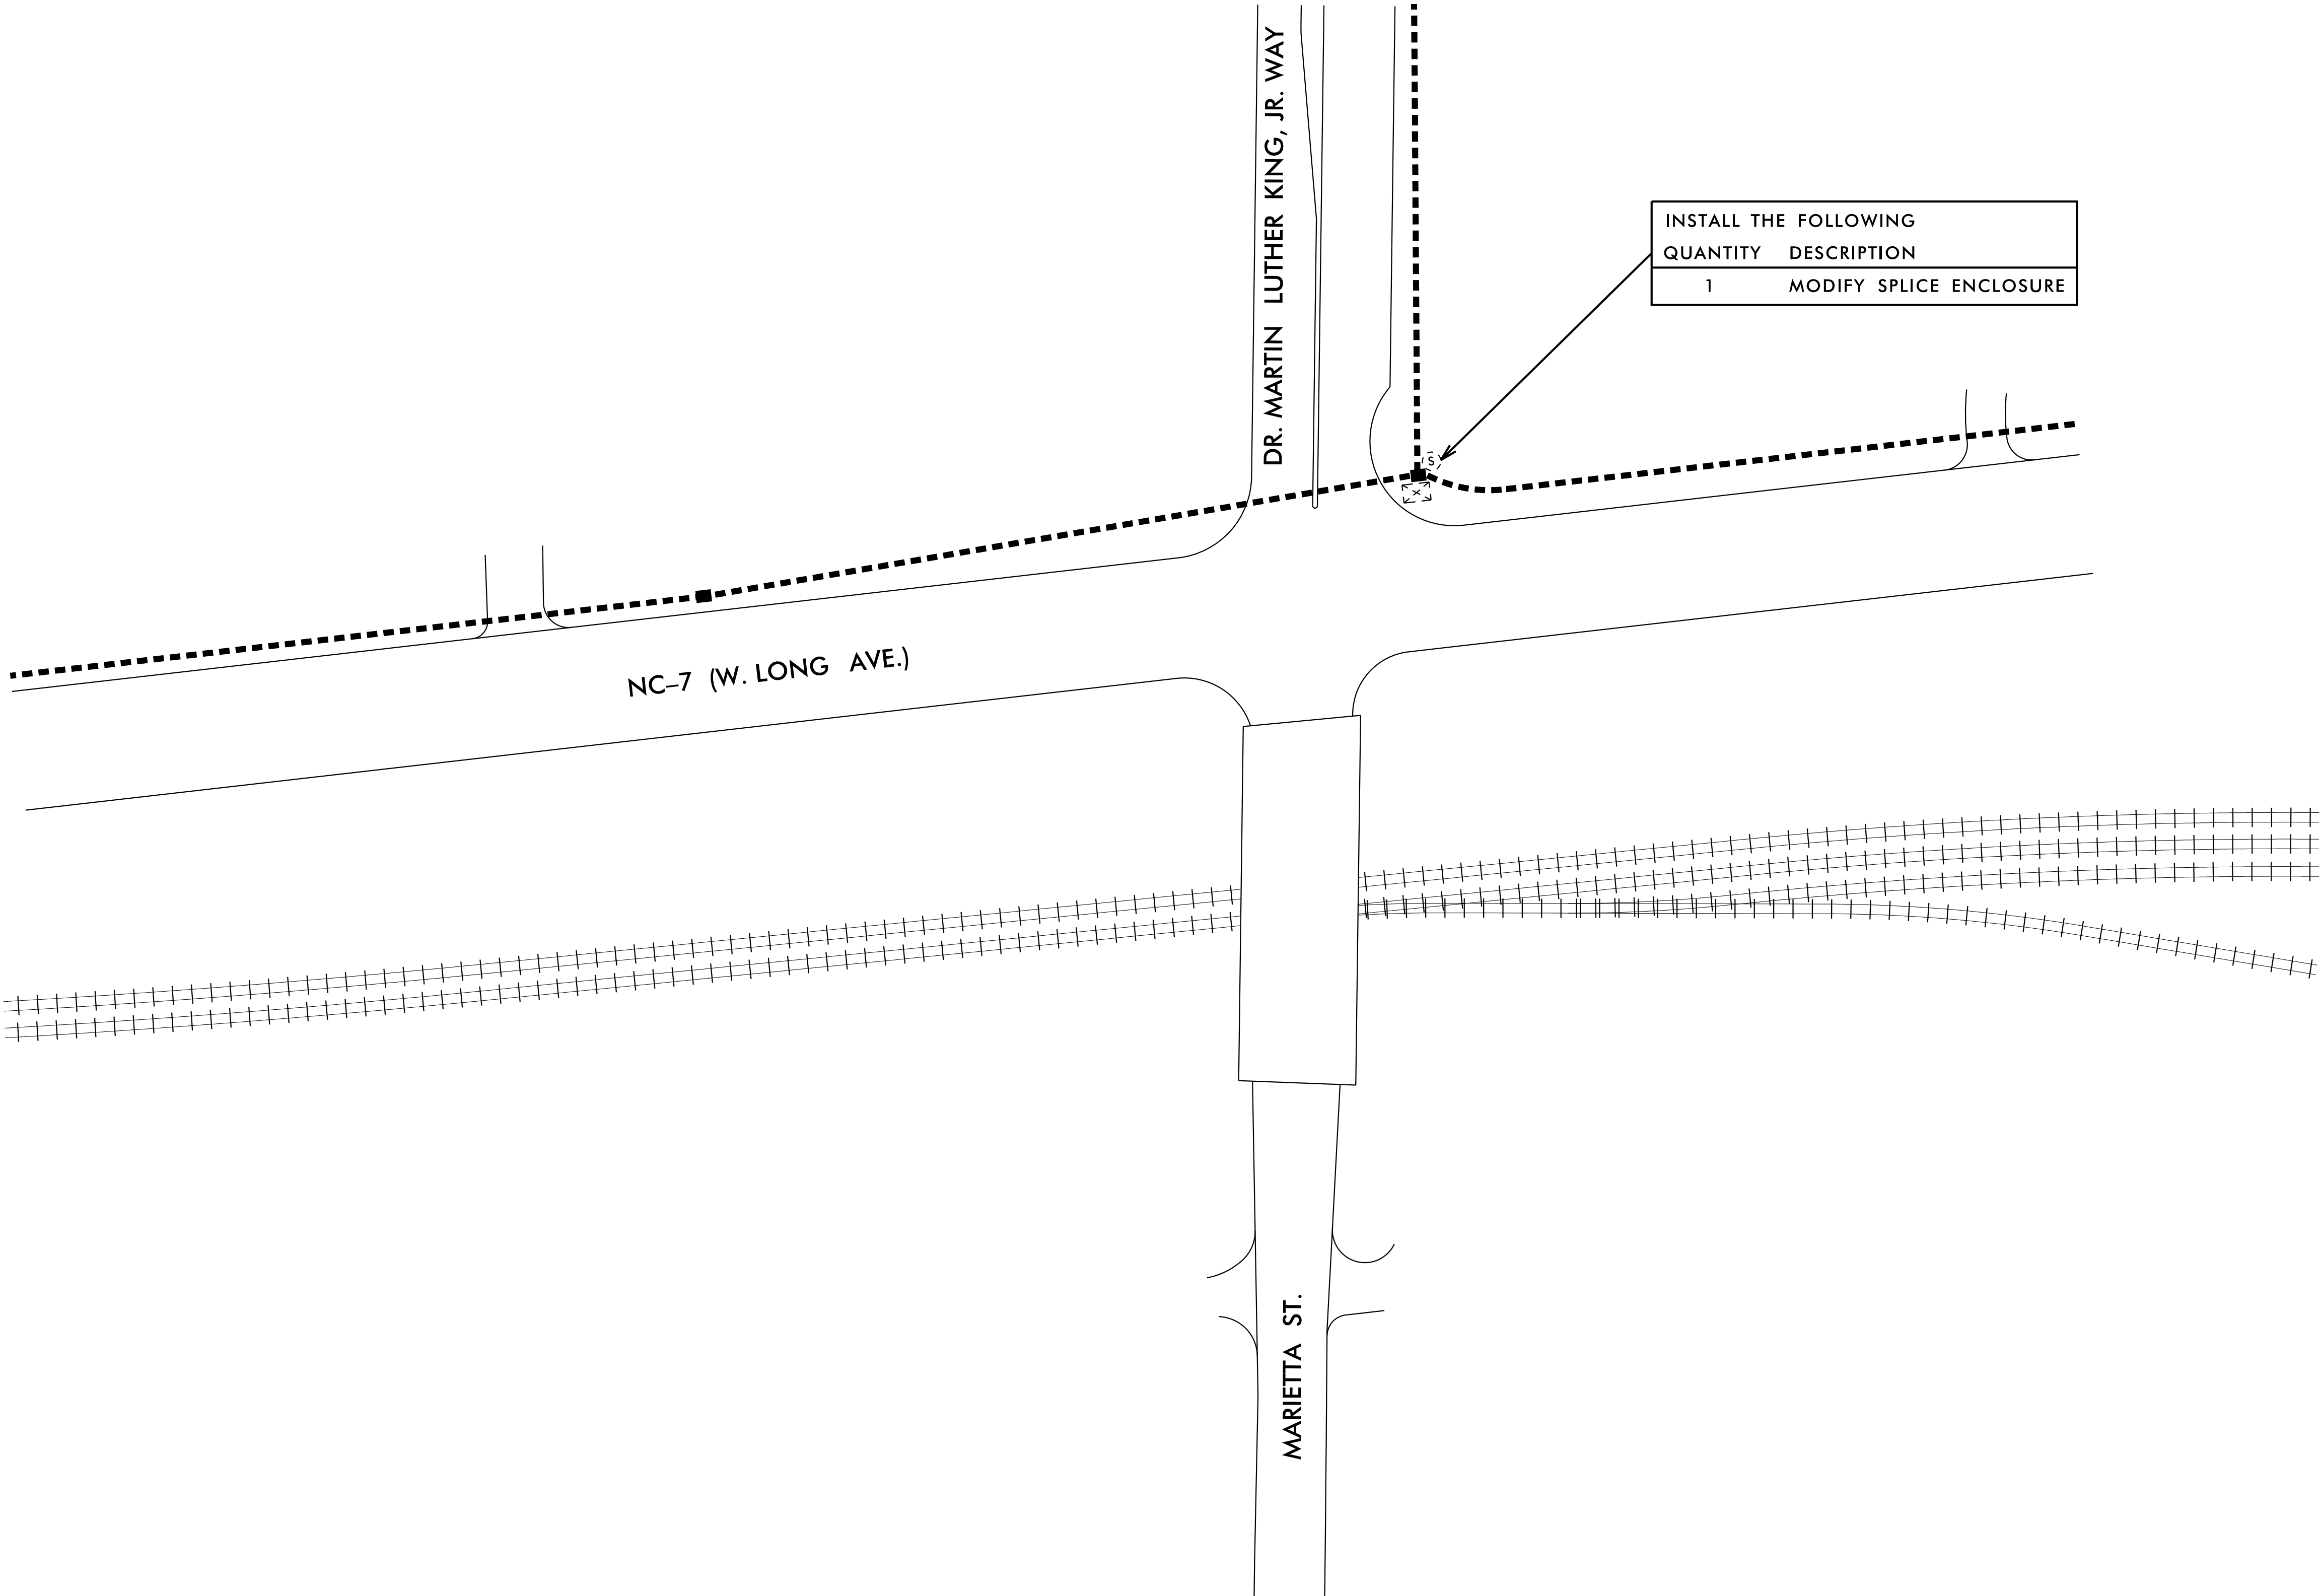


3/26/2019
K:\ARL\TPTD\ITS\01036443 I-85 ICM\6 Tasks\3 PS&E\Plans\C-5600.ITS_psh18A.dgn

Kimley»Horn
NC License #F-0102
421 Fayetteville St., Suite 600
Raleigh, NC 27636
Tel: (919) 677-2000
Fax: (919) 677-2050

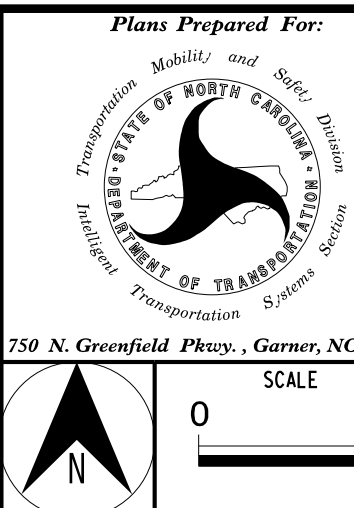

I-85 INTEGRATED CORRIDOR MANAGEMENT SYSTEM SIGNING AND DEVICE PLAN			
DIVISION 10		MECKLENBURG/GASTON COUNTIES	
PLAN DATE:	FEB 2019	REVIEWED BY:	A. GOOD
PREPARED BY:	J. CROSS	REVIEWED BY:	K. SMITH
REVISIONS	INIT.	DATE	

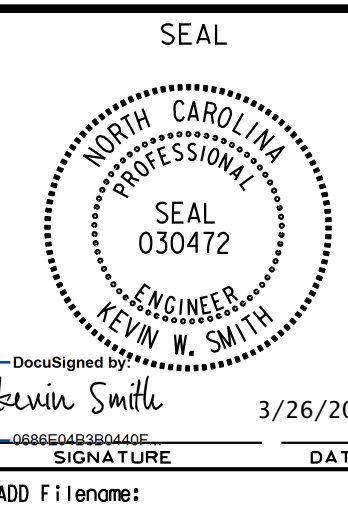

DocuSigned by
Kevin W. Smith
0686E74B3D044CF
SIGNATURE DATE
CADD Filename: _____

INSTALL THE FOLLOWING	
QUANTITY	DESCRIPTION
1	REMOVE EXISTING SIGN PANEL
1	CHANGEABLE TRAILBLAZER SIGN ASSEMBLY (TYPE 2A)

INSTALL THE FOLLOWING	
QUANTITY	DESCRIPTION
1	REMOVE EXISTING SIGN PANEL
1	CHANGEABLE TRAILBLAZER SIGN ASSEMBLY (TYPE 2B)

INSTALL THE FOLLOWING	
QUANTITY	DESCRIPTION
100 LF	DIRECTIONAL DRILL (1) (2")
2	JUNCTION BOX (STANDARD SIZE)
100 LF	SIGNAL CABLE (TB-08)
100 LF	SIGNAL CABLE (TB-09)

INSTALL THE FOLLOWING	
QUANTITY	DESCRIPTION
300 LF	DIRECTIONAL DRILL (1) (2")
1	JUNCTION BOX (STANDARD SIZE)
300 LF	SIGNAL CABLE (TB-08)

INSTALL THE FOLLOWING	
QUANTITY	DESCRIPTION
250 LF	DIRECTIONAL DRILL (1) (2")
1	JUNCTION BOX (STANDARD SIZE)
250 LF	SIGNAL CABLE (TB-11)

INSTALL THE FOLLOWING	
QUANTITY	DESCRIPTION
300 LF	DIRECTIONAL DRILL (1) (2")
2	JUNCTION BOX (STANDARD SIZE)
300 LF	SIGNAL CABLE (TB-10)
300 LF	SIGNAL CABLE (TB-11)


INSTALL THE FOLLOWING	
QUANTITY	DESCRIPTION
1	CONDUIT ENTRANCE INTO EXISTING FOUNDATION

INSTALL THE FOLLOWING	
QUANTITY	DESCRIPTION
1	REMOVE EXISTING SIGN PANEL
1	CHANGEABLE TRAILBLAZER SIGN ASSEMBLY (TYPE 1A)

INSTALL THE FOLLOWING	
QUANTITY	DESCRIPTION
1	REMOVE EXISTING SIGN PANEL
1	CHANGEABLE TRAILBLAZER SIGN ASSEMBLY (TYPE 1B)

3/25/2019 10:03:44 AM I-85 ICMV6 Tasks\3 PS&E\Plans\C-5600.ITB.psh20.dgn

Kimley»Horn
NC License #F-0102
421 Fayetteville St., Suite 600
Raleigh, NC 27636
Tel: (919) 677-2000
Fax: (919) 677-2050

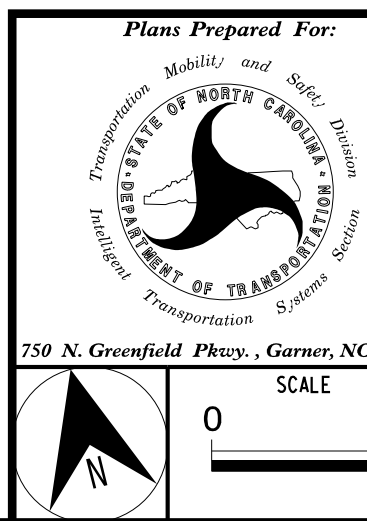

I-85 INTEGRATED CORRIDOR MANAGEMENT SYSTEM SIGNING AND DEVICE PLAN		SEAL
DIVISION 10 MECKLENBURG/GASTON COUNTIES		
PLAN DATE: FEB 2019	REVIEWED BY: A. GOOD	
PREPARED BY: J. CROSS	REVIEWED BY: K. SMITH	
REVISIONS		
INIT.	DATE	DocuSign Kevin W. Smith 3/26/2019 CADD Filename:

INSTALL THE FOLLOWING	
QUANTITY	DESCRIPTION
1	REMOVE EXISTING SIGN PANEL
1	CHANGEABLE TRAILBLAZER SIGN ASSEMBLY (TYPE 2A)

INSTALL THE FOLLOWING	
QUANTITY	DESCRIPTION
1	REMOVE EXISTING SIGN PANEL
1	CHANGEABLE TRAILBLAZER SIGN ASSEMBLY (TYPE 2B)

INSTALL THE FOLLOWING	
QUANTITY	DESCRIPTION
80 LF	UNPAVED TRENCH (1) (2")
2	JUNCTION BOX (STANDARD SIZE)
80 LF	SIGNAL CABLE (TB-12)
80 LF	SIGNAL CABLE (TB-13)

INSTALL THE FOLLOWING	
QUANTITY	DESCRIPTION
620 LF	DIRECTIONAL DRILL (1) (2")
2	JUNCTION BOX (STANDARD SIZE)
620 LF	SIGNAL CABLE (TB-12)


INSTALL THE FOLLOWING	
QUANTITY	DESCRIPTION
230 LF	DIRECTIONAL DRILL (1) (2")
90 LF	UNPAVED TRENCH (1) (2")
3	JUNCTION BOX (STANDARD SIZE)
320 LF	SIGNAL CABLE (TB-14)
320 LF	SIGNAL CABLE (TB-15)

INSTALL THE FOLLOWING	
QUANTITY	DESCRIPTION
450 LF	UNPAVED TRENCH (1) (2")
1	JUNCTION BOX (STANDARD SIZE)
450 LF	SIGNAL CABLE (TB-15)

INSTALL THE FOLLOWING	
QUANTITY	DESCRIPTION
1	REMOVE EXISTING SIGN PANEL
1	CHANGEABLE TRAILBLAZER SIGN ASSEMBLY (TYPE 1A)


INSTALL THE FOLLOWING	
QUANTITY	DESCRIPTION
1	CONDUIT ENTRANCE INTO EXISTING FOUNDATION

INSTALL THE FOLLOWING	
QUANTITY	DESCRIPTION
1	REMOVE EXISTING SIGN PANEL
1	CHANGEABLE TRAILBLAZER SIGN ASSEMBLY (TYPE 1B)

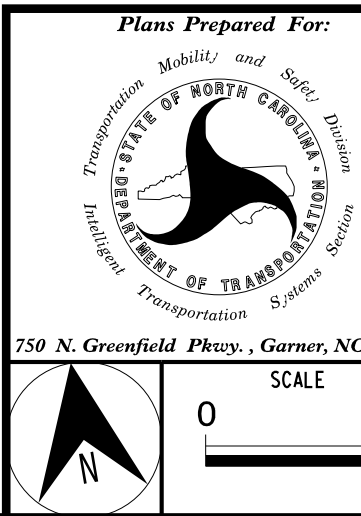


I-85 INTEGRATED CORRIDOR
MANAGEMENT SYSTEM
SIGNING AND DEVICE PLAN

DIVISION 10		MECKLENBURG/GASTON COUNTIES	
PLAN DATE:	FEB 2019	REVIEWED BY:	A. GOOD
PREPARED BY:	J. CROSS	REVIEWED BY:	K. SMITH
REVISIONS		INIT.	DATE

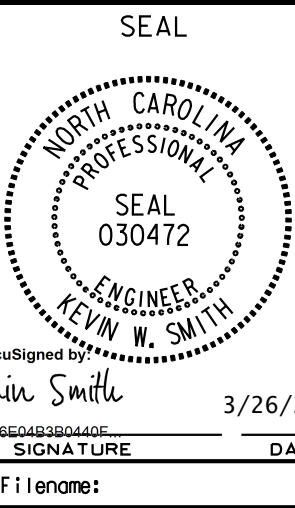


Kimley»Horn
NC License #F-0102
421 Fayetteville St., Suite 600
Raleigh, NC 27636
Tel: (919) 677-2000
Fax: (919) 677-2050

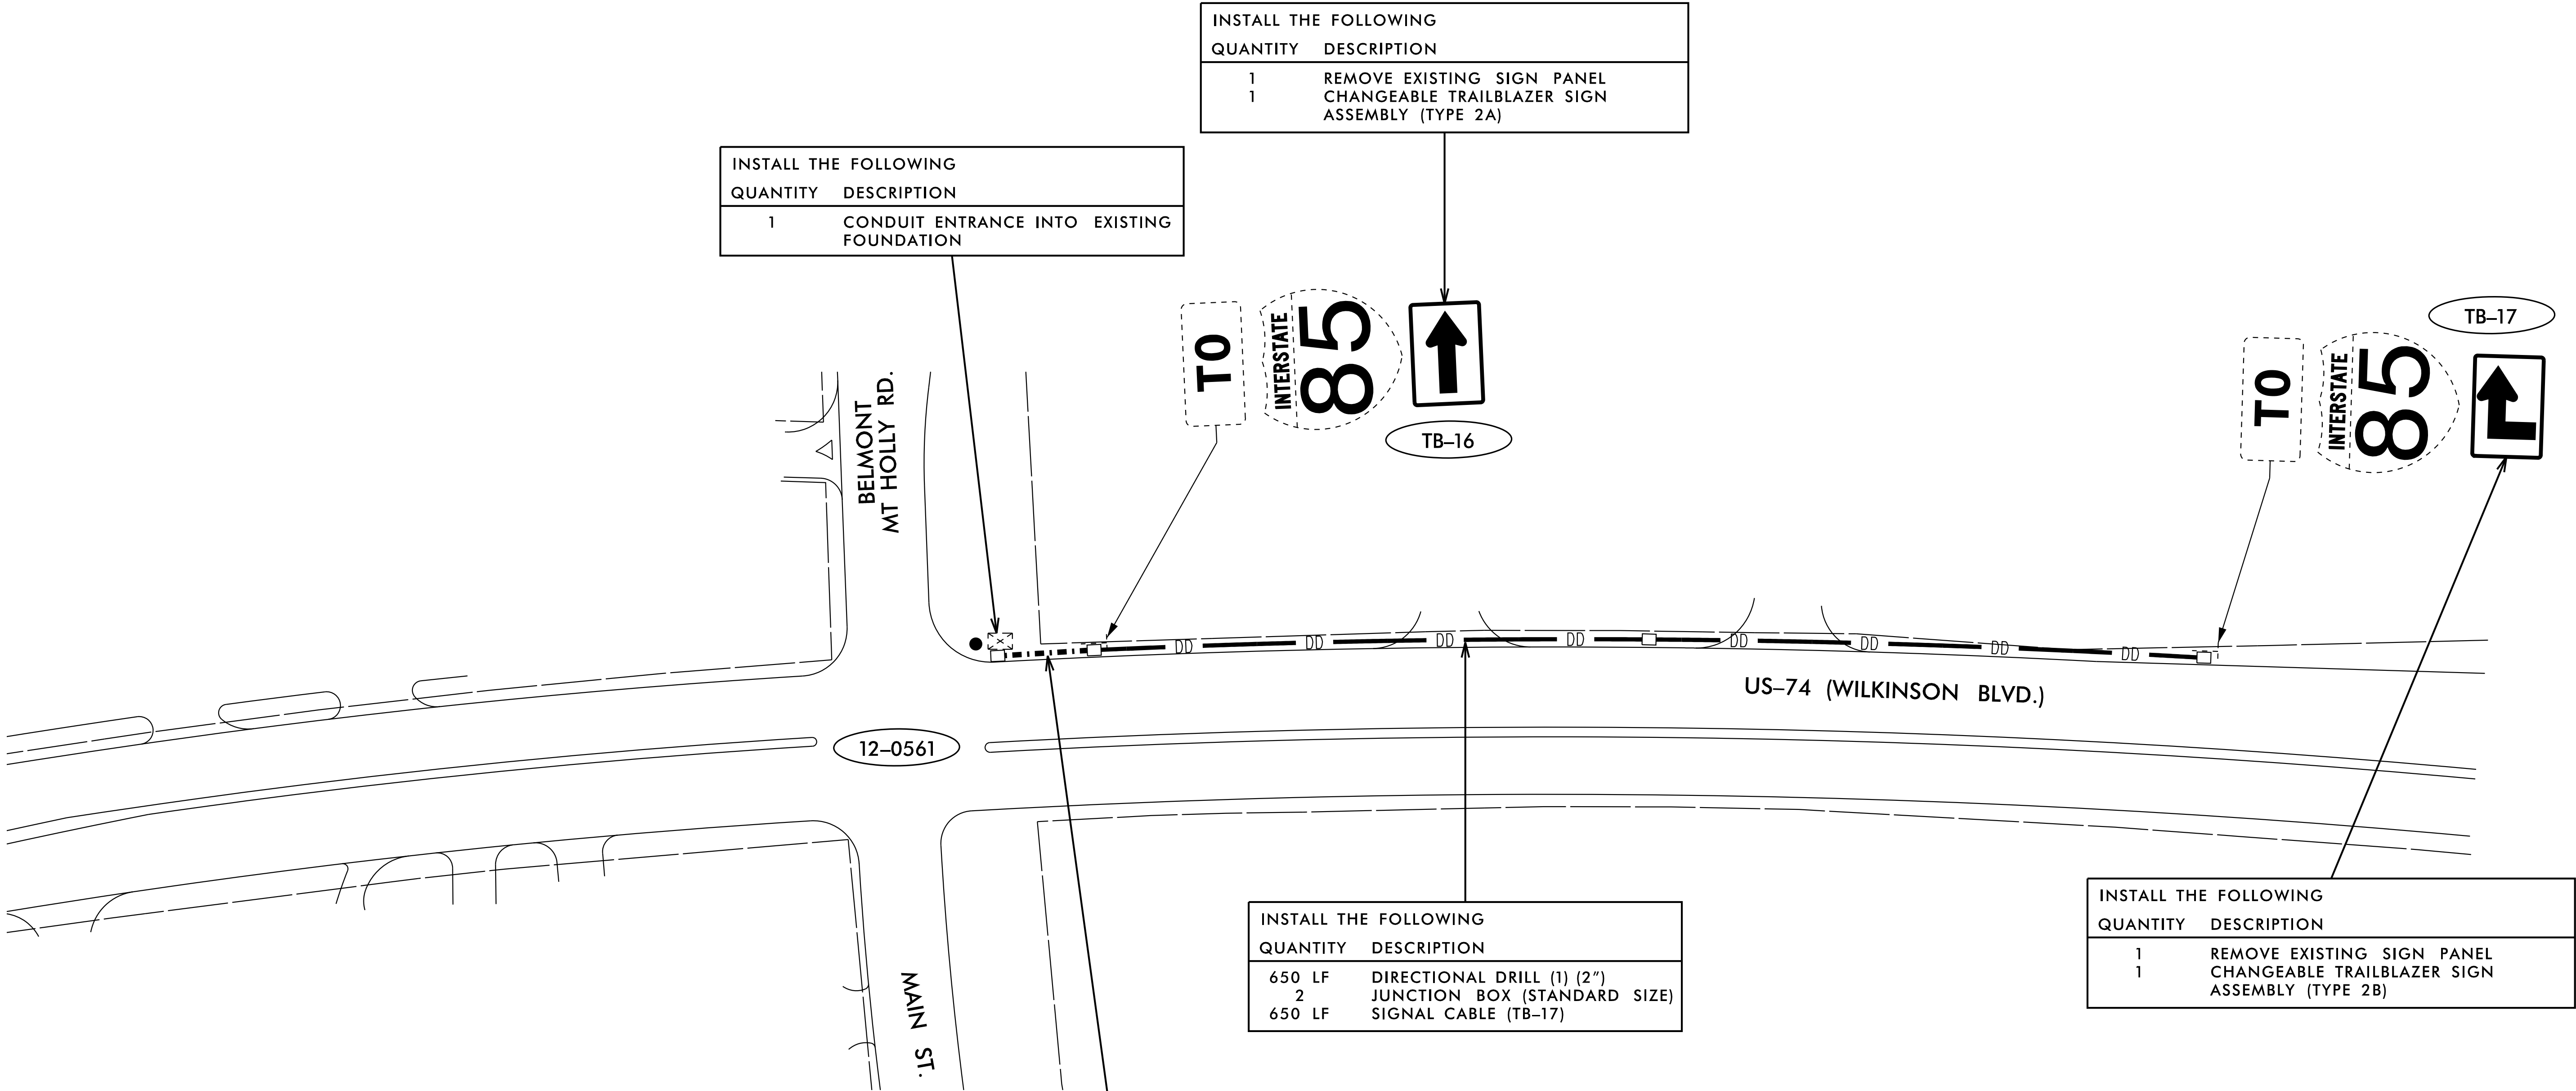



3/25/2019
K:\ARL\TPTD\ITS\01036443 I-85 ICM\6 Tasks\3 PS&E\Plans\C-5600.ITS_psh22.dgn

Kimley»Horn
NC License #F-0102
421 Fayetteville St., Suite 600
Raleigh, NC 27636
Tel: (919) 677-2000
Fax: (919) 677-2050

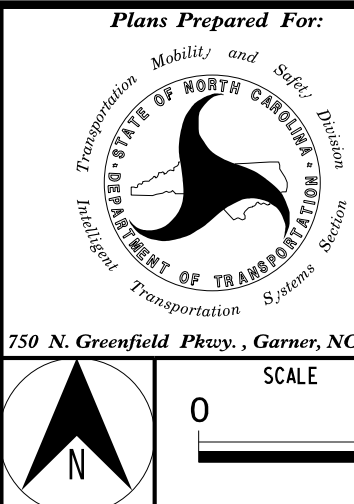

I-85 INTEGRATED CORRIDOR MANAGEMENT SYSTEM			
SIGNING AND DEVICE PLAN			
DIVISION 10		MECKLENBURG/GASTON COUNTIES	
PLAN DATE:	FEB 2019	REVIEWED BY:	A. GOOD
PREPARED BY:	J. CROSS	REVIEWED BY:	K. SMITH
REVISIONS	INIT.	DATE	

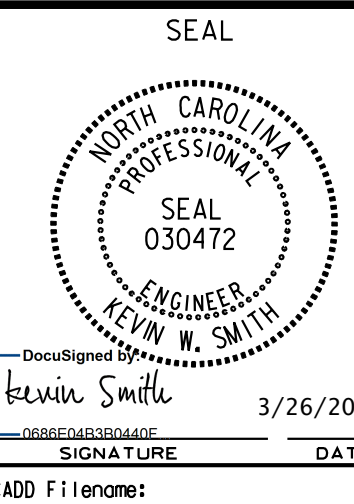

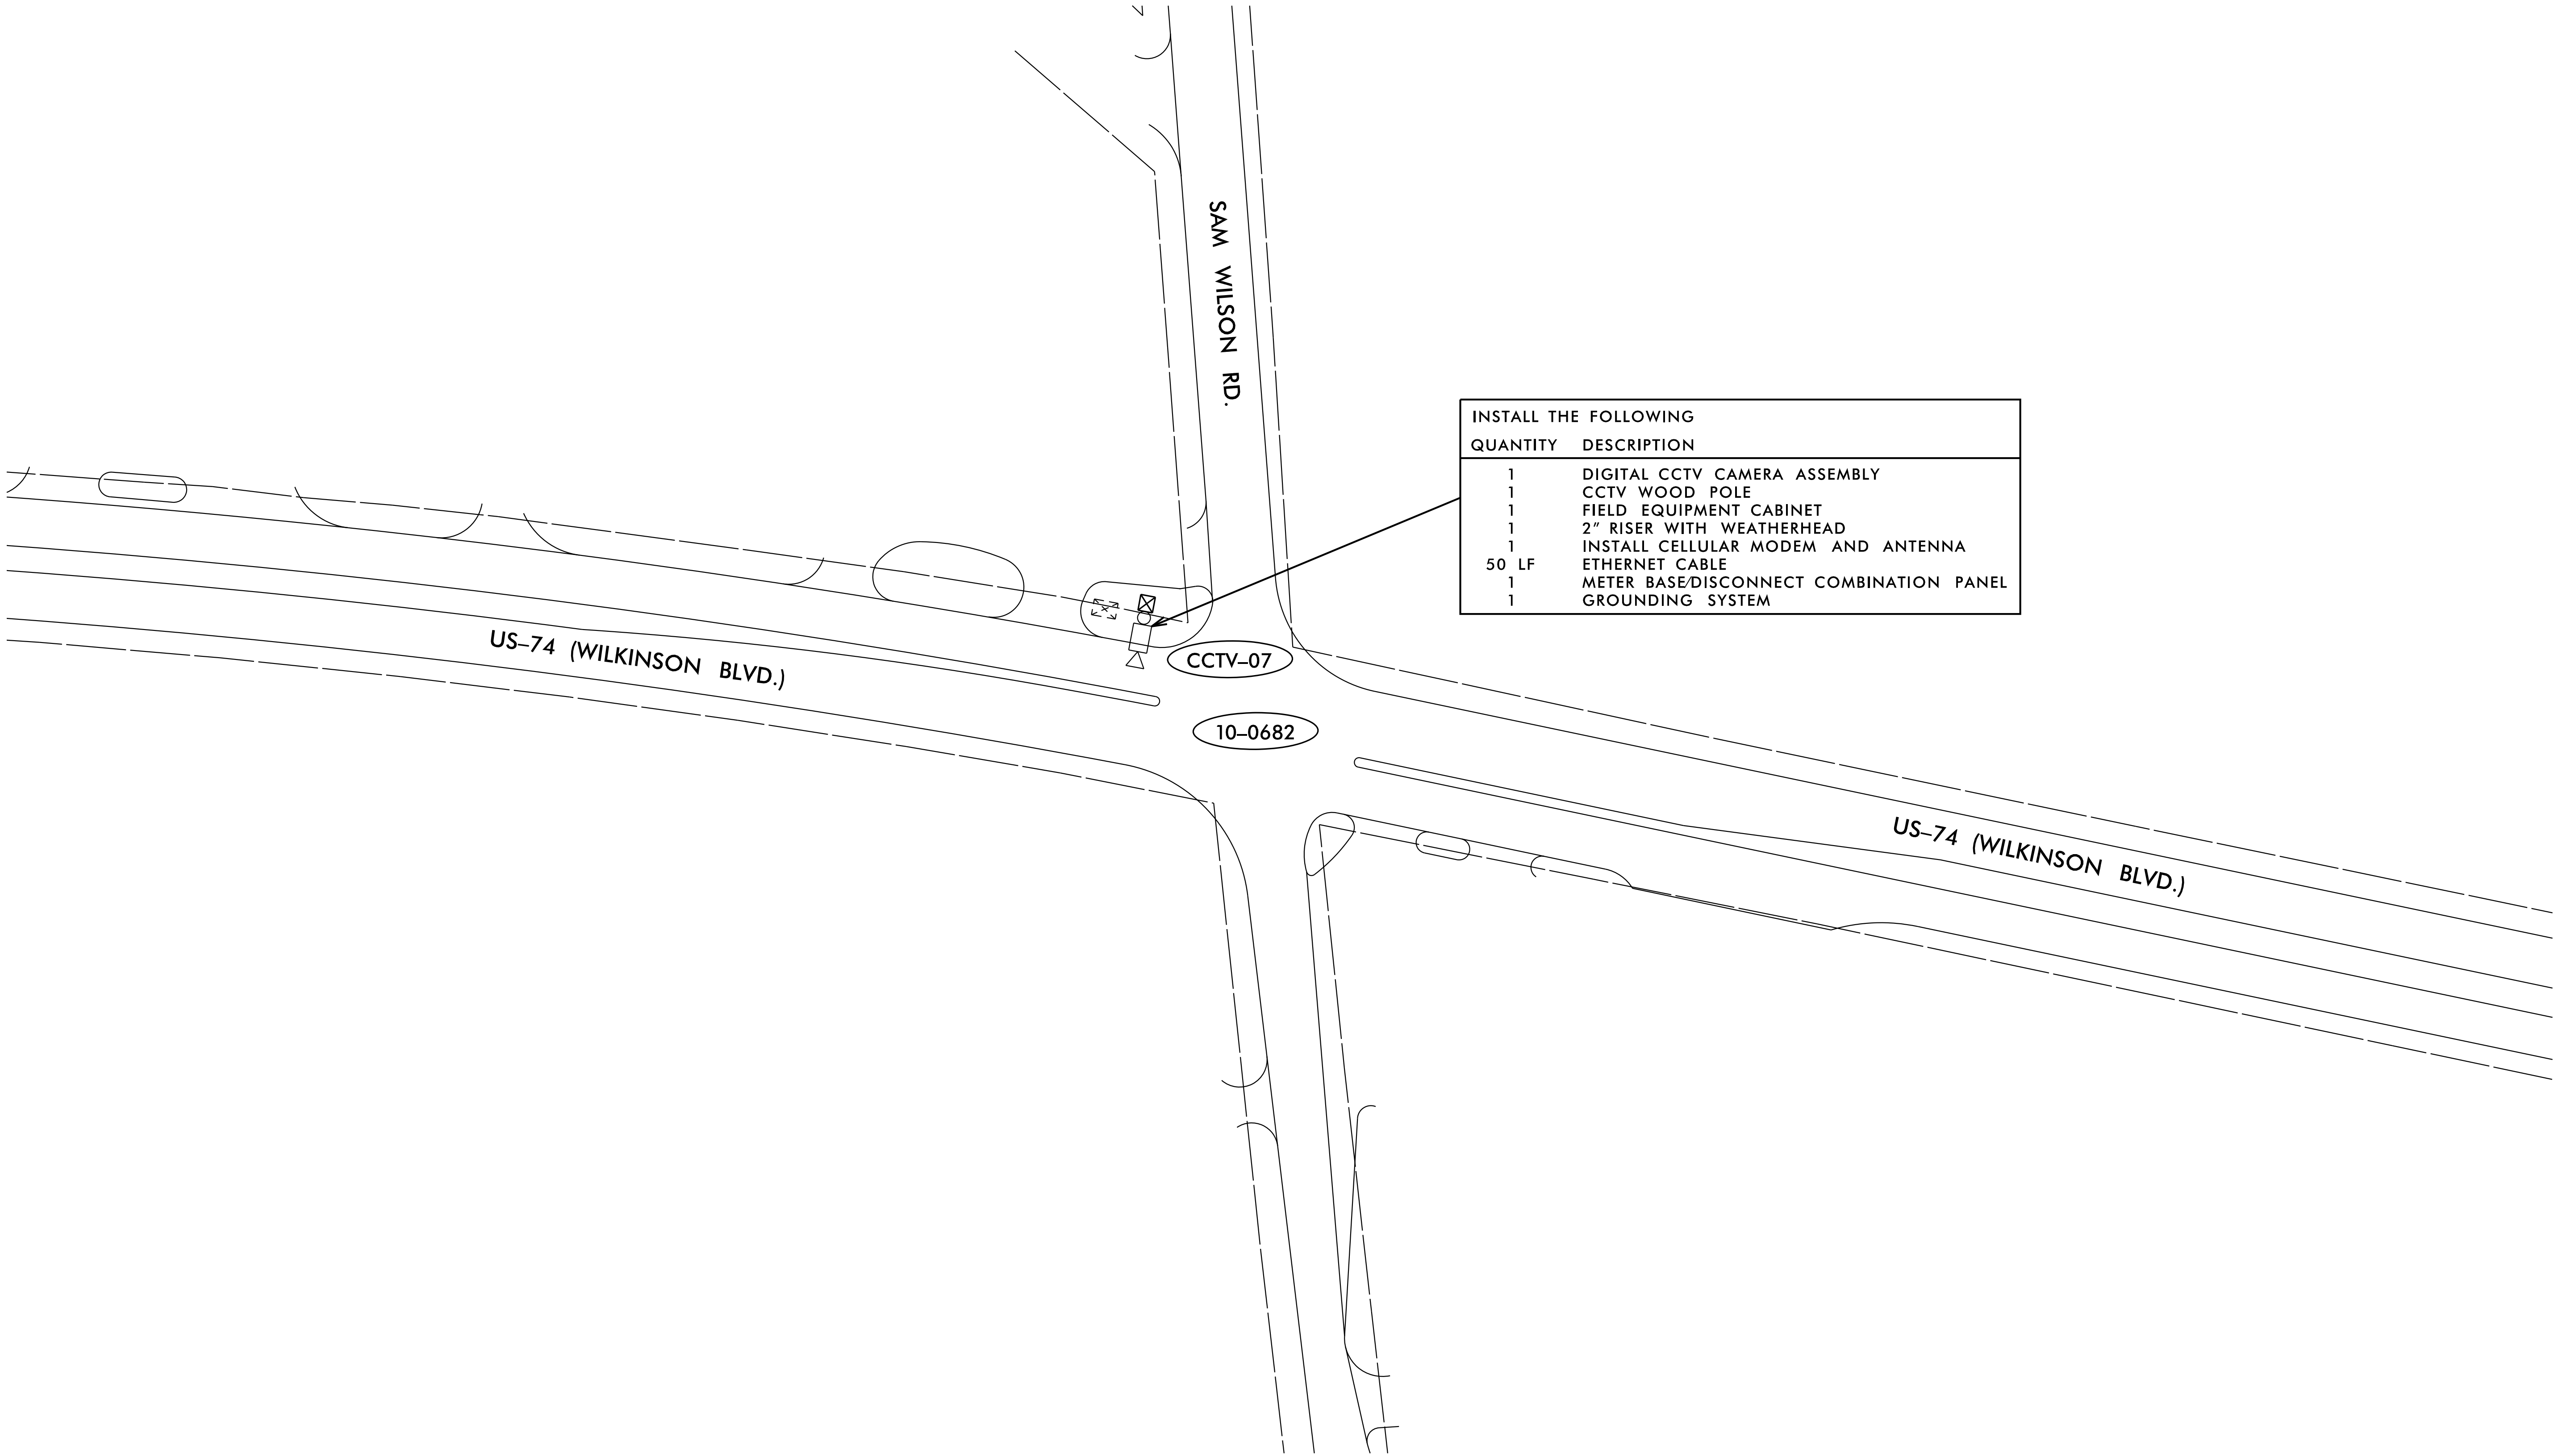

Kimley»Horn
NC License #F-0102
421 Fayetteville St., Suite 600
Raleigh, NC 27636
Tel: (919) 677-2000
Fax: (919) 677-2050

Plans Prepared For:

750 N. Greenfield Pkwy., Garner, NC 27529

750 N. Greenfield Pkwy., Garner, NC 27529



0 50
SCALE

I-85 INTEGRATED CORRIDOR MANAGEMENT SYSTEM SIGNING AND DEVICE PLAN			
DIVISION 10		MECKLENBURG/GASTON COUNTIES	
PLAN DATE:	FEB 2019	REVIEWED BY:	A. GOOD
PREPARED BY:	J. CROSS	REVIEWED BY:	K. SMITH
REVISIONS		INIT.	DATE


SEAL

NORTH CAROLINA
PROFESSIONAL
SEAL
030472
ENGINEER
KEVIN W. SMITH

DocuSigned by
Kevin W. Smith
3/26/2019

SIGNATURE DATE


CADD Filename:

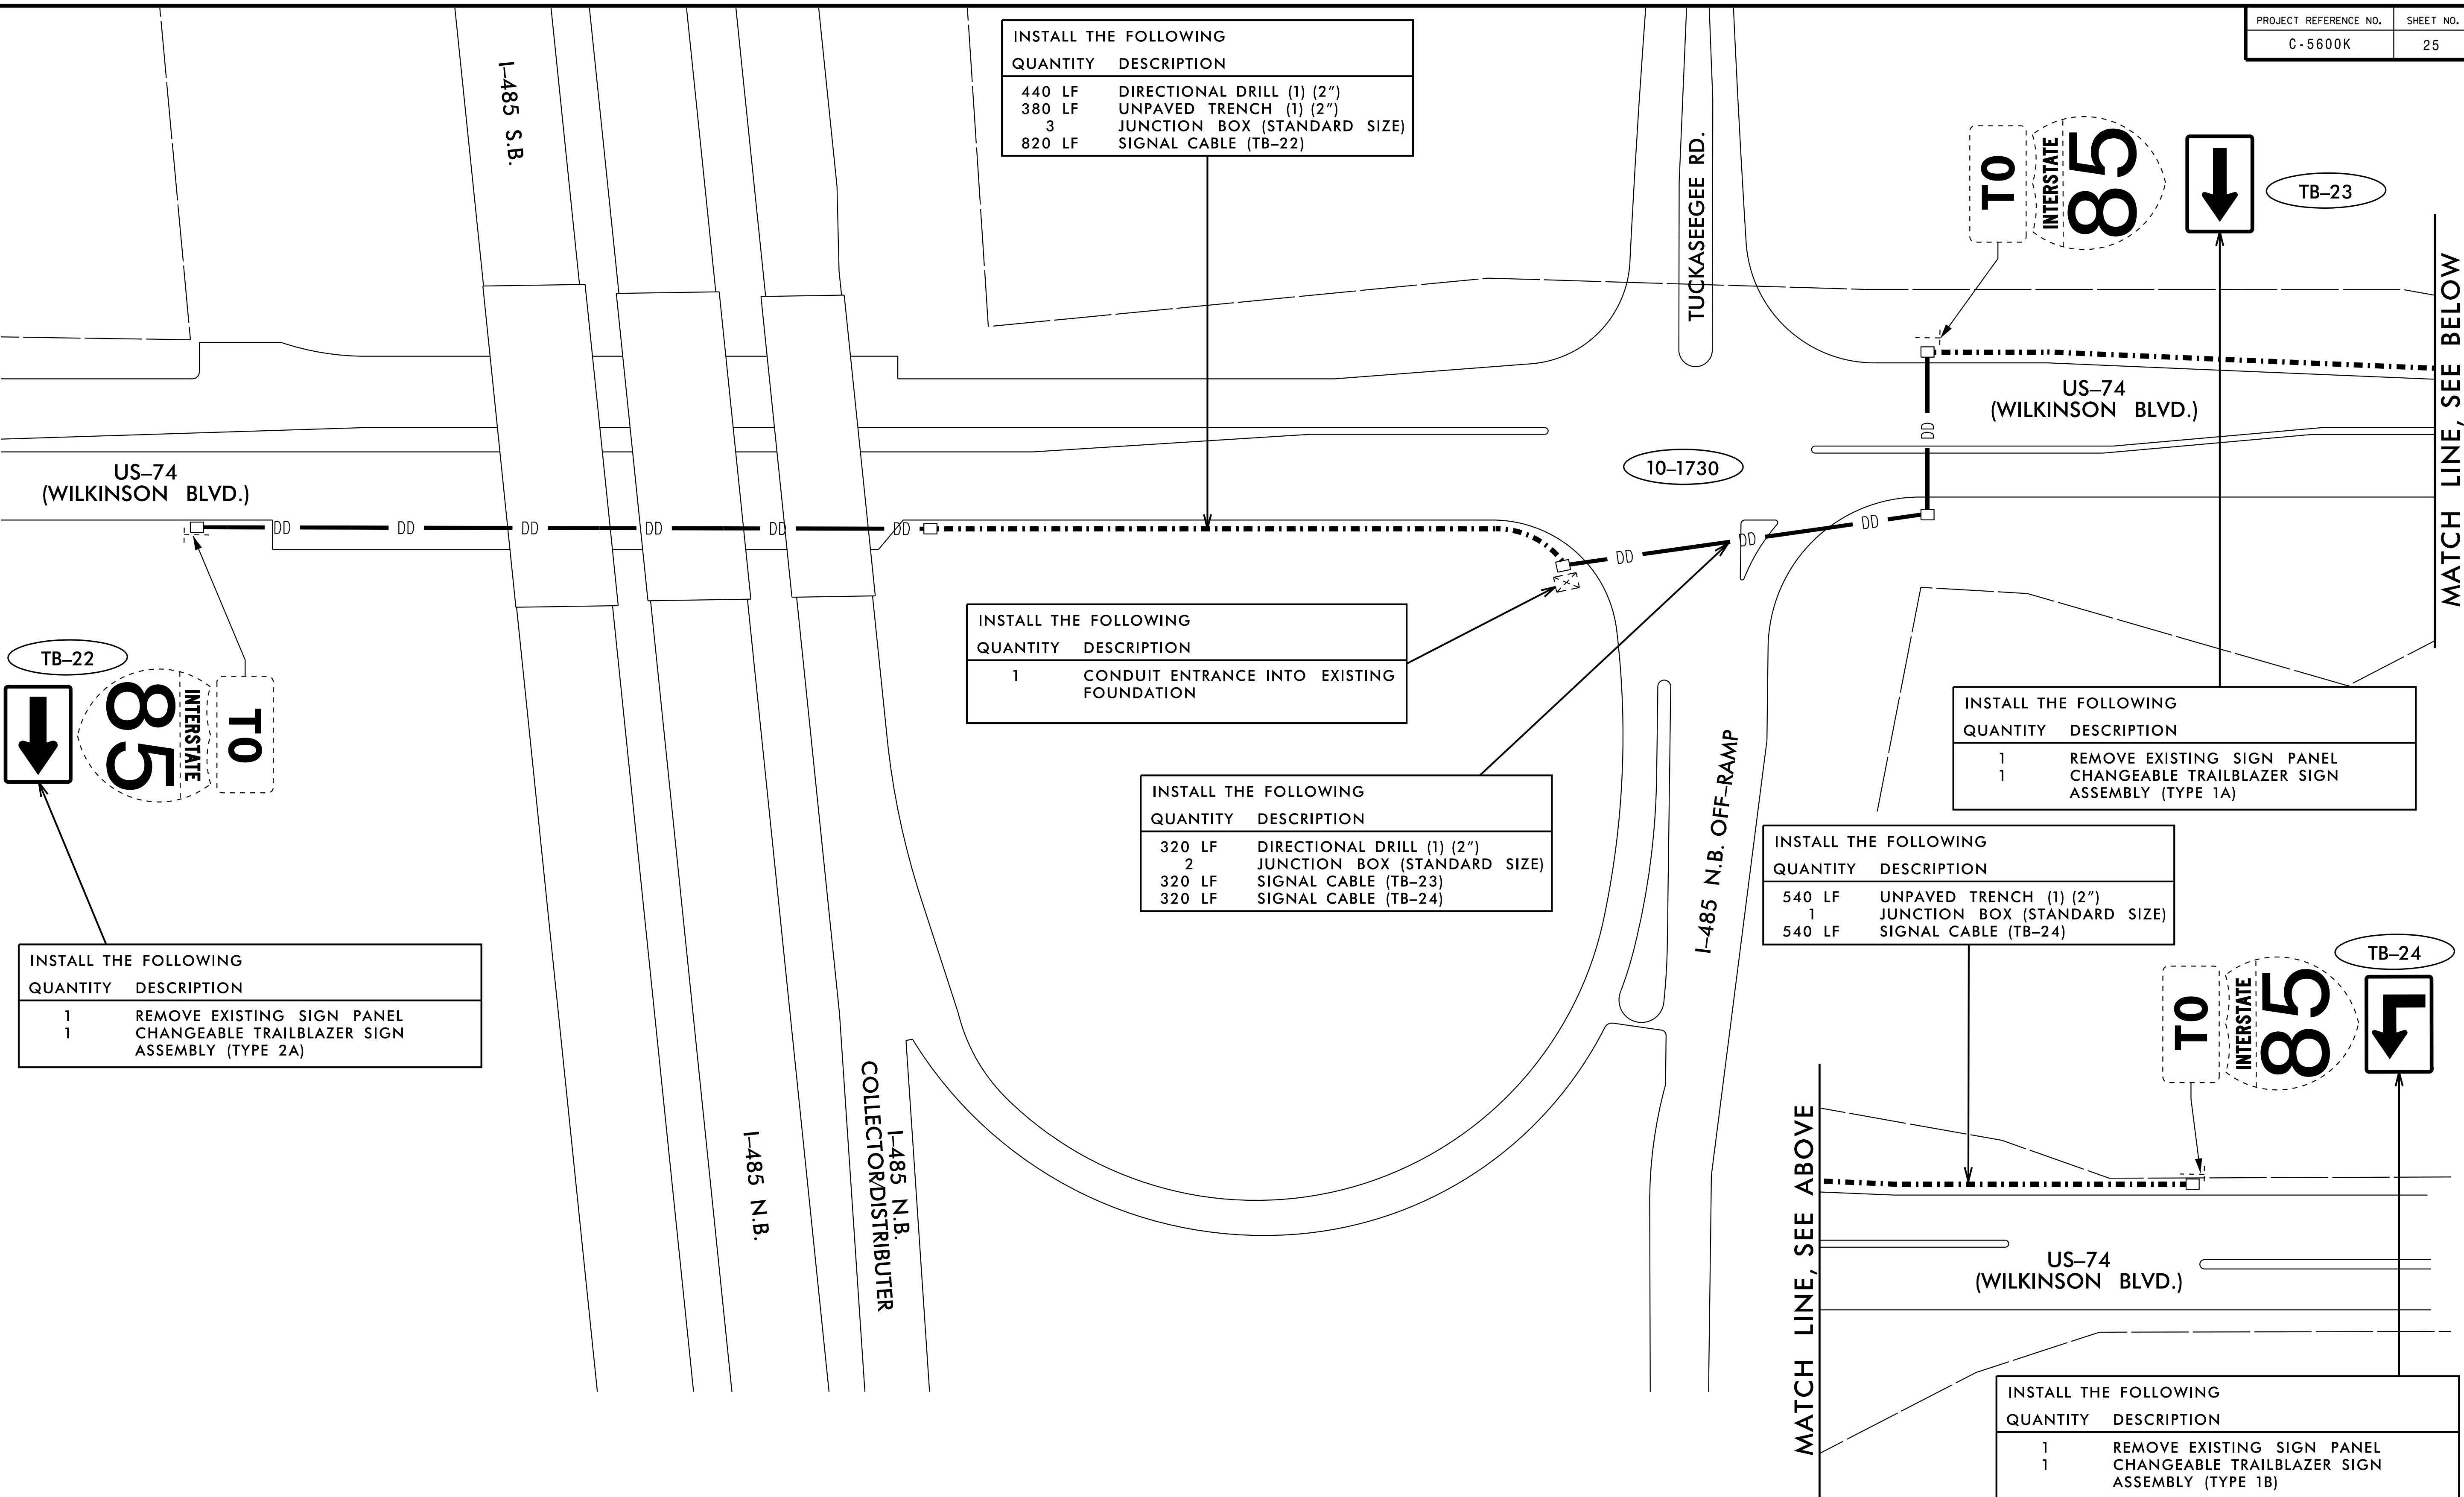

3/25/2019
K:\ARL\TPTD\ITS\01036443 I-85 ICM\6 Tasks\3 PS&E\Plans\C-5600.ITS_psh25.dgn

Kimley»Horn
NC License #F-0102
421 Fayetteville St., Suite 600
Raleigh, NC 27636
Tel: (919) 677-2000
Fax: (919) 677-2050

Plans Prepared For:

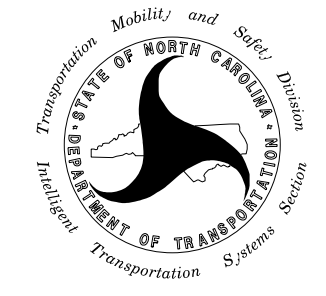

750 N. Greenfield Pkwy., Garner, NC 27529




SCALE 0 50

I-85 INTEGRATED CORRIDOR MANAGEMENT SYSTEM

SIGNING AND DEVICE PLAN

DIVISION 10		MECKLENBURG/GASTON COUNTIES	
PLAN DATE: FEB 2019	REVIEWED BY: A. GOOD		
PREPARED BY: J. CROSS	REVIEWED BY: K. SMITH		
REVISIONS		INIT.	DATE

SEAL

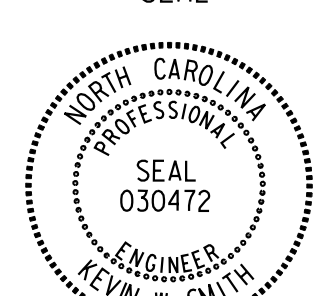

DocuSigned by
Kevin W. Smith
3/26/2019

SIGNATURE DATE

CADD Filename:

INSTALL THE FOLLOWING	
QUANTITY	DESCRIPTION
1	DMS
1	DMS PEDESTAL STRUCTURE
1	DMS ACCESS LADDER
8 CY	ITS OVERHEAD FOOTINGS
1	INSTALL CELLULAR MODEM AND ANTENNA
1	METER BASE/DISCONNECT COMBINATION PANEL
1	GROUNDING SYSTEM

DMS-02


I-85 S.B.

I-85 N.B.


TUCKASEEGEE RD.

3/25/2019
K:\ARL\TPTD\ITS\01036443 I-85 ICM\6 Tasks\3 PS&E\Plans\C-5600.ITS.psh26.dgn

Kimley»Horn
NC License #F-0102
421 Fayetteville St., Suite 600
Raleigh, NC 27636
Tel: (919) 677-2000
Fax: (919) 677-2050

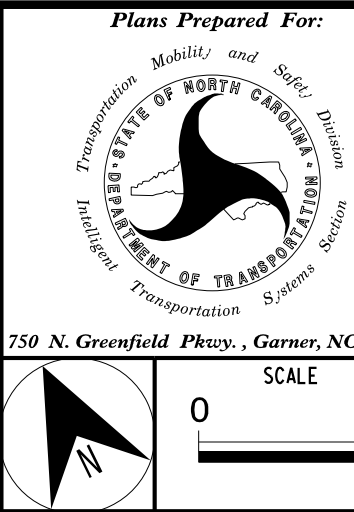

I-85 INTEGRATED CORRIDOR MANAGEMENT SYSTEM SIGNING AND DEVICE PLAN			
DIVISION 10		MECKLENBURG/GASTON COUNTIES	
PLAN DATE:	FEB 2019	REVIEWED BY:	A. GOOD
PREPARED BY:	J. CROSS	REVIEWED BY:	K. SMITH
REVISIONS	INIT.	DATE	

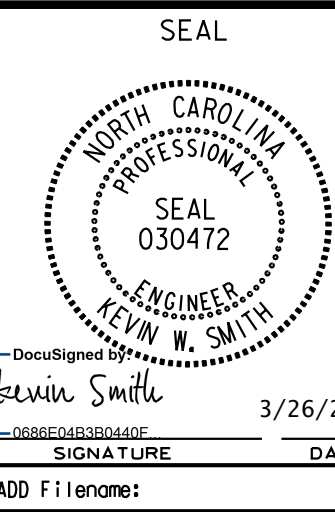

DocuSign
Kevin W. Smith
3/26/2019
SIGNATURE DATE
CADD Filename:

EXIT 17

321

Gastonia
Lincolnton
1/2 Mile

INSTALL THE FOLLOWING	
QUANTITY	DESCRIPTION
1	DIGITAL CCTV CAMERA ASSEMBLY
1	CCTV WOOD POLE
1	FIELD EQUIPMENT CABINET
1	2" RISER WITH WEATHERHEAD
1	INSTALL CELLULAR MODEM AND ANTENNA
50 LF	ETHERNET CABLE
1	METER BASE/DISCONNECT COMBINATION PANEL
1	GROUNDING SYSTEM


CCTV-09

I-85 N.B.


I-85 S.B.

3/25/2019
K:\ARL\TPTD\ITS\01036443 I-85 ICM\6 Tasks\3 PS&E\Plans\C-5600.ITS_psh28.dgn

Kimley»Horn
NC License #F-0102
421 Fayetteville St., Suite 600
Raleigh, NC 27636
Tel: (919) 677-2000
Fax: (919) 677-2050

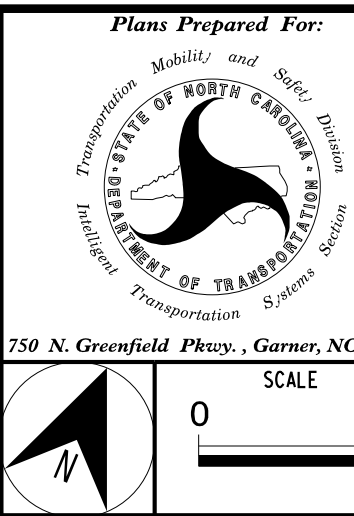

I-85 INTEGRATED CORRIDOR MANAGEMENT SYSTEM SIGNING AND DEVICE PLAN			
DIVISION 10		MECKLENBURG/GASTON COUNTIES	
PLAN DATE:	FEB 2019	REVIEWED BY:	A. GOOD
PREPARED BY:	J. CROSS	REVIEWED BY:	K. SMITH
REVISIONS		INIT.	DATE

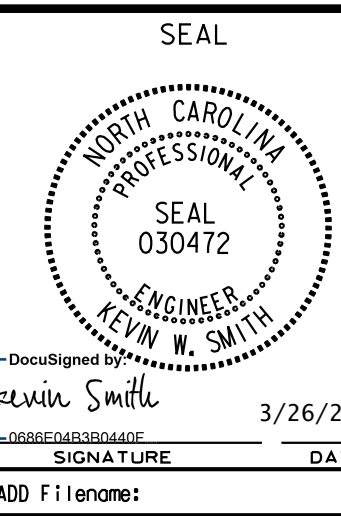

INSTALL THE FOLLOWING	
QUANTITY	DESCRIPTION
1	DIGITAL CCTV CAMERA ASSEMBLY
1	CCTV WOOD POLE
1	FIELD EQUIPMENT CABINET
1	2" RISER WITH WEATHERHEAD
1	INSTALL CELLULAR MODEM AND ANTENNA
50 LF	ETHERNET CABLE
1	METER BASE/DISCONNECT COMBINATION PANEL
1	GROUNDING SYSTEM

CCTV-10

EXIT 17

321


Gastonia
Lincolnton
1 Mile

I-85 N.B.


I-85 S.B.

3/25/2019
K:\ARL\TPTD\ITS\01036443 I-85 ICM\6 Tasks\3 PS&E\Plans\C-5600.ITS.psh29.dgn


Kimley»Horn
NC License #F-0102
421 Fayetteville St., Suite 600
Raleigh, NC 27636
Tel: (919) 677-2000
Fax: (919) 677-2050

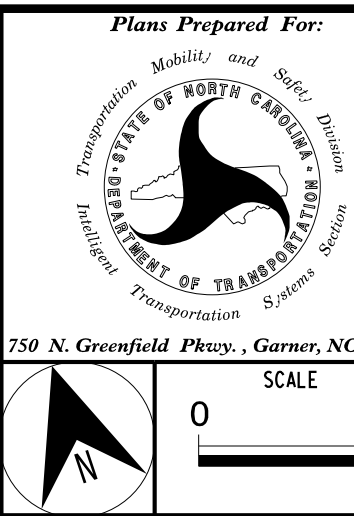

I-85 INTEGRATED CORRIDOR MANAGEMENT SYSTEM SIGNING AND DEVICE PLAN			
DIVISION 10		MECKLENBURG/GASTON COUNTIES	
PLAN DATE:	FEB 2019	REVIEWED BY:	A. GOOD
PREPARED BY:	J. CROSS	REVIEWED BY:	K. SMITH
REVISIONS	INIT.	DATE	

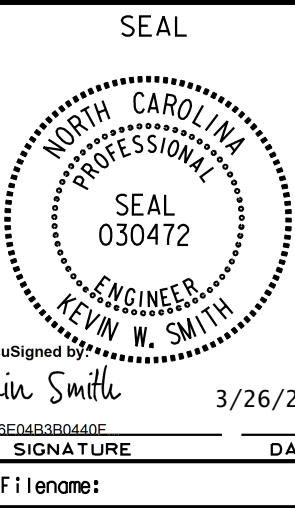

INSTALL THE FOLLOWING	
QUANTITY	DESCRIPTION
1	DIGITAL CCTV CAMERA ASSEMBLY
1	CCTV WOOD POLE
1	FIELD EQUIPMENT CABINET
1	2" RISER WITH WEATHERHEAD
1	INSTALL CELLULAR MODEM AND ANTENNA
50 LF	ETHERNET CABLE
1	METER BASE/DISCONNECT COMBINATION PANEL
1	GROUNDING SYSTEM

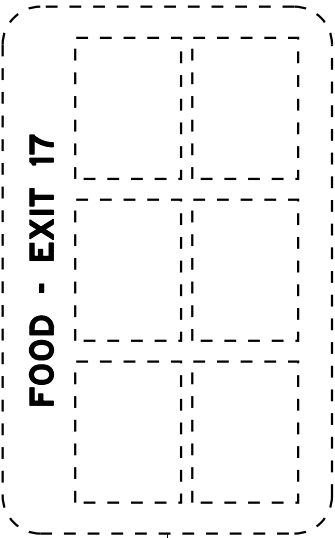

MODENA ST.



CCTV-11

I-85 S.B.

I-85 N.B.

3/25/2019
K:\ARL\TPTD\ITS\01036443 I-85 ICM\6 Tasks\3 PS&E\Plans\C-5600.ITS_psh30.dgn

Kimley»Horn
NC License #F-0102
421 Fayetteville St., Suite 600
Raleigh, NC 27636
Tel: (919) 677-2000
Fax: (919) 677-2050

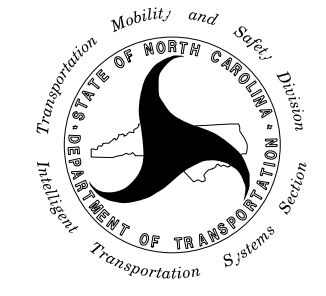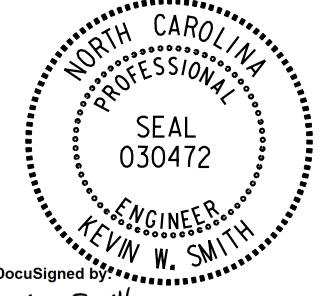 750 N. Greenfield Pkwy., Garner, NC 27529	I-85 INTEGRATED CORRIDOR MANAGEMENT SYSTEM SIGNING AND DEVICE PLAN		SEAL	
	DIVISION 10 MECKLENBURG/GASTON COUNTIES			
	PLAN DATE: FEB 2019	REVIEWED BY: A. GOOD		
	PREPARED BY: J. CROSS	REVIEWED BY: K. SMITH		
REVISIONS		INIT.	DATE	DocuSign Kevin W. Smith 3/26/2019 Signature Date CADD Filename:

12-0157
FRANKLIN BLVD AND EDGEWOOD RD
CHANNEL 1

COLOR CODE
TIA/EIA 598-C

(1) BLUE

(2) ORANGE

(3) GREEN

(4) BROWN

(5) SLATE

(6) WHITE

(7) RED

(8) BLACK

(9) YELLOW

(10) VIOLET

(11) ROSE

(12) AQUA

LEGEND

X – FUSION SPLICING INDIVIDUAL FIBER

O – EXISTING SPLICING

EXPRESS


EXPRESS ENTIRE BUFFER TUBE

SPLICE

SPLICE ENTIRE BUFFER TUBE OR MAINTAIN IF EXISTING EXPRESSED

NOTE:
CONTRACTOR IS RESPONSIBLE FOR FIELD VERIFYING EXISTING SPLICING. THE CONTRACTOR SHALL COORDINATE WITH THE ENGINEER WHERE EXISTING SPLICING IS NOT AS EXPECTED.

NOTES:
1. FIBER INTERCONNECT CENTER RACKS ARE SCHEMATIC ONLY – ACTUAL EQUIPMENT FORM MAY VARY.

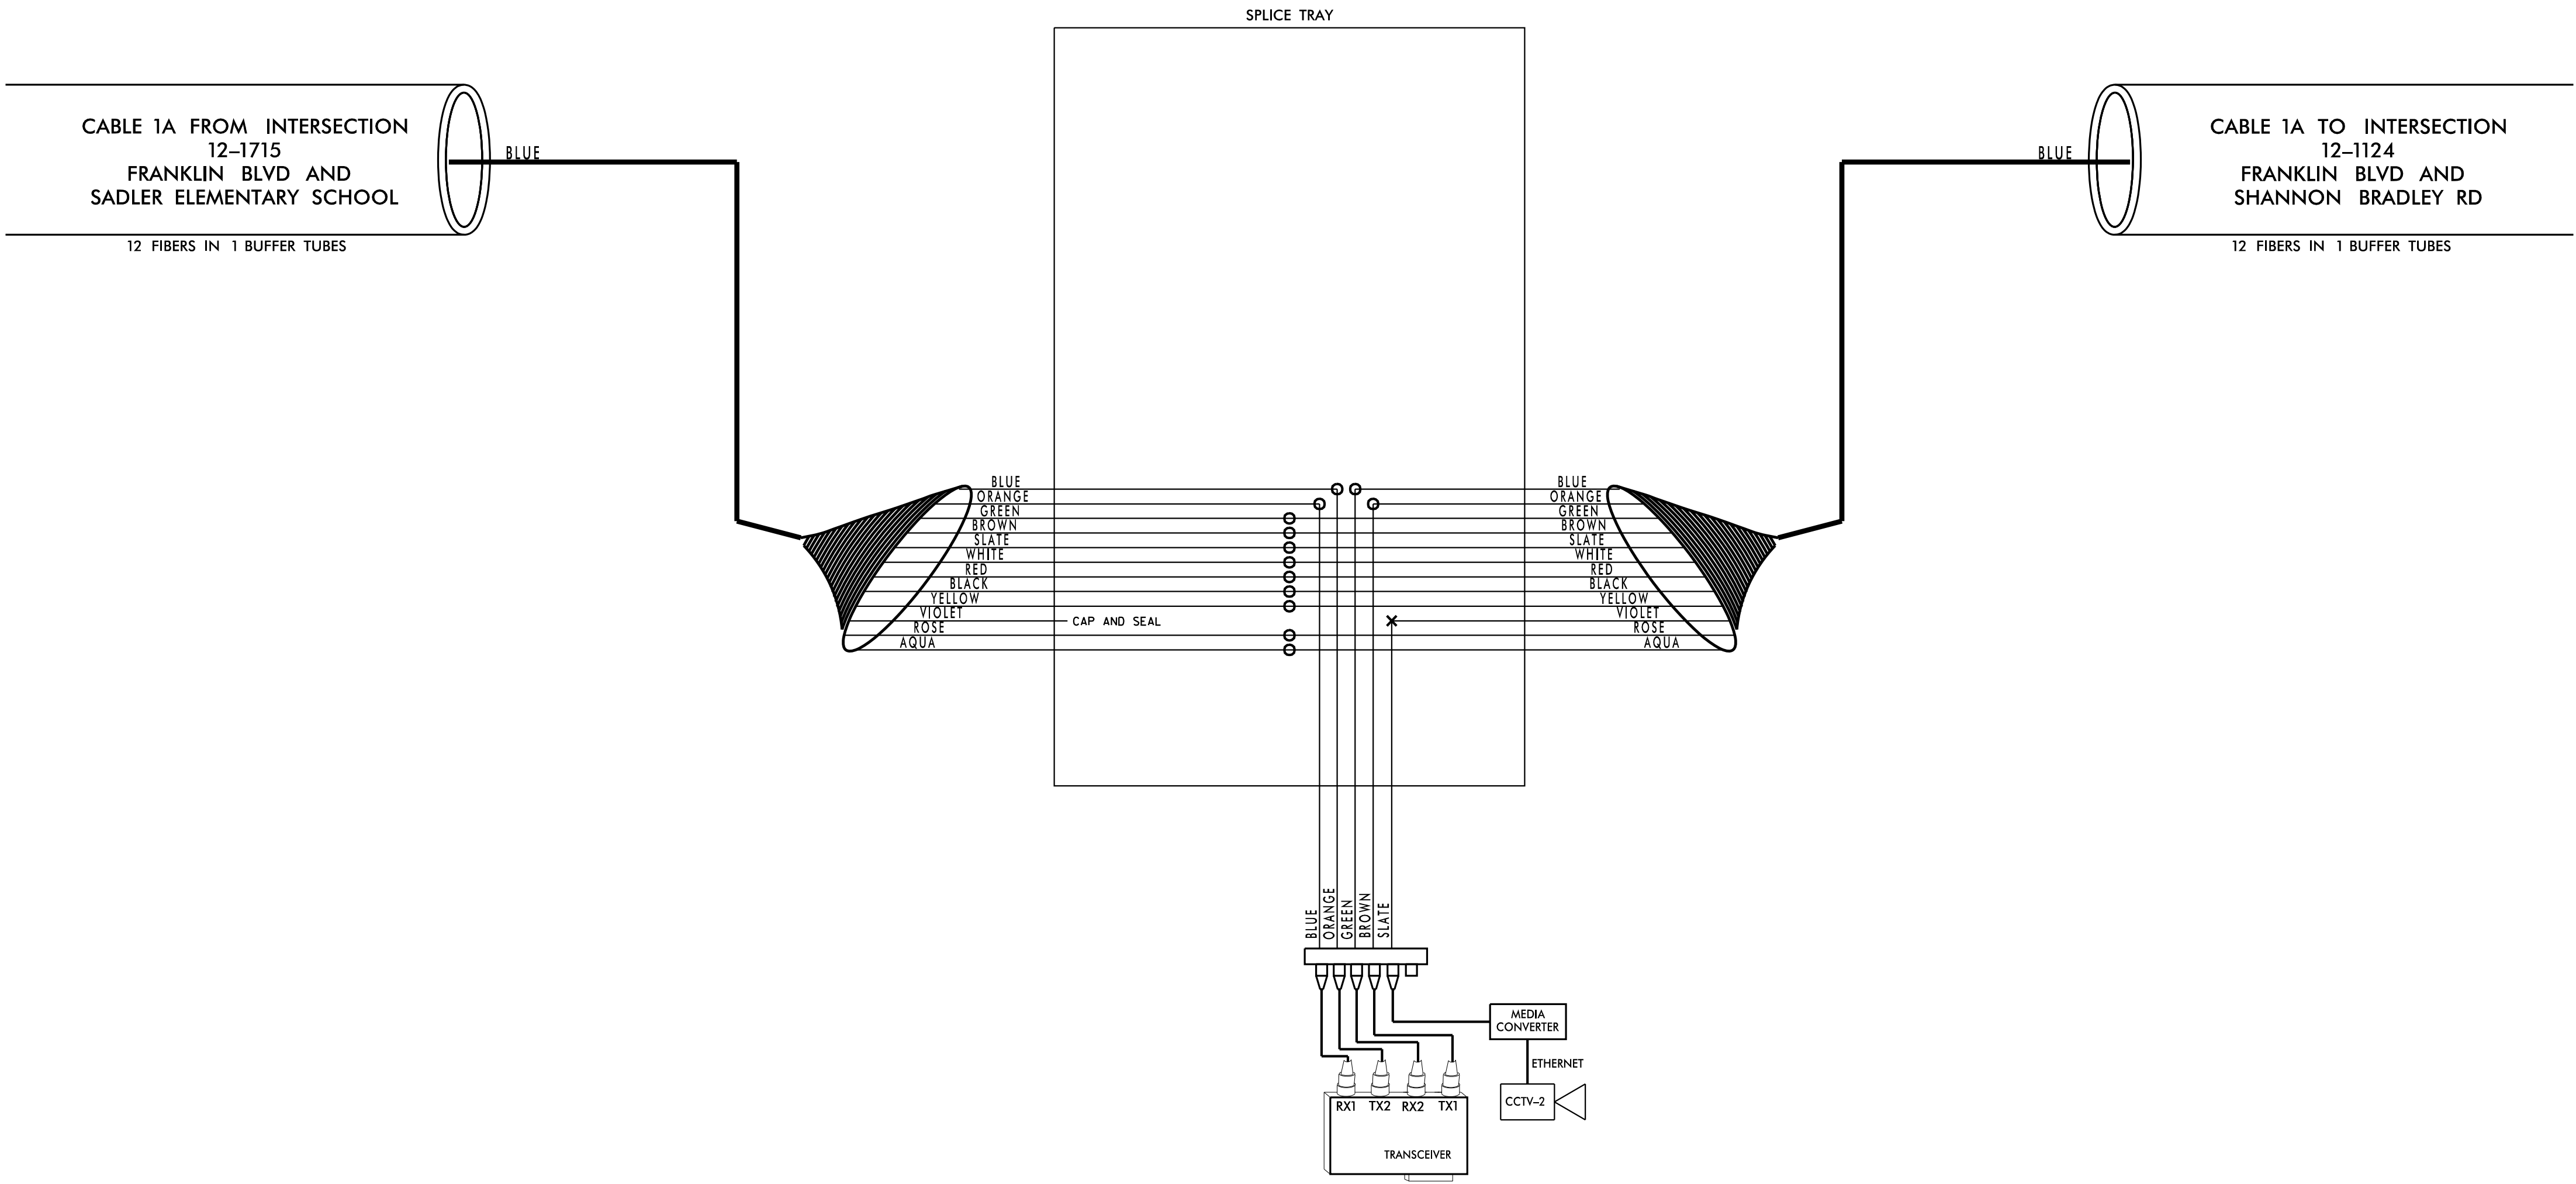

3/25/2019
K:\ARL\TPTD\ITS\01036443 I-85 ICM\6 Tasks\3 PS&E\Plans\C-5600.ITS_psh32.dgn

Kimley»Horn
NC License #F-0102
421 Fayetteville St., Suite 600
Raleigh, NC 27636
Tel: (919) 677-2000
Fax: (919) 677-2050

Plans Prepared For:
NORTH CAROLINA
DEPARTMENT OF TRANSPORTATION
Transportation System Section
750 N. Greenfield Place, Garner, NC 27529

I-85 INTEGRATED CORRIDOR
MANAGEMENT SYSTEM
SPLICE DIAGRAM


DIVISION 10 MECKLENBURG/GASTON COUNTIES

PLAN DATE: MAR 2019
REVIEWED BY: A. GOOD
PREPARED BY: J. CROSS
REVIEWED BY: K. SMITH

REVISIONS
INIT. DATE

SEAL
NORTH CAROLINA
PROFESSIONAL
ENGINEER
KEVIN W. SMITH
SEAL 030472
3/26/2019
CADD Filename:


12-0030
FRANKLIN BLVD AND GARRISON BLVD
CHANNEL 2

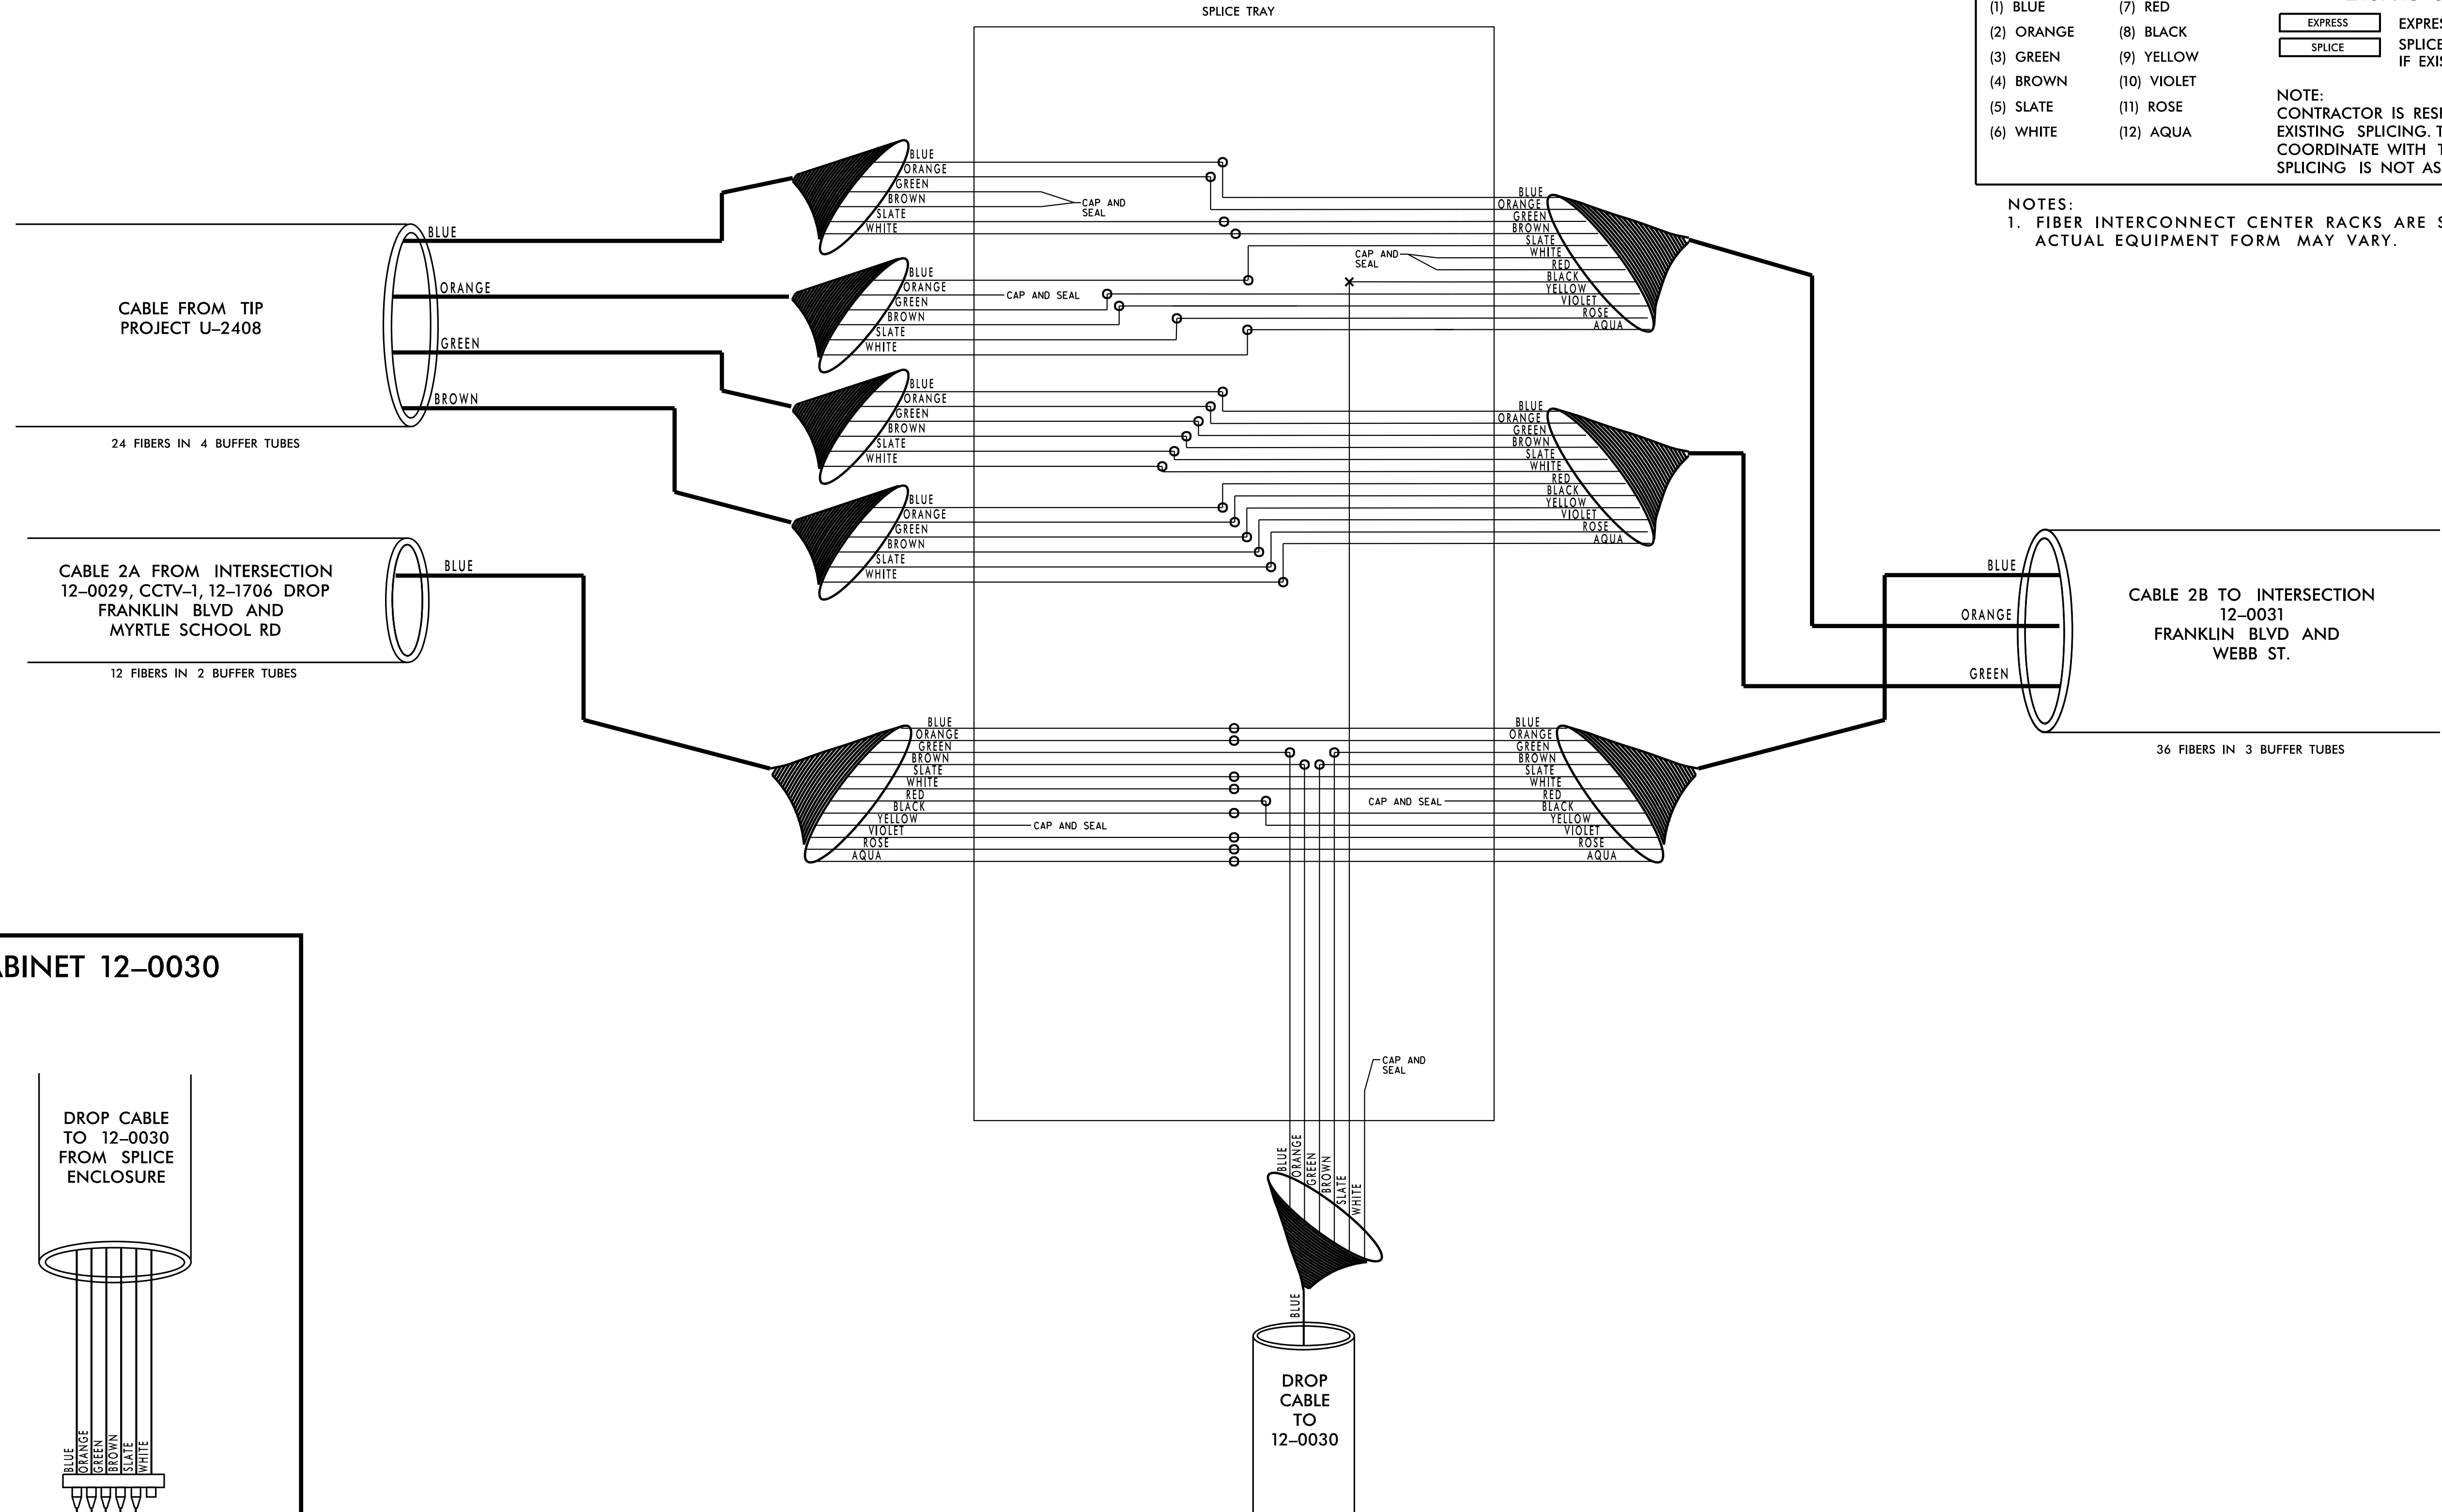



COLOR CODE TIA/EIA 598-C		LEGEND	
(1) BLUE	(7) RED	X - FUSION SPLYCE INDIVIDUAL FIBER	
(2) ORANGE	(8) BLACK	O - EXISTING SPLYCE	
(3) GREEN	(9) YELLOW	EXPRESS	EXPRESS ENTIRE BUFFER TUBE
(4) BROWN	(10) VIOLET	SPLYCE	SPLYCE ENTIRE BUFFER TUBE OR MAINTAIN IF EXISTING EXPRESSED
(5) SLATE	(11) ROSE	NOTE: CONTRACTOR IS RESPONSIBLE FOR FIELD VERIFYING EXISTING SPLYCING. THE CONTRACTOR SHALL COORDINATE WITH THE ENGINEER WHERE EXISTING SPLYCING IS NOT AS EXPECTED.	
(6) WHITE	(12) AQUA		

NOTES:
1. FIBER INTERCONNECT CENTER RACKS ARE SCHEMATIC ONLY - ACTUAL EQUIPMENT FORM MAY VARY.

CABINET 12-0030

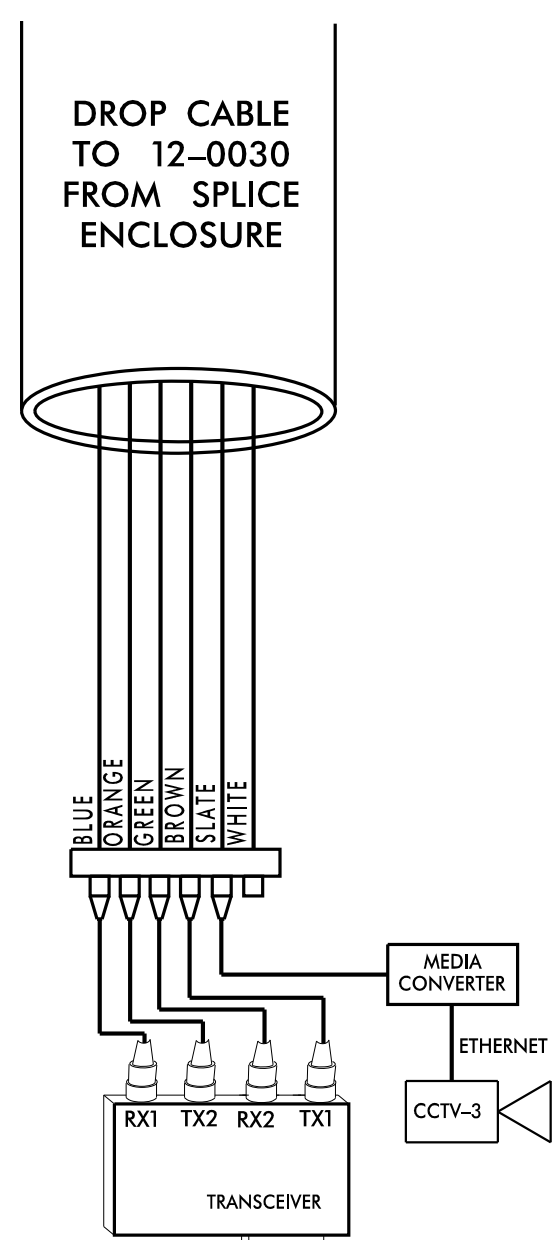

Kimley»Horn
NC License #F-0102
421 Fayetteville St., Suite 600
Raleigh, NC 27636
Tel: (919) 677-2000
Fax: (919) 677-2050

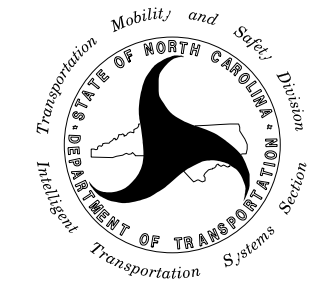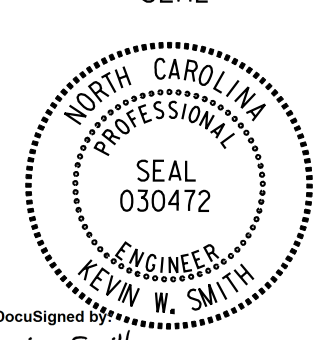 750 N. Greenfield Pkwy., Gaston, NC 27529	I-85 INTEGRATED CORRIDOR MANAGEMENT SYSTEM SPLYCE DIAGRAM		 SEAL 030472 KEVIN W. SMITH ENGINEER	
	DIVISION 10	MECKLENBURG/GASTON COUNTIES		
	PLAN DATE: MAR 2019	REVIEWED BY: A. GOOD		
	PREPARED BY: J. CROSS	REVIEWED BY: K. SMITH		
SCALE 0	REVISIONS		DocuSigned by Kevin W. Smith 3/26/2019 SIGNATURE DATE CADD Filename:	

12-0032
FRANKLIN BLVD AND LINWOOD RD
CHANNEL 3

COLOR CODE
TIA/EIA 598-C

(1) BLUE

(2) ORANGE

(3) GREEN

(4) BROWN

(5) SLATE

(6) WHITE

(7) RED

(8) BLACK

(9) YELLOW

(10) VIOLET

(11) ROSE

(12) AQUA

LEGEND

X – FUSION SPlice INDIVIDUAL FIBER

O – EXISTING SPlice

EXPRESS



EXPRESS ENTIRE BUFFER TUBE

SPlice

SPlice ENTIRE BUFFER TUBE OR MAINTAIN IF EXISTING EXPRESSED

NOTE:
CONTRACTOR IS RESPONSIBLE FOR FIELD VERIFYING EXISTING SPlicing. THE CONTRACTOR SHALL COORDINATE WITH THE ENGINEER WHERE EXISTING SPlicing IS NOT AS EXPECTED.

NOTES:
1. FIBER INTERCONNECT CENTER RACKS ARE SCHEMATIC ONLY – ACTUAL EQUIPMENT FORM MAY VARY.

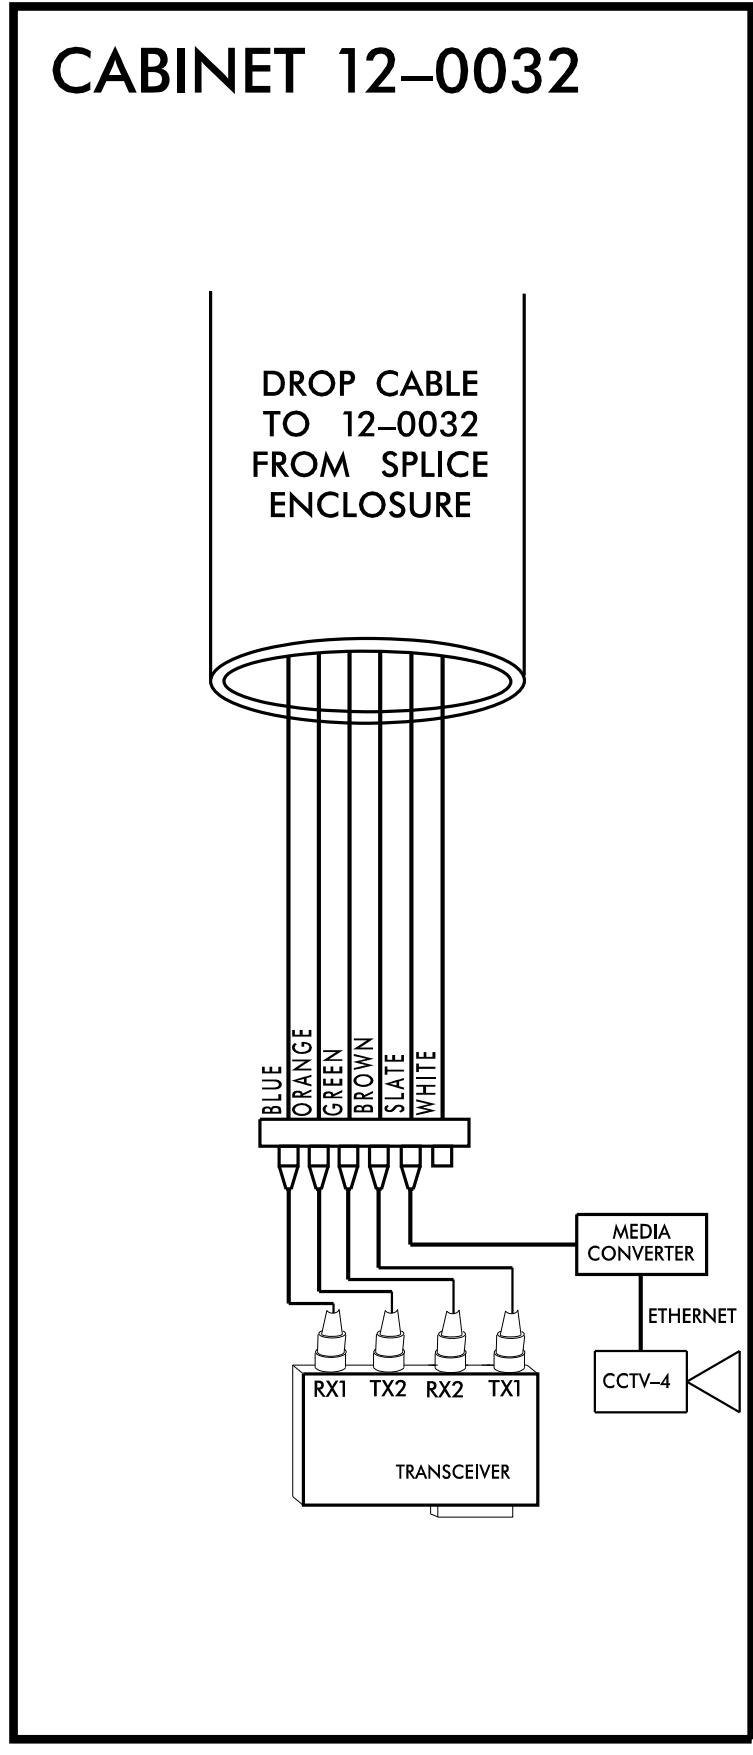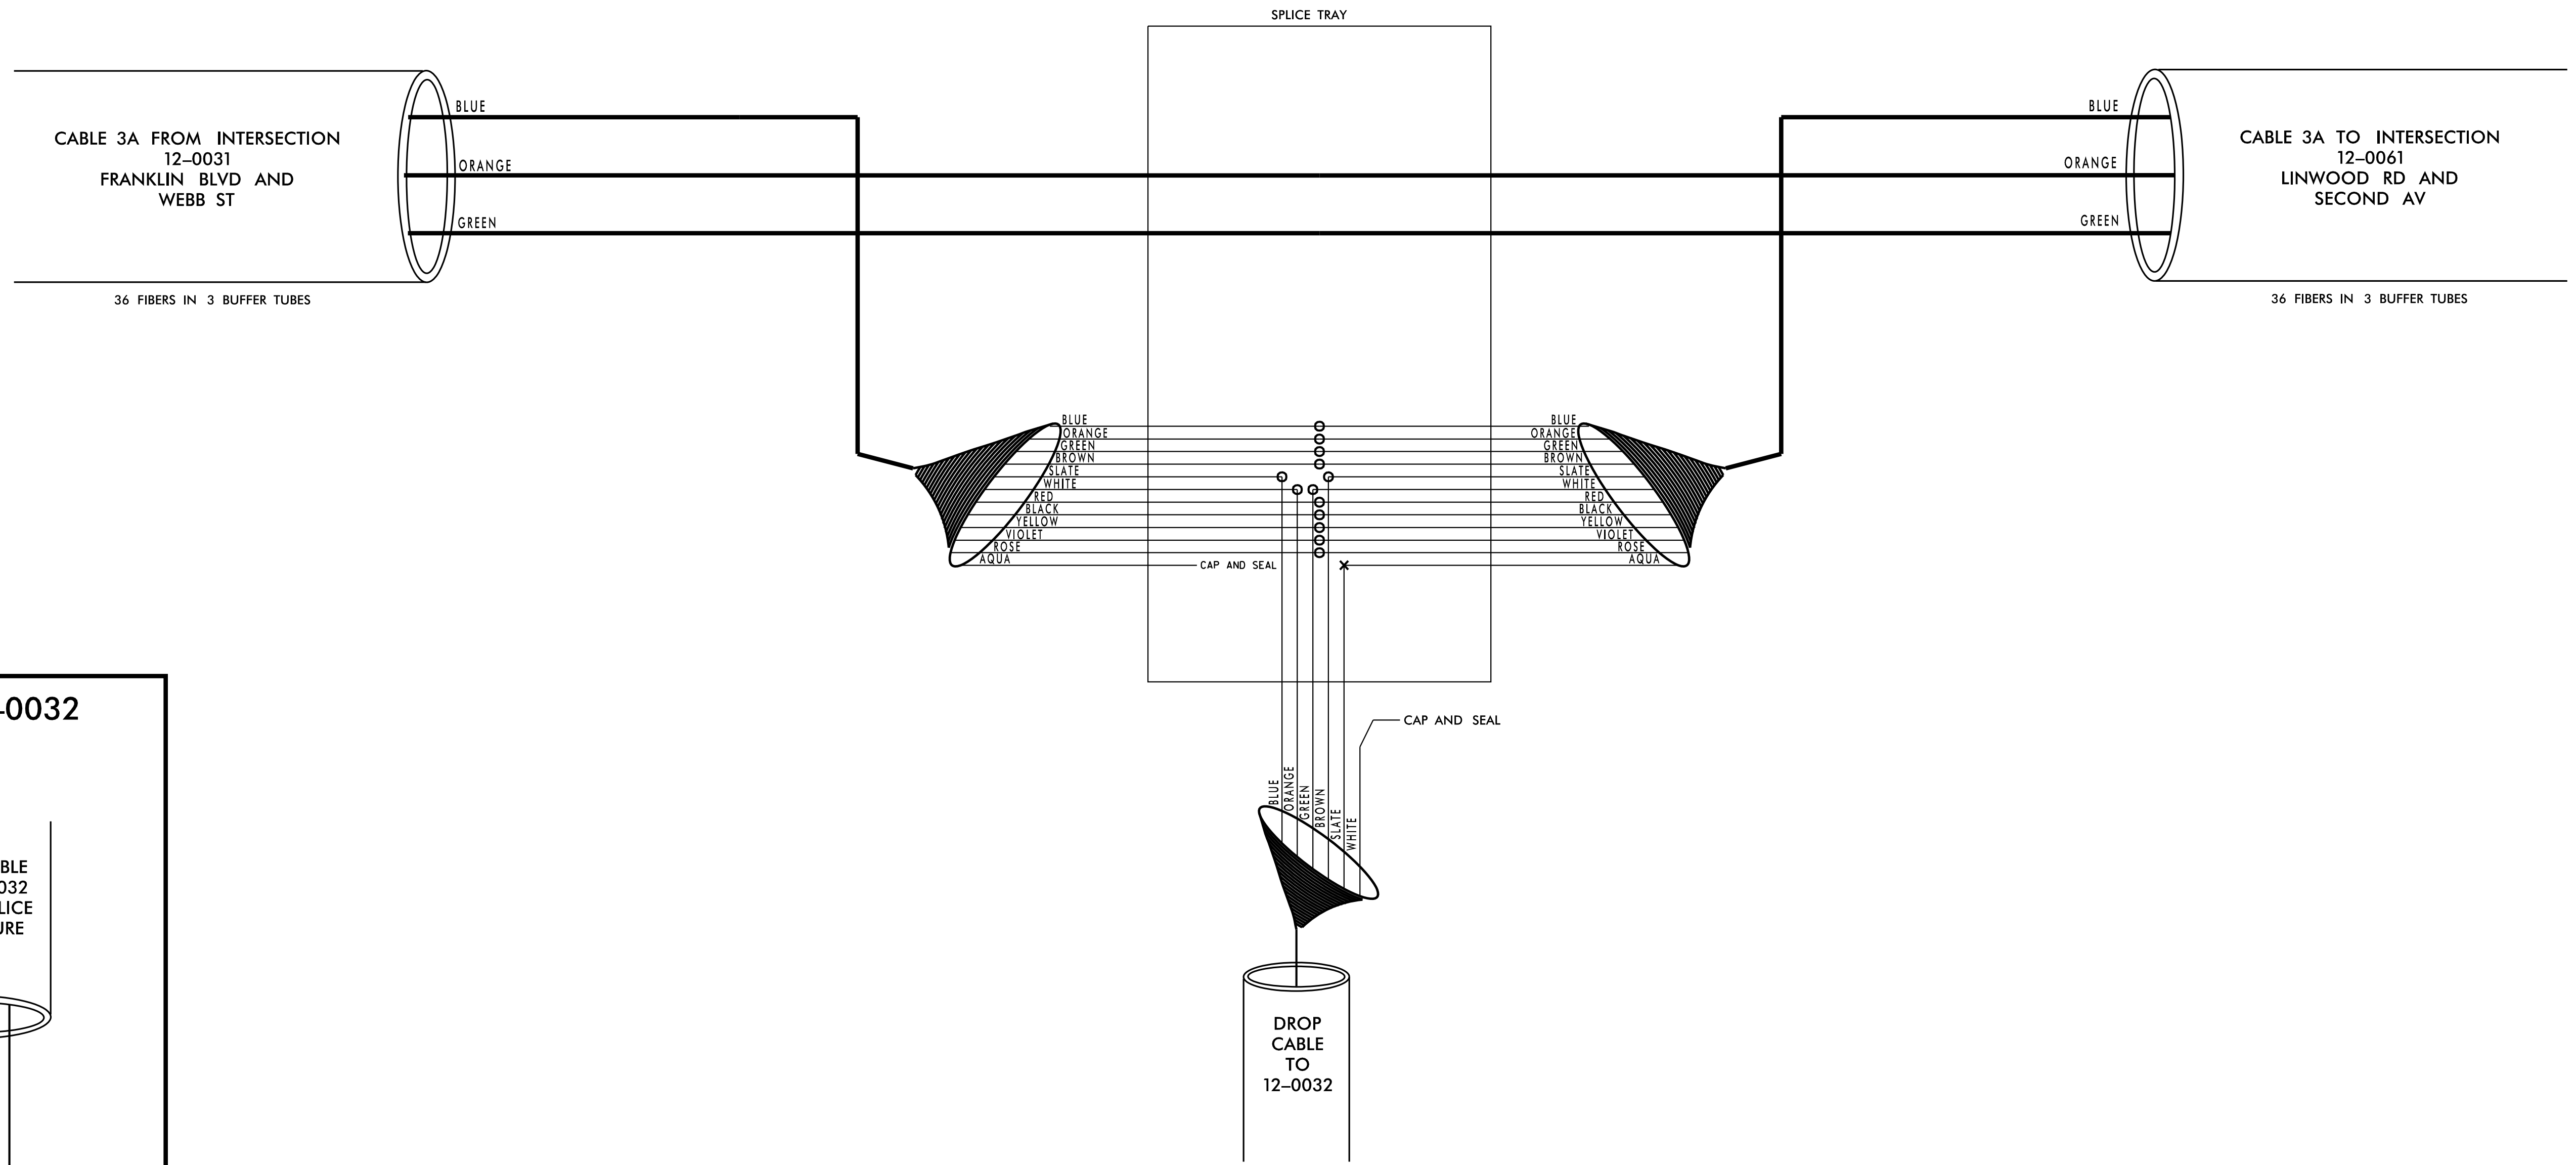

Kimley»Horn
NC License #F-0102
421 Fayetteville St., Suite 600
Raleigh, NC 27636
Tel: (919) 677-2000
Fax: (919) 677-2050

Plans Prepared For:
NORTH CAROLINA
DEPARTMENT OF TRANSPORTATION
Transportation Mobility and Safety Division
750 N. Greenfield Parkway, Garner, NC 27529

I-85 INTEGRATED CORRIDOR
MANAGEMENT SYSTEM
SPlice DIAGRAM

DIVISION 10 MECKLENBURG/GASTON COUNTIES

PLAN DATE: MAR 2019 REVIEWED BY: A. GOOD

PREPARED BY: J. CROSS REVIEWED BY: K. SMITH

REVISIONS

INIT. DATE

SEAL
NORTH CAROLINA
PROFESSIONAL
ENGINEER
KEVIN W. SMITH
SEAL 030472

DocuSigned by
Kevin W. Smith
3/26/2019
SIGNATURE DATE
CADD Filename:

12-0038
FRANKLIN BLVD AND CHESTER ST
CHANNEL 9

COLOR CODE
TIA/EIA 598-C

(1) BLUE

(2) ORANGE

(3) GREEN

(4) BROWN

(5) SLATE

(6) WHITE

(7) RED

(8) BLACK

(9) YELLOW

(10) VIOLET

(11) ROSE

(12) AQUA

LEGEND

X

— FUSION

○

— EXISTING

EXPRESS



EXPRESS ENTIRE BUFFER TUBE

SPLICE

SPLICE ENTIRE BUFFER TUBE OR MAINTAIN IF EXISTING EXPRESSED

NOTE:
CONTRACTOR IS RESPONSIBLE FOR FIELD VERIFYING EXISTING SPLICING. THE CONTRACTOR SHALL COORDINATE WITH THE ENGINEER WHERE EXISTING SPLICING IS NOT AS EXPECTED.

NOTES:
1. FIBER INTERCONNECT CENTER RACKS ARE SCHEMATIC ONLY – ACTUAL EQUIPMENT FORM MAY VARY.

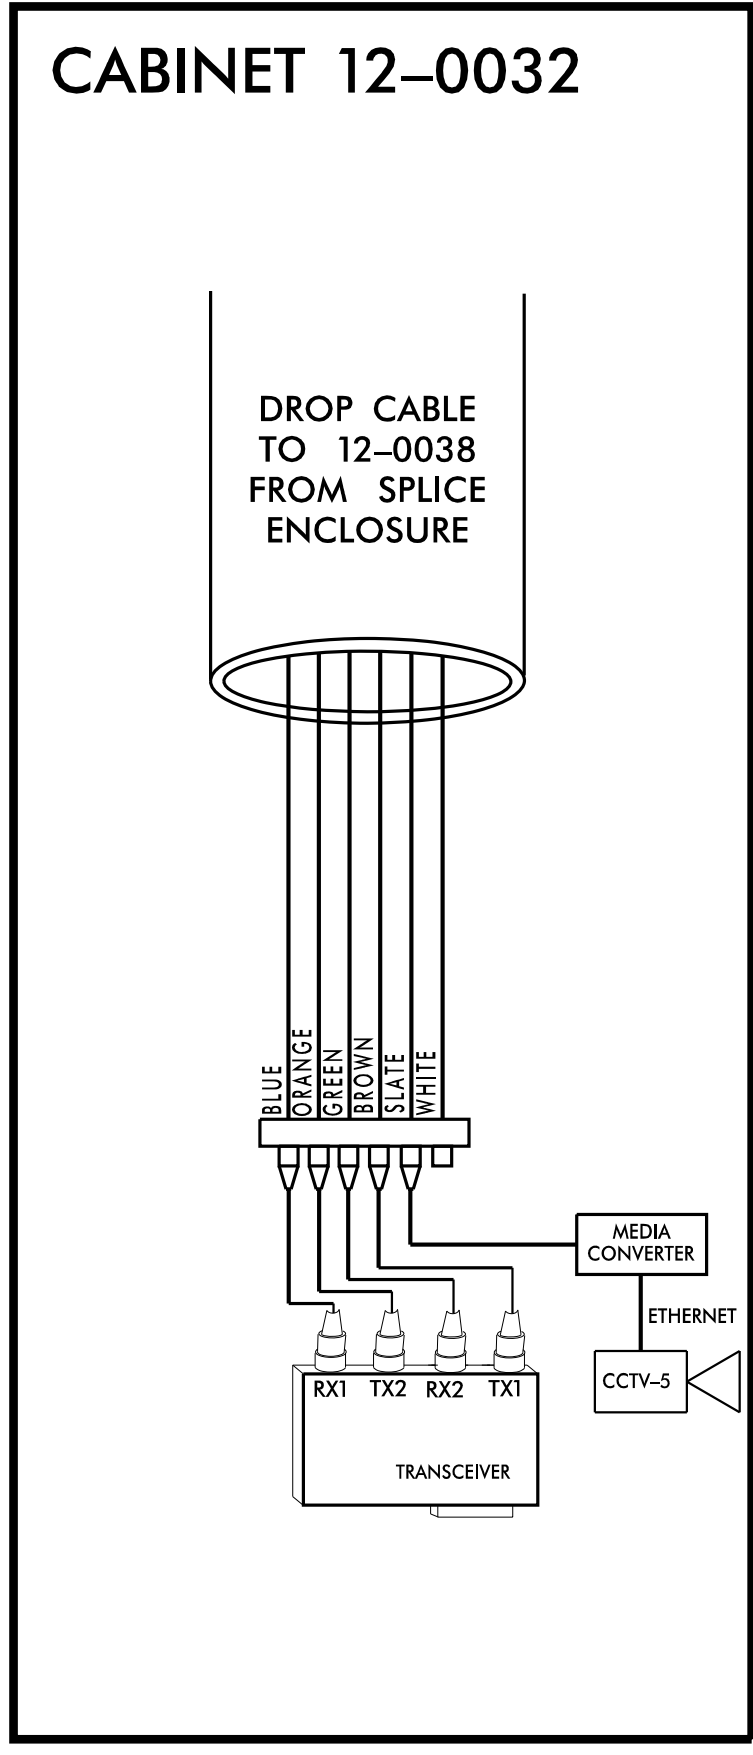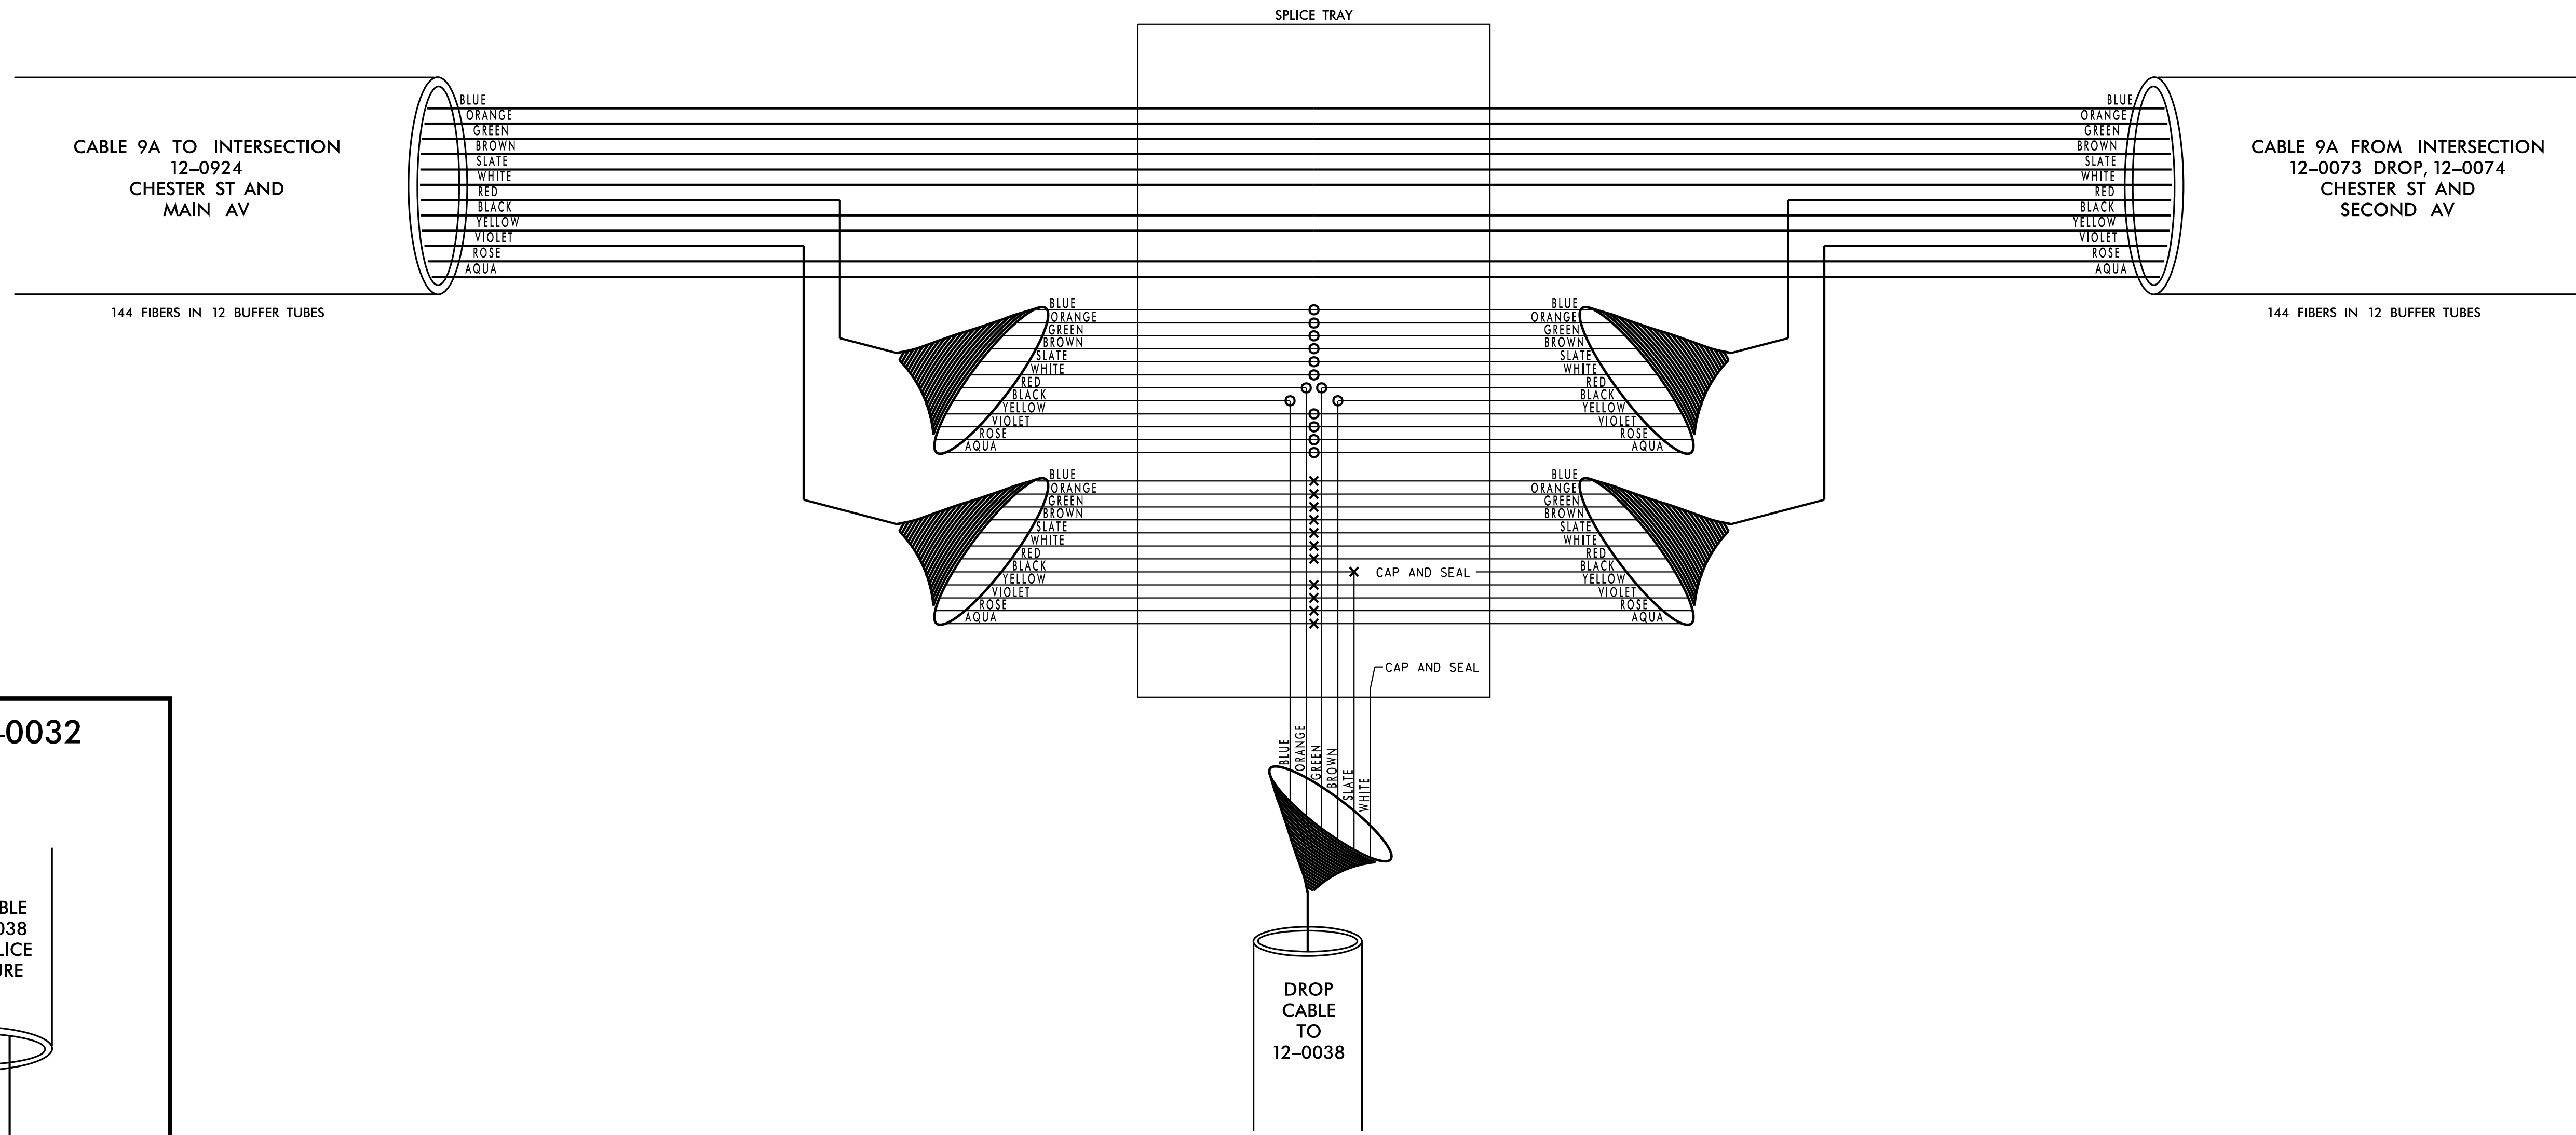

Plans Prepared For:
I-85 INTEGRATED CORRIDOR
MANAGEMENT SYSTEM
SPlice DIAGRAM

DIVISION 10
MECKLENBURG/GASTON COUNTIES

PLAN DATE: MAR 2019
REVIEWED BY: A. GOOD

PREPARED BY: J. CROSS
REVIEWED BY: K. SMITH

REVISIONS
INIT. DATE

SCALE
0


750 N. Greenfield Pkwy., Garner, NC 27529

NC License #F-0102
421 Fayetteville St., Suite 600
Raleigh, NC 27636
Tel: (919) 677-2000
Fax: (919) 677-2050

SEAL
NORTH CAROLINA
PROFESSIONAL
SEAL
030472
ENGINEER
KEVIN W. SMITH

DocuSigned by
Kevin W. Smith
0686E74B3D044C6
SIGNATURE DATE
3/26/2019
CADD Filename:

CITY 05, 12-0102 DROP, 12-0043 DROP
SECOND AVE AND OAKLAND ST
CHANNEL 12

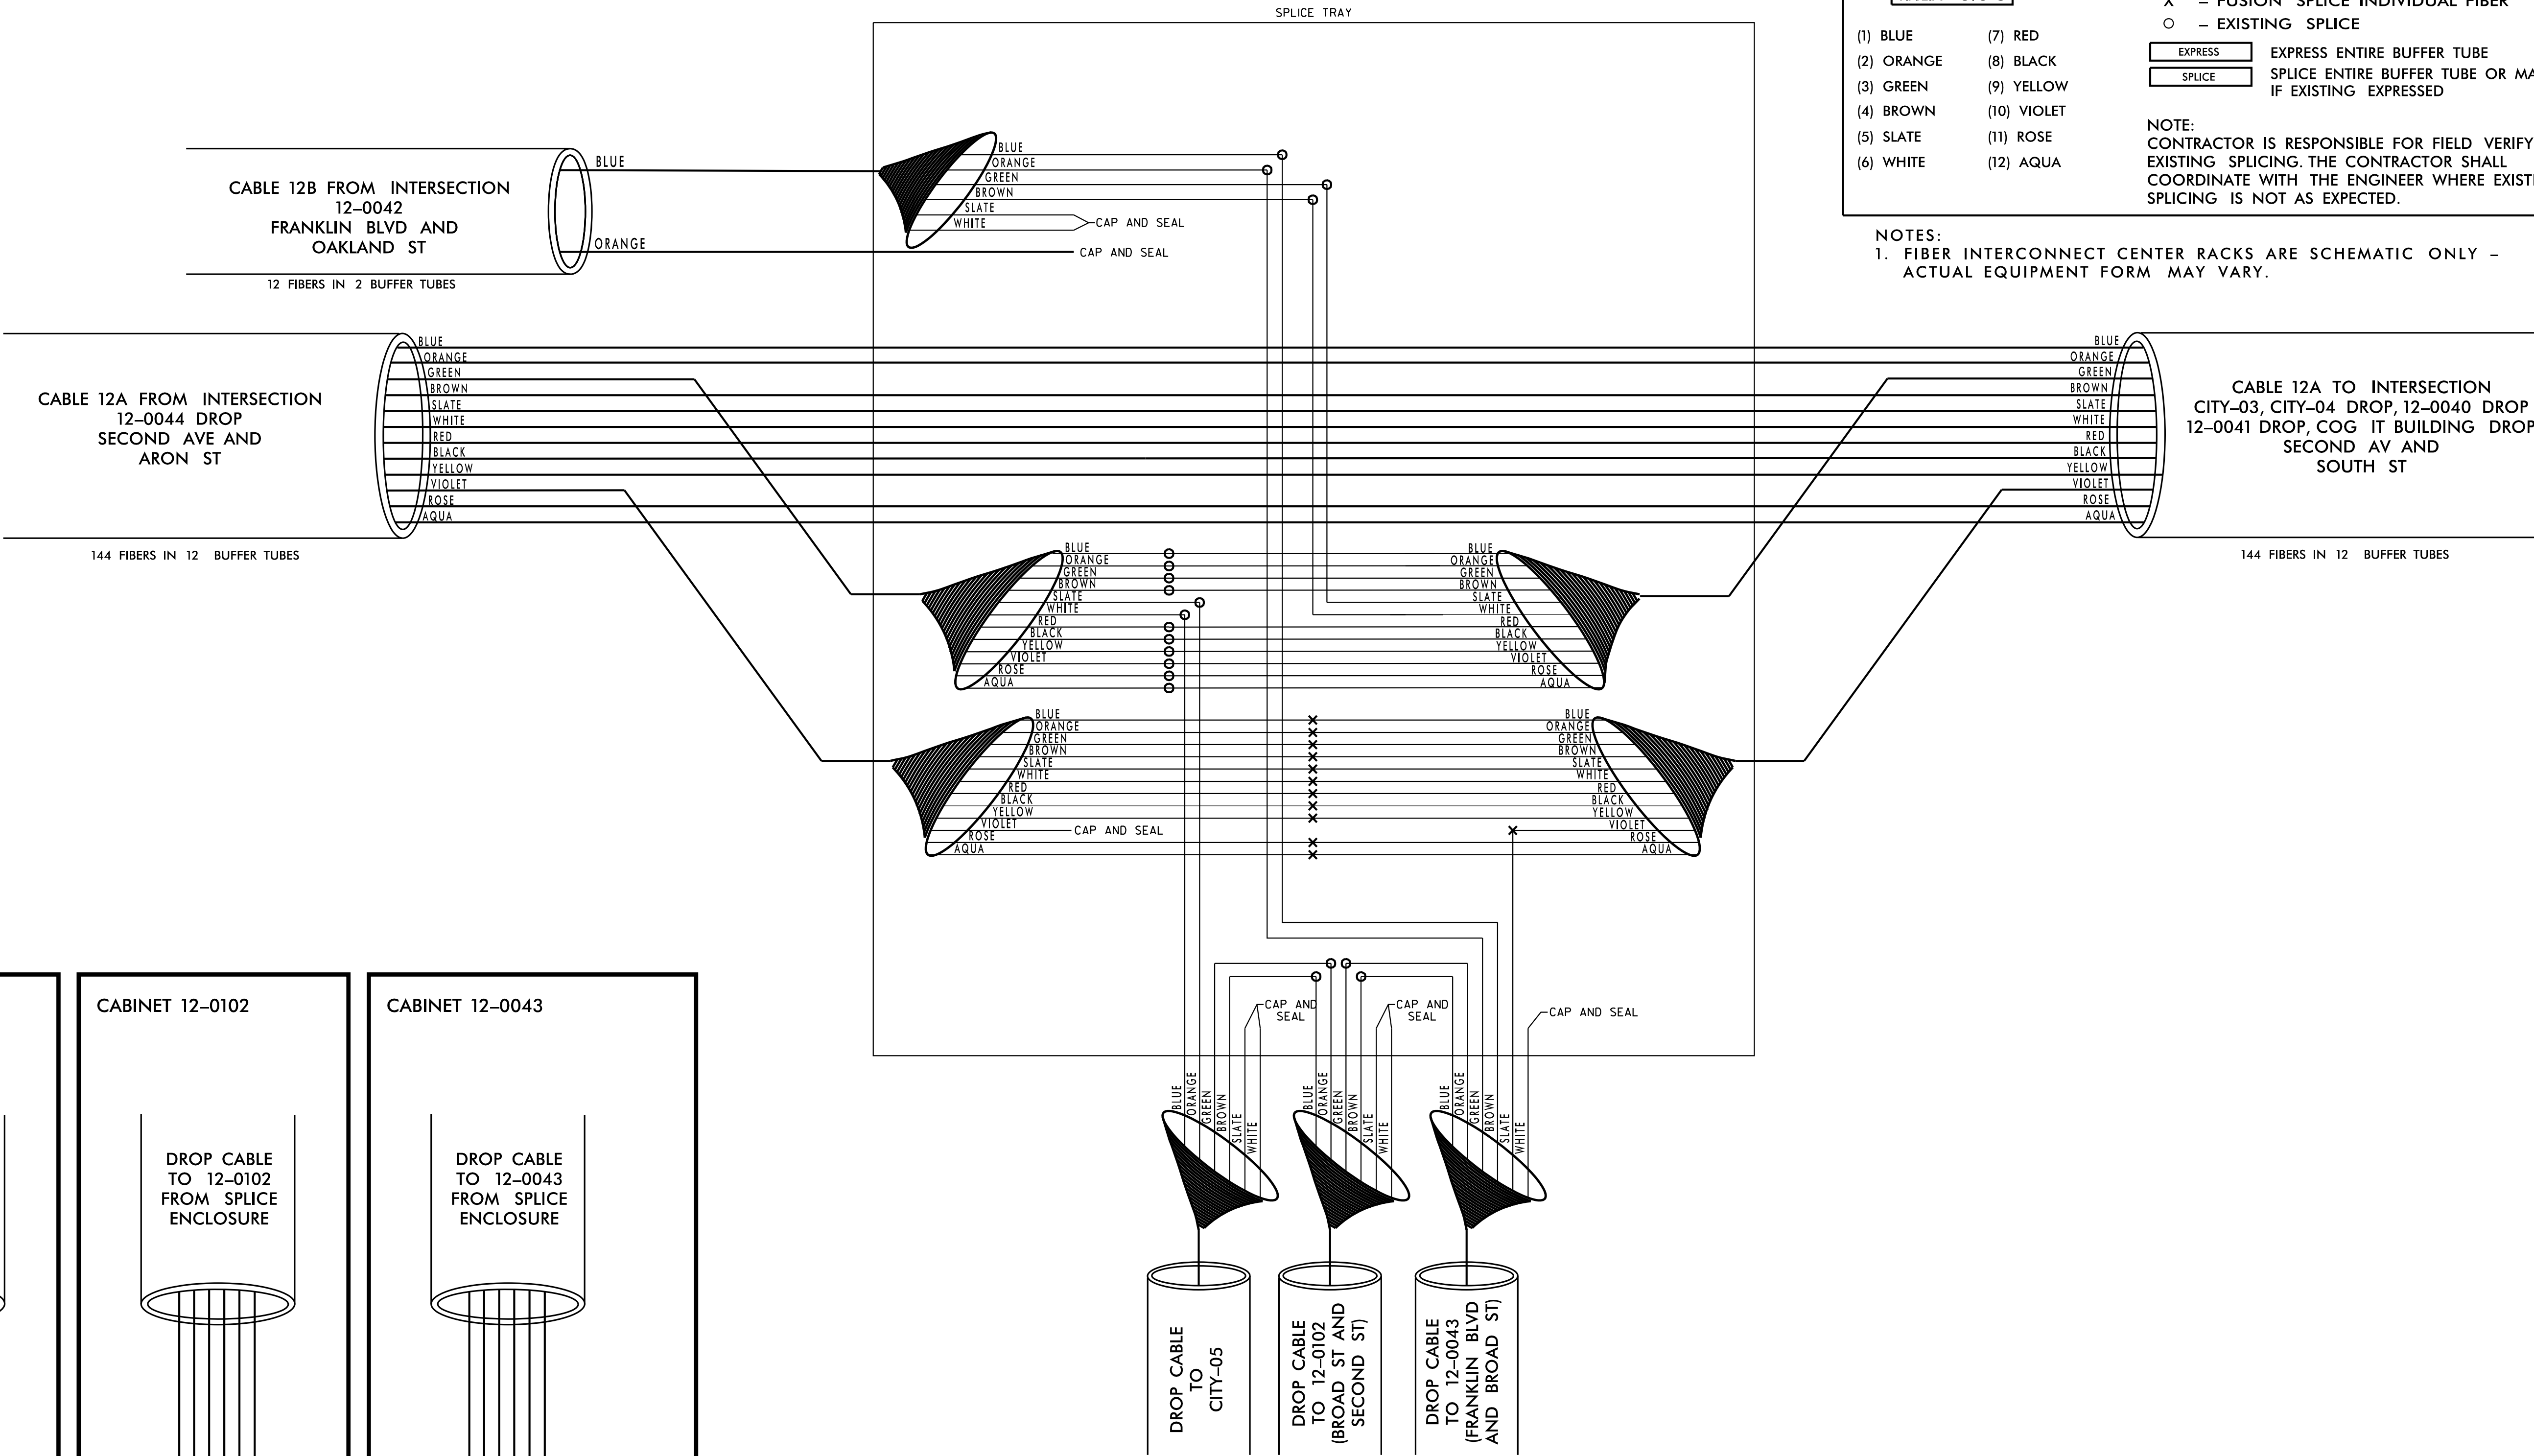

COLOR CODE
TIA/EIA 598-C

(1) BLUE

(2) ORANGE

(3) GREEN

(4) BROWN

(5) SLATE

(6) WHITE

(7) RED

(8) BLACK

(9) YELLOW

(10) VIOLET

(11) ROSE

(12) AQUA

LEGEND

X

— FUSION

SPLICE INDIVIDUAL FIBER

O

— EXISTING

SPLICE

EXPRESS

EXPRESS ENTIRE BUFFER TUBE


SPLICE

SPLICE ENTIRE BUFFER TUBE OR MAINTAIN IF EXISTING EXPRESSED

NOTE:

CONTRACTOR IS RESPONSIBLE FOR FIELD VERIFYING EXISTING SPLICING. THE CONTRACTOR SHALL COORDINATE WITH THE ENGINEER WHERE EXISTING SPLICING IS NOT AS EXPECTED.

NOTES:
1. FIBER INTERCONNECT CENTER RACKS ARE SCHEMATIC ONLY - ACTUAL EQUIPMENT FORM MAY VARY.

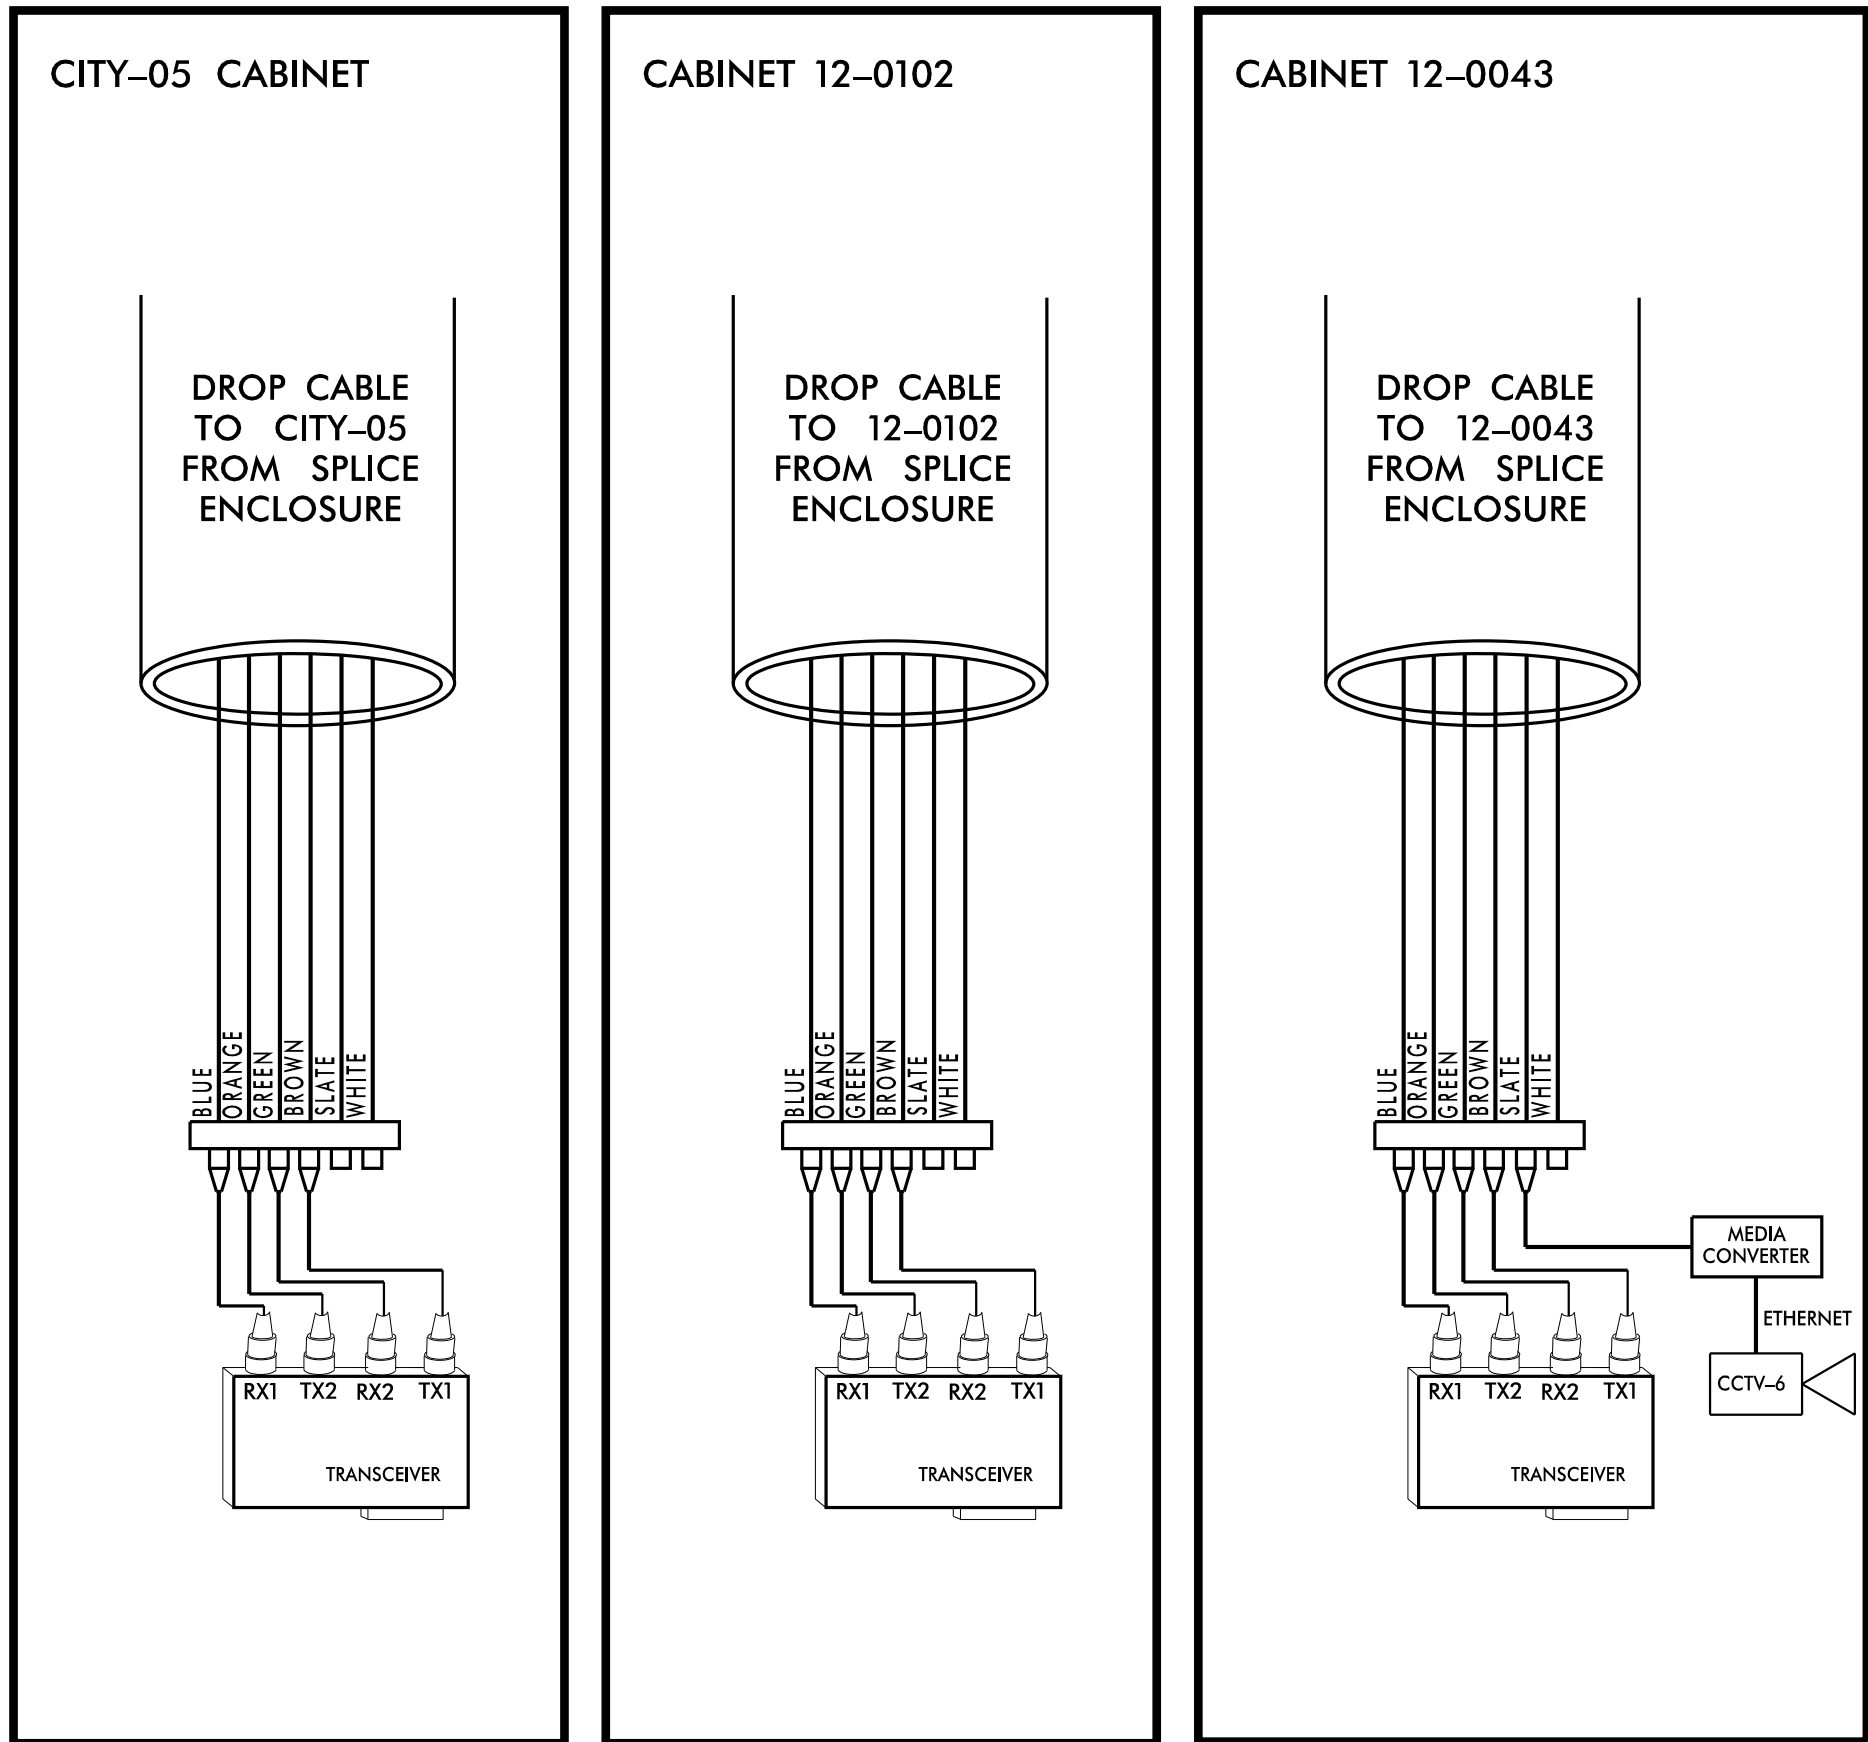

Plans Prepared For:

750 N. Greenfield Pkwy., Garner, NC 27529

0

SCALE

I-85 INTEGRATED CORRIDOR MANAGEMENT SYSTEM

SPLICE DIAGRAM

DIVISION 10 MECKLENBURG/GASTON COUNTIES

PLAN DATE: MAR 2019

REVIEWED BY: A. GOOD

PREPARED BY: J. CROSS

REVIEWED BY: K. SMITH

REVISIONS

INIT.

DATE

SEAL

DocuSigned by
Kevin W. Smith
3/26/2019

SIGNATURE


DATE

CADD Filename:



Kimley»Horn
NC License #F-0102
421 Fayetteville St., Suite 600
Raleigh, NC 27636
Tel: (919) 677-2000
Fax: (919) 677-2050

12-0074, 12-0073 DROP
CHESTER ST AND SECOND AV
CHANNEL 9

CABINET 12-0073

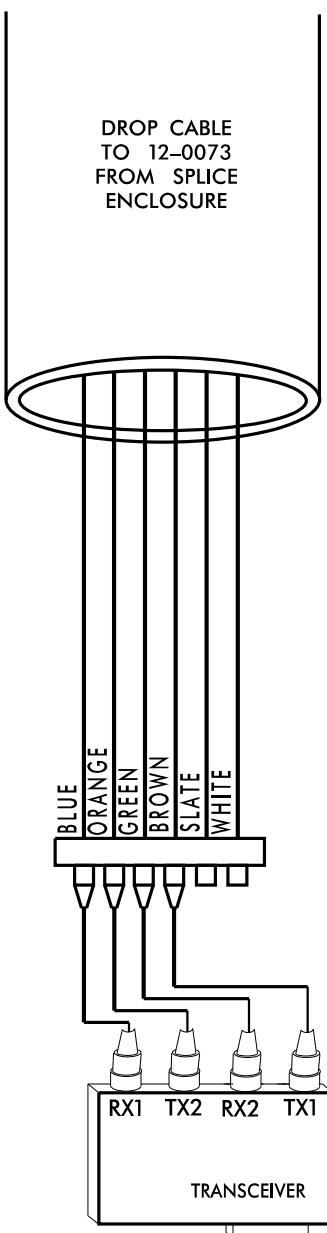

CABINET 12-0074

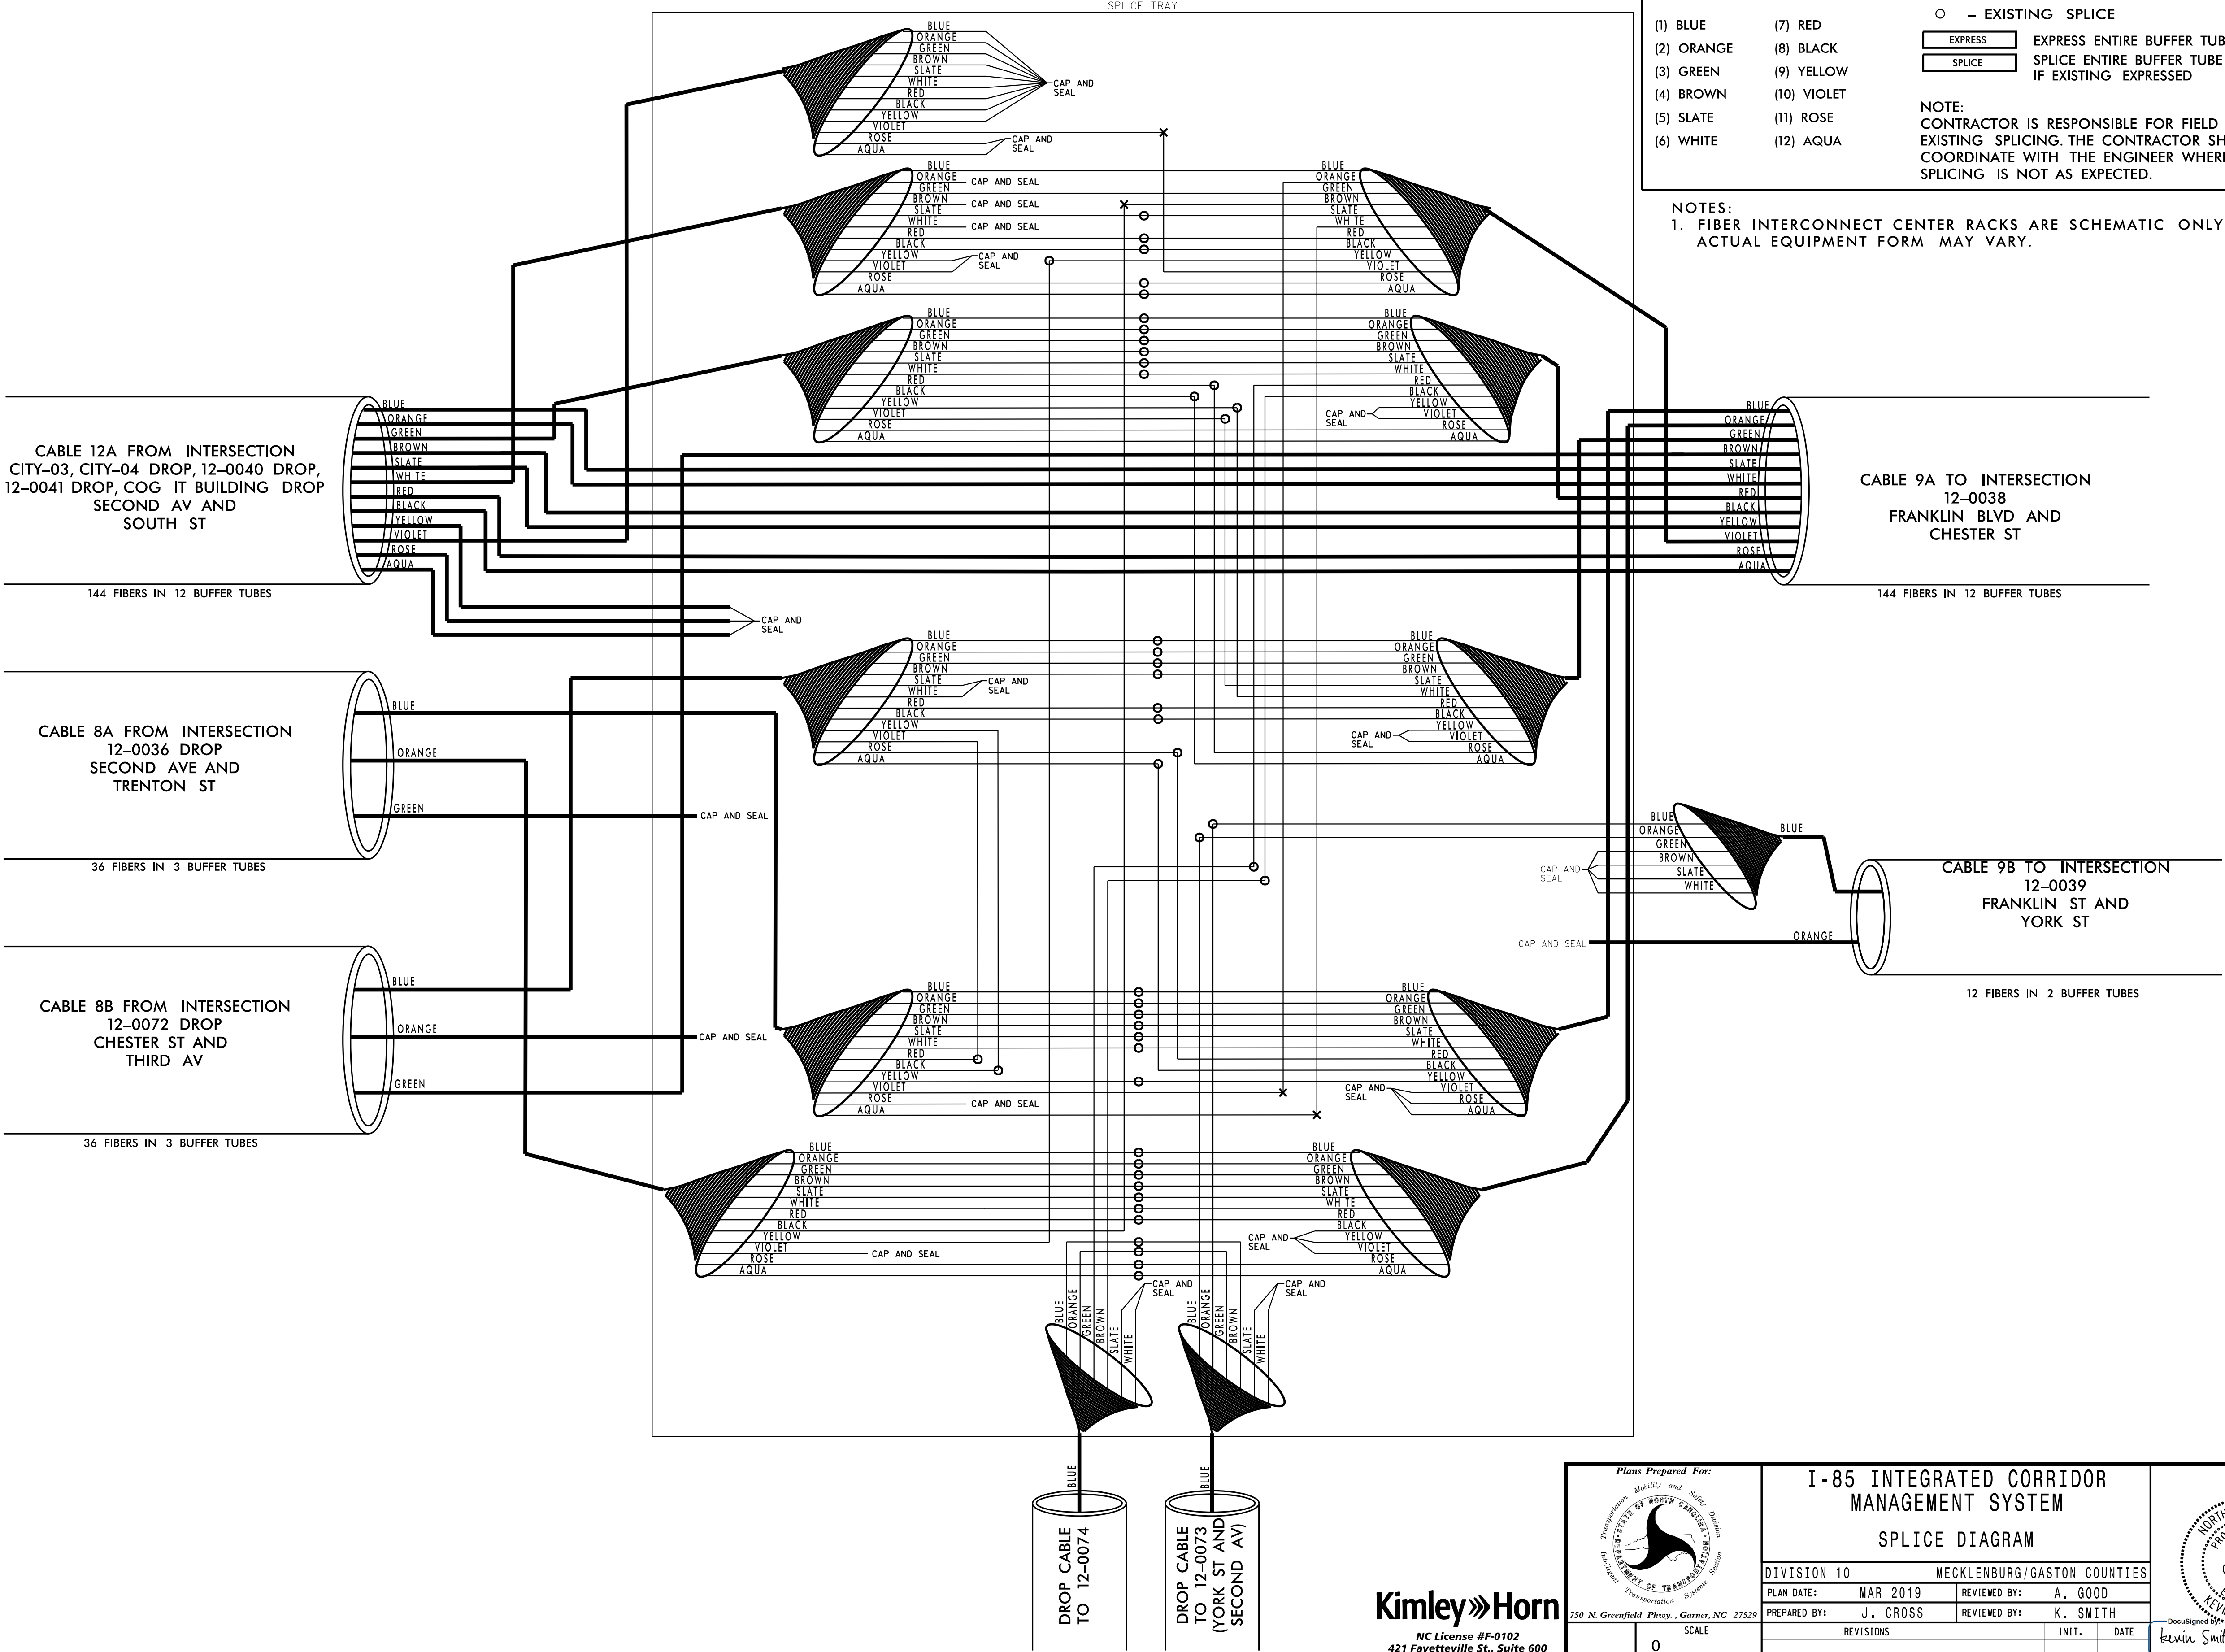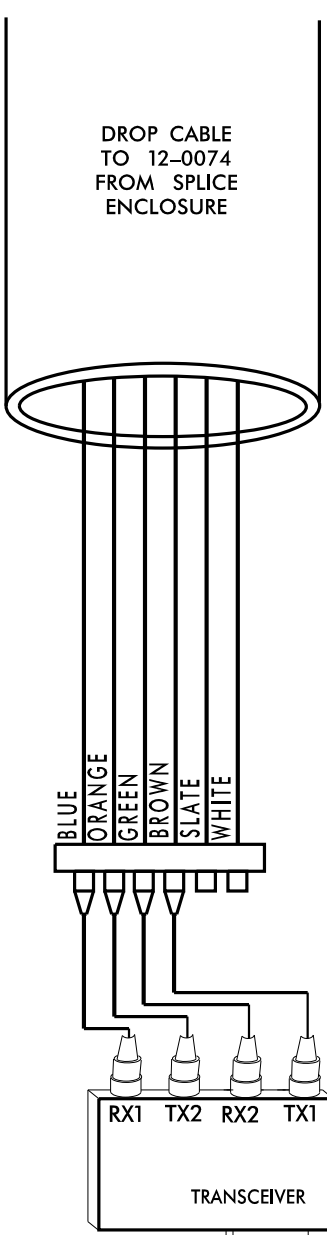

COLOR CODE
TIA/EIA 598-C

(1) BLUE	(7) RED
(2) ORANGE	(8) BLACK
(3) GREEN	(9) YELLOW
(4) BROWN	(10) VIOLET
(5) SLATE	(11) ROSE
(6) WHITE	(12) AQUA

LEGEND

X - FUSION SPLICE INDIVIDUAL FIBER
O - EXISTING SPLICE

EXPRESS - EXPRESS ENTIRE BUFFER TUBE
SPLICE - SPLICE ENTIRE BUFFER TUBE OR MAINTAIN IF EXISTING EXPRESSED

NOTE:
CONTRACTOR IS RESPONSIBLE FOR FIELD VERIFYING EXISTING SPLICING. THE CONTRACTOR SHALL COORDINATE WITH THE ENGINEER WHERE EXISTING SPLICING IS NOT AS EXPECTED.

NOTES:
1. FIBER INTERCONNECT CENTER RACKS ARE SCHEMATIC ONLY - ACTUAL EQUIPMENT FORM MAY VARY.

3/25/2019 K:\ARL\TPTD\ITS\01036443 I-85 ICM\6 Tasks\3 PS&E\3 PS&E\Plans\C-5600.ITS_psh37.dgn

Kimley»Horn
NC License #F-0102
421 Fayetteville St., Suite 600
Raleigh, NC 27636
Tel: (919) 677-2000
Fax: (919) 677-2050

Plans Prepared For:
I-85 INTEGRATED CORRIDOR MANAGEMENT SYSTEM
SPLICE DIAGRAM

DIVISION 10 MECKLENBURG/GASTON COUNTIES

PLAN DATE: MAR 2019 REVIEWED BY: A. GOOD
PREPARED BY: J. CROSS REVIEWED BY: K. SMITH

REVISIONS: INIT. DATE

SCALE: 0

Seal: NORTH CAROLINA PROFESSIONAL ENGINEER KEVIN W. SMITH SEAL 030472

DocuSign: Kevin Smith 3/26/2019

SIGNATURE DATE

CADD Filename:

12-0929
LONG AV AND MARIETTA ST
CHANNEL 13

COLOR CODE
TIA/EIA 598-C

(1) BLUE

(2) ORANGE

(3) GREEN

(4) BROWN

(5) SLATE

(6) WHITE

(7) RED

(8) BLACK

(9) YELLOW

(10) VIOLET

(11) ROSE

(12) AQUA

LEGEND

X

— FUSION

SPLICE INDIVIDUAL FIBER

O

— EXISTING

SPLICE

EXPRESS

EXPRESS ENTIRE BUFFER TUBE


SPLICE

SPLICE ENTIRE BUFFER TUBE OR MAINTAIN IF EXISTING EXPRESSED


NOTE:

CONTRACTOR IS RESPONSIBLE FOR FIELD VERIFYING EXISTING SPLICING. THE CONTRACTOR SHALL COORDINATE WITH THE ENGINEER WHERE EXISTING SPLICING IS NOT AS EXPECTED.

NOTES:
1. FIBER INTERCONNECT CENTER RACKS ARE SCHEMATIC ONLY - ACTUAL EQUIPMENT FORM MAY VARY.

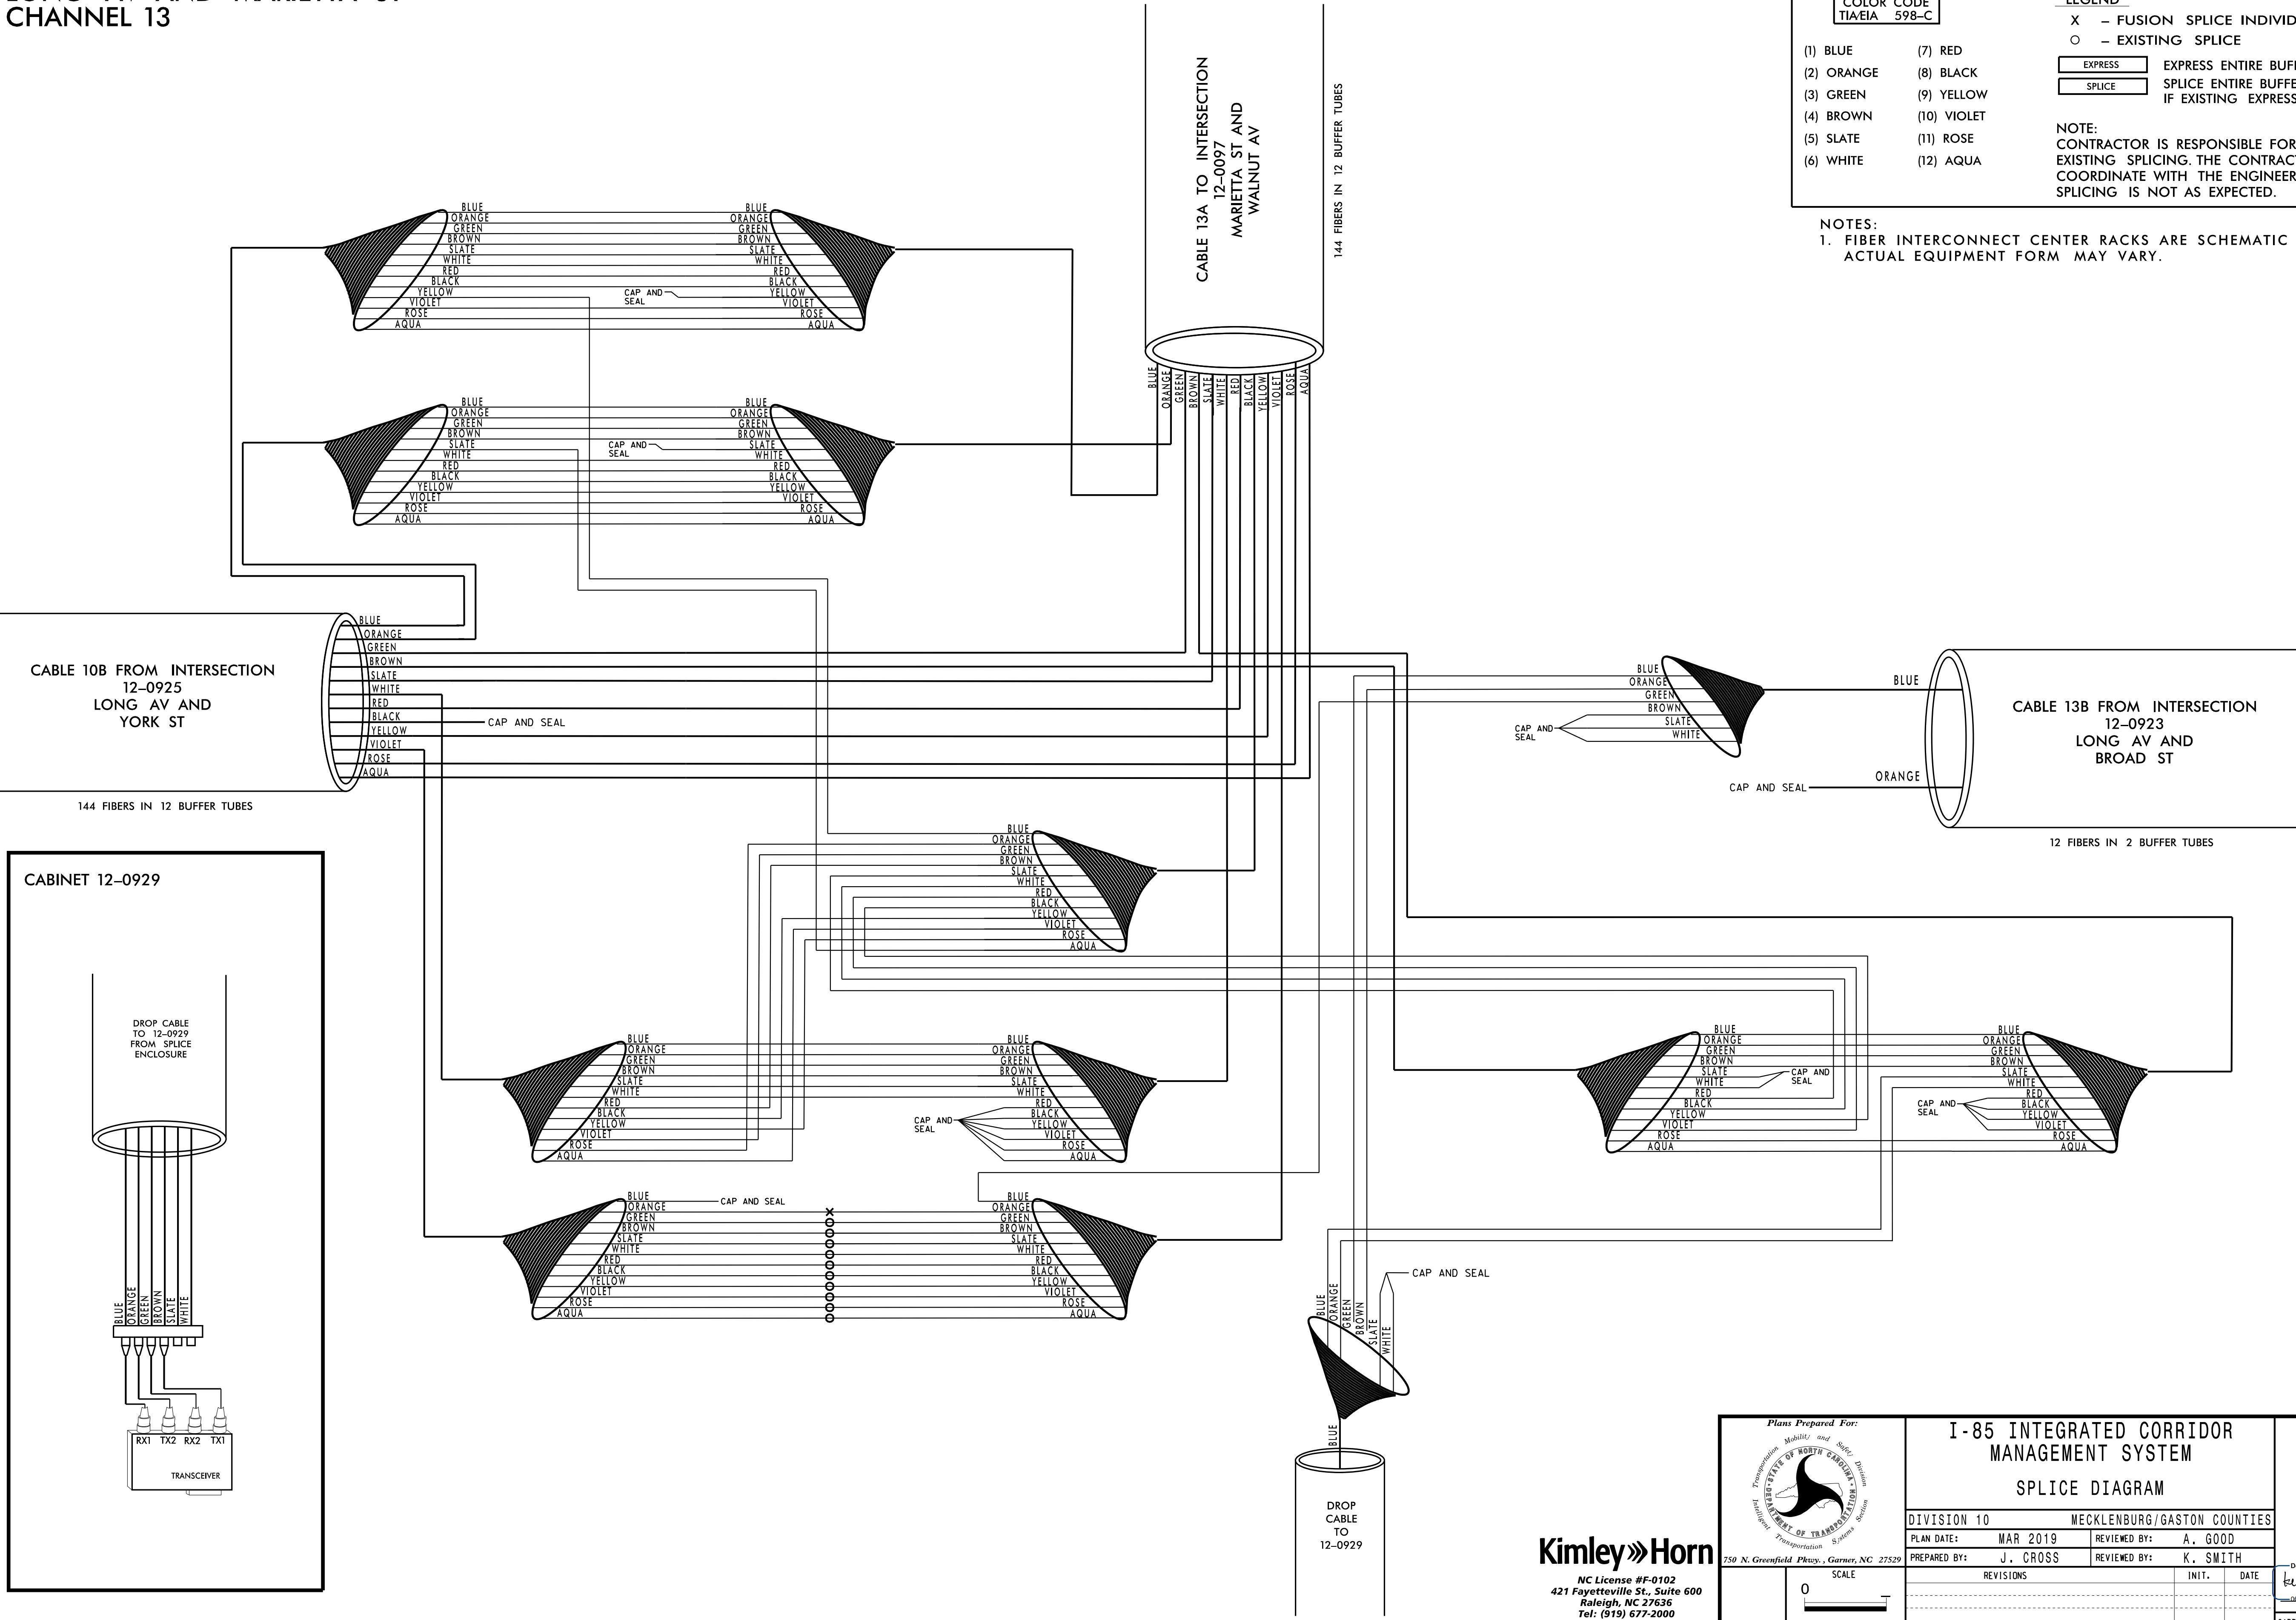

Plans Prepared For:

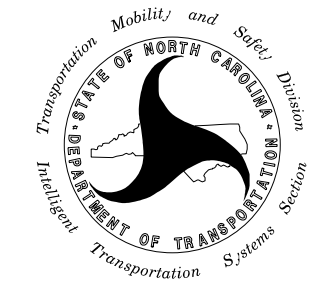

750 N. Greenfield Pkwy., Garner, NC 27529

NC License #F-0102

421 Fayetteville St., Suite 600

Raleigh, NC 27636

Tel: (919) 677-2000

Fax: (919) 677-2050

Kimley»Horn

I-85 INTEGRATED CORRIDOR
MANAGEMENT SYSTEM

SPLICE DIAGRAM

DIVISION 10 MECKLENBURG/GASTON COUNTIES


PLAN DATE: MAR 2019 REVIEWED BY: A. GOOD

PREPARED BY: J. CROSS REVIEWED BY: K. SMITH

REVISIONS

INIT. DATE

SEAL

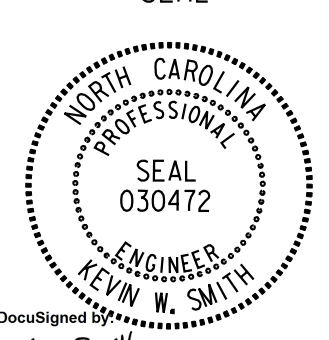

DocuSign
Kevin W. Smith
3/26/2019
SIGNATURE DATE
CADD Filename:

12-0203
CHESTER ST AND AIRLINE/LONG AV
CHANNEL 10

THIS SHEET IS FOR REFERENCE ONLY.
NO SPLICING WORK SHALL BE PERFORMED
AT THIS LOCATION.

COLOR CODE
TIA/EIA 598-C

(1) BLUE

(2) ORANGE

(3) GREEN

(4) BROWN

(5) SLATE

(6) WHITE

(7) RED

(8) BLACK

(9) YELLOW

(10) VIOLET

(11) ROSE

(12) AQUA

LEGEND

X

— FUSION SPLICE INDIVIDUAL FIBER

O

— EXISTING SPLICE

EXPRESS

EXPRESS ENTIRE BUFFER TUBE


SPLICE

SPLICE ENTIRE BUFFER TUBE OR MAINTAIN IF EXISTING EXPRESSED

NOTE:

CONTRACTOR IS RESPONSIBLE FOR FIELD VERIFYING EXISTING SPLICING. THE CONTRACTOR SHALL COORDINATE WITH THE ENGINEER WHERE EXISTING SPLICING IS NOT AS EXPECTED.

NOTES:
1. FIBER INTERCONNECT CENTER RACKS ARE SCHEMATIC ONLY - ACTUAL EQUIPMENT FORM MAY VARY.

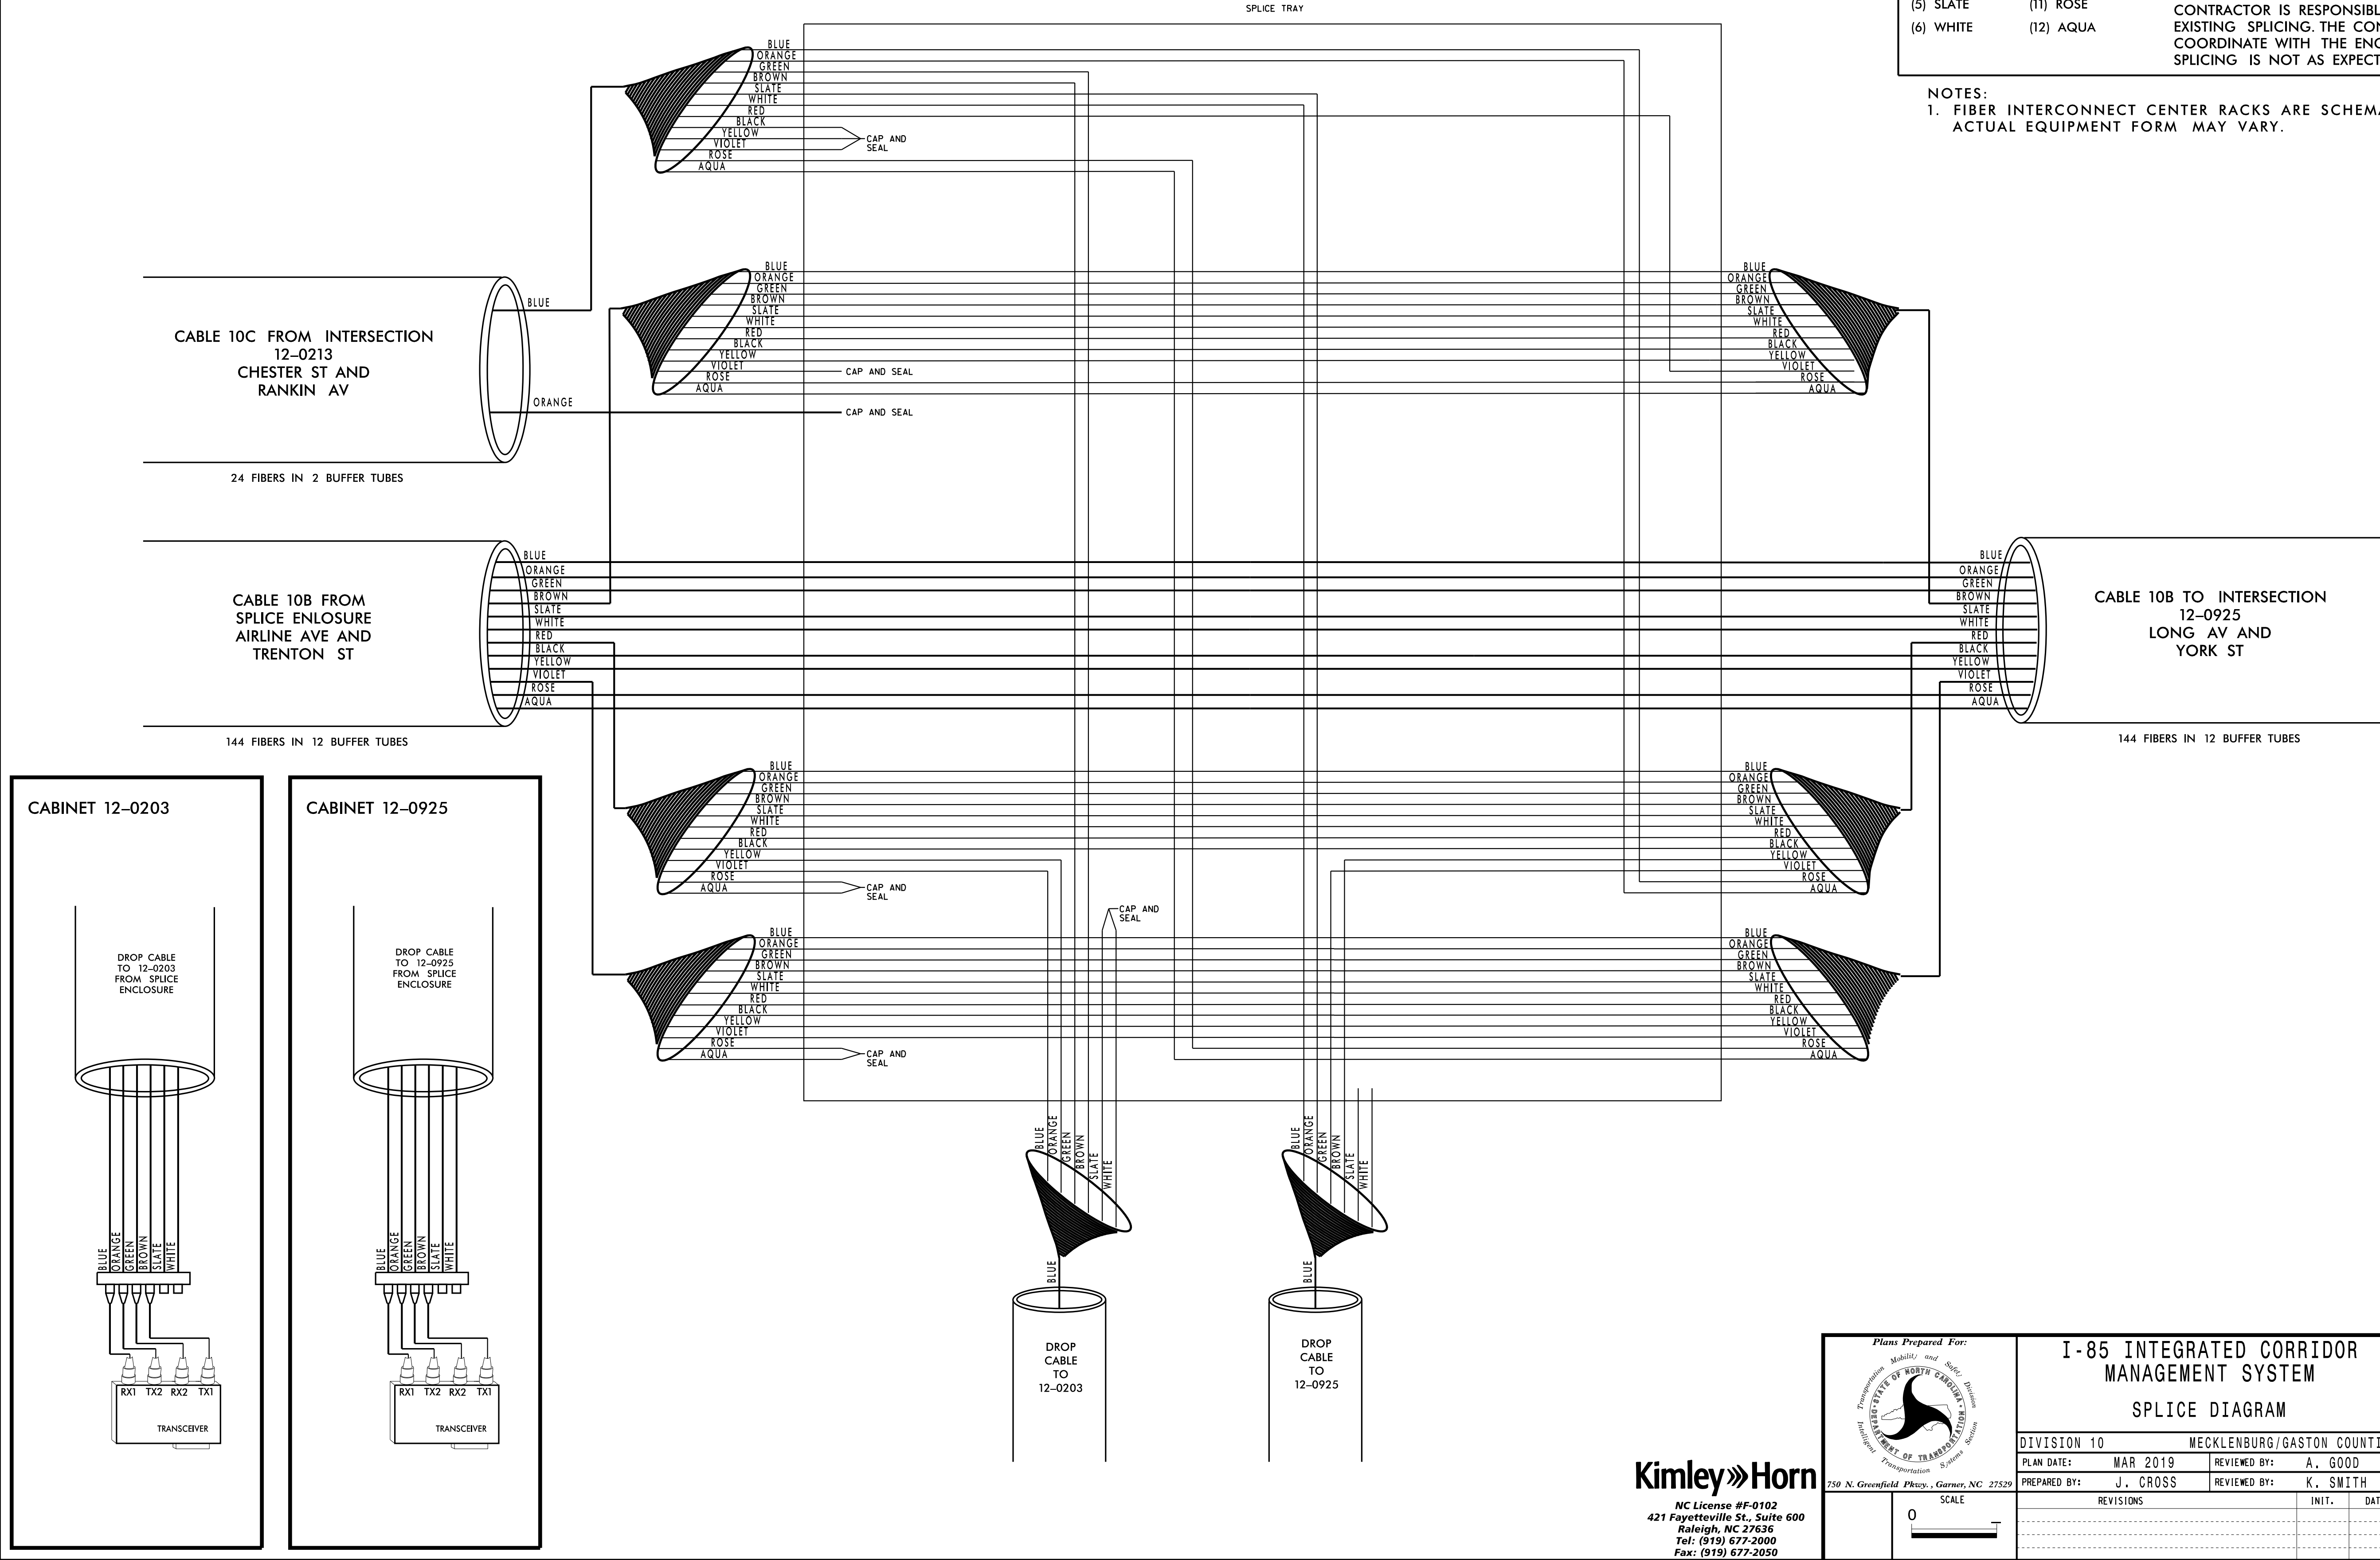

Plans Prepared For:

STATE OF NORTH CAROLINA

DEPARTMENT OF TRANSPORTATION

Division 10

I-85 INTEGRATED CORRIDOR
MANAGEMENT SYSTEM

SPLICE DIAGRAM

DIVISION 10

MECKLENBURG/GASTON COUNTIES

PLAN DATE: MAR 2019

REVIEWED BY: A. GOOD

PREPARED BY: J. CROSS

REVIEWED BY: K. SMITH

REVISIONS

INIT.

DATE

DocuSign

Signature

3/26/2019

SEAL

SEAL 030472

KEVIN W. SMITH

ENGINEER

CADD Filename:

DATE

TOC FIBER TERMINAL PANEL

CABLE 13D		BUFFER TUBE											
144 FIBERS		BLUE	ORANGE	GREEN	BROWN	SLATE	WHITE	RED	BLACK	YELLOW	VIOLET	ROSE	AQUA
FIBER	Blue												
	Orange										CCTV-2		
	Green												
	Brown										CCTV-3		
	Slate												
	White										CCTV-4		
	Red												
	Black										CCTV-5		
	Yellow												
	Violet										CCTV-6		
	Rose												
	Aqua												

3/26/2019
K:\RAL\TPTD\ITS\01036443 I-85 ICM\6 Tasks\3 PS&E\Plans\C-5600.ITS_psh40.dgn

Kimley»Horn
NC License #F-0102
421 Fayetteville St., Suite 600
Raleigh, NC 27636
Tel: (919) 677-2000
Fax: (919) 677-2050

Plans Prepared For:
DIVISION OF NORTH CAROLINA
TRANSPORTATION
750 N. Greenfield Pkwy., Garner, NC 27529

0
SCALE

I-85 INTEGRATED CORRIDOR
MANAGEMENT SYSTEM
SPLICE DIAGRAM

DIVISION 10 MECKLENBURG/GASTON COUNTIES

PLAN DATE: MAR 2019 REVIEWED BY: A. GOOD

PREPARED BY: J. CROSS REVIEWED BY: K. SMITH

REVISIONS

INIT. DATE


SEAL
NORTH CAROLINA
PROFESSIONAL
ENGINEER
KEVIN W. SMITH
SEAL 030472

DocuSigned by:
Kevin W. Smith
3/26/2019

SIGNATURE DATE

CADD Filename:

PHASING DIAGRAM

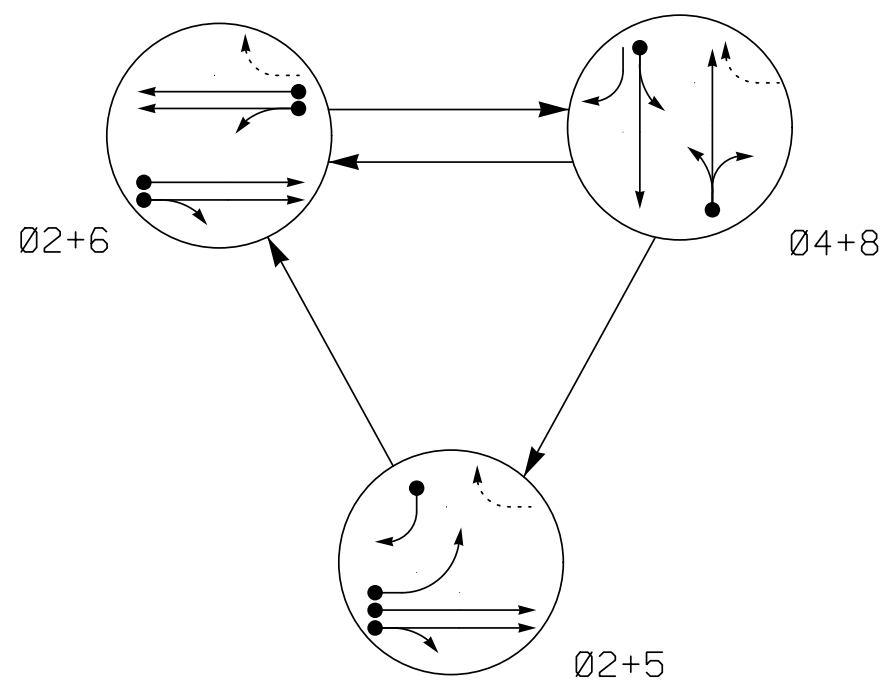


SIGNAL FACE	PHASE			
	Ø 2 + 5	Ø 2 + 6	Ø 4 + 8	F L O O H
21, 22	G	G	R	Y
41, 43	R	R	G	R
42	R	R	G	R
51	R	R	G	R
61, 62	R	G	R	Y
81, 82	R	R	G	R
SIGN 'F'	*	*	*	OFF

*Changeable Trailblazer Sign controlled remotely

SIGNAL FACE I.D.



⌚ Denotes L.E.D.

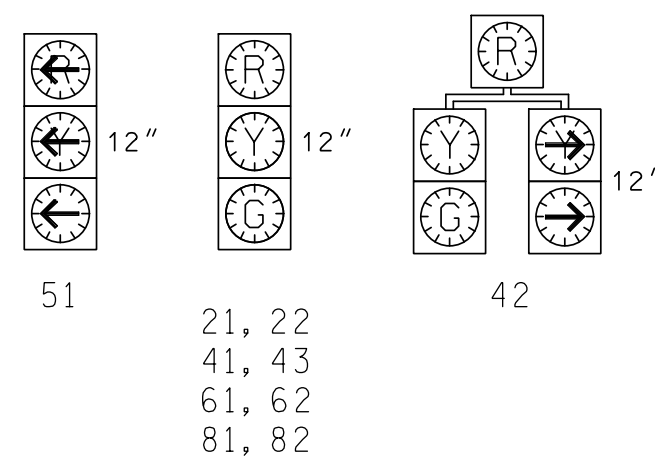

2070L LOOP & DETECTOR INSTALLATION											
INDUCTIVE LOOPS					DETECTOR PROGRAMMING						
LOOP	SIZE (FT)	TURNS	DISTANCE FROM STOPBAR (FT)	NEW LOOP	PHASE	CALLING	EXTENSION	FULL TIME DELAY SYSTEM LOOP	STRETCH TIME	DELAY TIME	NEW CARD
2A	EXISTING	EXISTING	EXISTING	Y	2	Y	Y	-	-	-	-
2B	EXISTING	EXISTING	EXISTING	Y	2	Y	Y	-	-	-	-
4A	EXISTING	EXISTING	EXISTING	Y	4	Y	Y	-	-	-	-
5A	EXISTING	EXISTING	EXISTING	Y	5	Y	Y	-	-	-	-
5B	EXISTING	EXISTING	EXISTING	Y	5	Y	Y	-	-	15	-
6A	EXISTING	EXISTING	EXISTING	Y	6	Y	Y	-	-	-	-
6B	EXISTING	EXISTING	EXISTING	Y	6	Y	Y	-	-	-	-
8A	EXISTING	EXISTING	EXISTING	Y	8	Y	Y	-	-	3	-
8B	EXISTING	EXISTING	EXISTING	Y	8	Y	Y	-	-	3	-
8C	EXISTING	EXISTING	EXISTING	Y	8	Y	Y	-	-	15	-

3 PHASE
FULLY ACTUATED
(Gastonia City System)
NOTES

- Refer to "Roadway Standard Drawings NCDOT" dated January 2002 and "Standard Specifications for Roads and Structures" dated January 2002.
- Do not program signal for late night flashing operation unless otherwise directed by the Engineer.
- Omit phase 5 during phase 6 on.
- Program controller to clear from phase 2+6 to phase 2+5 by progressing through phase 4+8 (see Electrical Details).
- Set all detector units to presence mode.
- Locate new cabinet so as not to obstruct sight distance of vehicles turning right on red.
- Pavement markings are existing.
- Maximum times shown in timing chart are for free-run operation only. Coordinated signal system timing values supersede these values.
- City system data:
Controller Asset # 1715.
- A signal upgrade was done in 2004 under a different project. This plan is revised to be part of the city system and some minor changes in the Timing Chart.

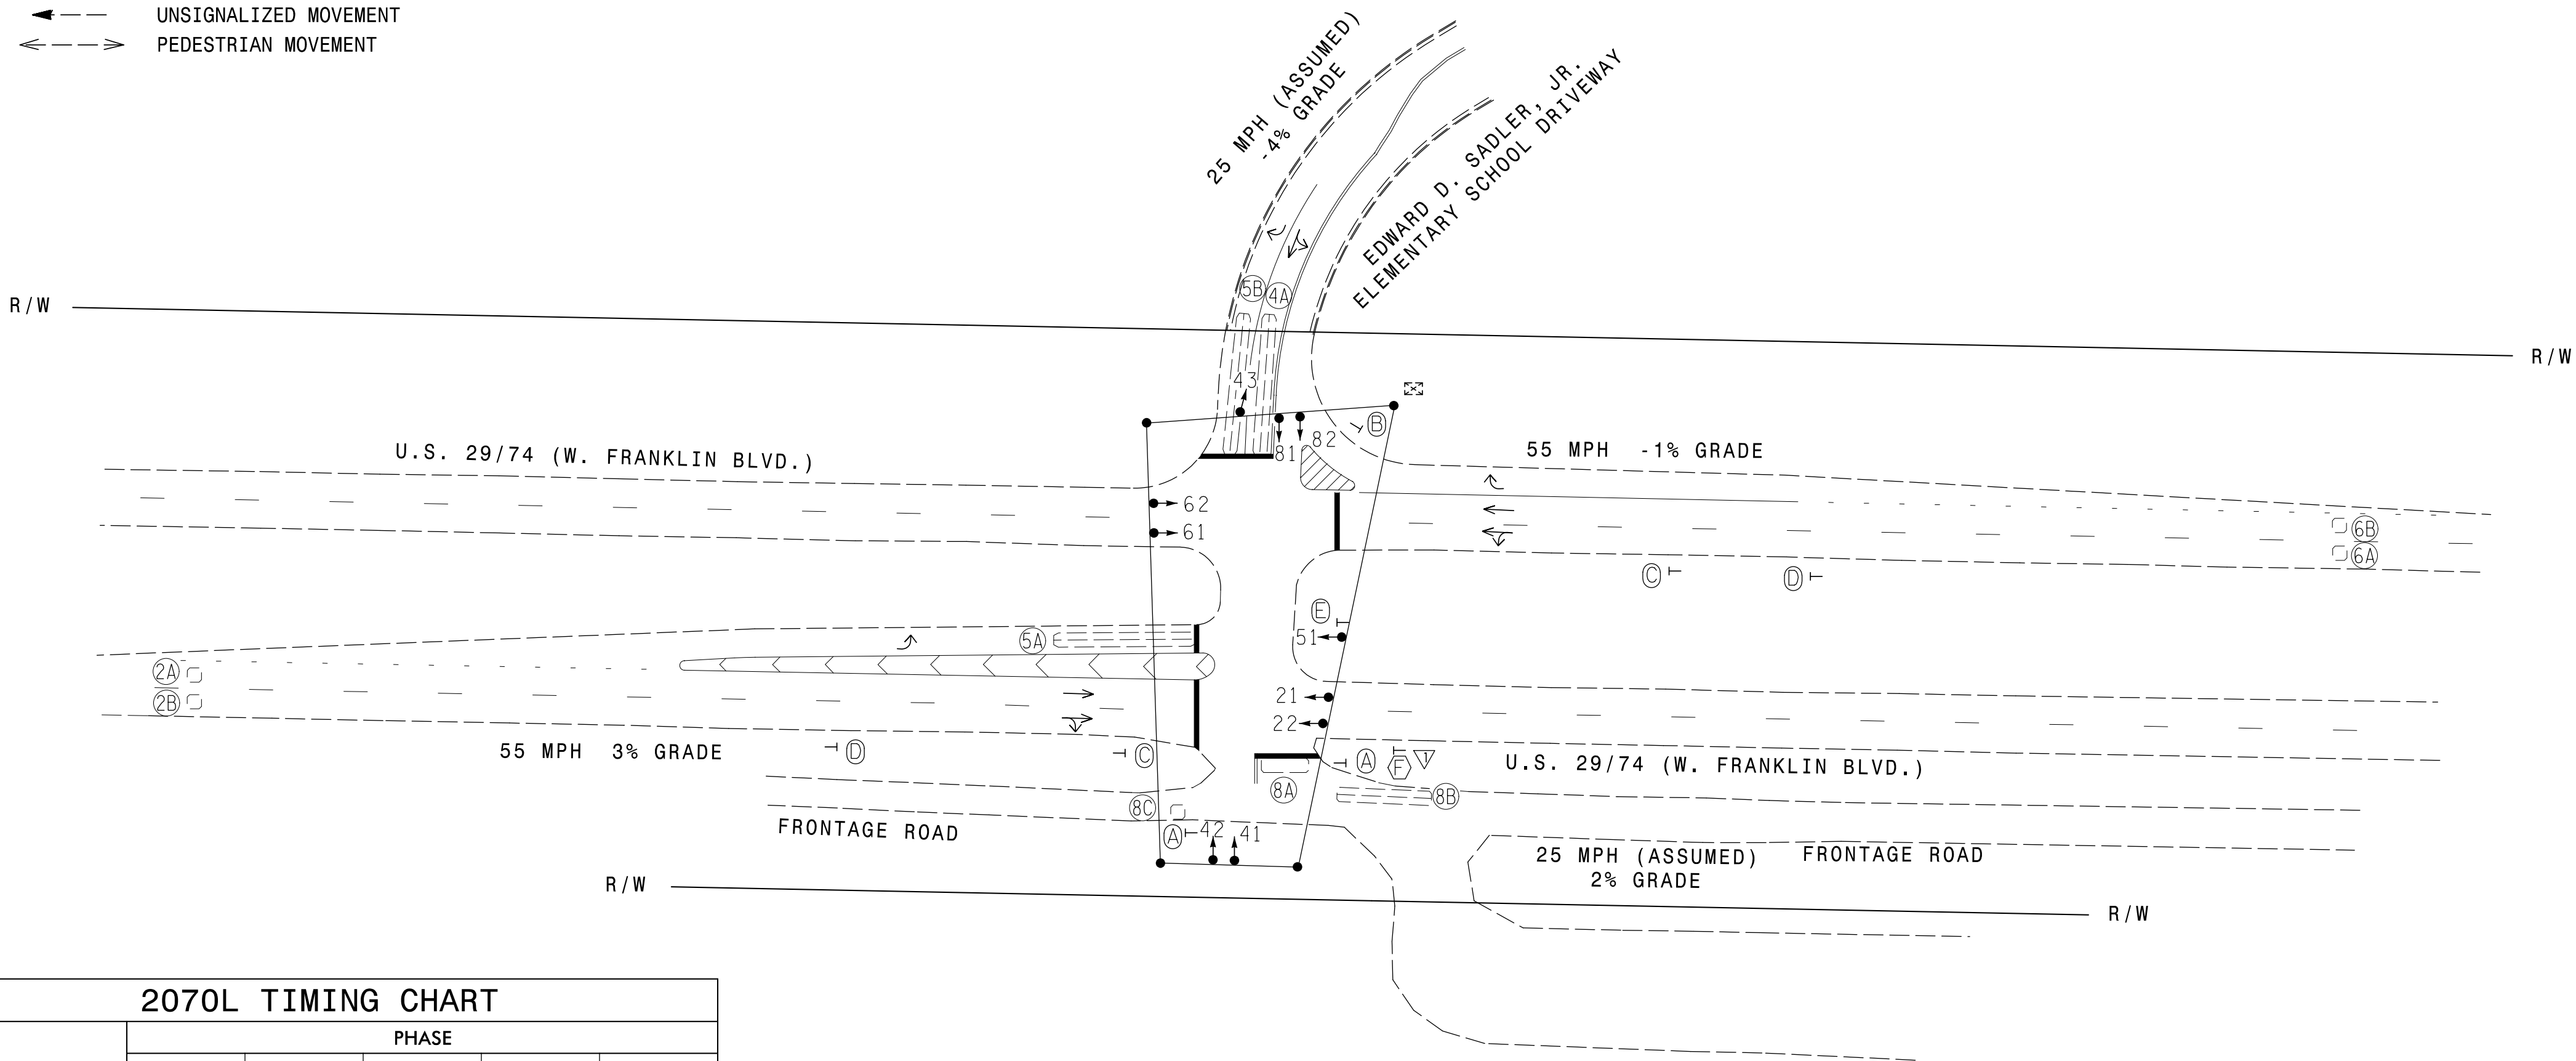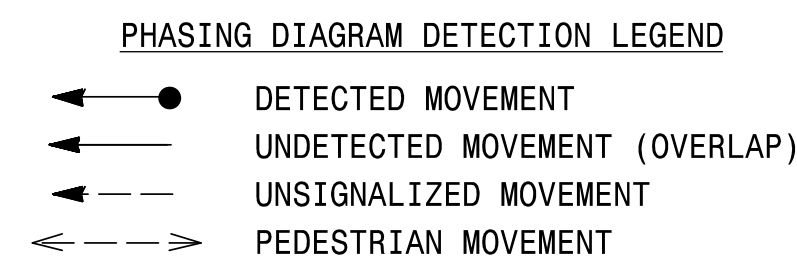

2070L TIMING CHART					
FEATURE	PHASE				
	2	4	5	6	8
Min Green 1 *	14	7	7	14	7
Extension 1 *	6.0	1.0	1.0	6.0	3.0
Max Green 1 *	90	30	20	90	30
Yellow Clearance	5.1	4.0	4.0	5.1	4.0
Red Clearance	2.5	3.1	2.7	2.5	3.1
Walk 1 *	-	-	-	-	-
Don't Walk 1	-	-	-	-	-
Seconds Per Actuation *	1.8	-	-	1.8	-
Max Variable Initial *	46	-	-	46	-
Time Before Reduction *	15	-	-	15	-
Time To Reduce *	45	-	-	45	-
Minimum Gap	3.4	-	-	3.4	-
Recall Mode	MIN. RECALL	-	-	MIN. RECALL	-
Vehicle Call Memory	YELLOW	-	-	YELLOW	-
Dual Entry	-	ON	-	-	ON
Simultaneous Gap	ON	ON	ON	ON	ON

* These values may be field adjusted. Do not adjust Min Green and Extension times for phases 2 and 6 lower than what is shown. Min Green for all other phases should not be lower than 4 seconds.

LEGEND




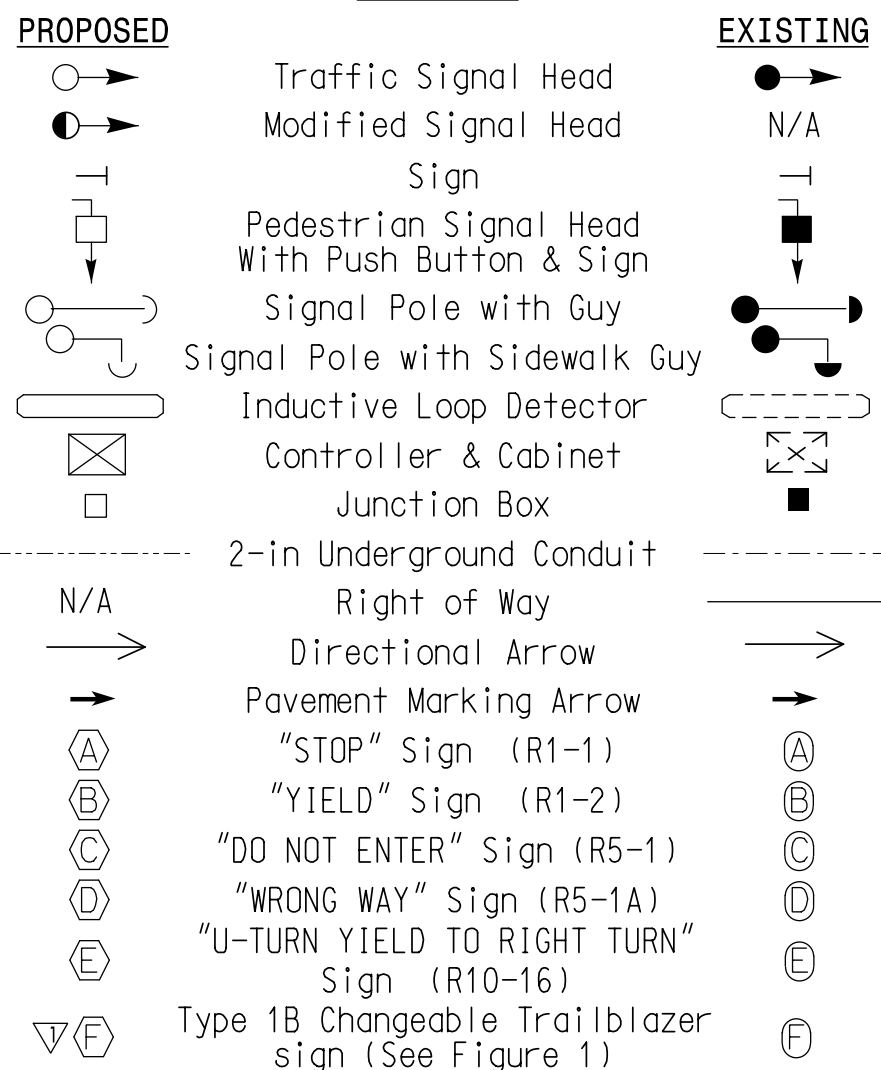


FIGURE 1

TYPE 1B - CHANGEABLE TRAILBLAZER SIGN

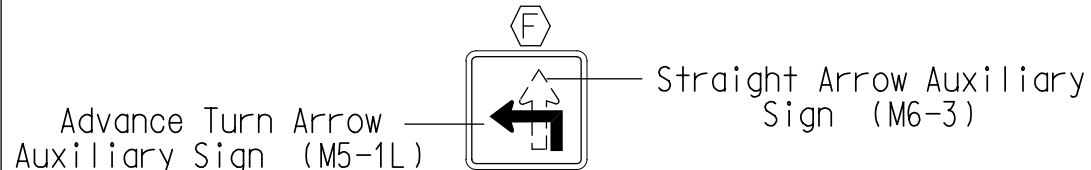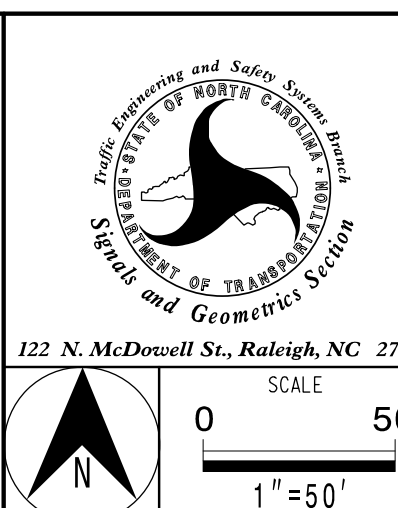

SIGNAL UPGRADE

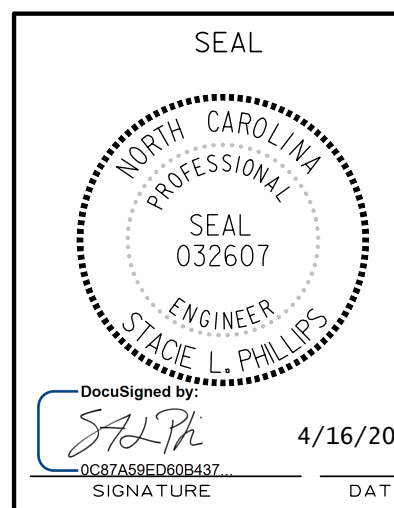

U.S. 29/74 (W. FRANKLIN BLVD.) AT EDWARD D. SADLER, JR. ELEMENTARY SCHOOL / FRONTAGE ROAD	
DIVISION 12	GASTON COUNTY
PLAN DATE: February 2005	REVIEWED BY: D.Y. Ishak
PREPARED BY: L. Blount	REVIEWED BY:
REVISIONS	INIT. DATE
INSTALL CHANGEABLE TRAILBLAZER SIGN	SLP 4/2019

SEAL	
Not a certified document as to the Original Document but Only as to the Revisions - This document originally Issued and sealed by Richard E. Mullinax, PE #22027 on 12/10/2004	
This document is only certified as to the revisions.	
SIGNATURE	DATE
SIG. INVENTORY NO.	12-1715

PROGRAMMING DETAIL

WD ENABLE

SW2

OFF ON

(remove jumpers and set switches as shown)

REMOVE DIODE JUMPERS 2-5, 2-6 AND 4-8.

CONFLICT PROGRAM CARD

COMPONENT SIDE

YELLOW DISABLE

The diagram shows a Conflict Program Card with two rows of components. The top row is labeled 'CONFLICT PROGRAM CARD' and the bottom row is labeled 'COMPONENT SIDE'. The card has 16 columns, numbered 9-0 to 8-9. Each column has a series of diodes and jumpers. The 'YELLOW DISABLE' section shows the settings for each column: 9-0 (0 9 0 0 1 0), 9-1 (0 10 0 0 2 0), 9-2 (0 11 0 0 3 0), 9-3 (0 12 0 0 4 0), 9-4 (0 13 0 0 5 0), 9-5 (0 14 0 0 6 0), 9-6 (0 15 0 0 7 0), 9-7 (0 16 0 0 8 0), 8-9 (0 17 0 0 9 0), 8-8 (0 18 0 0 10 0), 8-7 (0 19 0 0 11 0), 8-6 (0 20 0 0 12 0), 8-5 (0 21 0 0 13 0), 8-4 (0 22 0 0 14 0), 8-3 (0 23 0 0 15 0), 8-2 (0 24 0 0 16 0), 8-1 (0 25 0 0 17 0), 8-0 (0 26 0 0 18 0).

1. Card is provided with all diode jumpers in place. Removal of any jumper allows its channels to run concurrently.
2. Make sure jumpers SEL1-SEL5 are present on the monitor board.

(front view)

EX.: 1A, 2A, ETC. = LOOP NO.'S

DYNAMIC BACK-UP CONTROL PROGRAMMING

1. From Main Menu press '2' (Phase Control), then '1' (Phase Control Functions). Scroll to the bottom of the menu and enable Dynamic/Backup Control Function 1.
2. From Phase Control Functions Menu press '2' (Dynamic/Backup Control Functions).

BACKUP PROTECTION PROGRAMMING COMPLETE

1. To prevent "flash-conflict" problems, insert red flash program blocks for all unused vehicle load switches in the output file. The installer shall verify that signal heads flash in accordance with the Signal Plans.

2. Ensure that Red Enable is active at all times during normal operation. To prevent Red Failures on unused monitor channels, tie unused red monitor inputs 1,3,7,9,10,11,12,13,14,15 & 16 to load switch AC+ per the cabinet manufacturer's instructions.

3. Program controller to start up in phases 2 and 6 green.

4. Enable Simultaneous Gap-Out, on the controller unit, for all phases.

5. Program phases 4 and 8, on the controller unit, for Dual Entry.

6. Program phases 2 and 6, on the controller unit, for Variable Initial and Gap Reduction.

7. The cabinet and controller are part of the Gastonia City System.

```

CONTROLLER.....CONTRACTOR SUPPLIED 2070L*
CABINET.....CONTRACTOR SUPPLIED 332*
SOFTWARE.....ECONOLITE OASIS
CABINET MOUNT.....BASE
OUTPUT FILE POSITIONS...12
LOAD SWITCHES USED.....S2,S4,S5,S6,S8
PHASES USED.....2,4,5,6,8
OVERLAPS.....NONE

```

* Existing Equipment

LOOP NO.	LOOP TERMINAL	INPUT FILE POS.	PIN NO.	INPUT ASSIGNMENT NO.	DETECTOR NO.	NEMA PHASE	CALL	EXTEND	FULL TIME DELAY	STRETCH TIME	DELAY TIME
2A	TB2-5,6	I2U	39	1	2	2	Y	Y			
2B	TB2-7,8	I2L	43	5	12	2	Y	Y			
4A	TB4-9,10	I6U	41	3	4	4	Y	Y			
5A	TB3-1,2	J1U	55	17	5	5	Y	Y			
6A	TB3-5,6	J2U	40	2	6	6	Y	Y			
6B	TB3-7,8	J2L	44	6	16	6	Y	Y			
5B	TB3-9,10	J3U	64	26	36	5	Y	Y			15
8A	TB5-9,10	J6U	42	4	8	8	Y	Y			3
8B	TB5-11,12	J6L	46	8	18	8	Y	Y			3
8C	TB7-1,2	J7U	66	28	38	8	Y	Y			15

INPUT FILE POSITION LEGEND: J2L

FILE J _____
SLOT 2 _____
LOWER _____

[illegible]

** Changeable Trailblazer Signs. See wiring and programming detail on this sheet.

SIGN



Remove, tape, and label conflict monitor wire attached to rear of terminal 2PY(114) and 4PY(105).

THIS ELECTRICAL DETAIL IS FOR
THE SIGNAL DESIGN: 12-1715
DESIGNED: February 2005
SEALED: 2/23/05
REVISED: 4/16/2019

Signal Upgrade Sheet 1 of 2

US 29/74 (W. Franklin Blvd.) at Edward D. Sadler, Jr. Elementary School / Frontage Road
--

Division 12	Gaston County	Gastonia
-------------	---------------	----------

PREPARED BY: William Hairston	REVIEWED BY:
-------------------------------	--------------

REVISIONS	INIT.	DATE
-----------	-------	------

DOCUMENT NOT CONSIDERED
FINAL UNLESS ALL
SIGNATURES COMPLETED

REAL

Not a certified document as
to the Original Document but
Only as to the Revisions -
This document originally
issued and sealed by
George C. Brown, #022013,
on 02/25/05.
This document is only certified
as to the revisions.

SIGNATURE	DATE
-----------	------


\$\$\$SYSTIME\$\$\$
 \$\$\$DGN\$\$\$
 \$\$\$USERNAME\$\$\$

LOGICAL I/O PROCESSOR PROGRAMMING DETAIL
TO CONTROL TRAILBLAZER SIGN

(program controller as shown below)

1. FROM MAIN MENU PRESS '2' (PHASE CONTROL), THEN '1' (PHASE CONTROL FUNCTIONS). SCROLL TO THE BOTTOM OF THE MENU AND ENABLE ACT LOGIC COMMANDS 31 AND 32.
2. FROM MAIN MENU PRESS '6' (OUTPUTS), THEN '3' (LOGICAL I/O PROCESSOR).

TOGGLE TO COMMAND #31

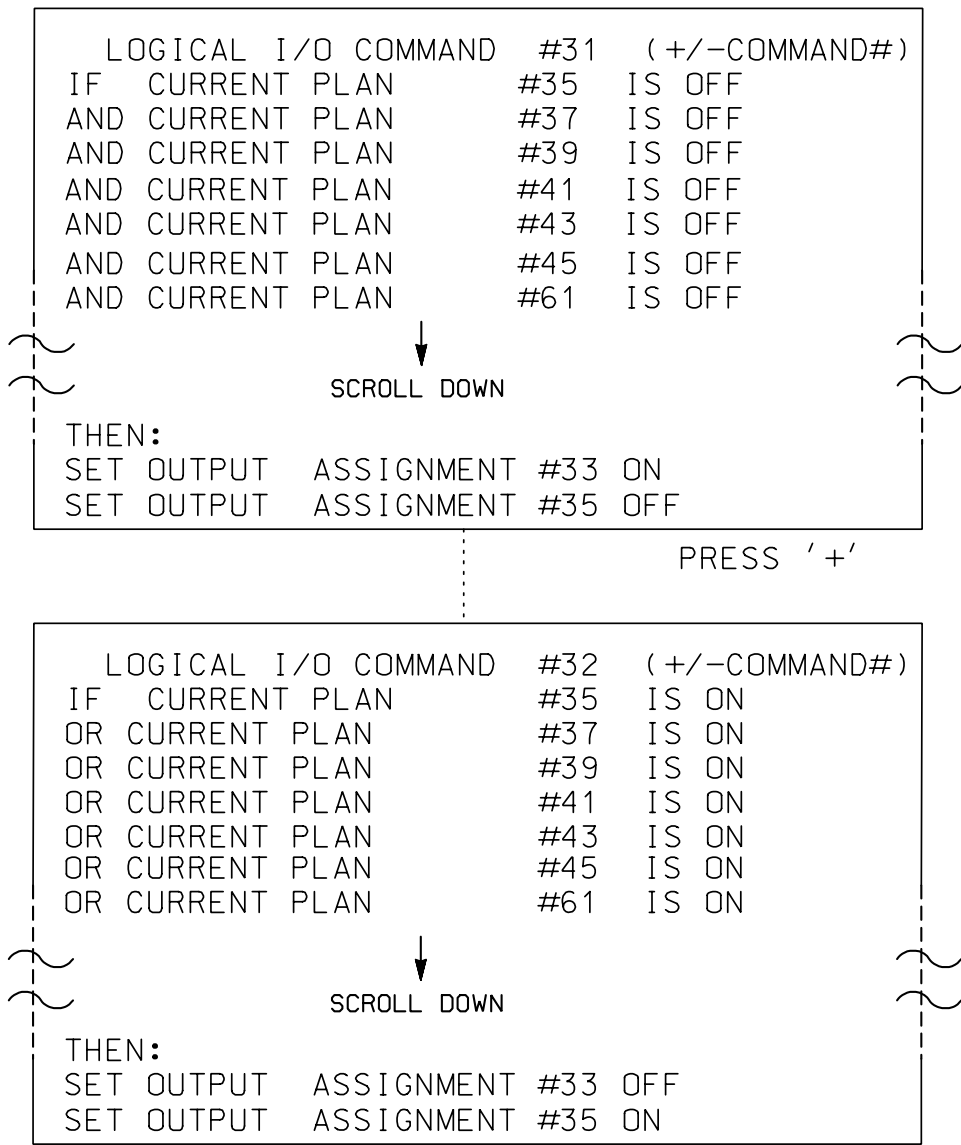

LOGIC I/O PROCESSOR PROGRAMMING COMPLETE

THIS ELECTRICAL DETAIL IS FOR
THE SIGNAL DESIGN: 12-1715
DESIGNED: February 2005
SEALED: 2/23/05
REVISED: 4/16/2019

DOCUMENT NOT CONSIDERED
FINAL UNLESS ALL
SIGNATURES COMPLETED

SEAL

*Not a certified document as
to the Original Document but
Only as to the Revisions -
This document originally
issued and sealed by
George C. Brown, #022013,
on 02/25/05.
This document is only certified
as to the revisions.*

SIGNATURE	DATE
SIG. INVENTORY NO.	12-1715

PLANS PREPARED IN THE OFFICE OF:
Kimley»Horn
NC License #F-0102
421 Fayetteville Street, Suite 600
Raleigh, NC 27601
(919) 677-2000

SEAL

NORTH CAROLINA
PROFESSIONAL
SEAL
032607
ENGINEER
STACIE L. PHILLIPS

DocuSigned by
Stacie L. Phillips
0CB7A55ED9B0A437...

4/16/2019

SIGNATURE DATE

**ELECTRICAL AND PROGRAMMING
DETAILS FOR:**


Prepared In the Offices of:



750 N. Greenfield Pkwy, Garner, NC 27529

US 29/74 (W. Franklin Blvd.)
at
Edward D. Sadler, Jr. Elementary
School / Frontage Road
Gastonia
Division 12 Gaston County
PLAN DATE: February 2005 REVIEWED BY: T. Joyce
PREPARED BY: William Hairston
REVISED BY:
REVISIONS
INIT. DATE
ADD TRAILBLAZER SIGN PROGRAMMING SLP 4/2019

PHASING DIAGRAM

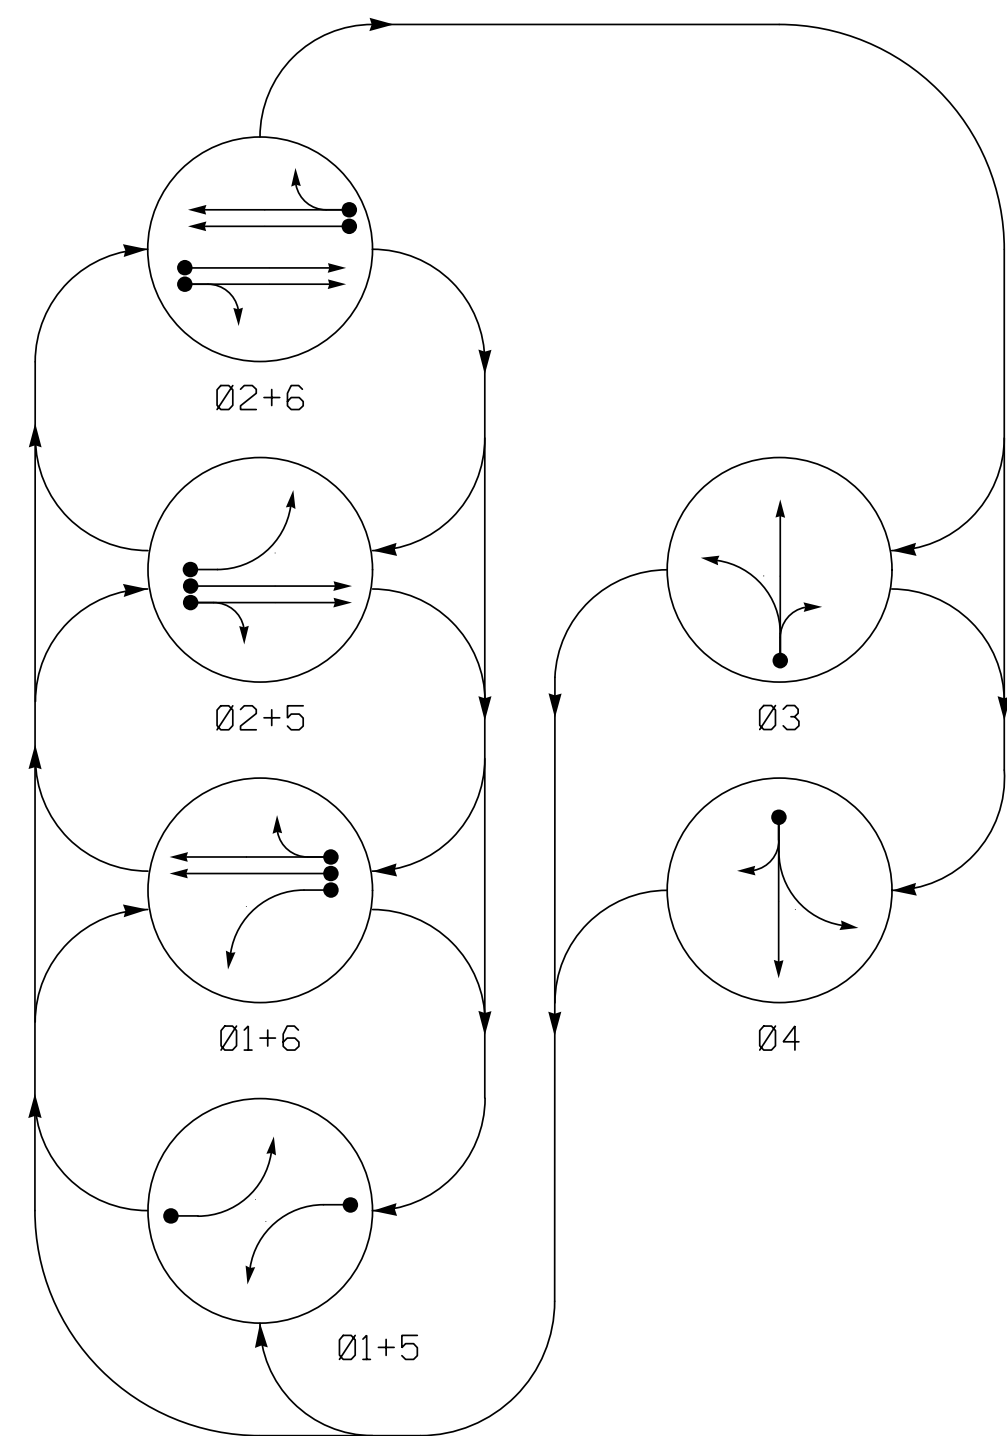

PHASING DIAGRAM DETECTION LEGEND

- | | |
|---|-------------------------------|
|  | DETECTED MOVEMENT |
|  | UNDETECTED MOVEMENT (OVERLAP) |
|  | UNSIGNALIZED MOVEMENT |
| | PEDESTRIAN MOVEMENT |


TABLE OF OPERATION

SIGNAL FACE	PHASE						
	Ø 1 + 5	Ø 1 + 6	Ø 2 + 5	Ø 2 + 6	Ø 3	Ø 4	FLASH
II	←	←	←R	←R	R	←R	←R
2I, 22	R	R	G	G	R	R	Y
3I					<u>G</u>	R	R
32, 33	R	R	R	R	G	R	R
4I	R	R	R	R	R	<u>G</u>	R
42, 43	R	R	R	R	R	G	R
5I	←	←R	←	←R	←R	←R	←R
6I, 62	R	G	R	G	R	R	Y
SIGN 'D'	*	*	*	*	*	*	OFF

*Changeable Trailblazer Sign controlled remotely

SIGNAL FACE I.D.

 Denotes L.E.D.

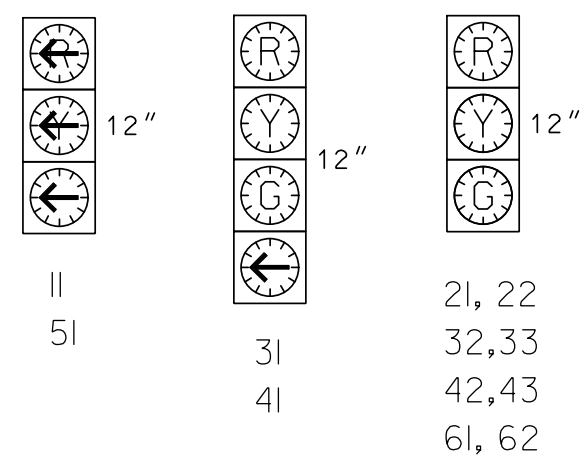


2070L LOOP & DETECTOR INSTALLATION

INDUCTIVE LOOPS					DETECTOR PROGRAMMING							
LOOP	SIZE (FT)	TURNS	DISTANCE FROM STOPBAR (FT)	NEW LOOP	PHASE	CALLING	EXTENSION	FULL TIME DELAY	SYSTEM LOOP	STRETCH TIME	DELAY TIME	NEW CARD
1A	6X25	EXISTING	EXISTING	Y	1	Y	Y	-	-	-	-	Y
1B	6X25	EXISTING	EXISTING	Y	1	Y	Y	-	-	-	-	Y
1C	6X25	EXISTING	EXISTING	Y	1	Y	-	-	-	-	-	Y
2A	6X6	EXISTING	EXISTING	Y	2	Y	Y	-	-	-	-	Y
2B	6X6	EXISTING	EXISTING	Y	2	Y	Y	-	-	-	-	Y
3A	6X80	EXISTING	EXISTING	Y	3	Y	Y	-	-	-	15	Y
3B	6X20	EXISTING	EXISTING	Y	3	Y	-	-	-	-	15	Y
4A	6X80	EXISTING	EXISTING	Y	4	Y	Y	-	-	-	15	Y
4B	6X35	EXISTING	EXISTING	Y	4	Y	Y	-	-	-	15	Y
5A	6X25	EXISTING	EXISTING	Y	5	Y	Y	-	-	-	-	Y
5B	6X25	EXISTING	EXISTING	Y	5	Y	Y	-	-	-	-	Y
5C	6X25	EXISTING	EXISTING	Y	5	Y	-	-	-	-	-	Y
6A	6X6	EXISTING	EXISTING	Y	6	Y	Y	-	-	-	-	Y
6B	6X6	EXISTING	EXISTING	Y	6	Y	Y	-	-	-	-	Y








6 Phase
Fully Actuated
(Gastonia City System)

NOTES

1. Refer to "Roadway Standard Drawings NCDOT" dated January 2002 and "Standard Specifications for Roads and Structures" dated January 2002.
2. Do not program signal for late night flashing operation unless otherwise directed by the Engineer.
3. Phase 1 or phase 5 may be lagged.
4. The order of phase 3 and phase 4 may be reversed.
5. Set all detector units to presence mode.
6. Locate new cabinet so as not to obstruct sight distance of vehicles turning right on red.
7. Pavement markings are existing.
8. Maximum times shown in timing chart are for free-run operation only. Coordinated signal system timing values supersede these values.
9. City system data:
Controller Asset #: 0157.

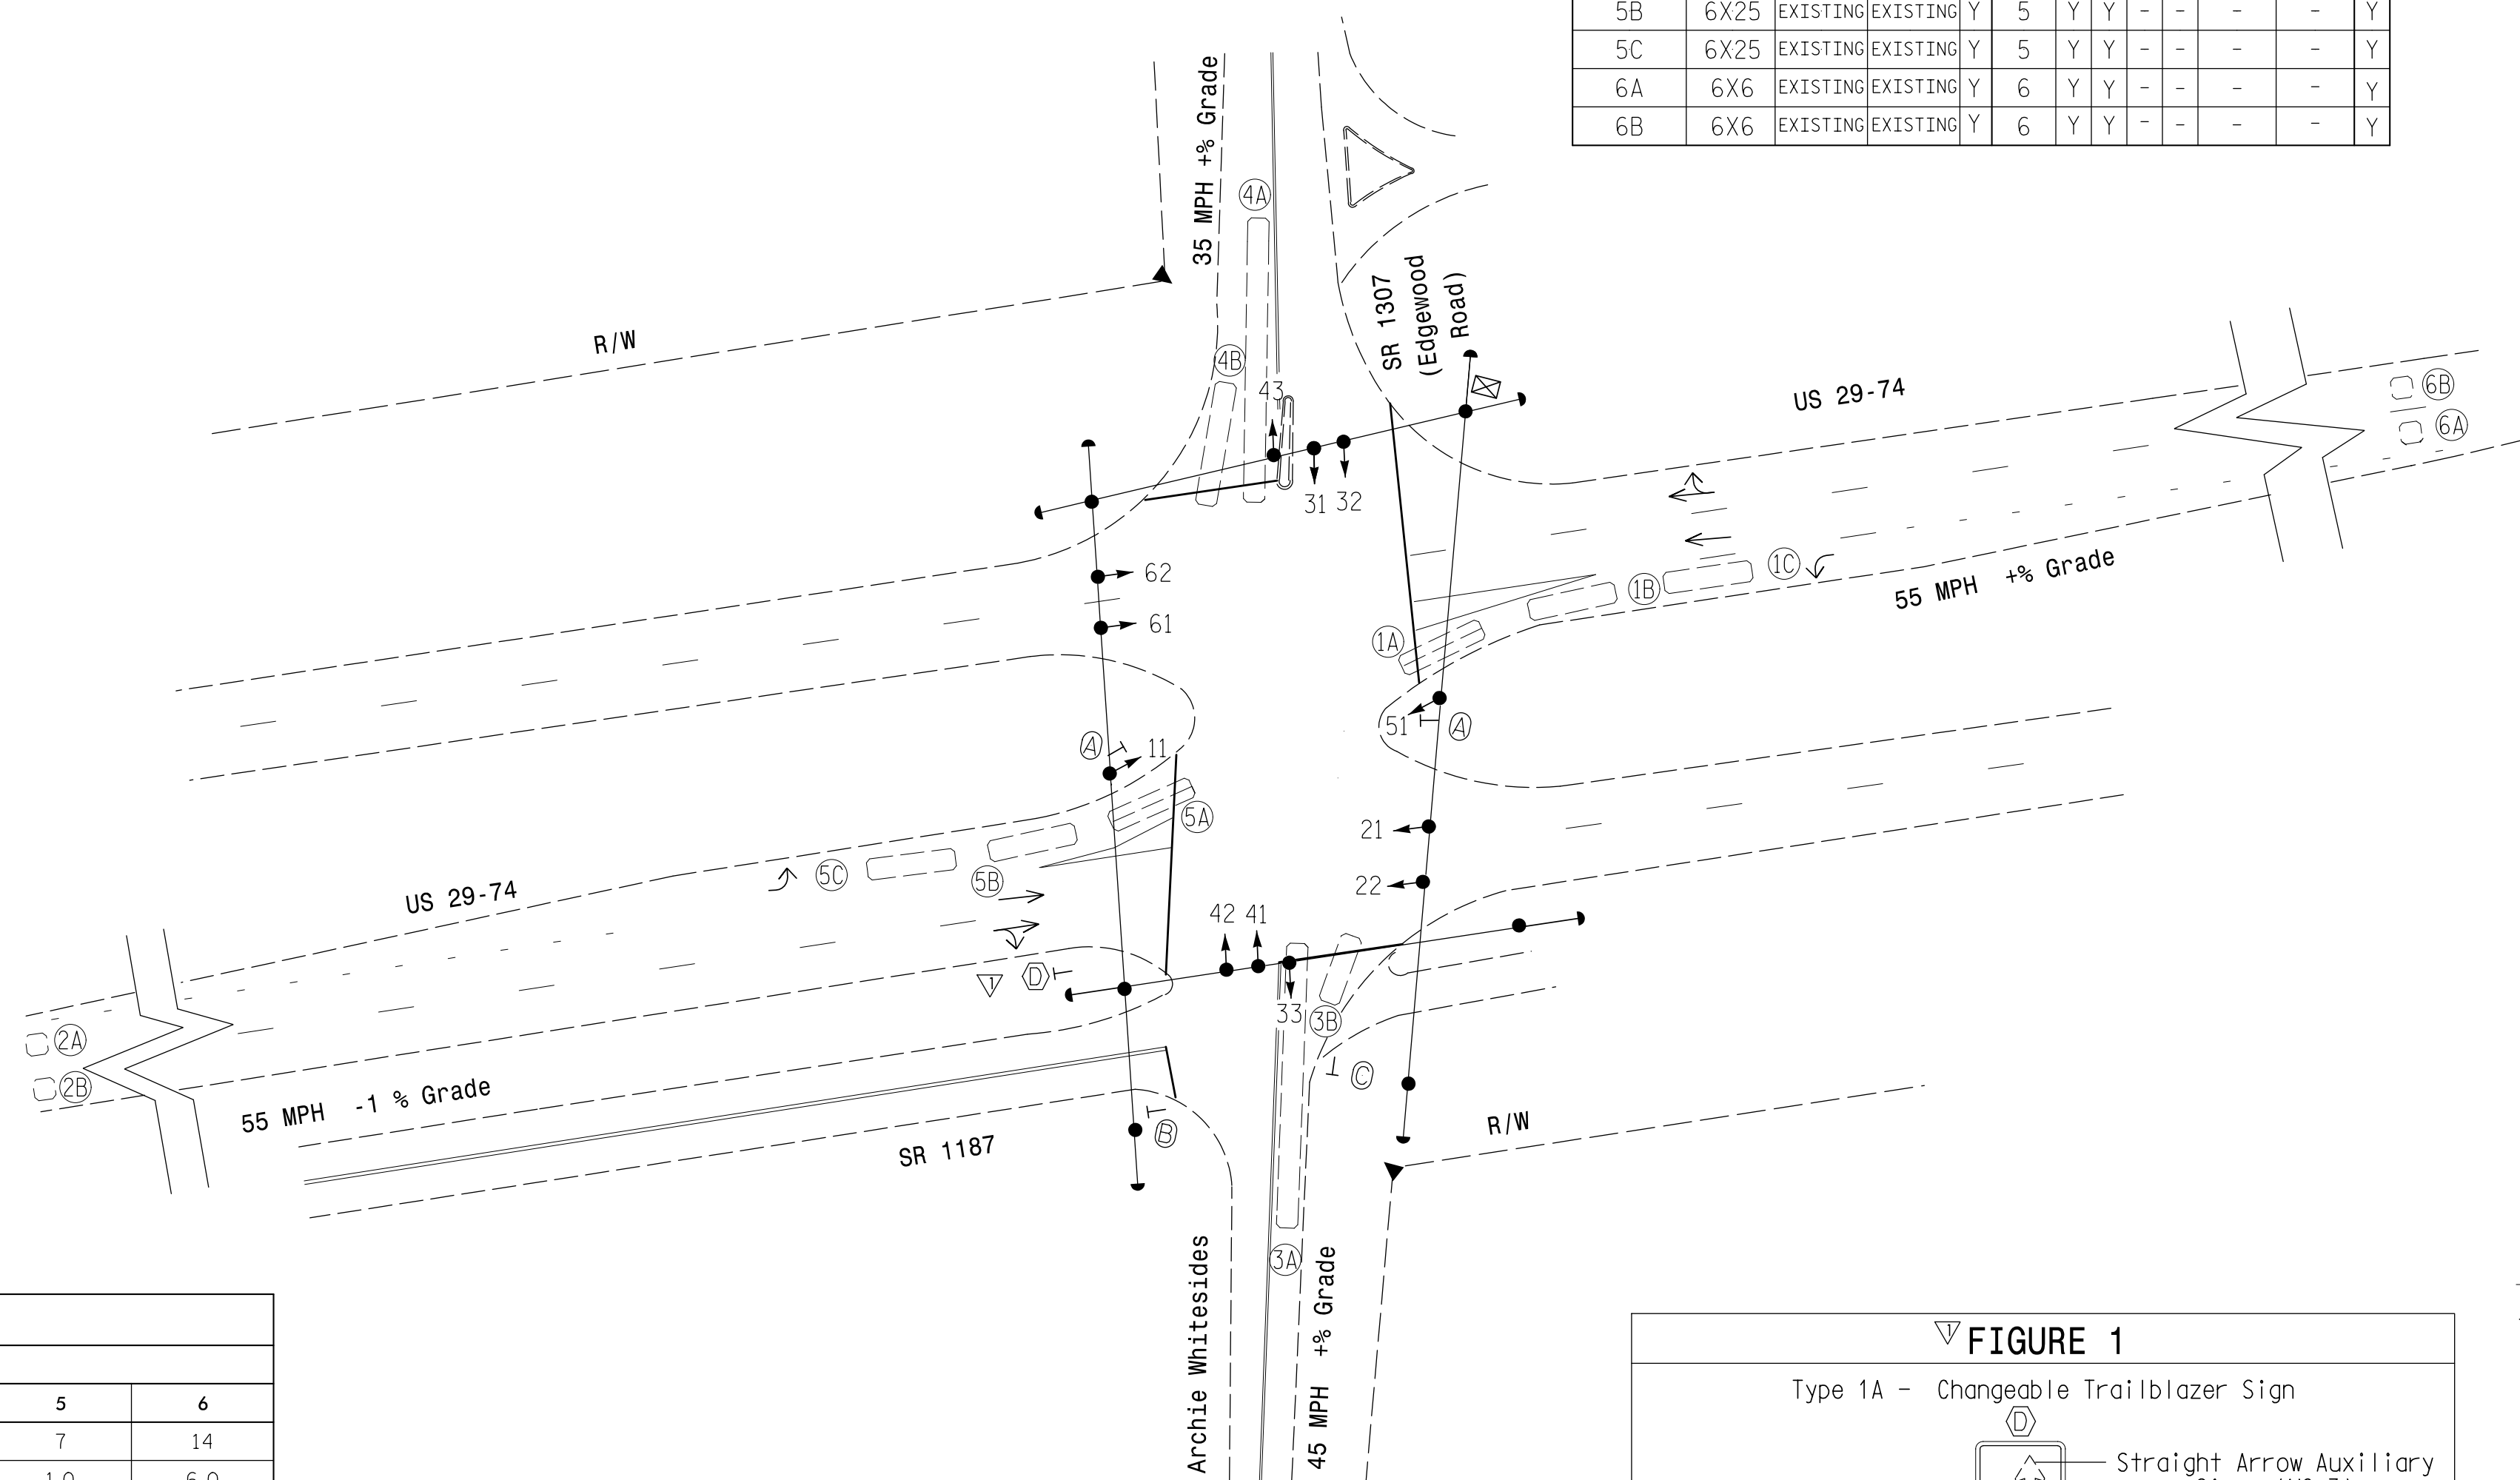

LEGEND

       PROPOSED		EXISTING
	Traffic Signal Head	 N/A
	Modified Signal Head	
	Sign	 N/A
	Pedestrian Signal Head With Push Button & Sign	 N/A
	Signal Pole with Guy	
	Signal Pole with Sidewalk Guy	
	Inductive Loop Detector	 N/A
	Controller & Cabinet	 N/A
	Pull Box	
	2-in Underground Conduit	 N/A
	Right of Way with Marker	 N/A
	Directional Arrow	
	Pavement Marking Arrow	 N/A
N/A	"LEFT TURN SIGNAL" Sign (R10-10L)	(A)
N/A	"STOP" Sign (R1-1)	(B)
N/A	"DO NOT BLOCK DRIVE" SIGN	(C)
	Type 1A Changeable Trailblazer sign (See Figure 1)	(D)

2070L TIMING CHART

FEATURE	PHASE					
	1	2	3	4	5	6
Min Green 1 *	7	14	7	7	7	14
Extension 1 *	1.0	6.0	1.0	1.0	1.0	6.0
Max Green 1 *	25	120	60	75	25	120
Yellow Clearance	3.0	5.3	4.5	3.8	3.0	5.2
Red Clearance	4.0	1.0	2.4	3.2	3.9	1.0
Walk 1 *	-	-	-	-	-	-
Don't Walk 1	-	-	-	-	-	-
Seconds Per Actuation *	-	1.5	-	-	-	1.5
Max Variable Initial *	-	44	-	-	-	44
Time Before Reduction *	-	20	-	-	-	20
Time To Reduction *	-	40	-	-	-	40
Minimum Gap	-	2.5	-	-	-	2.5
Recall Mode	-	MIN RECALL	-	-	-	MIN RECALL
Vehicle Call Memory	-	YELLOW	-	-	-	YELLOW
Dual Entry	-	-	-	-	-	-
Simultaneous Gap	ON	ON	ON	ON	ON	ON

* These values may be field adjusted. Do not adjust Min Green and Extension times for phases 2 and 6 lower than what is shown. Min Green for all other phases should not be lower than 4 seconds.

FIGURE 1

Type 1A - Changeable Trailblazer Sign

Left Arrow Auxiliary Sign (M6-1L)


Signal Upgrade

SEAL 	Prepared in the Offices of: 	US 29-74 At SR 1307 (Edgewood Road)/ (Archie Whitesides) Division 12 Gaston County W. of Gastonia	SEAL <i>Not a certified document as to the Original Document but Only as to the Revisions - This document originally Issued and sealed by Richard E. Mullnix, PE #22027 on 02/07/2005</i> <i>This document is only certified as to the revisions.</i>												
DocuSigned by:  08/15/2008 08:43Z SIGNATURE	122 N. McDowell St., Raleigh, NC 27603 	SCALE 0 40 1" = 40'	<table border="1" style="width: 100%; border-collapse: collapse;"> <tr> <td style="width: 50%;">PLANNED DATE: October 2004</td> <td style="width: 50%;">REVIEWED BY: Z.W. Little</td> </tr> <tr> <td>PREPARED BY: L. Blount</td> <td>REVIEWED BY:</td> </tr> </table> <table border="1" style="width: 100%; border-collapse: collapse; margin-top: 5px;"> <tr> <td style="width: 50%; text-align: center;">REVISONS</td> <td style="width: 10%; text-align: center;">INIT.</td> <td style="width: 10%; text-align: center;">DATE</td> <td style="width: 30%;"></td> </tr> <tr> <td style="text-align: center;">V INSTALL CHANGEABLE TRAILBLAZER SIGN</td> <td style="text-align: center;">SLP</td> <td style="text-align: center;">4/2019</td> <td></td> </tr> </table>	PLANNED DATE: October 2004	REVIEWED BY: Z.W. Little	PREPARED BY: L. Blount	REVIEWED BY:	REVISONS	INIT.	DATE		V INSTALL CHANGEABLE TRAILBLAZER SIGN	SLP	4/2019	
PLANNED DATE: October 2004	REVIEWED BY: Z.W. Little														
PREPARED BY: L. Blount	REVIEWED BY:														
REVISONS	INIT.	DATE													
V INSTALL CHANGEABLE TRAILBLAZER SIGN	SLP	4/2019													
4/16/2019 DATE			SIGNATURE DATE SIG. INVENTORY NO. 12-0157												

EDI MODEL 2010ECL CONFLICT MONITOR

PROGRAMMING DETAIL

(remove jumpers and set switches as shown)

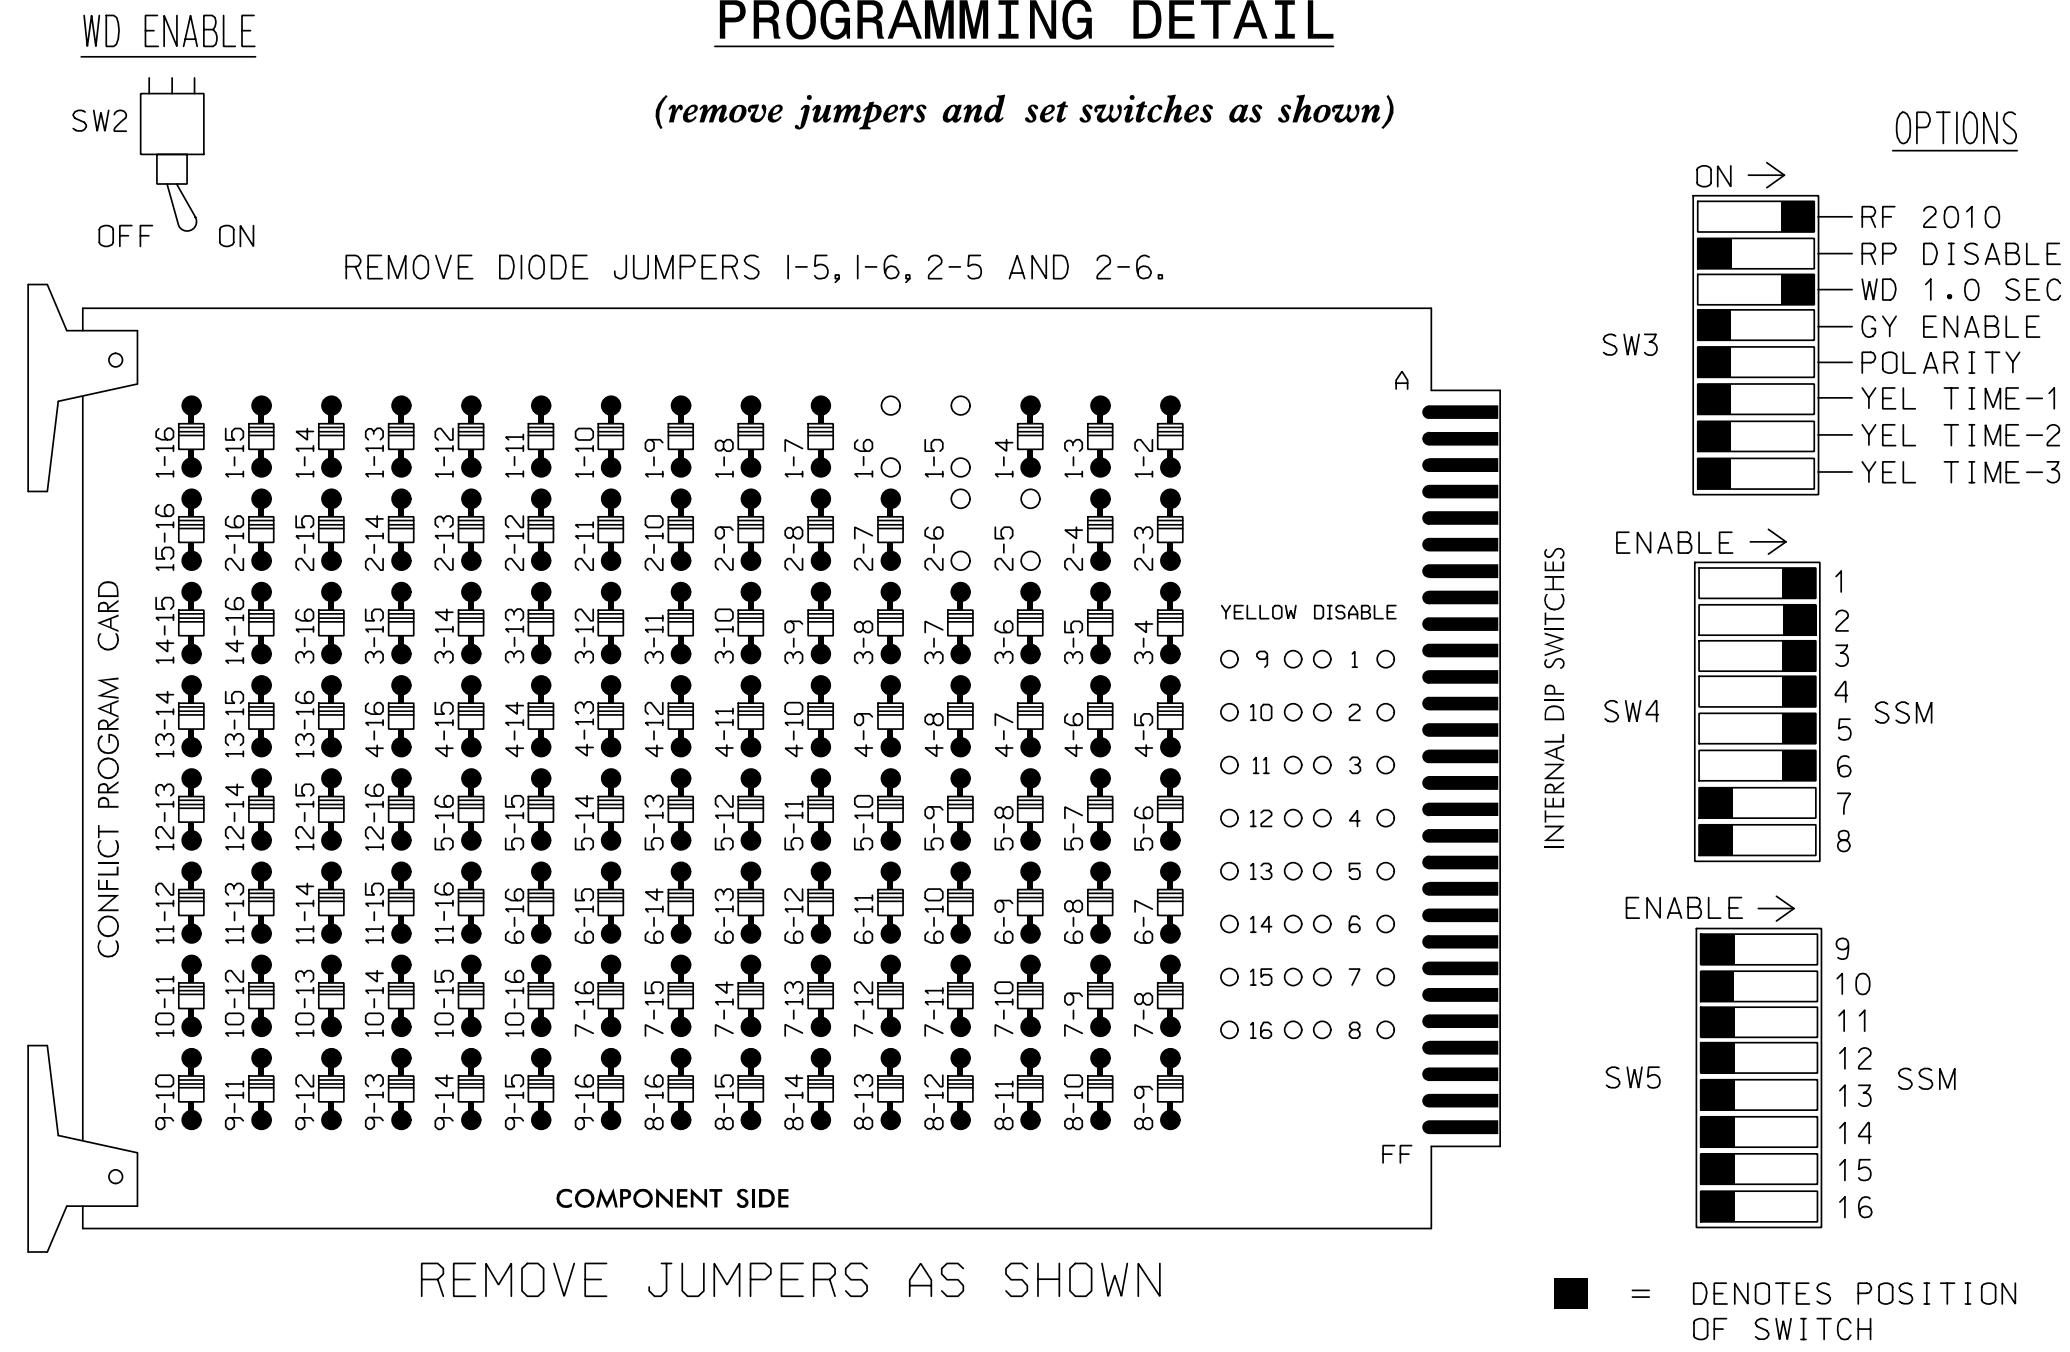

NOTES:

- Card is provided with all diode jumpers in place. Removal of any jumper allows its channels to run concurrently.
- Make sure jumpers SEL1-SEL5 are present on the monitor board.

NOTES

- To prevent "flash-conflict" problems, insert red flash program blocks for all unused vehicle load switches in the output file. The installer shall verify that signal heads flash in accordance with the Signal Plans.
- Ensure that Red Enable is active at all times during normal operation. To prevent Red Failures on unused monitor channels, tie unused red monitor inputs 7,8, 9,10,11,12,13,14,15 & 16 to load switch AC+ per the cabinet manufacturer's instructions.
- Program controller to start up in phases 2 and 6 green.
- Enable Simultaneous Gap-Out, on the controller unit, for all phases.
- Program phases 2 and 6, on the controller unit, for Variable Initial and Gap Reduction.
- The cabinet and controller are part of the Gastonia City System.

EQUIPMENT INFORMATION

CONTROLLER.....CONTRACTOR SUPPLIED 2070L
CABINET.....CONTRACTOR SUPPLIED 332
SOFTWARE.....ECONOLITE OASIS
CABINET MOUNT.....BASE
OUTPUT FILE POSITIONS...12
LOAD SWITCHES USED.....S1,S2,S3,S4,S5,S6
PHASES USED.....1,2,3,4,5,6
OVERLAPS.....NONE

FIELD CONNECTION HOOK-UP CHART

LOAD SWITCH NO.	S1	S2	S2P	S3	S4	S4P	S5	S6	S6P	S7	S8	S8P
PHASE	1	2	2 PED	3	4	4 PED	5	6	6 PED	7	8	8 PED
SIGNAL HEAD NO.	11	21,22	SIGN D	31	32,33	41	42,43	SIGN D	51	61,62	NU	NU
GREEN		130		118	118	103	103		136			
YELLOW		129		117	117	102	102		135			
RED		128		116	116	101	101		134			
RED ARROW	125							131				
YELLOW ARROW	126							132				
GREEN ARROW	127			118		103		133				
Hand icon												
PED YELLOW			** 114				** 105					
Person icon												

NU = Not Used

** Changeable Trailblazer Signs. See wiring and programming detail on this sheet.

INPUT FILE POSITION LAYOUT

(front view)

FILE	U	1	2	3	4	5	6	7	8	9	10	11	12	13	14
"I"		Ø 1	Ø 1	Ø 2	S	S	Ø 3	Ø 4	S	S	S	S	S	S	FS
		1A	1B	2A	→	→	3A	4A	→	→	→	→	→	→	DC ISOLATOR
		NOT USED	Ø 1	Ø 2	→	→	Ø 3	Ø 4	→	→	→	→	→	→	ST
			1C	2B	→	→	3B	4B	→	→	→	→	→	→	DC ISOLATOR
FILE	U	5	6	7	8	9	10	11	12	13	14				
"J"		Ø 5	Ø 5	Ø 6	S	S	S	S	S	S	S	S	S	S	S
		5A	5B	6A	→	→	→	→	→	→	→	→	→	→	→
		NOT USED	Ø 5	Ø 6	→	→	→	→	→	→	→	→	→	→	→
			5C	6B	→	→	→	→	→	→	→	→	→	→	→


EX. : 1A, 2A, ETC. = LOOP NO.'S

FS = FLASH SENSE
ST = STOP TIME

INPUT FILE CONNECTION & PROGRAMMING CHART


LOOP NO.	LOOP TERMINAL	INPUT FILE POS.	PIN NO.	INPUT ASSIGNMENT NO.	DETECTOR NO.	NEMA PHASE	CALL	EXTEND	FULL TIME DELAY	STRETCH TIME	DELAY TIME
1A	TB2-1,2	I1U	56	18	1	1	Y	Y			
1B	TB2-5,6	I2U	39	1	2	1	Y	Y			
1C	TB2-7,8	I2L	43	5	12	1	Y	Y			
2A	TB2-9,10	I3U	63	25	32	2	Y	Y			
2B	TB2-11,12	I3L	76	38	42	2	Y	Y			
3A	TB4-9,10	I6U	41	3	4	3	Y	Y			15
3B	TB4-11,12	I6L	45	7	14	3	Y	Y			15
4A	TB6-1,2	I7U	65	27	34	4	Y	Y			15
4B	TB6-3,4	I7L	78	40	44	4	Y	Y			15
5A	TB3-1,2	J1U	55	17	5	5	Y	Y			
5B	TB3-5,6	J2U	40	2	6	5	Y	Y			
5C	TB3-7,8	J2L	44	6	16	5	Y	Y			
6A	TB3-9,10	J3U	64	26	36	6	Y	Y			
6B	TB3-11,12	J3L	77	39	46	6	Y	Y			

 INPUT FILE POSITION LEGEND: J2L



CHANGEABLE TRAILBLAZER SIGN

WIRING AND PROGRAMMING DETAIL

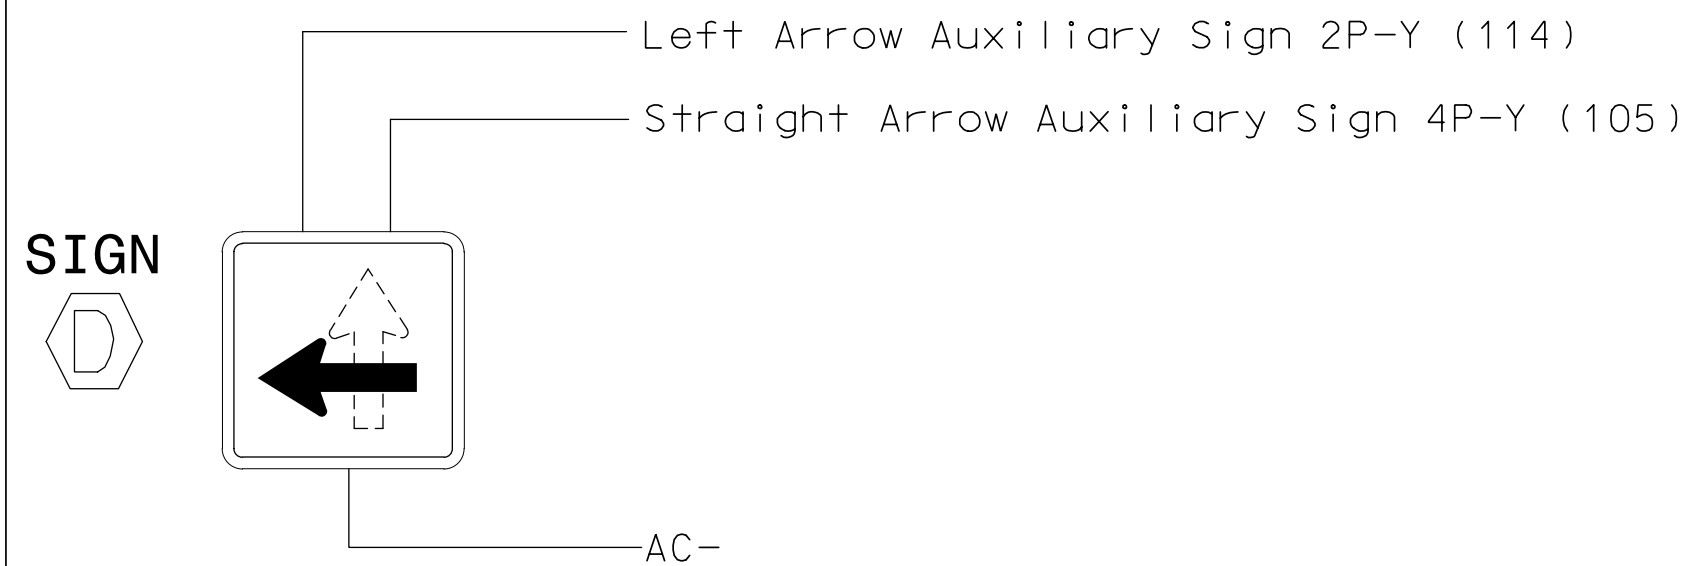


NOTE

Remove, tape, and label conflict monitor wire attached to rear of terminal 2PY(114) and 4PY(105).

THIS ELECTRICAL DETAIL IS FOR
THE SIGNAL DESIGN: 12-0157
DESIGNED: October 2004
SEALED: 2/7/05
REVISED: 4/16/2019

Signal Upgrade Sheet 1 of 2

DOCUMENT NOT CONSIDERED
FINAL UNLESS ALL
SIGNATURES COMPLETED

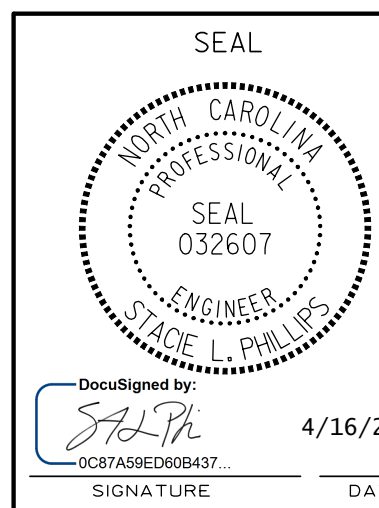

US 29-74			
at			
SR 1307 (Edgewood Road)/			
(Archie Whitesides)			
Division 12	Gaston County	Gastonia	
PLAN DATE: January 2005	REVIEWED BY: T. Joyce		
PREPARED BY: William Hairston	REVIEWED BY:		
REVISIONS		INIT.	DATE
ADD TRAILBLAZER SIGN PROGRAMMING	SLP		4/2019

SEAL

Not a certified document as to the Original Document but Only as to the Revisions - This document originally Issued and sealed by George C. Brown, #022013, on 02/07/05.

This document is only certified as to the revisions.

SIGNATURE DATE

SIG. INVENTORY NO. 12-0157

PLANS PREPARED IN THE OFFICE OF:

KimleyHorn

NC License #F-0102

421 Fayetteville Street, Suite 600

Raleigh, NC 27601

(919) 677-2000

3 Phase
Pre-Timed
Gastonia City System


NOTES

1. Refer to "Roadway Standard Drawings NCDOT" dated January 2002 and "Standard Specifications for Roads and Structures" dated January 2002.
2. Do not program signal for late night flashing operation unless otherwise directed by the Engineer.
3. Set all detector units to presence mode.
4. Locate new cabinet so as not to obstruct sight distance of vehicles turning right on red.
5. Pavement markings are existing.
6. Maximum times shown in timing chart are for free-run operation only. Coordinated signal system timing values supersede these values.
7. City system data: Controller Asset #0039.

LEGEND

PROPOSED	EXISTING

PHASING DIAGRAM

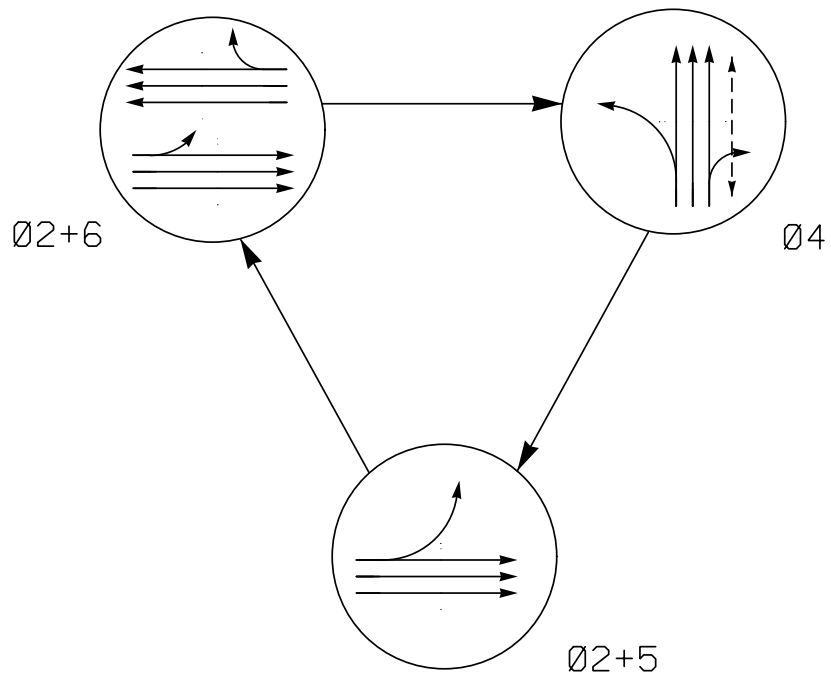


SIGNAL FACE	PHASE			
	Ø 2 + 5	Ø 2 + 6	Ø 4	FLD H
21	G	G	R	Y
22	G	G	R	Y
41, 42	R	R	G	R
61, 62	R	G	R	Y
P41, P42	DW	DW	W	DW
VSIGN 'C'	*	*	*	OFF

*Changeable Trailblazer Sign controlled remotely

SIGNAL FACE I.D.

Denotes L.E.D.

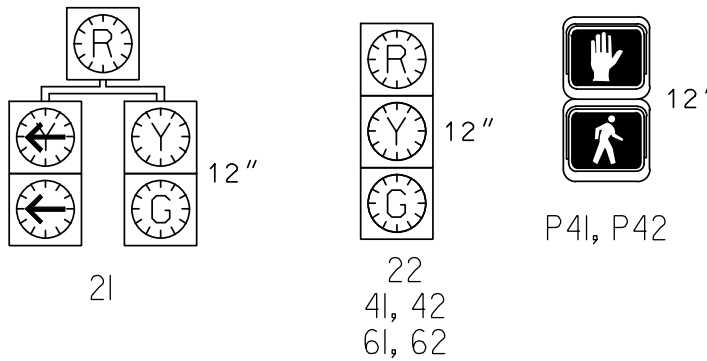


PHASING DIAGRAM DETECTION LEGEND

- DETECTED MOVEMENT
- UNDETECTED MOVEMENT (OVERLAP)
- UNSIGNALIZED MOVEMENT
- PEDESTRIAN MOVEMENT

2070L TIMING CHART



FEATURE	PHASE			
	2	4	5	6
Min Green 1 *	10	7	7	10
Extension 1 *	0.0	0.0	0.0	0.0
Max Green 1 *	60	25	15	60
Yellow Clearance	4.0	4.0	4.0	4.0
Red Clearance	1.5	2.1	1.4	1.5
Walk 1 *	-	4	-	-
Don't Walk 1	-	13	-	-
Seconds Per Actuation *	-	-	-	-
Max Variable Initial *	-	-	-	-
Time Before Reduction *	-	-	-	-
Time To Reduce *	-	-	-	-
Minimum Gap	-	-	-	-
Recall Mode	MAX RECALL	MAX/PED RECALL	MAX RECALL	MAX RECALL
Vehicle Call Memory	YELLOW	-	-	YELLOW
Dual Entry	-	-	-	-
Simultaneous Gap	ON	ON	ON	ON

* These values may be field adjusted. Do not adjust Min Green and Extension times for phases 2 and 6 lower than what is shown. Min Green for all other phases should not be lower than 4 seconds.

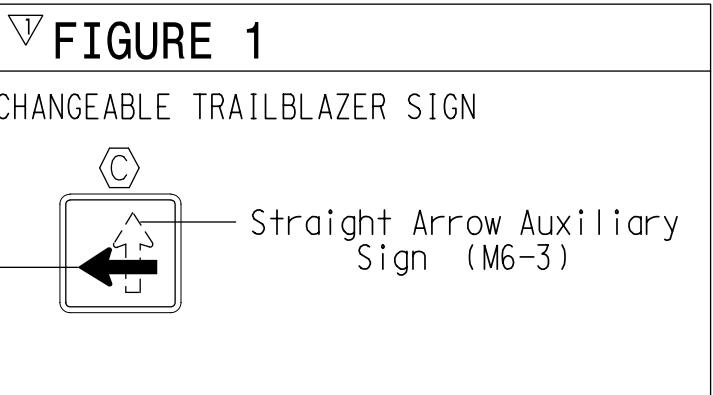

Signal Upgrade

PLANS PREPARED IN THE OFFICE OF:
Kimley»Horn
NC License #F-0102
421 Fayetteville Street, Suite 600
Raleigh, NC 27601
(919) 677-2000

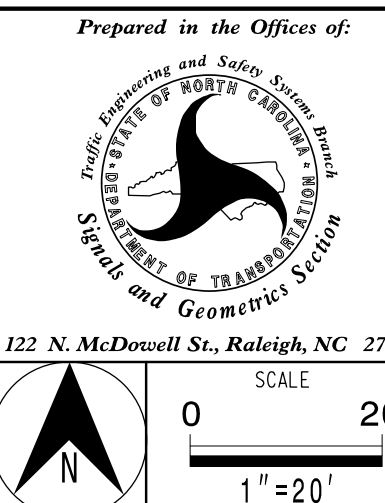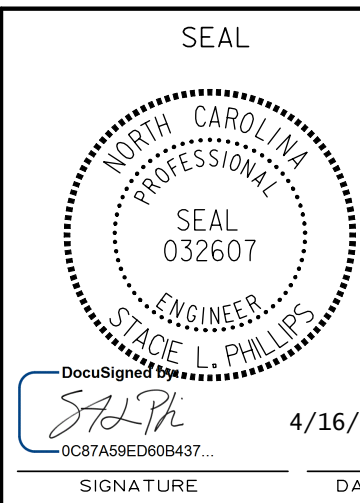


US 29-74-NC 274 (E. Franklin Boulevard) at US 321 N (York St.)	
Division 12	Gaston County
PLAN DATE: January 2005	REVIEWED BY:
PREPARED BY: WS/TSB	REVIEWED BY:
REVISIONS	INIT. DATE
INSTALL CHANGEABLE TRAILBLAZER SIGN	SLP 4/2019


DOCUMENT NOT CONSIDERED FINAL UNLESS ALL SIGNATURES COMPLETED	
SEAL	
<i>Not a certified document as to the Original Document but Only as to the Revisions - This document originally Issued and sealed by Richard E. Mullinax, PE #22027 on 02/07/2005 This document is only certified as to the revisions.</i>	
SIGNATURE	DATE
SIG. INVENTORY NO.	12-0039

PROGRAMMING DETAIL

WD ENABLE

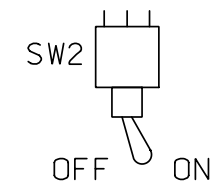


REMOVE DIODE JUMPERS 2-5, 2-6 and 4-14.

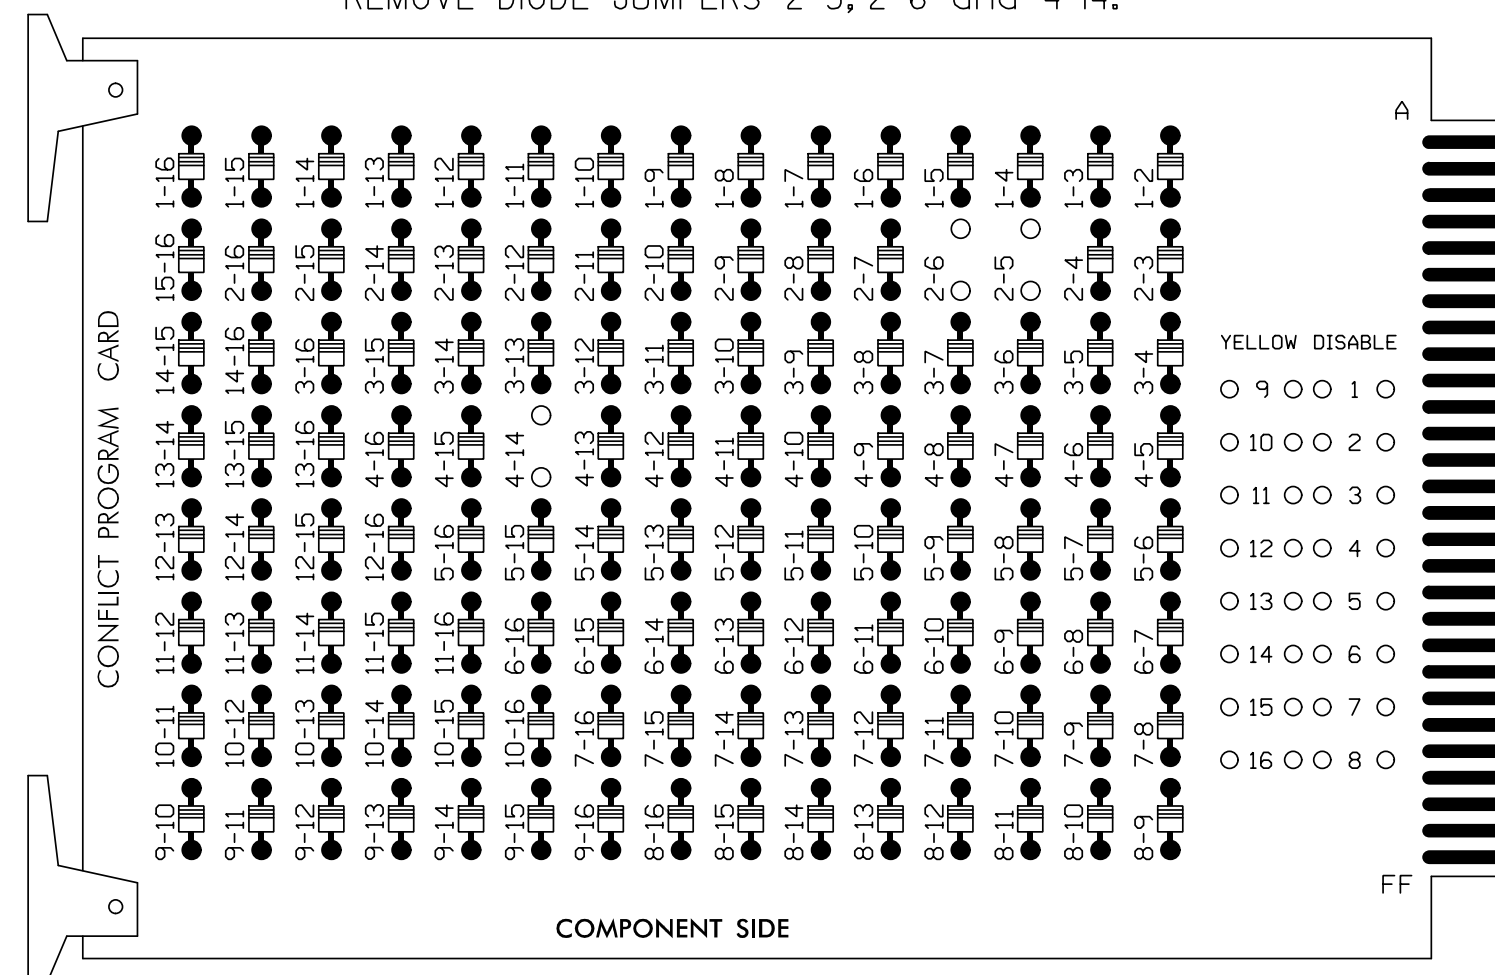

REMOVE JUMPERS AS SHOWN

OPTIONS

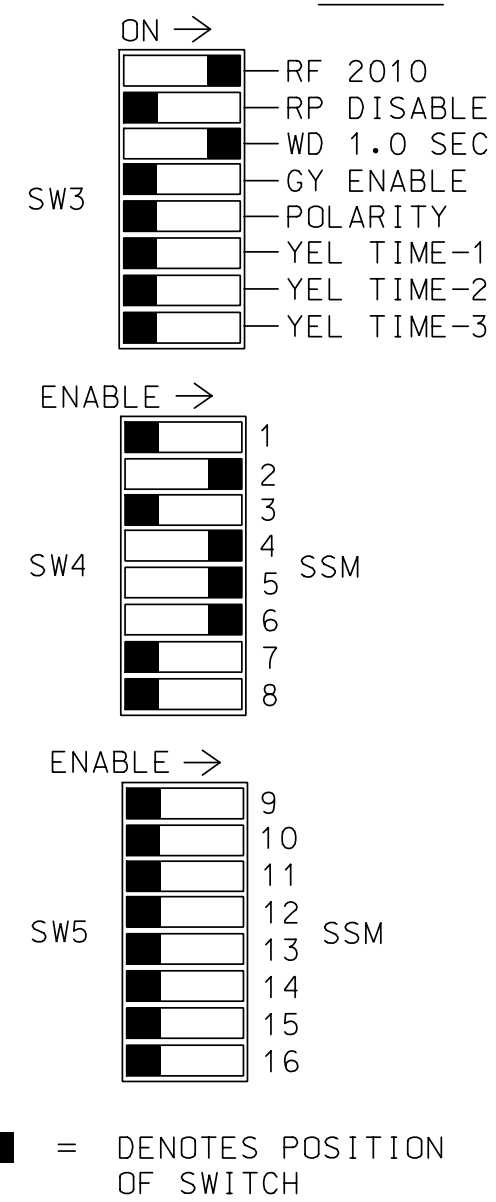

NOTES:

1. Card is provided with all diode jumpers in place. Removal of any jumper allows its channels to run concurrently.
2. Make sure jumpers SEL1-SEL5 are present on the monitor board.

1. To prevent "flash-conflict" problems, insert red flash program blocks for all unused vehicle load switches in the output file. The installer shall verify that signal heads flash in accordance with the Signal Plans.

2. Ensure that Red Enable is active at all times during normal operation. To prevent Red Failures on unused monitor channels, tie unused red monitor inputs 1,3,7, 8,9,10,11,12,13,14,15 & 16 to load switch AC+ per the cabinet manufacturer's instructions.
3. Program controller to start up in phases 2 and 6 green.
4. Enable Simultaneous Gap-Out, on the controller unit, for all phases.
5. Program phase 4 for 'STARTUP PED CALL'.
6. The cabinet and controller are part of the Gastonia City System.

EQUIPMENT INFORMATION

```

CONTROLLER.....CONTRACTOR SUPPLIED 2070L
CABINET.....CONTRACTOR SUPPLIED 332
SOFTWARE.....ECONOLITE OASIS
CABINET MOUNT.....BASE
OUTPUT FILE POSITIONS...12
LOAD SWITCHES USED.....S2,*S2P,S4,S4P,S5,S6
PHASES USED.....2,*2PED,4,4PED,5,6
OVERLAPS.....NONE
* Changeable Trailblazer Sign Only

```

FIELD CONNECTION HOOK-UP CHART


LOAD SWITCH NO.	S1	S2	S2P	S3	S4	S4P	S5	S6	S6P	S7	S8	S8P
PHASE	1	2	2 PED	3	4	4 PED	5	6	6 PED	7	8	8 PED
SIGNAL HEAD NO.	NU	21,22	SIGN C	NU	41,42	P41, P42	21	61,62	NU	NU	NU	NU
GREEN		130			103			136				
YELLOW		129			102			135				
RED		128			101		*	134				
RED ARROW												
YELLOW ARROW							132					
GREEN ARROW							133					
						106						
PED YELLOW			* * 114			* * 105						
						104						

NU = Not Used

* Denotes install load resistor. See load resistor installation detail this sheet.

** A Changeable Trailblazer Sign is wired to 2P-Y (2 PED YELLOW) and 4P-Y (4 PED YELLOW). See wiring and programming detail on this sheet.


(front view)

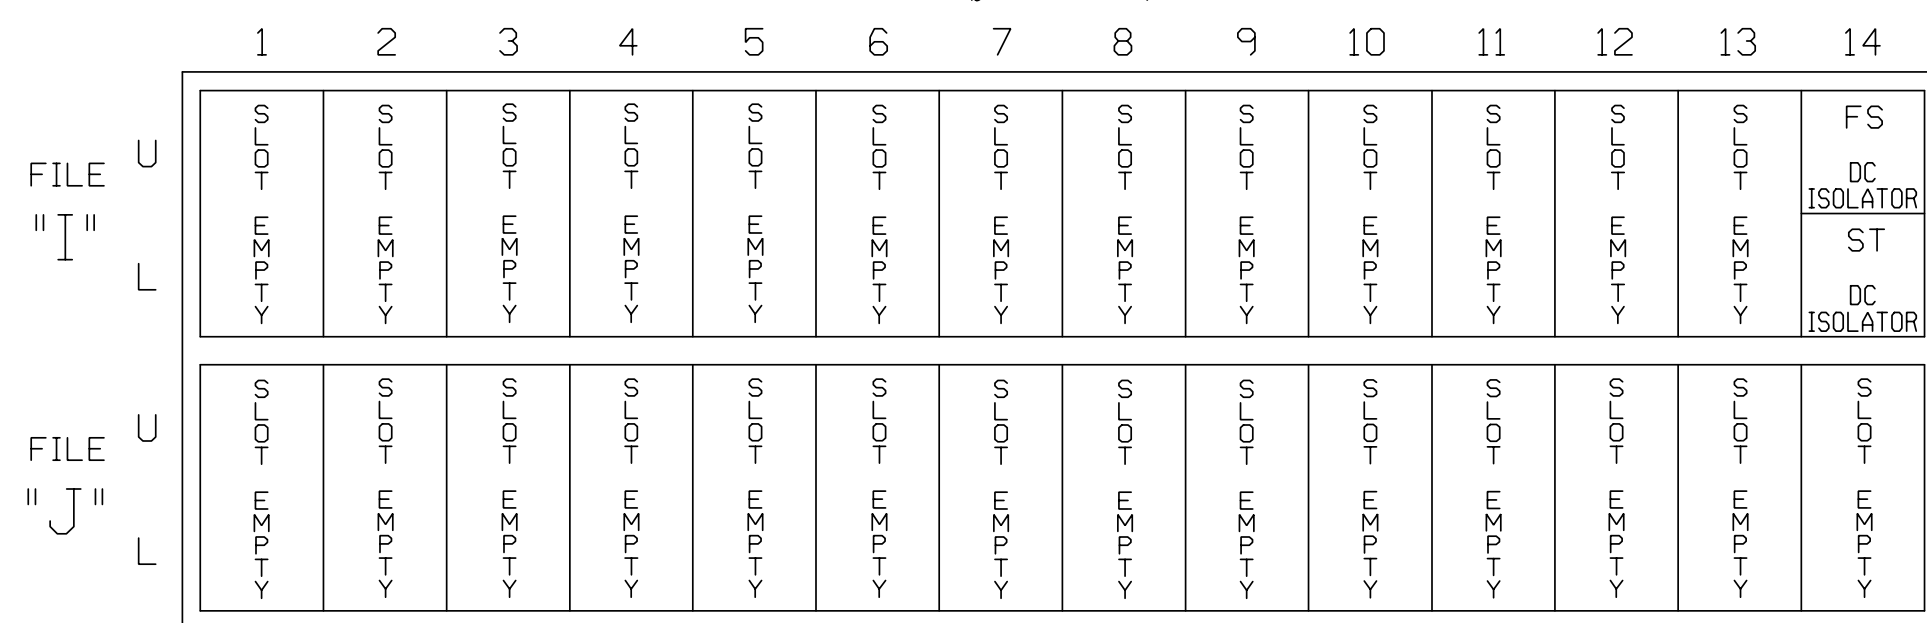

EX. : 1A, 2A, ETC. = LOOP NO.'S

FS = FLASH SENSE
ST = STOP TIME


LOAD RESISTOR INSTALLATION DETAIL

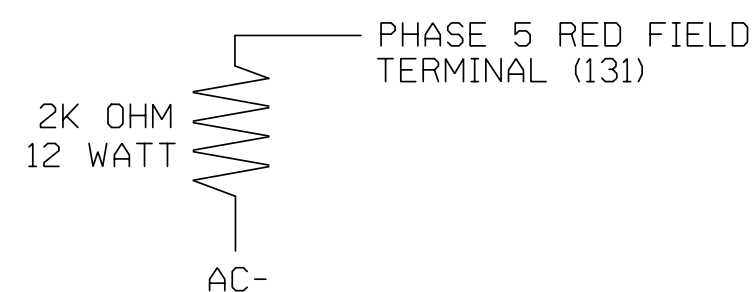

NOTE: The purpose of this resistor is to load the channel red monitor input in order for the Signal Sequence Monitor to use the full signal sequence monitoring capability on channels that do not use the red display in the field.

CHANGEABLE TRAILBLAZER SIGN

WIRING AND PROGRAMMING DETAIL

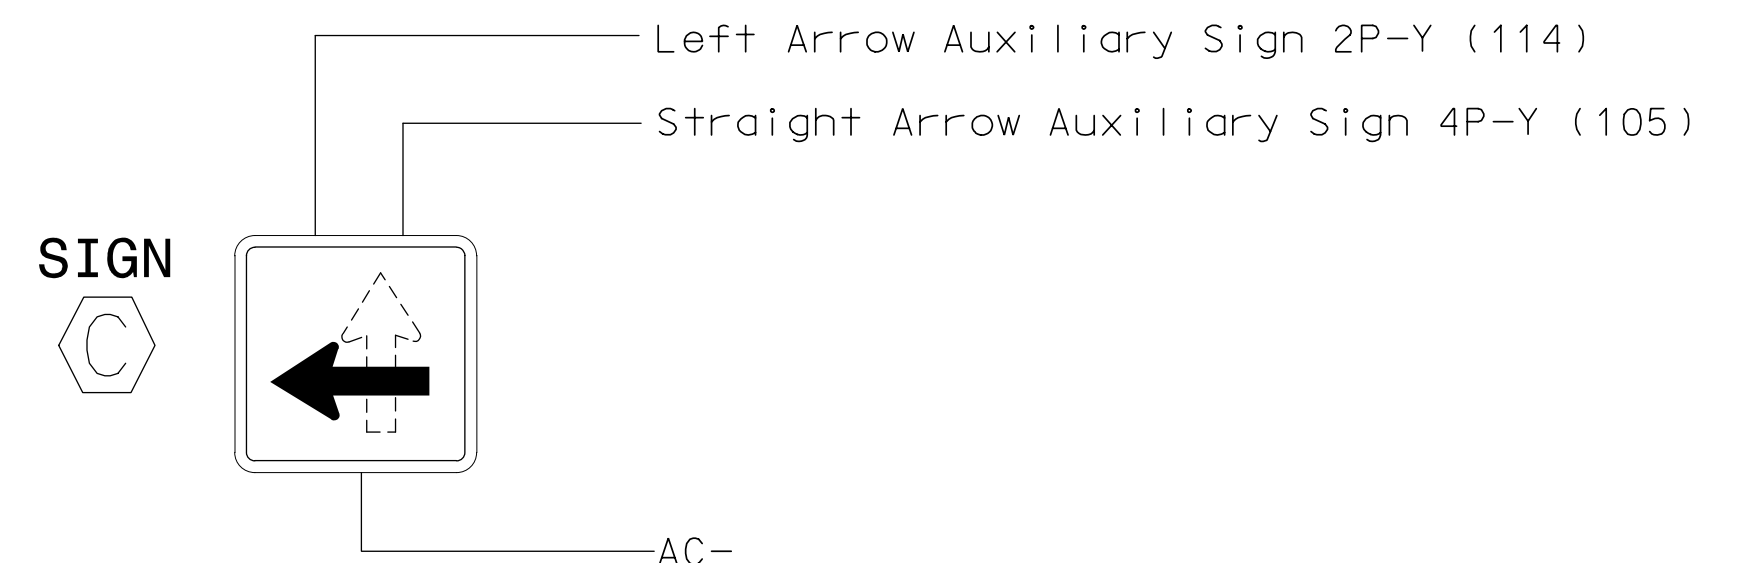

NOTE

Remove, tape, and label conflict monitor wire attached to rear of terminal 2PY(114) and 4PY(105).

THIS ELECTRICAL DETAIL IS FOR
THE SIGNAL DESIGN: 12-0039
DESIGNED: January 2005
SEALED: 02-07-05
REVISED: 4/16/2019

Signal Upgrade Sheet 1 of 2


DOCUMENT NOT CONSIDERED
FINAL UNLESS ALL
SIGNATURES COMPLETED

SEAL

*Not a certified document as
to the Original Document but
Only as to the Revisions -
This document originally
Issued and sealed by
George C. Brown, #022013,
on 02/21/05.
This document is only certified
as to the revisions.*

SIGNATURE	DATE
G. INVENTORY NO.	12-0039

PLANS PREPARED IN THE OFFICE OF:
Kimley»Horn
NC License #F-0102
421 Fayetteville Street, Suite 600
Raleigh, NC 27601
(919) 677-2000

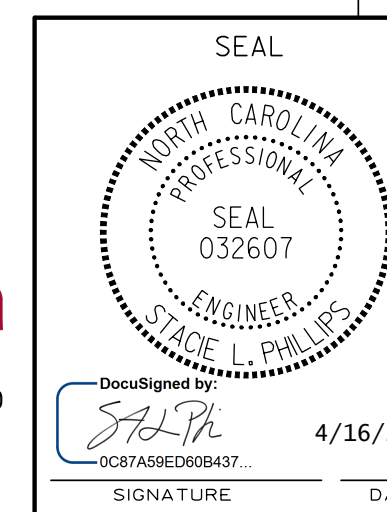

**ELECTRICAL AND PROGRAMMING
DETAILS FOR**

Prepared In the Offices of:



750 N. Greenfield Pkwy, Garner, NC 27525


US 29-74-NC 274 (E. Franklin Boulevard) at US 321 N (York St.)			
Division 12		Gaston County	
Gastonia		Gastonia	
PLAN DATE: February 2005		REVIEWED BY: T. Joyce	
PREPARED BY: James Peterson		REVIEWED BY:	
REVISIONS		INIT.	DATE
29 ☒ INSTALL CHANGEABLE TRAILBLAZER SIGN		SLP	4/2019

LOGICAL I/O PROCESSOR PROGRAMMING DETAIL
TO CONTROL TRAILBLAZER SIGN

(program controller as shown below)

1. FROM MAIN MENU PRESS '2' (PHASE CONTROL), THEN '1' (PHASE CONTROL FUNCTIONS). SCROLL TO THE BOTTOM OF THE MENU AND ENABLE ACT LOGIC COMMANDS 31 AND 32.
2. FROM MAIN MENU PRESS '6' (OUTPUTS), THEN '3' (LOGICAL I/O PROCESSOR).

TOGGLE TO COMMAND #31

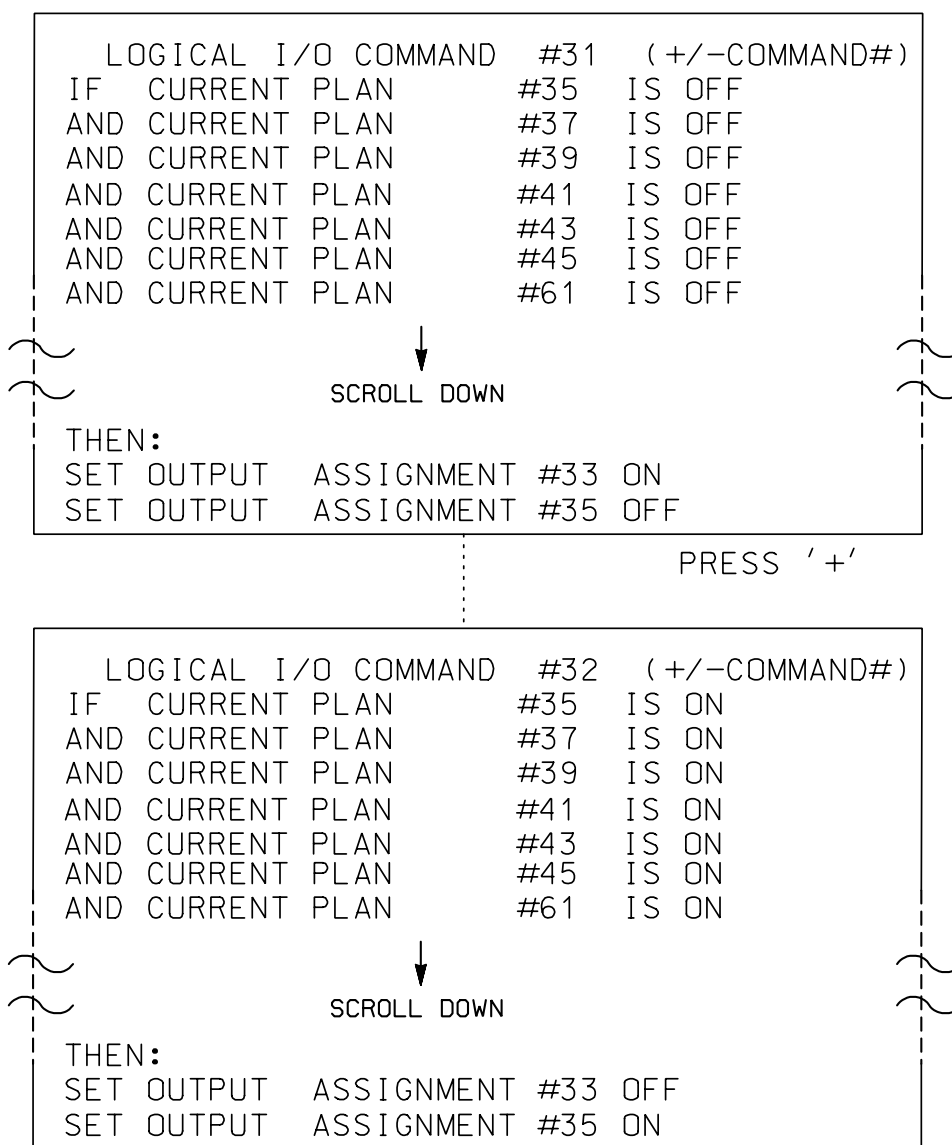

LOGIC I/O PROCESSOR PROGRAMMING COMPLETE

THIS ELECTRICAL DETAIL IS FOR
THE SIGNAL DESIGN: 12-0039
DESIGNED: January 2005
SEALED: 02-07-05
REVISED: 4/16/2019

Signal Upgrade Sheet 2 of 2

DOCUMENT NOT CONSIDERED
FINAL UNLESS ALL
SIGNATURES COMPLETED

SEAL

*Not a certified document as
to the Original Document but
Only as to the Revisions -
This document originally
Issued and sealed by
George C. Brown, #022013,
on 02/21/05.
This document is only certified
as to the revisions.*

SIGNATURE	DATE
SIG. INVENTORY NO.	12-0039

PLANS PREPARED IN THE OFFICE OF:
Kimley»Horn
NC License #F-0102
421 Fayetteville Street, Suite 600
Raleigh, NC 27601
(919) 677-2000

SEAL



NORTH CAROLINA
PROFESSIONAL
SEAL
032607
ENGINEER
STACE L. PHILLIPS

DocuSigned by
Stace L. Phillips
0C87A79E050B437...

4/16/2019

SIGNATURE DATE

US 29-74-NC 274 (E. Franklin Boulevard) at US 321 N (York St.)			
Division 12		Gaston County	
Gastonia			
PLAN DATE: February 2005	REVIEWED BY: T. Joyce		
PREPARED BY: James Peterson	REVIEWED BY:		
REVISONS		INIT.	DATE
9 ADD TRAILBLAZER SIGN PROGRAMMING		SLP	4/2019

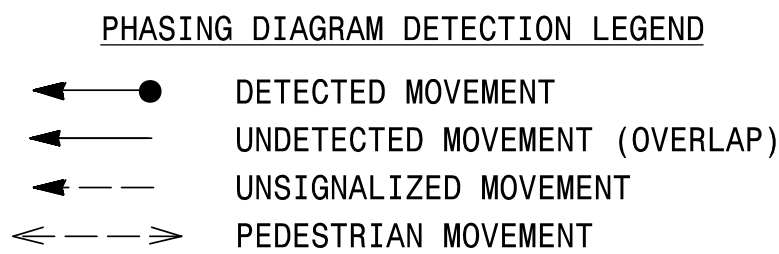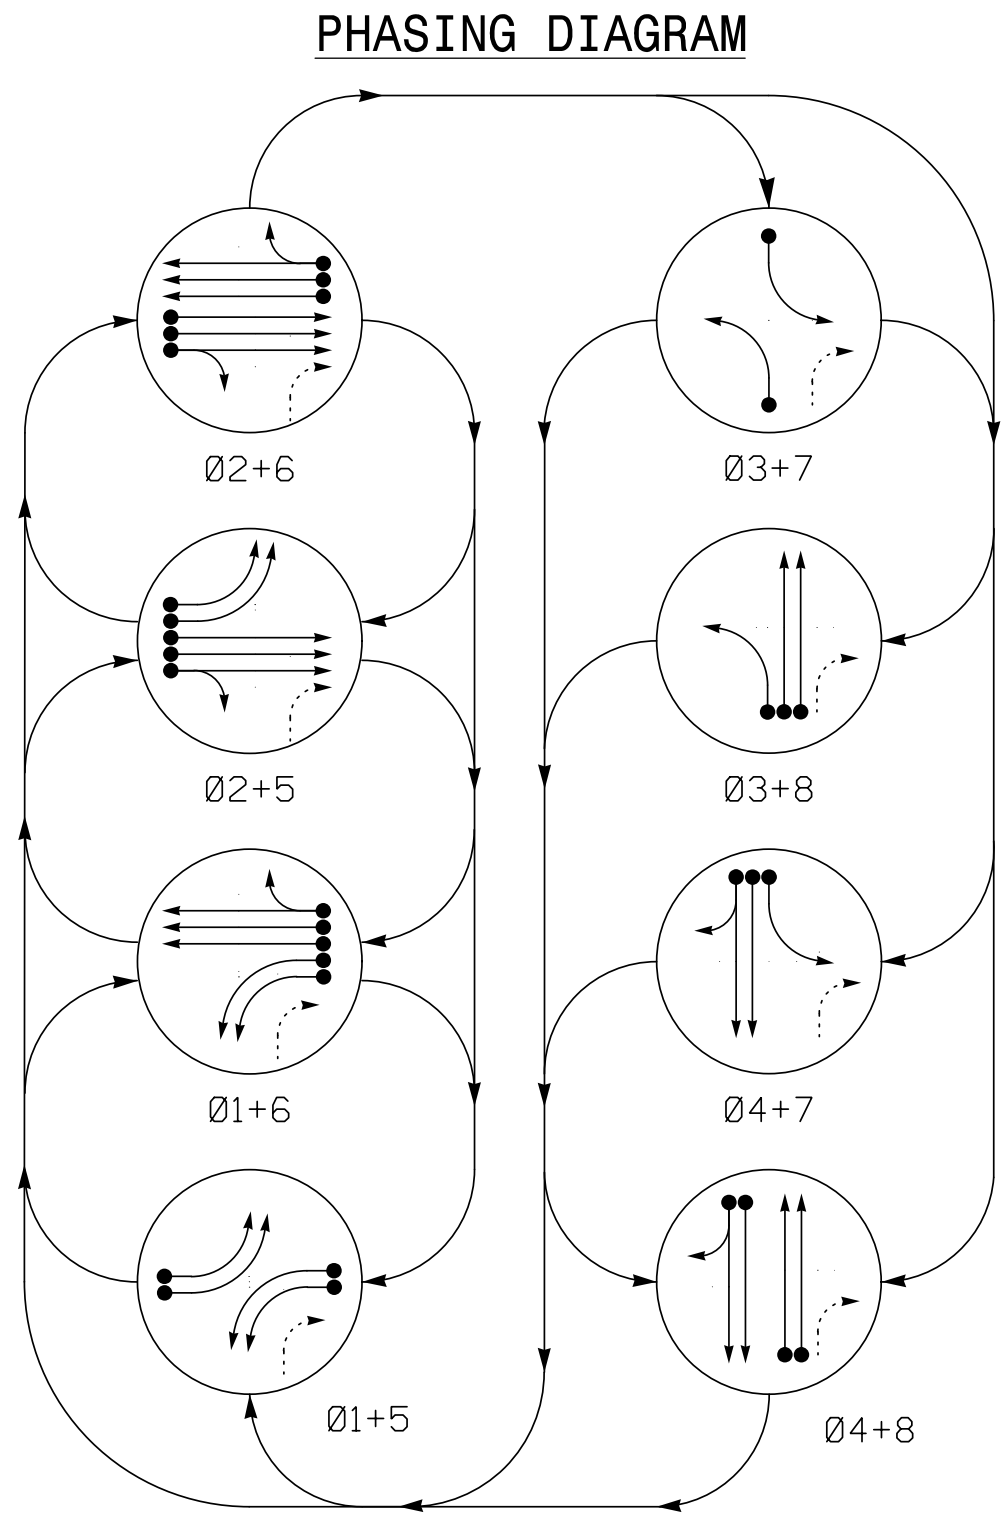


SIGNAL FACE	PHASE							
	Ø 1 + 5	Ø 1 + 6	Ø 2 + 5	Ø 2 + 6	Ø 3 + 7	Ø 3 + 8	Ø 4 + 7	Ø 4 + 8
11, 12	←	←	→	→	→	→	→	→
21, 22	R	R	G	G	R	R	R	R
31	→	→	→	→	→	→	→	→
41, 42	R	R	R	R	R	R	G	G
51, 52	←	←	→	→	→	→	→	→
61, 62	R	G	R	G	R	R	R	R
71	→	→	→	→	→	→	→	→
81, 82	R	R	R	R	R	G	G	R
SIGN 'C'	*	*	*	*	*	*	*	OFF
SIGN 'D'	*	*	*	*	*	*	*	OFF
SIGN 'E'	*	*	*	*	*	*	*	OFF
SIGN 'F'	*	*	*	*	*	*	*	OFF

*Changeable Trailblazer Signs controlled remotely

SIGNAL FACE I.D.

Denotes L.E.D.

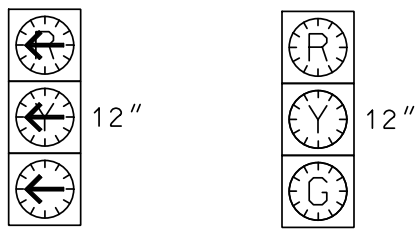

11, 12
31
51, 52
71



21, 22
41, 42
61, 62
81, 82

2070L LOOP & DETECTOR INSTALLATION											
INDUCTIVE LOOPS					DETECTOR PROGRAMMING						
LOOP	SIZE (FT)	TURNS	DISTANCE FROM STOPBAR (FT)	NEW LOOP	PHASE	CALLING	EXTENSION	FULL TIME DELAY SYSTEM LOOP	STRETCH TIME	DELAY TIME	NEW CARD
1A	6x60	Existing	Existing	—	1	Y	Y	-	-	-	Y
1B	6x60	Existing	Existing	—	1	Y	Y	-	-	-	Y
2A	Existing	Existing	Existing	—	2	Y	Y	-	-	-	Y
3A	6x60	Existing	Existing	—	3	Y	Y	-	-	-	Y
4A	Existing	Existing	Existing	—	4	Y	Y	-	-	-	Y
5A	6x60	Existing	Existing	—	5	Y	Y	-	-	-	Y
5B	6x60	Existing	Existing	—	5	Y	Y	-	-	-	Y
6A	Existing	Existing	Existing	—	6	Y	Y	-	-	-	Y
7A	6x60	Existing	Existing	—	7	Y	Y	-	-	-	Y
8A	Existing	Existing	Existing	—	8	Y	Y	-	-	-	Y

8 Phase
Fully Actuated
(Gastonia City System)

NOTES

- Refer to "Roadway Standard Drawings NCDOT" dated January 2002 and "Standard Specifications for Roads and Structures" dated January 2002.
- Do not program signal for late night flashing operation unless otherwise directed by the Engineer.
- Phase 1 or phase 5 may be lagged.
- Phase 3 or phase 7 may be lagged.
- Set all detector units to presence mode.
- Locate new cabinet so as not to obstruct vehicles turning right on red.
- Pavement markings are existing.
- Maximum times shown in timing chart are for free-run operation only. Coordinated signal system timing values shall supersede these values.
- City system data:
Controller Asset #: 0050.

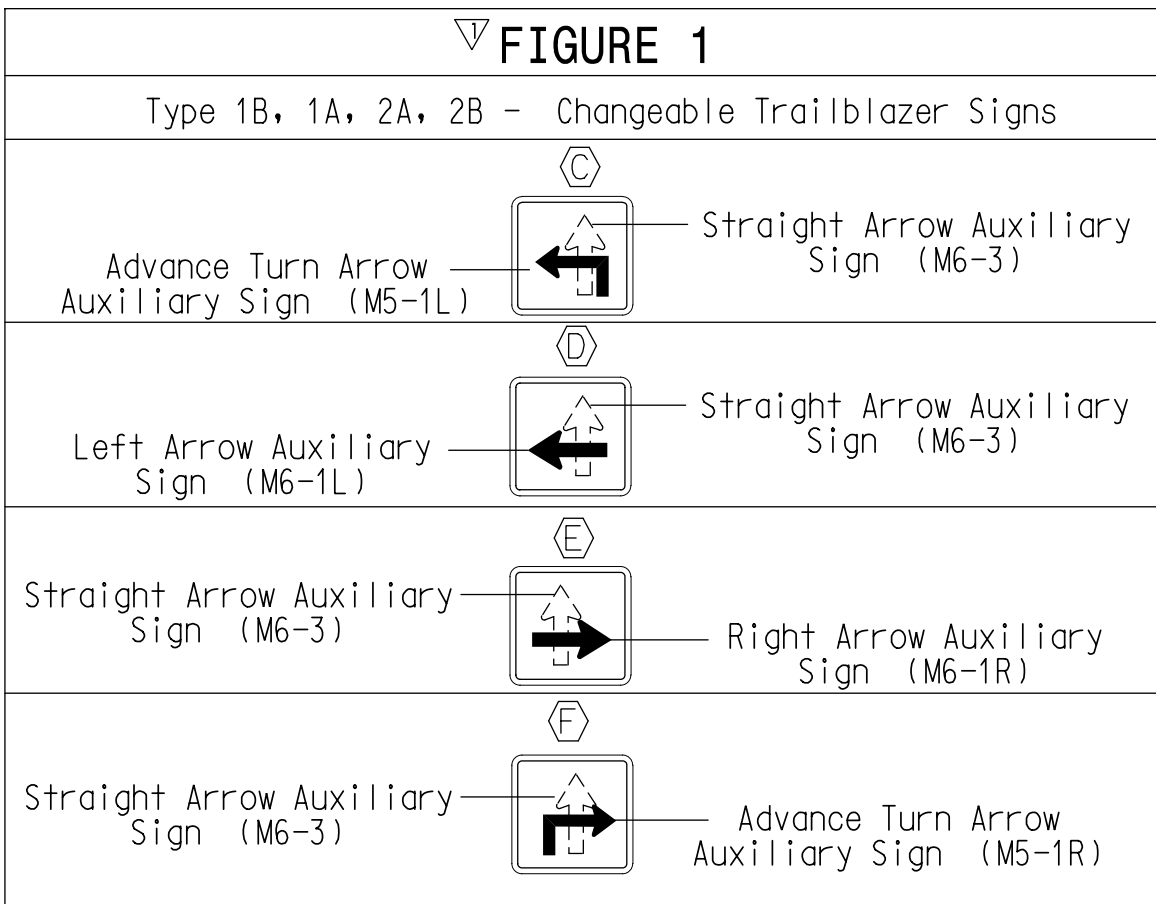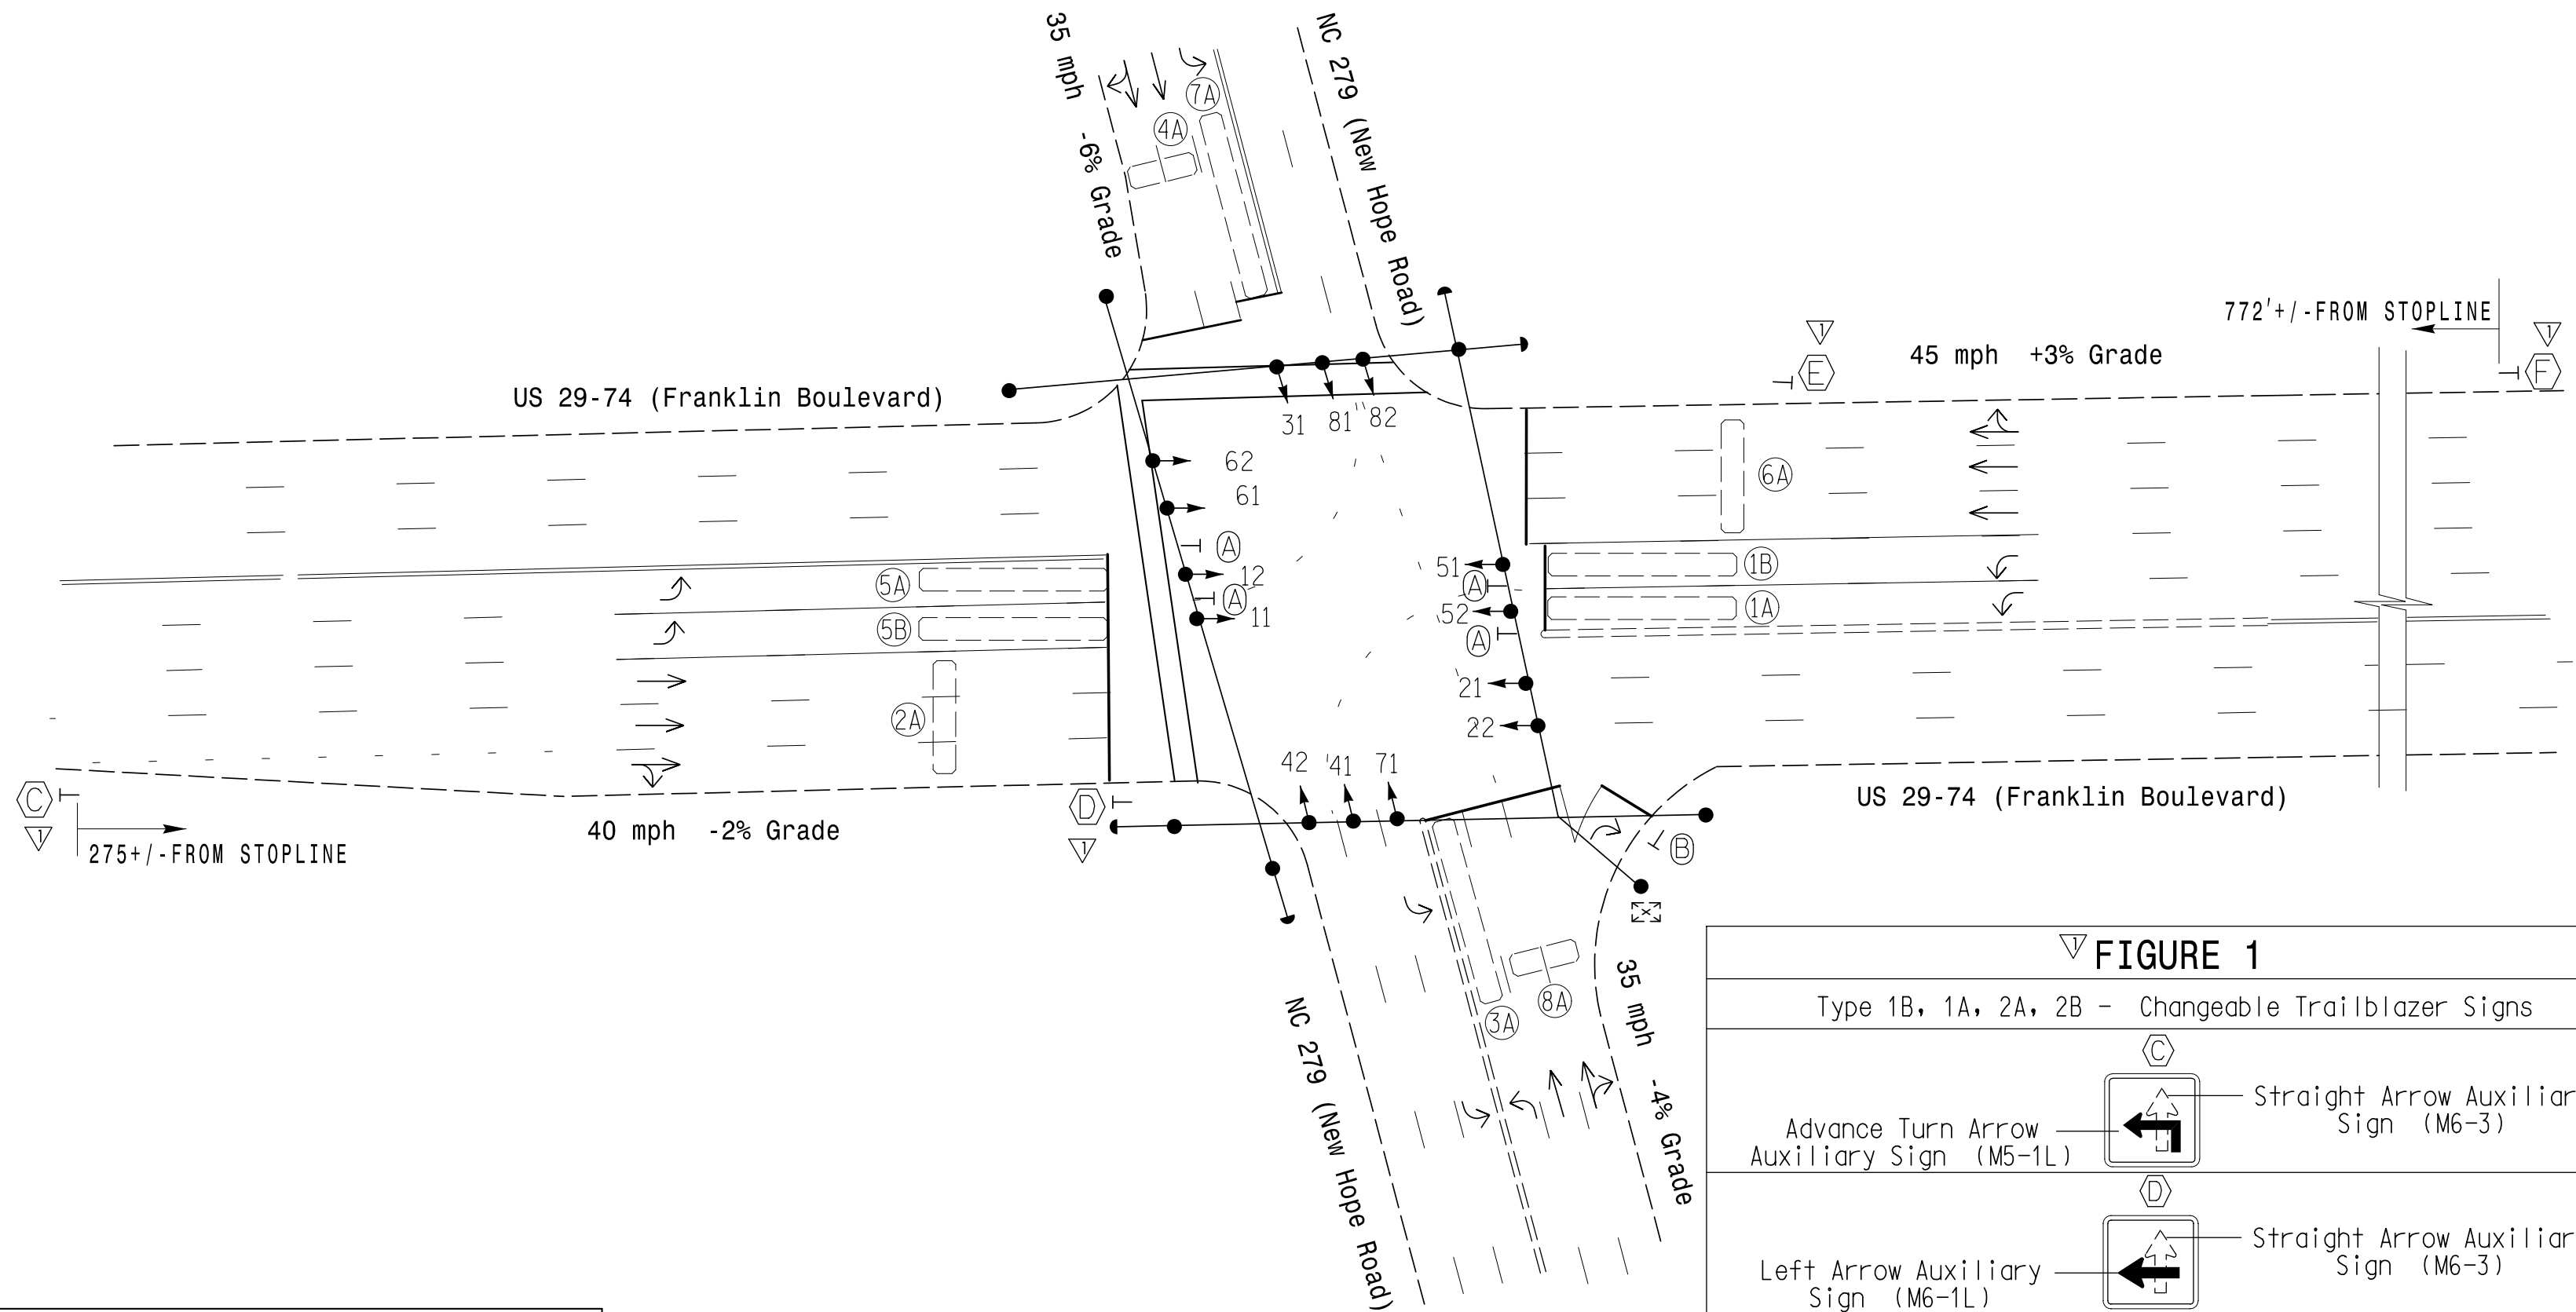

LEGEND



PROPOSED	EXISTING
Traffic Signal Head	N/A
Modified Signal Head Sign	N/A
Pedestrian Signal Head With Push Button & Sign	N/A
Signal Pole with Guy	N/A
Signal Pole with Sidewalk Guy	N/A
Inductive Loop Detector	N/A
Controller & Cabinet	N/A
Junction Box	N/A
2-in Underground Conduit	N/A
Right of Way	N/A
Directional Arrow	N/A
Left Arrow "ONLY" Sign (R3-5L)	N/A
"YIELD" Sign (R1-2)	N/A
Type 1B Changeable Trailblazer sign (See Figure 1)	N/A
Type 1A Changeable Trailblazer sign (See Figure 1)	N/A
Type 2A Changeable Trailblazer sign (See Figure 1)	N/A
Type 2B Changeable Trailblazer sign (See Figure 1)	N/A

2070L TIMING CHART								
FEATURE	PHASE							
	1	2	3	4	5	6	7	8
Min Green 1 *	7	12	7	7	7	12	7	7
Extension 1 *	2.0	2.0	1.0	1.0	1.0	2.0	1.0	1.0
Max Green 1 *	20	60	20	30	20	60	20	30
Yellow Clearance	4.0	4.7	4.0	4.0	4.0	4.7	4.0	4.0
Red Clearance	2.0	2.0	3.0	3.2	2.5	2.0	3.8	3.2
Walk 1 *	-	-	-	-	-	-	-	-
Don't Walk 1	-	-	-	-	-	-	-	-
Seconds Per Actuation *	-	-	-	-	-	-	-	-
Max Variable Initial *	-	-	-	-	-	-	-	-
Time Before Reduction *	-	-	-	-	-	-	-	-
Time To Reduce *	-	-	-	-	-	-	-	-
Minimum Gap	-	-	-	-	-	-	-	-
Recall Mode	-	MIN RECALL	-	-	-	MIN RECALL	-	-
Vehicle Call Memory	-	YELLOW	-	-	-	YELLOW	-	-
Dual Entry	-	-	-	-	-	-	-	-
Simultaneous Gap	ON	ON	ON	ON	ON	ON	ON	ON

* These values may be field adjusted. Do not adjust Min Green and Extension times for phases 2 and 6 lower than what is shown. Min Green for all other phases should not be lower than 4 seconds.

Signal Upgrade

PLANS PREPARED IN THE OFFICE OF:
Kimley»Horn
NC License #F-0102
421 Fayetteville Street, Suite 600
Raleigh, NC 27601
(919) 677-2000

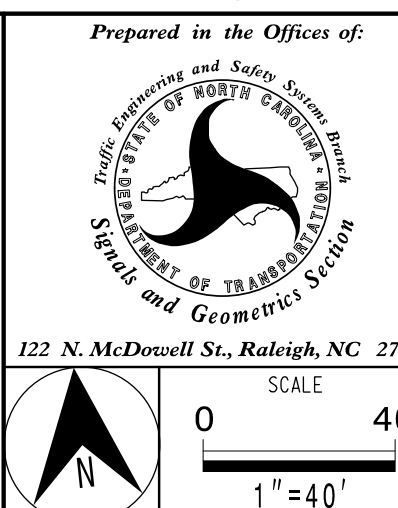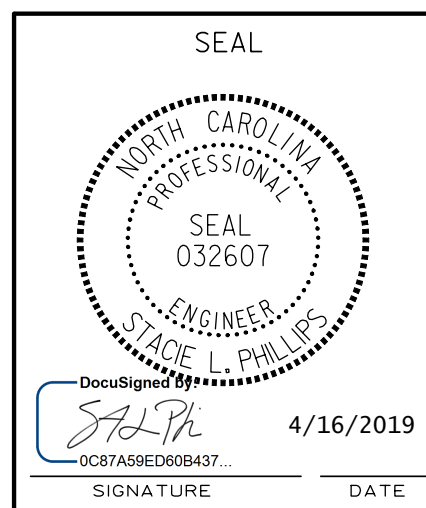

US 29-74 (Franklin Boulevard)
at
NC 279 (New Hope Road)

Division 12	Gaston County	Gastonia
PLAN DATE: April 2004	REVIEWED BY:	
PREPARED BY: Hambright/Porter	REVIEWED BY:	
REVISIONS	INIT.	DATE
INSTALL CHANGEABLE TRAILBLAZER SIGN	SLP	4/2019


Not a certified document as to the Original Document but Only as to the Revisions - This document originally Issued and sealed by Richard E. Mullinax, PE #22027 on 12/10/2004 This document is only certified as to the revisions.

SIGNATURE _____ DATE _____
SIG. INVENTORY NO. 12-0050

EDI MODEL 2010ECL CONFLICT MONITOR

PROGRAMMING DETAIL

(remove jumpers and set switches as shown)

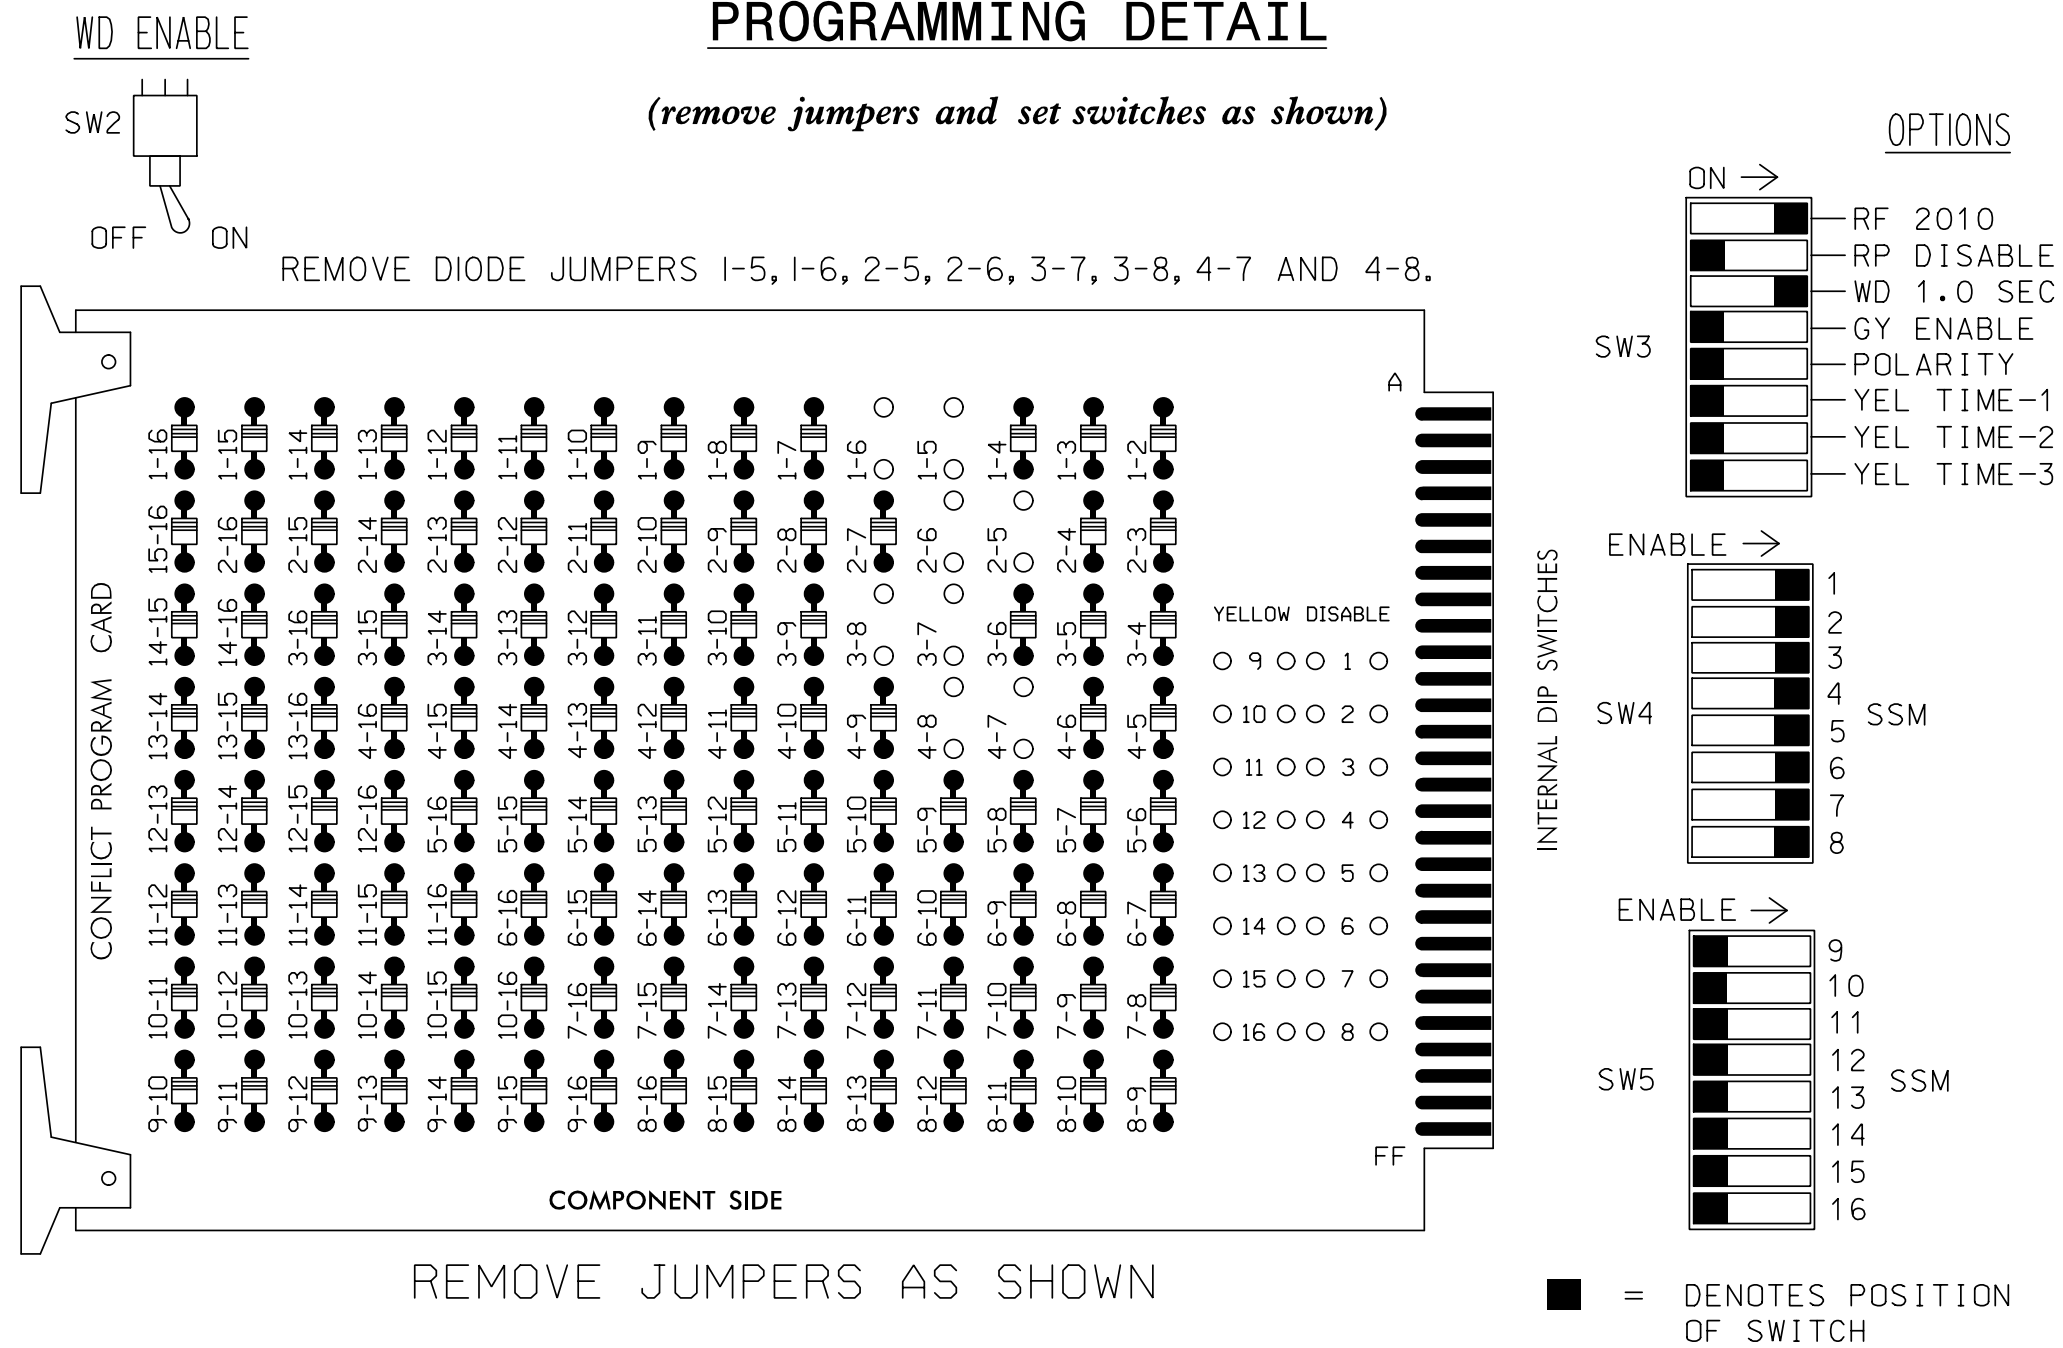

NOTES:

- CARD IS PROVIDED WITH ALL DIODE JUMPERS IN PLACE. REMOVAL OF ANY JUMPER ALLOWS ITS CHANNELS TO RUN CONCURRENTLY.
- MAKE SURE JUMPERS SEL1-SEL5 ARE PRESENT ON THE MONITOR BOARD.

NOTES

- TO PREVENT "FLASH-CONFLICT" PROBLEMS, INSERT RED FLASH PROGRAM BLOCKS FOR ALL UNUSED VEHICLE LOAD SWITCHES IN THE OUTPUT FILE. THE INSTALLER SHALL VERIFY THAT SIGNAL HEADS FLASH IN ACCORDANCE WITH THE SIGNAL PLANS.
- ENSURE THAT RED ENABLE IS ACTIVE AT ALL TIMES DURING NORMAL OPERATION. TO PREVENT RED FAILURES ON UNUSED MONITOR CHANNELS, TIE UNUSED RED MONITOR INPUTS 9,10, 11,12,13,14,15 & 16 TO LOAD SWITCH AC+ PER THE CABINET MANUFACTURER'S INSTRUCTIONS.
- PROGRAM CONTROLLER TO START UP IN PHASES 2 AND 6 GREEN.
- ENABLE SIMULTANEOUS GAP-OUT FEATURE, ON CONTROLLER UNIT, FOR ALL PHASES.
- THE CABINET AND CONTROLLER ARE PART OF GASTONIIA CITY SYSTEM.

EQUIPMENT INFORMATION

CONTROLLER.....CONTRACTOR SUPPLIED 2070L
CABINET.....CONTRACTOR SUPPLIED 332
SOFTWARE.....ECONOLITE OASIS
CABINET MOUNT.....BASE
OUTPUT FILE POSITIONS...12
LOAD SWITCHES USED.....S1,S2,S3,S4,S5,S6,S7,S8
PHASES USED.....1,2,3,4,5,6,7,8
OVERLAPS.....NONE

FIELD CONNECTION HOOK-UP CHART												
LOAD SWITCH NO.	S1	S2	S2P	S3	S4	S4P	S5	S6	S6P	S7	S8	S8P
PHASE	1	2	2 PED	3	4	4 PED	5	6	6 PED	7	8	8 PED
SIGNAL HEAD NO.	11,12	21,22	SIGN C/E	31	41,42	SIGN C	51,52	61,62	SIGN D	71	81,82	SIGN D/F
GREEN		130			103			136			109	
YELLOW		129			102			135			108	
RED		128			101			134			107	
RED ARROW	125			116			131			122		
YELLOW ARROW	126			117			132			123		
GREEN ARROW	127			118			133			124		
			* * 113								* * 110	
PED YELLOW			* * 114			* * 105			* * 120			* * 111
			* * 115								* * 112	

NU = NOT USED
* * Changeable Trailblazer Signs. See wiring and programming detail on sheet 2.

INPUT FILE POSITION LAYOUT

(front view)

		1	2	3	4	5	6	7	8	9	10	11	12	13	14
FILE "I"	U	∅ 1	∅ 2	S	S	∅ 3	∅ 4	S	S	S	S	S	S	S	FS
	L	1A	2A	←-V-→	←-V-→	3A	4A	←-V-→	←-V-→	←-V-→	←-V-→	←-V-→	←-V-→	←-V-→	DC ISOLATOR
	L	1B	NOT USED	←-V-→	←-V-→	NOT USED	NOT USED	←-V-→	←-V-→	←-V-→	←-V-→	←-V-→	←-V-→	←-V-→	ST
FILE "J"	U	∅ 5	∅ 6	S	S	∅ 7	∅ 8	S	S	S	S	S	S	S	
	L	5A	6A	←-V-→	←-V-→	7A	8A	←-V-→	←-V-→	←-V-→	←-V-→	←-V-→	←-V-→	←-V-→	
	L	5B	NOT USED	←-V-→	←-V-→	NOT USED	NOT USED	←-V-→	←-V-→	←-V-→	←-V-→	←-V-→	←-V-→	←-V-→	

EX. : 1A, 2A, ETC. = LOOP NO.'S

FS = FLASH SENSE
ST = STOP TIME


INPUT FILE CONNECTION & PROGRAMMING CHART

LOOP NO.	LOOP TERMINAL	INPUT FILE POS.	PIN NO.	INPUT ASSIGNMENT NO.	DETECTOR NO.	NEMA PHASE	CALL	EXTEND	FULL TIME DELAY	STRETCH TIME	DELAY TIME
1A	TB2-1,2	I1U	56	18	1	1	Y	Y			
1B	TB2-3,4	I1L	56	18	1	1	Y	Y			
2A	TB2-5,6	I2U	39	1	2	2	Y	Y			
3A	TB4-5,6	I5U	58	20	3	3	Y	Y			
4A	TB4-9,10	I6U	41	3	4	4	Y	Y			
5A	TB3-1,2	J1U	55	17	5	5	Y	Y			
5B	TB3-3,4	J1L	55	17	5	5	Y	Y			
6A	TB3-5,6	J2U	40	2	6	6	Y	Y			
7A	TB5-5,6	J5U	57	19	7	7	Y	Y			
8A	TB5-9,10	J6U	42	4	8	8	Y	Y			

INPUT FILE POSITION LEGEND: J2L

FILE J
SLOT 2
LOWER

SIGNAL UPGRADE SHEET 1 OF 2

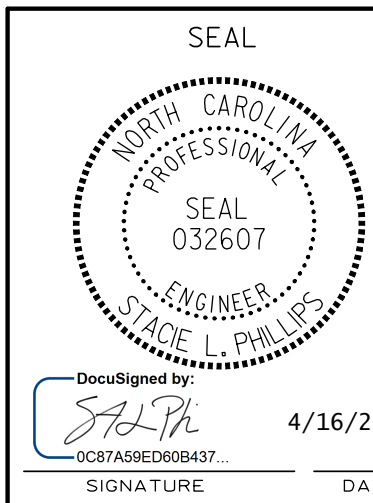

PLANS PREPARED IN THE OFFICE OF:


Kimley»Horn

NC License #F-0102

421 Fayetteville Street, Suite 600

Raleigh, NC 27601

(919) 671-2000

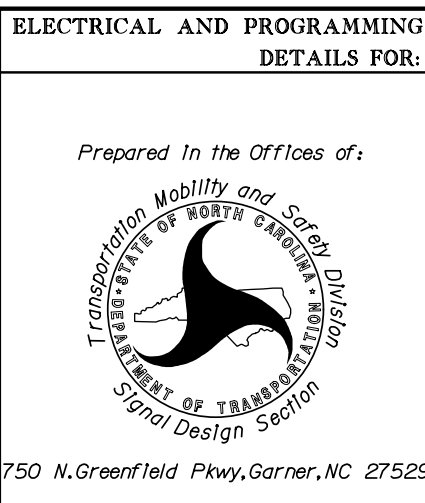

US 29-74 (FRANKLIN BOULEVARD) AT NC 279 (NEW HOPE ROAD)			
DIVISION 12	GASTON COUNTY	GASTONIA	
PLAN DATE: DECEMBER 2004	REVIEWED BY: T. JOYCE		
PREPARED BY: JAMES PETERSON	REVIEWED BY:		
REVISIONS	INIT.	DATE	
INSTALL CHANGEABLE TRAILBLAZER SIGN	SLP	4/2019	

DOCUMENT NOT CONSIDERED FINAL UNLESS ALL SIGNATURES COMPLETED

SEAL

Not a certified document as to the Original Document but Only as to the Revisions - This document originally Issued and sealed by George C. Brown, #022013, on 12/20/04.


This document is only certified as to the revisions.

SIGNATURE

DATE

SIG. INVENTORY NO. 12-0050

▽ **CHANGEABLE TRAILBLAZER SIGN**
WIRING AND PROGRAMMING DETAIL

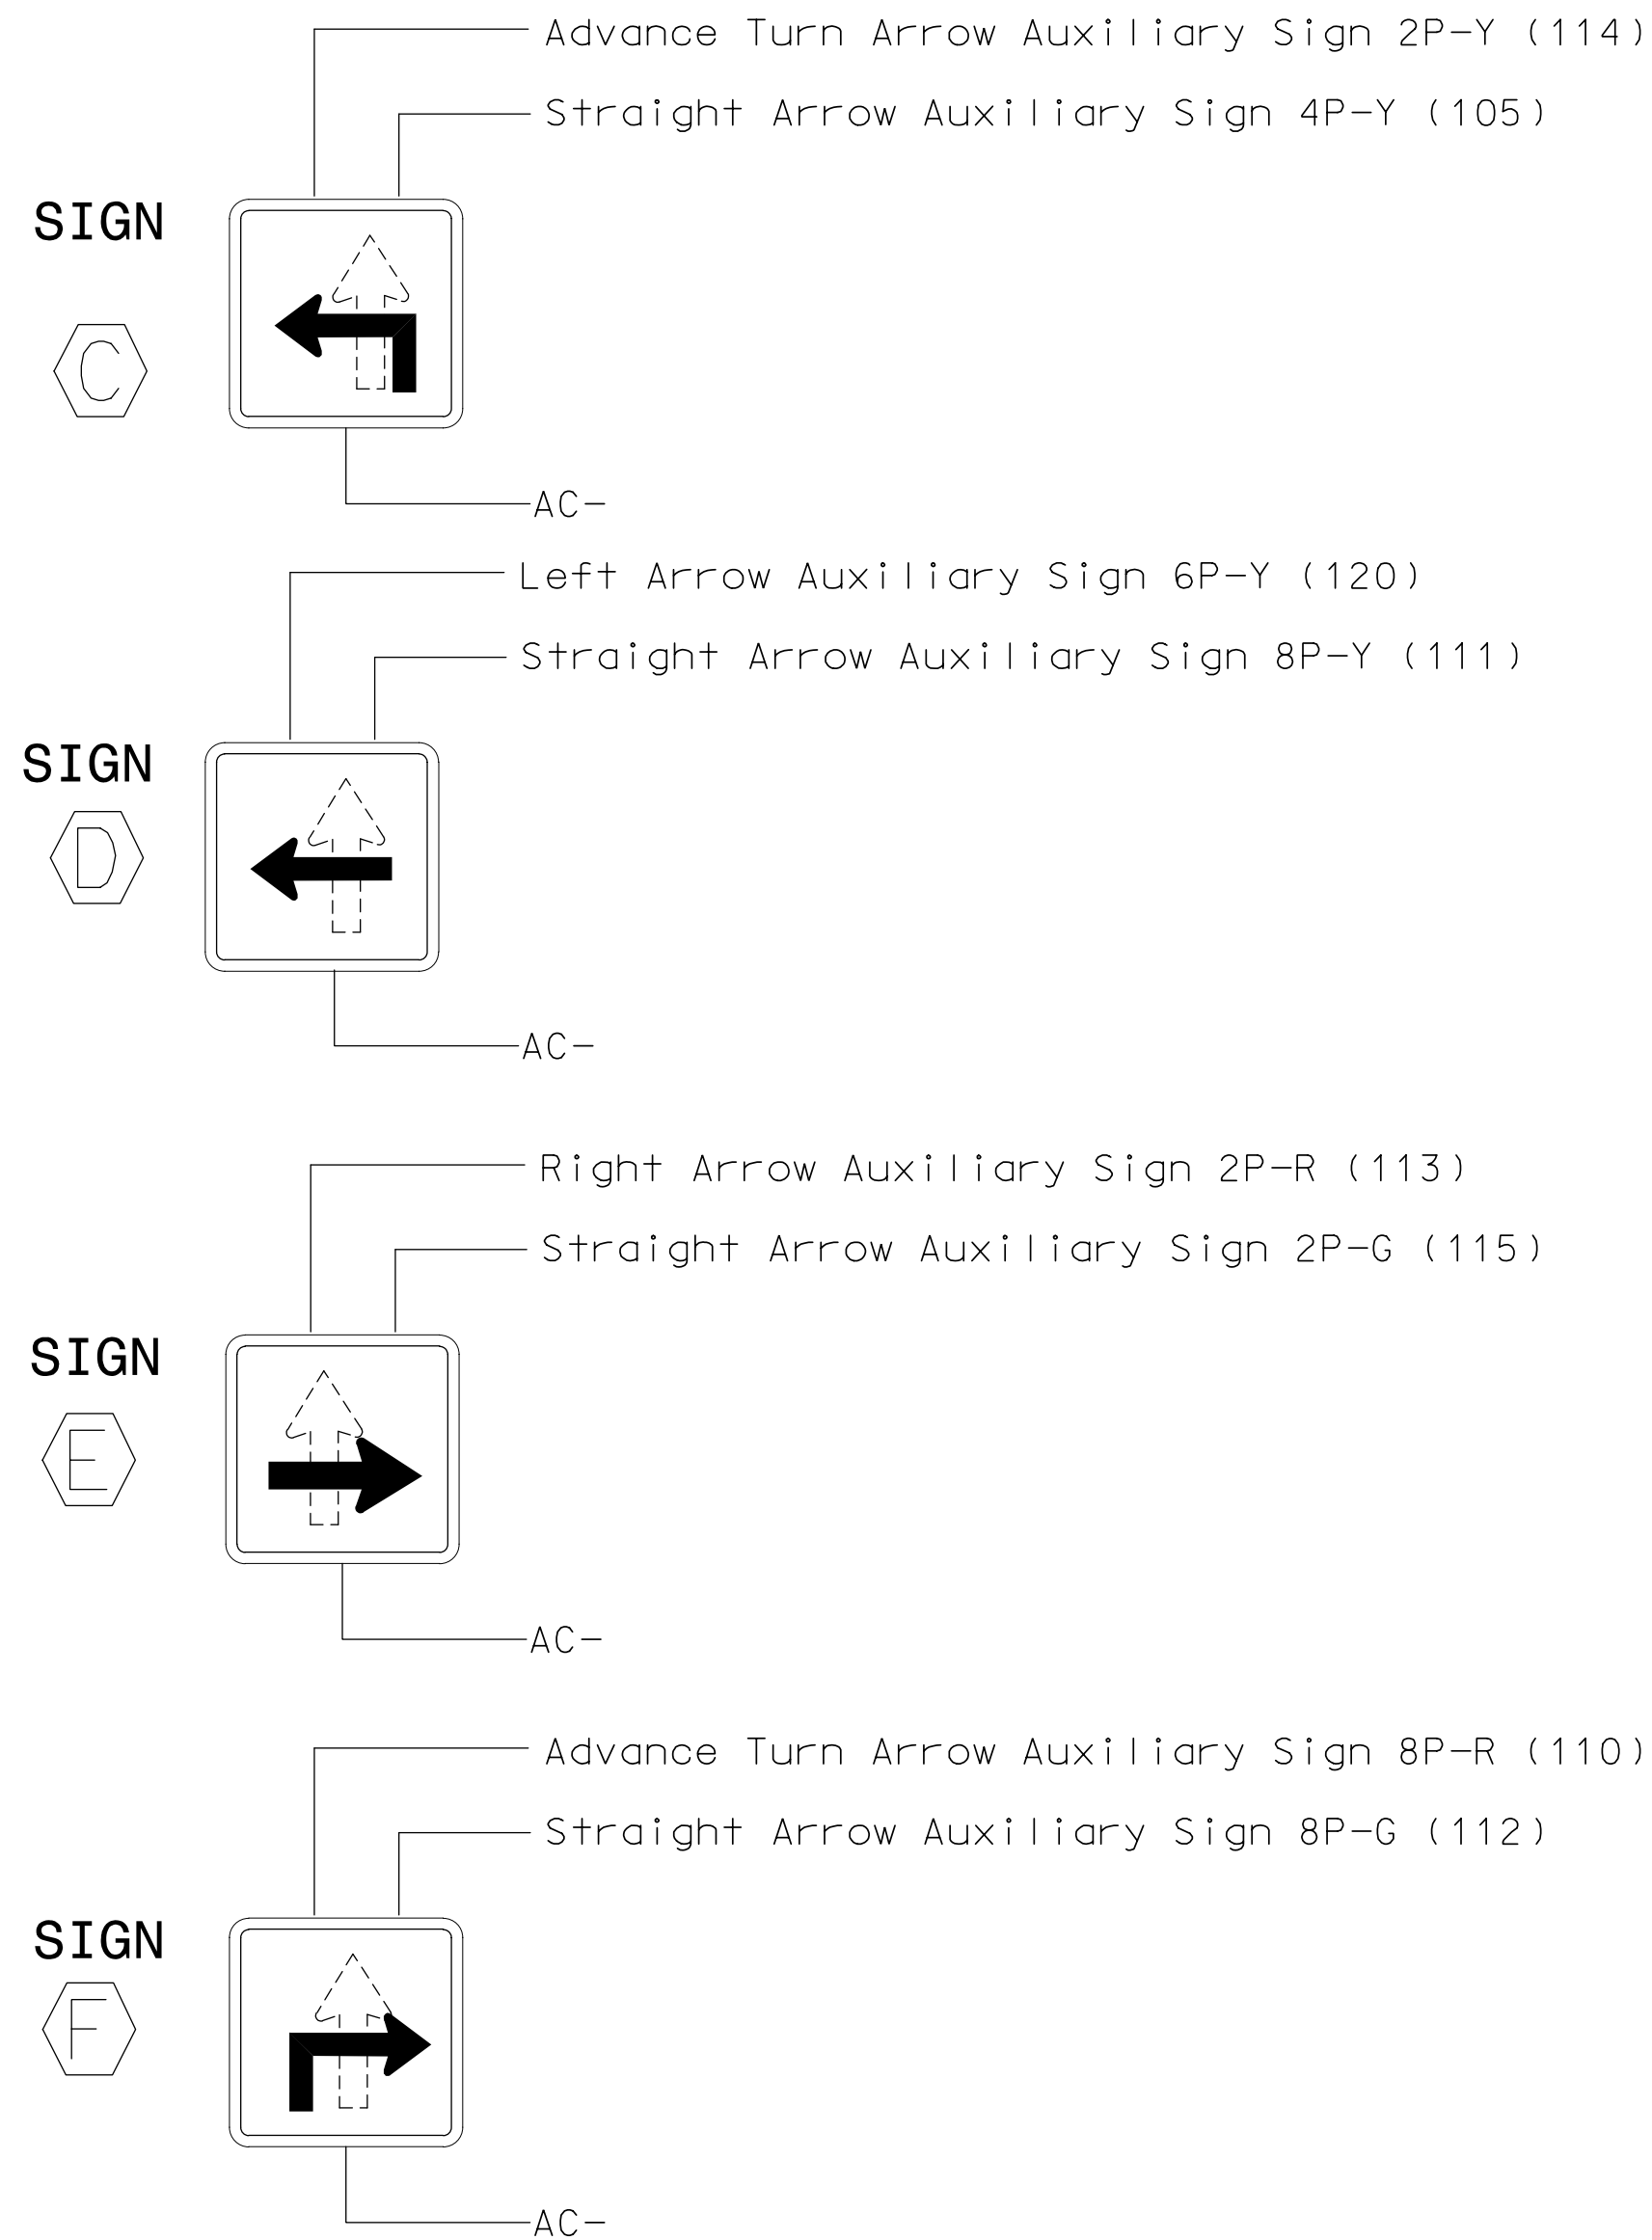


NOTE

Remove, tape, and label conflict monitor wire attached to rear of terminal 2PY (114), 4PY(105), 6PY (120), 8PY (111), 2PR (113), 2PG (115), 8PR (110), 8PG (112).

▽ **LOGICAL I/O PROCESSOR PROGRAMMING DETAIL**
TO CONTROL TRAILBLAZER SIGNS

(program controller as shown below)

1. FROM MAIN MENU PRESS '2' (PHASE CONTROL), THEN '1' (PHASE CONTROL FUNCTIONS). SCROLL TO THE BOTTOM OF THE MENU AND ENABLE ACT LOGIC COMMANDS 29, 30, 31 AND 32.
2. FROM MAIN MENU PRESS '6' (OUTPUTS), THEN '3' (LOGICAL I/O PROCESSOR).


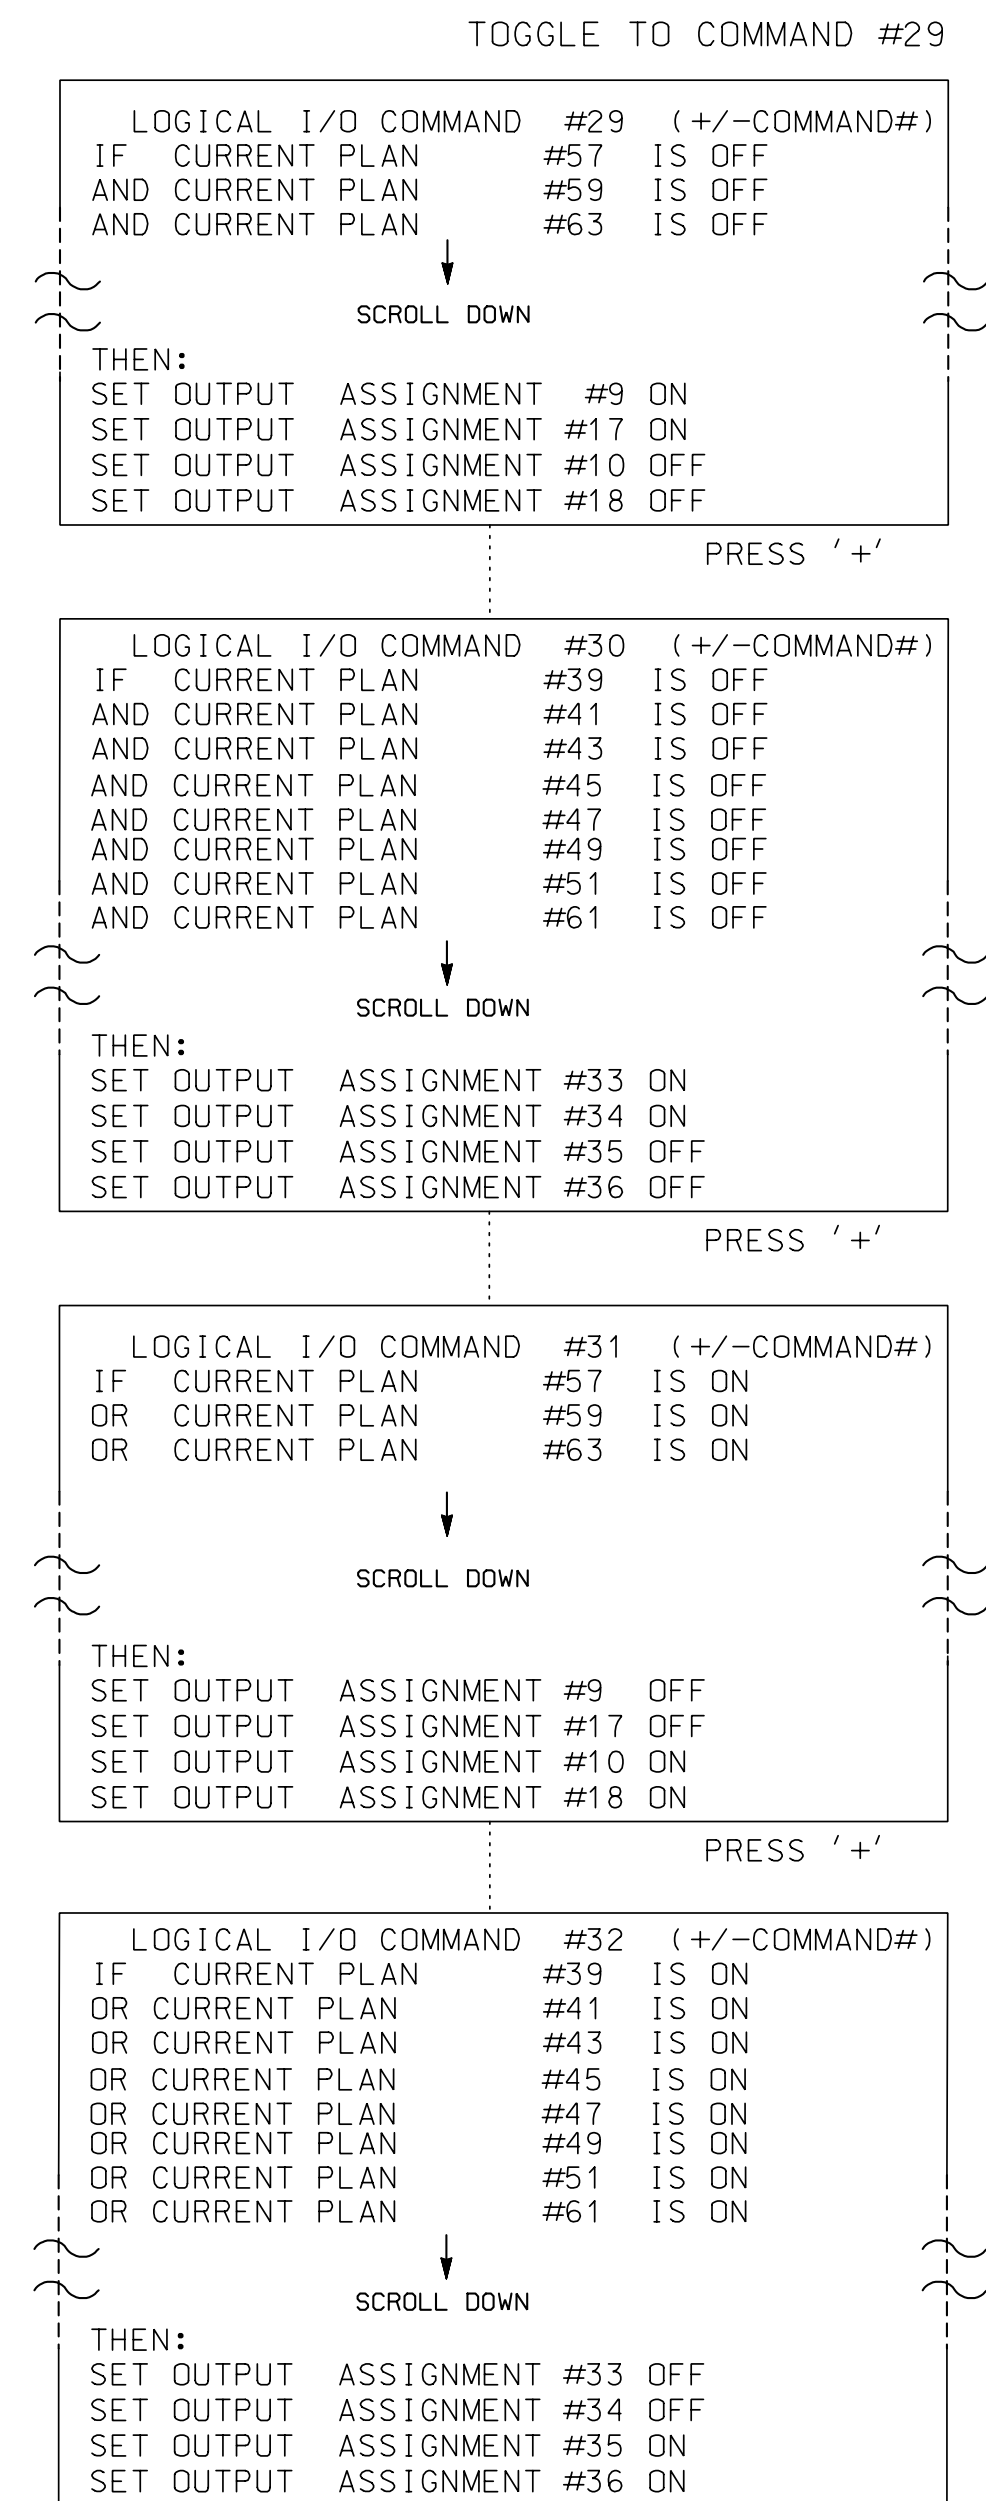


LOGIC I/O PROCESSOR PROGRAMMING COMPLETE

THIS ELECTRICAL DETAIL IS FOR
THE SIGNAL DESIGN: 12-0050
DESIGNED: APRIL 2004
SEALED: 12-10-04
REVISED: 4/16/2019

SIGNAL UPGRADE SHEET 2 OF 2

PLANS PREPARED IN THE OFFICE OF:
Kimley»Horn
NC License #F-0102
421 Fayetteville Street, Suite 600
Raleigh, NC 27601
(919) 677-2000

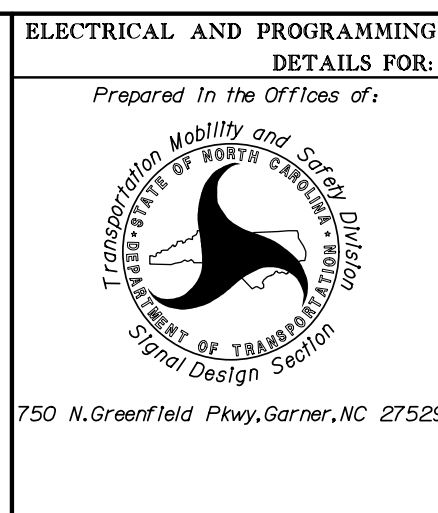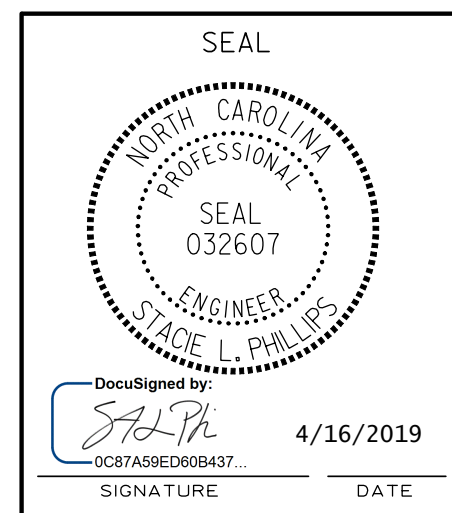

US 29-74 (FRANKLIN BOULEVARD)
AT
NC 279 (NEW HOPE ROAD)
DIVISION 12 GASTON COUNTY GASTONIA
PLAN DATE: DECEMBER 2004 REVIEWED BY: T. JOYCE
PREPARED BY: JAMES PETERSON REVIEWED BY:
REVISIONS
▽ **INSTALL CHANGEABLE TRAILBLAZER SIGN** SLP 4/2019
INIT. DATE
SIGNATURE DATE

DOCUMENT NOT CONSIDERED
FINAL UNLESS ALL
SIGNATURES COMPLETED

SEAL
Not a certified document as
to the Original Document but
Only as to the Revisions -
This document originally
Issued and sealed by
George C. Brown, #022013,
on 12/20/04.
This document is only certified
as to the revisions.

SIGNATURE DATE
SIG. INVENTORY NO. 12-0050

PROGRAMMING DETAIL

WD ENABLE

SW2

OFF ON

REMOVE DIODE JUMPERS 1-5, 1-6, 2-5 AND 2-6.

CONFLICT PROGRAM CARD

COMPONENT SIDE

YELLOW DISABLE

Component Side	Yellow Disable
9-0	0-9
10-11	10-12
11-12	11-13
12-13	12-14
13-14	13-15
14-15	14-16
15-16	15-17
1-5	1-6
2-5	2-6
3-5	3-6
4-5	4-6
5-6	5-7
6-7	6-8
7-8	7-9
8-9	8-0

NOTES:

1. CARD IS PROVIDED WITH ALL DIODE JUMPERS IN PLACE. REMOVAL OF ANY JUMPER ALLOWS ITS CHANNELS TO RUN CONCURRENTLY.
2. MAKE SURE JUMPERS SEL1-SEL5 ARE PRESENT ON THE MONITOR BOARD.

1. TO PREVENT "FLASH-CONFLICT" PROBLEMS, INSERT RED FLASH PROGRAM BLOCKS FOR ALL UNUSED VEHICLE LOAD SWITCHES IN THE OUTPUT FILE. THE INSTALLER SHALL VERIFY THAT SIGNAL HEADS FLASH IN ACCORDANCE WITH THE SIGNAL PLANS.
2. ENSURE THAT RED ENABLE IS ACTIVE AT ALL TIMES DURING NORMAL OPERATION. TO PREVENT RED FAILURES ON UNUSED MONITOR CHANNELS, TIE UNUSED RED MONITOR INPUTS 7,8,9,10, 11,12,13,14,15 & 16 TO LOAD SWITCH AC+ PER THE CABINET MANUFACTURER'S INSTRUCTIONS.
3. PROGRAM CONTROLLER TO START UP IN PHASES 2 AND 6 GREEN.
4. ENABLE SIMULTANEOUS GAP-OUT FEATURE, ON CONTROLLER UNIT, FOR ALL PHASES.
5. PROGRAM PHASES 2 AND 6, ON CONTROLLER UNIT, FOR VARIABLE INITIAL AND GAP REDUCTION.
6. THE CABINET AND CONTROLLER ARE PART OF THE GASTONIA CITY SYSTEM.

```

CONTROLLER.....CONTRACTOR SUPPLIED 2070L
CABINET .....CONTRACTOR SUPPLIED 332
SOFTWARE .....ECONOLITE OASIS
CABINET MOUNT.....BASE
OUTPUT FILE POSITIONS...12
LOAD SWITCHES USED.....S1,S2,S3,S4,S5,S6
PHASES USED.....1,2,3,4,5,6
OVERLAPS.....NONE

```

[illegible]

NU = NOT USED

** Changeable Trailblazer Signs. See wiring and programming detail on sheet 2.

(front view)


[illegible]

EX.: 1A, 2A, ETC. = LOOP NO.'S

FS = FLASH SENSE
ST = STOP TIME

LOOP NO.	LOOP TERMINAL	INPUT FILE POS.	PIN NO.	INPUT ASSIGNMENT NO.	DETECTOR NO.	NEMA PHASE	CALL	EXTEND	FULL TIME DELAY	STRETCH TIME	DELAY TIME
1A	TB2-5,6	I2U	39	1	2	1	Y	Y			
1B	TB2-7,8	I2L	43	5	12	1	Y	Y			15
2A	TB2-9,10	I3U	63	25	32	2	Y	Y			
2B	TB2-11,12	I3L	76	38	42	2	Y	Y			
2C	TB4-1,2	I4U	47	9	22	2	Y	Y			
3A	TB4-5,6	I5U	58	20	3	3	Y	Y			
3B	TB4-9,10	I6U	41	3	4	3	Y	Y			
3C	TB4-11,12	I6L	45	7	14	3	Y	Y			
4A	TB6-1,2	I7U	65	27	34	4	Y	Y			
4B	TB6-3,4	I7L	78	40	44	4	Y	Y			
4C	TB6-5,6	I8U	49	11	24	4	Y	Y			
5A	TB3-1,2	J1U	55	17	5	5	Y	Y			
6A	TB3-5,6	J2U	40	2	6	6	Y	Y			
6B	TB3-7,8	J2L	44	6	16	6	Y	Y			
6C	TB3-9,10	J3U	64	26	36	6	Y	Y			

 INPUT FILE POSITION LEGEND: J2U



THIS ELECTRICAL DETAIL IS FOR
THE SIGNAL DESIGN: 12-0077
DESIGNED: APRIL 2004
SEALED: 12-10-04
REVISED: 4/16/2019

SIGNAL UPGRADE Sheet 1 of 2

US 29-74 (FRANKLIN BOULEVARD)
AT
SR 2200 (ARMSRTRONG PARK ROAD/
COX ROAD)

DIVISION 12 GASTON COUNTY GASTONIA

PLAN DATE: DECEMBER 2004	REVIEWED BY: T. JOYCE
--------------------------	-----------------------

PREPARED BY: JAMES PETERSON	REVIEWED BY:
-----------------------------	--------------

REVISIONS	INIT.	DATE
1. ORIGINAL QUANTIFIABLE REPRODUCED FROM	---	---

✓	INSTALL CHANGEABLE TRAILBLAZER SIGN	SLP	4/2019
---	-------------------------------------	-----	--------

DOCUMENT NOT CONSIDERED
FINAL UNLESS ALL
SIGNATURES COMPLETED

SEAL


Not a certified document as
to the Original Document but
Only as to the Revisions -
This document originally
Issued and sealed by
George C. Brown, #022013,
on 12/20/04.
This document is only certified
as to the revisions.

SIGNATURE	DATE
SIG. INVENTORY NO.	12-0077

\$\$\$SYTIME\$\$\$
 \$\$\$SYDGN\$\$\$
 \$\$\$USERNAME\$\$\$

PLANS PREPARED IN THE OFFICE OF:
Kimley»Horn
NC License #F-0102
421 Fayetteville Street, Suite 600
Raleigh, NC 27601
(919) 677-2000

▽CHANGEABLE TRAILBLAZER SIGN
WIRING AND PROGRAMMING DETAIL

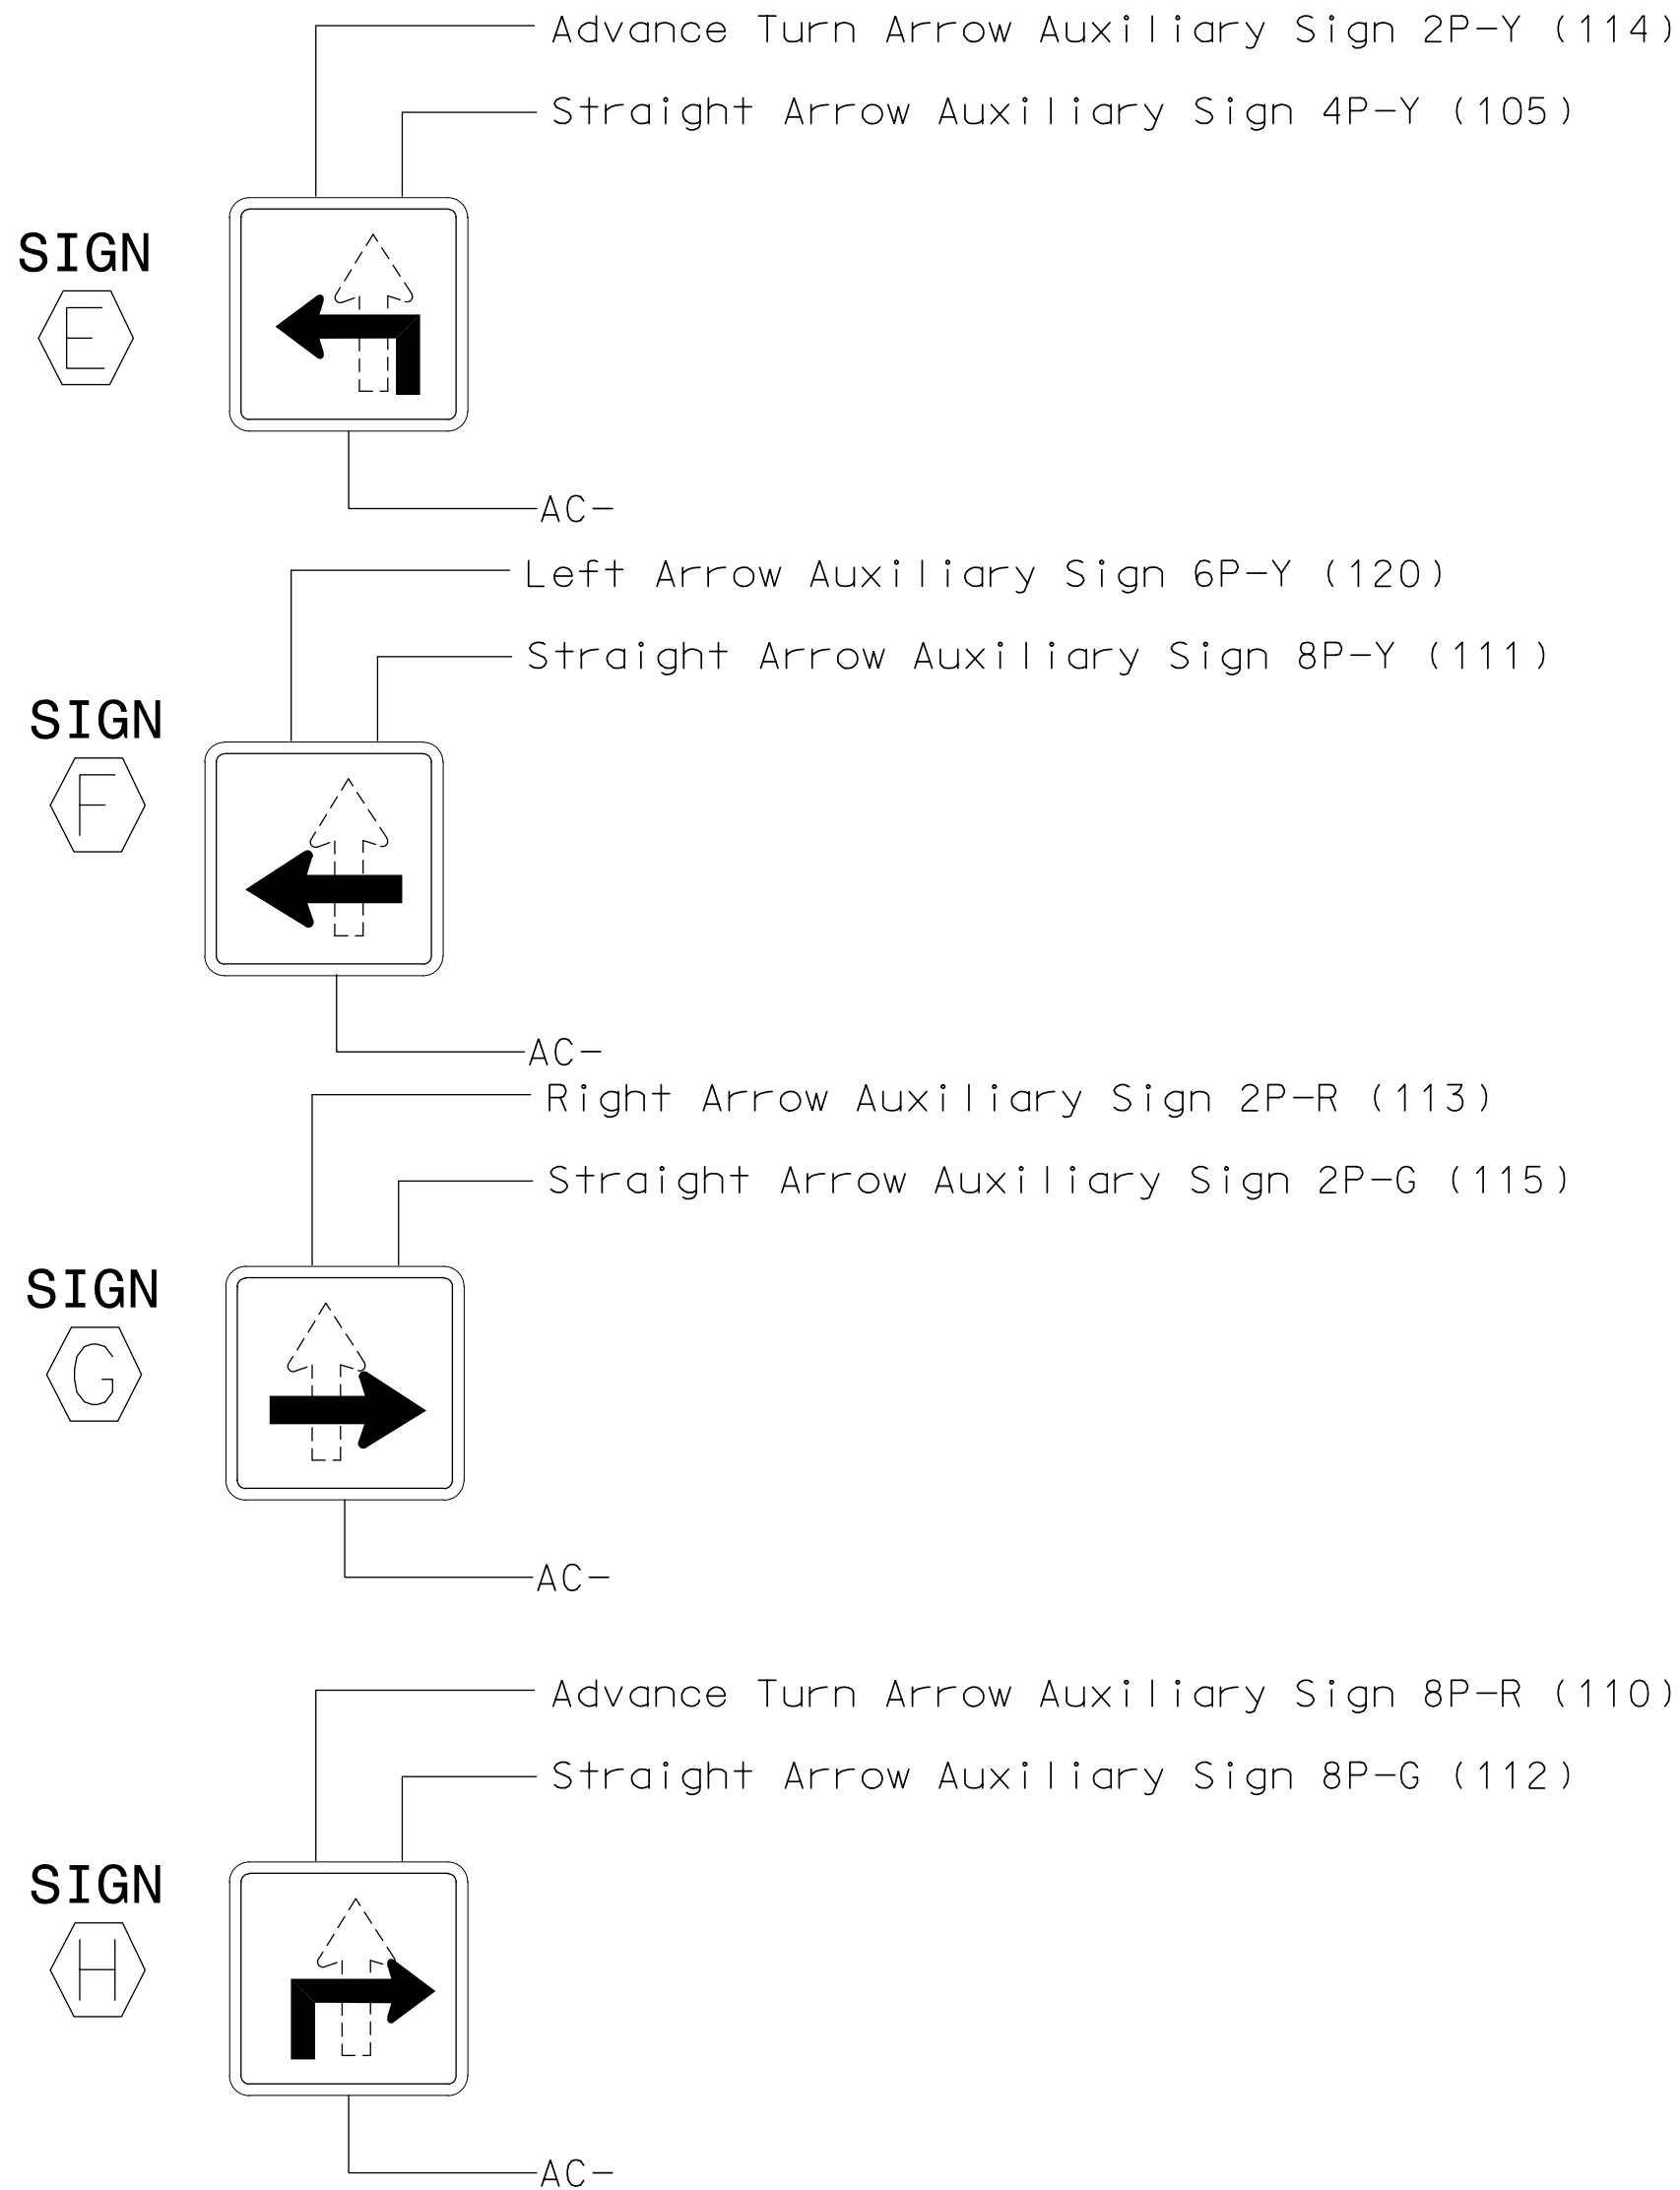


NOTE

Remove, tape, and label conflict monitor wire attached to rear of terminal 2PY (114), 4PY(105), 6PY (120), 8PY (111), 2PR (113), 2PG (115), 8PR (110), 8PG (112).

▽LOGICAL I/O PROCESSOR PROGRAMMING DETAIL
TO CONTROL TRAILBLAZER SIGNS
(program controller as shown below)

- FROM MAIN MENU PRESS '2' (PHASE CONTROL), THEN '1' (PHASE CONTROL FUNCTIONS). SCROLL TO THE BOTTOM OF THE MENU AND ENABLE ACT LOGIC COMMANDS 29, 30, 31 AND 32.
- FROM MAIN MENU PRESS '6' (OUTPUTS), THEN '3' (LOGICAL I/O PROCESSOR).


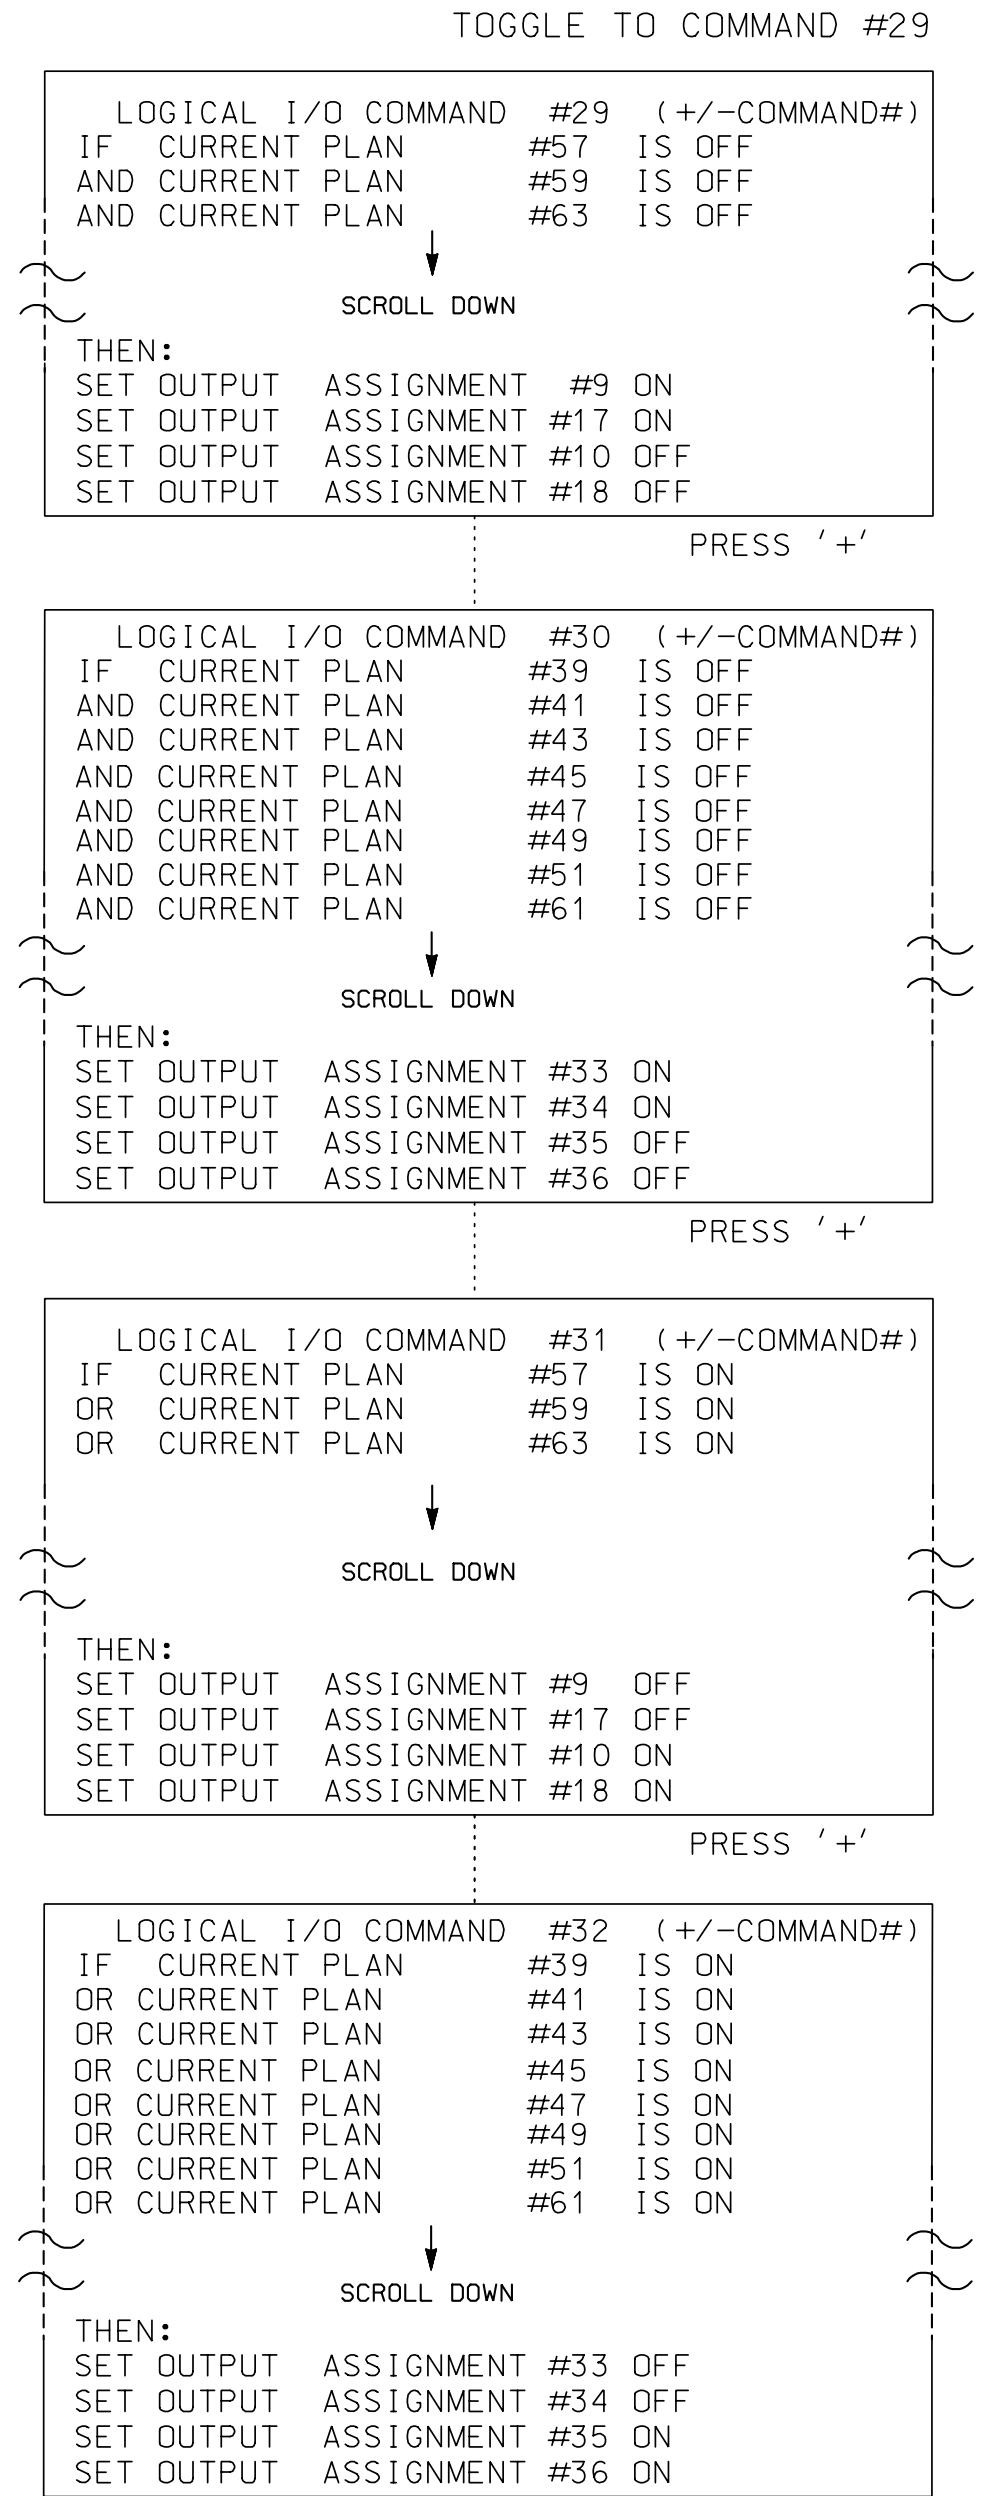


LOGIC I/O PROCESSOR PROGRAMMING COMPLETE

THIS ELECTRICAL DETAIL IS FOR
THE SIGNAL DESIGN: 12-0077
DESIGNED: APRIL 2004
SEALED: 12-10-04
REVISED: 4/16/2019

SIGNAL UPGRADE Sheet 2 of 2


PLANS PREPARED IN THE OFFICE OF:
Kimley»Horn
NC License #F-0102
421 Fayetteville Street, Suite 600
Raleigh, NC 27601
(919) 677-2000

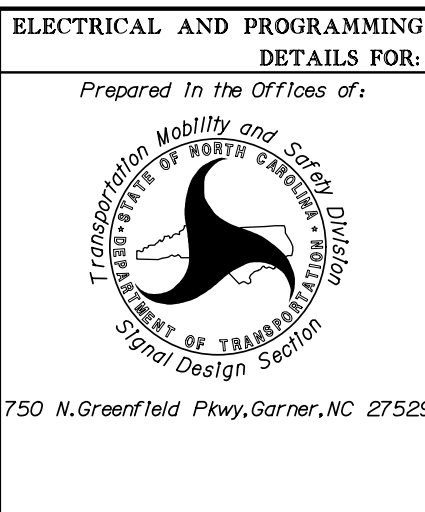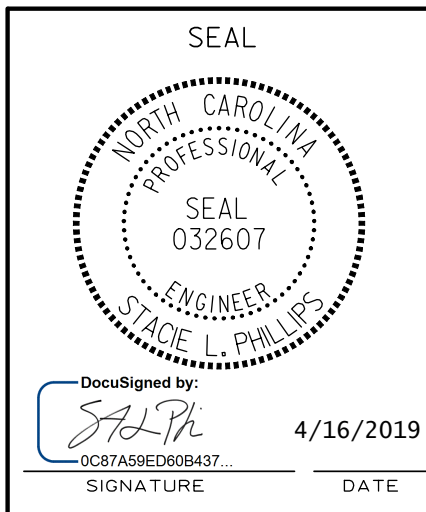

US 29-74 (FRANKLIN BOULEVARD) AT SR 2200 (ARMSRTRONG PARK ROAD/ COX ROAD)	
DIVISION 12	GASTON COUNTY
PLAN DATE: DECEMBER 2004	REVIEWED BY: T. JOYCE
PREPARED BY: JAMES PETERSON	REVIEWED BY:
REVISIONS	
▽ INSTALL CHANGEABLE TRAILBLAZER SIGN	SLP 4/2019

DOCUMENT NOT CONSIDERED FINAL UNLESS ALL SIGNATURES COMPLETED	
SEAL Not a certified document as to the Original Document but Only as to the Revisions - This document originally Issued and sealed by George C. Brown, #022013, on 12/20/04. This document is only certified as to the revisions.	
SIGNATURE	DATE
SIG. INVENTORY NO.	12-0077


PHASING DIAGRAM

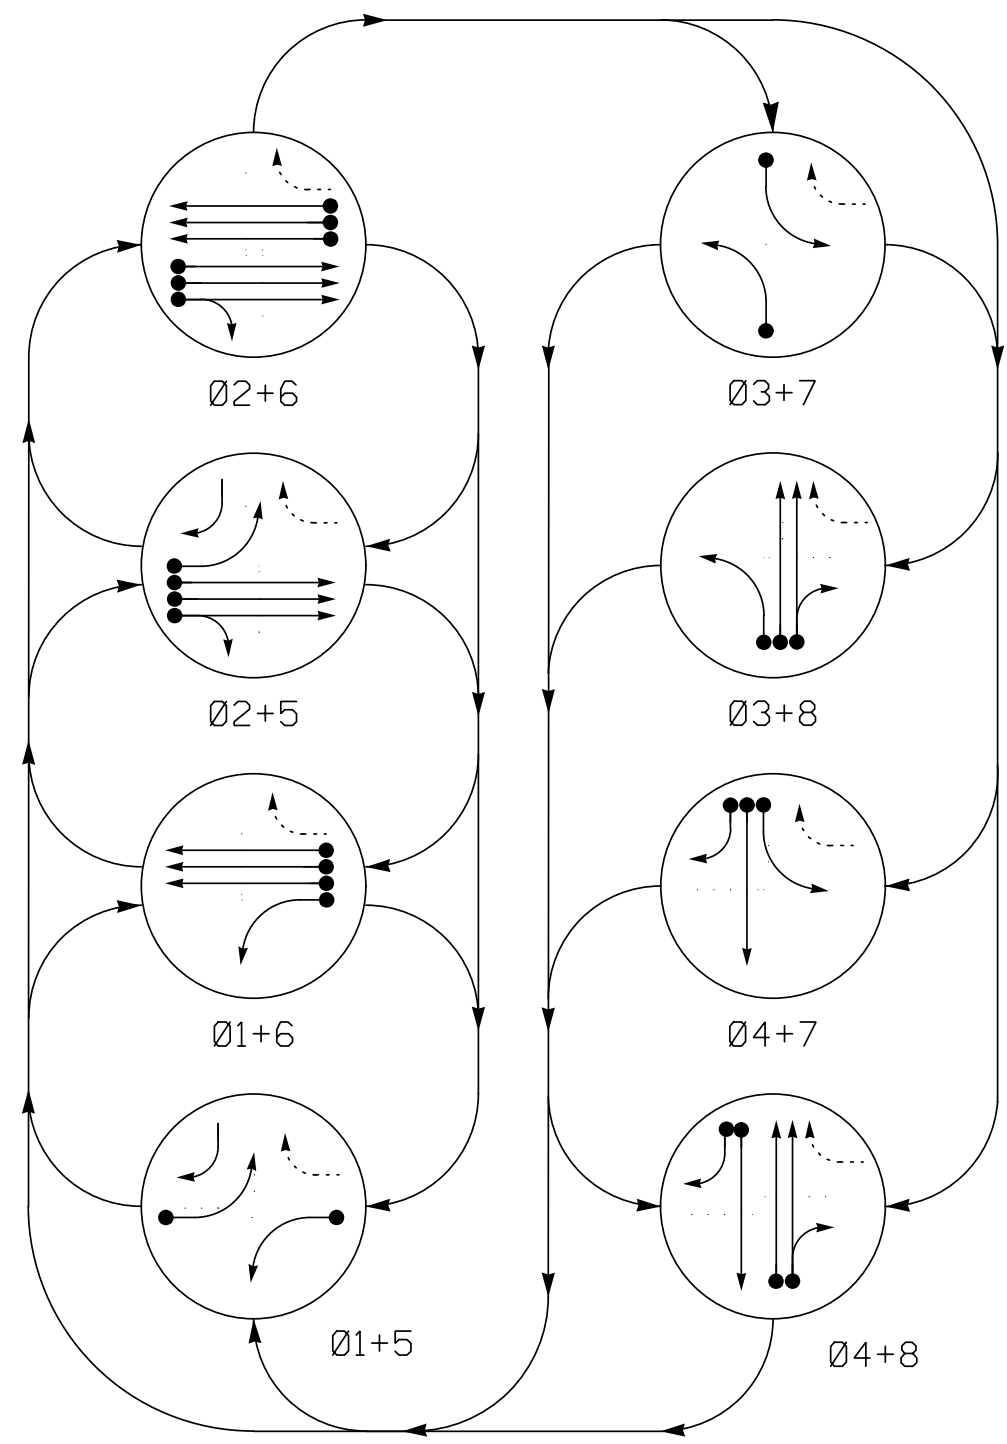

PHASING DIAGRAM DETECTION LEGEND

- DETECTED MOVEMENT
- UNDETECTED MOVEMENT (OVERLAP)
- UNSIGNALIZED MOVEMENT
- PEDESTRIAN MOVEMENT

US 29-74 (East Franklin Boulevard)

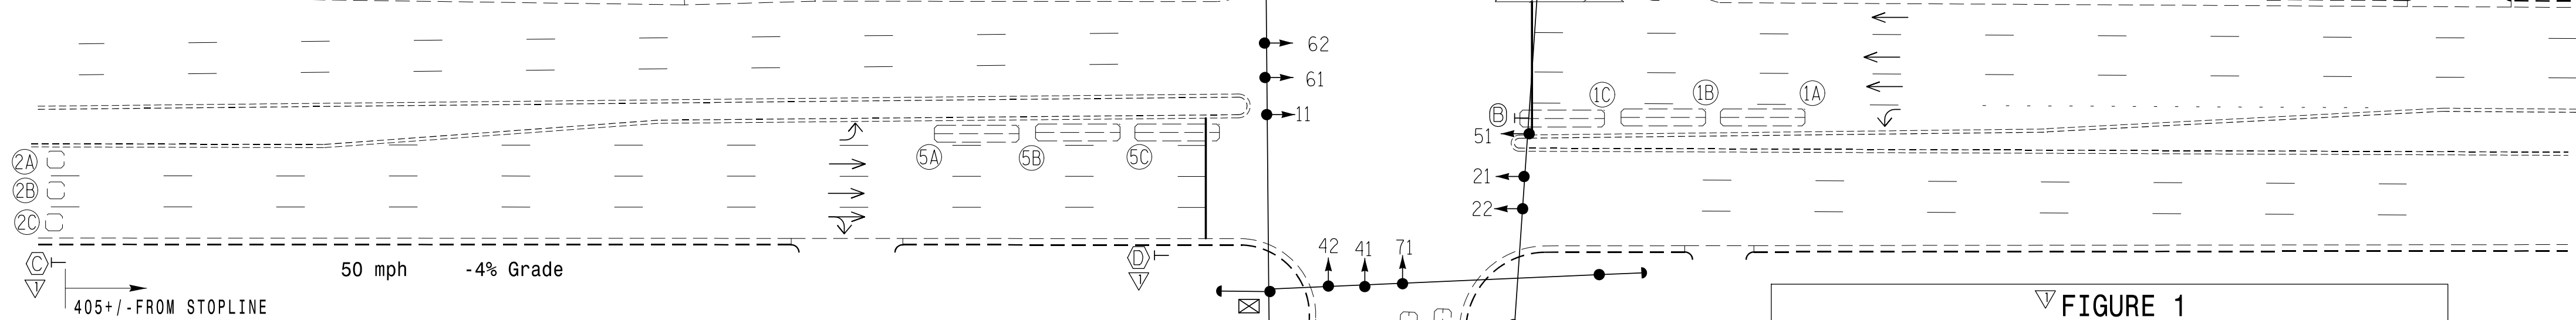

2070L TIMING CHART

FEATURE	PHASE							
	1	2	3	4	5	6	7	8
Min Green 1 *	7	14	7	4	7	14	7	7
Extension 1 *	2.0	6.0	2.0	1.0	1.0	6.0	1.0	2.0
Max Green 1 *	20	90	20	30	20	90	20	30
Yellow Clearance	4.0	5.1	4.0	4.0	4.0	5.1	4.0	4.0
Red Clearance	2.0	1.7	2.7	2.7	2.6	1.7	2.9	2.7
Walk 1 *	-	-	-	-	-	-	-	-
Don't Walk 1	-	-	-	-	-	-	-	-
Seconds Per Actuation *	-	1.5	-	-	-	1.5	-	-
Max Variable Initial *	-	34	-	-	-	34	-	-
Time Before Reduction *	-	15	-	-	-	15	-	-
Time To Reduce *	-	30	-	-	-	30	-	-
Minimum Gap	-	3.0	-	-	-	3.0	-	-
Recall Mode	-	MIN RECALL	-	-	-	MIN RECALL	-	-
Vehicle Call Memory	-	YELLOW	-	-	-	YELLOW	-	-
Dual Entry	-	-	-	-	-	-	-	-
Simultaneous Gap	ON	ON	ON	ON	ON	ON	ON	ON


* These values may be field adjusted. Do not adjust Min Green and Extension times for phases 2 and 6 lower than what is shown. Min Green for all other phases should not be lower than 4 seconds.

TABLE OF OPERATION

SIGNAL FACE	PHASE							
	Ø 1 + 5	Ø 1 + 6	Ø 2 + 5	Ø 2 + 6	Ø 3 + 7	Ø 3 + 8	Ø 4 + 7	Ø 4 + 8
11	←	←	→	→	→	→	→	→
21, 22	R	R	G	G	R	R	R	R
31	→	→	→	→	←	←	←	←
41	R	R	R	R	R	G	G	R
42	←	←	←	←	→	→	→	→
51	←	←	←	←	→	→	→	→
61, 62	R	G	R	G	R	R	R	R
71	→	→	→	→	←	←	←	←
81, 82	R	R	R	R	R	G	G	R
SIGN 'C'	*	*	*	*	*	*	*	OFF
SIGN 'D'	*	*	*	*	*	*	*	OFF
SIGN 'E'	*	*	*	*	*	*	*	OFF
SIGN 'F'	*	*	*	*	*	*	*	OFF

*Changeable Trailblazer Sign controlled remotely

SIGNAL FACE I.D.

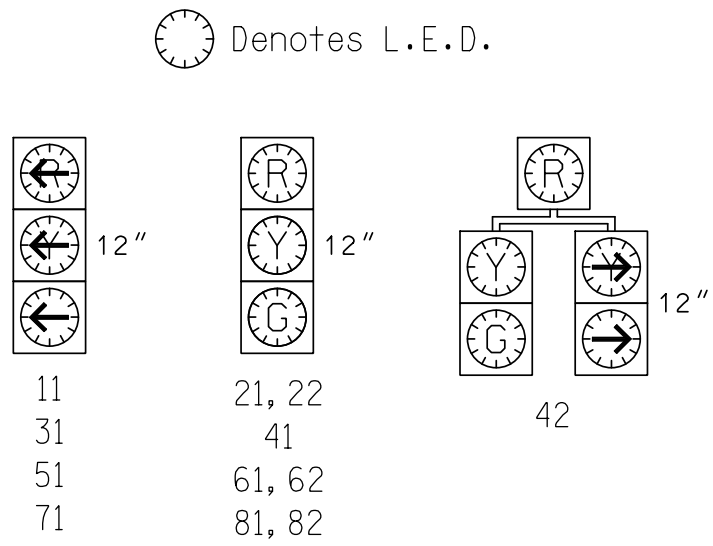

2070L LOOP & DETECTOR INSTALLATION

INDUCTIVE LOOPS				DETECTOR PROGRAMMING							
LOOP	SIZE (FT)	TURNS	DISTANCE FROM STOPBAR (FT)	NEW LOOP	PHASE	CALLING	EXTENSION	FULL TIME DELAY	SYSTEM LOOP	STRETCH TIME	DELAY TIME
1A	6x30	Existing	Existing	-	1	Y	Y	-	-	-	Y
1B	6x30	Existing	Existing	-	1	Y	Y	-	-	-	Y
1C	6x30	Existing	Existing	-	1	Y	Y	-	-	-	Y
2A	6x6	Existing	Existing	-	2	Y	Y	-	-	-	Y
2B	6x6	Existing	Existing	-	2	Y	Y	-	-	-	Y
2C	6x6	Existing	Existing	-	2	Y	Y	-	-	-	Y
3A	6x60	Existing	Existing	-	3	Y	Y	-	-	-	Y
4A	6x60	Existing	Existing	-	4	Y	Y	-	-	-	Y
4B	6x40	Existing	Existing	-	4	Y	Y	-	-	10	Y
5A	6x30	Existing	Existing	-	5	Y	Y	-	-	-	Y
5B	6x30	Existing	Existing	-	5	Y	Y	-	-	-	Y
5C	6x30	Existing	Existing	-	5	Y	Y	-	-	-	Y
6A	6x6	Existing	Existing	-	6	Y	Y	-	-	-	Y
6B	6x6	Existing	Existing	-	6	Y	Y	-	-	-	Y
6C	6x6	Existing	Existing	-	6	Y	Y	-	-	-	Y
7A	6x60	Existing	Existing	-	7	Y	Y	-	-	-	Y
8A	6x60	Existing	Existing	-	8	Y	Y	-	-	-	Y
8B	6x60	Existing	Existing	-	8	Y	Y	-	-	10	Y

8 Phase Fully Actuated (Gastonia City System)


NOTES

- Refer to "Roadway Standard Drawings NCDOT" dated January 2002 and "Standard Specifications for Roads and Structures" dated January 2002.
- Do not program signal for late night flashing operation unless otherwise directed by the Engineer.
- Phase 1 or phase 5 may be lagged.
- Phase 3 or phase 7 may be lagged.
- Set all detector units to presence mode.
- Locate new cabinet so as not to obstruct sight distance of vehicles turning right on red.
- Remove existing "Left Turn Signal" sign(s)-(R10-10L) and/or existing "Right Turn Signal" sign(s)-(R10-10R).
- Pavement markings are existing.
- Maximum times shown in timing chart are for free-run operation only. Coordinated signal system timing values supersede these values.
- City system data:
Controller Asset #: 0151.

LEGEND



PROPOSED	EXISTING
Traffic Signal Head	Modified Signal Head
Signal Pole with Guy	Signal Pole with Sidewalk Guy
Inductive Loop Detector	Controller & Cabinet
Junction Box	2-in Underground Conduit
Right of Way	Directional Arrow
Pavement Marking Arrow	"YIELD" Sign (R1-2)
U-Turn "MUST YIELD" Sign (R3-27)	Type 1B Changeable Trailblazer sign (See Figure 1)
Type 1A Changeable Trailblazer sign (See Figure 1)	Type 2A Changeable Trailblazer sign (See Figure 1)
Type 2B Changeable Trailblazer sign (See Figure 1)	

FIGURE 1

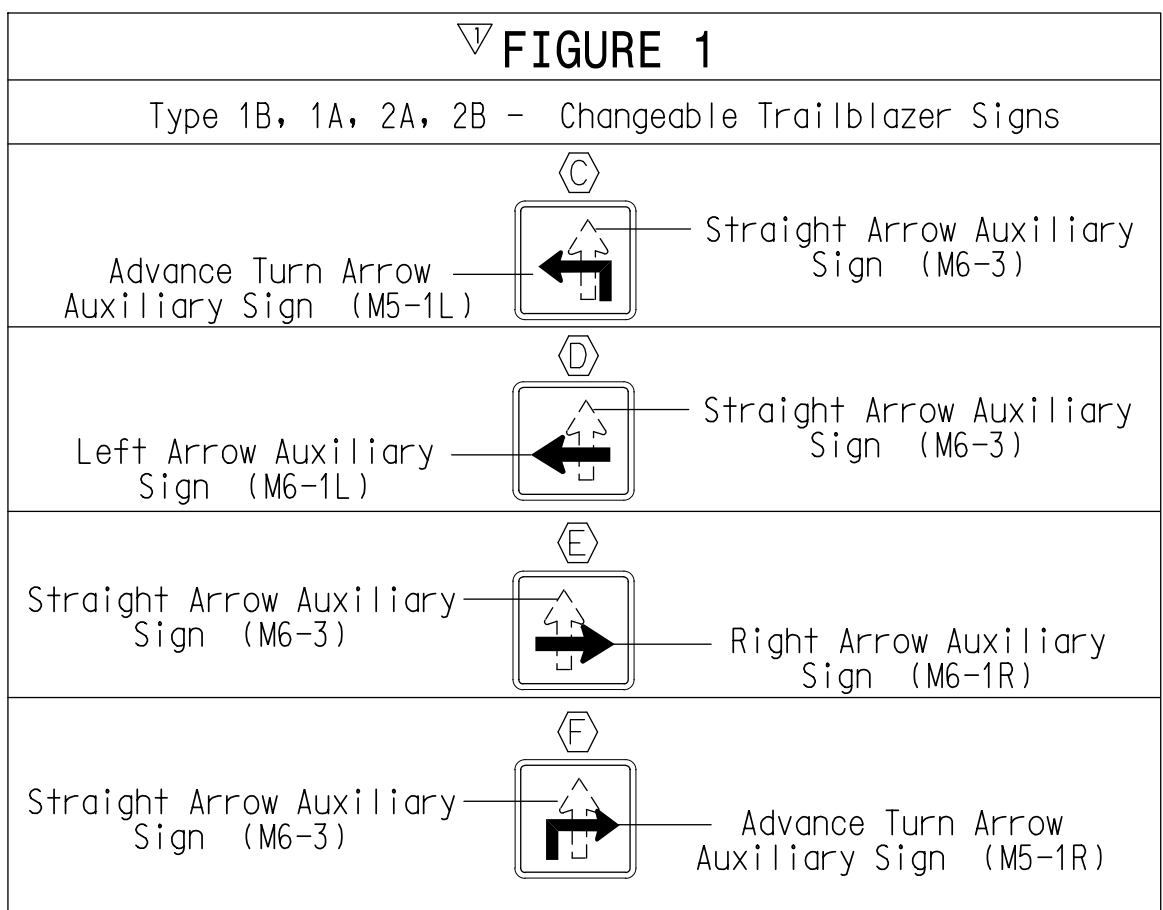

Signal Upgrade

PLANS PREPARED IN THE OFFICE OF:
Kimley-Horn
NC License #F-0102
421 Fayetteville Street, Suite 600
Raleigh, NC 27601
(919) 677-2000

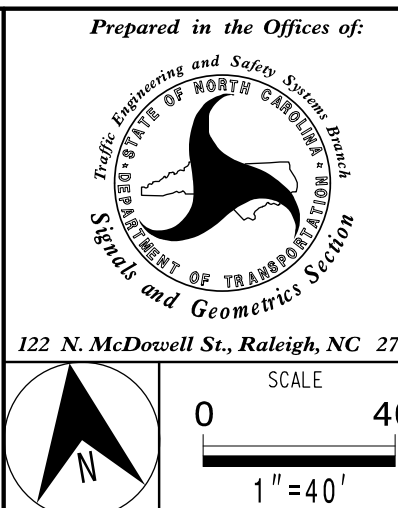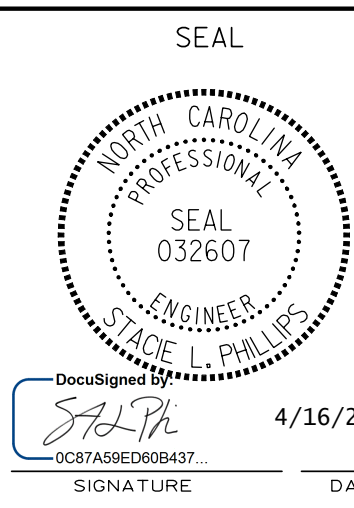


US 29-74 (Wilkinson Boulevard)		at		SR 2329 (Main Street/Redbud Drive)	
Division 12		Gaston County		Gastonia	
PLAN DATE: November 2004		REVIEWED BY:			
PREPARED BY: AB Hambricht		REVIEWED BY:			
REVISIONS		INIT.		DATE	
INSTALL CHANGEABLE TRAILBLAZER SIGN		SLP		4/2019	
SIGNATURE		DATE			
SIG. INVENTORY NO.		12-0151			

Not a certified document as to the Original Document but Only as to the Revisions - This document originally Issued and sealed by Richard E. Mullinax, PE #22027 on 02/07/2005 This document is only certified as to the revisions.

EDI MODEL 2010ECL CONFLICT MONITOR

PROGRAMMING DETAIL

(remove jumpers and set switches as shown)

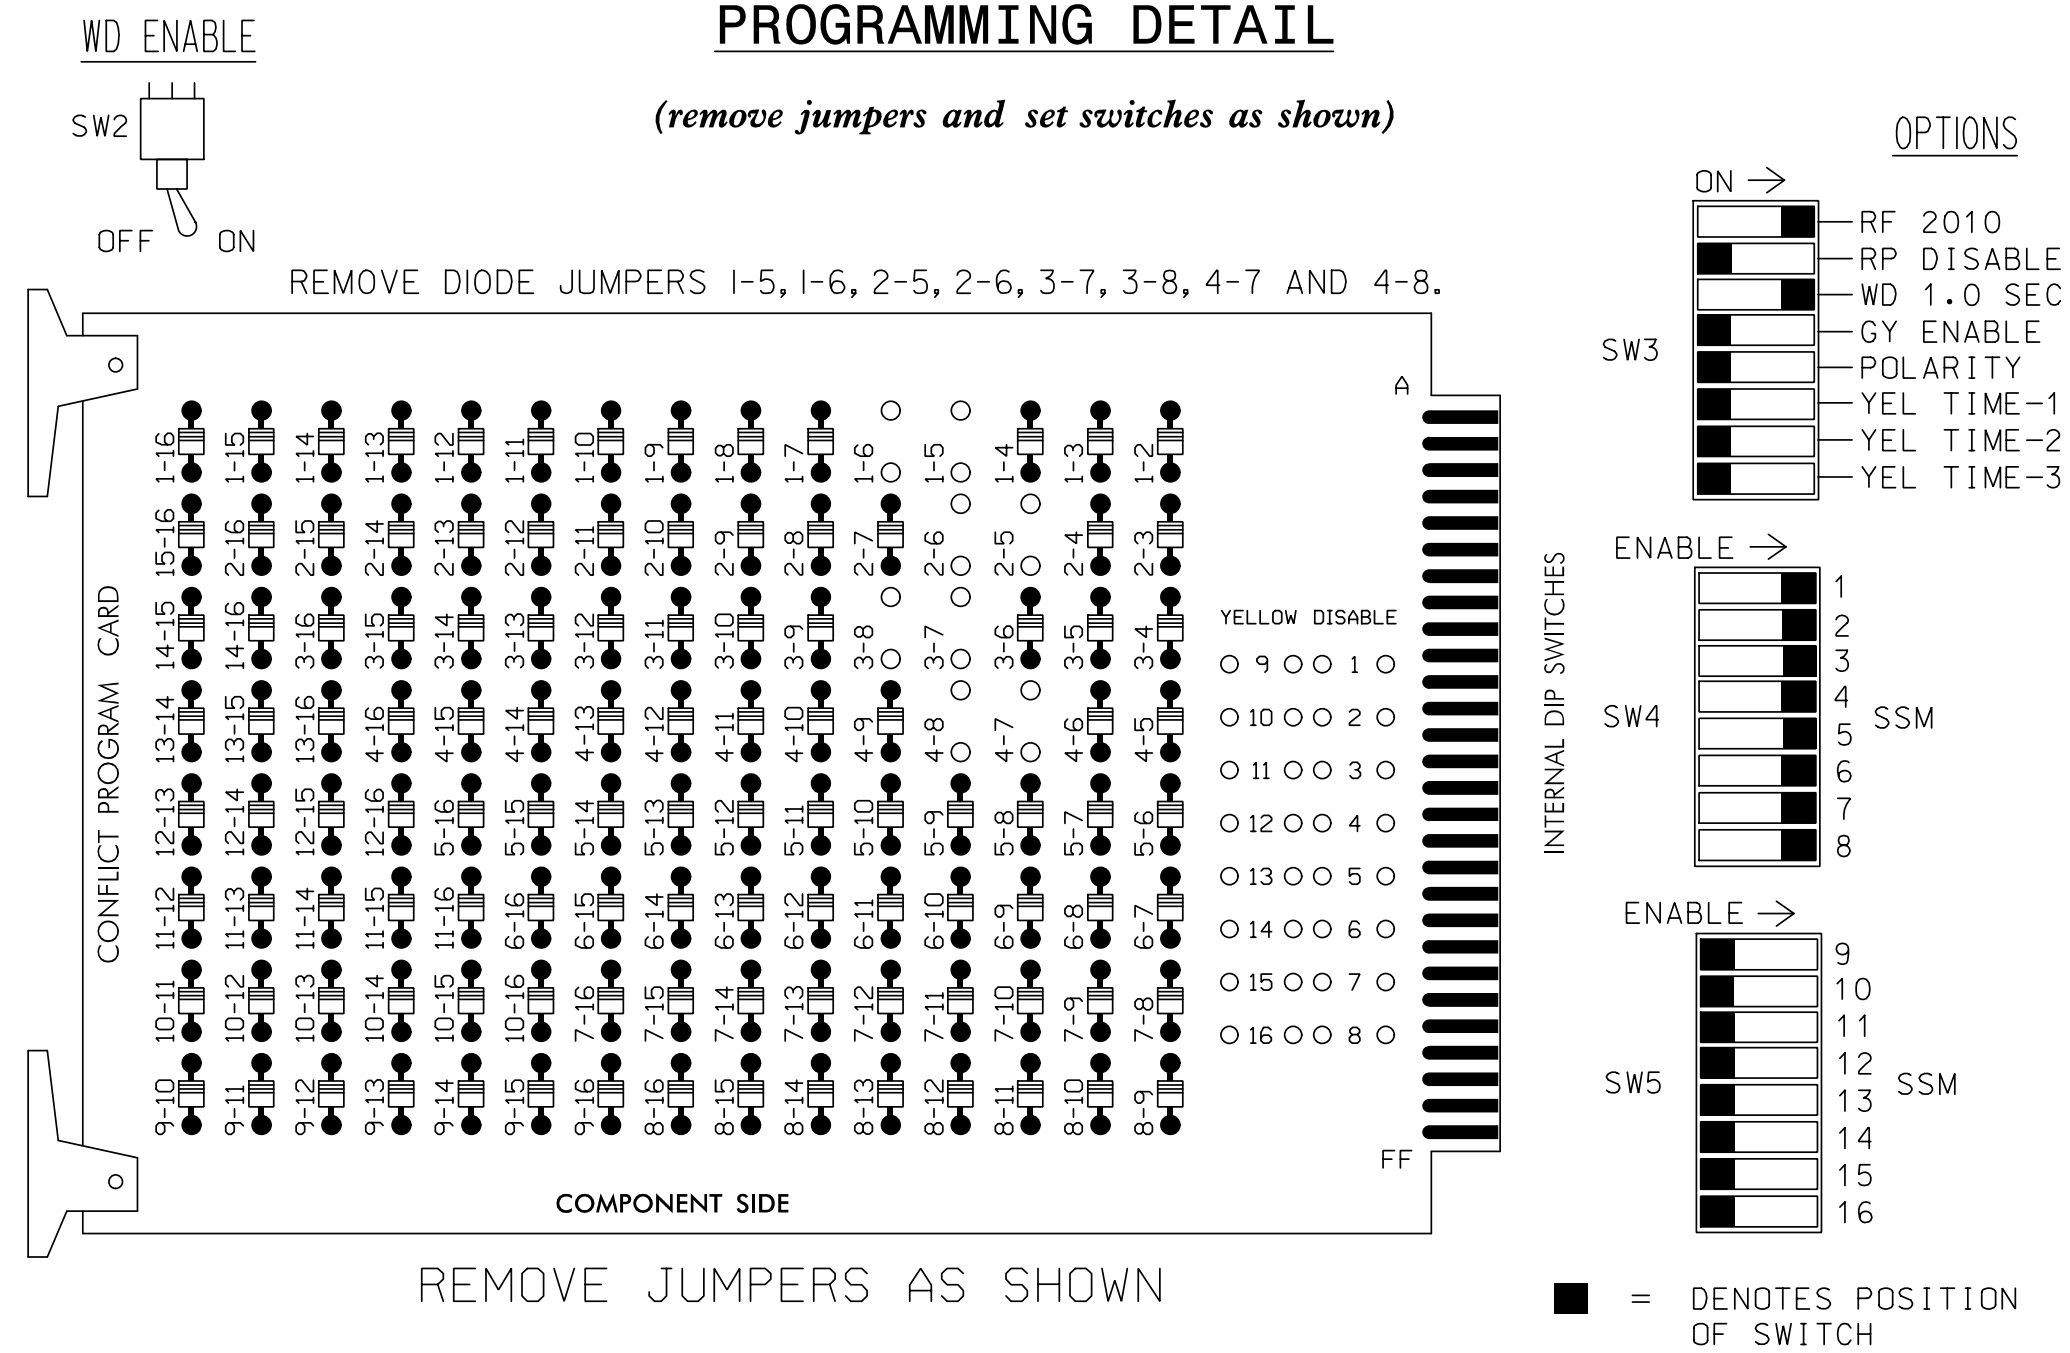

NOTES:

1. CARD IS PROVIDED WITH ALL DIODE JUMPERS IN PLACE. REMOVAL OF ANY JUMPER ALLOWS ITS CHANNELS TO RUN CONCURRENTLY.
2. MAKE SURE JUMPERS SEL1-SEL5 ARE PRESENT ON THE MONITOR BOARD.

NOTES

1. TO PREVENT "FLASH-CONFLICT" PROBLEMS, INSERT RED FLASH PROGRAM BLOCKS FOR ALL UNUSED VEHICLE LOAD SWITCHES IN THE OUTPUT FILE. THE INSTALLER SHALL VERIFY THAT SIGNAL HEADS FLASH IN ACCORDANCE WITH THE SIGNAL PLANS.
2. ENSURE THAT RED ENABLE IS ACTIVE AT ALL TIMES DURING NORMAL OPERATION. TO PREVENT RED FAILURES ON UNUSED MONITOR CHANNELS, TIE UNUSED RED MONITOR INPUTS 9,10, 11,12,13,14,15 & 16 TO LOAD SWITCH AC+ PER THE CABINET MANUFACTURER'S INSTRUCTIONS.
3. PROGRAM CONTROLLER TO START UP IN PHASES 2 AND 6 GREEN.
4. ENABLE SIMULTANEOUS GAP-OUT FEATURE, ON CONTROLLER UNIT, FOR ALL PHASES.
5. PROGRAM PHASES 2 AND 6, ON CONTROLLER UNIT, FOR VARIABLE INITIAL AND GAP REDUCTION.
6. THE CABINET AND CONTROLLER ARE PART OF THE GASTONIA CITY SYSTEM.

EQUIPMENT INFORMATION

```

CONTROLLER.....CONTRACTOR SUPPLIED 2070L
CABINET .....CONTRACTOR SUPPLIED 332
SOFTWARE .....ECONOLITE OASIS
CABINET MOUNT.....BASE
OUTPUT FILE POSITIONS...12
LOAD SWITCHES USED.....S1,S2,S3,S4,S5,S6,S7,S8
PHASES USED.....1,2,3,4,5,6,7,8
OVERLAPS.....NONE

```

INPUT FILE POSITION LAYOUT

(front view)

		1	2	3	4	5	6	7	8	9	10	11	12	13	14	
FILE "I"	U	Ø 1	Ø 1	Ø 2	Ø 2	Ø 3	Ø 4	SLOT	SLOT	SLOT	SLOT	SLOT	SLOT	SLOT	FS	
		1A	1B	2A	2C	3A	4A								DC ISOLATOR	
	L	NOT USED	Ø 1	Ø 2	NOT USED	NOT USED	Ø 4	EMPTY	EMPTY	EMPTY	EMPTY	EMPTY	EMPTY	EMPTY	EMPTY	ST DC ISOLATOR
				1C	2B			4B								
FILE "J"	U	Ø 5	Ø 5	Ø 6	Ø 6	Ø 7	Ø 8	SLOT	SLOT	SLOT	SLOT	SLOT	SLOT	SLOT	SLOT	
		5A	5B	6A	6C	7A	8A									
	L	NOT USED	Ø 5	Ø 6	NOT USED	NOT USED	Ø 8	EMPTY	EMPTY	EMPTY	EMPTY	EMPTY	EMPTY	EMPTY	EMPTY	
				5C	6B			8B								

EX.: 1A, 2A, ETC. = LOOP NO.'S

FS = FLASH SENSE
ST = STOP TIME


INPUT FILE CONNECTION & PROGRAMMING CHART

LOOP NO.	LOOP TERMINAL	INPUT FILE POS.	PIN NO.	INPUT ASSIGNMENT NO.	DETECTOR NO.	NEMA PHASE	CALL	EXTEND	FULL TIME DELAY	STRETCH TIME	DELAY TIME
1A	TB2-1,2	I1U	56	18	1	1	Y	Y			
1B	TB2-5,6	I2U	39	1	2	1	Y	Y			
1C	TB2-7,8	I2L	43	5	12	1	Y	Y			
2A	TB2-9,10	I3U	63	25	32	2	Y	Y			
2B	TB2-11,12	I3L	76	38	42	2	Y	Y			
2C	TB4-1,2	I4U	47	9	22	2	Y	Y			
3A	TB4-5,6	I5U	58	20	3	3	Y	Y			
4A	TB4-9,10	I6U	41	3	4	4	Y	Y			
4B	TB4-11,12	I6L	45	7	14	4	Y	Y			10
5A	TB3-1,2	J1U	55	17	5	5	Y	Y			
5B	TB3-5,6	J2U	40	2	6	5	Y	Y			
5C	TB3-7,8	J2L	44	6	16	5	Y	Y			
6A	TB3-9,10	J3U	64	26	36	6	Y	Y			
6B	TB3-11,12	J3L	77	39	46	6	Y	Y			
6C	TB5-1,2	J4U	48	10	26	6	Y	Y			
7A	TB5-5,6	J5U	57	19	7	7	Y	Y			
8A	TB5-9,10	J6U	42	4	8	8	Y	Y			
8B	TB5-11,12	J6L	46	8	18	8	Y	Y			10

INPUT FILE POSITION LEGEND: J2L

FILE J _____
SLOT 2 _____
LOWER _____

PLANS PREPARED IN THE OFFICE OF:
Kimley»Horn
NC License #F-0102
421 Fayetteville Street, Suite 600
Raleigh, NC 27601
(919) 677-2000

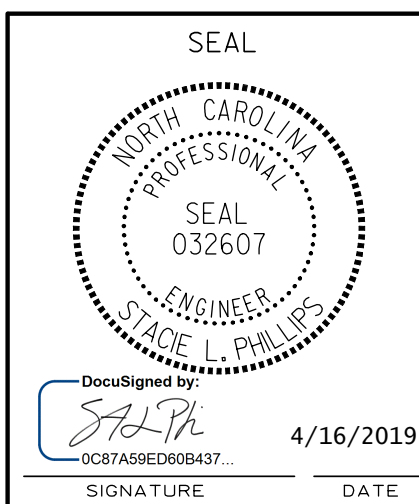

SIGNAL UPGRADE SHEET 1 OF 2

THIS ELECTRICAL DETAIL IS FOR
THE SIGNAL DESIGN: 12-0151
DESIGNED: NOVEMBER 2004
SEALED: 12-10-04
REVISED: 4/16/2019

US 29-74 (WILKINSON BOULEVARD)
AT
SR 2329 (MAIN STREET/
REDBUD DRIVE)

DIVISION 12		GASTON COUNTY		GASTON COUNTY	
PLAN DATE: DECEMBER 2004		REVIEWED BY:		T. JOYCE	
PREPARED BY: JAMES PETERSON		REVIEWED BY:			

REVISIONS	INIT.	DATE
1 INSTALL CHANGEABLE TRAILBLAZER SIGN	SLP	4/201

DOCUMENT NOT CONSIDERED
FINAL UNLESS ALL
SIGNATURES COMPLETED

SEAL
Not a certified document as
to the Original Document but
Only as to the Revisions -
This document originally
issued and sealed by
George C. Brown, #022013,
on 12/20/04.
This document is only certified
as to the revisions.


SIGNATURE	DATE
SIG. INVENTORY NO.	12-0151

▽ LOGICAL I/O PROCESSOR PROGRAMMING DETAIL

TO CONTROL TRAILBLAZER SIGNS

(program controller as shown below)

1. FROM MAIN MENU PRESS '2' (PHASE CONTROL), THEN '1' (PHASE CONTROL FUNCTIONS). SCROLL TO THE BOTTOM OF THE MENU AND ENABLE ACT LOGIC COMMANDS 29, 30, 31 AND 32.
2. FROM MAIN MENU PRESS '6' (OUTPUTS), THEN '3' (LOGICAL I/O PROCESSOR).

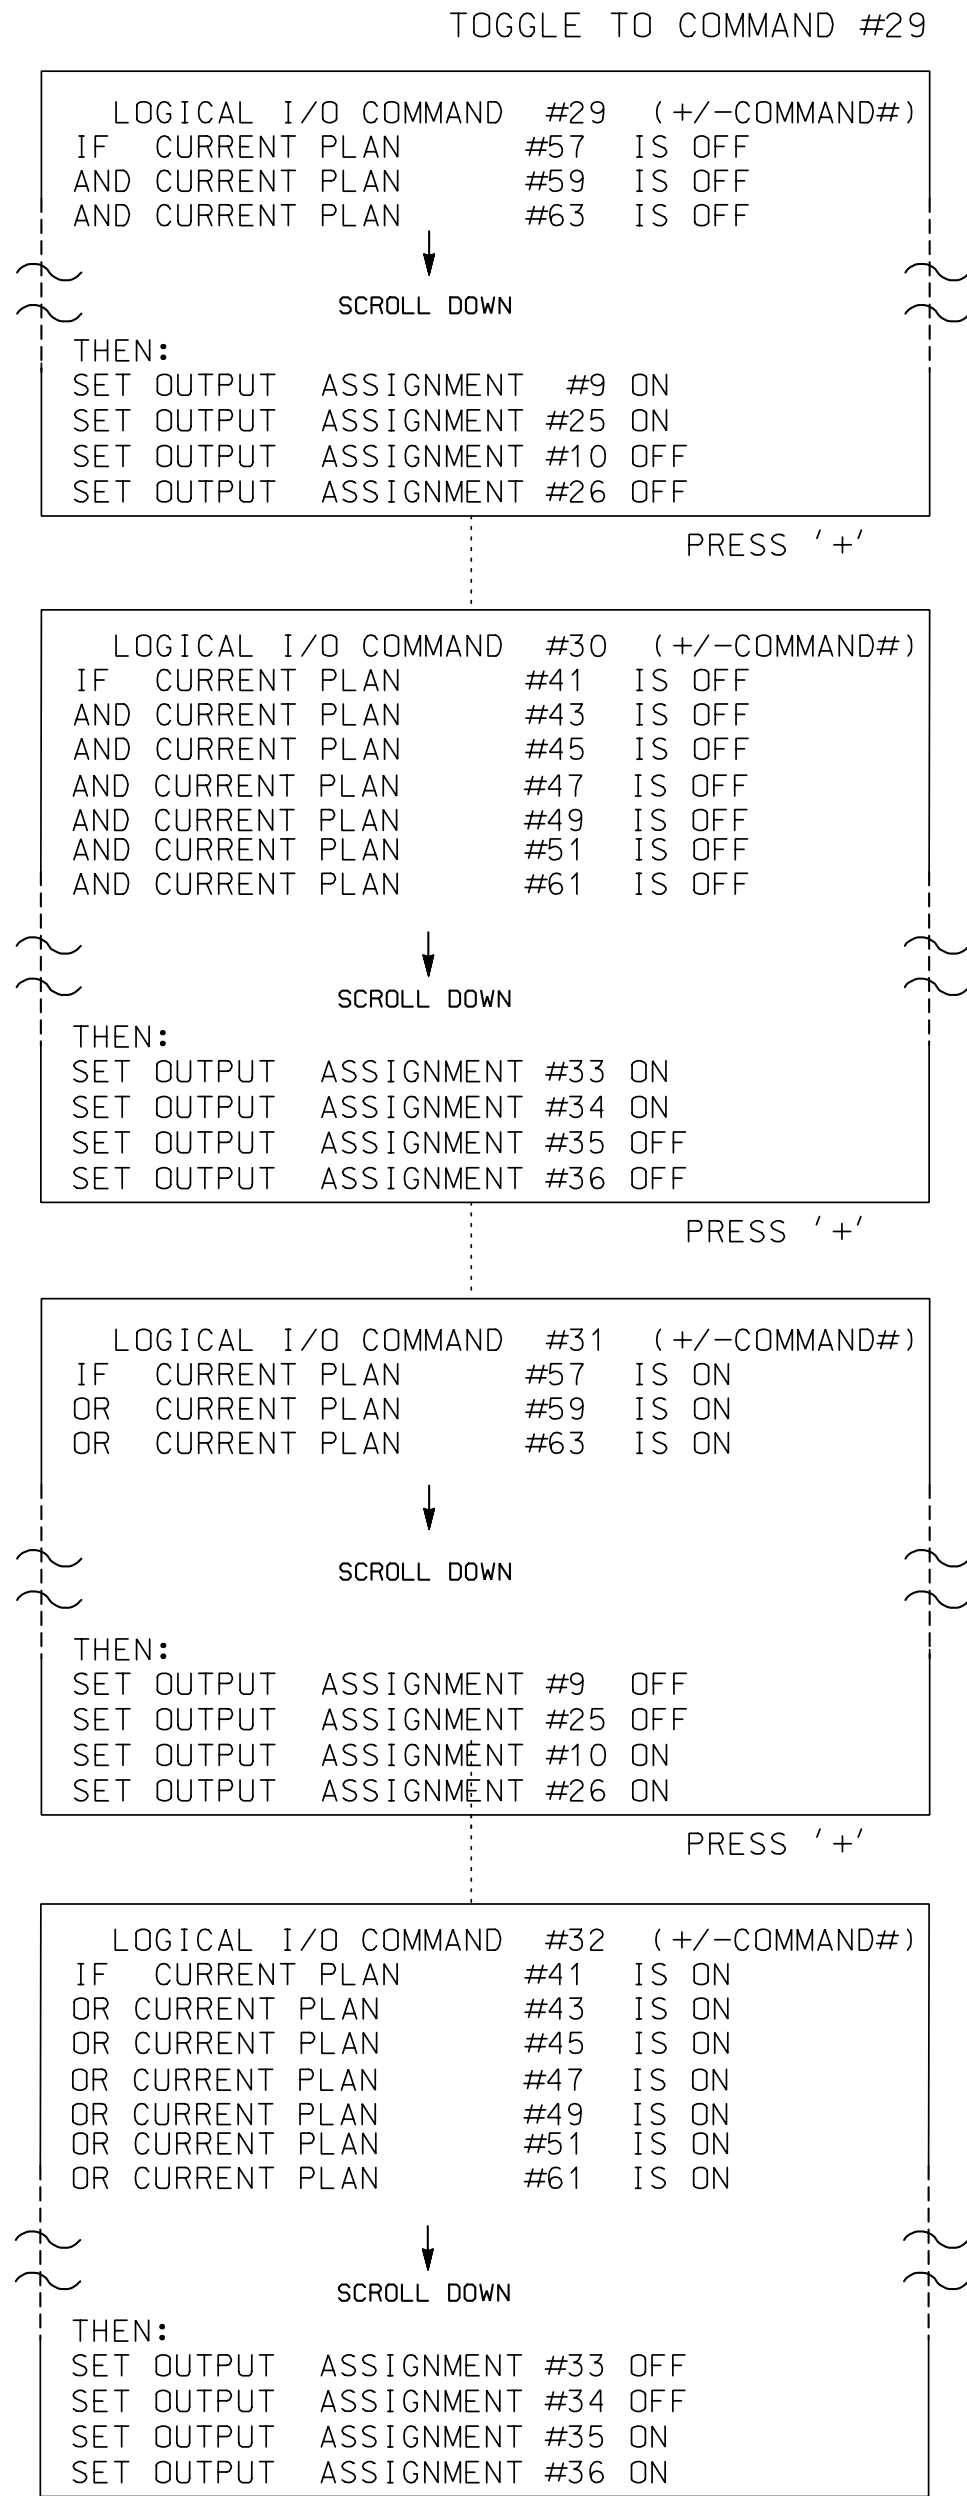

THIS ELECTRICAL DETAIL IS FOR
THE SIGNAL DESIGN: 12-0151
DESIGNED: NOVEMBER 2004
SEALED: 12-10-04
REVISED: 4/16/2019

LOGIC I/O PROCESSOR PROGRAMMING COMPLETE

SIGNAL UPGRADE SHEET 2 OF 2

SEAL
NORTH CAROLINA
PROFESSIONAL
SEAL
032607
ENGINEER
STACIE L. PHILLIPS

DocuSigned by:
SLP
0C87A59ED00B437
4/16/2019
SIGNATURE DATE


ELECTRICAL AND PROGRAMMING
DETAILS FOR:
Prepared in the Offices of:
Transportation Mobility and Safety Division
DEPARTMENT OF TRANSPORTATION
Signal Design Section
750 N. Greenfield Pkwy, Garner, NC 27529

US 29-74 (WILKINSON BOULEVARD)
AT
SR 2329 (MAIN STREET/
REDBUD DRIVE)
DIVISION 12 GASTON COUNTY GASTONIA
PLAN DATE: DECEMBER 2004 REVIEWED BY: T. JOYCE
PREPARED BY: JAMES PETERSON REVIEWED BY:
REVISIONS
▽ INSTALL CHANGEABLE TRAILBLAZER SIGN SLP 4/2019
INIT. DATE
SIGNATURE DATE

DOCUMENT NOT CONSIDERED
FINAL UNLESS ALL
SIGNATURES COMPLETED
SEAL
Not a certified document as
to the Original Document but
Only as to the Revisions -
This document originally
Issued and sealed by
George C. Brown, #022013,
on 12/20/04.
This document is only certified
as to the revisions.
SIGNATURE DATE
SIG. INVENTORY NO. 12-0151

▽ CHANGEABLE TRAILBLAZER SIGN

WIRING AND PROGRAMMING DETAIL

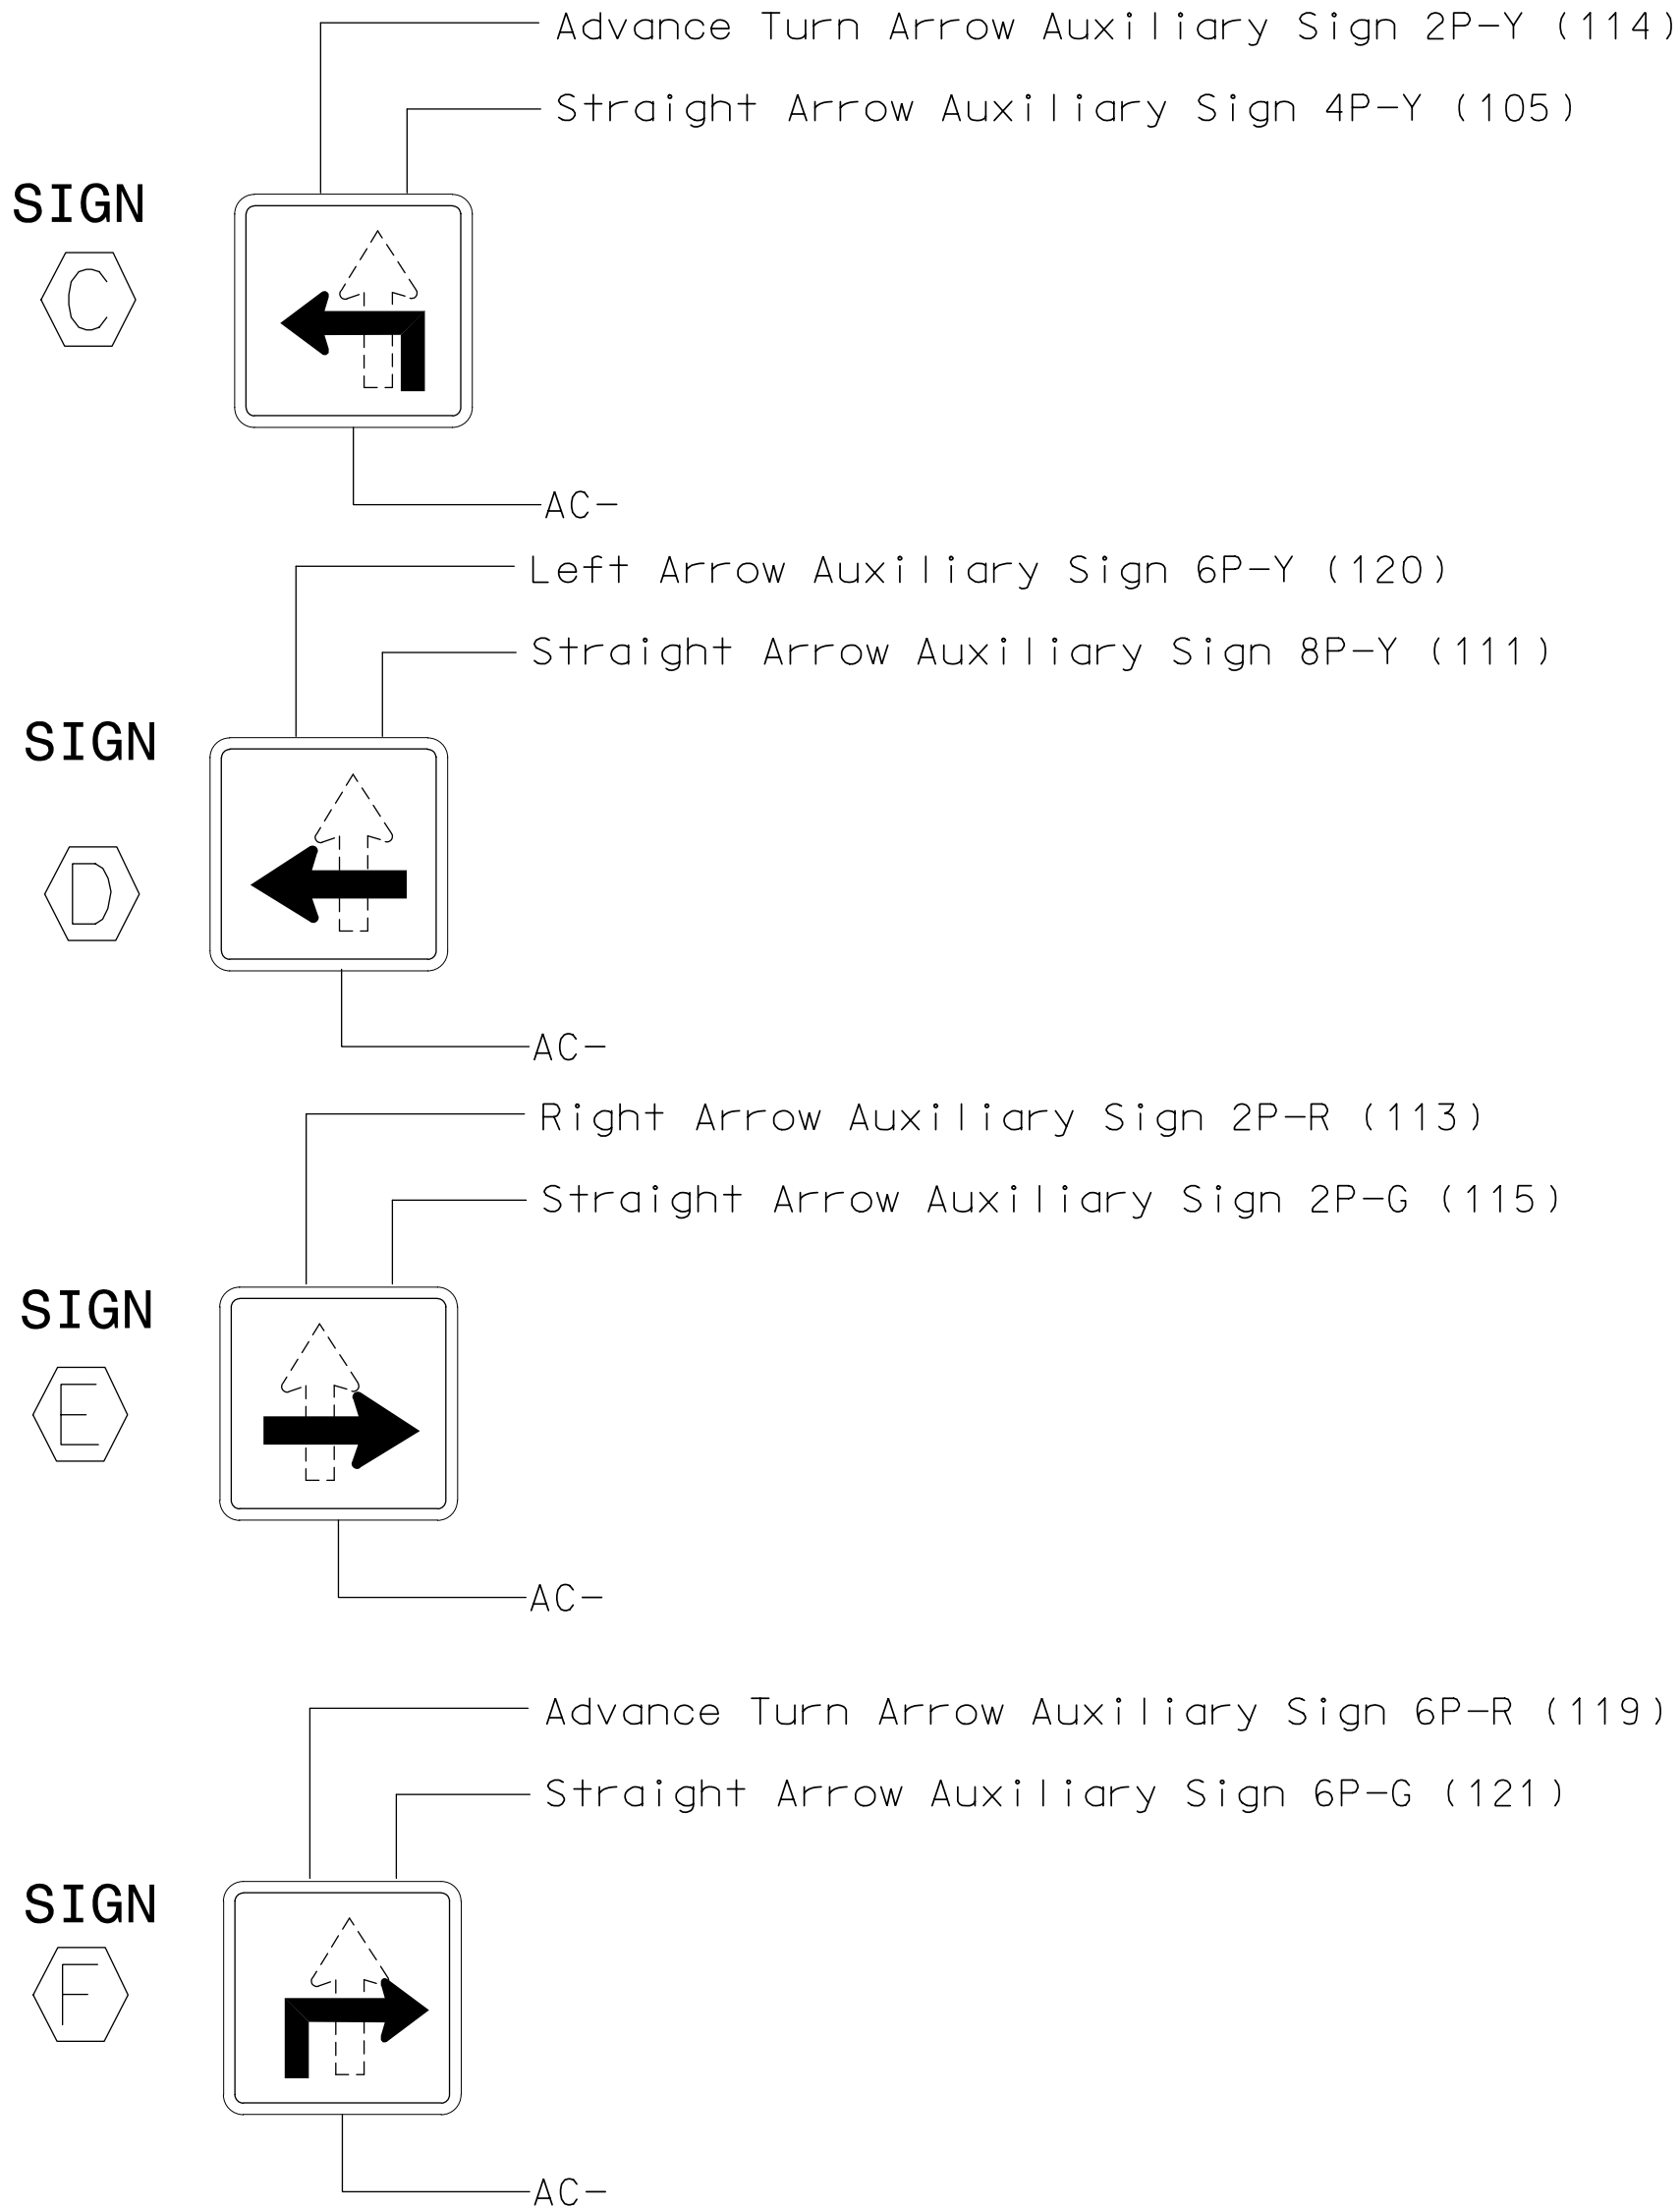

NOTE

Remove, tape, and label conflict monitor wire attached to rear of terminal 2PY(114), 4PY(105), 6PY (120), 8PY (111), 2PR (113), 2PG (115), 6PR (119), 6PG (121).

PLANS PREPARED IN THE OFFICE OF:
Kimley»Horn
NC License #F-0102
421 Fayetteville Street, Suite 600
Raleigh, NC 27601
(919) 671-2000

8 Phase
Fully Actuated
Belmont Signal System

NOTES


- Refer to "Roadway Standard Drawings NCDOT" dated January 2018 and "Standard Specifications for Roads and Structures" dated January 2018.
- Do not program signal for late night flashing operation unless otherwise directed by the Engineer.
- Phase 1 and/or phase 5 may be lagged.
- Phase 3 and/or phase 7 may be lagged.
- In the event of loop replacement, refer to the current ITS and Signals Design Manual and submit a Plan of Record to the Signal Design Section.
- Set all detector units to presence mode.
- Locate new cabinet so as not to obstruct sight distance of vehicles turning right on red.
- Pavement markings are existing.
- Maximum times shown in timing chart are for free-run operation only. Coordinated signal system timing values supersede these values.

SIGNAL FACE	PHASE							
	Ø 1 + 5	Ø 1 + 6	Ø 2 + 5	Ø 2 + 6	Ø 3 + 7	Ø 3 + 8	Ø 4 + 7	Ø 4 + 8
11	←	←	←	←	←	←	←	←
21,22	R	R	G	G	R	R	R	R
31	←	←	←	←	←	←	←	←
41,42	R	R	R	R	R	R	G	G
51	←	←	←	←	←	←	←	←
61,62,63,64	R	G	R	G	R	R	R	R
71	←	←	←	←	←	←	←	←
81,82	R	R	R	R	R	G	R	G
SIGN 'C'	*	*	*	*	*	*	*	OFF
SIGN 'D'	*	*	*	*	*	*	*	OFF

*Changeable Trailblazer Sign controlled remotely


SIGNAL FACE I.D.

All Heads L.E.D.

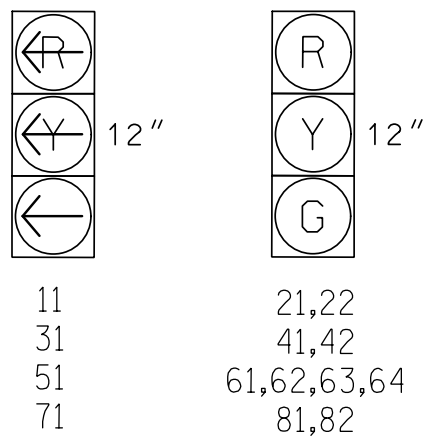

ASC/3 DETECTOR INSTALLATION CHART												
DETECTOR					PROGRAMMING							
LOOP	SIZE (FT)	DISTANCE FROM STOPBAR (FT)	TURNS	NEW LOOP	PHASE	CALLING	EXTEND TIME	DELAY TIME	USE ADDED INITIAL	TYPE	SYSTEM LOOP	NEW CARD
1A	6X40	+5	Exist	-	1	Yes	-	-	-	S	-	X
2A/S1	6X6	400	Exist	-	2	Yes	-	-	X	N	X	X
2B/S2	6X6	400	Exist	-	2	Yes	-	-	X	N	X	X
2C/S3	6X6	400	Exist	-	2	Yes	-	-	X	N	X	X
3A	6X60	+5	Exist	-	3	Yes	-	3	-	S	-	X
4A	6X40	10	Exist	-	4	Yes	-	-	-	S	-	X
4B	6X40	10	Exist	-	4	Yes	-	-	-	S	-	X
5A	6X40	+5	Exist	-	5	Yes	-	-	-	S	-	X
6A/S4	6X6	405	Exist	-	6	Yes	-	-	X	N	X	X
6B/S5	6X6	405	Exist	-	6	Yes	-	-	X	N	X	X
6C/S6	6X6	405	Exist	-	6	Yes	-	-	X	N	X	X
7A	6X40	0	Exist	-	7	Yes	-	3	-	S	-	X
8A	6X60	+5	Exist	-	8	Yes	-	-	-	S	-	X
S55	6X6	190	6	-	No	-	-	-	-	N	X	X
S56	6X6	190	6	-	No	-	-	-	-	N	X	X
S57	6X6	190	6	-	No	-	-	-	-	N	X	X

PHASING DIAGRAM

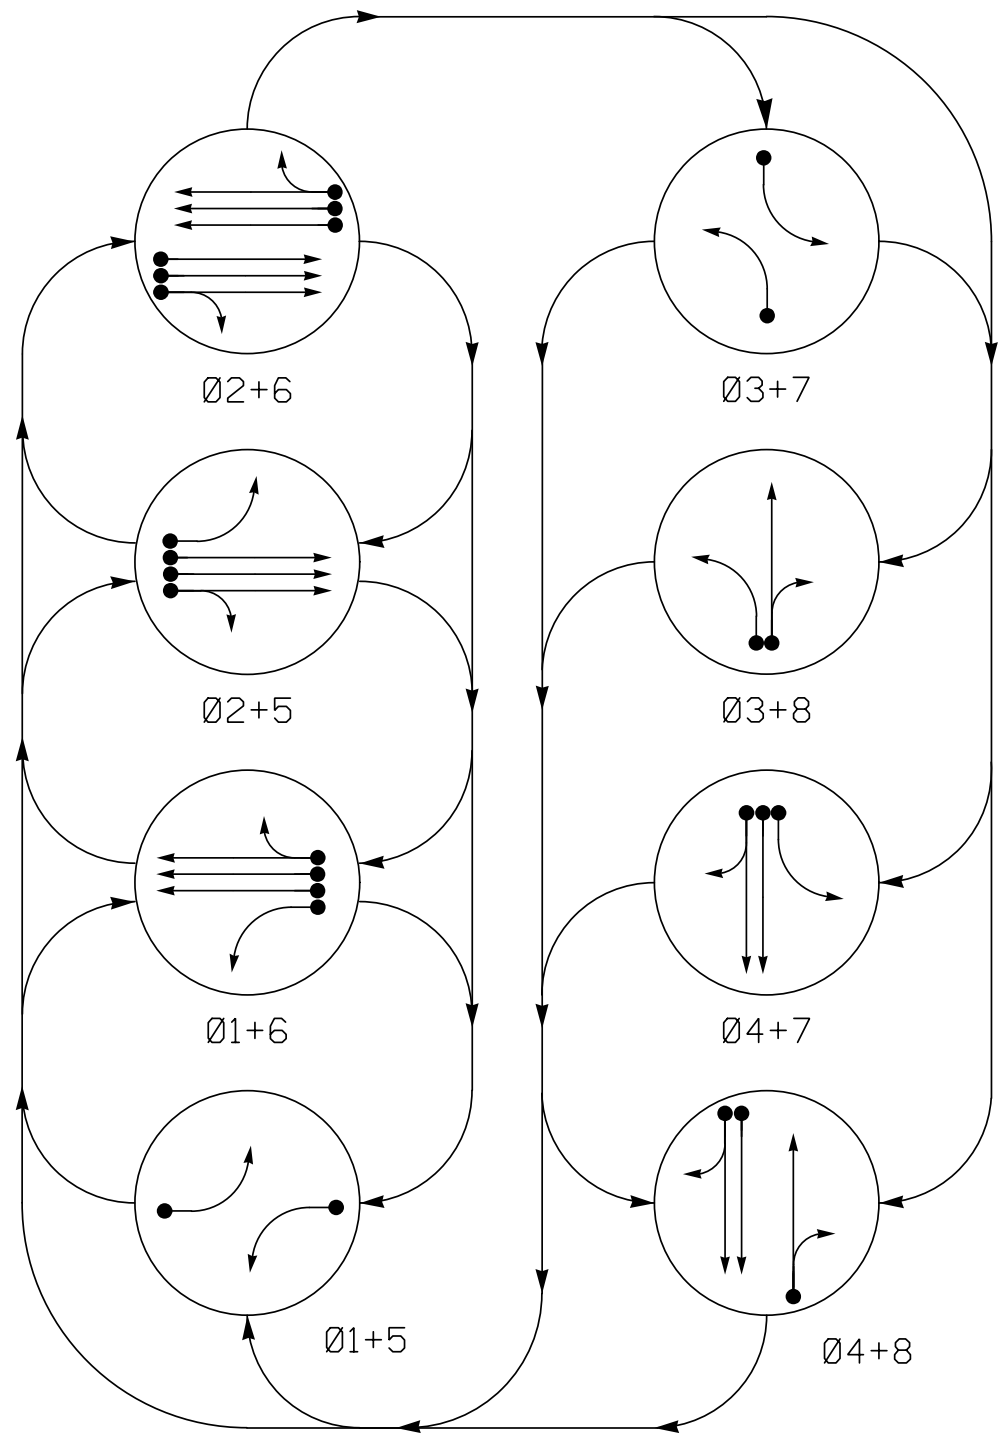

PHASING DIAGRAM DETECTION LEGEND

- DETECTED MOVEMENT
- UNDETECTED MOVEMENT (OVERLAP)
- UNSIGNALIZED MOVEMENT
- PEDESTRIAN MOVEMENT


ASC/3 TIMING CHART

FEATURE	PHASE							
	1	2	3	4	5	6	7	8
Min Green *	7	14	7	7	7	14	7	7
Walk *	0	0	0	0	0	0	0	0
Ped Clear	0	0	0	0	0	0	0	0
Veh. Extension *	2.0	6.0	1.0	2.0	2.0	6.0	2.0	1.0
Max I *	25	90	25	45	25	90	25	45
Yellow	3.0	4.6	3.0	3.8	3.0	4.5	3.0	3.8
Red Clear	2.6	1.0	2.4	2.0	2.8	1.1	2.9	1.9
Actuations B4 Add *	-	0	-	-	-	0	-	-
Seconds /Actuation *	-	1.5	-	-	-	1.5	-	-
Max Initial *	-	44	-	-	-	44	-	-
Time Before Reduction *	-	15	-	-	-	15	-	-
Time To Reduce *	-	45	-	-	-	45	-	-
Minimum Gap	-	3.8	-	-	-	3.8	-	-
Locking Detector	-	X	-	-	-	X	-	-
Recall Position	-	VEH. RECALL	-	-	-	VEH. RECALL	-	-
Dual Entry	-	-	-	-	-	-	-	-
Simultaneous Gap	X	X	X	X	X	X	X	X

* These values may be field adjusted. Do not adjust Min Green and Extension times for phases 2 and 6 lower than what is shown. Min Green for all other phases should not be lower than 4 seconds.

FIGURE 1

Type 2A, 2B - Changeable Trailblazer Sign

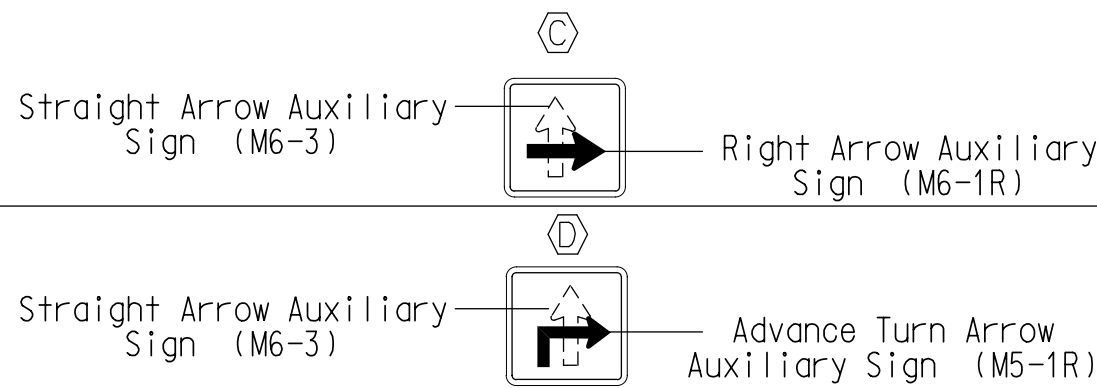



LEGEND

- | PROPOSED | EXISTING |
|--|--|
| Traffic Signal Head | Modified Signal Head |
| Pedestrian Signal Head With Push Button & Sign | Signal Pole with Guy |
| Signal Pole with Sidewalk Guy | Inductive Loop Detector |
| Controller & Cabinet | Junction Box |
| 2-in Underground Conduit | Right of Way |
| Directional Arrow | Railroad Tracks |
| "NO TURN ON RED" Sign (R10-11) | Street Name Sign |
| Type 2A Changeable Trailblazer sign (See Figure 1) | Type 2B Changeable Trailblazer sign (See Figure 1) |

Signal Upgrade

DOCUMENT NOT CONSIDERED FINAL
UNLESS ALL SIGNATURES COMPLETED

PLANS PREPARED IN THE OFFICE OF:
Kimley»Horn
NC License #F-0102
421 Fayetteville Street, Suite 600
Raleigh, NC 27601
(919) 677-2000

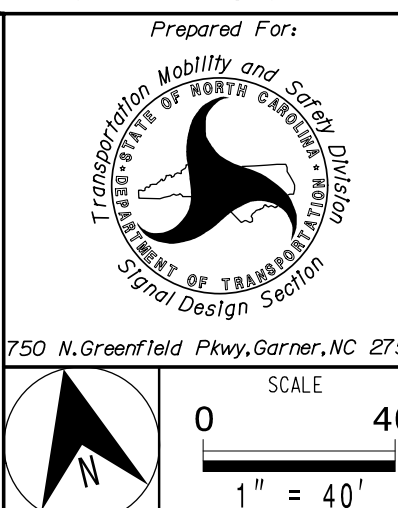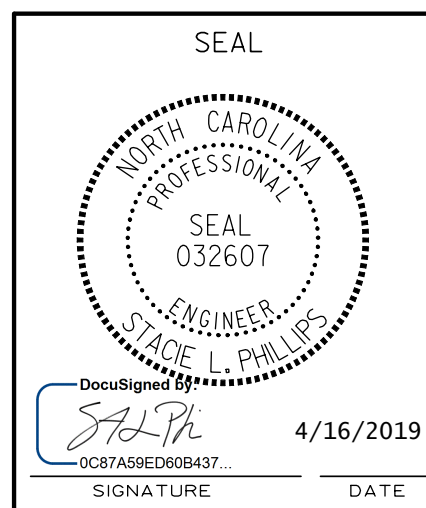

US 29-74 (Wilkinson Boulevard)
at
NC 7 (North Main Street)


Division 12 Gaston County Belmont
PLAN DATE: December 2018 REVIEWED BY: E. Sirgany
PREPARED BY: M. Parker REVIEWED BY:

REVISIONS
INSTALL CHANGEABLE TRAILBLAZER SIGN
DATE: 4/2019

SEAL
Not a certified document.
This document originally
Issued and sealed by
Edward W. Sirgany, PE #018174
on February 7, 2019.
This document shall not be
considered a certified
document.
DATE
SIG. INVENTORY NO. 12-0561

EDI MODEL 2018EClip-NC CONFLICT MONITOR
PROGRAMMING DETAIL

(remove jumpers and set switches as shown)

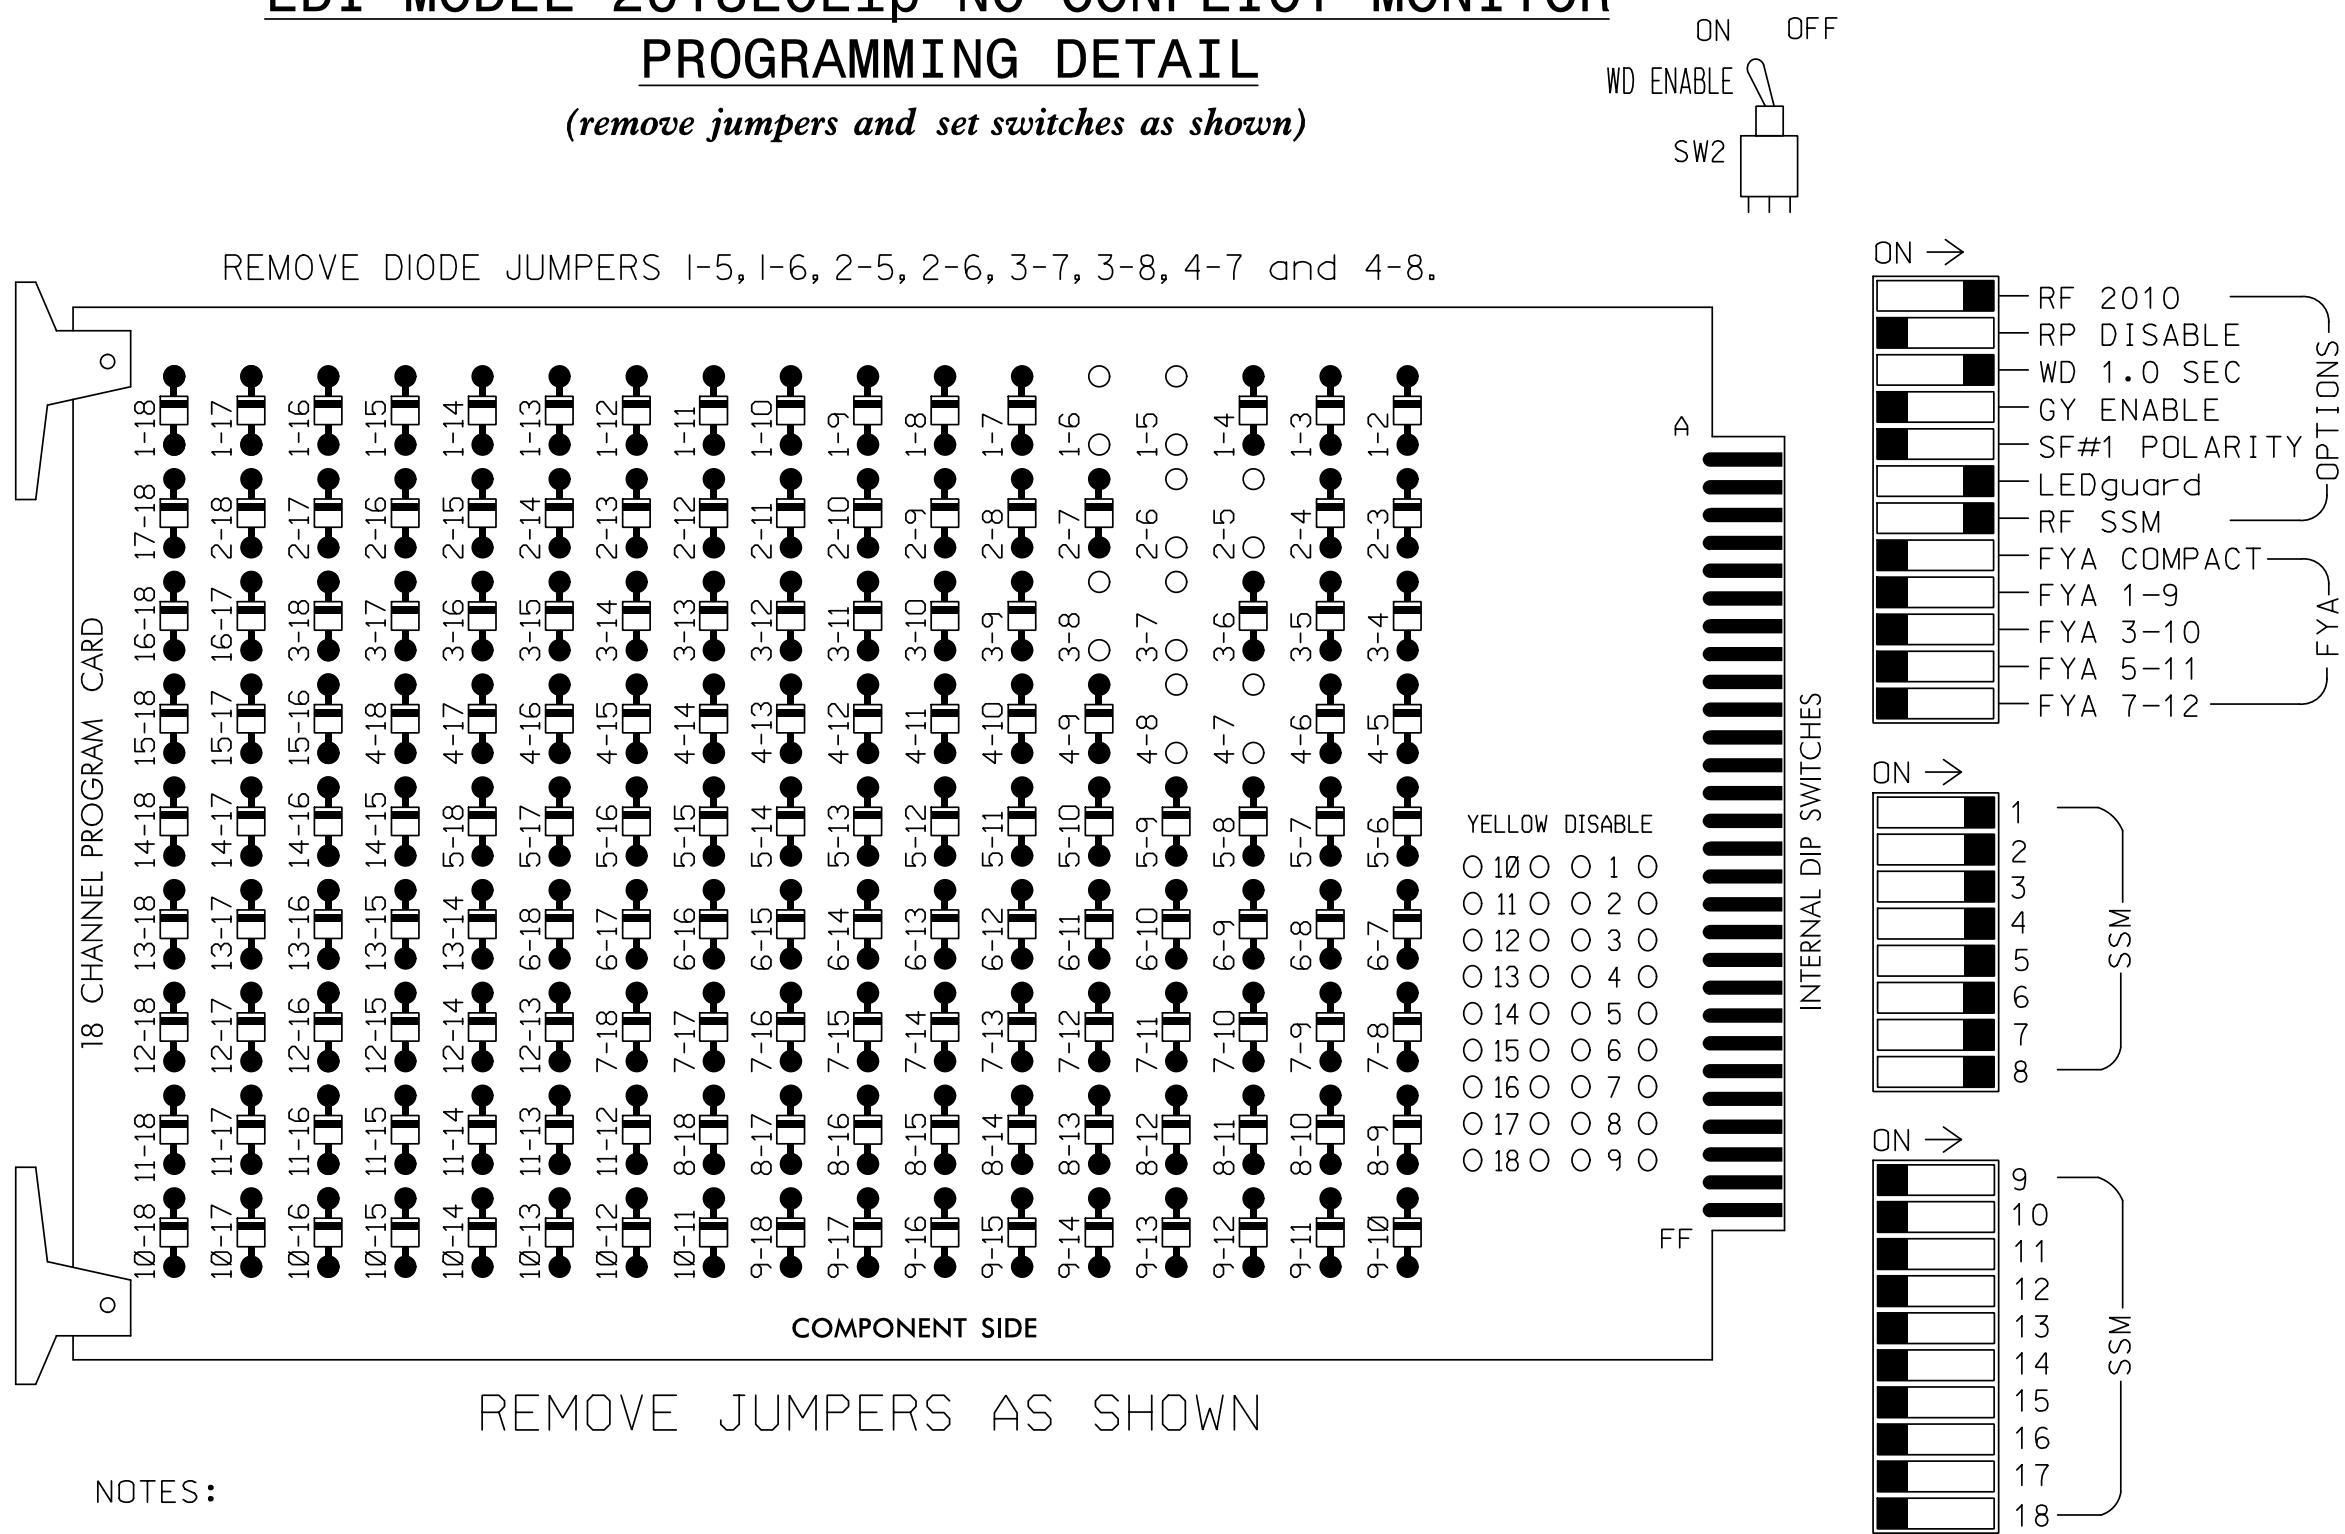

NOTES:

- Card is provided with all diode jumpers in place. Removal of any jumper allows its channels to run concurrently.
- Ensure jumpers SEL2-SEL5 and SEL9 are present on the monitor board.
- Ensure that Red Enable is active at all times during normal operation.
- Integrate monitor with Ethernet network in cabinet.

NOTES

- To prevent "flash-conflict" problems, insert red flash program blocks for all unused vehicle load switches in the output file. The installer shall verify that signal heads flash in accordance with the Signal Plans.
- Program controller to start up in phase 2 Green and 6 Green.
- The cabinet and controller are part of the Belmont Signal System.

EQUIPMENT INFORMATION

CONTROLLER.....2070LX
CABINET.....332 W/ AUX
SOFTWARE.....ECONOLITE ASC/3-2070
CABINET MOUNT.....BASE
OUTPUT FILE POSITIONS...18 WITH AUX. OUTPUT FILE
LOAD SWITCHES USED.....S1,S2,S4,S5,S7,S8,S10,S11
PHASES USED.....1,2,3,4,5,6,7,8
OVERLAPS.....NONE

INPUT FILE POSITION LAYOUT

(front view)

FILE U	1	2	3	4	5	6	7	8	9	10	11	12	13	14
"I"	Ø 1 1A	Ø 2/SYS 2A/S1	Ø 2/SYS 2C/S3	Ø 3 3A	Ø 4 4A	Ø 5 5A	Ø 6 6A	Ø 7 7A	Ø 8 8A	Ø 9 9A	Ø 10 10A	Ø 11 11A	Ø 12 12A	Ø 13 13A
L	NOT USED	Ø 2/SYS 2B/S2	NOT USED	NOT USED	Ø 4 4B	NOT USED	NOT USED	NOT USED	NOT USED	NOT USED	NOT USED	NOT USED	NOT USED	NOT USED

EX. : 1A, 2A, ETC. = LOOP NO.'S


FS = FLASH SENSE
ST = STOP TIME

INPUT FILE CONNECTION & PROGRAMMING CHART

LOOP NO.	LOOP TERMINAL	INPUT FILE POS.	PIN NO.	DETECTOR NO.	NEMA PHASE	CALL	EXTEND TIME	DELAY TIME	ADDED INITIAL	DETECTOR TYPE
1A	TB2-1,2	I1U	56	1	1	YES				S
2A/S1	TB2-5,6	I2U	39	2	2/SYS	YES			X	N
2B/S2	TB2-7,8	I2L	43	12	2/SYS	YES			X	N
2C/S3	TB2-9,10	I3U	63	32	2/SYS	YES			X	N
3A	TB4-5,6	I5U	58	3	3	YES		3		S
4A	TB4-9,10	I6U	41	4	4	YES				S
4B	TB4-11,12	I6L	45	14	4	YES				S
*S55	TB6-9,10	I9U	60	11	SYS	NO				N
*S56	TB6-11,12	I9L	62	13	SYS	NO				N
5A	TB3-1,2	J1U	55	5	5	YES				S
6A/S4	TB3-5,6	J2U	40	6	6/SYS	YES			X	N
6B/S5	TB3-7,8	J2L	44	16	6/SYS	YES			X	N
6C/S6	TB3-9,10	J3U	64	36	6/SYS	YES			X	N
7A	TB5-5,6	J5U	57	7	7	YES		3		S
8A	TB5-9,10	J6U	42	8	8	YES				S
*S57	TB7-9,10	J9U	59	15	SYS	NO				N

* System detector only. Remove any assigned vehicle phase.

 INPUT FILE POSITION LEGEND: J2L




SIGNAL HEAD HOOK-UP CHART

LOAD SWITCH NO.	S1	S2	S3	S4	S5	S6	S7	S8	S9	S10	S11	S12	AUX S1	AUX S2	AUX S3	AUX S4	AUX S5	AUX S6
CMU CHANNEL NO.	1	2	13	3	4	14	5	6	15	7	8	16	9	10	17	11	12	18
PHASE	1	2	2 PED	3	4	4 PED	5	6	6 PED	7	8	8 PED	OLA	OLB	SPARE	OLC	OLD	SPARE
SIGNAL HEAD NO.	11	21,22	SIGN C	31	41,42	SIGN C	51	61,62, 63,64	SIGN D	71	81,82	SIGN D	NU	NU	NU	NU	NU	NU
RED		128			101			134			107							
YELLOW		129			102			135			108							
GREEN		130			103			136			109							
RED ARROW	125			116			131			122								
YELLOW ARROW	126			117			132			123								
GREEN ARROW	127			118			133			124								
PED YELLOW			** 114			** 105			** 120		** 111							

NU = Not Used

** Changeable Trailblazer Signs. See wiring and programming detail on this sheet.

CHANGEABLE TRAILBLAZER SIGN
WIRING AND PROGRAMMING DETAIL

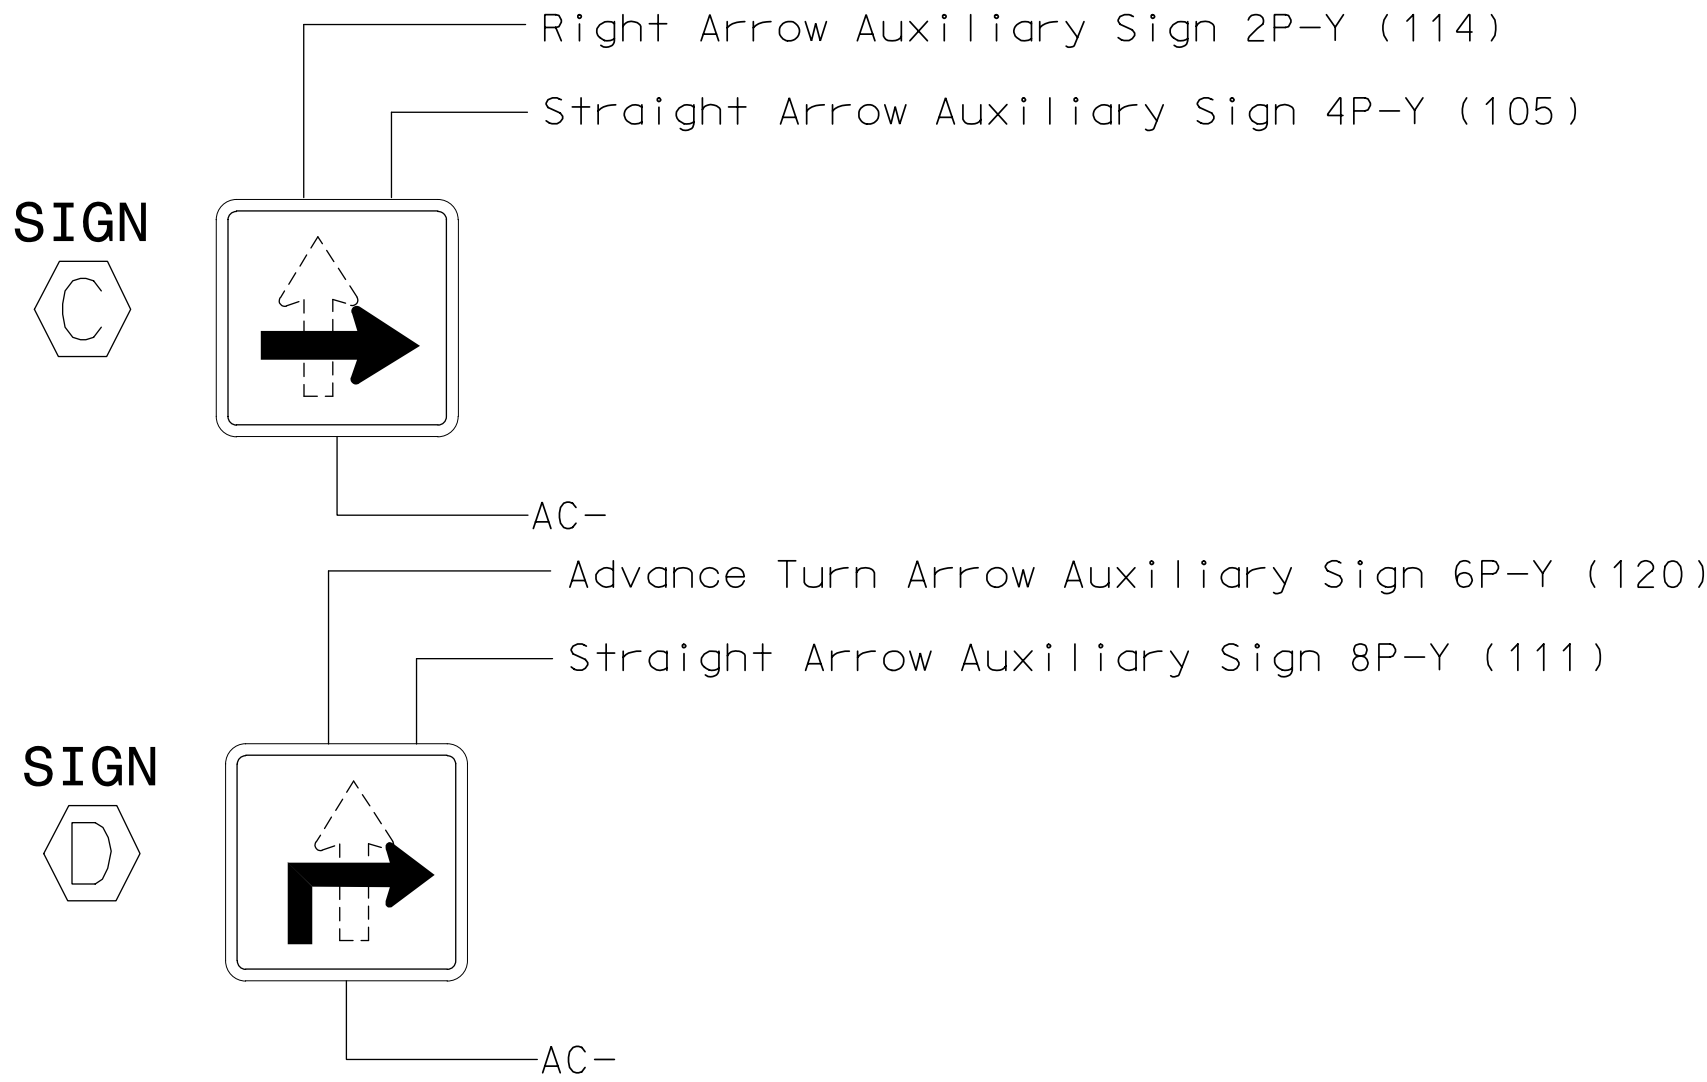


NOTE

Remove, tape, and label conflict monitor wire attached to rear of terminal 2PY(114), 4PY(105), 6PY (120), 8PY (111)

Electrical Detai Sheet 1 of 2

DOCUMENT NOT CONSIDERED
FINAL UNLESS ALL
SIGNATURES COMPLETED

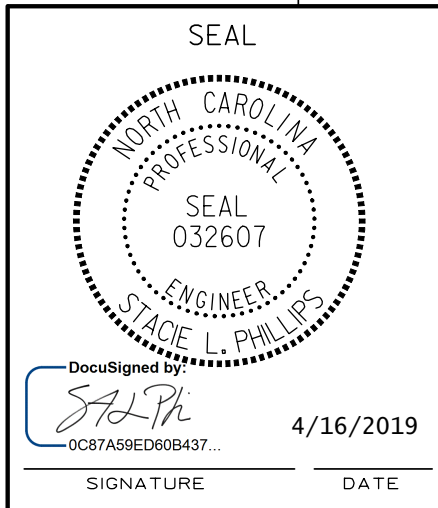

US 29-74 (Wilkinson Boulevard)
at
NC 7 (North Main Street)

Division 12 Gaston County Belmont

PLAN DATE: December 2018 REVIEWED BY:

PREPARED BY: J. Smith REVIEWED BY: E. Sirgany

REVISIONS INIT. DATE

INSTALL CHANGEABLE TRAILBLAZER SIGN SLP 4/2019

SEAL
Not a certified document.
This document originally
issued and sealed by
Edward W. Sirgany, PE #018174
on February 7, 2019.
This document shall not be
considered a certified
document.
DATE
SIG. INVENTORY NO. 12-0561

\$\$\$\$\$SYSTIME\$\$\$\$\$
\$\$\$\$\$DATE\$\$\$\$\$
\$\$\$\$\$TIME\$\$\$\$\$

ECONOLITE ASC/3-2070 LOGIC PROCESSOR PROGRAMMING DETAIL

FOR TRAILBLAZER SIGN(S)

(program controller as shown)

The following logic processor configuration sets sign(s) to the appropriate display by utilizing pedestrian load switches.

1. From Main Menu select 1. CONFIGURATION
2. From CONFIGURATION Submenu select 8. LOGIC PROCESSOR
3. From LOGIC PROCESSOR Submenu select 2. LOGIC STATEMENTS

ENTER A "32" IN THE LP# FIELD, PRESS 'ENTER', AND PROGRAM AS SHOWN.

LP#:	32	COPY FROM:	32	ACTIVE:	M	(T/F)
IF	COORD PLAN			IS	55	
OR	COORD PLAN			IS	57	
OR	COORD PLAN			IS	59	
OR	COORD PLAN			IS	63	
THEN	SIG SET PH PED CLR	4		ON		
	SIG SET PH PED CLR	8		ON		
	SIG SET PH PED CLR	2		OFF		
	SIG SET PH PED CLR	6		OFF		
ELSE	SIG SET PH PED CLR	4		OFF		
	SIG SET PH PED CLR	8		OFF		
	SIG SET PH PED CLR	2		ON		
	SIG SET PH PED CLR	6		ON		

4. From the LOGIC PROCESSOR Submenu select 1. LOGIC STATEMENT CONTROL



ENABLE LOGIC PROCESSOR STATEMENT 32 BY POSITIONING THE CURSOR OVER THE FIELD SHOWN BELOW AND USING THE TOGGLE KEY TO ENABLE IT.

LOGIC STATEMENT CONTROL																
	1	2	3	4	5	6	7	8	9	0	1	2	3	4	5	
LP 1-15	.	.	.	.	.	.	.	.	.	.	.	.	.	.	.	.
LP 16-30	.	.	.	.	.	.	.	.	.	.	.	.	.	.	.	.
LP 31-45	.	E	.	.	.	.	.	.	.	.	.	.	.	.	.	.
LP 46-60	.	.	.	.	.	.	.	.	.	.	.	.	.	.	.	.
LP 61-75	.	.	.	.	.	.	.	.	.	.	.	.	.	.	.	.
LP 76-90	.	.	.	.	.	.	.	.	.	.	.	.	.	.	.	.

END PROGRAMMING

THIS ELECTRICAL DETAIL IS FOR
THE SIGNAL DESIGN: 12-0561
DESIGNED: December 2018
SEALED: February 7, 2019
REVISED: 4/16/2019

PLANS PREPARED IN THE OFFICE OF:
Kimley»Horn
NC License #F-0102
421 Fayetteville Street, Suite 600
Raleigh, NC 27601
(919) 677-2000

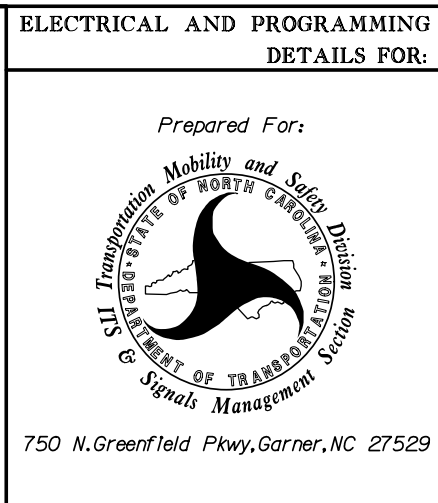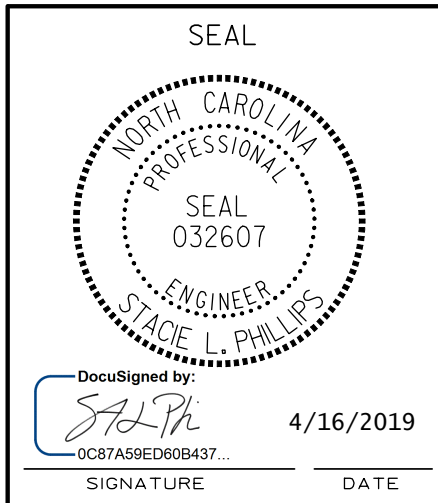

ELECTRICAL AND PROGRAMMING DETAILS FOR:				US 29-74 (Wilkinson Boulevard) at NC 7 (North Main Street)			
Division 12		Gaston County		Belmont			
PLAN DATE: December 2018		REVIEWED BY:					
PREPARED BY: J. Smith		REVIEWED BY: E. Sirgany					
REVISIONS		INIT.		DATE			
V INSTALL CHANGEABLE TRAILBLAZER SIGN		SLP		4/2019			

8 Phase Fully Actuated Belmont Signal System

NOTES

- Refer to "Roadway Standard Drawings NCDOT" dated January 2018 and "Standard Specifications for Roads and Structures" dated January 2018.
- Do not program signal for late night flashing operation unless otherwise directed by the Engineer.
- Phase 1 and/or phase 5 may be lagged.
- Phase 3 and/or phase 7 may be lagged.
- Set all detector units to presence mode.
- In the event of loop replacement, refer to the current ITS and Signals Design Manual and submit a Plan of Record to the Signal Design Section.
- Locate new cabinet so as not to obstruct sight distance of vehicles turning right on red.
- Pavement markings are existing.
- Maximum times shown in timing chart are for free-run operation only. Coordinated signal system timing values supersede these values.


ASC/3 DETECTOR INSTALLATION CHART												
DETECTOR				PROGRAMMING								
LOOP	SIZE (FT)	DISTANCE FROM STOPBAR (FT)	TURNS	NEW LOOP	PHASE	CALLING	EXTEND TIME	DELAY TIME	USE ADDED INITIAL	TYPE	SYSTEM LOOP	NEW CARD
1A	6X60	0	Exist	-	1	Yes	-	-	-	S	-	X
2A/S19	6X6	405	Exist	-	2	Yes	-	-	X	N	X	X
2B/S20	6X6	405	Exist	-	2	Yes	-	-	X	N	X	X
2C/S21	6X6	405	Exist	-	2	Yes	-	-	X	N	X	X
3A	6X60	+5	Exist	-	3	Yes	-	-	-	S	-	X
4A/S27	6X6	300	Exist	-	4	No	3.1	-	-	N	X	X
4B/S28	6X6	300	Exist	-	4	No	3.1	-	-	N	X	X
4C	6X60	+5	Exist	-	4	Yes	-	-	-	S	-	X
4D	6X60	+5	Exist	-	4	Yes	-	3	-	S	-	X
5A	6X60	0	Exist	-	5	Yes	-	-	-	S	-	X
6A/S22	6X6	405	Exist	-	6	Yes	-	-	X	N	X	X
6B/S23	6X6	405	Exist	-	6	Yes	-	-	X	N	X	X
6C/S24	6X6	405	Exist	-	6	Yes	-	-	X	N	X	X
7A	6X60	+5	Exist	-	7	Yes	-	3	-	S	-	X
8A/S25	6X6	300	6	-	8	No	3.1	-	-	N	X	X
8B/S26	6X6	300	6	-	8	No	3.1	-	-	N	X	X
8C	6X60	+5	Exist	-	8	Yes	-	-	-	S	-	X
8D	6X60	+5	Exist	-	8	Yes	-	10	-	S	-	X
8E	6X20	0	2-4-2	-	8	Yes	-	10	-	S	-	X
S50	6X6	+180	6	-	-	No	-	-	-	N	X	X
S51	6X6	+180	6	-	-	No	-	-	-	N	X	X
S52	6X6	+200	6	-	-	No	-	-	-	N	X	X
S53	6X6	+200	6	-	-	No	-	-	-	N	X	X
S54	6X6	+200	6	-	-	No	-	-	-	N	X	X

TABLE OF OPERATION												
SIGNAL FACE	PHASE								F	H	L	E
	Ø 1 + 5	Ø 1 + 6	Ø 2 + 5	Ø 2 + 6	Ø 3 + 7	Ø 3 + 8	Ø 4 + 7	Ø 4 + 8				
11	←	←	←	←	←	←	←	←	←	←	←	←
21,22,23	R	R	G	G	R	R	R	R	Y			
41,42	R	R	R	R	←	←	R	G	G	R		
51	←	←	←	←	←	←	←	←	←	←	←	←
61,62,63	R	G	R	G	R	R	R	R	Y			
71	←	←	←	←	←	←	←	←	←	←	←	←
81,82	R	R	R	R	R	G	R	G	R			
SIGN 'C'	*	*	*	*	*	*	*	*	OFF			
SIGN 'D'	*	*	*	*	*	*	*	*	OFF			
SIGN 'E'	*	*	*	*	*	*	*	*	OFF			
SIGN 'F'	*	*	*	*	*	*	*	*	OFF			


*Changeable Trailblazer Sign controlled remotely

SIGNAL FACE I.D.

All Heads L.E.D.

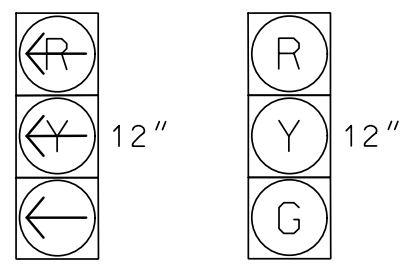


11 31 51 71 21,22,23 41,42 61,62,63 81,82

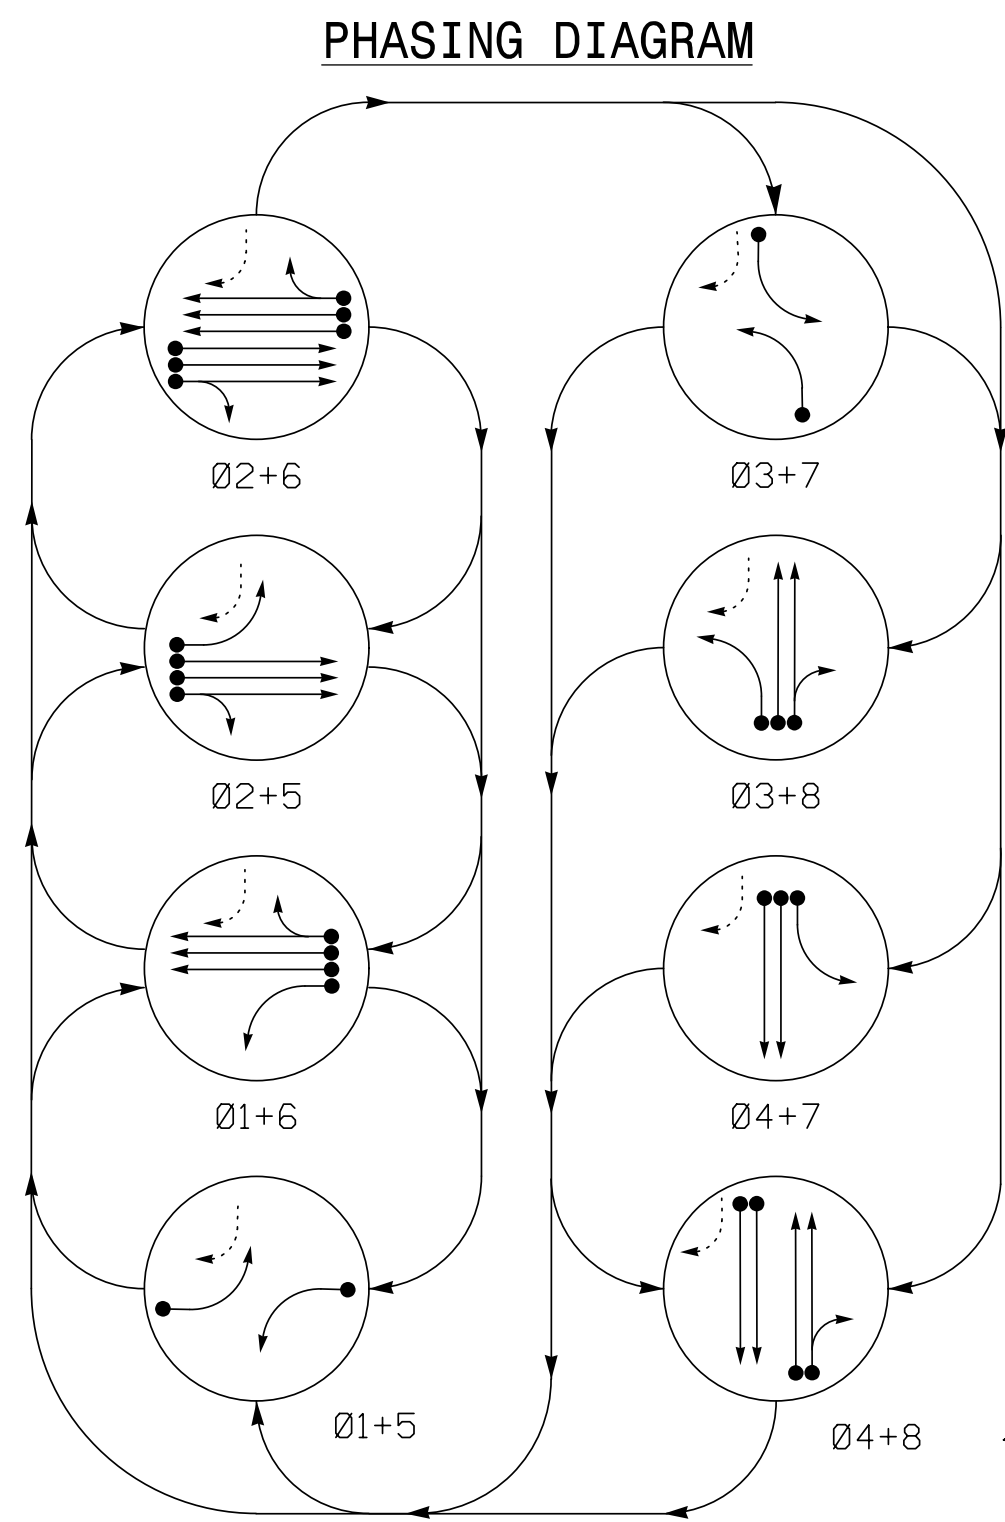

PHASING DIAGRAM DETECTION LEGEND

- DETECTED MOVEMENT
- UNDETECTED MOVEMENT (OVERLAP)
- UNSIGNALIZED MOVEMENT
- PEDESTRIAN MOVEMENT

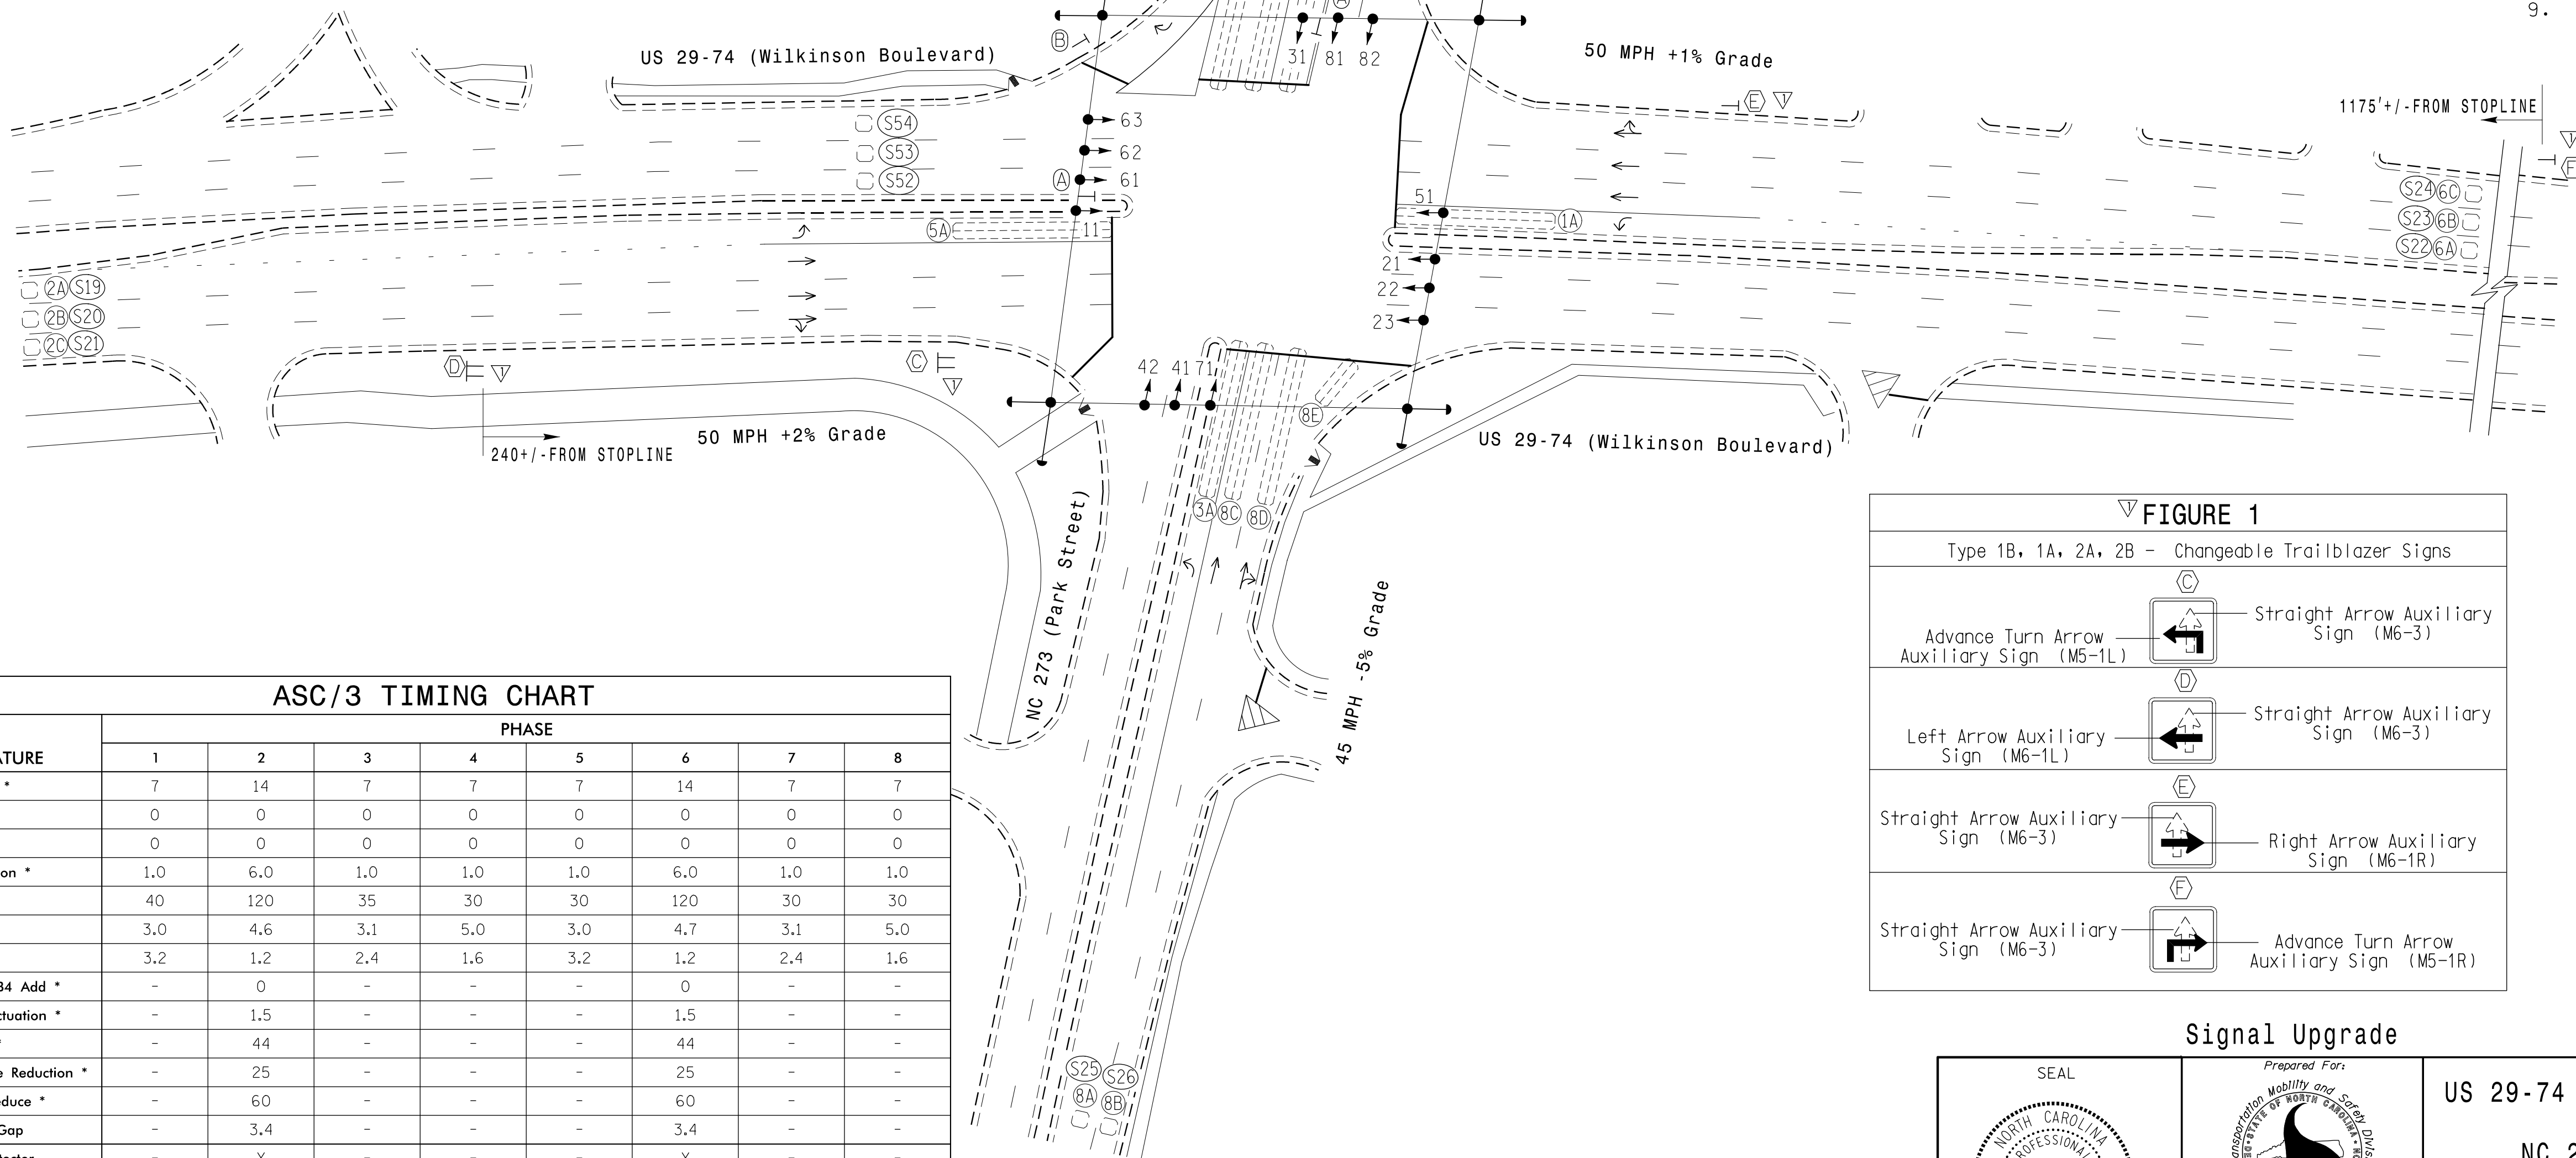


LEGEND

- | PROPOSED | EXISTING |
|--|----------|
| Traffic Signal Head | N/A |
| Modified Signal Head | N/A |
| Signal Pole with Guy | N/A |
| Signal Pole with Sidewalk Guy | N/A |
| Inductive Loop Detector | N/A |
| Controller & Cabinet | N/A |
| Junction Box | N/A |
| 2-in Underground Conduit | N/A |
| Right of Way | N/A |
| Directional Arrow | N/A |
| Curb Ramp | N/A |
| Street Name Sign | N/A |
| "YIELD" Sign (R1-2) | N/A |
| Type 1B Changeable Trailblazer sign (See Figure 1) | N/A |
| Type 1A Changeable Trailblazer sign (See Figure 1) | N/A |
| Type 2A Changeable Trailblazer sign (See Figure 1) | N/A |
| Type 2B Changeable Trailblazer sign (See Figure 1) | N/A |

FIGURE 1

Type 1B, 1A, 2A, 2B - Changeable Trailblazer Signs

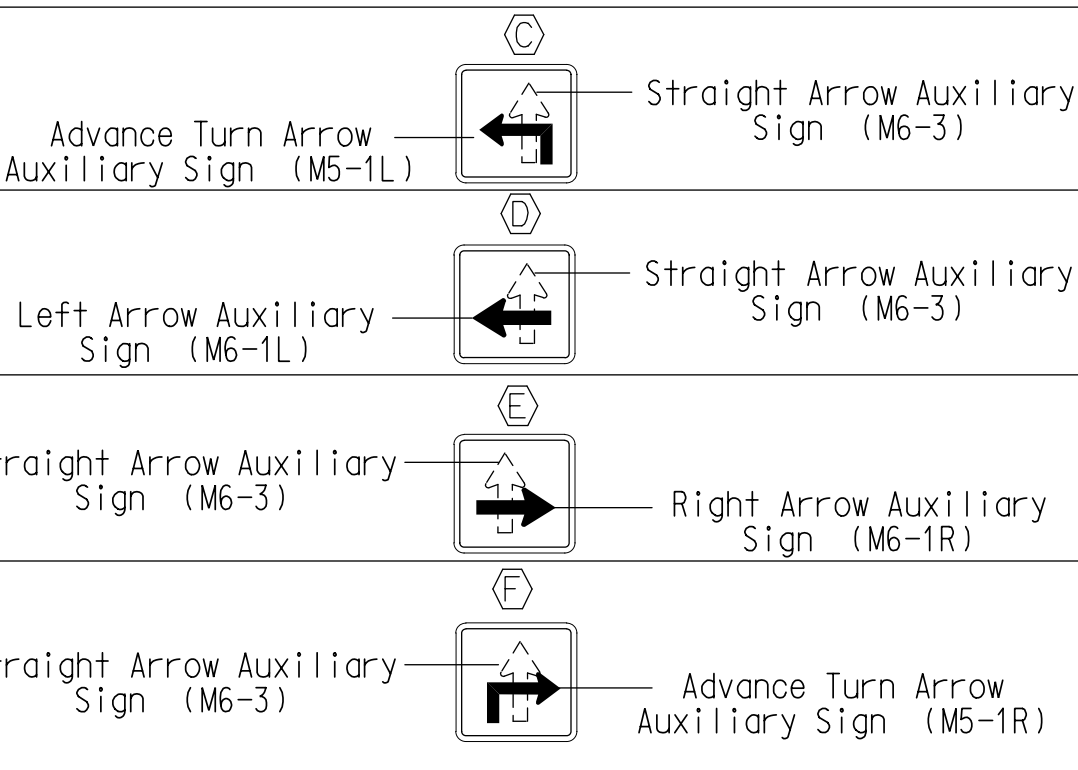

Signal Upgrade

DOCUMENT NOT CONSIDERED FINAL UNLESS ALL SIGNATURES COMPLETED

SEAL NORTH CAROLINA PROFESSIONAL ENGINEER SEAL 032607 SAUL L. PHILLIPS 4/16/2019	Prepared For Transportation Mobility and Safety Division DEPARTMENT OF TRANSPORTATION Signal Design Section 750 N. Greenfield Pkwy, Garner, NC 27529	US 29-74 (Wilkinson Boulevard) at NC 273 (Park Street) Division 12 Gaston County Belmont PLAN DATE: October 2018 REVIEWED BY: E. Sirgany PREPARED BY: J. Smith REVIEWED BY: REVISIONS INSTALL CHANGEABLE TRAILBLAZER SIGN SLP 4/2019	SEAL Not a certified document. This document originally Issued and sealed by Edward W. Sirgany, PE #018174 on February 7, 2019. This document shall not be considered a certified document. DATE SIG. INVENTORY NO. 12-0562
--	--	---	--

PLANS PREPARED IN THE OFFICE OF:
Kimley»Horn
NC License #F-0102
421 Fayetteville Street, Suite 600
Raleigh, NC 27601
(919) 677-2000

ASC/3 TIMING CHART								
FEATURE	PHASE							
	1	2	3	4	5	6	7	8
Min Green *	7	14	7	7	7	14	7	7
Walk *	0	0	0	0	0	0	0	0
Ped Clear	0	0	0	0	0	0	0	0
Veh. Extension *	1.0	6.0	1.0	1.0	1.0	6.0	1.0	1.0
Max 1 *	40	120	35	30	30	120	30	30
Yellow	3.0	4.6	3.1	5.0	3.0	4.7	3.1	5.0
Red Clear	3.2	1.2	2.4	1.6	3.2	1.2	2.4	1.6
Actuations B4 Add *	-	0	-	-	-	0	-	-
Seconds / Actuation *	-	1.5	-	-	-	1.5	-	-
Max Initial *	-	44	-	-	-	44	-	-
Time Before Reduction *	-	25	-	-	-	25	-	-
Time To Reduce *	-	60	-	-	-	60	-	-
Minimum Gap	-	3.4	-	-	-	3.4	-	-
Locking Detector	-	X	-	-	-	X	-	-
Recall Position	-	VEH. RECALL	-	-	-	VEH. RECALL	-	-
Dual Entry	-	-	-	-	-	-	-	-
Simultaneous Gap	X	X	X	X	X	X	X	X

* These values may be field adjusted. Do not adjust Min Green and Extension times for phases 2 and 6 lower than what is shown. Min Green for all other phases should not be lower than 4 seconds.

ECONOLITE ASC/3-2070 LOGIC PROCESSOR PROGRAMMING DETAIL
FOR TRAILBLAZER SIGN(S)

(program controller as shown)

The following logic processor configuration sets sign(s) to the appropriate display by utilizing pedestrian load switches.

1. From Main Menu select 1. CONFIGURATION
2. From CONFIGURATION Submenu select 8. LOGIC PROCESSOR
3. From LOGIC PROCESSOR Submenu select 2. LOGIC STATEMENTS

ENTER A "31" IN THE LP# FIELD, PRESS 'ENTER', AND PROGRAM AS SHOWN.

LP#:	31	COPY FROM:	31	ACTIVE:	M	(T/F)
IF	COORD PLAN			IS		55
OR	COORD PLAN			IS		63
THEN	SIG SET PHASE WALK		6	ON		
	SIG SET PHASE WALK		8	ON		
	SIG SET PH D WALK		6	OFF		
	SIG SET PH D WALK		8	OFF		
ELSE	SIG SET PHASE WALK		6	OFF		
	SIG SET PHASE WALK		8	OFF		
	SIG SET PH D WALK		6	ON		
	SIG SET PH D WALK		8	ON		

ENTER A "32" IN THE LP# FIELD, PRESS 'ENTER', AND PROGRAM AS SHOWN.

LP#:	32	COPY FROM:	32	ACTIVE:	M	(T/F)
IF	COORD PLAN			IS		47
OR	COORD PLAN			IS		49
OR	COORD PLAN			IS		51
OR	COORD PLAN			IS		61
THEN	SIG SET PH PED CLR		4	ON		
	SIG SET PH PED CLR		8	ON		
	SIG SET PH PED CLR		2	OFF		
	SIG SET PH PED CLR		6	OFF		
ELSE	SIG SET PH PED CLR		4	OFF		
	SIG SET PH PED CLR		8	OFF		
	SIG SET PH PED CLR		2	ON		
	SIG SET PH PED CLR		6	ON		


4. From the LOGIC PROCESSOR Submenu select 1. LOGIC STATEMENT CONTROL

ENABLE LOGIC PROCESSOR STATEMENTS 31 AND 32 BY POSITIONING THE CURSOR OVER THE FIELD SHOWN BELOW AND USING THE TOGGLE KEY TO ENABLE THEM.

LOGIC STATEMENT CONTROL															
	1	2	3	4	5	6	7	8	9	0	1	2	3	4	5
LP 1-15	.	.	.	.	.	.	.	.	.	.	.	.	.	.	.
LP 16-30	.	.	.	.	.	.	.	.	.	.	.	.	.	.	.
LP 31-45	E	E	.	.	.	.	.	.	.	.	.	.	.	.	.
LP 46-60	.	.	.	.	.	.	.	.	.	.	.	.	.	.	.
LP 61-75	.	.	.	.	.	.	.	.	.	.	.	.	.	.	.
LP 76-90	.	.	.	.	.	.	.	.	.	.	.	.	.	.	.

END PROGRAMMING

CHANGEABLE TRAILBLAZER SIGN
WIRING AND PROGRAMMING DETAIL

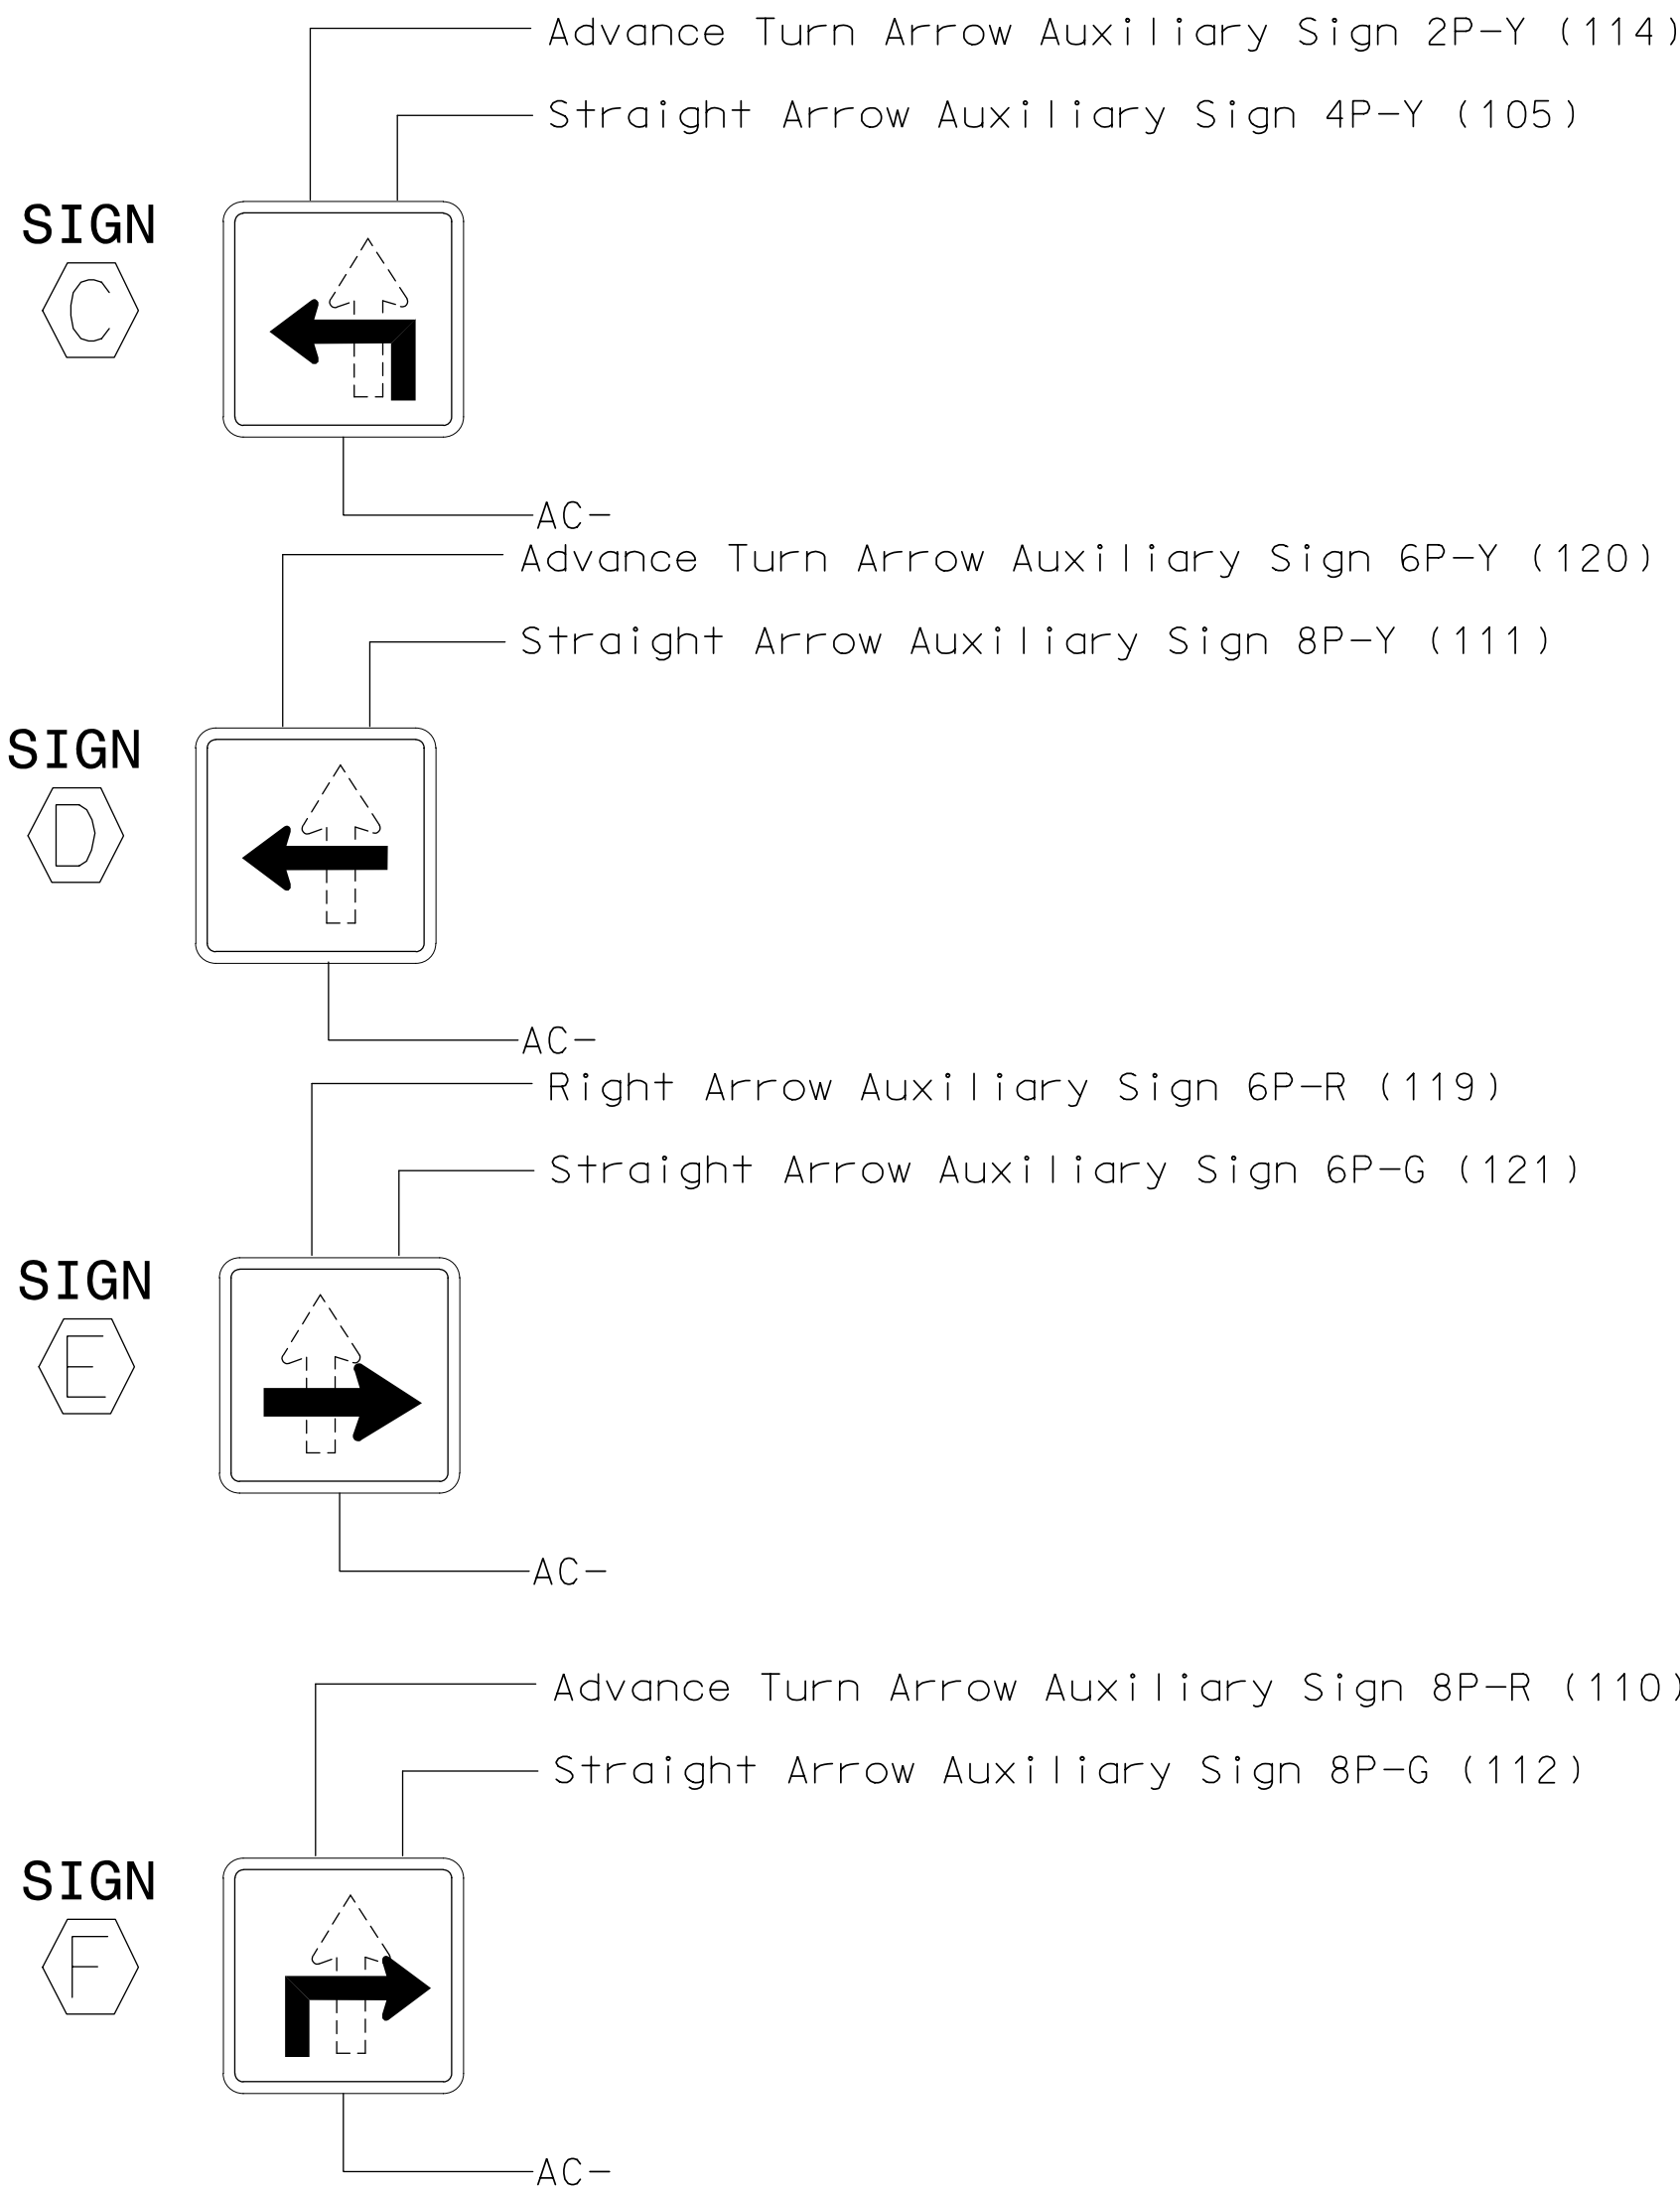



NOTE

Remove, tape, and label conflict monitor wire attached to rear of terminal 2PY (114), 4PY (105), 6PY (120), 8PY (111), 6PR (119), 6PG (121), 8PR (110), 8PG (112).

THIS ELECTRICAL DETAIL IS FOR
THE SIGNAL DESIGN: 12-0562
DESIGNED: October 2018
SEALED: February 7, 2019
REVISED: 4/16/2019

SIGNAL UPGRADE SHEET 2 OF 2

DOCUMENT NOT CONSIDERED
FINAL UNLESS ALL
SIGNATURES COMPLETED

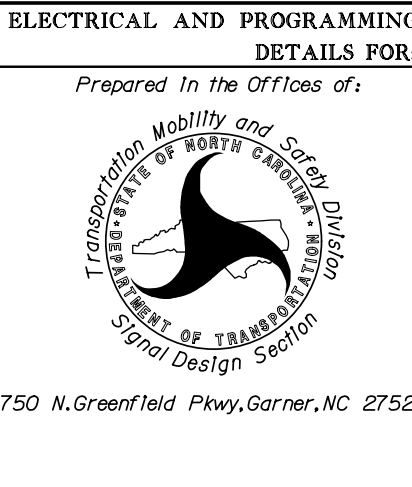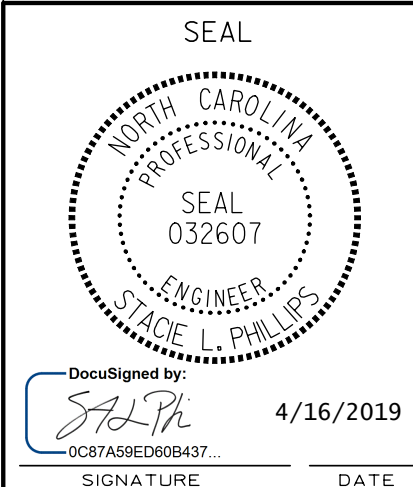

US 29-74 (Wilkinson Boulevard) at NC 273 (Park Street)	
Division 12	Gaston County
PLAN DATE: October 2018	REVIEWED BY: E. Sirgany
PREPARED BY: J. Smith	REVIEWED BY: E. Sirgany
REVISIONS	INIT. DATE
INSTALL CHANGEABLE TRAILBLAZER SIGN	SLP 4/2019


SEAL
Not a certified document.
This document originally
Issued and sealed by
Edward W. Sirgany, PE #018174
on February 7, 2019.
This document shall not be
considered a certified
document.

SIG. INVENTORY NO. 12-0562

PLANS PREPARED IN THE OFFICE OF:
Kimley»Horn
NC License #F-0102
421 Fayetteville Street, Suite 600
Raleigh, NC 27601
(919) 677-2000

EDI MODEL MMU2-16LEip
MALFUNCTION MANAGEMENT UNIT
PROGRAMMING DETAIL

(program card and tables as shown)

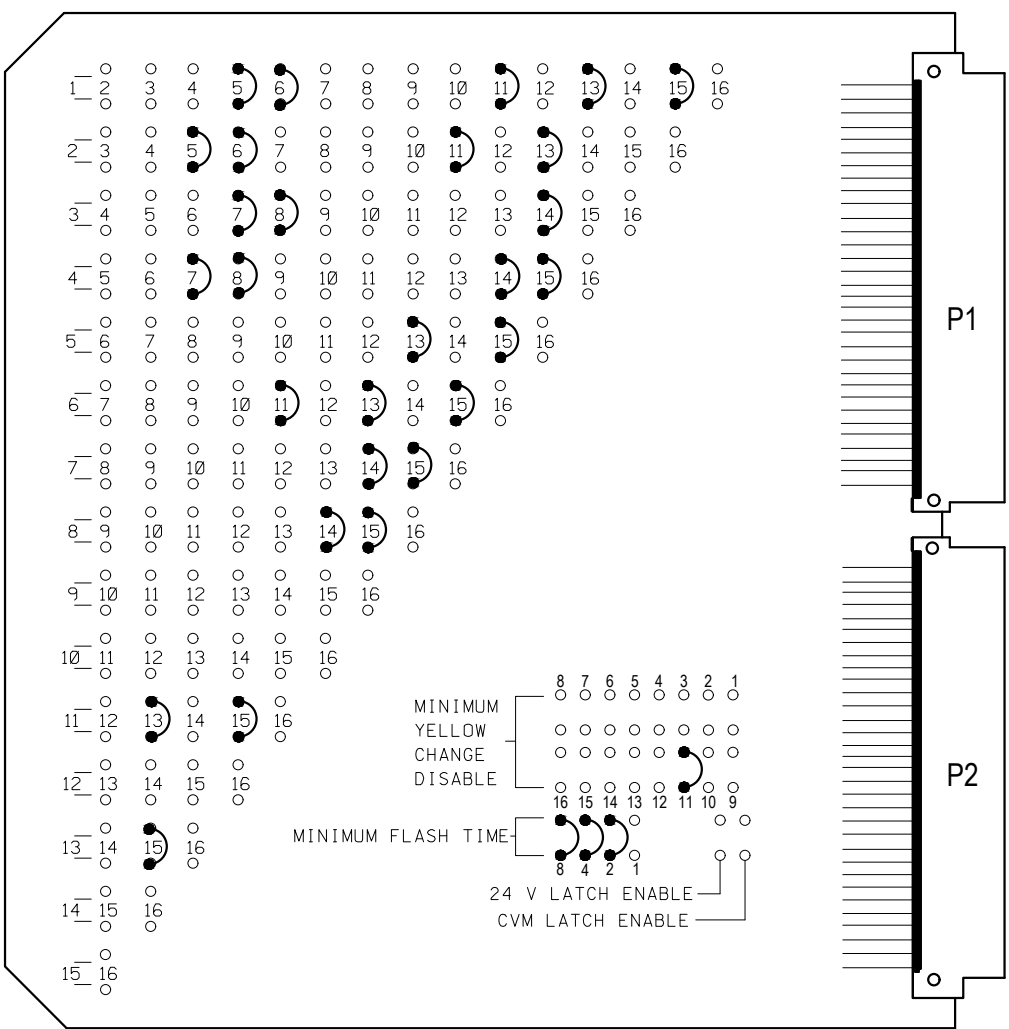

MMU PROGRAMMING CARD

FIELD CHECK ENABLE DUAL IND ENABLE RED FAIL ENABLE	
CHANNEL NUMBER	ENABLE/ DISABLE
1	DISABLE
2	ENABLE
3	DISABLE
4	ENABLE
5	ENABLE
6	ENABLE
7	ENABLE
8	ENABLE
9	DISABLE
10	DISABLE
11	ENABLE
12	DISABLE
13	ENABLE
14	ENABLE
15	ENABLE
16	DISABLE

MMU PROGRAMMING NOTE
ENSURE YELLOW CHANGE PLUS RED CLEARANCE MONITORING
IS ENABLED FOR ALL CHANNELS.

UNIT OPTIONS	
OPTION	SETTING
RECURRENT PULSE	ON
WALK DISABLE	OFF
LOG CVM FAULTS	ON
EXTERN WATCHDOG	OFF
24V-2=12VDC	OFF
PGM CARD MEMORY	ON
LEDguard	ON
FORCE TYPE 16	OFF
TYPE12-SOLC	OFF
VM 3x/Day Latch	ON

FLASHING YELLOW ARROW	
CONFIG MODE	B
ENABLE CHANNEL PAIR, FYA	
CH 1-13	ON
CH 3-14	ON
CH 5-15	OFF
CH 7-16	OFF
RED/YEL INPUT ENABLE	
CH 1	ON
CH 3	ON
CH 5	OFF
CH 7	OFF
FLASH RATE FAULT	OFF
FYA TRAP DETECT	OFF

NOTES

- To prevent "flash-conflict" problems, wire all unused load switches to flash red. Verify that signal heads flash in accordance with the signal plans.
- To prevent red failures on unused monitor channels, tie unused load switch red outputs 1, 3, 7, 8, 9, 10, 12 and 16 to load switch AC+ by inserting a jumper plug in the unused load switch socket from pin 1 (LS AC+) to pin 3 (RED out). Make sure all flash transfer relays are in place.
- Program controller to start up in phase 2 Green and 6 Green.
- Set power-up flash time to 10 seconds and implement on the Malfunction Management Unit. Set controller power-up flash time to 0 seconds.
- Program detectors in accordance with the manufacturer's instructions to accomplish the detection schemes shown on the signal design plans.
- Program detector call delay and extension timing on the controller, unless otherwise specified.
- Set all detector card unit channels to "presence" mode.
- The cabinet and controller are a part of the Charlotte Signal System.

SIGNAL HEAD HOOK-UP CHART

PHASE	1	2	3	4	5	6	7	8	2 PED	4 PED	6 PED	8 PED	OLA	OLB	OLC	OLD
SIGNAL HEAD NO.	11,12	21,22 23,24	31	41,42 43	51,52 53	61,62 63,64	71,72	81,82 83	SIGN K	SIGN K/M	P61,P62 SIGN L	SIGN L	* 11	* 31	13,14,15	NU
RED		2R		4R		6R		8R							15R	
YELLOW	*	2Y	*	4Y		6Y		8Y								
GREEN		2G		4G		6G		8G								
RED ARROW				5R		7R							13R	14R		
YELLOW ARROW				5Y	5Y	7Y							13Y	14Y	15Y	
FLASHING YELLOW ARROW													13G	14G		
GREEN ARROW	1G		3G		5G	5G	7G								15G	
									** 104	** 114	** 105	** 111				
PED YELLOW									** 106	** 116	** 107	** 112				

* Denotes install load resistor. See load resistor installation detail this sheet 2.
* See pictorial of head wiring in detail this sheet.
** Changeable Trailblazer Signs. See wiring and programming detail on sheet 3.

DETECTOR RACK SET-UP DETAIL

INSERT DETECTOR CARDS IN RACK ACCORDING TO THE DETAIL SHOWN BELOW.
PARTICULAR DETECTOR CHANNELS WILL CALL PHASES INDICATED.

DET BIU #1	CH1 L3 ø 1	CH3 L1 ø 1	CH1 L7 ø 2	CH3 L5 ø 1	CH1 L11 ø 2	CH3 L9 ø 2	CH1 L15 ø 4	CH3 L13 ø 3	CH1 L19 ø 5	CH3 L17 ø 5	CH1 L23 ø 6	CH3 L21 ø 6	CH1 L27 ø 7	CH3 L25 ø 6	CH1 L31 NOT USED	CH3 L29 ø 8	DET BIU #2
	CH2 L4 ø 1	CH4 L2 ø 1	CH2 L8 ø 2	CH4 L6 ø 2	CH2 L12 ø 3	CH4 L10 ø 2	CH2 L16 ø 5	CH4 L14 ø 4	CH2 L20 ø 6	CH4 L18 ø 5	CH2 L24 ø 6	CH4 L22 ø 6	CH2 L28 ø 7	CH4 L26 ø 7	CH2 L32 NOT USED	CH4 L30 ø 8	


EQUIPMENT INFORMATION

CONTROLLER.....2070LNC-1C
CABINETTS-2
SOFTWAREECONOLITE EOS
CABINET MOUNT.....BASE W/ RISER
LOADBAY POSITIONS.....16
LOAD SWITCHES USED.....1,2,3,4,5,6,7,8,11,13,14,15
PHASES USED.....1,2,3,4,5,6,6 PED,7,8
OLA.....*
OLB.....*
OLC.....*
OLD.....NOT USED

* See overlap programming detail on sheet 2


FYA SIGNAL WIRING DETAIL

(wire signal heads as shown)

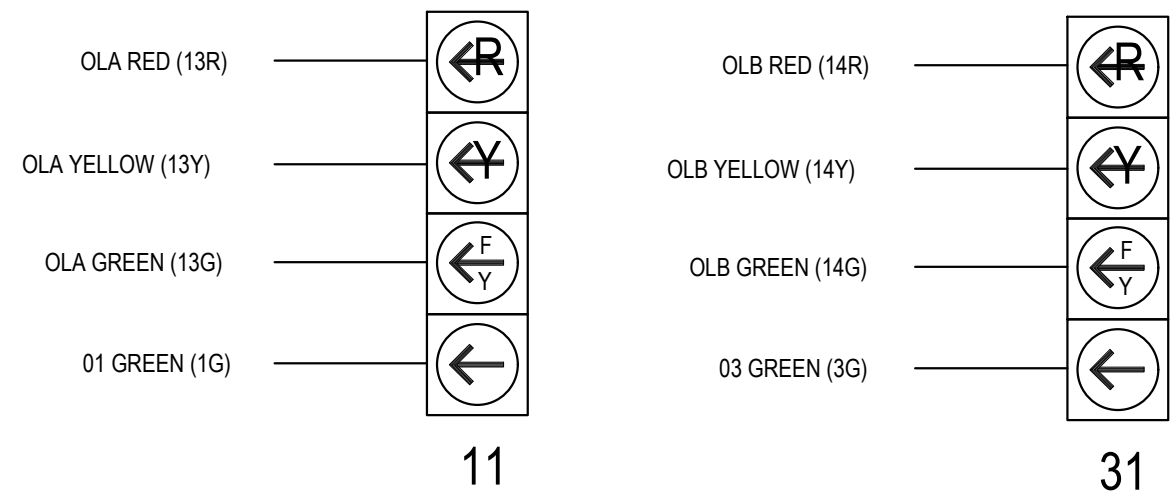

PEDESTRIAN PUSH BUTTON WIRING DETAIL

(wire push buttons as shown)

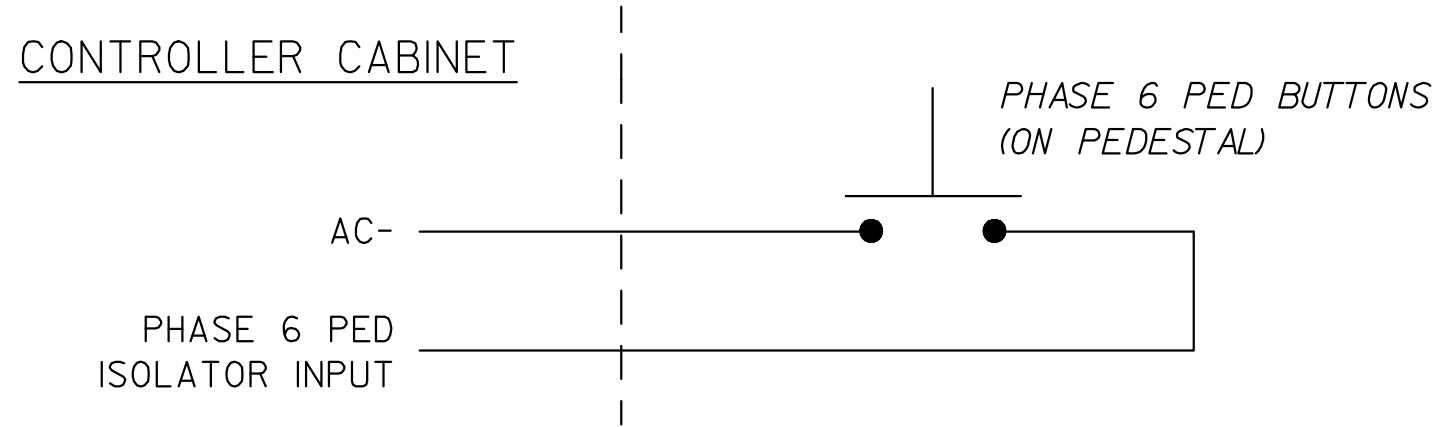

COUNTDOWN PEDESTRIAN SIGNAL OPERATION

Countdown Ped Signals are required to display timing only during Ped Clearance Interval. Consult Ped Signal Module user's manual for instructions on selecting this feature.

THIS ELECTRICAL DETAIL IS FOR
THE SIGNAL DESIGN: 10-1730
DESIGNED: MARCH 2019
SEALED: 4/16/2019
REVISED: _____

NOTE

BE SURE TO PROGRAM DETECTOR
TYPES AND TIMERS (EXTEND
AND DELAY) AS SHOWN ON THE
SIGNAL PLANS.

WIRE LOOPS TO TERMINALS
ON LOOP PANEL AS SHOWN
IN THE CHART BELOW

LOOP NO.	LOOP PANEL TERMINALS
11	L1A,L1B
12	L2A,L2B
13	L3A,L3B
14	L4A,L4B
15	L5A,L5B
21	L6A,L6B
22	L7A,L7B
23	L8A,L8B
24	L9A,L9B
25	L10A,L10B
26	L11A,L11B
31	L12A,L12B
32	L13A,L13B
41	L14A,L14B
42	L15A,L15B
51	L16A,L16B

PROGRAM CONTROLLER DETECTORS
ACCORDING TO THE SCHEDULE
SHOWN IN THE CHART BELOW

CONTROLLER DETECTOR NO.	FUNCTION	TIMING	
		FEATURE	TIME(SEC)
1	ø 1	-----	--
2	ø 1	-----	--
3	ø 1	-----	--
4	ø 1	-----	--
5	ø 1	-----	--
6	ø 2	-----	--
7	ø 2	-----	--
8	ø 2	-----	--
9	ø 2	-----	--
10	ø 2	-----	--
11	ø 2	-----	--
12	ø 3	-----	--
13	ø 3	-----	--
14	ø 4	-----	--
15	ø 4	-----	--
16	ø 5	-----	--

WIRE LOOPS TO TERMINALS
ON LOOP PANEL AS SHOWN
IN THE CHART BELOW

LOOP NO.	LOOP PANEL TERMINALS
52	L17A,L17B
53	L18A,L18B
54	L19A,L19B
61	L20A,L20B
62	L21A,L21B
63	L22A,L22B
64	L23A,L23B
65	L24A,L24B
66	L25A,L25B
71	L26A,L26B
72	L27A,L27B
73	L28A,L28B
81	L29A,L29B
82	L30A,L30B
NU	L31A,L31B
NU	L32A,L32B

PROGRAM CONTROLLER DETECTORS
ACCORDING TO THE SCHEDULE
SHOWN IN THE CHART BELOW

CONTROLLER DETECTOR NO.	FUNCTION	TIMING	
		FEATURE	TIME(SEC)
17	ø 5	-----	--
18	ø 5	-----	--
19	ø 5	-----	--
20	ø 6	-----	--
21	ø 6	-----	--
22	ø 6	-----	--
23	ø 6	-----	--
24	ø 6	-----	--
25	ø 6	-----	--
26	ø 7	-----	--
27	ø 7	-----	--
28	ø 7	-----	--
29	ø 8	-----	--
30	ø 8	-----	--
31		-----	--
32		-----	--

LOAD SWITCH
ASSIGNMENT DETAIL

(program controller according to
schedule in chart below)

LOAD SWITCH NUMBER	FUNCTION
1	ø 1
2	ø 2
3	ø 3
4	ø 4
5	ø 5
6	ø 6
7	ø 7
8	ø 8
9	ø 2 PED
10	ø 4 PED
11	ø 6 PED
12	ø 8 PED
13	OLA
14	OLB
15	OLC
16	OLD

ELECTRICAL DETAIL 1 OF 3



Designed by: *SALPA*
DATE: 4/16/2019

#	BY:	DATE:	CITY OF CHARLOTTE DEPARTMENT OF TRANSPORTATION 600 E. 4TH ST. CHARLOTTE, NC 28202 704 336-4119 FAX: 704 336-4400	
			WILKINSON BOULEVARD AND I-485 NB RAMP/TODD ROAD	
DESIGNED BY: SPP	DATE: 4/19	APPROVED BY: SLP	NCDOT# 10-1730	UNIT ID: 10666
		SIGNAL ID: 00943		

1. From Main Menu select 2. CONTROLLER
2. From CONTROLLER Submenu select 2. VEHICLE OVERLAP

OVERLAP A

OVERLAP E

OVERLAP (

Diagram illustrating the connection of Phase 1 and Phase 3 yellow field terminals to AC- terminals:

- PHASE 1 YELLOW FIELD TERMINAL (1Y) is connected to AC-.
- PHASE 3 YELLOW FIELD TERMINAL (3Y) is connected to AC-.

ACCEPTABLE VALUES	
VALUE (ohms)	WATTAGE
1.5K - 1.9K	25W (min)
2.0K - 3.0K	10W (min)

1. From Main Menu select **1. CONFIGURATION**
2. From CONFIGURATION Submenu select **1. CABINET**
3. From PORT 1 (SDLC) Submenu select **4. MONITOR PROGRAMMING**

Set intersection to Flash before attempting to enter or change any MMU programming data.

[illegible]

END PROGRAMMING

THIS ELECTRICAL DETAIL IS FOR
THE SIGNAL DESIGN: 10-1730
DESIGNED: MARCH 2019
SEALED: 4/16/2019
REVISED: _____

DocuSigned by:
SALPH
4/16/2019
DCR7A59FD60B437

#	BY:	DATE:	REVISION:	CITY OF CHARLOTTE DEPARTMENT OF TRANSPORTATION 600 E. 4TH ST. CHARLOTTE, NC 28202 704 336-4119 FAX: 704 336-4400	
				WILKINSON BOULEVARD AND I-485 NB RAMP/TODD ROAD	
DESIGNED BY: SPP		DATE: 4/19	APPROVED BY: SLP	NCDOT# 10-1730	UNIT ID: 10666
				SIGNAL ID: 00943	

ECONOLITE EOS-2070 LOGIC PROCESSOR PROGRAMMING DETAIL
FOR TRAILBLAZER SIGNS
(program controller as shown)

The following logic processor configuration sets signs to the appropriate display by utilizing pedestrian load switches.

- 1. From Main Menu select 1. CONFIGURATION
- 2. From CONFIGURATION Submenu select 5. LOGIC PROCESSOR
- 3. From LOGIC PROCESSOR Submenu select 2. LOGIC STATEMENTS

ENTER A "31" IN THE LP# FIELD, PRESS 'ENTER', AND PROGRAM AS SHOWN.

Table with 5 columns: LP#, COPY FROM, ACTIVE, M, (T/F). It contains logic configuration for LP 31, including IF/THEN/ELSE conditions for COORD PLAN and SIG SET PH PED CLR.

ENTER A "32" IN THE LP# FIELD, PRESS 'ENTER', AND PROGRAM AS SHOWN.

Table with 5 columns: LP#, COPY FROM, ACTIVE, M, (T/F). It contains logic configuration for LP 32, including IF/THEN/ELSE conditions for COORD PLAN and SIG SET PH PED CLR.


- 4. From the LOGIC PROCESSOR Submenu select 1. LOGIC STATEMENT CONTROL

ENABLE LOGIC PROCESSOR STATEMENTS 31 AND 32 BY POSITIONING THE CURSOR OVER THE FIELD SHOWN BELOW AND USING THE TOGGLE KEY TO ENABLE THEM.

Table titled 'LOGIC STATEMENT CONTROL' with columns for LP ranges (1-15, 16-30, 31-45, 46-60, 61-75, 76-90) and a grid of 10 columns (1-10) for enabling statements.

END PROGRAMMING

CHANGEABLE TRAILBLAZER SIGN
WIRING AND PROGRAMMING DETAIL

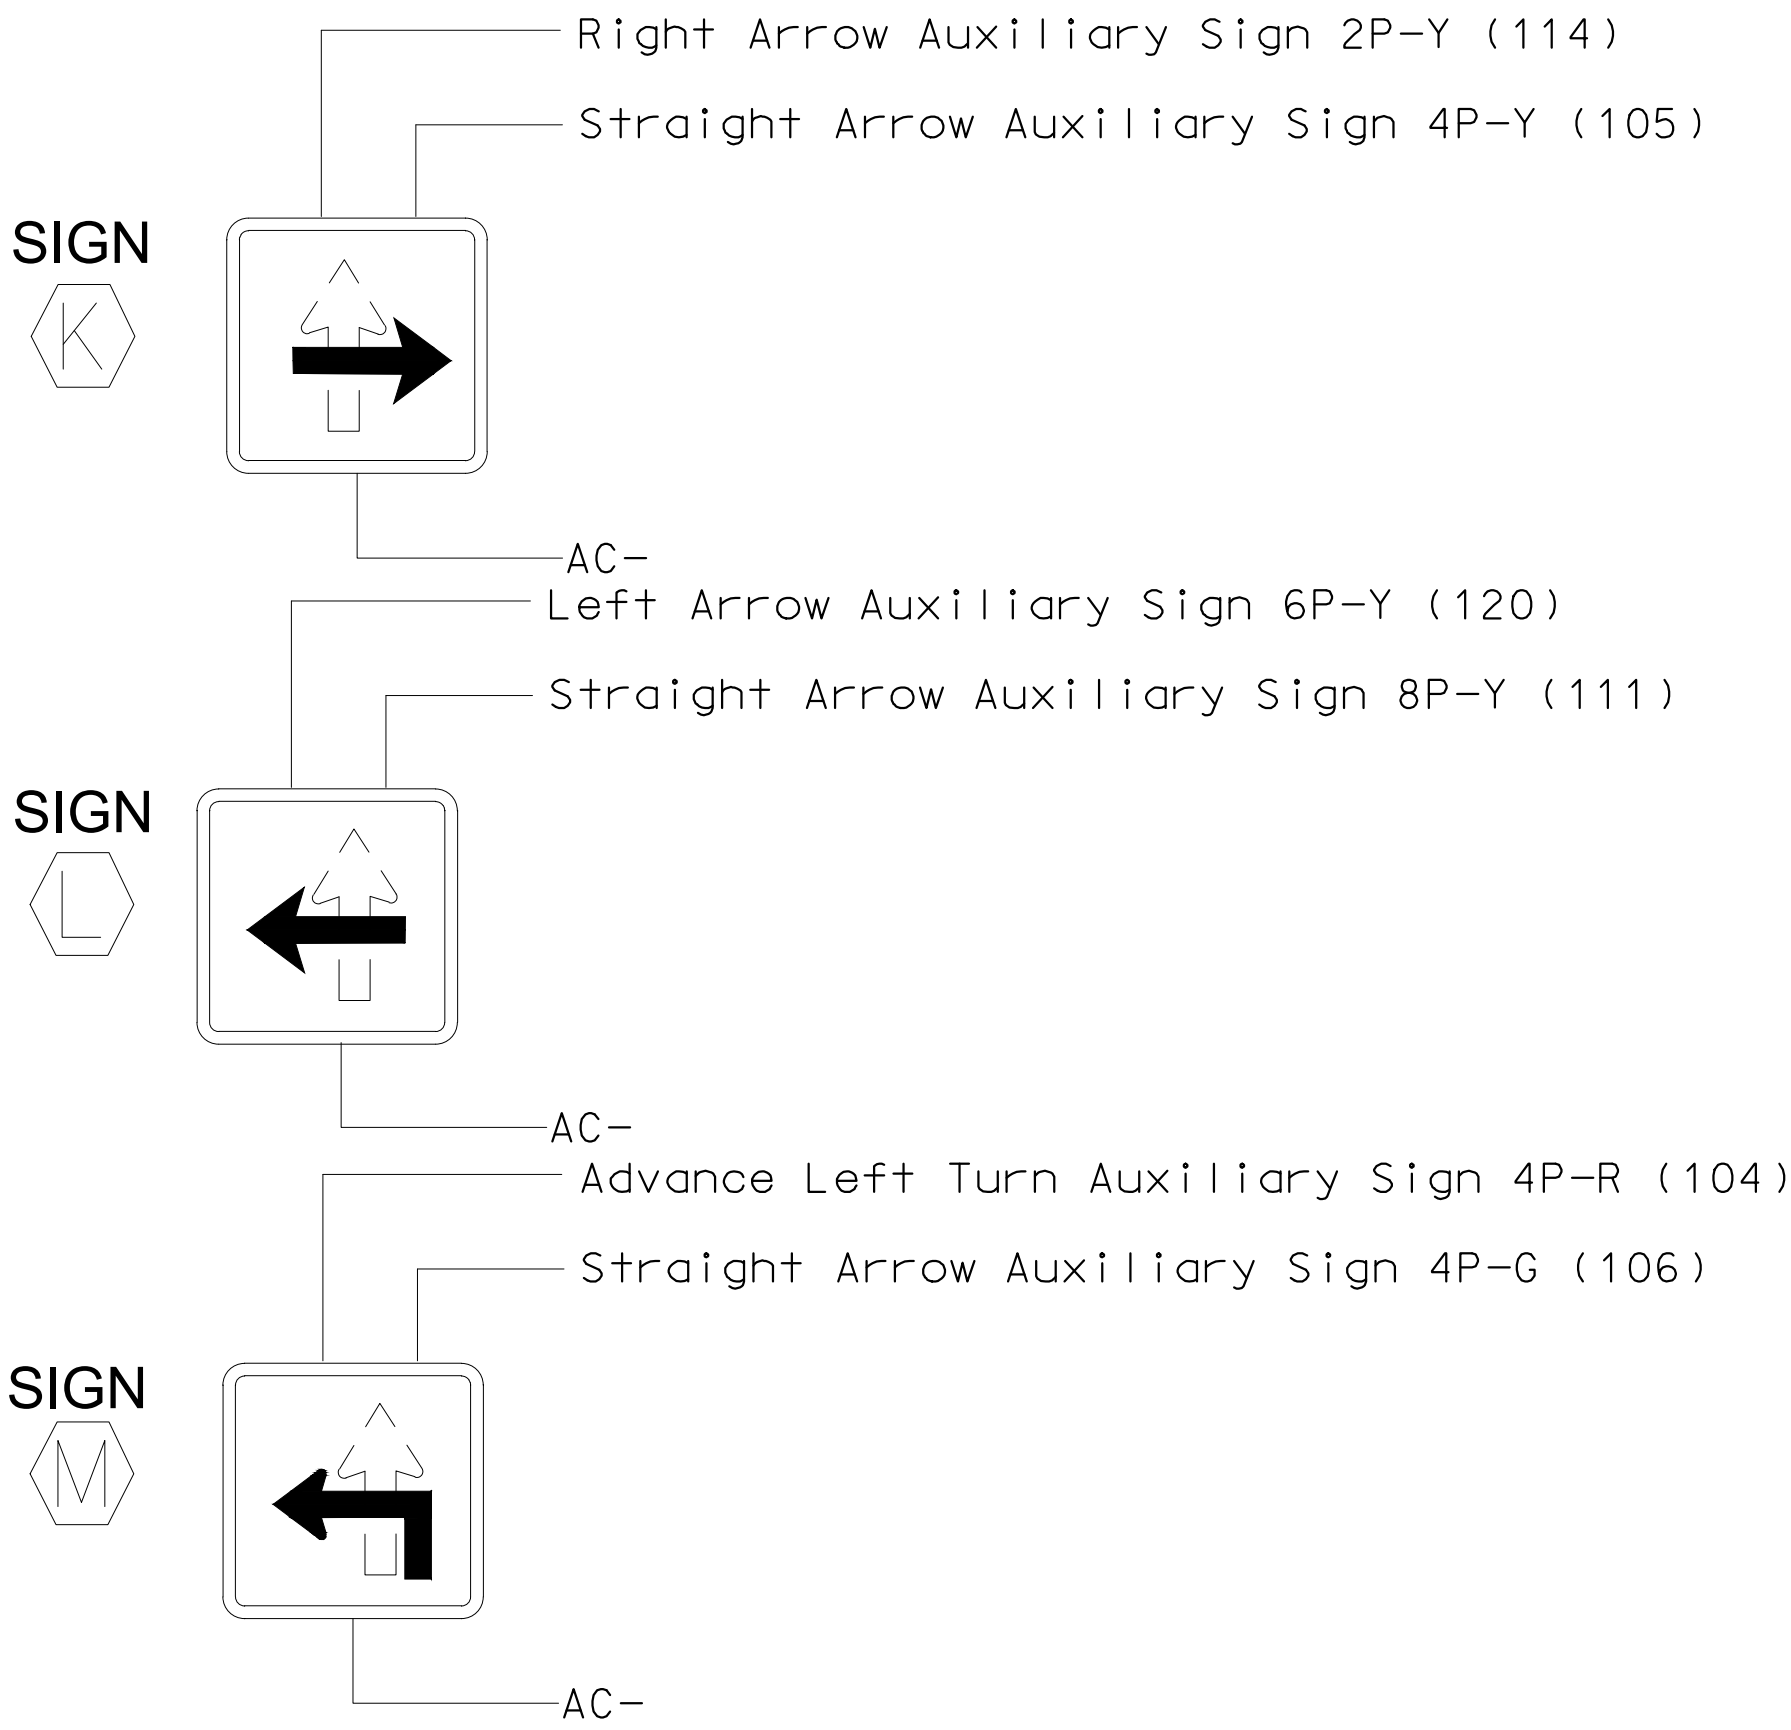

NOTE
Remove, tape, and label conflict monitor wire attached to rear of terminal 2PY (114), 4PY (105), 6PY (120), 8PY (111), 4PR (104), 4PG (106).

THIS ELECTRICAL DETAIL IS FOR
THE SIGNAL DESIGN: 10-1730
DESIGNED: MARCH 2019
SEALED: 4/16/2019
REVISED: _____

ELECTRICAL DETAIL 3 OF 3

Professional Engineer Seal for Stephanie L. Phillips, State of North Carolina, License No. 032607. Designated by: SPP, Date: 4/16/2019. City of Charlotte Department of Transportation, 600 E. 4th St., Charlotte, NC 28202. Project: WILKINSON BOULEVARD AND I-485 NB RAMP/TODD ROAD. Designated By: SPP, Date: 4/19, Approved By: SLP, NCDOT# 10-1730, Unit ID: 10666, Signal ID: 00943.

