

**This electronic collection of documents is provided
for the convenience of the user
and is Not a Certified Document –**

**The documents contained herein were originally issued
and sealed by the individuals whose names and license
numbers appear on each page, on the dates appearing
with their signature on that page.**

**This file or an individual page
shall not be considered a certified document.**

This topographic map depicts the MacClesfield area. Key features include:

- Project Location:** A circle marks the site of PROJECT 32-2065, situated near the intersection of roads 1106 and 1105.
- Topography:** Contour lines indicate elevation, with labels such as 1100, 1102, 1103, 1104, 1105, 1106, 1109, 1110, 1111, 1112, 1113, 1617, and 1619.
- Infrastructure:** A network of roads is shown, including major roads 1100, 1102, 1103, 1104, 1105, 1106, 1109, 1110, 1111, 1112, 1113, 1617, and 1619. Road shields for 258 and 1617 are present.
- Geographic Labels:** 'MacClesfield' is labeled at the top, and 'Klebs' and 'Coke' are labeled near the project area.
- Other Features:** A dashed line runs along the bottom left, and a small '1' is marked near the project location.

D.R. ETHRIDGE
PROJECT DESIGN ENGINEER

-L- 11+75 TO 12+25

RR SPIKE IN BASE OF 20" POPLAR



1 @ 112"x75" CMTA W/ ENDWALL
71.78' INV.

EXCAVATION AND STONE
INCIDENTAL TO PIPE
INSTALLATION

20-MAY-2016 09:50
S:\DDC\pipetopipe\E2065\roadway\Proj\322065_ddc4_psh.dgn
D4DDC

D400

PI Sta 12+52.83
Δ = 0° 23' 41.6" (RT)
D = 0° 08' 11.1"
L = 289.47'
T = 144.74'
R = 42,000.00'

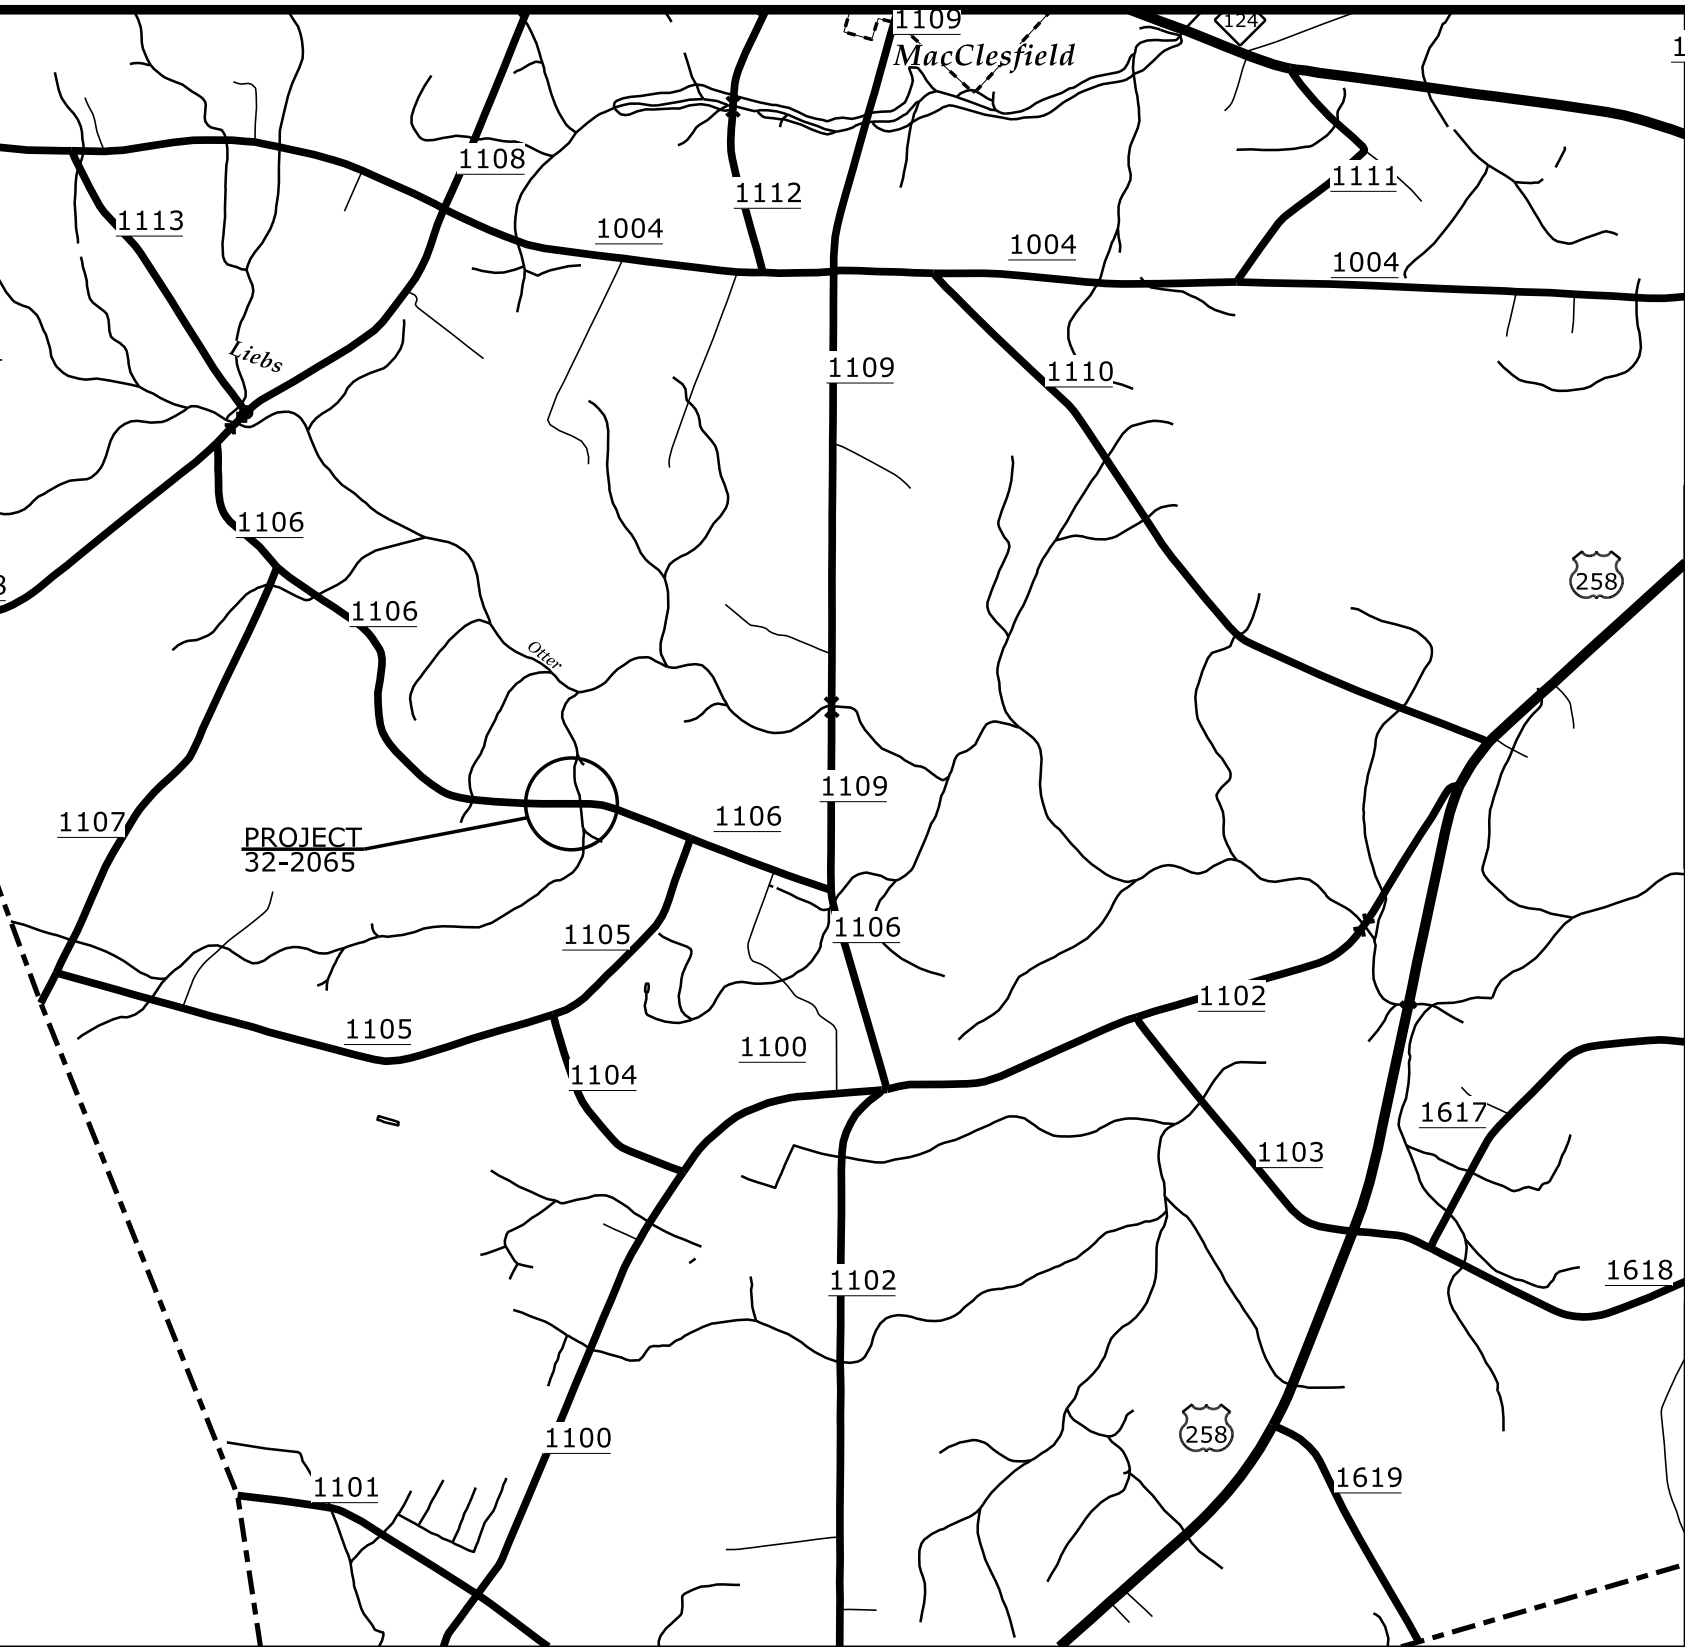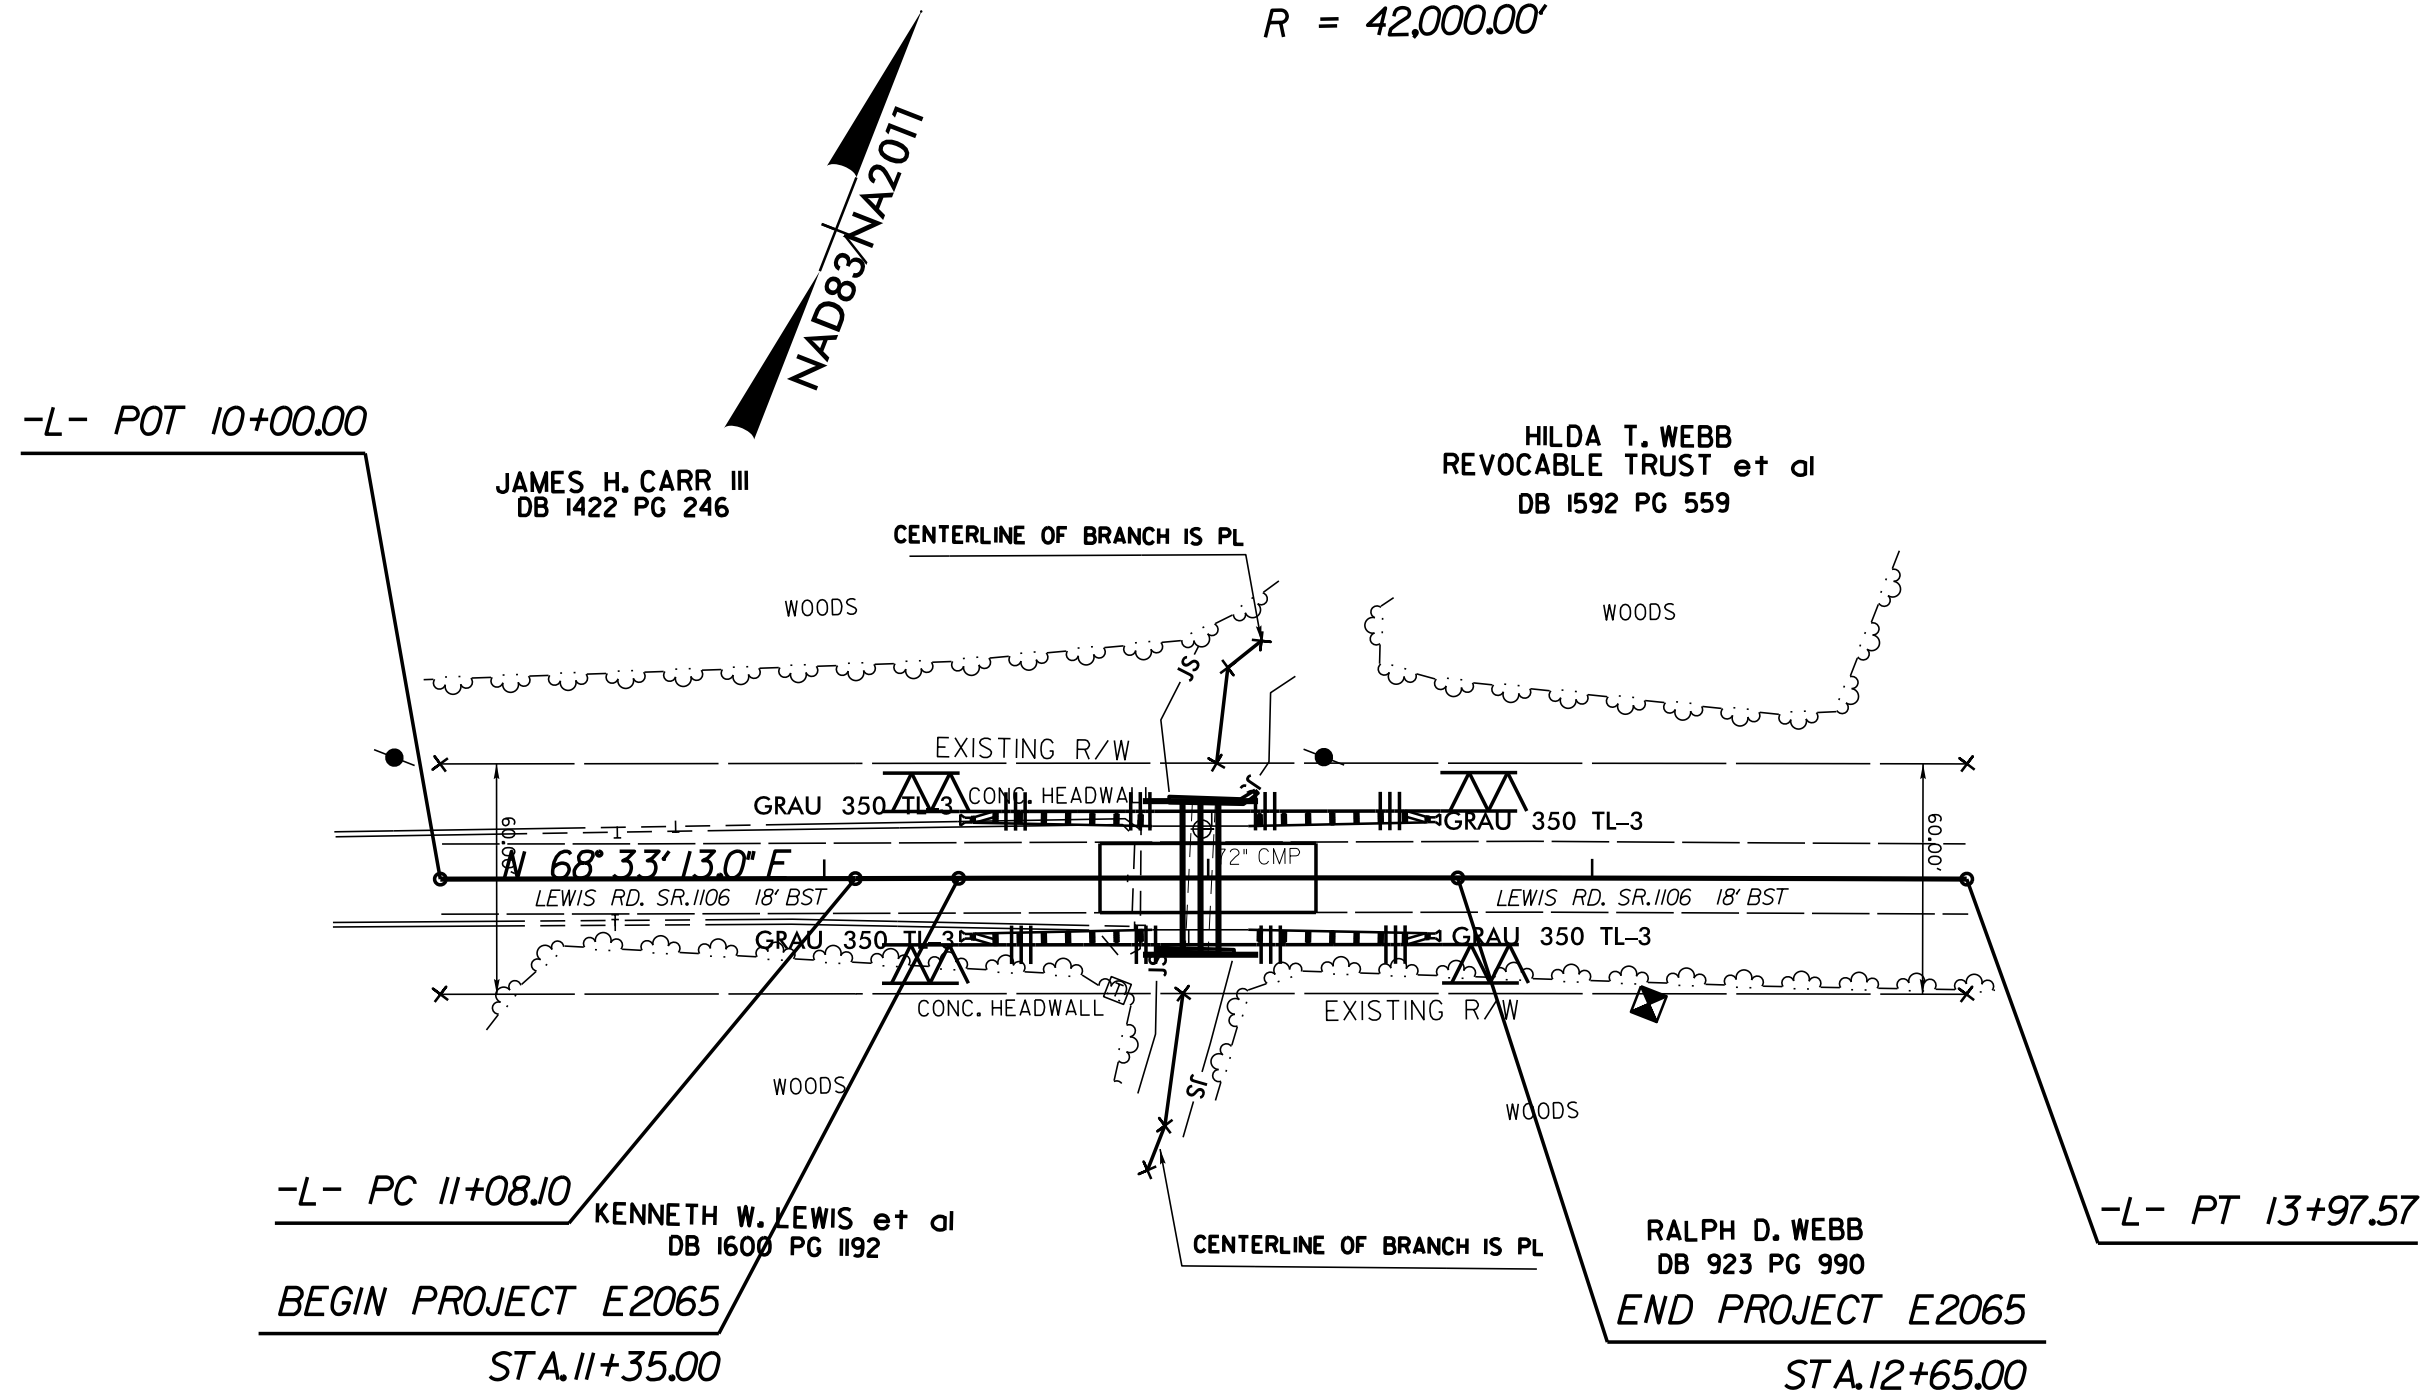

STATE OF NORTH CAROLINA

DIVISION OF HIGHWAYS

PLAN FOR PROPOSED
HIGHWAY EROSION CONTROL

STATE	PIPE NUMBER	CONTRACT	SHEET NO.
N.C.	32-2065	DD00178	1
STATE PROJ. NO.	F. A. PROJ. NO.	DESCRIPTION	
17BP.4.C.1		PE, CONST.	

THESE EROSION AND SEDIMENT CONTROL PLANS COMPLY WITH THE REGULATIONS SET FORTH BY THE NCG-010000 GENERAL CONSTRUCTION PERMIT EFFECTIVE AUGUST 3, 2011 ISSUED BY THE NORTH CAROLINA DEPARTMENT OF ENVIRONMENT AND NATURAL RESOURCES DIVISION OF WATER QUALITY.

GRAPHIC SCALES

50250050

PLANS

50250050

PROFILE (HORIZONTAL)

1050010

PROFILE (VERTICAL)

Prepared in the Office of:

ROADSIDE ENVIRONMENTAL UNIT
2012 STANDARD SPECIFICATIONS

Designed by:

AARON HARPER
NAME

3390
LEVEL III CERTIFICATION NO.


VICINITY MAP

Std. #	Description	Symbol
1605.01	Temporary Silt Fence	
1606.01	Special Sediment Control Fence	


INSTALL SPECIAL SEDIMENT CONTROL FENCE IN LOW
POINTS OF SILT FENCE AS NEEDED

INSTALL SILT FENCE TO CONTAIN
TEMPORARY EARTH MATERIAL STOCKPILES

BM #1
N: 718339.22 E: 2394366.52
BL STA OUT OF CHAIN
ELEV. = 80.86'
RR SPIKE IN BASE OF 20" POPLAR

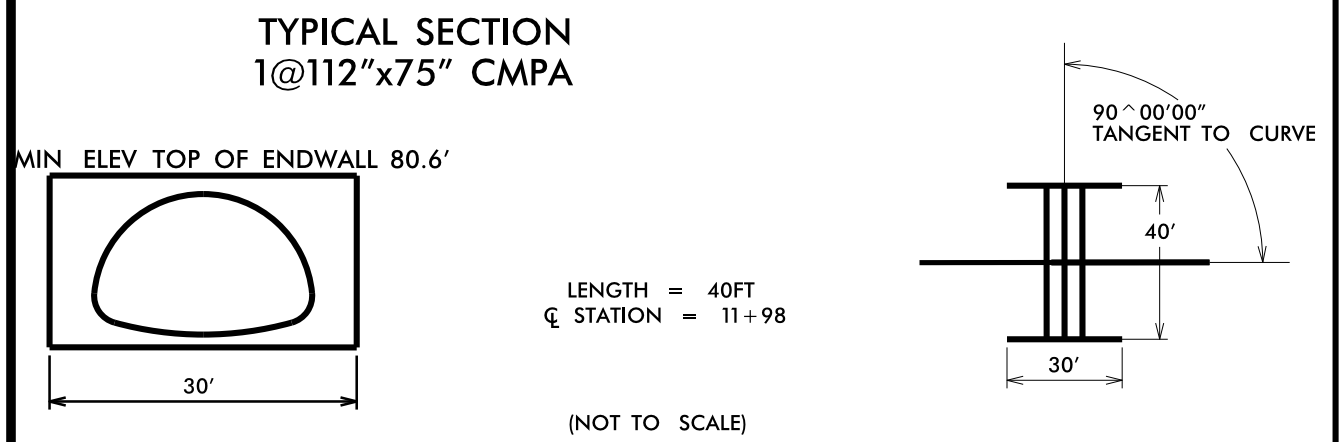


GUARDRAIL DATA						
STATION		LOC	LENGTH	DIST FROM CL	ANCHORS GRAU350	NOTES
BEGIN	END					
11+35.5	12+60.5	LT	125.0	13.5	2	25' NESTED
11+35.5	12+60.5	RT	125.0	13.5	2	25' NESTED
SUBTOTAL			250.0		4	
GRAU350 4*50			-200.0			
TOTAL			50.0		4	
10 ADDITIONAL GUARDRAIL POSTS						

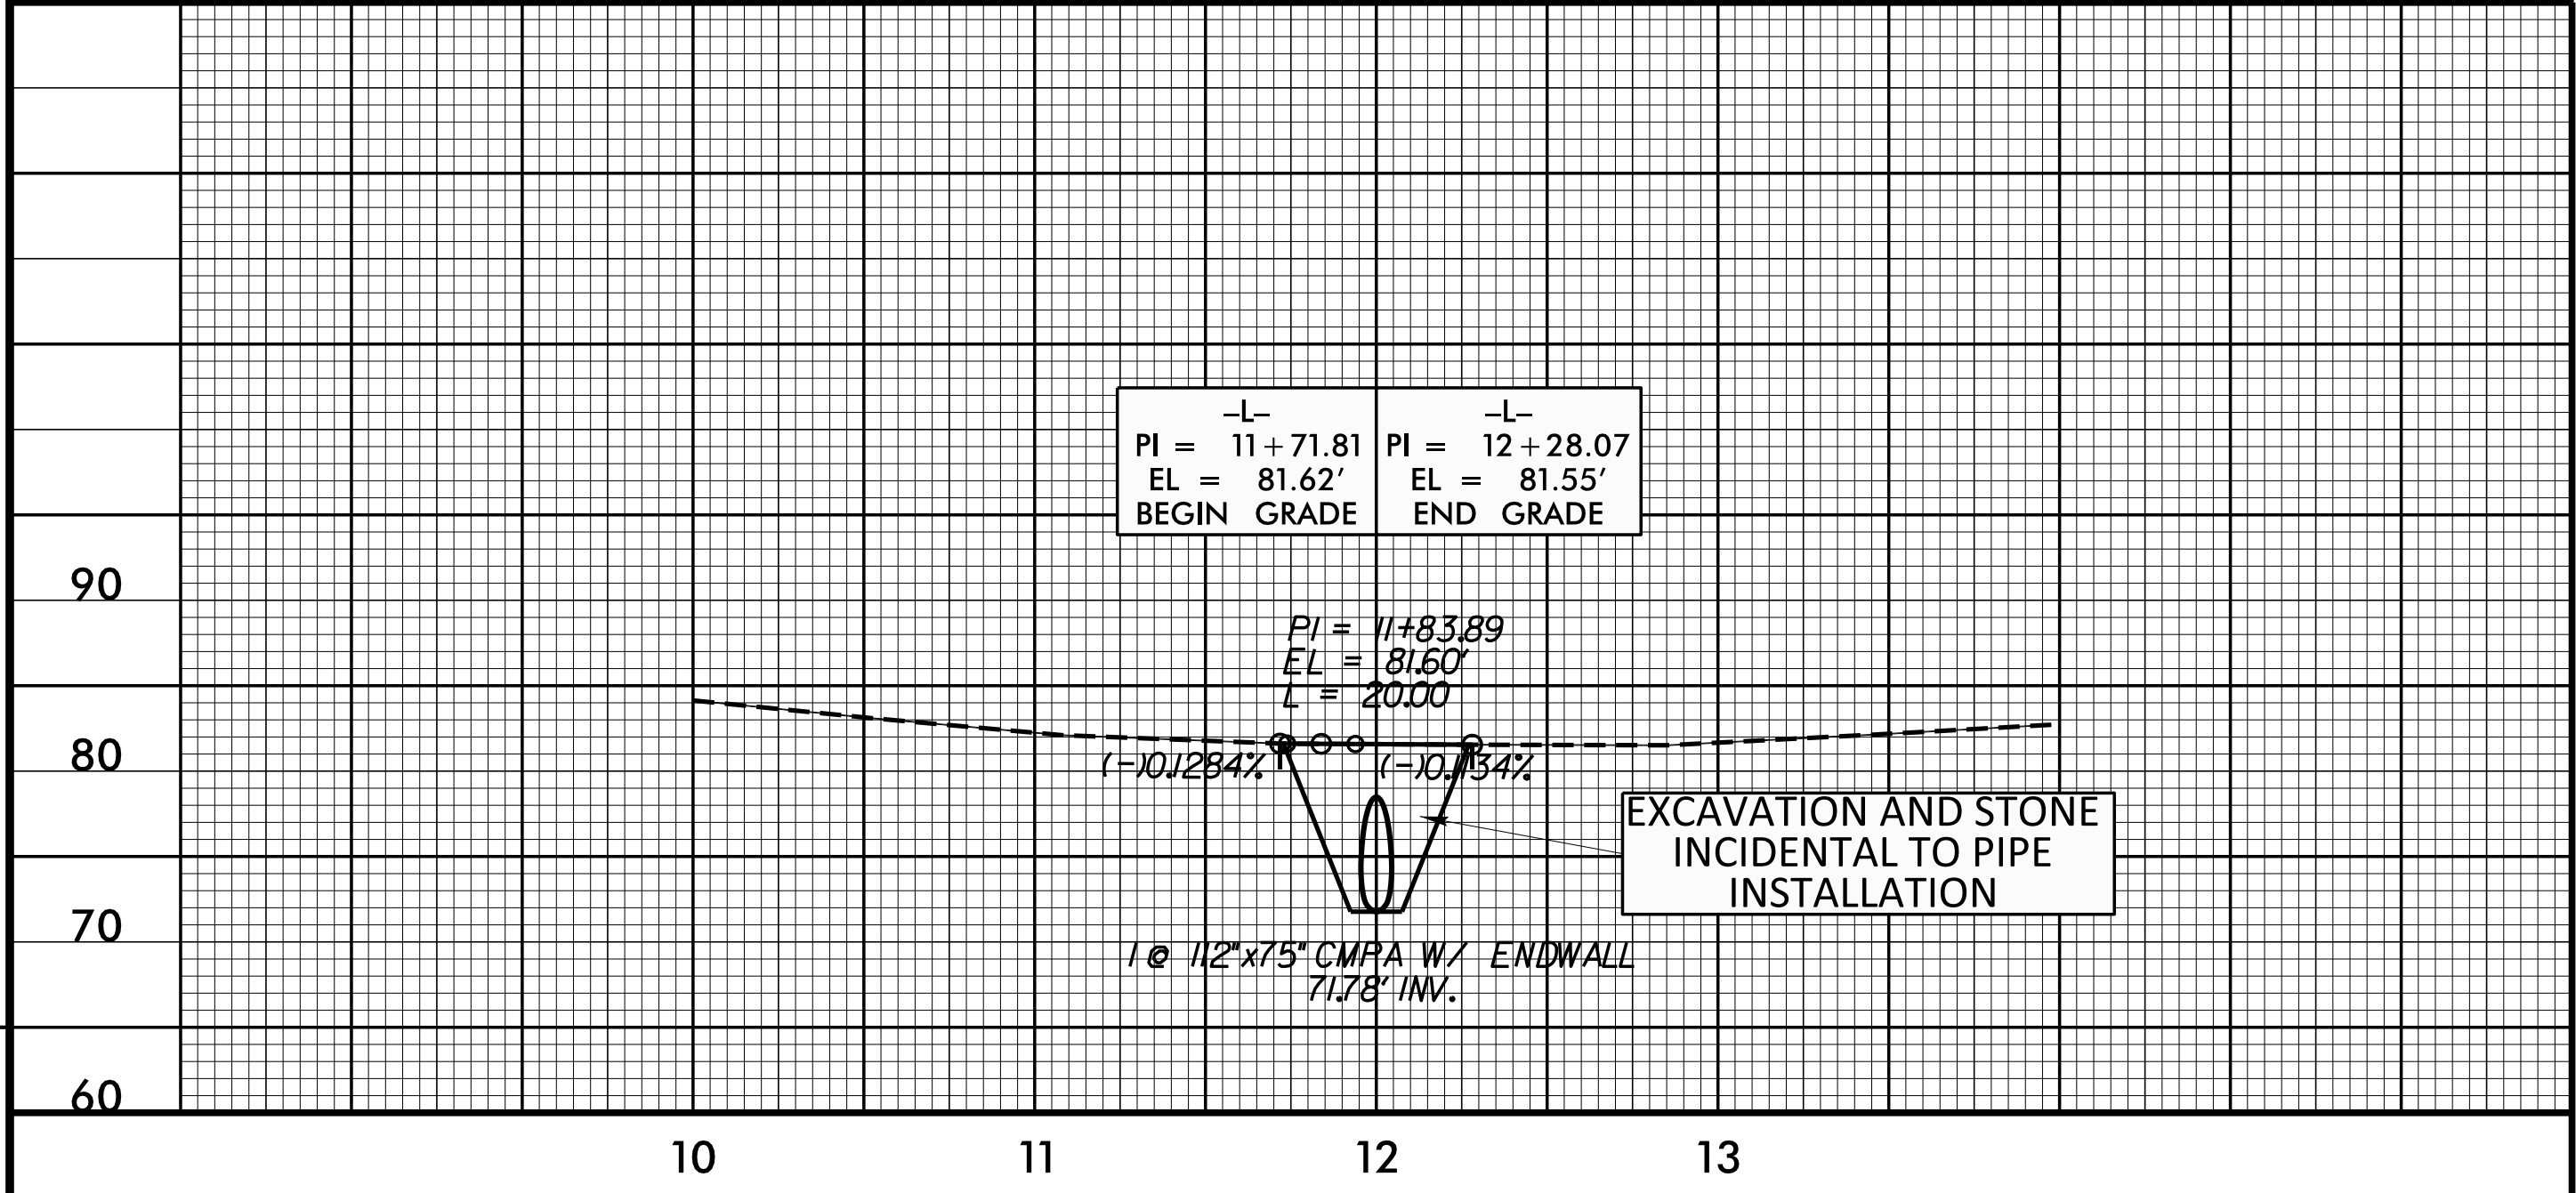


SOIL STABILIZATION TIMEFRAMES

SITE DESCRIPTION	STABILIZATION TIME	TIMEFRAME EXCEPTIONS
PERIMETER DIKS, SWALES, DITCHES AND SLOPES	7 DAYS	NONE
HIGH QUALITY WATER (HOW) ZONES	7 DAYS	NONE
SLOPES STEEPER THAN 3:1	7 DAYS	IF SLOPES ARE 10' OR LESS IN LENGTH AND ARE NOT STEEPER THAN 2:1, 14 DAYS ARE ALLOWED.
SLOPES 3:1 OR FLATTER	14 DAYS	7 DAYS FOR SLOPES GREATER THAN 50' IN LENGTH.
ALL OTHER AREAS WITH SLOPES FLATTER THAN 4:1	14 DAYS	NONE, EXCEPT FOR PERIMETERS AND HOW ZONES.

REVISIONS

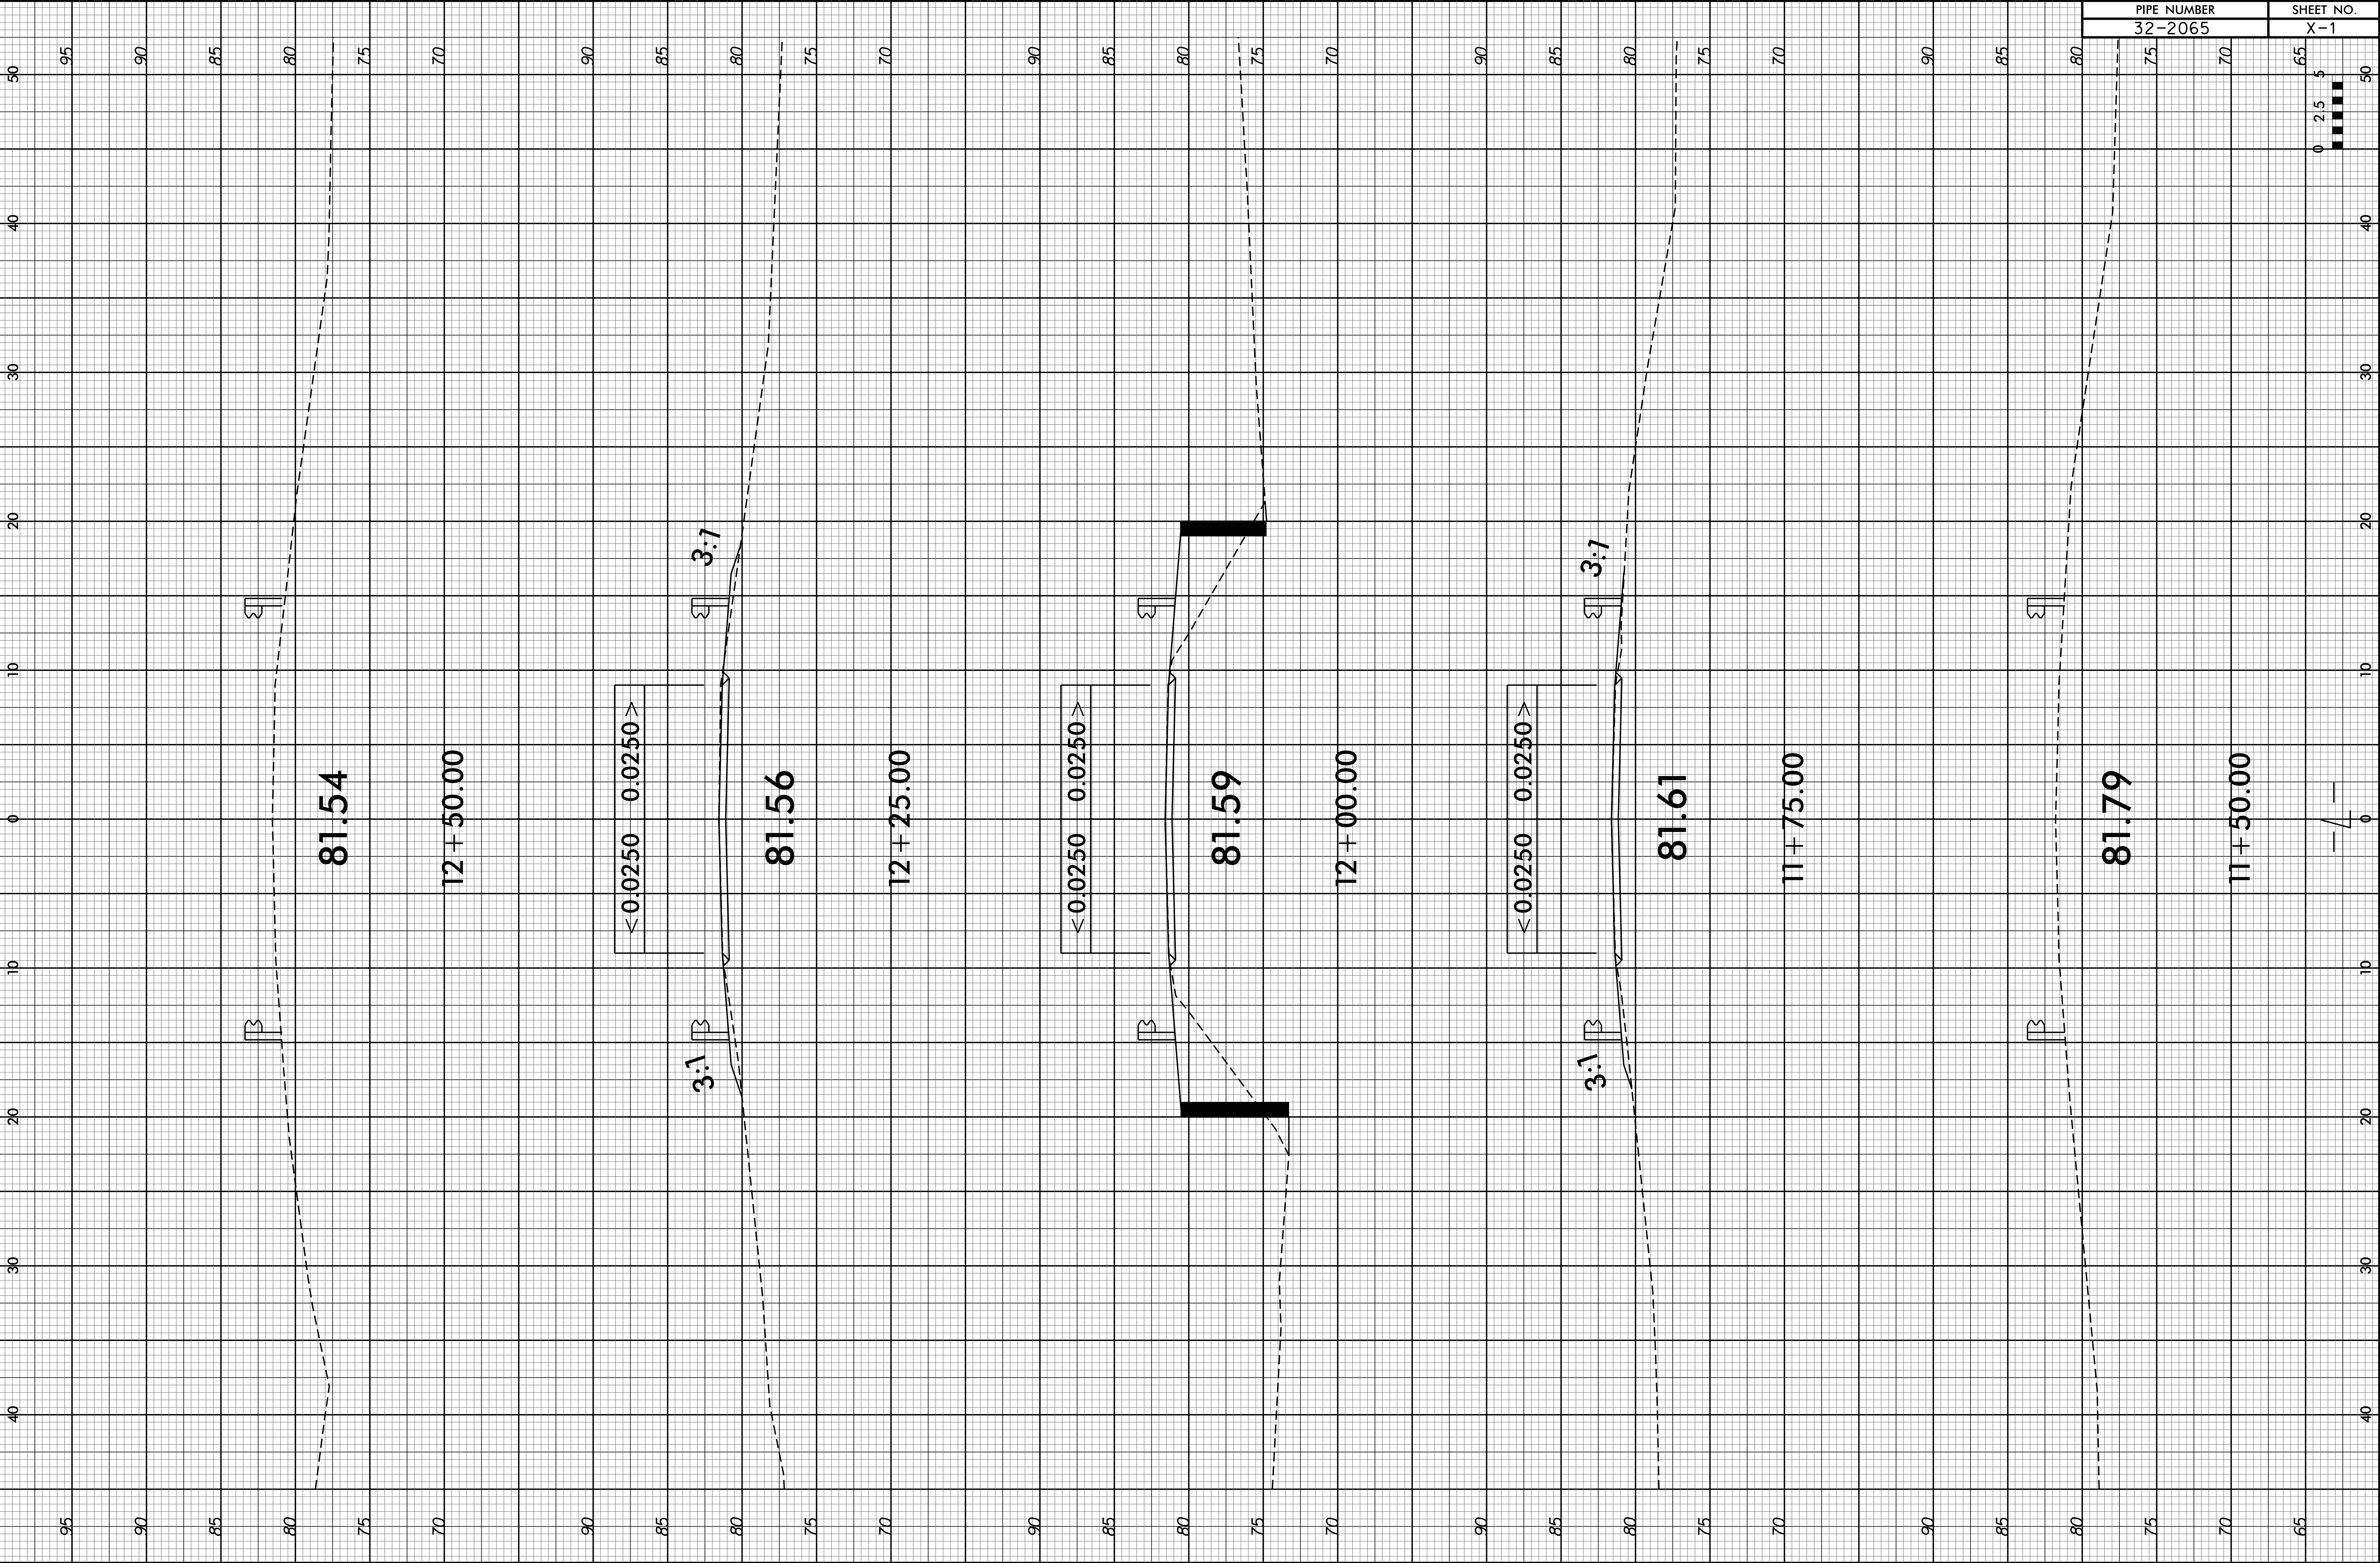

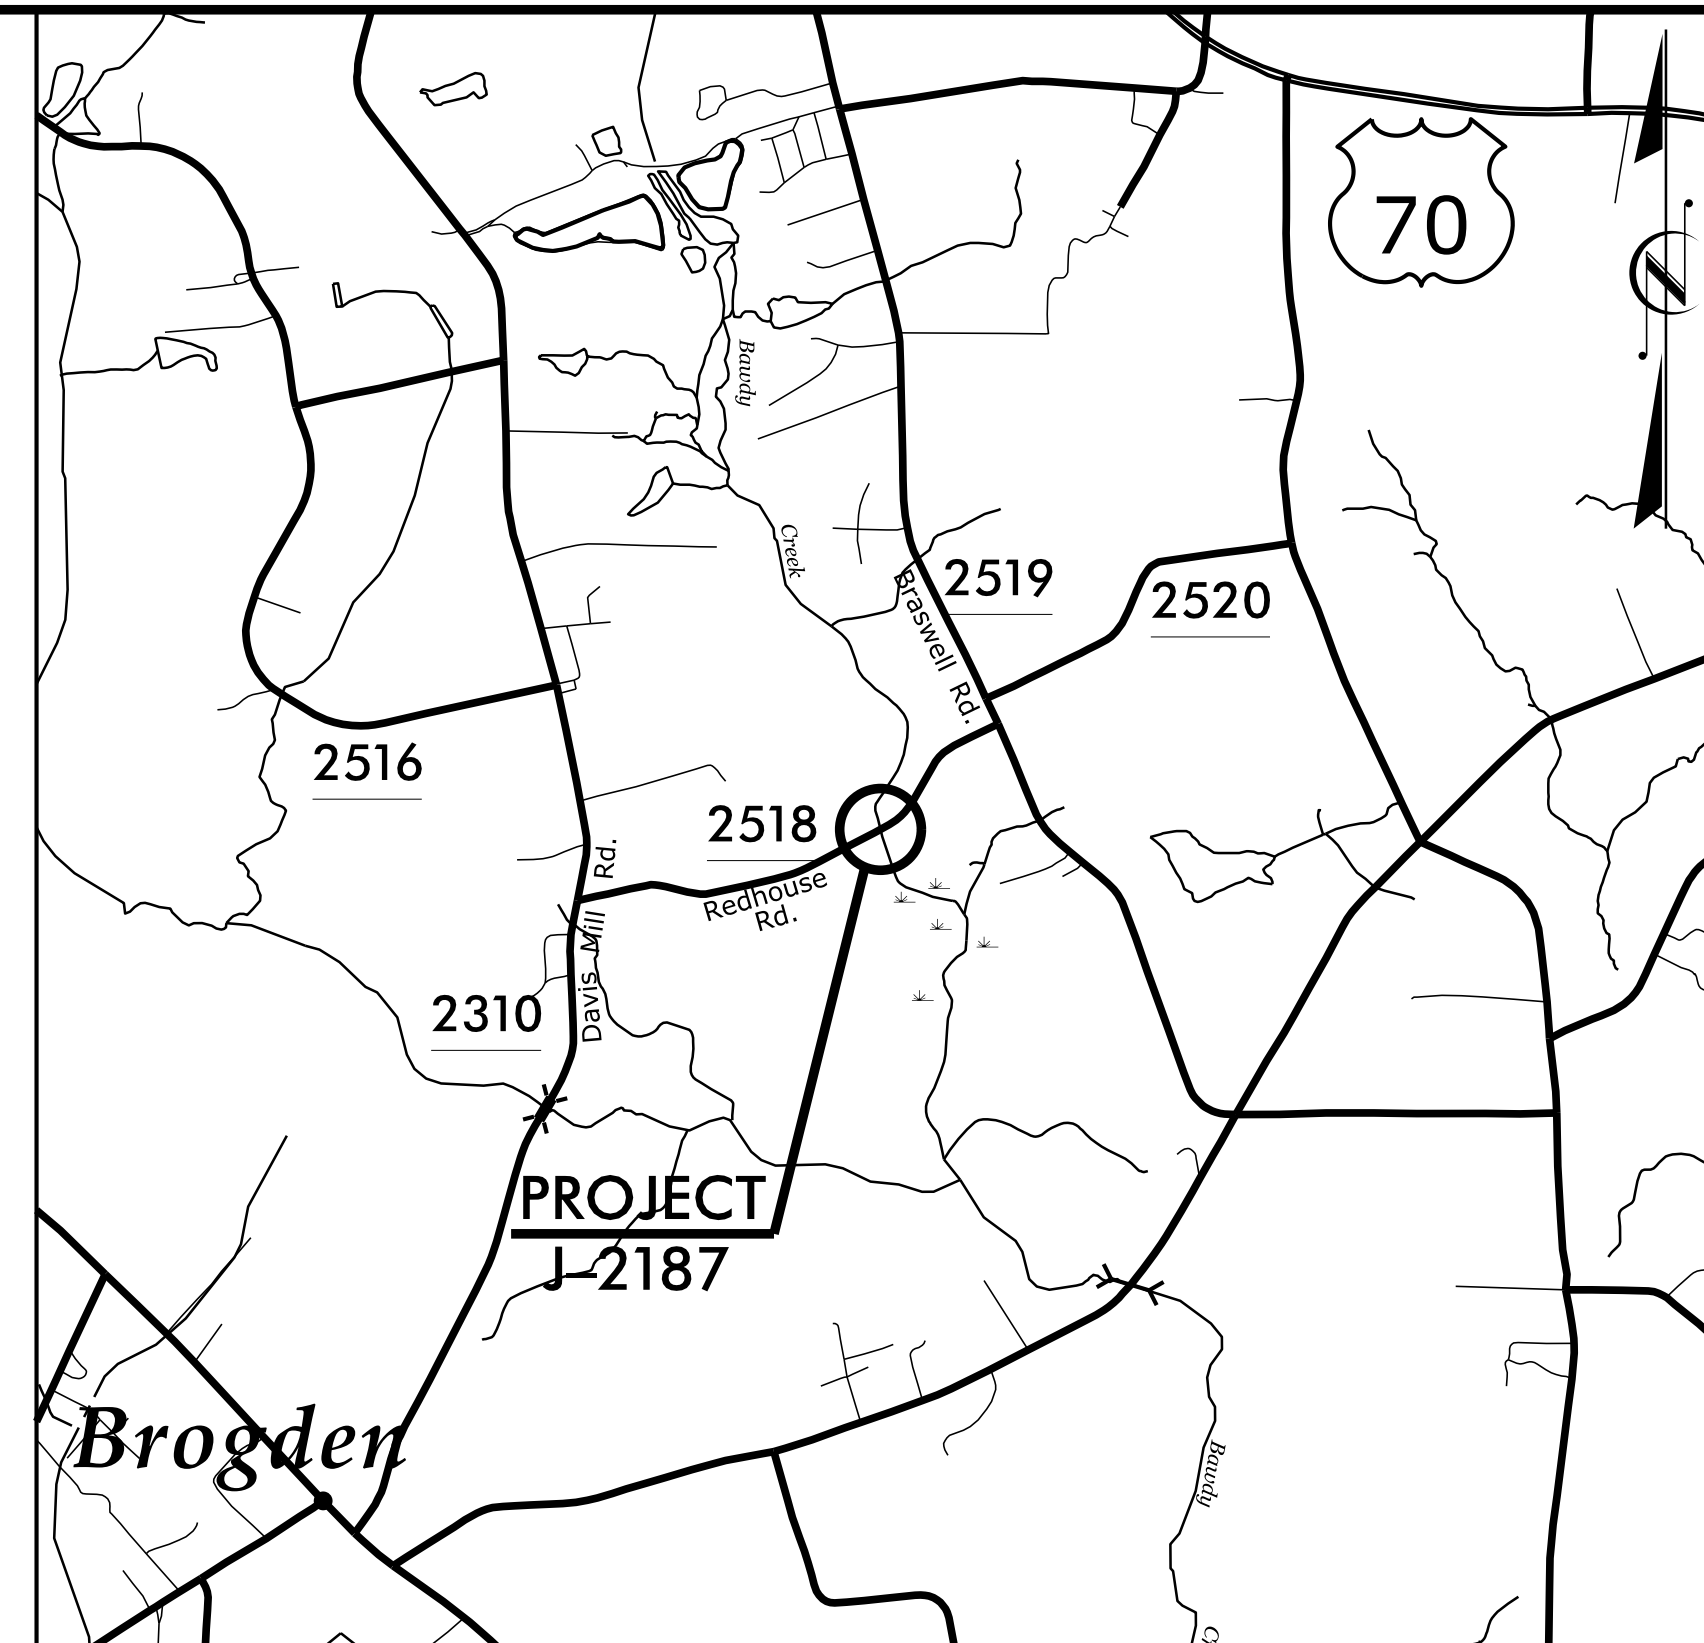

VICINITY MAP

<u>Std. #</u>	<u>Description</u>	<u>Symbol</u>
1605.01	Temporary Silt Fence	
1606.01	Special Sediment Control Fence	



SOIL STABILIZATION TIMEFRAMES

<i>SITE DESCRIPTION</i>	<i>STABILIZATION TIME</i>	<i>TIMEFRAME EXCEPTIONS</i>
PERIMETER DIKES, SWALES, DITCHES AND SLOPES	7 DAYS	NONE
HIGH QUALITY WATER (HOW) ZONES	7 DAYS	NONE
SLOPES STEEPER THAN 3:1	7 DAYS	IF SLOPES ARE 10' OR LESS IN LENGTH AND ARE NOT STEEPER THAN 2:1, 14 DAYS ARE ALLOWED.
SLOPES 3:1 OR FLATTER	14 DAYS	7 DAYS FOR SLOPES GREATER THAN 50' IN LENGTH.
ALL OTHER AREAS WITH SLOPES FLATTER THAN 4:1	14 DAYS	NONE, EXCEPT FOR PERIMETERS AND HOW ZONES.

D:\4000

20-MAY-2016 09:51
D:\DDC\pipe\pipe\wa2202\roadway\Proj\WA2202_Rdy.psh.dgn
D:\DDC

REVISIONS

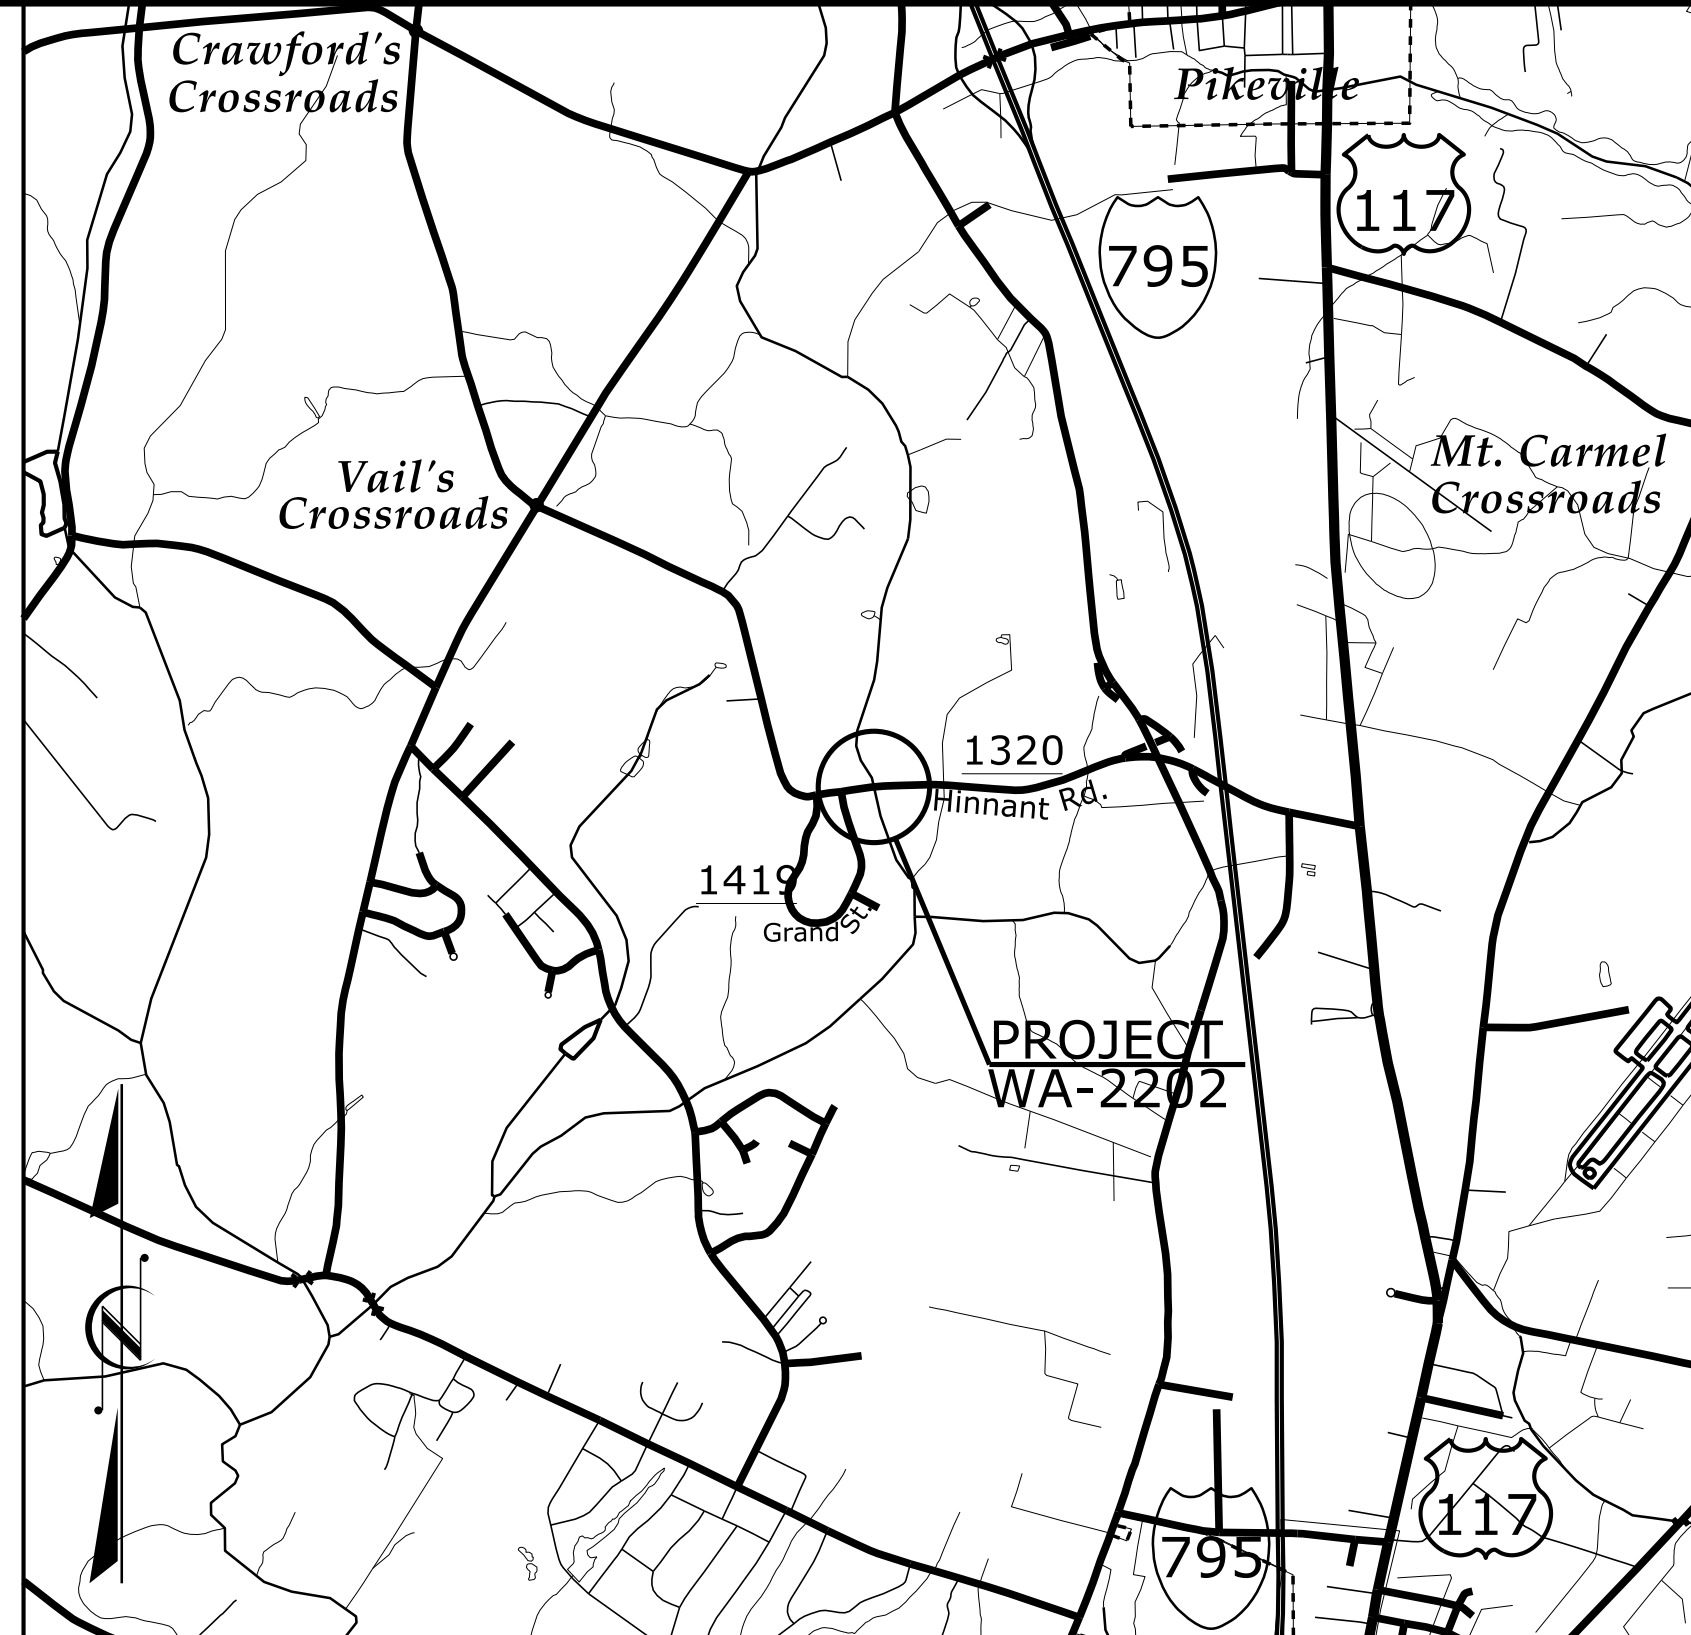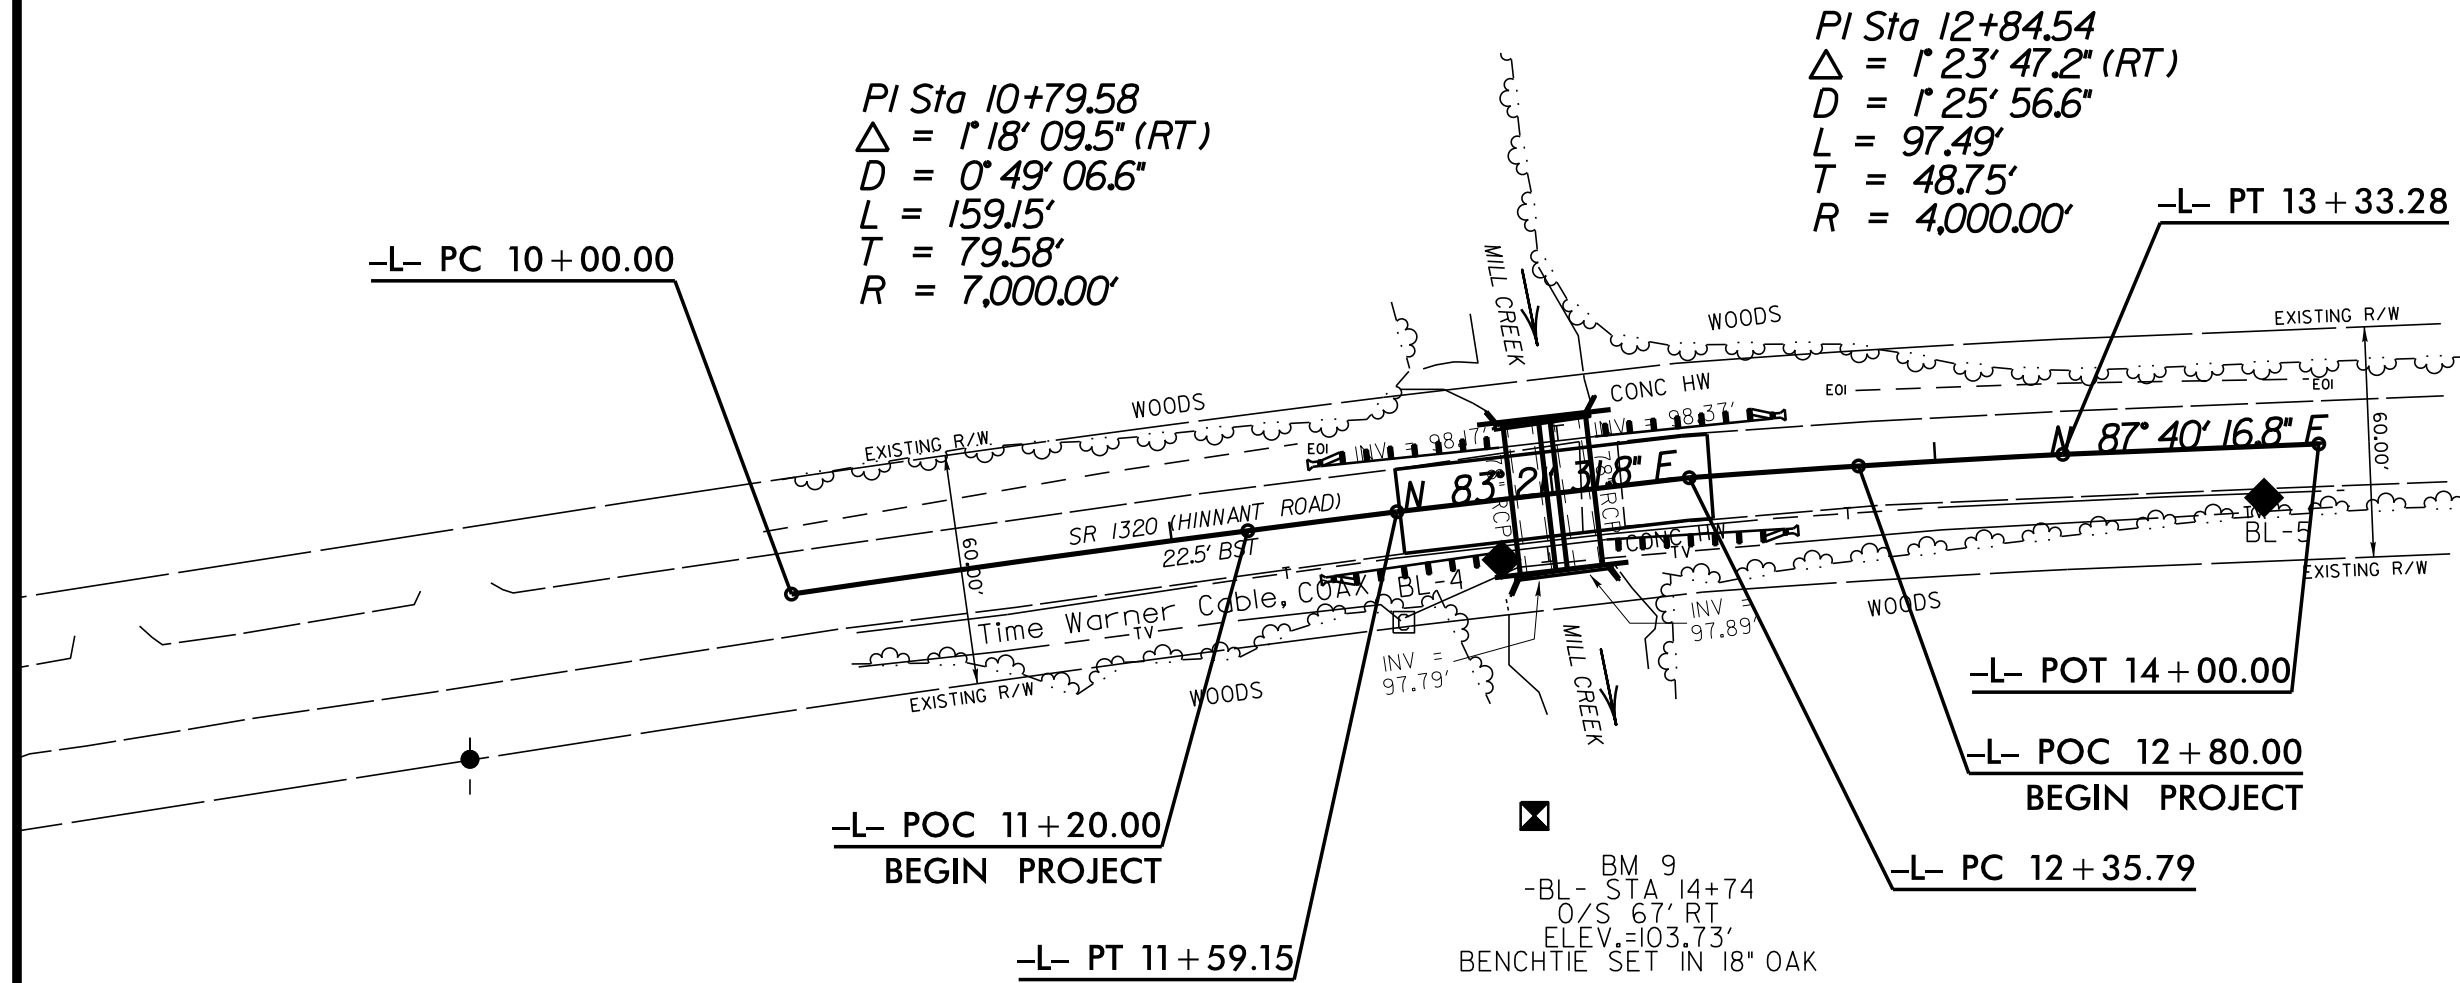

VICINITY MAP

STATE OF NORTH CAROLINA DIVISION OF HIGHWAYS WAYNE COUNTY

LOCATION: SR 1320 (HINNANT RD.) OVER MILL CREEK
TYPE OF WORK: REMOVE AND REPLACE PIPE

STATE	BRIDGE NUMBER	CONTRACT	SHEET NO.
N.C.	95-2202	DD00178	1
STATE PROJ. NO.	F. A. PROJ. NO.	DESCRIPTION	
17BP.4.C.4		PE, CONST.	
ROADWAY DESIGN ENGINEER 5/24/2016 NORTH CAROLINA PROFESSIONAL SEAL 040257 W. MATTHEW CLARK DocuSign W. Matthew Clark		HYDRAULICS ENGINEER (PIPE SIZE) 5/24/2016 NORTH CAROLINA PROFESSIONAL SEAL 034349 PAUL A. JORDAN DocuSign Paul A. Jordan	GRAPHIC SCALES 50 25 0 50 PLANS 50 25 0 50 PROFILE (HORIZONTAL) 10 5 0 10 PROFILE (VERTICAL)
DOCUMENT NOT CONSIDERED FINAL UNLESS ALL SIGNATURES COMPLETED			


Prepared in the Office of:
DIVISION OF HIGHWAYS
Division 4 DDC
509 Ward Blvd., Wilson NC, 27895

2012 STANDARD SPECIFICATIONS	TIM LITTLE, PE PROJECT ENGINEER D.R. ETHRIDGE PROJECT DESIGN ENGINEER
LETTING DATE: JUNE 2016	

PAVEMENT SCHEDULE

C1	PROP. APPROX. 1.5" ASPHALT CONCRETE SURFACE COURSE, TYPE S9.5B, AT AN AVERAGE RATE OF 168 LBS. PER SQ. YARD.
T	EARTH MATERIAL
E1	PROP. APPROX. 4" ASPHALT CONCRETE BASE COURSE, TYPE B25.0B, AT AN AVERAGE RATE OF 456 LBS. PER SQ. YARD.


NOTE: PAVEMENT EDGE SLOPES ARE 1:1 UNLESS SHOWN OTHERWISE.

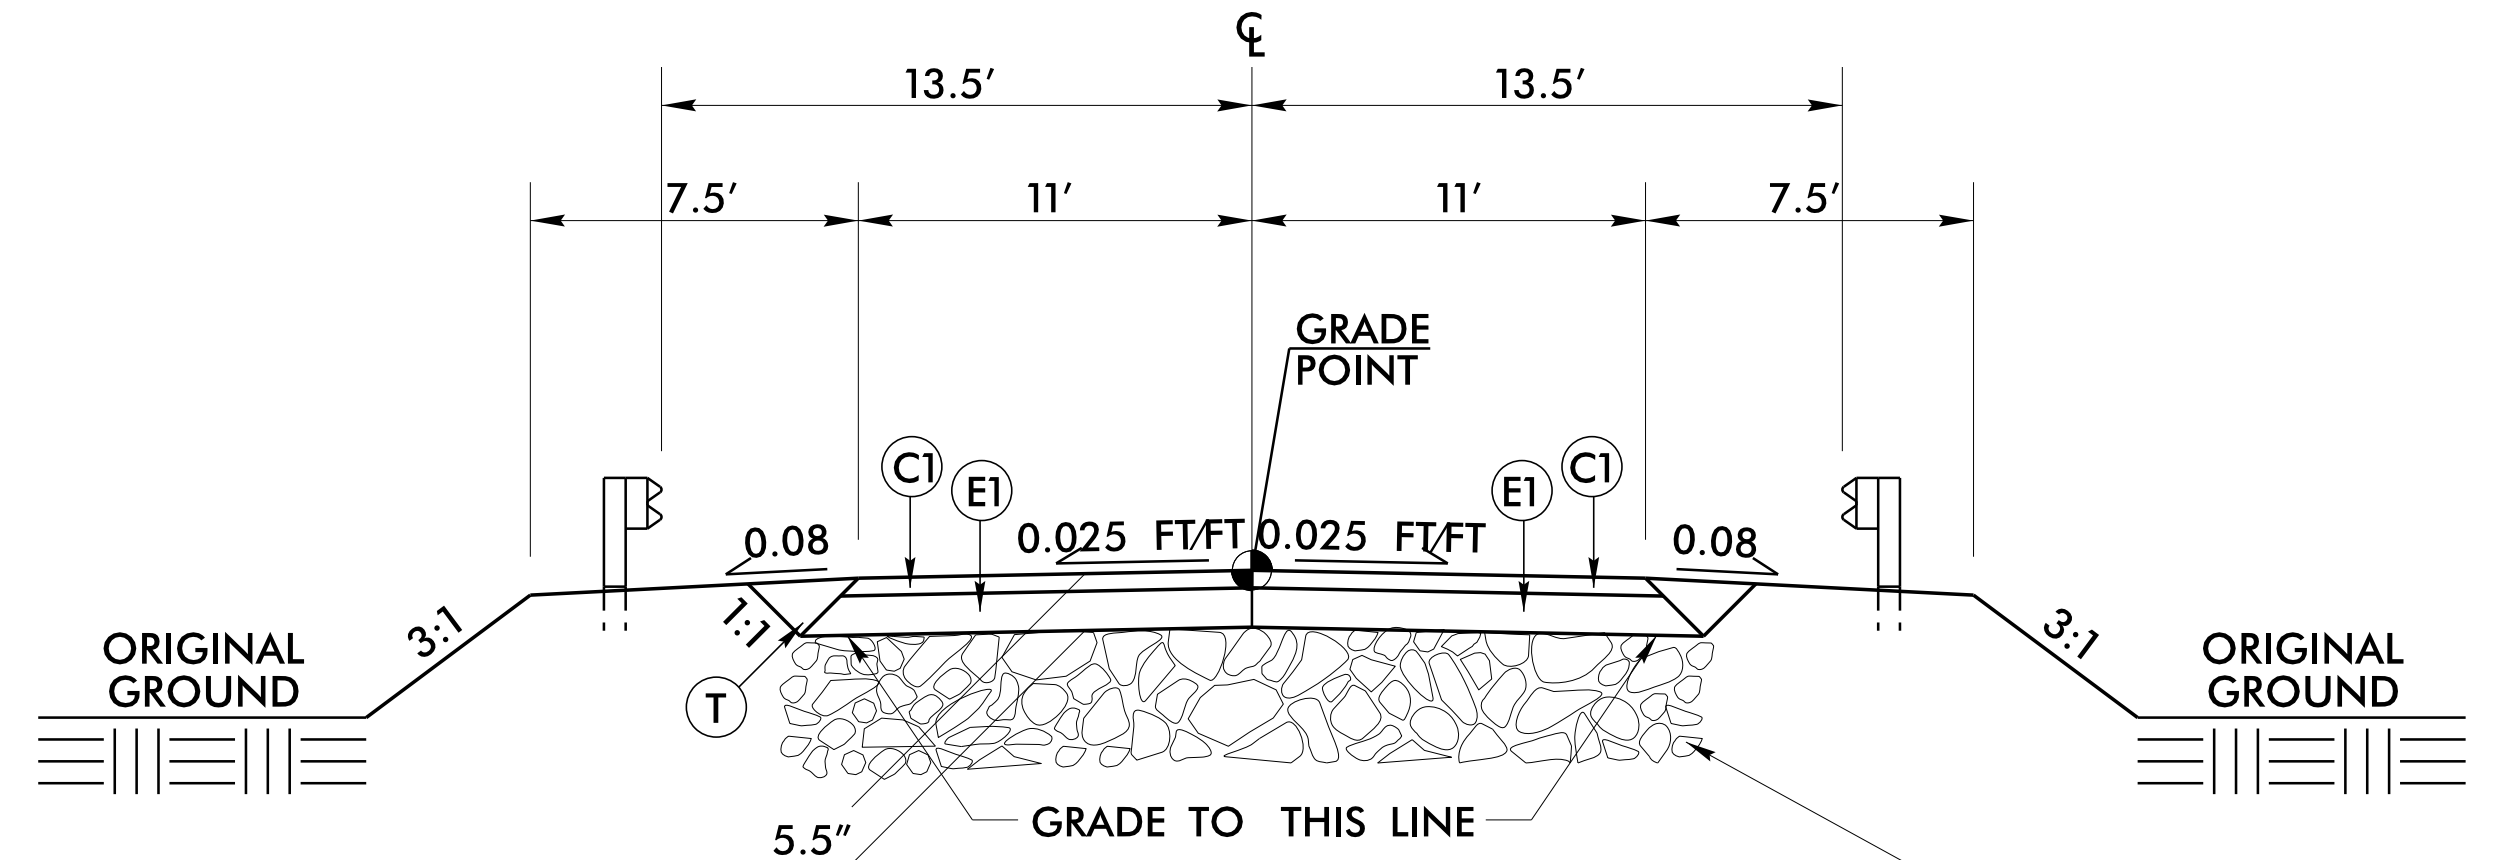


TYPICAL SECTION NO. 1

USE TYPICAL SECTION NO. 1
-L- 11+20.00 TO 12+80.00

TYPICAL SECTION 2@112"x75" CMPA

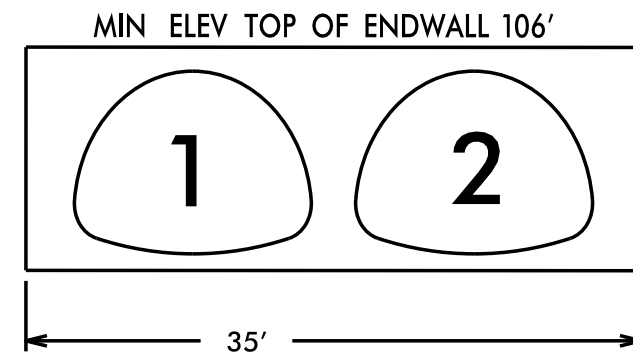


PIPE 1 LENGTH = 40 FT
PIPE 1 C STATION = 11+93.83
PIPE 2 LENGTH = 40 FT
PIPE 2 C STATION = 12+06.17

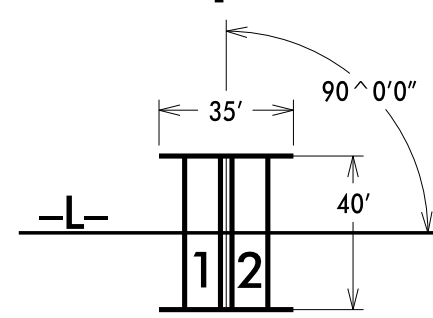

GUARDRAIL DATA


STATION		LOC	LENGTH	FROM CL	ANCHORS	NOTES
BEGIN	END					
11+37.5	12+62.5	LT	125.0	13.5	2	25' NESTED
11+37.5	12+62.5	RT	125.0	13.5	2	25' NESTED
SUBTOTAL			250.0		4	
GRAU350 4*50			-200.0			
TOTAL			50.0		4	
10 ADDITIONAL GUARDRAIL POSTS						

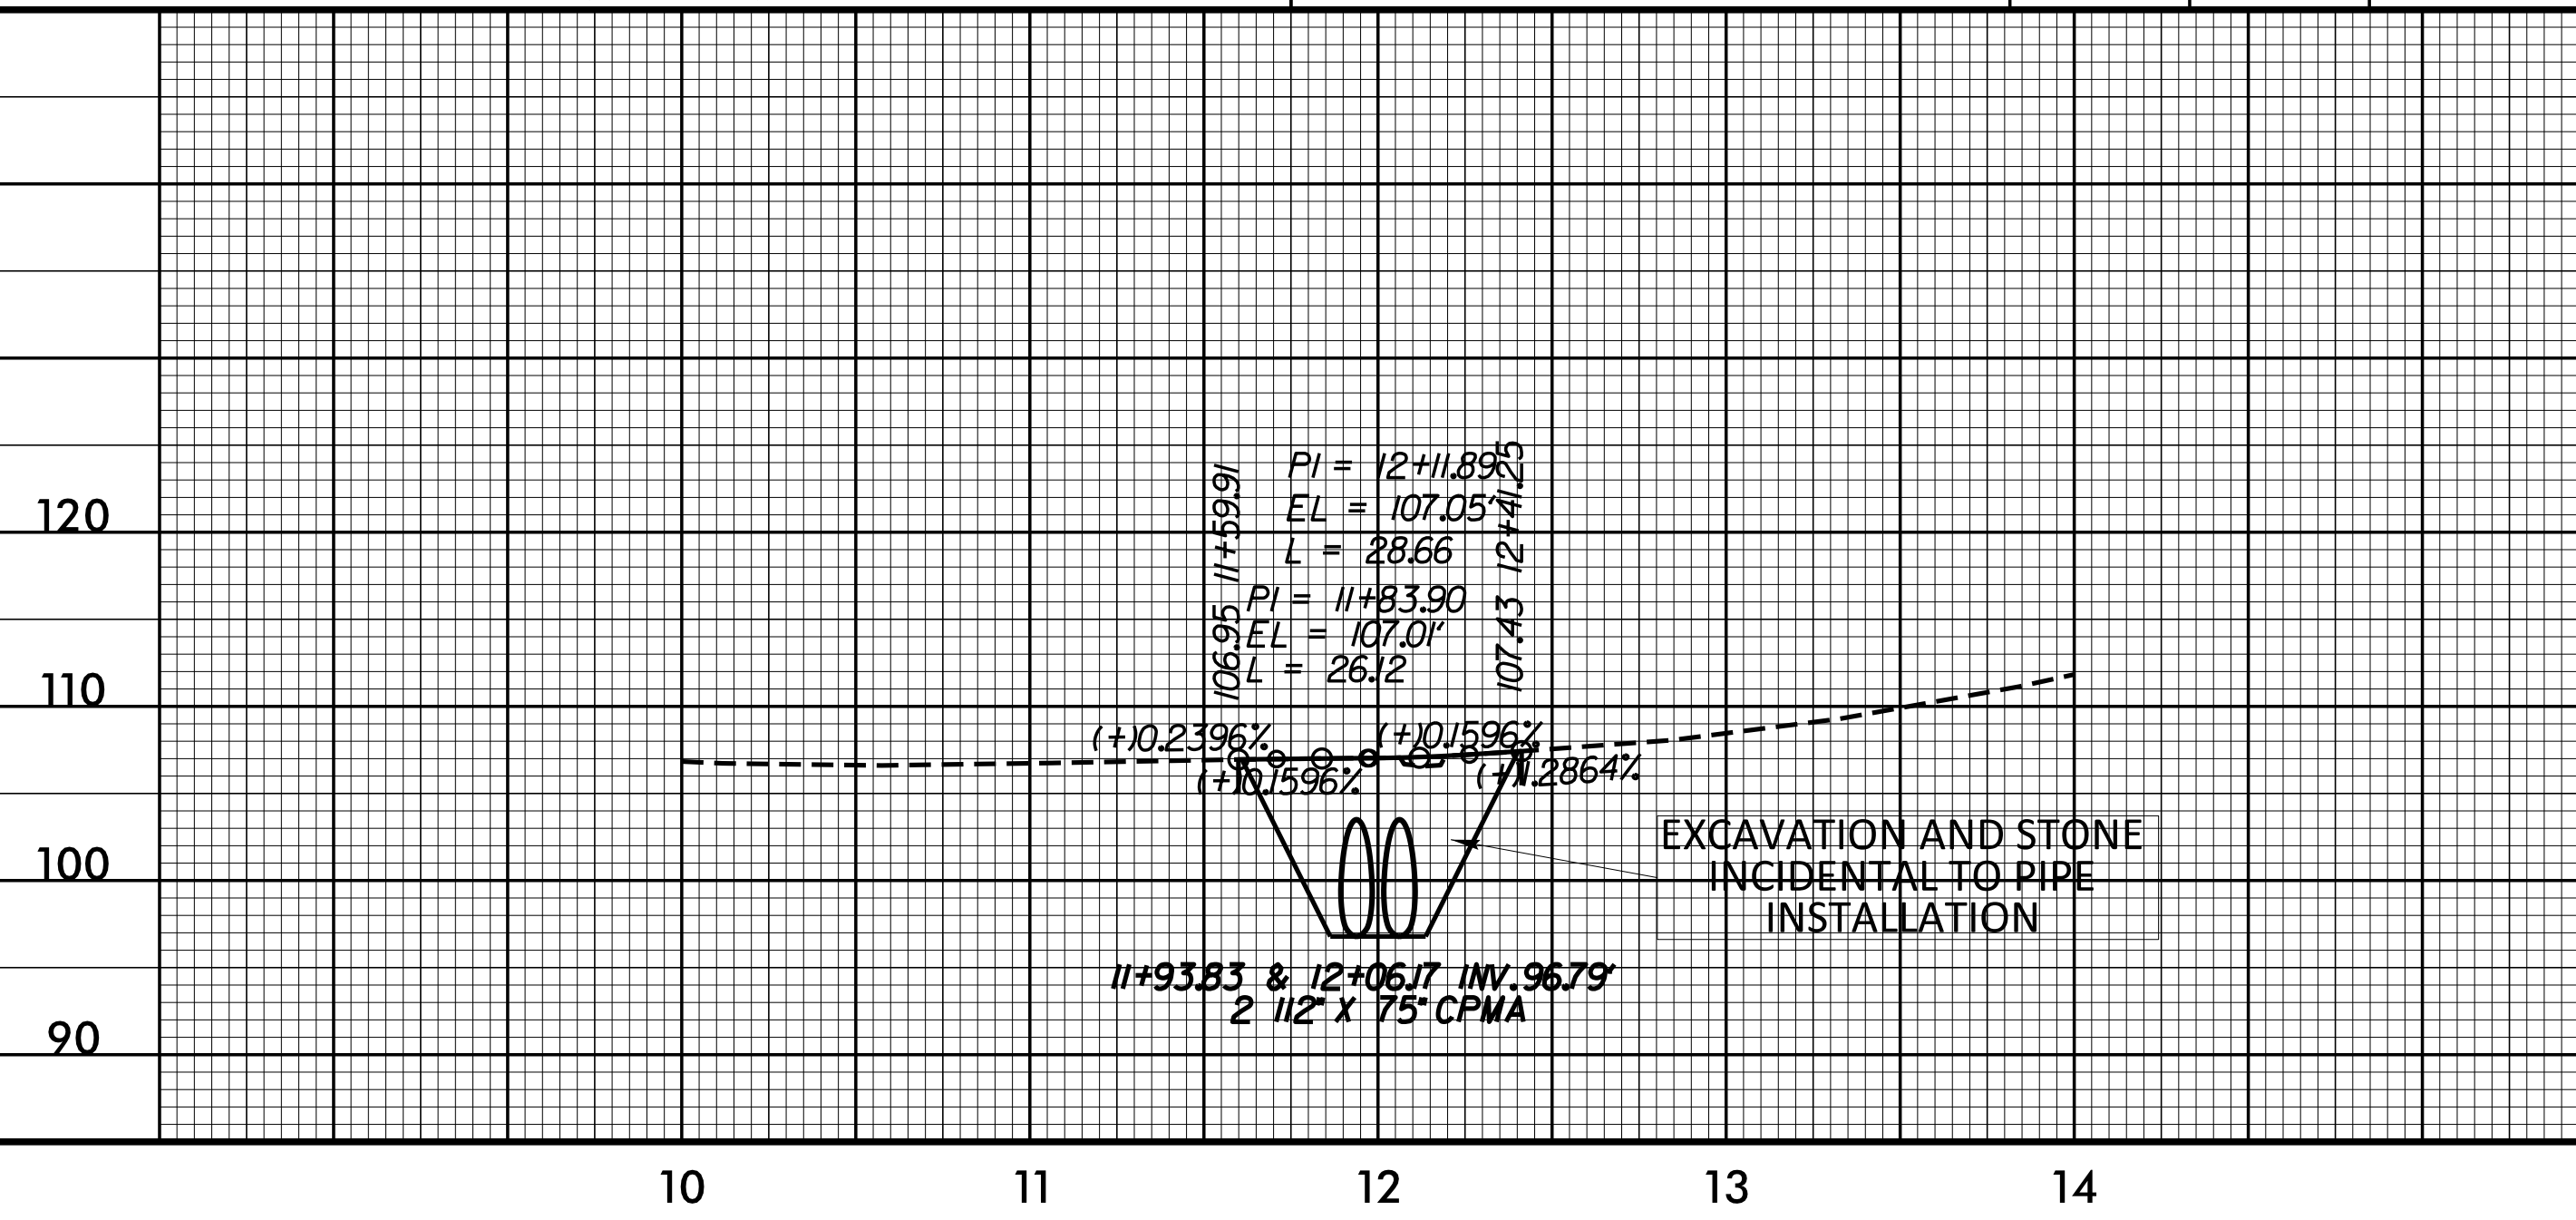

D:\400



24-MAY-2016 11:48
D:\DDC\pipelines\wa2202\roadway\Proj\WA2202_Rdy_psh_esc.dgn
D:\DDC

REVISIONS

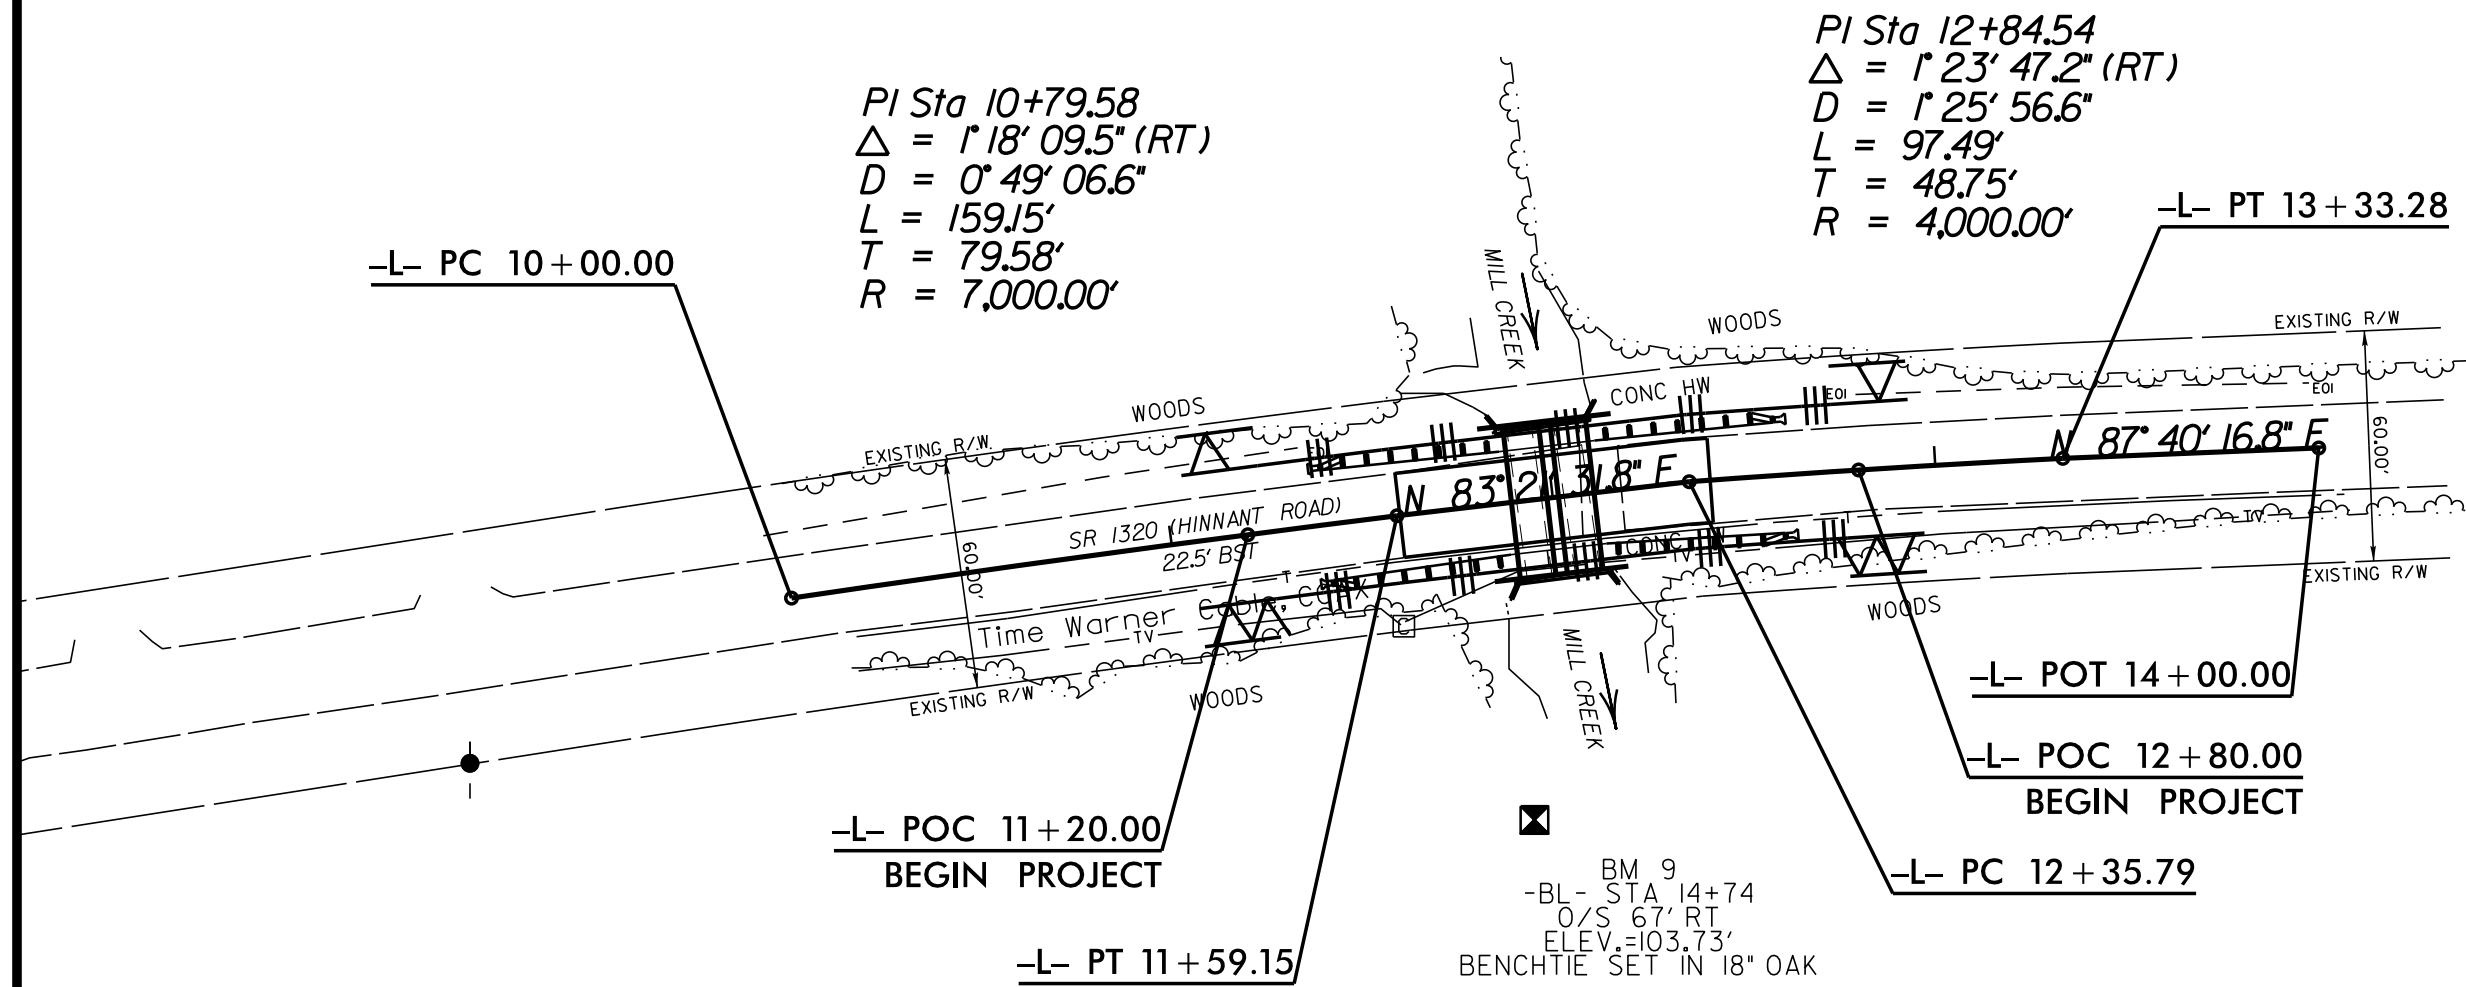

INSTALL SPECIAL SEDIMENT CONTROL FENCE IN LOW
POINTS OF SILT FENCE AS NEEDED

INSTALL SILT FENCE TO CONTAIN
TEMPORARY EARTH MATERIAL STOCKPILES

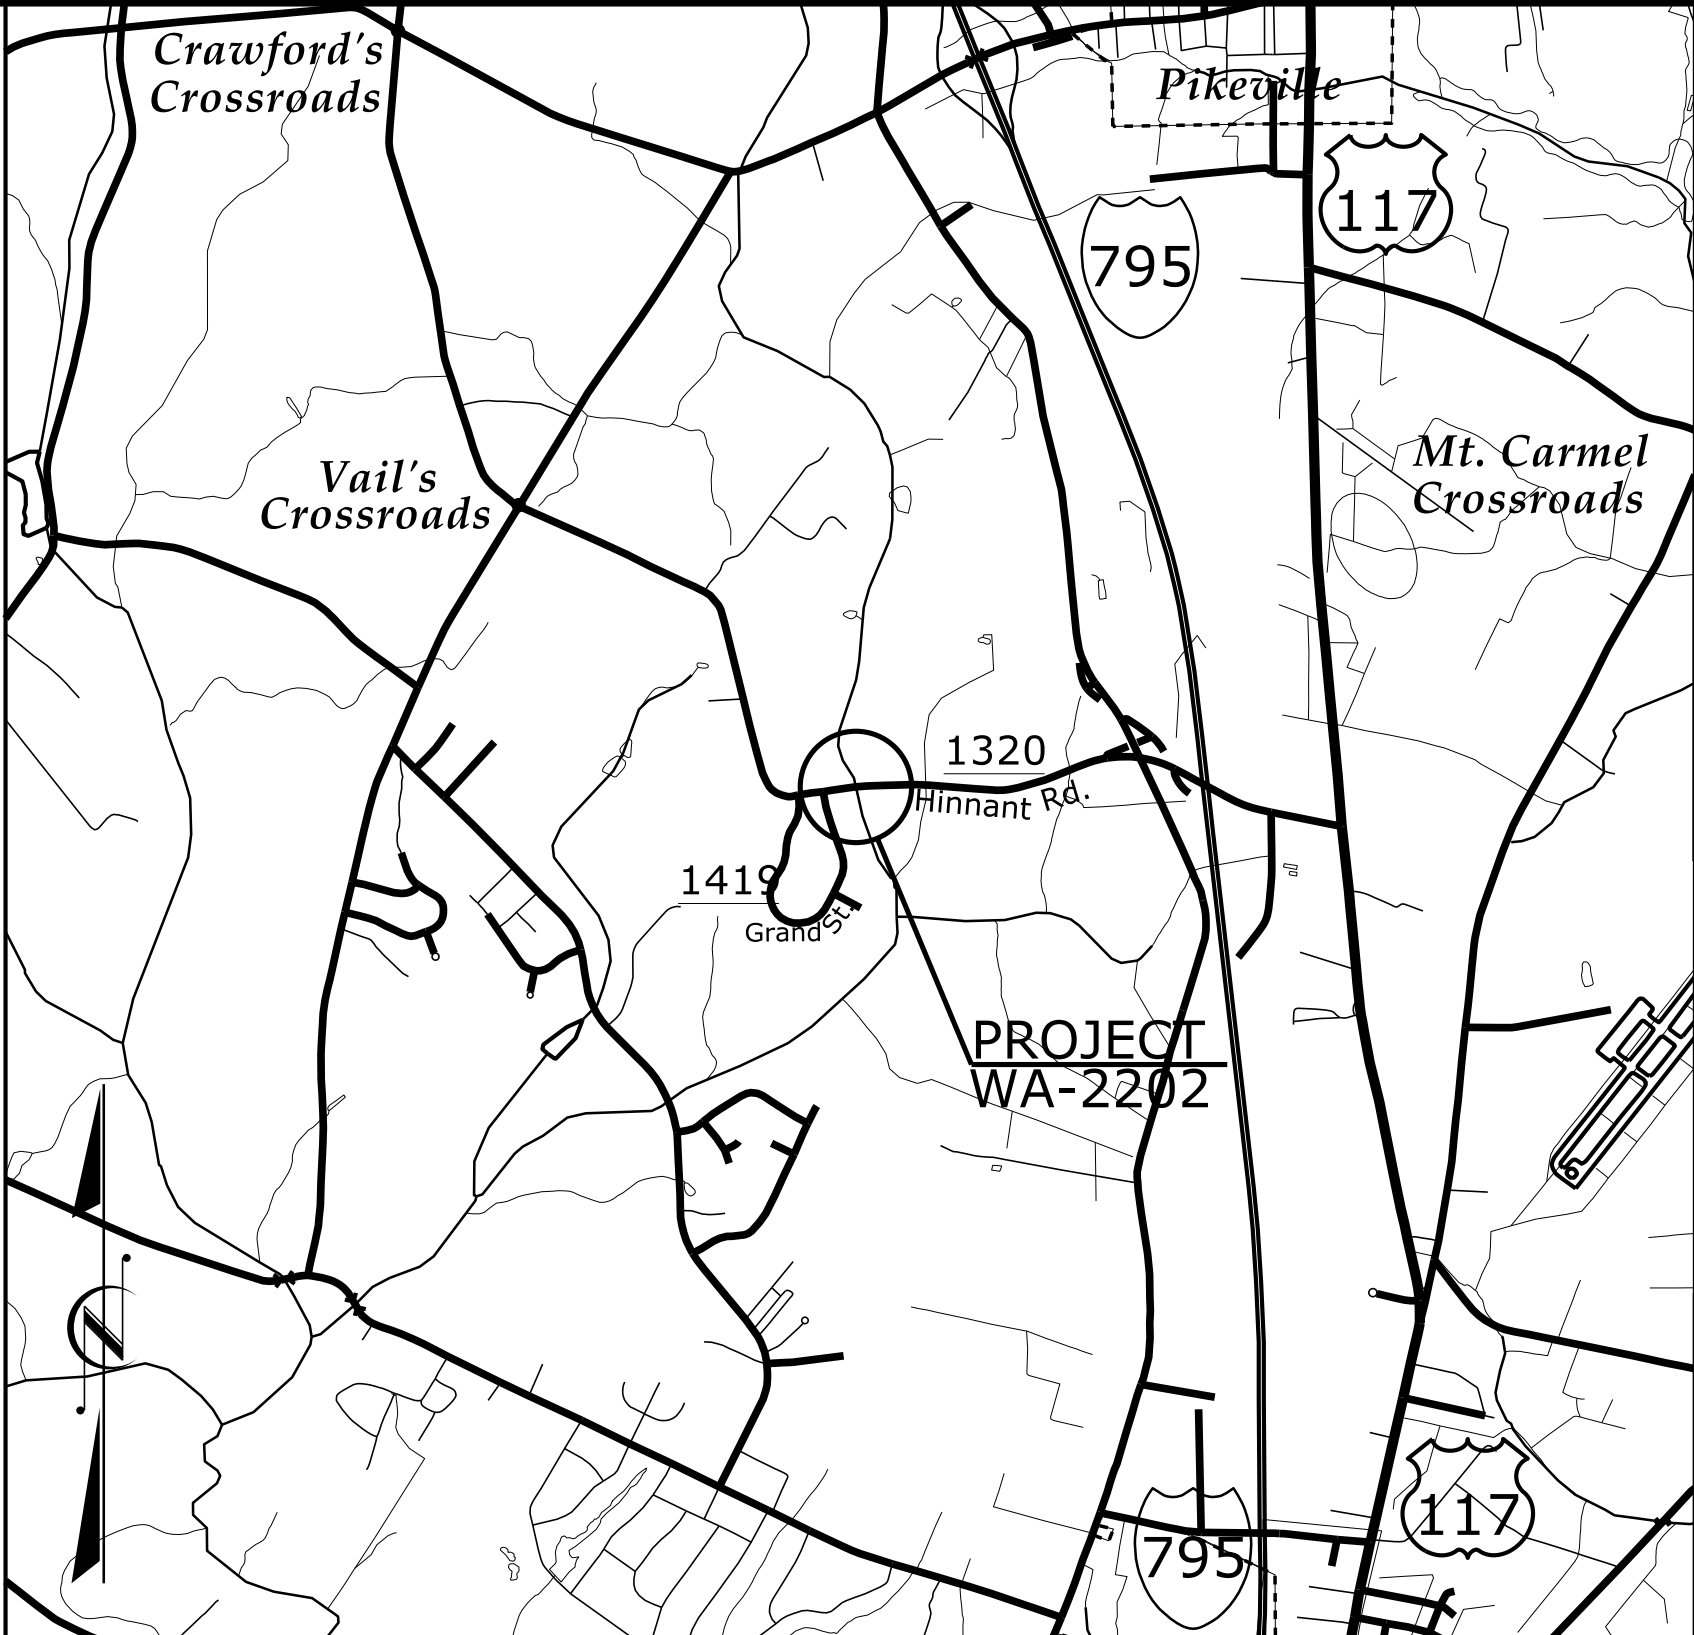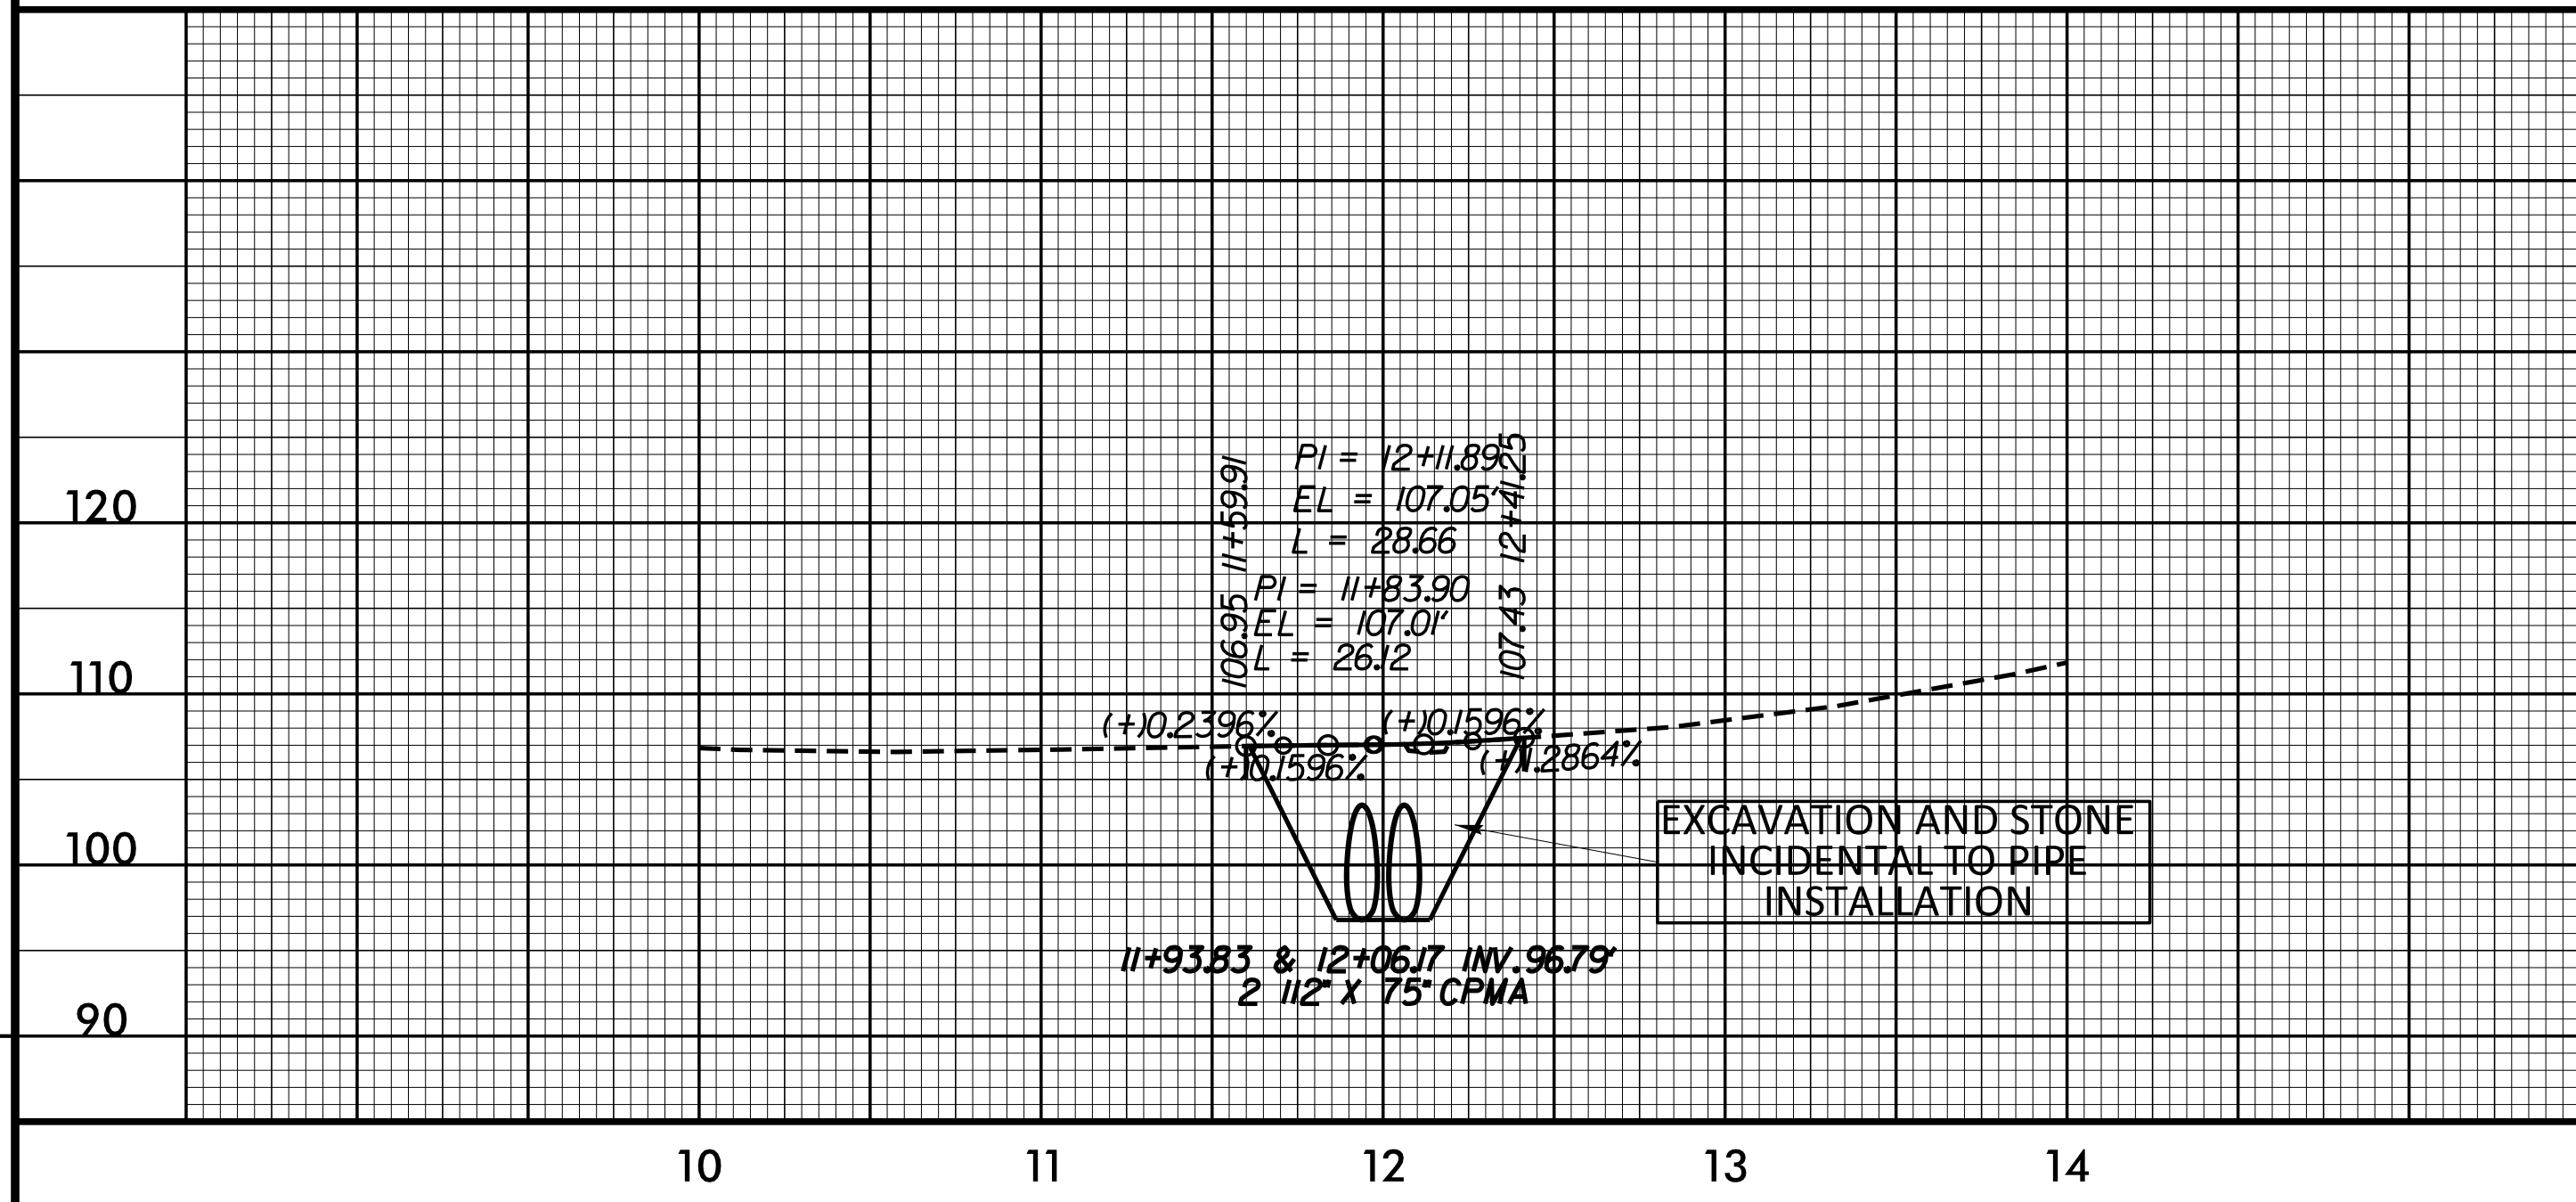

VICINITY MAP

Std. #	Description	Symbol
1605.01	Temporary Silt Fence	
1606.01	Special Sediment Control Fence	

SOIL STABILIZATION TIMEFRAMES

SITE DESCRIPTION	STABILIZATION TIME	TIMEFRAME EXCEPTIONS
PERIMETER DIKS, SWALES, DITCHES AND SLOPES	7 DAYS	NONE
HIGH QUALITY WATER (HOW) ZONES	7 DAYS	NONE
SLOPES STEEPER THAN 3:1	7 DAYS	IF SLOPES ARE 10' OR LESS IN LENGTH AND ARE NOT STEEPER THAN 2:1, 14 DAYS ARE ALLOWED.
SLOPES 3:1 OR FLATTER	14 DAYS	7 DAYS FOR SLOPES GREATER THAN 50' IN LENGTH.
ALL OTHER AREAS WITH SLOPES FLATTER THAN 4:1	14 DAYS	NONE, EXCEPT FOR PERIMETERS AND HOW ZONES.


STATE OF NORTH CAROLINA

DIVISION OF HIGHWAYS

PLAN FOR PROPOSED
HIGHWAY EROSION CONTROL

STATE	BRIDGE NUMBER	CONTRACT	SHEET NO.
N.C.	95-2202	DD00178	1
STATE PROJ. NO.	F. A. PROJ. NO.	DESCRIPTION	
17BP.4.C.4		PE, CONST.	

THESE EROSION AND SEDIMENT CONTROL PLANS COMPLY WITH THE REGULATIONS SET FORTH BY THE NCG-010000 GENERAL CONSTRUCTION PERMIT EFFECTIVE AUGUST 3, 2011 ISSUED BY THE NORTH CAROLINA DEPARTMENT OF ENVIRONMENT AND NATURAL RESOURCES DIVISION OF WATER QUALITY.

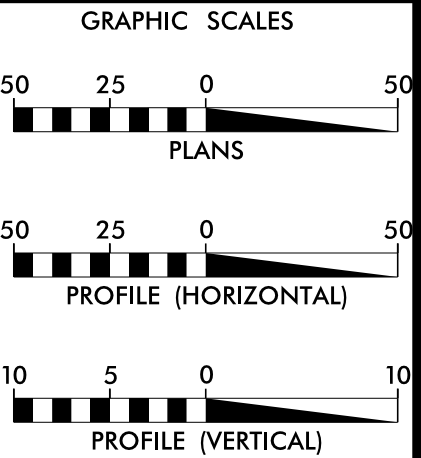

Prepared in the Office of:


ROADSIDE ENVIRONMENTAL UNIT
2012 STANDARD SPECIFICATIONS


Designed by:

AARON HARPER
NAME

3390

LEVEL III CERTIFICATION NO.

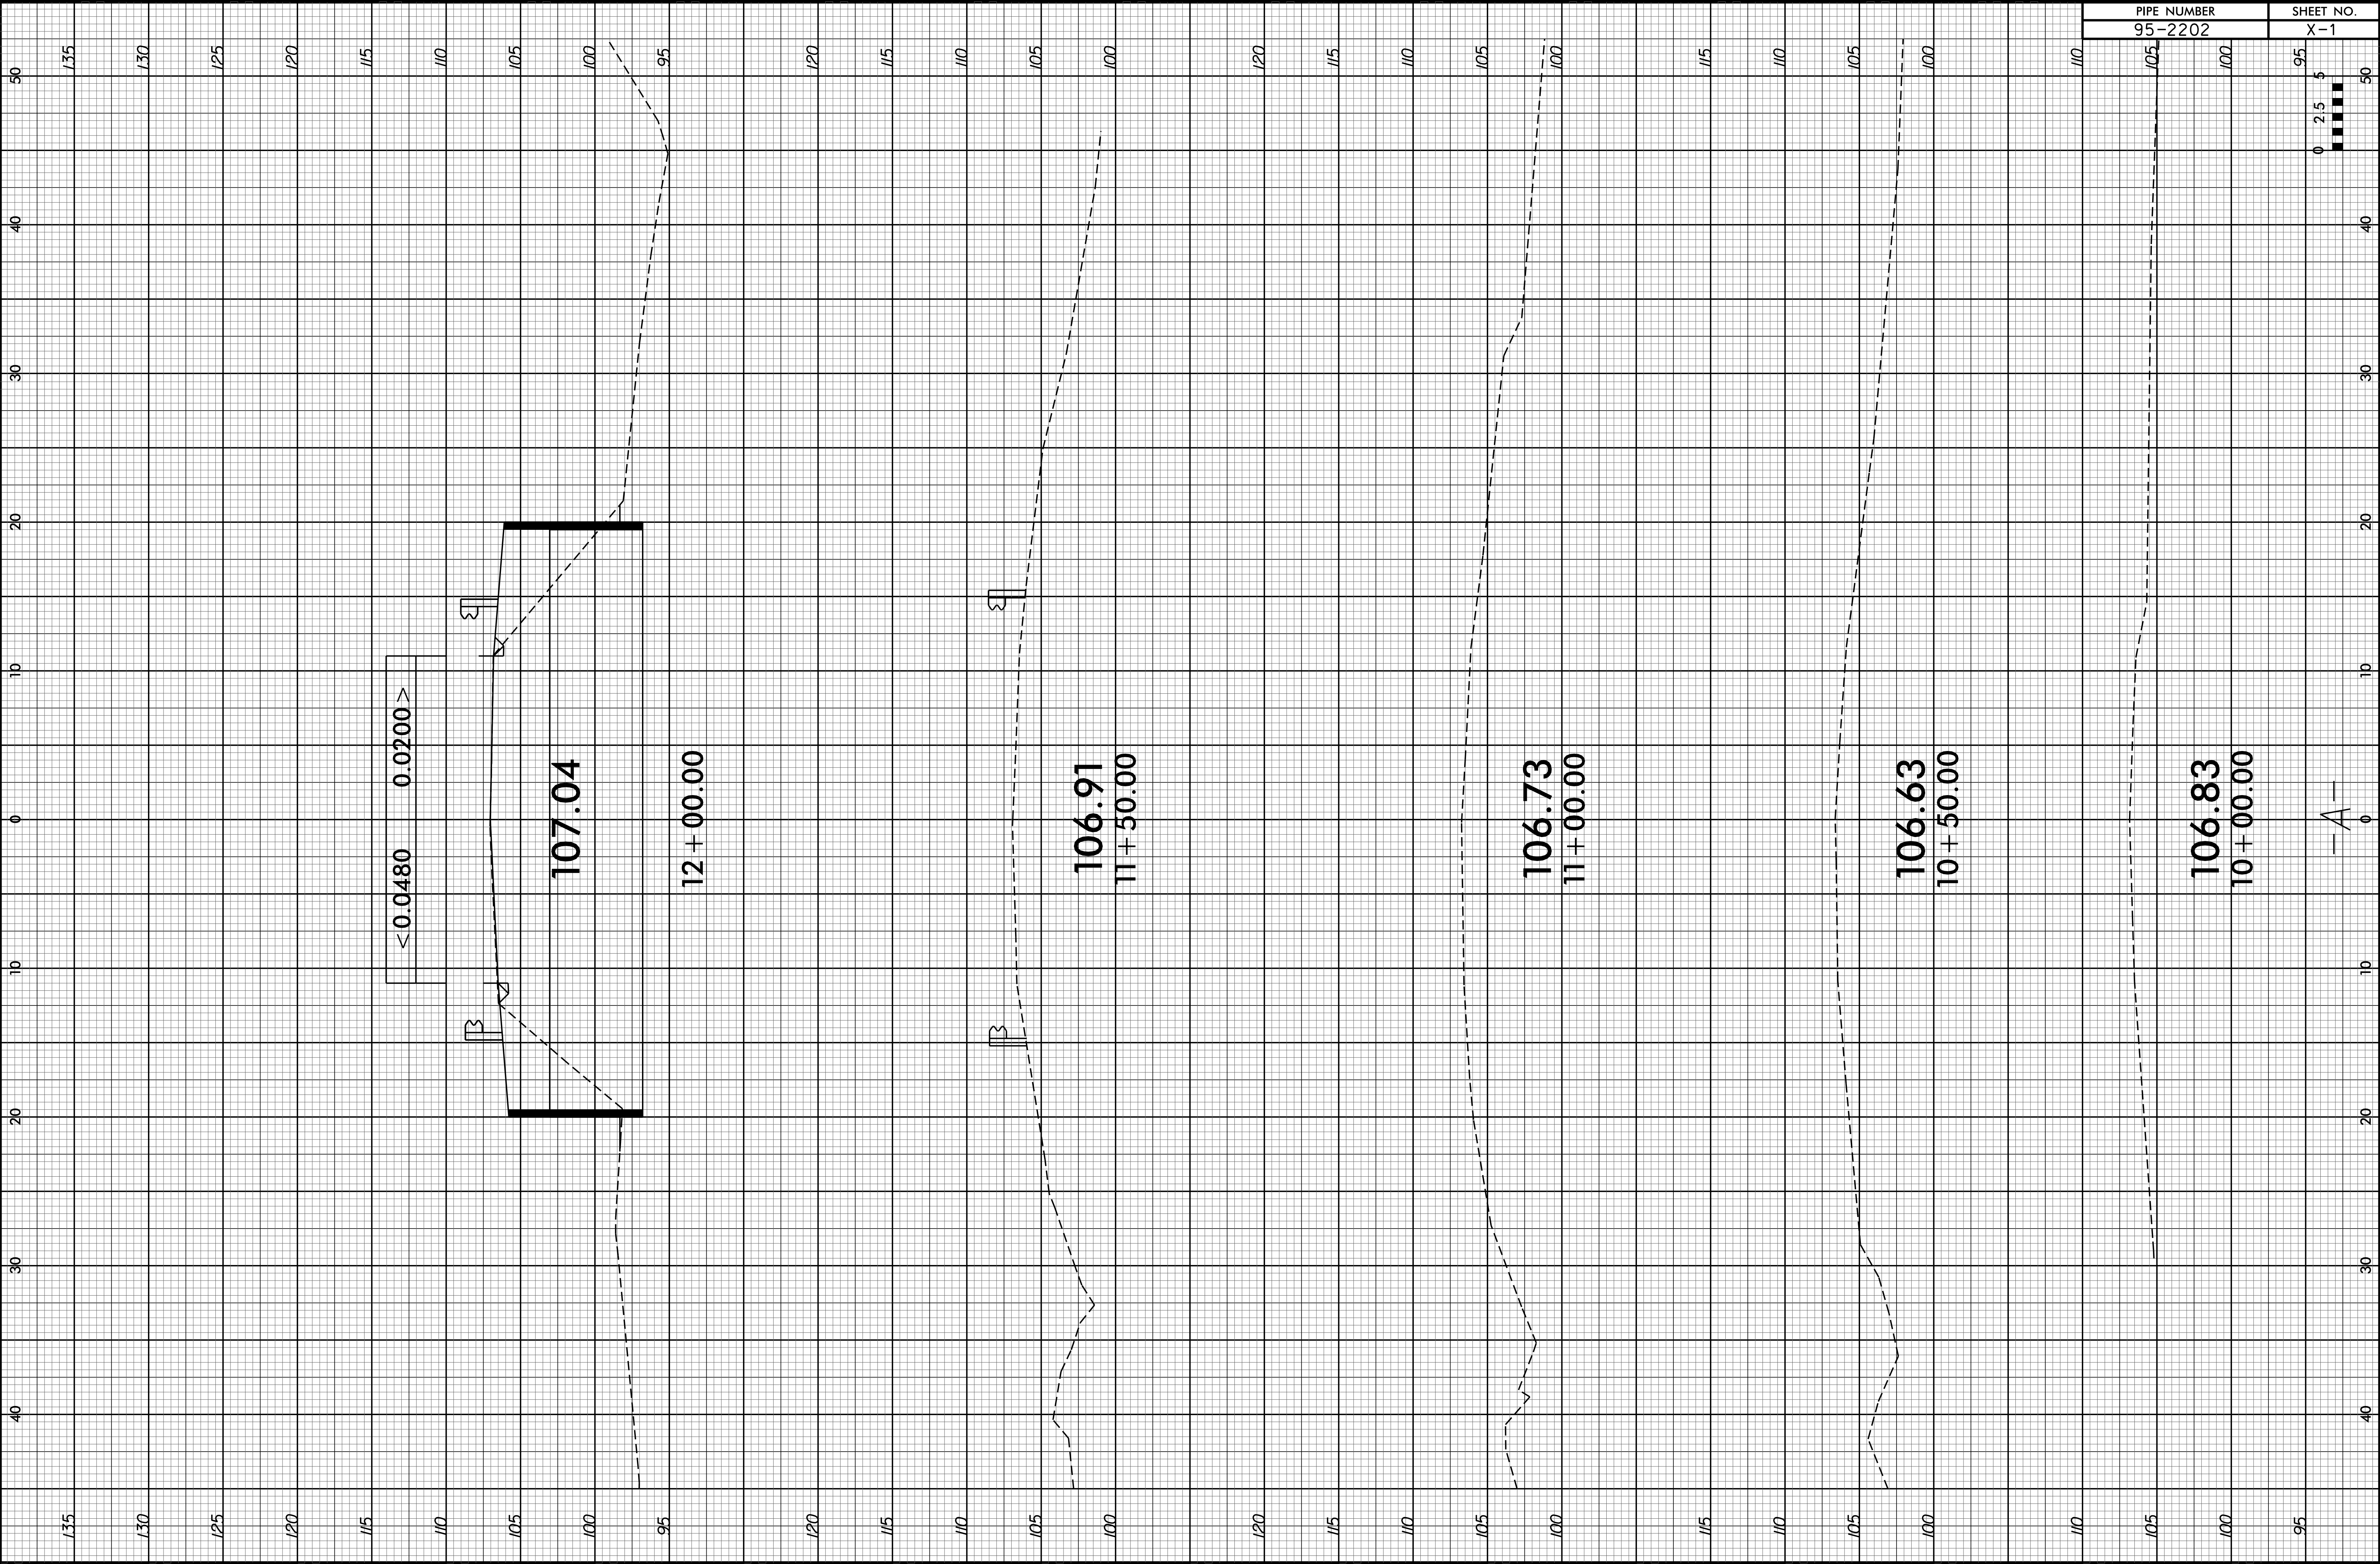

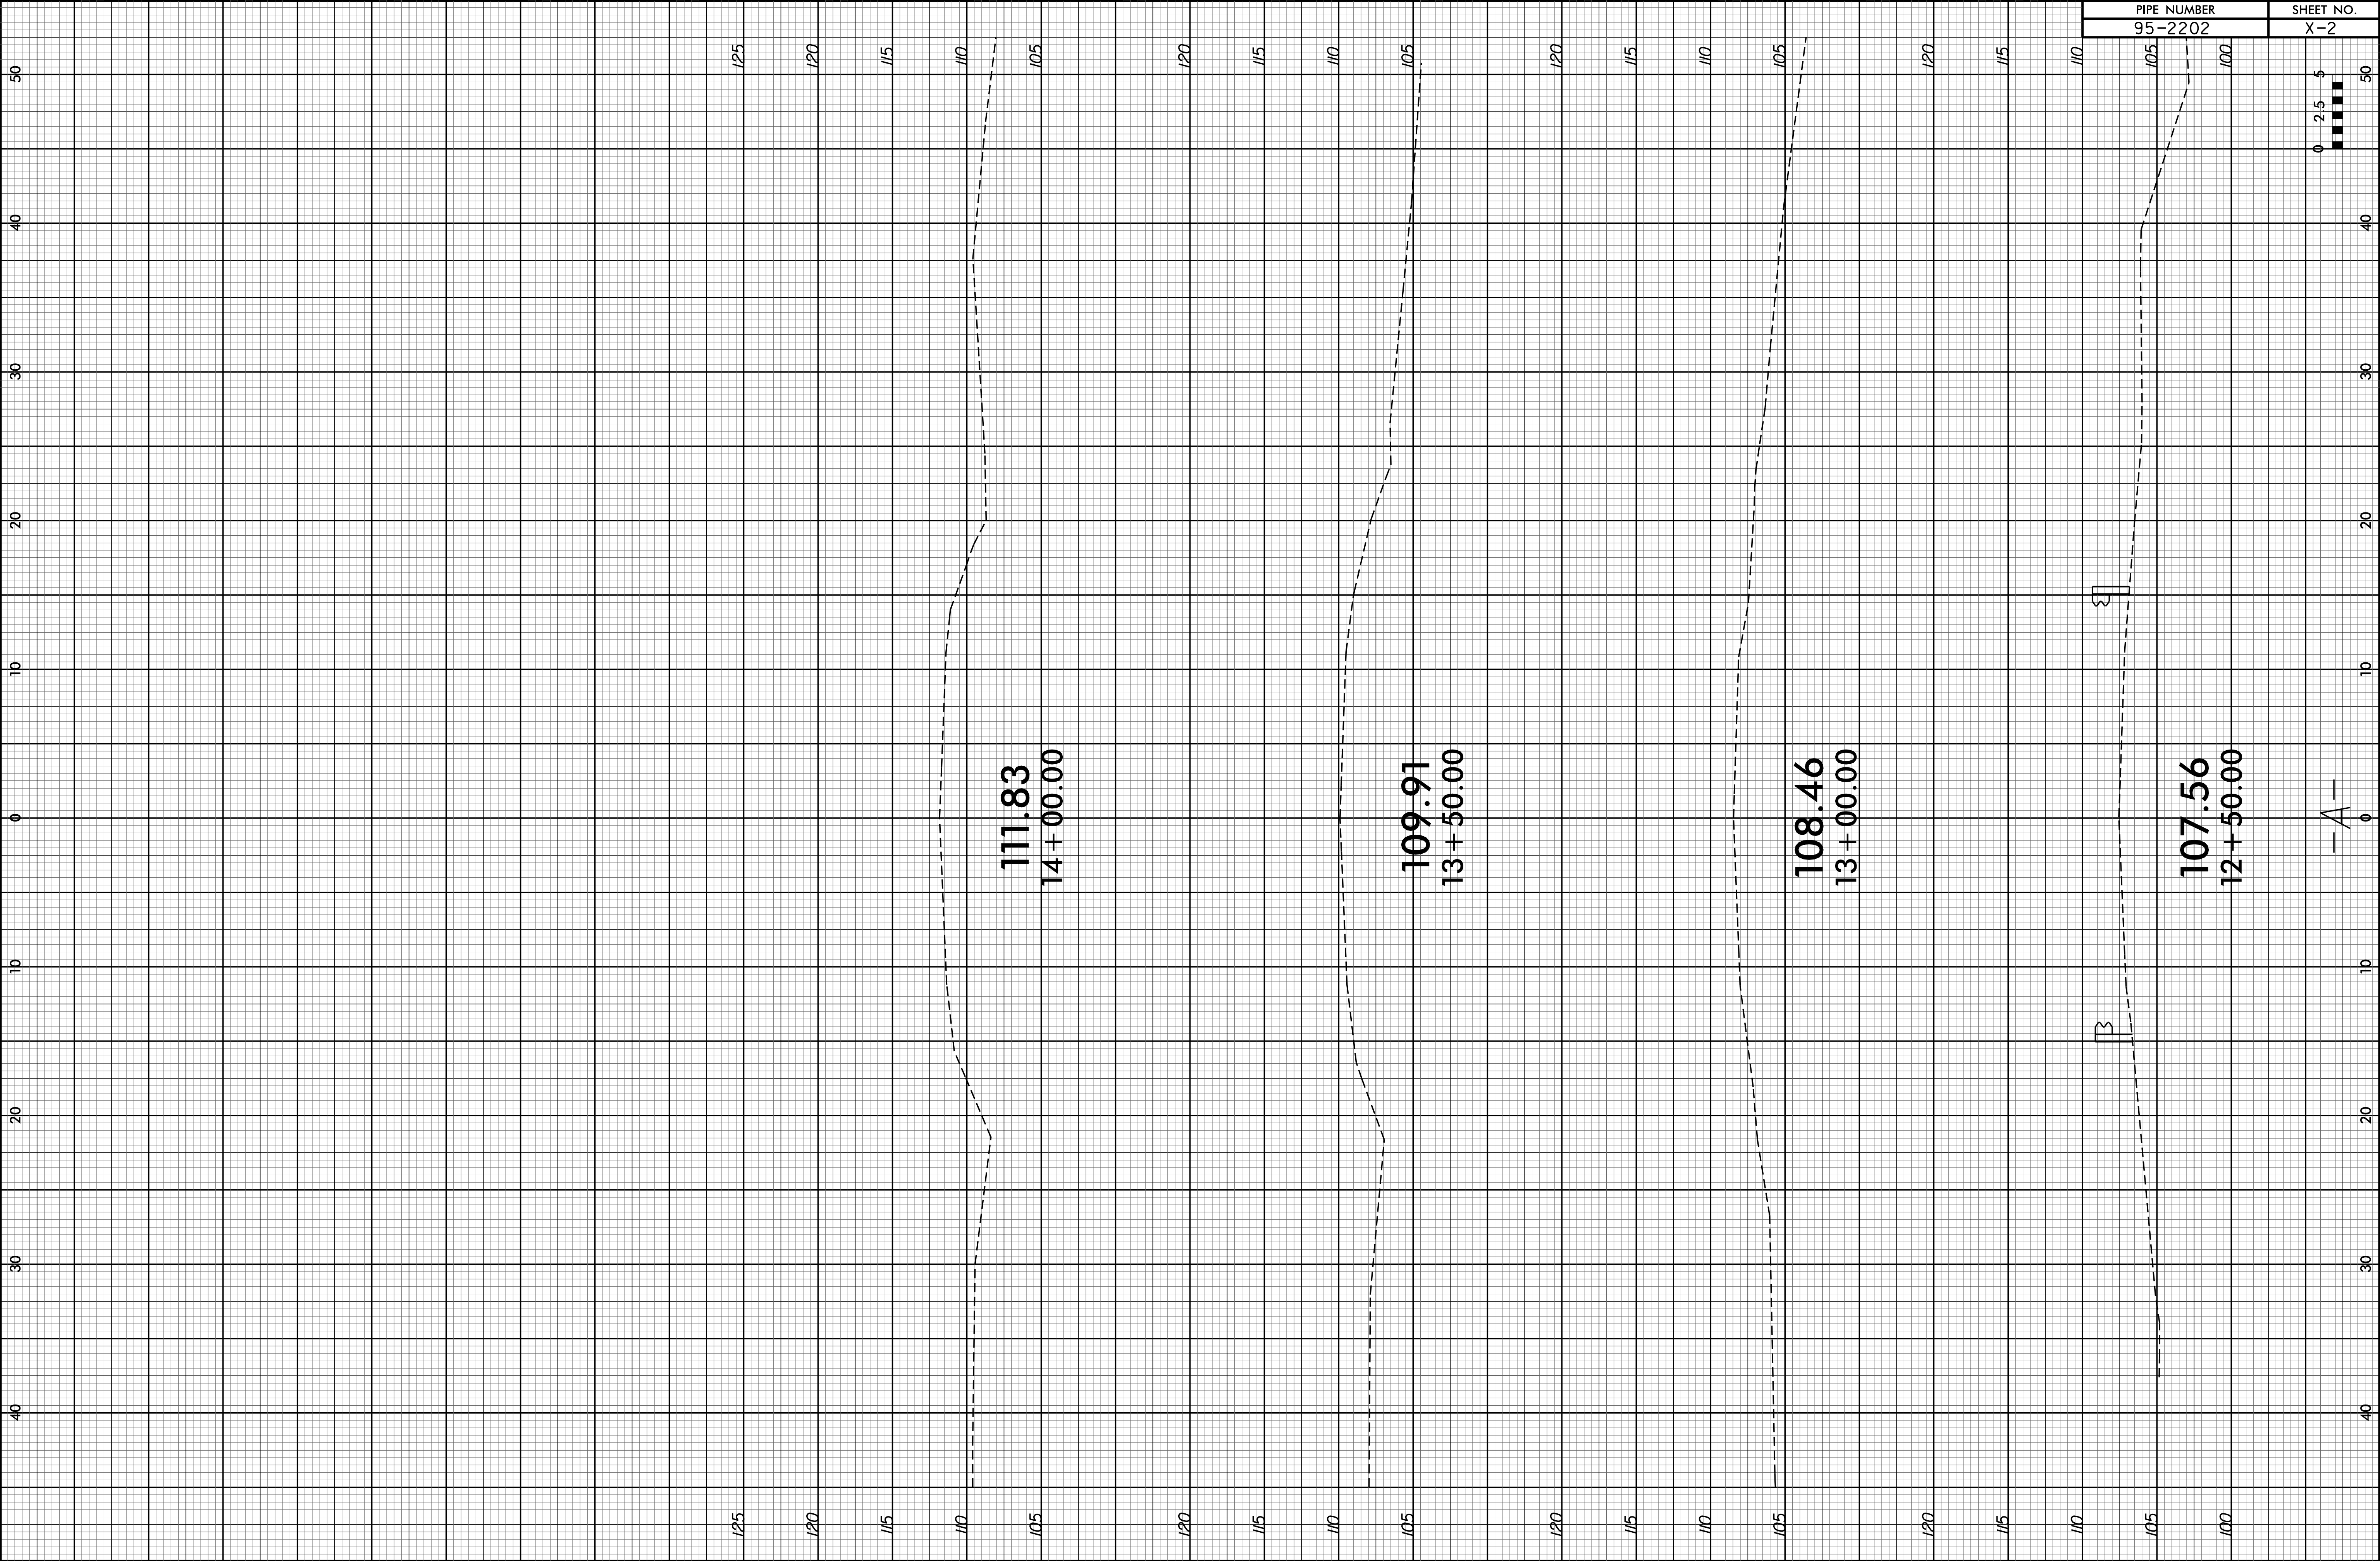

—A—

0 2.5 \$

PIPE NUMBER	SHEET NO.
95-2202	X-2