

**This electronic collection of documents is provided
for the convenience of the user
and is Not a Certified Document –**

**The documents contained herein were originally issued
and sealed by the individuals whose names and license
numbers appear on each page, on the dates appearing
with their signature on that page.**


**This file or an individual page
shall not be considered a certified document.**

10-MAY-2021 08:11
R:\Roadway\Proj\W5204C_ddc4_TSH.dgn
SSSSUSER\NAMESS\$


CONTRACT: DD00296

TIP PROJECT: W-5204C


See Sheet 1-A For Index of Sheets

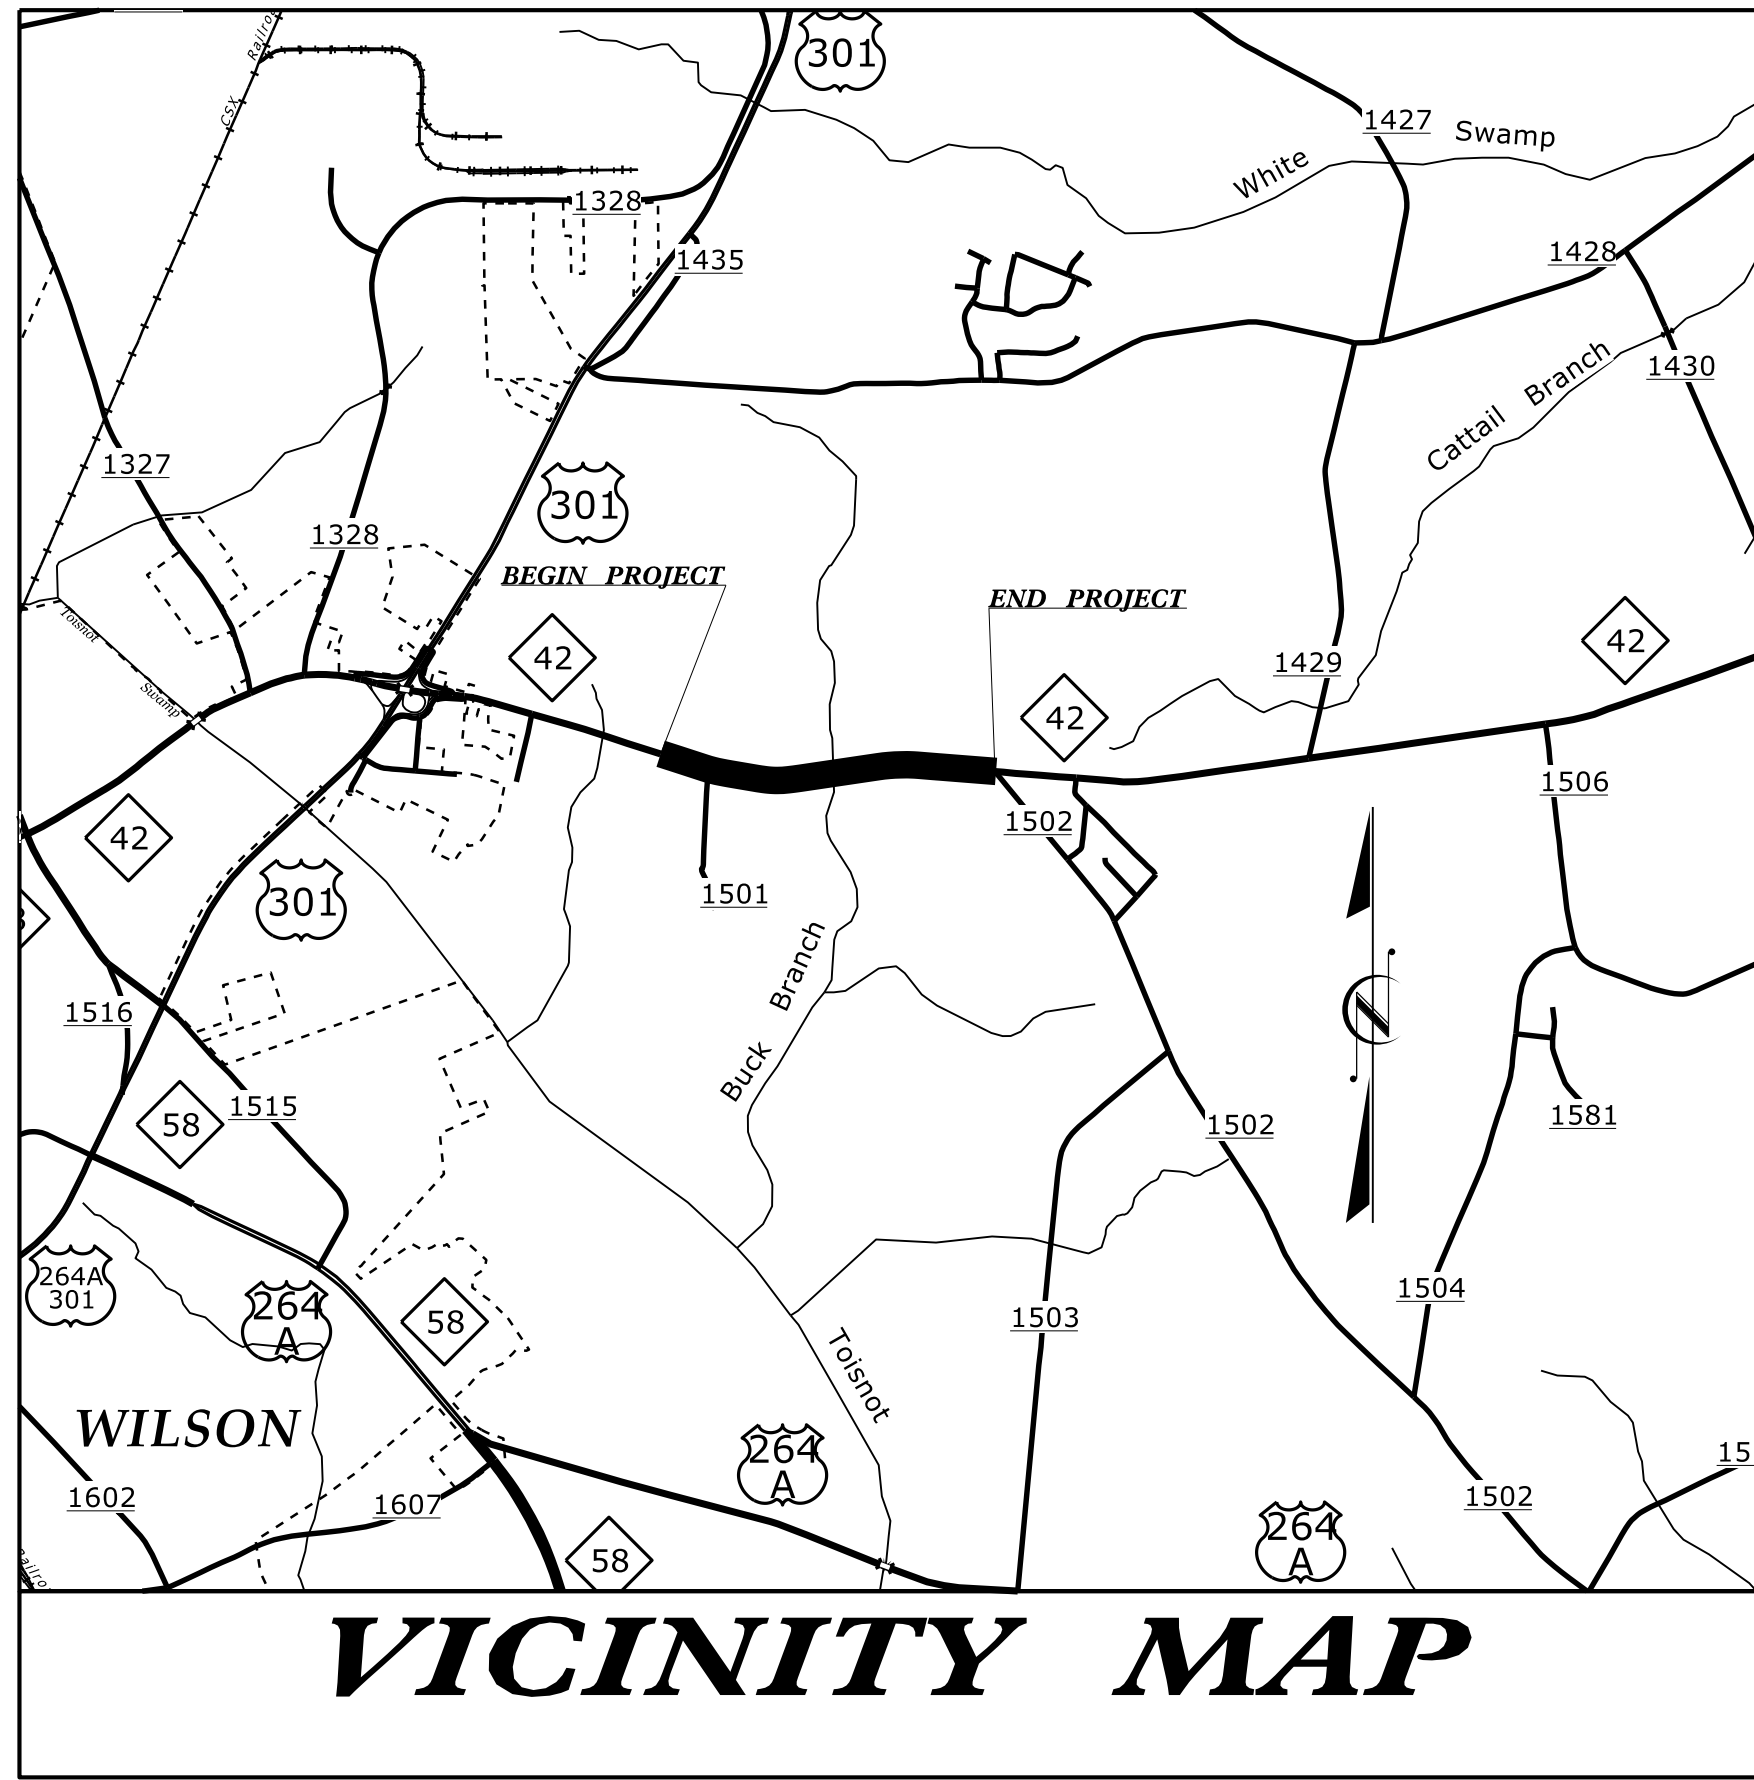

VICINITY MAP

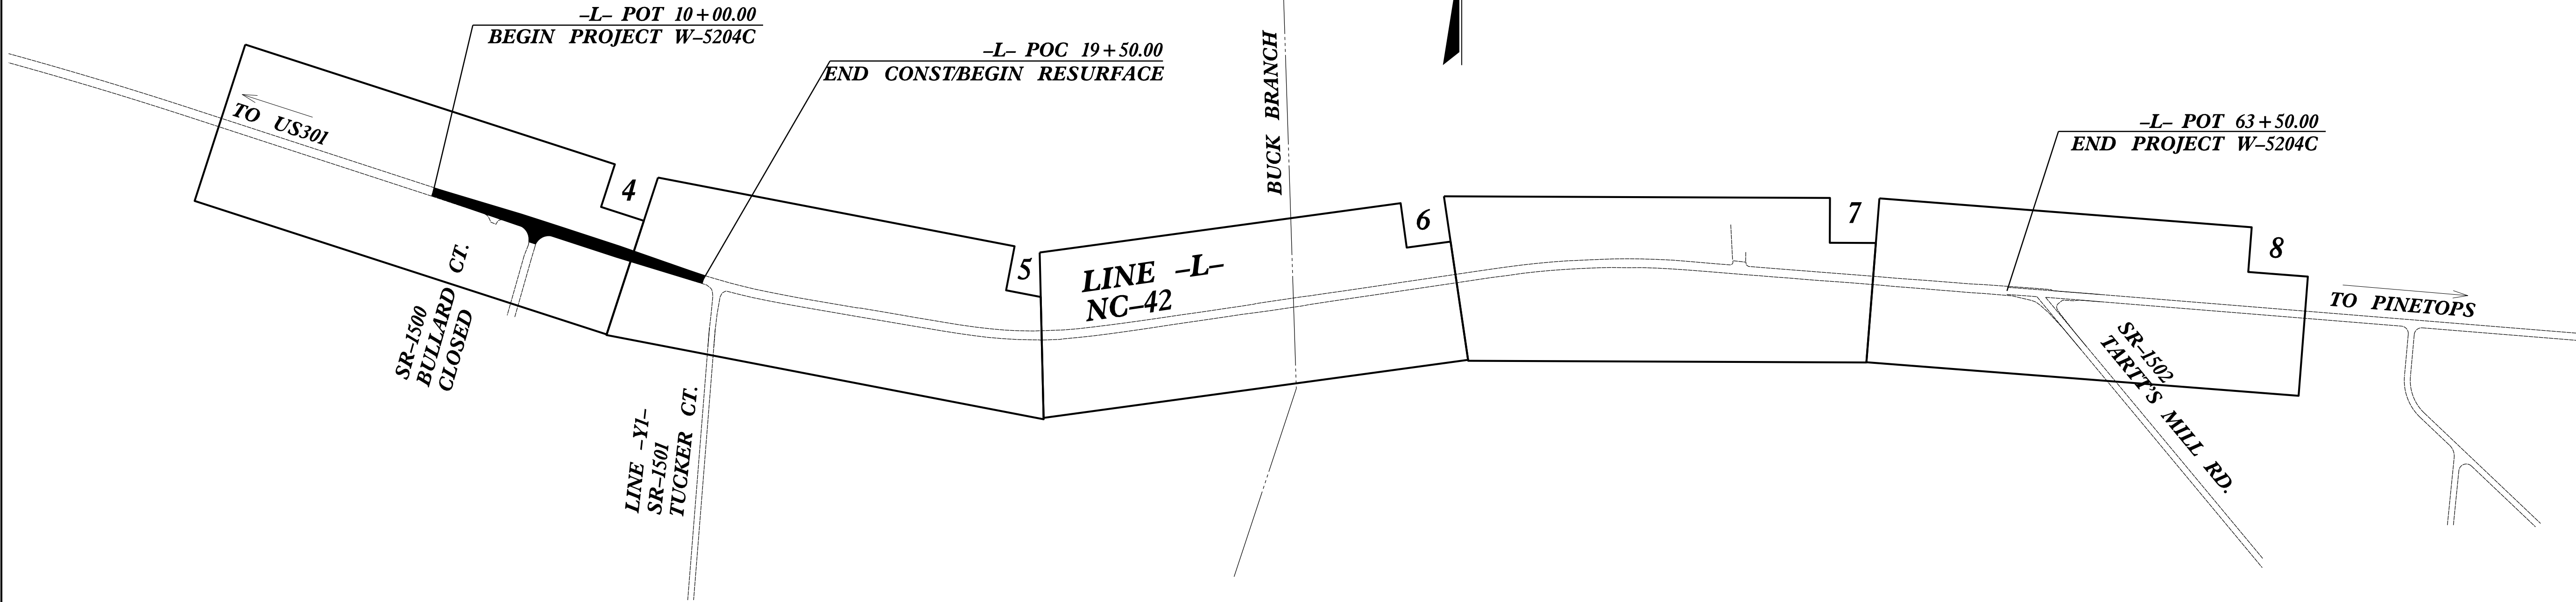

GRAPHIC SCALES

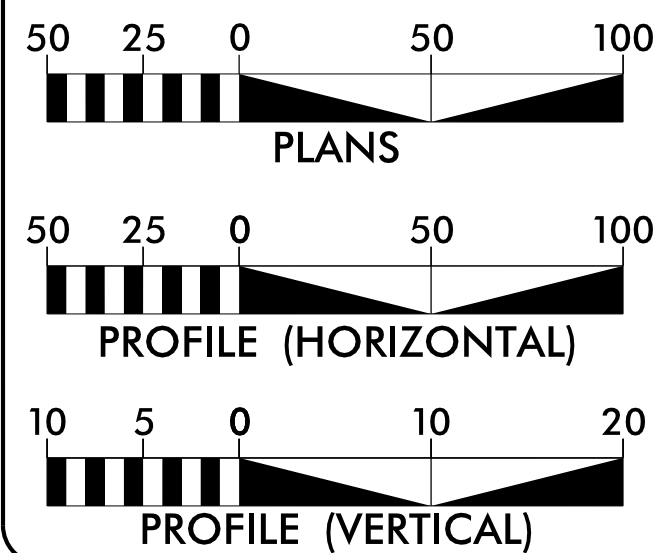

DESIGN DATA

ADT 2017 = 6700
ADT =
DHV = %
D = %
T = % *
V = 60 MPH
* TTST DUAL

PROJECT LENGTH

LENGTH ROADWAY TIP PROJECT W-5204C = 1.013 MILES
TOTAL LENGTH TIP PROJECT W-5204C = 1.013 MILES

STATE OF NORTH CAROLINA
DIVISION OF HIGHWAYS
WILSON COUNTY

LOCATION: NC-42 FROM SR-1500 (BULLARD CT.)
TO SR-1502 (TARTT'S MILL ROAD)

TYPE OF WORK: GRADING, DRAINAGE, AND PAVING.

STATE	STATE PROJECT REFERENCE NO.	SHEET NO.	TOTAL SHEETS
N.C.	W-5204C	1	
STATE PROJ.NO.	F. A. PROJ. NO.	DESCRIPTION	
45334.1.3	HSIP-0042(53)	PE	
45334.2.FR3	HSIP-0042(53)	RW	
45334.2.FRU3	HSIP-0042(53)	UTILITY	
45334.3.3	HSIP-0042(53)	CONST	

HYDRAULICS ENGINEER
5/10/2021


DocuSigned by:
Norwood A Gaiety III
E0C08850A45044B
SIGNATURE:

ROADWAY DESIGN
ENGINEER

5/10/2021

DocuSigned by:
Norwood A Gaiety III
E0C08850A45044B
SIGNATURE:

DIVISION OF HIGHWAYS
STATE OF NORTH CAROLINA

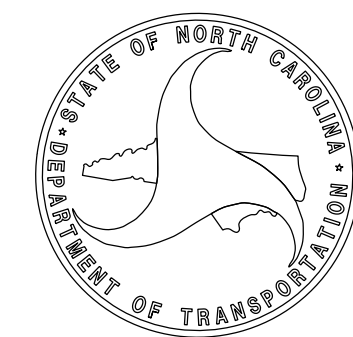

STATE HIGHWAY DESIGN ENGINEER

Prepared in the Office of:

DIVISION OF HIGHWAYS

Division 4 DDC
509 Ward Bldg., Wilson NC, 27895

2018 STANDARD SPECIFICATIONS

RIGHT OF WAY DATE:
NOVEMBER 9, 2015

LETTING DATE:
July 27, 2021

KEVIN G. BOWEN, PE
PROJECT ENGINEER

D.R. ETHRIDGE
PROJECT DESIGN ENGINEER

STATE OF NORTH CAROLINA
DIVISION OF HIGHWAYS

PROJ. REFERENCE NO.
W-5204C

SHEET NO.
I-A

ROADWAY DESIGN
ENGINEER

7/6/2021

NORTH CAROLINA
PROFESSIONAL
SEAL
040774
ENGINEER

DocuSigned by
Norwood A. Gentry III
F7D8B26A4C644B

SHEET NUMBER	INDEX OF SHEETS SHEET
1	TITLE SHEET
1A	INDEX OF SHEETS, GENERAL NOTES, AND LIST OF STANDARD DRAWINGS
1B	CONVENTIONAL SYMBOLS
1C-1 THRU 1C-2	SURVEY CONTROL SHEET
2A-1	PAVEMENT SCHEDULE AND TYPICAL SECTIONS
3B-1	ROADWAY SUMMARIES - EARTHWORK, PARCEL INDEX, AND DRAINAGE SUMMARIES.
4 THRU 8	PLAN SHEET
TMP-1 THRU TMP-2	TRANSPORTATION MANAGEMENT PLANS
PM-1	PAVEMENT MARKING PLANS
EC-1 THRU EC-7	EROSION CONTROL PLANS
UC-1 THRU UC-4	UTILITY CONSTRUCTION PLANS
X-1A	CROSS-SECTION SUMMARY
X-1 THRU X-6	CROSS-SECTIONS

2018 ROADWAY ENGLISH STANDARD DRAWINGS

THE FOLLOWING ROADWAY STANDARDS AS APPEAR IN "ROADWAY STANDARD DRAWINGS"
HIGHWAY DESIGN BRANCH - N. C. DEPARTMENT OF TRANSPORTATION - RALEIGH, N. C.,
DATED JANUARY, 2018 ARE APPLICABLE TO THIS PROJECT AND BY REFERENCE HEREBY ARE
CONSIDERED A PART OF THESE PLANS:

DIVISION 2 - EARTHWORK
200.03 METHOD OF CLEARING - METHOD III
225.02 GUIDE FOR GRADING SUBGRADE - SECONDARY AND LOCAL
225.04 METHOD OF OBTAINING SUPERELEVATION - TWO LANE PAVEMENT

DIVISION 3 - PIPE CULVERTS
300.01 METHOD OF PIPE INSTALLATION

DIVISION 5 - SUBGRADE, BASES AND SHOULDERS
560.01 METHOD OF SHOULDER CONSTRUCTION - HIGH SIDE OF SUPERELEVATED CURVE - METHOD I

DIVISION 6 - ASPHALT BASES AND PAVEMENTS
654.01 PAVEMENT REPAIRS

GENERAL NOTES: 2018 SPECIFICATIONS

GRADE LINE:
GRADING AND SURFACING OR RESURFACING AND WIDENING:
THE GRADE LINES SHOWN DENOTE THE FINISHED ELEVATION OF THE PROPOSED
SURFACING AT GRADE POINTS SHOWN ON THE TYPICAL SECTIONS. WHERE NO GRADE LINES
ARE SHOWN, THE PROFILES SHOWN DENOTE THE TOP ELEVATION OF THE EXISTING PAVEMENT
ALONG THE CENTER LINE OF SURVEY ON WHICH THE PROPOSED RESURFACING WILL BE
PLACED. GRADE LINES MAY BE ADJUSTED BY THE ENGINEER IN ORDER TO SECURE A
PROPER TIE-IN.

CLEARING:
CLEARING ON THIS PROJECT SHALL BE PERFORMED TO THE LIMITS ESTABLISHED BY METHOD III.

SUPERELEVATION:
ALL CURVES ON THIS PROJECT SHALL BE SUPERELEVATED IN ACCORDANCE WITH STD.
NO. 225.04. USING THE RATE OF SUPERELEVATION AND RUNOFF SHOWN ON THE PLANS.
SUPERELEVATION IS TO BE REVOLVED ABOUT THE GRADE POINTS SHOWN ON THE TYPICAL
SECTIONS.

SHOULDER CONSTRUCTION:
ASPHALT, EARTH, AND CONCRETE SHOULDER CONSTRUCTION ON THE HIGH SIDE OF
SUPERELEVATED CURVES SHALL BE IN ACCORDANCE WITH STD. NO. 560.01

SIDE ROADS:
THE CONTRACTOR WILL BE REQUIRED TO DO ALL NECESSARY WORK TO PROVIDE
SUITABLE CONNECTIONS WITH ALL ROADS, STREETS, AND DRIVES ENTERING THIS PROJECT.
THIS WORK WILL BE PAID FOR AT THE CONTRACT UNIT PRICE FOR THE PARTICULAR ITEMS
INVOLVED.

TEMPORARY SHORING:
SHORING REQUIRED FOR THE MAINTENANCE OF TRAFFIC WILL BE PAID FOR AS "EXTRA
WORK" IN ACCORDANCE WITH SECTION 104-7.

SUBSURFACE PLANS:
NO SUBSURFACE PLANS ARE AVAILABLE ON THIS PROJECT. THE CONTRACTOR SHOULD
MAKE HIS OWN INVESTIGATION AS TO THE SUBSURFACE CONDITIONS.

UTILITIES:
UTILITY OWNERS ON THIS PROJECT ARE:
SPECTRUM, CENTURYLINK, CITY OF WILSON (GAS), CITY OF WILSON (POWER) AND
CITY OF WILSON (WATER&SEWER).

ANY RELOCATION OF EXISTING UTILITIES WILL BE ACCOMPLISHED BY OTHERS, EXCEPT
AS SHOWN ON THE PLANS.

Note: Not to Scale

*S.U.E. = Subsurface Utility Engineering

CONVENTIONAL PLAN SHEET SYMBOLS

BOUNDARIES AND PROPERTY:

State Line	
County Line	
Township Line	
City Line	
Reservation Line	
Property Line	
Existing Iron Pin	
Property Corner	
Property Monument	
Parcel/Sequence Number	
Existing Fence Line	
Proposed Woven Wire Fence	
Proposed Chain Link Fence	
Proposed Barbed Wire Fence	
Existing Wetland Boundary	
Proposed Wetland Boundary	
Existing Endangered Animal Boundary	
Existing Endangered Plant Boundary	
Known Soil Contamination: Area or Site	
Potential Soil Contamination: Area or Site	

BUILDINGS AND OTHER CULTURE:

Gas Pump Vent or U/G Tank Cap	
Sign	
Well	
Small Mine	
Foundation	
Area Outline	
Cemetery	
Building	
School	
Church	
Dam	

HYDROLOGY:

Stream or Body of Water	
Hydro, Pool or Reservoir	
Jurisdictional Stream	
Buffer Zone 1	
Buffer Zone 2	
Flow Arrow	
Disappearing Stream	
Spring	
Wetland	
Proposed Lateral, Tail, Head Ditch	
False Sump	

RAILROADS:

Standard Gauge	
RR Signal Milepost	
Switch	
RR Abandoned	
RR Dismantled	

RIGHT OF WAY:

Baseline Control Point	
Existing Right of Way Marker	
Existing Right of Way Line	
Proposed Right of Way Line	
Proposed Right of Way Line with Iron Pin and Cap Marker	
Proposed Right of Way Line with Concrete or Granite R/W Marker	
Proposed Control of Access Line with Concrete C/A Marker	
Existing Control of Access	
Proposed Control of Access	
Existing Easement Line	
Proposed Temporary Construction Easement	
Proposed Temporary Drainage Easement	
Proposed Permanent Drainage Easement	
Proposed Permanent Drainage /Utility Easement	
Proposed Permanent Utility Easement	
Proposed Temporary Utility Easement	
Proposed Aerial Utility Easement	
Proposed Permanent Easement with Iron Pin and Cap Marker	

ROADS AND RELATED FEATURES:

Existing Edge of Pavement	
Existing Curb	
Proposed Slope Stakes Cut	
Proposed Slope Stakes Fill	
Proposed Curb Ramp	
Existing Metal Guardrail	
Proposed Guardrail	
Existing Cable Guiderail	
Proposed Cable Guiderail	
Equality Symbol	
Pavement Removal	

VEGETATION:

Single Tree	
Single Shrub	
Hedge	
Woods Line	

Orchard	
Vineyard	

EXISTING STRUCTURES:

MAJOR:	
Bridge, Tunnel or Box Culvert	
Bridge Wing Wall, Head Wall and End Wall	
MINOR:	
Head and End Wall	
Pipe Culvert	
Footbridge	
Drainage Box: Catch Basin, DI or JB	
Paved Ditch Gutter	
Storm Sewer Manhole	
Storm Sewer	

UTILITIES:

POWER:	
Existing Power Pole	
Proposed Power Pole	
Existing Joint Use Pole	
Proposed Joint Use Pole	
Power Manhole	
Power Line Tower	
Power Transformer	
U/G Power Cable Hand Hole	
H-Frame Pole	
Recorded U/G Power Line	
Designated U/G Power Line (S.U.E.*)	

TELEPHONE:

Existing Telephone Pole	
Proposed Telephone Pole	
Telephone Manhole	
Telephone Booth	
Telephone Pedestal	
Telephone Cell Tower	
U/G Telephone Cable Hand Hole	
Recorded U/G Telephone Cable	
Designated U/G Telephone Cable (S.U.E.*)	
Recorded U/G Telephone Conduit	
Designated U/G Telephone Conduit (S.U.E.*)	
Recorded U/G Fiber Optics Cable	
Designated U/G Fiber Optics Cable (S.U.E.*)	

WATER:

Water Manhole	
Water Meter	
Water Valve	
Water Hydrant	
Recorded U/G Water Line	
Designated U/G Water Line (S.U.E.*)	
Above Ground Water Line	

TV:

TV Satellite Dish	
TV Pedestal	
TV Tower	
U/G TV Cable Hand Hole	
Recorded U/G TV Cable	
Designated U/G TV Cable (S.U.E.*)	
Recorded U/G Fiber Optic Cable	
Designated U/G Fiber Optic Cable (S.U.E.*)	

GAS:

Gas Valve	
Gas Meter	
Recorded U/G Gas Line	
Designated U/G Gas Line (S.U.E.*)	
Above Ground Gas Line	

SANITARY SEWER:

Sanitary Sewer Manhole	
Sanitary Sewer Cleanout	
U/G Sanitary Sewer Line	
Above Ground Sanitary Sewer	
Recorded SS Forced Main Line	
Designated SS Forced Main Line (S.U.E.*)	

MISCELLANEOUS:

Utility Pole	
Utility Pole with Base	
Utility Located Object	
Utility Traffic Signal Box	
Utility Unknown U/G Line	
U/G Tank; Water, Gas, Oil	
Underground Storage Tank, Approx. Loc.	
A/G Tank; Water, Gas, Oil	
Geoenvironmental Boring	
U/G Test Hole (S.U.E.*)	
Abandoned According to Utility Records	
End of Information	

7/2/99
6/2/99

PROJECT REFERENCE NO.	SHEET NO.
W-5204C	1C-1
Location and Surveys	

SURVEY CONTROL SHEET W-5204-C


BL	POINT	DESC.	NORTH	EAST	ELEVATION	L STATION	OFFSET
	1	W5204C-1	723429.4900	2336549.8550	128.51	11+77.61	31.56 RT
	2	W5204C-2	723256.5160	2337092.5420	127.90	17+47.34	28.37 RT
	100	BL-100	723080.0440	2337834.5310	112.35	25+07.30	26.58 RT
	101	BL-101	723020.5120	2338626.5570	115.68	32+97.27	29.06 RT
	102	BL-102	723130.5740	2339329.5910	102.86	40+08.27	21.65 RT
	103	BL-103	723303.2110	2340335.2840	129.33	50+25.87	27.90 LT
	104	BL-104	723250.3900	2341022.8790	119.22	57+13.25	18.30 LT
	3	W5204C-3	723146.2320	2341887.7210	129.96	65+83.52	18.67 RT
	4	W5204C-4	723107.4160	2342403.9940	129.72	OUTSIDE PROJECT LIMITS	



TBM#1 ELEVATION = 114.13
N 723140 E 2337880
L STATION 25+42.00 41 LEFT
RR SPIKE IN BASE OF 60" TWIN OAK

TBM#2 ELEVATION = 105.51
N 723091 E 2339212
L STATION 38+86.00 43 RIGHT
RR SPIKE IN BASE OF 36" SYCAMORE

TBM#3 ELEVATION = 130.37
N 723144 E 2341610
L STATION 63+07.00 42 RIGHT
RR SPIKE IN ROOT OF 36" OAK

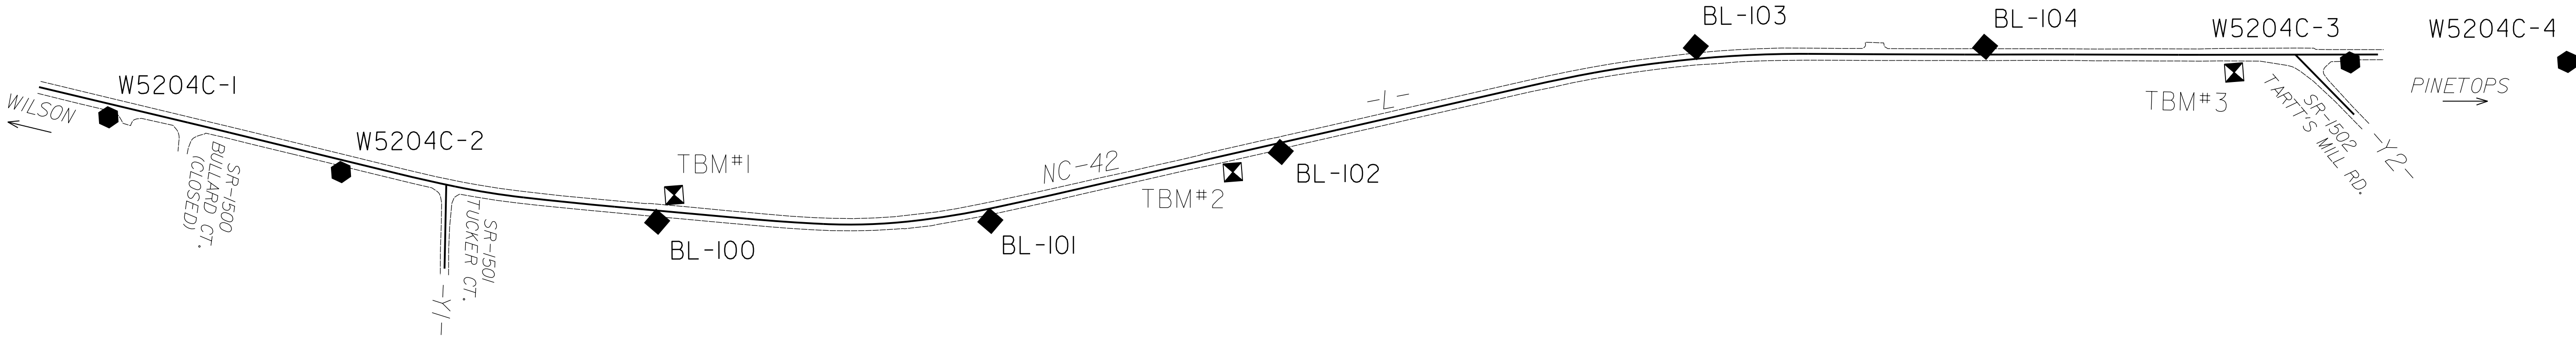

DATUM DESCRIPTION

THE LOCALIZED COORDINATE SYSTEM DEVELOPED FOR THIS PROJECT IS BASED ON THE STATE PLANE COORDINATES ESTABLISHED BY NCDOT FOR MONUMENT "GPS W5204C-2"
WITH NAD 83/NA 2011 STATE PLANE GRID COORDINATES OF
NORTHING: 723256.516(++) EASTING: 2337092.542(++)
ELEVATION: 127.90(++)
THE AVERAGE COMBINED GRID FACTOR USED ON THIS PROJECT (GROUND TO GRID) IS: 0.999906917
THE N.C. LAMBERT GRID BEARING AND
LOCALIZED HORIZONTAL GROUND DISTANCE FROM
"GPS W5204C-2" TO -L- STATION 10+00 IS
N69°51'56.83"W 747.80
ALL LINEAR DIMENSIONS ARE LOCALIZED HORIZONTAL DISTANCES
VERTICAL DATUM USED IS NAVD 88

NOTES:

1. THE CONTROL DATA FOR THIS PROJECT CAN BE FOUND ELECTRONICALLY BY SELECTING PROJECT CONTROL DATA AT:
[HTTPS://CONNECT.NCDOT.GOV/RESOURCES/LOCATION/](https://connect.ncdot.gov/resources/location/)
THE FILES TO BE FOUND ARE AS FOLLOWS:
W5204C_LS_CONTROL.TXT

SITE CALIBRATION INFORMATION HAS NOT BEEN PROVIDED FOR THIS PROJECT. IF FURTHER INFORMATION IS NEEDED, PLEASE CONTACT THE LOCATION AND SURVEYS UNIT.

INDICATES GEODETIC CONTROL MONUMENTS USED OR SET FOR HORIZONTAL PROJECT CONTROL BY THE NCDOT LOCATION AND SURVEYS UNIT.
PROJECT CONTROL ESTABLISHED USING GLOBAL POSITIONING SYSTEM.

NOTE: DRAWING NOT TO SCALE

10 MAY 2021 08:11
C:\GIS\PROJECTS\W5204C-1s-1c1.dgn
SHEET 1 OF 1

6/7/2019 9:10 AM

10-MAY-2021 08:11
S:\Projects\2021\W5204-C-1s-1c2.dgn

ROW MARKER IRON PIN AND CAP-E				
ALIGN	STATION	OFFSET	NORTH	EAST
L	10+00.00	30.00	723485.3649	2336381.2551
L	10+00.00	35.00	723480.6051	2336379.7241
L	10+00.00	-30.00	723542.4827	2336399.6279
L	10+00.00	-35.00	723547.2425	2336401.1589
L	13+00.00	-35.00	723455.3782	2336686.7498
L	13+64.71	35.00	723368.9264	2336726.9146
L	14+66.33	35.00	723337.6193	2336823.4016
L	14+86.50	45.00	723321.8419	2336839.4597
L	15+00.00	-45.00	723403.1771	2336880.2879
L	17+00.00	-35.00	723331.4638	2337067.2575
L	18+81.00	45.00	723199.1343	2337214.3915
L	18+81.00	-35.00	723275.1659	2337239.2751
L	19+77.52	50.00	723165.1200	2337306.0962
L	20+19.54	-35.00	723234.7582	2337370.5012
L	20+37.54	50.00	723148.0527	2337364.7078
L	21+85.42	35.00	723128.0242	2337515.3999
L	21+85.42	-35.00	723196.7581	2337528.6532
L	24+03.46	-35.00	723158.0801	2337742.4093
L	24+03.46	35.00	723089.0601	2337730.7368
L	26+50.00	35.00	723047.9499	2337973.8236
L	26+65.00	50.00	723030.6582	2337986.1151
L	27+00.00	50.00	723024.8219	2338020.6258
L	27+20.42	35.00	723036.2072	2338043.2592
L	27+20.42	-35.00	723105.2271	2338054.9316
L	29+02.50	35.00	723009.4812	2338224.8714
L	29+02.50	-35.00	723078.9378	2338233.5770
L	31+13.17	35.00	722999.6593	2338440.6357
L	31+13.17	-35.00	723069.6195	2338438.2765
L	33+14.91	35.00	723016.9565	2338645.1009
L	33+14.91	-35.00	723086.3188	2338635.6738
L	33+48.46	-35.00	723090.8371	2338668.9181
L	33+48.46	35.00	723021.4748	2338678.3452
L	34+90.26	35.00	723041.5316	2338819.1710
L	34+90.26	-35.00	723110.7678	2338808.8586
L	37+33.79	-35.00	723146.6447	2339049.7314
L	37+33.79	35.00	723077.4085	2339060.0438
L	38+40.93	-35.00	723162.3266	2339155.7972
L	38+40.93	35.00	723093.0684	2339165.9612
L	39+80.00	48.00	723100.3984	2339305.4398
L	39+80.00	-50.00	723197.3606	2339291.2150
L	39+80.00	-35.00	723182.5195	2339293.3930
L	39+80.00	35.00	723113.2607	2339303.5522
L	40+35.00	35.00	723121.2467	2339357.9693
L	40+35.00	48.00	723108.3845	2339359.8569
L	40+35.00	-35.00	723190.5056	2339347.8101
L	40+35.00	-50.00	723205.3466	2339345.6321
L	40+99.48	35.00	723130.6100	2339421.7712
L	40+99.48	-35.00	723199.8681	2339411.6072
L	41+49.42	35.00	723137.8905	2339471.2087
L	41+49.42	-35.00	723207.1384	2339460.9755
L	46+25.47	35.00	723207.4835	2339942.1444
L	46+25.47	-35.00	723276.7315	2339931.9112
L	47+78.59	-35.00	723295.9869	2340085.3502
L	47+78.59	35.00	723226.3576	2340092.5450
L	49+37.32	-35.00	723307.4578	2340245.8575
L	49+37.32	35.00	723237.5130	2340248.6376
L	49+65.29	-35.00	723308.5686	2340273.8054
L	49+65.29	35.00	723238.6238	2340276.5855
L	52+91.05	-35.00	723301.3984	2340603.5850
L	52+91.05	35.00	723231.6405	2340597.7675
L	54+47.55	-35.00	723288.3920	2340759.5436
L	54+47.55	35.00	723218.6342	2340753.7261
L	55+33.80	-35.00	723281.3559	2340845.4035
L	55+33.80	35.00	723211.5816	2340839.7865
L	56+64.66	-35.00	723270.8554	2340975.8415
L	56+64.66	35.00	723201.0811	2340970.2246
L	57+43.86	-35.00	723264.7234	2341054.6127
L	57+43.86	35.00	723194.9204	2341049.3642
L	57+75.48	-35.00	723262.3525	2341086.1437
L	57+75.48	35.00	723192.5496	2341080.8951
L	59+27.17	-35.00	723250.5823	2341237.5619
L	59+27.17	35.00	723180.8068	2341231.9605
L	61+74.55	35.00	723161.0114	2341478.5472
L	61+74.55	-35.00	723230.7869	2341484.1486
L	62+22.99	35.00	723157.2292	2341526.9853
L	62+22.99	-35.00	723227.0285	2341532.2822
L	63+40.00	30.00	723153.3605	2341644.0418
L	63+40.00	-30.00	723213.1884	2341648.5820
L	63+40.00	-35.00	723218.1741	2341648.9603
L	63+40.00	35.00	723148.3748	2341643.6634

SURVEY CONTROL SHEET W-5204-C

ROW MARKER PERMANENT EASEMENT-E				
ALIGN	STATION	OFFSET	NORTH	EAST
L	10+15.00	-35.00	723542.6493	2336415.4384
L	10+45.00	-49.00	723546.7904	2336448.2842
L	12+30.00	45.00	723400.6566	2336595.6135
L	12+30.00	35.00	723410.1763	2336598.6756
L	12+32.00	-62.00	723501.9043	2336630.2821
L	12+32.00	-49.00	723489.5287	2336626.3014
L	12+43.00	-49.00	723486.1604	2336636.7730
L	12+43.00	-62.00	723498.5359	2336640.7537
L	14+15.52	-49.06	723433.2952	2336801.1220
L	15+10.00	56.00	723304.0767	2336858.3763
L	18+81.00	-49.00	723288.4720	2337243.6280
L	19+78.49	55.00	723160.0491	2337305.5978
L	20+19.54	-49.00	723248.2092	2337374.3835
L	20+38.73	57.00	723140.9807	2337364.0127
L	20+75.00	59.00	723129.4016	2337399.6535
L	20+77.00	75.00	723113.3866	2337397.6993
L	20+85.00	59.00	723126.8669	2337409.6598
L	20+87.00	73.00	723112.7821	2337408.2769
L	20+90.00	-49.00	723230.4569	2337440.6155
L	22+95.00	-44.00	723185.5631	2337637.5710
L	23+07.00	47.00	723093.8770	2337633.2415
L	24+03.46	-44.00	723166.9548	2337743.9074
L	25+59.00	47.00	723051.2916	2337882.1001
L	25+98.00	51.00	723040.8443	2337919.8871
L	27+20.42	-44.00	723114.1011	2338056.4344
L	27+75.00	45.00	723017.4988	2338096.0369
L	29+02.50	-44.00	723087.8688	2338234.6926
L	30+52.00	60.00	722973.9887	2338377.5575
L	31+13.17	-44.00	723078.6154	2338437.9691
L	32+60.00	-44.00	723088.7422	2338581.1659
L	33+27.00	47.00	723006.6946	2338658.7010
L	38+40.93	-48.00	723175.1895	2339153.9041
L	41+49.39	-48.00	723219.9963	2339459.0481
L	43+51.00	-48.85	723250.3078	2339658.3692
L	43+51.00	-60.00	723261.3391	2339656.7390
L	43+60.00	48.00	723155.8151	2339681.4307
L	43+62.00	-48.90	723251.9617	2339669.2442
L	43+62.00	-60.00	723262.9472	2339667.6208
L	45+65.00	-49.75	723282.4836	2339869.9384
L	47+80.00	-47.00	723308.0706	2340085.5459
L	49+38.00	-49.00	723321.4737	2340245.9811
L	49+65.00	54.00	723219.6273	2340277.0505
L	49+95.00	-49.00	723323.5898	2340303.4912
L	52+25.00	57.00	723214.2848	2340531.4705
L	52+90.00	-42.00	723308.4628	2340603.1011
L	54+82.00	47.00	723203.8281	2340787.1124
L	56+87.00	-61.00	723295.0028	2341000.1056
L	56+87.00	-43.00	723277.0587	2340998.6879
L	56+98.00	-61.00	723294.1440	2341011.0271
L	56+98.00	-44.00	723277.1958	2341009.7007
L	56+98.00	-44.00	723277.1958	2341009.7007
L	57+28.00	47.00	723184.1551	2341032.6048
L	59+85.00	35.00	723176.1795	2341289.6015
L	59+85.00	40.00	723171.1955	2341289.2014
L	59+92.00	-55.00	723265.3307	2341303.7809
L	61+40.00	-49.00	723247.5070	2341450.8262
L	63+40.00	-47.00	723230.1397	2341649.8684


PROJECT REFERENCE NO.			
W-5204C			
SHEET NO.			
IC-2			
Location and Surveys			

FINAL			
TYPE	STATION	NORTH	EAST
POT	10+00.00	723513.9238	2336390.4415
PC	13+64.71	723402.2451	2336737.6320
PT	14+66.33	723370.8832	2336834.2882
PC	18+81.00	723241.9021	2337228.3885
PCC	20+19.54	723201.1322	2337360.7908
PCC	21+85.42	723162.3911	2337522.0265
PT	24+03.46	723123.5701	2337736.5731
PC	27+20.42	723070.7171	2338049.0954
PCC	29+02.50	723044.2095	2338229.2242
PCC	31+13.17	723034.6394	2338439.4561
PT	33+14.91	723051.6377	2338640.3873
PC	33+48.46	723056.1560	2338673.6317
PT	34+90.26	723076.1497	2338814.0148
PC	37+33.79	723112.0266	2339054.8876
PT	38+40.93	723127.6975	2339160.8792
PC	40+99.48	723165.2391	2339416.6892
PT	41+49.42	723172.5144	2339466.0921
PC	46+25.47	723242.1075	2339937.0278
PCC	47+78.59	723261.1722	2340088.9476
PT	49+37.32	723272.4854	2340247.2475
PC	49+65.29	723273.5962	2340275.1955
PT	52+91.05	723266.5195	2340600.6763
PC	54+47.55	723253.5131	2340756.6349
PT	55+33.80	723246.4687	2340842.5950
PC	56+64.66	723235.9682	2340973.0331
PT	57+43.86	723229.8219	2341051.9884
PC	57+75.48	723227.4511	2341083.5194
PT	59+27.17	723215.6945	2341234.7612
PC	61+74.55	723195.8991	2341481.3479
PT	62+22.99	723192.1289	2341529.6338
POT	66+50.01	723159.8162	2341955.4295

Y1			
TYPE	STATION	NORTH	EAST
POT	10+00.00	723207.0902	2337340.3660
POT	12+00.00	723008.0494	2337320.8024

Y2			
TYPE	STATION	NORTH	EAST
POT	10+00.00	723174.7267	2341758.9482
POT	12+00.00	723021.5429	2341887.5356


NOTE: DRAWING NOT TO SCALE

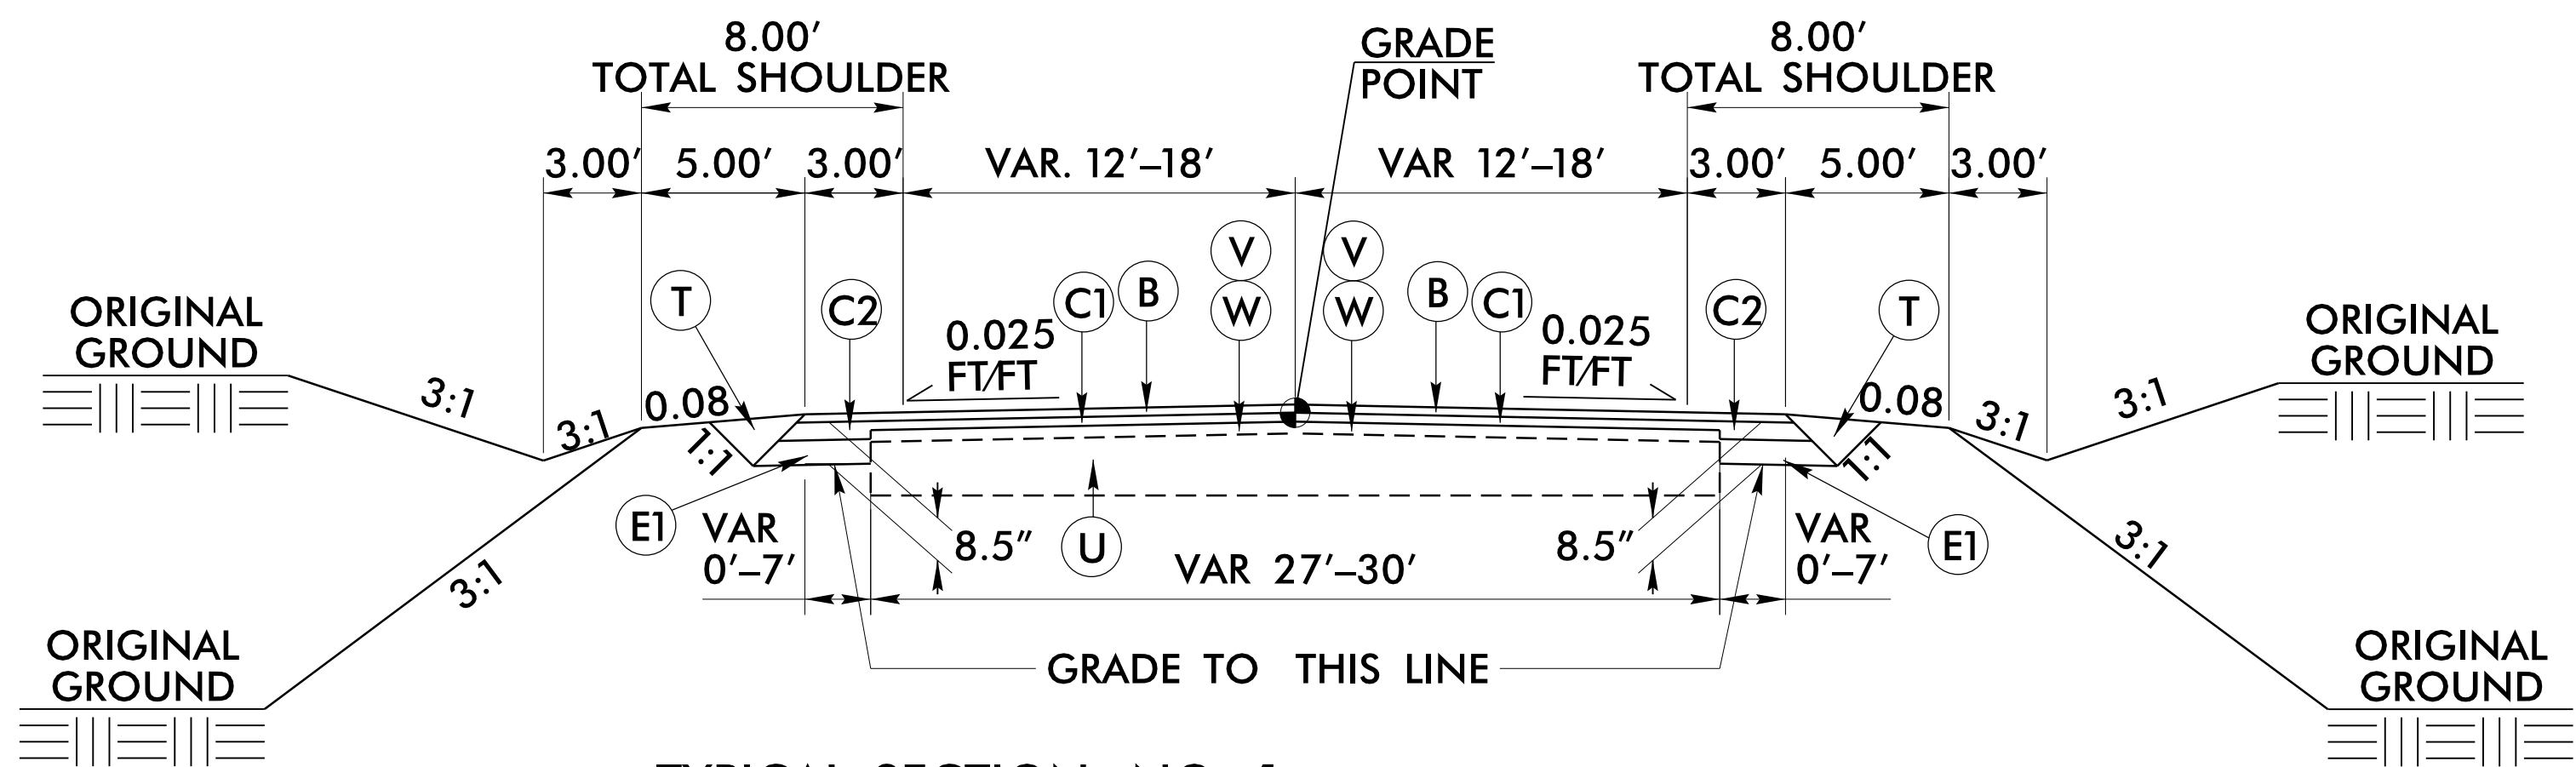

TYPICAL SECTION NO. 1

USE TYPICAL SECTION NO. 1
-L- 10+00.00 TO 19+50.00

NOTE: -L- 19+50.00 TO 63+50.00
MILL 1.5" (V)
1.5" S9.5B (C1)
OGAFC, TYPE FC-1 (B)


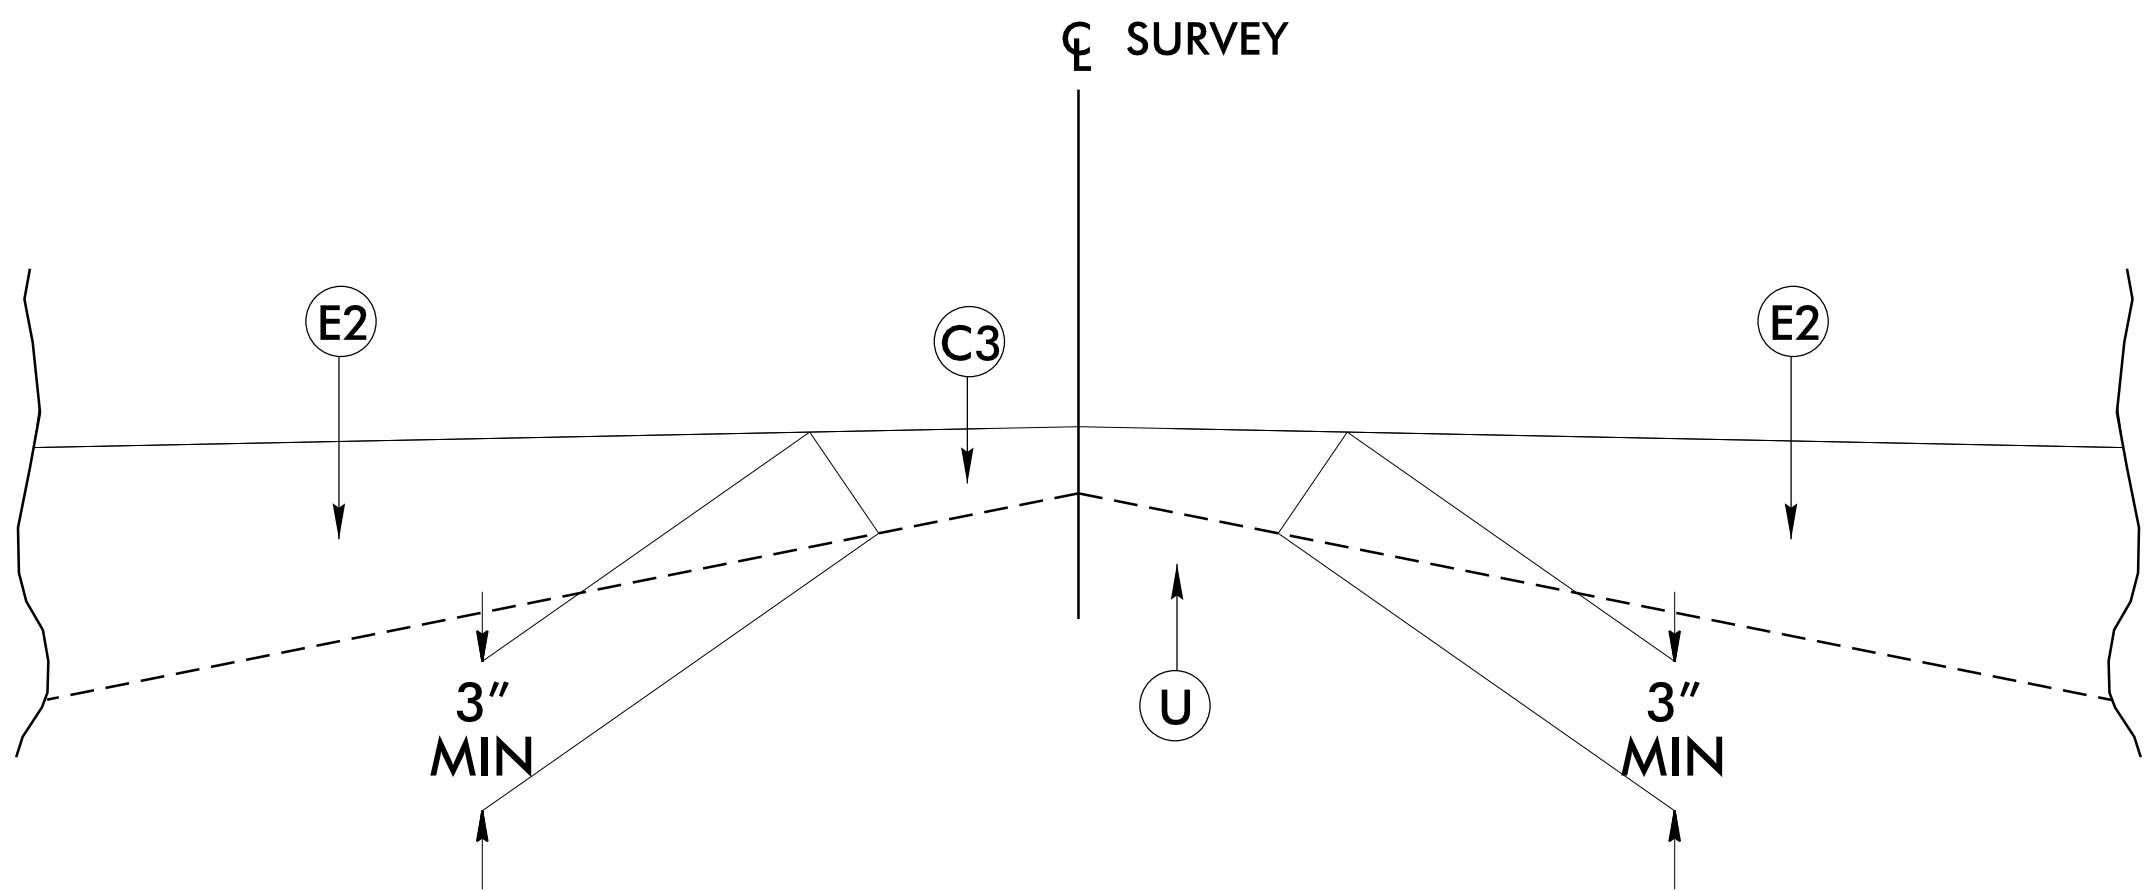


Detail Showing Method of Wedging

PROJECT REFERENCE NO.		SHEET NO.	
W5204-C		2A-1	
ROADWAY DESIGN ENGINEER		PAVEMENT DESIGN ENGINEER	
5/10/2021		5/10/2021	
NORTH CAROLINA PROFESSIONAL SEAL 40774		NORTH CAROLINA PROFESSIONAL SEAL 40774	
NORWOOD A. GAINES		NORWOOD A. GAINES	
Norwood A. Gaines III		Norwood A. Gaines III	

PAVEMENT SCHEDULE	
B	PROP. OPEN-GRADED ASPHALT FRICTION COURSE, TYPE FC-1 MODIFIED, AT AN AVERAGE RATE OF 90 LBS. PER SQ. YD.
C1	PROP. APPROX. 1.5" ASPHALT CONCRETE SURFACE COURSE, TYPE S9.5B, AT AN AVERAGE RATE OF 165 LBS. PER SQ. YARD.
C2	PROP. APPROX. 3" ASPHALT CONCRETE SURFACE COURSE, TYPE S9.5B, AT AN AVERAGE RATE OF 165 LBS. PER SQ. YARD IN EACH OF TWO LAYERS.
C3	PROP. VAR. DEPTH ASPHALT CONCRETE SURFACE COURSE TYPE S9.5B, AT AN AVERAGE RATE OF 110 LBS. PER SQ. YARD PER 1" DEPTH TO BE PLACED IN LAYERS NOT TO EXCEED 2" IN DEPTH.
E1	PROP. APPROX. 5.5" ASPHALT CONCRETE BASE COURSE, TYPE B25.0C, AT AN AVERAGE RATE OF 627 LBS. PER SQ. YARD.
E2	PROP. VAR. DEPTH ASPHALT CONCRETE BASE COURSE TYPE B25.0C, AT AN AVERAGE RATE OF 114 LBS. PER SQ. YARD PER 1" DEPTH TO BE PLACED IN LAYERS NOT LESS THAN 3" OR GREATER THAN 5.5" IN DEPTH.
U	EXISTING PAVEMENT
T	EARTH MATERIAL
W	VARIABLE DEPTH ASPHALT PAVEMENT (SEE DETAIL SHOWING METHOD OF WEDGING ON THIS SHEET)
V	MILLING 1.5"

 NOTE: PAVEMENT EDGE SLOPES ARE 1:1 UNLESS SHOWN OTHERWISE.

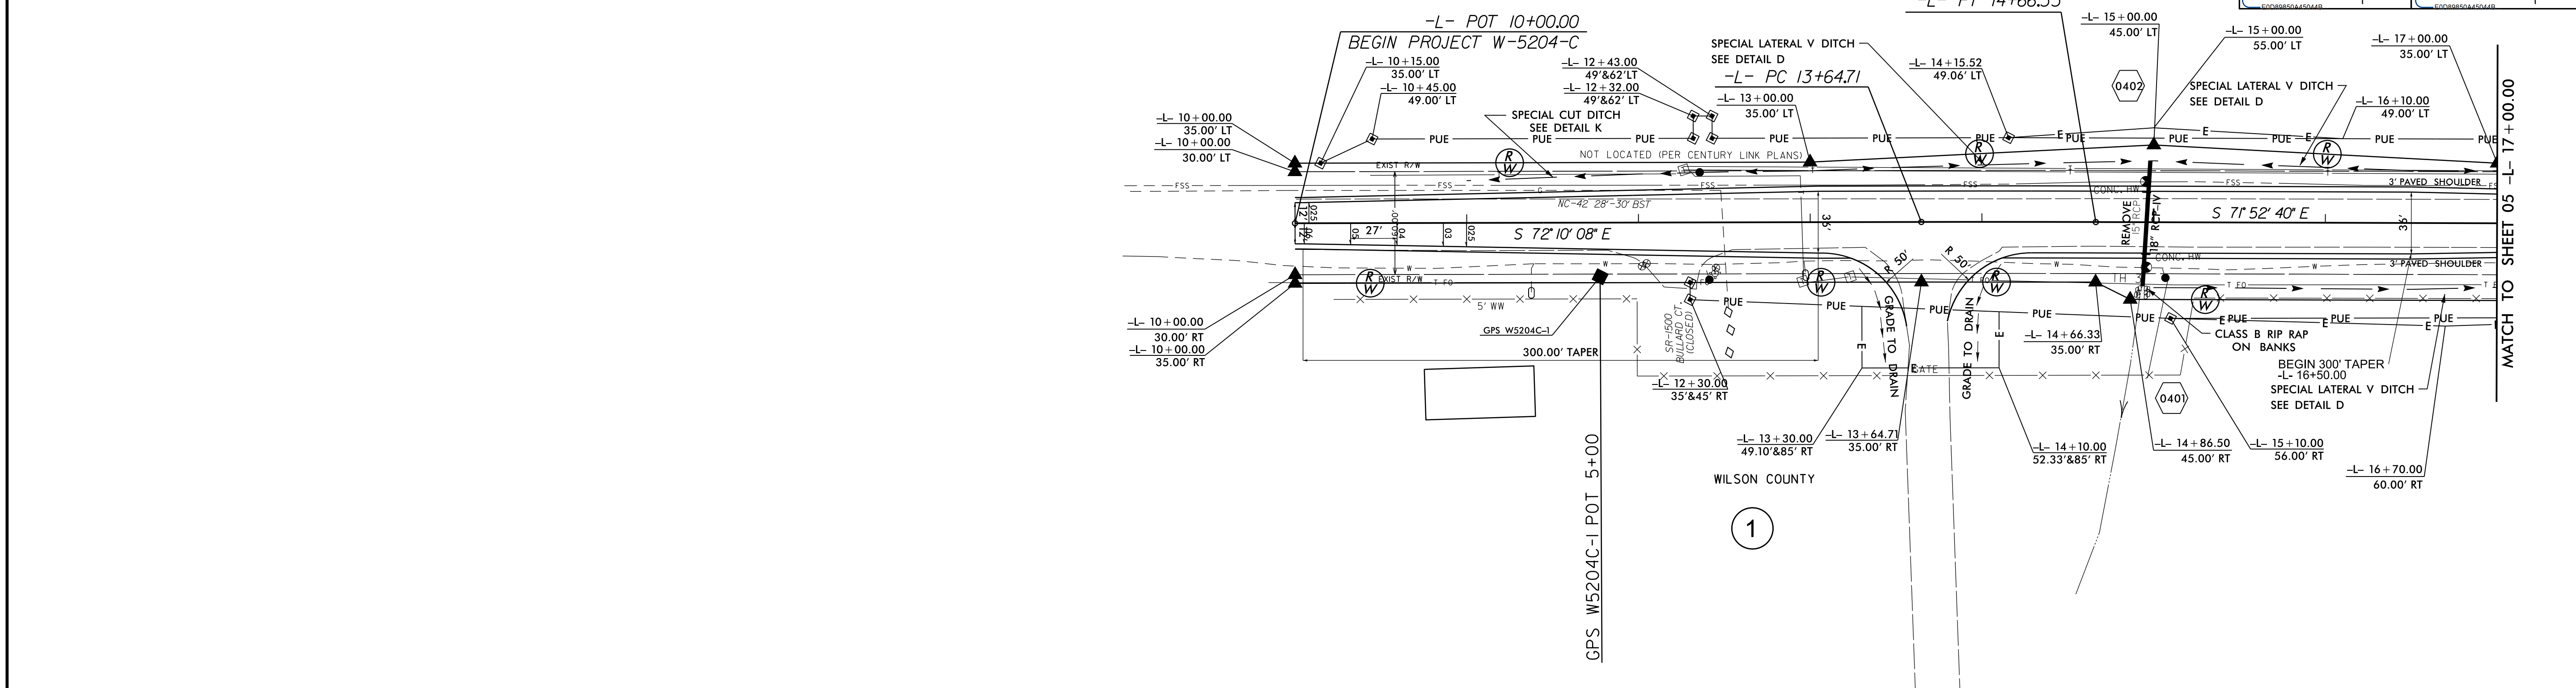

PROJECT REFERENCE NO.
W-5204C

SHEET NO.
05



R/W SHEET NO.
05

ROADWAY DESIGN ENGINEER
5/10/2021
NORTH CAROLINA
SEAL
40774
NORWOOD A. GAINEY III


HYDRAULICS ENGINEER
5/10/2021
NORTH CAROLINA
SEAL
40774
NORWOOD A. GAINEY III

REVISIONS

10-MAY-2021 08:13
R:\Roadway\Proj\W5204C_dcd4_PSH_05.dgn
\$\$\$\$\$USERNAME\$\$\$\$\$

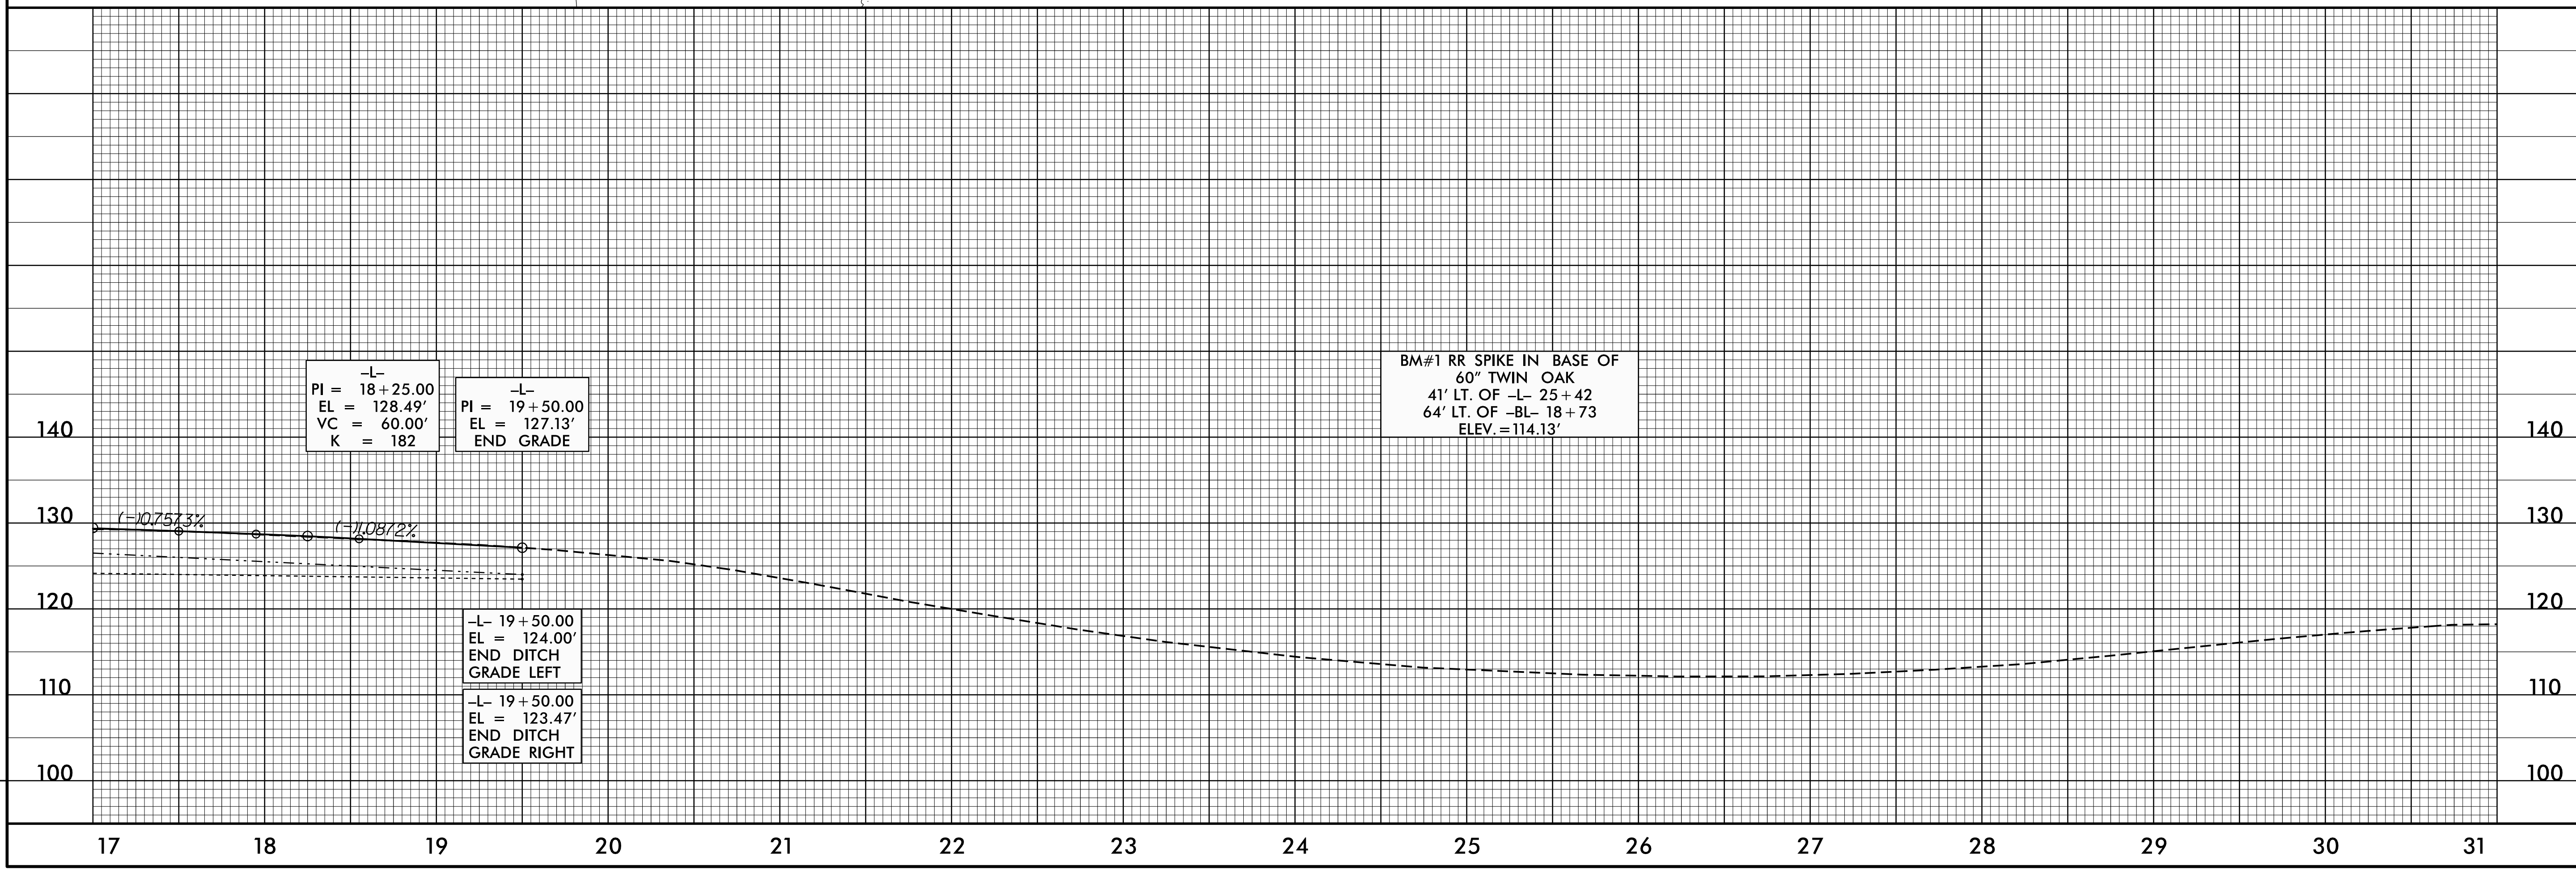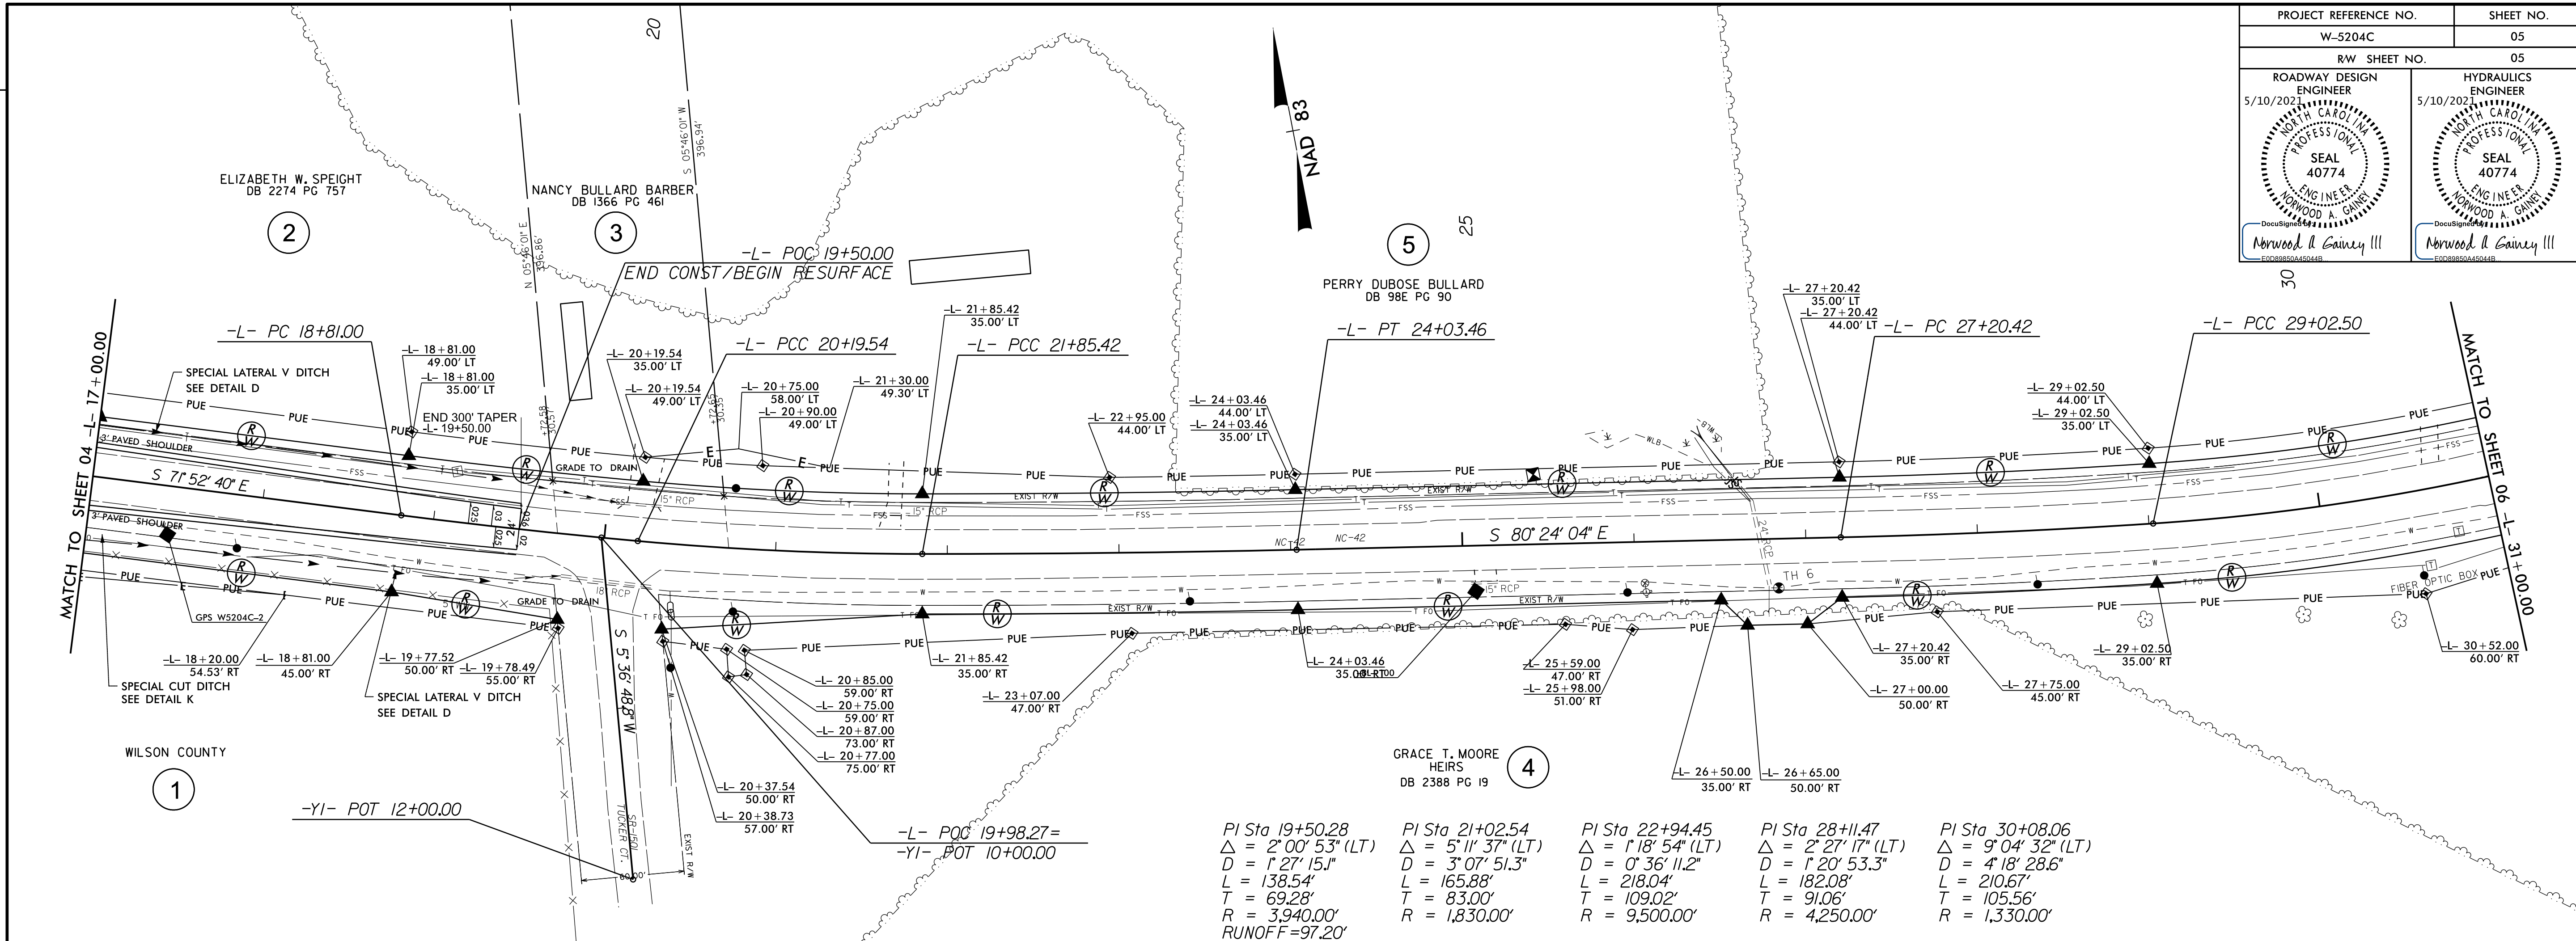


45
MAIC

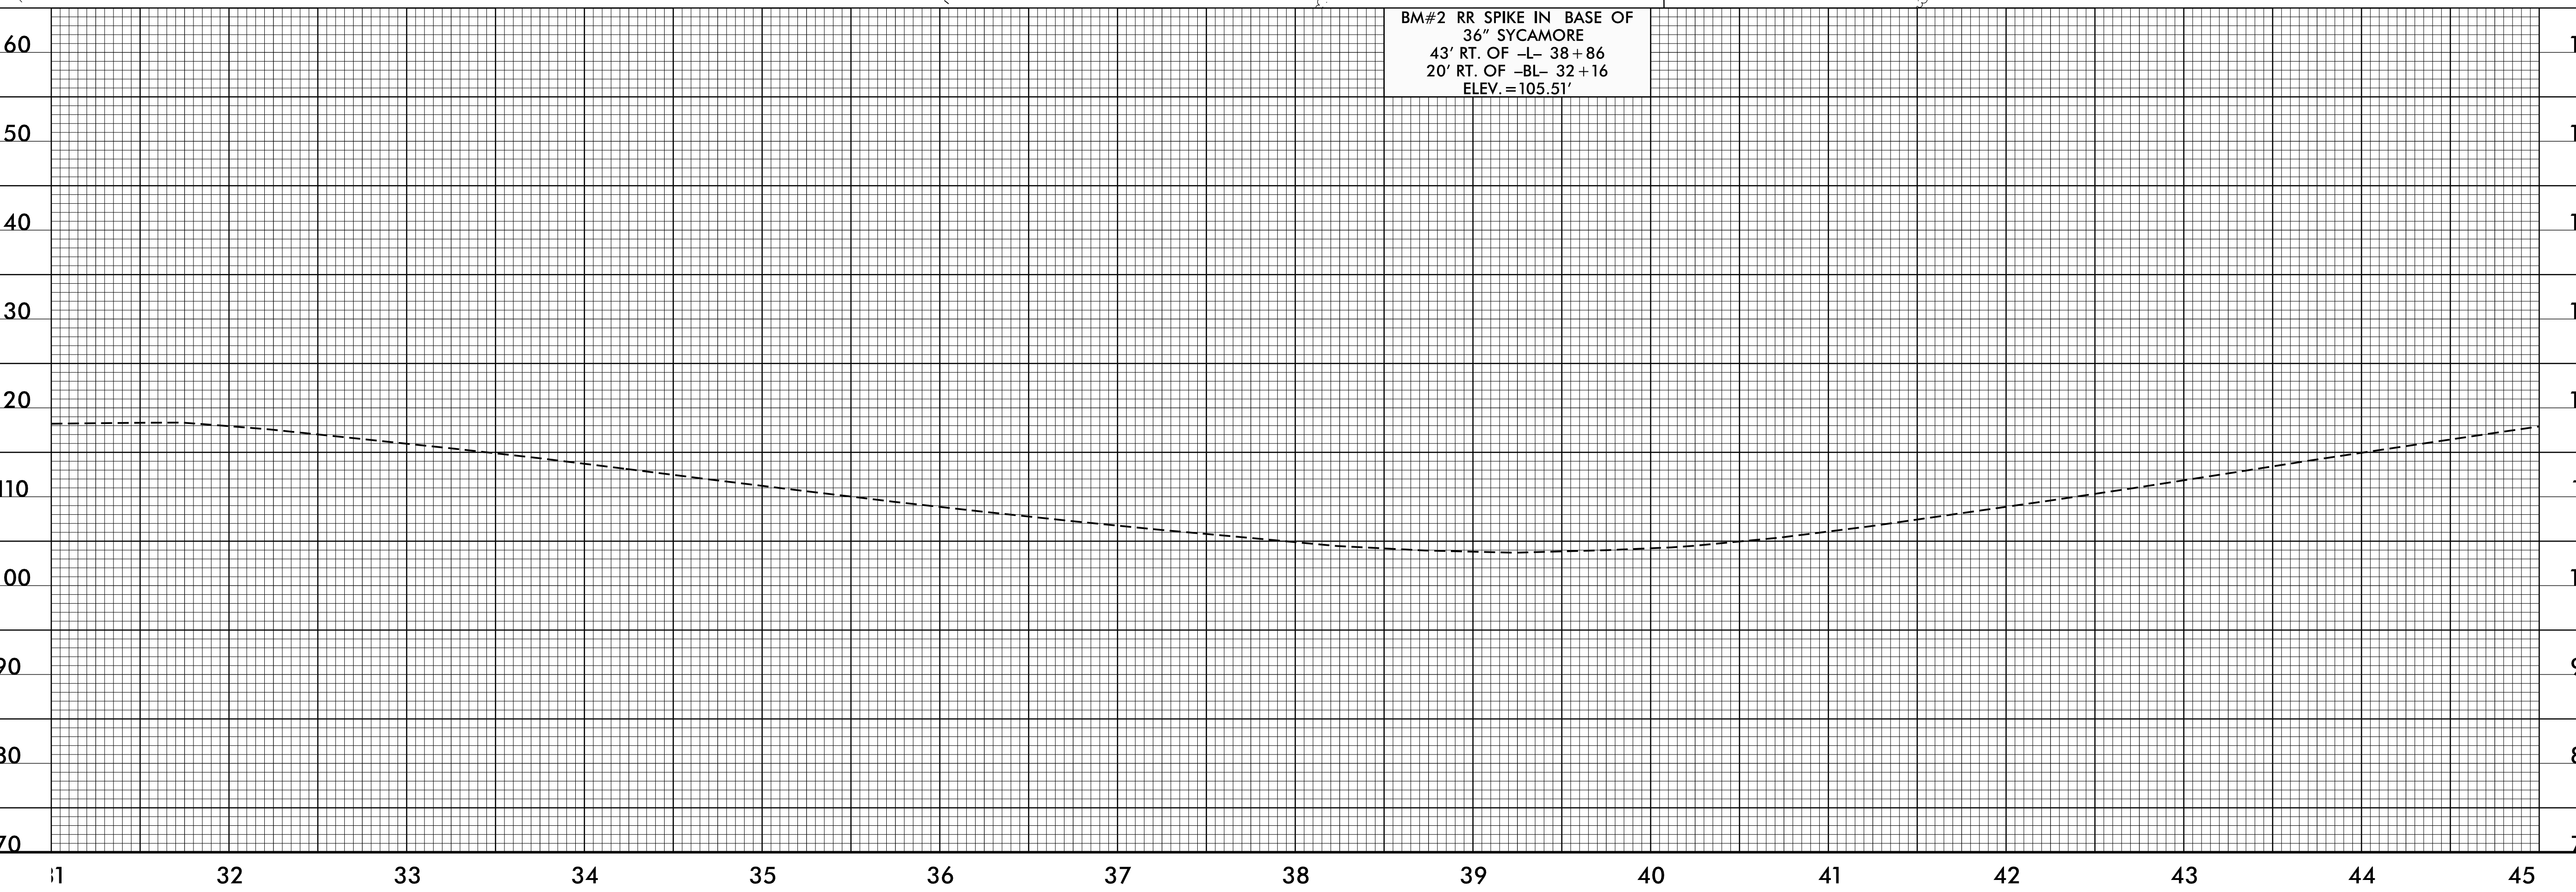

10-MAY-2021 08:13
R:\Roadway\Proj\W5204C_ddc4_PSH_06.dgn
\$\$\$\$\$USERNAME\$\$\$\$\$

10-MAY-2021 08:13
R:\Roadway\Proj\W5204C_dcd4_PSH_08.dgn
\$\$\$\$\$USERNAME\$\$\$\$\$



REVISIONS

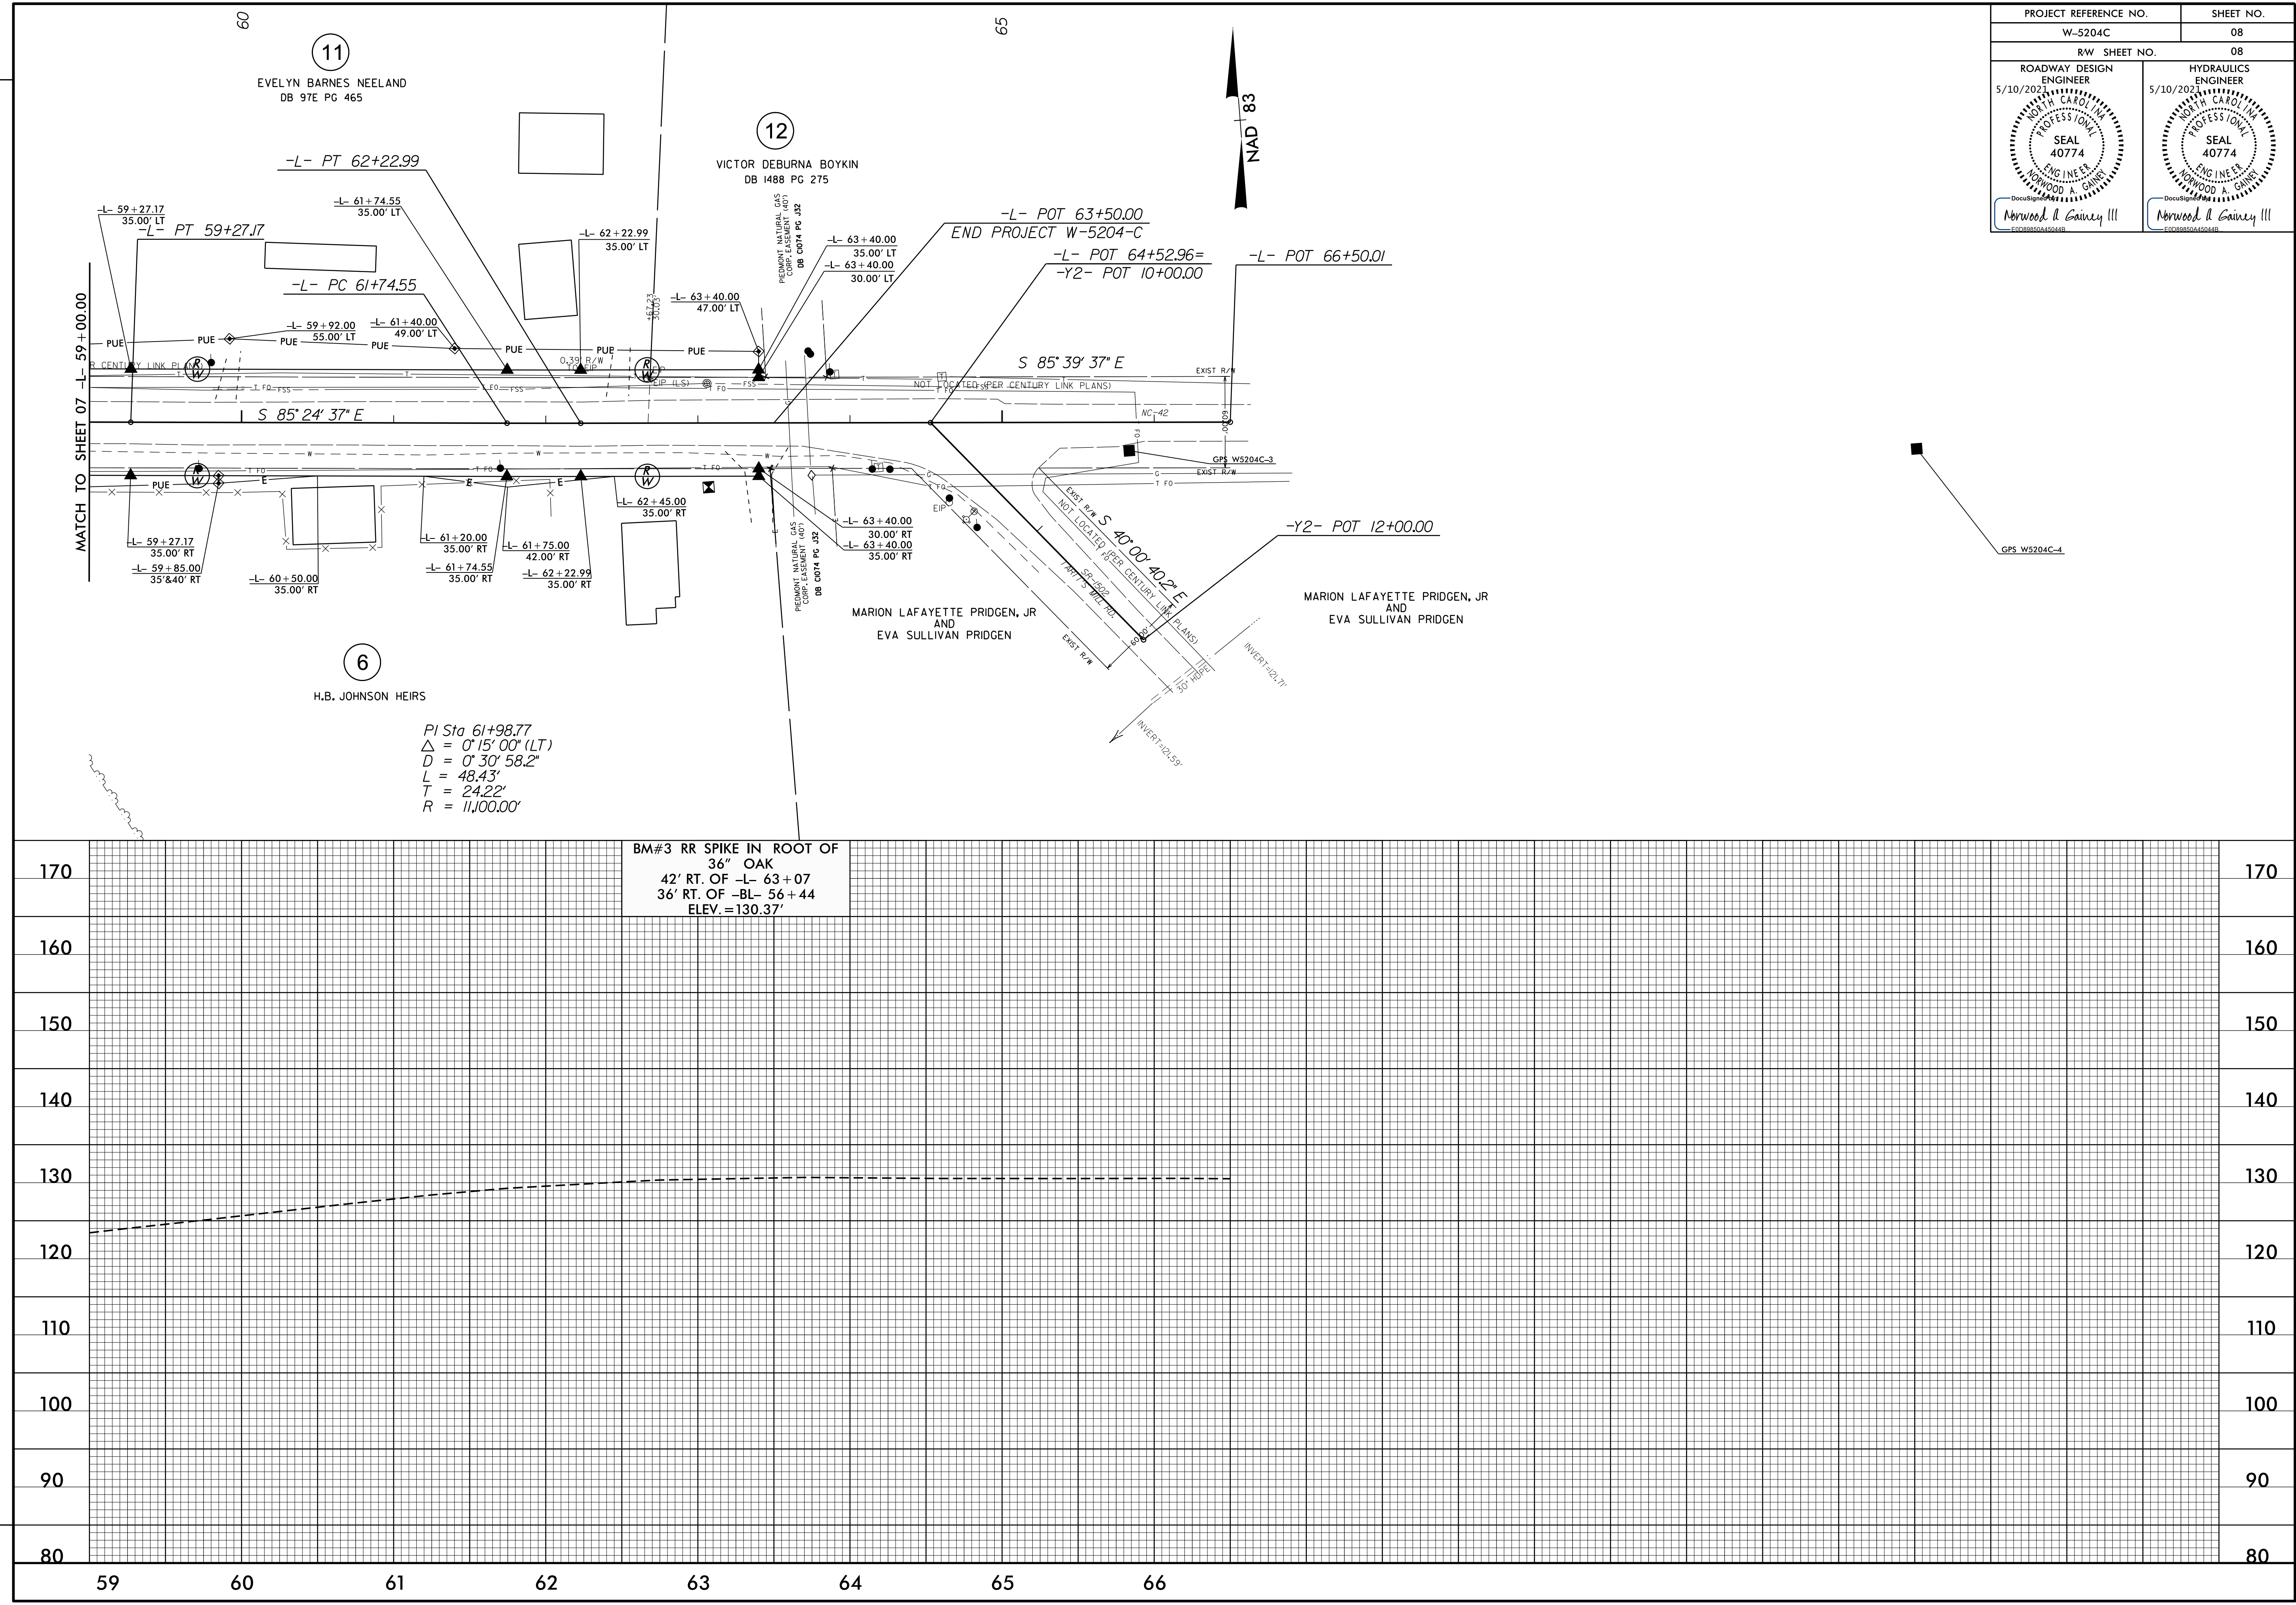


PROJECT REFERENCE NO.		SHEET NO.	
W-5204C		08	
R/W SHEET NO.		08	
ROADWAY DESIGN ENGINEER		HYDRAULICS ENGINEER	
5/10/2021		5/10/2021	
Norwood A. Gainer III		Norwood A. Gainer III	

STATE OF NORTH CAROLINA
DIVISION OF HIGHWAYS

TRANSPORTATION MANAGEMENT PLAN
WILSON COUNTY

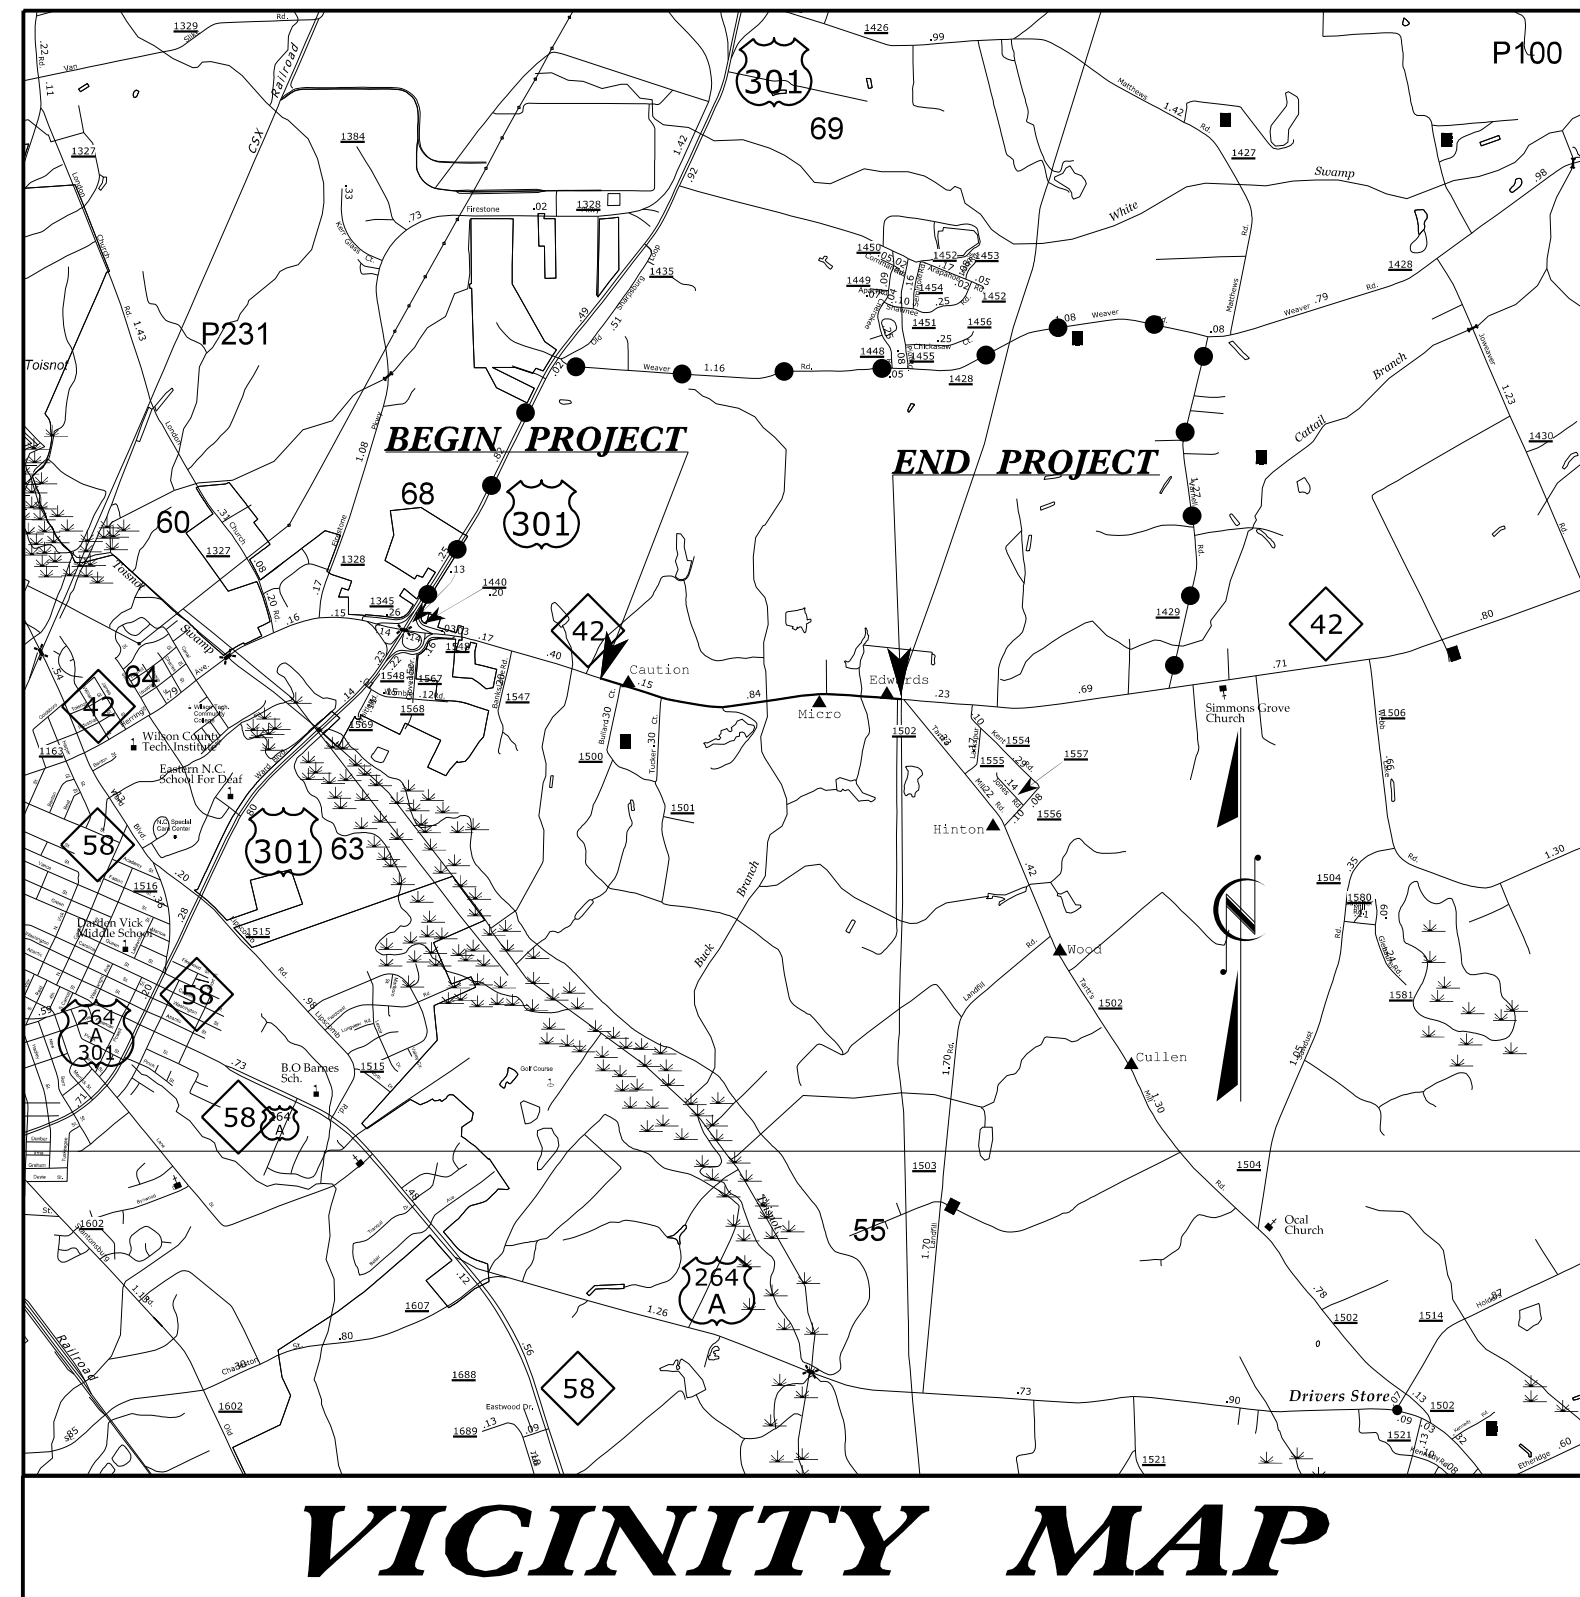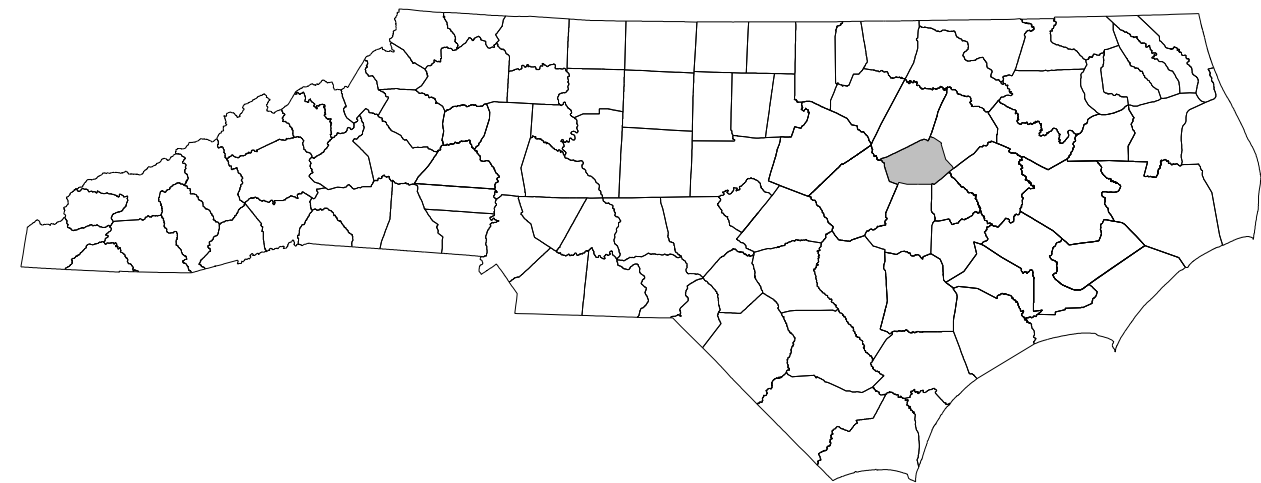

VICINITY MAP

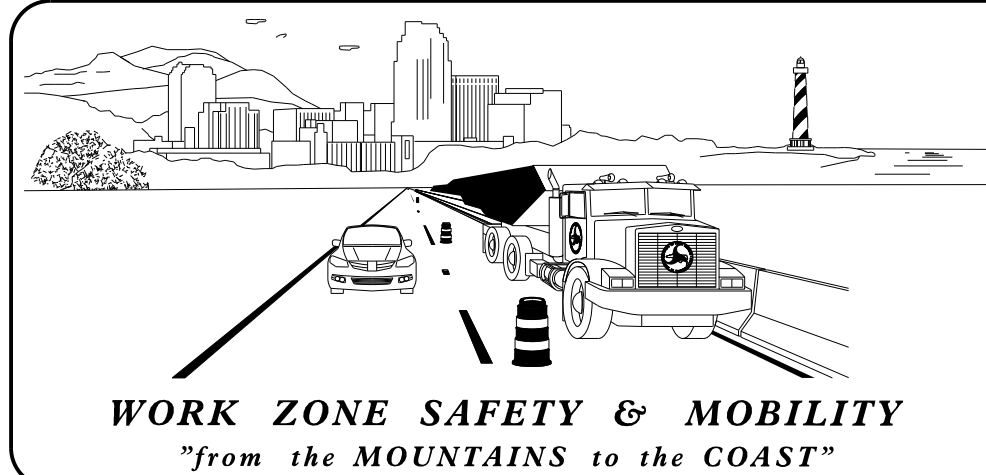


N.C.D.O.T. WORK ZONE TRAFFIC CONTROL
1561 MAIL SERVICE CENTER (MSC) RALEIGH, NC 27699-1561
750 N. GREENFIELD PARKWAY, GARNER, NC 27529 (DELIVERY)
PHONE: (919) 773-2800 FAX: (919) 771-2745

DR. J. E. HUMMER, P.E. STATE TRAFFIC MANAGEMENT ENGINEER

J. S. KITE, P.E. TRAFFIC CONTROL PROJECT ENGINEER

TRAFFIC CONTROL PROJECT DESIGN ENGINEER

S. B. JENNINGS TRAFFIC CONTROL DESIGN ENGINEER

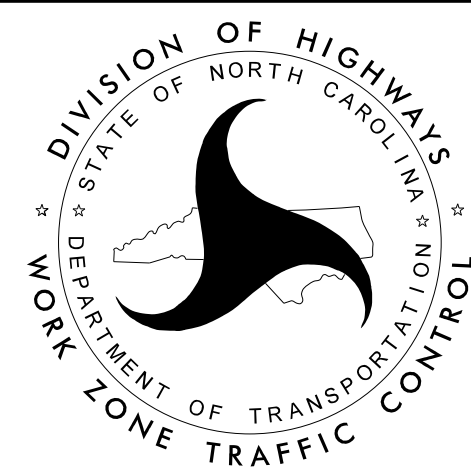

INDEX OF SHEETS


SHEET NO.	TITLE
TMP-1	TITLE SHEET, VICINITY MAP, INDEX OF SHEETS AND LIST OF APPLICABLE ROADWAY STANDARDS
TMP-1A	TRANSPORTATION OPERATIONS PLAN: GENERAL NOTES AND PHASING
TMP-2	WEEKEND CLOSURE FOR PIPE INSTALLATION

ROADWAY STANDARD DRAWINGS


THE FOLLOWING ROADWAY STANDARDS AS SHOWN IN "ROADWAY STANDARD DRAWINGS" N.C. DEPARTMENT OF TRANSPORTATION - RALEIGH, N.C., DATED JANUARY 2018 ARE APPLICABLE TO THIS PROJECT AND BY REFERENCE HEREBY ARE CONSIDERED A PART OF THESE PLANS:

STD. NO.	TITLE
1101.01	WORK ZONE ADVANCE WARNING SIGNS
1101.02	TEMPORARY LANE CLOSURES
1101.03	TEMPORARY ROAD CLOSURES
1101.04	TEMPORARY SHOULDER CLOSURES
1101.05	WORK ZONE VEHICLE ACCESSES
1101.06	WARNING SIGNS FOR BLASTING ZONES
1101.11	TRAFFIC CONTROL DESIGN TABLES
1110.01	STATIONARY WORK ZONE SIGNS
1110.02	PORTABLE WORK ZONE SIGNS
1115.01	FLASHING ARROW BOARDS
1130.01	DRUM
1135.01	CONES
1145.01	BARRICADES
1150.01	FLAGGING DEVICES
1160.01	TEMPORARY CRASH CUSHION
1165.01	WORK VEHICLE LIGHTING SYSTEMS AND TMA DELINEATION
1170.01	POSITIVE PROTECTION
1180.01	SKINNY-DRUM
1205.01	PAVEMENT MARKINGS - LINE TYPES AND OFFSETS
1205.02	PAVEMENT MARKINGS - TWO-LANE AND MULTI-LANE ROADWAYS
1205.03	PAVEMENT MARKINGS - EXITS AND ENTRANCE RAMPs
1205.04	PAVEMENT MARKINGS - INTERSECTIONS
1205.05	PAVEMENT MARKINGS - TURN LANES
1205.06	PAVEMENT MARKINGS - LANE DROPS
1205.07	PAVEMENT MARKINGS - PEDESTRIAN CROSSWALKS
1205.08	PAVEMENT MARKINGS - SYMBOLS AND WORD MESSAGES
1205.09	PAVEMENT MARKINGS - PAINTED ISLANDS
1205.10	PAVEMENT MARKINGS - SCHOOL AREAS
1205.11	PAVEMENT MARKINGS - RAILROAD CROSSINGS
1205.12	PAVEMENT MARKINGS - BRIDGES
1205.13	PAVEMENT MARKINGS - LANE REDUCTIONS
1250.01	RAISED PAVEMENT MARKERS - INSTALLATION SPACING
1251.01	RAISED PAVEMENT MARKERS - PERMANENT AND TEMPORARY
1261.01	GUARDRAIL AND BARRIER DELINEATORS - INSTALLATION SPACING
1261.02	GUARDRAIL AND BARRIER DELINEATORS - TYPES AND MOUNTING
1262.01	GUARDRAIL END DELINEATION
1264.01	OBJECT MARKERS - TYPES
1264.02	OBJECT MARKERS - INSTALLATION

 DOCUMENT NOT CONSIDERED FINAL
UNLESS ALL SIGNATURES COMPLETED

APPROVED: 
DATE: 6/27/2019

SEAL

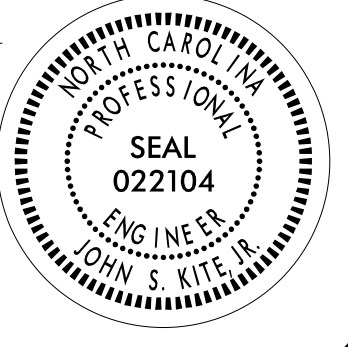

SHEET NO.

TMP-1

W-5204C

TIP PROJECT:

GENERAL NOTES

CHANGES MAY BE REQUIRED WHEN PHYSICAL DIMENSIONS IN THE DETAIL DRAWINGS, STANDARD DETAILS, AND ROADWAY DETAILS ARE NOT ATTAINABLE TO MEET FIELD CONDITIONS OR RESULT IN DUPLICATE OR UNDESIRE

THE FOLLOWING GENERAL NOTES APPLY AT ALL TIMES FOR THE DURATION OF THE CONSTRUCTION PROJECT EXCEPT WHEN OTHERWISE NOTED IN THE PLAN OR DIRECTED BY THE ENGINEER.

TIME RESTRICTIONS

A) DO NOT CLOSE OR NARROW TRAVEL LANES AS FOLLOWS:

ROAD NAME	DAY AND TIME RESTRICTIONS
NC 42	MONDAY THRU FRIDAY 6:00 A.M. TO 9:00 A.M. AND 4:00 P.M. TO 7:00 P.M.

B) DO NOT CLOSE OR NARROW TRAVEL LANES DURING HOLIDAYS AND SPECIAL EVENTS AS FOLLOWS:

ROAD NAME
NC 42

HOLIDAY

- FOR ANY UNEXPECTED OCCURRENCE THAT CREATES UNUSUALLY HIGH TRAFFIC VOLUMES, AS DIRECTED BY THE ENGINEER.
- FOR NEW YEAR’S, BETWEEN THE HOURS OF 6:00 A.M. DECEMBER 31st TO 7:00 P.M. JANUARY 2ND. IF NEW YEAR’S DAY IS ON A FRIDAY, SATURDAY, SUNDAY, OR MONDAY THEN UNTIL 7:00 P.M. THE FOLLOWING TUESDAY.
- FOR EASTER, BETWEEN THE HOURS OF 6:00 A.M. THURSDAY AND 7:00 P.M. MONDAY.
- FOR MEMORIAL DAY, BETWEEN THE HOURS OF 6:00 A.M. FRIDAY TO 7:00 P.M. TUESDAY.
- FOR INDEPENDENCE DAY, BETWEEN THE HOURS OF 6:00 A.M. THE DAY BEFORE INDEPENDENCE DAY AND 7:00 P.M. THE DAY AFTER INDEPENDENCE DAY.

IF INDEPENDENCE DAY IS ON A FRIDAY, SATURDAY, SUNDAY OR MONDAY THEN BETWEEN THE HOURS OF 6:00 A.M. THE THURSDAY BEFORE INDEPENDENCE DAY AND 7:00 P.M. THE TUESDAY AFTER INDEPENDENCE DAY.
- FOR LABOR DAY, BETWEEN THE HOURS OF 6:00 A.M. FRIDAY AND 7:00 P.M. TUESDAY.
- FOR THANKSGIVING DAY, BETWEEN THE HOURS OF 6:00 A.M. TUESDAY TO 7:00 P.M. MONDAY.
- FOR CHRISTMAS, BETWEEN THE HOURS OF 6:00 A.M. THE FRIDAY BEFORE THE WEEK OF CHRISTMAS DAY AND 7:00 P.M. THE FOLLOWING TUESDAY AFTER THE WEEK OF CHRISTMAS.

D) DO NOT CONDUCT ANY HAULING OPERATIONS AGAINST THE FLOW OF TRAFFIC OF AN OPEN TRAVELWAY UNLESS THE HAULING OPERATION IS PROTECTED BY BARRIER OR GUARDRAIL OR AS DIRECTED BY THE ENGINEER.

LANE AND SHOULDER CLOSURE REQUIREMENTS

- D) REMOVE LANE CLOSURE DEVICES FROM THE LANE WHEN WORK IS NOT BEING PERFORMED BEHIND THE LANE CLOSURE OR WHEN A LANE CLOSURE IS NO LONGER NEEDED OR AS DIRECTED BY THE ENGINEER.
- E) WHEN PERSONNEL AND/OR EQUIPMENT ARE WORKING WITHIN 15 FT OF AN OPEN TRAVEL LANE, CLOSE THE NEAREST OPEN SHOULDER USING ROADWAY STANDARD DRAWING NO. 1101.04 UNLESS THE WORK AREA IS PROTECTED BY BARRIER OR GUARDRAIL OR A LANE CLOSURE IS INSTALLED.
- F) WHEN PERSONNEL AND/OR EQUIPMENT ARE WORKING ON THE SHOULDER ADJACENT TO AN UNDIVIDED FACILITY AND WITHIN 5 FT OF AN OPEN TRAVEL LANE, CLOSE THE NEAREST OPEN TRAVEL LANE USING ROADWAY STANDARD DRAWING NO. 1101.02 UNLESS THE WORK AREA IS PROTECTED BY BARRIER OR GUARDRAIL.
- WHEN PERSONNEL AND/OR EQUIPMENT ARE WORKING ON THE SHOULDER ADJACENT TO A DIVIDED FACILITY AND WITHIN 10 FT OF AN OPEN TRAVEL LANE, CLOSE THE NEAREST OPEN TRAVEL LANE USING ROADWAY STANDARD DRAWING NO. 1101.02 UNLESS THE WORK AREA IS PROTECTED BY BARRIER OR GUARDRAIL.
- G) WHEN PERSONNEL AND/OR EQUIPMENT ARE WORKING WITHIN A LANE OF TRAVEL OF AN UNDIVIDED OR DIVIDED FACILITY, CLOSE THE LANE ACCORDING TO THE TRAFFIC CONTROL PLANS, ROADWAY STANDARD DRAWINGS, OR AS DIRECTED BY THE ENGINEER. CONDUCT THE WORK SO THAT ALL PERSONNEL AND/OR EQUIPMENT REMAIN WITHIN THE CLOSED TRAVEL LANE.
- H) DO NOT INSTALL MORE THAN ONE LANE CLOSURE IN ANY ONE DIRECTION ON NC 42.

PAVEMENT EDGE DROP OFF REQUIREMENTS

- I) BACKFILL AT A 6:1 SLOPE UP TO THE EDGE AND ELEVATION OF EXISTING PAVEMENT IN AREAS ADJACENT TO AN OPENED TRAVEL LANE THAT HAS AN EDGE OF PAVEMENT DROP-OFF AS FOLLOWS:
- BACKFILL DROP-OFFS THAT EXCEED 2 INCHES ON ROADWAYS WITH POSTED SPEED LIMITS OF 45 MPH OR GREATER.
- BACKFILL DROP-OFFS THAT EXCEED 3 INCHES ON ROADWAYS WITH POSTED SPEED LIMITS LESS THAN 45 MPH.
- BACKFILL WITH SUITABLE COMPACTED MATERIAL, AS APPROVED BY THE ENGINEER, AT NO EXPENSE TO THE DEPARTMENT.

TRAFFIC PATTERN ALTERATIONS

- J) NOTIFY THE ENGINEER TWENTY ONE (21) CALENDAR DAYS PRIOR TO ANY TRAFFIC PATTERN ALTERATION.

SIGNING

- K) INSTALL ADVANCE WORK ZONE WARNING SIGNS WHEN WORK IS WITHIN 40 FT FROM THE EDGE OF TRAVEL LANE AND NO MORE THAN THREE (3) DAYS PRIOR TO THE BEGINNING OF CONSTRUCTION.
- L) PROVIDE SIGNING AND DEVICES REQUIRED TO CLOSE THE ROAD ACCORDING TO THE ROADWAY STANDARD DRAWINGS AND TRAFFIC CONTROL PLANS.
- PROVIDE SIGNING REQUIRED FOR THE OFF-SITE DETOUR ROUTE AS SHOWN IN THE TRAFFIC CONTROL PLANS.
- M) COVER OR REMOVE ALL SIGNS AND DEVICES REQUIRED TO CLOSE THE ROAD WHEN ROAD CLOSURE IS NOT IN OPERATION.
- COVER OR REMOVE ALL SIGNS REQUIRED FOR THE OFF-SITE DETOUR WHEN THE DETOUR IS NOT IN OPERATION.
- N) ENSURE ALL NECESSARY SIGNING IS IN PLACE PRIOR TO ALTERING ANY TRAFFIC PATTERN.

PAVEMENT MARKINGS AND MARKERS

- O) INSTALL TEMPORARY PAVEMENT MARKINGS AND TEMPORARY PAVEMENT MARKERS ON INTERIM LAYERS OF PAVEMENT AS FOLLOWS:

ROAD NAME	MARKING	MARKER
NC 42	PAINT	TEMPORARY RAISED

- P) PLACE ONE APPLICATION OF PAINT FOR TEMPORARY TRAFFIC PATTERNS. PLACE A SECOND APPLICATION OF PAINT SIX (6) MONTHS AFTER THE INITIAL APPLICATION AND EVERY SIX MONTHS AS DIRECTED BY THE ENGINEER.
- Q) TIE PROPOSED PAVEMENT MARKING LINES TO EXISTING PAVEMENT MARKING LINES.
- R) REMOVE/REPLACE ANY CONFLICTING/DAMAGED PAVEMENT MARKINGS AND MARKERS BY THE END OF EACH DAY’S OPERATION.

PHASING

NOTE: CONTRACTOR SHALL MAINTAIN ACCESS TO DRIVES AT ALL TIMES

STEP 1 -- INSTALL WORK ZONE ADVANCE WARNING SIGNS ON -L- NC 42 PER RSD 1101.01, SHEET 3 OF 3.

-- INSTALL AND COVER STATIONARY SIGNS AS SHOWN ON TMP-2

-- PLACE CMS(S) AS SHOWN ON TMP-2, ACTIVATE INITIAL MESSAGE ON THE SATURDAY PRIOR TO CLOSING NC 42 IN STEP 2.

COMPLETE THE WORK REQUIRED OF STEP 2 THROUGH 4 IN 59 CONSECUTIVE HOURS BEGINNING ON A FRIDAY AT 7:00 P.M. AND ENDING THE FOLLOWING MONDAY AT 6:00 A.M. SEE INTERMEDIATE CONTRACT TIME AND LIQUIDATED DAMAGES.

STEP 2 -- USING RSD 1101.03, SHEET 1, AND TMP-2, ACTIVATE SECOND CMS(S) MESSAGES, CLOSE NC 42 AND DETOUR AS SHOWN ON TMP-2.

STEP 3 -- AWAY FROM TRAFFIC, INSTALL PIPE AT -L- STA. 26+70



STEP 4 -- REMOVE BARRICADES, PORTABLE ROAD CLOSURE SIGNS, COVER DETOUR SIGNS AND OPEN NC 42 TO TRAFFIC.

STEP 5 -- USING RSD 1101.02, SHEET 1 OF 14, WEDGE AND WIDEN -L- AS SHOWN ON THE ROADWAY PLANS, UP TO BUT NOT INCLUDING THE FINAL LAYER OF SURFACE COURSE. PLACE TEMPORARY PAVEMENT MARKING IN THE EXISTING PATTERN.

STEP 6 -- USING RSD 1101.02, SHEET 1 OF 14, PLACE FINAL LAYER OF SURFACE COURSE AND THE FINAL PAVEMENT MARKINGS.

STEP 7 -- REMOVE ALL TRAFFIC CONTROL DEVICES.

APPROVED: DocuSigned by: Norwood A Gaine 62060020A40040... 7/6/2021 SEAL DOCUMENT NOT CONSIDERED FINAL UNLESS ALL SIGNATURES COMPLETED	SEAL 40774 ENGINEER NORWOOD A. GAINES DIVISION OF HIGHWAYS STATE OF NORTH CAROLINA DEPARTMENT OF TRANSPORTATION WORK ZONE TRAFFIC CONTROL	TRANSPORTATION OPERATIONS PLAN
---	---	---

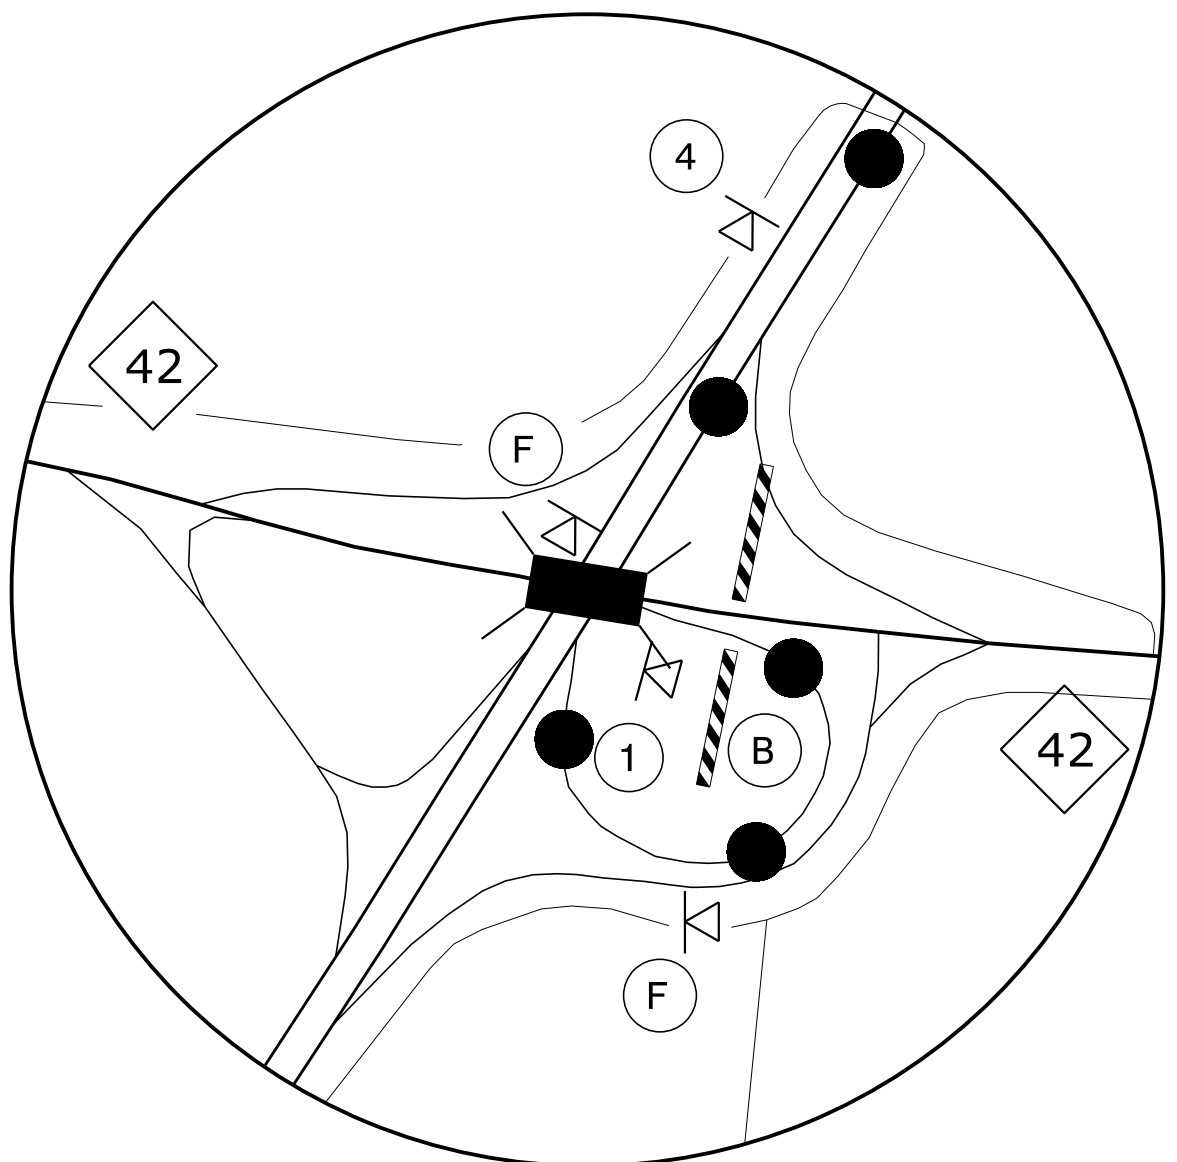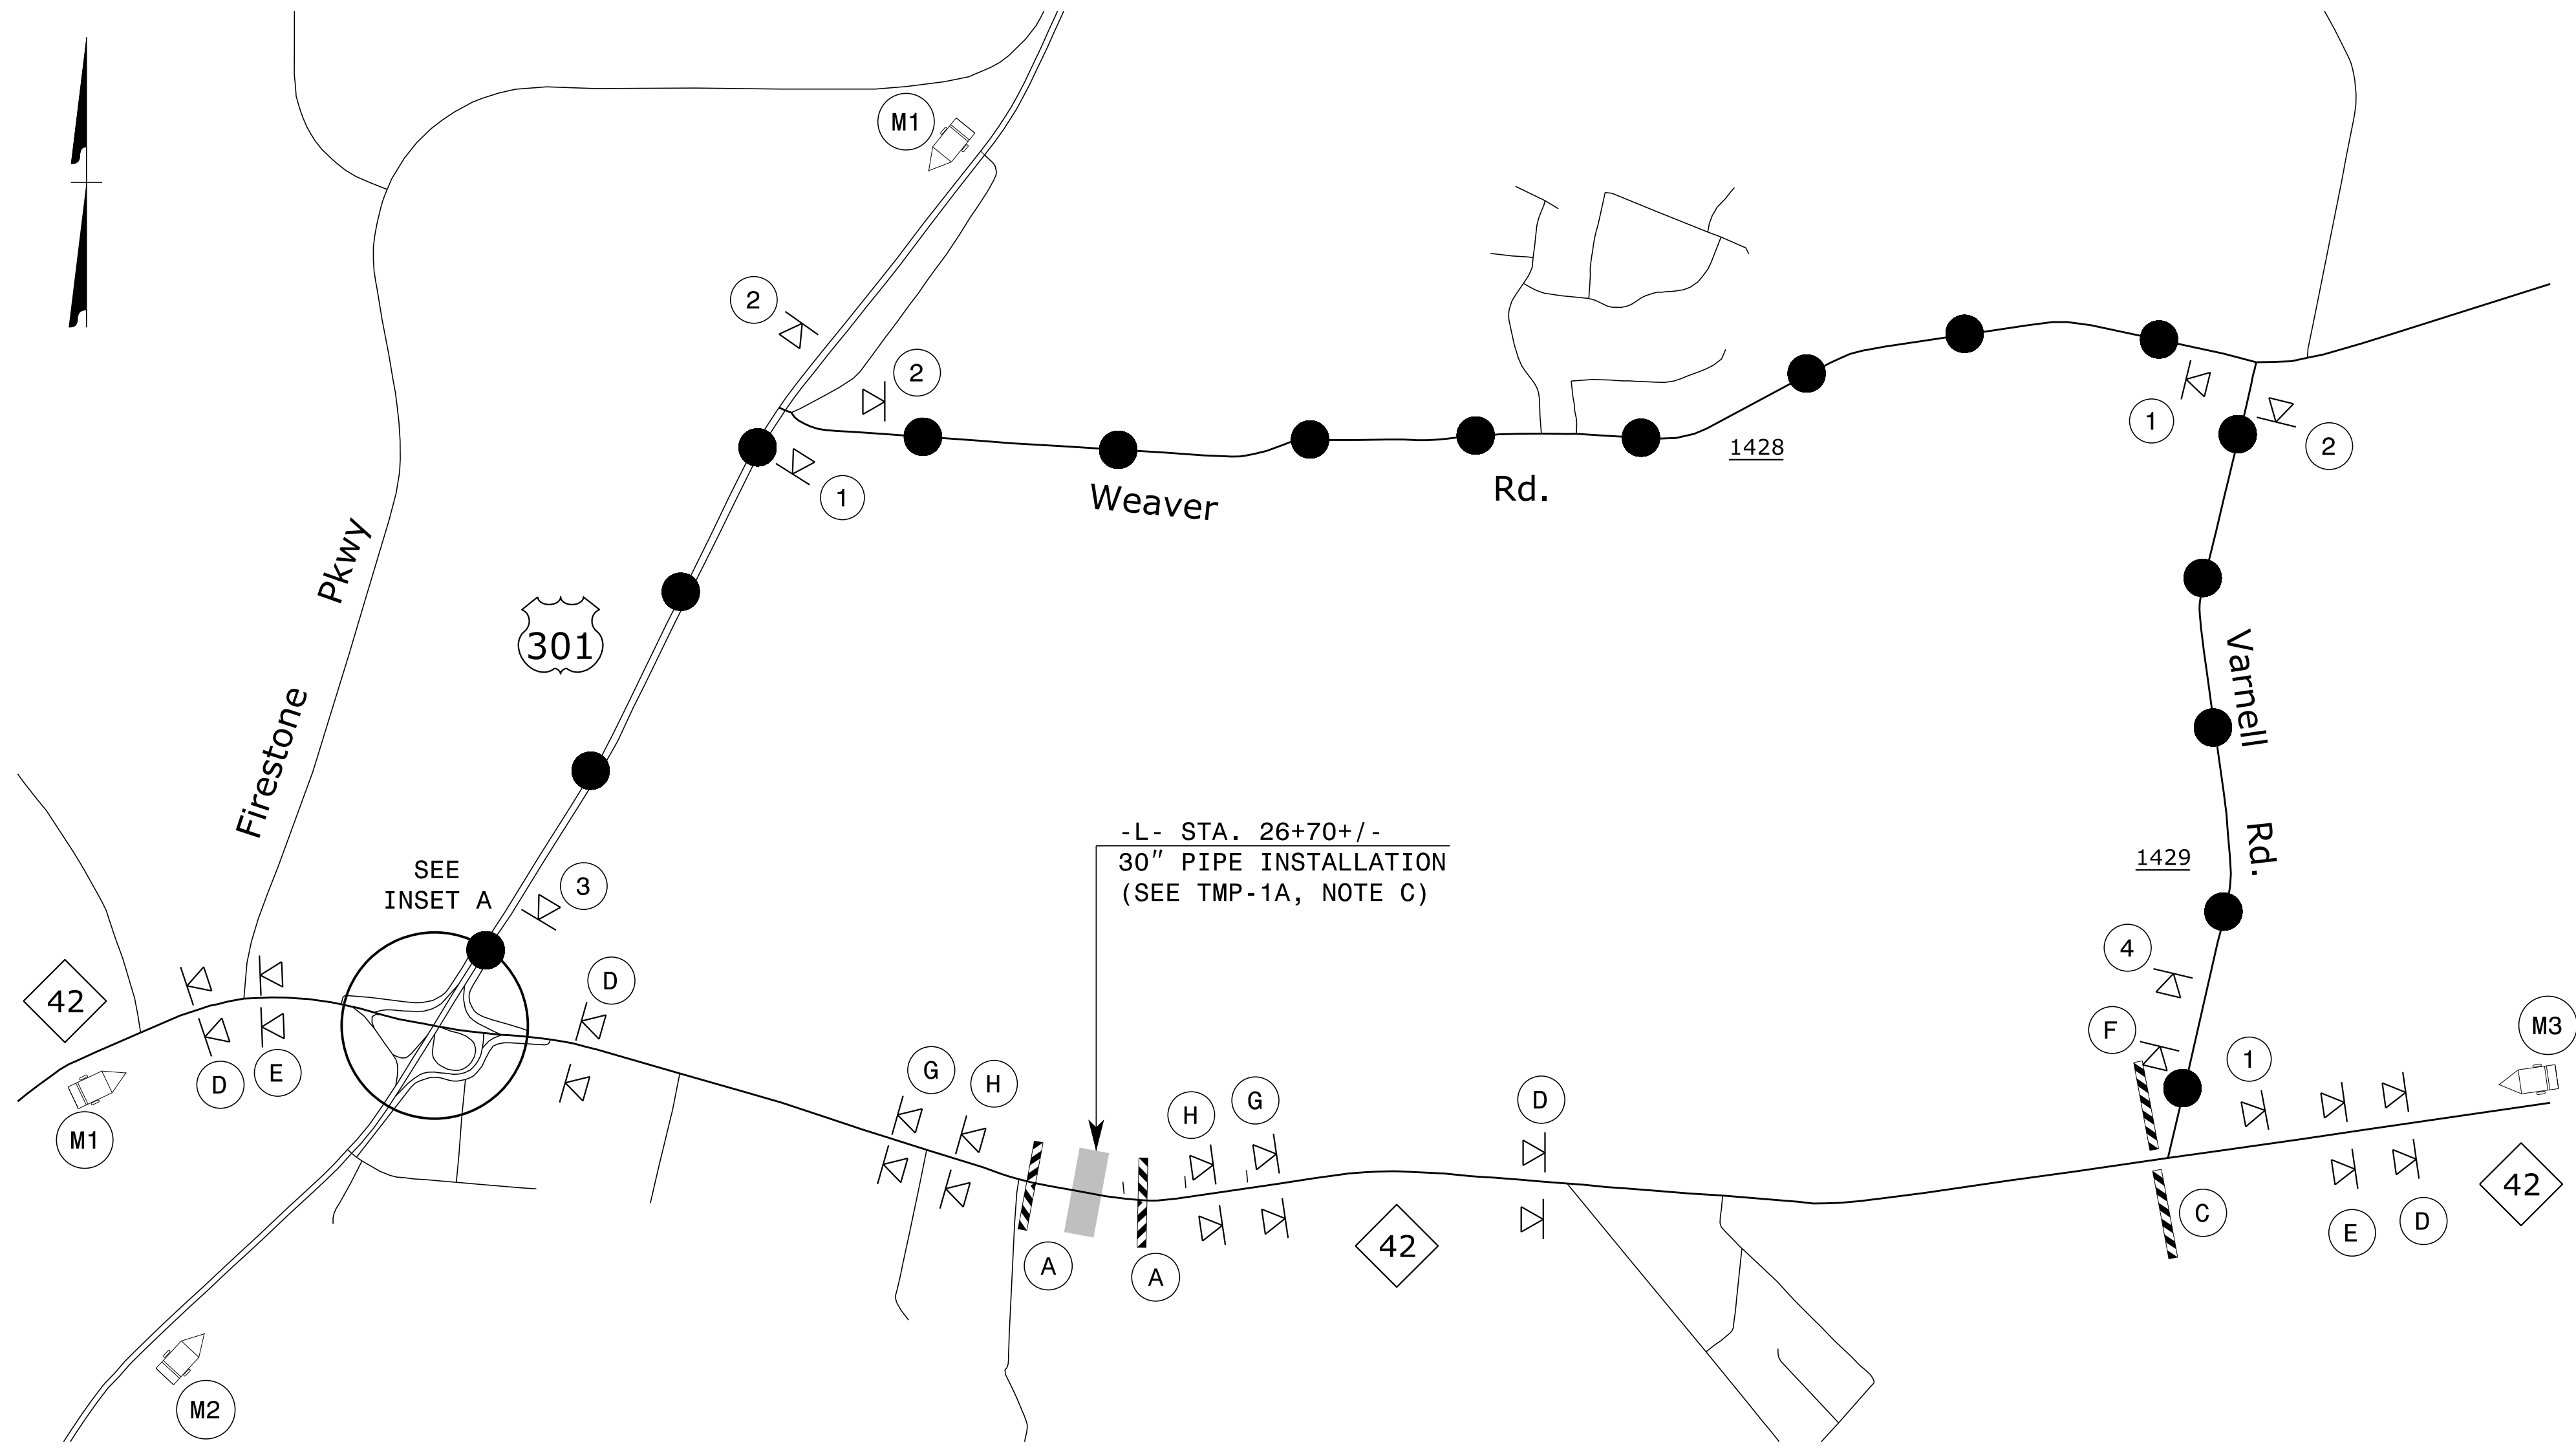

INSET A

PLACE ALL CMS BOARDS 1 MILE +/- BEFORE DETOUR

M1

+

M2

M3

MESSAGE NO. 1	MESSAGE NO. 2
NC 42 E	FRI 6 PM
WILL	UNTIL
CLOSE	MON 6 AM

MESSAGE NO. 1	MESSAGE NO. 2
NC 42 W	FRI 6 PM
WILL	UNTIL
CLOSE	MON 6 AM


CHANGEABLE MESSAGE
SIGN

CHANGEABLE MESSAGE
SIGN


MESSAGE BEGINNING MONDAY PRIOR TO ROAD CLOSURE

M1		M2		M3	
MESSAGE NO. 1	MESSAGE NO. 2	MESSAGE NO. 1	MESSAGE NO. 2	MESSAGE NO. 1	MESSAGE NO. 2
NC 42 E	NC 42 E	NC 42 E	NC 42 E	NC 42 W	NC 42 W
CLOSED	FOLLOW	CLOSED	STAY ON	CLOSED	FOLLOW
AHEAD	DETOUR	AHEAD	US 301	AHEAD	DETOUR
CHANGEABLE MESSAGE SIGN		CHANGEABLE MESSAGE SIGN		CHANGEABLE MESSAGE SIGN	


MESSAGE DURING ROAD CLOSURE

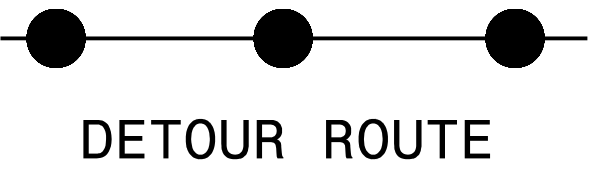


DETOUR ROUTE

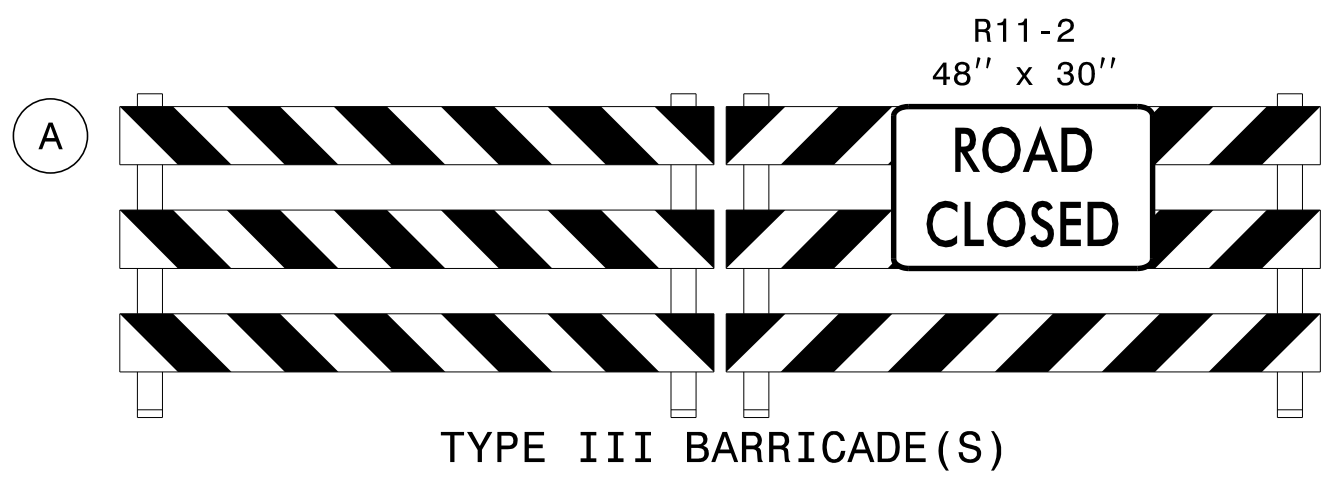



TYPE III BARRICADE(S)

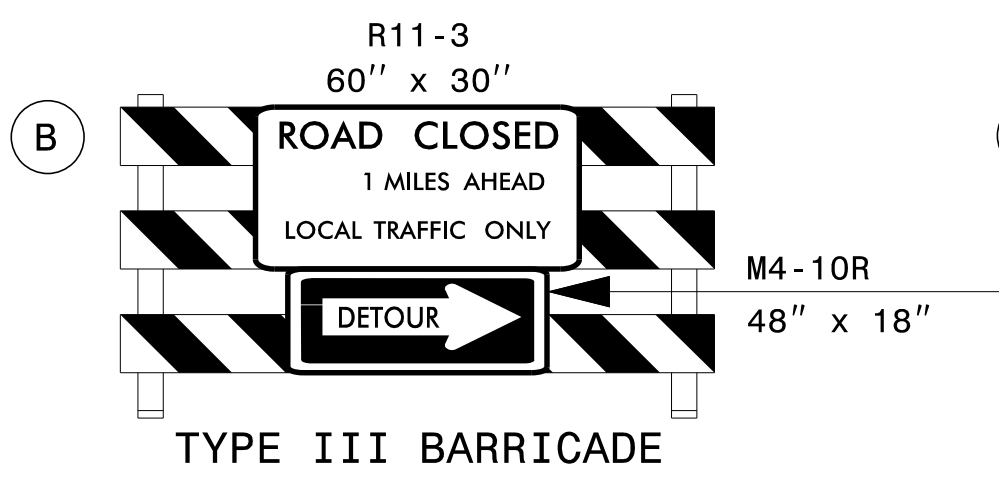


TYPE III BARRICADE

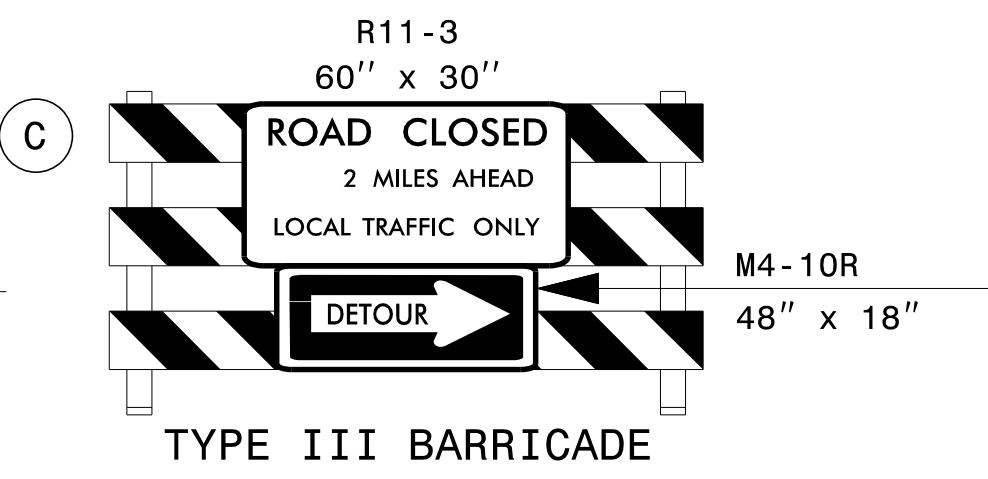

TYPE III BARRICADE

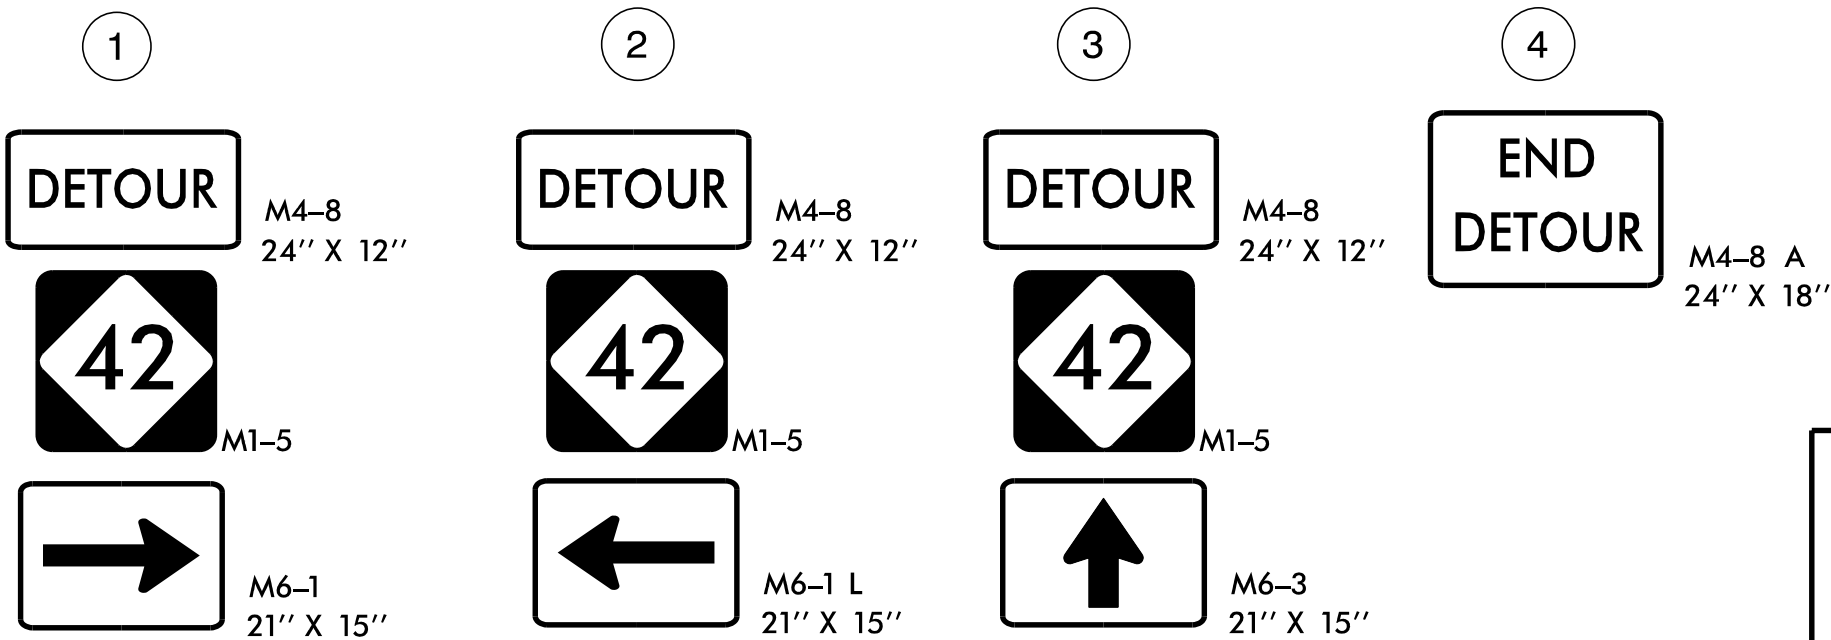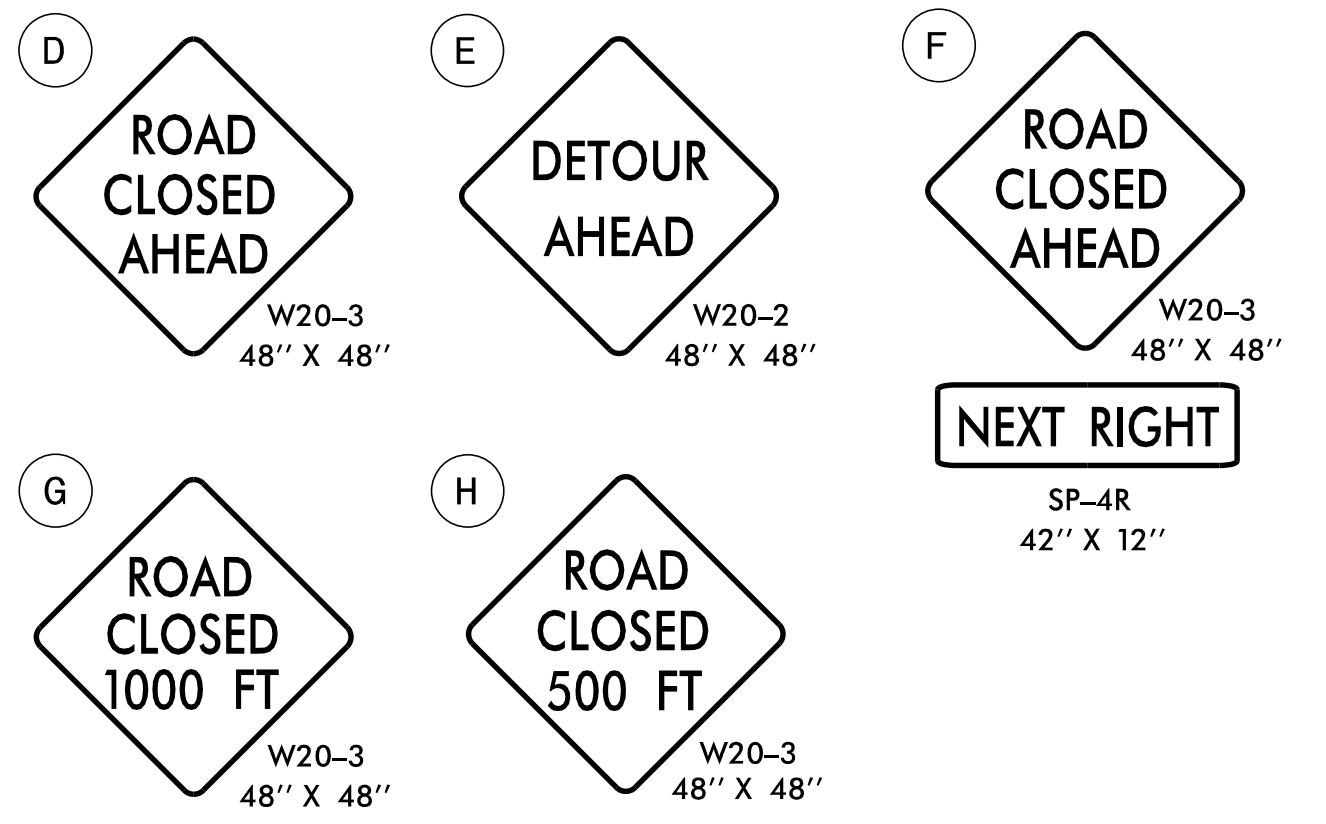


 APPROVED: 


DATE: 6/27/2019



DOCUMENT NOT CONSIDERED FINAL
UNLESS ALL SIGNATURES COMPLETED

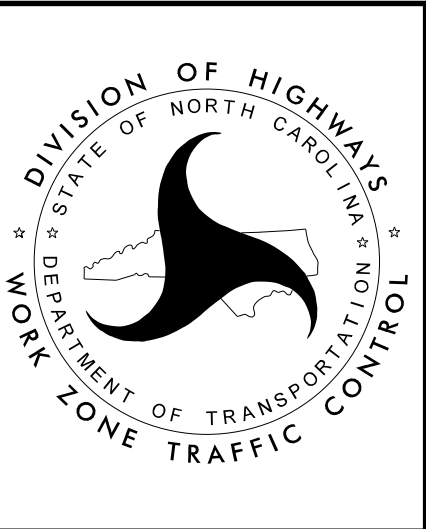

WEEKEND ROAD
CLOSURE FOR
PIPE INSTALLATON

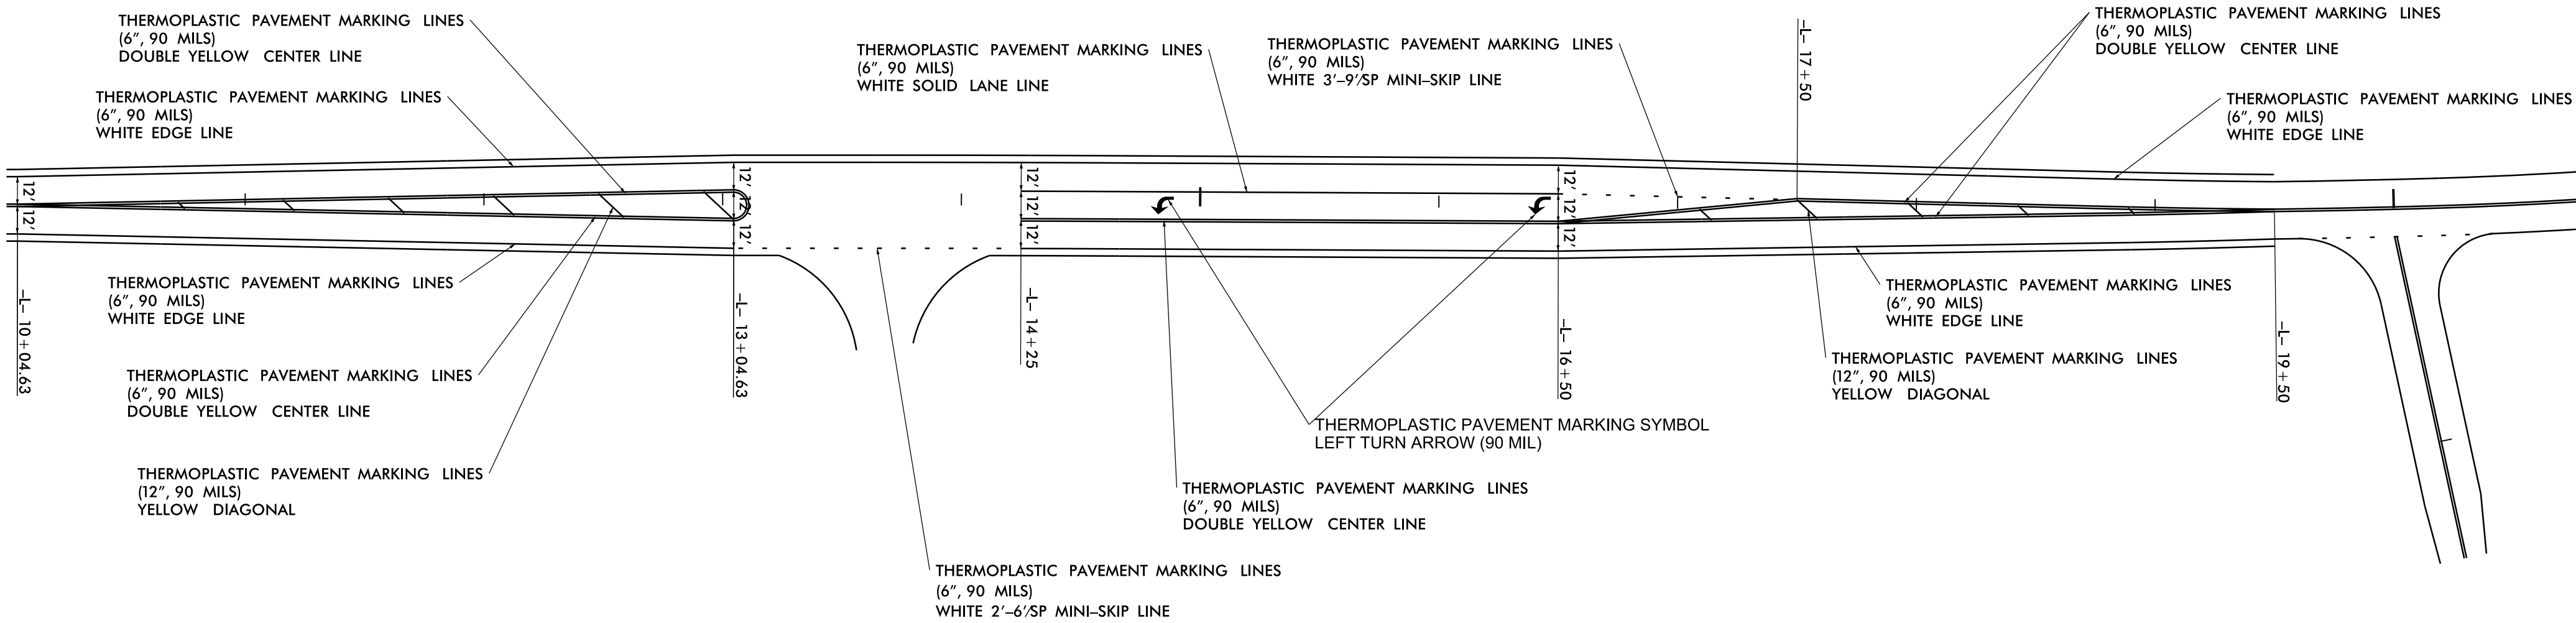


04-MAY-2021 08:49 N.C. EC- Revised 2019-10-03 TSH:dgw
W:\mnm\m\04-MAY-2021 08:49 N.C. EC- Revised 2019-10-03 TSH:dgw

TIP PROJECT: W-5204C

STATE OF NORTH CAROLINA
DIVISION OF HIGHWAYS
PLAN FOR PROPOSED
HIGHWAY EROSION CONTROL
WILSON COUNTY

LOCATION: NC-42 FROM SR-1500 (BULLARD CT.)
TO SR-1502 (TARTT'S MILL ROAD)

TYPE OF WORK: GRADING, DRAINAGE, AND PAVING.

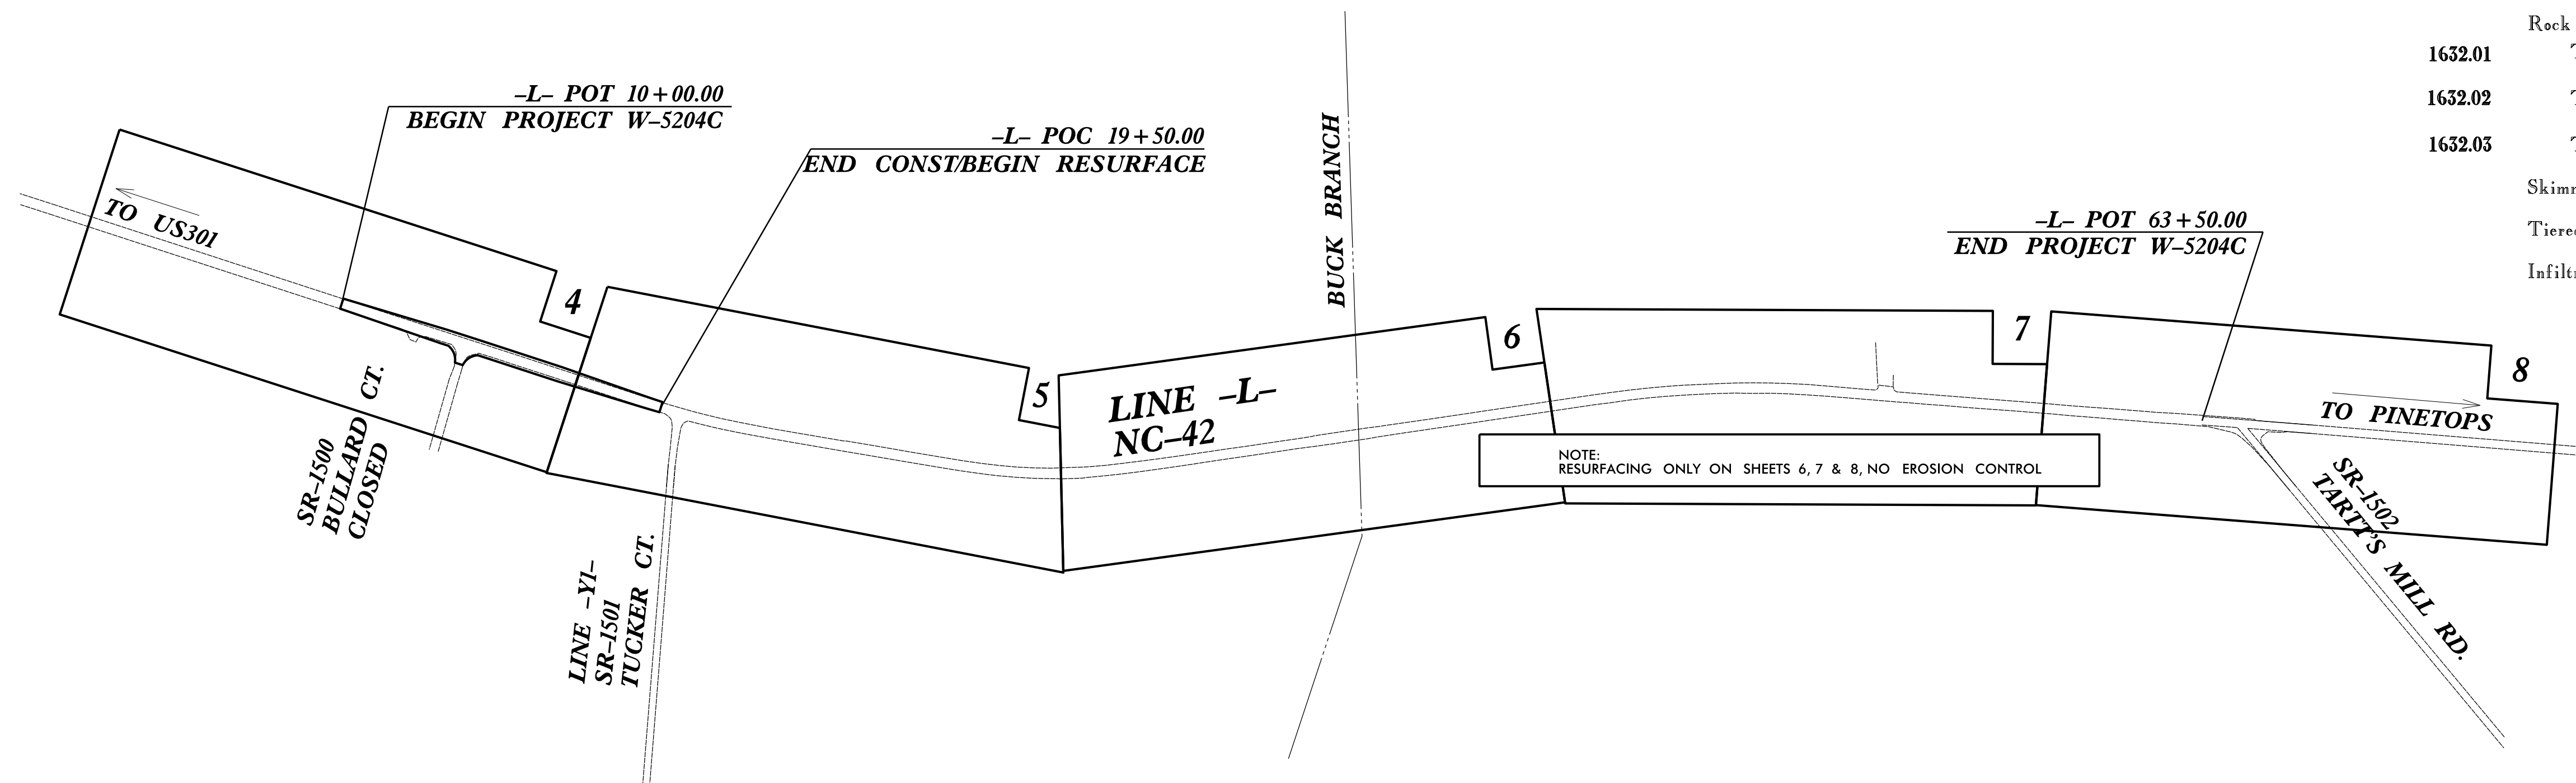

STATE	STATE PROJECT REFERENCE NO.	SHEET NO.	TOTAL SHEETS
N.C.	W-5204C	EC-1	
STATE PROJ. NO.	F.A. PROJ. NO.	DESCRIPTION	

EROSION AND SEDIMENT CONTROL MEASURES

Std. #	Description	Symbol
1630.03	Temporary Silt Ditch.....	TSO
1630.05	Temporary Diversion.....	TD
1605.01	Temporary Silt Fence.....	III III III
1606.01	Special Sediment Control Fence.....	III III III
1622.01	Temporary Berms and Slope Drains.....	III III III
1630.02	Silt Basin Type B.....	III III III
1633.01	Temporary Rock Silt Check Type-A.....	III III III
	Temporary Rock Silt Check Type-A with Matting and Polyacrylamide (PAM).....	III III III
1633.02	Temporary Rock Silt Check Type-B.....	III III III
	Wattle / Coir Fiber Wattle.....	III III III
	Wattle / Coir Fiber Wattle with Polyacrylamide (PAM).....	III III III
1634.01	Temporary Rock Sediment Dam Type-A.....	III III III
1634.02	Temporary Rock Sediment Dam Type-B.....	III III III
1635.01	Rock Pipe Inlet Sediment Trap Type-A.....	III III III
1635.02	Rock Pipe Inlet Sediment Trap Type-B.....	III III III
1630.04	Stilling Basin.....	III III III
1630.06	Special Stilling Basin.....	III III III
	Rock Inlet Sediment Trap:	III III III
1632.01	Type A.....	III III III
1632.02	Type B.....	III III III
1632.03	Type C.....	III III III
	Skimmer Basin.....	III III III
	Tiered Skimmer Basin.....	III III III
	Infiltration Basin.....	III III III

THIS PROJECT CONTAINS
EROSION CONTROL PLANS
FOR CLEARING AND
GRUBBING PHASE OF
CONSTRUCTION.

THIS PROJECT HAS
BEEN DESIGNED TO
SENSITIVE WATERSHED
STANDARDS.

ROADSIDE ENVIRONMENTAL UNIT
DIVISION OF HIGHWAYS
STATE OF NORTH CAROLINA

THESE EROSION AND SEDIMENT CONTROL PLANS COMPLY
WITH THE REGULATIONS SET FORTH BY THE
NCG-010000 GENERAL CONSTRUCTION PERMIT EFFECTIVE APRIL 1, 2019
ISSUED BY THE NORTH CAROLINA DEPARTMENT OF ENVIRONMENTAL
QUALITY DIVISION OF WATER RESOURCES.

Prepared in the Office of:
ROADSIDE ENVIRONMENTAL UNIT
1 South Wilmington St.
Raleigh, NC 27611
2018 STANDARD SPECIFICATIONS

Designed by:
Wes Chandler 3374
NAME LEVEL III CERTIFICATION NO.




Roadway Standard Drawings

The following roadway english standards as appear in "Roadway Standard Drawings"- Roadway Design Unit - N. C. Department of Transportation - Raleigh, N. C., dated January 2018 and the latest revision thereto are applicable to this project and by reference hereby are considered a part of these plans.

1604.01	Railroad Erosion Control Detail	1632.01	Rock Inlet Sediment Trap Type A
1605.01	Temporary Silt Fence	1632.02	Rock Inlet Sediment Trap Type J
1606.01	Special Sediment Control Fence	1632.03	Rock Inlet Sediment Trap Type C
1607.01	Gravel Construction Entrance	1633.01	Temporary Rock Silt Check Type A
1622.01	Temporary Berms and Slope Drains	1633.02	Temporary Rock Silt Check Type J
1630.01	Riser Basin	1634.01	Temporary Rock Sediment Dam Type A
1630.02	Silt Basin Type J	1634.02	Temporary Rock Sediment Dam Type J
1630.03	Temporary Silt Ditch	1635.01	Rock Pipe Inlet Sediment Trap Type A
1630.04	Stilling Basin	1635.02	Rock Pipe Inlet Sediment Trap Type J
1630.05	Temporary Diversion	1640.01	Coir Fiber Jaffle
1630.06	Special Stilling Basin	1645.01	Temporary Stream Crossing
1631.01	Matting Installation		



WATTLE WITH POLYACRYLAMIDE (PAM) DETAIL

PROJECT REFERENCE NO.		SHEET NO.	
W-5204C		EC-2	
RW SHEET NO.			
ROADWAY DESIGN ENGINEER		HYDRAULICS ENGINEER	

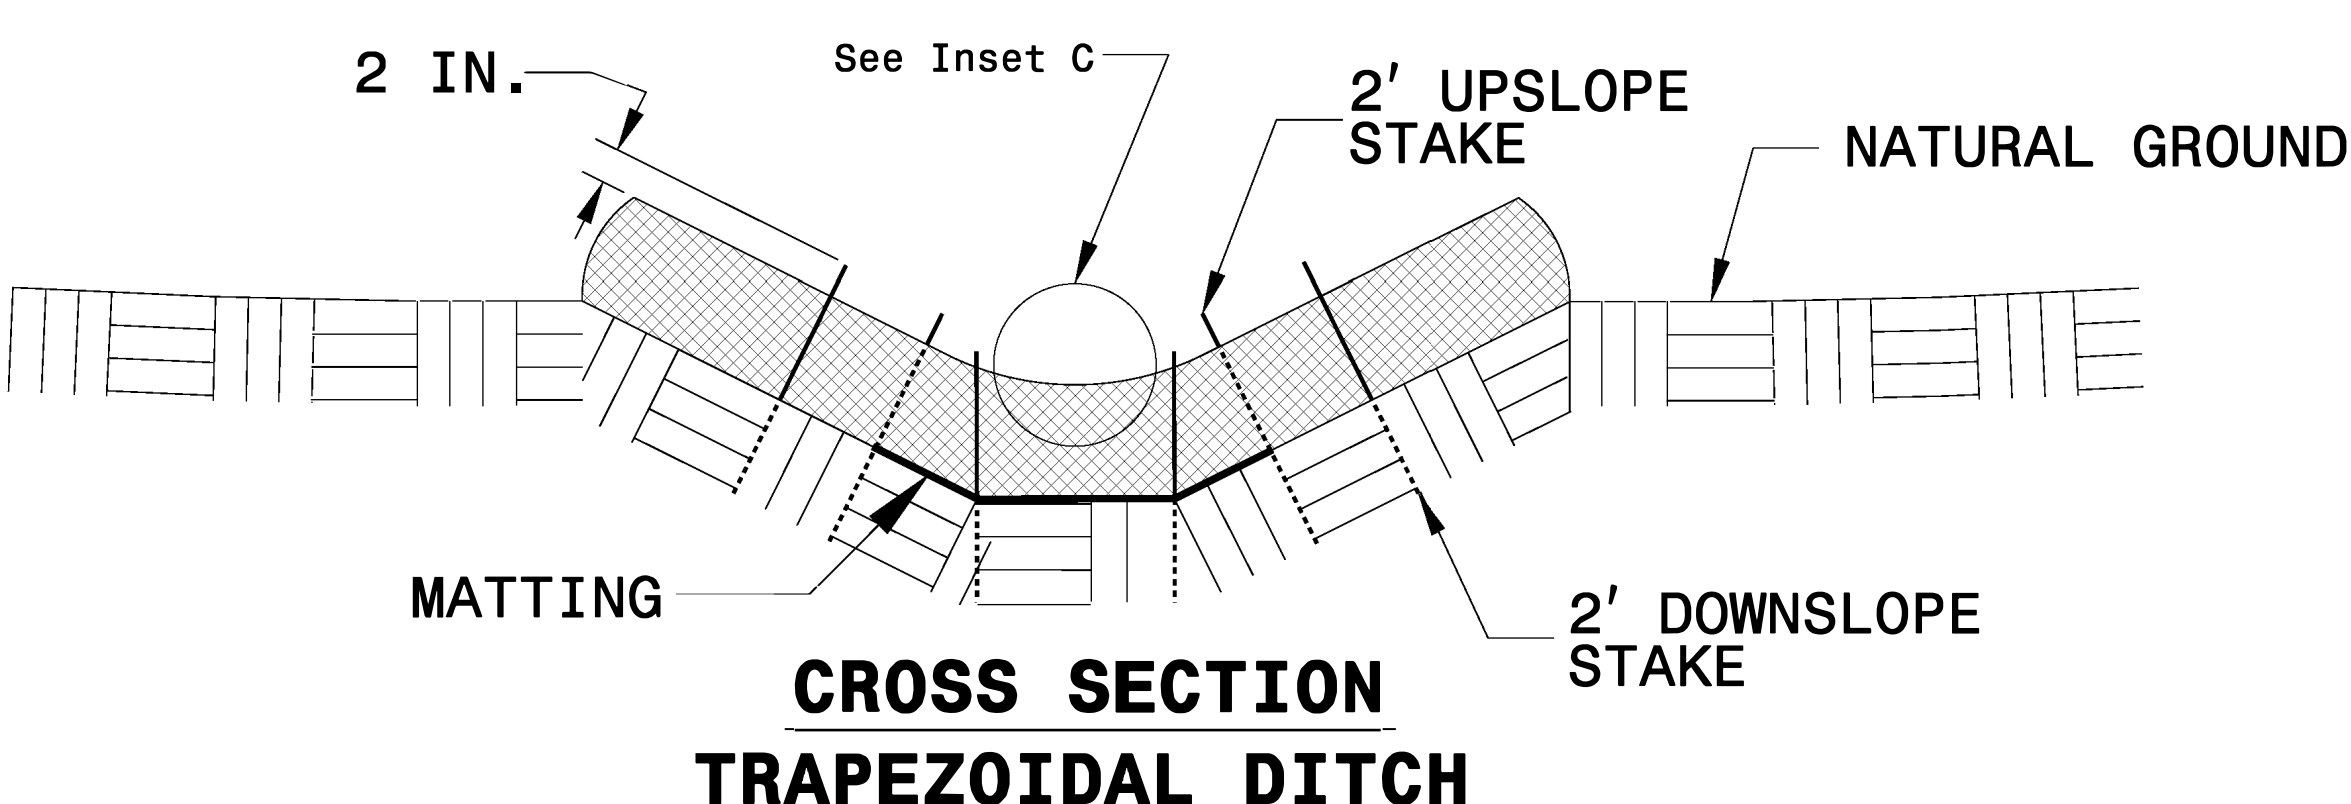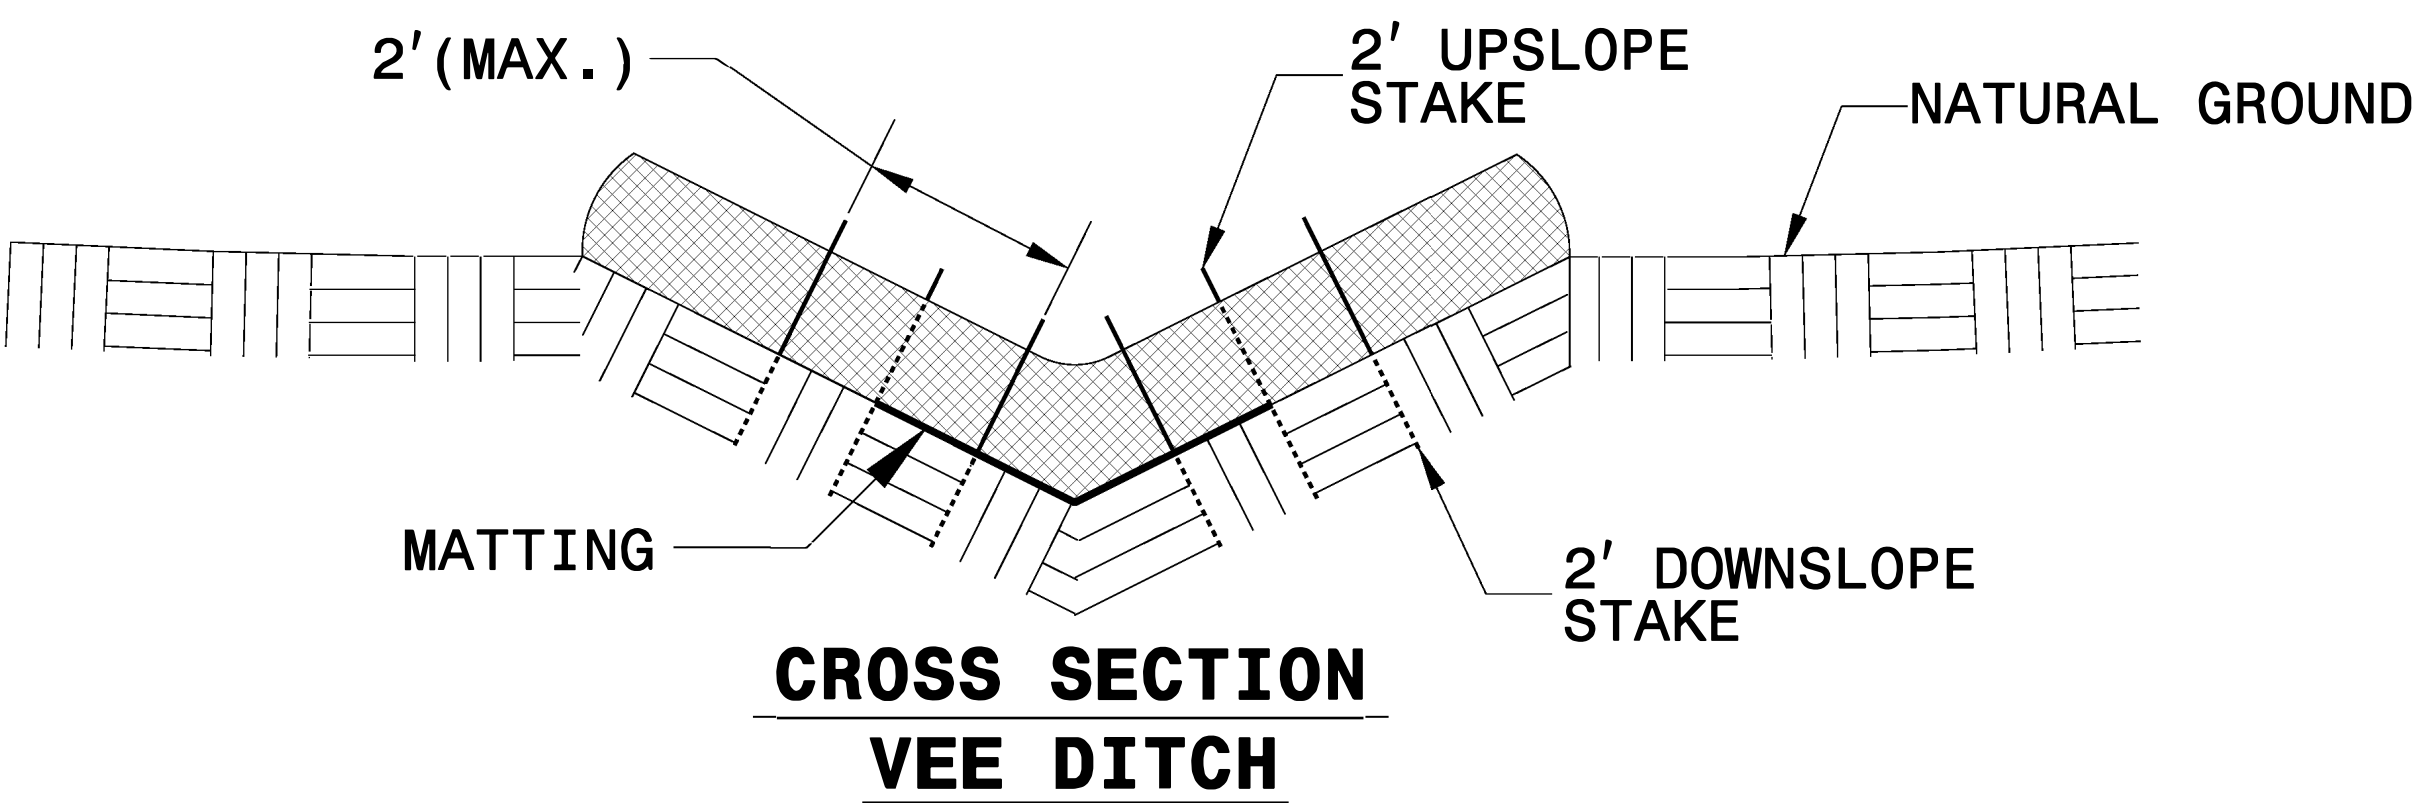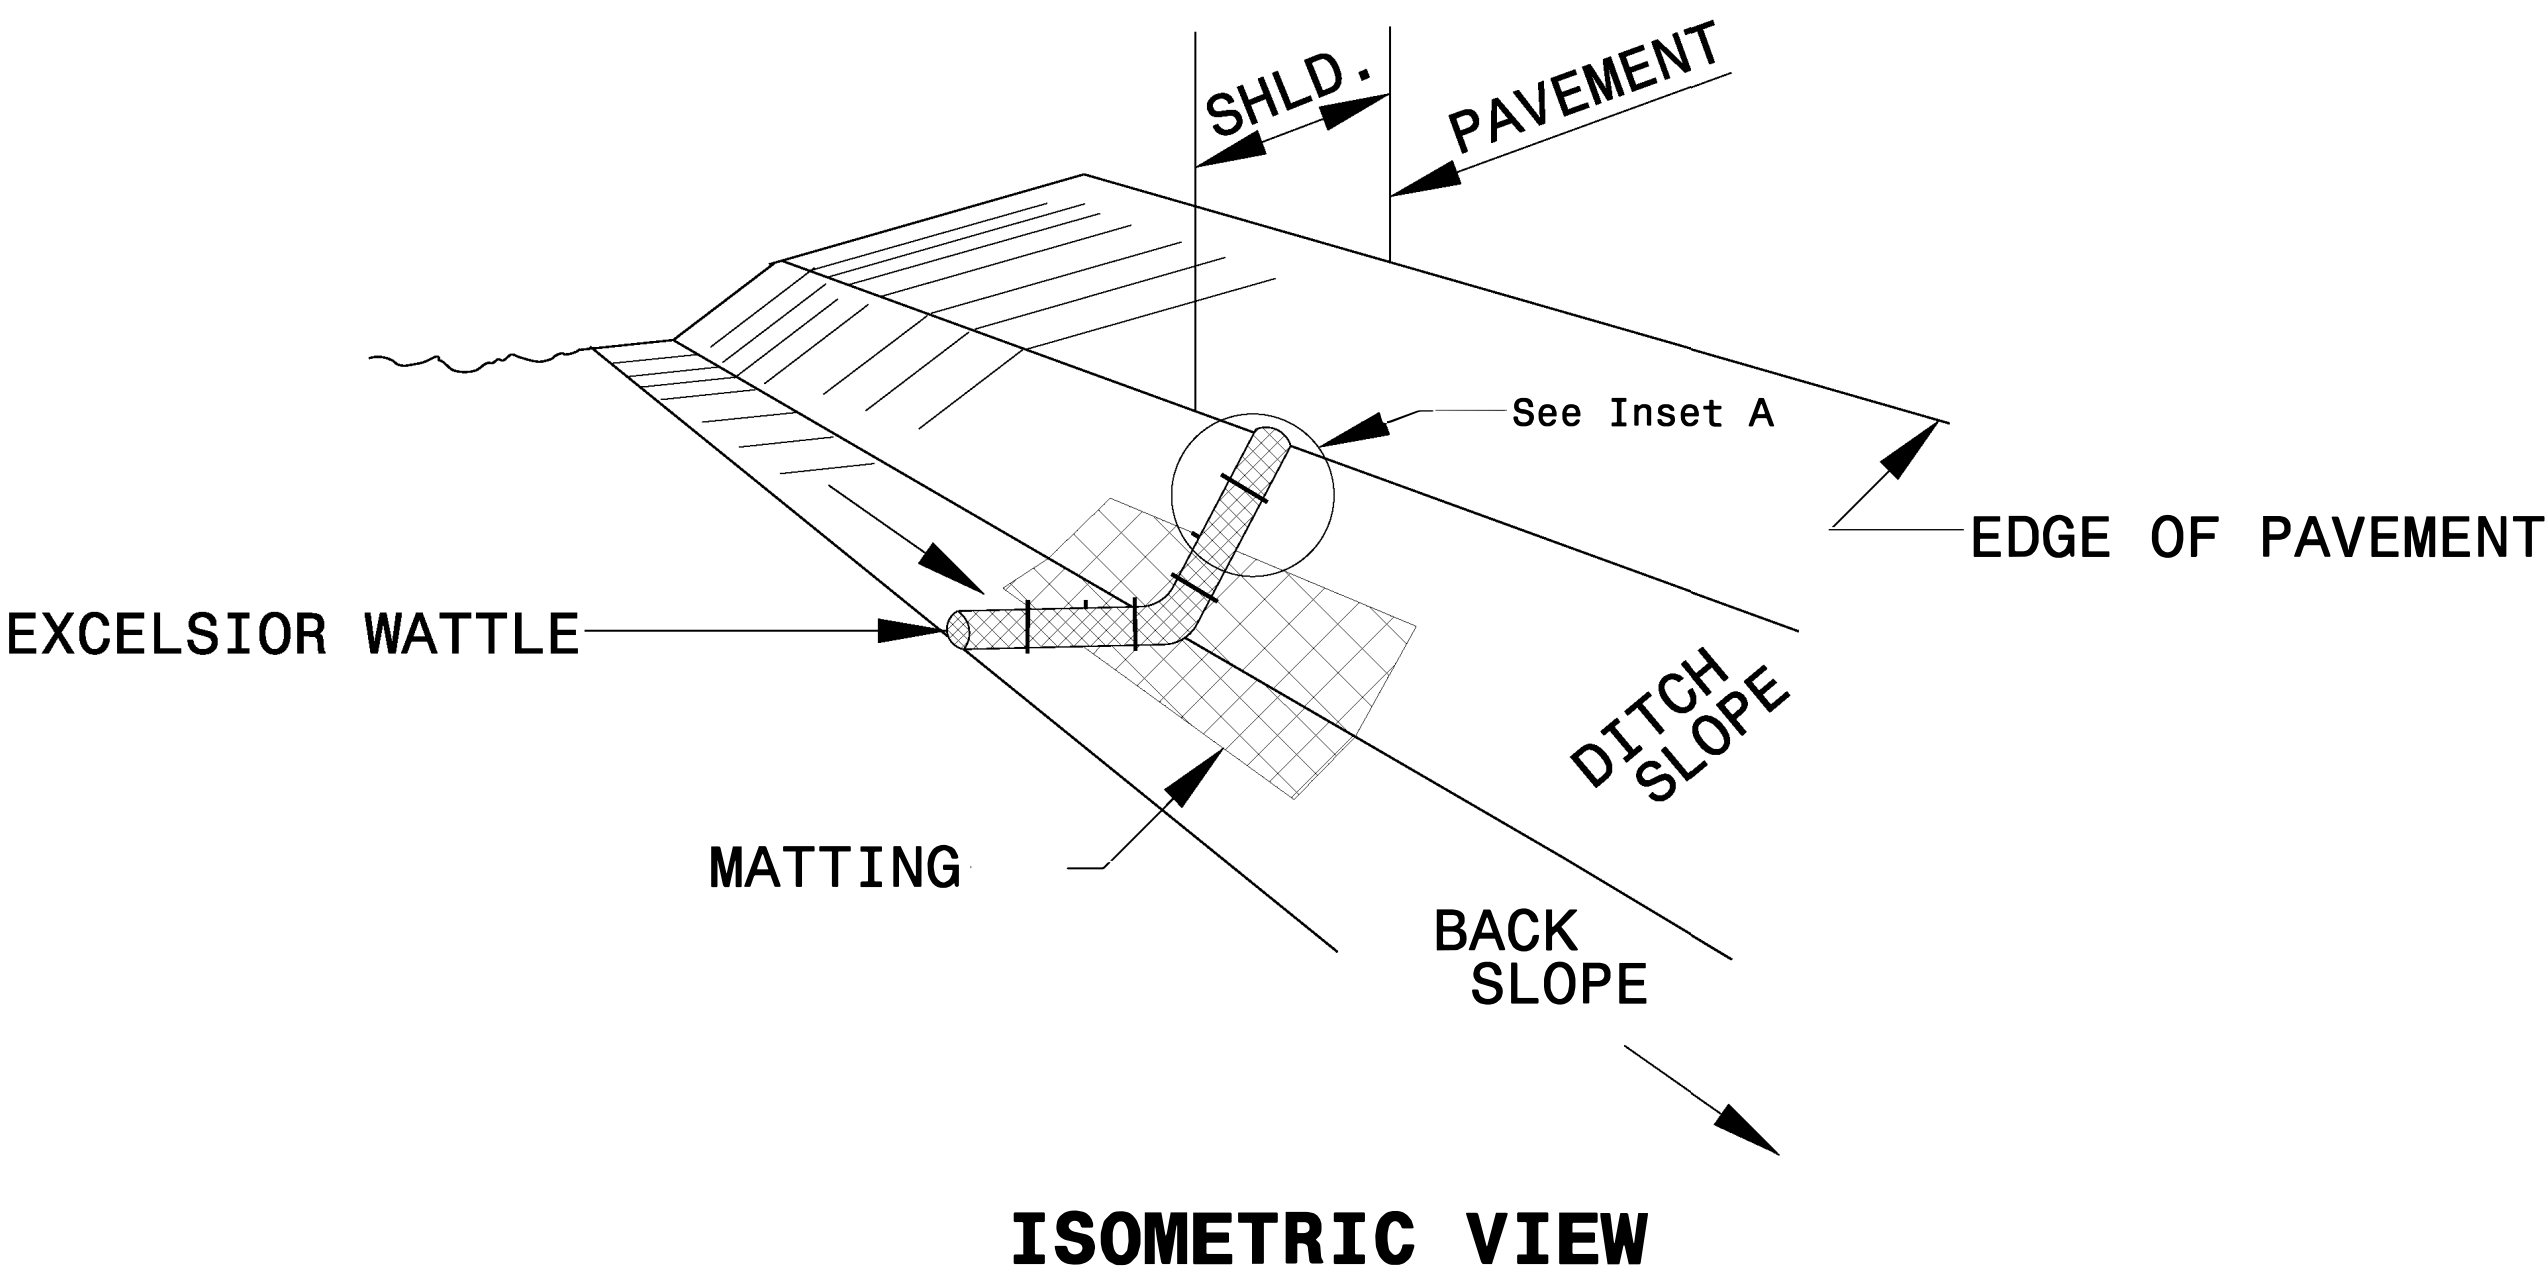

NOTES:

- USE MINIMUM 12 IN. DIAMETER EXCELSIOR WATTLE.
- USE 2 FT. WOODEN STAKES WITH A 2 IN. BY 2 IN. NOMINAL CROSS SECTION.
- ONLY INSTALL WATTLE(S) TO A HEIGHT IN DITCH SO FLOW WILL NOT WASH AROUND WATTLE AND SCOUR DITCH SLOPES AND AS DIRECTED.
- INSTALL A MINIMUM OF 2 UPSLOPE STAKES AND 4 DOWNSLOPE STAKES AT AN ANGLE TO WEDGE WATTLE TO BOTTOM OF DITCH.
- PROVIDE STAPLES MADE OF 0.125 IN. DIAMETER STEEL WIRE FORMED INTO A U SHAPE NOT LESS THAN 12" IN LENGTH.
- INSTALL STAPLES APPROXIMATELY EVERY 1 LINEAR FOOT ON BOTH SIDES OF WATTLE AND AT EACH END TO SECURE IT TO THE SOIL.
- INSTALL MATTING IN ACCORDANCE WITH SECTION 1631 OF THE STANDARD SPECIFICATIONS.
- PRIOR TO POLYACRYLAMIDE (PAM) APPLICATION, OBTAIN A SOIL SAMPLE FROM PROJECT LOCATION, AND FROM OFFSITE MATERIAL, AND ANALYZE FOR APPROPRIATE PAM FLOCCULANT TO BE APPLIED TO EACH WATTLE.
- INITIALLY APPLY 2 OUNCES OF ANIONIC OR NEUTRALLY CHARGED PAM OVER WATTLE WHERE WATER WILL FLOW AND 1 OUNCE OF PAM ON MATTING ON EACH SIDE OF WATTLE. REAPPLY PAM AFTER EVERY RAINFALL EVENT THAT IS EQUAL TO OR EXCEEDS 0.50 IN.

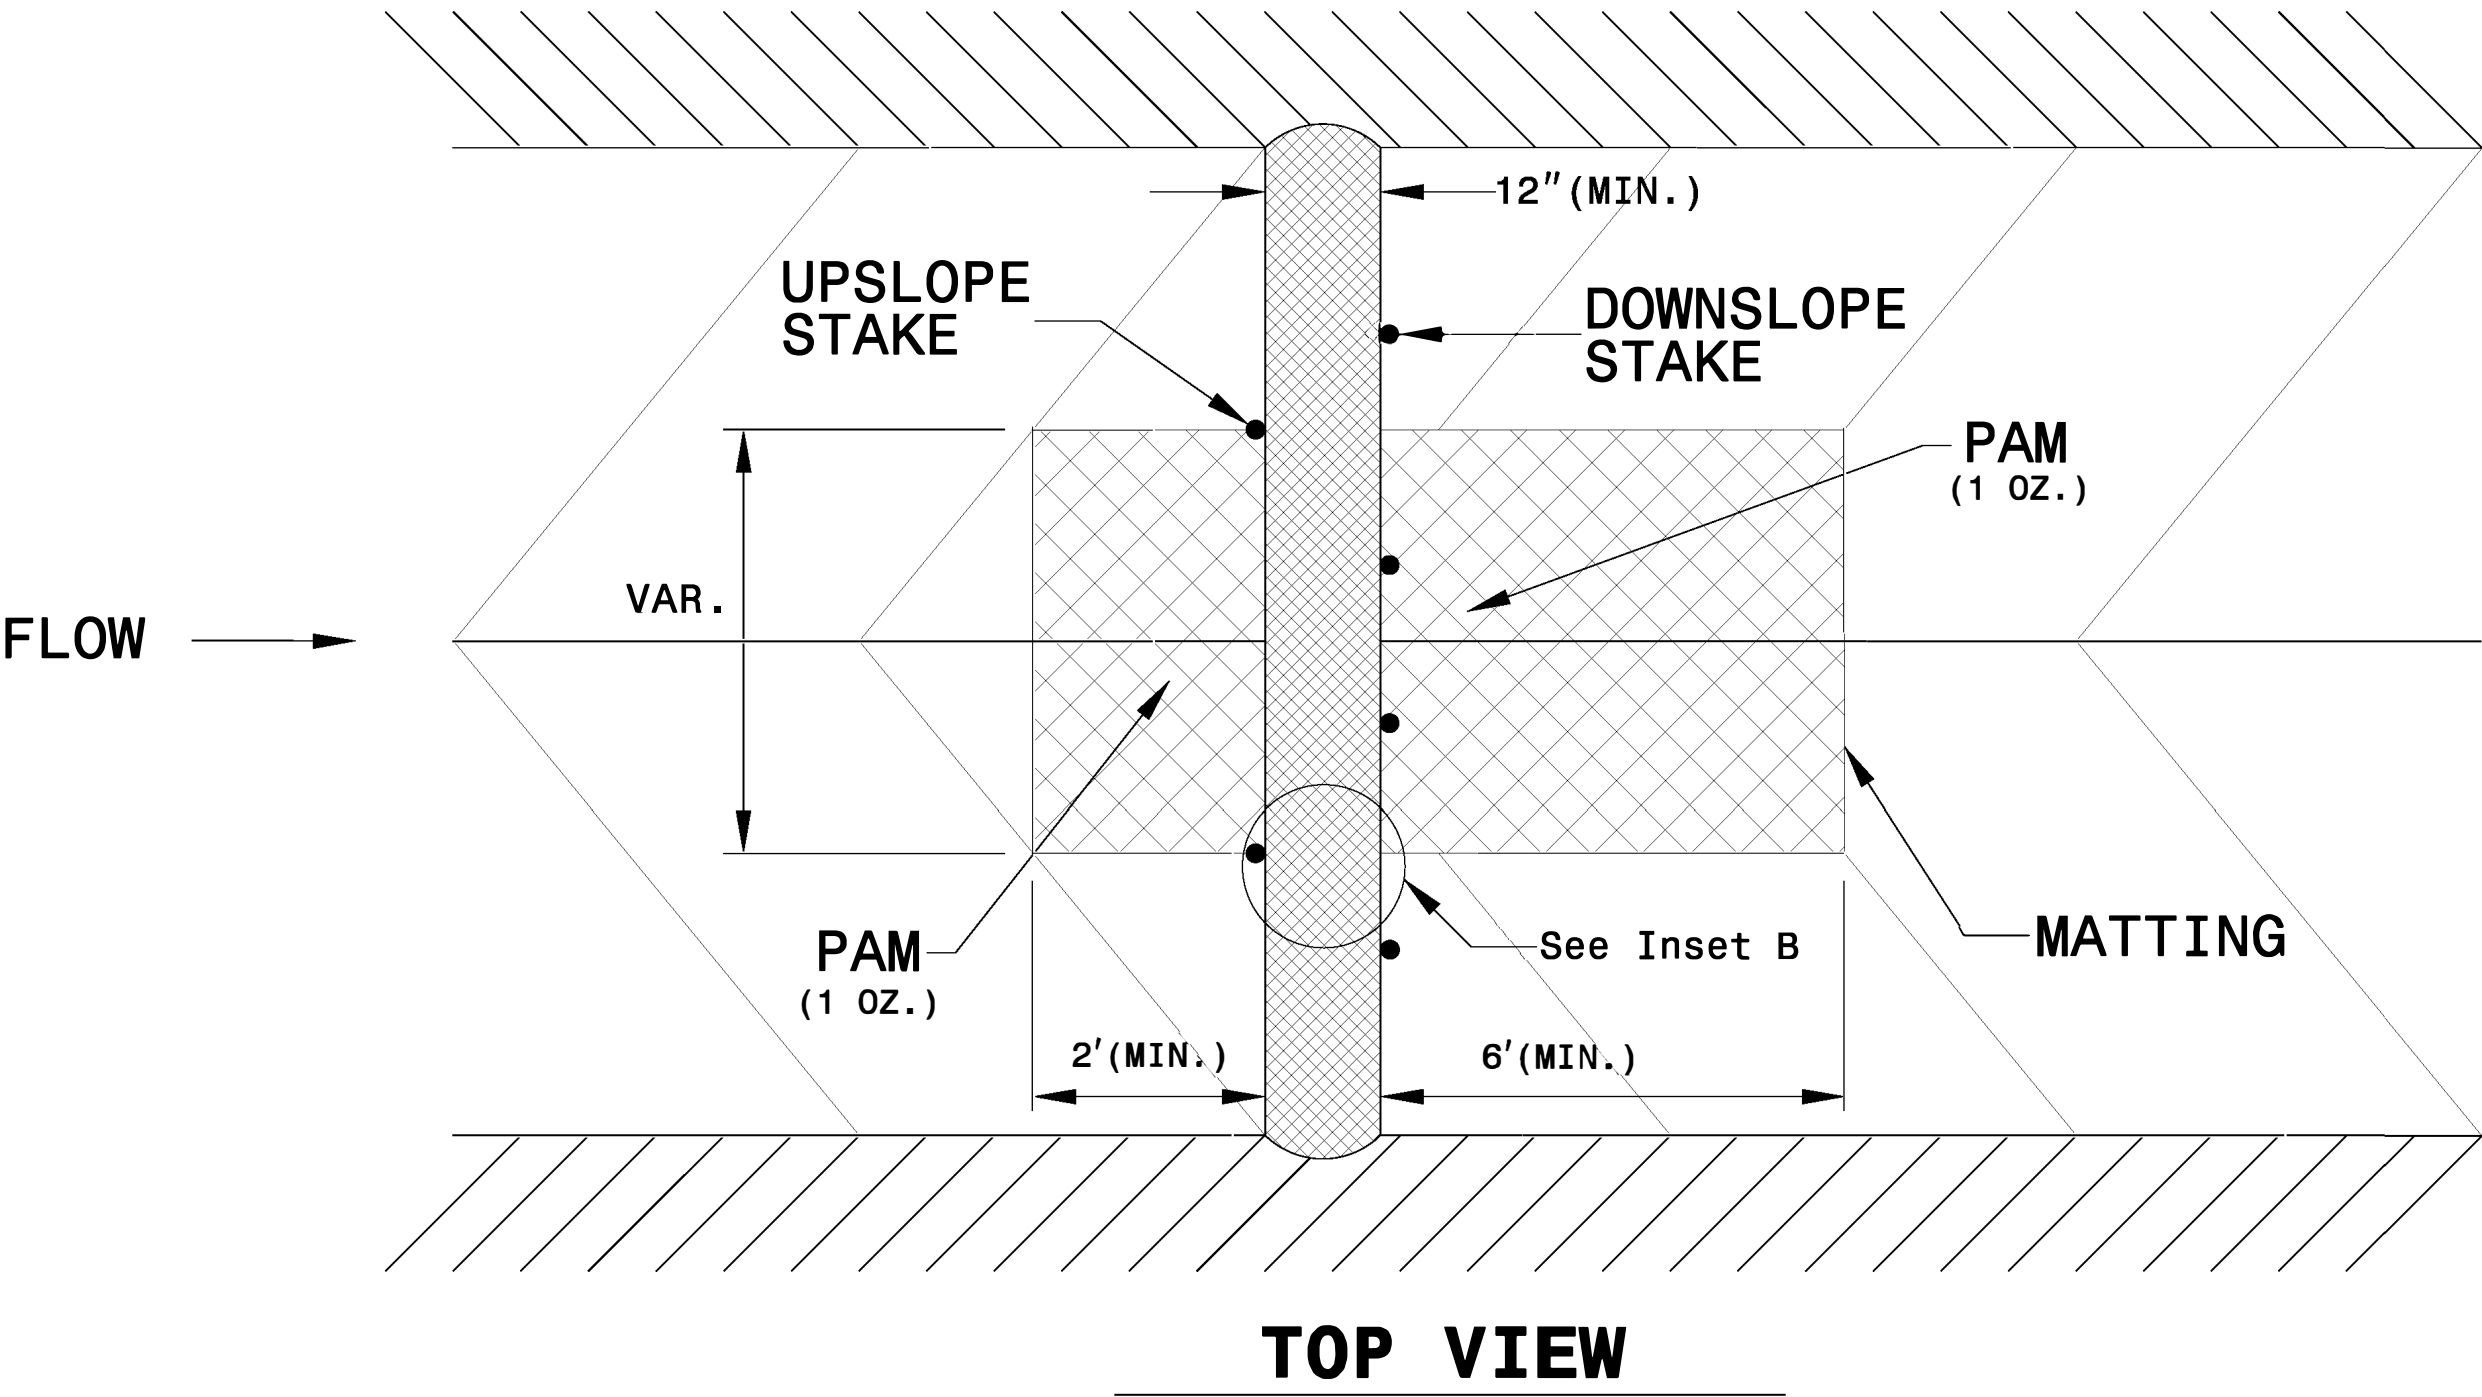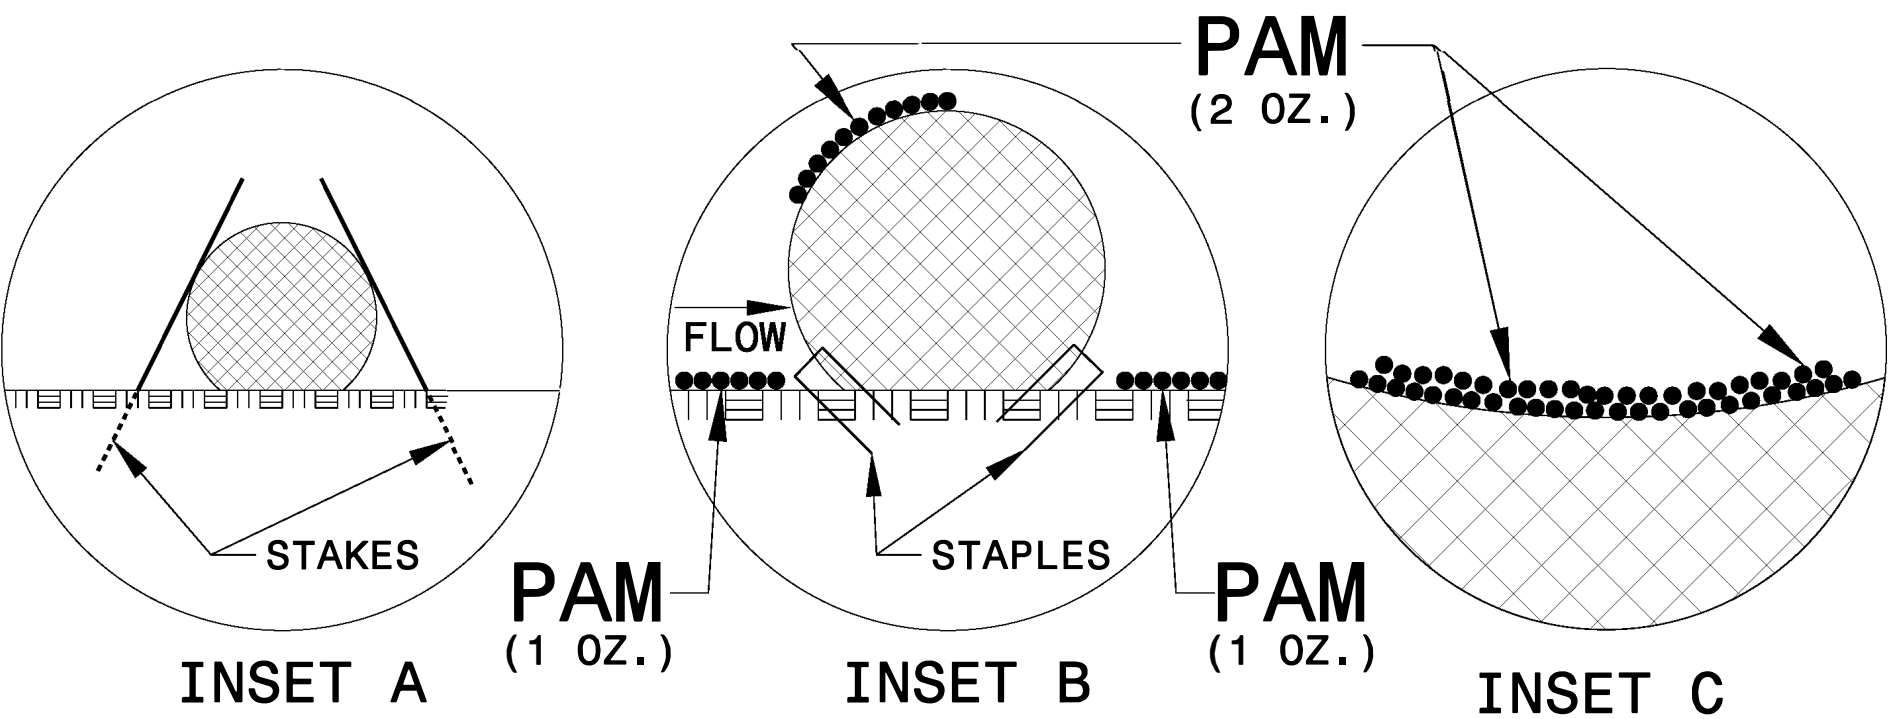

PROJECT REFERENCE NO.	SHEET NO.
W-5204C	EC-3
ROADWAY DESIGN ENGINEER	HYDRAULICS ENGINEER

SOIL STABILIZATION SUMMARY SHEET

MATTING FOR EROSION CONTROL

MATTING FOR EROSION CONTROL



[illegible][illegible]

PROJECT REFERENCE NO.	SHEET NO.
W-5204C	EC-3A
ROADWAY DESIGN ENGINEER	HYDRAULICS ENGINEER

SOIL STABILIZATION TIMEFRAMES

SITE DESCRIPTION	STABILIZATION TIME	TIMEFRAME EXCEPTIONS
PERIMETER DIKES, SWALES, DITCHES AND SLOPES	7 DAYS	NONE
HIGH QUALITY WATER (HQW) ZONES	7 DAYS	NONE
SLOPES STEEPER THAN 3:1	7 DAYS	IF SLOPES ARE 10' OR LESS IN LENGTH AND ARE NOT STEEPER THAN 2:1, 14 DAYS ARE ALLOWED.
SLOPES 3:1 OR FLATTER	14 DAYS	7 DAYS FOR SLOPES GREATER THAN 50' IN LENGTH.
ALL OTHER AREAS WITH SLOPES FLATTER THAN 4:1	14 DAYS	NONE, EXCEPT FOR PERIMETERS AND HQW ZONES.

PROJECT REFERENCE NO.	SHEET NO.
W-5204C	EC-7/CONST.5
R/W SHEET NO. 05	
ROADWAY DESIGN ENGINEER	HYDRAULICS ENGINEER

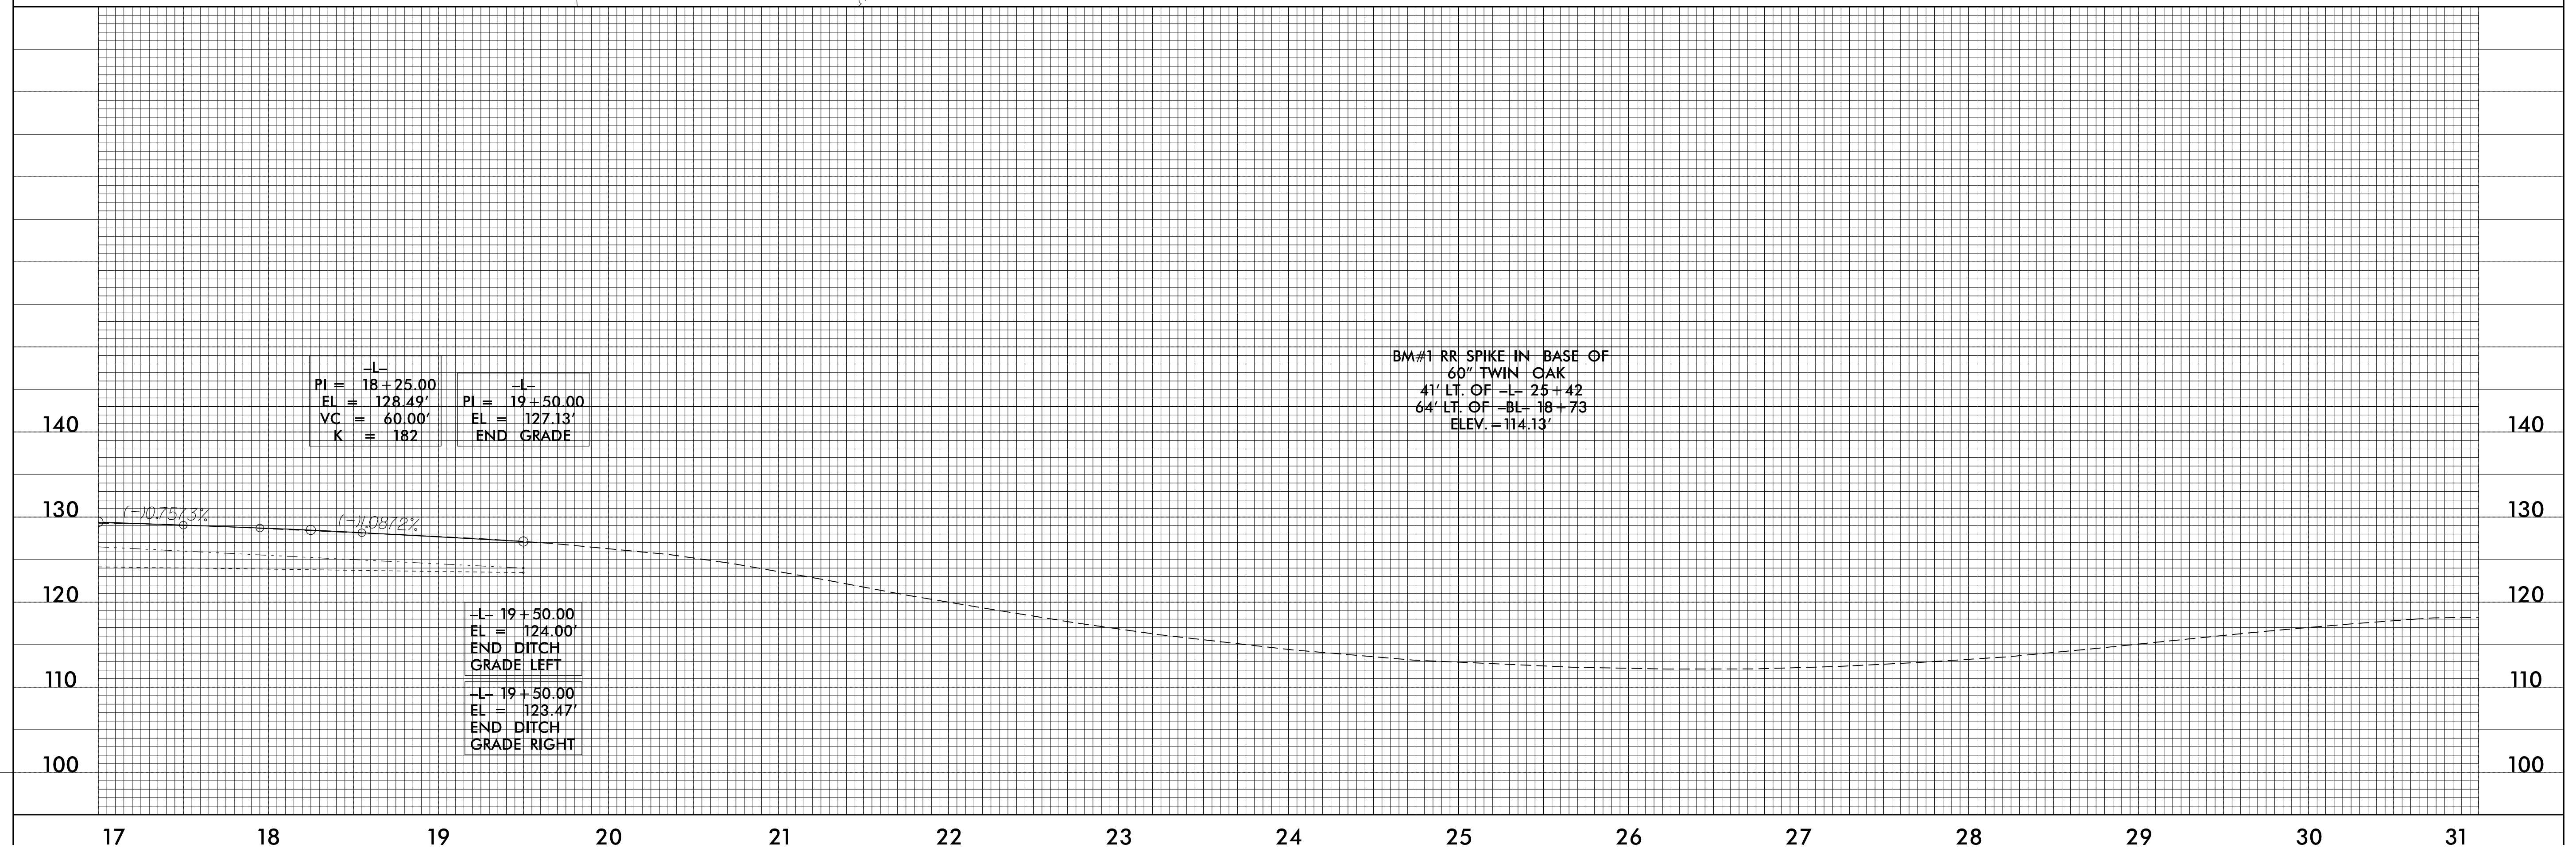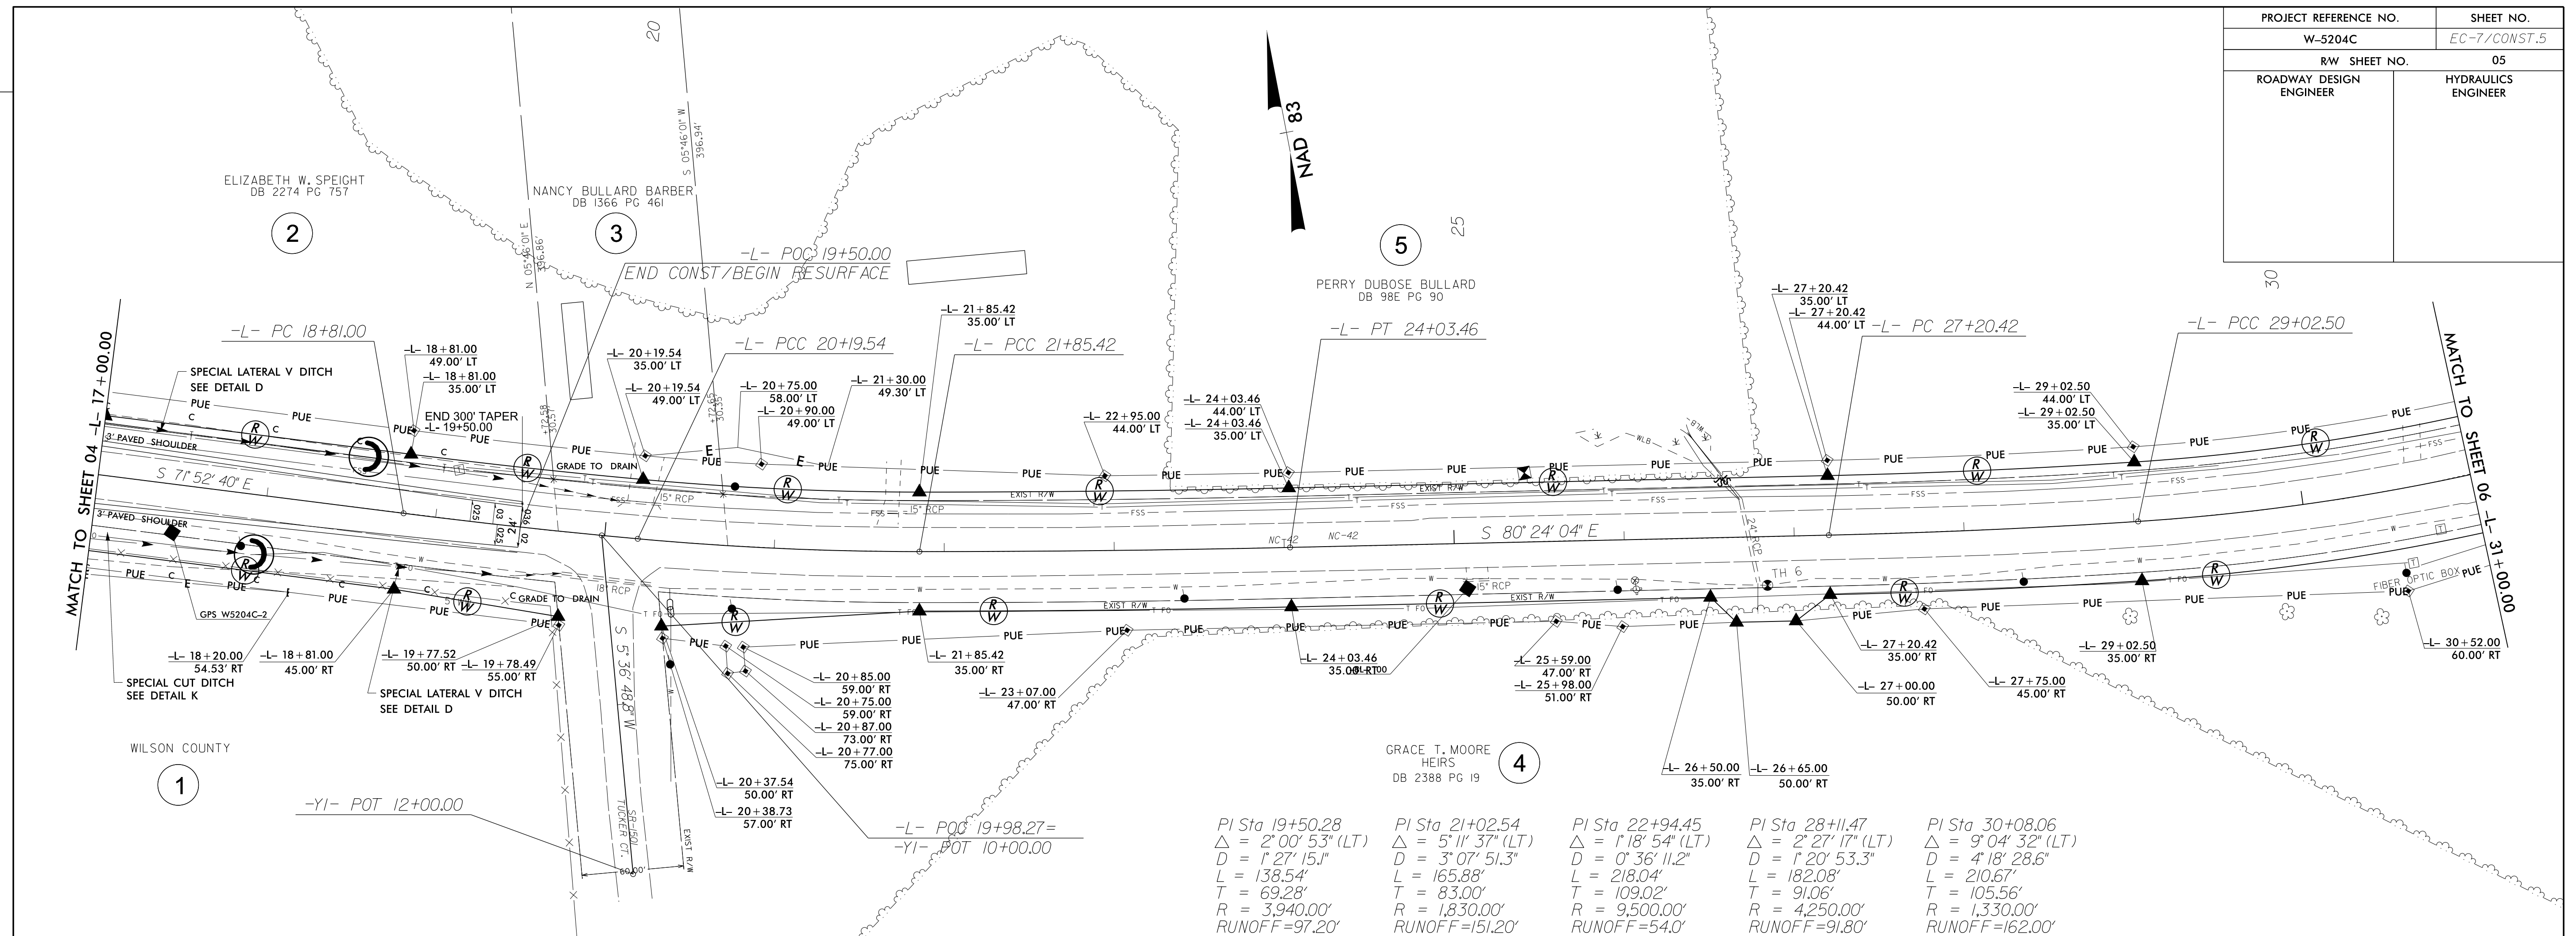

REVISIONS

```

$$$$SYTIME$$$$
$$$$$$$$$DGN$$$$$$$$$
$$$$$USERNAME$$$$

```


STATE OF NORTH CAROLINA
DIVISION OF HIGHWAYS




UTILITY CONSTRUCTION PLANS
WILSON COUNTY

LOCATION: NC-42 FROM SR-1500 (BULLARD CT.)
TO SR-1501 (TUCKER CT.)

TYPE OF WORK: UTILITY CONSTRUCTION




UTILITY OWNER:
CITY OF WILSON
1800 HERRING AVENUE
WILSON, NORTH CAROLINA 27893

PREPARED BY:
BARTLETT ENGINEERING & SURVEYING, PC
1906 NASH STREET NORTH
WILSON, NORTH CAROLINA 27893-1726

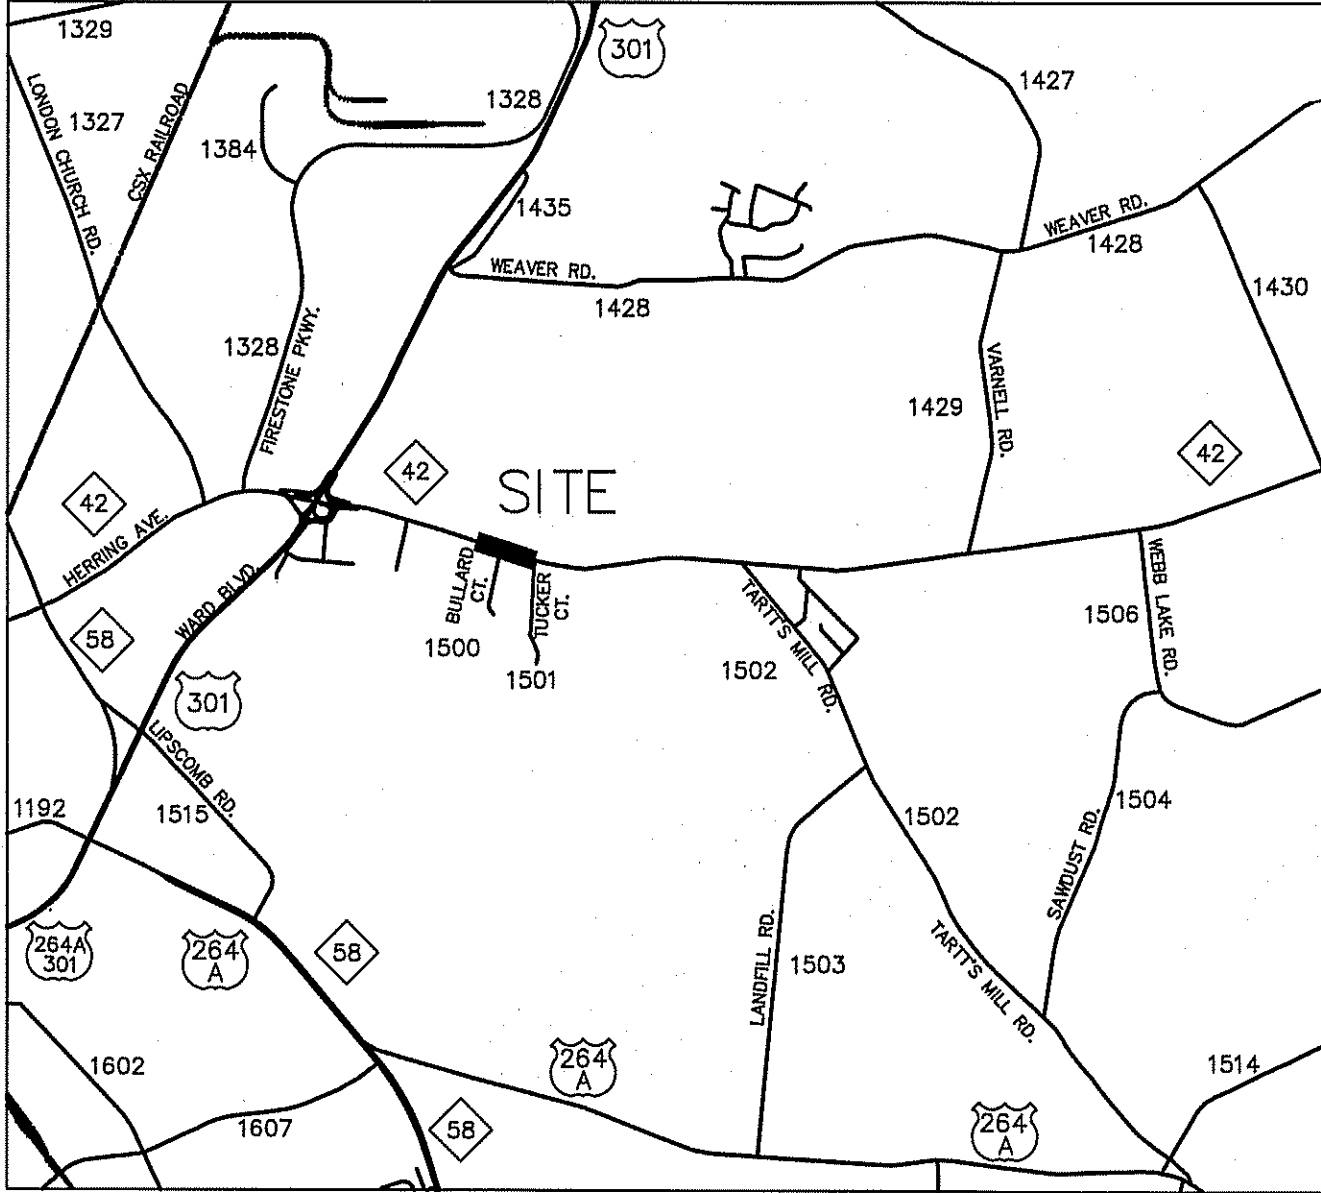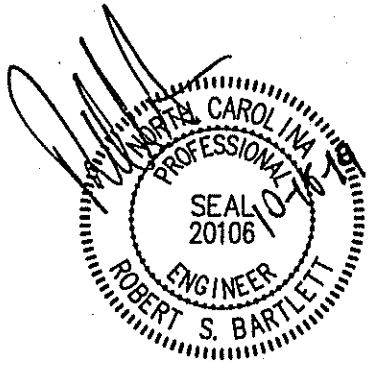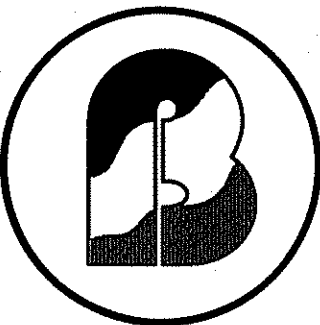

LOCATION MAP
NO SCALE

- INDEX OF SHEETS
- UC-1 COVER SHEET
 - UC-2 NOTES
 - UC-3 PLAN & PROFILE (STA. 10+00 - STA. 19+50)
 - UC-4 DETAILS

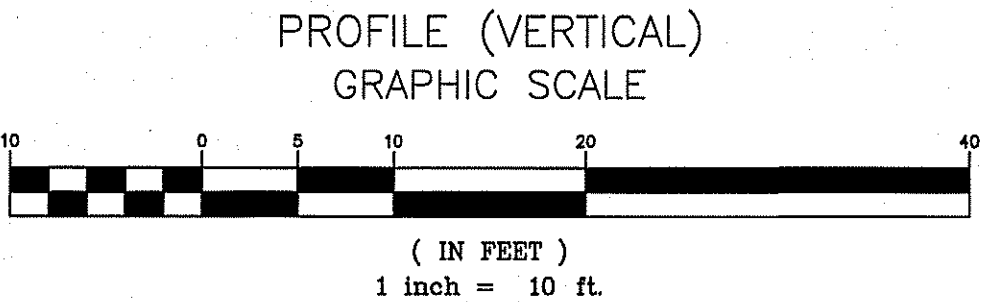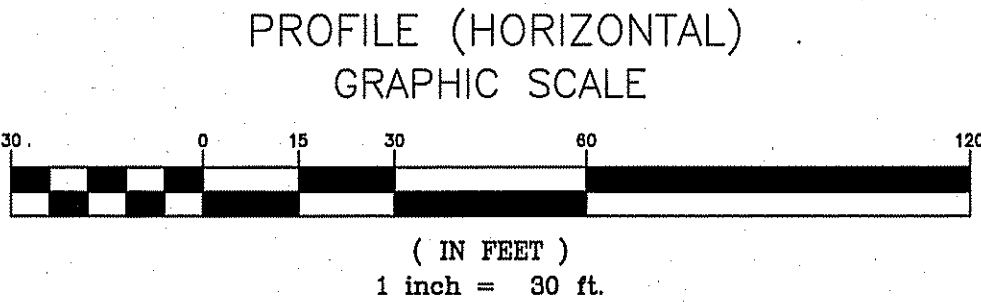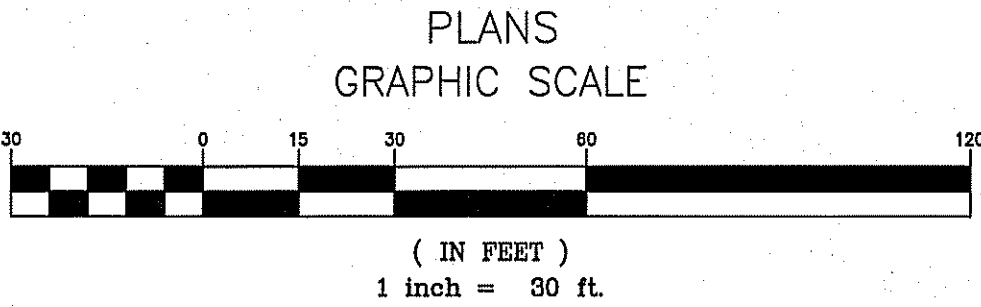

BARTLETT
ENGINEERING & SURVEYING, PC
1906 NASH STREET NORTH
WILSON, N.C. 27893-1726
TELE: (252) 399-0704
FAX: (252) 399-0804
www.bartlettus.com
LICENSE # C-1551

COVER SHEET

TIP NO. W-5204C
UTILITY CONSTRUCTION PLANS
NC 42 FROM BULLARD CT. TO TARTT'S MILL RD.
WILSON, NORTH CAROLINA

DATE: MARCH 2017
SURVEY BY: RF
DRAWN BY: RF
CLIENT CODE: WC
PROJECT: 16-241
CADFILE: 16241CP2
SCALE: NTS

REVISIONS
MARCH 9, 2018
JANUARY 10, 2019

SHEET
UC-1

UTILITY CONSTRUCTION

GENERAL NOTES:

1.

THE PROPOSED UTILITY CONSTRUCTION SHALL MEET THE APPLICABLE REQUIREMENTS OF THE NC DEPARTMENT OF TRANSPORTATION'S "STANDARD SPECIFICATIONS FOR ROADS AND STRUCTURES" DATED JANUARY 2018.
2.

THE EXISTING WATER AND SEWER UTILITIES BELONG TO THE CITY OF WILSON.
3.

ALL WATER LINES TO BE INSTALLED WITHIN COMPLIANCE OF THE RULES AND REGULATIONS OF THE NORTH CAROLINA DEPARTMENT OF ENVIRONMENTAL QUALITY, DIVISION OF WATER RESOURCES, PUBLIC WATER SUPPLY SECTION. ALL SEWER LINES TO BE INSTALLED WITHIN COMPLIANCE OF THE RULES AND REGULATIONS OF THE NORTH CAROLINA DEPARTMENT OF ENVIRONMENT QUALITY, DIVISION OF WATER RESOURCES, WATER QUALITY SECTIONS. PERFORM ALL WORK IN ACCORDANCE WITH THE APPLICABLE PLUMBING CODES.
4.

THE UTILITY OWNER OWNS THE EXISTING UTILITY FACILITIES AND WILL OWN THE NEW UTILITY FACILITIES AFTER ACCEPTANCE BY THE DEPARTMENT. THE DEPARTMENT OWNS THE CONSTRUCTION CONTRACT AND HAS ADMINISTRATIVE AUTHORITY. COMMUNICATIONS AND DECISIONS BETWEEN THE CONTRACTOR AND UTILITY OWNER ARE NOT BINDING UPON THE DEPARTMENT OR THIS CONTRACT UNLESS AUTHORIZED BY THE ENGINEER. AGREEMENTS BETWEEN THE UTILITY OWNER AND CONTRACTOR FOR THE WORK THAT IS NOT PART OF THIS CONTRACT OR IS SECONDARY TO THIS CONTRACT ARE ALLOWED, BUT ARE NOT BINDING UPON THE DEPARTMENT.
5.

PROVIDE ACCESS FOR THE DEPARTMENT PERSONNEL AND THE OWNER'S REPRESENTATIVES TO ALL PHASES OF CONSTRUCTION. NOTIFY DEPARTMENT PERSONNEL AND THE UTILITY OWNER TWO WEEKS PRIOR TO COMMENCEMENT OF ANY WORK AND ONE WEEK PRIOR TO SERVICE INTERRUPTION. KEEP UTILITY OWNERS' REPRESENTATIVES INFORMED OF WORK PROGRESS AND PROVIDE OPPORTUNITY FOR INSPECTION OF CONSTRUCTION AND TESTING.
6.

THE PLANS DEPICT THE BEST AVAILABLE INFORMATION FOR THE LOCATION, SIZE, AND TYPE OF MATERIAL FOR ALL EXISTING UTILITIES. MAKE INVESTIGATIONS FOR DETERMINING THE EXACT LOCATION, SIZE, AND TYPE MATERIAL OF THE EXISTING FACILITIES AS NECESSARY FOR THE CONSTRUCTION OF THE PROPOSED UTILITIES AND FOR AVOIDING DAMAGE TO EXISTING FACILITIES. REPAIR ANY DAMAGE INCURRED TO EXISTING FACILITIES TO THE ORIGINAL OR BETTER CONDITION AT NO ADDITIONAL COST TO THE DEPARTMENT.
7.

MAKE FINAL CONNECTIONS OF THE NEW WORK TO THE EXISTING SYSTEM WHERE INDICATED ON THE PLANS, AS REQUIRED TO FIT THE ACTUAL CONDITIONS, OR AS DIRECTED.
8.

MAKE CONNECTIONS BETWEEN EXISTING AND PROPOSED UTILITIES AT TIMES MOST CONVENIENT TO THE PUBLIC, WITHOUT ENDANGERING THE UTILITY SERVICE, AND IN ACCORDANCE WITH THE UTILITY OWNER'S REQUIREMENTS. MAKE CONNECTIONS ON WEEKENDS, AT NIGHT, AND ON HOLIDAYS IF NECESSARY.
9.

ALL UTILITY MATERIALS SHALL BE APPROVED PRIOR TO DELIVERY TO THE PROJECT. SEE 1500-7, "SUBMITTALS AND RECORDS" IN SECTION 1500 OF THE STANDARD SPECIFICATIONS.

GENERAL NOTES:

ALL TRAFFIC CONTROL DEVICES, PAVEMENT MARKINGS, SIGNS AND SIGNALS SHALL BE DESIGNED, INSTALLED AND MAINTAINED IN CONFORMANCE WITH THE STANDARDS SET FORTH IN THE MANUAL ON UNIFORM TRAFFIC CONTROL.

THE CONTRACTOR SHALL BE RESPONSIBLE FOR ALL WORK ZONE TRAFFIC CONTROL IN OR ADJACENT TO NCDOT OR CITY R/W. ALL METHODS SHALL CONFORM TO THE MANUAL ON UNIFORM TRAFFIC CONTROL DEVICES (MUTCD) AND NCDOT STANDARDS.

THE UTILITY LOCATIONS SHOWN ON THIS MAP ARE APPROXIMATE ONLY, AND ARE NOT RELIABLE FOR CONSTRUCTION PURPOSES FOR ACTUAL FIELD LOCATIONS. CALL 1-800-632-4549 OR 811 THREE WORKING DAYS MINIMUM PRIOR TO EXCAVATION.

CONTRACTOR IS RESPONSIBLE FOR COORDINATING REQUIRED INSPECTIONS BY CITY OF WILSON.


UTILITIES SHOWN ON PLANS ARE LOCATED APPROXIMATELY. CONTRACTOR SHALL BE RESPONSIBLE FOR VERIFYING THE LOCATION OF ALL EXISTING UTILITIES AND SERVICES WHETHER SHOWN ON PLANS OR NOT.

CONTRACTOR TO BE RESPONSIBLE FOR REMOVAL AND REPLACEMENT OF THESE FACILITIES IF DAMAGED.

WATER, SEWER, AND STORM DRAINAGE LINES SHOULD BE CONSTRUCTED TO THE FOLLOWING SPECIFICATIONS:

- MIN. 10' LATERAL SEPARATION BETWEEN WATER/SEWER LINES.
- MIN. 24" VERT. SEPARATION BETWEEN WATER/SEWER, IF WATER MUST BE PLACED BELOW SEWER, DUCTILE IRON IS REQUIRED ON BOTH LINES. DUCTILE IRON SHOULD EXTEND 10' PAST INTERSECTION ON WATER LINE AND TO THE NEXT MANHOLE ON SEWER LINE PER CITY OF WILSON SPECIFICATIONS.
- WATER/SEWER CROSSINGS SHALL BE ARRANGED SO THAT SEWER JOINTS ARE EQUIDISTANT AND AS FAR AS POSSIBLE FROM THE WATER MAIN JOINTS.
- MIN. 24" VERT. SEPARATION BETWEEN STORM DRAIN AND SAN. SEWER OR DUCTILE IRON IS REQUIRED.

ALL WORK SHALL CONFORM TO LATEST EDITION OF THE CITY OF WILSON STANDARDS AND SPECIFICATIONS, SPECIFICALLY SECTIONS 02510 AND 02530, WHICH CAN BE FOUND AT WWW.WILSONNC.APPIANENGRS.COM.

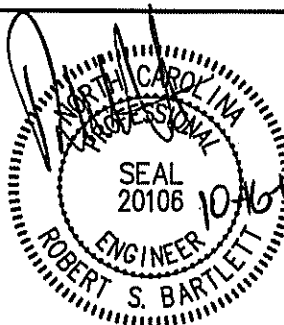

BARTLETT
ENGINEERING & SURVEYING, PC
1906 NASH STREET NORTH
WILSON, N.C. 27893-1726
TELE: (252) 399-0704
FAX: (252) 399-0804
www.bartlettus.com
LICENSE# C-1551

NOTES

TIP NO. W-5204C
UTILITY CONSTRUCTION PLANS
NC 42 FROM BULLARD CT. TO TARTT'S MILL RD.
WILSON, NORTH CAROLINA





DATE: MARCH 2017
SURVEY BY:
DRAWN BY: RF
CLIENT CODE: WC
PROJECT: 16-241
CADFILE: 16241CP2
SCALE: NTS

REVISIONS
MARCH 9, 2018
JANUARY 10, 2019
OCTOBER 11, 2019

SHEET

UC-2

- LEGEND:
- EXISTING FIRE HYDRANT
 - EXISTING WATER METER
 - EXISTING TELEPHONE FDESTAL
 - EXISTING POWER POLE
 - EXISTING TEST HOLES (SUE)
 - EXISTING SS FORCE MAIN LINE
 - EXISTING WATER LINE
 - EXISTING GAS LINE
 - EXISTING U/G TELEPHONE LINE
 - EXISTING U/G FIBER OPTIC CABLE
 - EXISTING ROW LINE
 - EXISTING EDGE OF PAVEMENT
 - EXISTING FENCE LINE
 - PROPOSED SS FORCE MAIN LINE
 - PROPOSED WATER LINE
 - PROPOSED ROW LINE
 - PROPOSED CONSTRUCTION EASEMENT
 - PROPOSED DRAINAGE DITCH

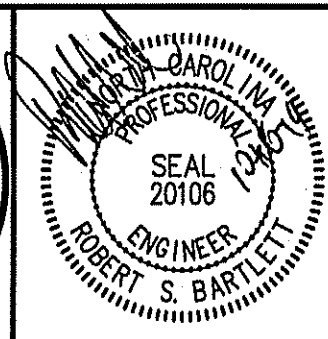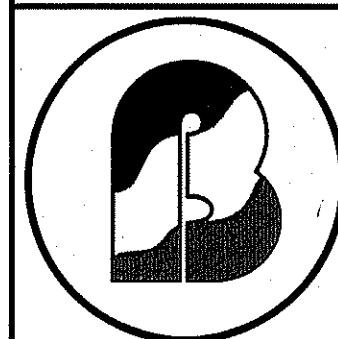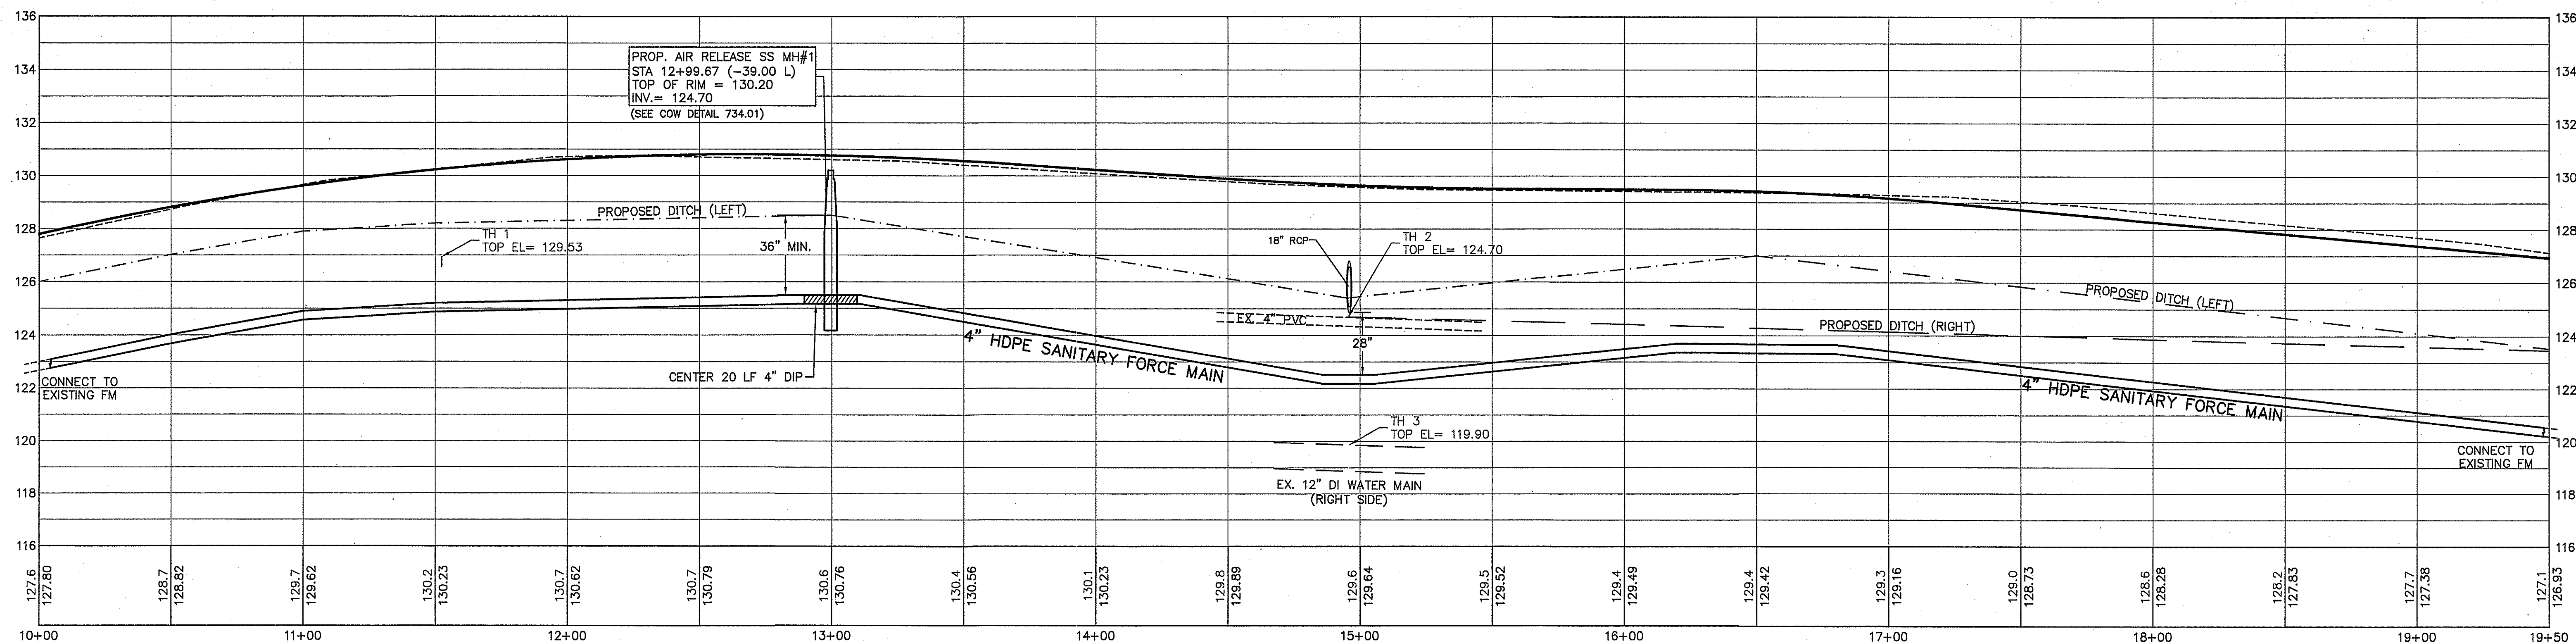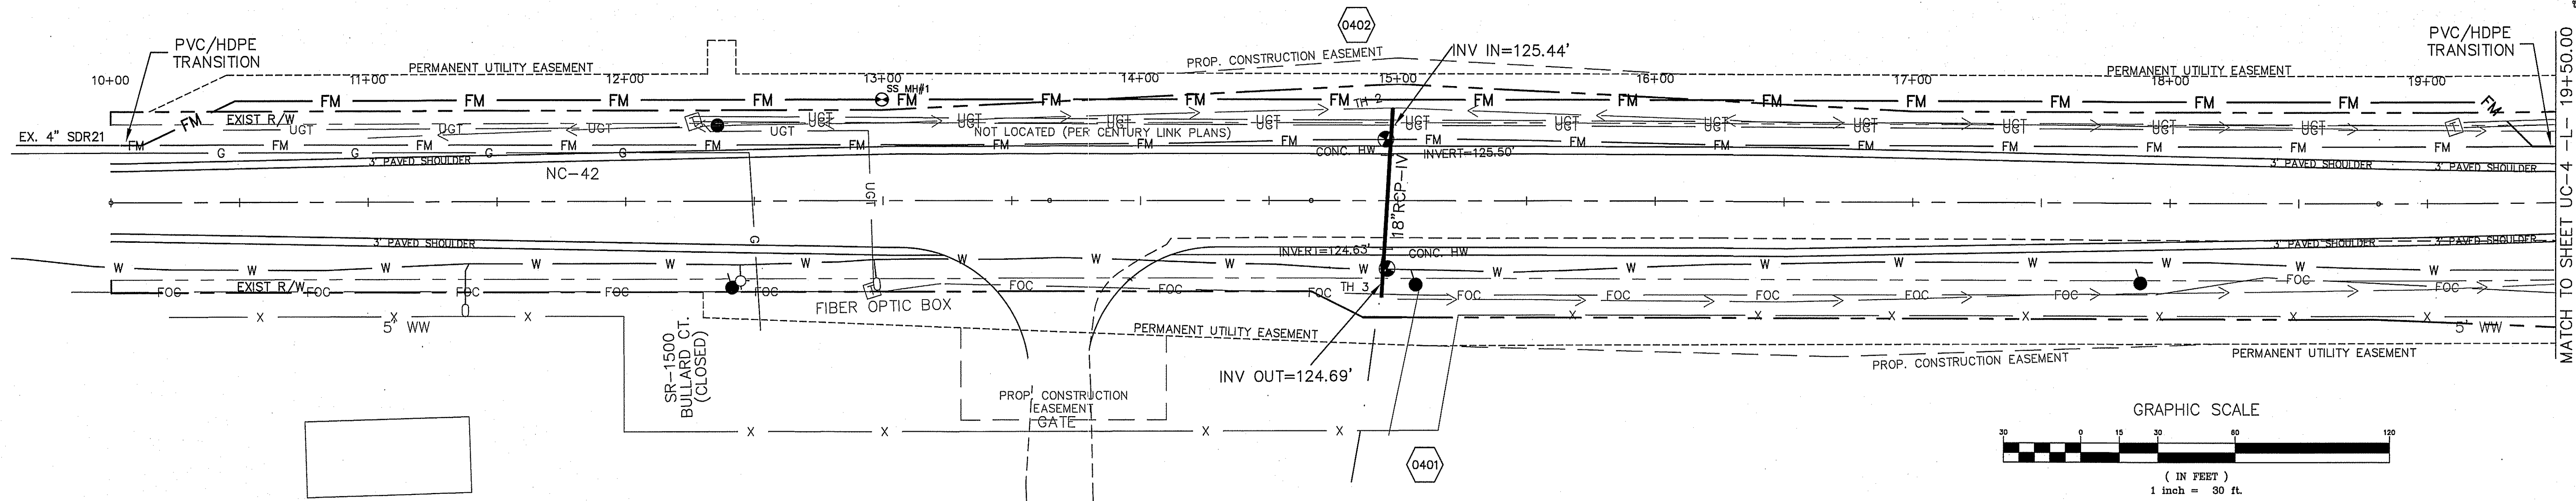

BARTLETT
ENGINEERING & SURVEYING, PC

1906 NASH STREET NORTH
WILSON, N.C. 27893-1726
License No. C-1551

TELE: (252) 399-0704
FAX: (252) 399-0804
www.bartlett.us.com

PLAN & PROFILE
(STA. 10+00 - STA. 19+50)

TIP NO. W-5204C

UTILITY CONSTRUCTION PLANS

WILSON, NC

NC 42

DATE: MARCH 2017

SCALE(HORZ):

1 : 30

SCALE(VERT):

1 : 10

REVISIONS:

PROJECT: 16-241
CLIENT CODE: WC
CADFILE: 16241CP2A-2
FIELD BOOK:
DRAWN BY: RF
SURVEY BY: KP, JB

MARCH 9, 2018
JANUARY 10, 2019
OCTOBER 11, 2019

CITY OF WILSON






WILSON COUNTY

NORTH CAROLINA

ZONE:

PIN #

SHEET UC-3

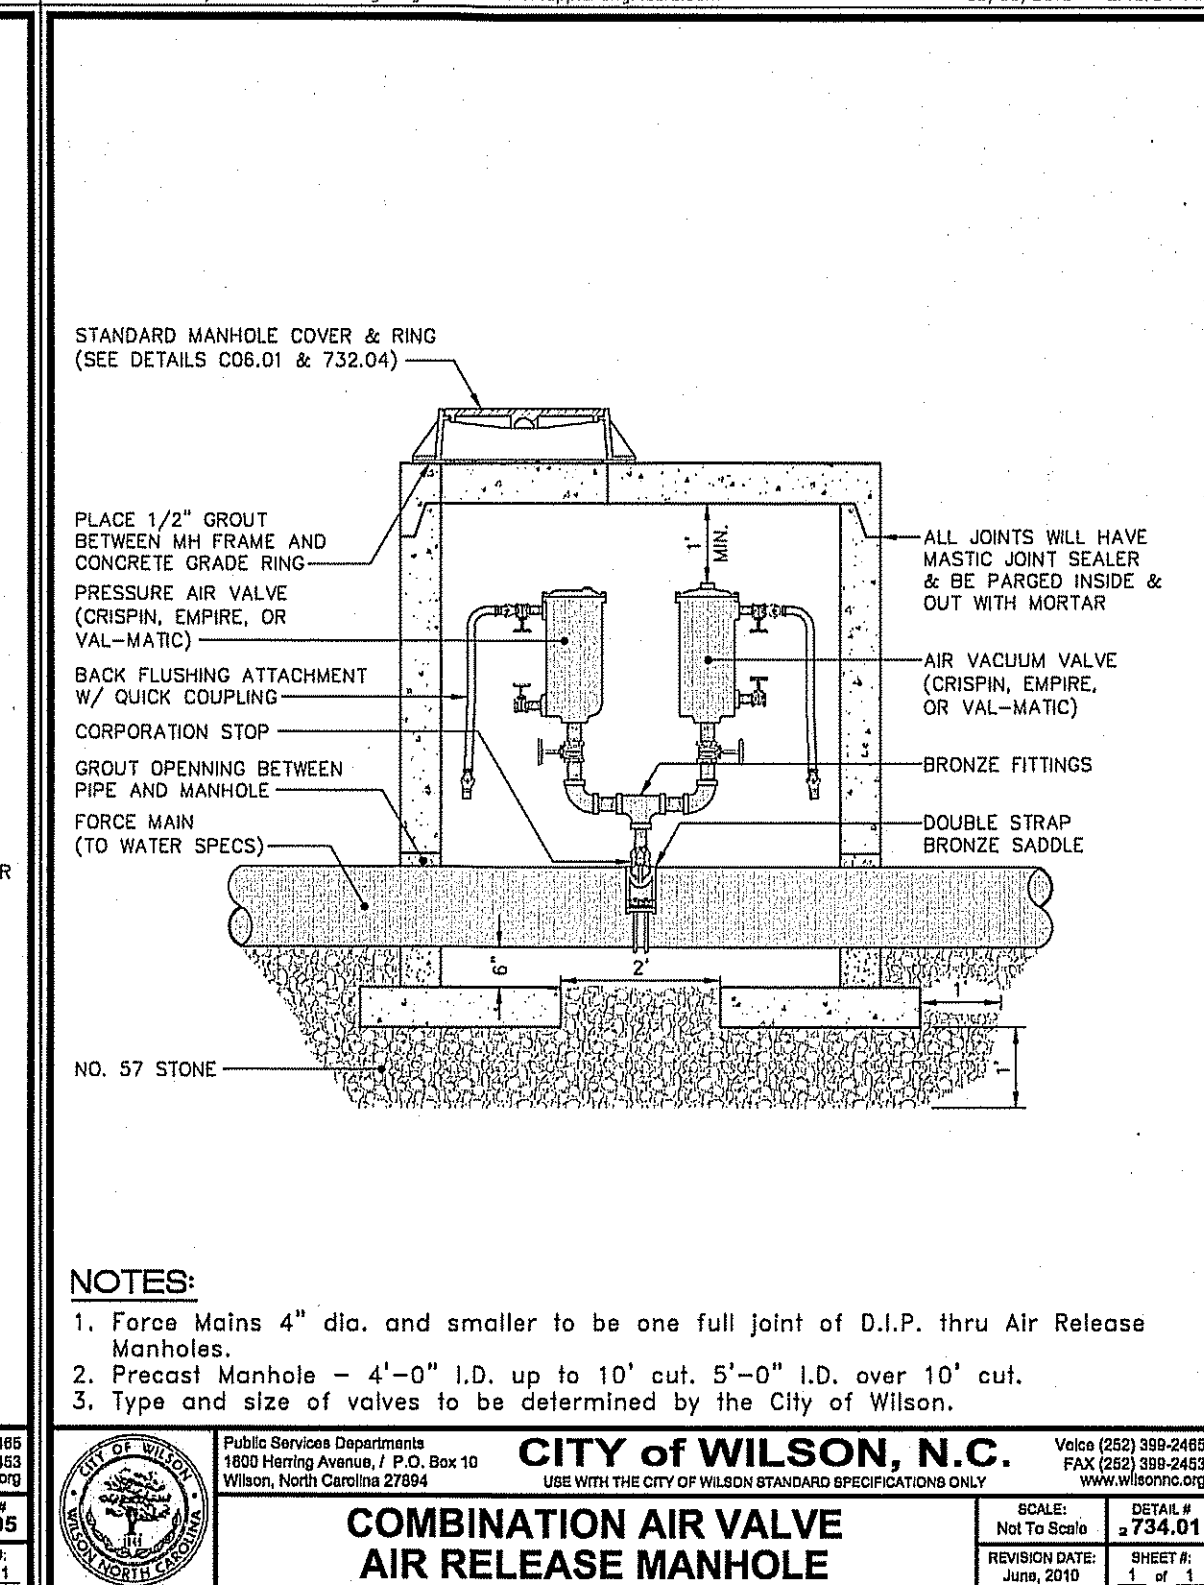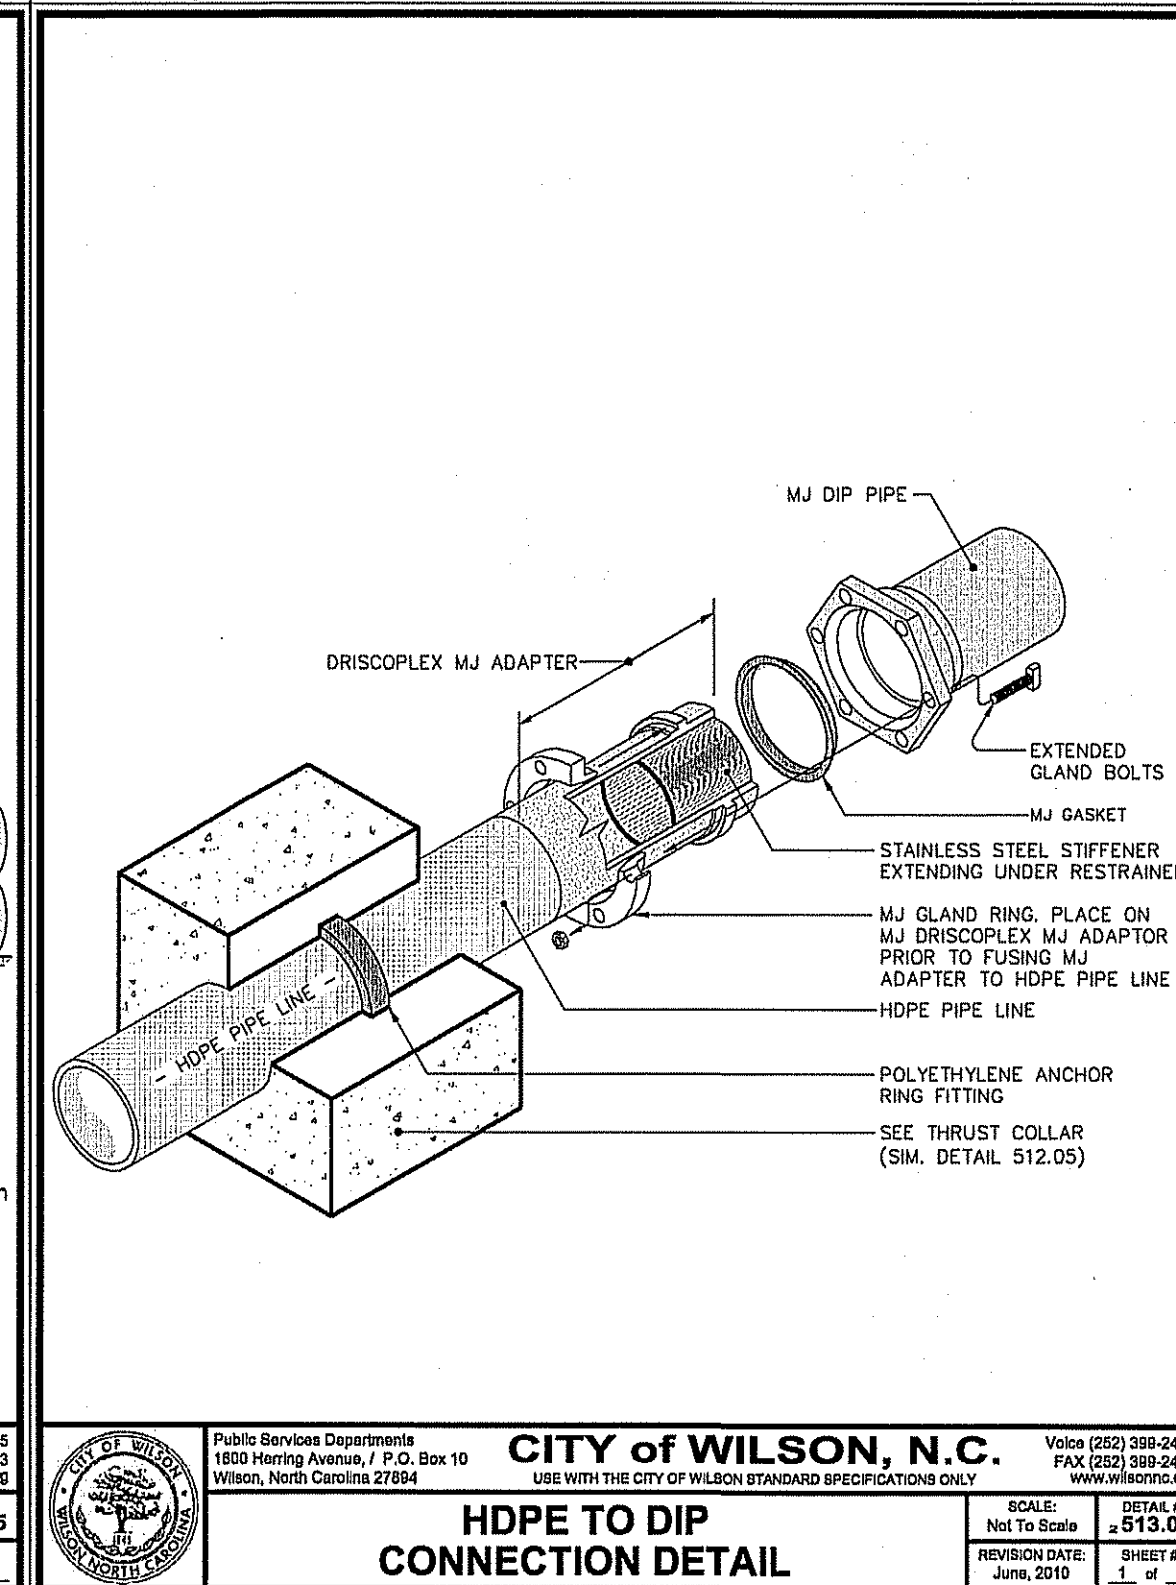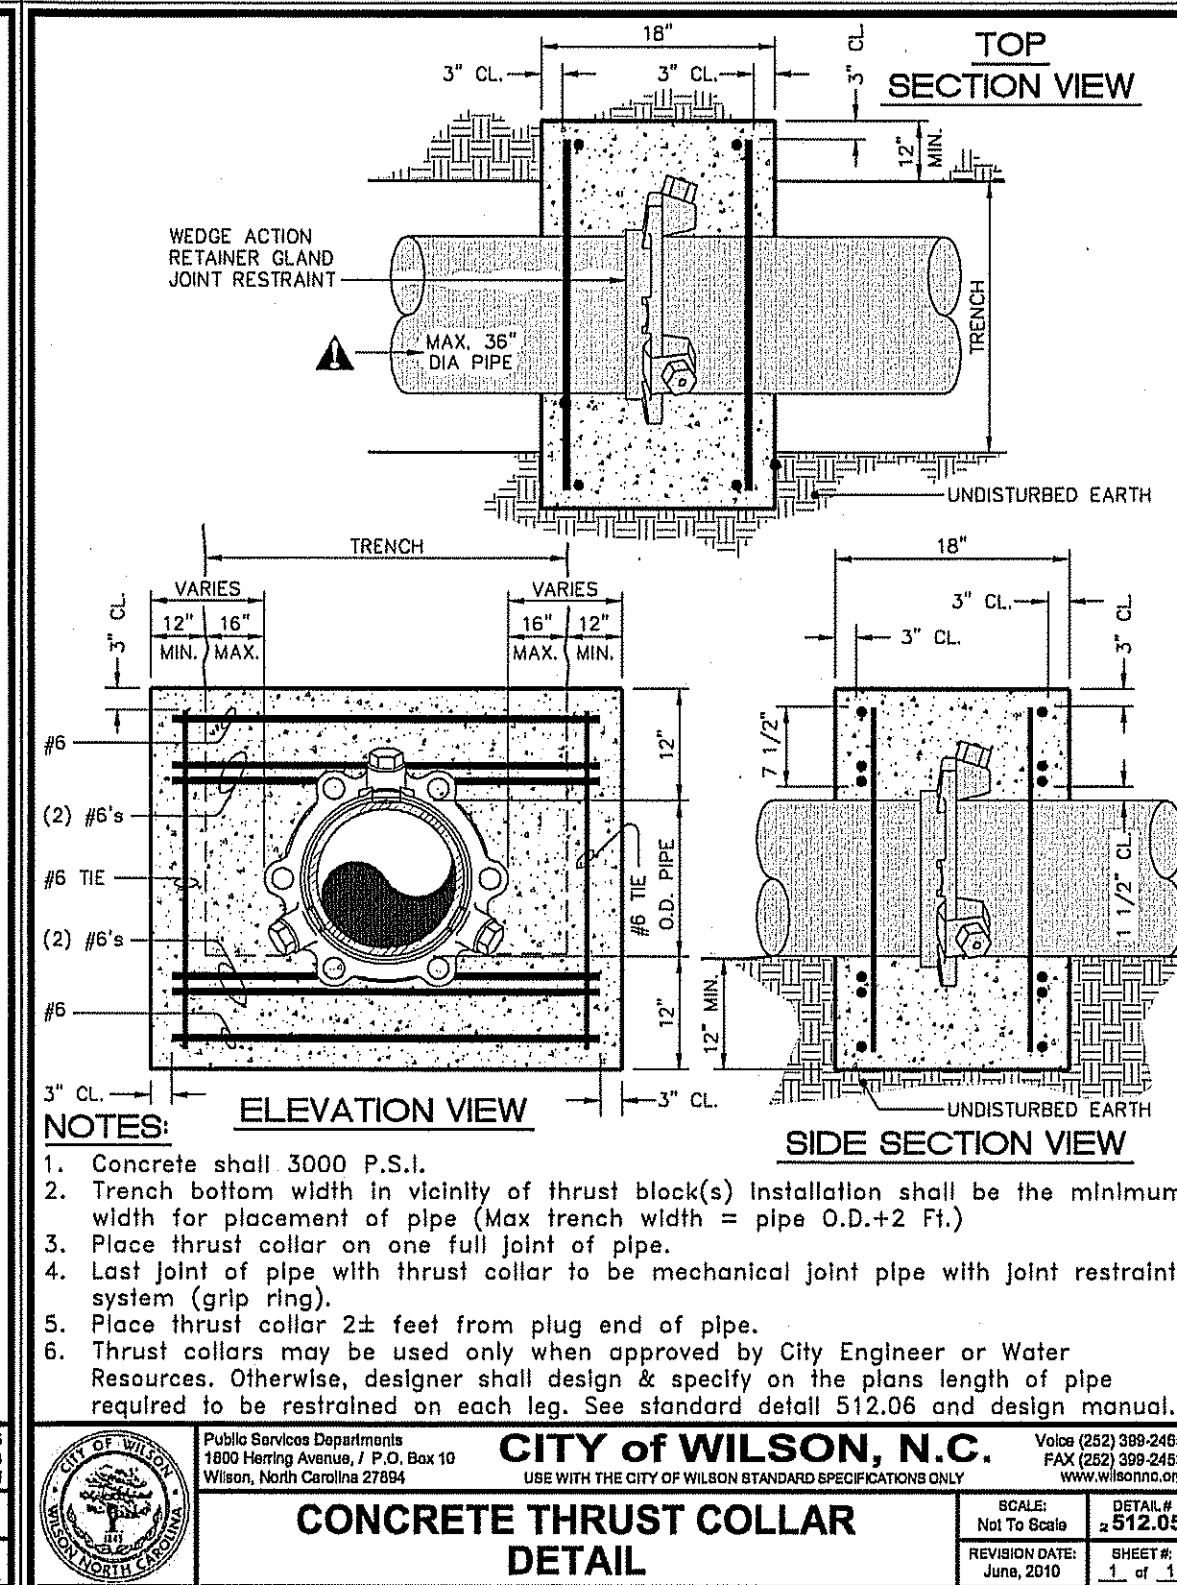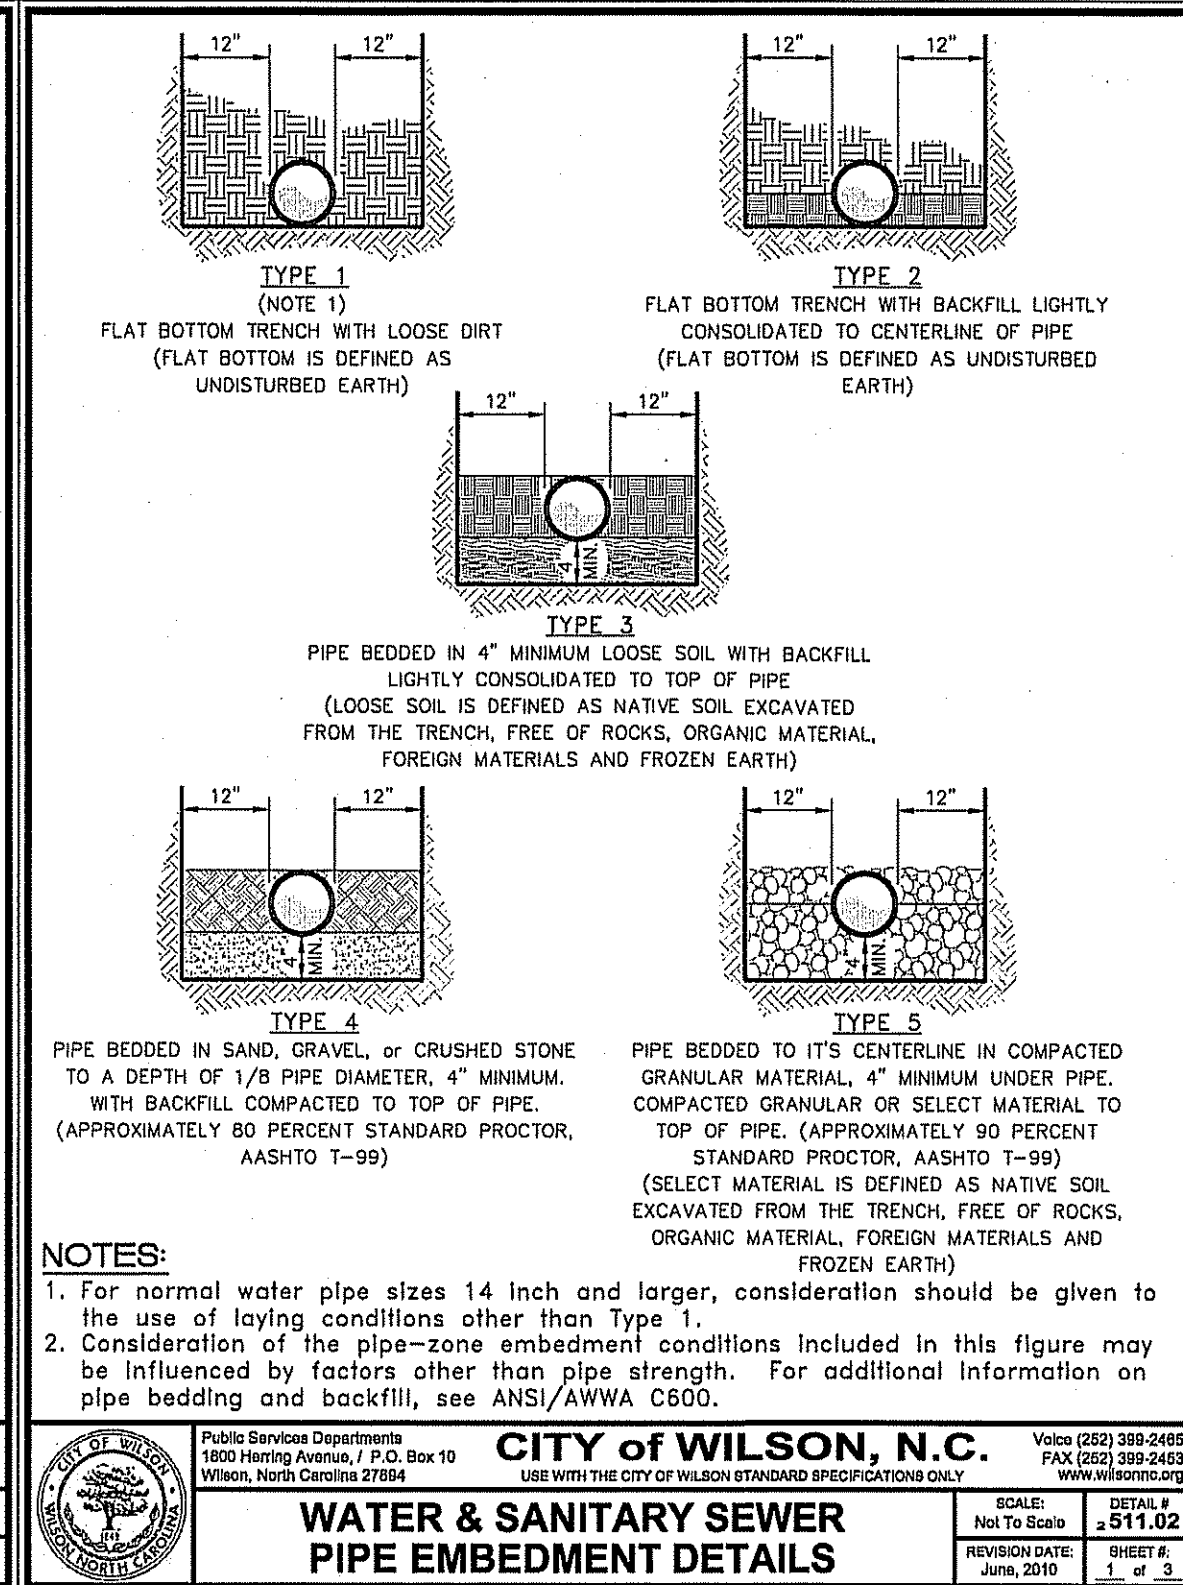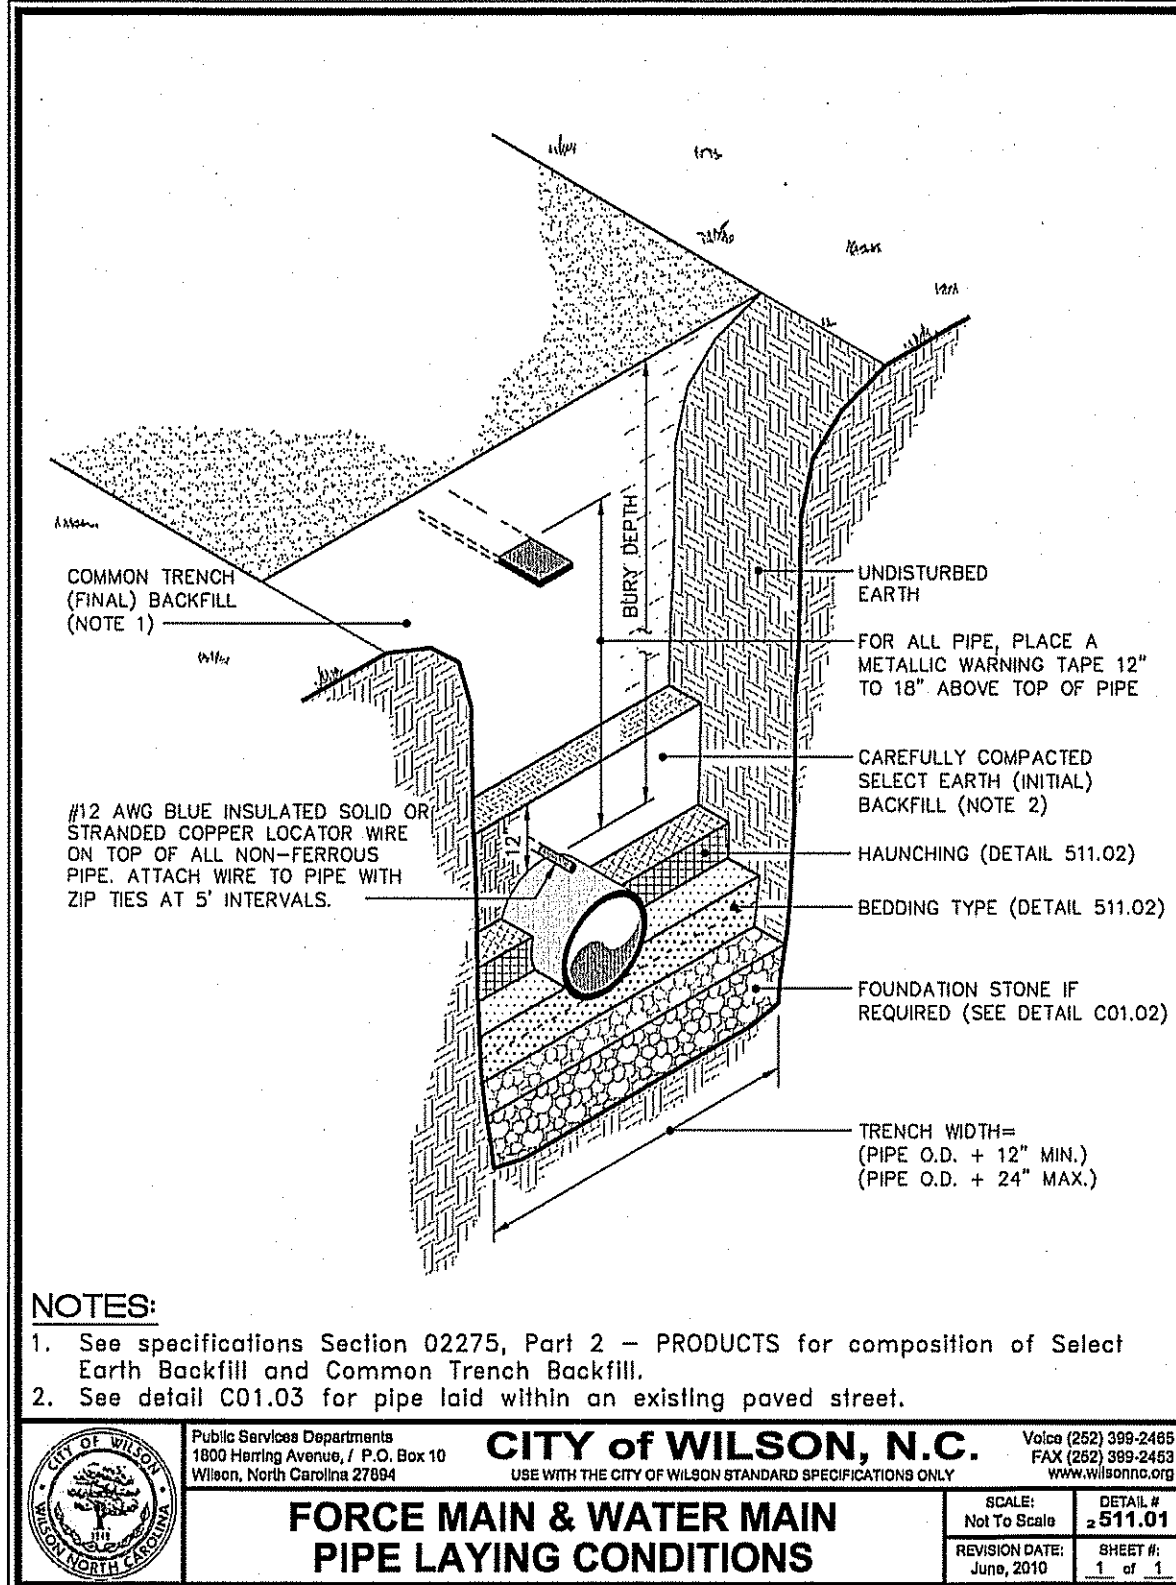

BARTLETT
ENGINEERING & SURVEYING, PC

1906 NASH STREET NORTH
WILSON, N.C. 27893-1726
LICENSE # C-1551

TELE: (252) 399-0704
FAX: (252) 399-0804
www.bartlettus.com

DETAILS

TIP NO. W-5204C
UTILITY CONSTRUCTION PLANS
NC 42 FROM BULLARD CT. TO TARTT'S MILL RD.
WILSON, NORTH CAROLINA

DATE: MARCH 2017	REVISIONS
SURVEY BY:	
DRAWN BY: RF	
CLIENT CODE: WC	
PROJECT: 16-241	
CADFILE: 16241CP2	
SCALE: NTS	
MARCH 9, 2018 JANUARY 10, 2019 OCTOBER 11, 2019	

SHEET

UC-4

P:\CADD\LANDPROJECTS\WC\16241\CP2A-2.dwg, Oct 11, 2019 2:08PM EST

STATE OF NORTH CAROLINA DIVISION OF HIGHWAYS

CROSS-SECTION SUMMARY

NOTE: EMBANKMENT COLUMN DOES NOT INCLUDES BACKFILL FOR UNDERCUT

X-1A

NOTE: EMBANKMENT COLUMN DOES NOT INCLUDES BACKFILL FOR UNDERCUT

STATION L	UNCLASSIFIED EXCAVATION (CU YD)	EMBANKMENT (CU YD)
10+00		
10+50	12	4
11+00	11	6
11+50	11	9
12+00	15	9
12+50	15	9
13+00	10	19
13+50	13	22
14+00	21	19
14+50	28	38
15+00	48	70
15+50	61	65
16+00	59	41
16+50	74	32
17+00	94	27
17+50	101	26
18+00	87	26
18+50	63	28
19+00	47	30
19+50	37	25



