



STATE	STATE PROJECT REFERENCE NO.	SHEET NO.	TOTAL SHEETS
N.C.	HS-2006A	1	
STATE PROJ. NO.	F.A. PROJ. NO.	DESCRIPTION	
49312.1.2	HSIP-1415 (005)	PE	
49312.3.2	HSIP-1415 (005)	CONST	

STATE OF NORTH CAROLINA
DIVISION OF HIGHWAYS

CUMBERLAND COUNTY

LOCATION: SR 1415(YADKIN ROAD) AT US 401 BYP (SKIBO ROAD), AT SR 1437 (SANTE FE DRIVE), AND AT SOUTHWICK DRIVE

TYPE OF WORK: ADD SIGNALIZED PERDESTRIAN CROSSINGS TO ALL THREE INTERSECTIONS, AND UPGRADE SIGNAL AT SOUTHWICK DRIVE.

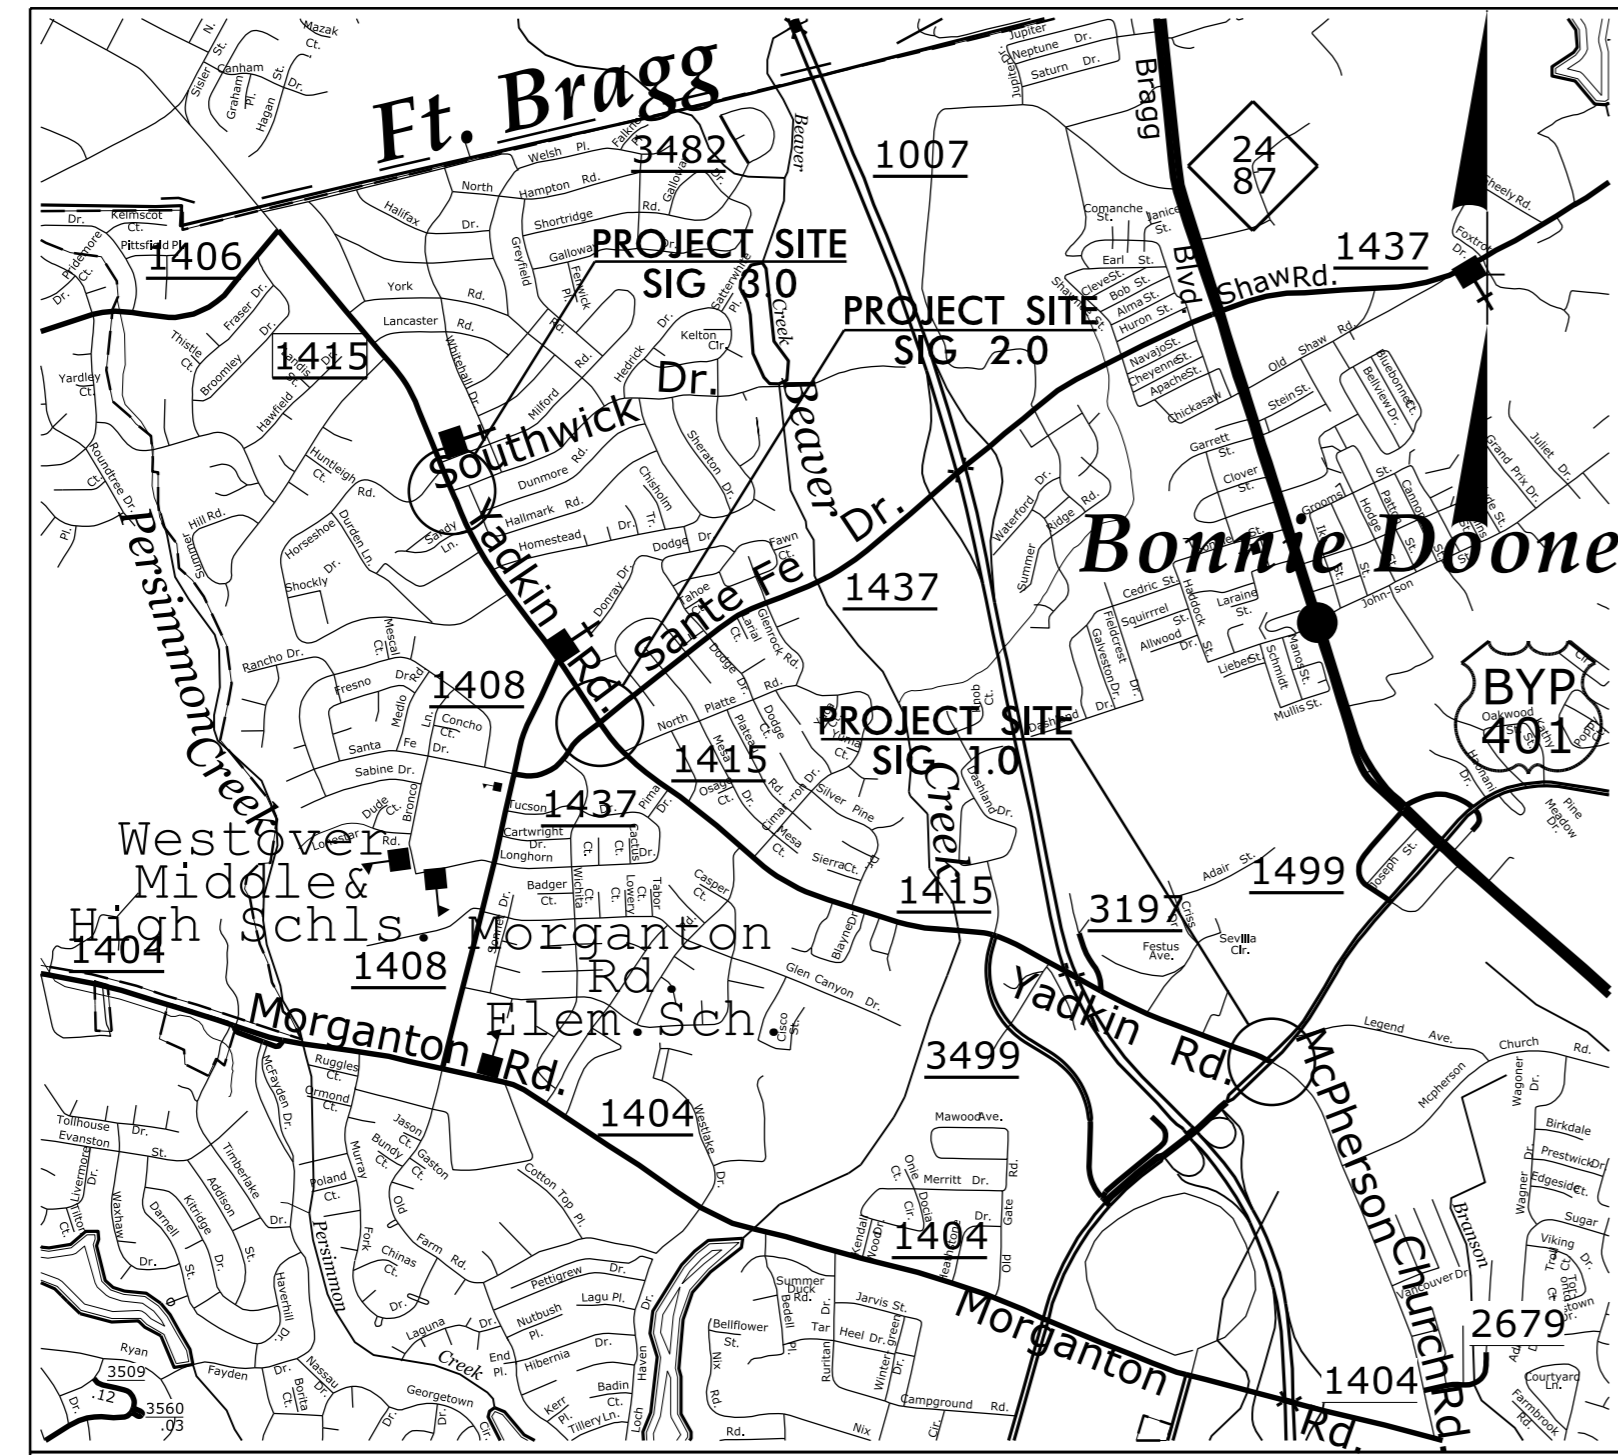
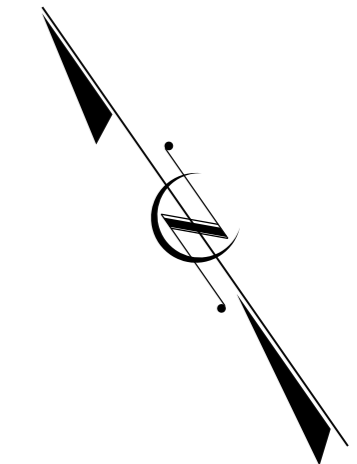


VICINITY MAP

TIP PROJECT: HS-2006A

CONTRACT: DF00431

SHEET 4
Sig 1.0 06-0055

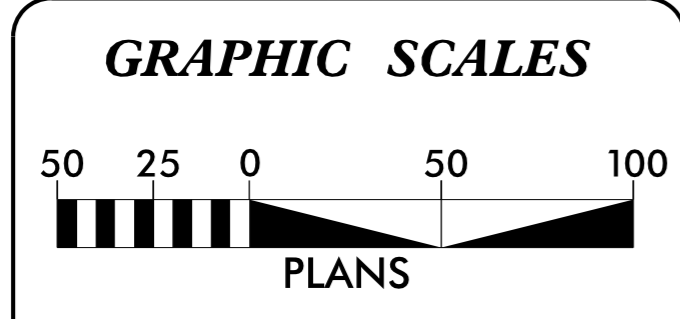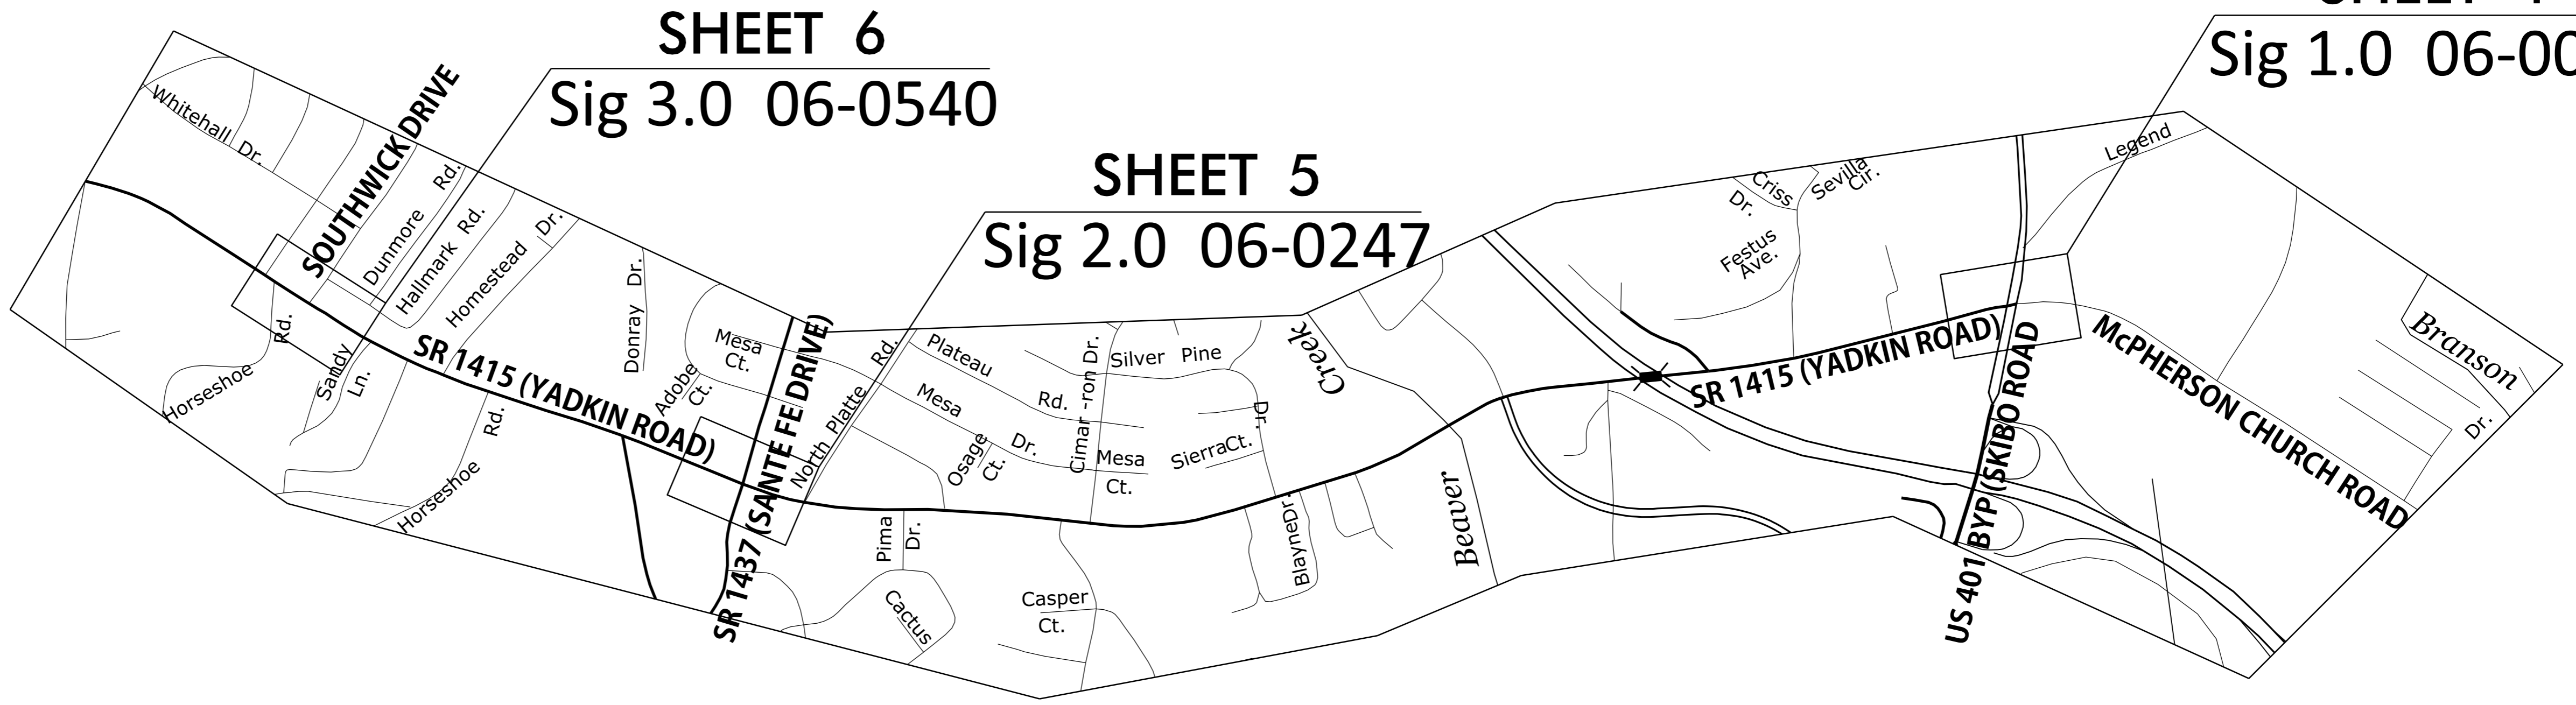

DESIGN DATA

PROJECT LENGTH


Prepared in the Office of:
DIVISION OF HIGHWAYS
DIVISION 6
431 Transportation Dr., Fayetteville NC, 28301
2018 STANDARD SPECIFICATIONS

RIGHT OF WAY DATE:
N/A

LETTING DATE:
MAY 17, 2023

JOHN GAUTHIER
PROJECT ENGINEER

PROJECT DESIGN ENGINEER

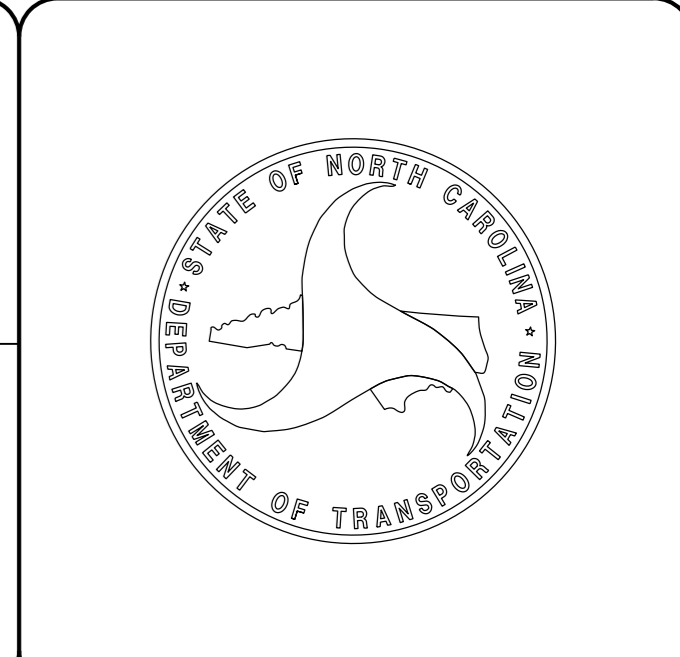

25-APR-2023 10:12 S:\DDC\Projects\HS-2006A_Yadkin Sidewalks\Roadway\proj\HS-2006A_Rdy_1sh.dgn \$\$\$USERNAME\$\$\$

PROJECT REFERENCE NO. <i>HS-2006A</i>	SHEET NO. <i>04</i>
RW SHEET NO.	
ROADWAY DESIGN ENGINEER	HYDRAULICS ENGINEER
DOCUMENT NOT CONSIDERED FINAL UNLESS ALL SIGNATURES COMPLETED	



5/14/99

12-APR-2023 11:17
 I:\projects\2006A_Yadkin\Roadway\proj\NHS-2006A_Rdy_psh_04.dgn
 3/23/2023 11:17 AM

PROJECT REFERENCE NO. <i>HS-2006A</i>	SHEET NO. <i>05</i>
RW SHEET NO.	
ROADWAY DESIGN ENGINEER	HYDRAULICS ENGINEER

**DOCUMENT NOT CONSIDERED FINAL
UNLESS ALL SIGNATURES COMPLETED**



5/14/99

\\fs1\NHS-2006A\Roadway\proj\NHS-2006A_Rdy_psh_05.dgn
11:33 AM 5/14/99

PROJECT REFERENCE NO. <i>HS-2006A</i>	SHEET NO. <i>06</i>
RW SHEET NO.	
ROADWAY DESIGN ENGINEER	HYDRAULICS ENGINEER
DOCUMENT NOT CONSIDERED FINAL UNLESS ALL SIGNATURES COMPLETED	



5/14/99

12-APR-2023 15:43
 I:\HS-2006A\Yadkin\Roadway\proj\HS-2006A_Rdy_psh_06.dgn
 10/06/2023