

**This electronic collection of documents is provided
for the convenience of the user
and is Not a Certified Document –**

**The documents contained herein were originally issued
and sealed by the individuals whose names and license
numbers appear on each page, on the dates appearing
with their signature on that page.**


**This file or an individual page
shall not be considered a certified document.**

09/08/99

14-JUN-2017 12:55
H:\DDC\Projects\W-5601CC (SR 1229) McDougald Rd - Harnett\Roadway\proj\W-5601CC.Rdy-+sh.dgn
\$\$\$\$\$USERNAME\$\$\$\$\$

CONTRACT: DF00172

TIP PROJECT: W-5601CC

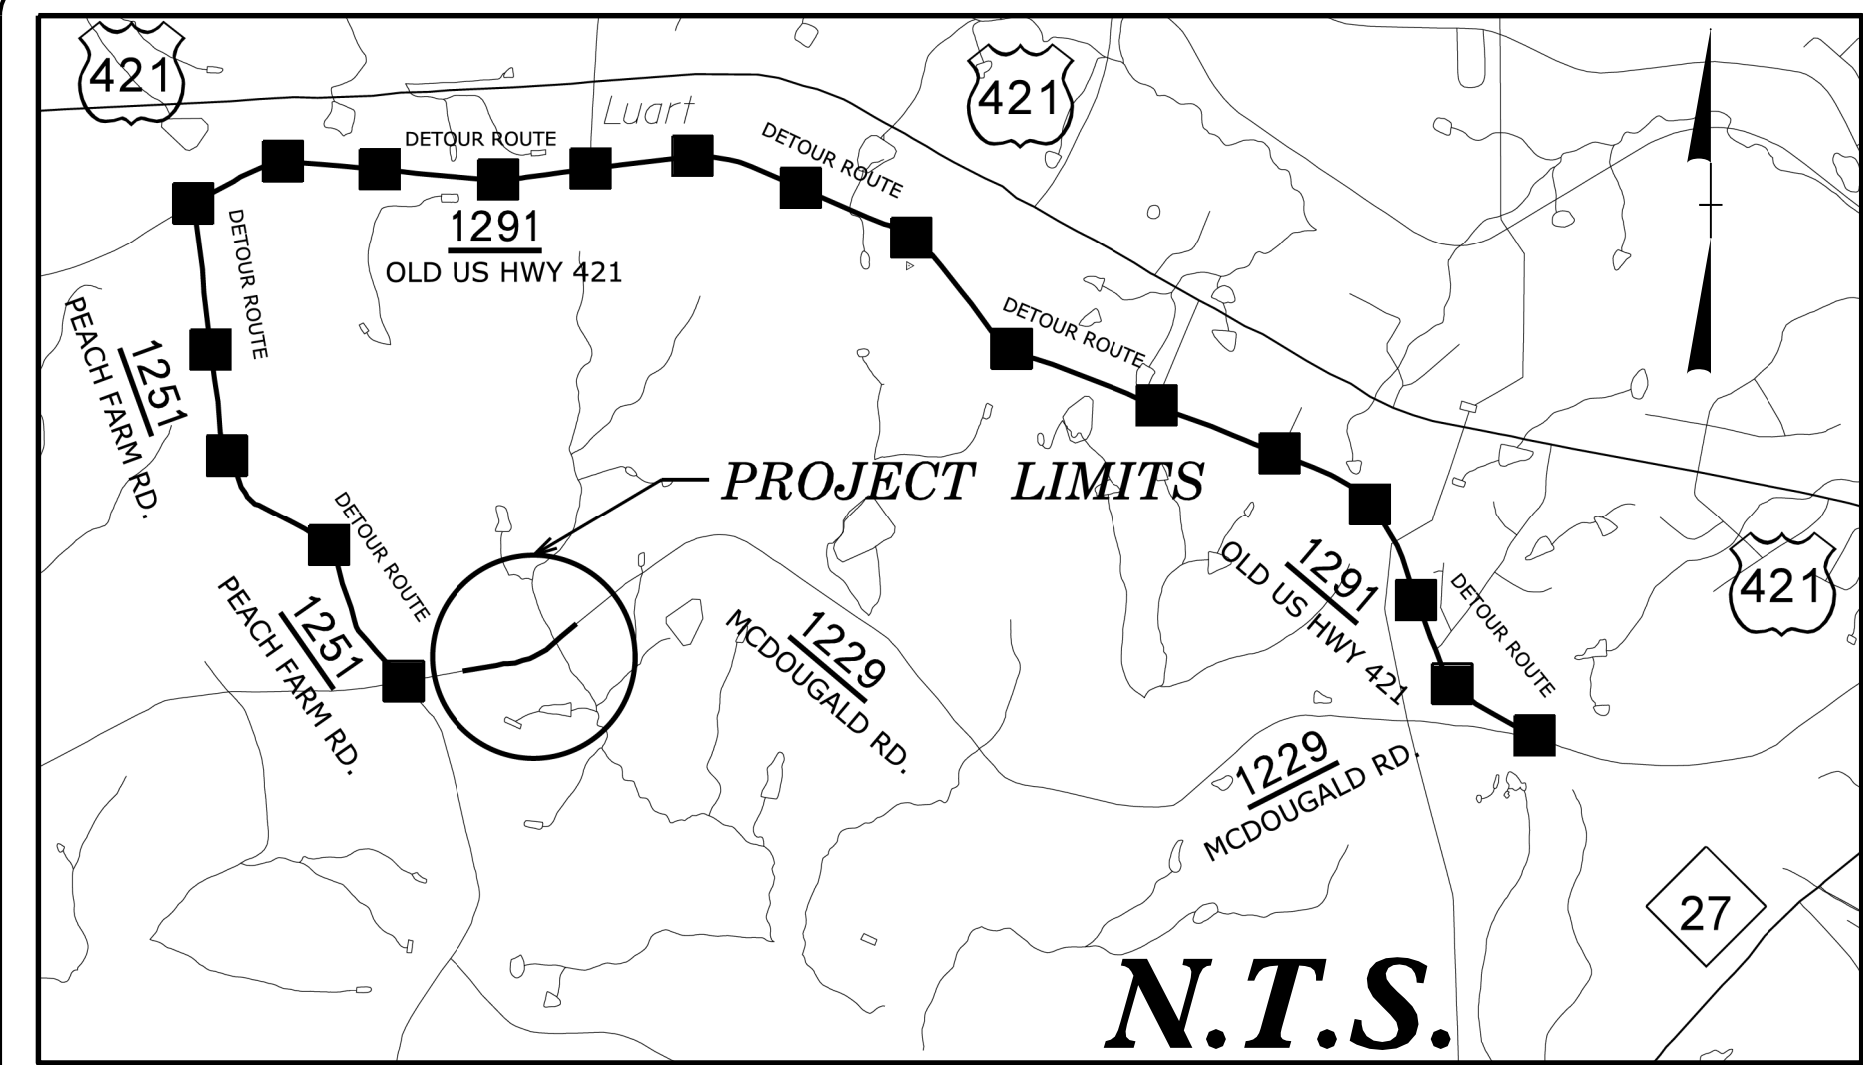

OFF SITE DETOUR

STATE OF NORTH CAROLINA
DIVISION OF HIGHWAYS

HARNETT COUNTY

LOCATION: McDOUGALD ROAD (SR 1229) APPROXIMATELY 0.3 MILES
EAST OF PEACH FARM ROAD (SR 1251)

TYPE OF WORK: CULVERT, WIDENING, PAVING, GUARDRAIL, DRAINAGE
AND PAVEMENT MARKINGS


STATE	STATE PROJECT REFERENCE NO.	SHEET NO.	TOTAL SHEETS
N.C.	W-5601CC	1	
STATE PROJ. NO.	F.A. PROJ. NO.	DESCRIPTION	
50138.1.82	HSIP-1229(015)	P.E.	
50138.2.82	HSIP-1229(015)	ROW /UTIL	
50138.3.82	HSIP-1229(015)	CONSTRUCTION	

BEGIN STATE PROJECT W-5601CC

END STATE PROJECT W-5601CC


-L- STA 9+50.00

-L- STA 22+00.00

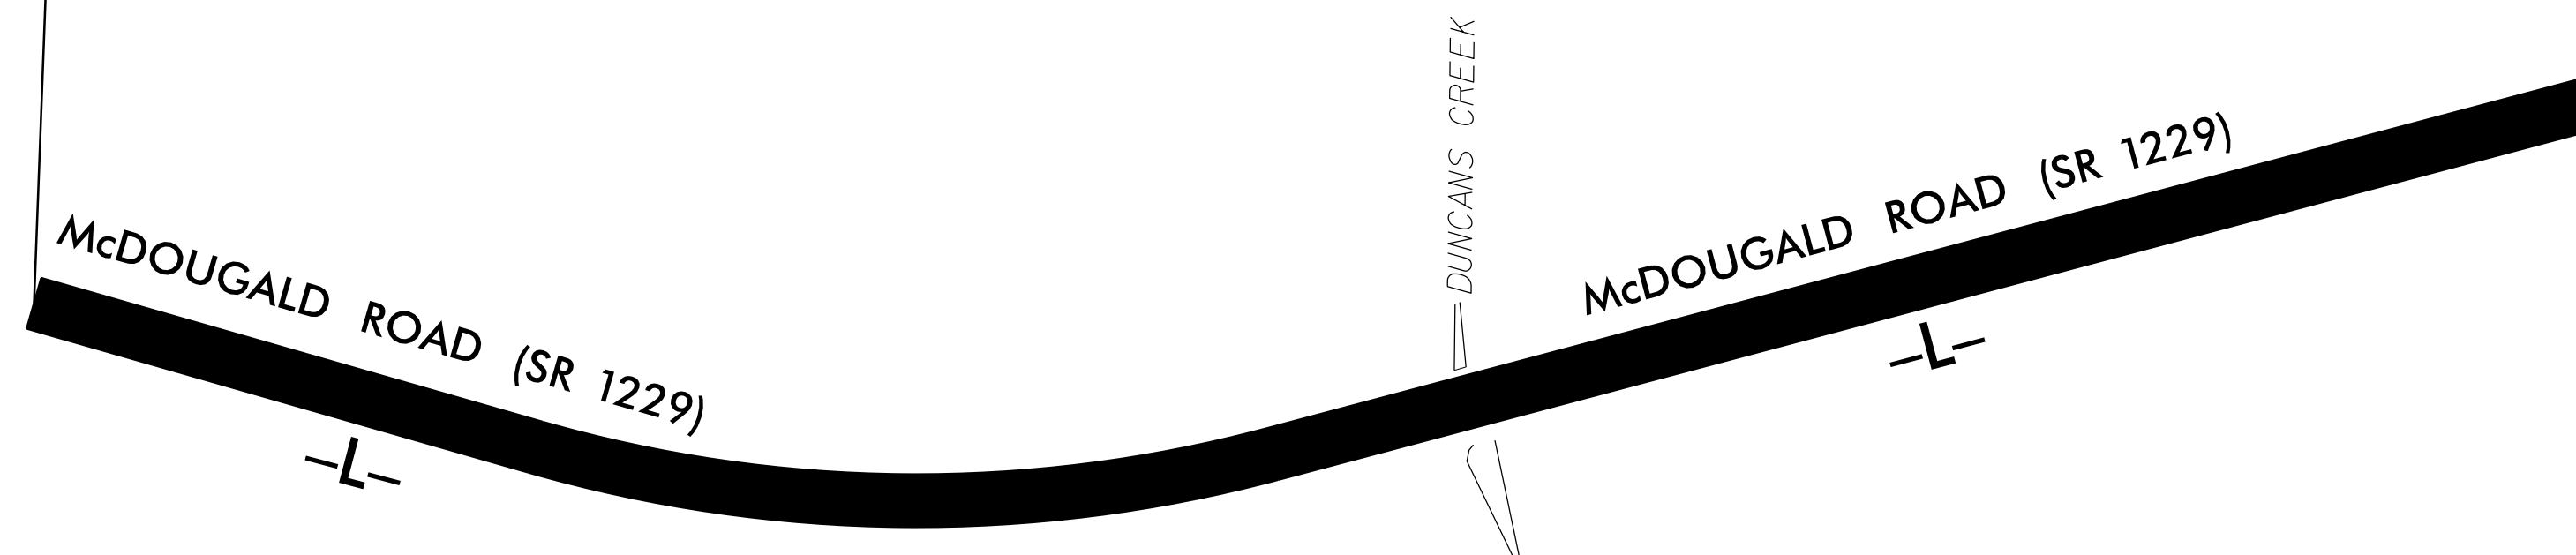

N.T.S.

GRAPHIC SCALES

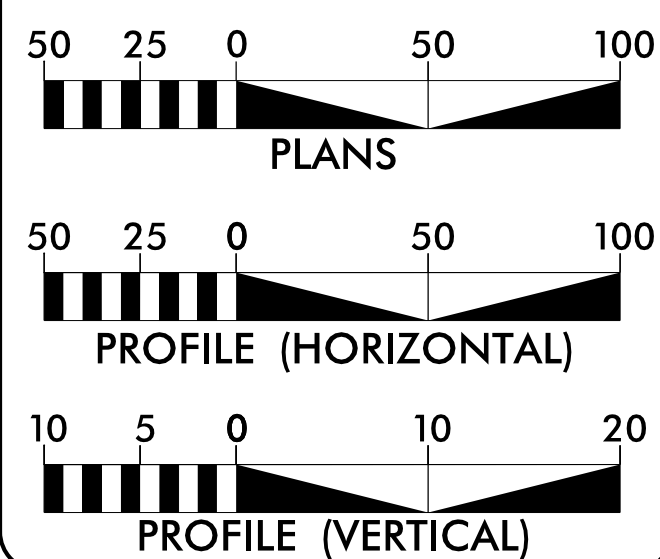

DESIGN DATA

ADT 2017 = 612
ADT 2037 = 1105

PROJECT LENGTH

TOTAL PROJECT LENGTH = 0.237 MILES

Prepared in the Office of:
DIVISION OF HIGHWAYS
431 Transportation Dr., Fayetteville NC 28301


2012 STANDARD SPECIFICATIONS

RIGHT OF WAY DATE:
OCTOBER 31, 2016

LETTING DATE:
JULY 19, 2017

SEAN MATUSZEWSKI
PROJECT ENGINEER

ALEX HENDERSON
PROJECT DESIGN ENGINEER

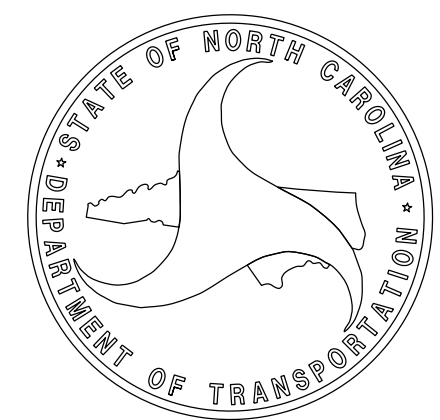

STATE OF NORTH CAROLINA, DIVISION OF HIGHWAYS
CONVENTIONAL PLAN SHEET SYMBOLS

BOUNDARIES AND PROPERTY:

State Line	
County Line	
Township Line	
City Line	
Reservation Line	
Property Line	
Existing Iron Pin	
Computed Property Corner	
Property Monument	
Parcel/Sequence Number	
Existing Fence Line	
Proposed Woven Wire Fence	
Proposed Chain Link Fence	
Proposed Barbed Wire Fence	
Existing Wetland Boundary	
Proposed Wetland Boundary	
Existing Endangered Animal Boundary	
Existing Endangered Plant Boundary	
Existing Historic Property Boundary	
Known Contamination Area: Soil	
Potential Contamination Area: Soil	
Known Contamination Area: Water	
Potential Contamination Area: Water	
Contaminated Site: Known or Potential	

BUILDINGS AND OTHER CULTURE:

Gas Pump Vent or U/G Tank Cap	
Sign	
Well	
Small Mine	
Foundation	
Area Outline	
Cemetery	
Building	
School	
Church	
Dam	

HYDROLOGY:

Stream or Body of Water	
Hydro, Pool or Reservoir	
Jurisdictional Stream	
Buffer Zone 1	
Buffer Zone 2	
Flow Arrow	
Disappearing Stream	
Spring	
Wetland	
Proposed Lateral, Tail, Head Ditch	
False Sump	

RAILROADS:

Standard Gauge	
RR Signal Milepost	
Switch	
RR Abandoned	
RR Dismantled	

RIGHT OF WAY & PROJECT CONTROL:

Secondary Horiz and Vert Control Point	
Primary Horiz Control Point	
Primary Horiz and Vert Control Point	
Exist Permanent Easment Pin and Cap	
New Permanent Easement Pin and Cap	
Vertical Benchmark	
Existing Right of Way Marker	
Existing Right of Way Line	
New Right of Way Line	
New Right of Way Line with Pin and Cap	
New Right of Way Line with Concrete or Granite RW Marker	
New Control of Access Line with Concrete C/A Marker	
Existing Control of Access	
New Control of Access	
Existing Easement Line	
New Temporary Construction Easement	
New Temporary Drainage Easement	
New Permanent Drainage Easement	
New Permanent Drainage / Utility Easement	
New Permanent Utility Easement	
New Temporary Utility Easement	
New Aerial Utility Easement	

ROADS AND RELATED FEATURES:

Existing Edge of Pavement	
Existing Curb	
Proposed Slope Stakes Cut	
Proposed Slope Stakes Fill	
Proposed Curb Ramp	
Existing Metal Guardrail	
Proposed Guardrail	
Existing Cable Guiderail	
Proposed Cable Guiderail	
Equality Symbol	
Pavement Removal	

VEGETATION:

Single Tree	
Single Shrub	

Hedge	
Woods Line	
Orchard	
Vineyard	

EXISTING STRUCTURES:

MAJOR:	
Bridge, Tunnel or Box Culvert	
Bridge Wing Wall, Head Wall and End Wall	
MINOR:	
Head and End Wall	
Pipe Culvert	
Footbridge	
Drainage Box: Catch Basin, DI or JB	
Paved Ditch Gutter	
Storm Sewer Manhole	
Storm Sewer	

UTILITIES:

POWER:	
Existing Power Pole	
Proposed Power Pole	
Existing Joint Use Pole	
Proposed Joint Use Pole	
Power Manhole	
Power Line Tower	
Power Transformer	
U/G Power Cable Hand Hole	
H-Frame Pole	
U/G Power Line LOS B (S.U.E.*)	
U/G Power Line LOS C (S.U.E.*)	
U/G Power Line LOS D (S.U.E.*)	

TELEPHONE:

Existing Telephone Pole	
Proposed Telephone Pole	
Telephone Manhole	
Telephone Pedestal	
Telephone Cell Tower	
U/G Telephone Cable Hand Hole	
U/G Telephone Cable LOS B (S.U.E.*)	
U/G Telephone Cable LOS C (S.U.E.*)	
U/G Telephone Cable LOS D (S.U.E.*)	
U/G Telephone Conduit LOS B (S.U.E.*)	
U/G Telephone Conduit LOS C (S.U.E.*)	
U/G Telephone Conduit LOS D (S.U.E.*)	
U/G Fiber Optics Cable LOS B (S.U.E.*)	
U/G Fiber Optics Cable LOS C (S.U.E.*)	
U/G Fiber Optics Cable LOS D (S.U.E.*)	

WATER:

Water Manhole	
Water Meter	
Water Valve	
Water Hydrant	
U/G Water Line LOS B (S.U.E.*)	
U/G Water Line LOS C (S.U.E.*)	
U/G Water Line LOS D (S.U.E.*)	
Above Ground Water Line	

TV:

TV Pedestal	
TV Tower	
U/G TV Cable Hand Hole	
U/G TV Cable LOS B (S.U.E.*)	
U/G TV Cable LOS C (S.U.E.*)	
U/G TV Cable LOS D (S.U.E.*)	
U/G Fiber Optic Cable LOS B (S.U.E.*)	
U/G Fiber Optic Cable LOS C (S.U.E.*)	
U/G Fiber Optic Cable LOS D (S.U.E.*)	

GAS:

Gas Valve	
Gas Meter	
U/G Gas Line LOS B (S.U.E.*)	
U/G Gas Line LOS C (S.U.E.*)	
U/G Gas Line LOS D (S.U.E.*)	
Above Ground Gas Line	

SANITARY SEWER:

Sanitary Sewer Manhole	
Sanitary Sewer Cleanout	
U/G Sanitary Sewer Line	
Above Ground Sanitary Sewer	
SS Forced Main Line LOS B (S.U.E.*)	
SS Forced Main Line LOS C (S.U.E.*)	
SS Forced Main Line LOS D (S.U.E.*)	



MISCELLANEOUS:

Utility Pole	
Utility Pole with Base	
Utility Located Object	
Utility Traffic Signal Box	
Utility Unknown U/G Line LOS B (S.U.E.*)	
U/G Tank; Water, Gas, Oil	
Underground Storage Tank, Approx. Loc.	
A/G Tank; Water, Gas, Oil	
Geoenvironmental Boring	
U/G Test Hole LOS A (S.U.E.*)	
Abandoned According to Utility Records	AATUR
End of Information	E.O.I.

6/2/99

FINAL PAVEMENT DESIGN

PAVEMENT SCHEDULE	
C1	PROP. APPROX. 1½" ASPHALT CONCRETE SURFACE COURSE, TYPE S9.5B, AT AN AVERAGE RATE OF 168 LBS. PER SQ. YD.
C2	PROP. VAR. DEPTH ASPHALT CONCRETE SURFACE COURSE, TYPE S9.5B, AT AN AVERAGE RATE OF 112 LBS. PER SQ. YD. PER 1" DEPTH. TO BE PLACED IN LAYERS NOT TO EXCEED 2" IN DEPTH.
D1	PROP. VAR. DEPTH ASPHALT CONCRETE INTERMEDIATE COURSE, TYPE I19.0B, AT AN AVERAGE RATE OF 114 LBS. PER SQ. YD. PER 1" DEPTH, TO BE PLACED IN LAYERS NOT LESS THAN 2½" IN DEPTH OR GREATER THAN 4" IN DEPTH.
E1	PROP. APPROX. 5½" ASPHALT CONCRETE BASE COURSE, TYPE B25.0B, AT AN AVERAGE RATE OF 627 LBS. PER SQ. YD.
E2	PROP. VAR. DEPTH ASPHALT CONCRETE BASE COURSE, TYPE B25.0B, AT AN AVERAGE RATE OF 114 LBS. PER SQ. YD. PER 1" DEPTH. TO BE PLACED IN LAYERS NOT LESS THAN 3" IN DEPTH OR GREATER THAN 5½" IN DEPTH.
T	EARTH MATERIAL.
W	VARIABLE DEPTH ASPHALT PAVEMENT (SEE STANDARD WEDGING DETAIL)
U	EXISTING PAVEMENT.

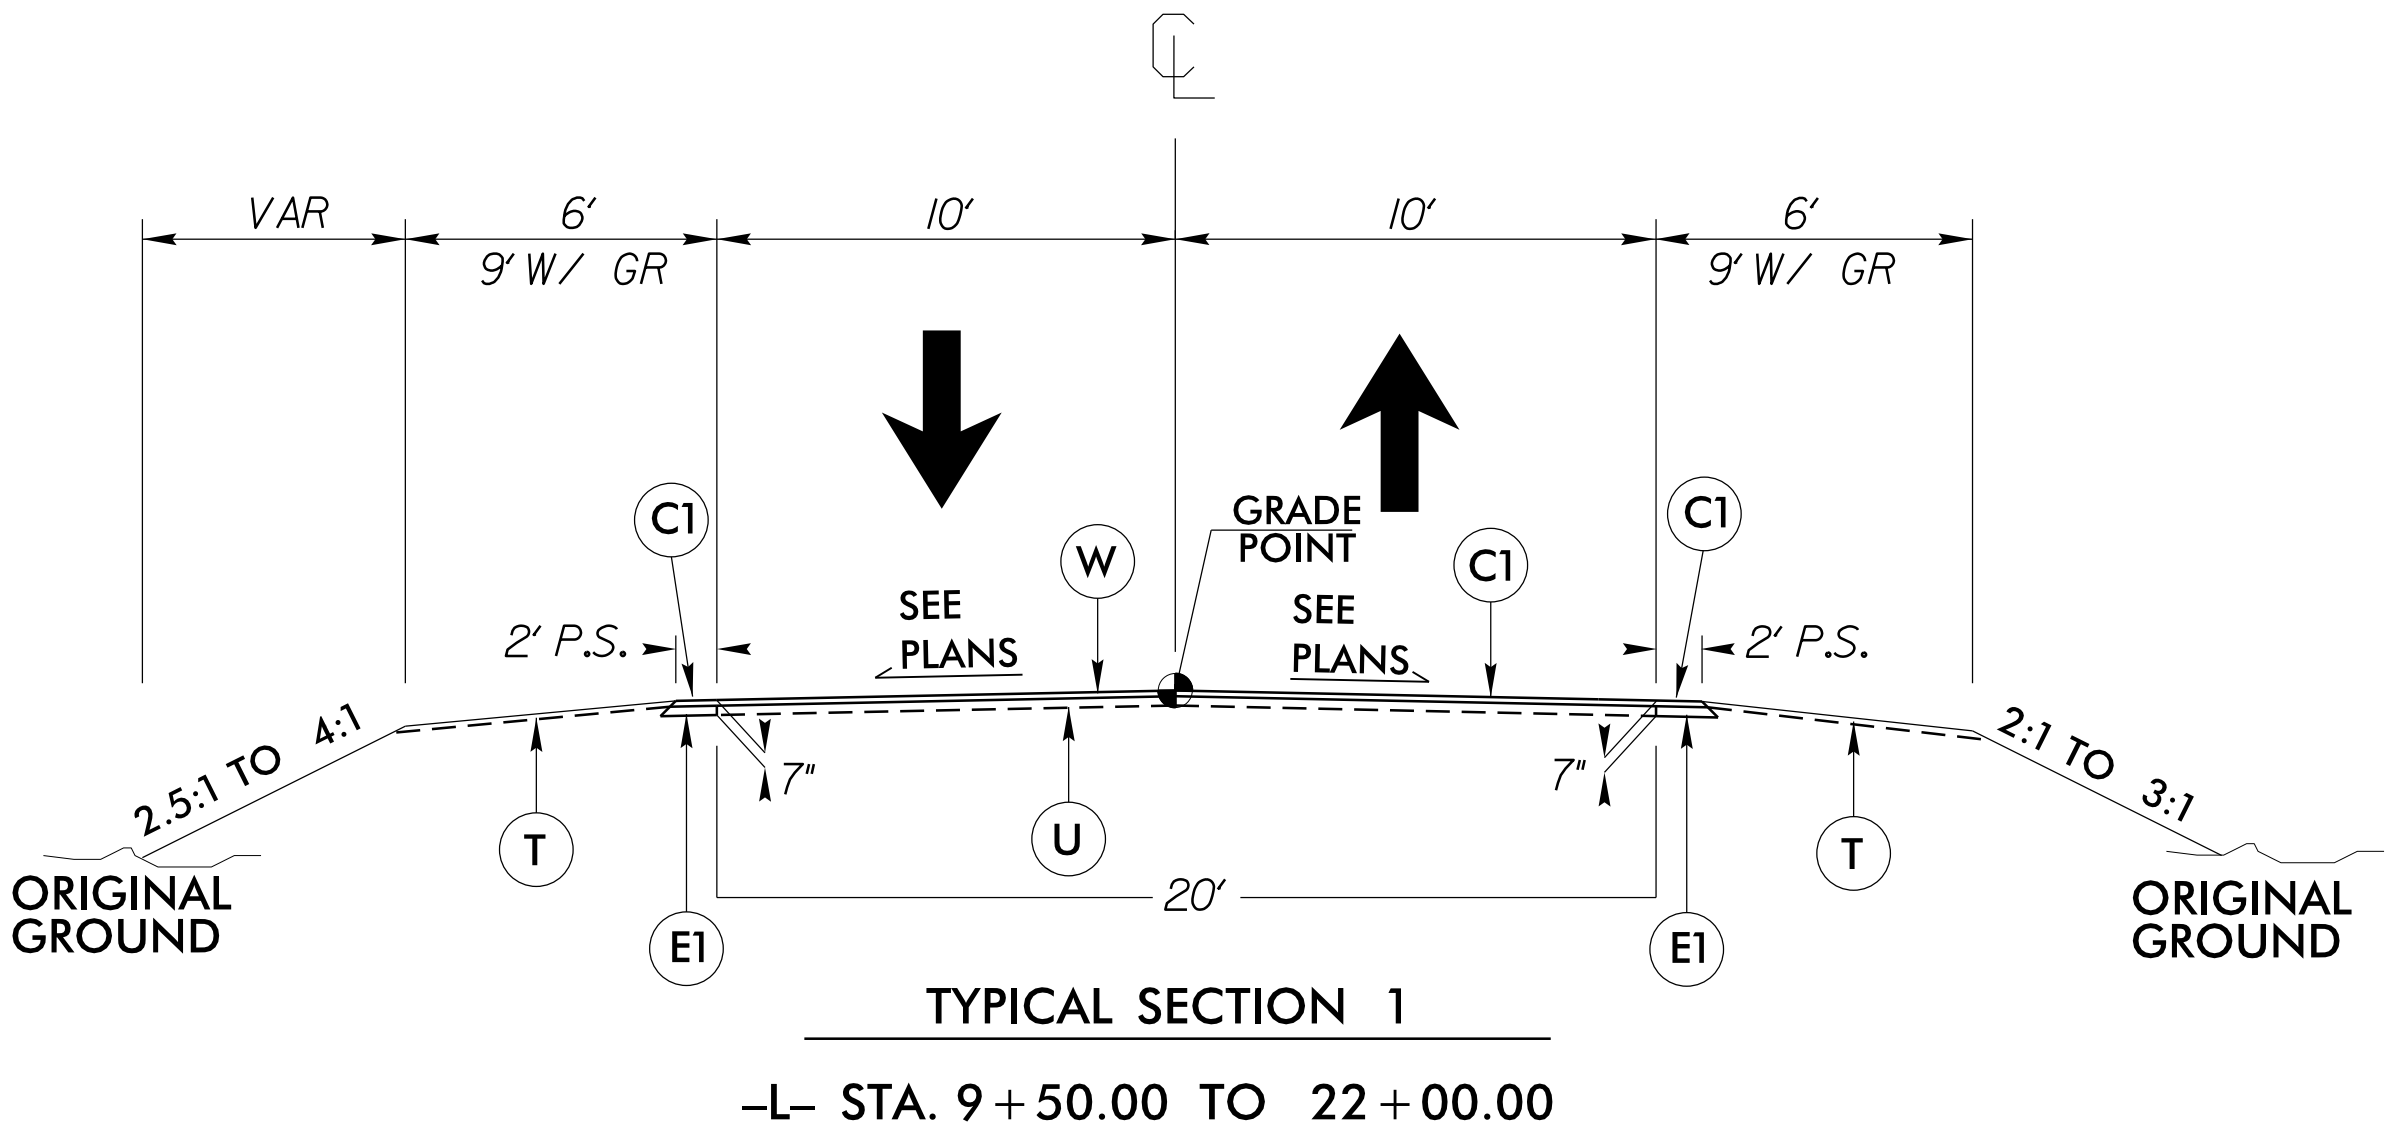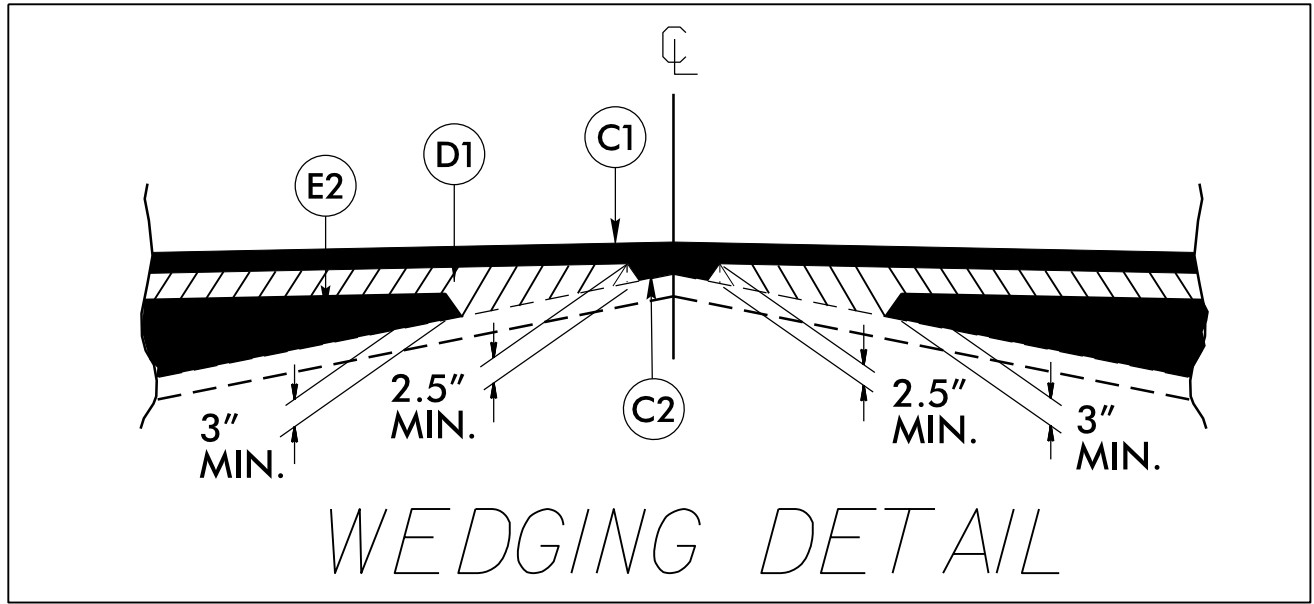


MILLING AT PAVEMENT TIE-INS

NOTES TO CONTRACTOR

For surface mixes over 1" in thickness, mill the existing pavement in accordance with the following sketch as directed by the Engineer.

Locations shall include ties into existing concrete pavement, at bridge approaches where the bridge will not be resurfaced, and at the beginning and ending point of each resurfacing map.

Perform the work in accordance with Section 607 of the January 2012 North Carolina Department of Transportation Standard Specifications for Roads and Structures. Resurfacing will be accomplished at the same time as the milling operation.

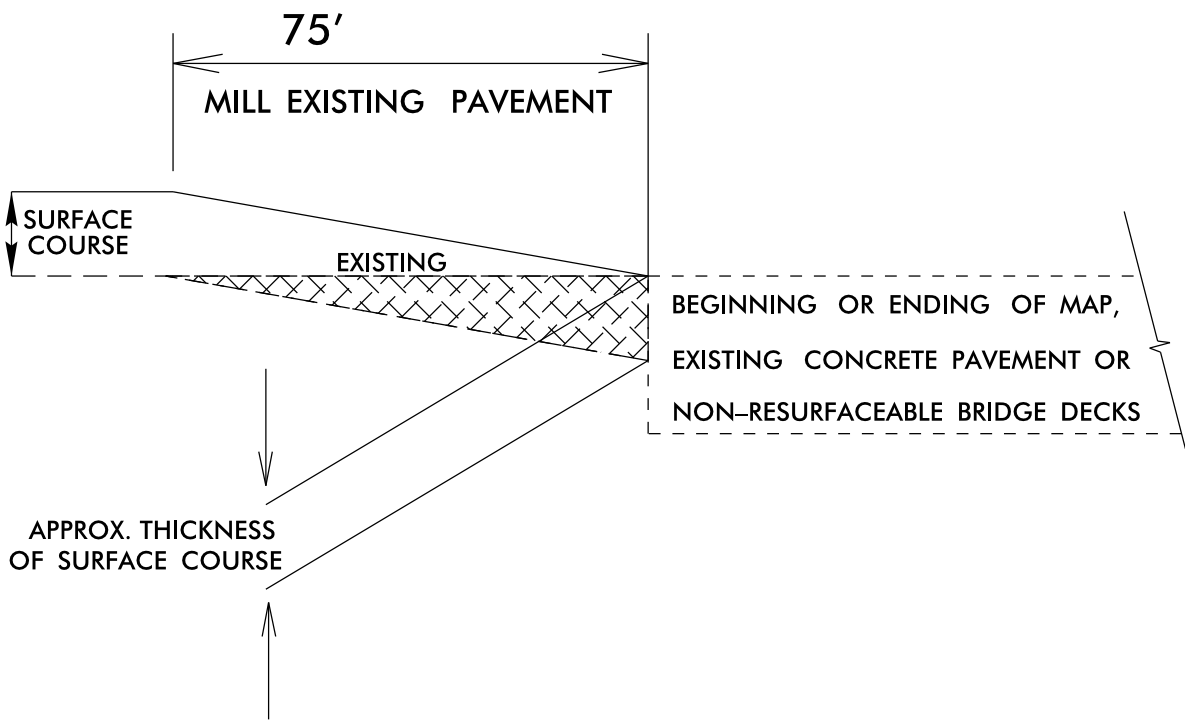

PROJECT NOTES

1. The Contractor shall not work on both sides of the road simultaneously within the same area.
2. Ingress and egress shall be maintained to all businesses and dwellings on the project.
3. At the end of each workday, the Contractor shall be required to backfill any area adjacent to existing travelway that has been graded leaving no more than a 1" drop-off.
4. A minimum of two-way, two-lane traffic (plus all existing left and right turn lanes) shall be maintained during periods of construction inactivity.
5. The Contractor shall not be allowed to stop traffic for more than 5 minutes at a time in any one direction.
6. During periods of construction inactivity, the difference in elevation between lanes shall not exceed 1-1/2 inch.
7. Access to fire hydrants shall be maintained at all times.
8. During periods of construction inactivity, place cones/drums 3' from existing edge of pavement (travelway) as directed by the Engineer.
9. Channelizing devices in work areas shall be spaced not greater than 50' on center in tangent areas, 45' on center in tapers, and 10' on center in radii, and shall be set 3' off the edge of travelway, unless otherwise indicated on plans.
10. Contractor to install Erosion Control devices as directed by the Engineer.
11. The contractor shall be responsible for the permanent staking of all Proposed Right of Way, Control of Access and Drainage Easements Per NCDOT Division 6 Special Provision in the contract.
12. Contractor shall provide driveway turnouts at all soil or gravel drives as directed by the Engineer.

*****SIGNING WILL BE INCIDENTAL TO THE PROJECT*****
THE CONTRACTOR IS RESPONSIBLE FOR RELOCATING, REMOVING, REPLACING, OR INSTALLING SIGNS AS DIRECTED BY THE ENGINEER. THERE WILL BE NO DIRECT PAY FOR THE RELOCATION, REMOVAL, REPLACEMENT, OR INSTALLATION OF SIGNS.

CONTRACTOR SHALL COORDINATE WITH LOCAL TRAFFIC SERVICES UNIT FOR SIGNS, AND PLACEMENT OF ALL PAVEMENT MARKINGS.


FOR SIGNS AND PAVEMENT MARKINGS, CONTACT TRAFFIC SERVICES 910-364-0606, 14 DAYS PRIOR TO FINAL PLACEMENT.

14-JUN-2017 12:55 PM C:\Users\jgibson\Documents\Projects\W-560\ICC.Rdy-tyr.dgn

Q4-MAY-2017 15:14
S:\Contracts\2017\Standard Drawings\Details in Lieu of Standards\Drawings\Details in Lieu of Standards\862d01 862d03 862d03\862d01.dgn
Jhowerton - R1 CS0-272955

STATE OF
NORTH CAROLINA
DEPT. OF TRANSPORTATION
DIVISION OF HIGHWAYS
RALEIGH, N.C.

ROADWAY DETAIL DRAWING FOR
GUARDRAIL PLACEMENT


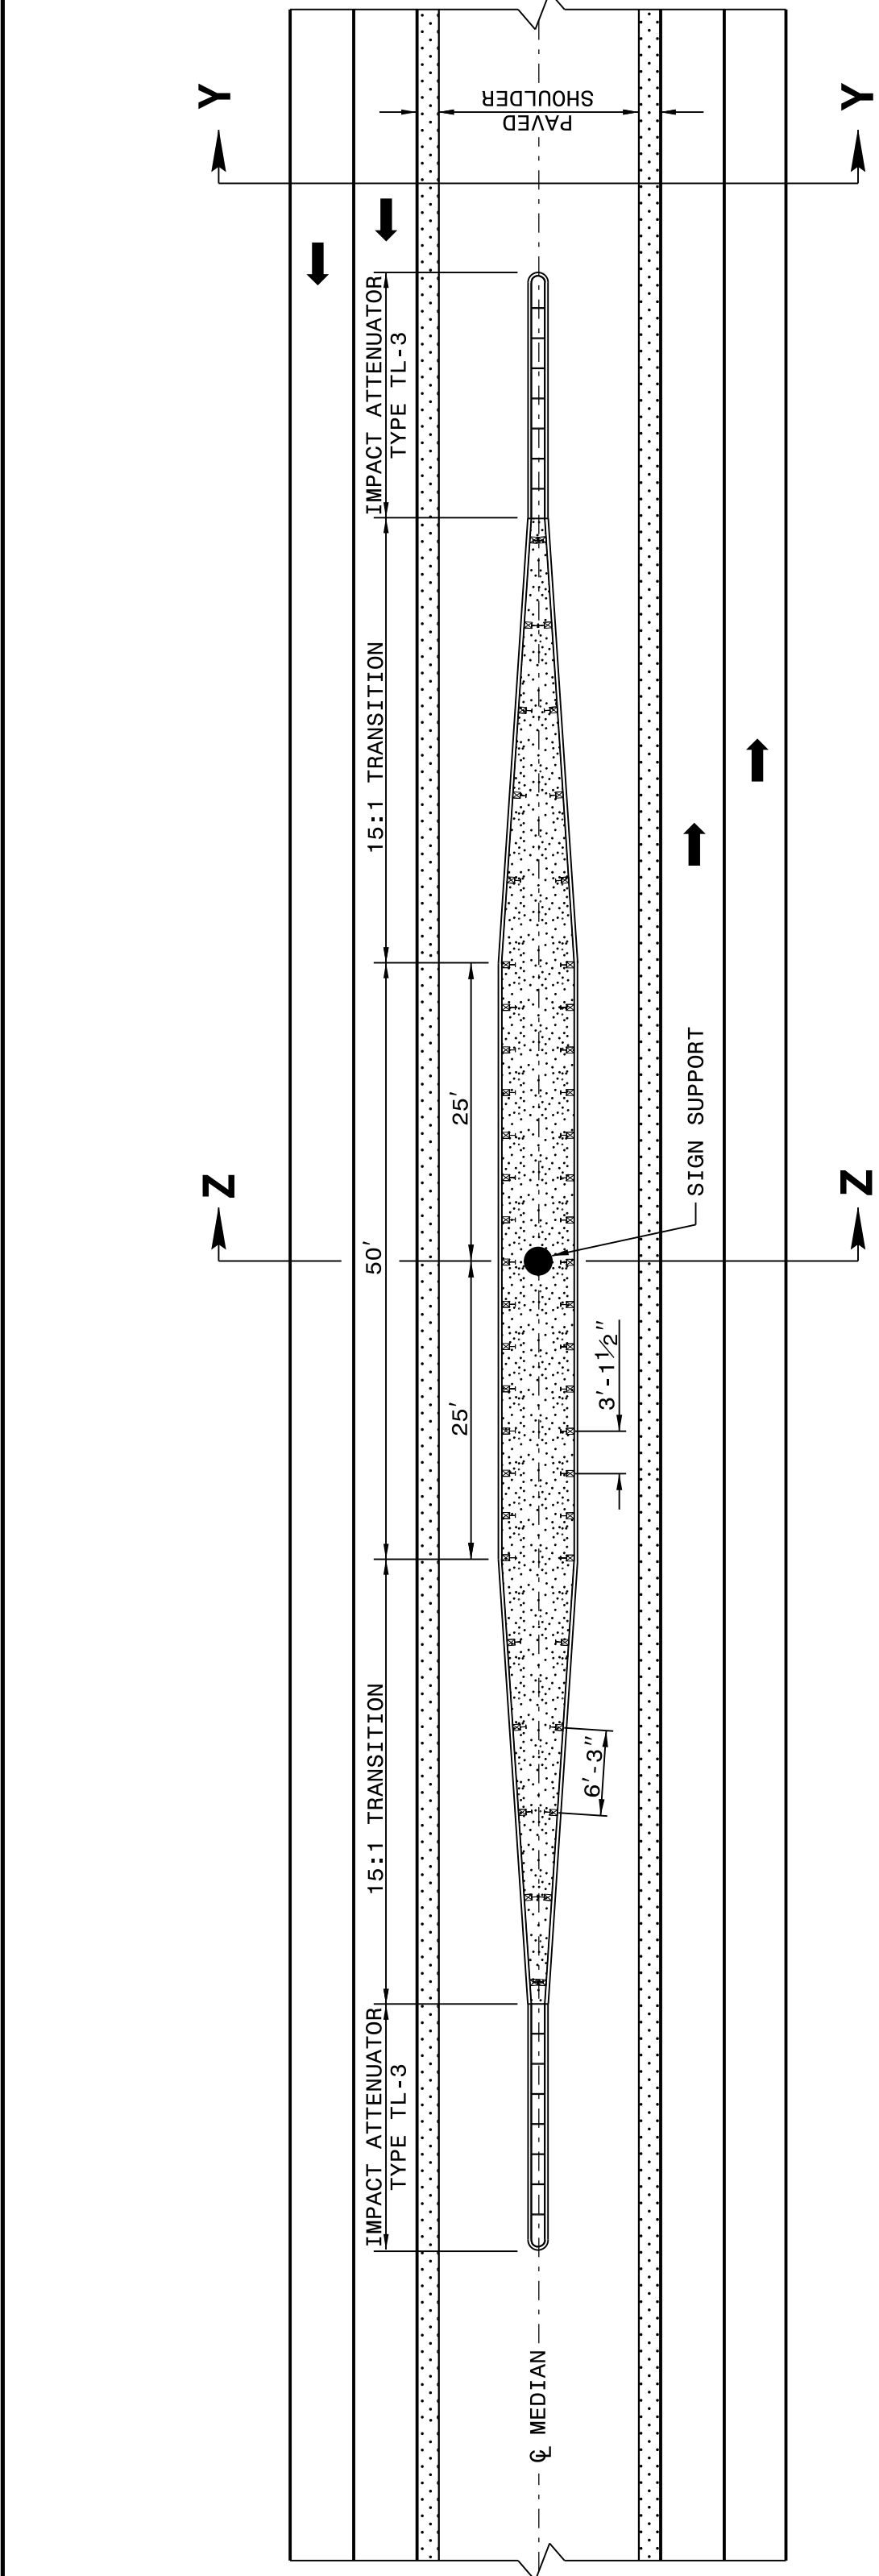


ROADWAY DETAIL DRAWING FOR
GUARDRAIL PLACEMENT

STATE OF
NORTH CAROLINA
DEPT. OF TRANSPORTATION
DIVISION OF HIGHWAYS
RALEIGH, N.C.

NOTE SPECIAL LAYER OF PAVEMENT


USE 3'-1 1/2" POST SPACING ON THE 50' OF GUARDRAIL PARALLEL TO LANES AND 6'-3" POST SPACING ON 15:1 TRANSITION SECTIONS.
GRADE MEDIAN IN THE VICINITY OF THE SIGN SUPPORT AS ILLUSTRATED IN THE ROADWAY STANDARD DRAWINGS (STANDARD 862D01 SHEET 1 OF 12).

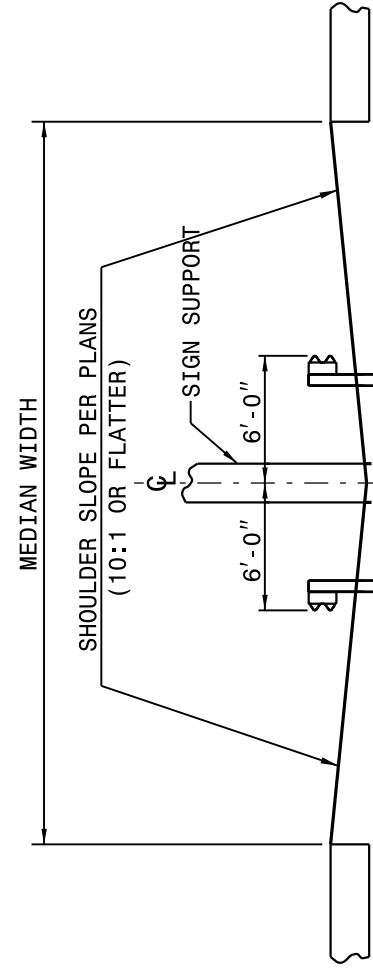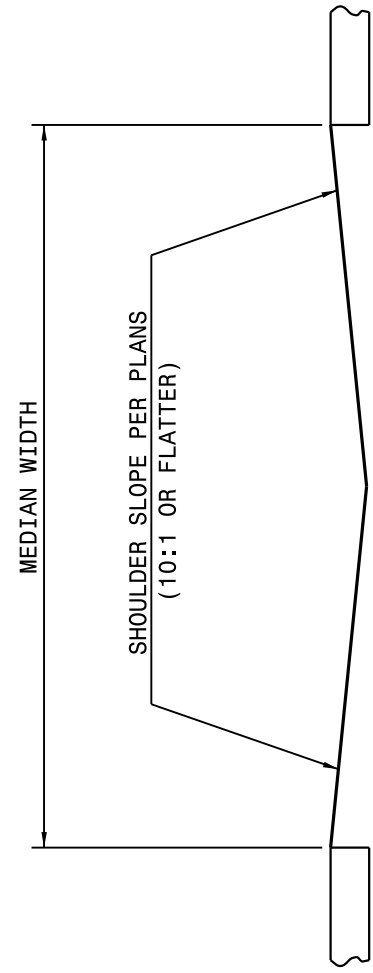

DETAIL OF GUARDRAIL AT MEDIAN SIGN SUPPORT



SHEET 2 OF 11
862D01

STATE OF
NORTH CAROLINA
DEPT. OF TRANSPORTATION
DIVISION OF HIGHWAYS
RALEIGH, N.C.

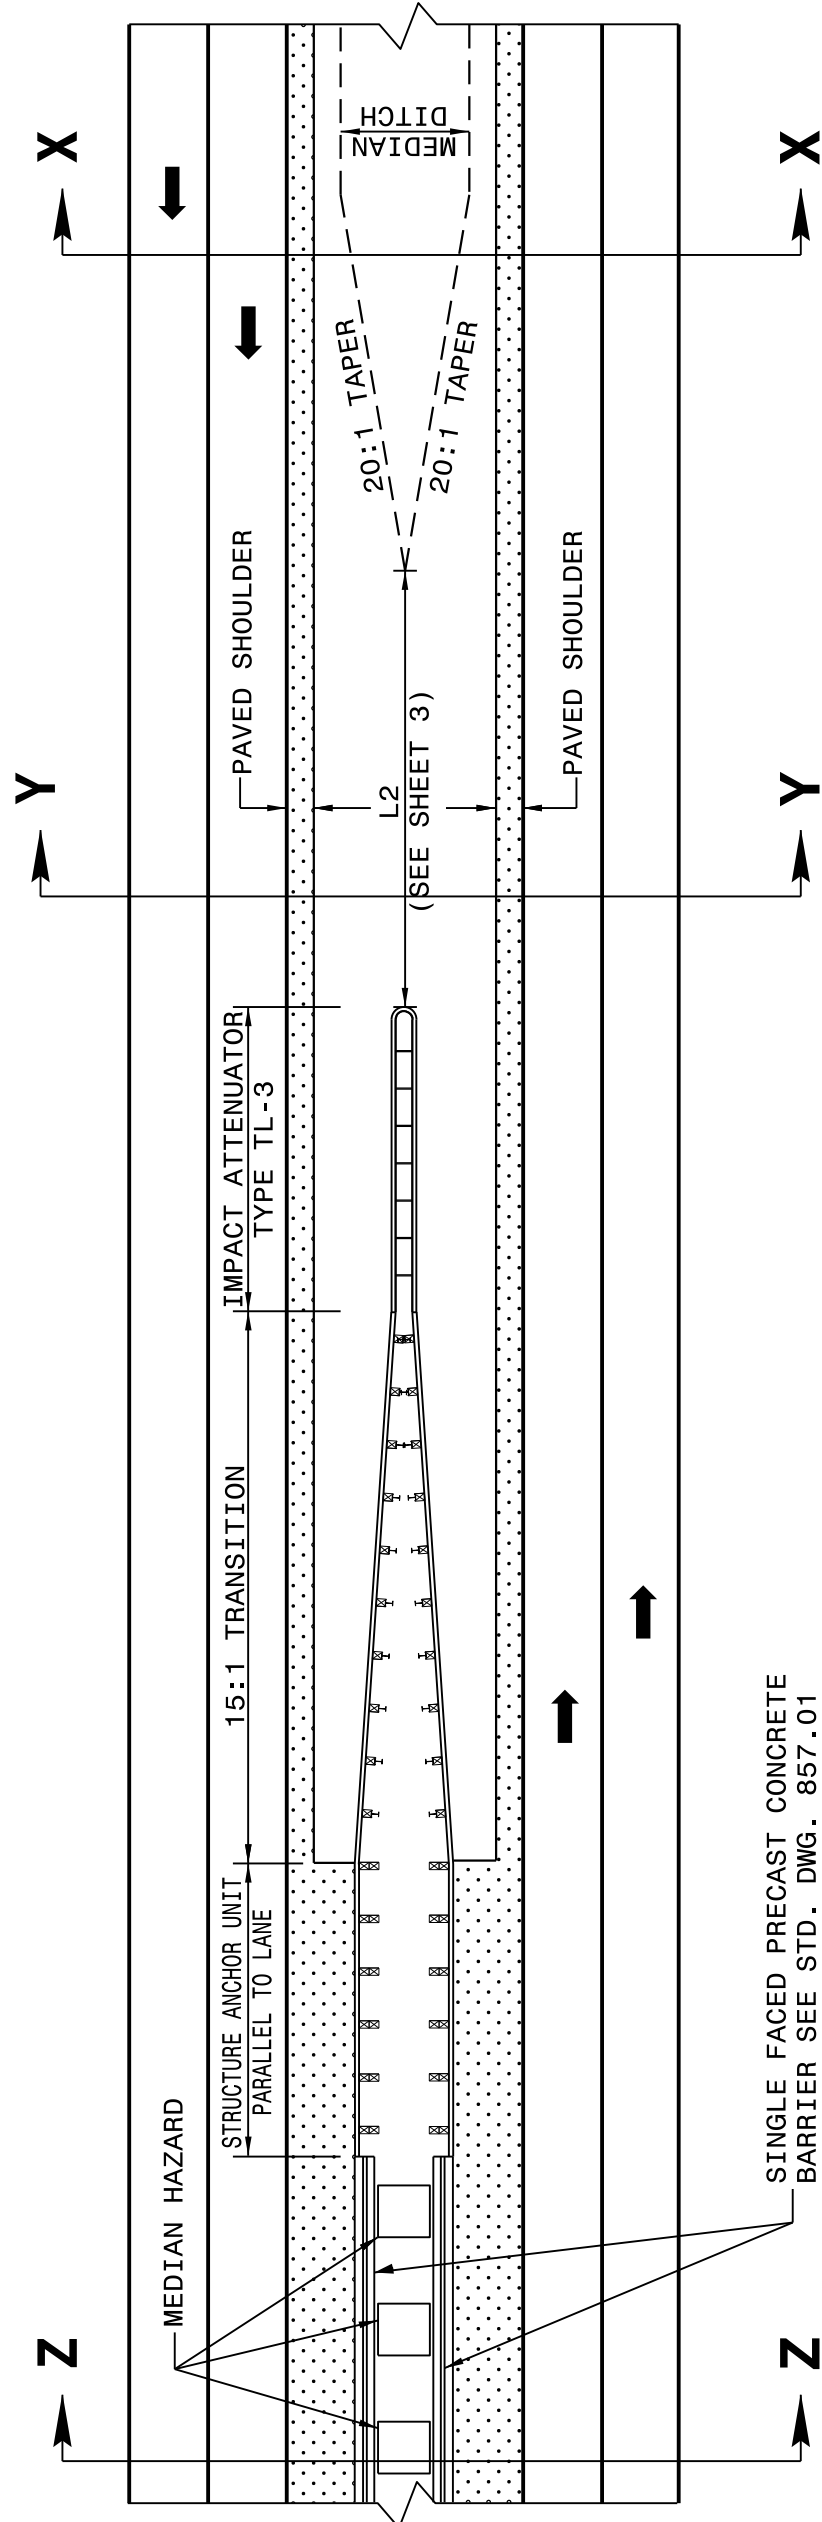

STATE OF
NORTH CAROLINA
DEPT. OF TRANSPORTATION
DIVISION OF HIGHWAYS
RALEIGH, N.C.

ROADWAY DETAIL DRAWING FOR
GUARDRAIL PLACEMENT

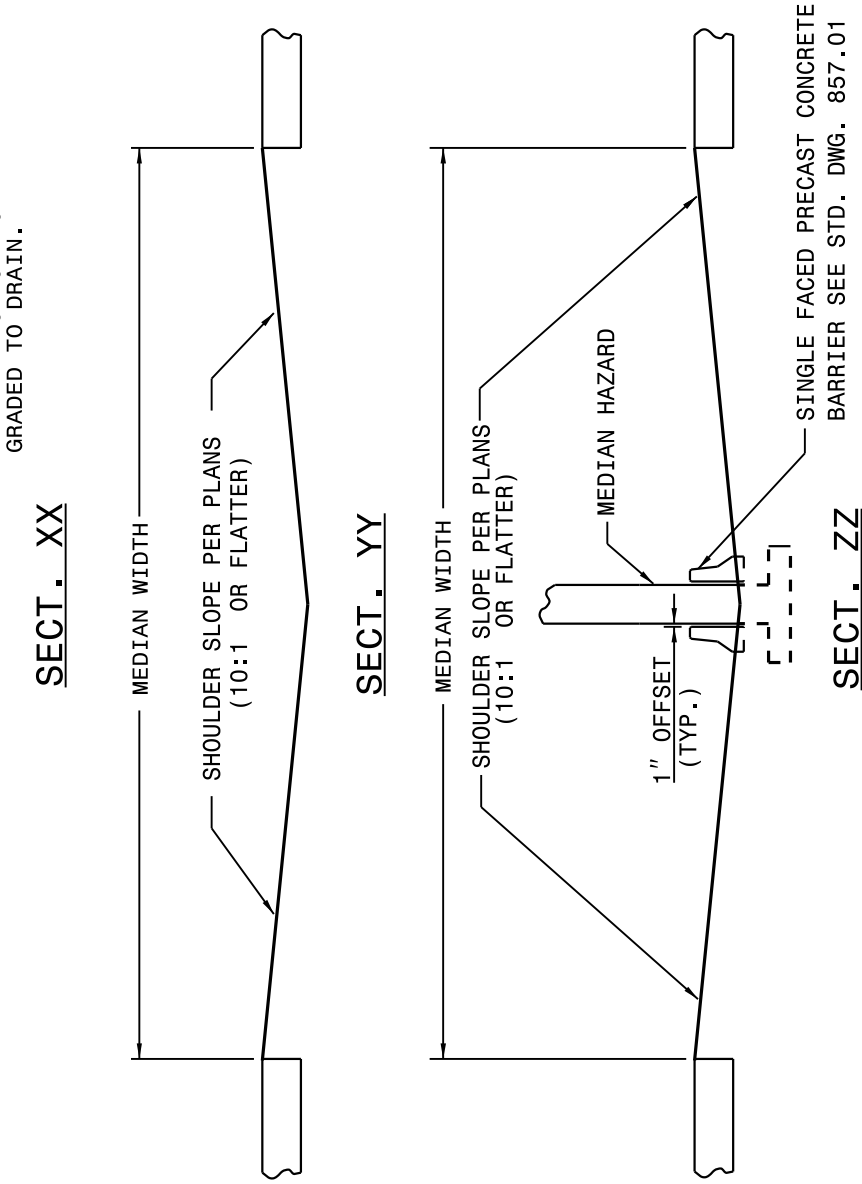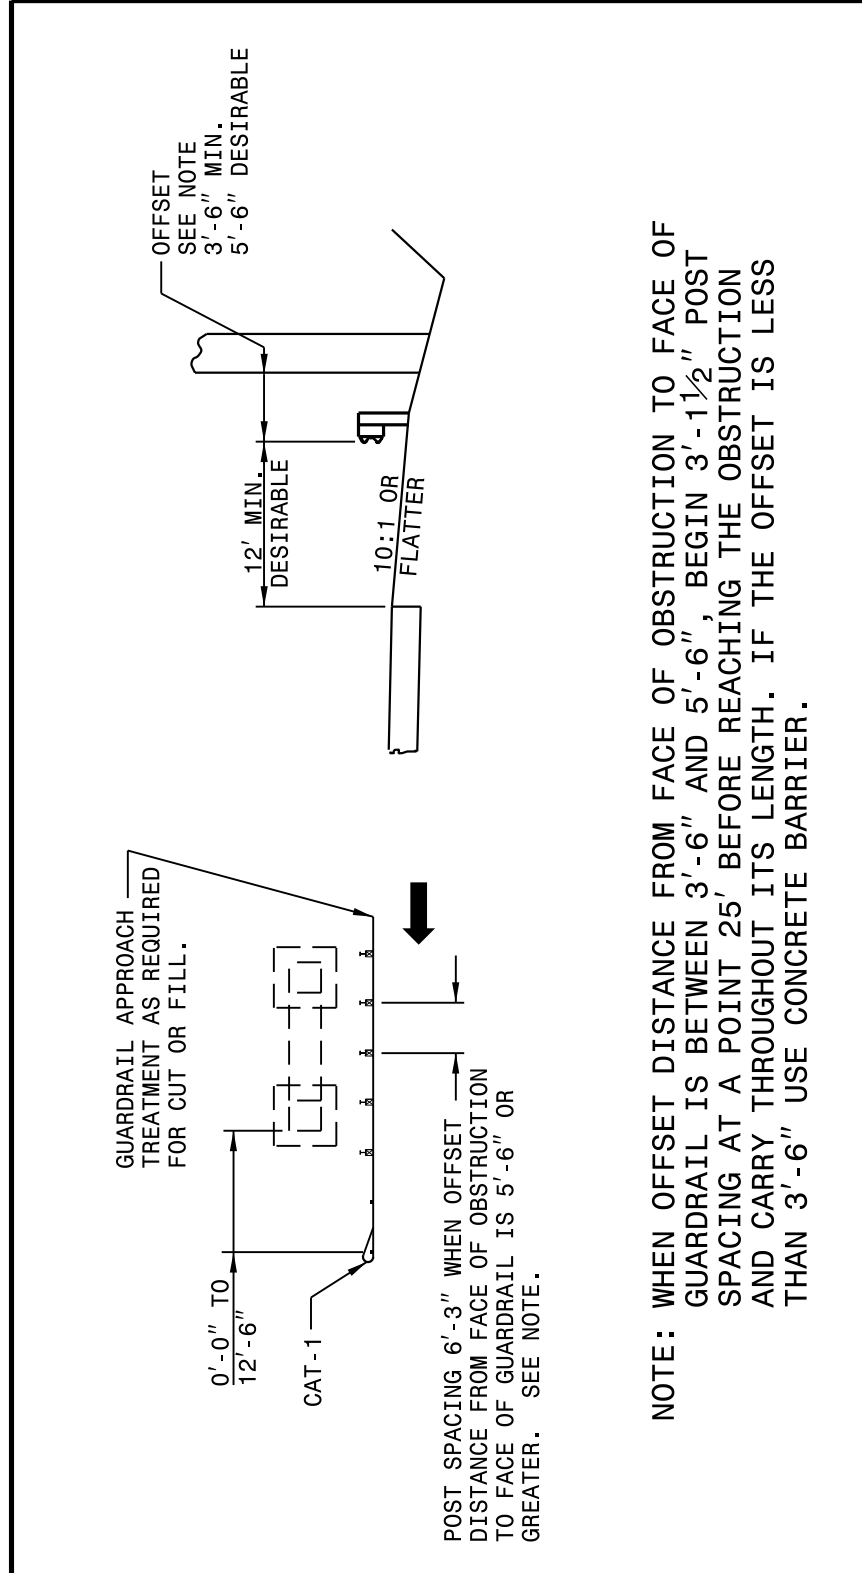

DETAIL OF RIGHT SIDE GUARDRAIL AT UNDERPASS

SHEET 1 OF 11
862D01

DETAIL OF MEDIAN TREATMENT AT UNDERPASS

SHEET 1 OF 11
862D01

CONTRACT STANDARDS
AND DEVELOPMENT UNIT
Office 919-707-6950 FAX 919-250-4119

SEE TITLE BLOCK

ORIGINAL BY: J HOWERTON DATE: 06-22-12
MODIFIED BY: DATE:
CHECKED BY: DATE:
FILE SPEC.:

DOCUMENT NOT CONSIDERED FINAL
UNLESS ALL SIGNATURES COMPLETED

DocuSigned by:
Jael S. Howerton, P.E.
073F3D17DCC045F
NORTH CAROLINA
PROFESSIONAL
SEAL
022966
ENGINEER
Jael S. Howerton
6/14/2017

94 MAY-2017 1514
C:\projects\Special Details\Howerton\Standard Drawings\Details in Lieu of Standards\Division 8\862d01 862d03 862d01.dgn
Howerton
CS0-292595

STATE OF
NORTH CAROLINA
DEPT. OF TRANSPORTATION
DIVISION OF HIGHWAYS
RALEIGH, N.C.


ROADWAY DETAIL DRAWING FOR
GUARDRAIL PLACEMENT

SHEET 4 OF 11
862D01

STATE OF
NORTH CAROLINA
DEPT. OF TRANSPORTATION
DIVISION OF HIGHWAYS
RALEIGH, N.C.

ROADWAY DETAIL DRAWING FOR
GUARDRAIL PLACEMENT

SHEET 4 OF 11
862D01

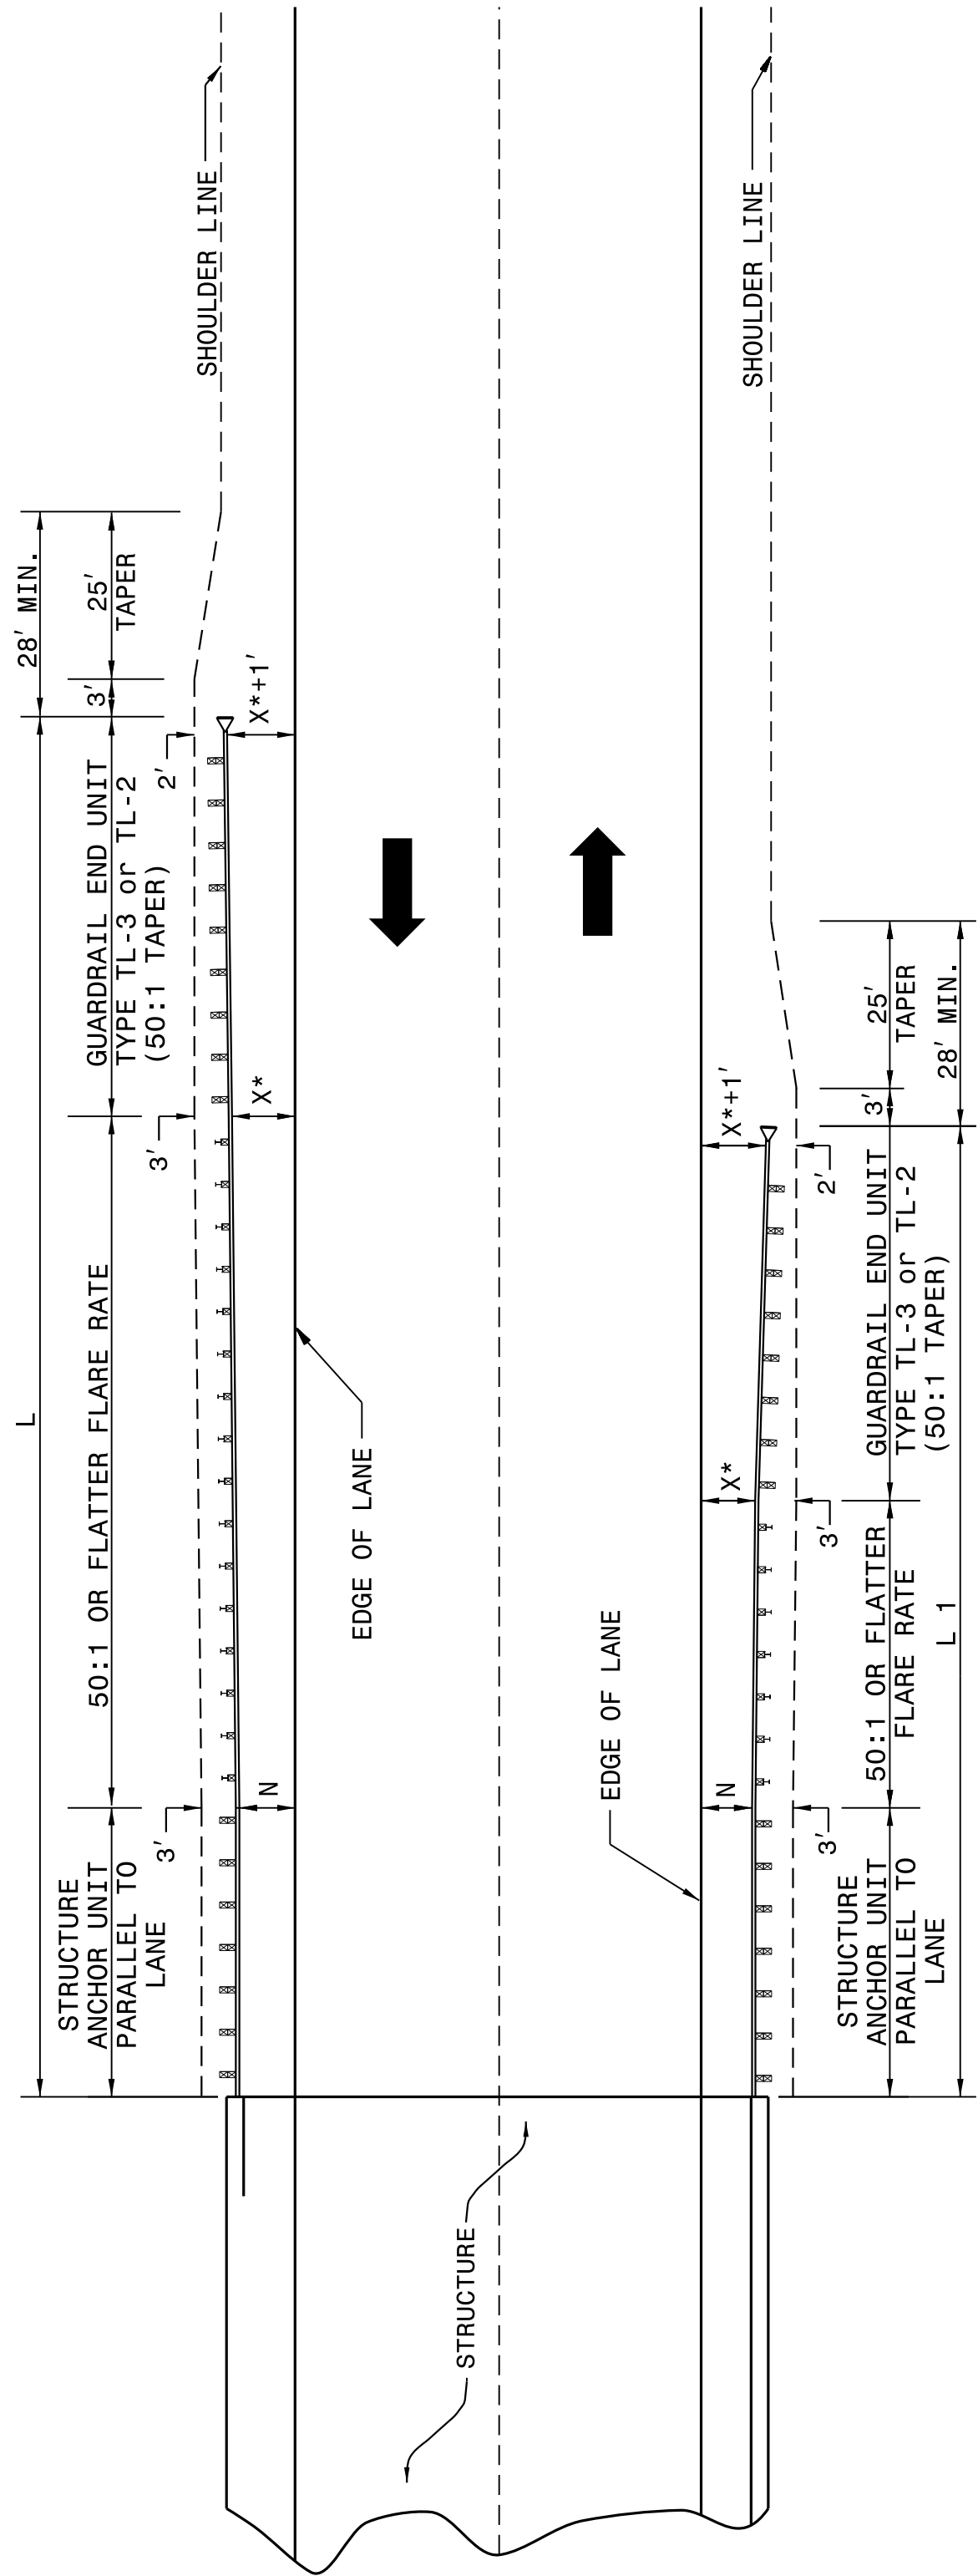

* USE FLARE RATE AS THE CONTROL IF THE "X" DISTANCE IS NOT OBTAINED.
("X" IS BASED ON SHOULDER WIDTHS IN THE HIGHWAY DESIGN BRANCH
MANUAL, PART 1, 1-4B, F1).

"N"= DISTANCE FROM EDGE OF LANE TO FACE OF GUARDRAIL WHERE GUARDRAIL IS
PARALLEL TO LANE.

SEE STD. 862.03 FOR STRUCTURE ANCHOR UNITS

FOR POSTED SPEEDS ≥ 45mph USE GREU TYPE TL-3

FOR POSTED SPEEDS < 45mph USE GREU TYPE TL-2

GUARDRAIL INSTALLATION AT BRIDGE APPROACHES FOR TWO-LANE, TWO-WAY TRAFFIC									
DESIGN SPEED (MPH)	"L" APPROACH LENGTH (FT.)		"L1" TRAILING LENGTH (FT.)						
	DESIGN YEAR ADT	CURRENT YEAR ADT	DESIGN YEAR ADT	CURRENT YEAR ADT	DESIGN YEAR ADT	CURRENT YEAR ADT	DESIGN YEAR ADT	CURRENT YEAR ADT	DESIGN YEAR ADT
70	OVER 2000	1001-2000	400	UNDER 400	OVER 2000	1001-2000	400	UNDER 400	OVER 2000
60	362.5'	362.5'	350.0'	287.5'	187.5'	187.5'	137.5'	100.0'	75.0'
50	300.0'	287.5'	275.0'	225.0'	137.5'	137.5'	100.0'	75.0'	75.0'
40	212.5'	212.5'	200.0'	162.5'	87.5'	87.5'	75.0'	75.0'	75.0'
	175.0'	150.0'	137.5'	112.5'	75.0'	75.0'	75.0'	75.0'	75.0'
X *	8'	6'	4'	4'	8'	6'	4'	4'	4'

LENGTHS AND OFFSETS FOR PROPOSED GUARDRAIL AT TWO LANE - TWO WAY LOCATIONS

STATE OF
NORTH CAROLINA
DEPT. OF TRANSPORTATION
DIVISION OF HIGHWAYS
RALEIGH, N.C.


ROADWAY DETAIL DRAWING FOR
GUARDRAIL PLACEMENT

SHEET 3 OF 11
862D01

STATE OF
NORTH CAROLINA
DEPT. OF TRANSPORTATION
DIVISION OF HIGHWAYS
RALEIGH, N.C.

ROADWAY DETAIL DRAWING FOR
GUARDRAIL PLACEMENT

SHEET 3 OF 11
862D01

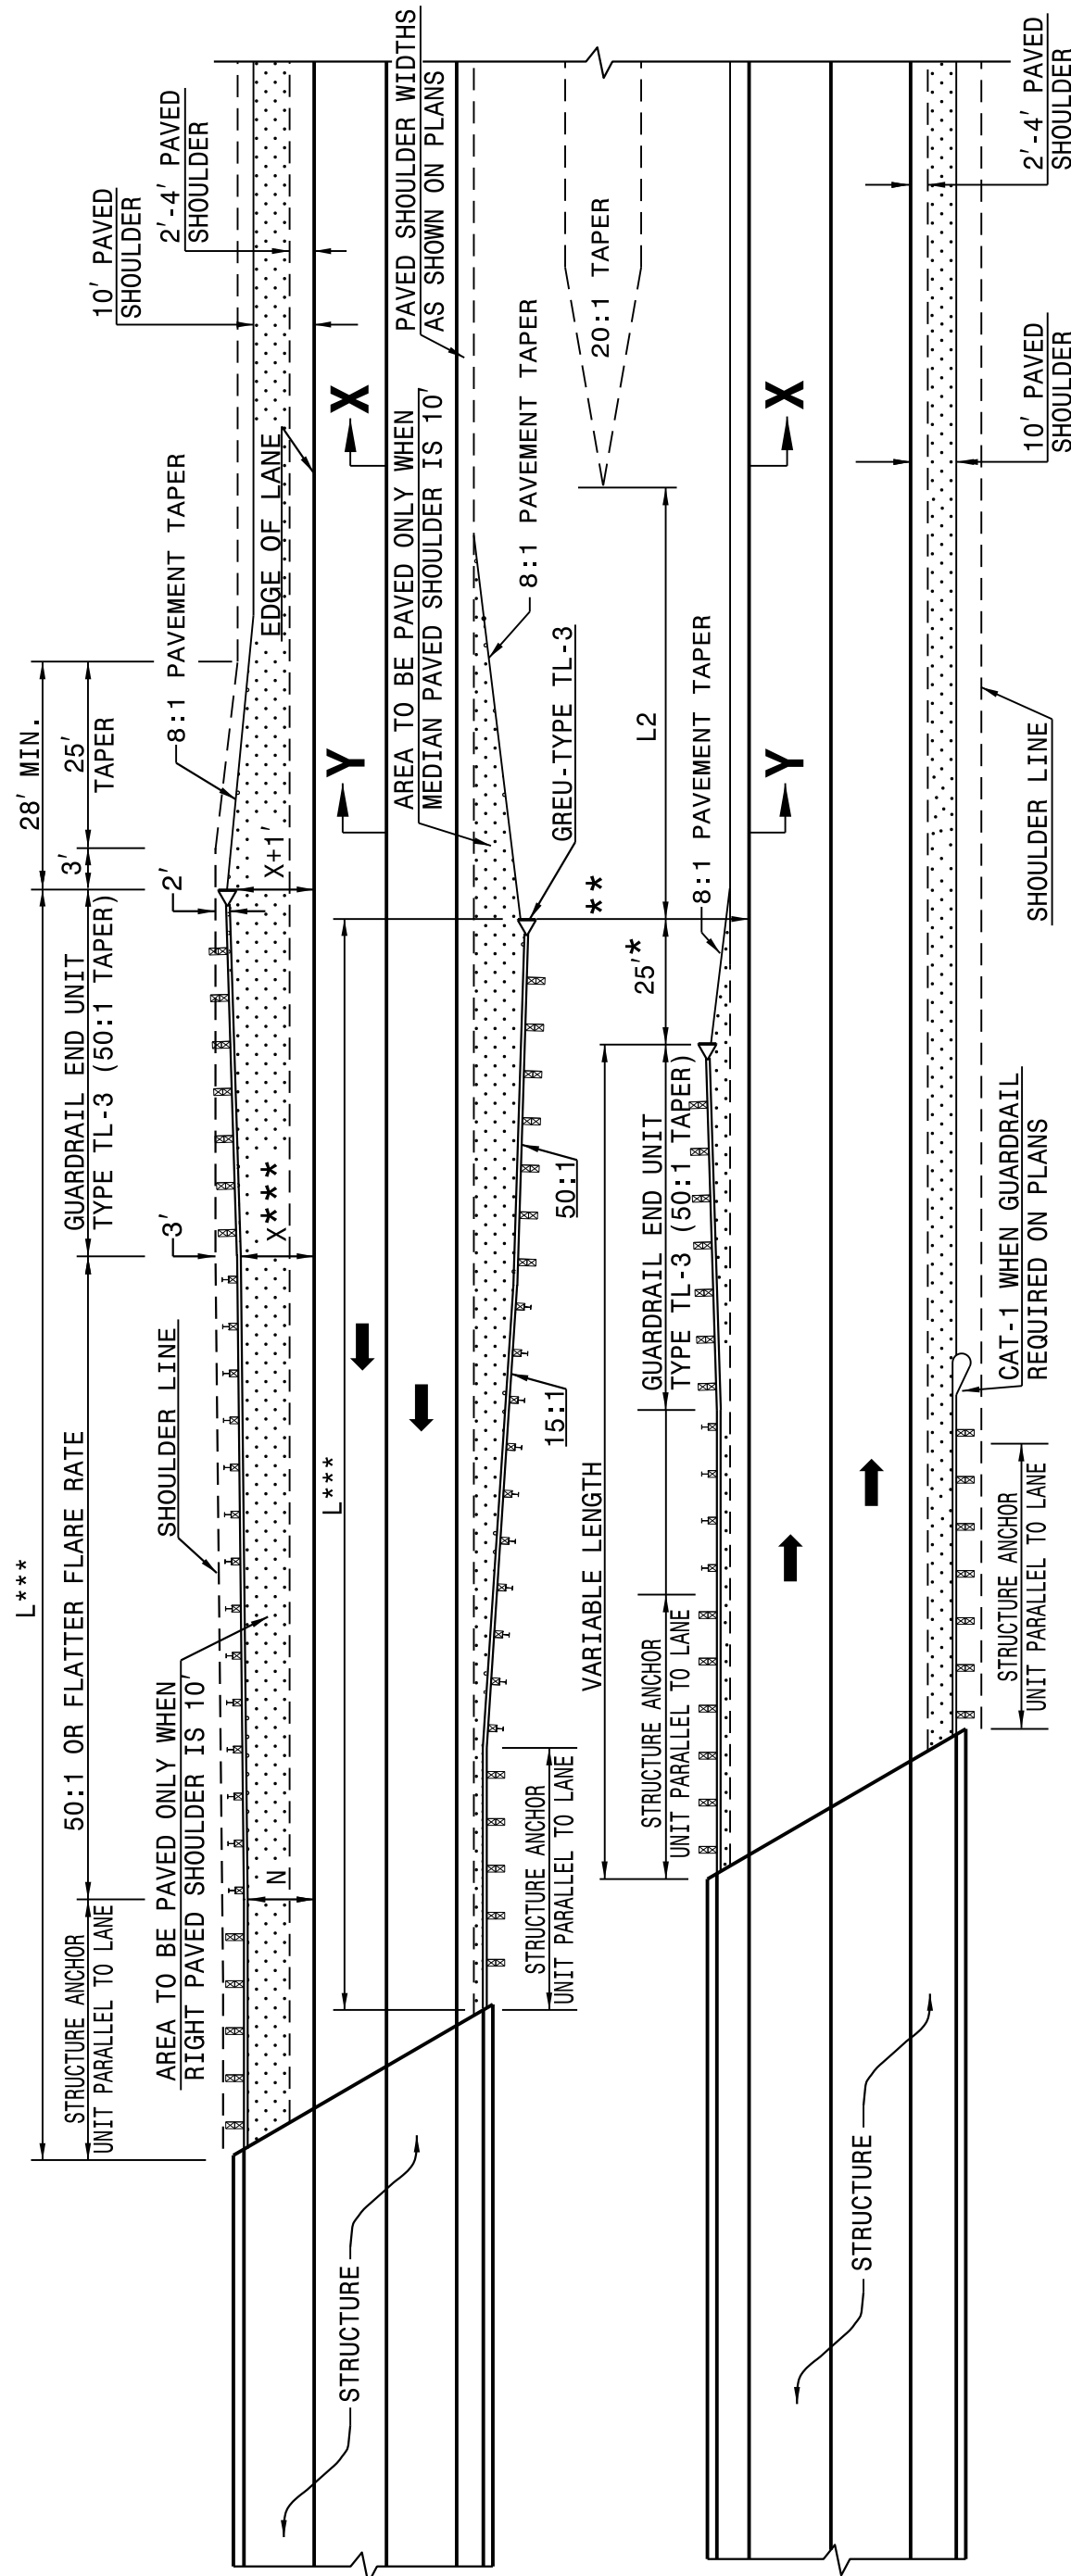

FOR POSTED SPEEDS ≥ 45mph USE GREU TYPE TL-3
FOR POSTED SPEEDS < 45mph USE GREU TYPE TL-2

DIMENSIONS FOR LENGTH OF GUARDRAIL APPROACHING DUAL LANE BRIDGES				
MEDIAN WIDTH	-L-***		-L2- DIM.	
	70 MPH	60 MPH	50 MPH	
30'	300.0'	250.0'	150.0'	80.0'
36'	300.0'	250.0'	150.0'	60.0'
40' & ABOVE	300.0'	250.0'	150.0'	40.0'

NOTES: * MINOR VARIATION TO THE 25'-0" DIMENSION IS PERMISSIBLE TO ACCOMMODATE THE 12'-6" IN
GUARDRAIL LENGTHS.

** NO GUARDRAIL IS REQUIRED ON THE TRAILING END WHEN THIS DISTANCE EXCEEDS CLEAR ROADSIDE
RECOVERY AREA FOR THE APPROPRIATE DESIGN SPEED.

*** BASED ON "X" OF 12'

USE FLARE RATE AS THE CONTROL IF THE "X" DISTANCE IS NOT OBTAINED. ("X" IS BASED ON
SHOULDER WIDTHS IN THE HIGHWAY DESIGN BRANCH MANUAL, PART 1, 1-4B, F1A).

"N"= DISTANCE FROM EDGE OF LANE TO FACE OF GUARDRAIL WHERE GUARDRAIL IS PARALLEL TO LANE.
THE DESIGN LAYOUT FOR LENGTHS SHOWN ON THIS STANDARD ARE MINIMUM DESIGN LENGTHS.

SEE SHEET 1 OF 12 FOR SECTIONS XX, YY

SEE STD. 862.03 FOR STRUCTURE ANCHOR UNITS

DETAIL OF GUARDRAIL APPROACHING DUAL LANE BRIDGES

CONTRACT STANDARDS
AND DEVELOPMENT UNIT
Office 919-707-6950 FAX 919-250-4119

SEE TITLE BLOCK

ORIGINAL BY: J. HOWERTON DATE: 06-22-12
MODIFIED BY: DATE:
CHECKED BY: DATE:
FILE SPEC.: DATE:

DOCUMENT NOT CONSIDERED FINAL
UNLESS ALL SIGNATURES COMPLETED


DocuSigned by:
Jael S. Howerton, P.E.
873F3D1770
NORTH CAROLINA
PROFESSIONAL
SEAL
022966
ENGINEER
Jael S. Howerton
6/14/2017

84-MAY-2017 15:15 C:\projects\Standard Drawings\Standard Drawings\Details in Lieu of Standards\Drawings\Details in Lieu of Standards\862d01.dgn
JHOWERTON A1 CS0-292595


STATE OF
NORTH CAROLINA
DEPT. OF TRANSPORTATION
DIVISION OF HIGHWAYS
RALEIGH, N.C.

ROADWAY DETAIL DRAWING FOR
GUARDRAIL PLACEMENT

SHEET 6 OF 11
862D01

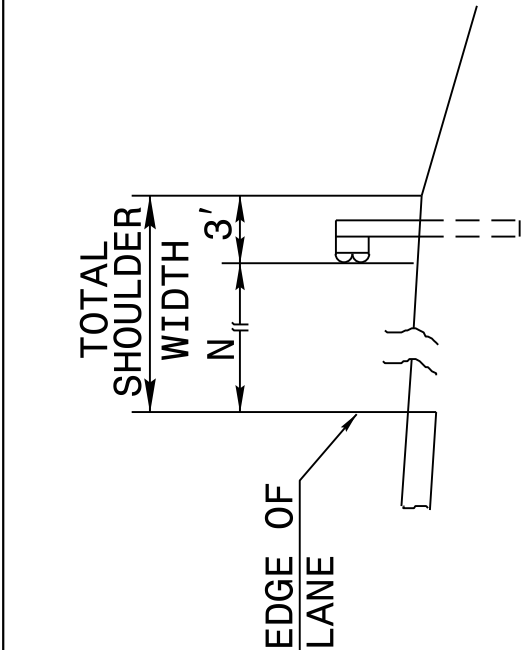


FILL SECTION

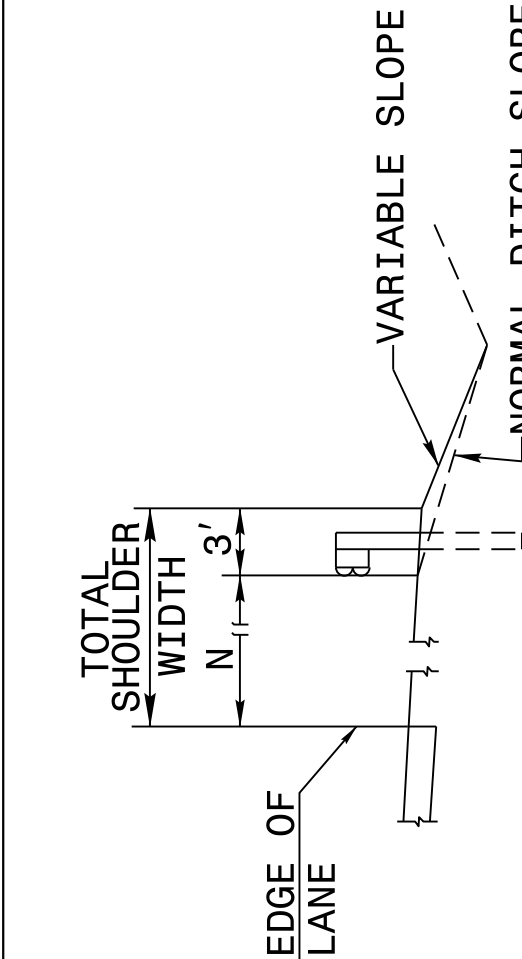

CUT SECTION

"N" = DISTANCE FROM EDGE OF LANE TO FACE OF GUARDRAIL WHERE GUARDRAIL IS PARALLEL TO LANE.

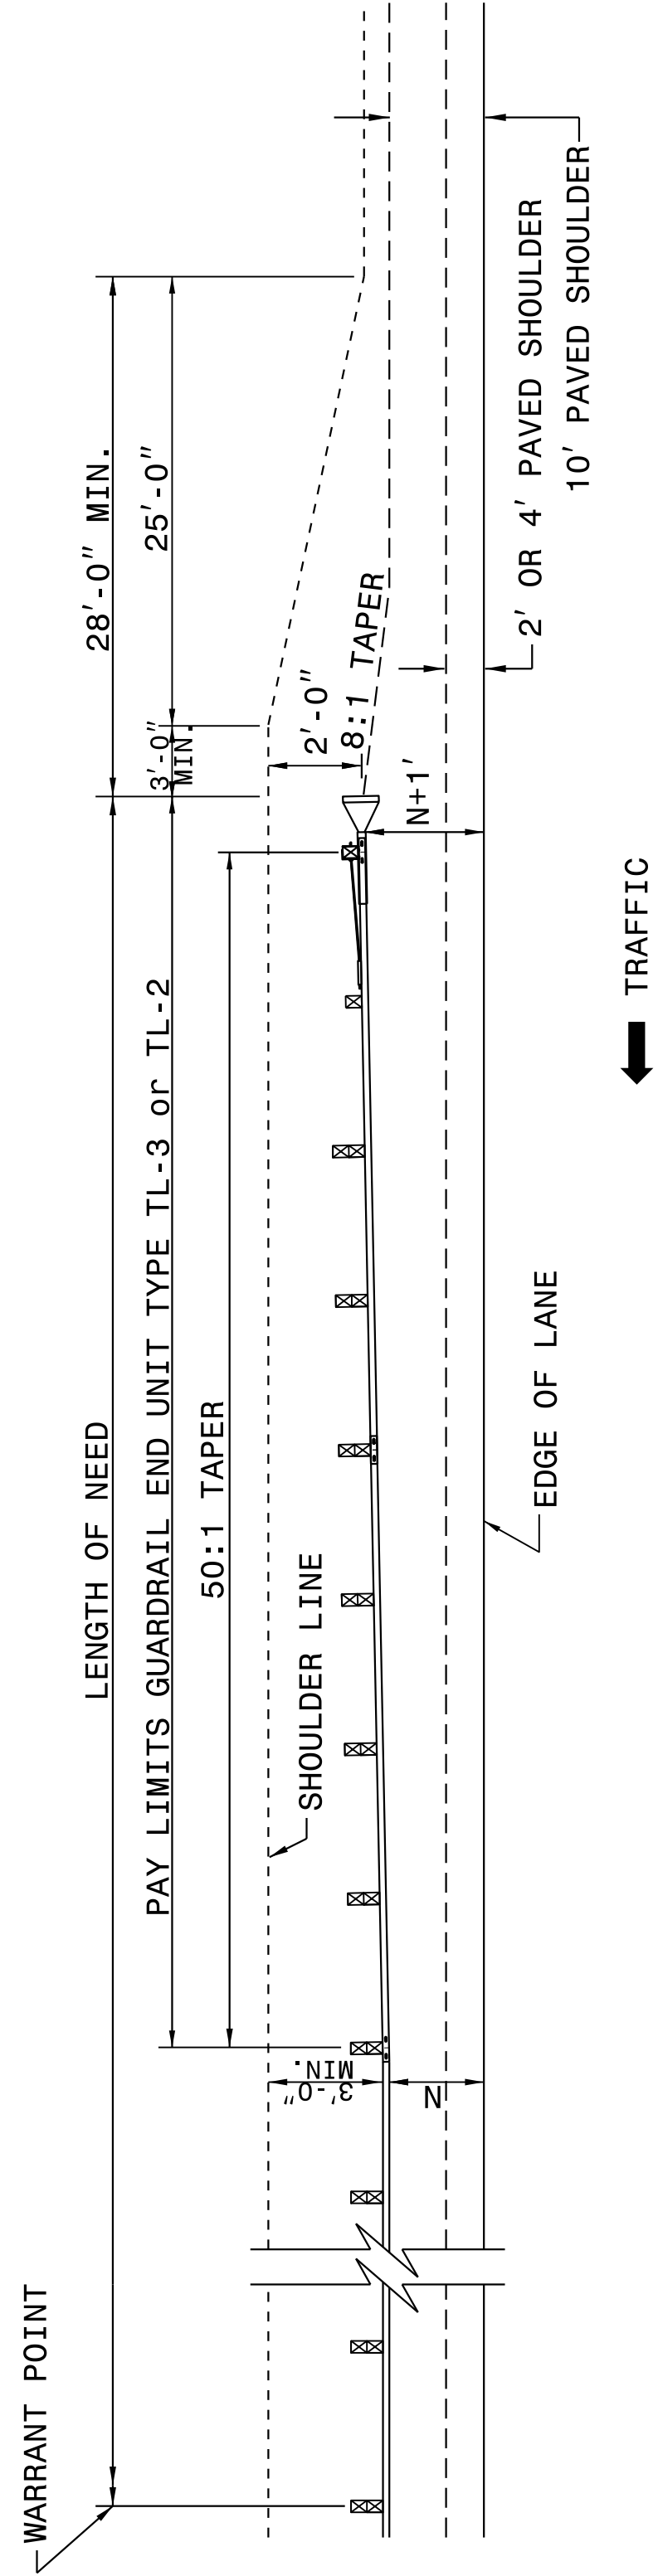

FOR POSTED SPEEDS $\geq$ 45mph USE GREU TYPE TL-3
FOR POSTED SPEEDS $<$ 45mph USE GREU TYPE TL-2

DETAIL OF BEGINNING OF GUARDRAIL IN CUT OR FILL SECTION

STATE OF
NORTH CAROLINA
DEPT. OF TRANSPORTATION
DIVISION OF HIGHWAYS
RALEIGH, N.C.


ROADWAY DETAIL DRAWING FOR
GUARDRAIL PLACEMENT

SHEET 6 OF 11
862D01

STATE OF
NORTH CAROLINA
DEPT. OF TRANSPORTATION
DIVISION OF HIGHWAYS
RALEIGH, N.C.

ROADWAY DETAIL DRAWING FOR
GUARDRAIL PLACEMENT

SHEET 5 OF 11
862D01

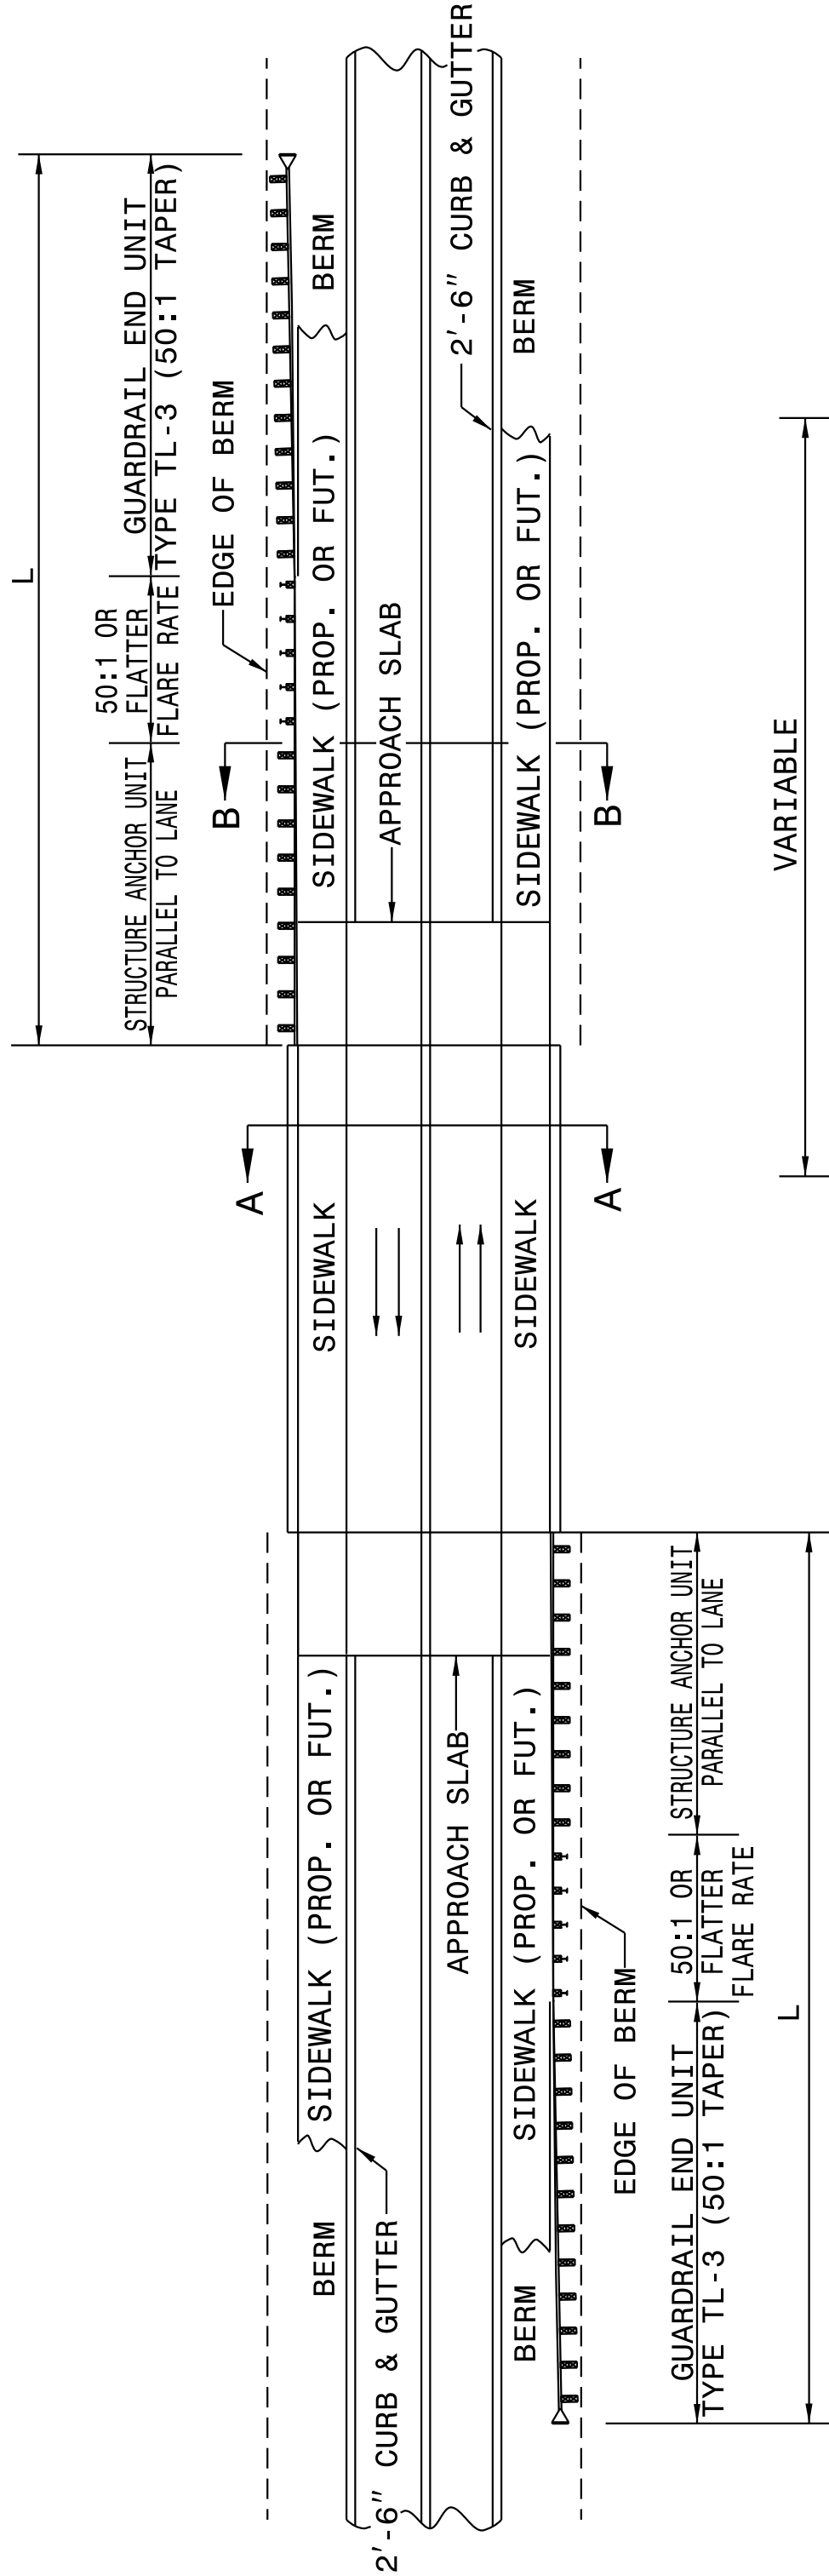

MINIMUM GUARDRAIL LENGTHS "L" REQUIRED AT
BRIDGE APPROACHES ON 2'-6" CONCRETE CURB
AND GUTTER ROADWAYS

DESIGN SPEED (MPH)	"L"
40	150'
50	225'


NOTE: "L" VALUES ARE BASED ON NO HAZARDS
OTHER THAN END OF BRIDGE BEING
PRESENT WITHIN THE CLEAR ZONE.

SEE STD. 862D03 FOR STRUCTURE ANCHOR UNITS.

FOR POSTED SPEEDS $\geq$ 45mph USE GREU TYPE TL-3
FOR POSTED SPEEDS $<$ 45mph USE GREU TYPE TL-2

SECTION A-A

SECTION B-B

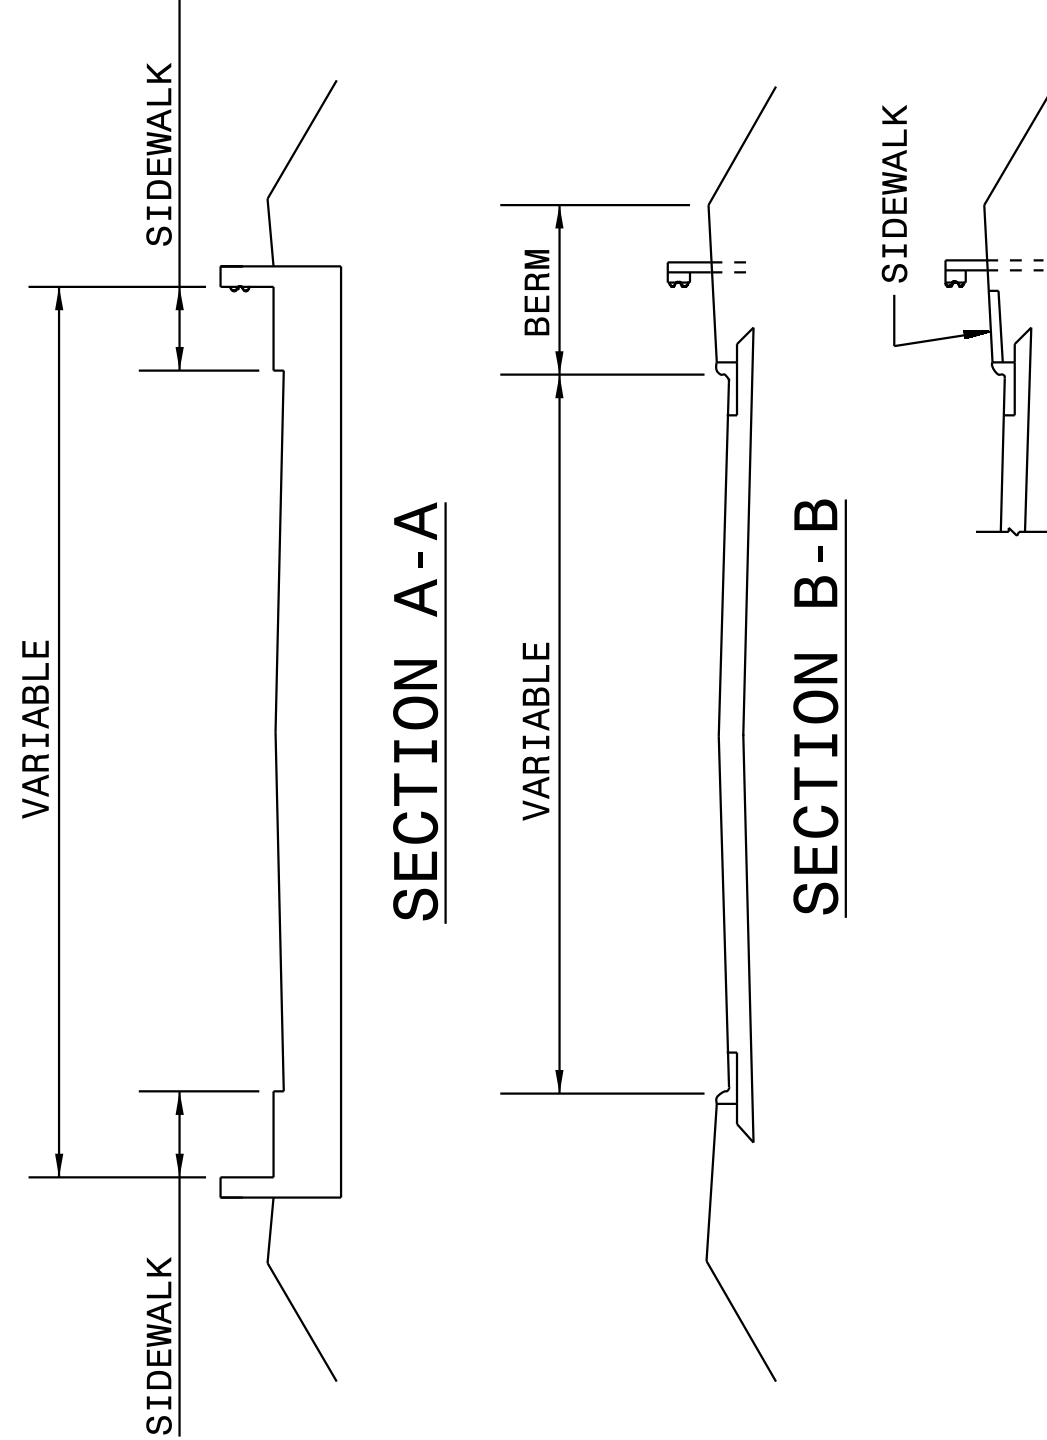

STANDARD GUARDRAIL PLACEMENT AT BRIDGES WITH 2'-6" CONCRETE CURB AND GUTTER

STATE OF
NORTH CAROLINA
DEPT. OF TRANSPORTATION
DIVISION OF HIGHWAYS
RALEIGH, N.C.

ROADWAY DETAIL DRAWING FOR
GUARDRAIL PLACEMENT


SHEET 5 OF 11
862D01

ORIGINAL BY: J. HOWERTON DATE: 06-22-12
MODIFIED BY: DATE:
CHECKED BY: DATE:
FILE SPEC.: DATE:

CONTRACT STANDARDS
AND DEVELOPMENT UNIT
Office 919-707-6950 FAX 919-250-4119

SEE TITLE BLOCK

DOCUMENT NOT CONSIDERED FINAL
UNLESS ALL SIGNATURES COMPLETED

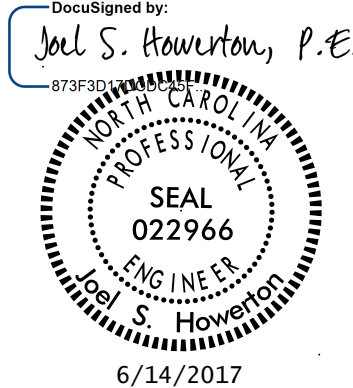


Q:\MAY-2017\546 Projects\Special Details\Jhowerton\Standard Drawings\Details in Lieu of Standards\Division 8\662d01 862d03 862d03\862d01.dgn
Jhowerton AT CSD-26266g

STATE OF
NORTH CAROLINA
DEPT. OF TRANSPORTATION
DIVISION OF HIGHWAYS
RALEIGH, N.C.

ROADWAY DETAIL DRAWING FOR
GUARDRAIL PLACEMENT

SHEET 8 OF 11
862D01

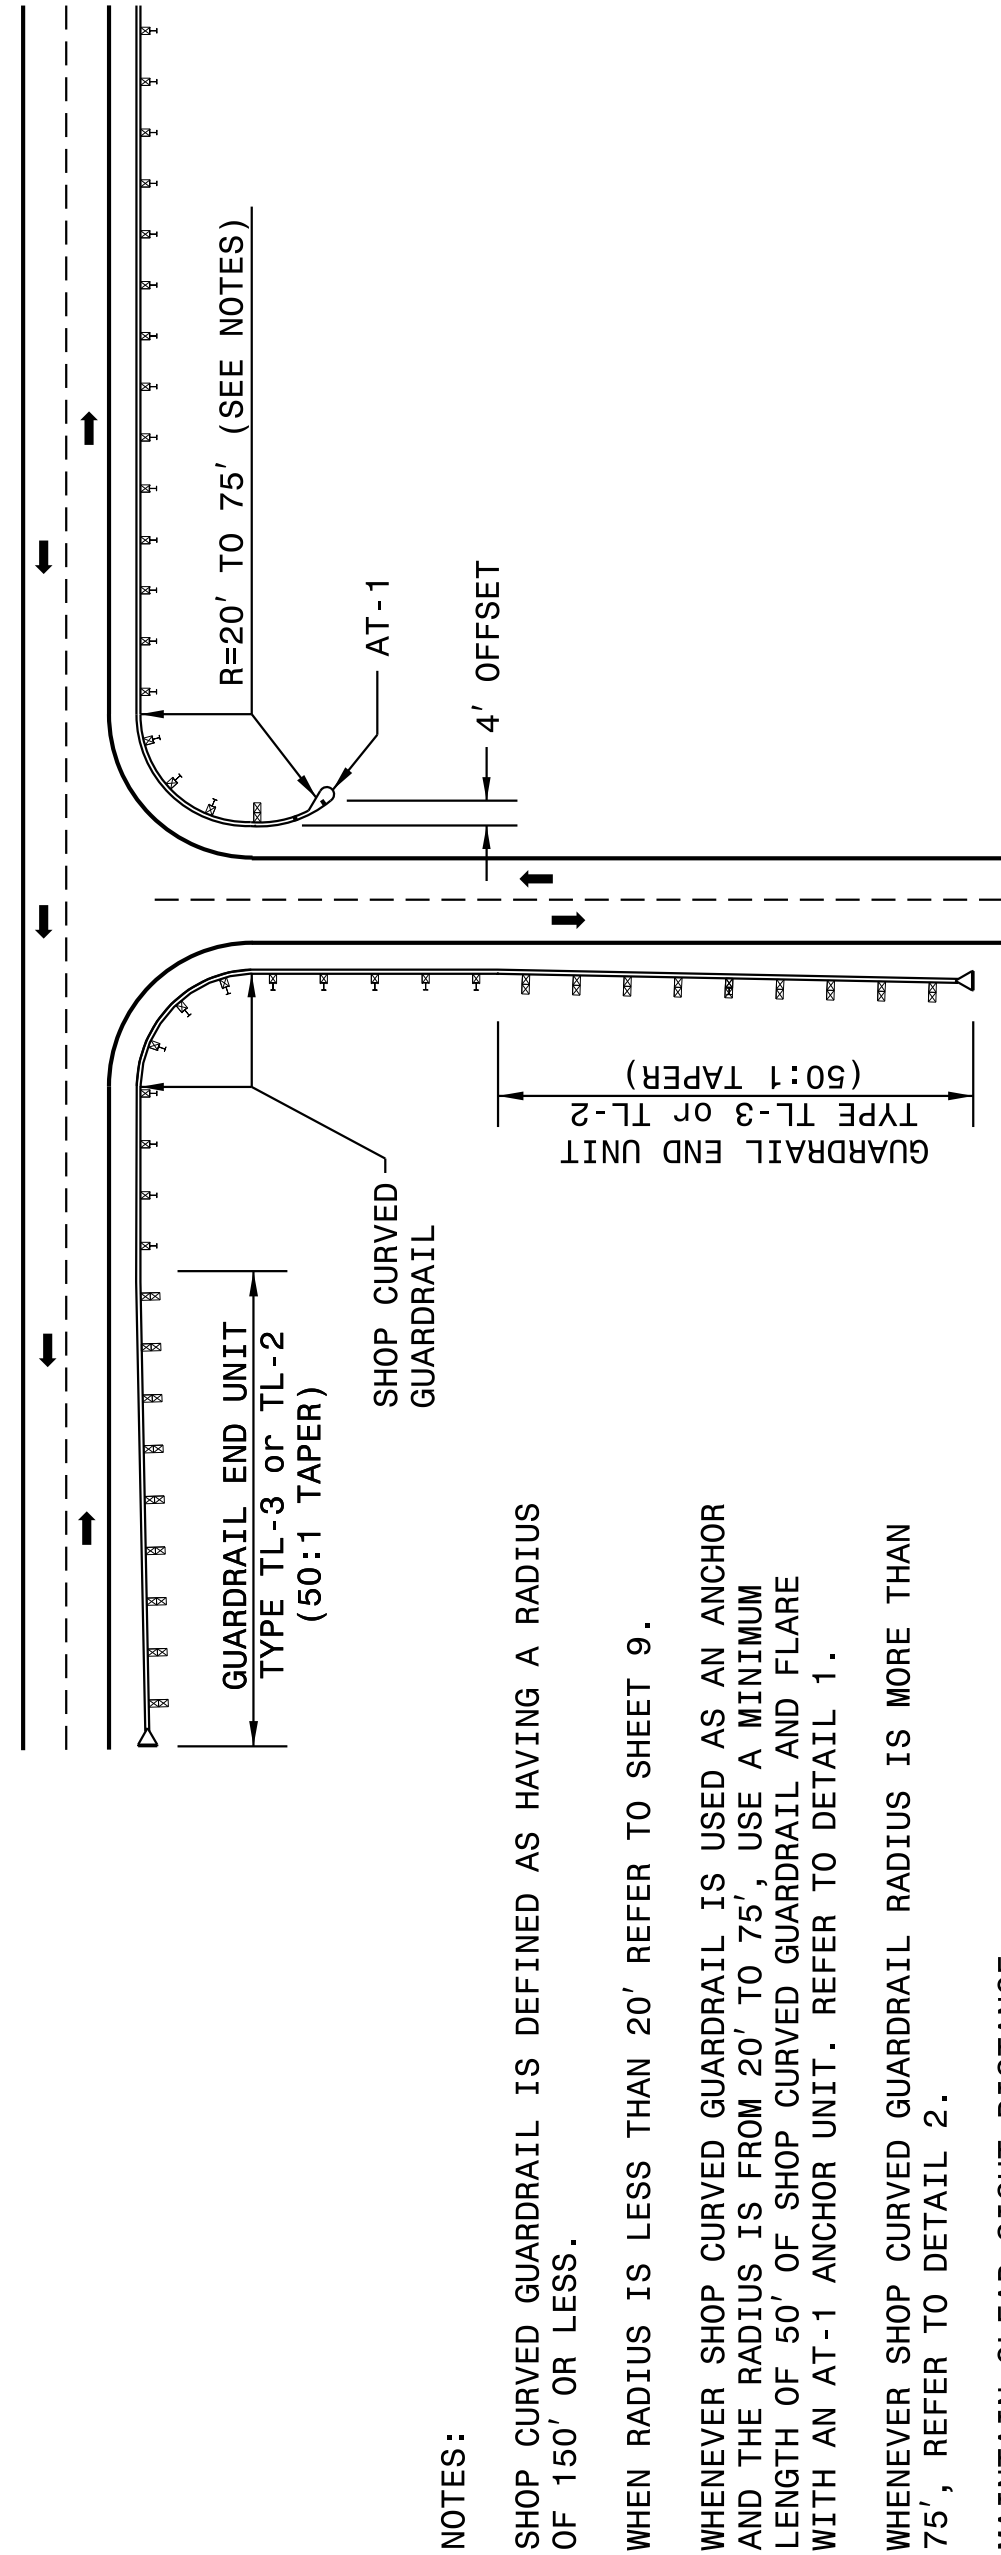

DETAIL - 1

ROADWAY DETAIL DRAWING FOR
GUARDRAIL PLACEMENT

SHEET 8 OF 11
862D01


DETAIL - 2

GUARDRAIL TREATMENT AT INTERSECTIONS

STATE OF
NORTH CAROLINA
DEPT. OF TRANSPORTATION
DIVISION OF HIGHWAYS
RALEIGH, N.C.

ROADWAY DETAIL DRAWING FOR
GUARDRAIL PLACEMENT

SHEET 7 OF 11
862D01

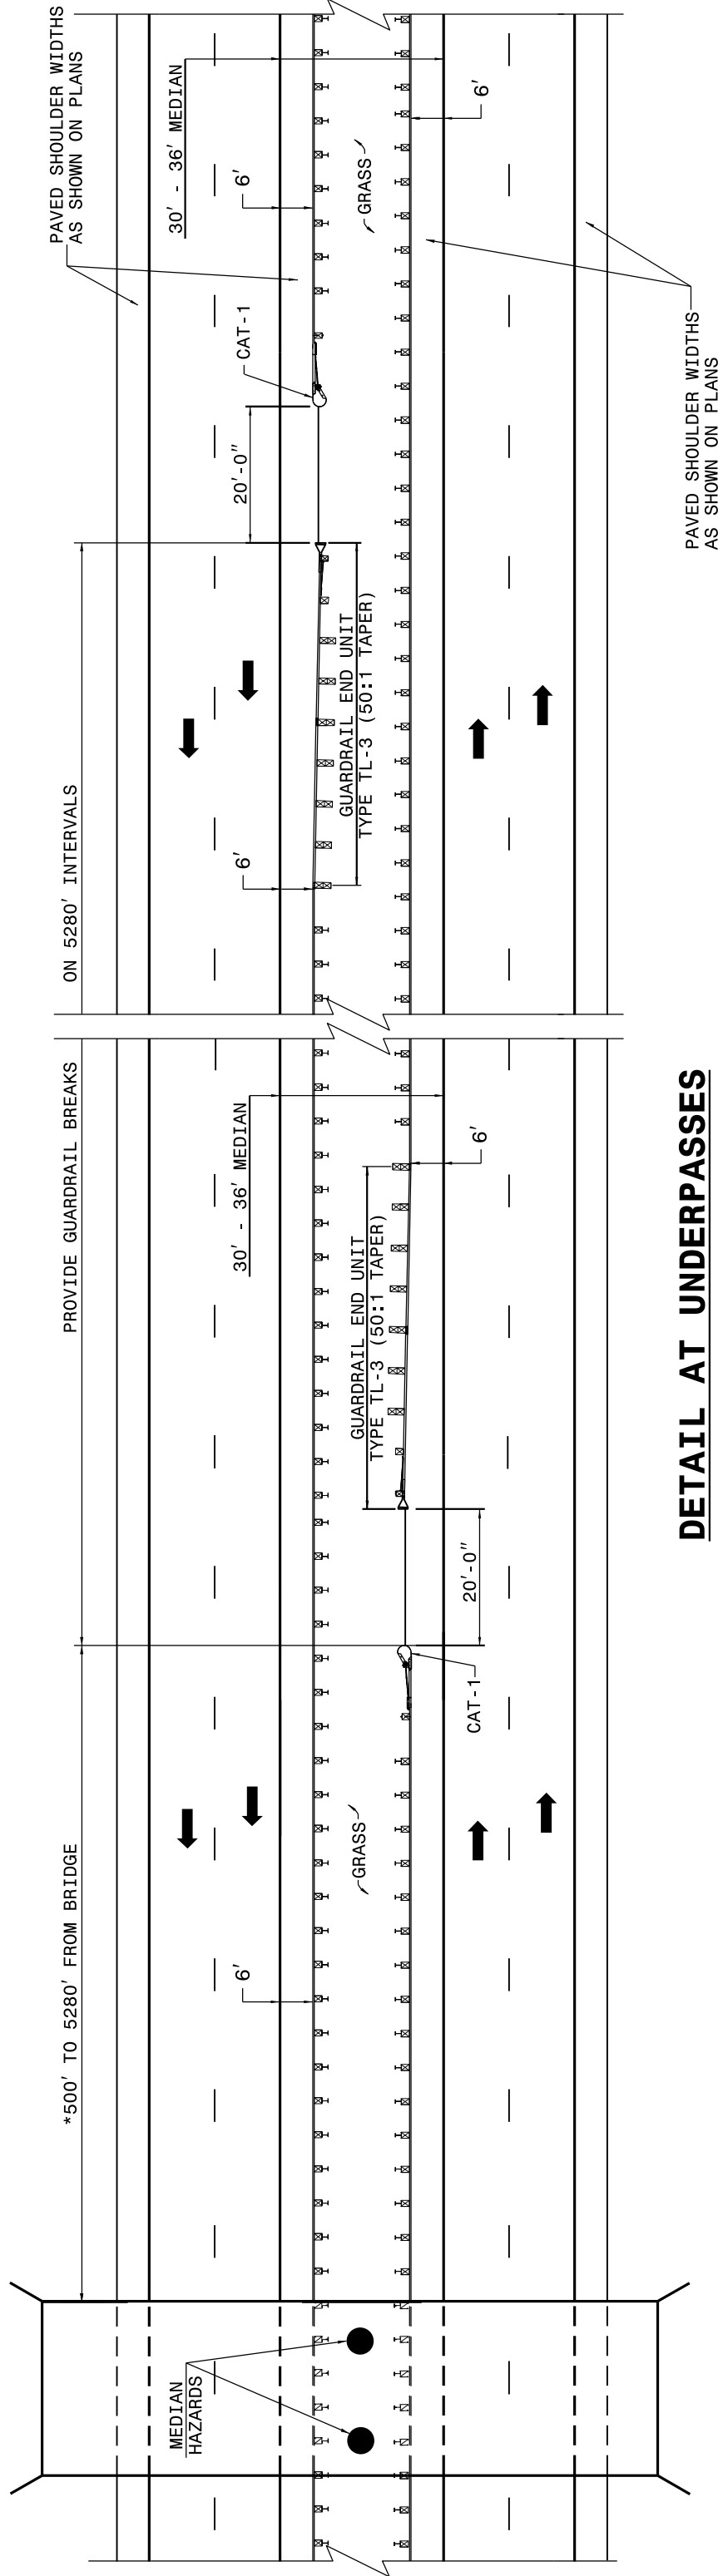


DETAIL AT UNDERPASSES

* GUARDRAIL OPENING MAY BE SPACED AS CLOSE AS 350 FT. FROM STRUCTURE IF NECESSARY TO ALLOW MOWER ACCESS TO MEDIAN

ROADWAY DETAIL DRAWING FOR
GUARDRAIL PLACEMENT

SHEET 7 OF 11
862D01

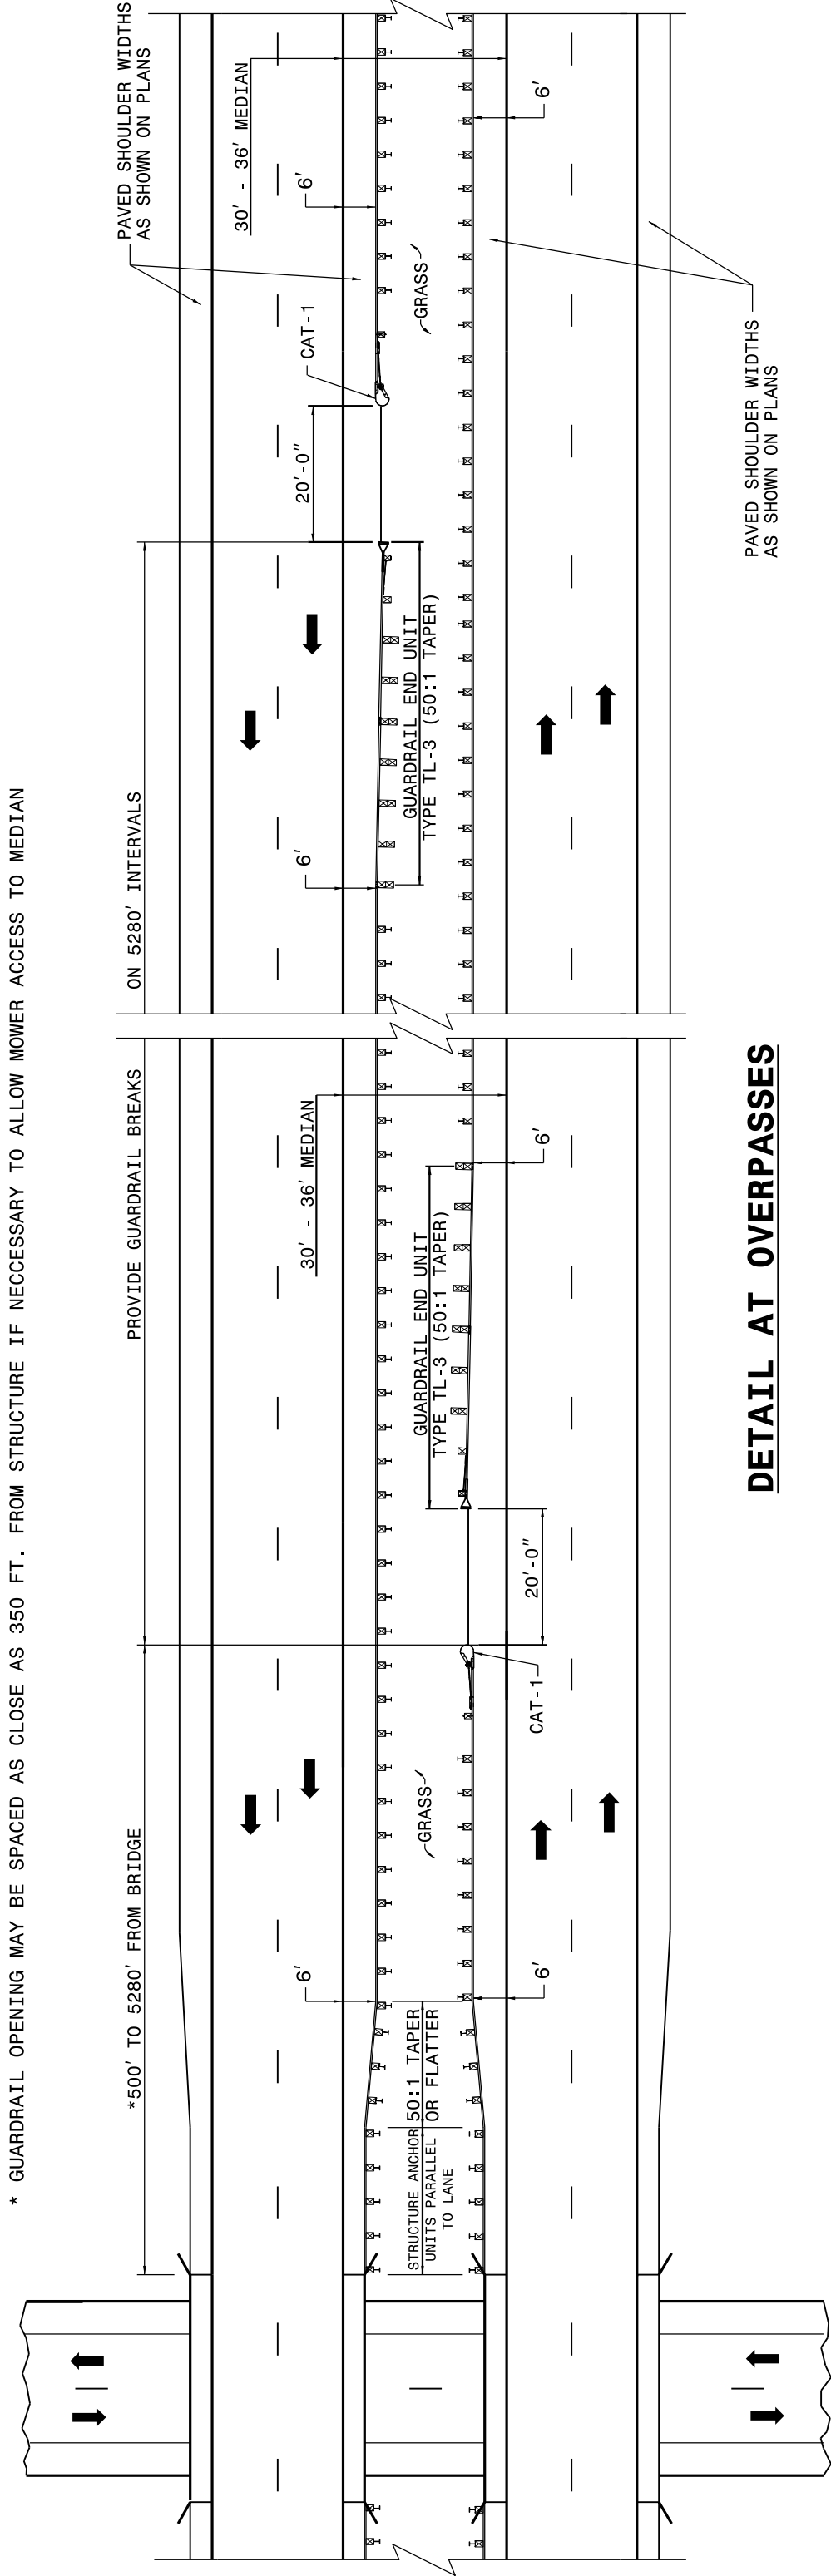

DETAIL AT OVERPASSES

FOR POSTED SPEEDS $\geq$ 45mph USE GREU TYPE TL-3
FOR POSTED SPEEDS $<$ 45mph USE GREU TYPE TL-2

GUARDRAIL BREAK INTERVALS WITH 30' - 36' MEDIANS

CONTRACT STANDARDS
AND DEVELOPMENT UNIT
Office 919-707-6950 FAX 919-250-4119

SEE TITLE BLOCK

ORIGINAL BY: J HOWERTON DATE: 06-22-12
MODIFIED BY: DATE:
CHECKED BY: DATE:
FILE SPEC.:



DOCUMENT NOT CONSIDERED FINAL
UNLESS ALL SIGNATURES COMPLETED

DocuSigned by:
Joel S. Howerton, P.E.
873F3D70
PROFESSIONAL
SEAL
022966
ENGINEER
JOEL S. HOWERTON
6/14/2017

PROJECT REFERENCE NO.
W-5601CC

SHEET NO.
2B-4

Q:\MAY-2017\546 Projects\Special Details\Howerton\Standard Drawings\Details in Lieu of Standards\Division 8\862d01 862d03 862d03\862d01.dgn
JHOWERTON
CSD-2012-06

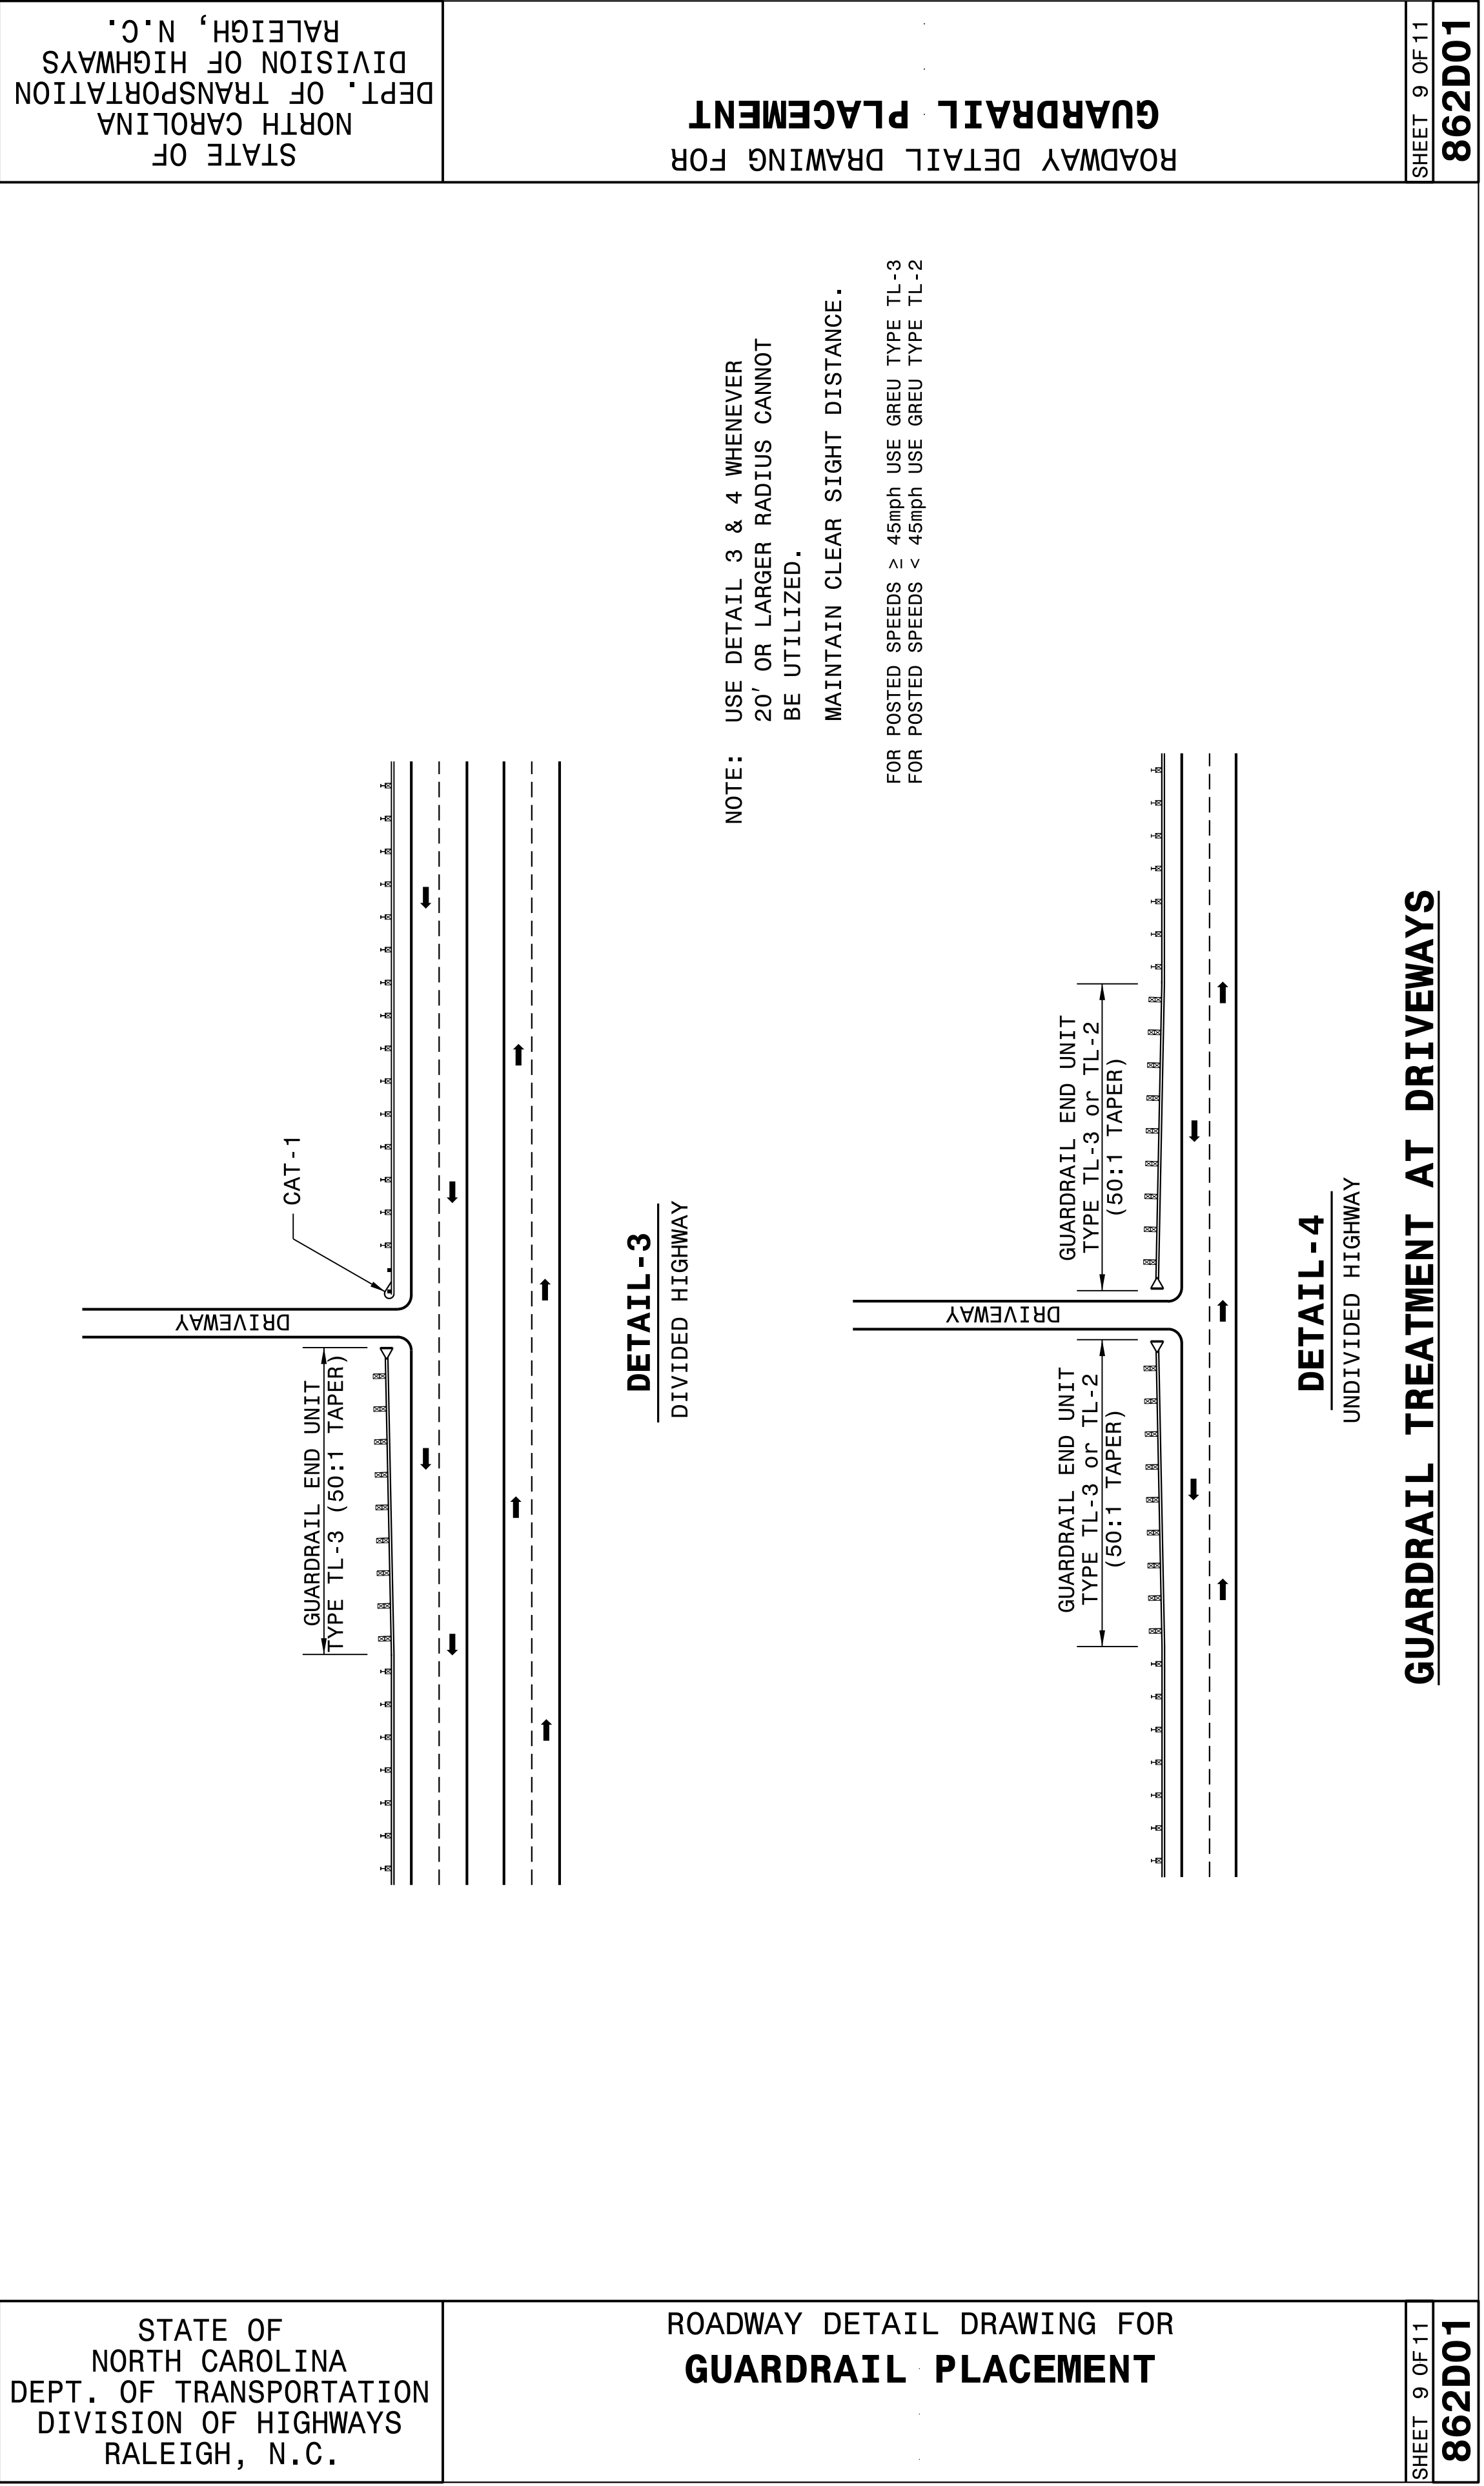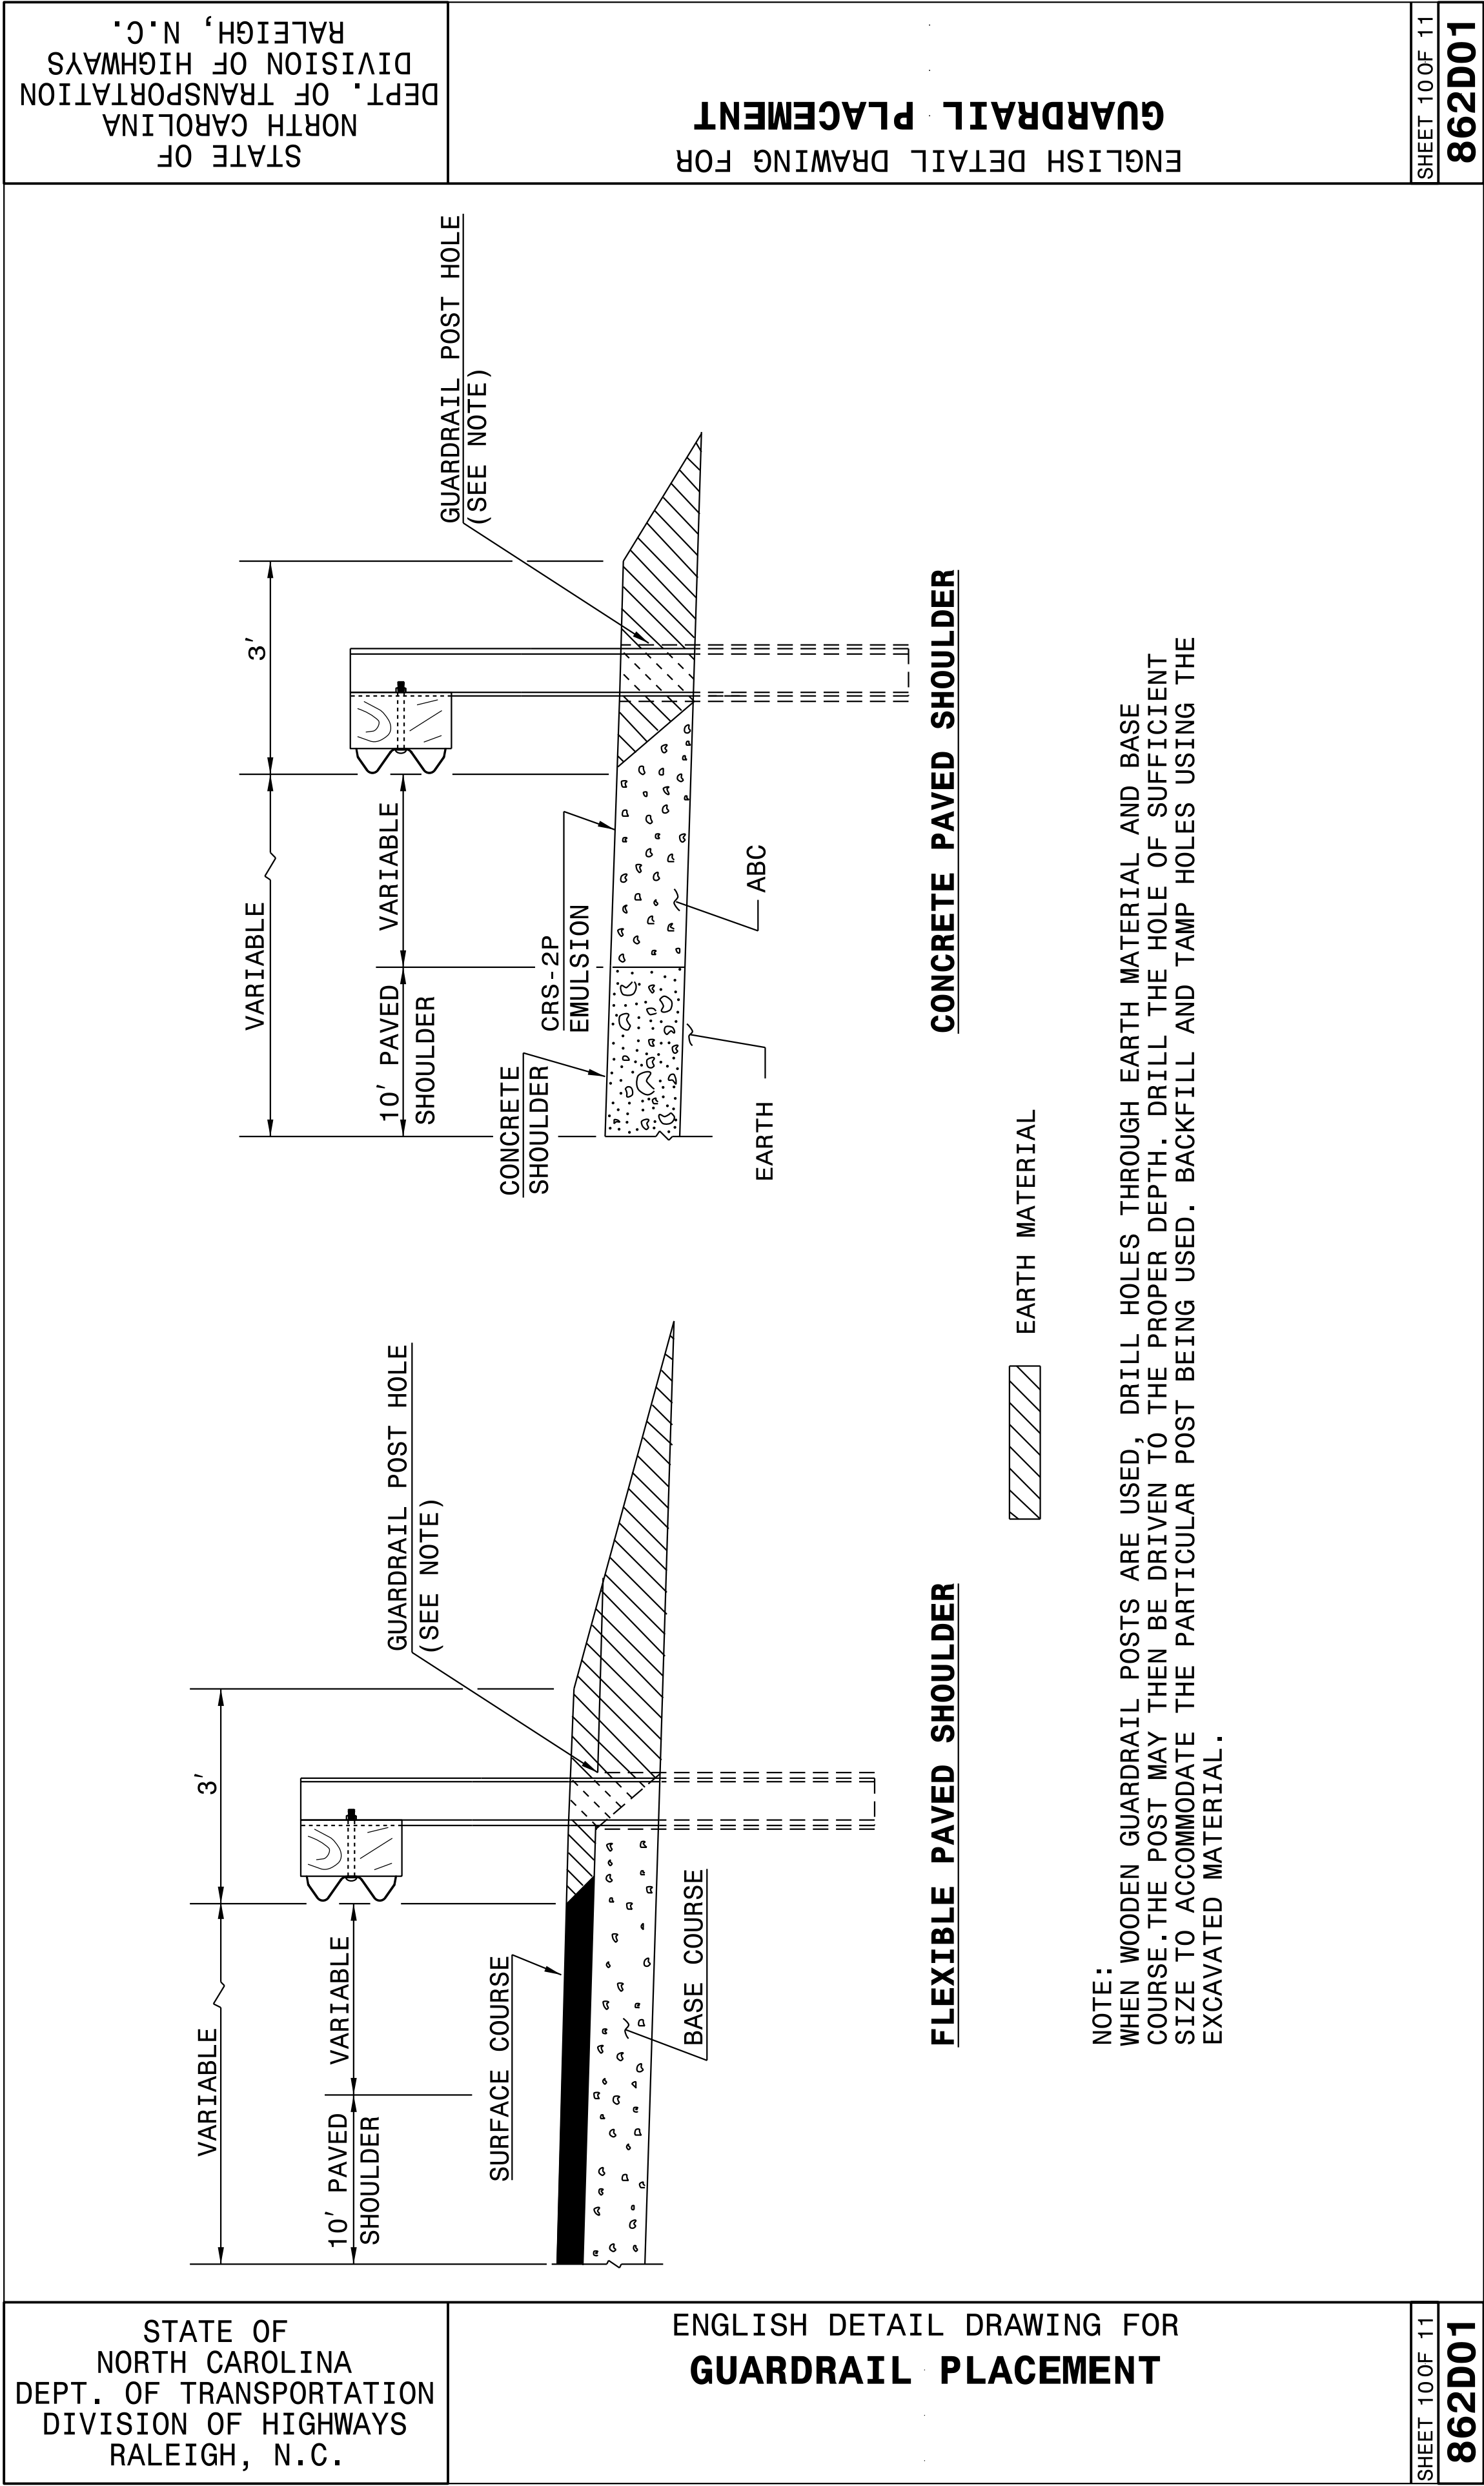

PROJECT REFERENCE NO. W-5601CC	SHEET NO. 2B-5
-----------------------------------	-------------------

DOCUMENT NOT CONSIDERED FINAL
UNLESS ALL SIGNATURES COMPLETED

CONTRACT STANDARDS
AND DEVELOPMENT UNIT
Office 919-707-6950 FAX 919-250-4119


SEE TITLE BLOCK

ORIGINAL BY: J HOWERTON DATE: 06-22-12
MODIFIED BY: DATE:
CHECKED BY: DATE:
FILE SPEC.: DATE:

DesigSigned by:
Jael S. Howerton, P.E.
873F3D1775

PROFESSIONAL
SEAL
022966
ENGINEER
Jael S. Howerton
6/14/2017

24-MAY-2017 15:17
\\Contracts\Special Details in Lieu of Standards\Division 8\662d01 662d03 662d03\662d01.dgn
poweron AT CSD-242545

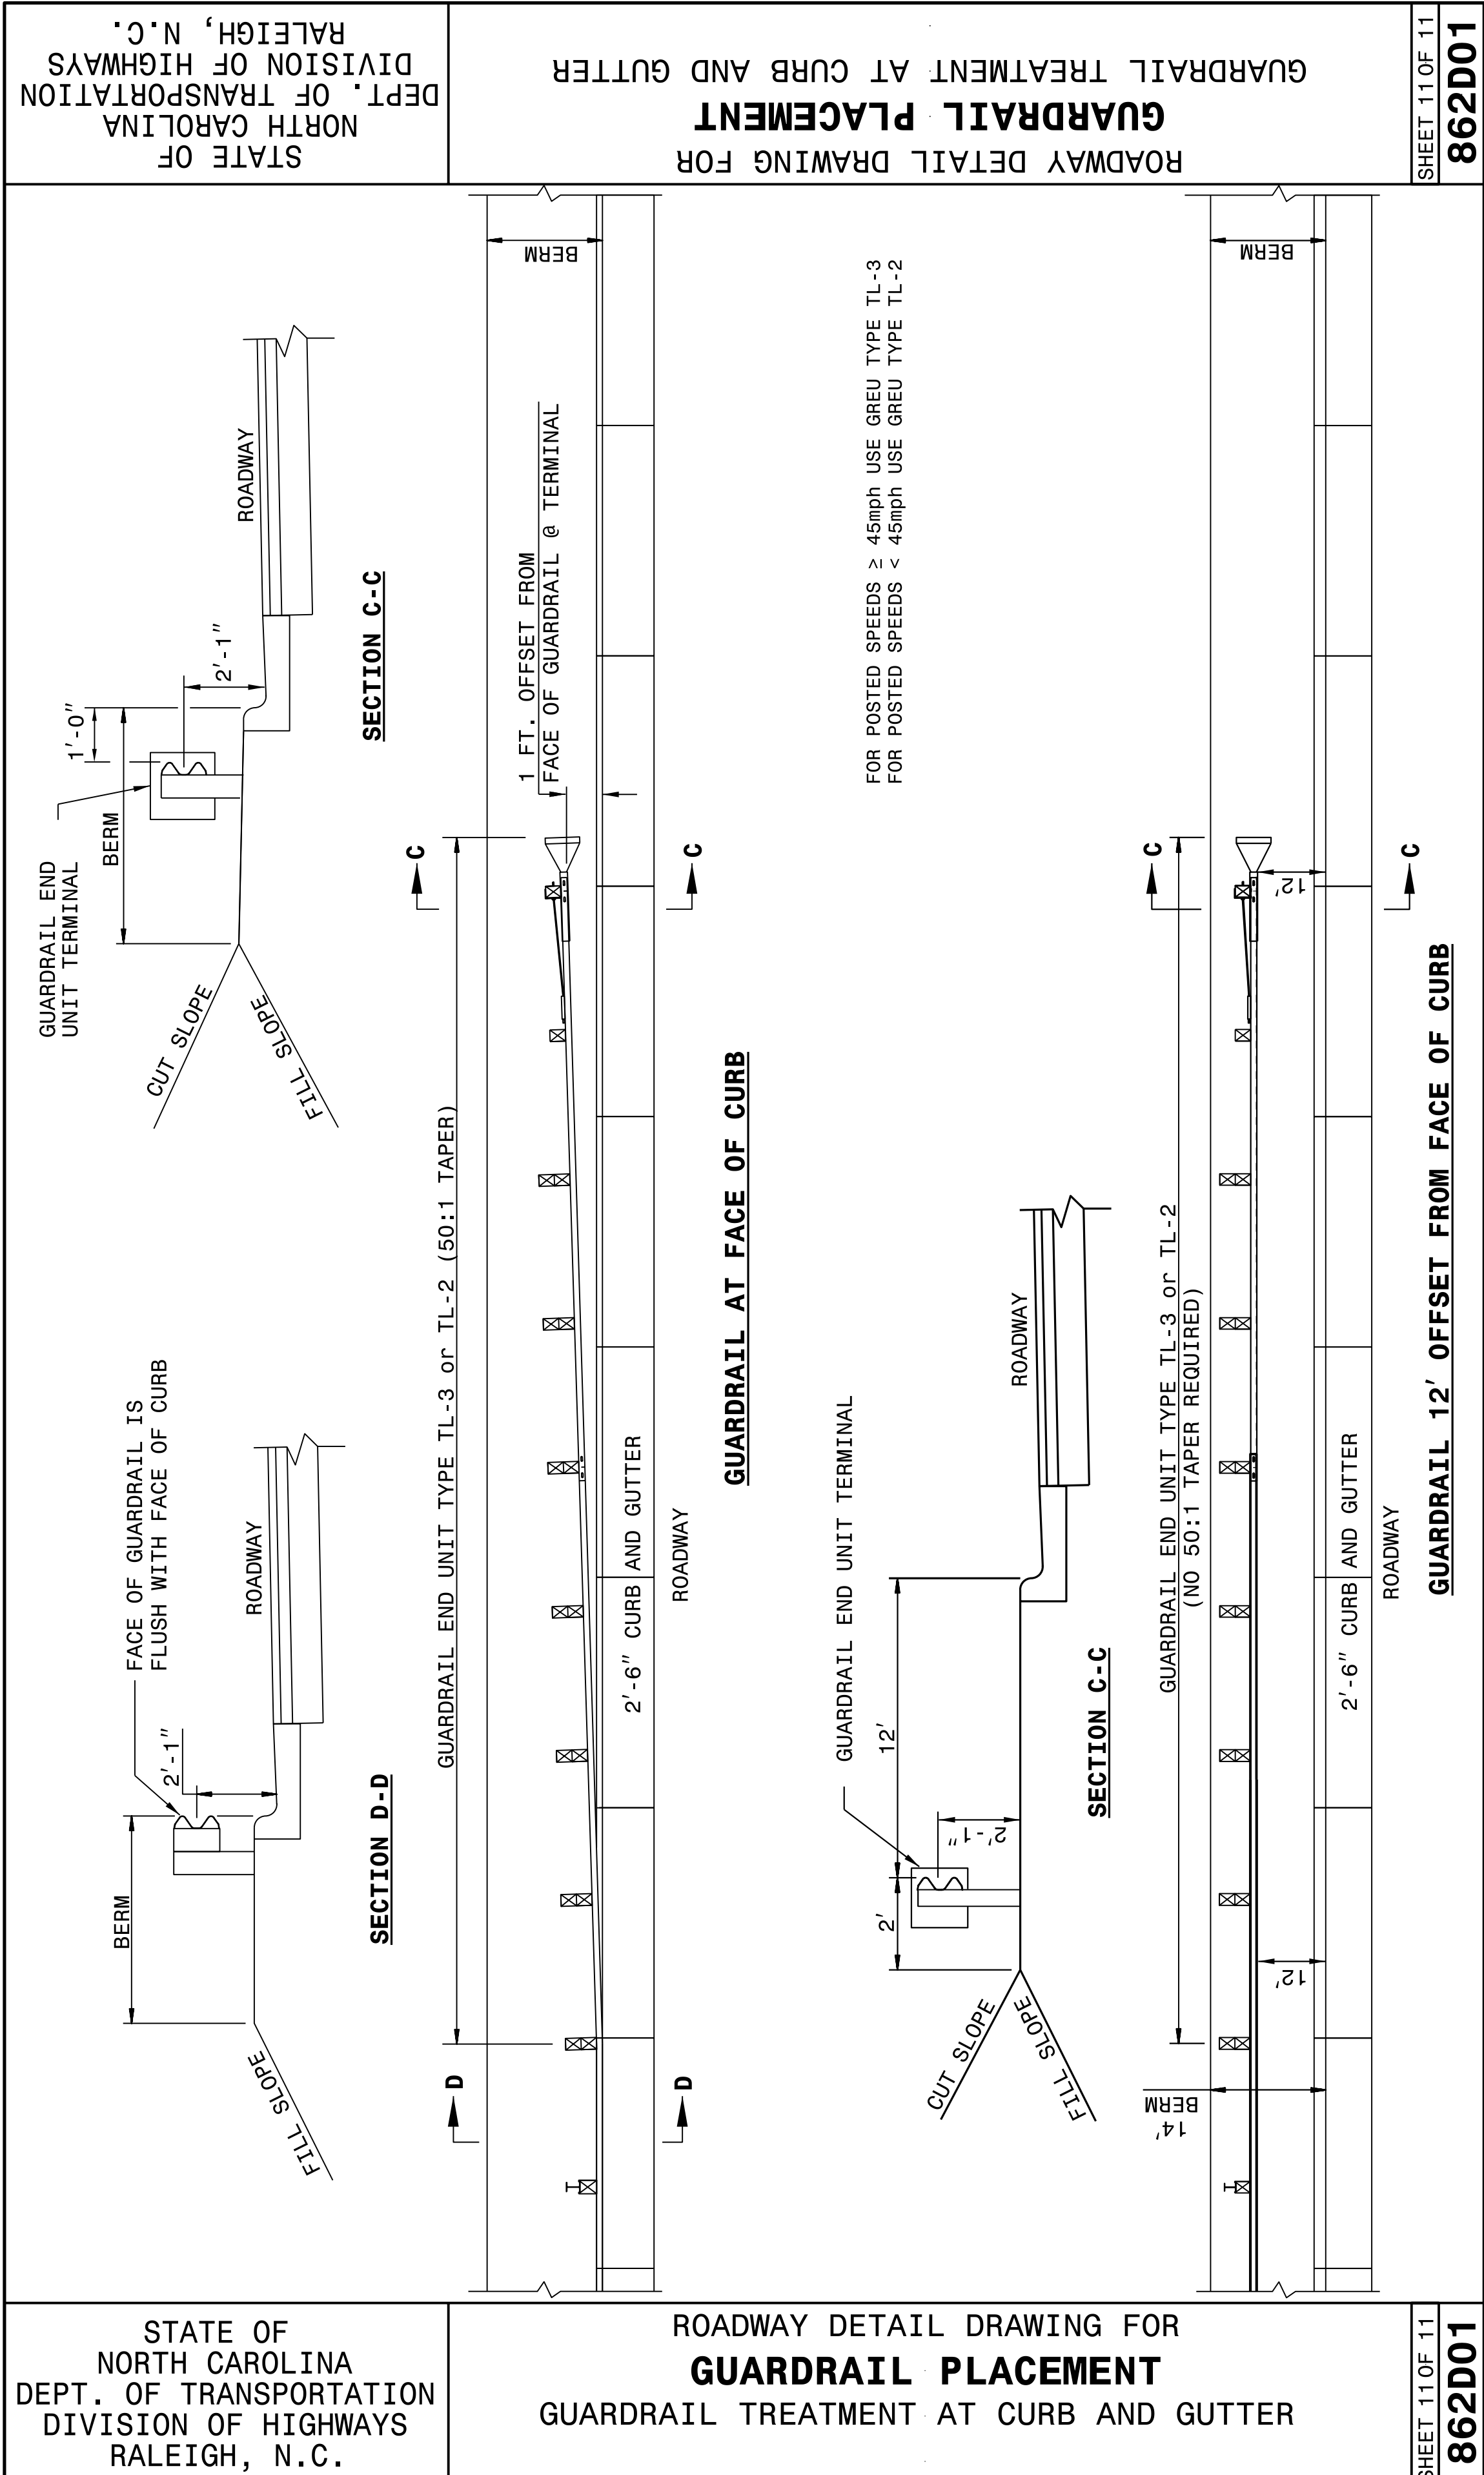

DocuSigned by:
Joel S. Howerton, P.E.
873F3D127050



A circular professional engineer seal for the State of North Carolina. The outer ring contains the text "NORTH CAROLINA" at the top and "Joel S. Howerton" at the bottom. The inner ring contains the text "PROFESSIONAL" at the top and "ENGINEER" at the bottom. In the center, the word "SEAL" is at the top, the license number "022966" is in the middle, and the expiration date "6/14/2017" is at the bottom.

**DOCUMENT NOT CONSIDERED FINAL
UNLESS ALL SIGNATURES COMPLETED**

**CONTRACT STANDARDS
AND DEVELOPMENT UNIT**
Office 919-707-6950 FAX 919-250-4119

SEE TITLE BLOCK

ORIGINAL BY: J HOWERTON DATE: 06-22-12
MODIFIED BY: _____ DATE: _____
CHECKED BY: _____ DATE: _____
FILE SPEC : _____

23-MAY-2017 12:50
S:\Contracts\Projects\Special Details\Howerton\Standard Drawings\Details in Lieu of Standards\Division 8\862d01 862d03 862d03\862d02.dgn
Howerton A1 CS0-272595

STATE OF
NORTH CAROLINA
DEPT. OF TRANSPORTATION
DIVISION OF HIGHWAYS
RALEIGH, N.C.


ROADWAY DETAIL DRAWING FOR
GUARDRAIL INSTALLATION

SHEET 2 OF 8
862D02


STATE OF
NORTH CAROLINA
DEPT. OF TRANSPORTATION
DIVISION OF HIGHWAYS
RALEIGH, N.C.

ROADWAY DETAIL DRAWING FOR
GUARDRAIL INSTALLATION

SHEET 2 OF 8
862D02

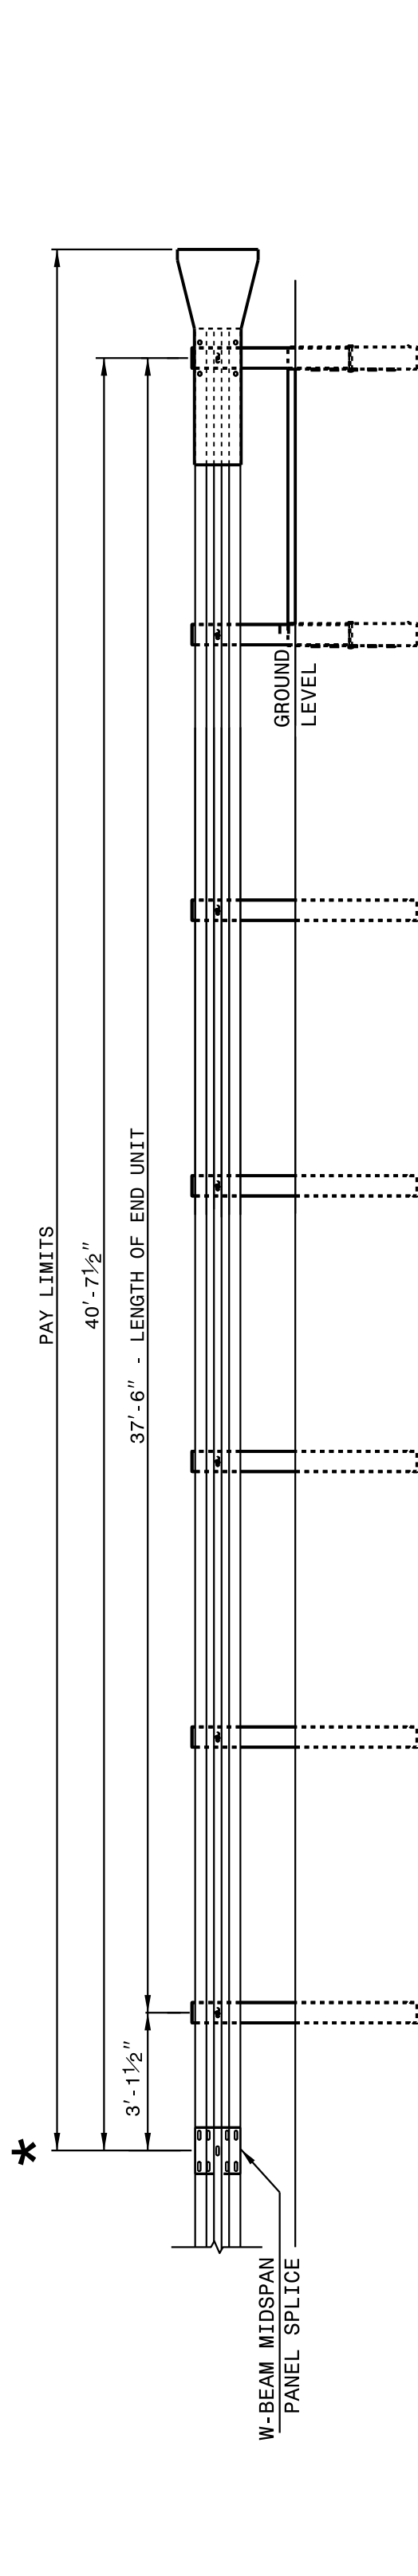

FLARED AND TANGENT
ELEVATION VIEW

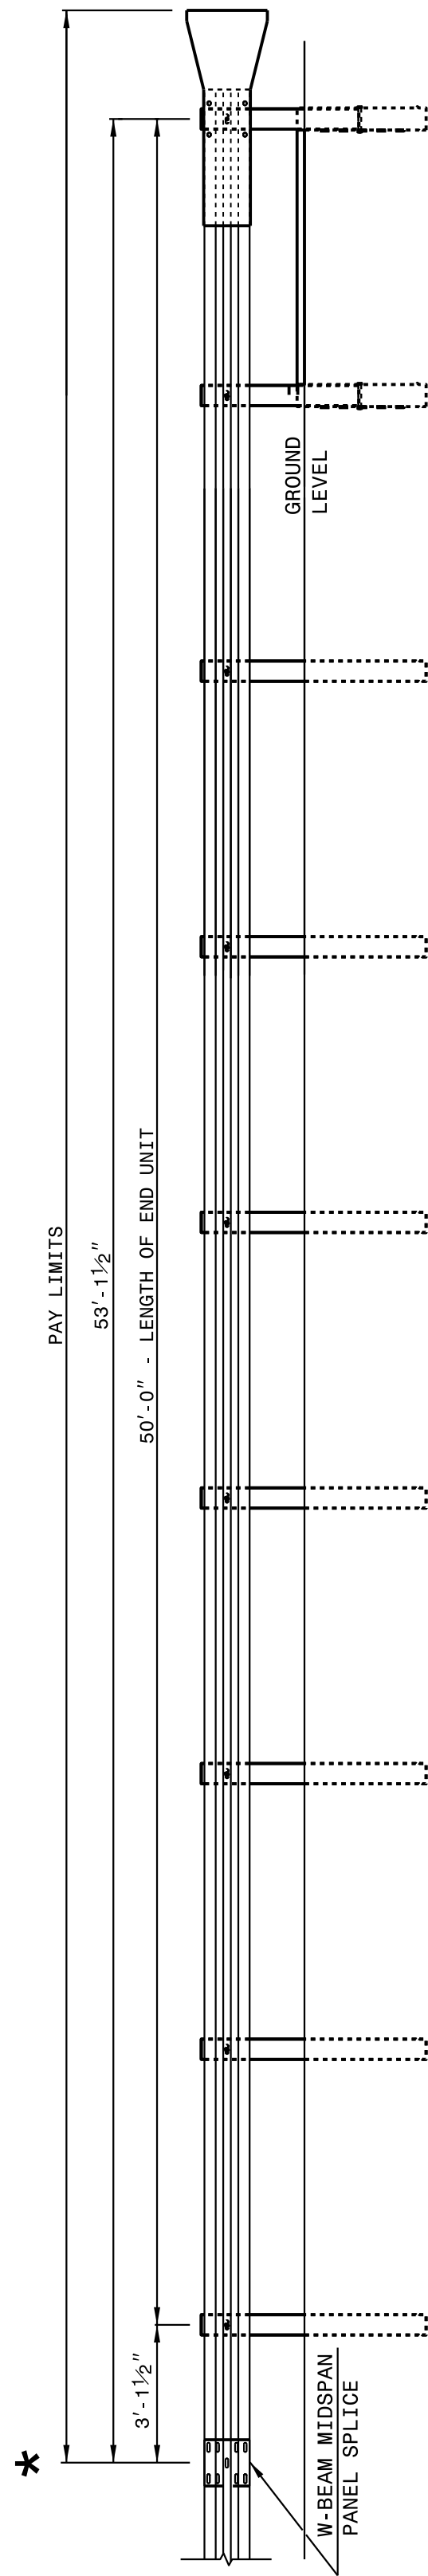

FLARED AND TANGENT
ELEVATION VIEW

APPROACH END UNITS

STATE OF
NORTH CAROLINA
DEPT. OF TRANSPORTATION
DIVISION OF HIGHWAYS
RALEIGH, N.C.


ROADWAY DETAIL DRAWING FOR
GUARDRAIL INSTALLATION

SHEET 1 OF 8
862D02

STATE OF
NORTH CAROLINA
DEPT. OF TRANSPORTATION
DIVISION OF HIGHWAYS
RALEIGH, N.C.

ROADWAY DETAIL DRAWING FOR
GUARDRAIL INSTALLATION

SHEET 1 OF 8
862D02

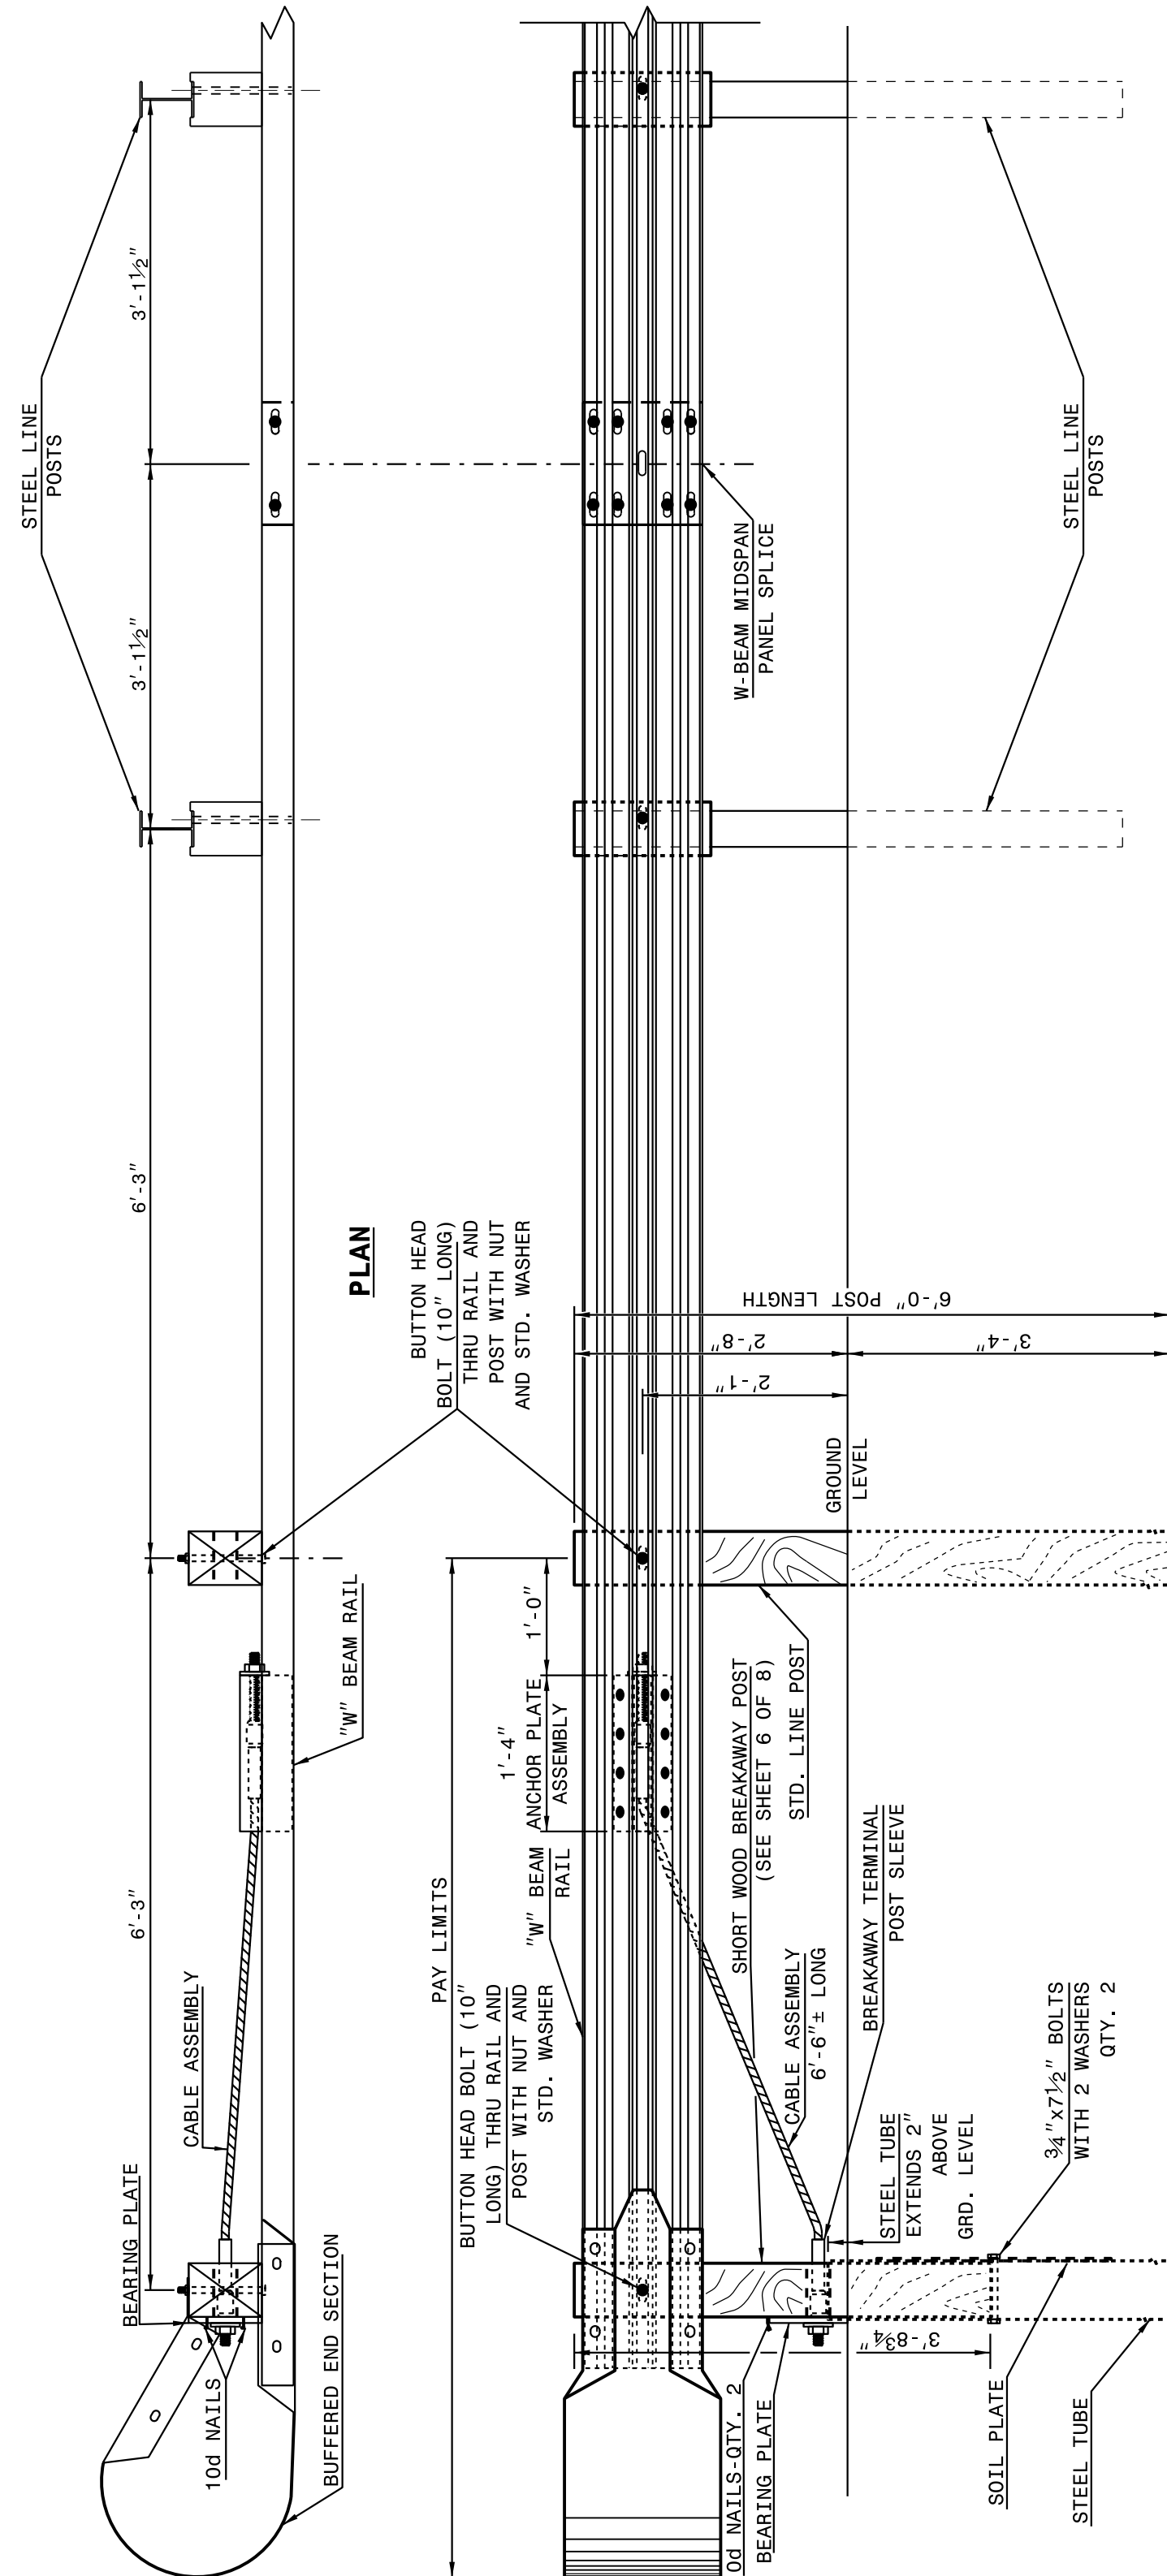

ELEVATION

TRAILING END UNIT ASSEMBLY

C.A.T.-1 SYSTEM

CONTRACT STANDARDS
AND DEVELOPMENT UNIT
Office 919-707-6950 FAX 919-250-4119

SEE TITLE BLOCK

ORIGINAL BY: J. HOWERTON DATE: 06-22-12
MODIFIED BY: DATE:
CHECKED BY: DATE:
FILE SPEC.: DATE:

DOCUMENT NOT CONSIDERED FINAL
UNLESS ALL SIGNATURES COMPLETED

DocuSigned by:
Jael S. Howerton, P.E.
873F3D115004
NORTH CAROLINA
PROFESSIONAL
SEAL
022966
ENGINEER
Jael S. Howerton
6/14/2017


PROJECT REFERENCE NO.	SHEET NO.
W-5601CC	2B-9

04-MAY-2017 15:21
S:\Contracts\Construction\Special Details\Howerton\Standard Drawings\Details in Lieu of Standards\Division 8\862d01 862d03 862d03\862d02.dgn
Howerton, N.C. USD-212593

STATE OF
NORTH CAROLINA
DEPT. OF TRANSPORTATION
DIVISION OF HIGHWAYS
RALEIGH, N.C.

ROADWAY DETAIL DRAWING FOR
GUARDRAIL INSTALLATION

SHEET 8 OF 8
862D02

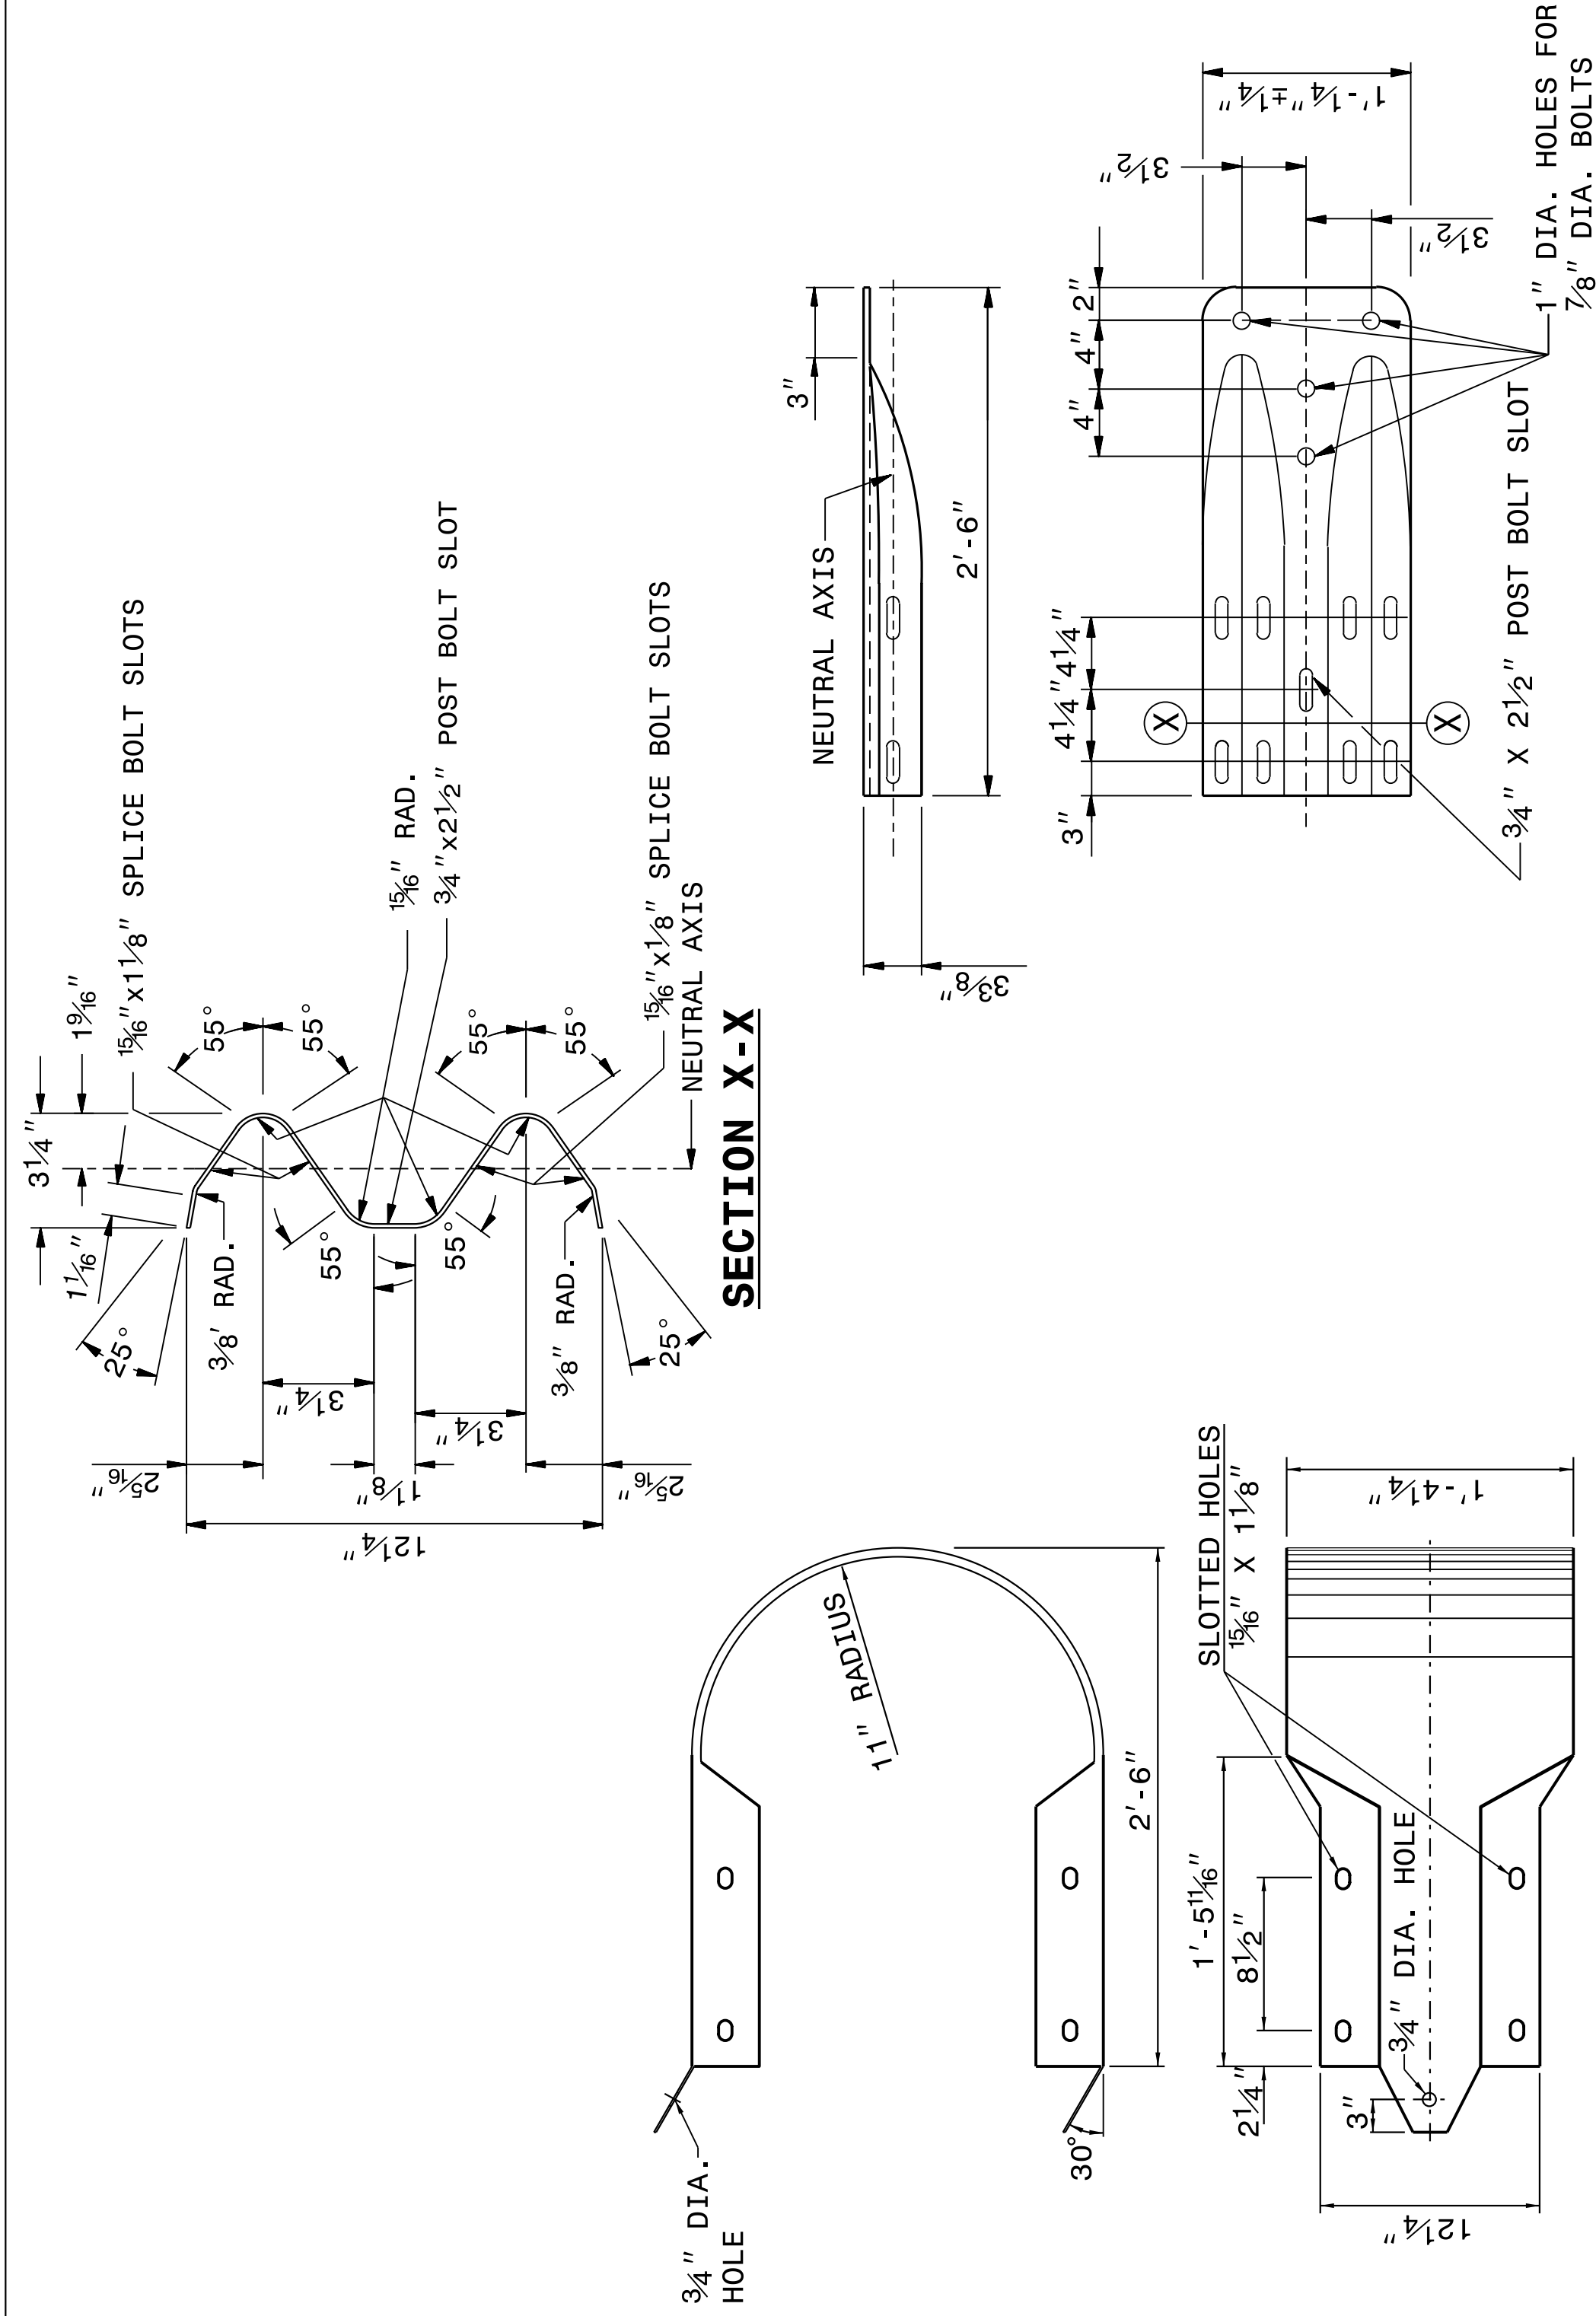

SYSTEM PARTS - GENERAL USE

TYPICAL END SHOE

SHEET 8 OF 8
862D02

STATE OF
NORTH CAROLINA
DEPT. OF TRANSPORTATION
DIVISION OF HIGHWAYS
RALEIGH, N.C.


ROADWAY DETAIL DRAWING FOR
GUARDRAIL INSTALLATION

SHEET 8 OF 8
862D02

STATE OF
NORTH CAROLINA
DEPT. OF TRANSPORTATION
DIVISION OF HIGHWAYS
RALEIGH, N.C.

ROADWAY DETAIL DRAWING FOR
GUARDRAIL INSTALLATION

SHEET 7 OF 8
862D02

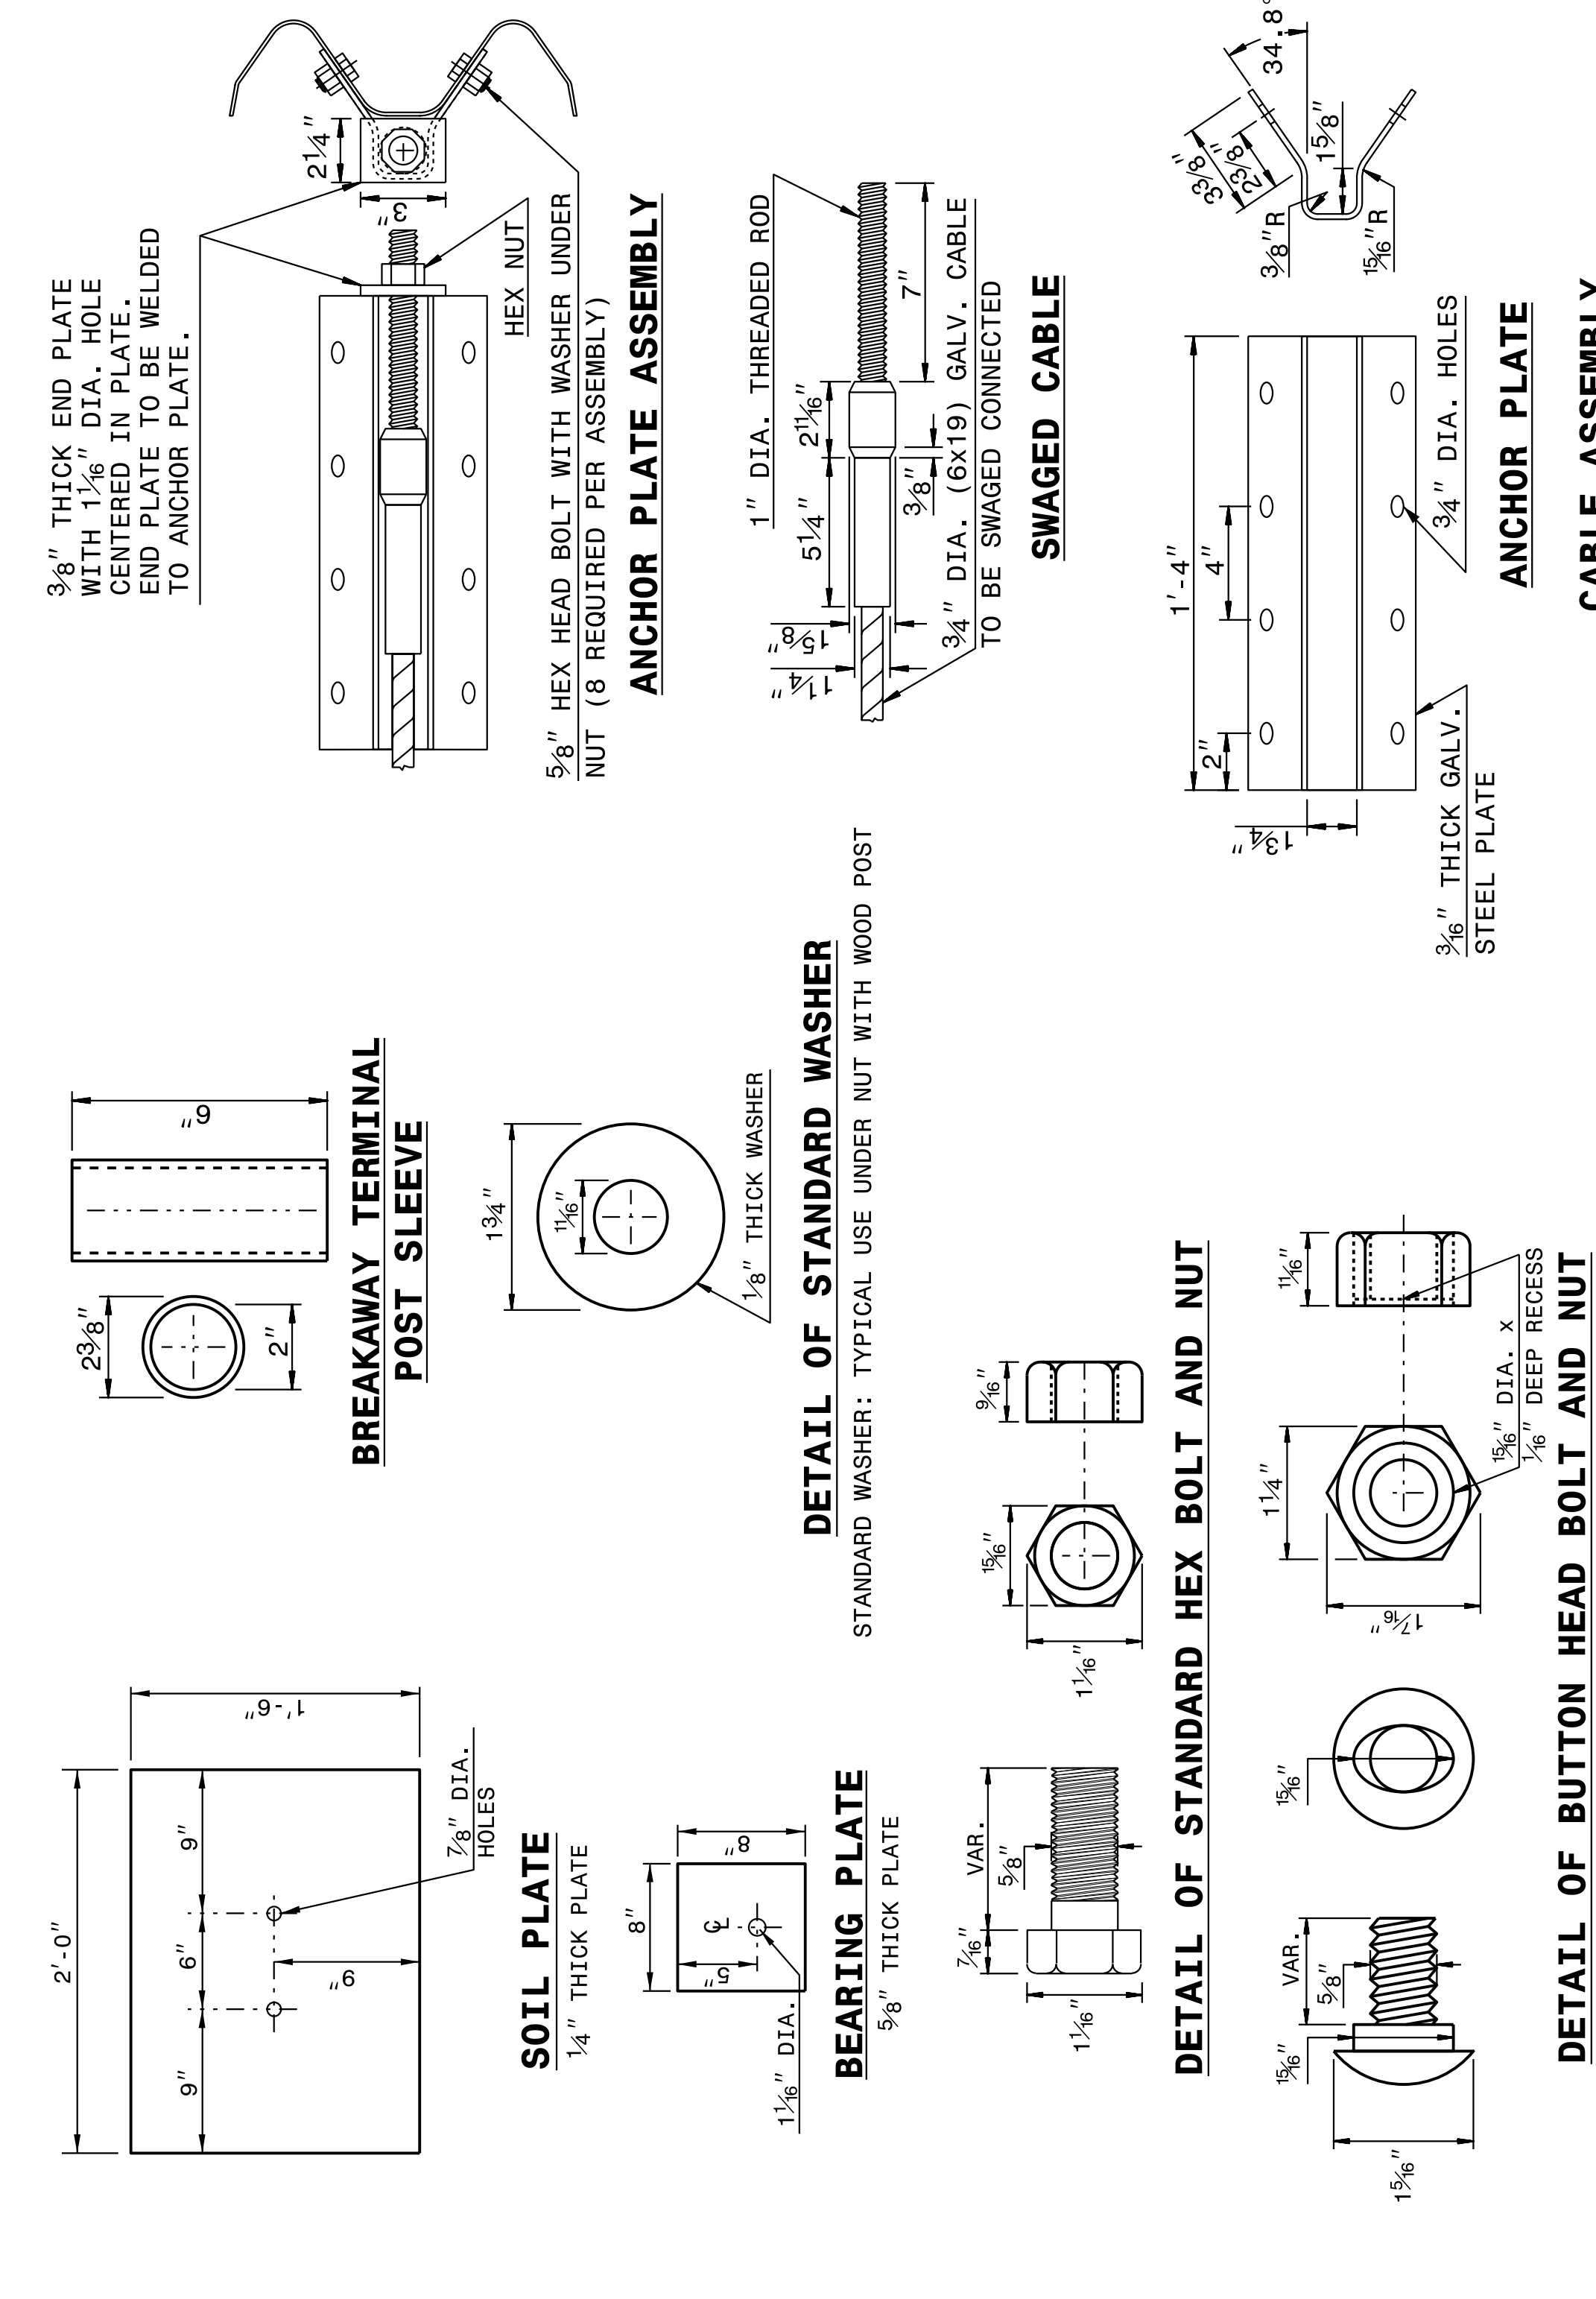

SYSTEM PARTS

SHEET 7 OF 8
862D02

ROADWAY DETAIL DRAWING FOR
GUARDRAIL INSTALLATION


STATE OF
NORTH CAROLINA
DEPT. OF TRANSPORTATION
DIVISION OF HIGHWAYS
RALEIGH, N.C.

ORIGINAL BY: J. HOWERTON DATE: 06-22-12
MODIFIED BY: DATE:
CHECKED BY: DATE:
FILE SPEC.:
DOCUMENT NOT CONSIDERED FINAL
UNLESS ALL SIGNATURES COMPLETED

CONTRACT STANDARDS
AND DEVELOPMENT UNIT
Office 919-707-6950 FAX 919-250-4119

SEE TITLE BLOCK


Designed by:
Joel S. Howerton, P.E.
873F3D77
NORTH CAROLINA
PROFESSIONAL
SEAL
022966
ENGINEER
Joel S. Howerton
6/14/2017

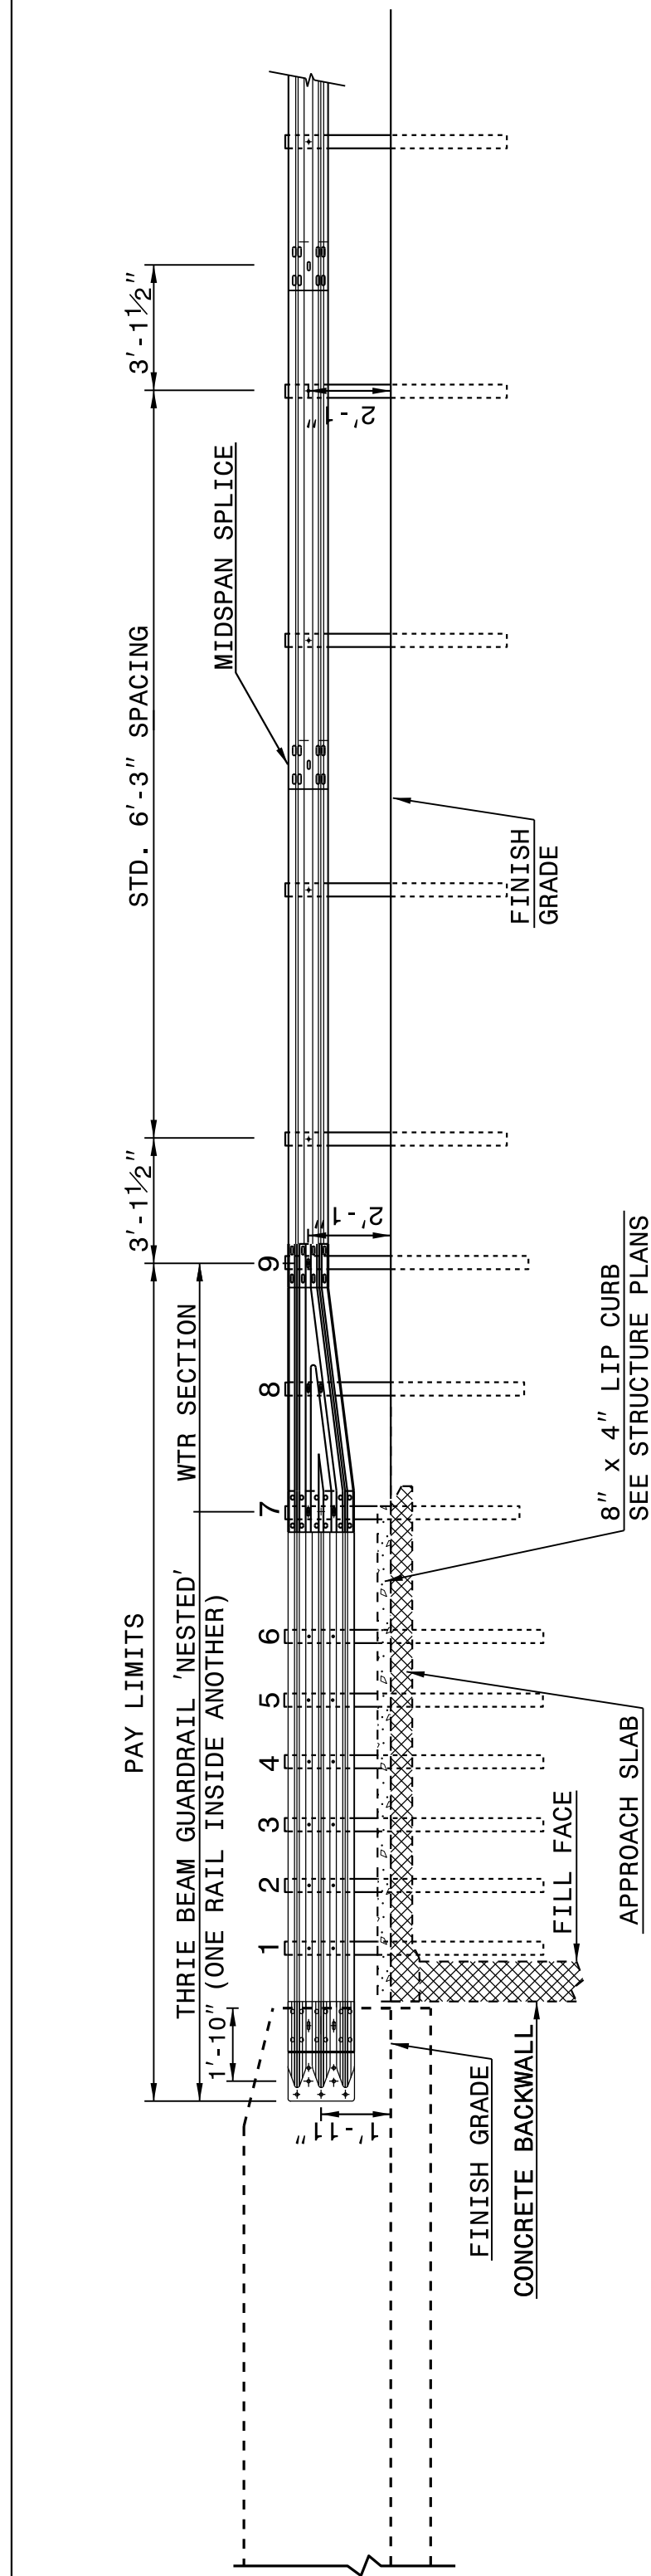

ELEVATION

NOTE:

- **POST NOT REQUIRED FOR SKEW ANGLES GREATER THAN 150° OR LESS THAN 30° UNLESS OTHERWISE DIRECTED BY THE ENGINEER.
- *THE DISTANCE FROM END OF BRIDGE RAIL TO CENTER LINE OF THE FIRST POST SHOULD BE 11'2". IF CONCRETE BACKWALL IS NOT PRESENT.
- MEASURE GERM GUTTER MUST BE INSTALLED TO THE LIMITS 8' x 4' LIP CURB IS SHOWN IF ANCHOR UNIT IS NOT ADJACENT TO AN APPROACH SLAB.
- SHOULDER GUARDRAIL HEIGHT FROM THE TOP OF ADJACENT SURFACE (SHOULDER, BERM, OR GUTTER).
- LAP JOINTS IN THE DIRECTION OF TRAFFIC FLOW.
- SEE SHEET 5 FOR POST SECTIONS 1 THRU 9.

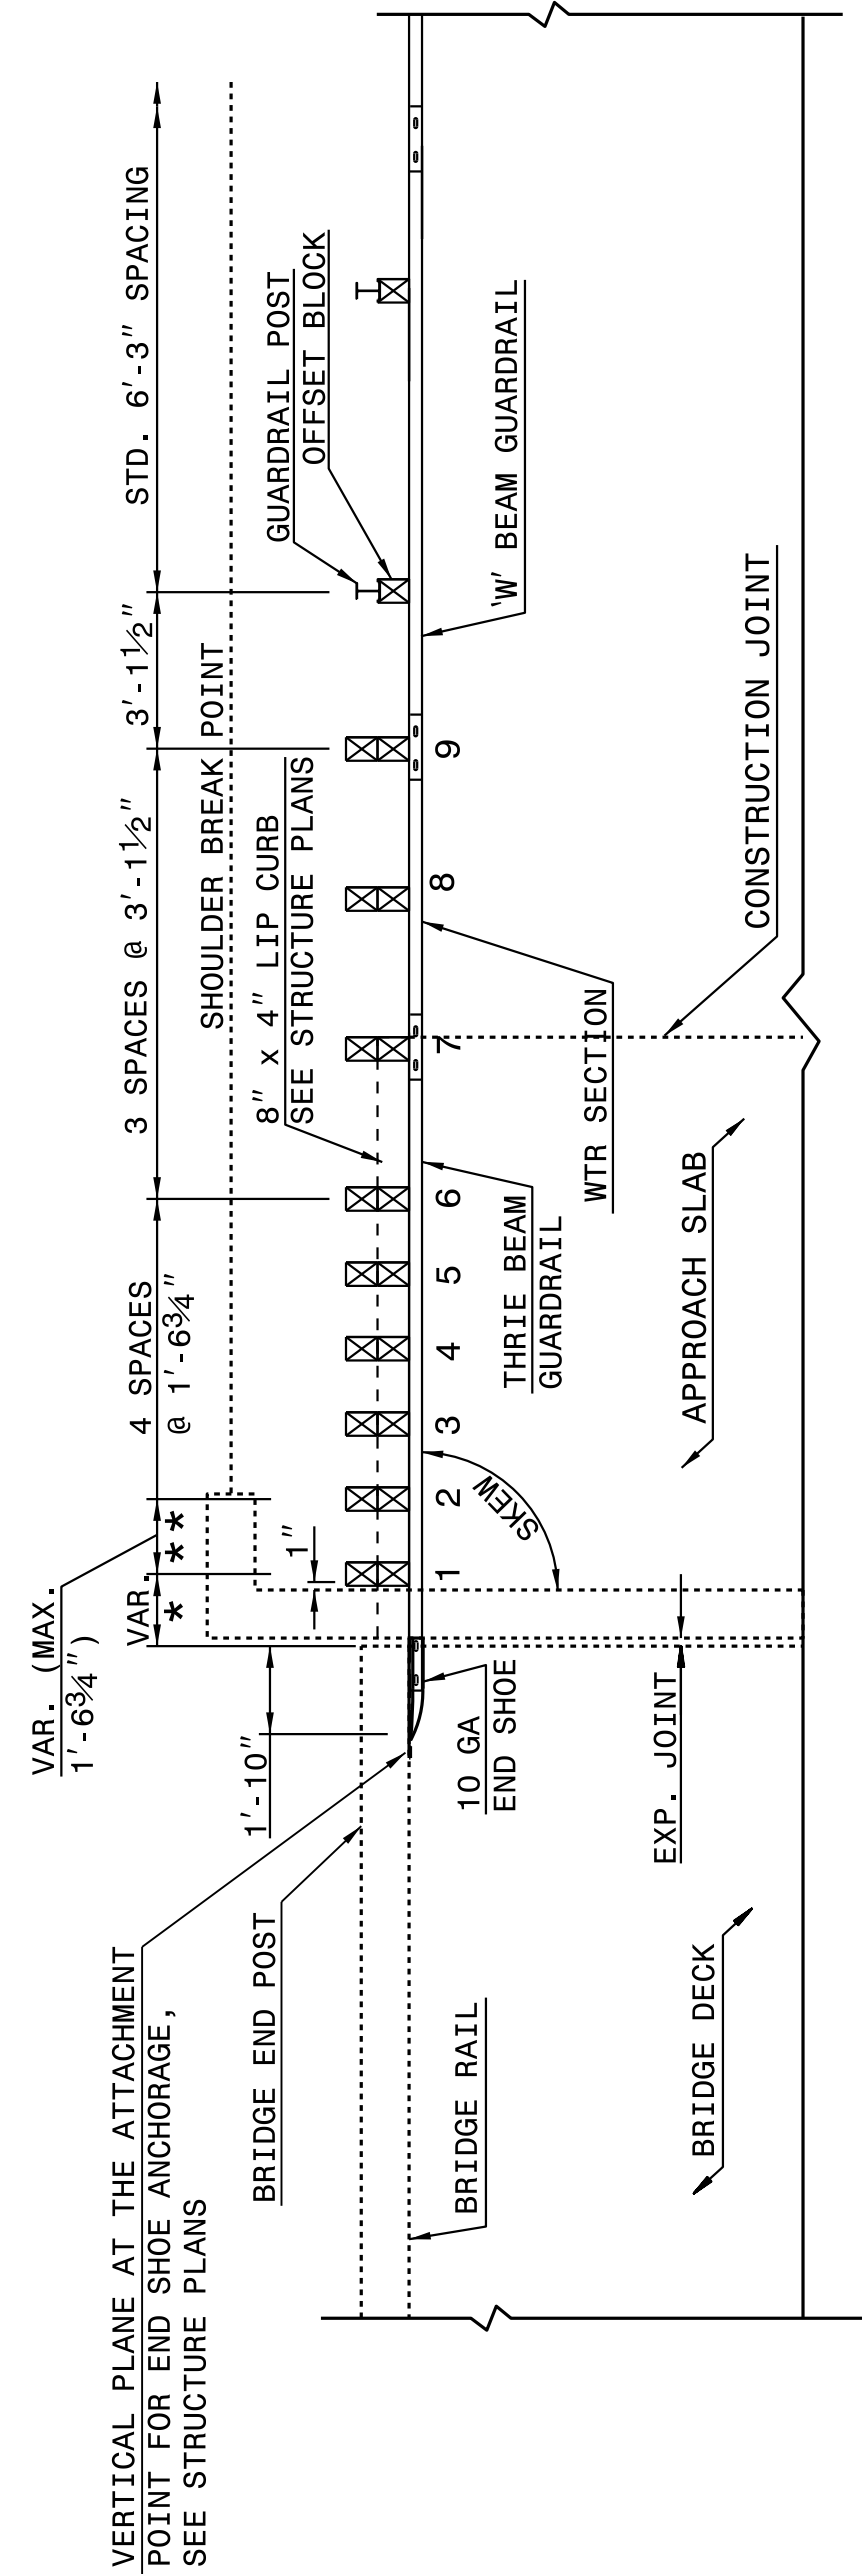


PLAN VIEW

**GUARDRAIL ANCHOR UNIT, TYPE III FOR ATTACHMENT TO
RAIL ON BRIDGE - SUB REGIONAL TIER**

SHEET 2 OF 7
862D03


SHEET 2 OF 7

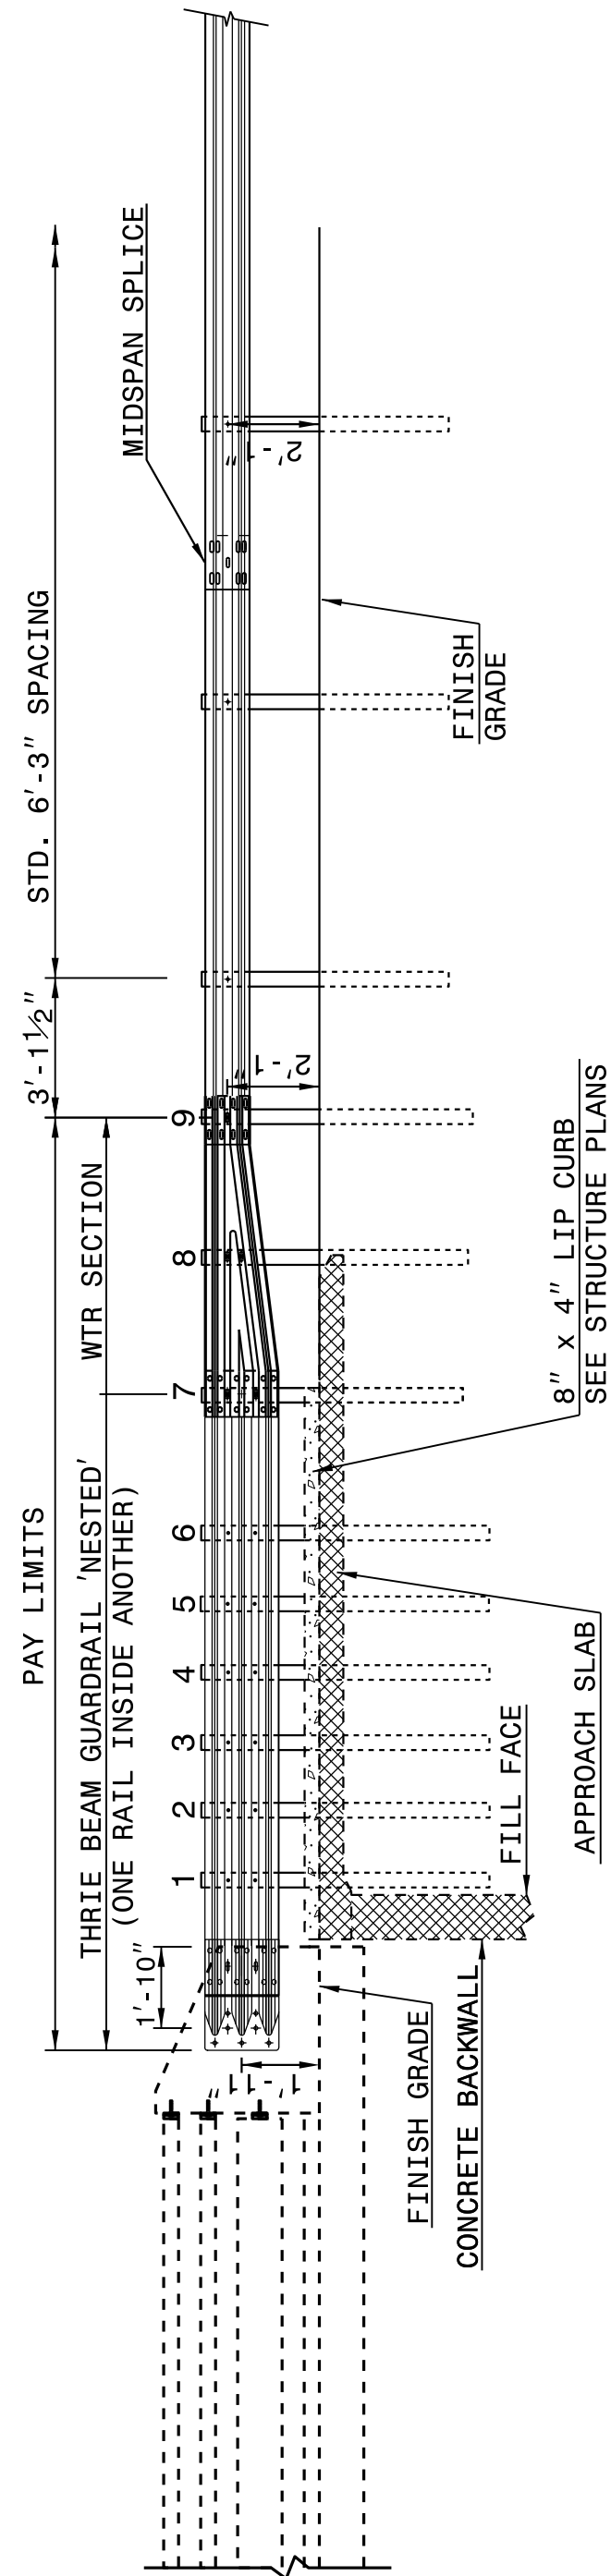

ELEVATION

NOTE:

- *POST NOT REQUIRED FOR SKEW ANGLES GREATER THAN 150° OR LESS THAN 30° UNLESS OTHERWISE DIRECTED BY THE ENGINEER.
- *THE DISTANCE FROM END OF BRIDGE RAIL TO CENTER LINE OF THE FIRST POST SHOULD BE 11½' IF CONCRETE BACKWALL IS NOT PRESENT.
- SHOULDER BERM GUTTER MUST BE INSTALLED TO THE LIMITS 8' x 4' LIP CURB IS SHOWN IF ANCHOR UNIT IS NOT ADJACENT TO AN APPROACH SLAB.
- MEASURE GUARDRAIL HEIGHT FROM THE TOP OF ADJACENT SURFACE (SHOULDER, BERM, OR GUTTER).
- LAP JOINTS IN THE DIRECTION OF TRAFFIC FLOW.
- SEE SHEET 5 FOR POST SECTIONS 1 THRU 9.

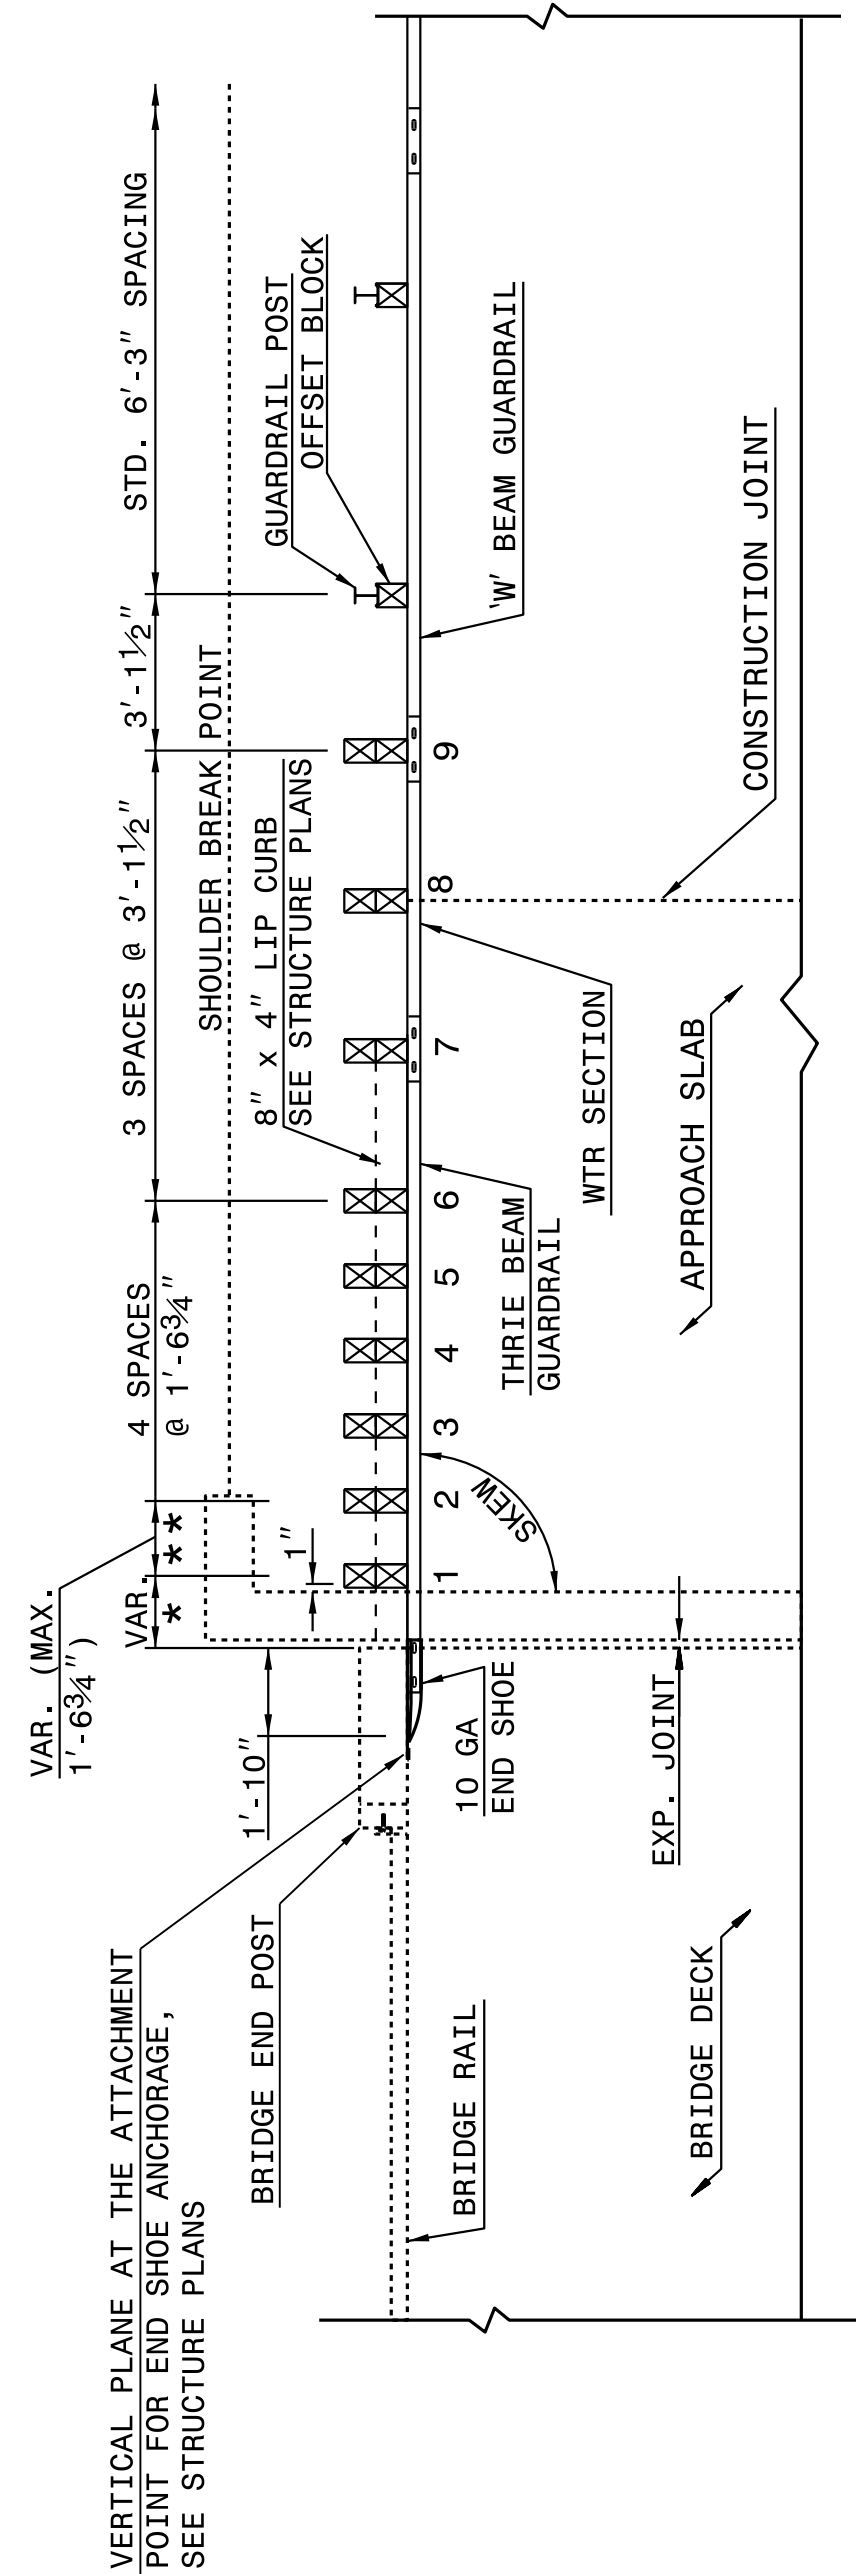

PLAN VIEW

SHEET 1 OF 7

862D03

SHEET 1 OF 7

862D03


04-MAY-2017 14:54
S:\Contracts\Construction\Special Details\Standard Drawings\Details in Lieu of Standards\Division 8\862d01 862d03 862d03\862d03.dgn
J.Howerton N.C. USD 212593

STATE OF
NORTH CAROLINA
DEPT. OF TRANSPORTATION
DIVISION OF HIGHWAYS
RALEIGH, N.C.



ROADWAY DETAIL DRAWING FOR
STRUCTURE ANCHOR UNITS
GUARDRAIL ANCHOR UNIT TYPE B-83

SHEET 6 OF 7
862D03

SECTION A-A

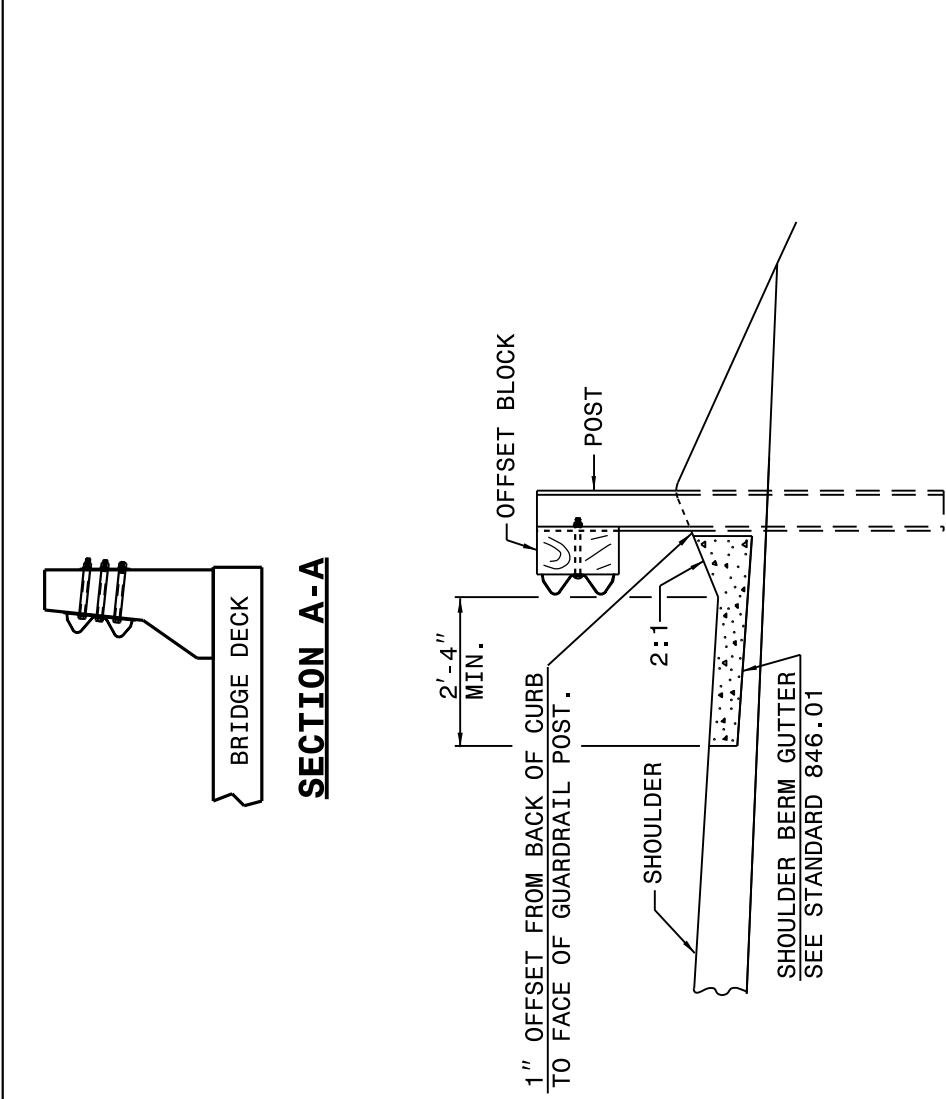


SECTION B-B

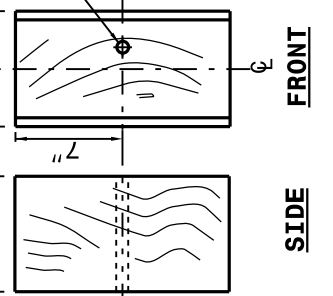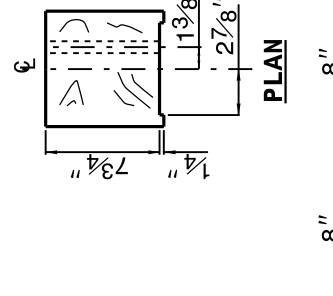

SECTION C-C



SECTION D-D

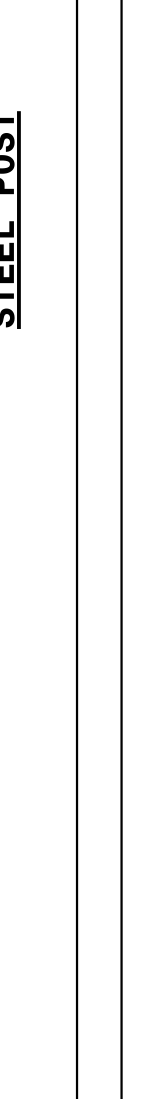


STATE OF
NORTH CAROLINA
DEPT. OF TRANSPORTATION
DIVISION OF HIGHWAYS
RALEIGH, N.C.


ROADWAY DETAIL DRAWING FOR
STRUCTURE ANCHOR UNIT
GUARDRAIL ANCHOR UNIT TYPE B-77
FOR F-SHAPE BARRIER

SHEET 5 OF 7
862D03

SECTION A-A

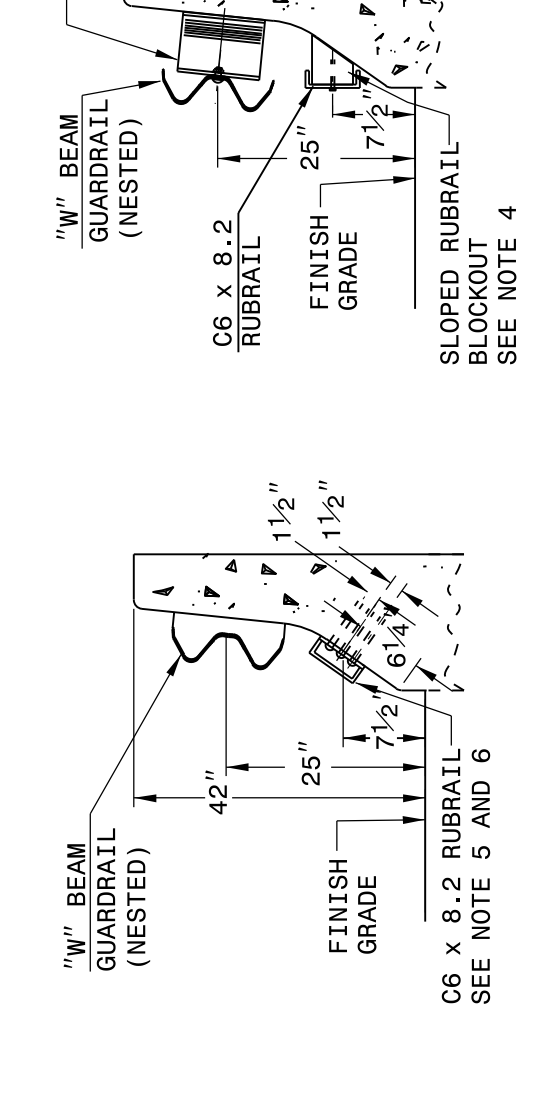


SECTION B-B

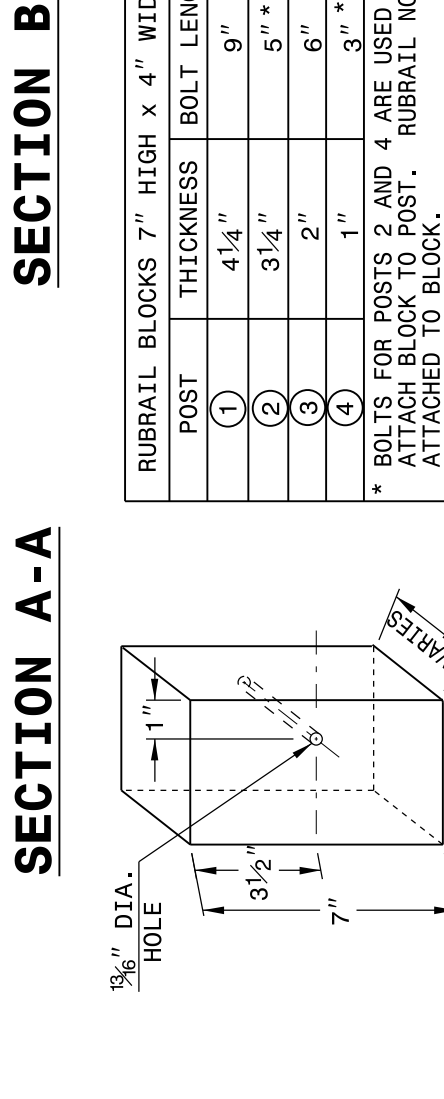


SECTION C-C




SECTION D-D

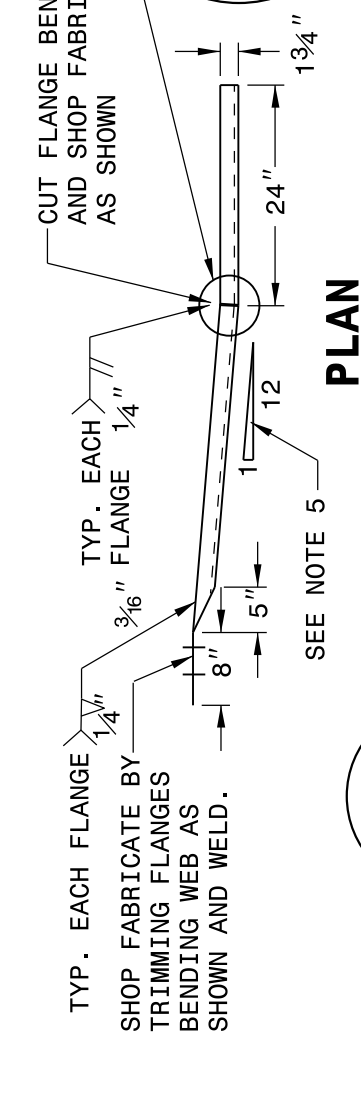

SECTION E-E

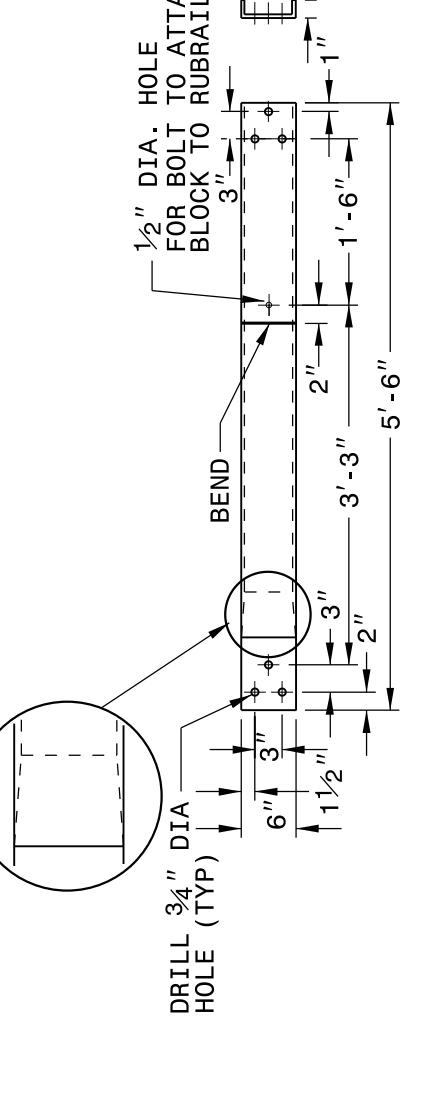

SECTION F-F

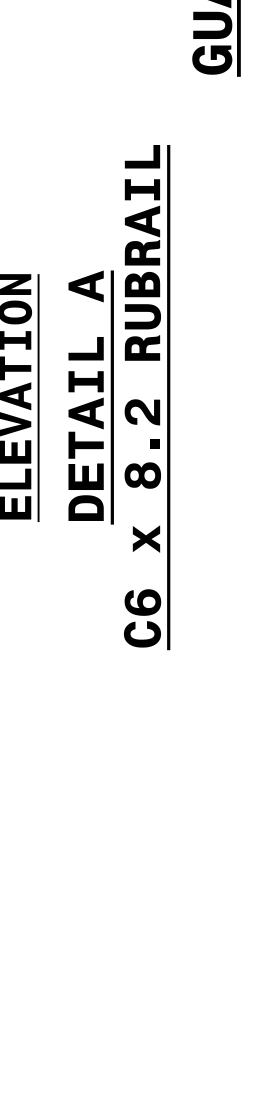

ORIGINAL BY: J. HOWERTON DATE: 06-22-12
MODIFIED BY: DATE:
CHECKED BY: DATE:
FILE SPEC.:

CONTRACT STANDARDS
AND DEVELOPMENT UNIT
Office 919-707-6950 FAX 919-250-4119

SEE TITLE BLOCK





DOCUMENT NOT CONSIDERED FINAL
UNLESS ALL SIGNATURES COMPLETED

DocuSigned by:
Jael S. Howerton, P.E.
022966
6/14/2017

STATE OF
NORTH CAROLINA
DEPT. OF TRANSPORTATION
DIVISION OF HIGHWAYS
RALEIGH, N.C.

ROADWAY DETAIL DRAWING FOR
STRUCTURE ANCHOR UNITS
GUARDRAIL ANCHOR UNIT TYPE B-83

SHEET 6 OF 7
862D03

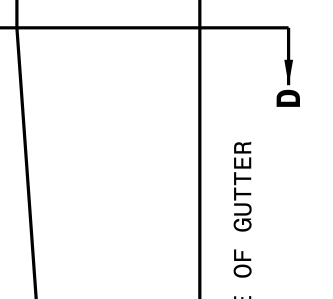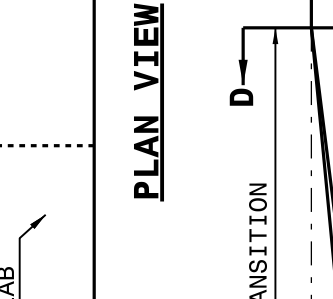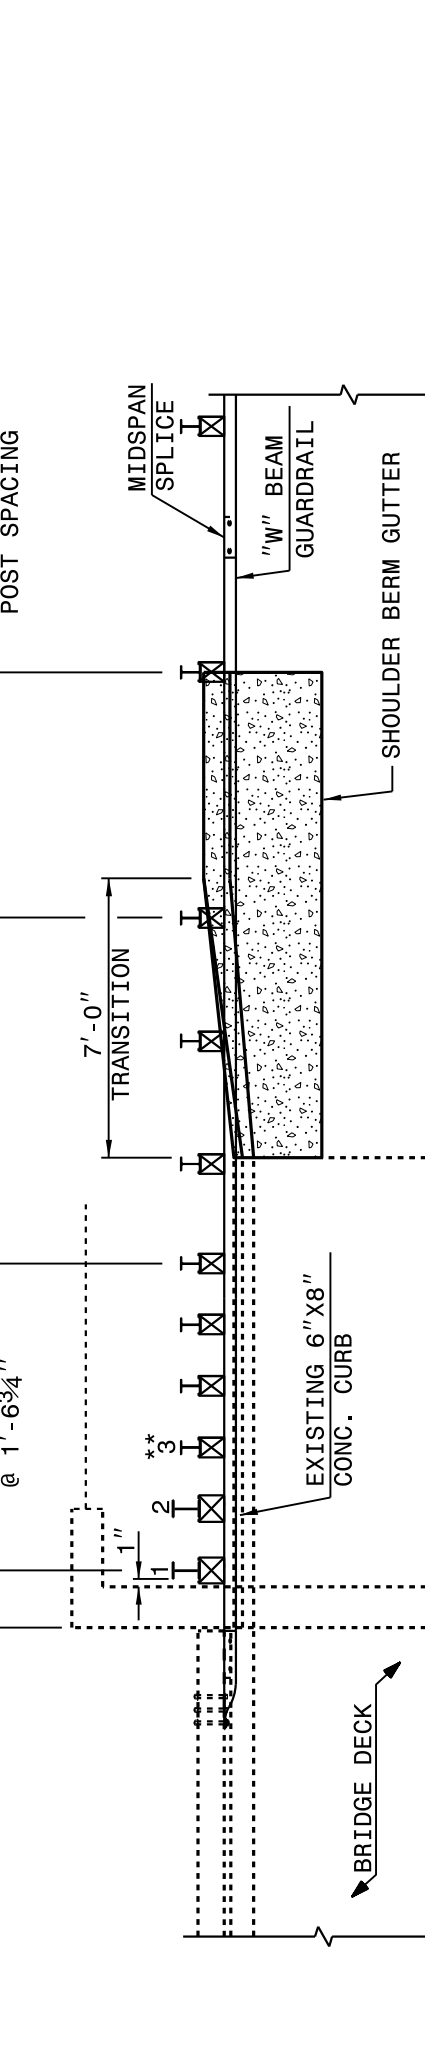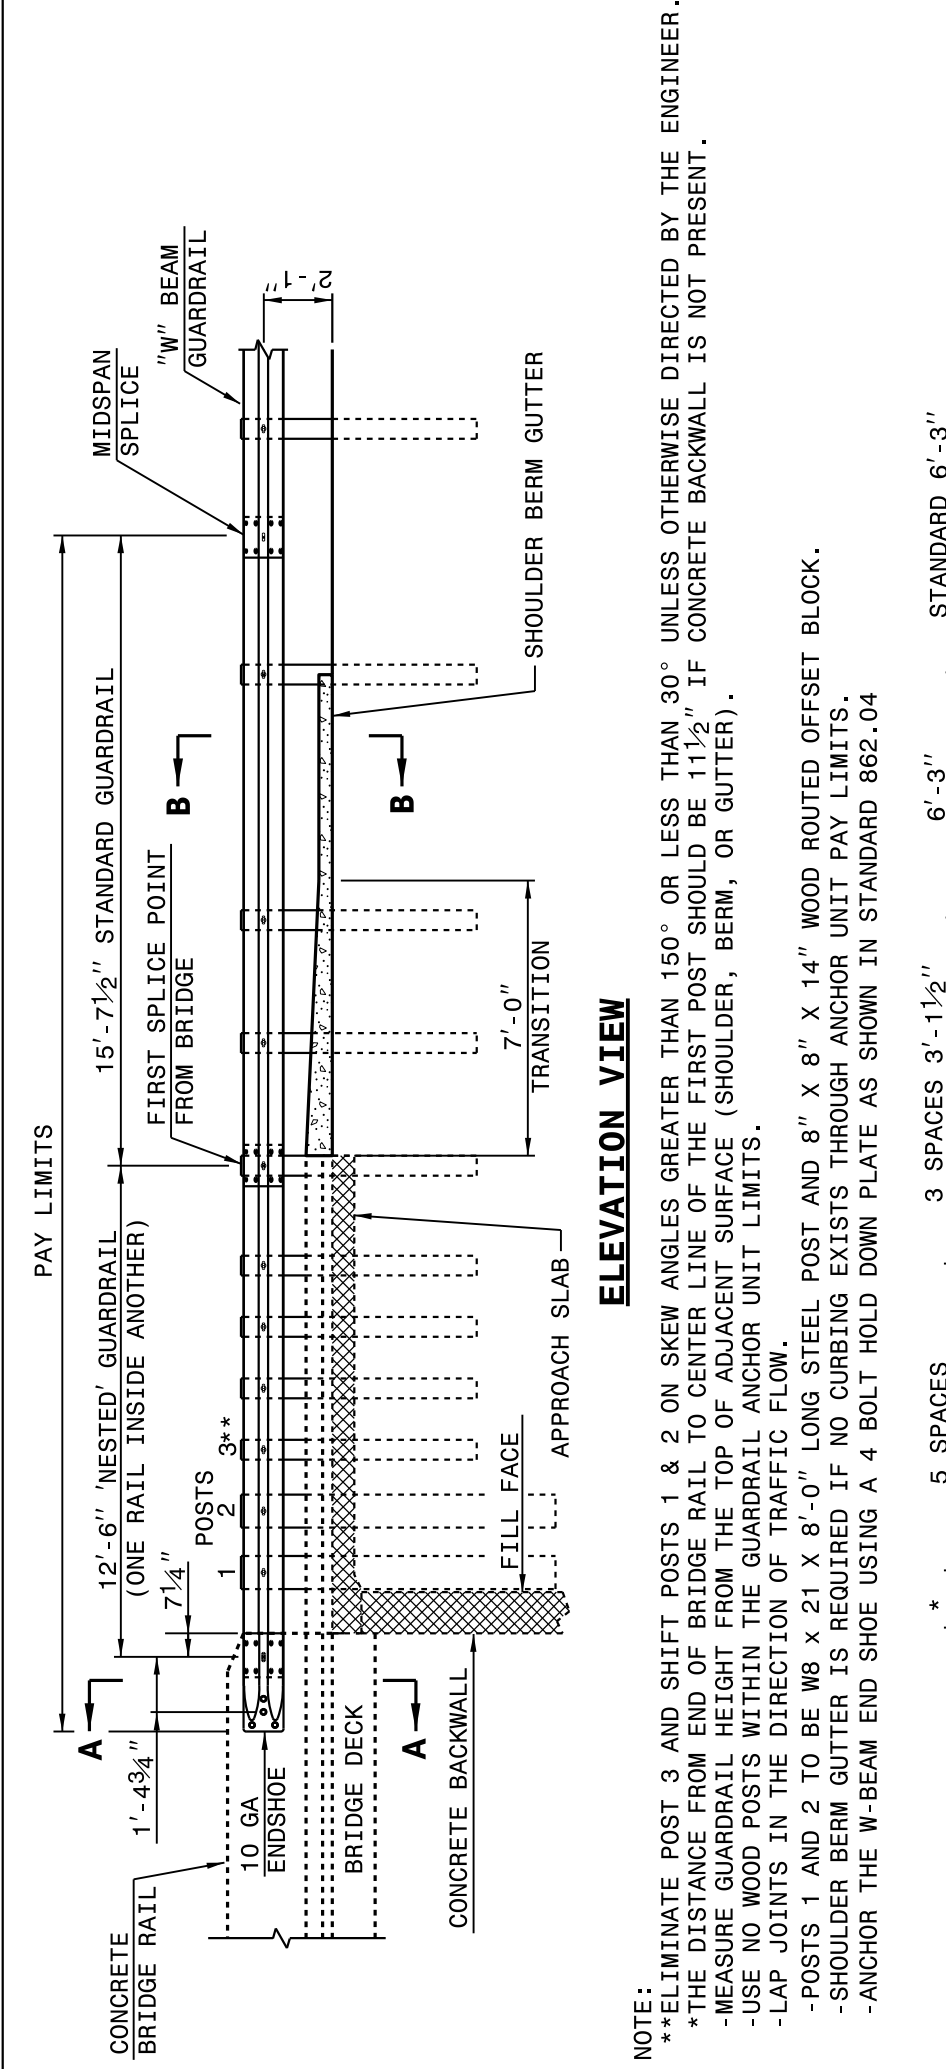

SECTION C-C



SECTION D-D




STATE OF
NORTH CAROLINA
DEPT. OF TRANSPORTATION
DIVISION OF HIGHWAYS
RALEIGH, N.C.


ROADWAY DETAIL DRAWING FOR
STRUCTURE ANCHOR UNIT
GUARDRAIL ANCHOR UNIT TYPE B-77
FOR F-SHAPE BARRIER

SHEET 5 OF 7
862D03

SECTION A-A

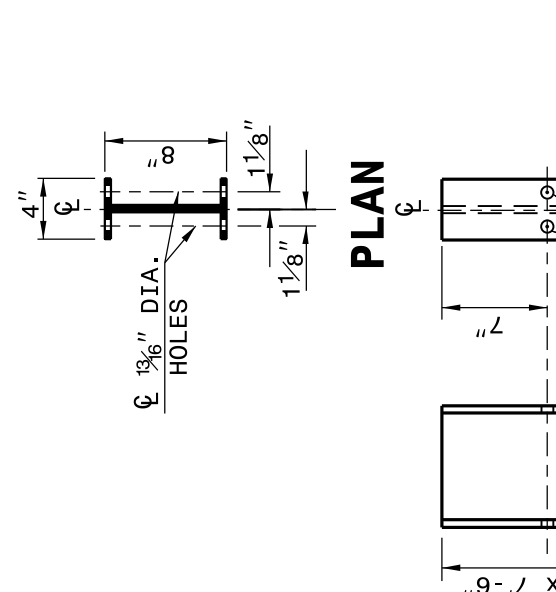


SECTION B-B

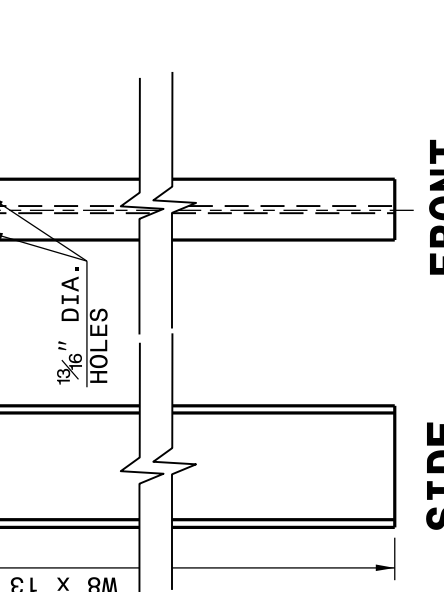


SECTION C-C



SECTION D-D

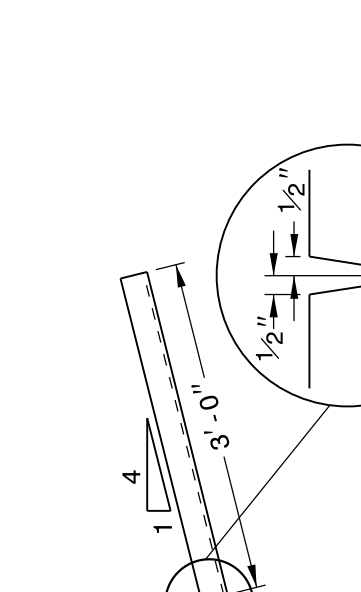


SECTION E-E

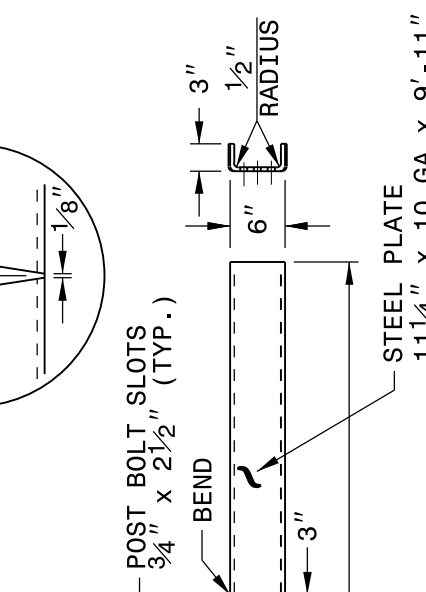

SECTION F-F



Q4-MAY-2017 14155
S:\Contracts\Construction\Special Details\Howerton\Standard Drawings\Details in Lieu of Standards\862d01 862d03 862d03\862d03.dgn
Howerton N.C. 02022015

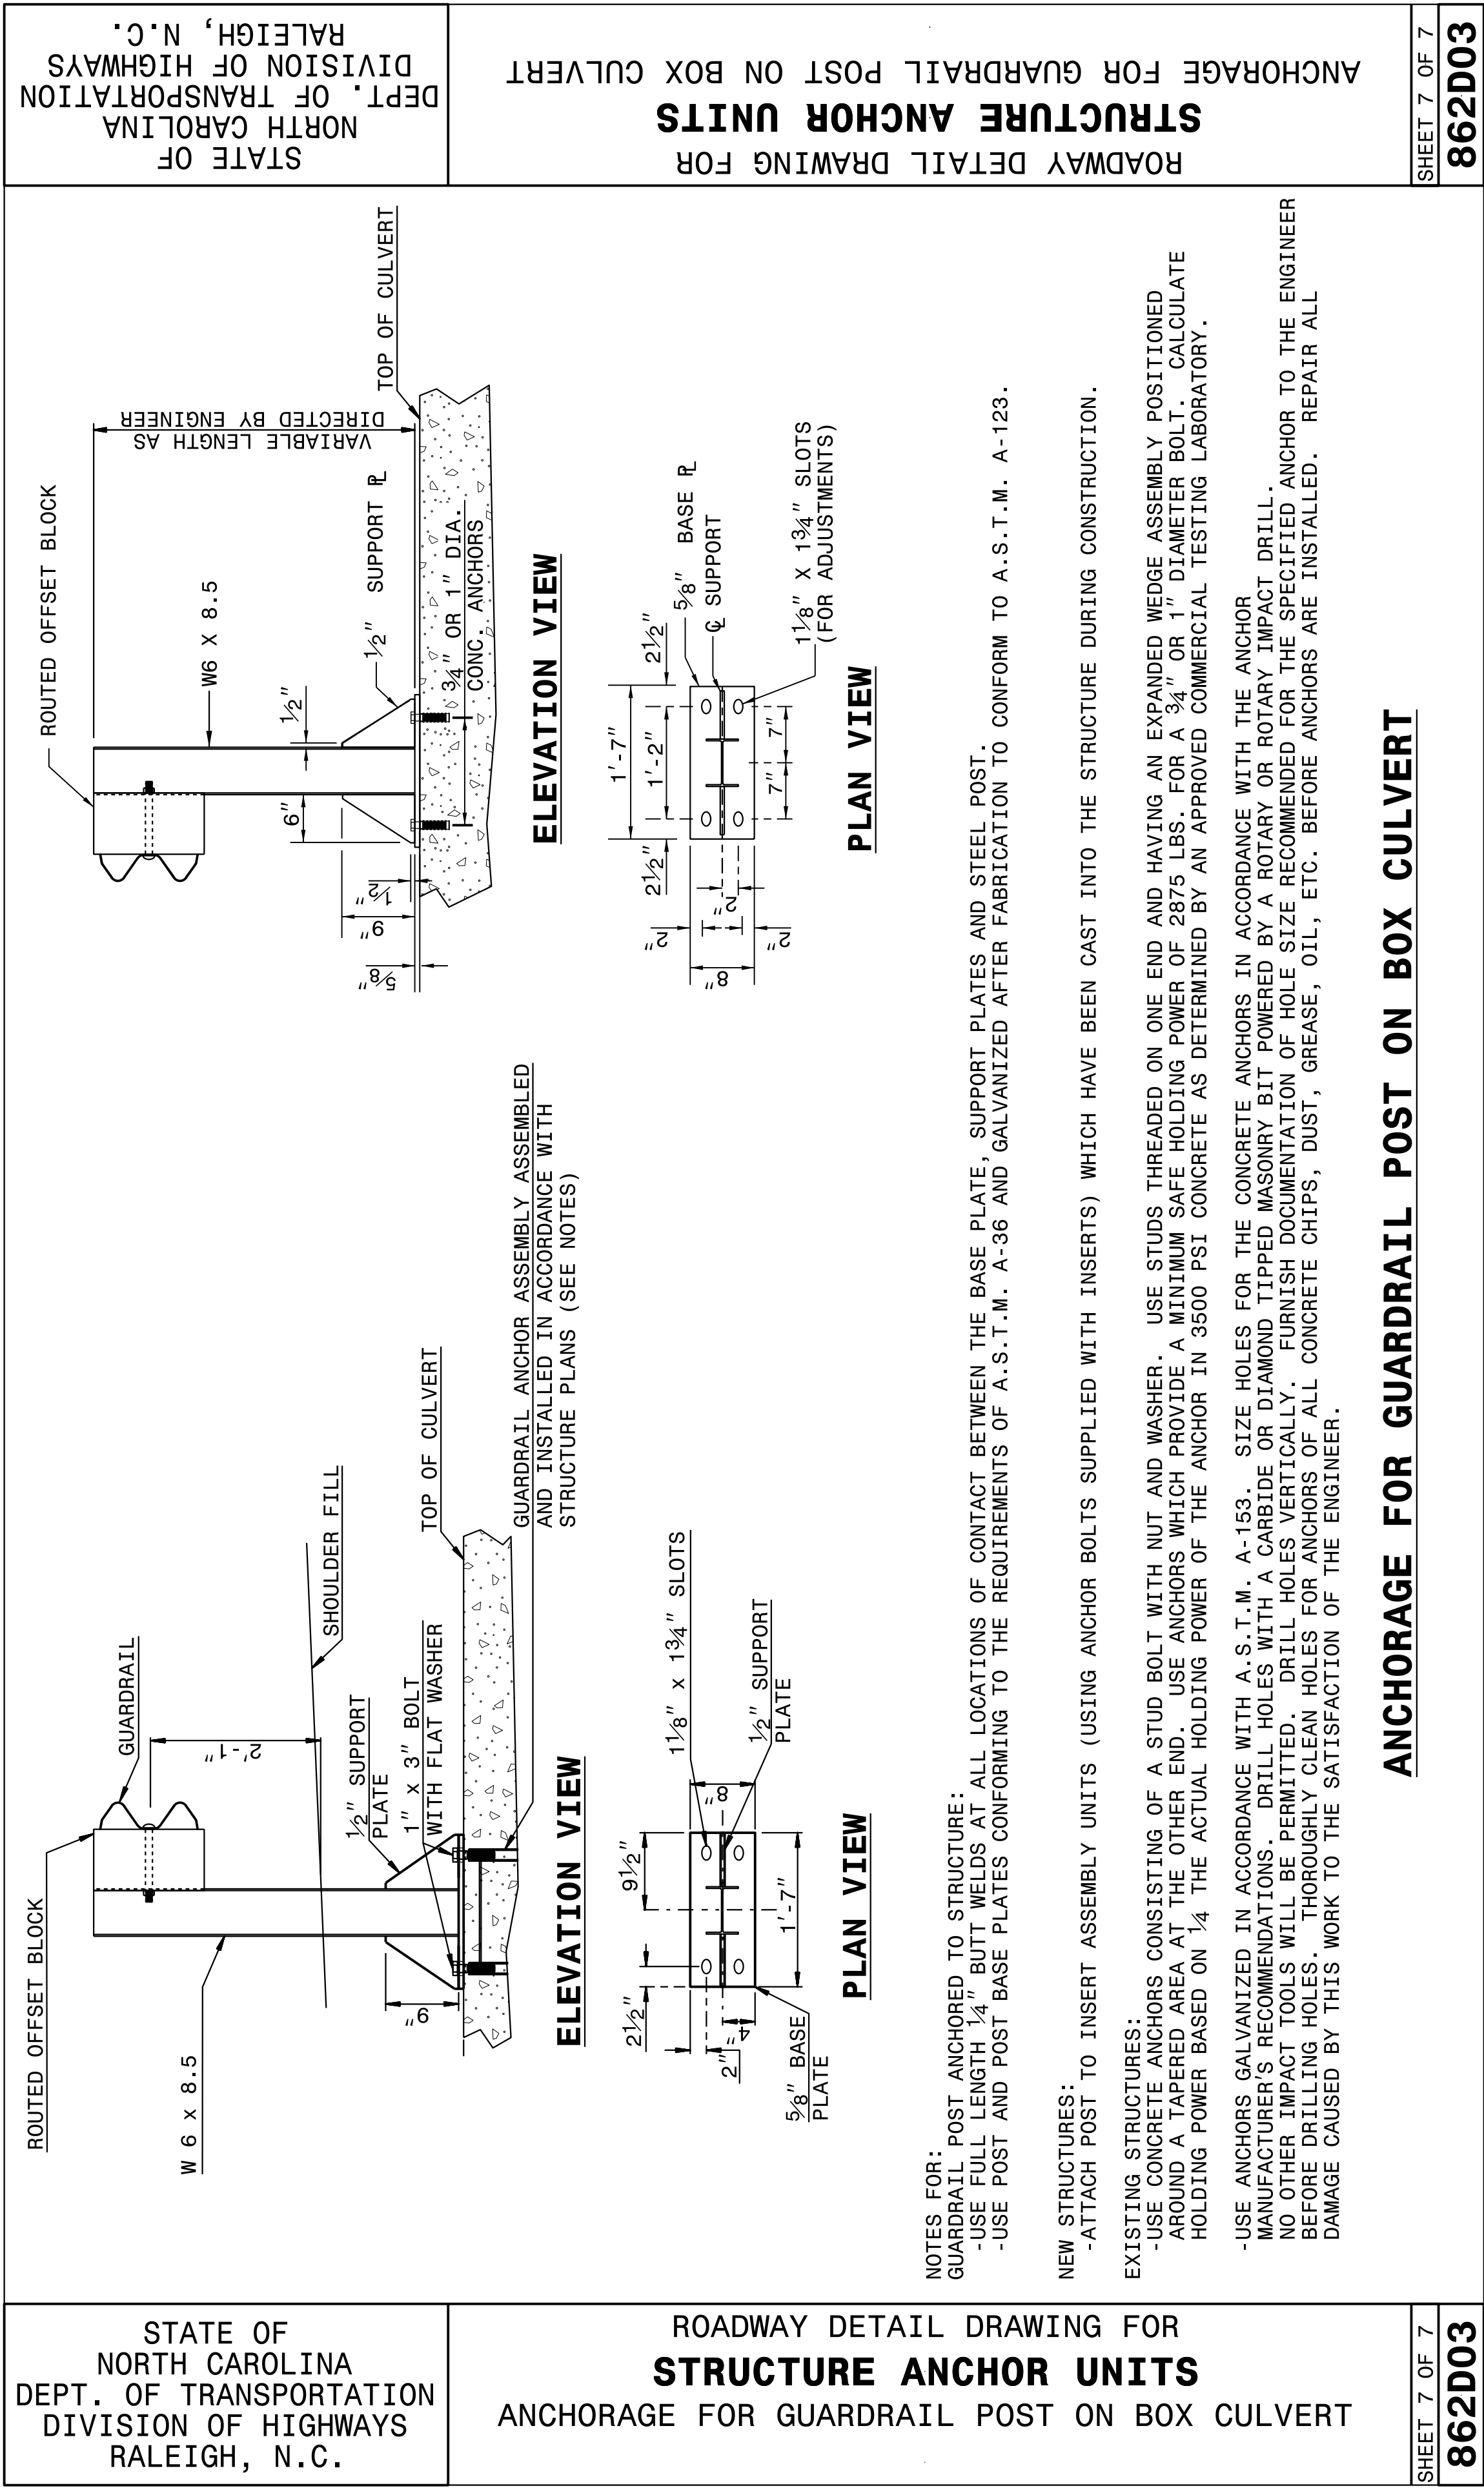

DOCUMENT NOT CONSIDERED FINAL
UNLESS ALL SIGNATURES COMPLETED

CONTRACT STANDARDS
AND DEVELOPMENT UNIT

Office 919-707-6950 FAX 919-250-4119

SEE TITLE BLOCK

ORIGINAL BY: J. HOWERTON DATE: 06-22-12

MODIFIED BY: DATE:

CHECKED BY: DATE:

FILE SPEC.:

DocuSigned by:
Jael S. Howerton, P.E.
873F3D1E-4E40-40C0-8000-000000000000
NORTH CAROLINA
PROFESSIONAL
SEAL
022966
ENGINEER
Jael S. Howerton
6/14/2017

SUMMARY OF EARTHWORK

IN CUBIC YARDS

LOCATION	UNCLASSIFIED EXCAVATION	UNDERCUT	EMBT + %	BORROW	WASTE
9 + 50 – 22 + 00	83		1341		
MATERIAL FOR SHOULDER CONSTRUCTION			63		
5% TO REPLACE TOP SOIL ON BORROW PIT			66		
PROJECT TOTAL	83		1470	1387	
SAY				1400	


****GRADING ON THIS PROJECT WILL BE PAID AS LUMP SUM. SEE SPECIAL PROVISION.**

"N" = DISTANCE FROM EDGE OF LANE TO FACE OF GUARDRAIL.
 TOTAL SHOULDER WIDTH = DISTANCE FROM EDGE OF TRAVEL LANE TO SHOULDER BREAK POINT.
 FLARE LENGTH = DISTANCE FROM LAST SECTION OF PARALLEL GUARDRAIL TO END OF GUARDRAIL.
 W = TOTAL WIDTH OF FLARE FROM BEGINNING OF TAPER TO END OF GUARDRAIL.
 G = GATING IMPACT ATTENUATOR TYPE 350
 NG = NON-GATING IMPACT ATTENUATOR TYPE 350

GUARDRAIL SUMMARY

[illegible]

14-JUN-2017 12:55
H:\ODC\Projects\W-5601CC (SR 1229) McDougald Rd - Harnett\Roadway\proj\W-5601CC_Rdy-sum.dgn
H:\ODC\Projects\W-5601CC (SR 1229) McDougald Rd - Harnett\Roadway\proj\W-5601CC_Rdy-sum.dgn

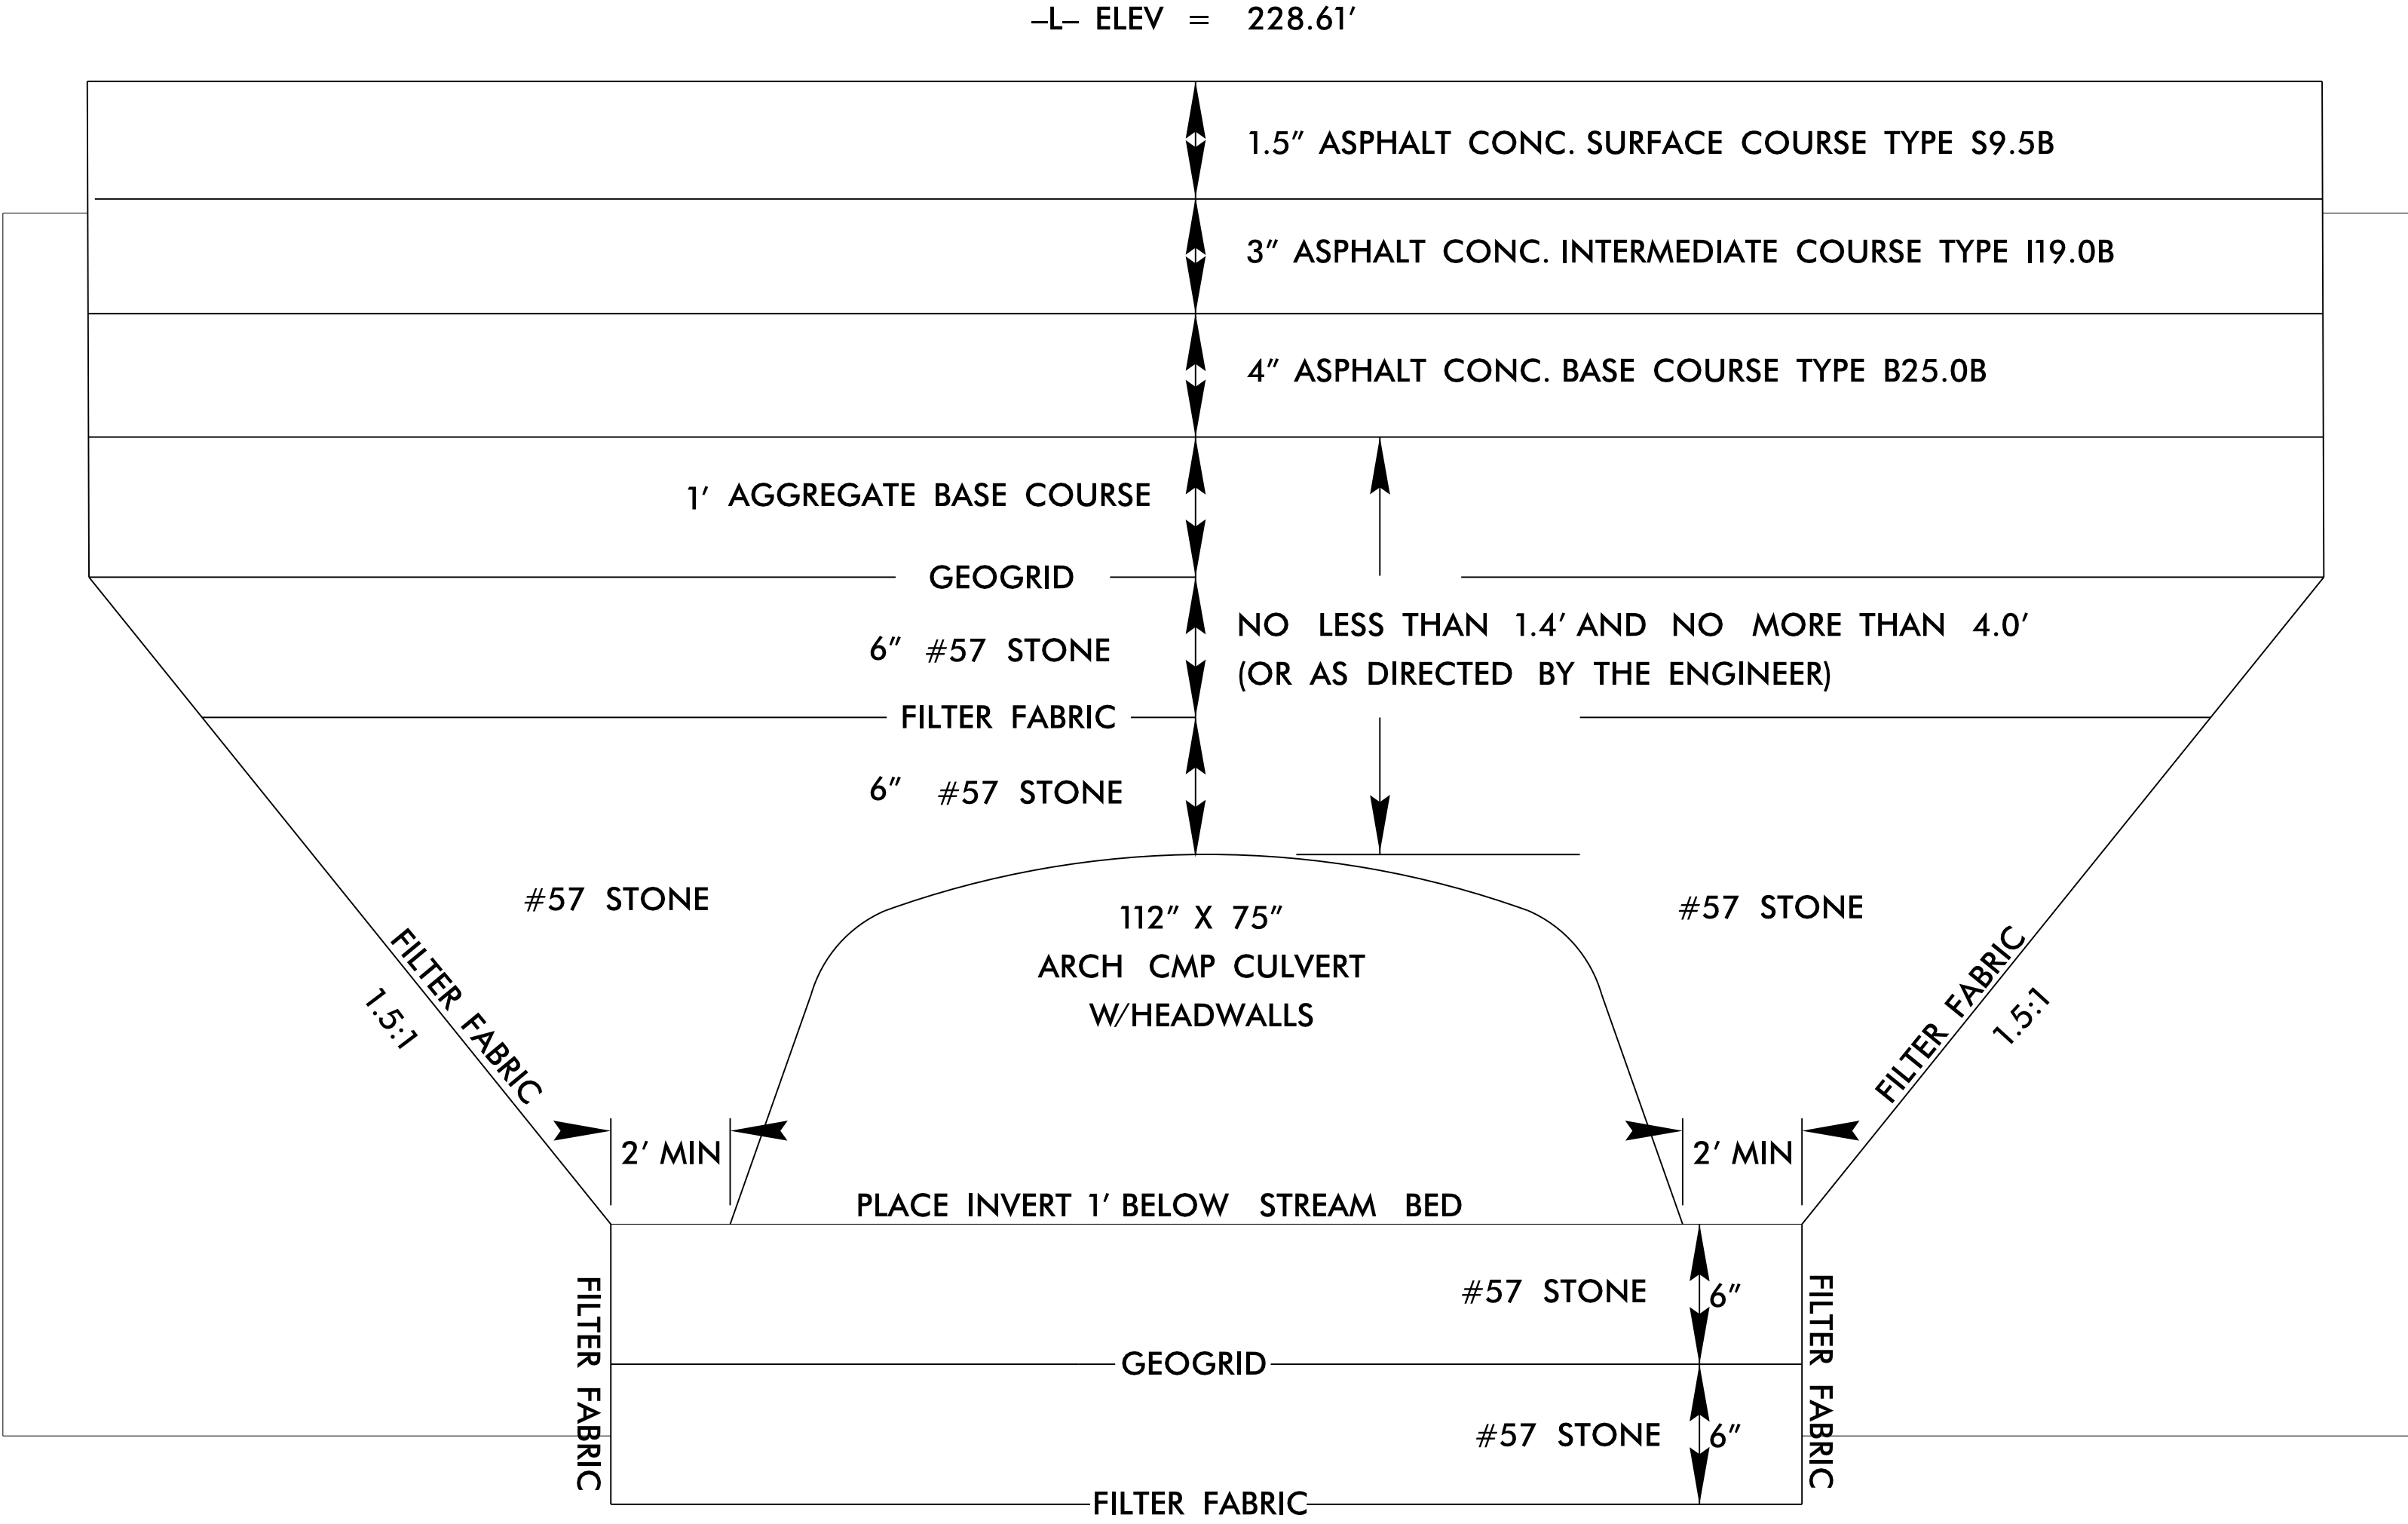


GEOGRID AND FILTER FABRIC ARE INCIDENTAL TO LINE ITEM "PIPE & HEADWALL (ASSEMBLE AND INSTALL) 112" X 75""
NO ADDITIONAL PAYMENT WILL BE MADE FOR THE MATERIAL OR INSTALLATION OF THESE ITEMS. SEE SPECIAL PROVISION.

REVISIONS

14-JUN-2017 12:55 8/17/99
S:\Users\jason\Projects\W-5601CC\W-5601CC_Rdy.psh-4.dgn
S:\Users\jason\Projects\W-5601CC\W-5601CC_Rdy.psh-4.dgn

DATUM DESCRIPTION
THE LOCALIZED COORDINATE SYSTEM DEVELOPED FOR THIS PROJECT IS BASED ON THE STATE PLANE COORDINATES ESTABLISHED BY NCDOT FOR MONUMENT "W5601CC b11"
WITH NAD 83/NA 2011 STATE PLANE GRID COORDINATES OF
NORTHING: 599697.344(ft) EASTING: 2032340.924(ft)
ELEVATION: 259.28(ft)
THE AVERAGE COMBINED GRID FACTOR USED ON THIS PROJECT (GROUND TO GRID) IS: 0.9998693
THE N.C. LAMBERT GRID BEARING AND LOCALIZED HORIZONTAL GROUND DISTANCE FROM "W5601CC BL1" TO -L- STATION 9+50.00 IS
N73°52'7.26"E 132.17'(ft)
ALL LINEAR DIMENSIONS ARE LOCALIZED HORIZONTAL DISTANCES
VERTICAL DATUM USED IS NAVD 88

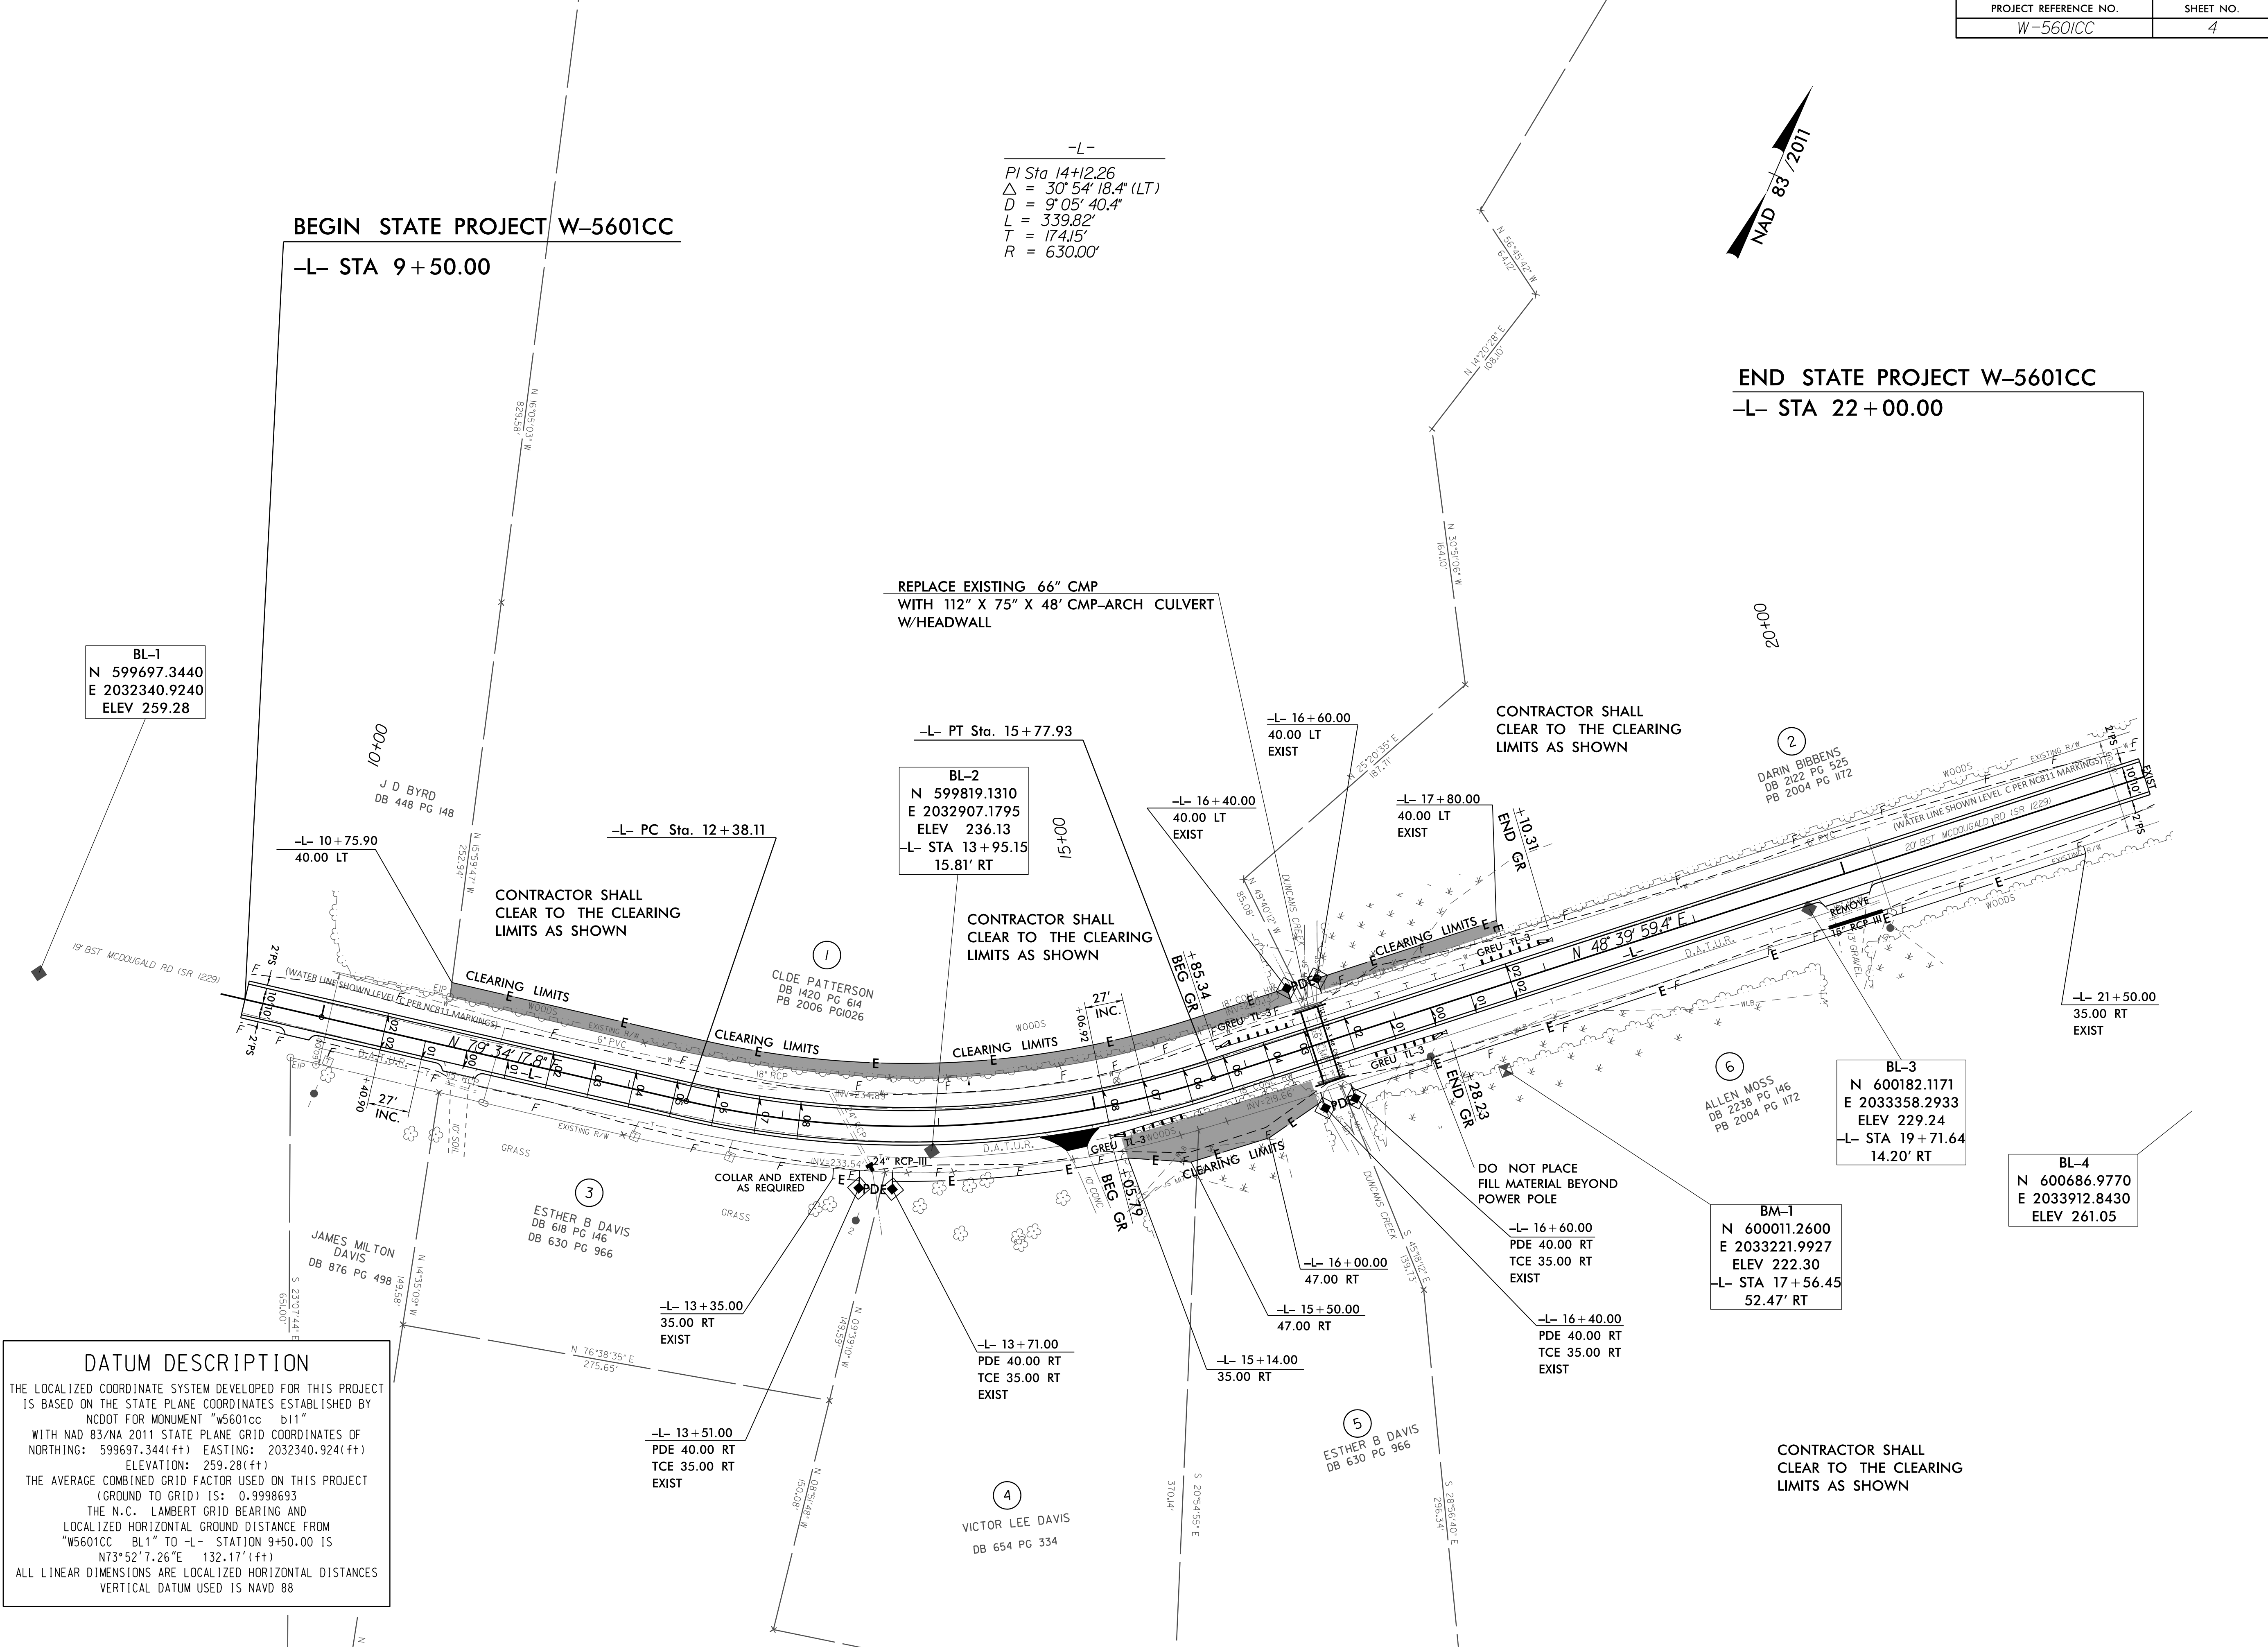

TIP PROJECT:

W-560ICC

STATE OF NORTH CAROLINA
DIVISION OF HIGHWAYS

PLAN FOR PROPOSED
TRAFFIC CONTROL, MARKING & DELINEATION
HARNETT COUNTY

ROADWAY STANDARD DRAWINGS

THE FOLLOWING ROADWAY STANDARDS AS APPEAR IN "ROADWAY STANDARD DRAWINGS" - PROJECT SERVICES UNIT - N.C. DEPARTMENT OF TRANSPORTATION - RALEIGH, N.C., DATED JULY 2012 ARE APPLICABLE TO THIS PROJECT AND BY REFERENCE HEREBY ARE CONSIDERED A PART OF THESE PLANS:

STD. NO.	TITLE
1101.03	TEMPORARY ROAD CLOSURES
1110.01	STATIONARY WORK ZONE SIGNS
1145.01	BARRICADES
1101.03	TEMPORARY ROAD CLOSURES
1101.04	TEMPORARY SHOULDER CLOSURES
1101.05	WORK ZONE VEHICLE ACCESSES
1101.11	TRAFFIC CONTROL DESIGN TABLES
1110.01	STATIONARY WORK ZONE SIGNS
1110.02	PORTABLE WORK ZONE SIGNS
1130.01	DRUMS
1135.01	CONES
1145.01	BARRICADES
1150.01	FLAGGING DEVICES
1180.01	SKINNY-DRUM
1205.01	PAVEMENT MARKINGS - LINE TYPES & OFFSETS
1205.02	PAVEMENT MARKINGS - 2 LANE & MULTILANE ROADWAYS
1250.01	PAVEMENT MARKER SPACING
1251.01	RAISED PAVEMENT MARKERS - (TEMPORARY & PERMANENT)

PHASING

PHASE 1: INCLUDES ALL WORK OFF THE EXISTING ROAD, OUT OF TRAFFIC.

PHASE 2: INCLUDES THE CLOSING OF SR 1229 AND UTILIZING THE OFF SITE DETOUR TO INSTALL THE BOX CULVERT, TIE IN THE NEW ALIGNMENT AT BOTH ENDS OF THE PROJECT, AND PLACE FINAL SURFACE COURSE AND PAVEMENT MARKINGS (ICT No.3). MESSAGE BOARDS SHALL BE IN PLACE FOR THE DURATION OF ROAD CLOSURE.

INDEX OF SHEETS

SHEET NO.	TITLE
TCP-1	LIST OF APPLICABLE ROADWAY STANDARD DRAWINGS, LEGEND AND INDEX OF SHEETS
TCP-2	DETOUR AND SIGNING

GENERAL NOTES

CHANGES MAY BE REQUIRED WHEN PHYSICAL DIMENSIONS IN THE DETAIL DRAWINGS, STANDARD DETAILS, AND ROADWAY DETAILS ARE NOT ATTAINABLE TO MEET FIELD CONDITIONS OR RESULT IN DUPLICATE OR UNDESIRED OVERLAPPING OF DEVICES. MODIFICATION MAY INCLUDE: MOVING, SUPPLEMENTING, COVERING, OR REMOVAL OF DEVICES AS DIRECTED BY THE ENGINEER.

THE FOLLOWING GENERAL NOTES APPLY AT ALL TIMES FOR THE DURATION OF THE CONSTRUCTION PROJECT EXCEPT WHEN OTHERWISE NOTED IN THE PLAN OR DIRECTED BY THE ENGINEER.

TRAFFIC PATTERN ALTERATIONS

A) NOTIFY THE ENGINEER THIRTY (30) CALENDAR DAYS PRIOR TO ANY TRAFFIC PATTERN ALTERATION.

SIGNING

B) PROVIDE SIGNING AND DEVICES REQUIRED TO CLOSE THE ROAD ACCORDING TO THE ROADWAY STANDARD DRAWINGS AND TRAFFIC CONTROL PLANS.

PROVIDE SIGNING REQUIRED FOR THE OFF-SITE DETOUR ROUTE AS SHOWN IN THE TRAFFIC CONTROL PLANS.

C) COVER OR REMOVE ALL SIGNS AND DEVICES REQUIRED TO CLOSE THE ROAD WHEN ROAD CLOSURE IS NOT IN OPERATION.

COVER OR REMOVE ALL SIGNS REQUIRED FOR THE OFF-SITE DETOUR WHEN THE DETOUR IS NOT IN OPERATION.

 
 
D) ENSURE ALL NECESSARY SIGNING IS IN PLACE PRIOR TO ALTERING ANY TRAFFIC PATTERN.

TRAFFIC CONTROL DEVICES




E) PLACE TYPE III BARRICADES, WITH "ROAD CLOSED" SIGN R11-2 ATTACHED, OF SUFFICIENT LENGTH TO CLOSE ENTIRE ROADWAY.

LEGEND

GENERAL

-  DIRECTION OF TRAFFIC FLOW
-  NORTH ARROW
-  PROPOSED PVMT.  EXIST. PVMT.
-  WORK AREA
-  REMOVAL OF EXISTING PAVEMENT

   
TRAFFIC CONTROL DEVICES

-  TYPE I BARRICADE
-  TYPE II BARRICADE
-  TYPE III BARRICADE
-  CONE
-  DRUM  SKINNY DRUM
-  FLASHING ARROW PANEL (TYPE C)
-  STATIONARY SIGN
-  PORTABLE SIGN
-  STATIONARY OR PORTABLE SIGN
-  CRASH CUSHION
-  CHANGEABLE MESSAGE SIGN
-  TRUCK MOUNTED IMPACT ATTENUATOR (TMIA)
-  POLICE
-  FLAGGER

PAVEMENT MARKINGS

-  CRYSTAL/CRYSTAL PAVEMENT MARKER
-  YELLOW/YELLOW PAVEMENT MARKER
-  CRYSTAL/RED PAVEMENT MARKER
-  PAVEMENT MARKING SYMBOLS


I2-APR-2017 13:21
H:\DDC\Projects\W-5601CC (SR 1229) McDougald Rd - Harnett\TCP\W-5601CC_TC_TCP-2.dgn
\$\$\$\$\$USERNAME\$\$\$\$\$

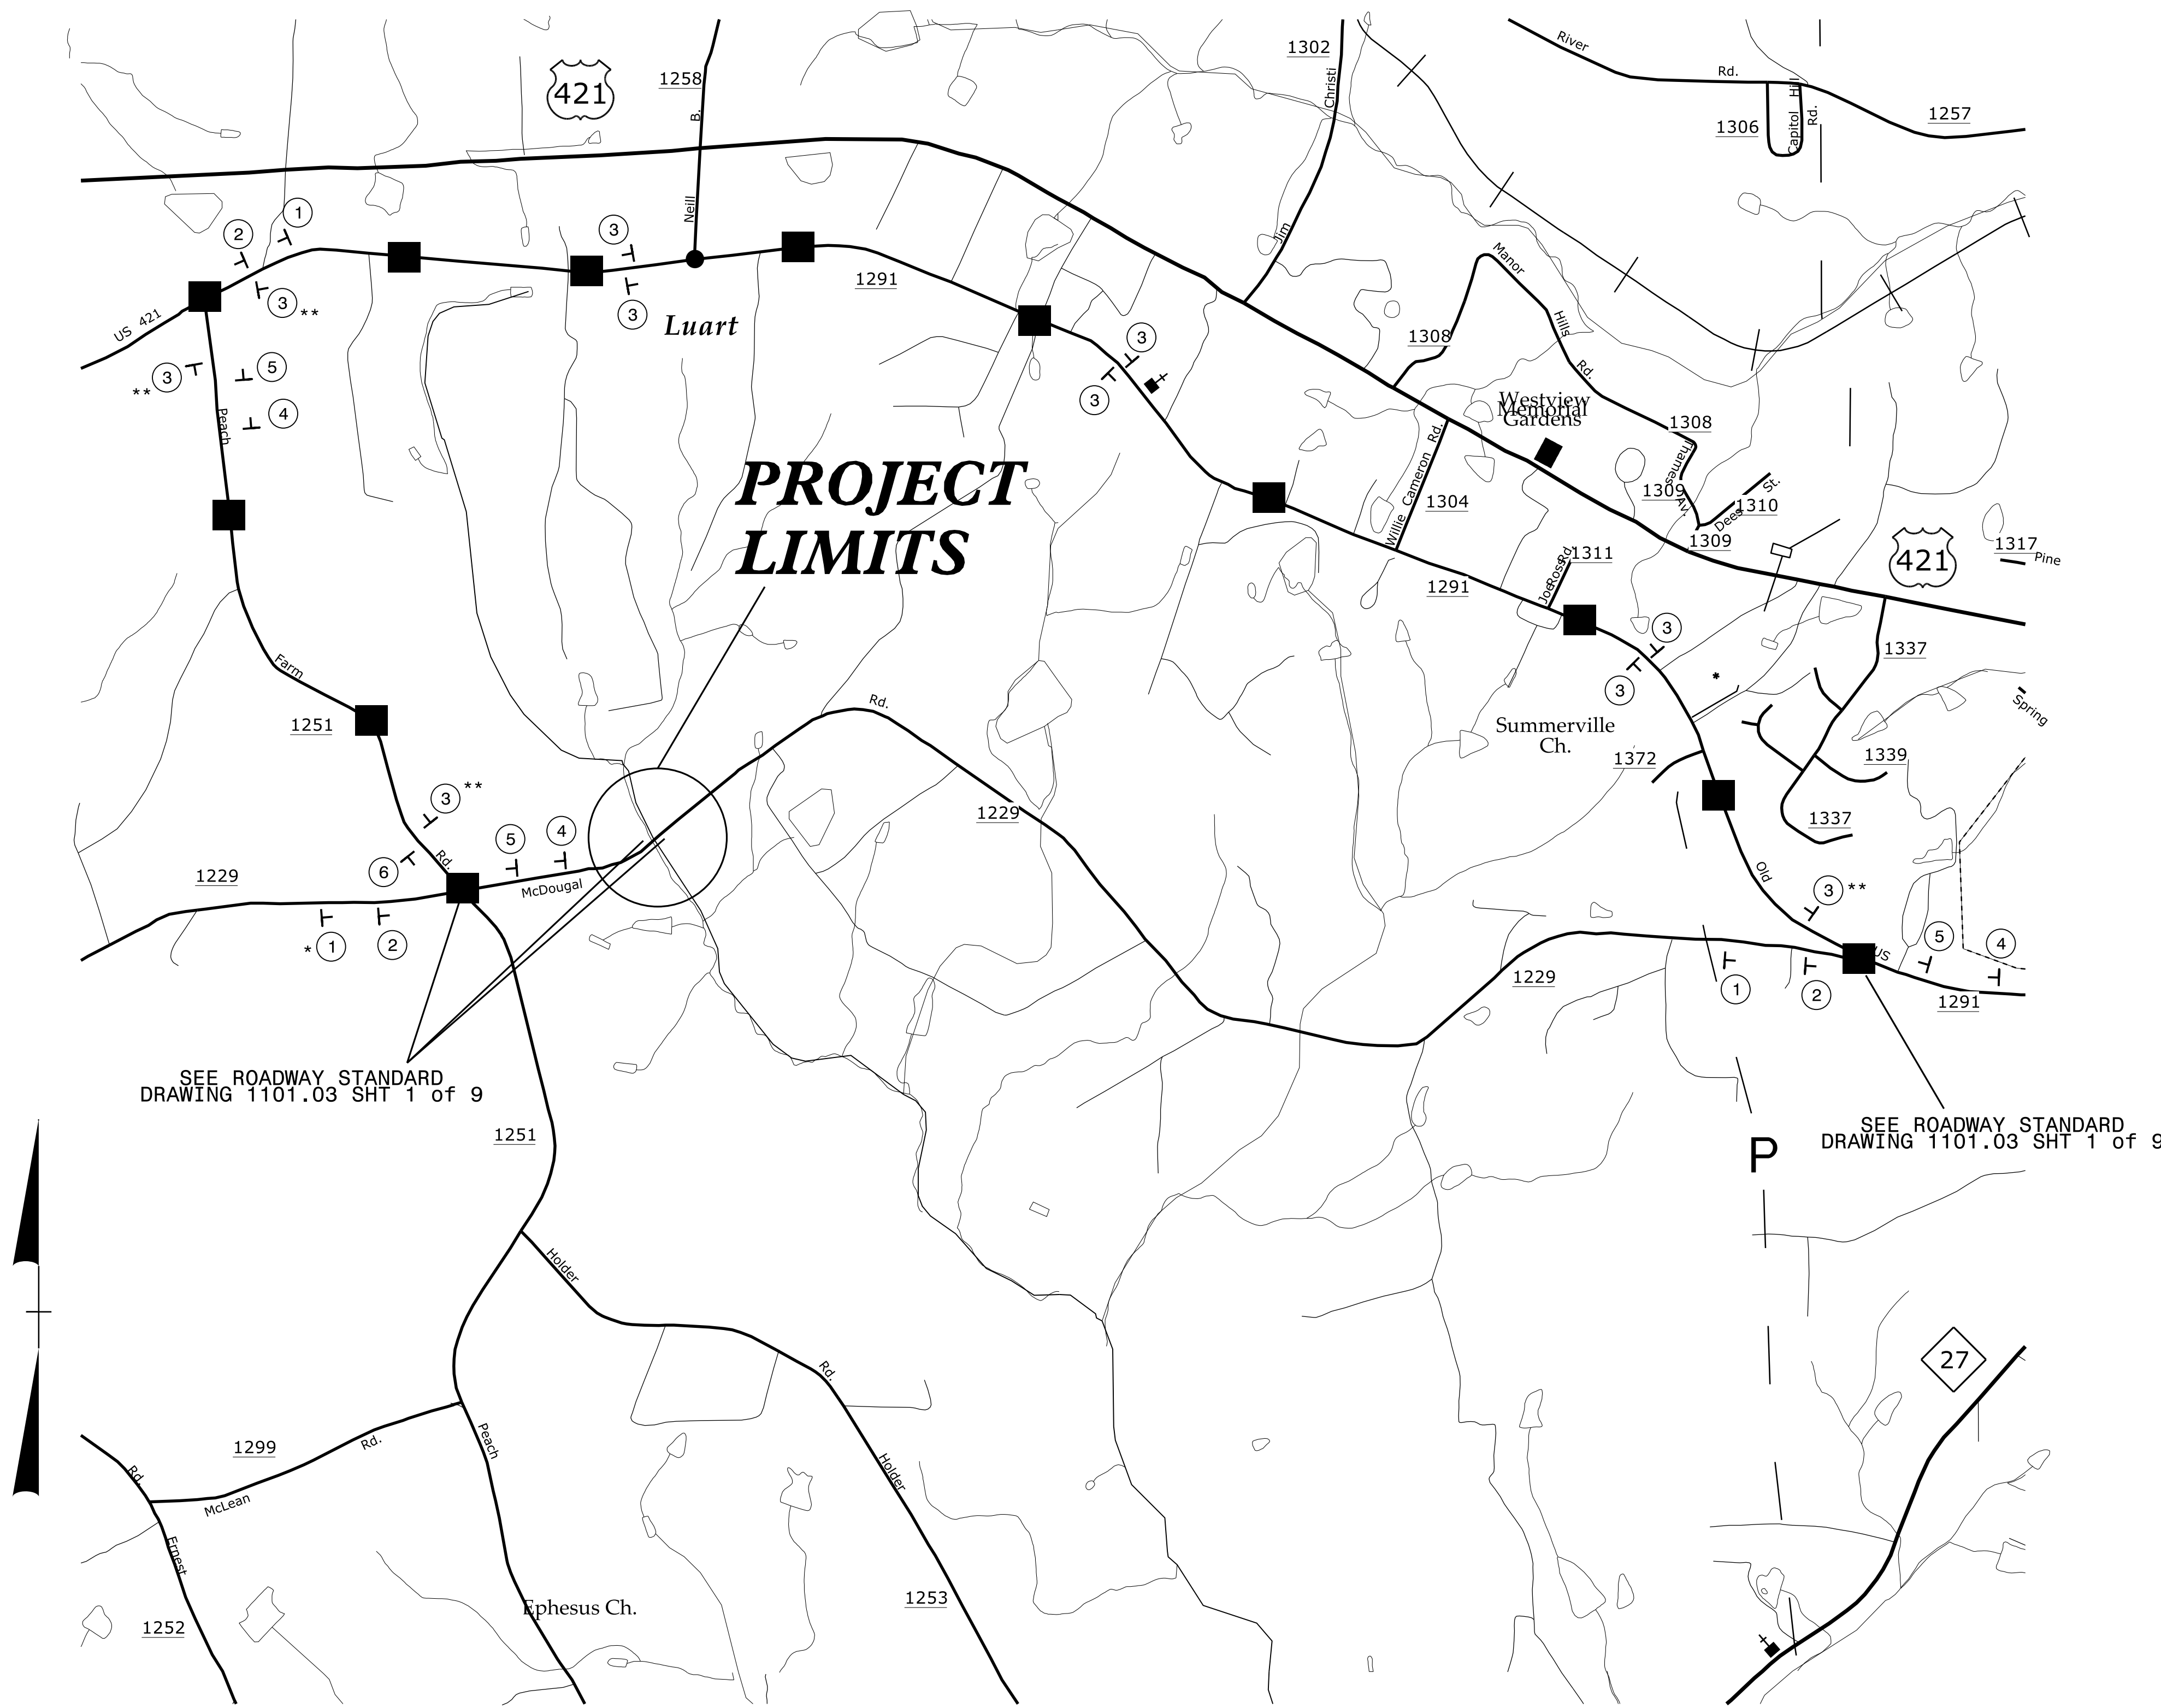

NOTE

① ④ * 1,000 FEET IN ADVANCE
OF INTERSECTION

 ** 200 FEET +/-
FROM INTERSECTION



DETOUR ROUTE

All work to be performed by
the contractor.

W-5506CC in Harnett Co.

DETOUR PLAN

PROJ. REFERENCE NO.	SHEET NO.
W-5601CC	TCP-2

- 1

DETOUR

M4-8
24" x 12"

SR 1229

M4-8
24" x 12"

M5-1
21" x 15"
- 2

DETOUR

M4-8
24" x 12"

SR 1229

M4-8
24" x 12"

M6-1
21" x 15"
- 3

DETOUR

M4-8
24" x 12"

SR 1229

M4-8
24" x 12"

M6-3
21" X 15"
- 4

DETOUR

M4-8
24" x 12"

SR 1229

M4-8
24" x 12"

M5-1 R
21" X 15"
- 5

DETOUR

M4-8
24" x 12"

SR 1229

M4-8
24" x 12"

M6-1
21" x 15"
- 6

DETOUR


M4-8
24" x 12"

SR 1229


M4-8
24" x 12"

END
DETOUR


M4-8 A
24" X 18"

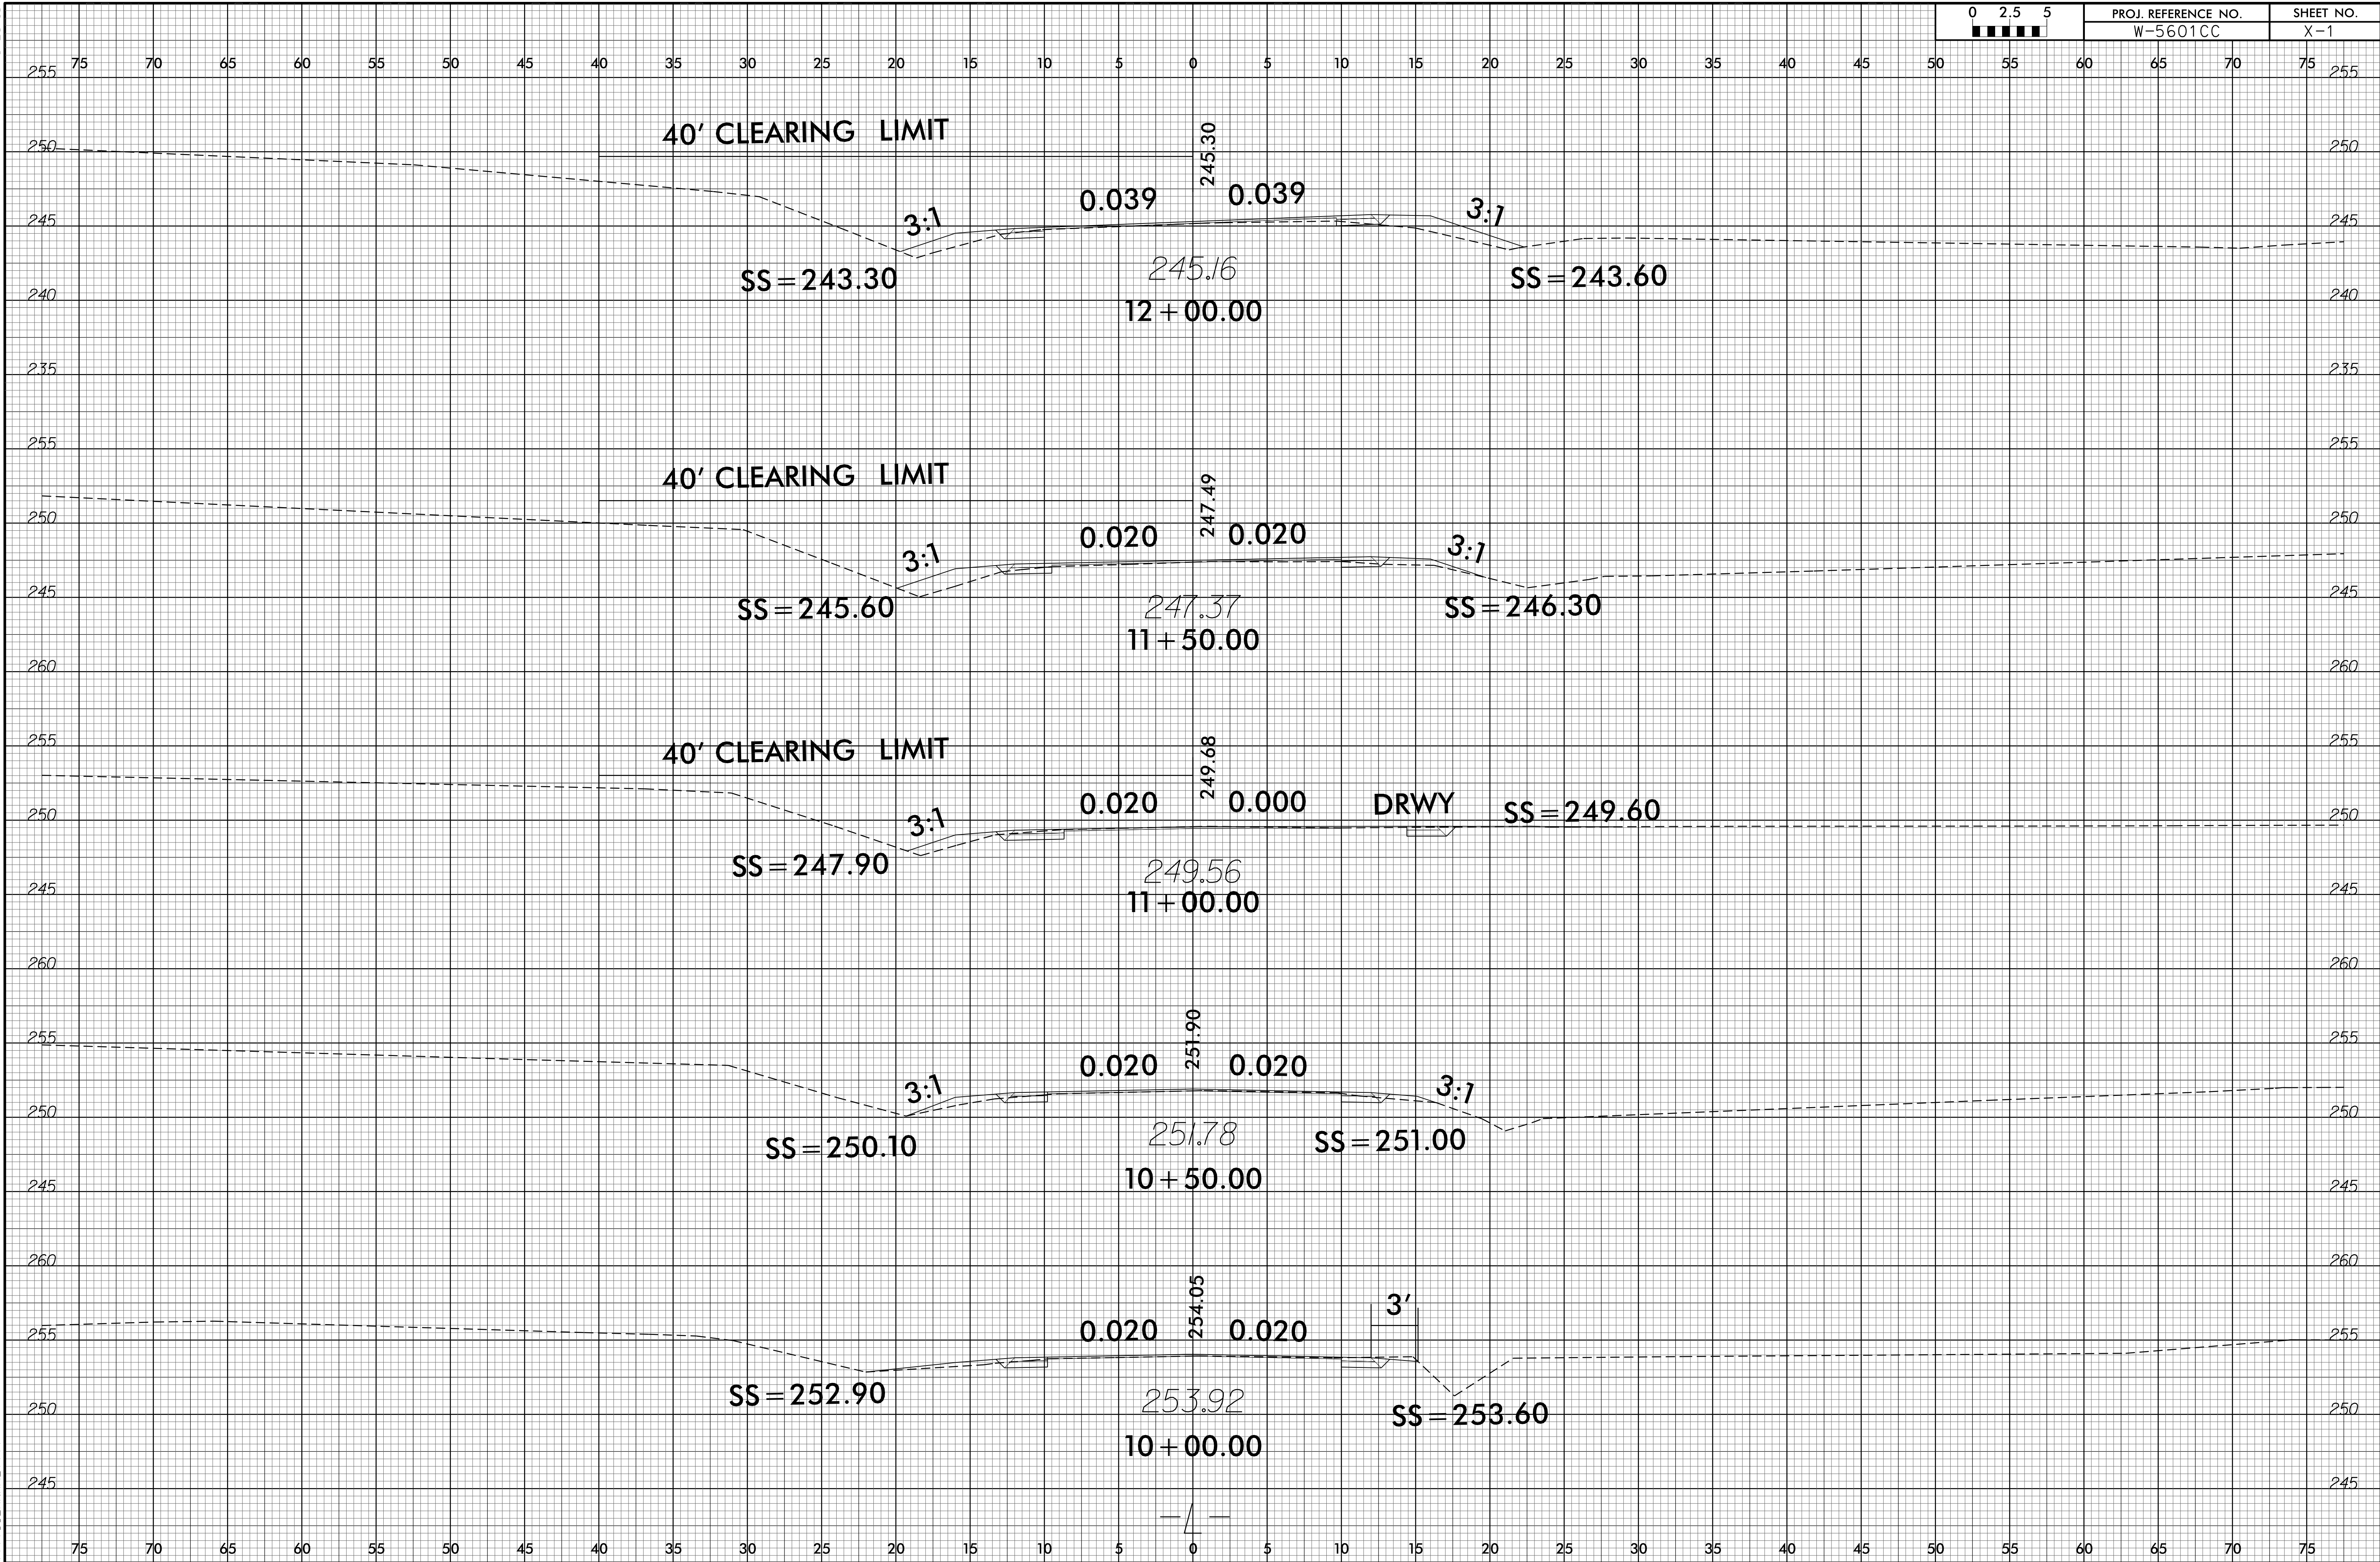

6/23/16

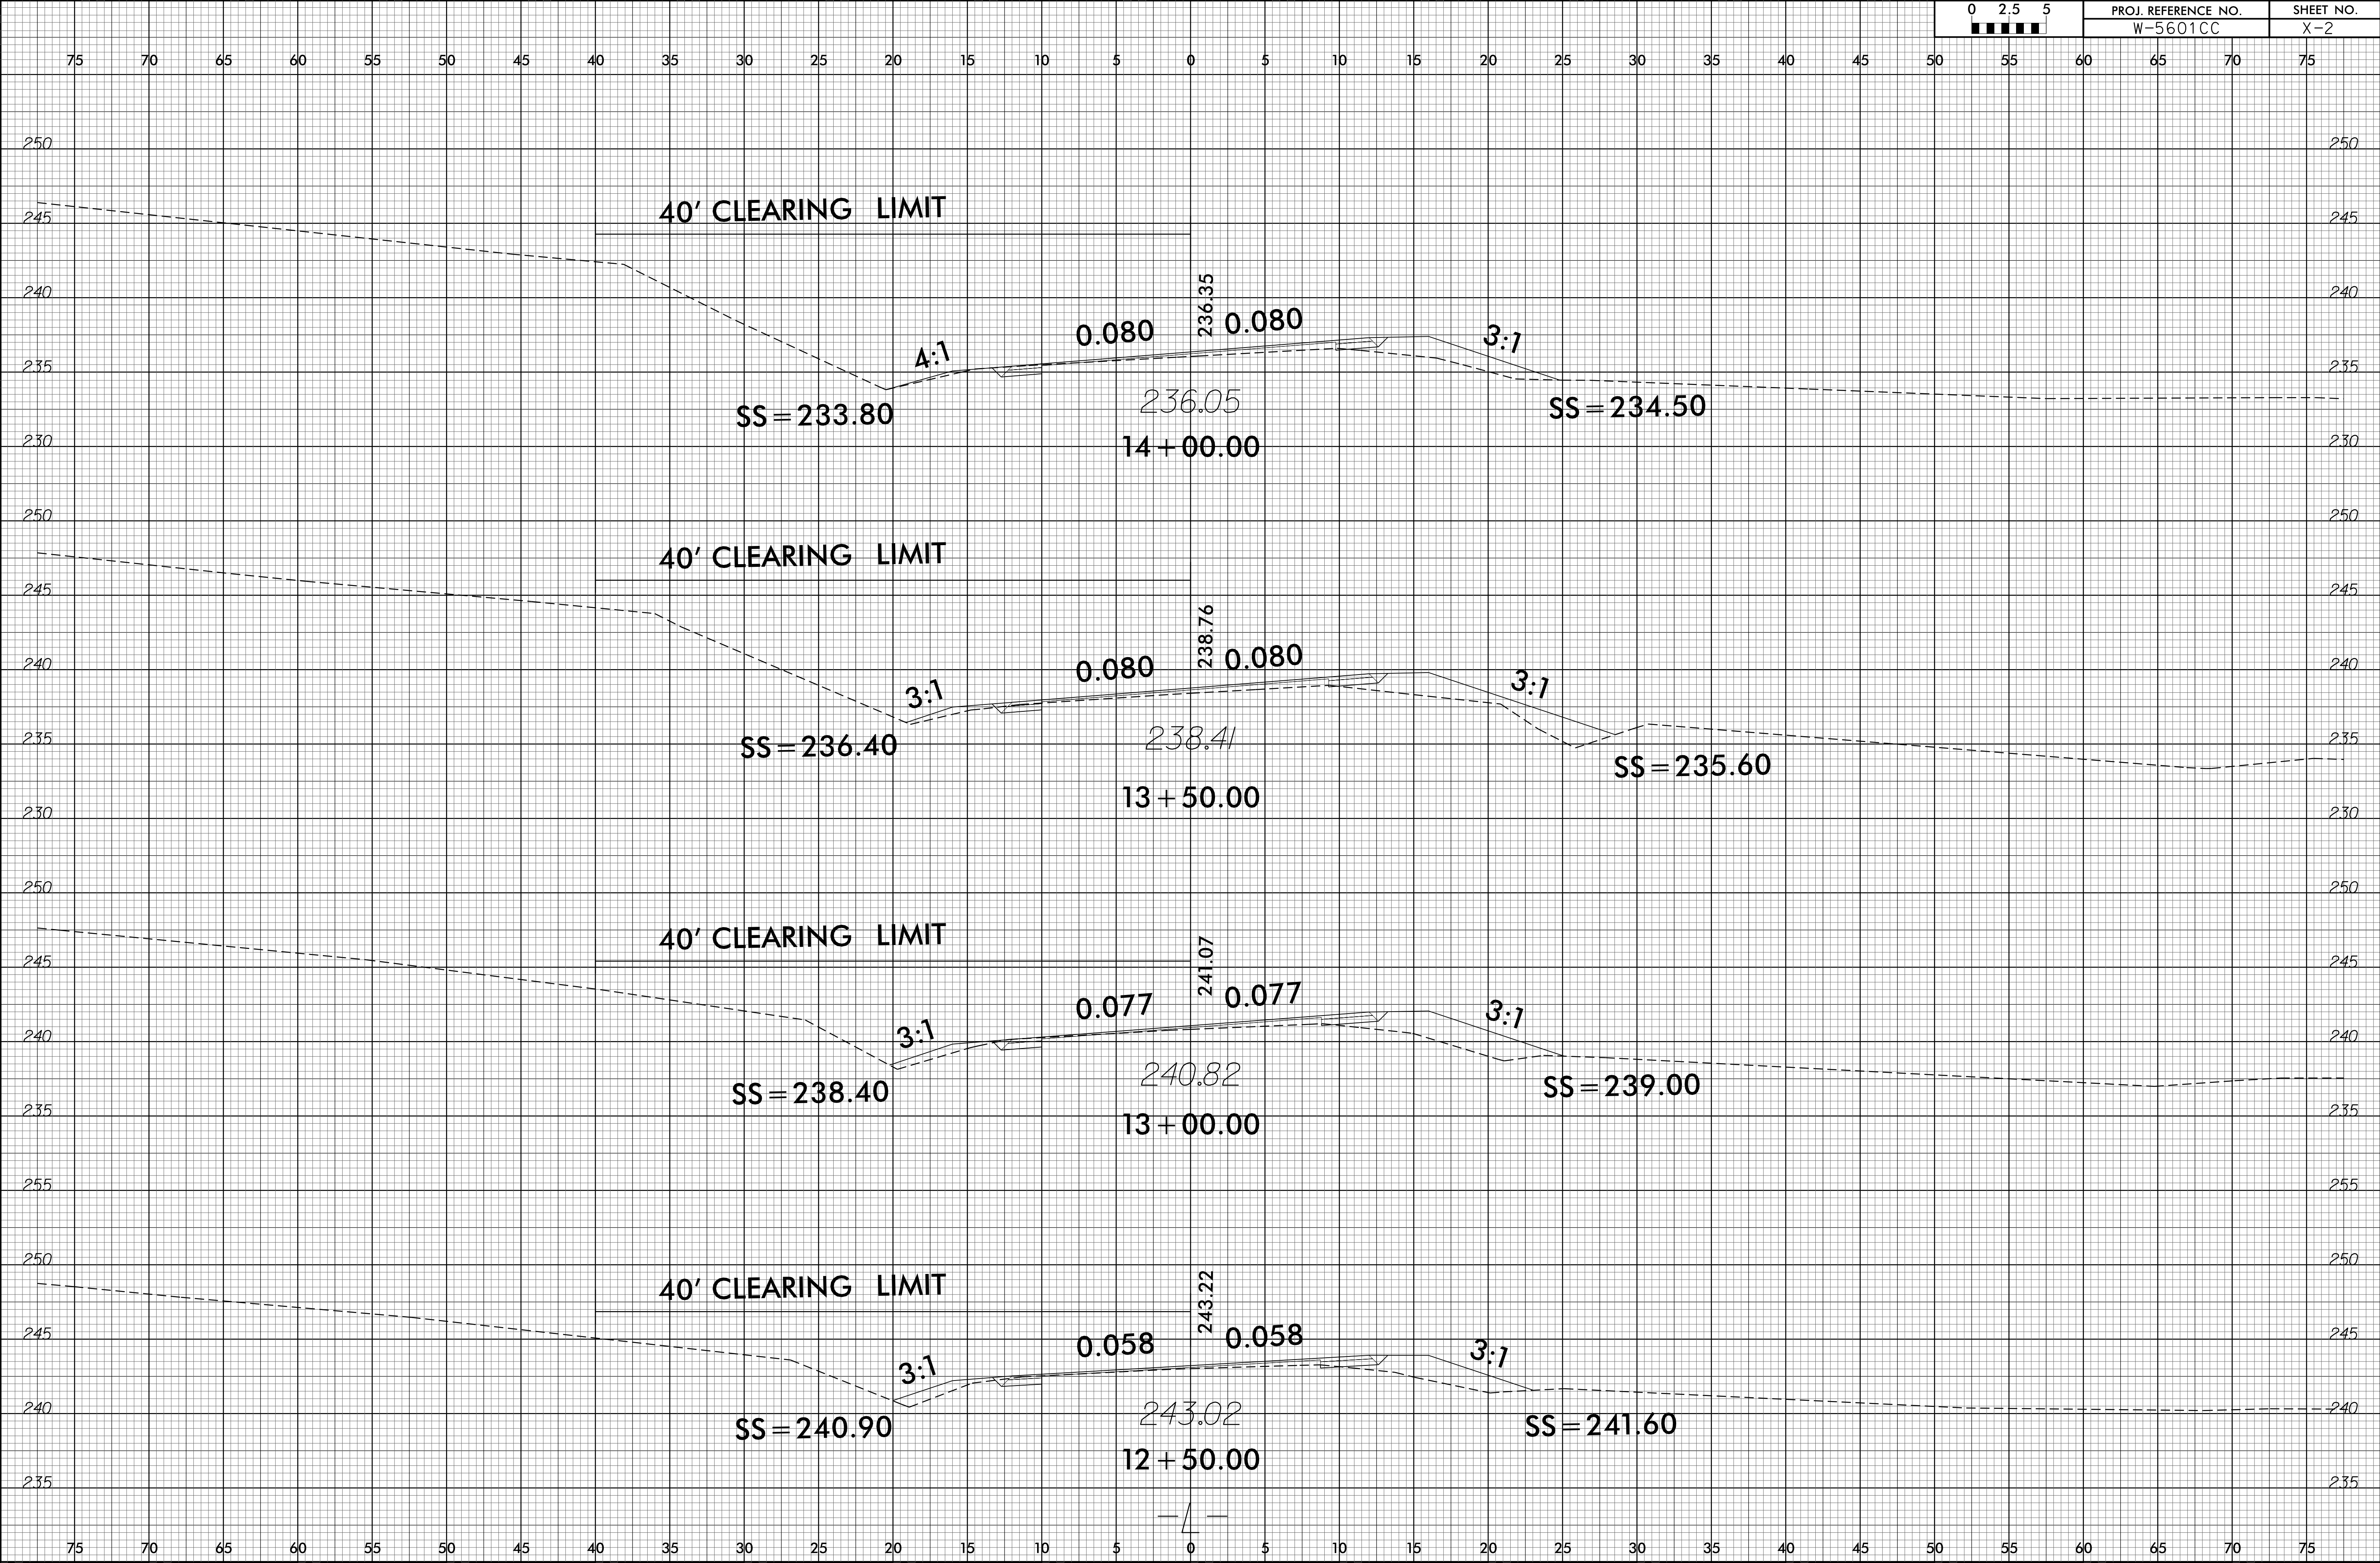


6/23/16

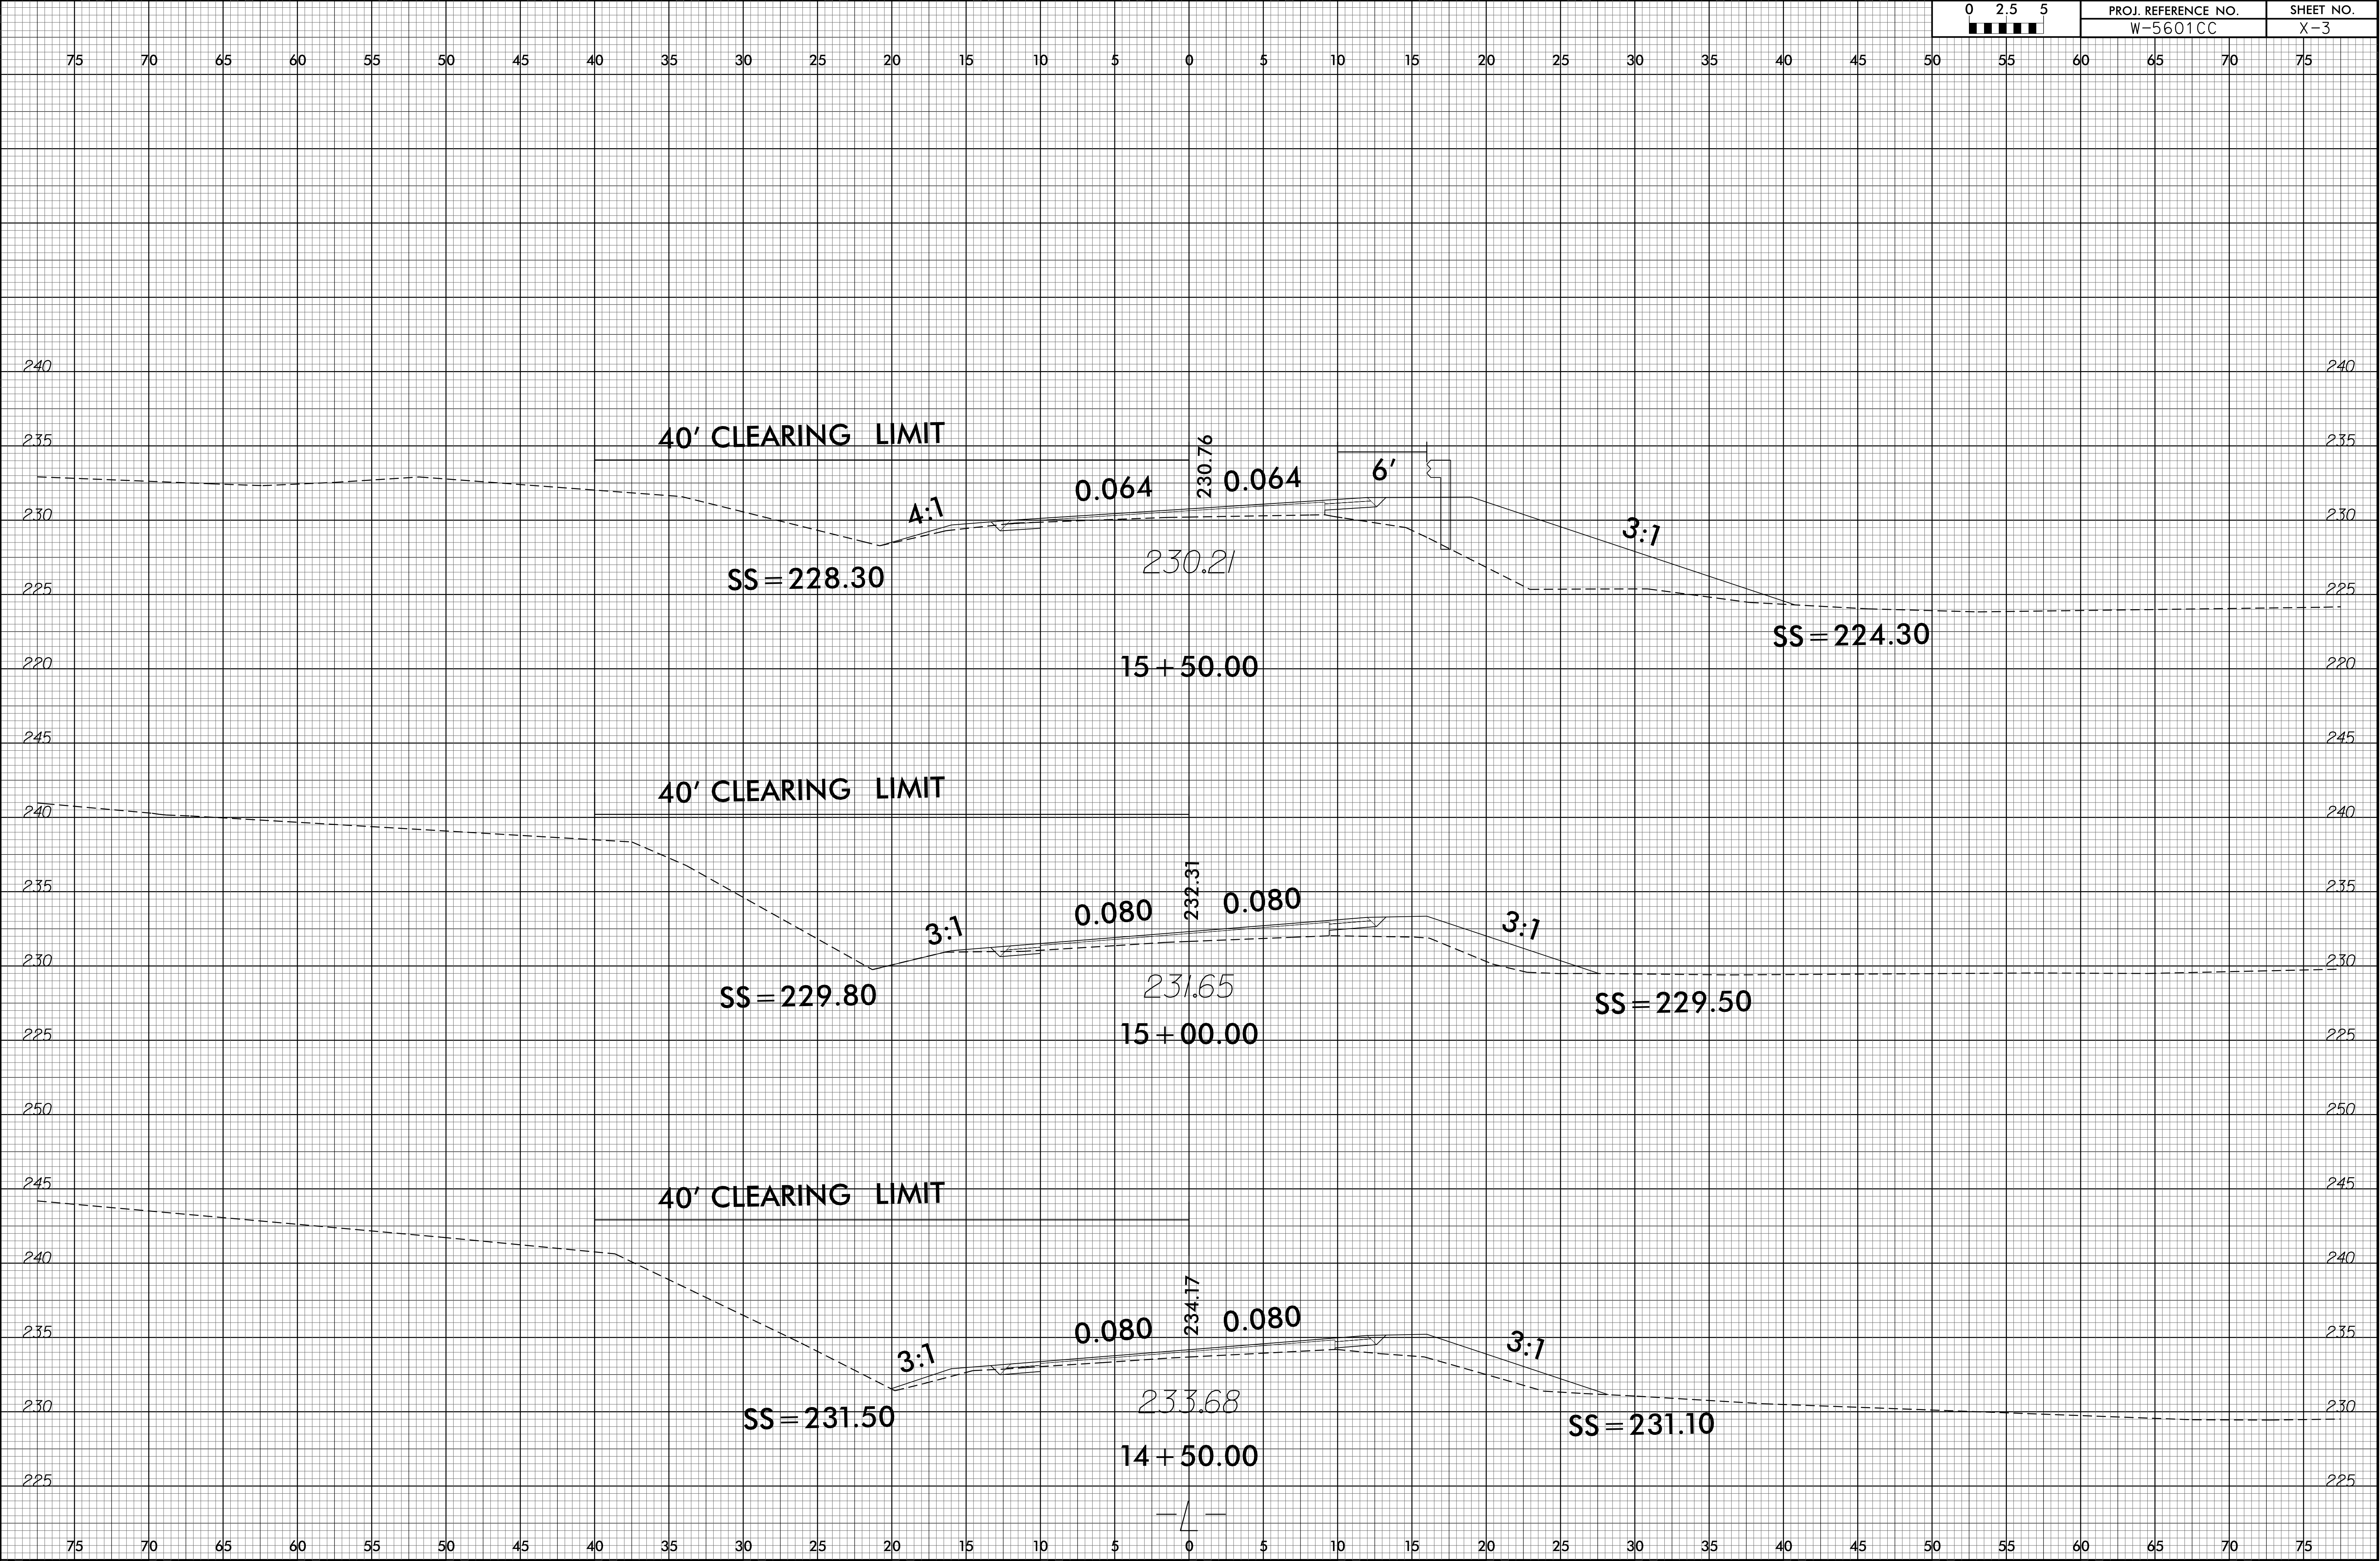

6/23/16

I4-JUN-2017 12:55
H:\DCC\Projects\W-5601CC (SR 1229)\McDougald Rd - Harnett\Roadway\Xsc\W-5601CC_Rdy.xpl.dgn
SSUSER\HARNETT

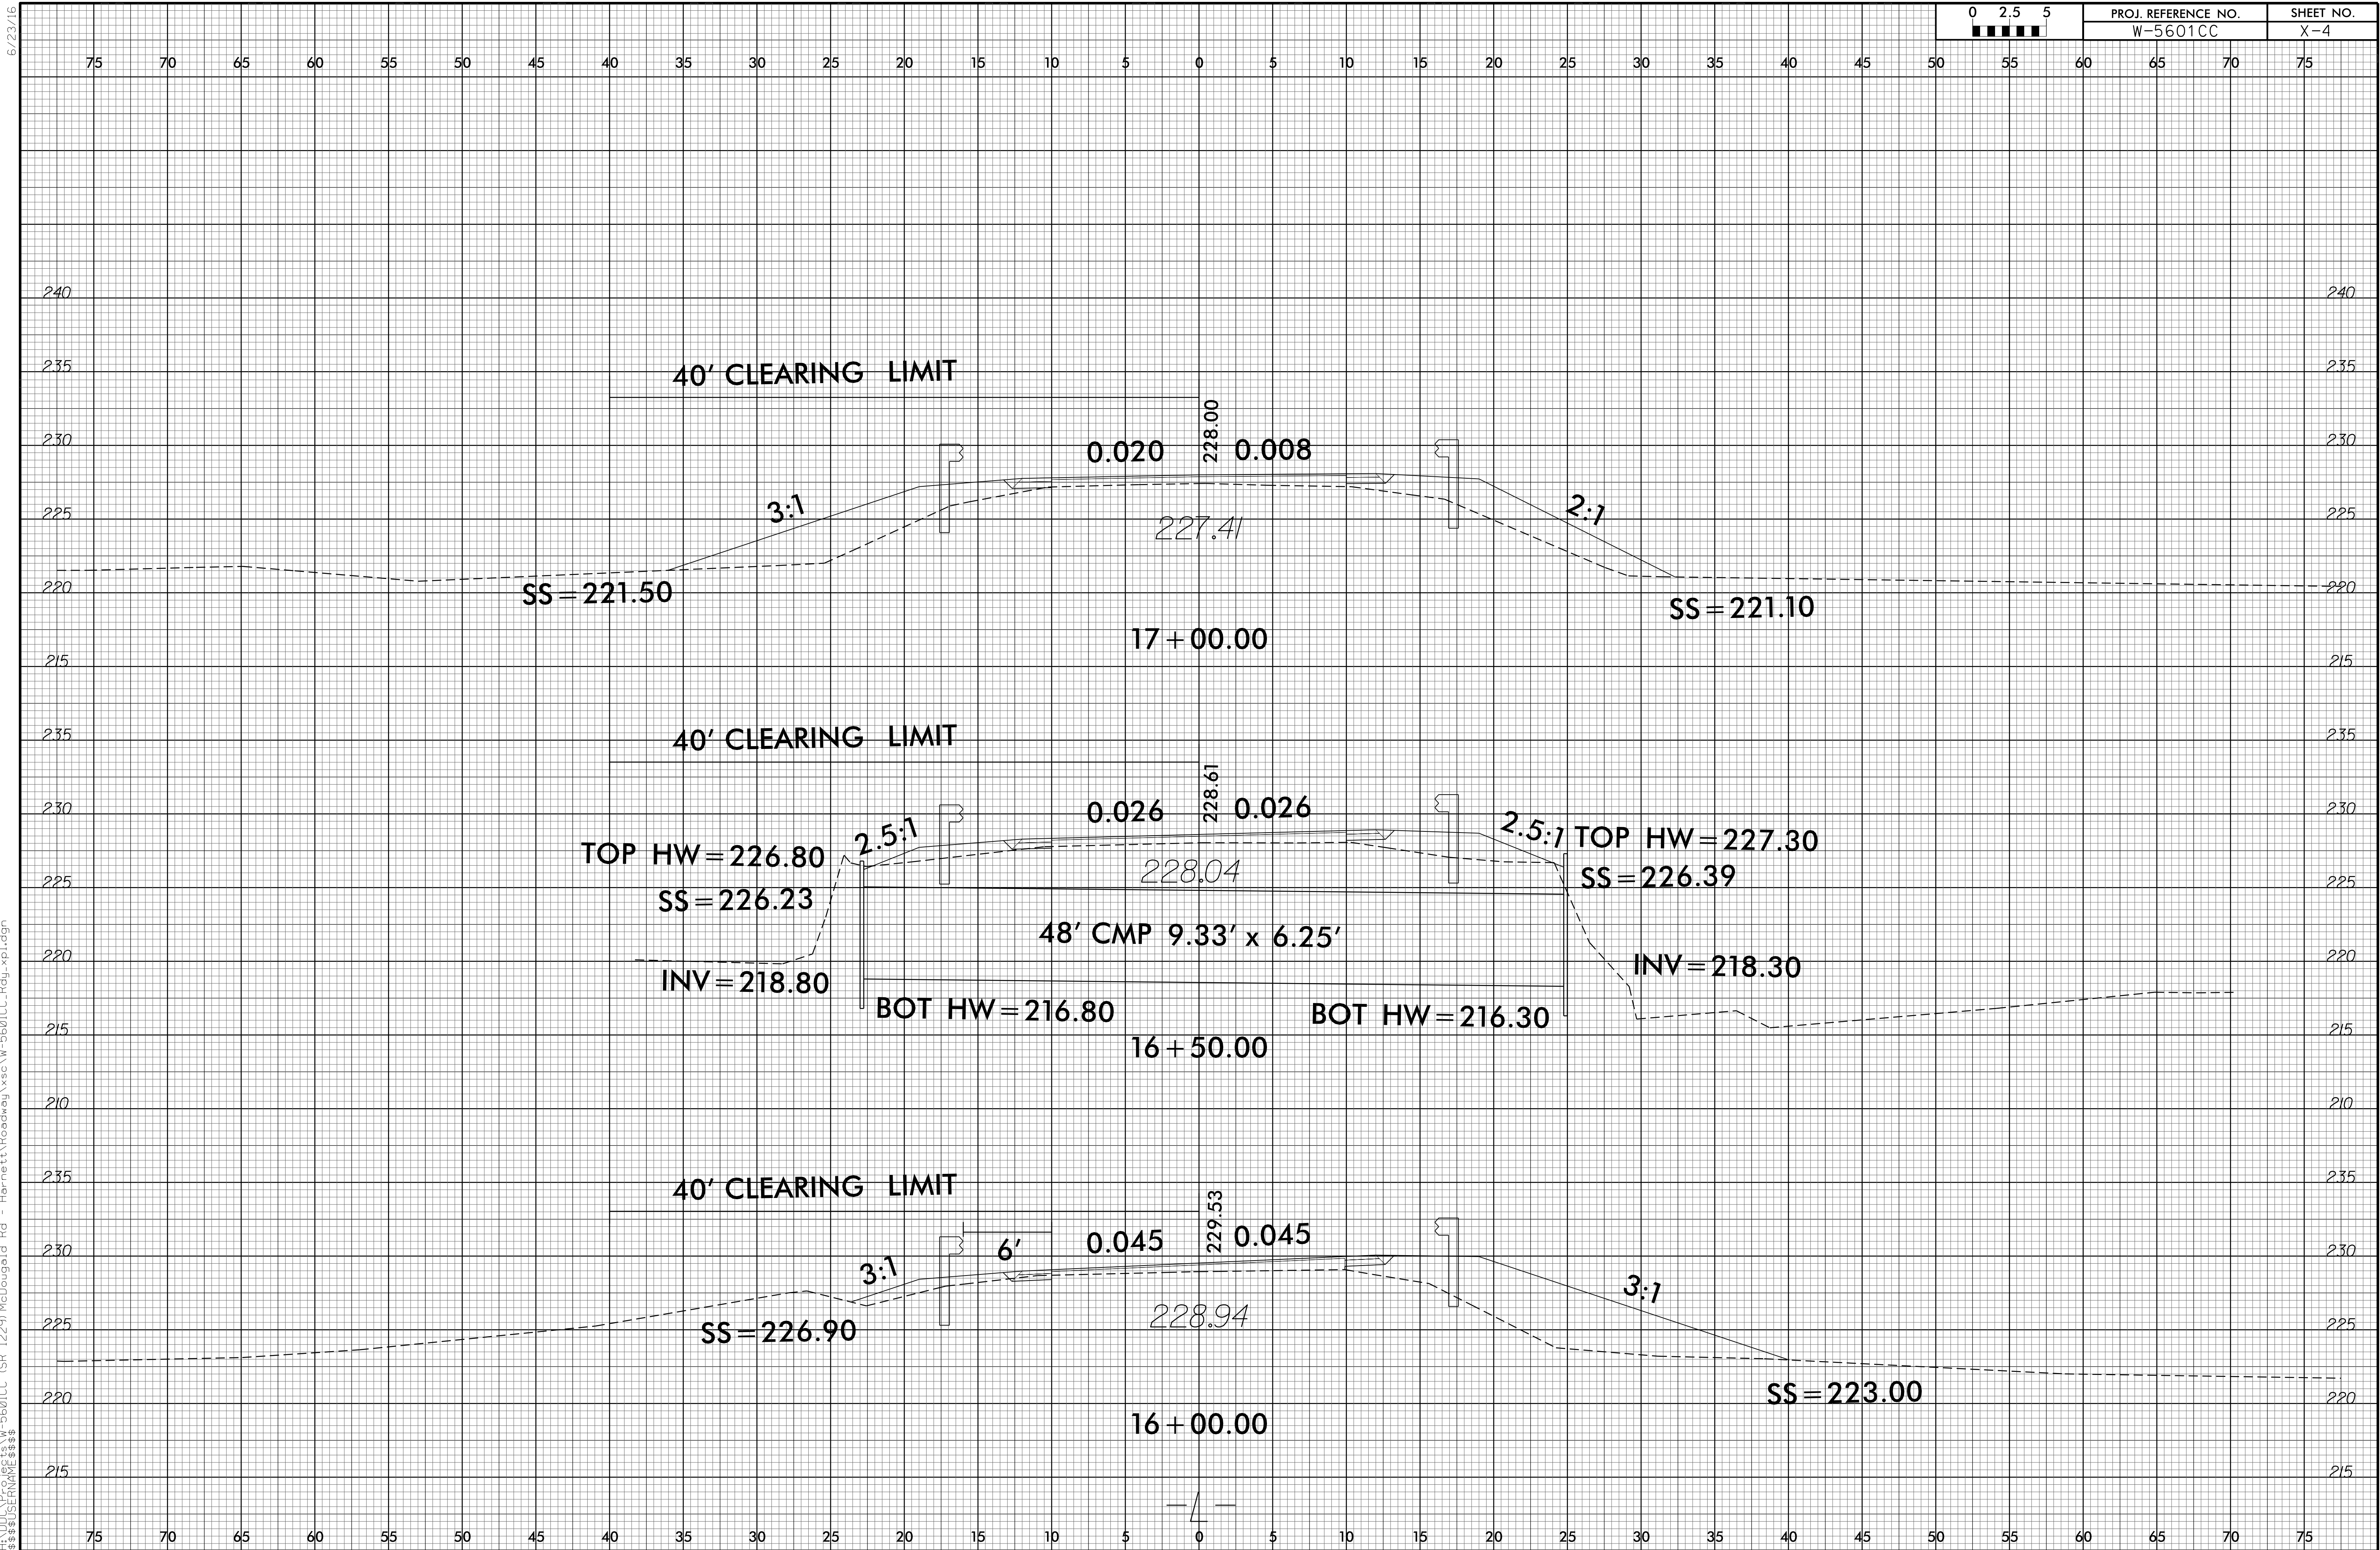

6/23/16

I4-JUN-2017 12:55
H:\DOC\PROJECTS\W-5601CC (SR 1229)\McDougald Rd - Harnett\Roadway\Xsc\W-5601CC_Rdy.xpl.dgn
SSUSERR\W-5601CC

