



STATE OF NORTH CAROLINA
DEPARTMENT OF TRANSPORTATION

ROY COOPER
GOVERNOR

JAMES H. TROGDON, III
SECRETARY

January 10, 2018

TO: Prospective Bidders
FROM: Jeff Turner, Division Proposals Engineer
SUBJECT: **Addendum #1**
Contract DI00184 – “W-5601DY”
Grading, Drainage, Widening, and Rignment on NC 150 at SR 1547
(Graham / Caldwell Road) in Rowan County

The subject contract proposal contains the following addendum:


1. Add the attached cross section sheets to the plans.


This addendum officially becomes part of the contract.

Mailing Address:
NC DEPARTMENT OF TRANSPORTATION
DIVISION 9 – PROJECT DEVELOPMENT
375 SILAS CREEK PARKWAY
WINSTON-SALEM, NC 27127


Telephone: (336) 747-7800
Fax: (336) 703-6693
Website: www.ncdot.gov

Location:
375 SILAS CREEK PARKWAY
WINSTON-SALEM, NC 27127

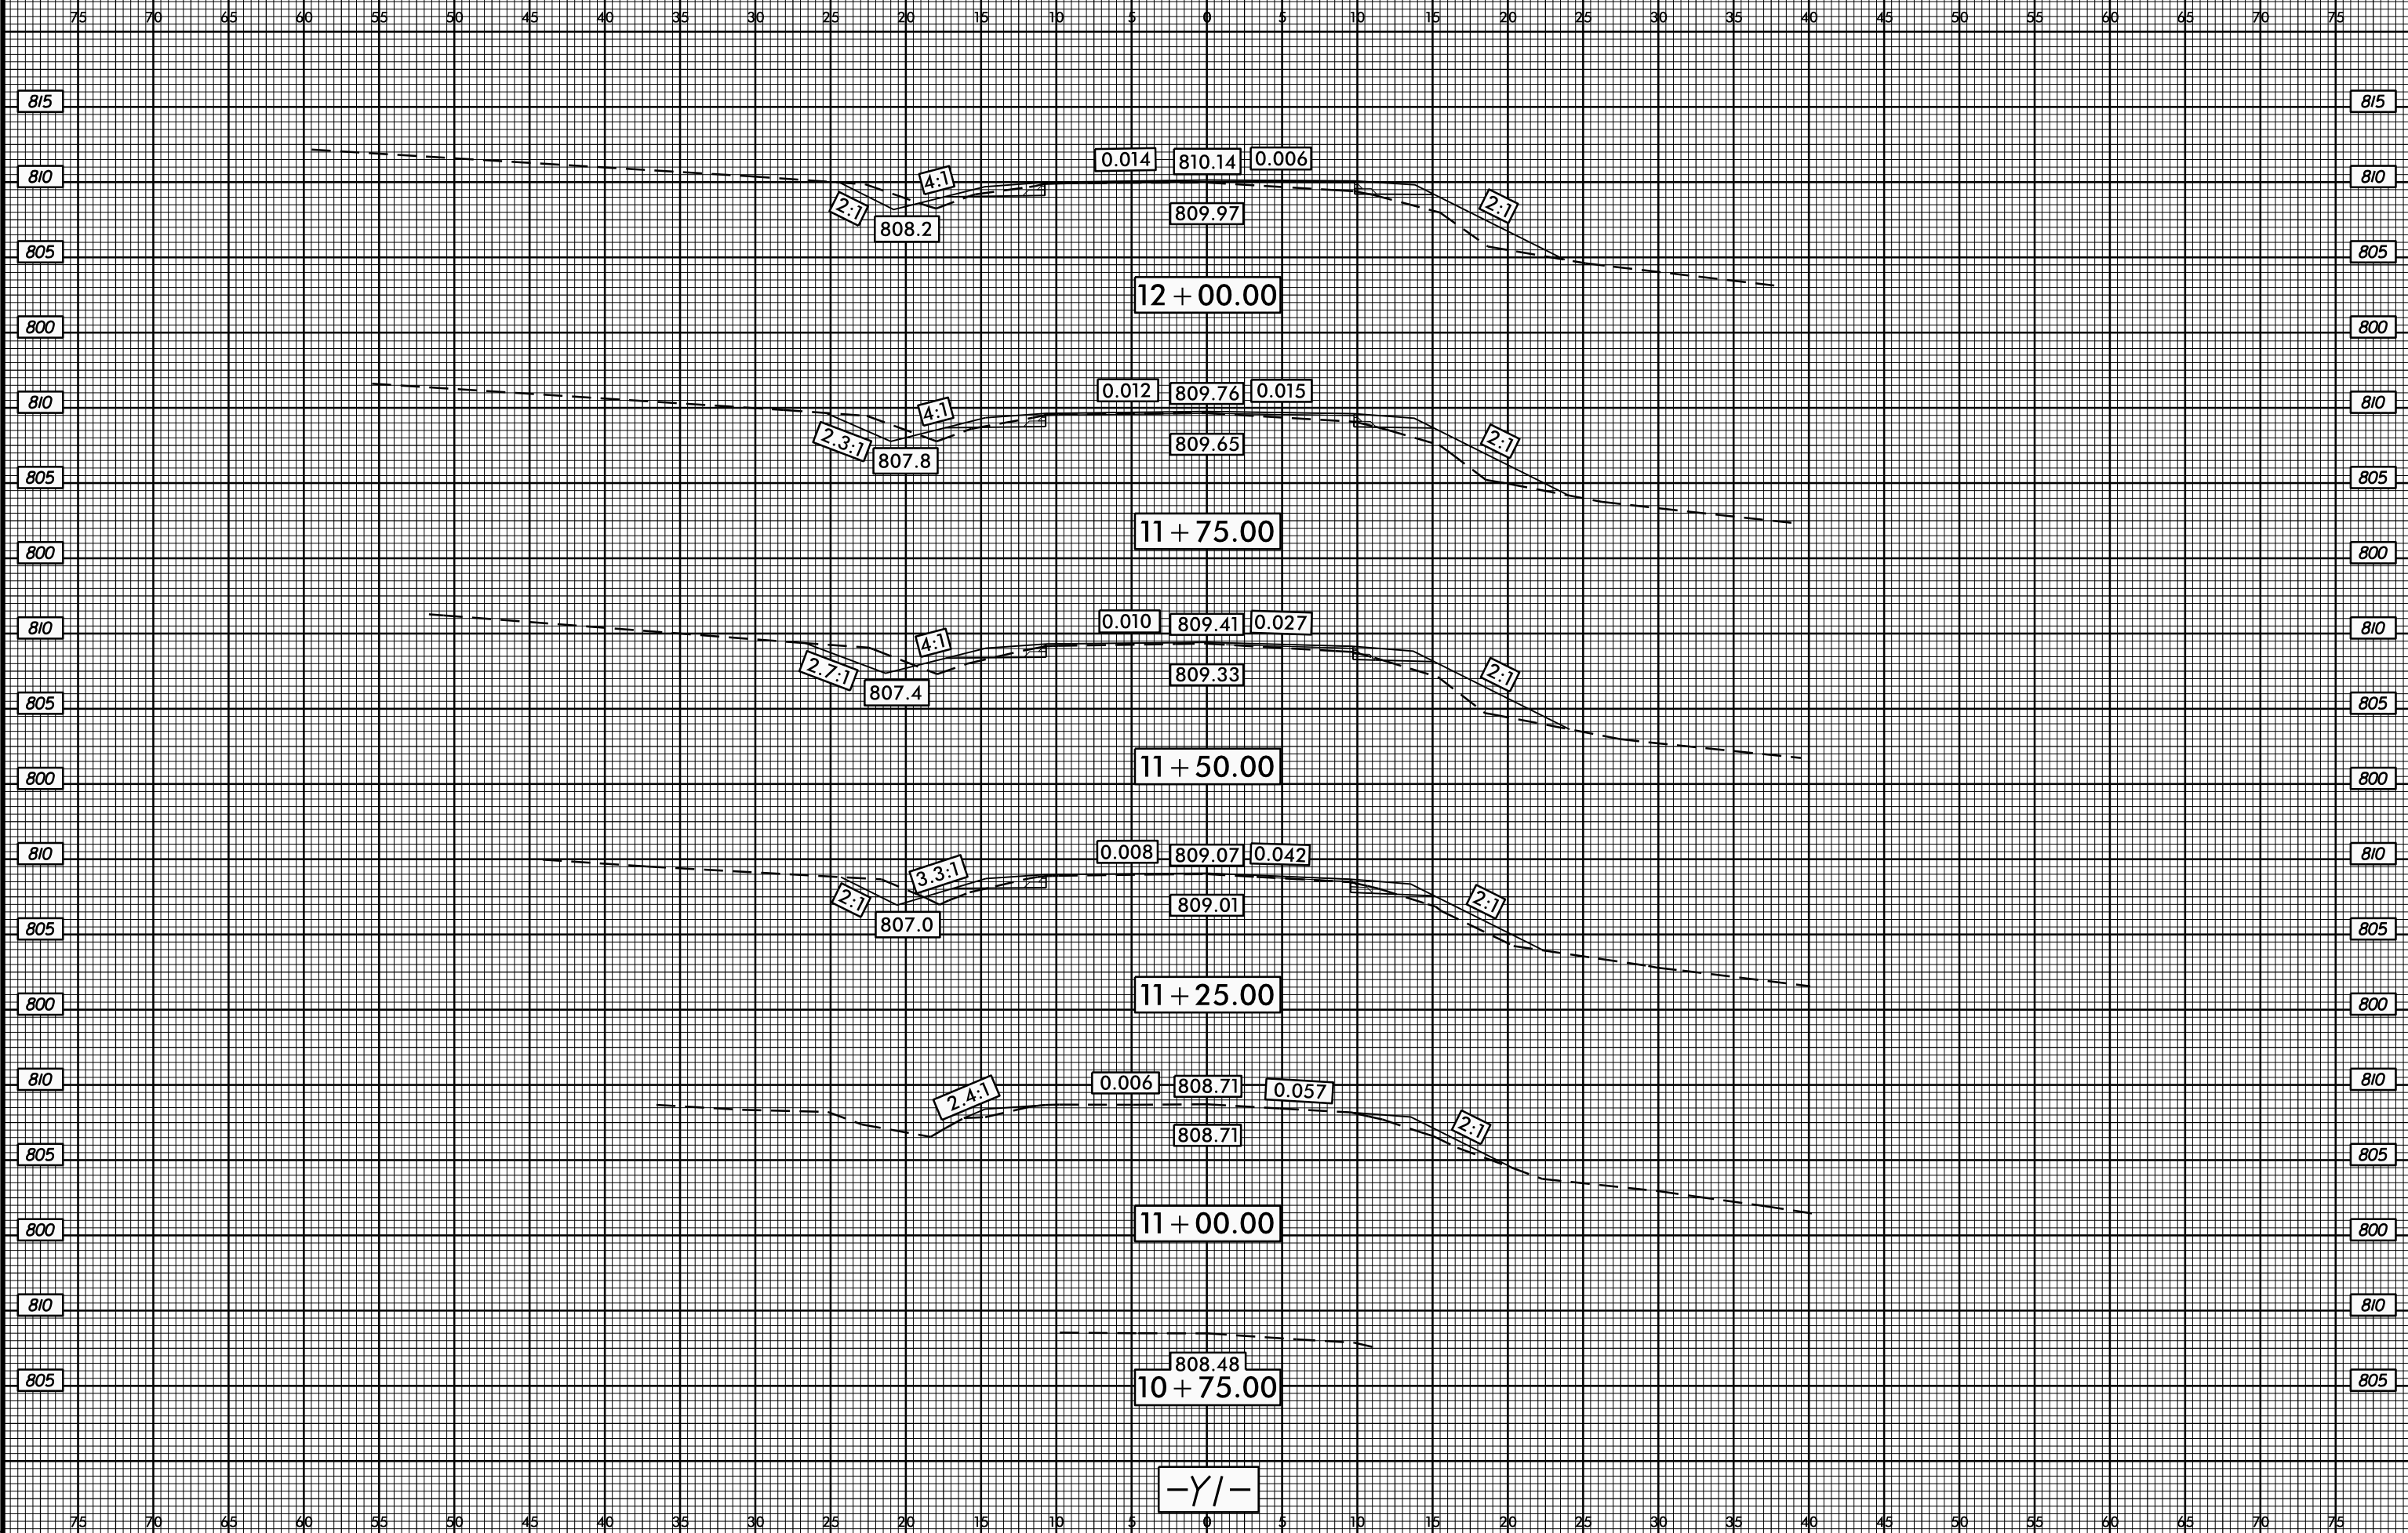

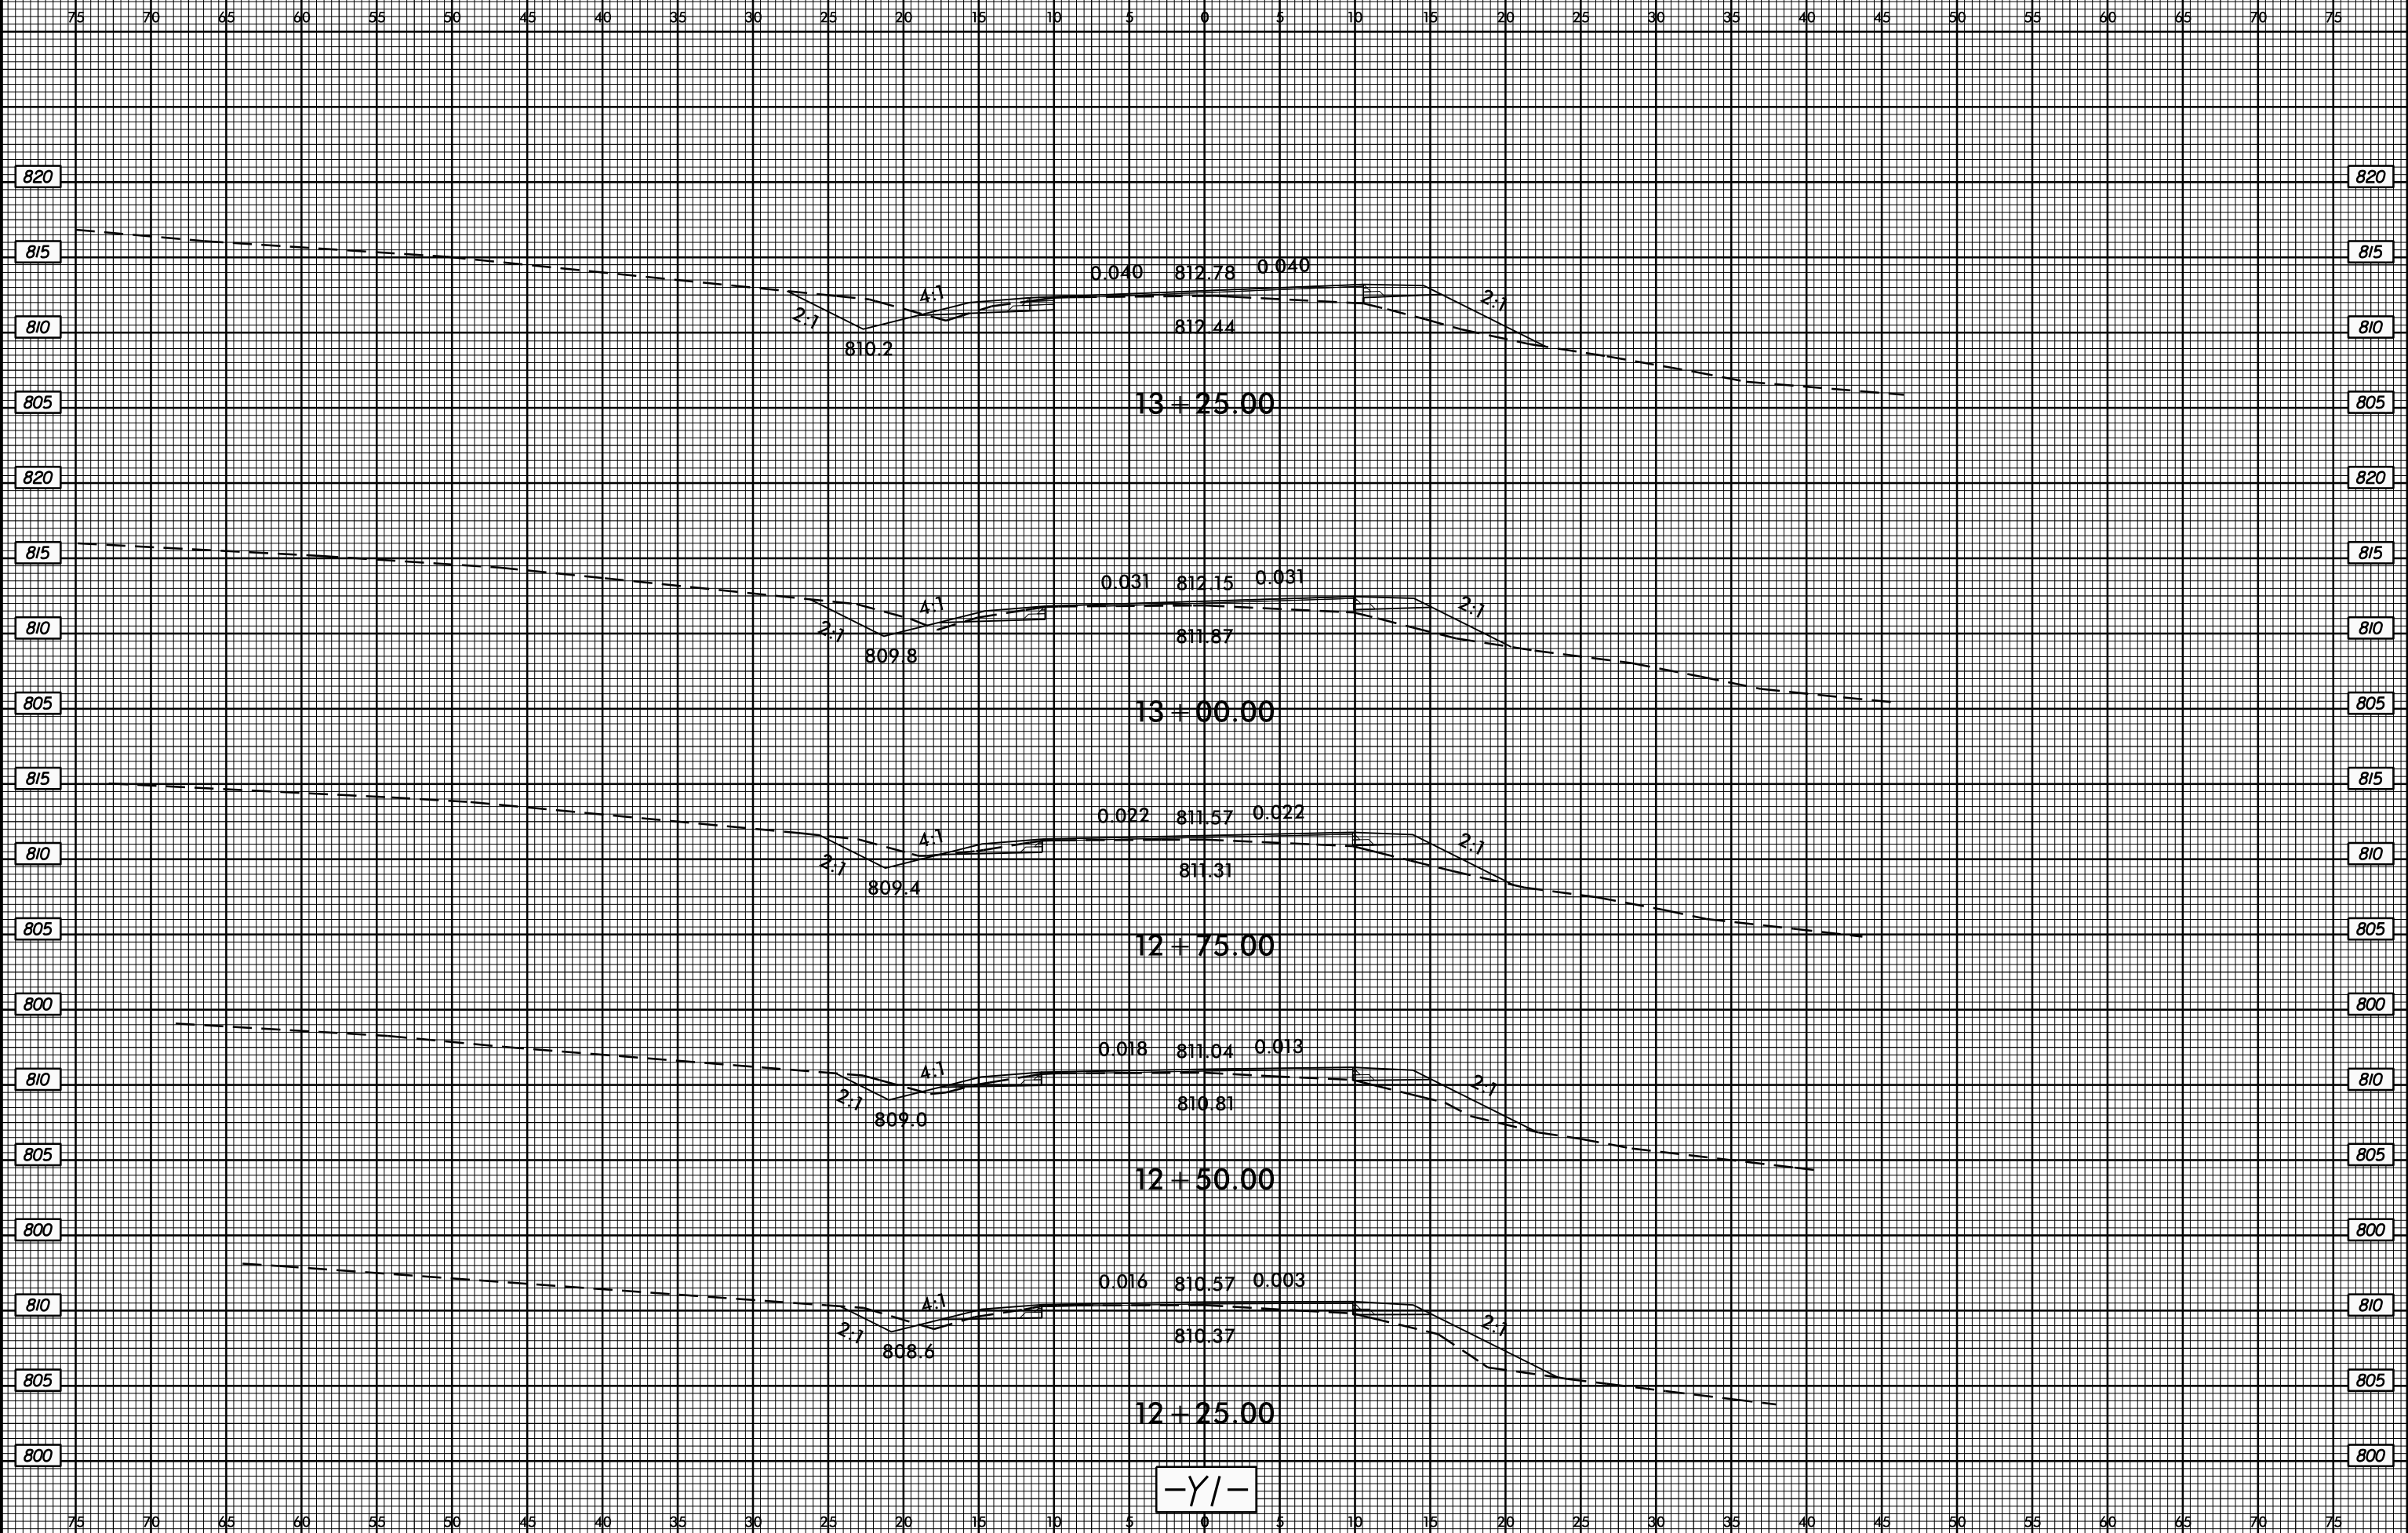

-Y/-

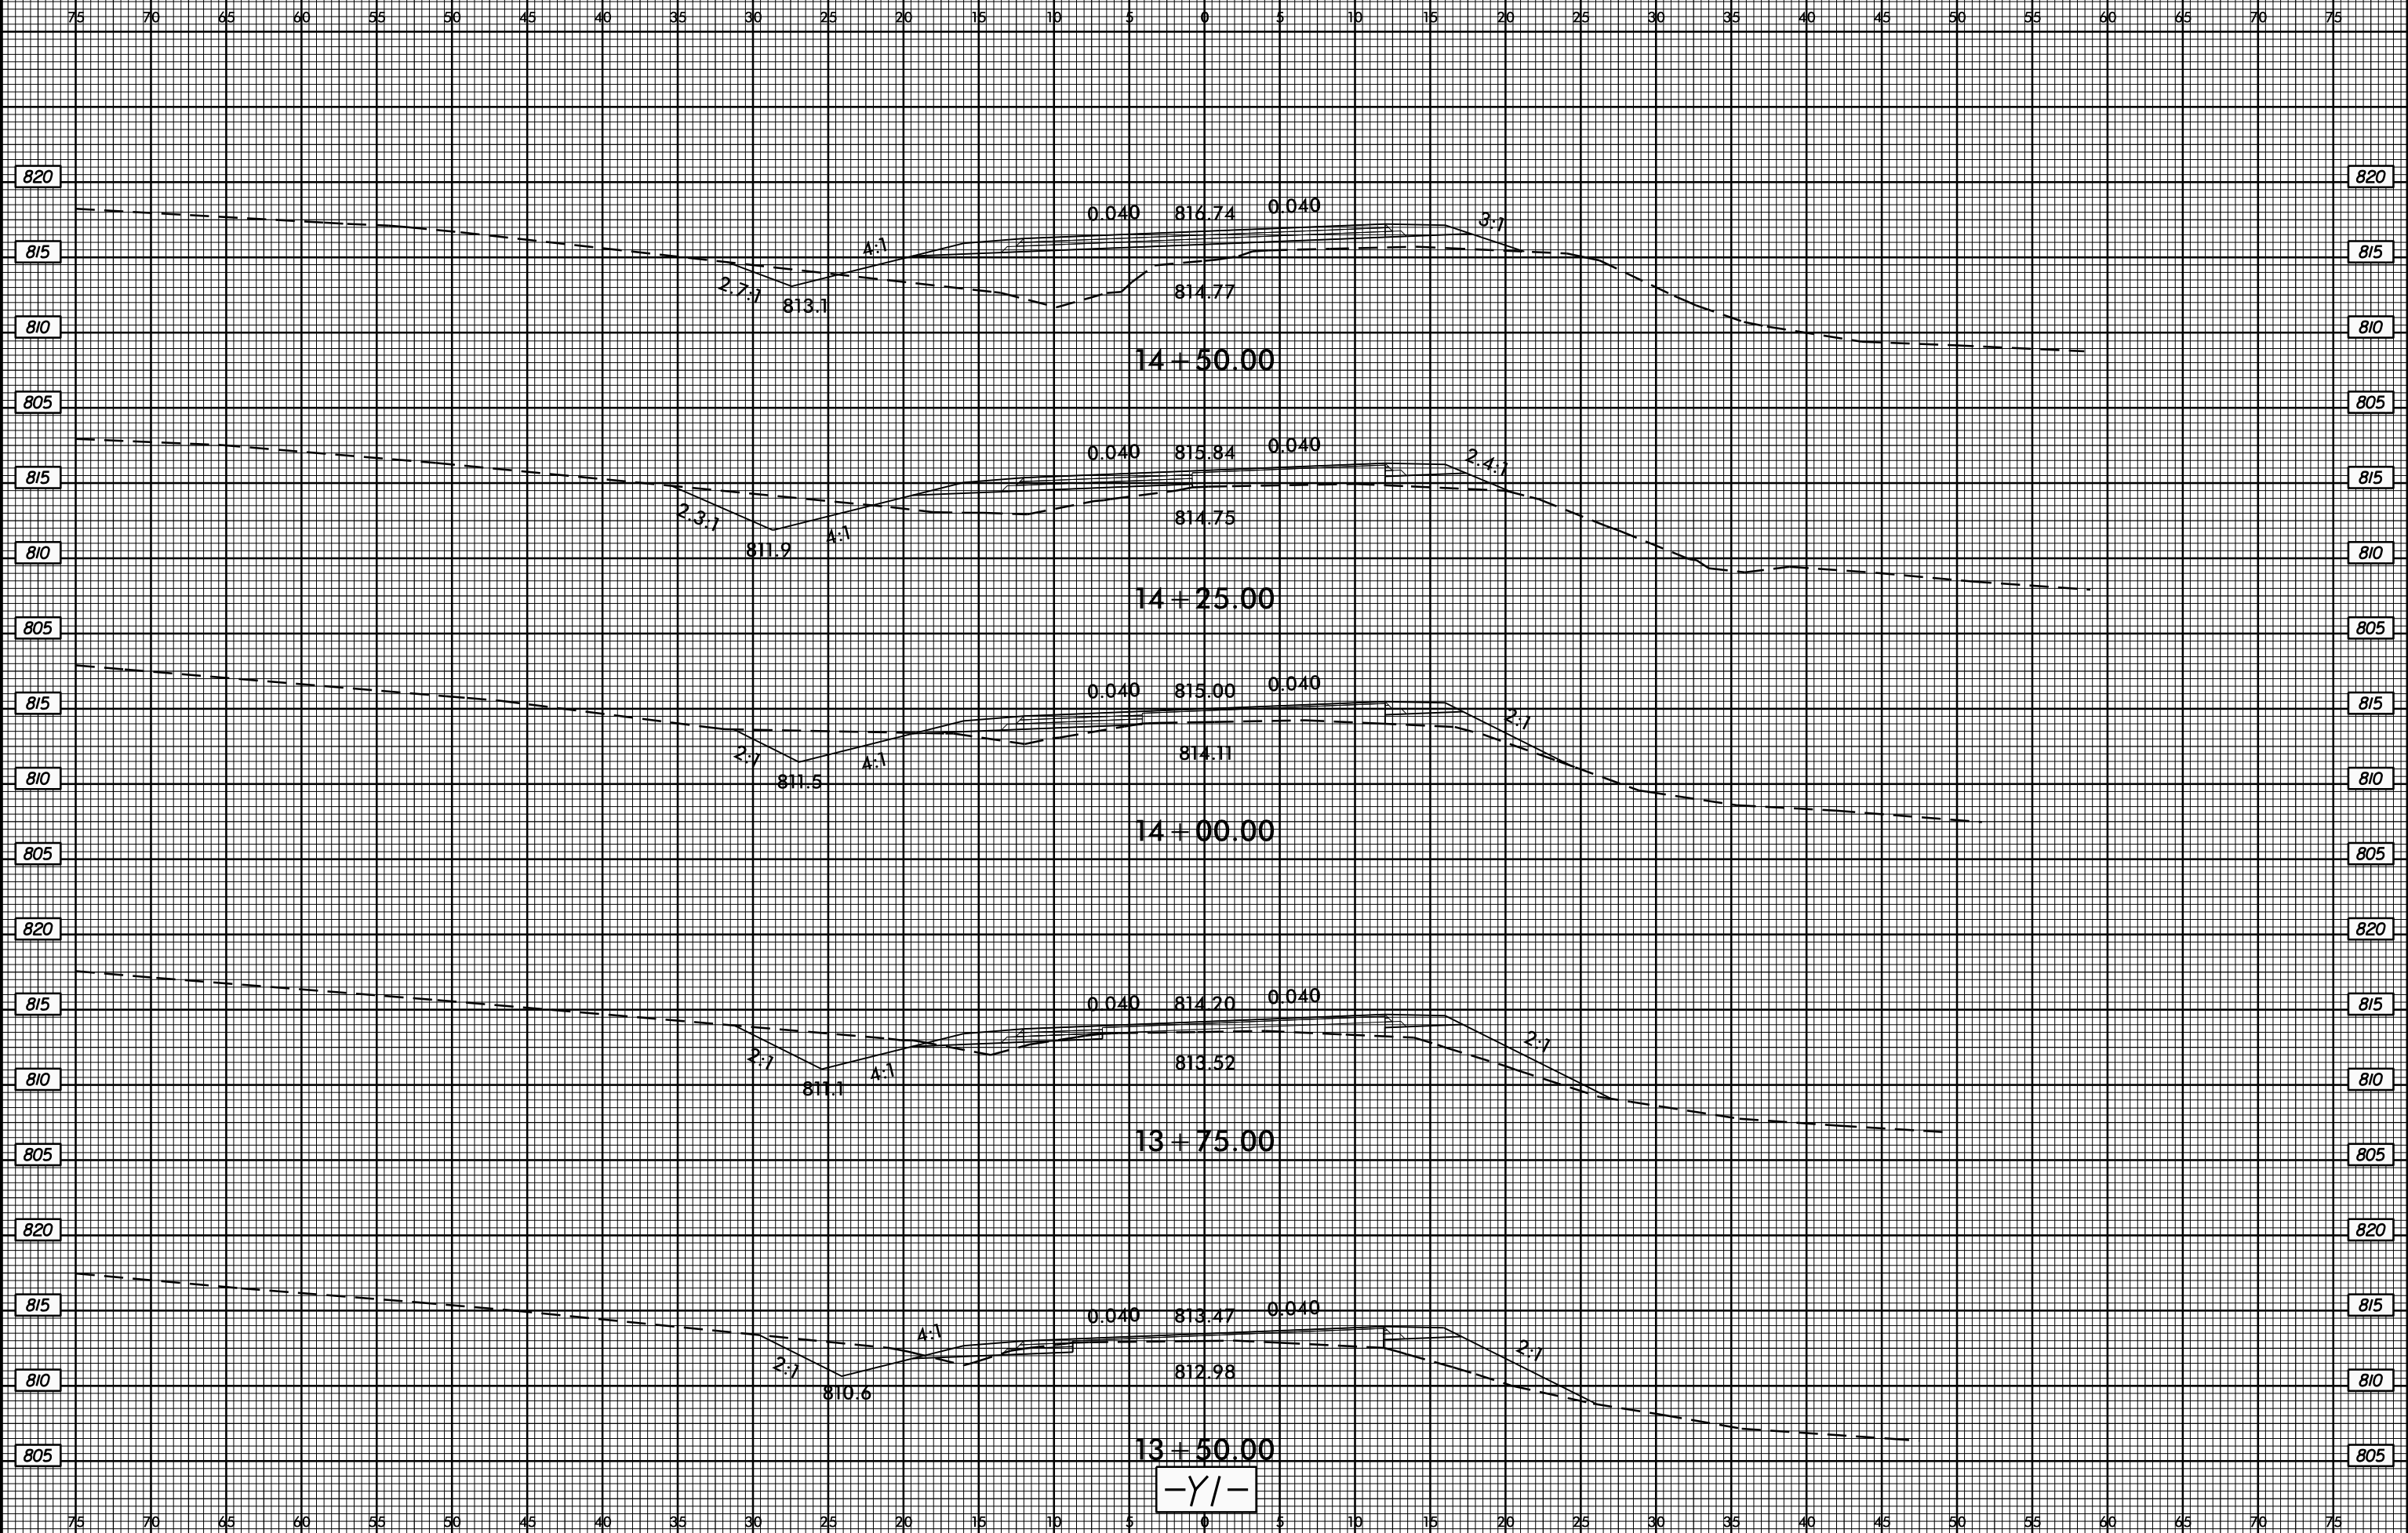


-Y/-

6/23/16




PROJ. REFERENCE NO.
W-5601DY

SHEET NO.
X-4

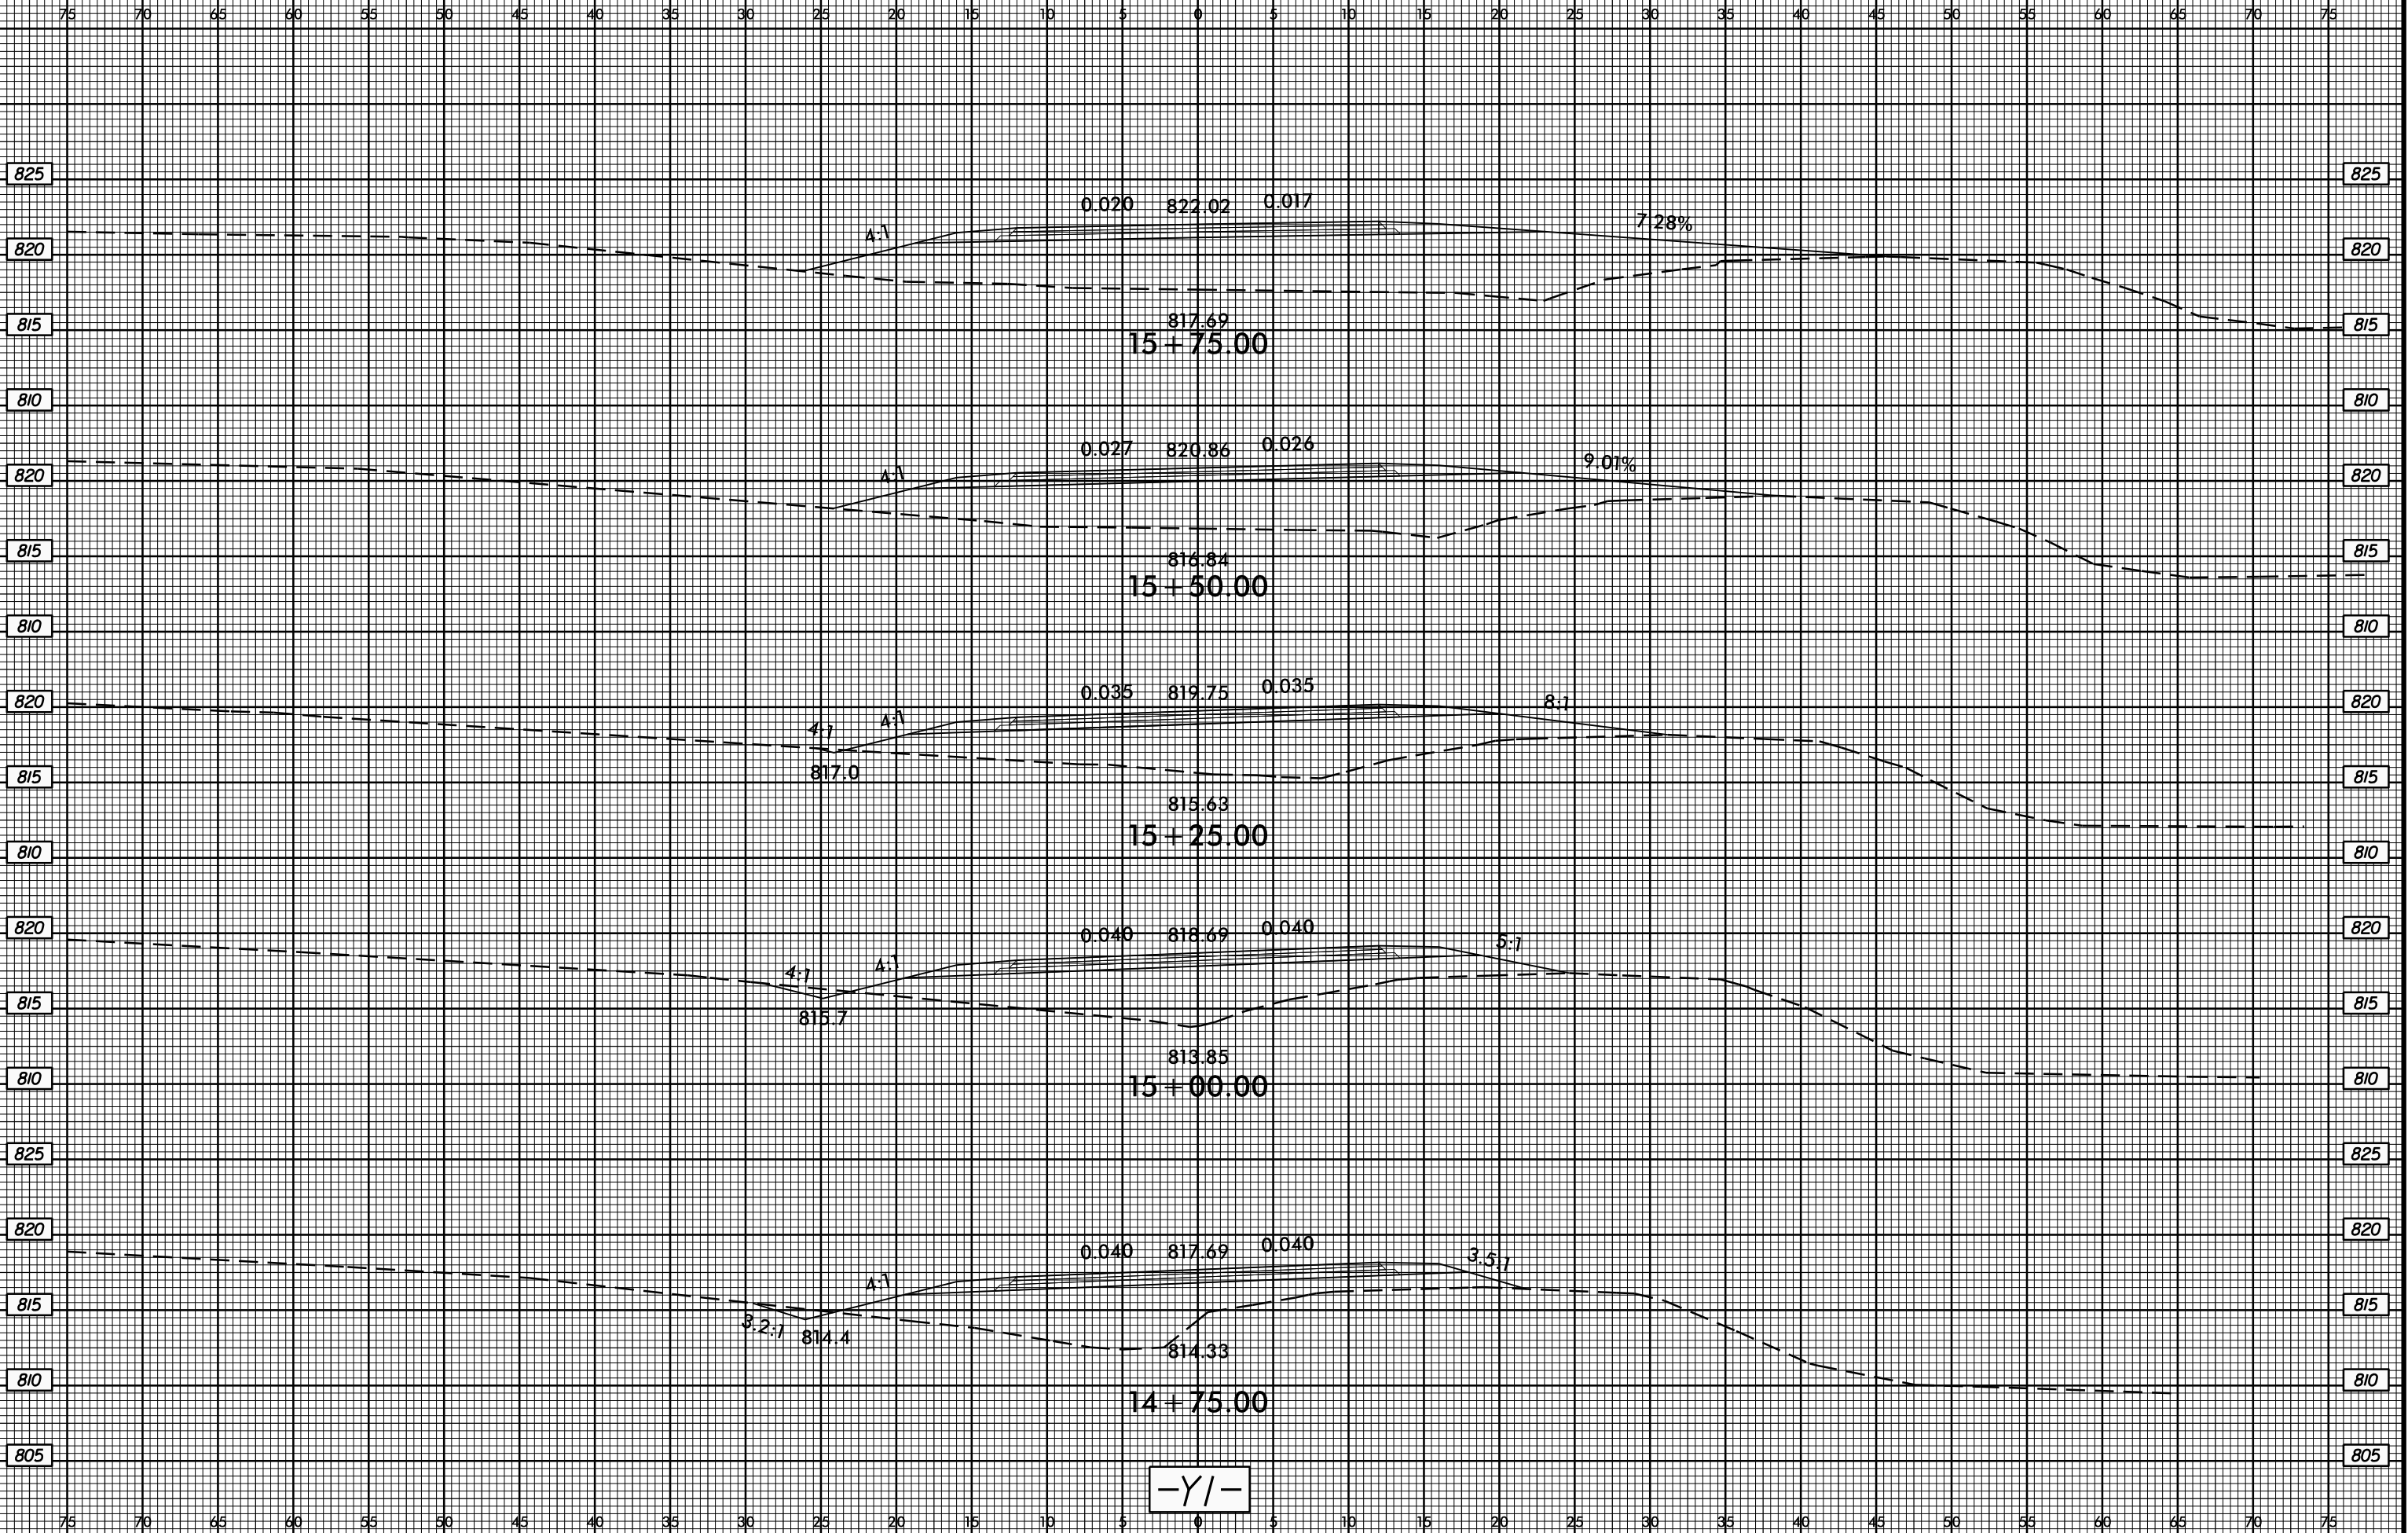


-Y/-

 08-NOV-2017 09:54
S:\Projects\Development\TIP-Projects\W-5601DY-NC150-Gr-ahamRd\W5601DY-ddc-xpl.YI.dgn
User: jk




75 70 65 60 55 50 45 40 35 30 25 20 15 10 5 0 5 10 15 20 25 30 35 40 45 50 55 60 65 70 75

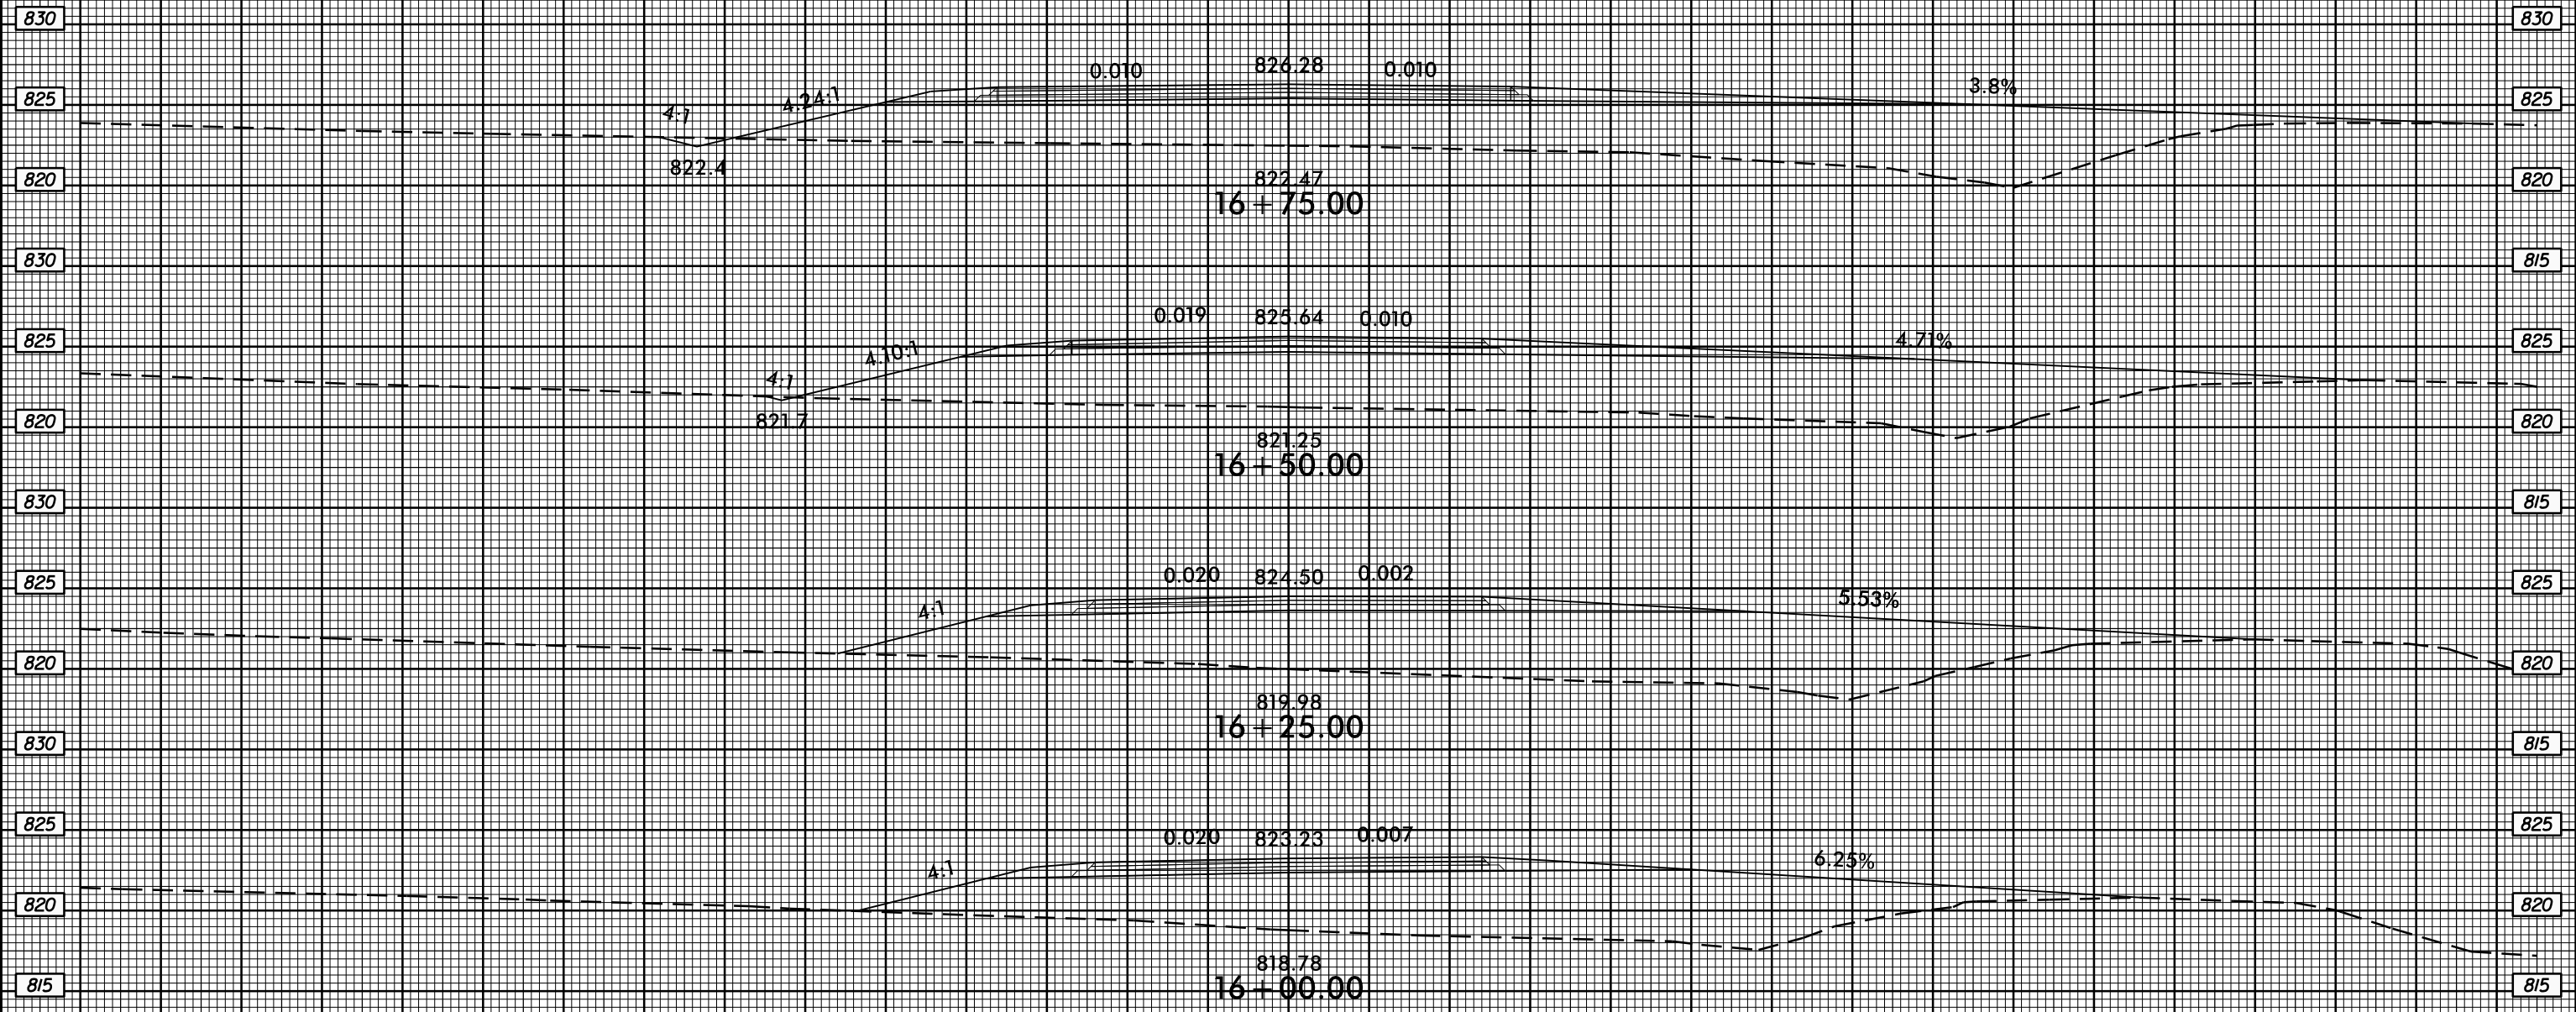


-Y/-

75 70 65 60 55 50 45 40 35 30 25 20 15 10 5 0 5 10 15 20 25 30 35 40 45 50 55 60 65 70 75

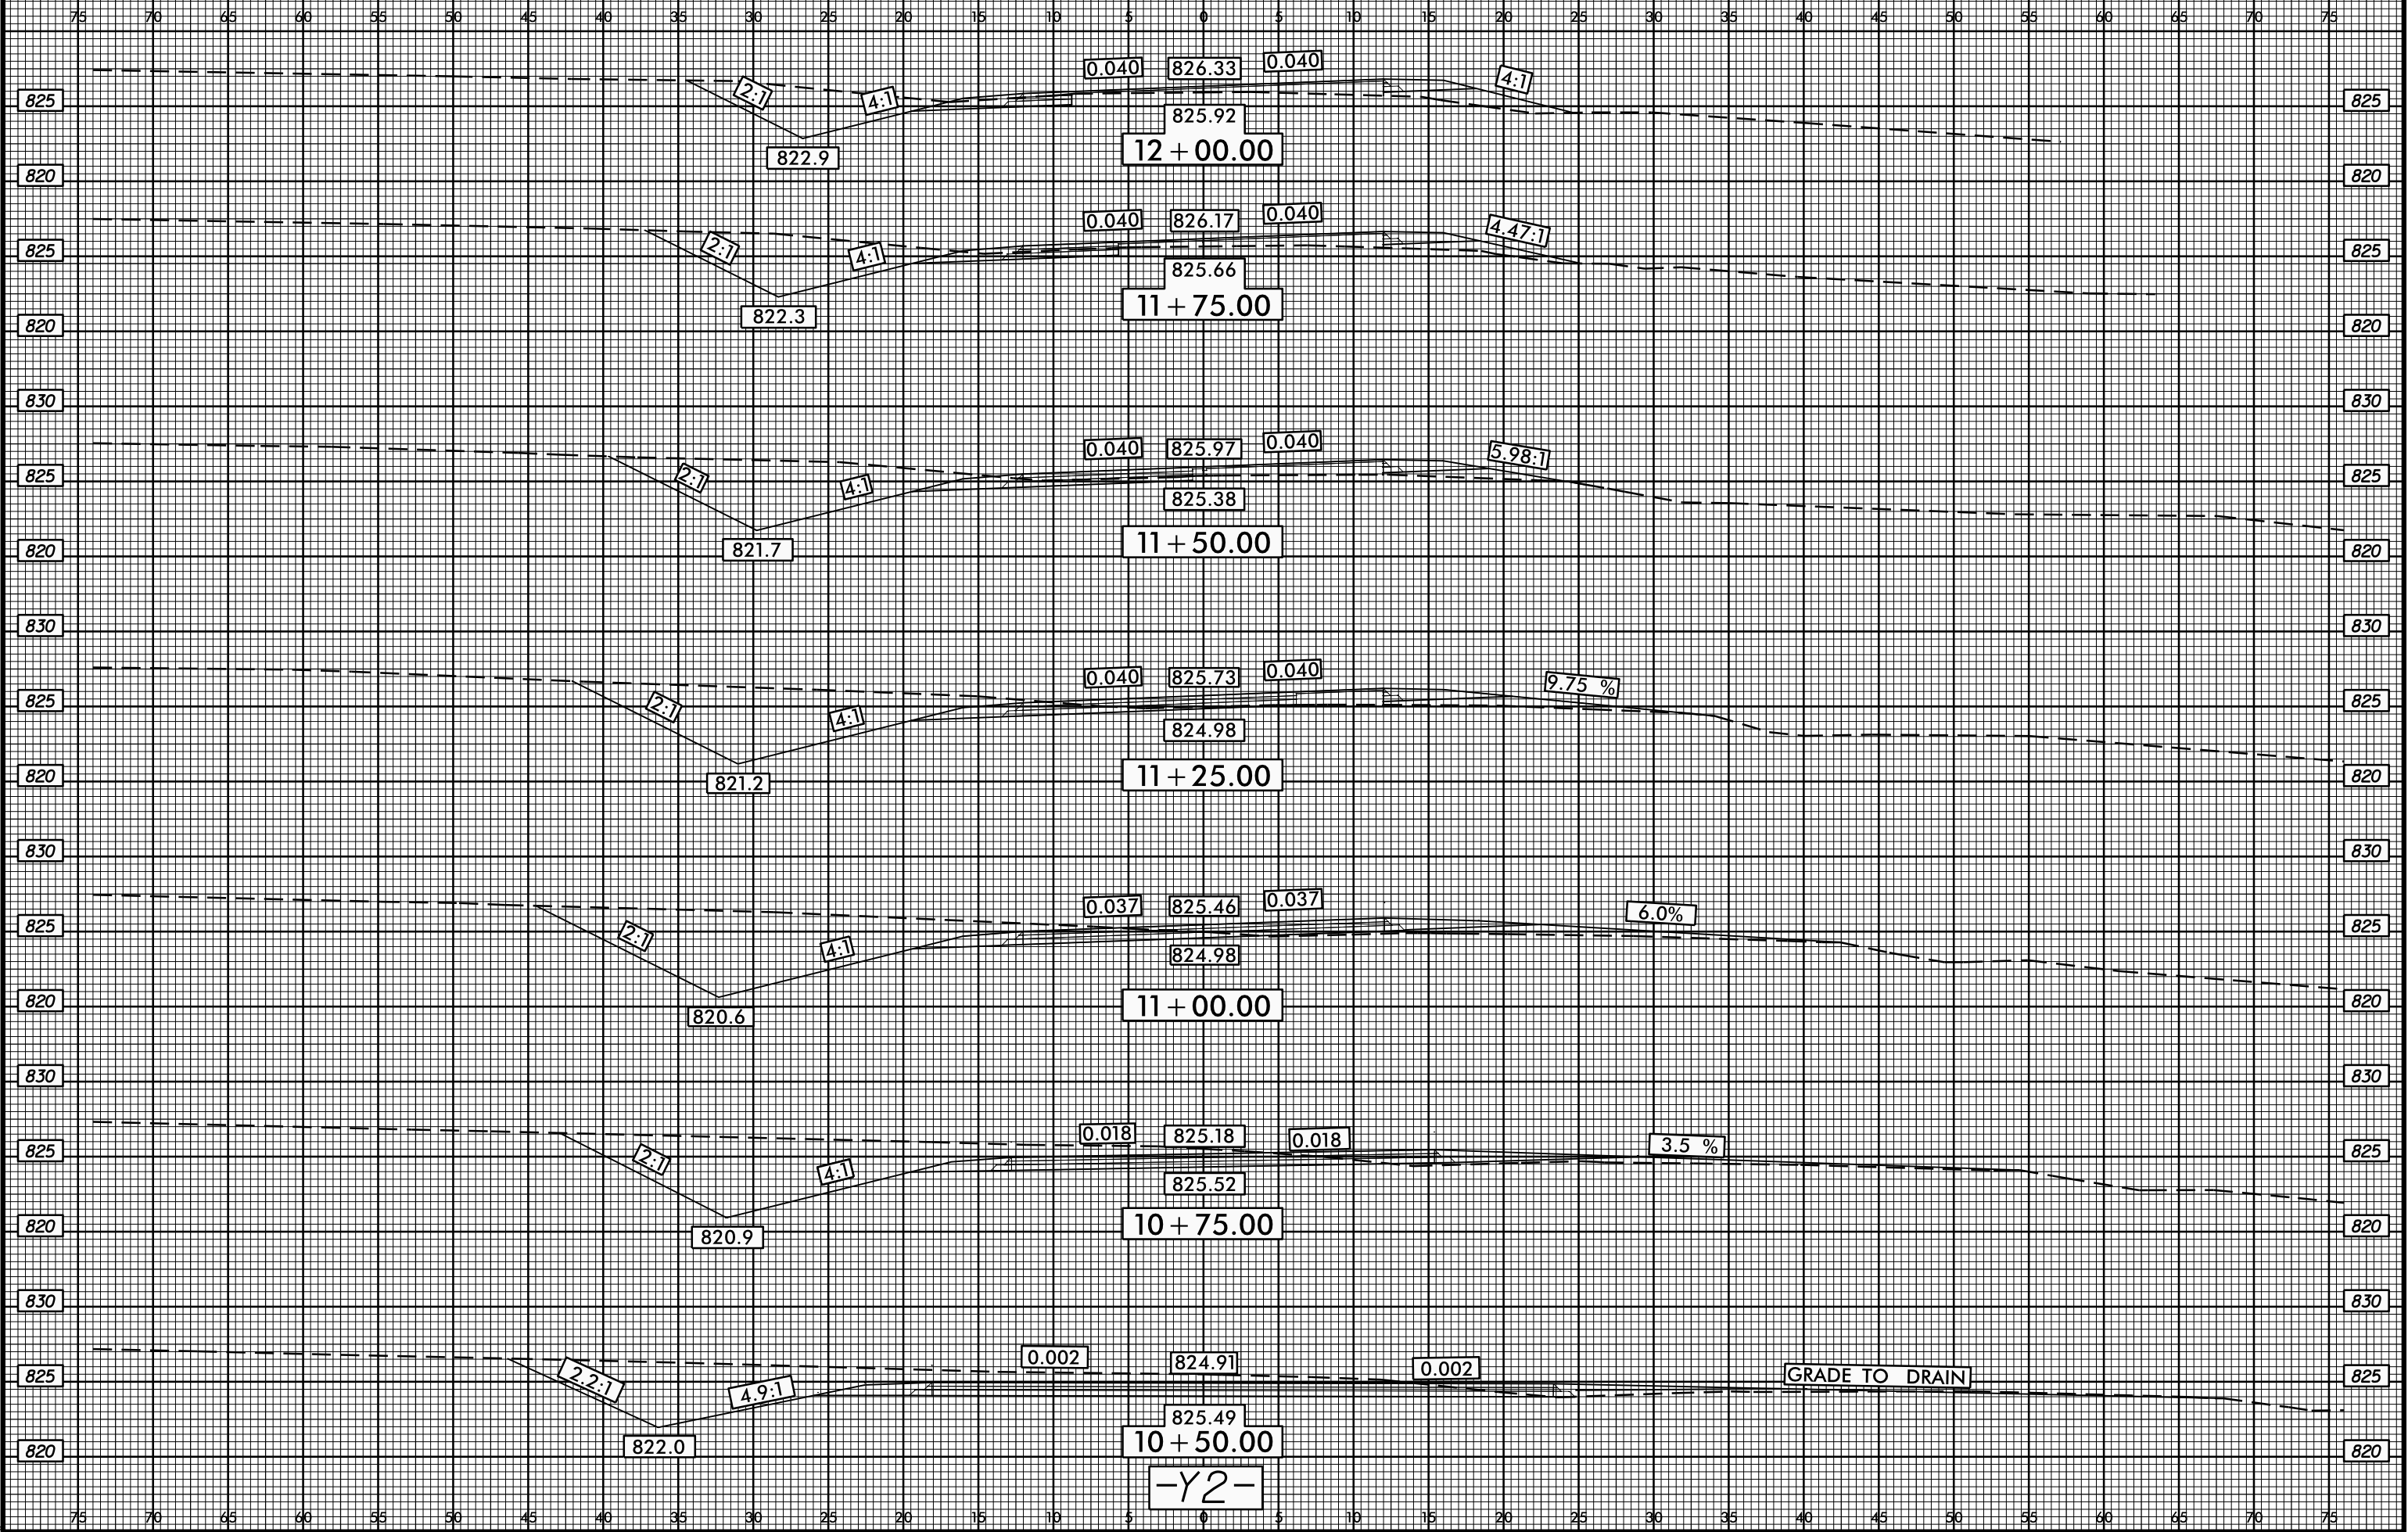

75 70 65 60 55 50 45 40 35 30 25 20 15 10 5 0 5 10 15 20 25 30 35 40 45 50 55 60 65 70 75

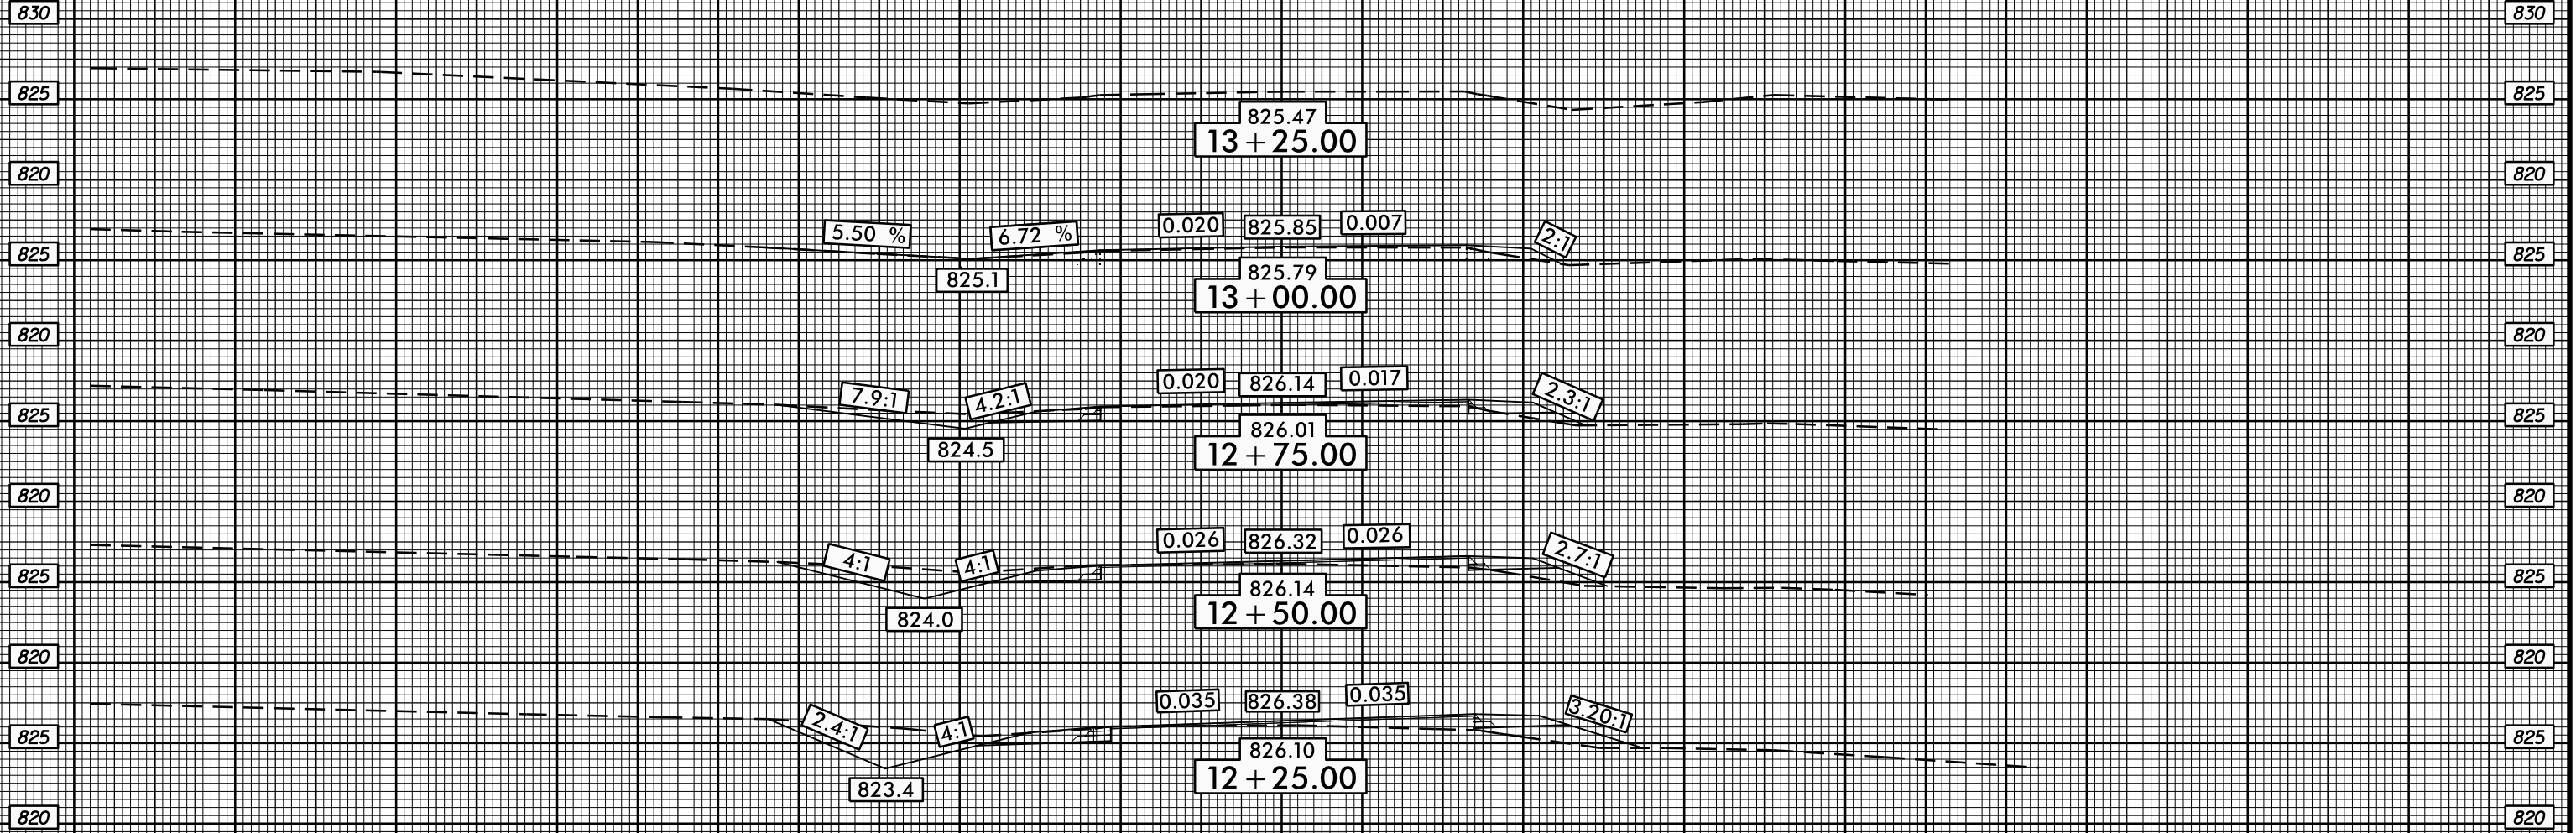

-Y2-